


DRINKING  
LEFT SIDE  
SEE SITE PLAN FOR  
ISAR

**ES** HVAC PLAN  
SCALE: 1/4" = 1'-0"

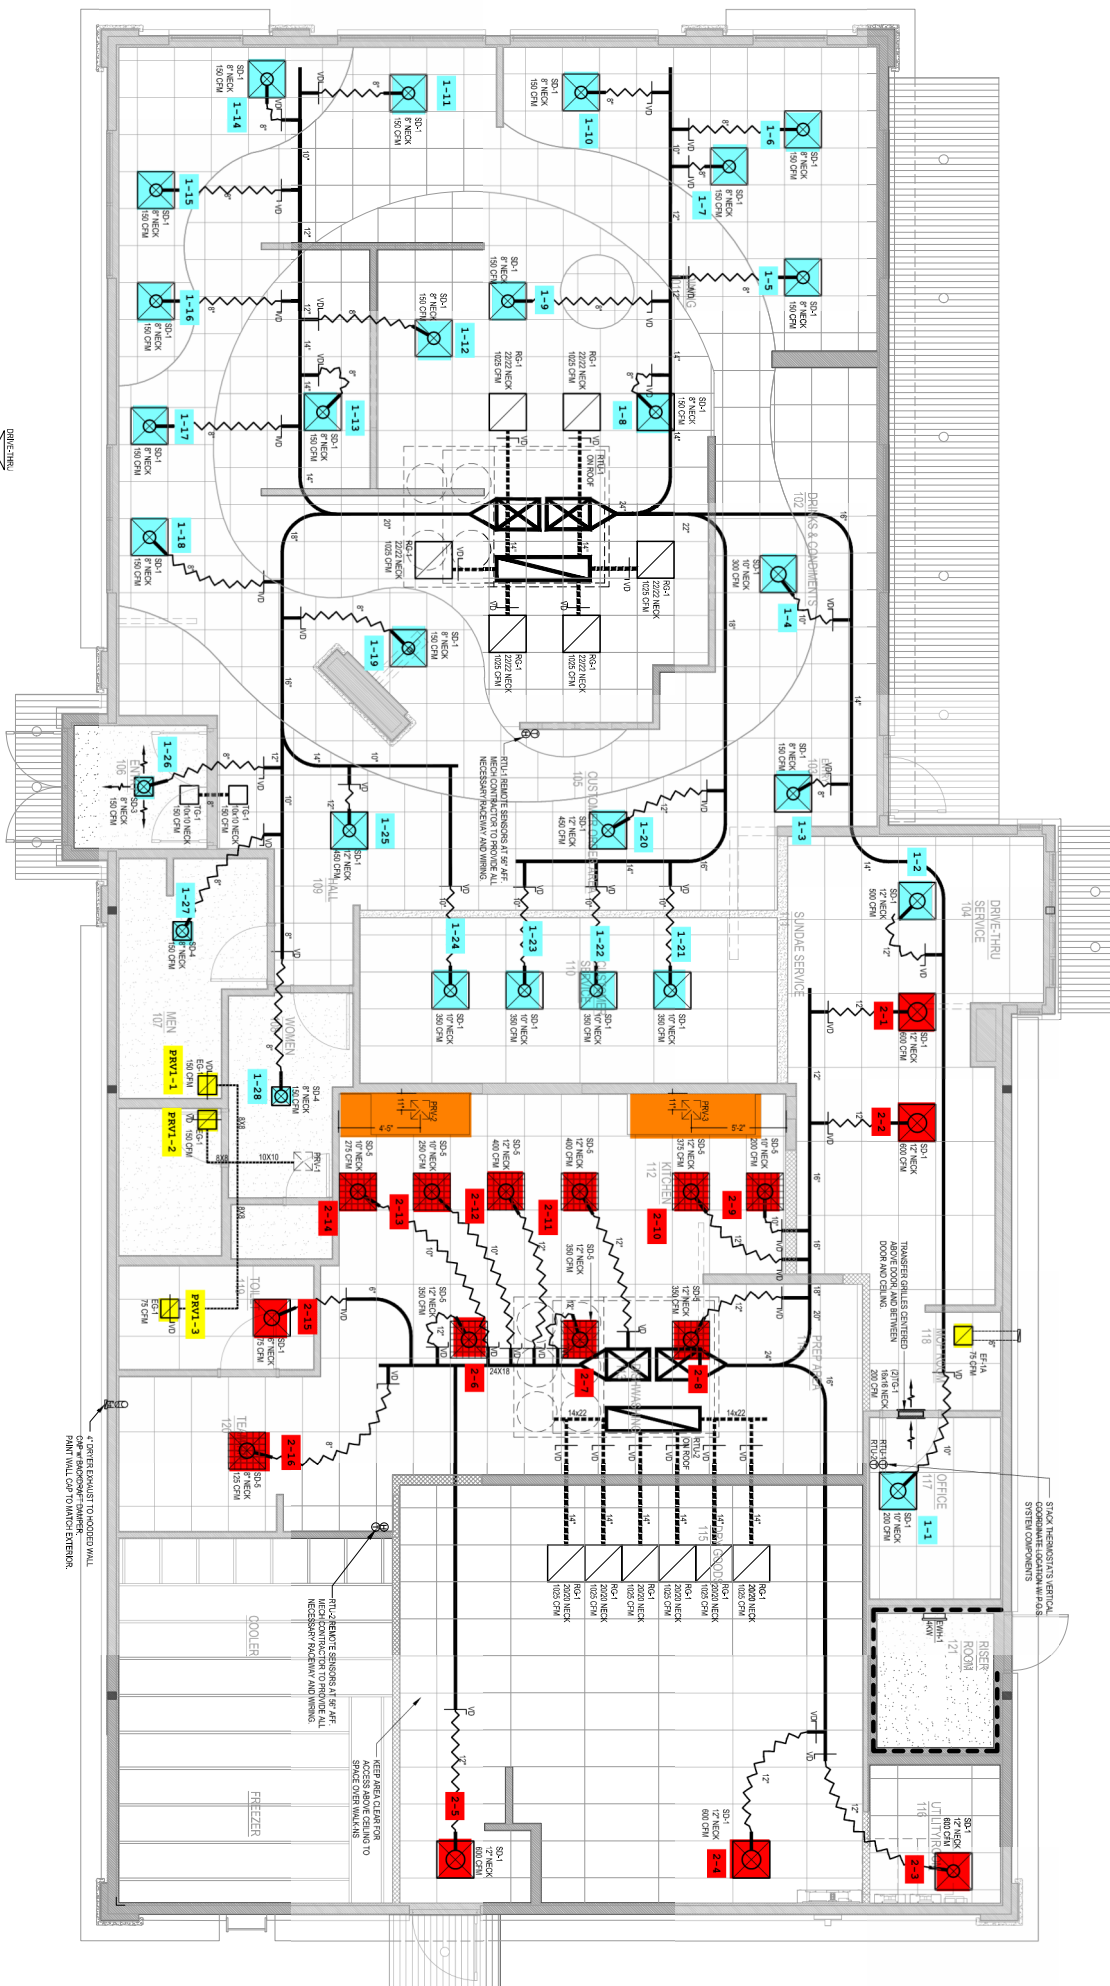

STACK TERMINALS VERTICAL  
CORRELATE LOCATION WITH P.D.S.  
SHEET FOR CONNECTIONS

\* BARRIER EXHAUST TO HOODED WALL  
ON 4" BACKDRAFT DAMPER  
FROM WALL UP TO WYNDOW EXHAUST

RHU RELATIVE HUMIDITY SENSORS AT 8' AFF.  
NECESSARY PREVIEW AND WIRING.

KEEP AREA CLEAR FOR  
ACCESS ABOVE CEILING TO  
SERVICE OVERHEADS

TRANSFER GRATES CENTERED  
ABOVE DOOR JAMB BETWEEN  
ROOM AND HALLWAY

OFFICE

RISER ROOM

UTILITY

FREEZER

COOLER

KITCHEN

WOMEN

MEN

SANDWICH SERVICE

DRINKS & COMPLEMENTS

DRINKING

LEFT SIDE

SEE SITE PLAN FOR

ISAR

SCALE: 1/4" = 1'-0"

ES

HVAC PLAN

DRINKS & COMPLEMENTS

DRINKING

LEFT SIDE

SEE SITE PLAN FOR

ISAR

SCALE: 1/4" = 1'-0"

ES

HVAC PLAN

DRINKS & COMPLEMENTS

DRINKING

LEFT SIDE

SEE SITE PLAN FOR

ISAR

SCALE: 1/4" = 1'-0"

ES

HVAC PLAN

DRINKS & COMPLEMENTS

DRINKING

LEFT SIDE

SEE SITE PLAN FOR

ISAR

SCALE: 1/4" = 1'-0"

ES

HVAC PLAN

DRINKS & COMPLEMENTS

DRINKING

LEFT SIDE

SEE SITE PLAN FOR

ISAR

SCALE: 1/4" = 1'-0"

ES

HVAC PLAN

DRINKS & COMPLEMENTS

DRINKING

LEFT SIDE

SEE SITE PLAN FOR

ISAR

SCALE: 1/4" = 1'-0"

ES

HVAC PLAN

DRINKS & COMPLEMENTS

DRINKING

LEFT SIDE

SEE SITE PLAN FOR

ISAR

SCALE: 1/4" = 1'-0"

ES

HVAC PLAN

DRINKS & COMPLEMENTS

DRINKING

LEFT SIDE

SEE SITE PLAN FOR

ISAR

SCALE: 1/4" = 1'-0"

ES

HVAC PLAN

DRINKS & COMPLEMENTS

DRINKING

LEFT SIDE

SEE SITE PLAN FOR

ISAR

SCALE: 1/4" = 1'-0"

ES

HVAC PLAN

DRINKS & COMPLEMENTS

DRINKING

LEFT SIDE

SEE SITE PLAN FOR

ISAR

SCALE: 1/4" = 1'-0"

ES

HVAC PLAN

DRINKS & COMPLEMENTS

DRINKING

LEFT SIDE

SEE SITE PLAN FOR

ISAR

SCALE: 1/4" = 1'-0"

ES

HVAC PLAN

DRINKS & COMPLEMENTS

DRINKING

LEFT SIDE

SEE SITE PLAN FOR

ISAR

SCALE: 1/4" = 1'-0"

ES

HVAC PLAN

DRINKS & COMPLEMENTS

DRINKING

LEFT SIDE

SEE SITE PLAN FOR

ISAR

SCALE: 1/4" = 1'-0"

ES

HVAC PLAN

DRINKS & COMPLEMENTS

DRINKING

LEFT SIDE

SEE SITE PLAN FOR

ISAR

SCALE: 1/4" = 1'-0"

ES

HVAC PLAN

DRINKS & COMPLEMENTS

DRINKING

LEFT SIDE

SEE SITE PLAN FOR

ISAR

SCALE: 1/4" = 1'-0"

ES

HVAC PLAN

DRINKS & COMPLEMENTS

DRINKING

LEFT SIDE

SEE SITE PLAN FOR

ISAR

SCALE: 1/4" = 1'-0"

ES

HVAC PLAN

DRINKS & COMPLEMENTS

DRINKING

LEFT SIDE

SEE SITE PLAN FOR

ISAR

SCALE: 1/4" = 1'-0"

ES

HVAC PLAN

DRINKS & COMPLEMENTS

DRINKING

LEFT SIDE

SEE SITE PLAN FOR

ISAR

SCALE: 1/4" = 1'-0"

ES

HVAC PLAN

DRINKS & COMPLEMENTS

DRINKING

LEFT SIDE

SEE SITE PLAN FOR

ISAR

SCALE: 1/4" = 1'-0"

ES

HVAC PLAN

DRINKS & COMPLEMENTS

DRINKING

LEFT SIDE

SEE SITE PLAN FOR

ISAR

SCALE: 1/4" = 1'-0"

ES

HVAC PLAN

DRINKS & COMPLEMENTS

DRINKING

LEFT SIDE

SEE SITE PLAN FOR

ISAR

SCALE: 1/4" = 1'-0"

ES

HVAC PLAN

DRINKS & COMPLEMENTS

DRINKING

LEFT SIDE

SEE SITE PLAN FOR

ISAR

SCALE: 1/4" = 1'-0"

ES

HVAC PLAN

DRINKS & COMPLEMENTS

DRINKING

LEFT SIDE

SEE SITE PLAN FOR

ISAR

SCALE: 1/4" = 1'-0"

ES

HVAC PLAN

DRINKS & COMPLEMENTS

DRINKING

LEFT SIDE

SEE SITE PLAN FOR

ISAR

SCALE: 1/4" = 1'-0"

ES

HVAC PLAN

DRINKS & COMPLEMENTS

DRINKING

LEFT SIDE

SEE SITE PLAN FOR

ISAR

SCALE: 1/4" = 1'-0"

ES

HVAC PLAN

DRINKS & COMPLEMENTS

DRINKING

LEFT SIDE

SEE SITE PLAN FOR

ISAR

SCALE: 1/4" = 1'-0"

ES

HVAC PLAN

DRINKS & COMPLEMENTS

DRINKING

LEFT SIDE

SEE SITE PLAN FOR

ISAR

SCALE: 1/4" = 1'-0"

ES

HVAC PLAN

DRINKS & COMPLEMENTS

DRINKING

LEFT SIDE

SEE SITE PLAN FOR

ISAR

SCALE: 1/4" = 1'-0"

ES