


Chick-fil-A  
5200 Buffington Road  
Atlanta, Georgia 30349

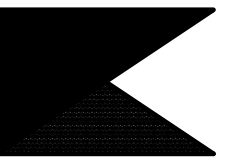

**Kurzynske & Associates**  
CONSULTING ENGINEERS  
2708 Lebanon Pike - Suite One  
Nashville, Tennessee 37214  
Telephone: (615) 255-5203



**CHICK-FIL-A**  
**DELTRAN FSU**  
1301 FAIRVIEW BLVD  
DELTRAN, NJ 08075

**FSR#01385**


BUILDING TYPE / SIZE: S97-110  
RELEASE: v05.22  
REVISION SCHEDULE  
NO. DATE DESCRIPTION

CONSULTANT PROJECT # 22146.HF.R  
PRINTED FOR CONSTRUCTION  
DATE 1/30/2023  
DRAWN BY JP

Information contained on this drawing and in all digital files produced for above named project may not be reproduced in any manner without express written or verbal consent from authorized project representatives.

SHEET BELOW SLAB DEMO PLAN  
SHEET NUMBER

**P0.1**

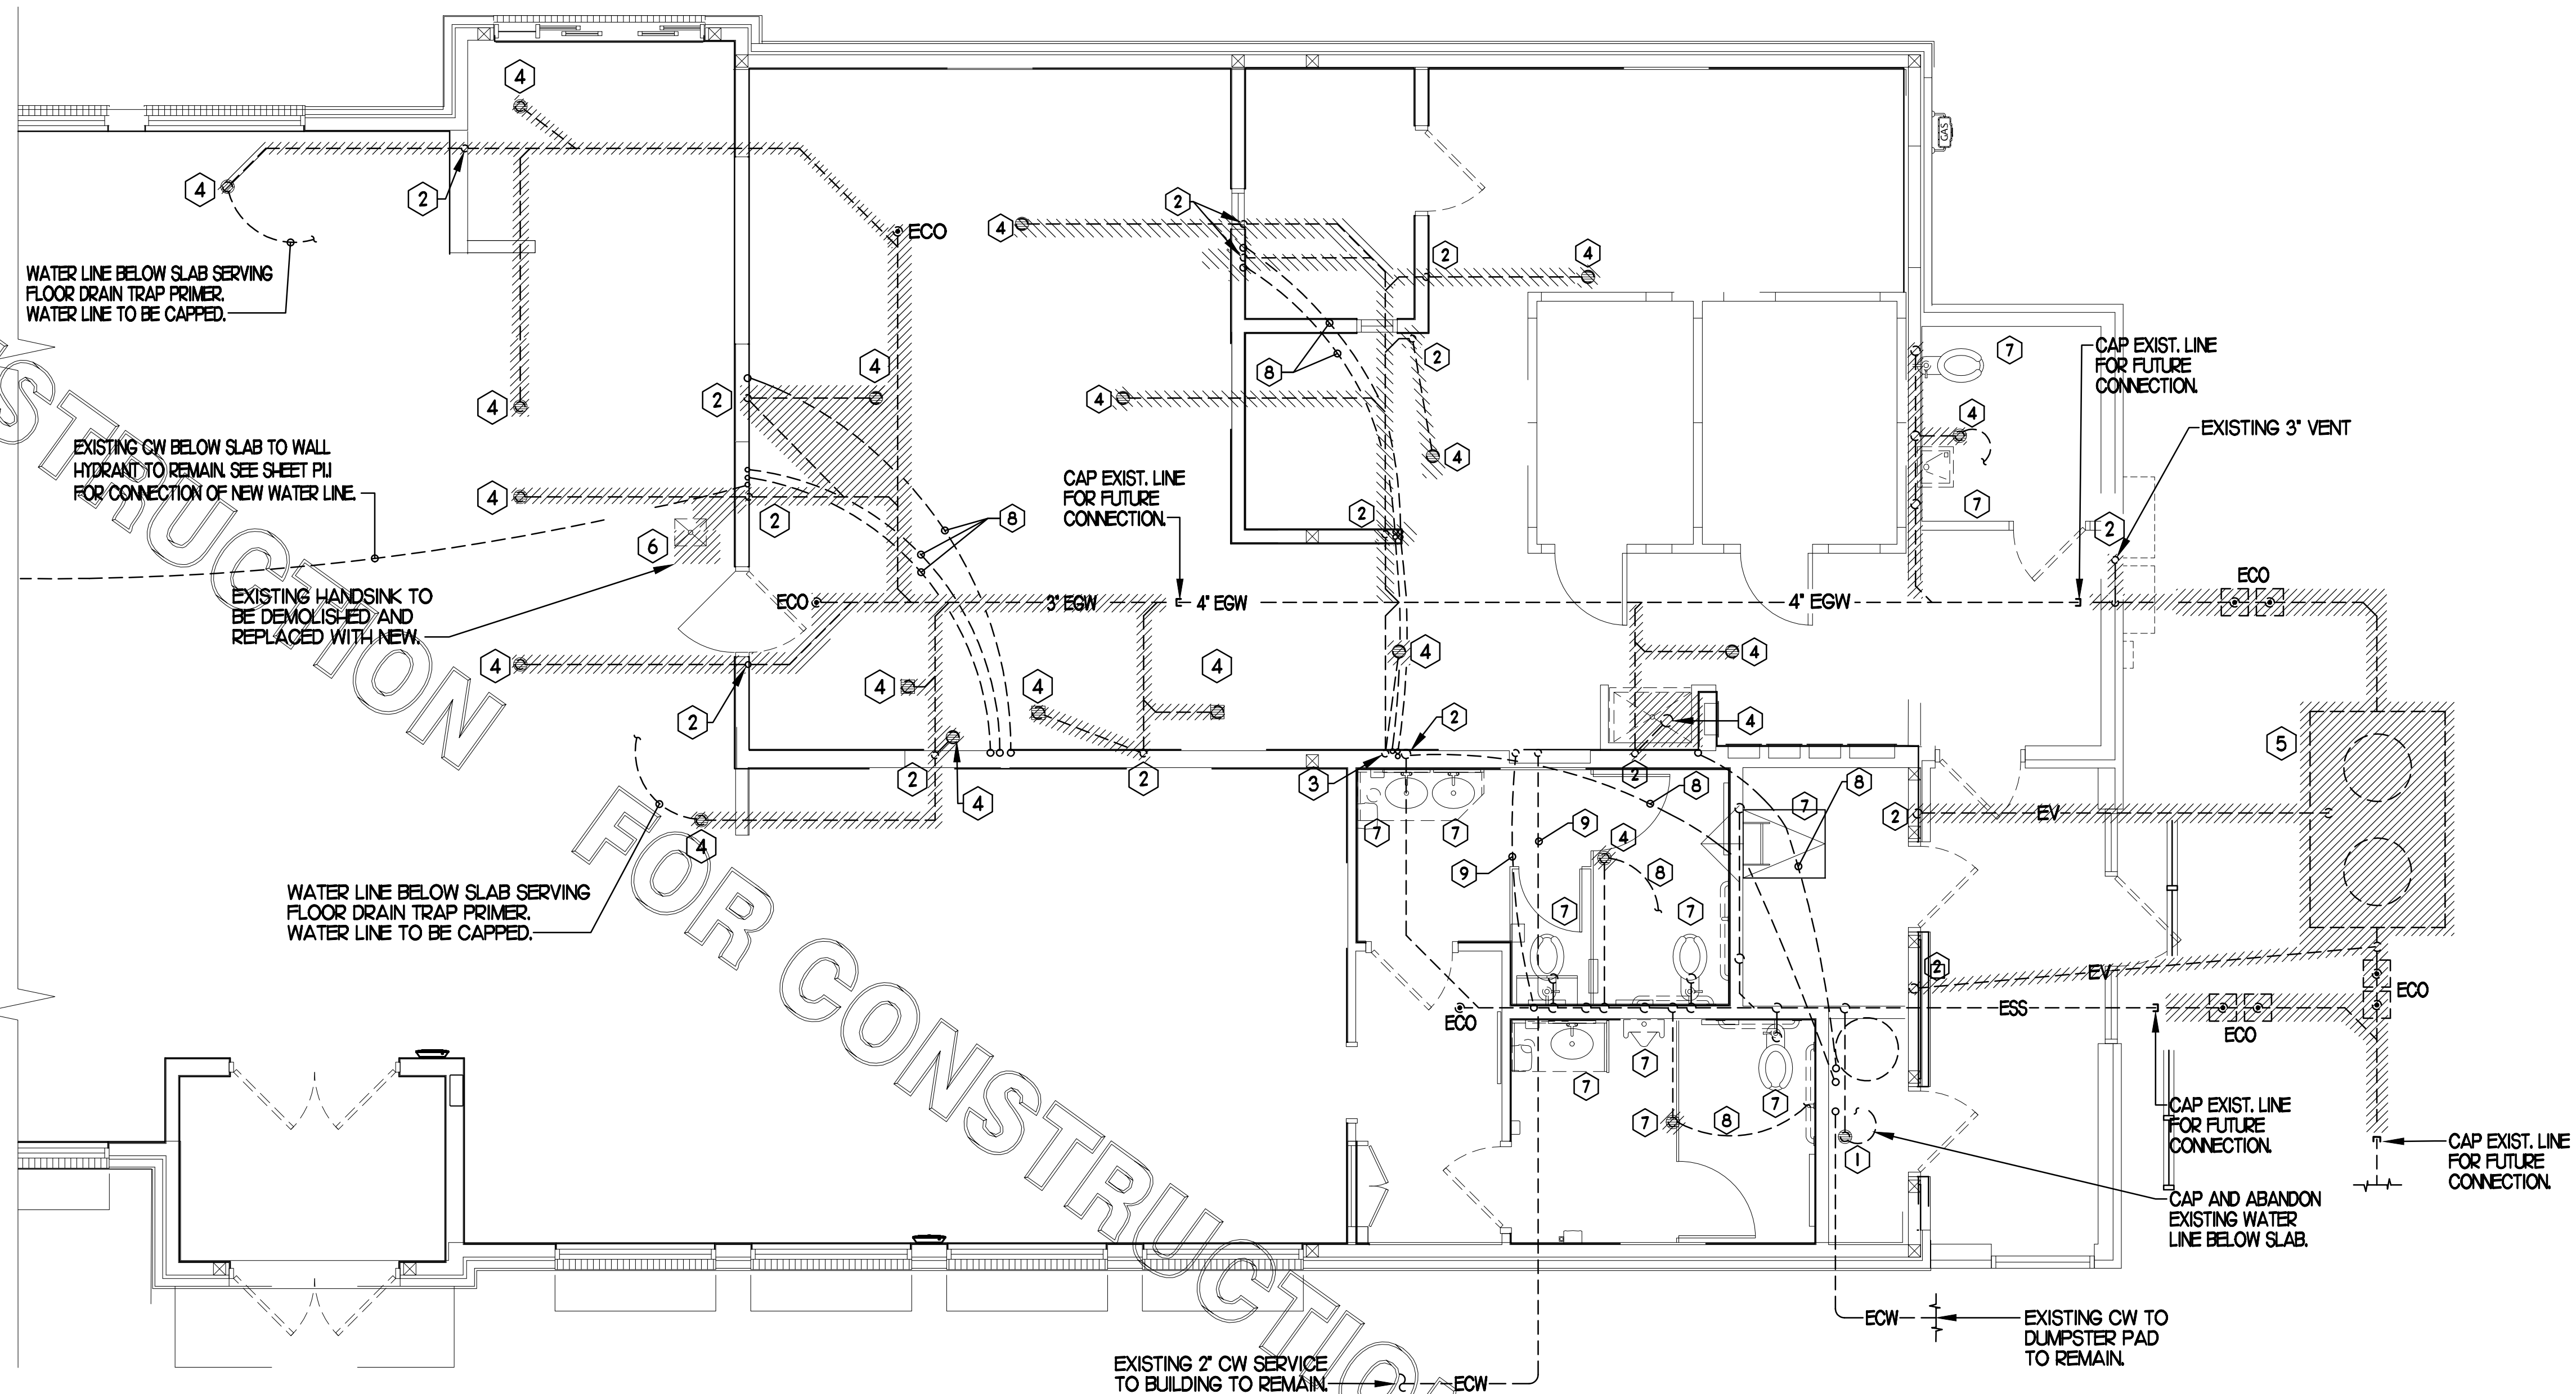

PLUMBING CONTRACTOR SHALL CAP AND ABANDON ALL EXISTING WATER PIPING LOCATED BELOW SLAB AND WITHIN WALLS. WHERE WATER PIPING IS LOCATED IN ACCESSIBLE AREA OR WALL TO BE DEMOLISHED, PIPING SHALL BE DEMOLISHED.

**NOTE:**  
PLUMBING CONTRACTOR SHALL CLEAN OUT THE EXISTING SANITARY SEWER LINE WITHIN SPACE TO MAIN BUILDING SEWER LINE WHICH SHALL BE FIELD VERIFIED EITHER AT THE STREET OR IN THE PARKING LOT AND ALSO VERIFY ALL NEW WASTE LINES ARE CLEAR. LINES SHALL BE CLEARED OF ALL EXISTING DEBRIS AND SHALL BE GUARANTEED THAT A CLEAR FLOW SHALL EXIST WHEN OFA TAKES POSSESSION. AFTER WASTE LINES ARE INSTALLED, PRIOR TO GRAVEL AND CONCRETE POUR, PLUMBING CONTRACTOR SHALL MAINTAIN THAT WASTE LINE STUB-UPS ARE CAPPED TO ENSURE THAT GRAVEL AND CONCRETE DO NOT ENTER PIPING.

**1 BELOW SLAB PLUMBING DEMOLITION PLAN**  
SCALE: 1/4"=1'-0"

PRIOR TO CONSTRUCTION, PLUMBING CONTRACTOR SHALL COORDINATE EXISTING LOCATIONS OF EXISTING WATER LINES (BUILDING SUPPLY, DUMPSTER PAD, FIRE SPRINKLER, ETC.) IF DEEMED NECESSARY, REROUTE NEW LINES, SIZED SAME AS EXISTING FROM BUILDING IN ORDER TO AVOID ANY CONFLICT WITH NEW BUILDING ADDITION. PLUMBING CONTRACTOR SHALL BE RESPONSIBLE FOR ANY PIPING & TRENCHING REQUIRED.

**SHEET NOTES**

- 1 VERIFY IF EXISTING SLAB IS A POST TENSION TYPE. CONTRACTOR IS REQUIRED TO PERFORM GROUND PENETRATING RADAR (GPR) TEST ON THE FLOOR PRIOR TO CUTTING FLOOR FOR KITCHEN DRAIN RELOCATIONS.
- 2 LOCATIONS OF WASTE LINES, VENTS, CW LINES & OTHER UNDER AND ABOVE GROUND ITEMS AS SHOWN ON THESE PLANS ARE APPROXIMATE AND THEIR ACTUAL LOCATION MAY VARY SIGNIFICANTLY. FIELD VERIFY ALL EXISTING CONDITIONS, INCLUDING LOCATION, FALL, DIRECTION OF FLOW AND CONNECTING INVERTS, PRIOR TO COMMENCING WORK. NOTIFY CHICK-FIL-A CONSTRUCTION REPRESENTATIVE IF EXISTING MAJOR DISCREPANCIES IN ROUTING OF SERVICE LINES ARE DISCOVERED IN FIELD.
- 3 IT IS THE RESPONSIBILITY OF THE CONTRACTOR TO VISIT THE SITE DURING BID PHASE, WITH EXISTING DRAWINGS PROVIDED BY THE OWNER, IN ORDER TO DETERMINE THE TRUE AS-BUILT CONDITIONS OF THE POTABLE WATER, SANITARY WASTE-VENT AND OTHER PIPING SYSTEMS.
- 4 GENERAL CONTRACTOR SHALL BE RESPONSIBLE FOR REMOVING, STORING, AND RELOCATING EXISTING PLUMBING EQUIPMENT. PLUMBING CONTRACTOR TO COORDINATE DISCONNECTING OF EXISTING EQUIPMENT WITH GENERAL CONTRACTOR PRIOR TO COMMENCING WORK.
- 5 ALL LINES THAT ARE TO BE ABANDONED IN PLACE SHALL BE DEMOLISHED MIN. 6" BELOW SLAB, IN WALL OR ABOVE CEILING AND PLUGGED WATER/AIR TIGHT. ALL AFFECTED ADJACENT SURFACES SHALL BE REPAIRED AND REFINISHED TO MATCH SURROUNDING AREA.
- 6 VERIFY ALL FIXTURES THAT ARE TO BE REUSED ARE IN GOOD USABLE CONDITION; REPLACE FIXTURE IF DEFICIENCIES ARE FOUND
- 7 EXCEPT AS NOTED ON PLAN OR DETAILS, ALL NEW OR RELOCATED FLOOR DRAINS SHALL BE INSTALLED CENTERED IN 3 FT. DIAM. 1" DEEP SLAB DEPRESSION.
- 8 CONTRACTOR IS RESPONSIBLE FOR REPAIRING AND LEVELING OF FLOOR DEPRESSIONS IN AREAS WHERE EXISTING FLOOR DRAINS, CLEANOUTS &/OR OTHER FLOOR ITEMS ARE BEING DEMOLISHED, ABANDONED OR RELOCATED.

**KEY NOTES**

- 1 EXISTING FLOOR FIXTURE TO REMAIN. PLUMBING CONTRACTOR SHALL BE RESPONSIBLE FOR VERIFYING FIXTURE IS CLEAR AND USABLE AND TRAP PRIMER (IF EXISTING) IS WORKING PROPERLY. IF DEFICIENCIES FOUND IN FIELD, REPLACE PRIMER &/OR WATER SUPPLY LINE OR REPLACE FIXTURE AS NECESSARY.
- 2 DEMOLISH EXISTING VENT IN WALL AND CAP OFF ABOVE CEILING AND BELOW SLAB. VENT BELOW SLAB SHALL BE CAPPED OFF JUST ABOVE TAKE-OFF FROM WASTE LINE.
- 3 EXISTING VENT TO REMAIN IN WALL.
- 4 DEMOLISH EXISTING FLOOR FIXTURE OR ABOVE SLAB FIXTURE, IF NECESSARY, PREPARE LINES FOR CONNECTION OF NEW FIXTURE OR EXTENSION REFER TO P.I.I. AND CIVIL PLANS. COORDINATE WORK WITH G.C. IF FLOOR DRAIN IS DEMOLISHED, IF EXISTING, CAP WATER LINE FROM TRAP PRIMER.
- 5 REMOVE EXISTING GREASE INTERCEPTOR. DEMOLISH ALL LINES FROM EXISTING GREASE INTERCEPTOR TO POINTS OF CONNECTION INDICATED ON P.I.I. AND CIVIL PLANS. COORDINATE WITH SITE & NEW CONSTRUCTION WORK. CAP EXISTING LINES FOR FUTURE CONNECTION WHERE SHOWN.
- 6 PLUMBING CONTRACTOR SHALL DEMOLISH EXISTING TRAP PRIMER LOCATED BELOW COUNTER AND CAP OFF AND ABANDON EXISTING WATER PIPING BELOW SLAB.
- 7 DEMOLISH EXISTING RESTROOM FIXTURE. CAP WASTE CONNECTION BELOW SLAB, WHERE APPLICABLE, CAP EXISTING VENT/CW/HW CONNECTIONS BACK TO RESPECTIVE MAINS FOR FUTURE CONNECTION.
- 8 CAP AND ABANDON BELOW SLAB WATER LINE(S).
- 9 EXISTING WATER LINES IN WALL AND BELOW SLAB SERVING RESTROOMS ARE TO REMAIN. SEE P.I.I. AND P2.I. FOR CONNECTION NOTES.

**SITE PIPING DEMO NOTES**

- CAREFULLY EXAMINE & VERIFY ALL EXISTING CONDITIONS PRIOR TO COMMENCING ANY DEMOLITION WORK. FIELD VERIFY ALL SERVICE LINES LOCATIONS, DIAMETERS, ROUTING, INVERTS ETC.
- REFER TO SITE PLAN FOR EXACT LOCATION OF EXISTING GREASE INTERCEPTOR AND ALL SITE PIPING.

**PIPING LEGEND**

EXISTING GREASE WASTE (EGW)	EGW
EXISTING SANITARY SEWER (ESS)	ESS
EXISTING FILTERED WATER UNDER GROUND (EFW)	EFW
EXISTING COLD WATER UNDER GROUND (ECW)	ECW
EXISTING TEMPERED WATER UNDER GROUND (ETW)	ETW
EXISTING HOT WATER UNDER GROUND (EHW)	EHW
EXISTING LINE/FIXTURE TO BE DEMOLISHED	----
EXISTING WATER LINE(S) IN WALL TO BE DEMO'D	∞

CONSTRUCTION



Chick-fil-A  
5200 Buffington Road  
Atlanta, Georgia 30349



**Kurzynske & Associates**  
CONSULTING ENGINEERS  
2708 Lebanon Pike - Suite One  
Nashville, Tennessee 37214  
Telephone: (615) 258-5203



**CHICK-FIL-A**  
**DELTRAN FSU**  
1301 FAIRVIEW BLVD  
DELTRAN, NJ 08075

**FSR#01385**

BUILDING TYPE / SIZE: S97-110  
RELEASE: v05.22  
**REVISION SCHEDULE**


NO.	DATE	DESCRIPTION

CONSULTANT PROJECT # 22146.HF.R  
PRINTED FOR CONSTRUCTION  
DATE 1/30/2023  
DRAWN BY AK

Information contained on this drawing and in all digital files produced for above named project may not be reproduced in any manner without express written or verbal consent from authorized project representatives.

SHEET ABOVE SLAB DEMO PLAN  
SHEET NUMBER

**P0.2**

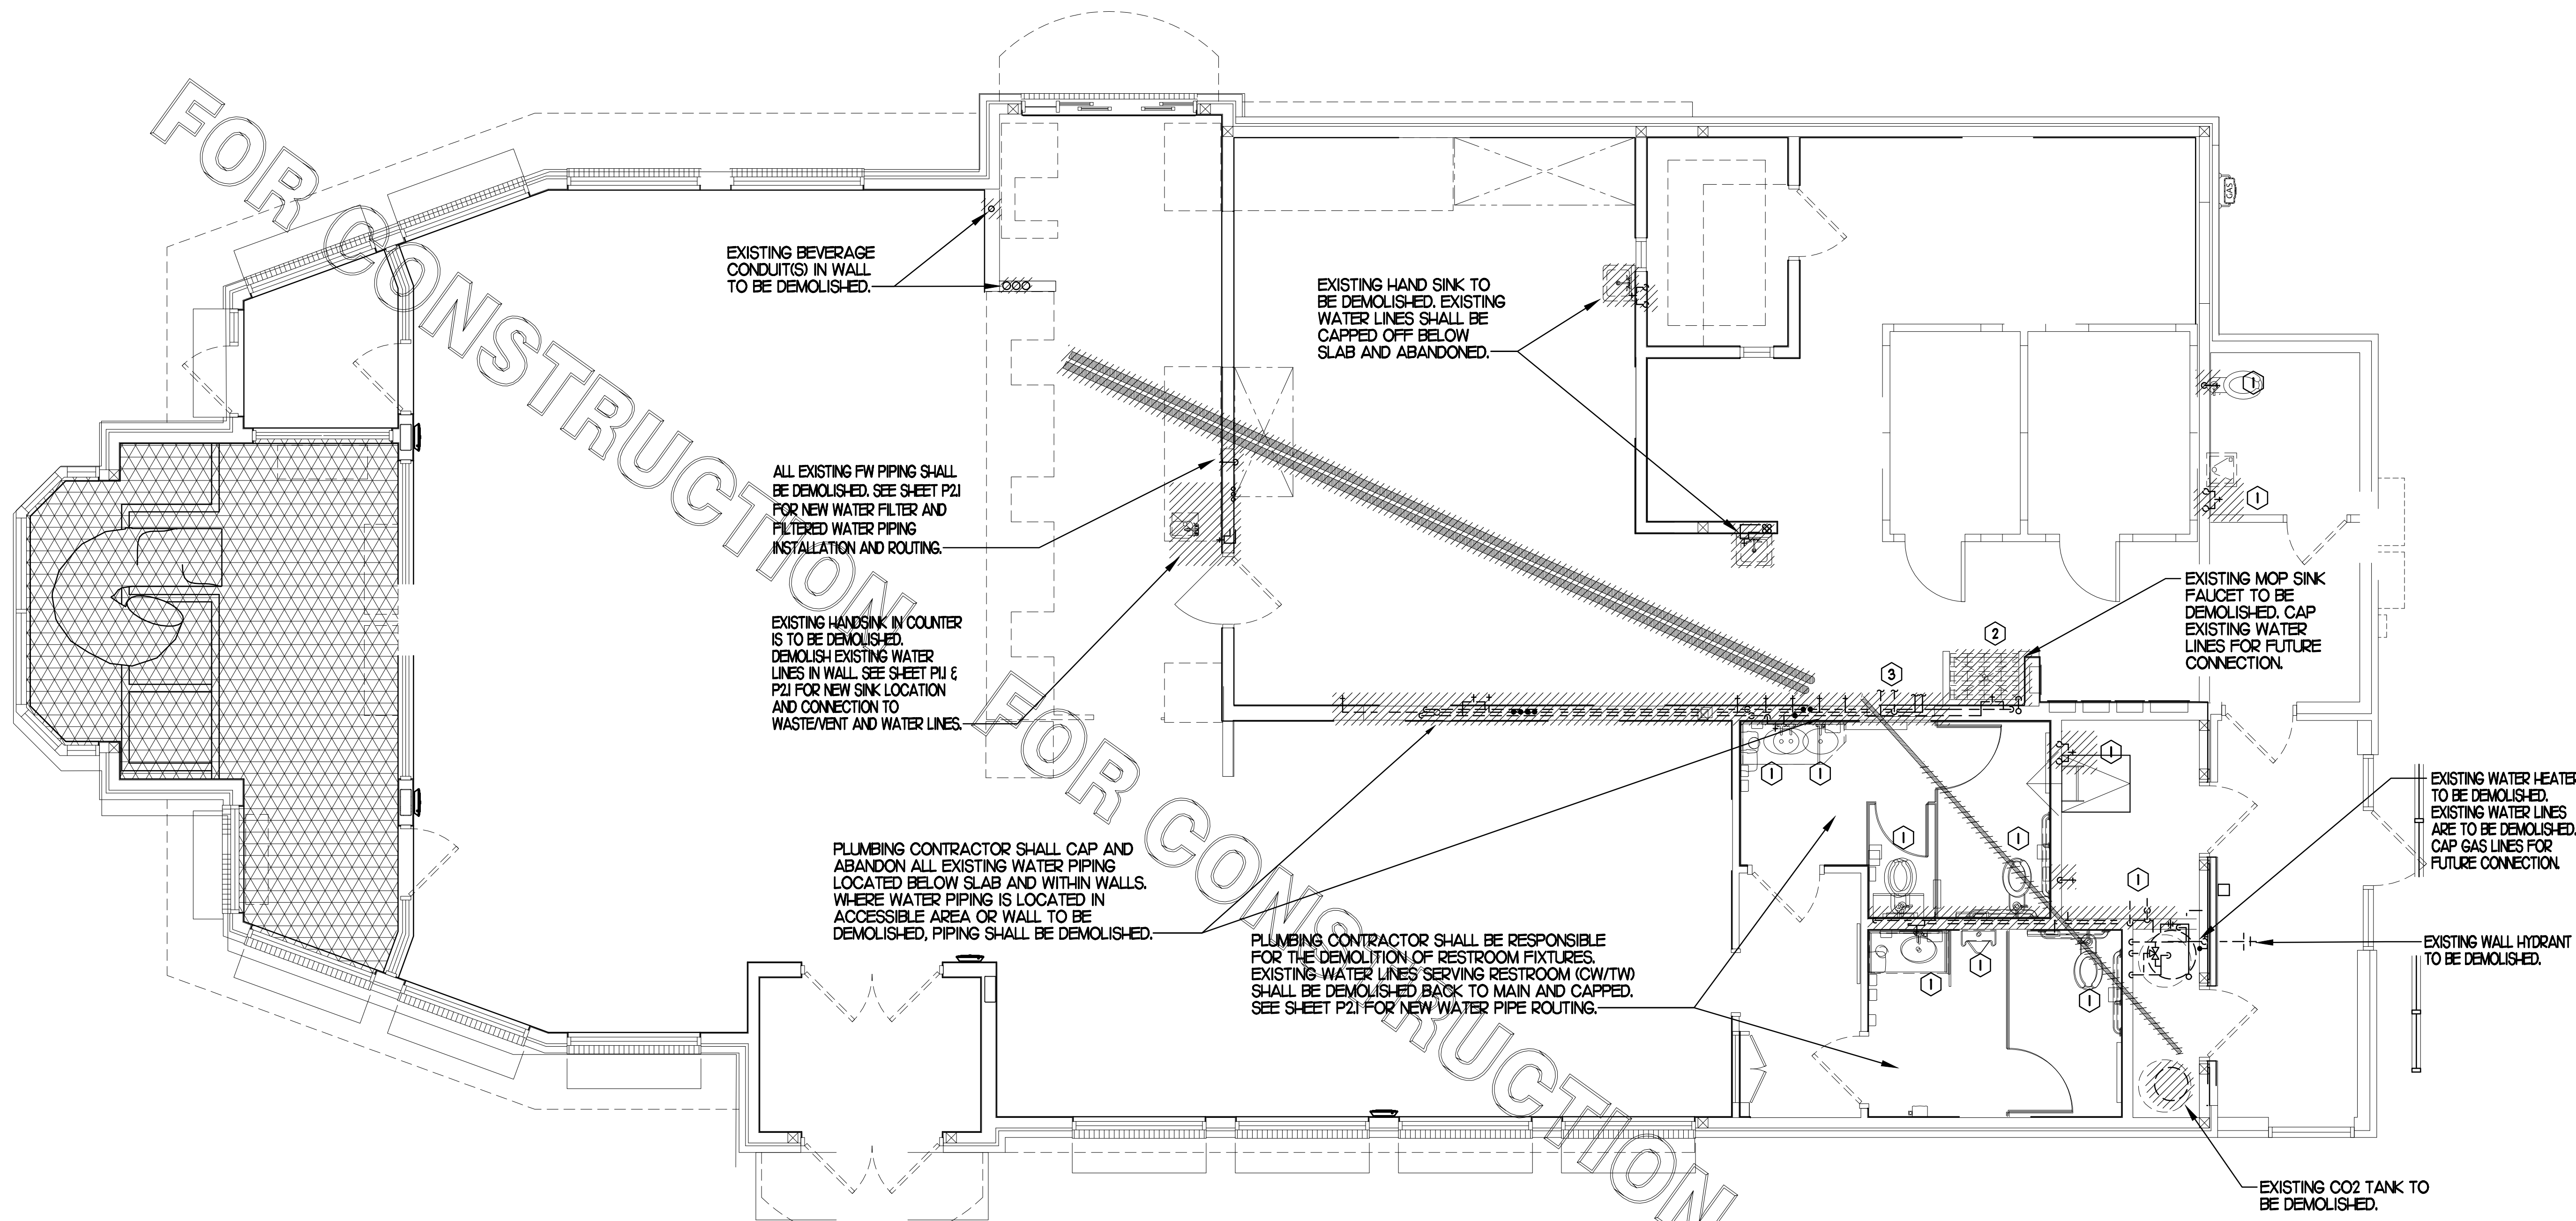

**I ABOVE SLAB PLUMBING DEMOLITION PLAN**  
SCALE: 1/4"=1'-0"

**SITE PIPING DEMO NOTES**

- CAREFULLY EXAMINE & VERIFY ALL EXISTING CONDITIONS PRIOR TO COMMENCING ANY DEMOLITION WORK. FIELD VERIFY ALL SERVICE LINES LOCATIONS, DIAMETERS, ROUTING, INVERTS ETC.
- REFER TO SITE PLAN FOR EXACT LOCATION OF EXISTING GREASE INTERCEPTOR AND ALL SITE PIPING.

**PIPING LEGEND**

EXISTING GREASE WASTE (EGW)	---	EGW
EXISTING SANITARY SEWER (ESS)	---	ESS
EXISTING FIRE PROTECTION LINE (F)	---	4F
EXISTING COLD WATER UNDER GROUND (ECW)	---	ECW
EXISTING TEMPERED WATER UNDER GROUND (ETW)	---	ETW
EXISTING HOT WATER UNDER GROUND (EHW)	---	EHW
EXISTING LINE/FIXTURE TO BE DEMOLISHED	//////	
EXISTING WATER LINES IN WALL TO BE DEMOD	oo	

**KEY NOTES**

- DEMOLISH EXISTING RESTROOM FIXTURE. CAP EXISTING WATER LINES AND WASTE/VENT LINES WITHIN WALL. PREPARE LINES FOR CONNECTION TO NEW FIXTURE. SEE SHEET P1.I AND P2.I.
- EXISTING MOP SINK FAUCET/DRAIN TO BE DEMOLISHED. CAP WATER LINES AT MAIN.
- EXISTING WATER FILTRATION SYSTEM IN THIS AREA TO BE DEMOLISHED. SEE SHEET P2.I FOR NEW LOCATION. CAP AND ABANDON ALL EXISTING FW LINES AND CAP CW SUPPLY LINE. SEE SHEET P2.I FOR NEW FW PIPING.

CONSTRUCTION

### FLOOR FIXTURE ELEVATIONS

IMPORTANT! INSTALL THE FLOOR FIXTURE SUCH THAT THE TOP-OF-RIM ELEVATION IS AS FOLLOWS:

FIXTURE	TYPE	RIM ELEVATION
P-10	FLOOR DRAIN	1/4" BFF
P-35	MOP SINK DRAIN	7" BFF
P-36	INDIRECT WASTE RECEIVER	1/4" BFF
P-37	FLOOR DRAIN	1/4" BFF

NOTE: THE RIM ELEVATIONS SHOWN HERE SHOULD MATCH THE DERESSED SLAB. CONFIRM WITH ARCHITECTURAL PLANS. SEE ARCHITECTURAL PLANS FOR FLOOR SLOPE AT SLAB DEPRESSION FOR FIXTURES INSTALLED BELOW FINISHED FLOOR ELEVATION. FLOOR FIXTURES NOT LISTED HERE SHALL BE INSTALLED FLAT AND FLUSH WITH FINISHED FLOOR ELEVATION.

### PIPING LEGEND (This Sheet)

EXISTING FLOOR DRAIN	FD
EXISTING FLOOR SINK	FS
EXISTING GREASE WASTE (EGW)	EGW
NEW GREASE WASTE (EGW)	GW
EXISTING SANITARY SEWER (ESS)	ESS
EXISTING COLD WATER UNDER GROUND (ECW)	ECW
EXISTING HOT WATER UNDER GROUND (EHW)	EHW
EXISTING TEMPERED WATER UNDER GROUND (ETW)	ETW
NEW WATER UNDER GROUND (CW, HW, TW OR FHW/FWZ)	CW
POINT OF CONNECTION	○
FLOOR DRAIN	□
FLOOR SINK	○
FLOOR/EXTERIOR CLEANOUT	○

### MOP SINK NOTE

IMPORTANT! INSTALL P-35 FLOOR DRAIN WITH TOP OF DRAIN 0'-7" BFF. COORDINATE WITH GENERAL CONTRACTOR. SEE ARCHITECTURAL AND STRUCTURAL DRAWINGS.

PLUMBING CONTRACTOR SHALL VERIFY LOCATION, INVERT ELEVATION AND FLOW DIRECTION OF EXISTING LINE PRIOR TO ANY WORK. COORDINATE WITH ALL OTHER UTILITIES LOCATED BELOW GROUND PRIOR TO ANY EARTHWORK.

PLUMBING CONTRACTOR SHALL ROUTE ALL NEW VENT LINES SHOWN AND NOTED UP IN WALL AND TO ABOVE CEILING AND MAKE CONNECTION TO NEAREST VENT HEADER THE SAME SIZE OR LARGER.

### SITE PIPING NOTES


- CAREFULLY EXAMINE & VERIFY ALL EXISTING CONDITIONS PRIOR TO COMMENCING WORK.
- REFER TO SITE PLAN FOR EXACT LOCATION OF EXISTING & NEW GREASE INTERCEPTOR AND ALL SITE PIPING.
- CLOSELY COORDINATE INSTALLATION WITH EARTH WORK.
- PROVIDE PVC SLEEVES ON ALL PIPING PENETRATING EXISTING OR NEW FOUNDATIONS.

### SHEET NOTES


- COORDINATE INSTALLATION OF SANITARY PIPING WITH FOOTINGS IN THE FIELD. SLEEVE ALL NEW AND EXISTING PIPING PENETRATIONS IN FOOTINGS WITH PVC.
- WHERE REQUIRED BY LOCAL AUTHORITY HAVING JURISDICTION PROVIDE SAFE WASTE SYSTEM AS OUTLINED IN STATE AND LOCAL CODE AMENDMENTS.
- ALL WATER PIPING INSTALLED WITHIN EXTERIOR WALLS SHALL BE LOCATED ON THE INTERIOR SIDE OF THE INSULATION.
- ALL VENT PIPING TO BE 1/2" DIAMETER UNDO.

### KEY NOTES


- CONNECT NEW WASTE/VENT LINE TO EXISTING AS SHOWN. VERIFY FALL, FLOW DIRECTION AND CONNECTING INVERTS. PROVIDE VENT CONNECTION TO EXISTING SYSTEM WHERE APPLICABLE.
- ROUTE NEW VENT LINE UP IN WALL TO ABOVE CEILING. MAKE CONNECTION TO EXISTING VENT HEADER OF SAME SIZE OR LARGER. WHERE DRAIN IS LOCATED IN NEW ADDITION, ROUTE VENT LINE UP IN WALL AND ABOVE CEILING INTO EXISTING BUILDING AND MAKE NECESSARY CONNECTION.
- INSTALL NEW PLUMBING FIXTURE. MAKE CONNECTION TO EXISTING WASTE LINE LOCATED BELOW SLAB/WITHIN WALL. PLUMBING CONTRACTOR SHALL BE RESPONSIBLE FOR ANY ADDITIONAL PIPE REQUIRED.
- INSTALL FLOOR DRAIN P-35 AT MOP SINK DEPRESSION WITH TOP OF STRAINER 0'-7" BFF.
- PROVIDE AND INSTALL NEW WASTE PIPING BELOW KITCHEN SINK. PROVIDE 1/2" SCHED 40 PVC INDIRECT WASTE DRAIN FROM EACH SINK BASIN TO FLOOR SINK. NO P-TRAPS REQUIRED.
- OWNER PROVIDED, PLUMBER INSTALLED STOP/BFP PANEL. SEE K-SHEET ELEVATIONS FOR EXACT LOCATION. ROUTE 1" DIA SCHED 40 PVC BFP DRAIN TIGHT TO WALL TO TERMINATE AT MOP SINK DRAIN ON OPPOSITE SIDE OF WALL.
- ROUTE DRAIN LINE FULL SIZE TO FLOOR SINK LOCATED BELOW POT SINK AND TERMINATE WITH CODE APPROVED AIR GAP.
- PROVIDE WITH TRAP SEAL PROTECTOR, P-26A.
- INSTALL NEW RESTROOM PLUMBING FIXTURE. MAKE CONNECTION TO EXISTING WASTE LINE LOCATED BELOW SLAB/WITHIN WALL. PLUMBING CONTRACTOR SHALL BE RESPONSIBLE FOR ANY ADDITIONAL PIPE REQUIRED.
- NOT USED
- NEW 3" DIAMETER VENT PIPING UNDER GROUND AND RISER IN WALL. INSTALL WALL CLEANOUT W/ CLEANOUT PLUG CHARLOTTE PIPE NO. 445-X ON RISER AT 3'-0" ABOVE GRADE TO CENTER OF PLUG. INSTALL J.R. SMITH 4760-12"X12" ACCESS DOOR.
- WHERE NEW CONSTRUCTION INTERFERES WITH EXISTING REFUSE PAD WATER LINE, PLUMBING CONTRACTOR SHALL ROUTE NEW 3/4" CW BELOW GRADE AS REQUIRED TO YARD HYDRANT. THERE SHALL BE NO JOINTS BELOW SLAB.

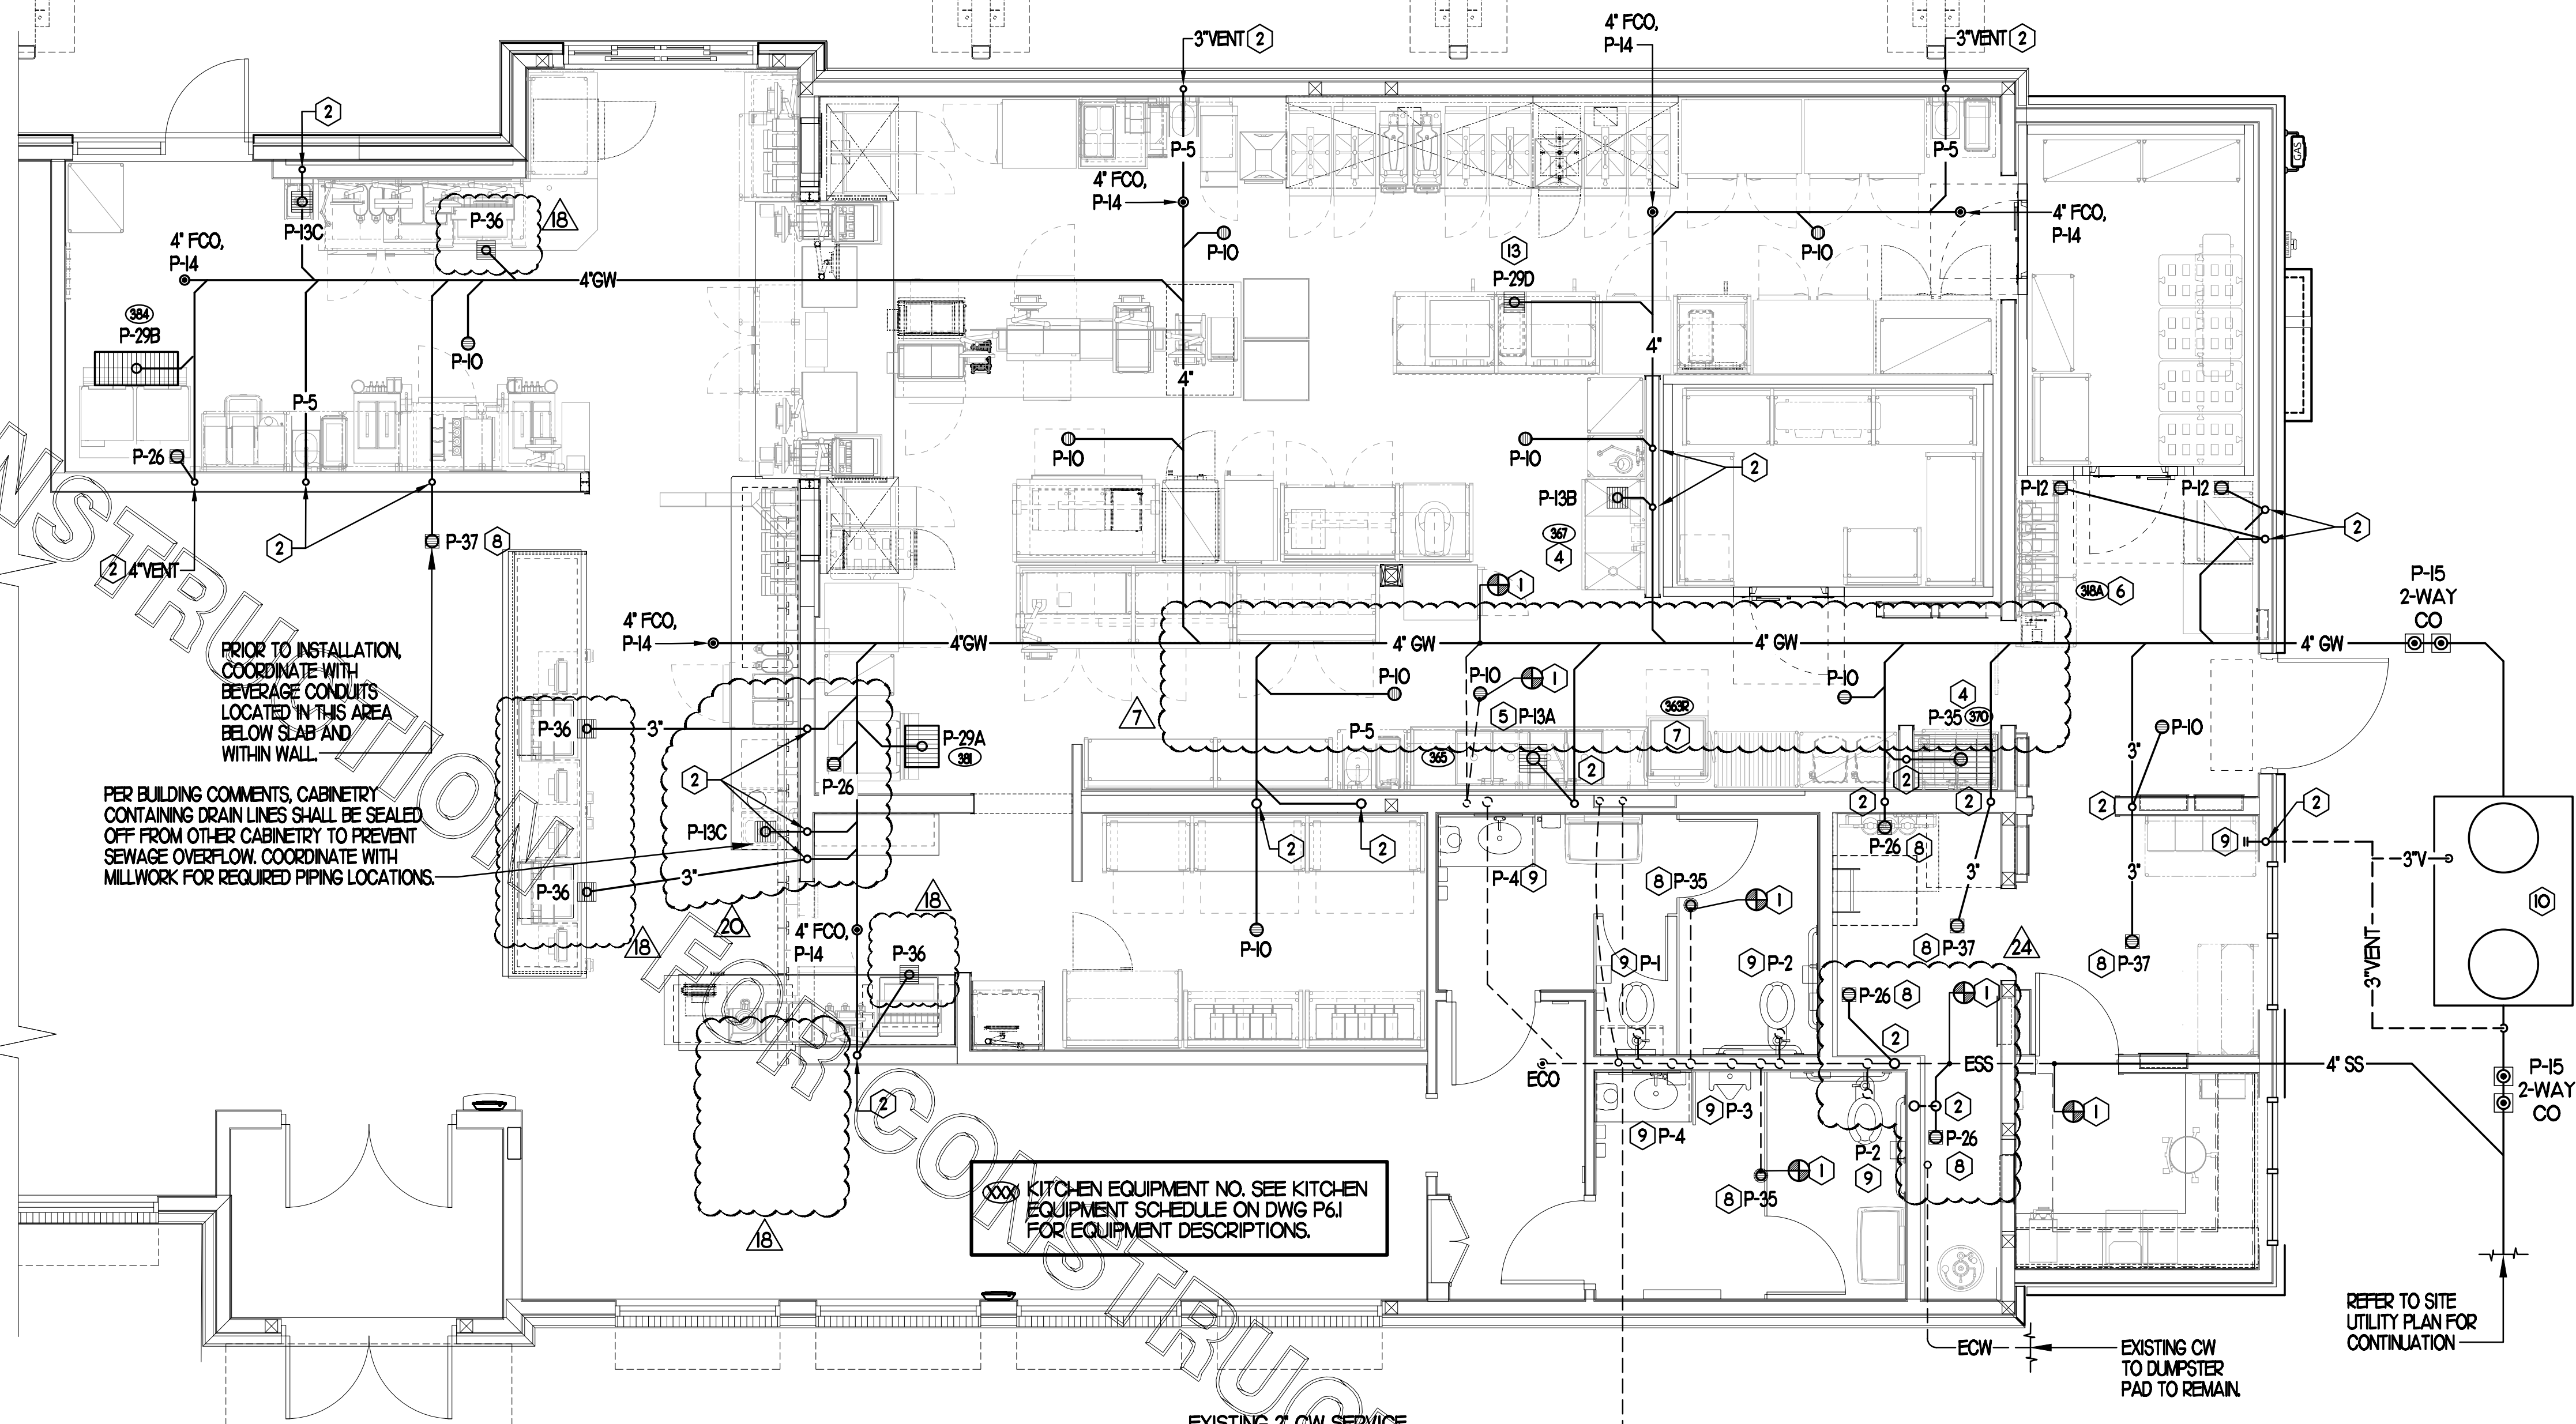


**1 BELOW SLAB PLUMBING PLAN**  
SCALE: 1/4"=1'-0"

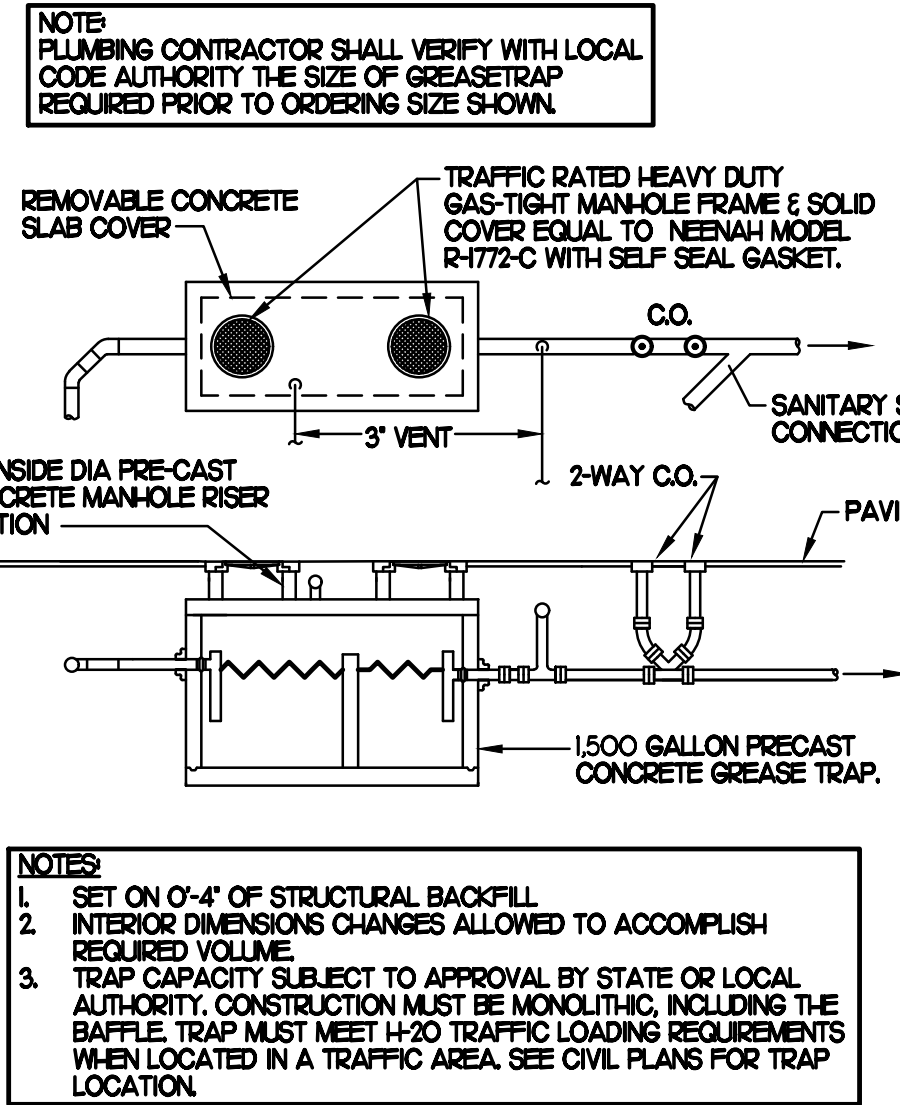

**2 GREASE INTERCEPTOR**  
SCALE: NONE

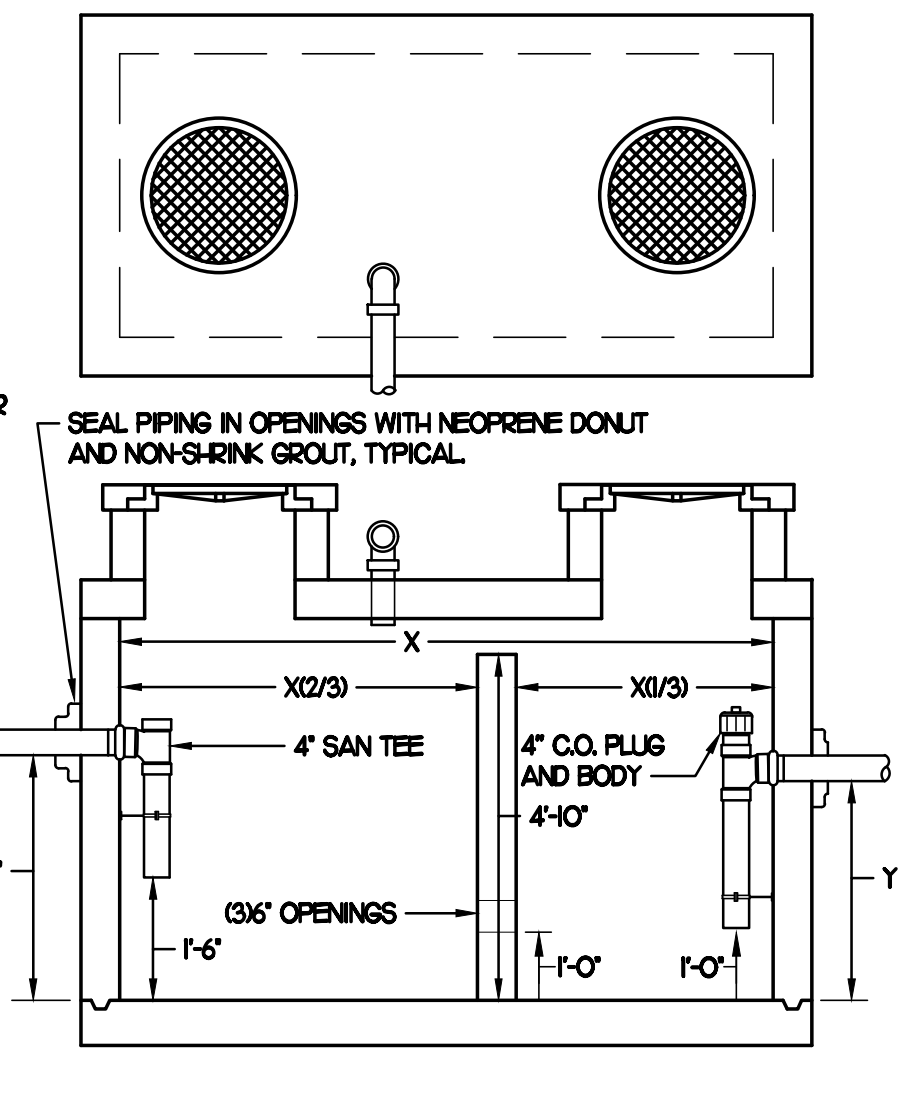

**4 SAN. C.O. OUTSIDE BUILDING**  
SCALE: NONE

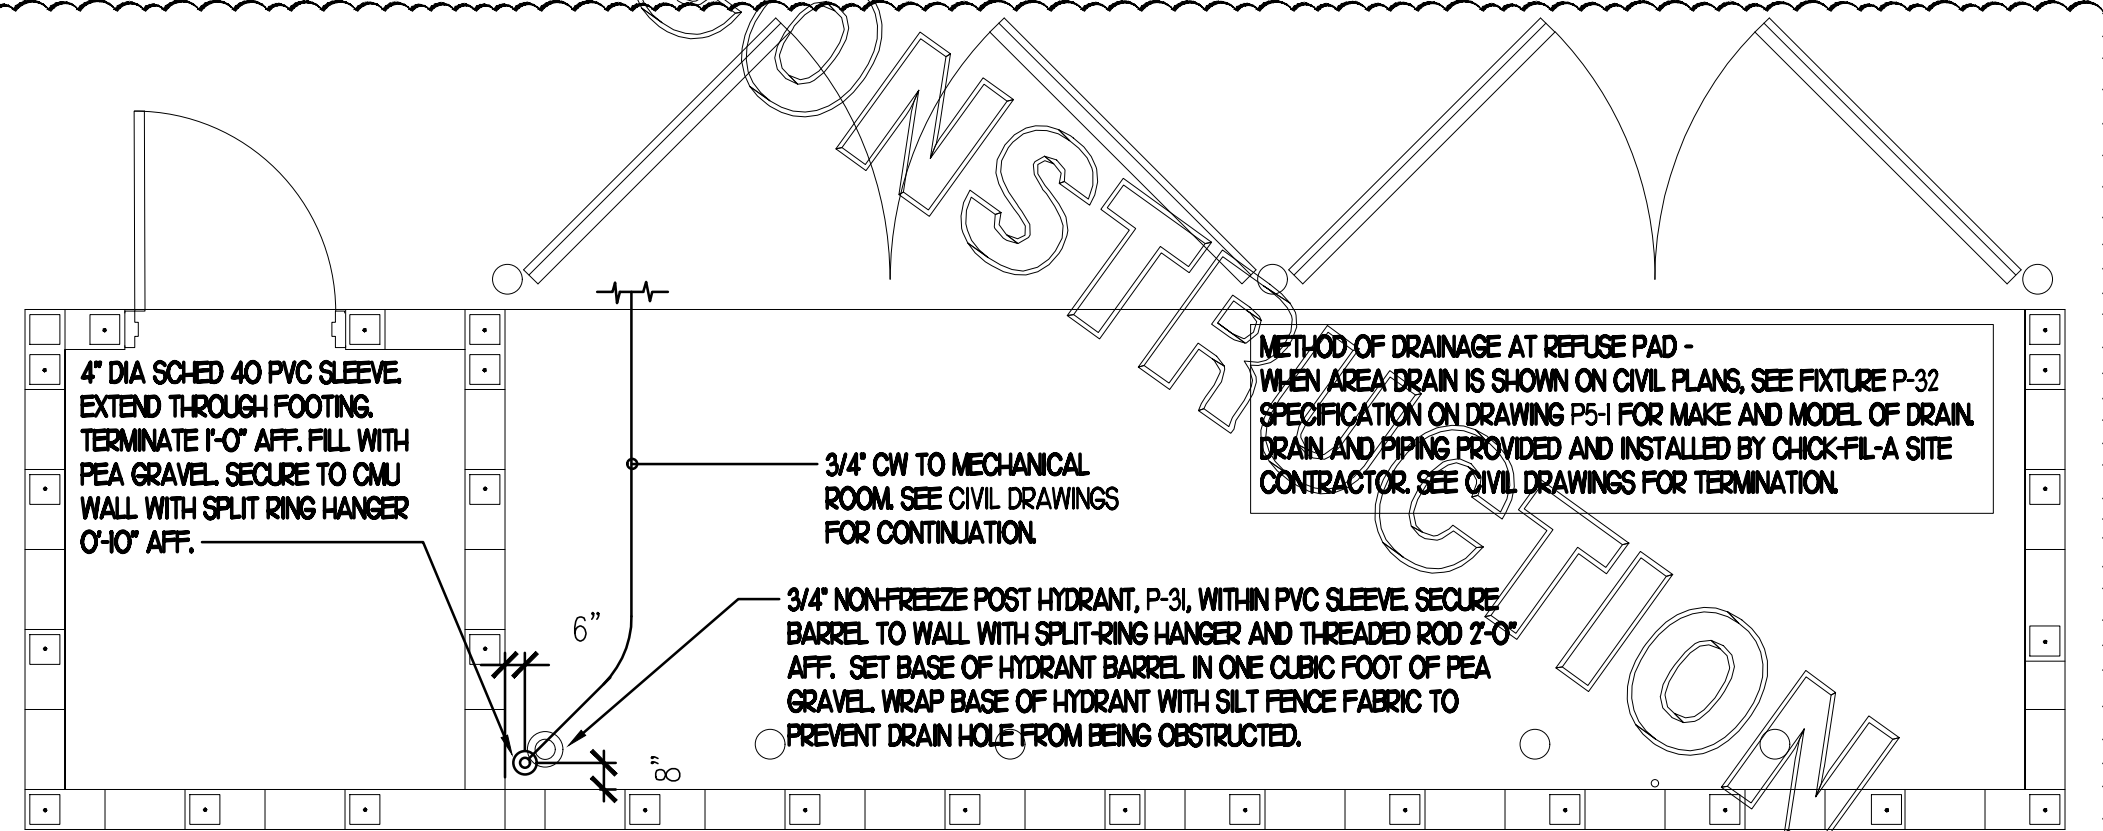


**3 REFUSE PAD PLUMBING**  
SCALE: NONE



Chick-fil-A

Chick-fil-A  
5200 Buffington Road  
Atlanta, Georgia 30349

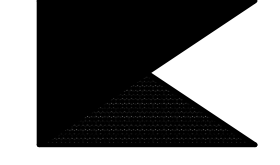

Kurzynske & Associates  
CONSULTING ENGINEERS  
2705 Lebanon Pike - Suite One  
Nashville, Tennessee 37214  
Telephone: (615) 255-8203



**CHICK-FIL-A**  
DELTRAN FSU  
1301 FAIRVIEW BLVD  
DELTRAN, NJ 08075

**FSR#01385**

BUILDING TYPE / SIZE: S97-110  
RELEASE: V05.22

NO.	DATE	DESCRIPTION
7	07/31/23	Pre-bid Comments
18	01/09/24	Design Note
20	02/20/24	CD Coordination
24	04/02/24	CD Comments
CONSULTANT PROJECT # 22146.HF.R		
PRINTED FOR CONSTRUCTION		
DATE 1/30/2023		
DRAWN BY BF		

Information contained on this drawing and in all digital files produced for above named project may not be reproduced in any manner without express written or verbal consent from authorized project representatives.


SHEET BELOW SLAB PLUMBING PLAN

SHEET NUMBER

**P1.1**



**Chick-fil-A**  
5200 Buffington Road  
Atlanta, Georgia 30349

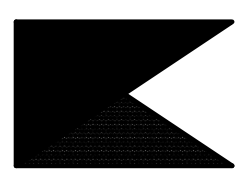

**Kurzynski & Associates**  
CONSULTING ENGINEERS  
2705 Lebanon Pike - Suite One  
Nashville, Tennessee 37214  
Telephone: (615) 255-8203



**CHICK-FIL-A**  
DELTRAN FSU  
1301 FAIRVIEW BLVD  
DELTRAN, NJ 08075

**FSR#01385**

BUILDING TYPE / SIZE: S97-110  
RELEASE: V05.22  
REVISION SCHEDULE

NO.	DATE	DESCRIPTION
7	07/31/23	Pre-bid Comments


18	01/09/24	Design Note
20	02/20/24	CD Coordination
24	04/02/24	CD Comments

CONSULTANT PROJECT # 22146.HF.R  
PRINTED FOR CONSTRUCTION  
DATE 1/30/2023  
DRAWN BY BF

Information contained on this drawing and in all digital files produced for above named project may not be reproduced in any manner without express written or verbal consent from authorized project representatives.

SHEET SLAB ROUGH-IN PLAN  
SHEET NUMBER

**P1.2**

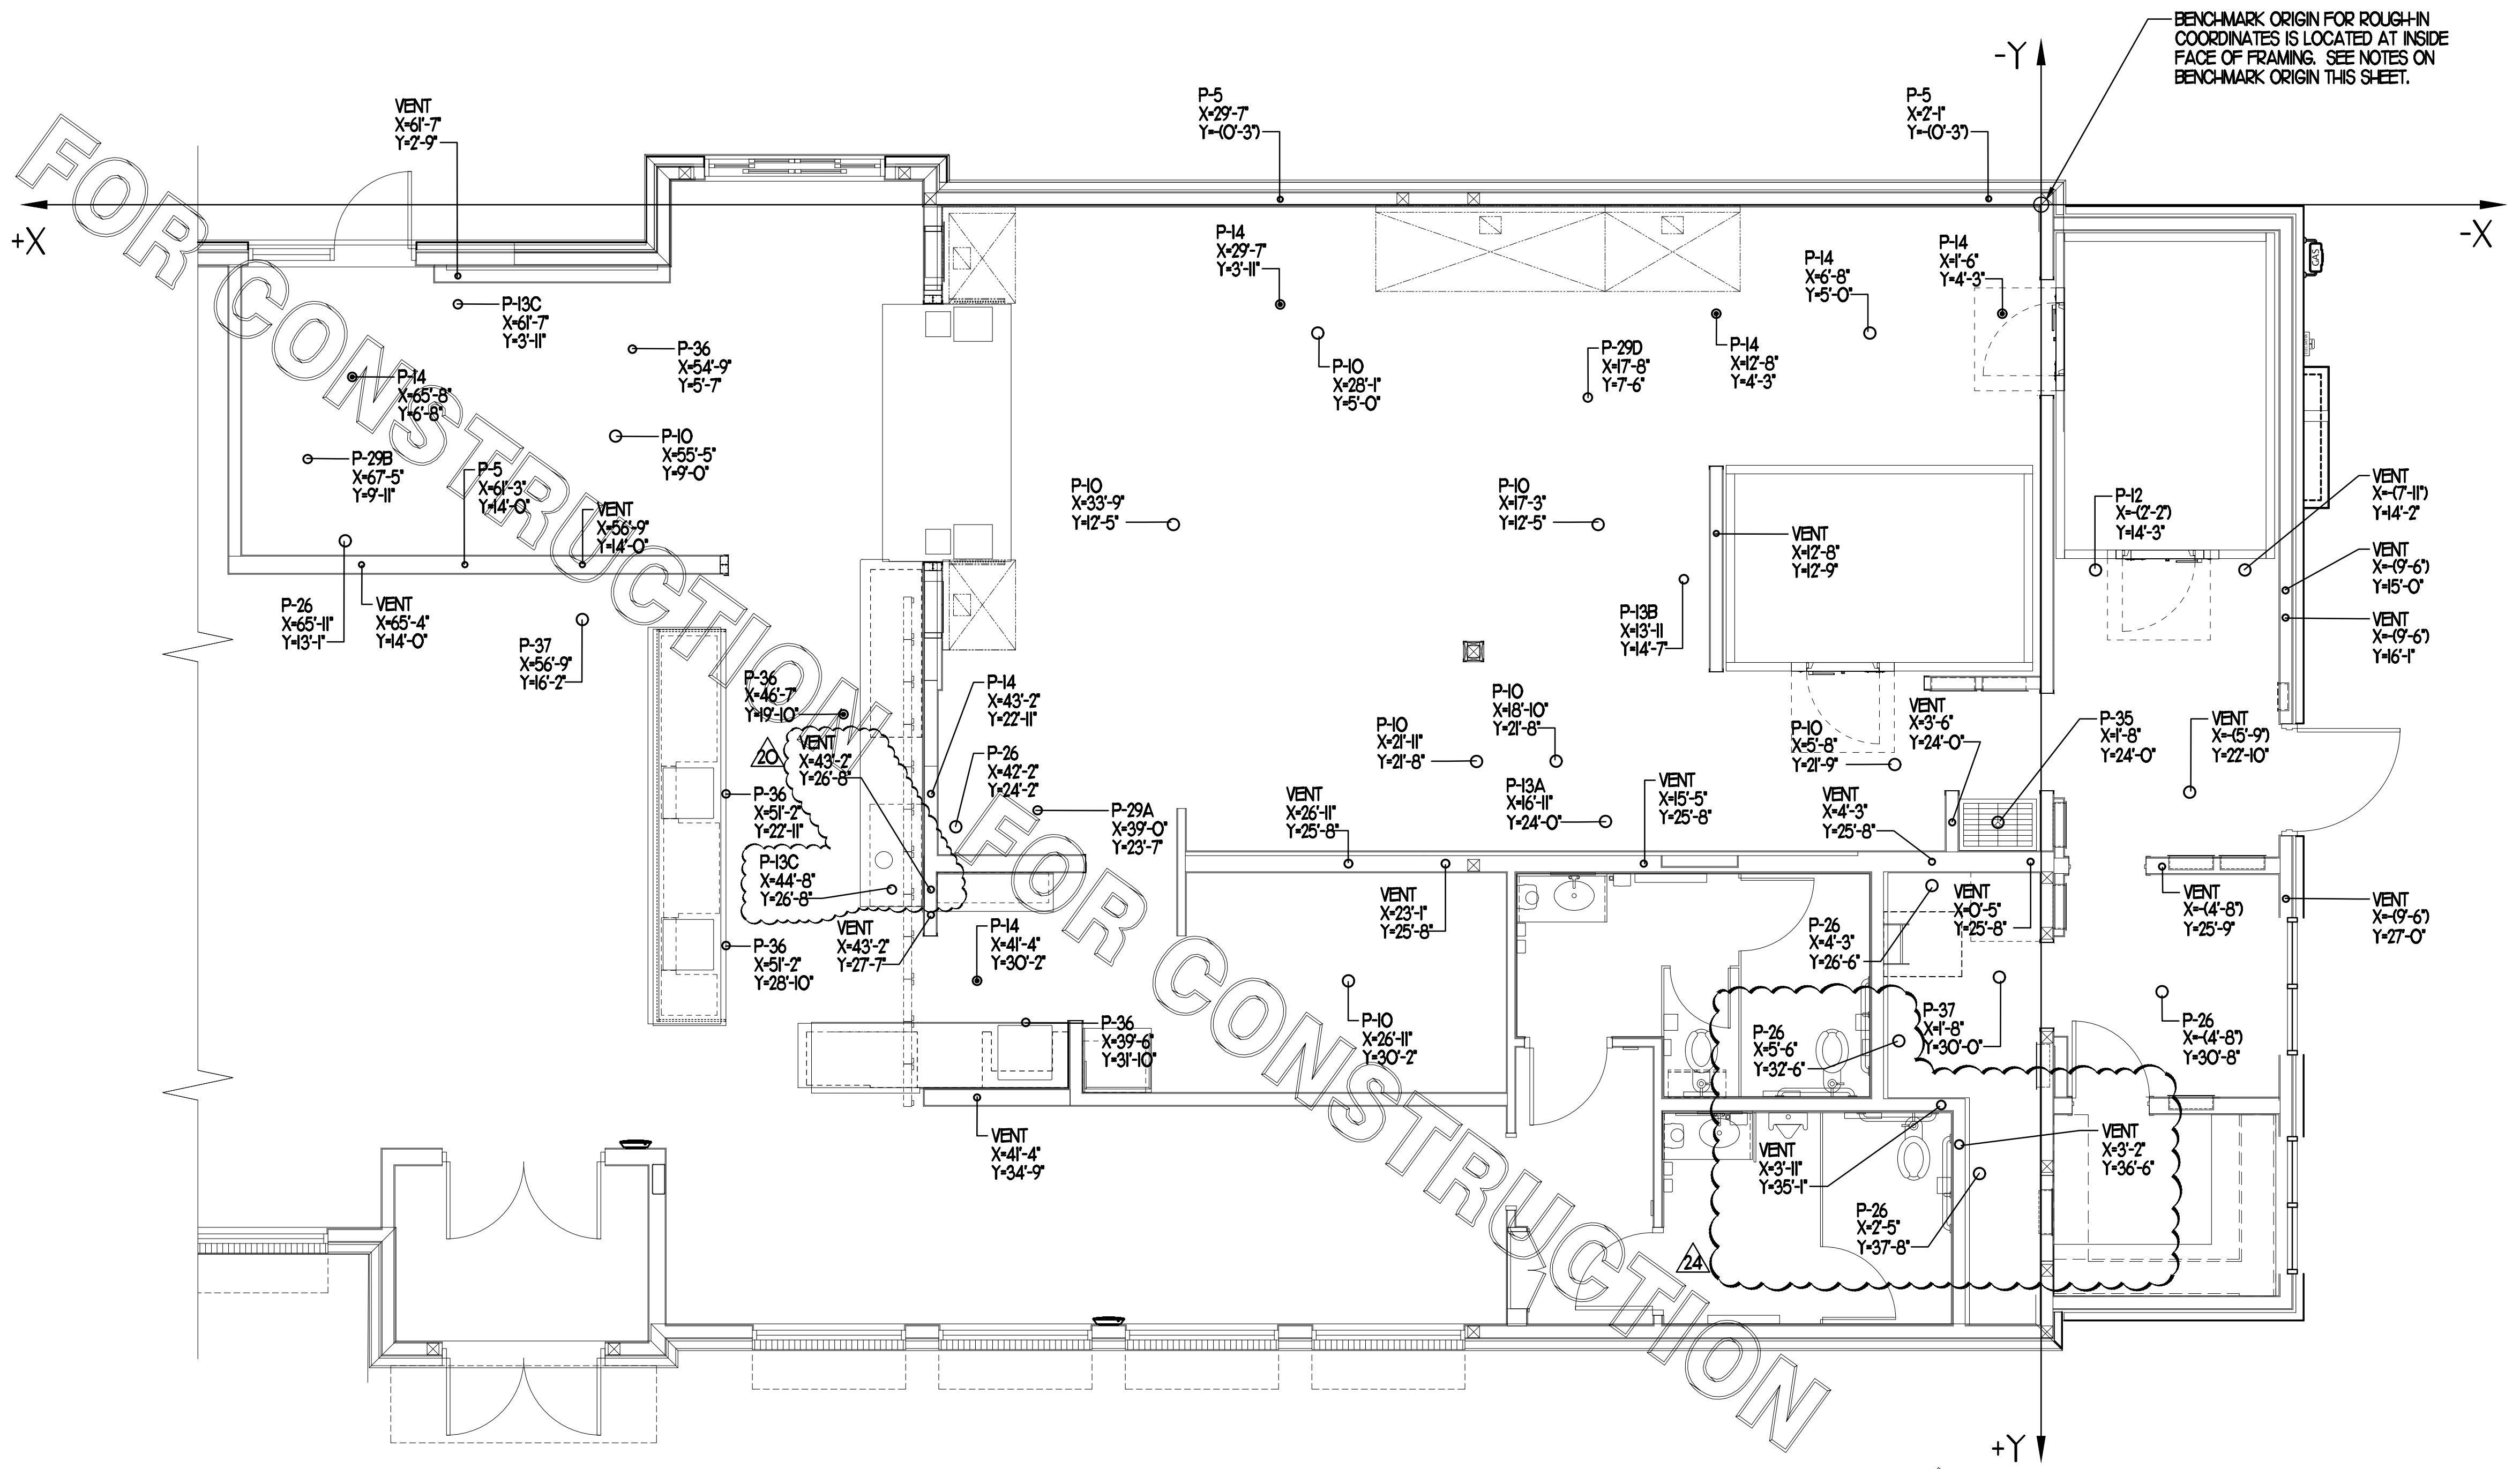

**1 SLAB ROUGH-IN PLAN**  
SCALE: 1/4"=1'-0"

**NOTES ABOUT (0,0) BENCHMARK ORIGIN**

- THE (X-O, Y-O) BENCHMARK ORIGIN IS LOCATED AT THE OUTSIDE FACE OF FRAMING FOR THE EXTERIOR WALL AT THE CORNER WHERE SHOWN ON THE ADJACENT PLAN.
- IT IS EXTREMELY IMPORTANT FOR THE PLUMBING INSTALLER TO BECOME COMPLETELY FAMILIAR WITH THE FACE-OF-FRAMING POSITION AND ITS RELATION TO THE FLOOR SLAB CONSTRUCTION PRIOR TO BEGINNING THE UNDERSLAB PLUMBING ROUGH-IN.
- PLUMBING CONTRACTOR SHALL REVIEW STRUCTURAL DETAIL "TYPICAL SECTION @ EXTERIOR WALL" FOR PRECISE LOCATION OF FACE-OF-FRAMING WITH RESPECT TO THE SLAB INSTALLATION PRIOR TO LOCATING SLAB ROUGH-INS. (THIS DETAIL IS TYPICALLY FOUND ON SHEET S31 OF THE STRUCTURAL SET, DETAIL #4/4A)

**COORDINATE LEGEND**

TYPE	EXAMPLE	PIPE COORDINATES
#1	CW X-43'-8" Y-14'-7"	APPLIES TO WATER PIPING ROUGH-IN PENETRATION ONLY. SEE P/1 FOR CONTINUATION.
#2	VENT X-43'-8" Y-14'-7"	APPLIES TO DWV PENETRATION ONLY.

NOTE: TRAP PRIMER PIPING NOT SHOWN ON THIS PLAN. SEE I/P/1 FOR TRAP PRIMER LOCATIONS.

**NOTE OF SPECIAL IMPORTANCE:**  
BELOW-SLAB BEVERAGE CONDUIT SHALL BE 6" DIAMETER SCHED 40 DWV SOLID WALL, NO FOAM CORE ALLOWED. USE LONG RADIUS ELBOWS (A.K.A. SWEEPS) ON ALL BEVERAGE CONDUIT. PLEASE NOTE BEVERAGE CONDUIT ROUGH-IN LOCATIONS ARE MEASURED TO THE FRACTION OF AN INCH.

**MOP SINK NOTE**  
IMPORTANT: INSTALL P-35 FLOOR DRAIN WITH TOP OF DRAIN 0'-7" BFF. COORDINATE WITH GENERAL CONTRACTOR.

**FLOOR FIXTURE ELEVATIONS**

IMPORTANT: INSTALL THE FLOOR FIXTURES SUCH THAT THE TOP-OF-RIM ELEVATION IS AS FOLLOWS


FIXTURE	TYPE	RIM ELEVATION
P-10	FLOOR DRAIN	1/4" BFF
P-35	MOP SINK DRAIN	7" BFF
P-36	INDIRECT WASTE RECEIVER	1" BFF
P-37	FLOOR DRAIN	1/4" BFF

NOTE: FIXTURE RIM/GRATE SHALL SET BE FLUSH WITH ADJACENT FLOOR. SEE ARCHITECTURAL PLANS FOR FLOOR SLOPE AT SLAB DEPRESSION FOR FIXTURES INSTALLED BELOW FINISHED FLOOR ELEVATION. FLOOR FIXTURES NOT LISTED HERE SHALL BE INSTALLED FLAT AND FLUSH WITH FINISHED FLOOR ELEVATION.

THIS IS A NEW SHEET ADDED TO THE SET.

CONSTRUCTION

P-11 MOUNTED 24" AFG. ORDER HYDRANT WITH 4" WOODFORD WALL THICKNESS. EXTEND SUPPLY TUBE AND OPERATING ROD ASSEMBLY INTO INTERIOR WALL. INSTALL PIPE DROP AND VALVE ON INTERIOR SIDE OF WALL INSULATION.

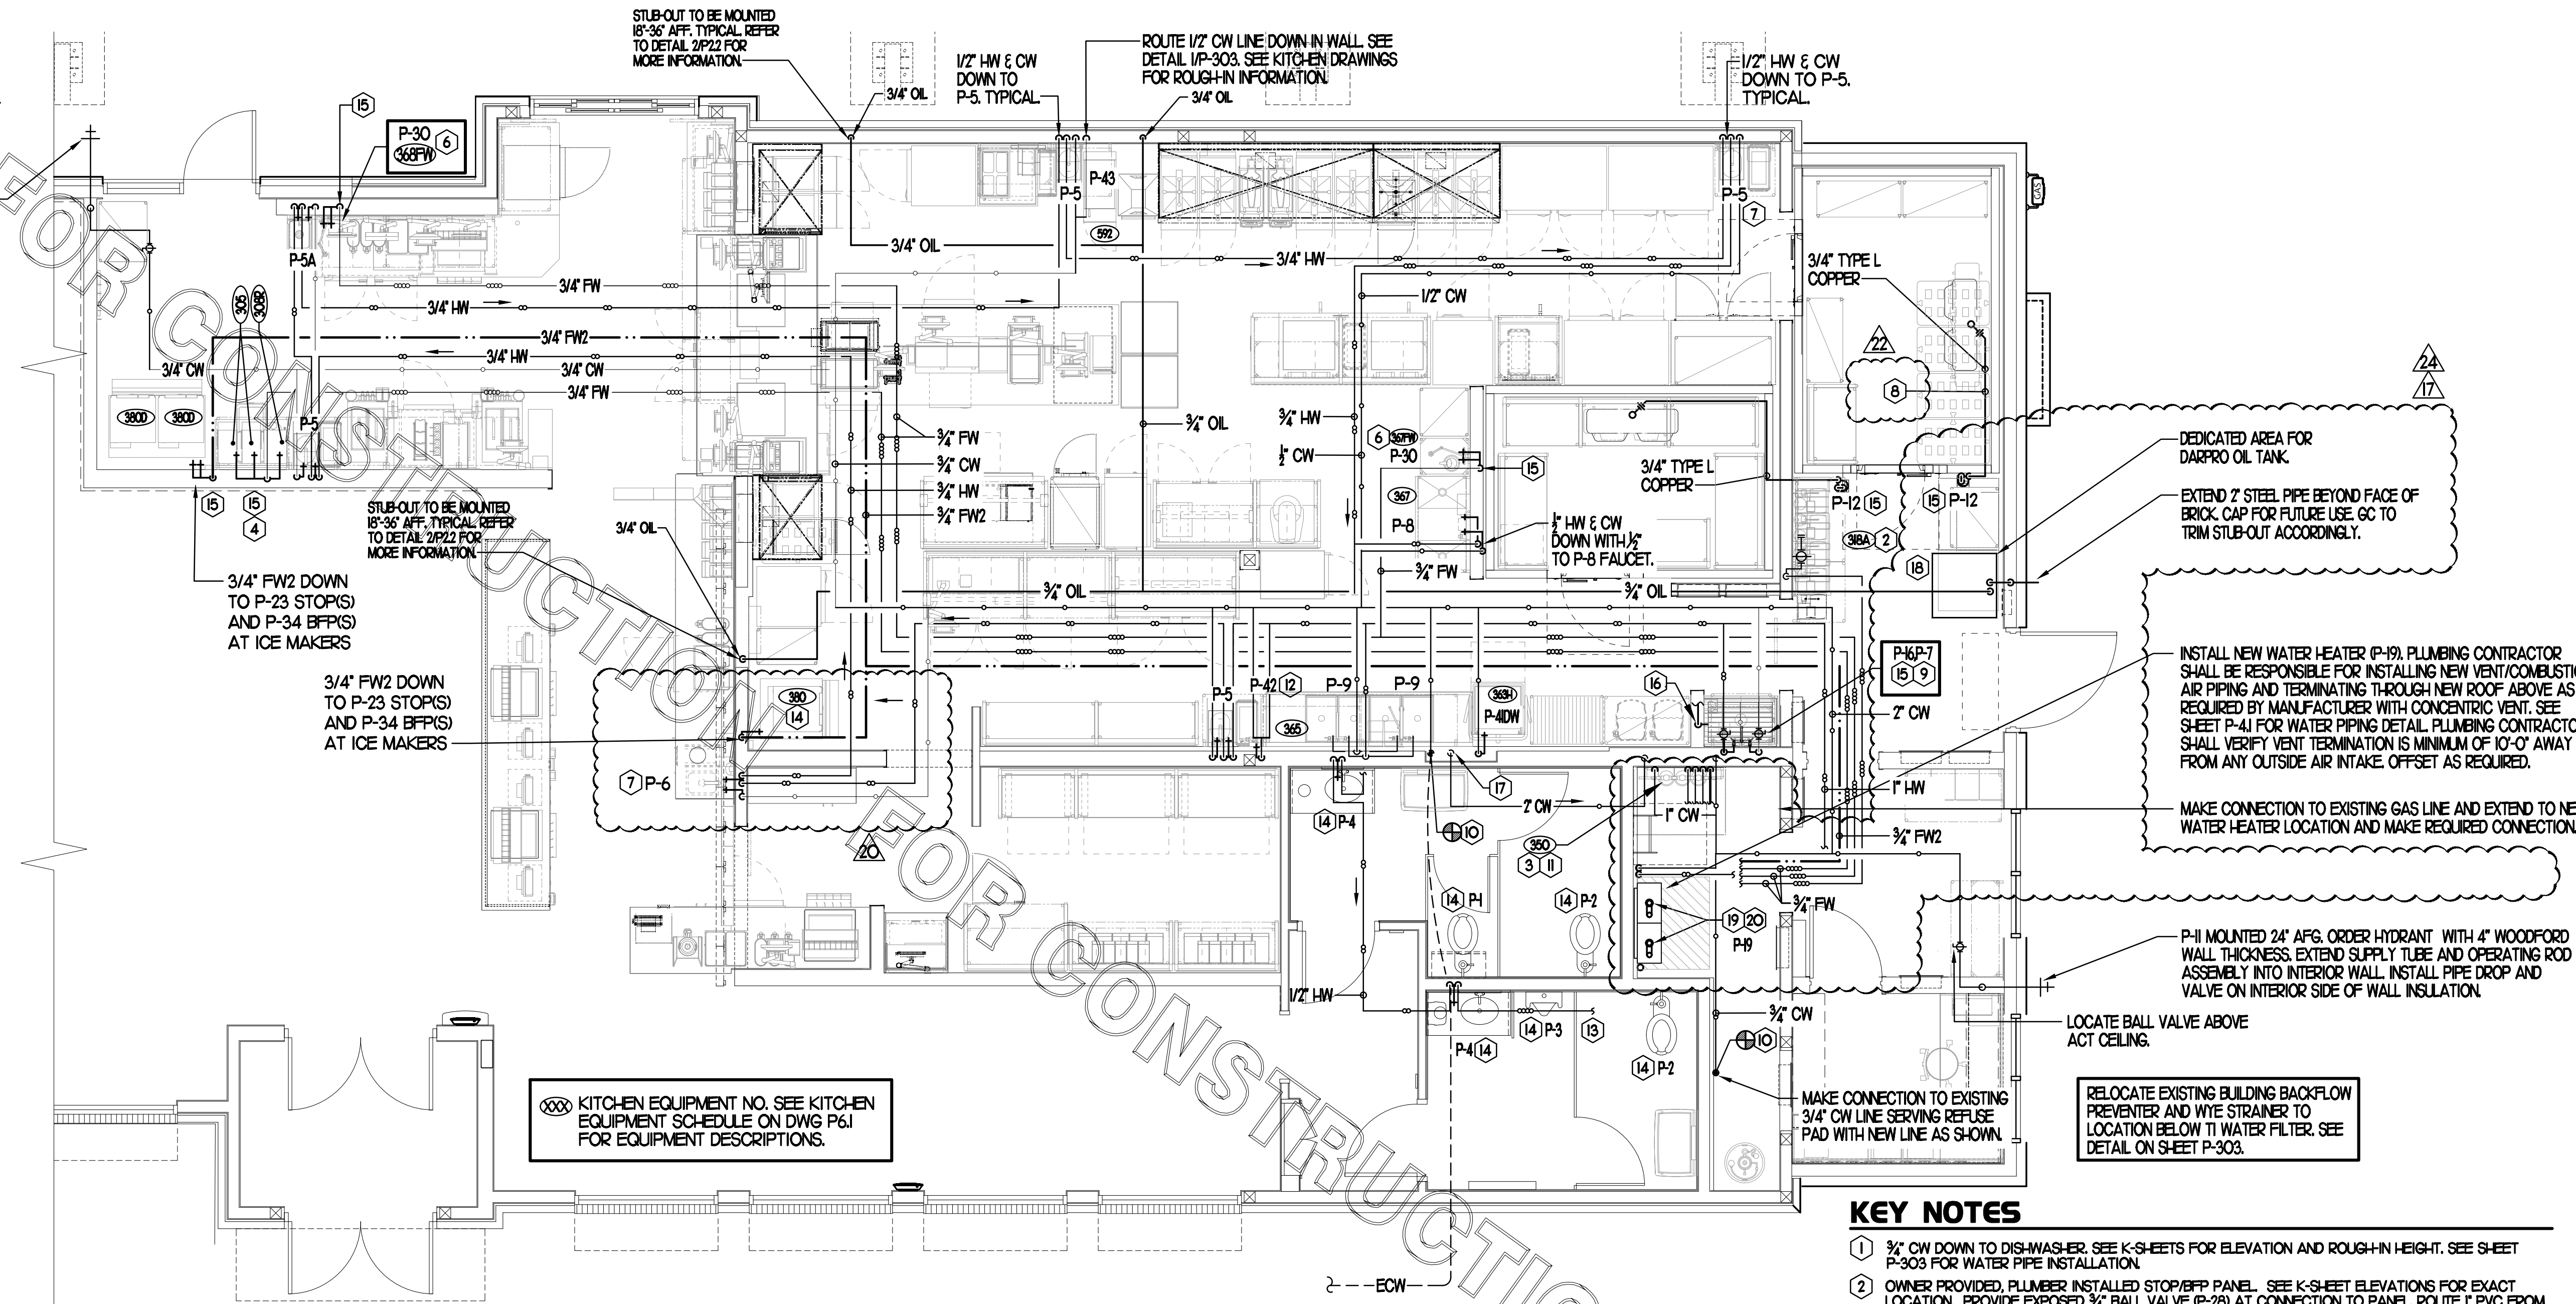

Ⓚ KITCHEN EQUIPMENT NO. SEE KITCHEN EQUIPMENT SCHEDULE ON DWG P-61 FOR EQUIPMENT DESCRIPTIONS.

DEDICATED AREA FOR DARPRO OIL TANK.  
EXTEND 2" STEEL PIPE BEYOND FACE OF BRICK. CAP FOR FUTURE USE. GC TO TRIM STUB-OUT ACCORDINGLY.

INSTALL NEW WATER HEATER (P-19). PLUMBING CONTRACTOR SHALL BE RESPONSIBLE FOR INSTALLING NEW VENT/COMBUSTION AIR PIPING AND TERMINATING THROUGH NEW ROOF ABOVE AS REQUIRED BY MANUFACTURER WITH CONCENTRIC VENT. SEE SHEET P-41 FOR WATER PIPING DETAIL. PLUMBING CONTRACTOR SHALL VERIFY VENT TERMINATION IS MINIMUM OF 10'-0" AWAY FROM ANY OUTSIDE AIR INTAKE. OFFSET AS REQUIRED.

MAKE CONNECTION TO EXISTING GAS LINE AND EXTEND TO NEW WATER HEATER LOCATION AND MAKE REQUIRED CONNECTION.

P-11 MOUNTED 24" AFG. ORDER HYDRANT WITH 4" WOODFORD WALL THICKNESS. EXTEND SUPPLY TUBE AND OPERATING ROD ASSEMBLY INTO INTERIOR WALL. INSTALL PIPE DROP AND VALVE ON INTERIOR SIDE OF WALL INSULATION.

LOCATE BALL VALVE ABOVE ACT CEILING.

RELOCATE EXISTING BUILDING BACKFLOW PREVENTER AND WYE STRAINER TO LOCATION BELOW TI WATER FILTER. SEE DETAIL ON SHEET P-303.

**KEY NOTES**

- 3/4" CW DOWN TO DISHWASHER. SEE K-SHEETS FOR ELEVATION AND ROUGH-IN HEIGHT. SEE SHEET P-303 FOR WATER PIPE INSTALLATION.
- OWNER PROVIDED. PLUMBER INSTALLED STOP/BFP PANEL. SEE K-SHEET ELEVATIONS FOR EXACT LOCATION. PROVIDE EXPOSED 3/4" BALL VALVE (P-28) AT CONNECTION TO PANEL. ROUTE 1" PVC FROM FACTORY PANEL DRAIN CONNECTION TO P-12 FUNNEL DRAIN LOCATED BELOW BEVERAGE RACK.
- FW & FW2 LINES FROM WATER FILTRATION SYSTEM. REFER TO DETAIL ON P-22.
  - 3/4" FW TO CARBONATOR
  - 3/4" FW TO JUICE STATION
  - 3/4" FW TO COFFEE & TEA MAKERS
  - 3/4" FW2 TO ICE MACHINES
- 1/2" FW TO P-24 & P-34 AT TWO (2) TEA BREWERS AND ONE COFFEE MAKER. SEE DETAIL THIS SHEET.
- TURN 3/2" CONDENSATE PIPING OUT OF COOLER/FREEZER AND EXTEND OUTLET TO P-12 FUNNEL DRAIN. SECURE PIPING TO COOLER WALL WITH RUBBER INSULATED PIPE CLAMPS TO PREVENT GALVANIC CORROSION. SEAL ALL PENETRATIONS IN WALLS WITH PERMAGUM CORD. TERMINATE ABOVE FUNNEL WITH ELBOW AND AIR GAP. PROVIDE 2" DEEP TRAP WITH OPEN TEE OUTLET.
- 3/4" FW DROP TO TWO-HANDLE FAUCET P-30. MOUNT FAUCET ON WALL. SEE K-SHEETS FOR EXACT LOCATION. PIPE 1/2" FW TO EACH FAUCET INLET WITH 6" SPREAD. PROVIDE BALL VALVE ABOVE CEILING.
- PROVIDE 1/2" HW & CW CONNECTIONS TO FIXTURE.
- APPLY RATCHMAN XL-TRACE MODEL 561-1 SELF REGULATING HEATING CABLE. USE END SEAL KIT FROM MANUFACTURER. CONTRACTOR SHALL HEAT TRACE ENTIRE LENGTH OF CONDENSATE PIPING UNTIL TERMINATION POINT.
- INSTALL P-36 3-WAY VALVE WITH BACKFLOW PREVENTER ON P-7 FAUCET SPOUT FOR CONNECTION TO ECO LAB DETERGENT DISPENSER. SEE DETAIL THIS SHEET. PROVIDE BALL VALVE FOR EACH WATER LINE ABOVE CEILING WITH P-22 BALL CHECK VALVE IN EACH DROP.
- MAKE CONNECTION TO EXISTING WATER LINE ABOVE CEILING/WITHIN WALL.
- NEW WATER FILTERS. SEE DETAIL P-22.
- ROUTE 1/2" HW & CW TO P-42 EMERGENCY EYEWASH MIXING VALVE. ROUTE 1/2" TW FROM P-42 VALVE TO EMERGENCY EYEWASH STATION.
- 1/2" HOT WATER RETURN LINE. MAKE CONNECTION TO CW INLET SIDE OF WATER HEATER. SEE DETAIL 4P14.
- INSTALL NEW FIXTURE IN RESTROOM. RECONNECT TO EXISTING CW FOR TR. VENT & SANITARY SEWER SERVICES.
- INSTALL SHOCK ABSORBER (P-25) AT TOP OF WATER LINE DROP DOWN TO FIXTURE.
- 1/2" INSULATED CONDENSATE PIPING WITHIN WALL DOWN FROM ROOF. TERMINATE OVER MOP SINK 1'-0" ABOVE GRABE WITH 90 DEGREE ELBOW AND ESCUTCHEON. SEE DETAIL FOR CONTINUATION.
- PLUMBING CONTRACTOR SHALL EXTEND WATER SERVICE LINE OVERHEAD TOWARD P-28 BACKFLOW PREVENTER, STRAINER, AND WYE (P-40) ASSOCIATED VALVES LOCATED AS SHOWN. THERE SHALL BE NO TAKE-OFFS PRIOR TO BACKFLOW PREVENTER. ROUTE NEW LINE SIZED SAME AS EXISTING MAIN ENTRANCE OVER-HEAD AND MAKE CONNECTION TO EXISTING LINES (HW & CW) SERVING THE RESTROOMS. FIELD VERIFY EXACT LOCATIONS. CONTRACTOR SHALL ALSO RELOCATE/PROVIDE NEW WATER BOOSTER PUMP LOCATED ABOVE TI WATER FILTER. REINSTALL PER EXISTING CONDITIONS.
- TURN 3/4" & 2" SCHEDULE 40 STEEL PIPE DOWN THROUGH CEILING FOR FUTURE DARPRO OIL TANK AND CAP ACCORDINGLY. PROVIDE CHROMED ESCUTCHEONS AT CEILING PENETRATIONS. 1" OIL LINE TO BE CAPPED 2' BELOW CEILING. PROVIDE 3/4" DIAMETER SCHEDULE 40 (BLACK OR GALVANIZED) STEEL PIPING BACK TO FUTURE DARPRO OIL TANK. PIPING TO BE ROUTED TO ALLOW AS MUCH FALL AS POSSIBLE TO THE TANK.
- WATER HEATER CONCENTRIC PIPE VENT UP TO ROOF. OFFSET WITH MECHANICAL ROOM AS NECESSARY TO MAINTAIN 5'-0" CLEARANCE FROM PARAPET. SEE DETAIL P-210 FOR WATER HEATER VENT ROOF PENETRATION.
- DISCHARGE CONDENSATE DRAIN PIPE INTO FUNNEL DRAIN LOCATED BELOW. CONDENSATE DRAIN PIPE SHALL BE ROUTED TIGHT TO WALL AND SHALL BE ROUTED THROUGH COMMERCIAL NEUTRALIZATION TANK W/MEDIA PRIOR TO DISCHARGE.


**PIPING LEGEND**

EXISTING COLD WATER (ECW)	ECW
EXISTING HOT WATER (EHW)	EHW
EXISTING FILTERED WATER (EPW)	EPW
EXISTING PREFILTERED WATER (EPW)	EPW
POINT OF CONNECTION	⊕
NEW COLD WATER	CW
NEW HOT WATER	HW
NEW TEMPERED WATER	TW
NEW FILTERED WATER	FW
NEW FW2 TO COFFEE/TEA BREWERS	FW2
BEVERAGE CONDUIT	---


**SHEET NOTES**

- COORDINATE VENT TERMINAL LOCATIONS WITH FRESH AIR HOODS ON ROOFTOP EQUIPMENT SO AS TO MAINTAIN MINIMUM 15'-0" CLEARANCE.
- HOLD ALL PIPING ABOVE THE CEILING TIGHT TO STRUCTURE. DUCT LOCATIONS TAKE PRIORITY. SEE DRAWING MJI FOR DUCT LAYOUT. COORDINATE CONFLICTS WITH GC.
- SEE K-SHEET ELEVATIONS FOR KITCHEN EQUIPMENT WATER PIPING ROUGH-IN LOCATIONS.
- VERIFY WALL TYPE AND WALL THICKNESS AT EXTERIOR HOSE BIBS PRIOR TO ORDERING EQUIPMENT.
- COORDINATE ABOVE-CEILING PIPING LOCATIONS AND ROUTING WITH HVAC CONTRACTOR AND M-SHEETS PRIOR TO INSTALLATION. ALL MAIN DUCT TRUNK LOCATIONS SHALL TAKE PRIORITY. PIPING MAY REQUIRE REMOVAL AND REINSTALLATION AT PLUMBING CONTRACTOR'S EXPENSE IF PIPING OBSTRUCTS THE M-SHEET DUCT LAYOUT AS SHOWN OR PREVENTS ACCESS TO GREESE DUCT CLEANOUT OPENINGS.
- UNLESS NOTED OTHERWISE, WATER PIPING SHALL BE COPPER OR CPVC AS LISTED IN SPECIFICATIONS. SEE SPECIFICATIONS.

**1 ABOVE SLAB PLUMBING PLAN**

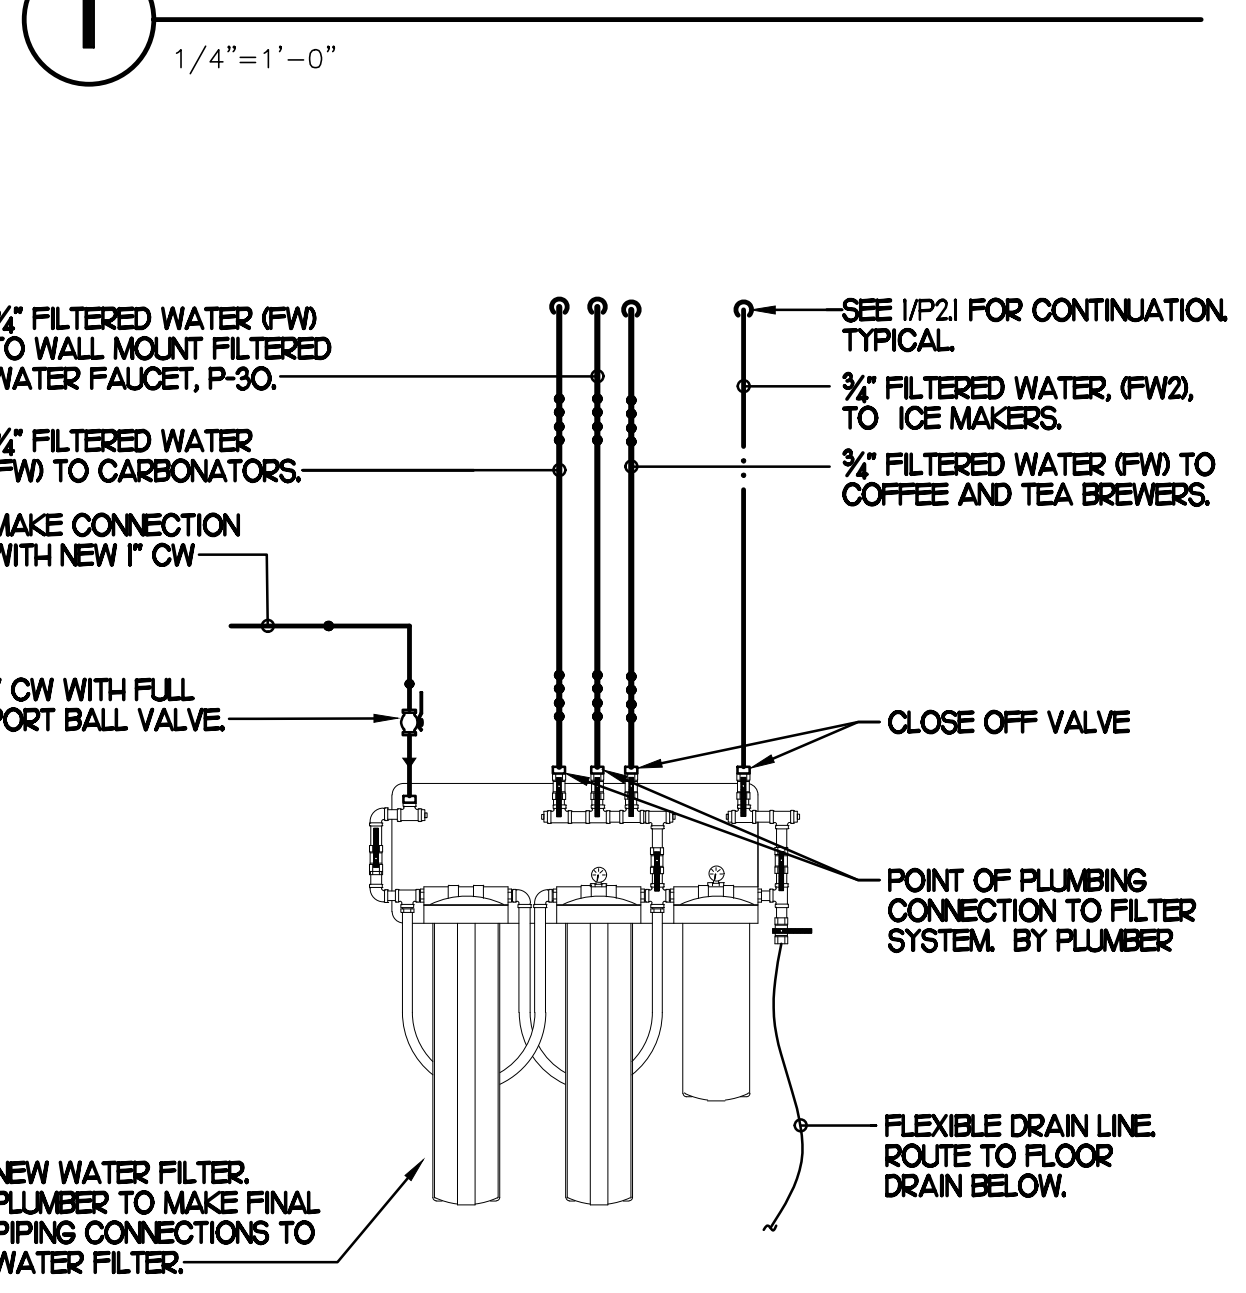

**9 WATER FILTER RISER PIPING**  
SCALE: NONE

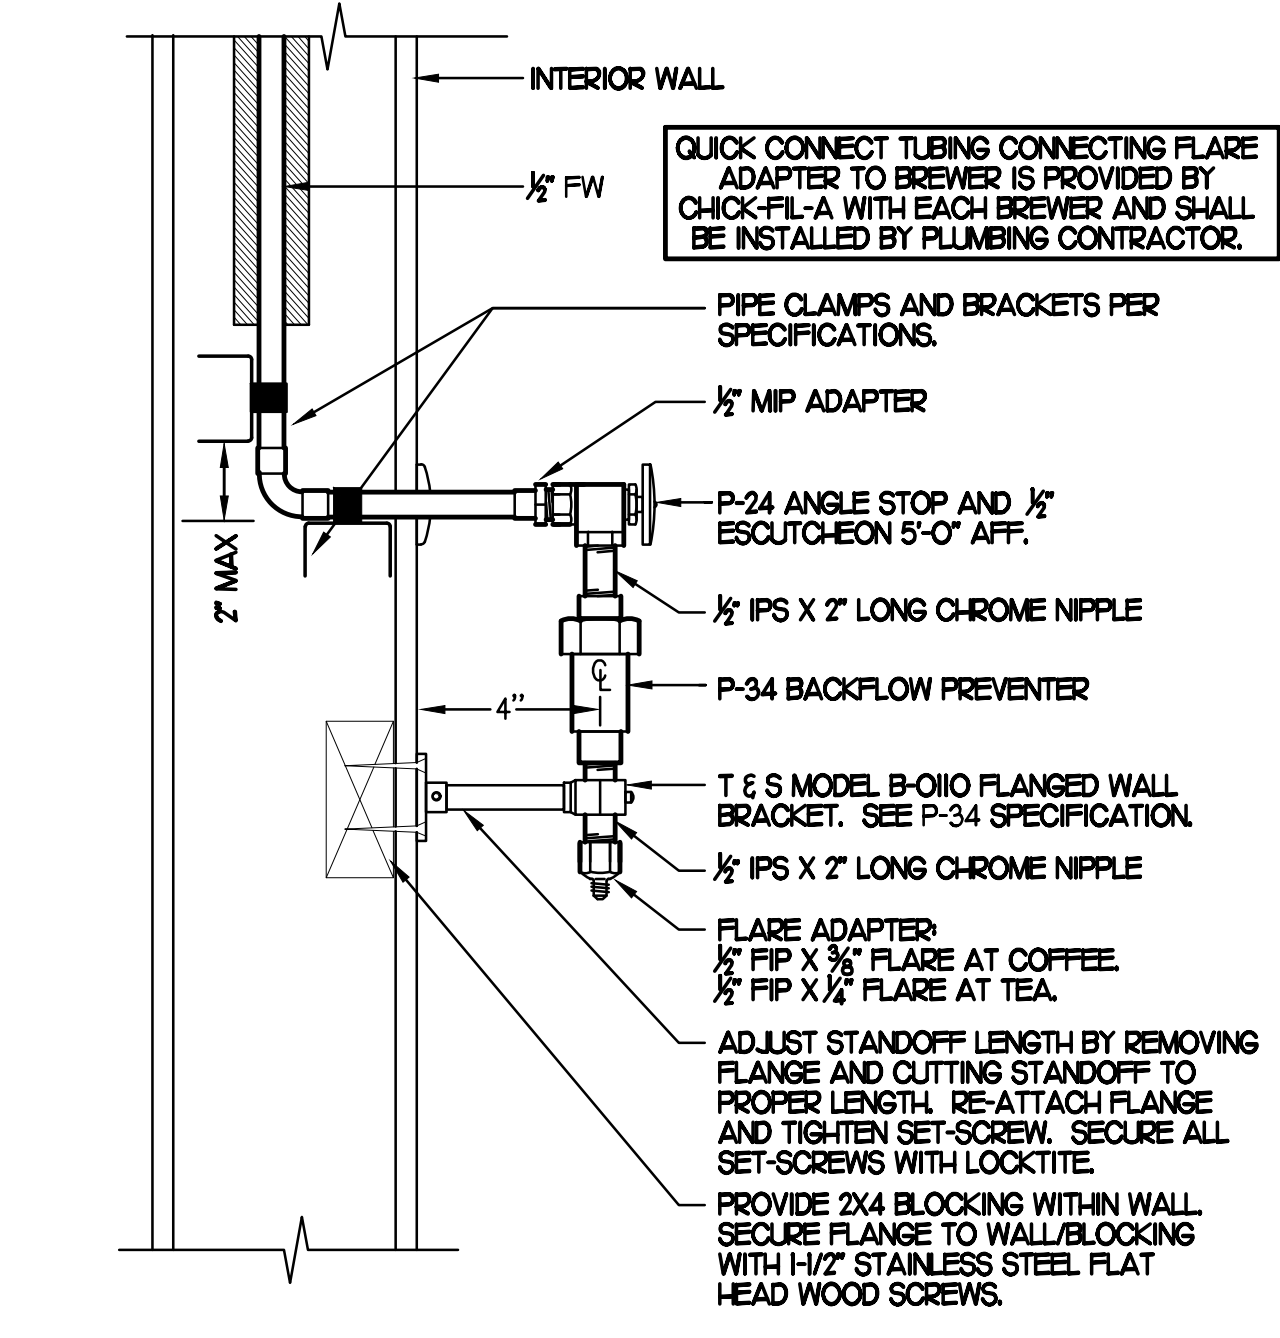

**6 COFFEE & TEA BREWER STOP & BFP**  
NO SCALE



Chick-fil-A

Chick-fil-A  
5200 Buffington Road  
Atlanta, Georgia 30349



**Kurzynske & Associates**  
CONSULTING ENGINEERS  
2708 Lebanon Pike - Suite One  
Nashville, Tennessee 37214  
Telephone: (615) 255-9203



**CHICK-FIL-A**  
**DELTRAN FSU**  
1301 FAIRVIEW BLVD  
DELTRAN, NJ 08075

**FSR#01385**

BUILDING TYPE / SIZE:	S97-110	
RELEASE:	v05.22	
<b>REVISION SCHEDULE</b>		
NO.	DATE	DESCRIPTION
7	07/31/23	Pre-bid Comments
17	01/09/24	Kitchen Coordination
20	02/20/24	CD Coordination
22	03/07/24	Pre-Con Comments
24	04/02/24	CD Comments
CONSULTANT PROJECT # 22146.HF.R		
PRINTED FOR	CONSTRUCTION	
DATE	1/30/2023	
DRAWN BY	BF	

Information contained on this drawing and in all digital files produced for above named project may not be reproduced in any manner without express written or verbal consent from authorized project representatives.  
SHEET ABOVE SLAB PLUMBING PLAN  
SHEET NUMBER

**P2.1**

CONSTRUCTION

4" DIA SCHED 40 PVC BEVERAGE CONDUIT DOWN IN WALL. START ABOVE CEILING AND TURN OUT THRU WALL TOWARDS DRIVE-THRU DRINK TOWER WITH BOTTOM EDGE OF WALL PENETRATION 0'-8" ABOVE FINISHED FLOOR. LOCATE PENETRATION ALONG WALL AT CENTER OF DRINK TOWER. SEE BEVERAGE CONDUIT NOTE #7.

### BEVERAGE CONDUIT NOTES

1. REUSE EXISTING BEVERAGE CONDUITS OR THEIR PORTIONS WHERE INDICATED ON DRAWINGS. ROUTE BEVERAGE SYSTEM PIPING OVER-HEAD FROM THE BEVERAGE RACK TO DRINK TOWERS IN 6" SCH 40 PVC CONDUITS. ALL CONDUITS SHALL BE HELD TIGHT TO STRUCTURE AND SUPPORTED WITH THREADED ROD AND CLEVIS HANGERS AT INTERVALS SHOWN IN SPECIFICATIONS FOR HORIZONTAL OVER-HEAD PIPING. COORDINATE ROUTING WITH THE GENERAL CONTRACTOR TO AVOID MECHANICAL AND ELECTRICAL SYSTEMS.
2. COORDINATE ROUTING OF ALL CONDUITS WITH HVAC DUCT IN KITCHEN. SEE SHEET M-11 FOR LOCATION OF AC UNITS AND DUCT ROUTING.
3. TURN CONDUITS DOWN THROUGH THE CEILING AT THE BEVERAGE RACK AND PROVIDE CHROME ESCUTCHEONS AT CEILING PENETRATIONS. TERMINATE OPPOSITE END ABOVE CEILING OVER SERVING AREA OR TURN DOWN TO WALLS, AS PER PLANS.
4. INSTALL CONTINUOUS CONDUIT FROM CO2 FILL-BOX LOCATION TO BULK CO2 TANK AS SHOWN ON PLANS AND DETAILS. COORDINATE 4" CONDUIT WALL STUB INSTALLATION CLOSELY WITH GENERAL CONTRACTOR AND BRICK MASON. PRIOR TO COVERING UP OF CONDUIT, VERIFY WITH GENERAL CONTRACTOR THE FULL LENGTH OF FILL/VENT TUBING MAY BE INSTALLED AND SUBSEQUENTLY REMOVED FROM CONDUIT. SEE PLAN AND DETAIL #6 THIS SHEET.
5. ROUTE 2" DIA BULK CO2 CONDUIT ABOVE CEILING. PROVIDE CHROME ESCUTCHEON AT WALL WITH 45 DEGREE ELBOW TIGHT TO ESCUTCHEON AND DIRECTED DOWNWARD. TERMINATE INTERIOR END OF CONDUIT 1'-0" ABOVE KITCHEN CEILING WITH 90 DEGREE ELBOW DIRECTED TOWARD CARBONATORS. EXTEND 2" DIA CONDUIT FROM WITHIN 1'-0" OF ELBOW TOWARD CARBONATORS. TERMINATE OPPOSITE END ABOVE CEILING ABOVE CARBONATORS.
6. AT CONDUIT DROP IN DRIVE-THRU, PROVIDE 1/8TH BEND FITTING WITH SHORT PIPE STUB AT BASE OF DROP. CUT STUB AND FITTINGS FLUSH WITH FINISHED WALL.
7. FOR BEVERAGE CONDUIT DROPS AT WALL WITH SHEATHING ABOVE THE CEILING, PROVIDE APPROPRIATE FITTING AT UPPER END OF CONDUIT DROP TO EXTEND CONDUIT THROUGH SHEATHING.

6" BEVERAGE CONDUIT BELOW SLAB (TYPICAL OF 2)

PLUMBING CONTRACTOR SHALL COORDINATE BEVERAGE CONDUIT INSTALLATION WITH FLOOR DRAIN LOCATIONS AND ANY ELECTRICAL CONDUITS PRIOR TO INSTALLATION SO AS NOT TO INTERFERE. TYPICAL OF ALL BEVERAGE CONDUITS.

PLUMBING CONTRACTOR SHALL COORDINATE WITH ARCHITECTURAL AND CFX SHOP DRAWINGS FOR BEVERAGE CONDUIT STUB-UP LOCATION PRIOR TO INSTALLATION AND SLAB CUTTING. (TYPICAL OF 2).

TWO (2) - 6" DIA SCHED 40 BEVERAGE CONDUITS UP FROM BELOW SLAB. EXTEND WITHIN WALL. TERMINATE ABOVE CEILING WITH 90 DEGREE LONG TURN ELBOW.

6" DIA SCHED 40 PVC BEVERAGE CONDUIT DOWN IN WALL. START ABOVE CEILING AND TURN OUT THRU WALL TOWARDS DRIVE-THRU DRINK TOWER WITH BOTTOM EDGE OF WALL PENETRATION 0'-8" ABOVE FINISHED FLOOR. LOCATE PENETRATION ALONG WALL AT CENTER OF DRINK TOWER. SEE BEVERAGE CONDUIT NOTE #7.

6" DIAMETER BEVERAGE CONDUITS ABOVE CEILING. (TYP)

2" CO2 CONDUIT ABOVE CEILING. SEE BEVERAGE CONDUIT NOTE #5.

### BEVERAGE CONDUIT PIPING PLAN

1/4" = 1'-0"

PRIOR TO DEMOLITION OF ANY EXISTING CONDUITS, PLUMBING CONTRACTOR SHALL COORDINATE WITH BEVERAGE PROVIDER IF EXISTING CONDUITS ARE ADEQUATE. ALL EXISTING CONDITIONS SHALL BE VERIFIED PRIOR TO BID.

FIXTURE CONNECTION SCHEDULE						
MARK	FIXTURE	FW	FW2	CW	HW	WASTE
P-1	WATER CLOSET - FLOOR MOUNT (1.6 GPF)	X	X	1"	X	4"
P-2	WATER CLOSET - ADA FLOOR MOUNT (1.6 GPF)	X	X	1"	X	4"
P-3	URINAL - ADA WALL HUNG (1.0 GPF)	X	X	3/4"	X	2"
P-4	LAVATORY - ADA COUNTER TOP (0.50 GPM)	X	X	1/2"	1/2"	H/4"
P-5	KITCHEN HAND SINK - WALL HUNG (1.0 GPM)	X	X	1/2"	1/2"	H/2"
P-5A	KITCHEN DUMP SINK - WALL HUNG (1.0 GPM)	X	X	1/2"	1/2"	H/2"
P-6	SINGLE COMP SINK - COUNTERTOP (1.0 GPM)	X	X	1/2"	1/2"	H/2"
P-7	MOP SINK	X	X	1/2"	1/2"	3"
P-8	VEGETABLE PREP SINK (0.65 GPM SPRAYER)	X	X	1/2"	1/2"	(2) H/2"
P-9	POT SINK (0.65 GPM SPRAYER)	X	X	(2) 1/2"	(2) 1/2"	(4) H/2"
P-10	FLOOR DRAIN (ROUND TOP)	X	X	X	X	3"
P-11	WALL HYDRANT (NON FREEZE)	X	X	3/4"	X	X
P-12	FUNNEL DRAIN (3")	X	X	X	X	3"
P-13A	FLOOR SINK (3") 12" TOP	X	X	X	X	3"
P-13B	FLOOR SINK (3") 8" TOP	X	X	X	X	3"
P-13C	FLOOR SINK (3")	X	X	X	X	3"
P-14	CLEANOUT INSIDE BUILDING	X	X	X	X	SEE PLAN
P-16	3-WAY VALVE/ VACUUM BREAKER	X	X	3/4"	3/4"	X
P-20	THERMOMETER	X	X	X	1/2"	X
P-21	BACKFLOW PREVENTER	X	X	X	2"	X
P-22	MOP SINK CHECK VALVES	X	X	1/2"	1/2"	X
P-23	UTILITY CONNECTION (ICE MAKER)	X	1/2"	X	X	X
P-24	UTILITY CONNECTION (COFFEE & TEA)	X	X	X	X	X
P-25	SHOCK ABSORBER	1/2"	1/2" & 3/4"	1/2"	1/2"	X
P-26	FUNNEL DRAIN	X	X	X	X	3"
P-26A	TRAP SEAL PROTECTOR	X	X	X	X	3"
P-27	WATER PRESSURE GAUGE	X	X	1/4"	X	X
P-28	BALL VALVE-CARBONATOR STOP/BFP PANEL	3/4"	X	X	X	X
P-29A	ICE MACHINE TRENCH DRAIN (18"X14.5")	X	X	X	X	4"
P-29B	ICE MACHINE TRENCH DRAIN (36"X14.5")	X	X	X	X	4"
P-30	FILTERED WATER FAUCET	(2) 1/2"	X	X	X	X
P-31	DUMPSTER POST HYDRANT	X	X	3/4"	X	X
P-32	DUMPSTER DRAIN	X	X	X	X	3"
P-33	TRAP PRIMER (MECHANICAL TYPE)	X	X	1/2"	X	X
P-34	DISPENSER BACKFLOW PREVENTER	1/2"	X	X	X	X
P-35	FLOOR DRAIN	X	X	X	X	3"
P-36	BEVERAGE TOWER INDIRECT RECEIVER	X	X	X	X	3"
P-37	FLOOR DRAIN (SQUARE TOP)	X	X	1/2"	X	3"
P-38	HOT WATER CIRCULATING PUMP	X	X	X	1/2"	X
P-41W	WYE STRAINER	X	X	X	2"	X
P-42	DISHWASHER SUPPLY FAUCET	X	X	3/4"	X	X
P-43	EMERGENCY THERMOSTATIC MIXING VALVE (EMERGENCY EYE WASH)	X	X	1/2"	1/2"	X
P-43	REHEATER SUPPLY VALVE	X	X	1/2"	X	X


NOTES: ① REFER TO FOOD SERVICE DRAWINGS FOR KITCHEN EQUIPMENT INSTALLATION AND HOOK-UP RESPONSIBILITIES.

KITCHEN EQUIPMENT SCHEDULE							
TAG	DESCRIPTION	FW	FW2	CW	HW	WASTE	ROUGH-IN
305	TEA BREWER	1/2"	X	X	X	X	P-24
306	COFFEE MAKER	1/2"	X	X	X	X	P-24
308	CARBONATOR BFP PANEL	3/4"	X	X	X	X	SEE K-41
300	WATER FILTER PANEL	(3) 3/4"	3/4"	3/4"	X	X	SEE DET 9/P21
303	DISHWASHER	X	X	3/4"	X	INDIRECT	SEE K-41
306	POT SINK	X	X	(2) 1/2"	(2) 1/2"	INDIRECT	TWO #365F FAUCETS, P-9
307	VEGETABLE PREP SINK	X	X	1/2"	1/2"	INDIRECT	ONE #367F FAUCET, P-8
307F	KITCHEN WALL FAUCET	(2) 1/2"	X	X	X	X	P-30 48" AFF.
307F	KITCHEN WALL FAUCET	(2) 1/2"	X	X	X	X	P-30 48" AFF.
310	MOP SINK	X	X	1/2"	1/2"	3" P-35	SEE DET 2/P21
38	ICE BIN	X	X	X	X	INDIRECT	P-26 DRAIN
38A	ICE BIN	X	X	X	X	INDIRECT	P-26 DRAIN
380	ICE MAKER	X	1/2"	X	X	INDIRECT	P-23, SEE DET3/P41
380	ICE MAKER	X	(2) 1/2"	X	X	INDIRECT	P-23, SEE DET3/P41
392	REHEATER	X	X	1/2"	X	INDIRECT	SEE KITCHEN DWGS

NOTES: ① REVIEW PLANS AND KITCHEN EQUIPMENT DRAWINGS IN ORDER TO DETERMINE WHICH EQUIPMENT IS NEW, EXISTING TO BE RELOCATED OR EXISTING TO REMAIN IN PLACE.

### CO2 FILL/VENT CONDUIT AND FILL-BOX INSTALLATION

SCALE: NONE

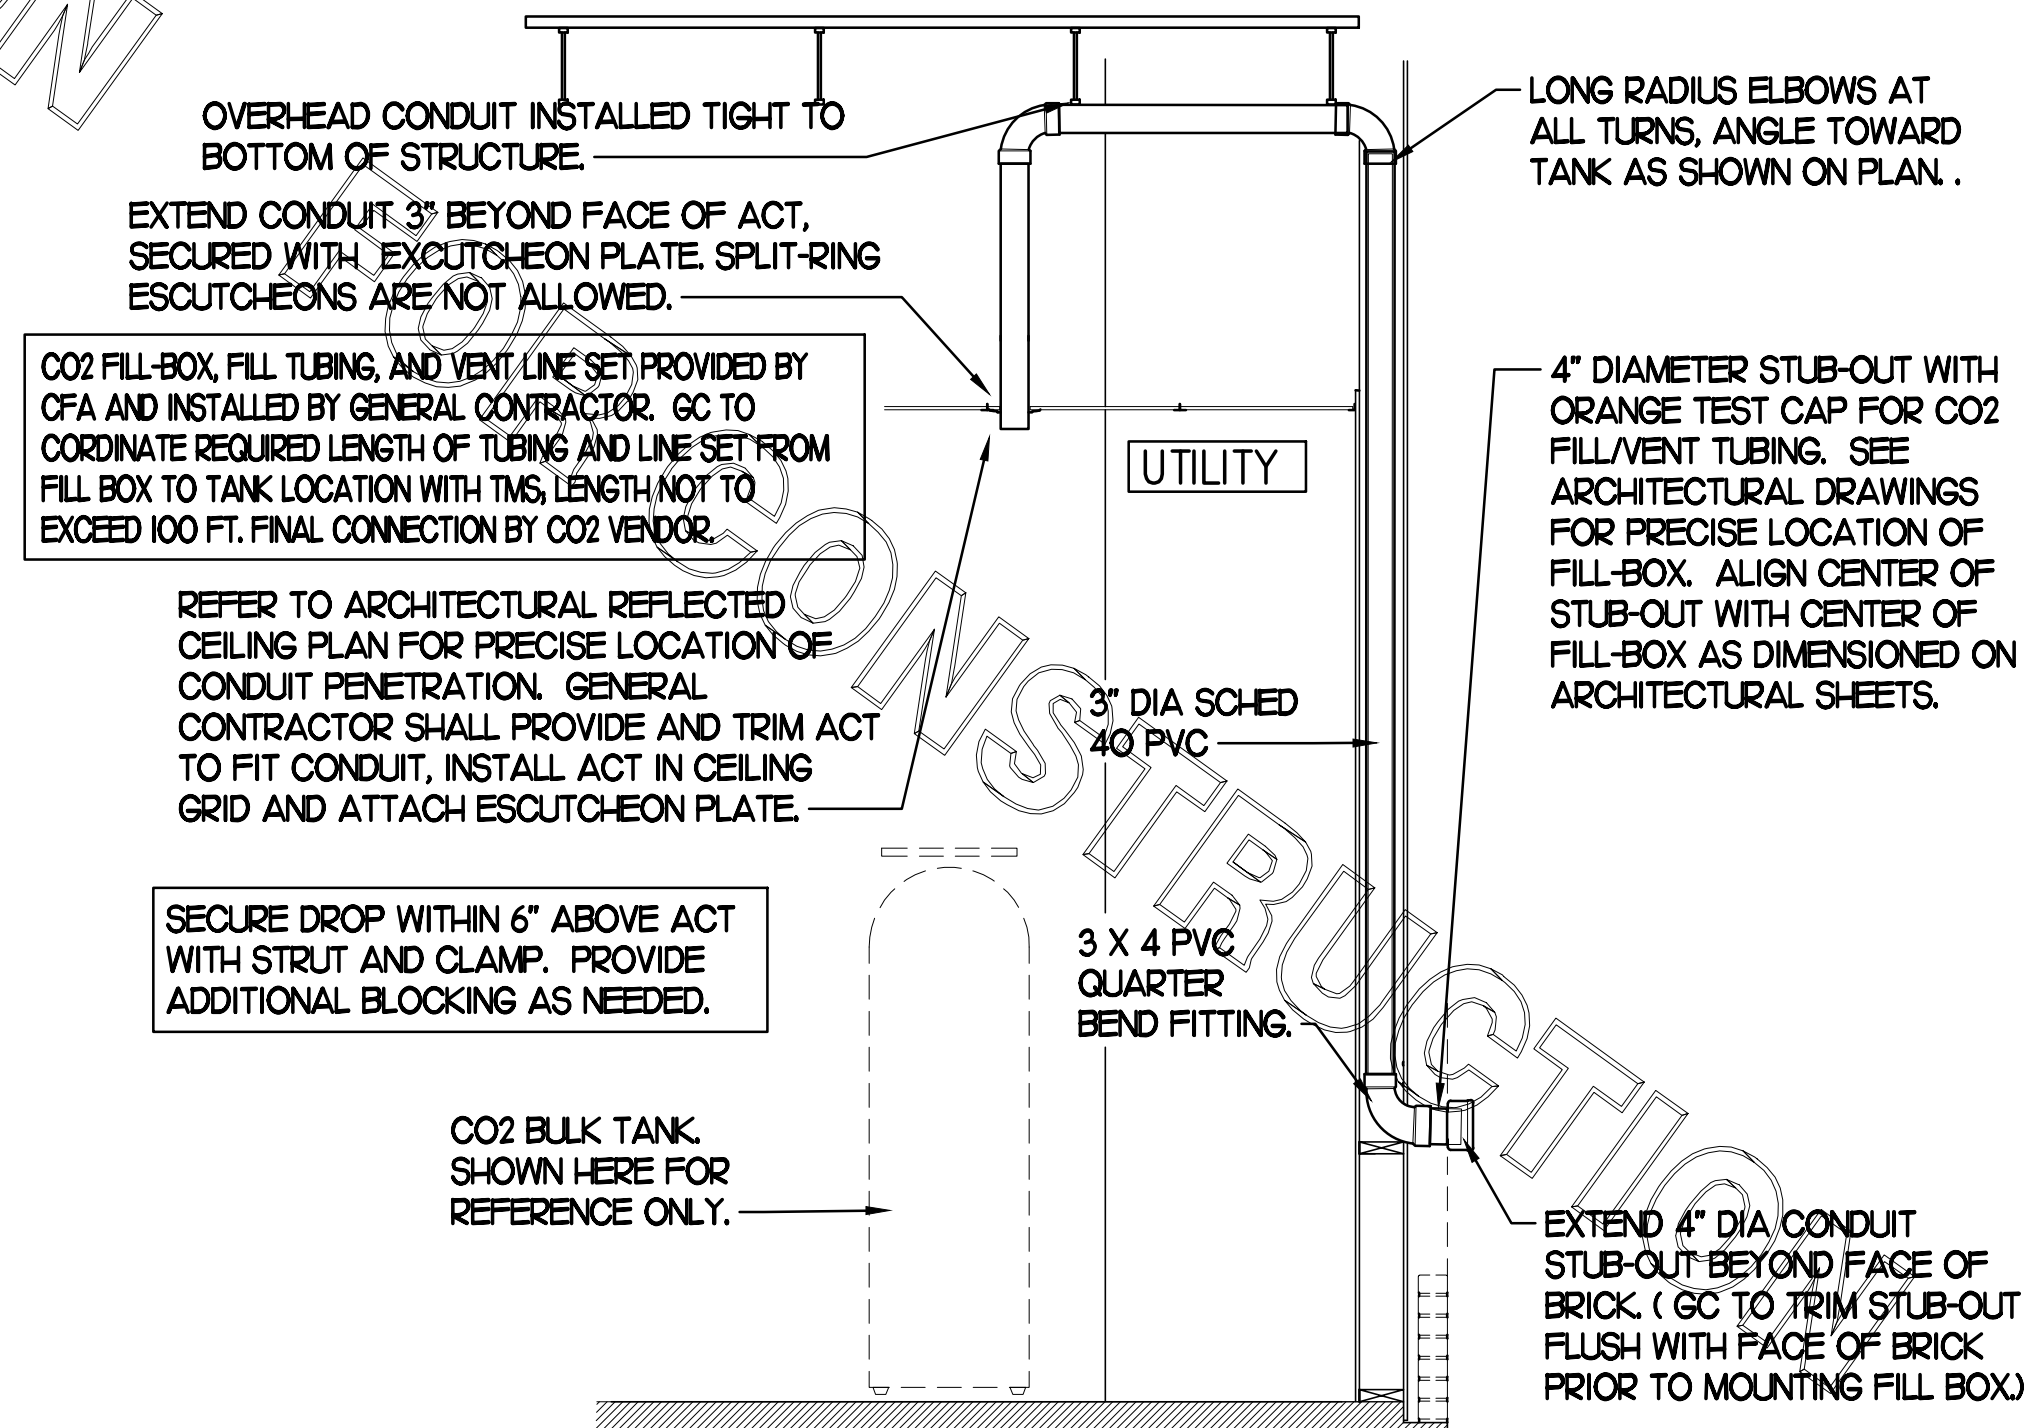

Chick-fil-A

Chick-fil-A  
5200 Buffington Road  
Atlanta, Georgia 30349



Kurzynske & Associates  
CONSULTING ENGINEERS  
2708 Lebanon Pike - Suite One  
Nashville, Tennessee 37214  
Telephone: (615) 255-5203




**CHICK-FIL-A**  
DELTRAN FSU  
1301 FAIRVIEW BLVD  
DELTRAN, NJ 08075

**FSR#01385**

BUILDING TYPE / SIZE: S97-110  
RELEASE: v05.22  
REVISION SCHEDULE  
NO. DATE DESCRIPTION  
7 07/31/23 Pre-bid Comments

CONSULTANT PROJECT # 22146.HF.R  
PRINTED FOR CONSTRUCTION  
DATE 1/30/2023  
DRAWN BY BF  
Information contained on this drawing and in all digital files produced for above named project may not be reproduced in any manner without express written or verbal consent from authorized project representatives.  
SHEET BEVERAGE CONDUIT PLAN  
SHEET NUMBER

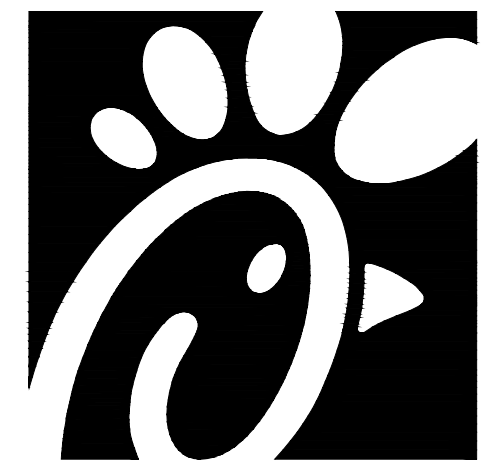


Chick-fil-A  
5200 Buffington Road  
Atlanta, Georgia 30349



**Kurzynske & Associates**  
CONSULTING ENGINEERS  
2706 Lebanon Pike - Suite One  
Nashville, Tennessee 37214  
Telephone: (615) 255-8203

MARK T. KURZYNSKE  
NEW JERSEY LICENSE # GE44646

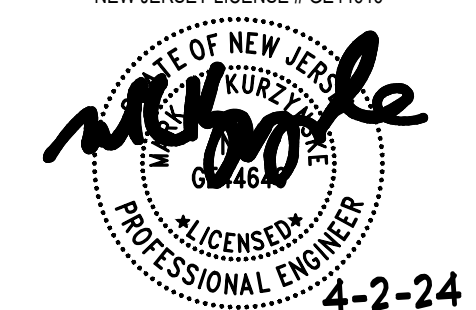

4-2-24

**CHICK-FIL-A**  
DELTRAN FSU  
1301 FAIRVIEW BLVD  
DELTRAN, NJ 08075

**FSR#01385**

BUILDING TYPE / SIZE: S97-110

RELEASE: V05.22

REVISION SCHEDULE

NO.	DATE	DESCRIPTION
1	02/22/23	Owner Revision

18 01/09/24 Design Note

24 04/02/24 CD Comments

CONSULTANT PROJECT # 22146.HF.R

PRINTED FOR CONSTRUCTION

DATE 1/30/2023


DRAWN BY BF

Information contained on this drawing and in all digital files produced for above named project may not be reproduced in any manner without express written or verbal consent from authorized project representatives.

SHEET  
ROOF PLAN  
AND DETAILS

SHEET NUMBER


**P3.1**

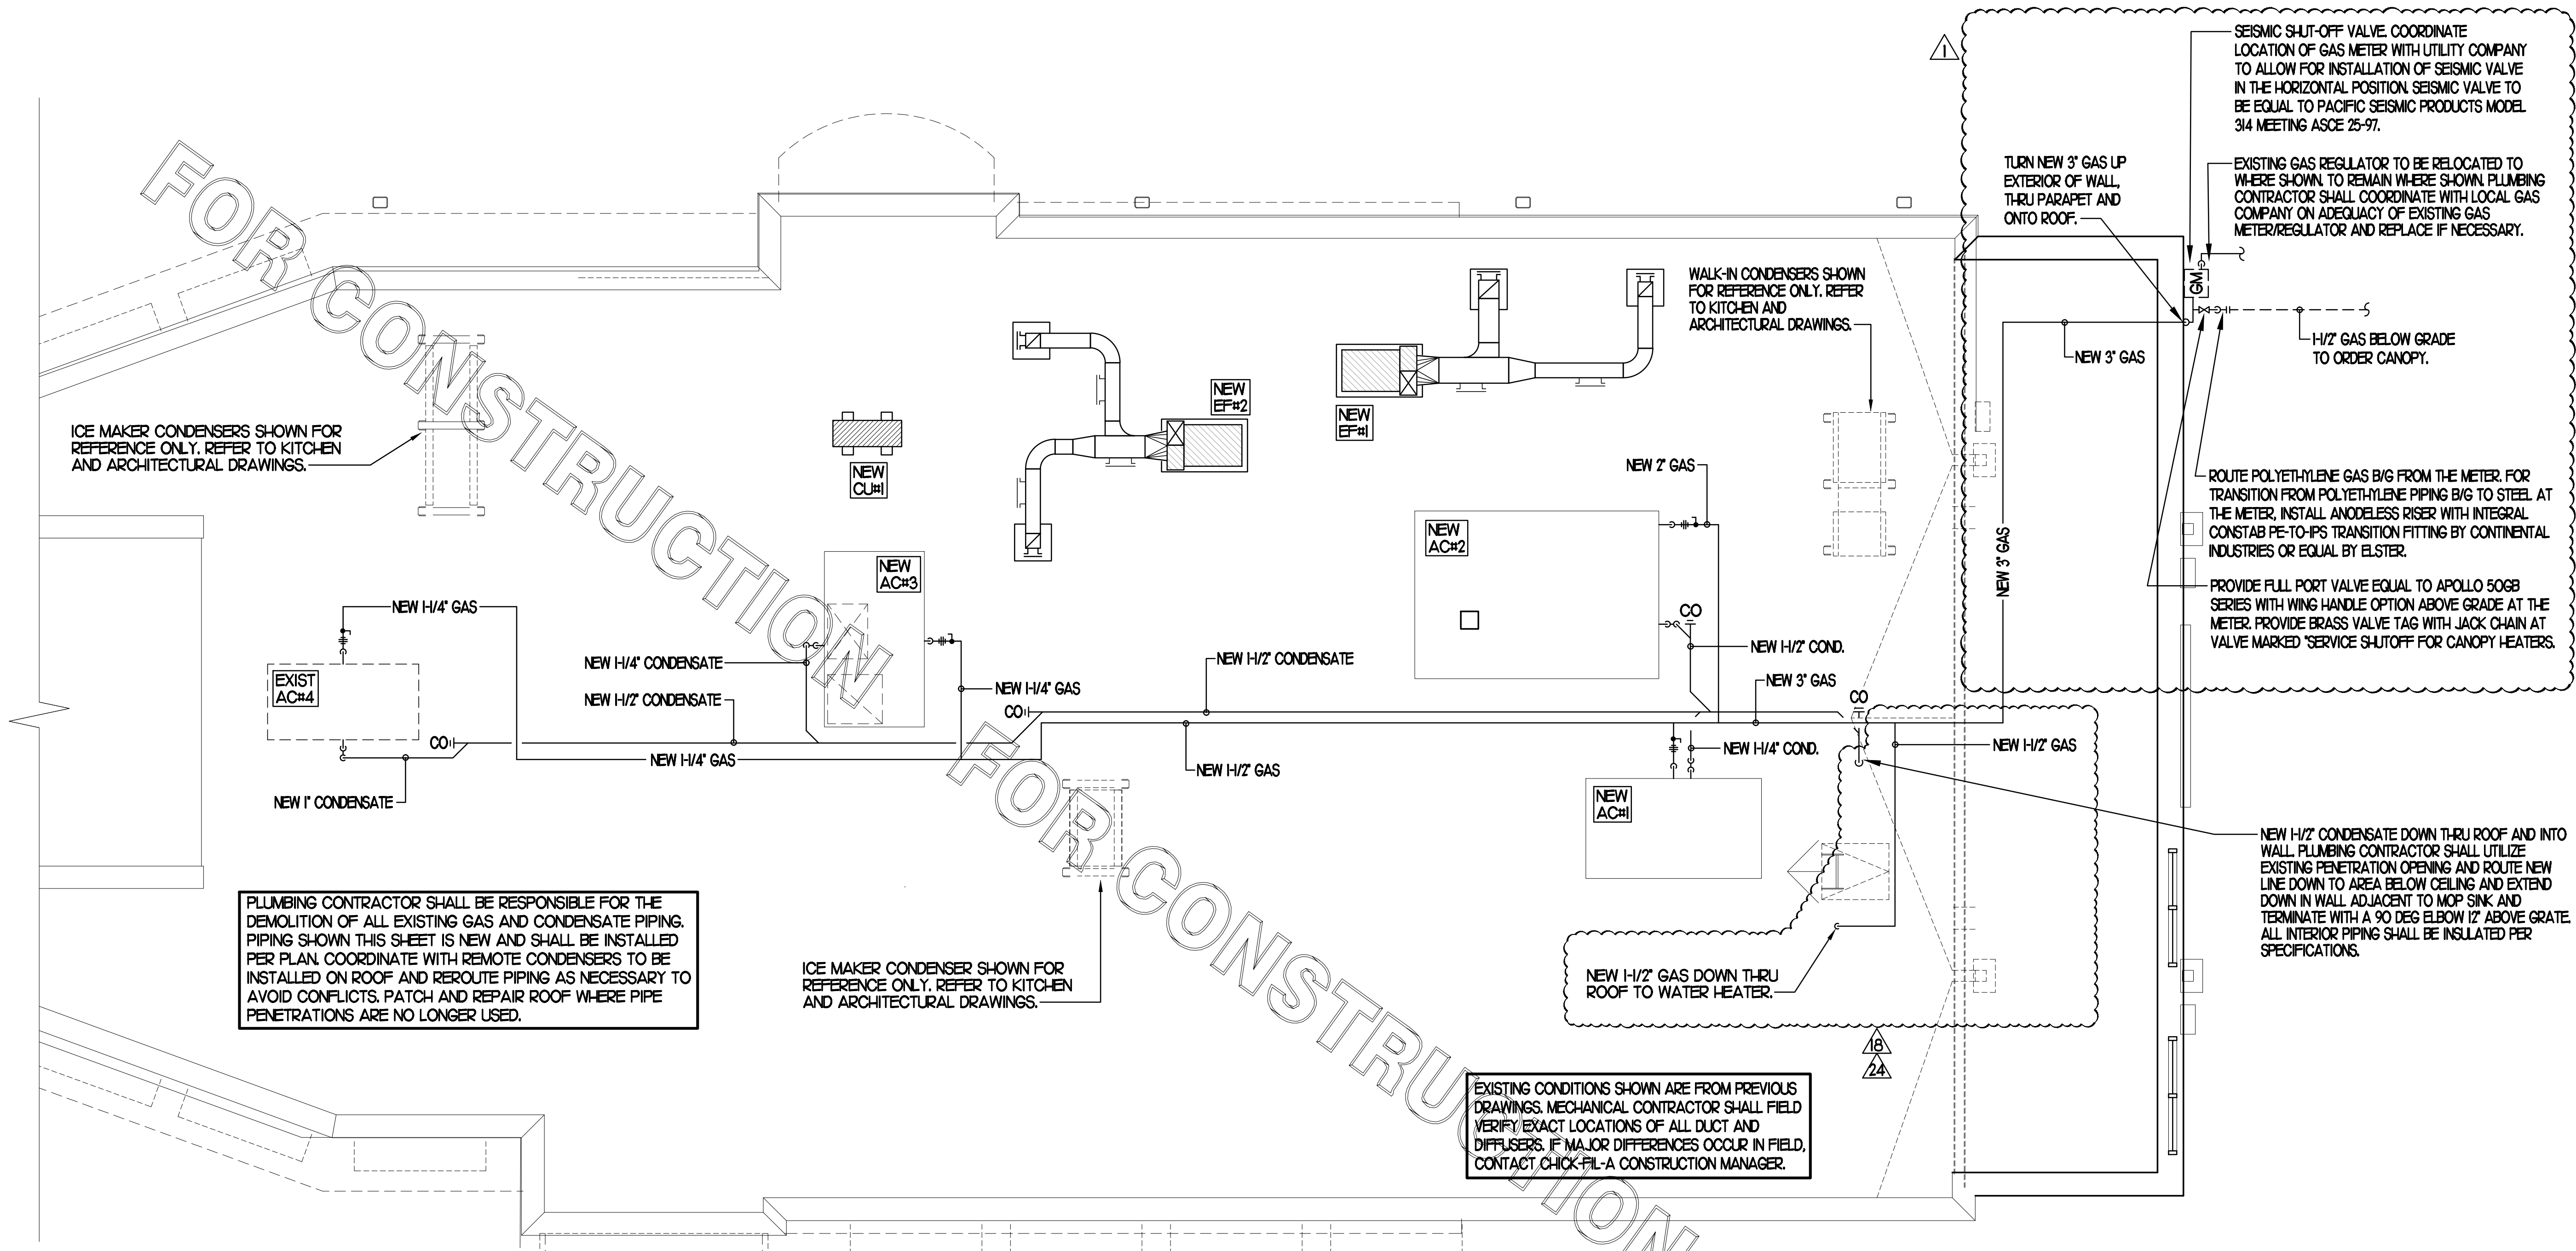

**1 PLUMBING ROOF PLAN**


SCALE: 1/4"=1'-0"

- NOTES:
- NON ADJUSTABLE MODEL CIO PIPE STAND TO BE USED FOR NON-ELEVATED PIPING INSTALLED FLAT ON ROOF DECK.
  - PROVIDE MODEL CE-8 OR CE-12 OR CE-16 AS NEEDED FOR ELEVATING CONDENSATE PIPING TO MAINTAIN PROPER SLOPE AND FOR GAS PIPING CROSSING OVER CONDENSATE PIPING.
  - ENSURE GAS AND CONDENSATE PIPING DO NOT OBSTRUCT ROOFTOP EQUIPMENT ACCESS OPENINGS. RE-PIPING OF SYSTEMS DUE TO CONFLICTS WITH EQUIPMENT ACCESS OPENINGS SHALL BE DONE AT PLUMBING CONTRACTOR'S EXPENSE.

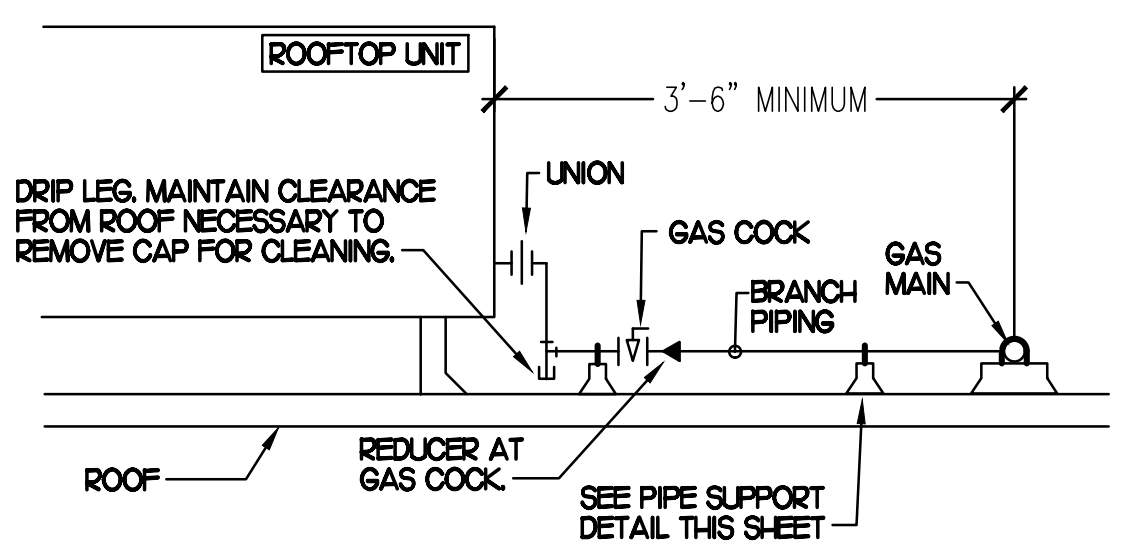

**3 GAS PIPING AT RTU**

NO SCALE

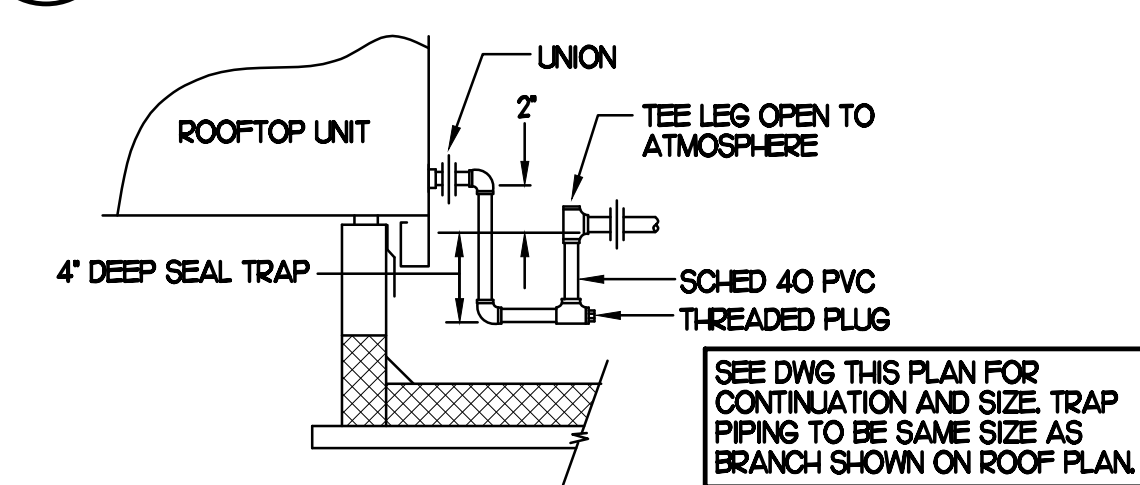

**2 CONDENSATE DRAIN PIPING**

NO SCALE

**ROOF PIPING NOTE:**  
PLUMBING CONTRACTOR SHALL BE RESPONSIBLE FOR DEMOLITION OF EXISTING GAS & CONDENSATE PIPING NO LONGER NEEDED ALONG WITH THE INSTALLATION OF ALL NEW GAS & CONDENSATE PIPING REQUIRED. PLUMBING CONTRACTOR SHALL BE RESPONSIBLE FOR ALL NEW PIPING REQUIRED.

**SHEET NOTES**

- NEW GAS PIPING SHALL BE PAINTED WITH A ZINC BASED PRIMER WITH A COLOR TOP COAT SPECIFIED BY THE GC. WHERE COLOR TOP COAT IS NOT REQUIRED, TWO COATS OF ZINC BASE PRIMER SHALL BE USED. ALL FIELD JOINTS SHALL BE COATED WITH TWO COATS OF A ZINC BASED PRIMER. SLEEVE ALL WALL PENETRATIONS WITH SCHEDULE 40 PVC AND PROVIDE STAINLESS STEEL ESCUTCHEONS ON BOTH SIDES OF WALL PENETRATIONS.
- PIPING ON ROOF SHALL NOT BE INSTALLED NEARER THAN 1'-0" FROM INSIDE EDGE OF PARAPET UNLESS NOTED OTHERWISE.
- CONDENSATE PIPING ON ROOF SHALL BE SCHEDULE 40 PVC.
- ANY EXISTING PENETRATIONS OF ROOF BY EXISTING GAS, CONDENSATE, REFRIGERANT OR OTHER PIPING THAT ARE NOT BEING REUSED FOR NEW PIPING SHALL BE PATCHED AND REPAIRED (WATERTIGHT) TO MATCH SURROUNDING AREA.
- FIELD VERIFY ALL LOCATIONS, DIAMETERS, CLEARANCES AND ROUTING OF EXISTING LINES AND EQUIPMENT.


**GAS CONNECTION SCHEDULE**

EQUIPMENT	GAS LOAD
AC#1 (NEW)	240,000 BTUS
AC#2 (NEW)	480,000 BTUS
AC#3 (NEW)	240,000 BTUS
AC#4 (EXISTING)	150,000 BTUS
<b>WATER HEATER (NEW)</b>	
GH-HI-#6 (50,000 EA)	300,000 BTUS
<b>TOTAL CONNECTED LOAD</b>	<b>1,800,000 BTUS</b>

- REMARKS:
- EQUIVALENT TO 1606.0 CFH
  - 7 W.C. DELIVERY PRESSURE
  - DEVELOPED LENGTH 135 FT. (METER TO AC#4) 135 FEET TO GH AT F27 ORDER CANOPY.
  - VERIFY GAS LOAD OF EXISTING EQUIPMENT.


**4 PIPING SUPPORT**

NO SCALE

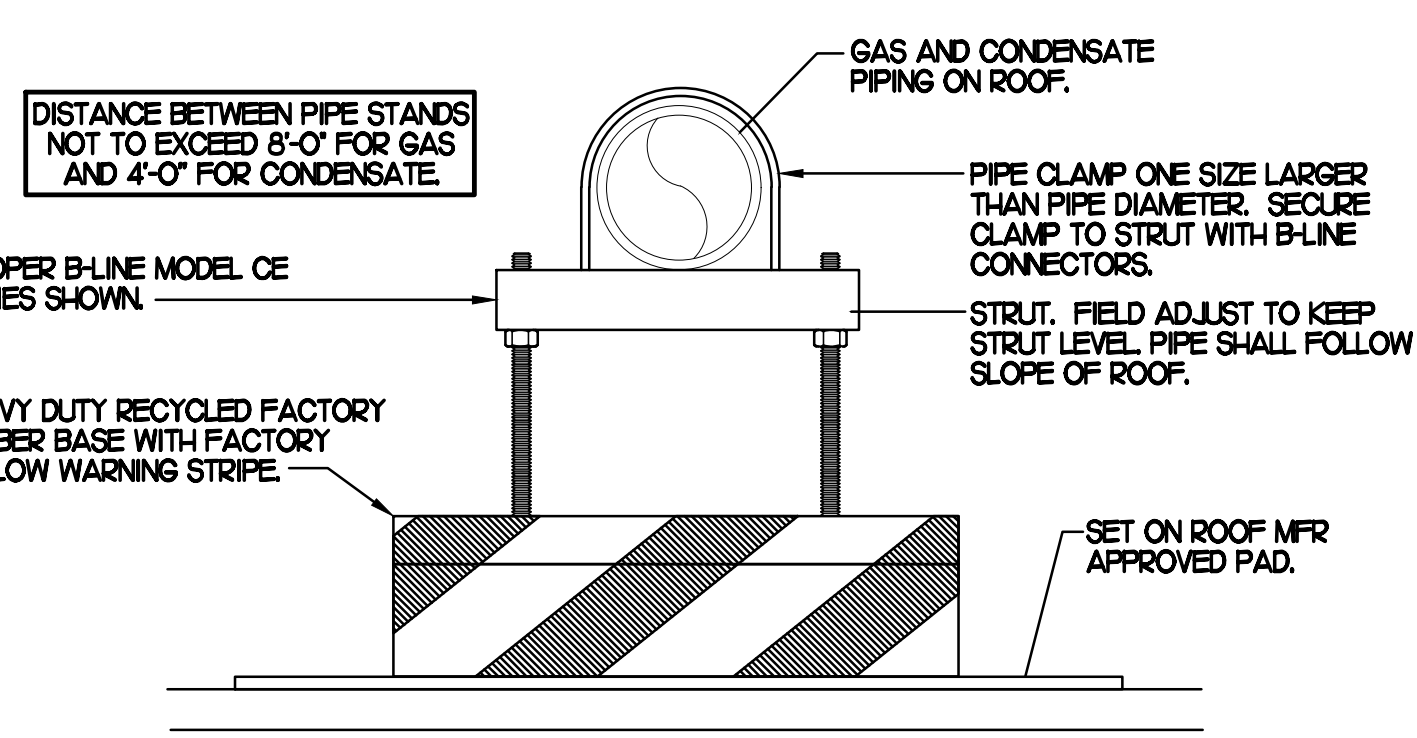


**NOTE TO WATER HEATER INSTALLER:**

- 1 POSITION VALVES AND TRIM IN MECH ROOM SUCH THAT VALVES AND TRIM ARE UNOBSTRUCTED TO VIEW AND SO THAT ACCESS FOR OPERATION OR REPAIR IS POSSIBLE WITHOUT USE OF STEP LADDERS OR NEED TO DISASSEMBLE ANY COMPONENTS.
- 2 VENT HEATER UP THRU ROOF AND PROVIDE FRESH AIR PIPING PER MANUFACTURER'S RECOMMENDATIONS.
- 3 CONTRACTOR MAY REUSE EXISTING WATER HEATER COMPONENTS PROVIDED THEY ARE IN GOOD CONDITION. FIELD VERIFY CAPACITY OF EXISTING COMPONENTS AND REPLACE IF FOUND NECESSARY. COORDINATE WITH CFA CONSTRUCTION MANAGER. NEW FIXTURES ARE SHOWN IN PLUMBING FIXTURE LIST IN EVENT REPLACEMENT IS FOUND NECESSARY.

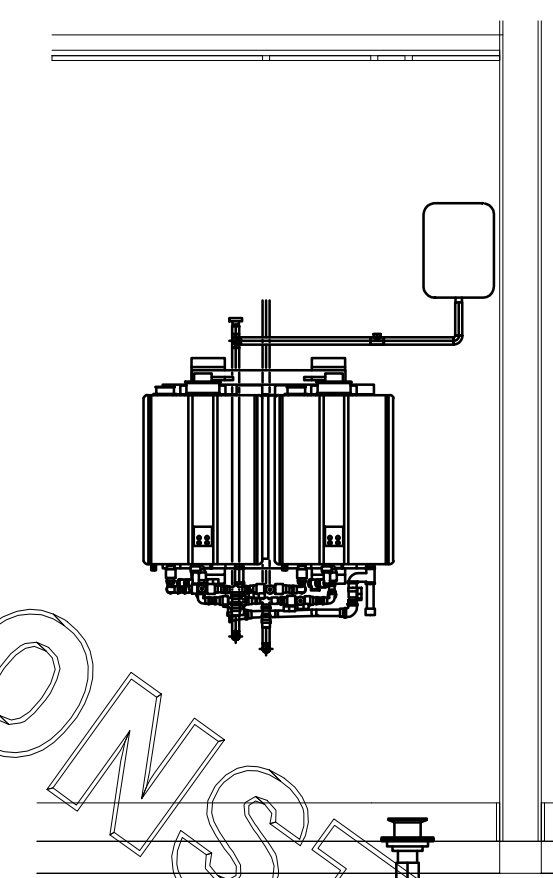


**5 TANKLESS WATER HEATER DETAIL**  
NO SCALE

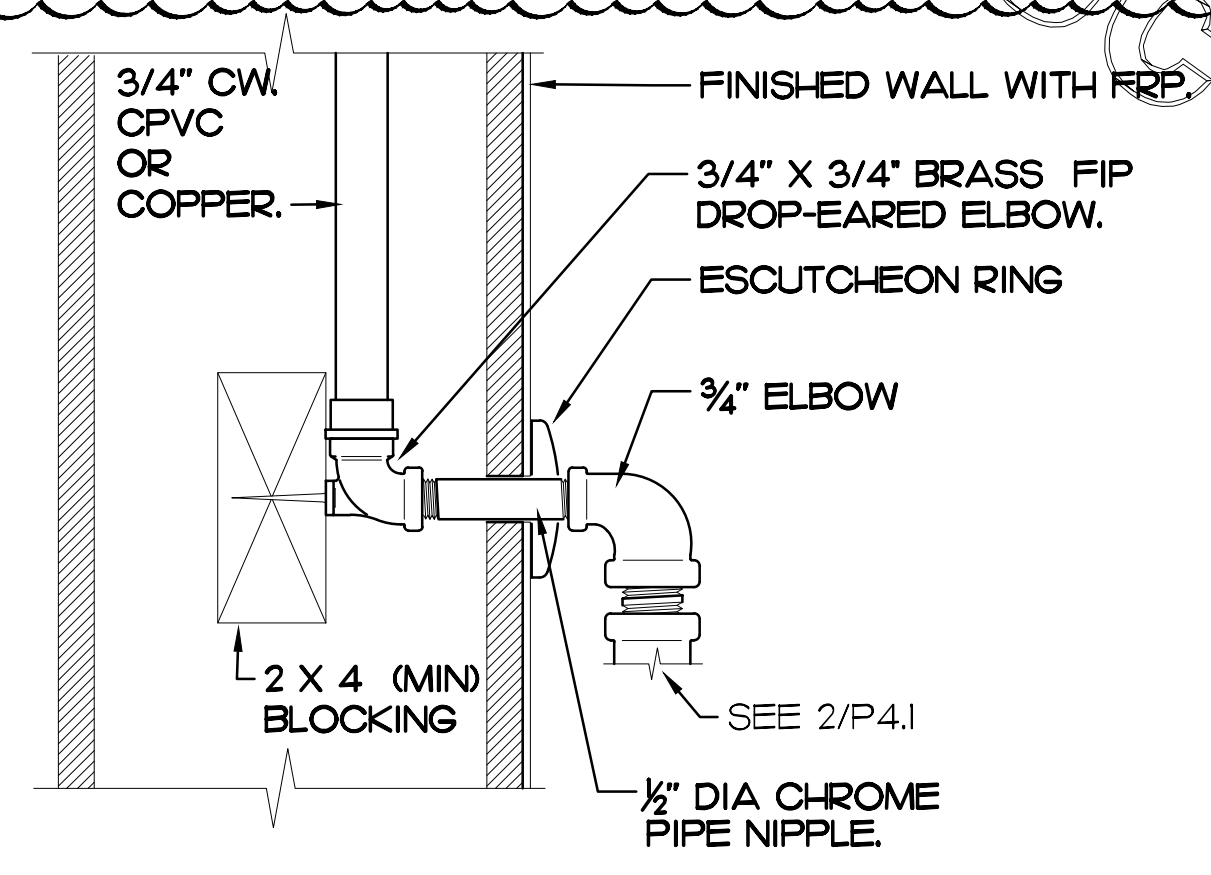


SECURE DROP-EARED ELBOW TO BLOCKING WITH 1-1/4" FLAT HEAD PHILLIP SCREWS.


**2A SECTION AT PIPING WITHIN WALL**  
SCALE: NONE

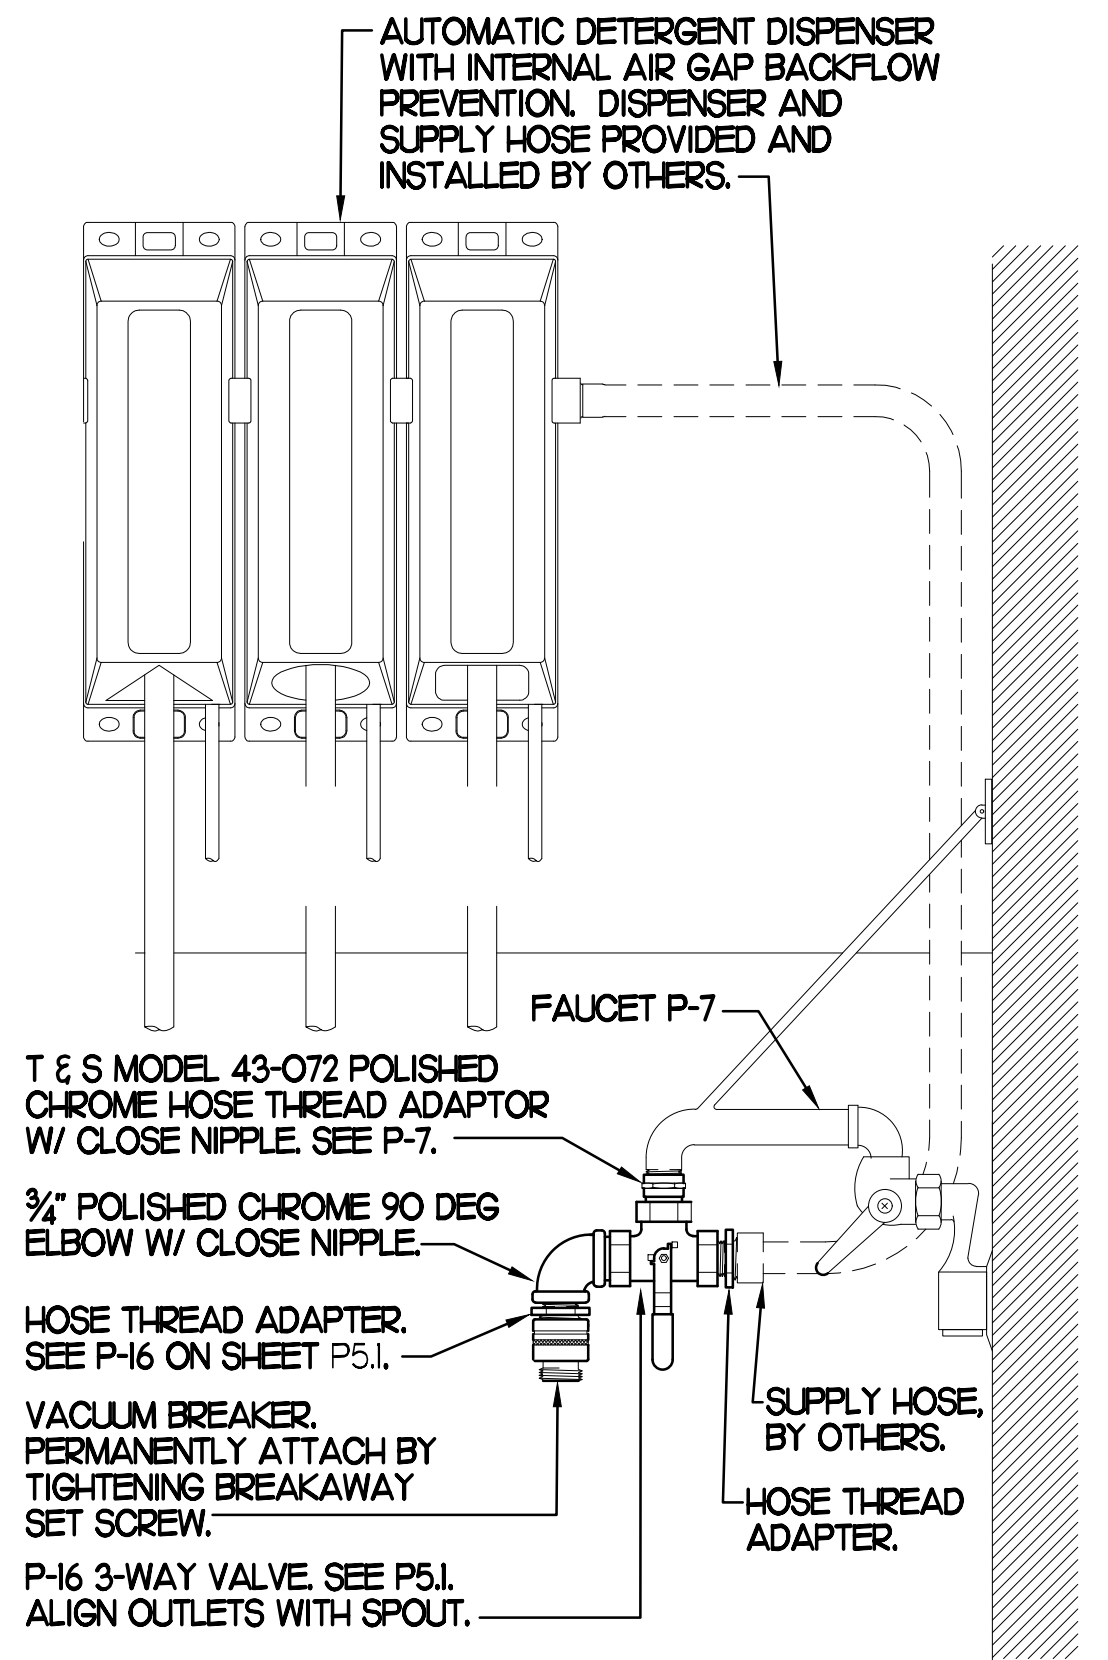


**4 3-WAY VALVE AT MOP SINK**  
SCALE: NONE

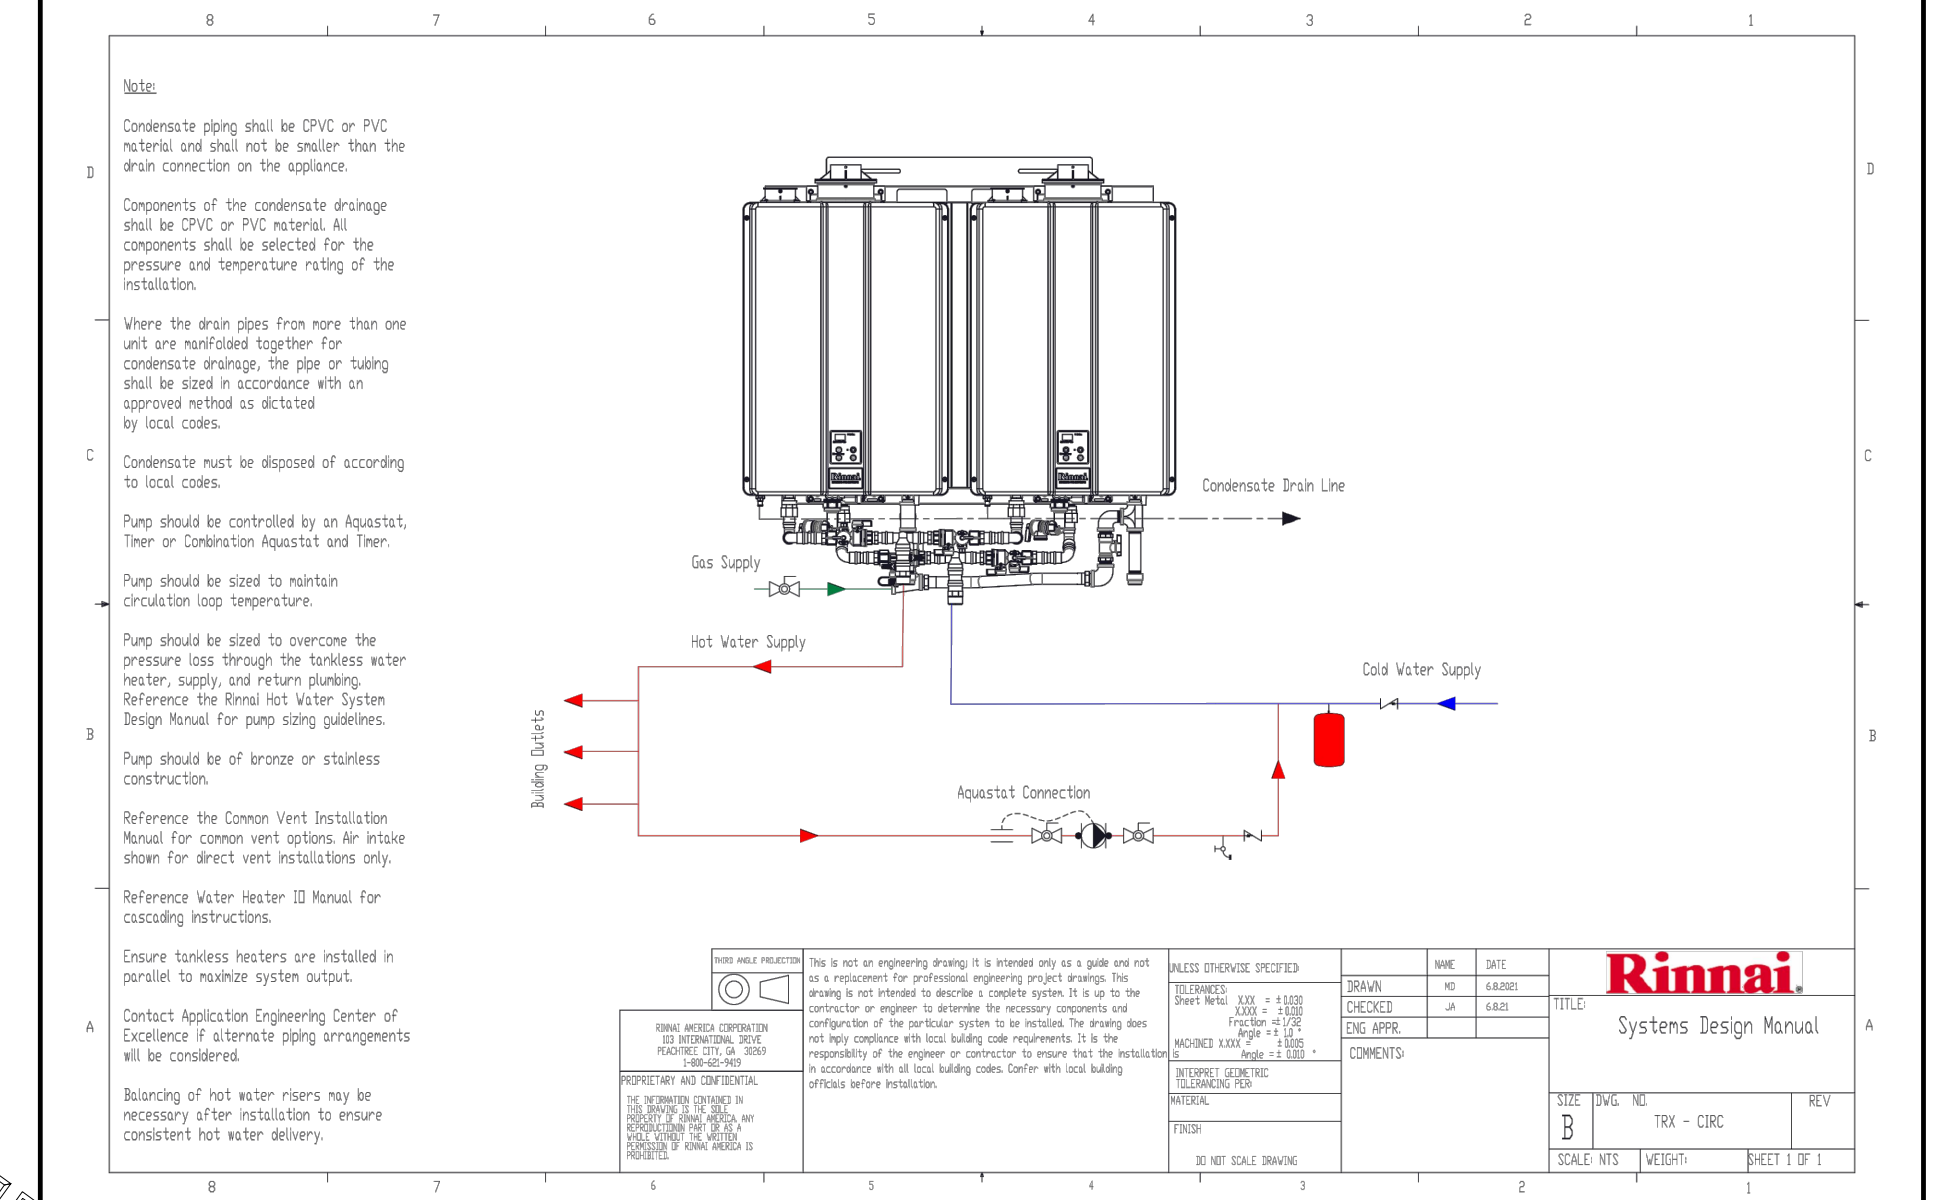


**6 WATER HEATER VENT ROOF PENETRATION**  
NO SCALE

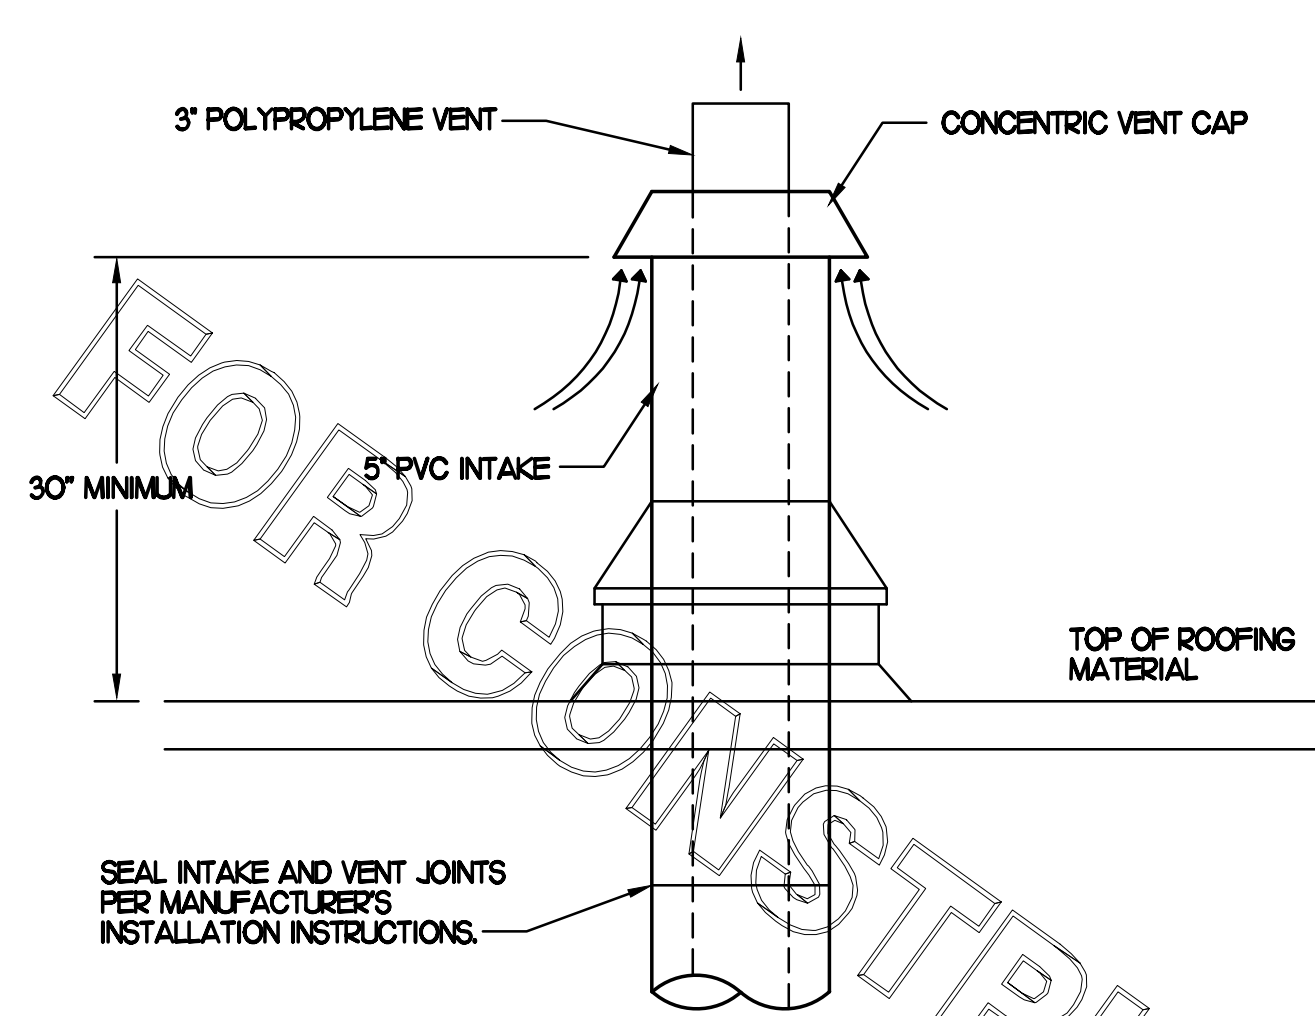


**2 DISHWASHER WATER SUPPLY VALVE ASSEMBLY**  
SCALE: NONE

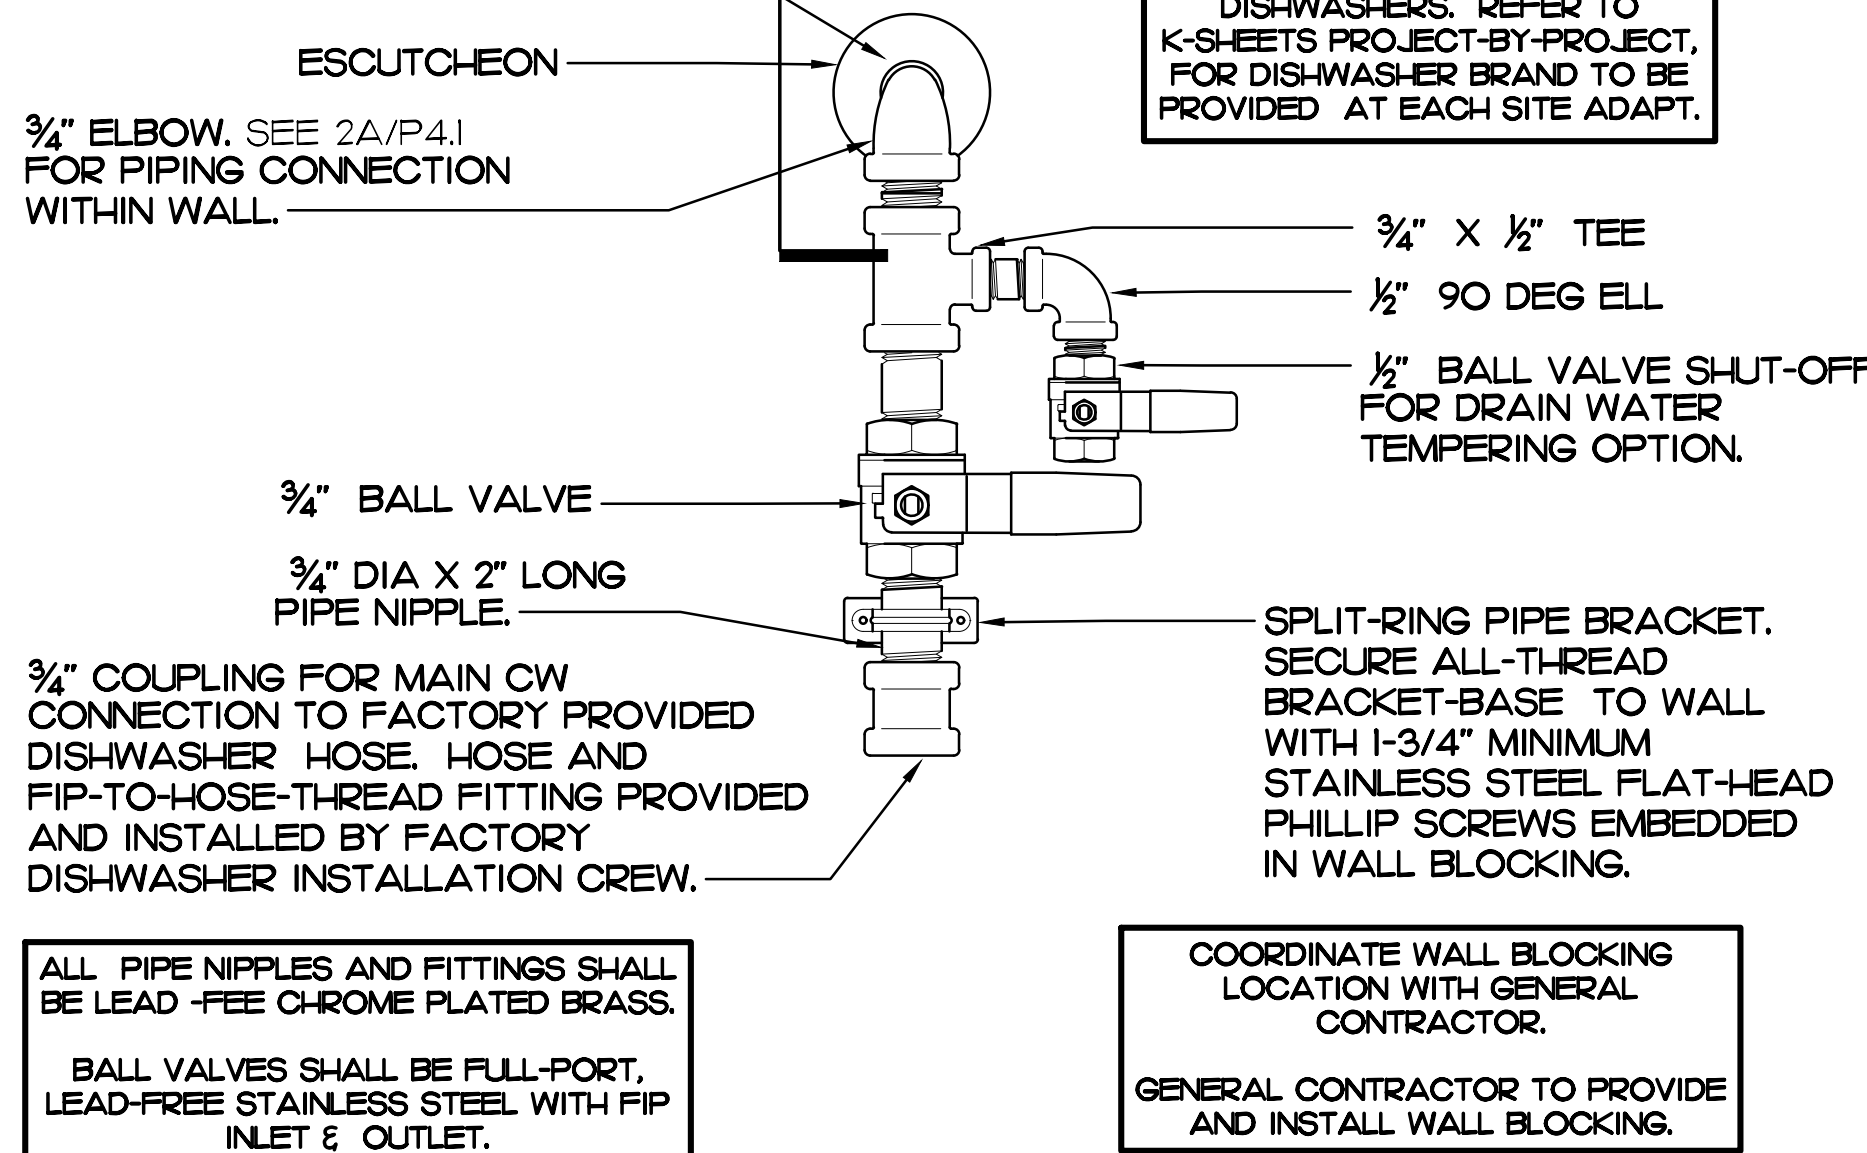



**3 ICE MACHINE PIPING**  
SCALE: NONE

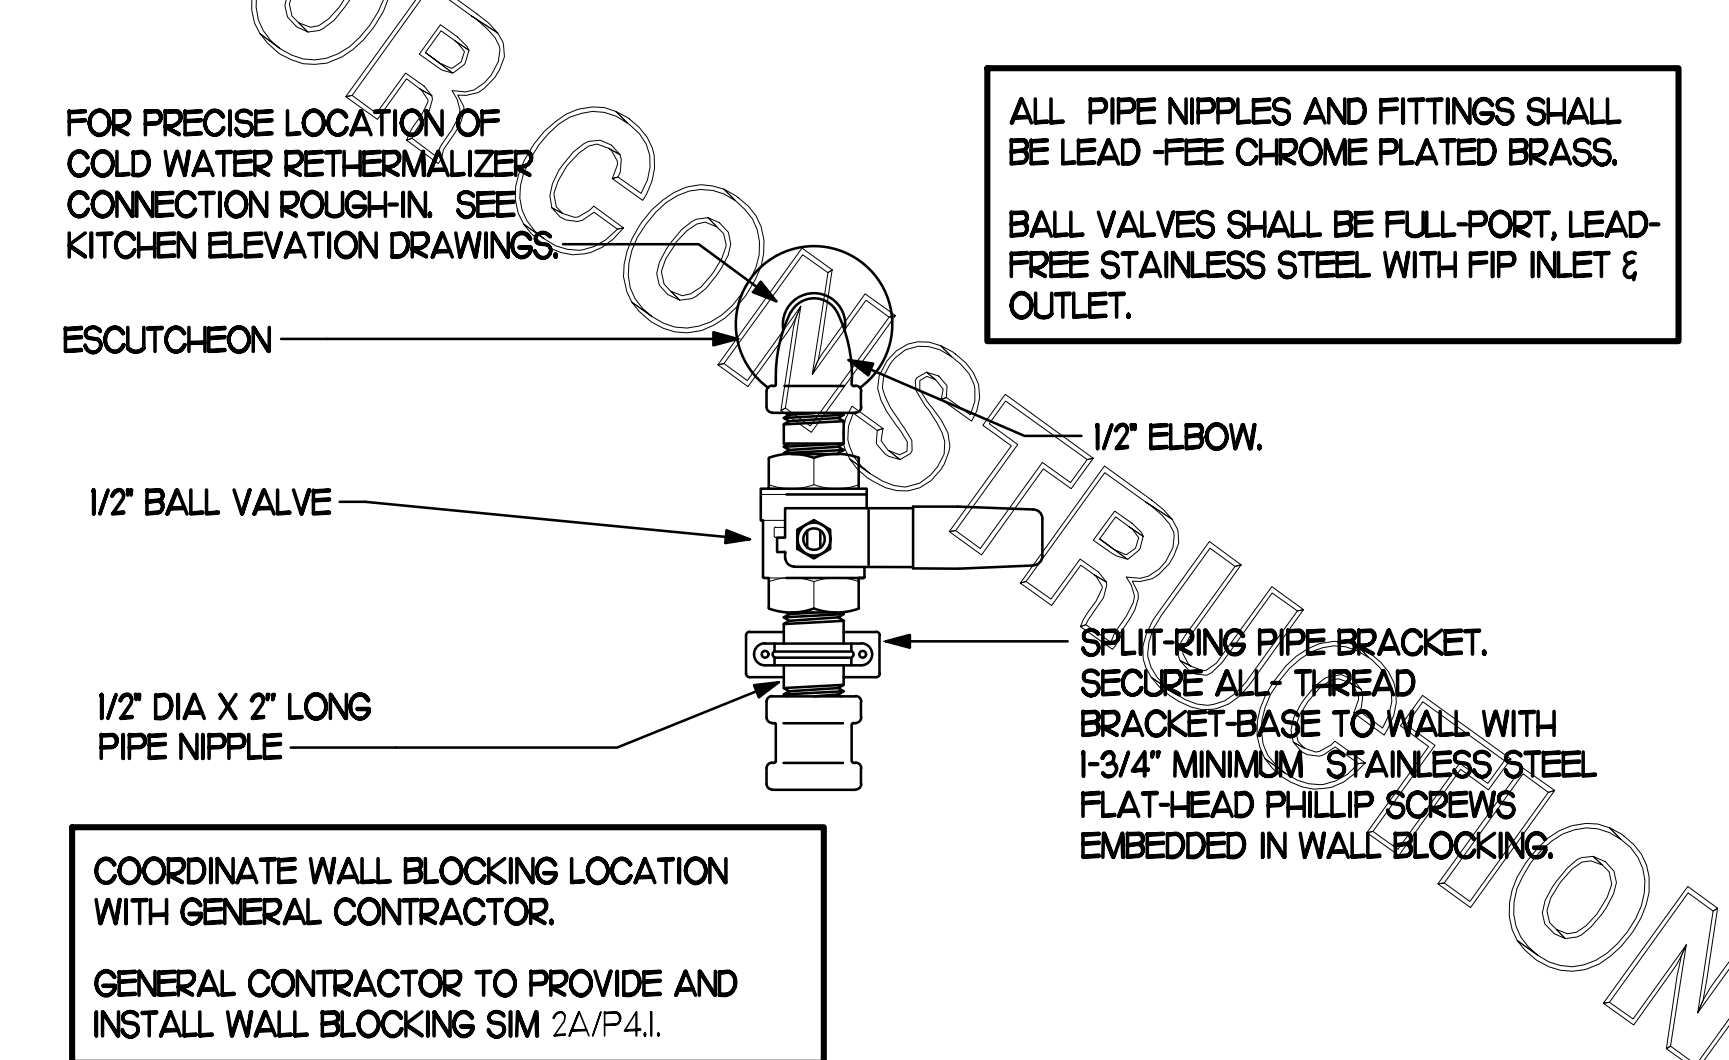

**1 RETHERMALIZER WATER SUPPLY VALVE**  
SCALE: NONE

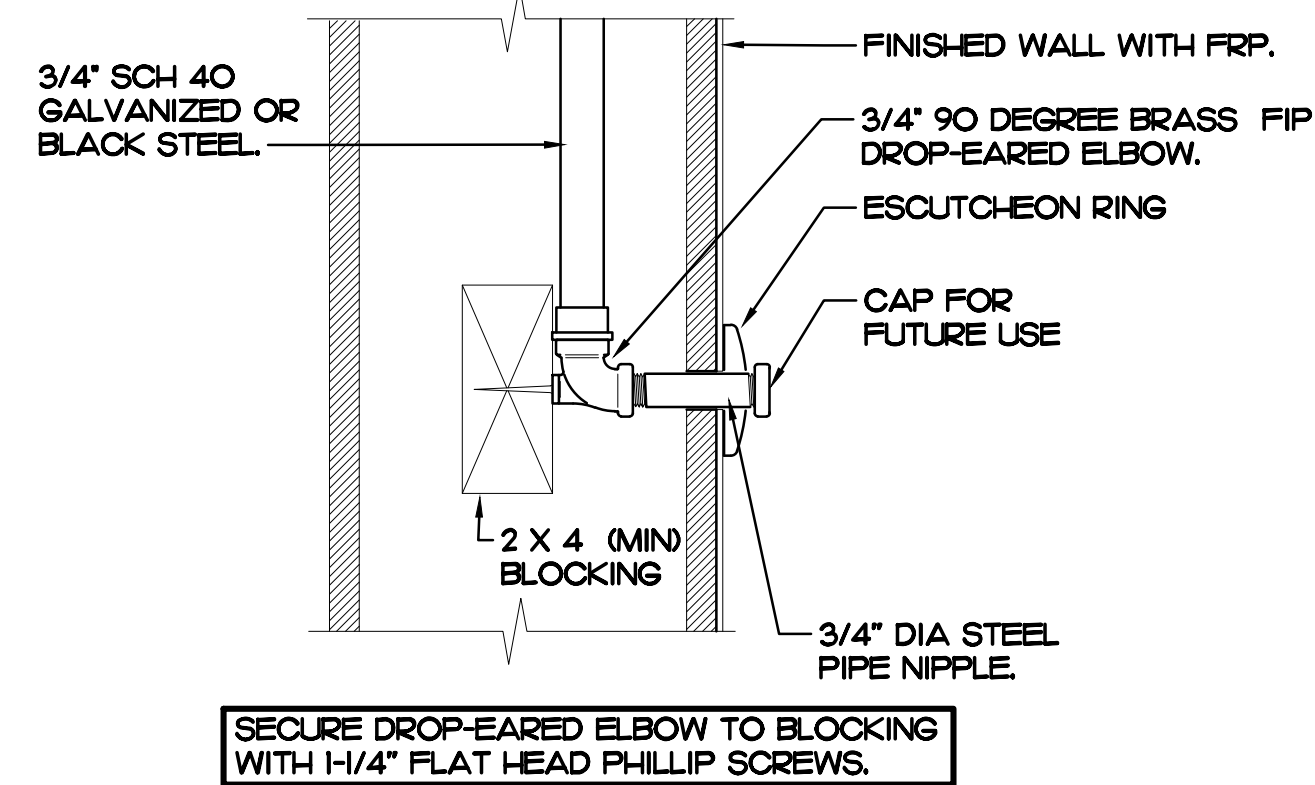


**6 DARPRO OIL PIPING SECTION WITHIN WALL**  
SCALE: NONE

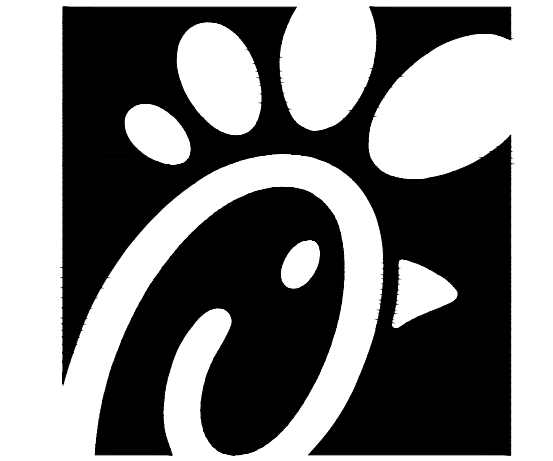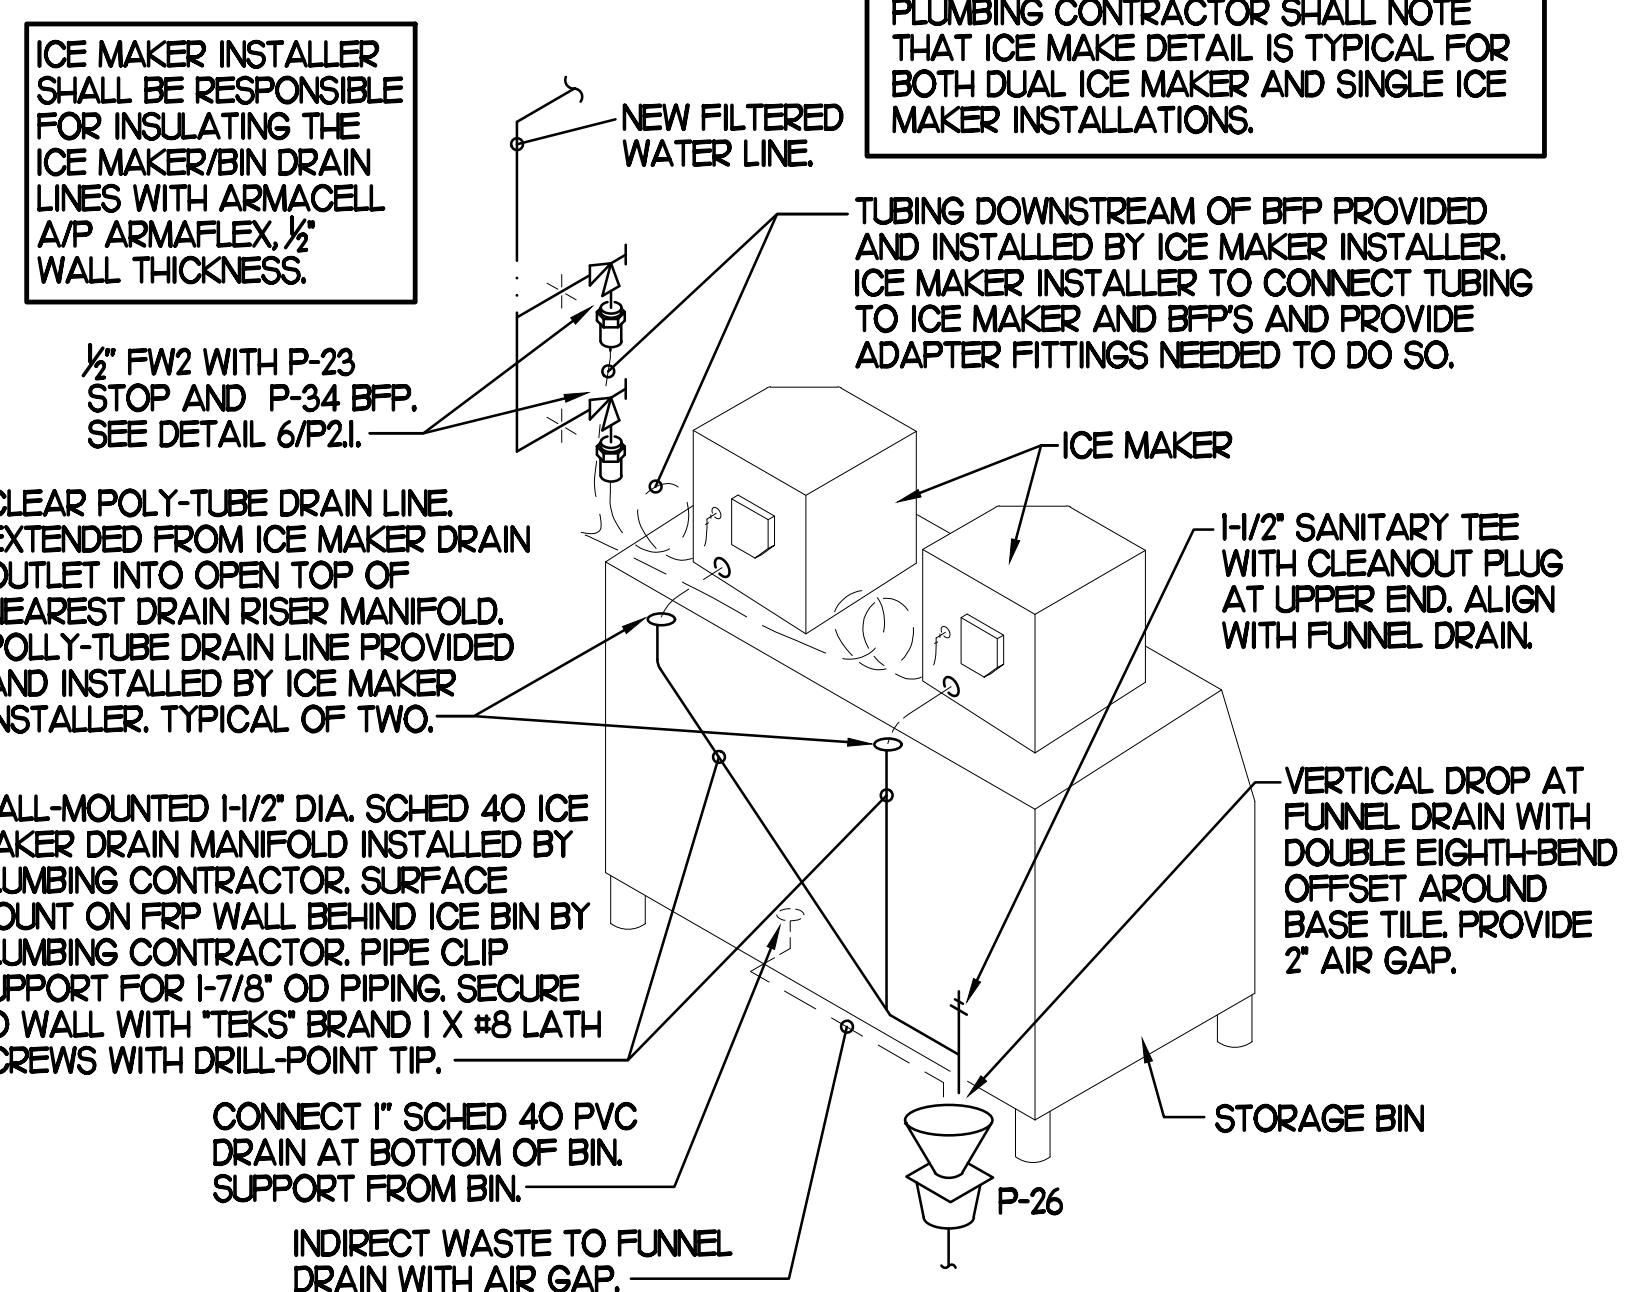

**Chick-fil-A**

Chick-fil-A  
5200 Buffington Road  
Atlanta, Georgia 30349

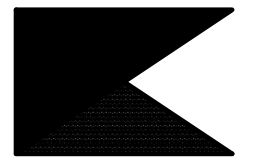

**Kurzynske & Associates**  
CONSULTING ENGINEERS  
2706 Lebanon Pike - Suite One  
Nashville, Tennessee 37214  
Telephone: (615) 255-8203



**CHICK-FIL-A**  
DELTRAN FSU  
1301 FAIRVIEW BLVD  
DELTRAN, NJ 08075

**FSR#01385**  
BUILDING TYPE / SIZE: S97-110  
RELEASE: V05.22  
REVISION SCHEDULE  
NO. DATE DESCRIPTION

24	04/02/24	CD Comments
CONSULTANT PROJECT # 22146.HF.R		
PRINTED FOR CONSTRUCTION		
DATE 1/30/2023		
DRAWN BY BF		

Information contained on this drawing and in all digital files produced for above named project may not be reproduced in any manner without express written or verbal consent from authorized project representatives.  
SHEET PLUMBING DETAILS  
SHEET NUMBER

# I. SECTION CIS100 - PLUMBING SPECIFICATIONS

## PART I - PRODUCTS (C15100)

### 1.01 GENERAL REQUIREMENTS

A. THE FOLLOWING SPECIFICATIONS ARE THE MINIMUM REQUIREMENT. WHERE FEDERAL, STATE OR LOCAL REQUIREMENTS DIFFER FROM THIS SPECIFICATION, THE MORE RESTRICTIVE OF THE TWO SHALL BE FOLLOWED.

### 1.02 SCOPE

A. HOT AND COLD POTABLE WATER PIPING ABOVE SLAB SHALL BE TYPE 'L' HARD DRAWN COPPER OR FLOWGUARD GOLD CPVC AS MANUFACTURED BY NIBCO OR CHARLOTTE PIPE & FOUNDRY AND MEETING ASTM D-2846. FILTERED WATER PIPING SHALL BE FLOWGUARD GOLD CPVC. HOT AND COLD PIPING WITHIN WALLS BEHIND KITCHEN HOODS SHALL BE COPPER.

B. POTABLE WATER PIPING BELOW SLAB AND OUTSIDE BELOW GRADE SHALL BE TYPE 'K' SOFT ANNEALED SEAMLESS. NO JOINTS SHALL BE ALLOWED BELOW SLAB. POTABLE WATER PIPING BELOW GRADE SHALL BE SLEEVED FOR ITS ENTIRE LENGTH WITH POLY SLEEVE AS MADE BY IPS WATER-TITE. ALL SLAB PENETRATIONS SHALL BE SLEEVED WITH POLY SLEEVE TO PROTECT PIPING FROM CORROSION BY CONCRETE.

C. COPPER PIPE FITTINGS SHALL BE WROUGHT COPPER SWEET PATTERNS SOLDERED USING 95-5 LEAD-FREE SOLDER MEETING ASTM B-32 OR BRAZED WITH SIL-FOS. SOLDER FLUXES SHALL MEET ASTM B-813 AND SHALL BE LEAD FREE. BRAZING FLUXES SHALL MEET AWS B3.1 OR F63-C.

D. WATER PIPING DOWNSTREAM OF SOFT DRINK CARBONATORS SHALL BE PROVIDED AND INSTALLED BY LOCAL SOFT DRINK VENDOR.

E. CPVC FITTINGS FOR PIPING SHALL BE SOLVENT WELD TYPE MEETING ASTM D-2846 WITH CEMENTS MEETING ASTM F-493 AND PRIMER MEETING ASTM F-656. CURE TIME MUST COMPLY WITH MANUFACTURER'S RECOMMENDATIONS. FOR CPVC PIPING INSTALLATION, WALL STUBS AT FIXTURES AND EQUIPMENT SHALL BE COPPER AND SHALL BE SERIES 630-C. CPVC TO COPPER STUB OUT ELBOWS BY SIOUX CHIEF.

F. NIPPLES, ELBOWS, AND OTHER ACCESSORY FITTINGS REQUIRED TO COMPLETE ANY WATER PIPING CONNECTION SHALL BE BRASS OR OF SIMILAR TYPE METAL AS THE FITTING TO WHICH IT IS CONNECTED. GALVANIZED FITTINGS ARE PROHIBITED. (EXCEPTION: GALVANIZED HEAT TRAP WATER HEATER NIPPLES IF INTERNALLY PROTECTED WITH TEFLON OR POLYMER CORROSION-RESISTANT COATING.)

G. ALL HVAC CONDENSATE PIPING SHALL BE SCHEDULE 40 PVC DWV AS MANUFACTURED BY CHARLOTTE PIPE AND MEETING ASTM D-1784, D-1785 AND D-2865.

H. U.N.O. ALL SANITARY WASTE, VENT, STORM DRAINAGE PIPING AND FITTINGS INSIDE THE BUILDING, ABOVE AND BELOW GRADE, AND FOR ROOFTOP CONDENSATE, SHALL BE SOLID WALL SCHEDULE 40 PVC DWV AS MANUFACTURED BY CHARLOTTE PIPE AND MEETING ASTM D-2665 AND D-2949. FOAM CORE AND/OR CELLULAR CORE PVC PIPING SHALL NOT BE ALLOWED. PVC PIPING OUTSIDE THE BUILDING, BELOW GRADE, SHALL BE TYPE SDR-35 MEETING ASTM D-3034, U.N.O.

I. DWV PIPE AND FITTINGS WITHIN WALLS BEHIND KITCHEN HOODS SHALL BE SERVICE WEIGHT HUBLESS CAST IRON WITH SLEEVE, SHIELD, AND DRAWN/BAND JOINTS MEETING ASTM A-888 AND ASTM C-564.

J. PVC-DWV FITTINGS FOR PIPING SHALL BE SOLVENT WELD TYPE INSIDE AND UNDERSLAB MEETING ASTM D-2665, D-3311 AND F-186. CEMENTS SHALL MEET ASTM D-2564 AND PRIMER MEETING ASTM F-656. CURE TIME MUST COMPLY WITH MANUFACTURER'S RECOMMENDATIONS. EXTERIOR PIPING JOINTS SHALL BE NEOPRENE PUSH-ON TYPE.

K. PROVIDE 1" THICK PIPE INSULATION FOR ALL ABOVE SLAB HOT AND TEMPERED WATER PIPING. PROVIDE 1/2" THICK INSULATION FOR ALL ABOVE SLAB COLD WATER, FILTERED WATER, CONDENSATE PIPING, AND HORIZONTAL RAIN WATER CONDUCTORS INSIDE THE BUILDING. PIPING INSULATION SHALL BE KNAUF 1000F 25/50 FIBERGLASS PIPE COVERING, WHITE KRAFT PAPER VAPOR BARRIER (02 PERMS) BONDED TO ALUMINUM FOIL AND REINFORCED WITH GLASS FIBERS. MAXIMUM THERMAL CONDUCTIVITY OF 0.23 AT 75F. LONGITUDINAL LAP SHALL BE SELF SEALING. INSULATION FOR WALK-IN COOLER/FREEZER CONDENSATE PIPING SHALL BE ARMAFLEX AP ARMAFLEX WITH MINIMUM 1/2" WALL THICKNESS.

L. PIPE INSULATION AND COVERINGS SHALL HAVE A RATING OF NOT GREATER THAN 25 FLAME SPREAD, NO HIGHER THAN 50 SMOKE DEVELOPED, AND NO MORE THAN 50 FUEL CONTRIBUTED. THE ONLY EXCEPTION SHALL BE ARMAFLEX AP, WHEN SPECIFIED, WHICH SHALL NOT EXCEED 100 SMOKE DEVELOPED.

M. A PVC 25/50 PRE-FORMED COVER SHALL BE PROVIDED AT ALL INSULATED PIPING FITTINGS EQUAL TO PROTO PVC CORP LOSMOKE, 800-875-7788.

N. ALL NATURAL GAS PIPING SHALL BE SCHEDULE 40 BLACK STEEL MEETING ASTM A53 WITH SCREWED OR WELDED FITTINGS AND GASKET TYPE UNIONS AND FLANGES. FOR SCREWED PIPING, PIPING SHALL BE JOINED WITH BLACK 150 POUND MALLEABLE IRON SCREWED FITTINGS AS ALLOWED BY LOCAL AUTHORITY. CONTRACTOR SHALL VERIFY THE NEED FOR WELDED PIPING AS REQUIRED BY THE LOCAL GAS CODE AND/OR APPLICABLE LOCAL ORDINANCES AND AMENDMENTS.

O. EXPOSED SUPPORTS AND ATTACHMENTS SHALL BE STAINLESS STEEL, CHROME OR CHROME PLATED. GALVANIZED ATTACHMENTS WILL NOT BE ACCEPTED.

P. USE MATERIALS SPECIFIED ON THESE PLANS. SUBSTITUTIONS ARE ALLOWED ONLY IF SPECIFIED MATERIALS ARE UNAVAILABLE. PRODUCT SUBSTITUTIONS WILL NOT BE ACCEPTED WITHOUT PRIOR APPROVAL. ALL WATER PIPING, FITTINGS, FIXTURES AND ACCESSORIES SHALL BE CERTIFIED LEAD FREE AS DEFINED IN, AND PER THE INTENT OF, THE "REDUCTION IN LEAD IN DRINKING WATER ACT".

## PART II - EXECUTION (C15100)

### 2.01 TRENCHING (C15100)

A. EXCAVATION, BACKFILLING, AND TRENCH WORK SHALL BE DONE IN ACCORDANCE WITH LATEST O.S.H.A. AND APPLICABLE SAFETY STANDARDS.

B. PROVIDE NECESSARY SHORING AND CLEANING TO KEEP TRENCHES IN GOOD WORKING CONDITION, INCLUDING PUMPING OUT WATER.

C. IN MOSTLY ROCK MATERIAL, TRENCHES SHALL BE EXCAVATED TO 6" BELOW THE ELEVATION OF THE BOTTOM OF THE PIPES. AFTER EXCAVATION, TRENCH SHALL THEN BE FILLED TO THE PROPER ELEVATION WITH CRUSHED LIMESTONE. GRAVEL SHALL BE REMOVED FROM UNDER PIPE BELLS SO THE PIPE RESTS FIRMLY ON THE TRENCH BOTTOM.

D. IN MOSTLY EARTH OR SAND MATERIAL, TRENCHES SHALL BE EXCAVATED TO 6" BELOW THE ELEVATION OF THE BOTTOM OF THE PIPES. AFTER EXCAVATION, TRENCH SHALL THEN BE FILLED TO THE PROPER ELEVATION WITH FINE SAND OR GRAVEL. TRENCH BOTTOM SHALL BE REMOVED AT PIPE BELLS SO THE PIPE RESTS FIRMLY ON THE TRENCH BOTTOM.

E. BACKFILLING AND TAMPING SHALL BE CAREFULLY DONE BY HAND SIMULTANEOUSLY ALONG BOTH SIDES OF THE PIPE USING ROCK FREE EARTH, CRUSHED STONE OR SAND UNTIL THE PIPE IS COVERED TO A DEPTH OF AT LEAST 12". BACKFILL SHALL BE ACCOMPLISHED IN SUCCESSIVE 6" LAYERS. THE REST OF THE

FILL-UP TO THE TOPSOIL LAYER MAY BE GRAVEL OR ROCK FREE EARTH.

F. ACCEPTABLE SOIL MATERIALS FOR BACKFILL AND FILL SHALL BE FREE OF CLAY, ROCK OR GRAVEL LARGER THAN 2" IN ANY DIMENSION, DEBRIS, WASTE, FROZEN MATERIALS AND OTHER DELETERIOUS MATTER HAVING A PLASTICITY INDEX LESS THAN 30. BACKFILL SHALL BE ACCOMPLISHED IN LAYERS OF NOT MORE THAN 6" AND EACH LAYER SHALL BE COMPACTED. THE LAST 12" OF BACKFILL SHALL BE ROCK FREE TOPSOIL.

G. SURFACE SHALL BE RESTORED TO ITS ORIGINAL CONDITION.

### 2.02 INSTALLATION (C15100)

A. WATER PIPING IN EXTERIOR WALL SHALL BE INSTALLED ON THE HEATED SIDE OF WALL INSULATION.

B. EXPOSED HOT AND COLD WATER TRIM FITTINGS AND ACCESSORIES IN FINISHED AREAS SHALL BE CHROME FINISHED.

C. ACCEPTABLE METHODS OF PIPE SUPPORT WITHIN WALLS SHALL BE THE SUMNER SYSTEM, POSIFIX, STAKFIX, PIPEFIX, HOLDRITE OR CHANNEL.

D. PROVIDE J.R. SMITH OR APPROVED EQUAL SHOCK ABSORBERS #5005 THRU 5050 SIZE AS RECOMMENDED BY MANUFACTURER. INSTALLED ON HOT AND COLD WATER BRANCH LINES CONTAINING SINGLE LEVER FAUCETS, FLUSH VALVES OR EQUIPMENT WITH QUICK CLOSING VALVES BETWEEN THE LAST TWO FIXTURES AS SHOWN ON THE CONTRACT DRAWINGS. SHOCK ABSORBERS SERVICING FIXTURES WITH FLUSH VALVES SHALL BE SECURELY ANCHORED IN THEIR VERTICAL POSITION.

E. SANITARY WASTE LINES SHALL BE UNIFORMLY GRADED TO ELEVATIONS SHOWN. IF NO ELEVATIONS ARE GIVEN, SEWERS SHALL BE PITCHED NOT LESS THAN 1/4" PER FOOT FOR ALL PIPING 2-1/2" IN DIAMETER AND SMALLER AND 1/8" PER FOOT FOR ALL PIPING 3" IN DIAMETER AND LARGER.

F. STORM PIPING SHALL BE SLOPED AT 1/2" PER FT (2%) UNLESS NOTED OTHERWISE ON PLANS.

G. SUPPORT HORIZONTAL PIPING ACCORDING TO LOCAL PLUMBING CODE. HANGER RODS SHALL BE SIZED AS FOLLOWS:

NOMINAL PIPE SIZE (IN)	MINIMUM HANGER DIAMETER (IN)
1/2	3/8
3/4 TO 1-1/2	3/8
2 TO 2-1/2	3/8
3 TO 6	1/2

H. HANGERS FOR PIPING GREATER THAN 1" SHALL PASS OVER THE INSULATION. PROVIDE SADDLES FOR INSULATED PIPING.

I. INSULATION SHALL BE APPLIED WITH JOINTS TIGHTLY BUTTED. OPEN CRACKS, VOIDS AND DEPRESSIONS SHALL BE FILLED WITH HYDRAULIC SETTING CEMENT. TAPPING MATCHING THE FINISH SHALL BE PASTED NEATLY OVER JOINTS. FITTINGS AND VALVES SHALL BE INSULATED WITH THE SAME TYPE.

J. PROVIDE AND INSTALL A CUT-OFF VALVE, UNION AND FULL SIZE QUIT LEG AT CONNECTION TO EACH GAS-FIRED PIECE OF EQUIPMENT. INSTALL PIPING AT AND AROUND EQUIPMENT SO AS TO NO WAY OBSTRUCT EQUIPMENT ACCESS PANELS AND/OR ACCESS DOORS.

K. COORDINATE ABOVE-CEILING PIPING LOCATIONS AND ROUTING WITH HVAC CONTRACTOR AND M-SHEETS PRIOR TO INSTALLATION. ALL MAIN DUCT TRUNK LOCATIONS SHALL TAKE PRIORITY. PIPING MAY REQUIRE REMOVAL AND REINSTALLATION AT PLUMBING CONTRACTOR'S EXPENSE IF PIPING OBSTRUCTS THE M-SHEET DUCT LAYOUT AS SHOWN OR PREVENTS ACCESS TO GREASE DUCT CLEANOUT OPENINGS.

L. ALL GAS PIPING ABOVE ROOF SHALL BE CLEANED FREE OF RUST AND PAINTED WITH COAT OF ZINC RUST PRIMER AND ONE COAT OF ALUMINUM BASE PAINT. METER AND GAS RISER SHALL BE PRIMED AND PAINTED TO MATCH BUILDING. APPLY TWO COATS OF ASPHALTUM BASE PAINT TO PIPING BURIED UNDERGROUND.

### 2.03 TESTING (C15100)

A. POTABLE WATER PIPING SHALL BE PRESSURE TESTED IN ACCORDANCE WITH APPLICABLE CODE REQUIREMENTS AND MANUFACTURER'S RECOMMENDATIONS.

B. THE POTABLE WATER SYSTEM SHALL BE FLUSHED OUT PROGRESSIVELY BY OPENING OUTLETS AND FLOWING WATER UNTIL IT RUNS CLEAR. AFTER PIPE CLEANING IS COMPLETED, THE STRAINERS SHALL BE REMOVED, CLEANED, AND REPLACED. THEN THE ENTIRE POTABLE WATER SYSTEM SHALL BE DISINFECTED IN ACCORDANCE WITH THE AUTHORITY HAVING JURISDICTION.

C. THE SANITARY WASTE SYSTEM SHALL BE FLUSHED OUT PROGRESSIVELY WITH FLOWING WATER UNTIL IT RUNS CLEAR.

D. THE ENTIRE SANITARY WASTE SYSTEM AND STORM DRAINAGE SYSTEM SHALL BE PRESSURE TESTED IN ACCORDANCE WITH APPLICABLE CODE REQUIREMENTS AND MANUFACTURER'S RECOMMENDATIONS.

E. NATURAL GAS PIPING SHALL BE LEAK TESTED IN ACCORDANCE WITH APPLICABLE CODE REQUIREMENTS AND MANUFACTURER'S RECOMMENDATIONS.

## PART III - MANUFACTURERS

### 3.01 PRODUCTS - PIPING SYSTEMS, ETC (C15100)

A. HYDRANTS, CARRIERS, DRAINS, AND SHOCK ABSORBERS: ZURN. ACCEPTABLE ALTERNATES: JAY R. SMITH, JONES STEPHENS CORP, WATTS, OR JOSAM.

B. ALTERNATES TO ZURN (ZRN) FIXTURES: ONLY AS SHOWN ON PLANS. APPROVED JAY R. SMITH (JRS), WATTS (WTS), MODEL NUMBERS LISTED ON FIXTURE SCHEDULE, THIS SHEET.

### 3.02 PRODUCTS - RESTROOM FIXTURES PORCELAIN & VALVES (C15405)

A. PREFERRED FIXTURES: TOTO. NO EXCEPTION.

B. ALTERNATE FIXTURES: ONLY AS SHOWN ON PLANS.

C. FITTINGS: AS SPECIFIED ON THE PLANS. NO SUBSTITUTIONS ALLOWED.

D. FLUSH VALVES AND LAVATORY FAUCETS: TOTO MANUFACTURING. NO SUBSTITUTIONS ALLOWED.

E. PREFERRED TOILET SEATS: TOTO. ALTERNATE TOILET SEATS: CHURCH, BEMIS, AND BENEKE.

F. FLOOR SINKS: ZURN WITH ALUMINUM SEDIMENT BUCKETS. NO SUBSTITUTIONS ALLOWED.

# 2. PLUMBING FIXTURES

## RESTROOM FIXTURES (C15405)

P-1 WATER CLOSET: TOTO MODEL CT705EN BOWL WITH 128 GPF TET-11-A #32CP ECO-POWER FLUSH VALVE AND SC534 SEAT. NO SUBSTITUTIONS. WHITE, FLOOR MOUNTED, FLUSH VALVE TYPE. VITREOUS CHINA, 1/2" TOP SPUD, ELONGATED BOWL. ELECTRONIC SENSOR OPERATED HANDS-FREE FLUSH VALVE. WHITE OPEN FRONT SEAT WITH CHECK HINGE. CHICK-FIL-A HAS NATIONAL ACCOUNTS WITH TOTO. PLEASE SEE NATIONAL ACCOUNT INFORMATION ON THIS SHEET FOR PRICING OF TOTO FIXTURES.

P-2 WATER CLOSET (ADA): TOTO MODEL CT705EN BOWL WITH 128 GPF TET-11-A #32CP ECO-POWER FLUSH VALVE AND SC534 SEAT. NO SUBSTITUTIONS. H.C. ACCESSIBLE. WHITE, FLOOR MOUNTED, 1/2" HIGH FLUSH VALVE TYPE, VITREOUS CHINA, 1/2" TOP SPUD, ELONGATED BOWL. ELECTRONIC SENSOR OPERATED HANDS-FREE FLUSH VALVE. WHITE OPEN FRONT SEAT WITH CHECK HINGE. CHICK-FIL-A HAS NATIONAL ACCOUNTS WITH TOTO. PLEASE SEE NATIONAL ACCOUNT INFORMATION ON THIS SHEET FOR PRICING OF TOTO FIXTURES.

P-3 URINAL: TOTO MODEL UT445U URINAL WITH TEL 1 UA 12CP Q125 GPF SELF-SUSTAINED HYDROPOWER SELF-GENERATING ELECTRONIC SENSOR OPERATED FLUSH VALVE. NO SUBSTITUTIONS. VITREOUS CHINA, 3/4" TOP SPUD, SENSOR OPERATED WITH MANUAL OVERRIDE BUTTON. INTERNAL VALVE FILTER PROTECTION. PLEASE SEE NATIONAL ACCOUNT INFORMATION ON THIS SHEET FOR PRICING OF TOTO PRODUCTS.

P-4 LAVATORY FAUCET (BUILT-IN COUNTERTOP LAVATORY PROVIDED BY OWNER): TOTO MODEL T2855ETCP ECO-POWER SENSOR HOT/COLD FAUCET WITH THERMOSTATICALLY CONTROLLED ASSE 1070 MIXING VALVE FAUCET. 0.09 GALLONS PER CYCLE. NO SUBSTITUTIONS. PROVIDE MCGUIRE LFT5 SUPPLY WITH STOP. MCGUIRE LFT5 CRD DRAIN WITH OFFSET TAILPIECE. MCGUIRE 8872 POLISHED CHROME P-TRAP. P-TRAP SHALL BE PARALLEL WITH BACK WALL. PROVIDE A TUBERO INC. HANDI LAV-GUARD INSULATION KITS MODELS IOE-2 AND IOE-2-Z. CHICK-FIL-A HAS NATIONAL ACCOUNTS WITH TOTO. PLEASE SEE NATIONAL ACCOUNT INFORMATION ON THIS SHEET FOR PRICING OF TOTO FIXTURES.

## PLUMBING (C15100)

P-5 KITCHEN HAND SINK ROUGH-IN SINK BY TMS, FAUCET: TOTO MODEL #TEL65-C20ECP - PROVIDED BY HJC WITH TP3094 NOZZLE. CONTRACTOR SHALL INSTALL WALL HUNG, STAINLESS STEEL SINK AND FAUCET SET AND MAKE FINAL CONNECTIONS. MCGUIRE LFT75 SUPPLIES WITH STOPS AND A MCGUIRE 8912C POLISHED CHROME P-TRAP (PROVIDED BY HJC). ADJUST FAUCET OUTLET TEMPERATURE TO 110 DEGREES F (OR HIGHER AS REQUIRED BY LOCAL JURISDICTION).

P-5A KITCHEN DUMP SINK ROUGH-IN SINK BY TMS, FAUCET: TMS MODEL #B146-CFA-VF05 - PROVIDED BY HJC WITH TP3094 NOZZLE. CONTRACTOR SHALL INSTALL WALL HUNG, STAINLESS STEEL SINK AND FAUCET SET AND MAKE FINAL CONNECTIONS. MCGUIRE LFT75 SUPPLIES WITH STOPS AND A MCGUIRE 8912C POLISHED CHROME P-TRAP (PROVIDED BY HJC).

P-6 SERVING COUNTER DROP-IN SINK ROUGH-IN SINK PROVIDED BY CLAYTON FIXTURE, FAUCET-TOTO T2475ETCP WITH 1.0 GPM AERATOR PROVIDED BY HJC. CONTRACTOR SHALL INSTALL SINK AND FAUCET SET AND MAKE FINAL CONNECTIONS. MCGUIRE 8912C POLISHED CHROME P-TRAP AND MCGUIRE LFT7520 STOPS WITH 20" CHROME PLATED 3/4" COPPER RISERS (PROVIDED BY HJC). ADJUST FAUCET OUTLET TEMPERATURE TO 110 DEGREES F (OR HIGHER AS REQUIRED BY LOCAL JURISDICTION).

P-7 MOP SINK FAUCET: MOP SINK BASIN BUILT BY GENERAL CONTRACTOR. PROVIDE T65 BRASS MODEL B-2345 FAUCET WITH CERAMIC SPRING CHECK VALVE CARTRIDGES, HOSE THREAD SPOUT OUTLET, TOP BRACE, ADJUSTABLE INLET SPREAD FROM 3" TO 8", INCLUDE T65 BRASS MODEL 49-072 HOSE-THREAD X 3/4" FEMALE NPT CHROME ADAPTOR. NO SUBSTITUTIONS. SEE ALSO P-14.

P-8 VEGETABLE PREP SINK ROUGH-IN SINK PROVIDED BY TMS, FAUCET: T65 B-01524-CR2CT WITH 0.65 GPM SPRAY HEAD BY HJC. CONTRACTOR SHALL INSTALL SINK AND MAKE FINAL CONNECTIONS. MCGUIRE LFT508 STOPS AND BRASSCRAFT 36" CHROME PLATED 1" OD COPPER RISERS MODEL 3-36AC PROVIDED BY HJC. ASSEMBLE AND MOUNT TWO HANDLE FAUCET WITH PRE-RINSE SPRAY ARM. INSTALL ADD-ON FAUCET WITH SPOUT AT BASE OF PRE-RINSE RISER. SEE K-SHEET ELEVATIONS. PROVIDE 1/2" SCHED 80 PVC PIPE AND FITTINGS. INDIRECT WASTE LINES FROM SINK BASINS TO FLOOR SINK P-13B, NO P-TRAPS REQUIRED. HJC TO PROVIDE FISHER #22209 DRAINS WITH FLAT STRAINERS.

P-9 FOUR COMPARTMENT POT SINK ROUGH-IN SINK PROVIDED BY TMS, FAUCETS: T65 B-01524-CR2CT & B2299-CR WITH 0.65 GPM SPRAY HEAD PROVIDED BY HJC. CONTRACTOR SHALL INSTALL SINK, ASSEMBLE & MOUNT TWO FAUCETS AND MAKE FINAL CONNECTIONS. MCGUIRE LFT508 STOPS AND BRASSCRAFT 36" CHROME PLATED 1" OD COPPER RISERS MODEL 3-36AC PROVIDED BY HJC. ASSEMBLE AND MOUNT ONE TWO-HANDLE FAUCET WITH PRE-RINSE SPRAY, INSTALL ADD-ON FAUCET WITH SPOUT AT BASE OF PRE-RINSE RISER. ASSEMBLE AND MOUNT ONE TWO-HANDLE FAUCET WITH DOUBLE JOINT SPOUT ON OPPOSITE SIDE. SEE K-SHEET ELEVATIONS FOR FAUCET LOCATIONS. PROVIDE 1/2" SCHED 80 PVC PIPE AND FITTINGS. INDIRECT WASTE LINES FROM EACH SINK BASIN TO FLOOR SINK P-13A, NO P-TRAPS REQUIRED. HJC TO PROVIDE FISHER #22209 DRAINS WITH FLAT STRAINERS.

P-10 FLOOR DRAIN (3") ZURN EZ-PV3-28 BRONZE SPUD WITH 8" DIAMETER NICKEL BRONZE STRAINER. ALT. JONES STEPHENS CORP. 053144.

P-11 WALL HYDRANT (NON-FREEZE) WOODFORD MODEL 67-C AUTOMATIC DRAINING WALL HYDRANT WITH DUAL CHECK BPP. ASSE 1052 APPROVED WALL CLAMP, POLISHED BRASS FINISH. 1" STYLE INLET. SEE WALL HYDRANT NOTES ON P121 FOR WALL THICKNESS AT WALL HYDRANTS. ALT. (WTS) HY-42.

P-12 FUNNEL DRAIN (3") ZURN MODEL 2N415-3N-6S-4 FLOOR DRAIN W/FUNNEL. INDIRECT WASTE RECEIVER WITH NICKEL BRONZE STRAINER AND FUNNEL. PROVIDE 6" SQUARE STRAINER WITH 4" ROUND FUNNEL AT WALK-IN COOLER. ALT. (WTS) FDI03P-M6-F4-1, (JRS) 3510L03.

P-13A FLOOR SINK (POT SINK) ZURN MODEL Z190-KC-H-4N-1-23 CAST IRON INDIRECT WASTE RECEIVER WITH 1/2" SQUARE BODY, FLASHING CLAMP, 8" DEEP, ALUMINUM SEDIMENT BUCKET, AND NO GRATE. NO SUBSTITUTIONS.

P-13B FLOOR SINK (VEGETABLE SINK) ZURN MODEL Z190-KC-3N-1-23 CAST IRON INDIRECT WASTE RECEIVER WITH FLASHING CLAMP, 8" SQ. BODY, ALUMINUM SEDIMENT BUCKET, AND NO GRATE. NO SUBSTITUTIONS.

P-13C FLOOR SINK (DUMP SINK) 3" WASTE CONNECTION. ZURN MODEL Z190-NL-KC-2-23 CAST IRON BODY WITH INDIRECT WASTE RECEIVER, NEO-LOC OUTLET, ANCHOR FLANGE WITH SEEPAGE HOLES AND CLAMP COLLAR, WITH HALF GRATE, AND ALUMINUM BUCKET. PROVIDE BY HJC. NO SUBSTITUTIONS.

P-14 CLEANOUTS INSIDE BUILDING: ZURN 2N400-XN-L-T-8P CLEANOUT WITH 6" SQUARE NICKEL BRONZE TOP AND TAPER THREADED BRONZE PLUG. SEE PLAN FOR SIZE. ALT. (X-Pipe DIA) (WTS) CO-X00P-F, (JRS) 4053L.

P-15 CLEANOUTS OUTSIDE BUILDING: ZURN Z1474-X-N-EXTRA-HEAVY DUTY CAST IRON CLEANOUT. CO. CAST IN COVER, ABS PLUG, NEO-LOK OUTLET. ALT. (X-PIPE DIA) (WTS) CO-X00-M-F, CO-38X, (ZRN) Z1474-X-N (JRS) 426L.

P-16 3-WAY DIVERter VALVE ASSEMBLY: WATTS MODEL LFB 6780 ROUGH BRASS LEAD-FREE DIVERter BALL VALVE WITH 3/4" FIP INLET AND OUTLETS AND QUARTER TURN LEVER HANDLE. PROVIDE WITH TWO (2) FORGED BRASS 3/4" MIP X 3/4" MALE GARDEN HOSE-THREAD ADAPTERS (PLUMBEST MODEL G20-C03 OR EQUAL). PROVIDE WITH ONE ASSE IOI APPROVED CHROME PLATED VACUUM BREAKER (WOODFORD MODEL 34H-C4 OR EQUAL). FOR INSTALLATION AT MOP SINK. SEE P124. PROVIDE ALSO TWO 3/4" CLOSE CHROME PLATED BRASS NIPPLE AND 3/4" POLISHED CHROME 90 DEGREE ELBOW.

P-17 VACUUM RELIEF VALVE: WATTS MODEL #LFB36M, 3/4" CONNECTION.

P-18 EXPANSION TANK: STATE INDUSTRIES MODEL ETC-5X. ACCEPTANCE 3.05 GALLONS AT 40 PSI PRECHARGE. 3/4" CONNECTION. ALTERNATE MODELS SIZED PER WATER HEATER MANUFACTURER RECOMMENDATIONS ARE ACCEPTABLE.

P-19 WATER HEATER RINAI MODEL NUMBER TRX020UN TANKLESS TYPE GAS FIRED WATER HEATER, 398 MBH INPUT, 7.6 GPM FLOW RATE AT 100F RISE. SEALED COMBUSTION, CONDENSING TYPE WITH COMMERCIAL NEUTRALIZATION TANK (W/MEDIA, WITH 8 YEAR HEAT EXCHANGER WARRANTY, 5 YEAR PART AND COMPONENTS WARRANTY, AND 1 YEAR REASONABLE LABOR WARRANTY).

P-20 THERMOMETER: PROVIDE TRECICE MODEL 8834-04-04 3" DIAL TYPE THERMOMETER WITH BOTTOM 1/2" NPT. CONNECTION, 4" STEM AND 0 DEG F TO 200 DEG F RANGE. LEAD FREE.

P-21 BACKFLOW PREVENTERS: COORDINATE LOCATION WITH CIVIL SITE UTILITY PLAN. BACKFLOW PREVENTER TYPE AND MODEL IS DETERMINED BY CIVIL ENGINEER IF LOCATED OUTSIDE THE BUILDING.

DOUBLE CHECK TYPE  
WATTS NO. LFL007MOT 2" DUAL CHECK MODULAR TYPE BACKFLOW PREVENTER MEETING ASSE IO15 AND AWWA C510-92. WHERE REQUIRED BY LOCAL AUTHORITY, USE THE RPZ TYPE BPP SHOWN BELOW. ALT. (ZRN) 112-350XL.

REDUCED PRESSURE ZONE (RPZ) TYPE  
WATTS NO. LFL009M2 2" MODULAR TYPE WITH TEST PORTS AND INTERMEDIATE RELIEF VALVE MEETING ASSE IO15 AND AWWA C511-89. PROVIDE WATTS NO. 909-AG-C AIR GAP DEVICE. ALT. (ZRN) 112-975XL2J.

P-22 MOP SINK CHECK VALVES: T65 BRASS 1/2" MODEL B-CVH-2 BALL CHECK.

P-23 UTILITY CONNECTION (ICE MAKER): PROVIDE A MCGUIRE MODEL LFT506SB LEAD-FREE CHROME WHEEL ANGLE STOP, 1/2" FIP INLET AND OUTLET. PROVIDE CHROME WALL ESCUTCHEON. INSTALL WITH BPP P-34. SEE DETAIL 3/P21 FOR PIPING AT ICE MAKERS.

P-24 UTILITY CONNECTION (COFFEE & TEA BREWERS): PROVIDE A MCGUIRE MODEL LFT506SB LEAD-FREE CHROME WHEEL ANGLE STOP, 1/2" FIP INLET AND OUTLET. PROVIDE CHROME WALL ESCUTCHEON. INSTALL WITH BPP P-34.

P-25 SHOCK ABSORBER: ZURN Z1700-H00 THRU Z1700-300 AS NEEDED, SIZE AS RECOMMENDED BY MANUFACTURER. ALT. (WTS) SSA + SSB, (JRS) 5005 THROUGH 5050.

P-26 FUNNEL DRAIN (3") ZURN 2N415-3N-6S-4 FLOOR DRAIN W/FUNNEL. INDIRECT WASTE RECEIVER WITH NICKEL BRONZE STRAINER AND FUNNEL. PROVIDE 8" ROUND STRAINER WITH 3.25" X 8.25" OBLONG FUNNEL. ALT. (WTS) FDI03P-A8-G-1, (JRS) SMITH 3510L03.

P-26A TRAP SEAL PROTECTOR: PROVENT TRAP GUARD MODEL TG3H 3" TRAP SEAL INSERT FOR INTERIOR INSTALLATION AND REPLACEMENT ACCESS THROUGH STRAINER. PROVIDE AT P-35 FLOOR DRAINS IN RESTROOMS, P-37 FLOOR DRAINS DINING ROOM, AND P-26 FUNNEL DRAINS IN KITCHEN ROOM. TRAP GUARDS TO BE USED ALONG WITH EQUIVALENT TRAP PRIMERS. PROVIDE PROSET MODEL TG33R-ZURN WHEN USING ZURN FLOOR FIXTURES.

P-27 WATER PRESSURE GAUGE: TRECICE MODEL 800B, 2-1/2" ROUND, BOTTOM OUTLET WITH 1/4" NPT. CONNECTION AND 0 TO 100 PSI RANGE.

P-28 BALL VALVE: NIBCO MODEL 4660-T, 3/4", WITH IPS INLET AND OUTLET.

P-29A ICE MACHINE TRENCH DRAIN (8") ZURN ZR12-CFA-18 TRENCH DRAIN WITH SEDIMENT CUP AND SERRATED LADDER GRATES. PROVIDE WITH 4" DRAIN AND TRAP. TRENCH DRAIN SHALL BE RECESSED INTO SLAB SO THE TOP OF THE PERIMETER FRAME IS FLUSH WITH THE FINISHED FACE OF THE ADJACENT TILE FLOOR. TRENCH DRAIN, SEDIMENT CUP, AND GRATES SHALL BE 304 STAINLESS STEEL.

P-29B ICE MACHINE TRENCH DRAIN (36") ZURN ZR12-CFA-36 TRENCH DRAIN WITH SEDIMENT CUP AND SERRATED LADDER GRATES. PROVIDE WITH 4" DRAIN AND TRAP. TRENCH DRAIN SHALL BE RECESSED INTO SLAB SO THE TOP OF THE PERIMETER FRAME IS FLUSH WITH THE FINISHED FACE OF THE ADJACENT TILE FLOOR. TRENCH DRAIN, SEDIMENT CUP, AND GRATES SHALL BE 304 STAINLESS STEEL.

P-29C CENTERLINE TABLE FLOOR SINK: ZURN Z1910-KC-3N-1-23 SANI-FLOOR RECEPTOR CAST IRON INDIRECT WASTE RECEIVER WITH 8-1/2" SQUARE BODY, ALUMINUM SEDIMENT BUCKET AND HALF-GRATE. NO SUBSTITUTIONS.

P-29D BREADING TABLE FLOOR SINK: ZURN Z1910-KC-3N-1-23 SANI-FLOOR RECEPTOR CAST IRON INDIRECT WASTE RECEIVER WITH 8" SQUARE BODY, ALUMINUM SEDIMENT BUCKET AND HALF-GRATE. NO SUBSTITUTIONS.

P-30 FILTERED WATER FAUCET: FILTERED WATER FAUCETS: T65 B-02236-CR-063X KITCHEN FAUCET & T65 B-02236-CR-063X TUB FAUCET. TWO-HANDLE WALL MOUNT FAUCET WITH SWING SPOUT. MOUNT ON AS SHOWN ON K-SHEETS. PIPE FILTERED WATER TO BOTH SIDES OF FAUCET. CONNECT TO SUPPLY PIPING WITH BRASS OR CHROME NIPPLES. GALVANIZED NOT ALLOWED.

P-31 DUMPSTER POST HYDRANT (NON-FREEZE) WOODFORD MODEL Y2 LEVER TYPE POST HYDRANT, 3/4" HOSE CONNECTION, LOCKABLE LEVER HANDLE, BRASS CASING, BRASS OPERATING ROD, ASSE 1062 APPROVED AND 36" DEPTH OF BURY.

P-32 DUMPSTER PAD DRAIN: J.R. SMITH FIGURE NO. 22800C3 3" FLOOR DRAIN WITH 7-1/2" HINGED CAST IRON SLOTTED GRATE AND SEDIMENT BUCKET. PROVIDED AND INSTALLED BY SITE CONTRACTOR. ALT. (ZRN) 2560-3N-L-Y.

P-33 TRAP PRIMER (MECHANICAL TYPE) PRECISION PRODUCTS PR-500. PROVIDE DISTRIBUTION UNIT WHERE SERVING MULTIPLE DRAINS. PROVIDE SCREWDRIVER STOP AT PRIMER INLET. ALT. (WTS) TP-300A-DR. DO NOT USE UNLESS REQUIRED BY LOCAL AUTHORITY.

P-34 DISPENSER BACKFLOW PREVENTER: WATTS MODEL #MLF7R122D ASSE 1024 RATED WITH 1/2" FIP INLET AND OUTLET, DUAL CHECK TYPE. PROVIDE 1/2" DIA X 2" LONG CHROME NIPPLE AT BPP INLET AND OUTLET. PROVIDE T65 BRASS MODEL B-010 CHROME WALL BRACKET.

P-35 FLOOR DRAIN (3") JONES STEPHENS CORP D50-064 PVC BODY, BRONZE SPUD WITH 6" DIAMETER NICKEL BRONZE STRAINER. SEE DWG PH FOR DRAINS IN RESTROOMS REQUIRING 1/2" TRAP PRIMER CONNECTION. ALT. (WTS) FDI03-A6-60, (ZRN) FROGNP35-C.

P-36 BEVERAGE TOWER INDIRECT RECEIVER (3") ZURN Z190H-L-2-23-91 CAST IRON INDIRECT WASTE RECEIVER, HALF-GRATE, STAINLESS STEEL MESH LINER, AND ALUMINUM BUCKET.

P-37 FLOOR DRAIN (3") JONES STEPHENS CORP D50-076 PVC BODY, BRONZE SPUD WITH 6" SQUARE NICKEL BRONZE STRAINER. PROVIDE 1/2" TRAP PRIMER CONNECTION FOR DINING ROOM DRA

# 1 KITCHEN EQUIPMENT SCHEDULE - CHICK-FIL-A REMODEL Store #1385

VERIFY THE QUANTITY AND ROUGH-IN OF EACH EQUIPMENT ITEM WITH THE KITCHEN EQUIPMENT SCHEDULE

SCHEDULE NOTES	EQUIP. NO.	EQUIPMENT DESCRIPTION	ELECTRICAL LOAD				NEMA CONFIG		COOPER/ARROW HART (UON) RECEPTACATOG. NO.	Wire/Condu it MARK NO.	COMMENTS AND REMARKS		
			VOLTS	PH	WIRES	KW	AMPS	WALL				DROP-CORD	
	180	ORDER REGISTER (POS)	120	1	2			0.7	5-20R	N/A	IG5362RN (ORANGE)	1-IG	
	182	RECEIPT PRINTER	120	1	2			0.18	5-20R	5-20R	IG5362RN (ORANGE)	1-IG	
	182L	LABEL PRINTER	120	1	2			0.18	5-20R	5-20R	IG5362RN (ORANGE)	1-IG	
NOTE 5	183	ORDER MONITOR	120	1	2			0.125	5-20R	5-20R	IG5362RN (ORANGE)	1-IG	
NOTE 2 OR 5	184	IPAD	120	1	2	0.120		1.0	5-20R	5-20R	VG20	1	
NOTE 2	190	DRIVE-THRU VIDEO MONITOR	120	1	2			0.8	5-20R	N/A	CR20	1	
NOTE 5	211b	FLY SYSTEM - KITCHEN AREA	120	1	2	0.078		0.650	5-15R	N/A	TR780W (DUPEX)	1	CLOCK STYLE RECEPTACLE REQ'D
	269	ANSUL FIRE SYSTEM	120	1	2			VERIFY	DIRECT	N/A	-	1	FED FROM CFA-T500 PANEL
	270	ANSUL FIRE SYSTEM	120	1	2			VERIFY	DIRECT	N/A	-	1	FED FROM CFA-T500 PANEL
NOTE 2	300a	MILKSHAKE DISPENSER	120	1	2			4.0	5-20R	N/A	1877 (SIMPLEX)	1	
	300X	DOUBLE BARREL ICE DREAM	208	3	3			15.0	15-20R	N/A	HUBBELL HBL8420	2	FURNISHED WITH ANGLE PLUG
	305	TEA BREWER	120	1	2	1.650		13.8	5-20R	N/A	VG20	1	
	308	COFFEE BREWER	208	1	3	4.000		19.2	L14-30R	N/A	AHL1430R	8	
NOTE 2	309	SINGLE JUICE DISPENSER	120	1	2			3.6	5-20R	N/A	1877 (SIMPLEX)	1	
NOTE 2	310	DOUBLE JUICE DISPENSER	120	1	2			8.5	5-20R	N/A	1877 (SIMPLEX)	1	
	315W	DRINK TOWER	120	1	2			10.0	5-20R	N/A	CR20	1	
NOTE 2	320	TURBO CARBONATOR	120	1	2			6.2	5-20R	N/A	CR20	1	
	363H	HIGH-TEMP DISHMACHINE	208	3	3			45.4	DIRECT	N/A	-	17	PROVIDE IN-SIGHT DISC SWITCH OR PAD-LOCK DEVICE ON BRANCH BREAKER IF ALLOWED BY AHJ
	380A	ICE BIN SANITATION SYSTEM	120	1	2	0.010		5-15R	N/A	N/A	-	-	PLUGS INTO DUPEX OF ONE #380Z UNIT
NOTE 5	380	INTERIOR ICE MAKER	120	1	2	0.600		5-15R	N/A	817 (SIMPLEX) CR15 (DUPEX)	1		
	380C	ROOF MTD ICE CONDENSER	208	3	4	5.112		14.2	DIRECT	N/A	-	6	
NOTE 5	380D	INTERIOR ICE MAKER	120	1	2	0.600		5-15R	N/A	817 (SIMPLEX) CR15 (DUPEX)	1		
	380CD	ROOF MTD ICE CONDENSER	208	3	4	5.652		15.7	DIRECT	N/A	-	6	
NOTE 2	400	REACH-IN FRY FREEZER	120	1	2			9.4	5-20R	L5-20R	VG20 / AHL520R	1	
	410	WALK-IN FREEZER DOOR HTR/LTG	120	1	2			3.3	DIRECT	N/A	-	1	REFER TO LIGHTING FLOOR PLAN
	410	WI FREEZER CONDENSER	208	3	3			16.30	DIRECT	N/A	-	11	REQUIRES 35 AMP MOCP
	410	WI FREEZER EVAP COIL	208	1	2			1.5	DIRECT	N/A	-	-	POWER FED FROM CONDENSER
NOTE 5	420	SINGLE UC REFRIGERATOR	120	1	2			4.7	5-20R	L5-20R	1877 (SIMPLEX) / AHL520R	1	
NOTE 2	421	DOUBLE UC REFRIGERATOR	120	1	2			6.3	5-20R	L5-20R	1877 (SIMPLEX) / AHL520R	1	
NOTE 5	422	REFRIGERATED EQUIPMENT STAND	120	1	2			6.7	5-15R	L5-15R	1877 (SIMPLEX) / CWL515C	1	
NOTE 5	431	REFRIGERATED WORK TABLE	120	1	2			6.3	5-20R	L5-20R	1877 (SIMPLEX) / AHL520R	1	PROVIDE TWIST LOCK PLUG IN FIELD
NOTE 5	432	REFRIGERATED WORK TABLE	120	1	2			6.3	5-20R	L5-20R	1877 (SIMPLEX) / AHL520R	1	PROVIDE TWIST LOCK PLUG IN FIELD
NOTE 2	439	COLD RAIL	120	1	2			7.1	5-20R	N/A	VG20	1	
NOTE 2	440CT	BREADING TABLE	120	1	2			1.0	L5-15R	L5-15R	CWL515R / CWL515C	1	PROVIDE 10-FT CORD AND TWIST LOCK PLUG
NOTE 5	441	REFRIGERATED SALAD PREP	120	1	2			9.0	L5-15R	L5-15R	CWL515R / CWL515C	1	15 AMP TWIST LOCK PLUG PROVIDED W/ EQUIP
NOTE 2	442WCT	SINGLE UPRIGHT REFRIGERATOR	120	1	2			7.0	L5-15R	L5-15R	CWL515R / CWL515C	1	PROVIDE TWIST LOCK PLUG IN FIELD
	444	DOUBLE DOOR THAWING CABINET	120	1	2			16.0	DIRECT	DIRECT	-	1	PROVIDE 6-FT LIQUID-TIGHT FLEX CONDUIT
	449	WALK-IN COOLER LIGHTING	120	1	2			2.4	DIRECT	N/A	-	1	REFER TO LIGHTING FLOOR PLAN
	449	WI COOLER CONDENSER	208	3	3			9.50	DIRECT	N/A	-	2	REQUIRES 15 AMP MOCP
	449	WI COOLER EVAP COIL	208	1	2			1.0	DIRECT	N/A	-	1	POWER FED FROM CONDENSER
NOTE 2 OR 5	500A	VERTICAL CONTACT TOASTER	120	1	2	1.800		15.0	5-20R	L5-20R	VG20 / AHL520R	1	
	500B	RADIANT TOASTER	208	1	3	5.000		24.0	L6-30R	L6-30R	AHL530R / AHL530C	8	
NOTE 5	503	EGG STATION	208	1	3	2.000		12.5	6-20R	L6-20R	1876 (SIMPLEX) / AHL620C	2	TWIST LOCK PLUG PROVIDED W/ EQUIP
	505V	MULTI-COOK OVEN	208	3	3	7.920		22.0	L15-30R	L15-30R	AHL1530R / AHL1530C	9	PROVIDE 6 FT CORD AND PLUG
NOTE 3	522	OPEN FRYER - ELECTRIC	208	3	3	22.000		61.0	NOTE 3	N/A	-	22	PLUG AND CORD-SET PROVIDED W/ EQUIP
NOTE 3	522A	DOUBLE OPEN FRYER - REQUIRES TWO ELECTRICAL CONNECTIONS EACH OF THE SAME LOAD AND CHARACTERISTICS AS #522 ABOVE	208	3	3	22.000		61.0	NOTE 3	N/A	-	22	PLUG AND CORD-SET PROVIDED W/ EQUIP
	523	PRESSURE FRYER - ELECTRIC	208	3	3	13.500		38.0	15-50R	N/A	HUBBELL HBL8450A	14	PLUG AND CORD-SET PROVIDED W/ EQUIP
	524	DUAL SIDED CHAR-GRILL	208	3	3	9.000		24.1/28.2/23.1	15-50R	N/A	HUBBELL HBL8450A	14	
NOTE 2	560	FRY HOLDING STATION	120	1	2	1.840		15.4	DIRECT	N/A	-	1	
NOTE 5	562A	HOT HOLDING TOWER	120	1	2	1.911		15.9	L5-20R	L5-20R	AHL520R / AHL520C	1	
NOTE 5	563D	DOUBLE SANDWICH SLIDE	120	1	2	1.090		9.13	5-20R	N/A	1877 (SIMPLEX)	1	
NOTE 5	563S	SINGLE SANDWICH SLIDE	120	1	2	0.548		4.56	5-20R	N/A	1877 (SIMPLEX)	1	
NOTE 5	564	PRODUCT HOLDING CABINET	120	1	2	1.320		11.00	5-20R	L5-20R	1877 / AHL520C	1	
	564A	PRODUCT HOLDING CABINET	120	1	2	0.660		5.50	5-20R	L5-20R	1877 / AHL520C	1	
	564B	PRODUCT HOLDING CABINET	120	1	2	0.660		5.50	5-20R	L5-20R	1877 / AHL520C	1	
NOTE 2	565C	FOOD COOKER/WARMER	120	1	2	1.500		12.50	5-20R	L5-20R	VG20 / AHL520R	1	
NOTE 5	580H	MULTI-USE HOLDING CABINET	120	1	2	1.920		16.0	5-20R	L5-20R	1877 / AHL520C	1	
	592	SOUP RETHERMALIZER	208	3	3	7.920		22.0	15-30R	L15-30R	AH8430N / AHL1530C	9	PROVIDE TWIST LOCK PLUG IN FIELD WHEN REQ'D
NOTE 5	600	MIXER	120	1	2			8.0	5-20R	L5-20R	VG20 / AHL520C	1	PROVIDE TWIST LOCK PLUG IN FIELD WHEN REQ'D
NOTE 5	602	SALAD SPINNER	120	1	2	0.373			5-20R	L5-20R	VG20 / AHL520C	1	
NOTE 2	607	LEMON JUICER	120	1	2		1/4 HP		5-20R	N/A	VG20	1	PROVIDE GFCI DUPEX RECEPTACLE
	669	OFFICE SAFE (SMART SAFE)	120	1	2				5-20R	N/A	CR20	1	
NOTE 2	671	LED MENU BOARD	120	1	2				5-20R	N/A	CR20	1	

WIRING DEVICE PACKAGE, INCLUDING SWITCHES (EXCEPT HUBBELL BRAND DEVICES) SHALL BE PURCHASED AS A PART OF A NATIONAL ACCOUNTS PROGRAM THROUGH GEXPRO (FORMERLY GE SUPPLY). CONTACT BRIAN REECE AT 770-840-4162 (EMAIL: BRIAN.REECE@GEXPRO.COM)

NOTE 1: ALL SO CORD LENGTHS SHALL BE MEASURED FROM THE REAR OF THE EQUIPMENT TO THE END OF THE CORD.

NOTE 2: CONTRACTOR SHALL PROVIDE GROUND-FAULT PROTECTION FOR ALL 120 VOLT 15 AMP AND 20 AMP RECEPTACLES IN THE KITCHEN / FOOD PREPARATION AREAS. GROUND-FAULT PROTECTION SHALL BE PROVIDED AT THE RECEPTACLE AS A GFCI TYPE RECEPTACLE UNLESS NOTED OTHERWISE ON THE PLANS WHERE A GFCI TYPE BREAKER IS INDICATED.

NOTE 3: A RECESSED PIN & SLEEVE BOX IS PROVIDED WITH THE EXHAUST HOOD PACKAGE AND INSTALLED BY THE CONTRACTOR. THE P&S BOX INCLUDES THE "SLEEVE" RECEPTACLES FOR THE OPEN FRYERS. THE OPEN FRYER SUPPLIER WILL PROVIDE PRE-WIRED CORDSET WITH A "PIN" DEVICE INTEGRAL WITH THE OPEN FRYER TO PLUG INTO THE "SLEEVE" RECEPTACLE.

NOTE 4: WIRE NUMBER INDICATED DOES NOT INCLUDE THE REQUIRED GREEN EQUIPMENT GROUND CONDUCTOR OR, WHEN APPLICABLE, THE STRIPED IG CONDUCTOR.


NOTE 5: PROVIDE GFCI TYPE BRANCH BREAKER FOR KITCHEN/FOOD PREPARATION AREA RECEPTACLES THAT ARE TWIST-LOCK, CLOCK STYLE, OR IG (ISOLATED GROUND) TYPE.

NOTE 6: REFER TO THE CONDUIT AND CONDUCTOR SCHEDULE FOR THE WIRE/CONDUIT MARK NUMBER AND THE MINIMUM WIRE AND CONDUIT SIZE FOR EACH EQUIPMENT ITEM.

NOTE 7: THE 'R' SUBSCRIPT ON EQUIPMENT NUMBERS ON THE KITCHEN SERIES DRAWINGS REFERS TO EXISTING EQUIPMENT THAT HAS BEEN RELOCATED. IN SEVERAL CASES THERE MAY BE ONE OR MORE NEW AND ONE OR MORE RELOCATED ITEMS, THEREFORE, IN ORDER TO AVOID CONFUSION, ALL EQUIPMENT IS LISTED AS 'NEW' AND THIS SUBSCRIPT IS NOT USED. FIELD VERIFY ELECTRICAL REQUIREMENTS - WHAT IS INDICATED IN THIS SCHEDULE IS BASED ON 'NEW BUILD' PROTOTYPICAL EQUIPMENT ITEMS.

# 2 ELECTRICAL LEGEND

SYMBOL	DESCRIPTION	MTG HT AFF TO CL	SYMBOL	DESCRIPTION	MTG HT AFF TO CL
<b>LIGHTING FIXTURES</b>					
□	SURFACE MTD FLUORESCENT LIGHTING FIXTURE		—	CONDUIT CONCEALED ABOVE CEILING OR IN WALL	
⊞	RECESSED FLUORESCENT LIGHTING FIXTURE		—	CIRCUIT HOMERUN TO PANELBOARD WITH MINIMUM 2#12, #12S, 3/4" C	
○	SURFACE MTD FLUORESCENT OR HID LIGHTING FIXTURE		—	CONDUIT TURNING UP	
⊙	RECESSED FLUORESCENT OR HID LIGHTING FIXTURE		—	CONDUIT TURNING DOWN	
⊙	WALL MOUNTED LIGHTING FIXTURE, SEE LIGHTING FIXTURE SCHEDULE (FLUORESCENT OR HID FIXTURE)	AS NOTED	—	CONDUIT CONCEALED IN OR BELOW SLAB (OUTSIDE - UNDERGROUND)	
⊙	WALL MOUNTED EXIT SIGN, SHADING INDICATES FACES, PROVIDE WITH CHEVRON DIRECTIONAL ARROWS WHERE INDICATED ON PLANS PROVIDED WITH BATTERY PACK	6" BELOW CEILING TO TOP	—	FLEXIBLE LIGHT FIXTURE WHIP, SIX FOOT MAXIMUM LENGTH	
⊙	CEILING MOUNTED EXIT SIGN, SHADING INDICATES FACES, PROVIDE WITH CHEVRON DIRECTIONAL ARROWS WHERE INDICATED ON PLANS PROVIDED WITH BATTERY PACK		—	METAL CLAD CABLE ASSEMBLY - ONLY WHERE INDICATED ON DWGS OR SPECS	
⊙	COMBO EXIT WITH TWO LAMP HEADS, SEE LIGHTING FIXTURE SCHEDULE		NOTES: FOR ALL CONDUITS REFER TO PLANS FOR OTHER CONDUITS, REFER TO VENDOR DRAWINGS FOR CONDUIT AND WIRING REQUIREMENTS FOR LOW VOLTAGE SYSTEMS AND CONTROL WIRING.		
⊙	WALL MOUNTED EMERGENCY BATTERY PACK LIGHTING FIXTURE	AS NOTED	MULTIPLE IPH CIRCUITS MAY OCCUPY THE SAME CONDUIT IN ACCORDANCE WITH THE NEC, MAXIMUM OF THREE AND OF DIFFERENT PHASES.		
⊙	CEILING MOUNTED EMERGENCY BATTERY PACK LIGHTING FIXTURE		LOW VOLTAGE AND CONTROL WIRING SHALL BE IN SEPARATE CONDUIT FROM POWER WIRING.		
—	FLUORESCENT STRIP LIGHTING FIXTURE		<b>DISTRIBUTION EQUIPMENT</b>		
⊙	WALLWASHER STYLE RECESSED DOWNLIGHT, AIM LIGHT TOWARD WALL		⊞	NON-FUSIBLE SAFETY SWITCH, SIZE AND TYPE AS NOTED ON PLANS (AMPS/POLES) UNLESS NOTED OTHERWISE	6'-6"
⊞	RECESSED LIGHTING FIXTURE WITH EMERGENCY BATTERY PACK		⊞	FUSIBLE SAFETY SWITCH, SIZE AND TYPE AS NOTED ON PLANS (AMPS/POLES) UNLESS NOTED OTHERWISE	6'-6"
⊞	PENDANT LIGHTING FIXTURE	AS NOTED	⊞	FLUSH MOUNTED LIGHTING PANELBOARD	6'-6"
—	LIGHTING TRACK WITH TRACK HEADS		⊞	SURFACE MOUNTED LIGHTING PANELBOARD	6'-6"
<b>WIRING DEVICES</b>					
⊞	120 VOLT DUPEX RECEPTACLE, 20 AMPS UON	18"	⊞	TRANSFORMER, PROVIDE SECONDARY GROUNDING PER NEC	
⊞	120 VOLT DUPEX AT SPECIAL MOUNTING HEIGHT, 20 AMPS UON	44" UON	⊞	ENCLOSED CIRCUIT BREAKER, SIZE AND TYPE AS NOTED ON PLANS (AMPS/POLES) UNLESS NOTED OTHERWISE	6'-6"
⊞	120 VOLT QUADRAPLEX RECEPTACLE, 20 AMPS UON	18" UON	⊞	ENCLOSED CIRCUIT BREAKER, SIZE AND TYPE AS NOTED ON PLANS (AMPS/POLES) UNLESS NOTED OTHERWISE	6'-6"
⊞	120 VOLT QUADRAPLEX AT SPECIAL MOUNTING HEIGHT, 20 AMPS UON	44"	⊞	FLUSH MOUNTED LIGHTING PANELBOARD	6'-6"
⊞	120 VOLT SIMPLEX RECEPTACLE, 20 AMPS UON	18" UON	⊞	SURFACE MOUNTED LIGHTING PANELBOARD	6'-6"
⊞	SINGLE SPECIAL PURPOSE RECEPTACLE WITH VOLTS, AMPS, AND PHASE AS NOTED, NEMA CONFIGURATION AS REQUIRED BY EQUIPMENT	18" UON	⊞	TRANSFORMER, PROVIDE SECONDARY GROUNDING PER NEC	
⊞	RECEPTACLE MOUNTED ON CORD DROP, 120 VOLT, 20 AMP, UON, OUTLET BOX FLUSH WITH CEILING		⊞	ENCLOSED CIRCUIT BREAKER, SIZE AND TYPE AS NOTED ON PLANS (AMPS/POLES) UNLESS NOTED OTHERWISE	6'-6"
⊞	120 VOLT DUPEX RECEPTACLE, 20 AMPS UON	18"	* 6'-6" DISTANCE IS TO TOP-MOST DISCONNECTING DEVICE OR HIGHEST POSITION OF OPERATING HANDLE OF DISCONNECTING DEVICE		
<b>MISCELLANEOUS SYMBOLS</b>					
⊞	GROUND		⊞	EXHAUST FAN MOTOR	
⊞	MOTOR		⊞	JUNCTION BOX	
⊞	EXHAUST FAN MOTOR		⊞	CONDUIT AND WIRE MARK NUMBER, REFER TO CONDUCTORS AND CONDUIT SCHEDULE FOR SIZE	
⊞	JUNCTION BOX		⊞	KITCHEN EQUIPMENT MARK NUMBER, REFER TO KITCHEN EQUIPMENT SCHEDULE FOR REQUIREMENTS	
⊞	CONDUIT AND WIRE MARK NUMBER, REFER TO CONDUCTORS AND CONDUIT SCHEDULE FOR SIZE		⊞	NOTE NUMBER	
⊞	KITCHEN EQUIPMENT MARK NUMBER, REFER TO KITCHEN EQUIPMENT SCHEDULE FOR REQUIREMENTS		⊞	HOOD EXTINGUISHING ANSUL PULL STATION	
⊞	NOTE NUMBER		⊞	SMOKE DETECTORS REMOTE STATUS INDICATOR W/ 1/2" CONDUIT STUB-UP	
⊞	HOOD EXTINGUISHING ANSUL PULL STATION		⊞	PUSH-BUTTON	
⊞	SMOKE DETECTORS REMOTE STATUS INDICATOR W/ 1/2" CONDUIT STUB-UP		⊞	BELL, TYPE AS NOTED ON PLANS	
⊞	PUSH-BUTTON		⊞	PHOTO-ELECTRIC CELL	
⊞	BELL, TYPE AS NOTED ON PLANS		<b>TELEPHONE</b>		
⊞	PHOTO-ELECTRIC CELL		⊞	TELEPHONE OUTLET	18" UON
<b>ABBREVIATIONS</b>					
AFF	ABOVE FINISHED FLOOR		⊞	TELEPHONE OUTLET AT SPECIAL MOUNTING HEIGHT	60" UON
AFG	ABOVE FINISHED GRADE		NOTE: EACH TELEPHONE OUTLET (FLOOR OR WALL MOUNTED) SHALL BE PROVIDED WITH A 3/4" EMPTY CONDUIT, WITH PULL WIRE, TO ACCESSIBLE CEILING SPACE		
AHU	AIR HANDLING UNIT		<b>CCTV / SECURITY SYSTEM</b>		
C	CONDUIT				

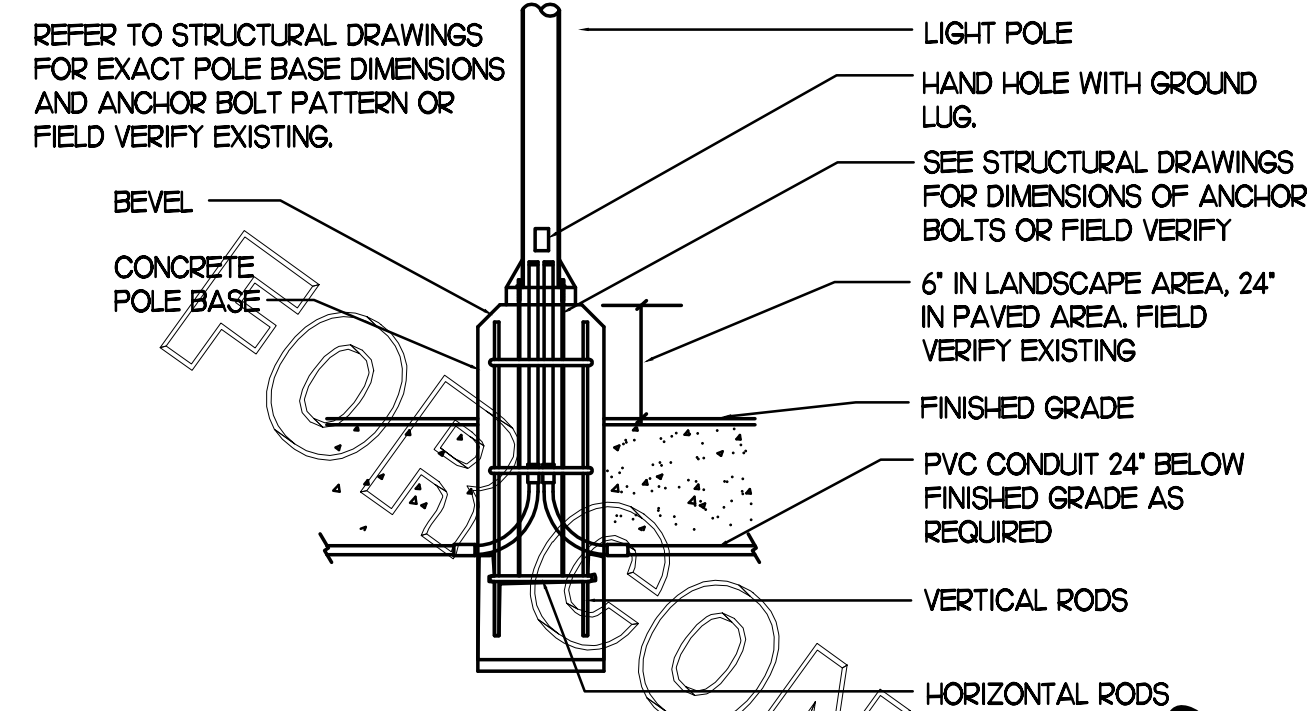

**TYPICAL POLE BASE DETAIL**

NOT TO SCALE - FIELD VERIFY EXISTING POLE BASE BEFORE CONSTRUCTION

EQUIPMENT ITEMS ELECTRICAL CORD TO BE CONNECTED TO THE BELL BOX MOUNTED ON TOP-REAR OF THE ITEM

COOPER #S2983 NON-METALLIC WEATHER-PROOF TYPE SWITCH COVER (TO REDUCE ACCIDENTAL BUMPING AND TURNING POWER OFF) WITH SPEC GRADE SWITCH BEHIND COVER (SEE SECTION 1614I IN THE ELECTRICAL SPECIFICATIONS)




FLEXIBLE CONDUIT ELBOW CONNECTOR

SURFACE MOUNTED SINGLE GANG BELL BOX MOUNTED TO THE TOP-REAR OF THE EQUIPMENT ITEM AT THE POINT OF THE POWER CONNECTION

6 FOOT FLEXIBLE LIQUID-TIGHT METAL CONDUIT FROM OEP DROP CORD BOX FLUSH IN CEILING BOX TO THE KITCHEN EQUIPMENT ITEM


**KITCHEN EQUIP DIRECT CONNECTION**

NOT TO SCALE DROP CORD - ISLAND CONDITION

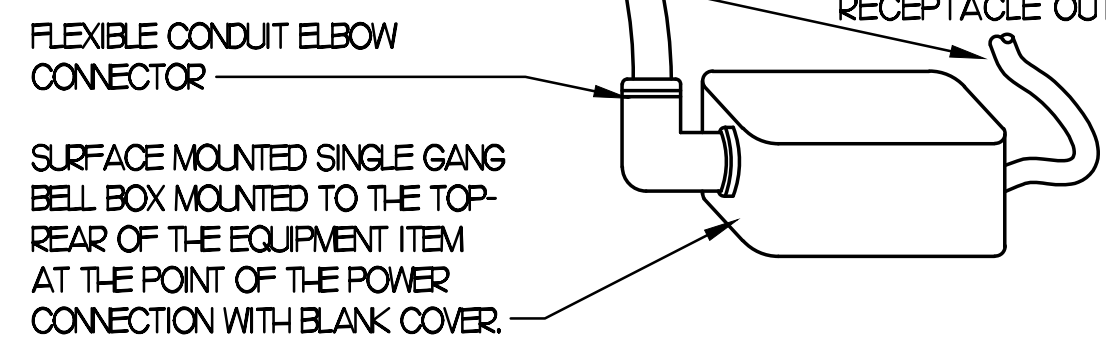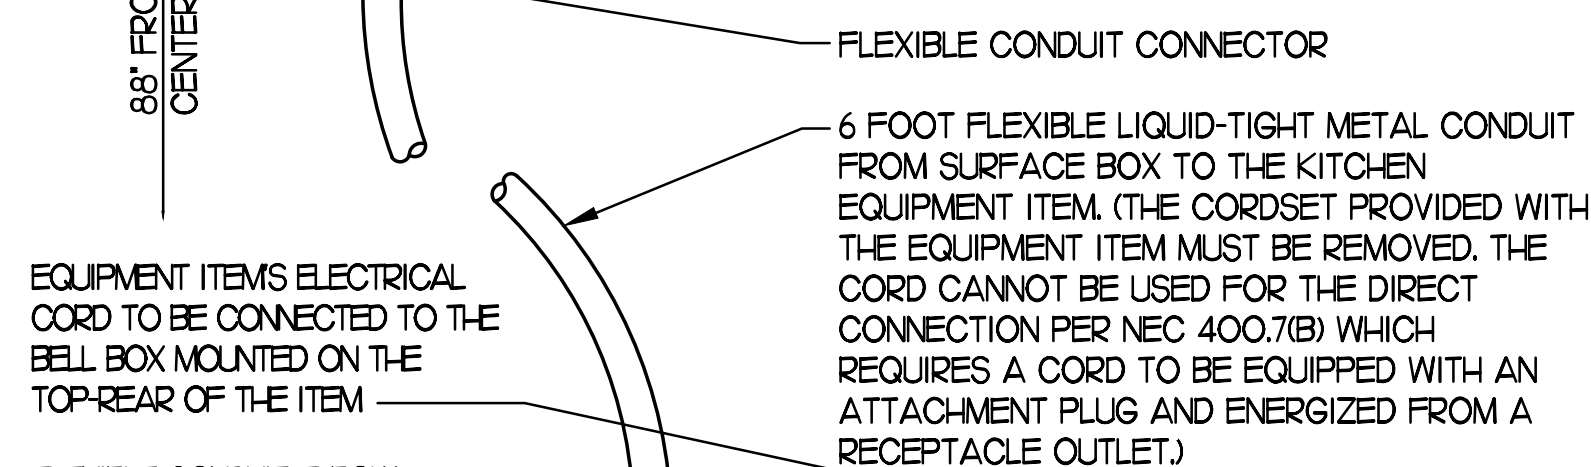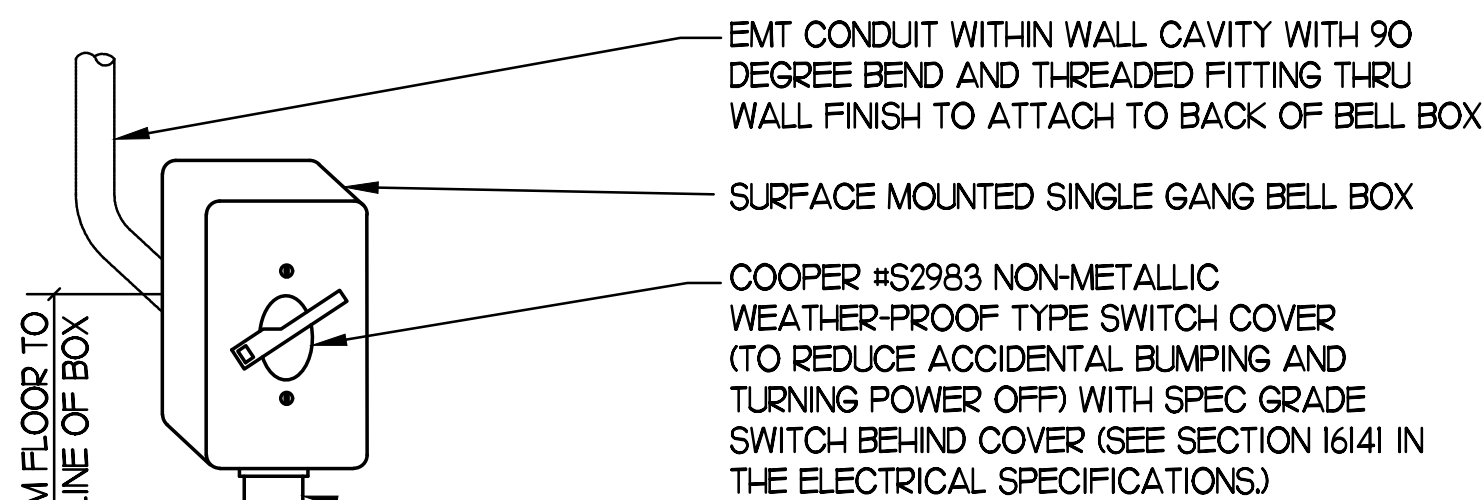


**KITCHEN EQUIP DIRECT CONNECTION**

NOT TO SCALE WALL MOUNT CONDITION

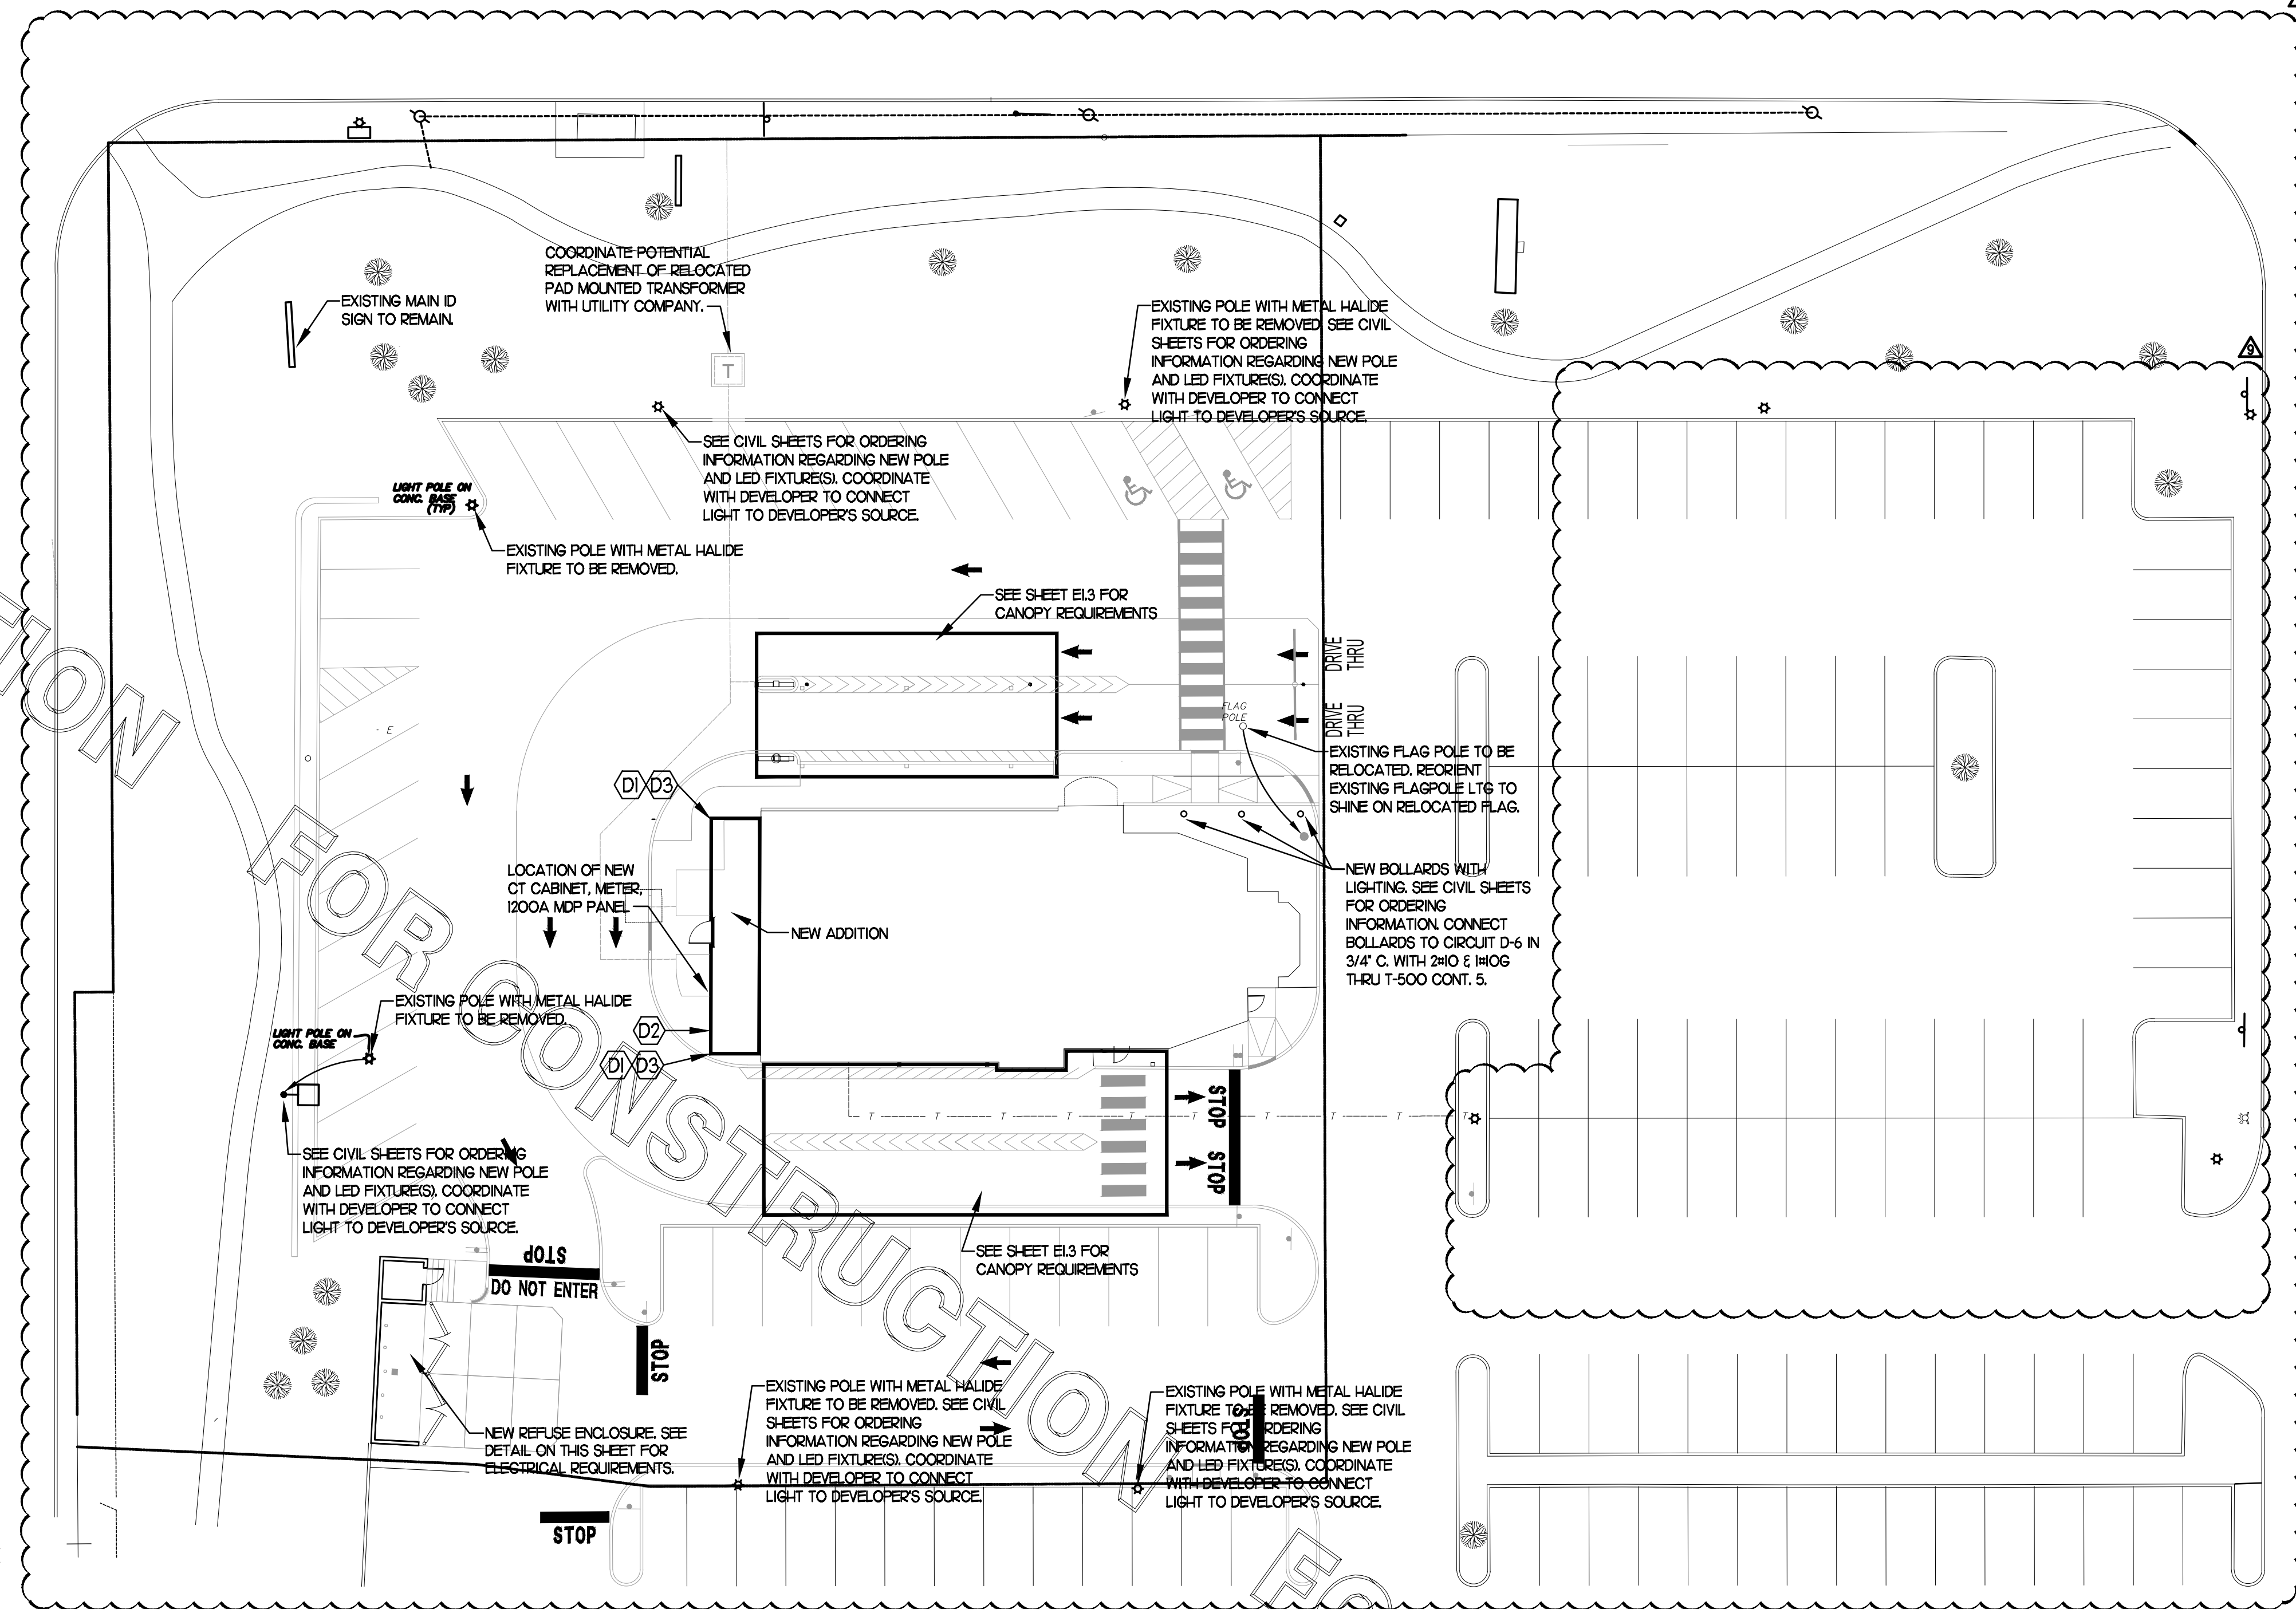


**ELECTRICAL SITE PLAN**

SCALE: 1" = 20'-0"

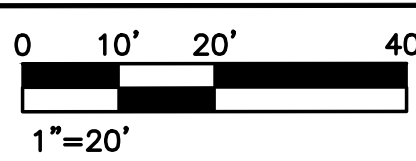

**KEYNOTES - DT CASH STATION**

- (D1) LOCATION OF A 360 DEGREE BUILDING MOUNTED EXTERIOR CAMERA (BY OTHERS), PROVIDE A 3/4" CONDUIT AT 9'-4" AFF TO AN EXTERIOR WALL MOUNTED WP JUNCTION BOX WITH THE CONDUIT ABOVE THE INTERIOR CEILING AND EXTENDED TO AN ACCESSIBLE CEILING AREA FOR CAMERA CABLES BY OTHERS.
- (D2) PROVIDE AN EXTERIOR DUPLEX 120V, 20A RECEPTACLE AT 18" AFF WITH 'IN-USE' STYLE LOCKABLE WP COVER AND CONNECT TO A GENERAL PURPOSE 120V RECEPTACLE CIRCUIT. FIELD COORDINATE WHETHER THIS OUTLET IS NEEDED.
- (D3) PROVIDE A JUNCTION BOX ON THE INSIDE PARAPET WALL ABOVE THE ROOF WITH A 3/4" CONDUIT STUBBED DOWN INTO AN ACCESSIBLE CEILING SPACE AREA BELOW FOR THE OWNER PROVIDED WI-FI EXTERIOR ANTENNAE.

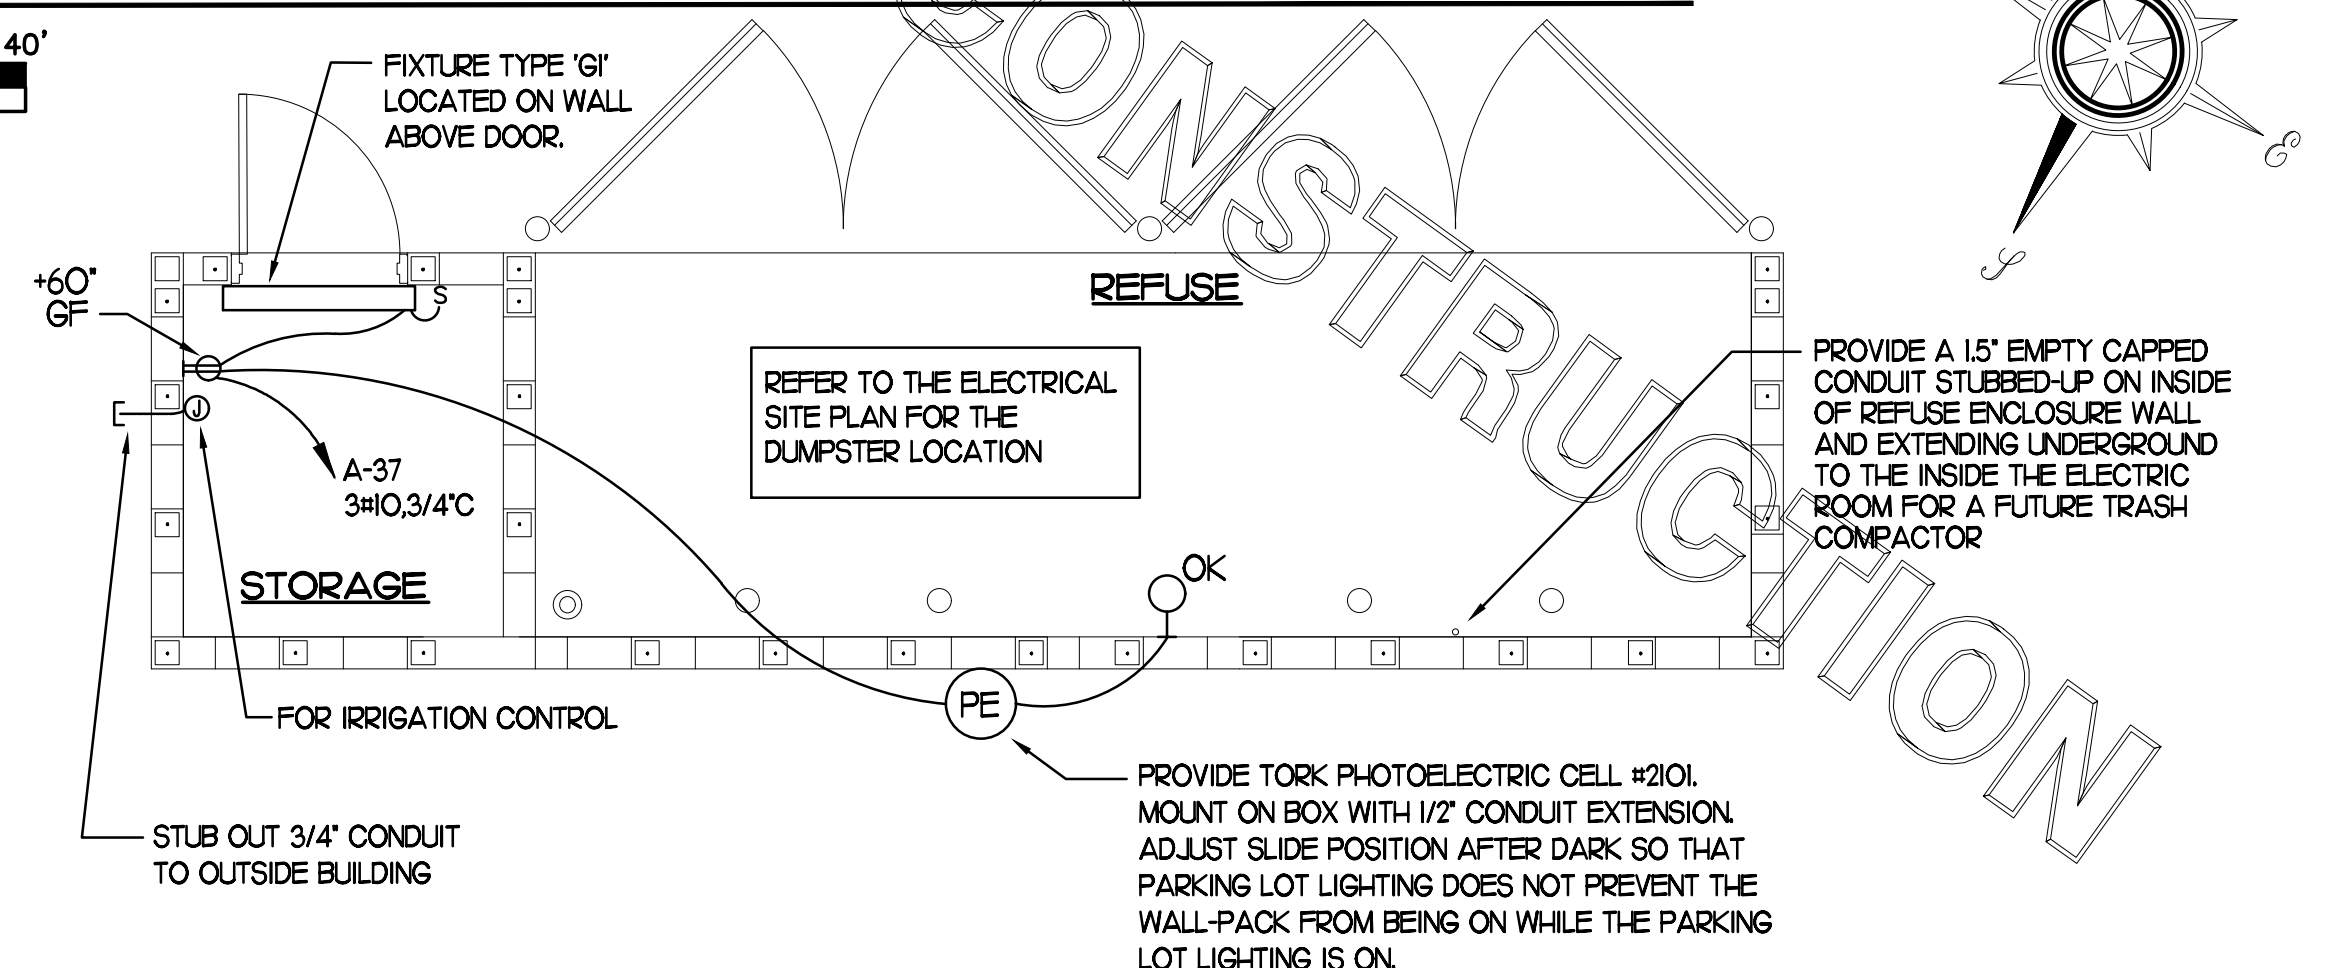


**REFUSE ENCLOSURE PLAN - ELECTRICAL**

NOT TO SCALE



*Chick-fil-A*

**Chick-fil-A**  
5200 Buffington Road  
Atlanta, Georgia 30349

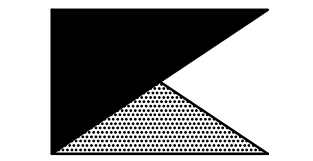

**Kurzynske & Associates**  
CONSULTING ENGINEERS  
2705 Lebanon Pike - Suite One  
Nashville, Tennessee 37214  
Telephone: (615) 255-5203



**CHICK-FIL-A**  
**DELTRAN FSU**  
1301 FAIRVIEW BLVD  
DELTRAN, NJ 08075

**FSR#01385**

BUILDING TYPE / SIZE: S97-110  
RELEASE: v05.22

REVISION SCHEDULE		
NO.	DATE	DESCRIPTION
3	05/16/23	Construction Set
9	08/16/23	RFI Comment

CONSULTANT PROJECT # 22146.HF.R  
PRINTED FOR CONSTRUCTION  
DATE 1/30/2023  
DRAWN BY ML


Information contained on this drawing and in all digital files produced for above named project may not be reproduced in any manner without express written or verbal consent from authorized project representatives.

ELECTRICAL SITE PLAN & DETAILS


SHEET NUMBER

**E1.2**


CONSTRUCTION

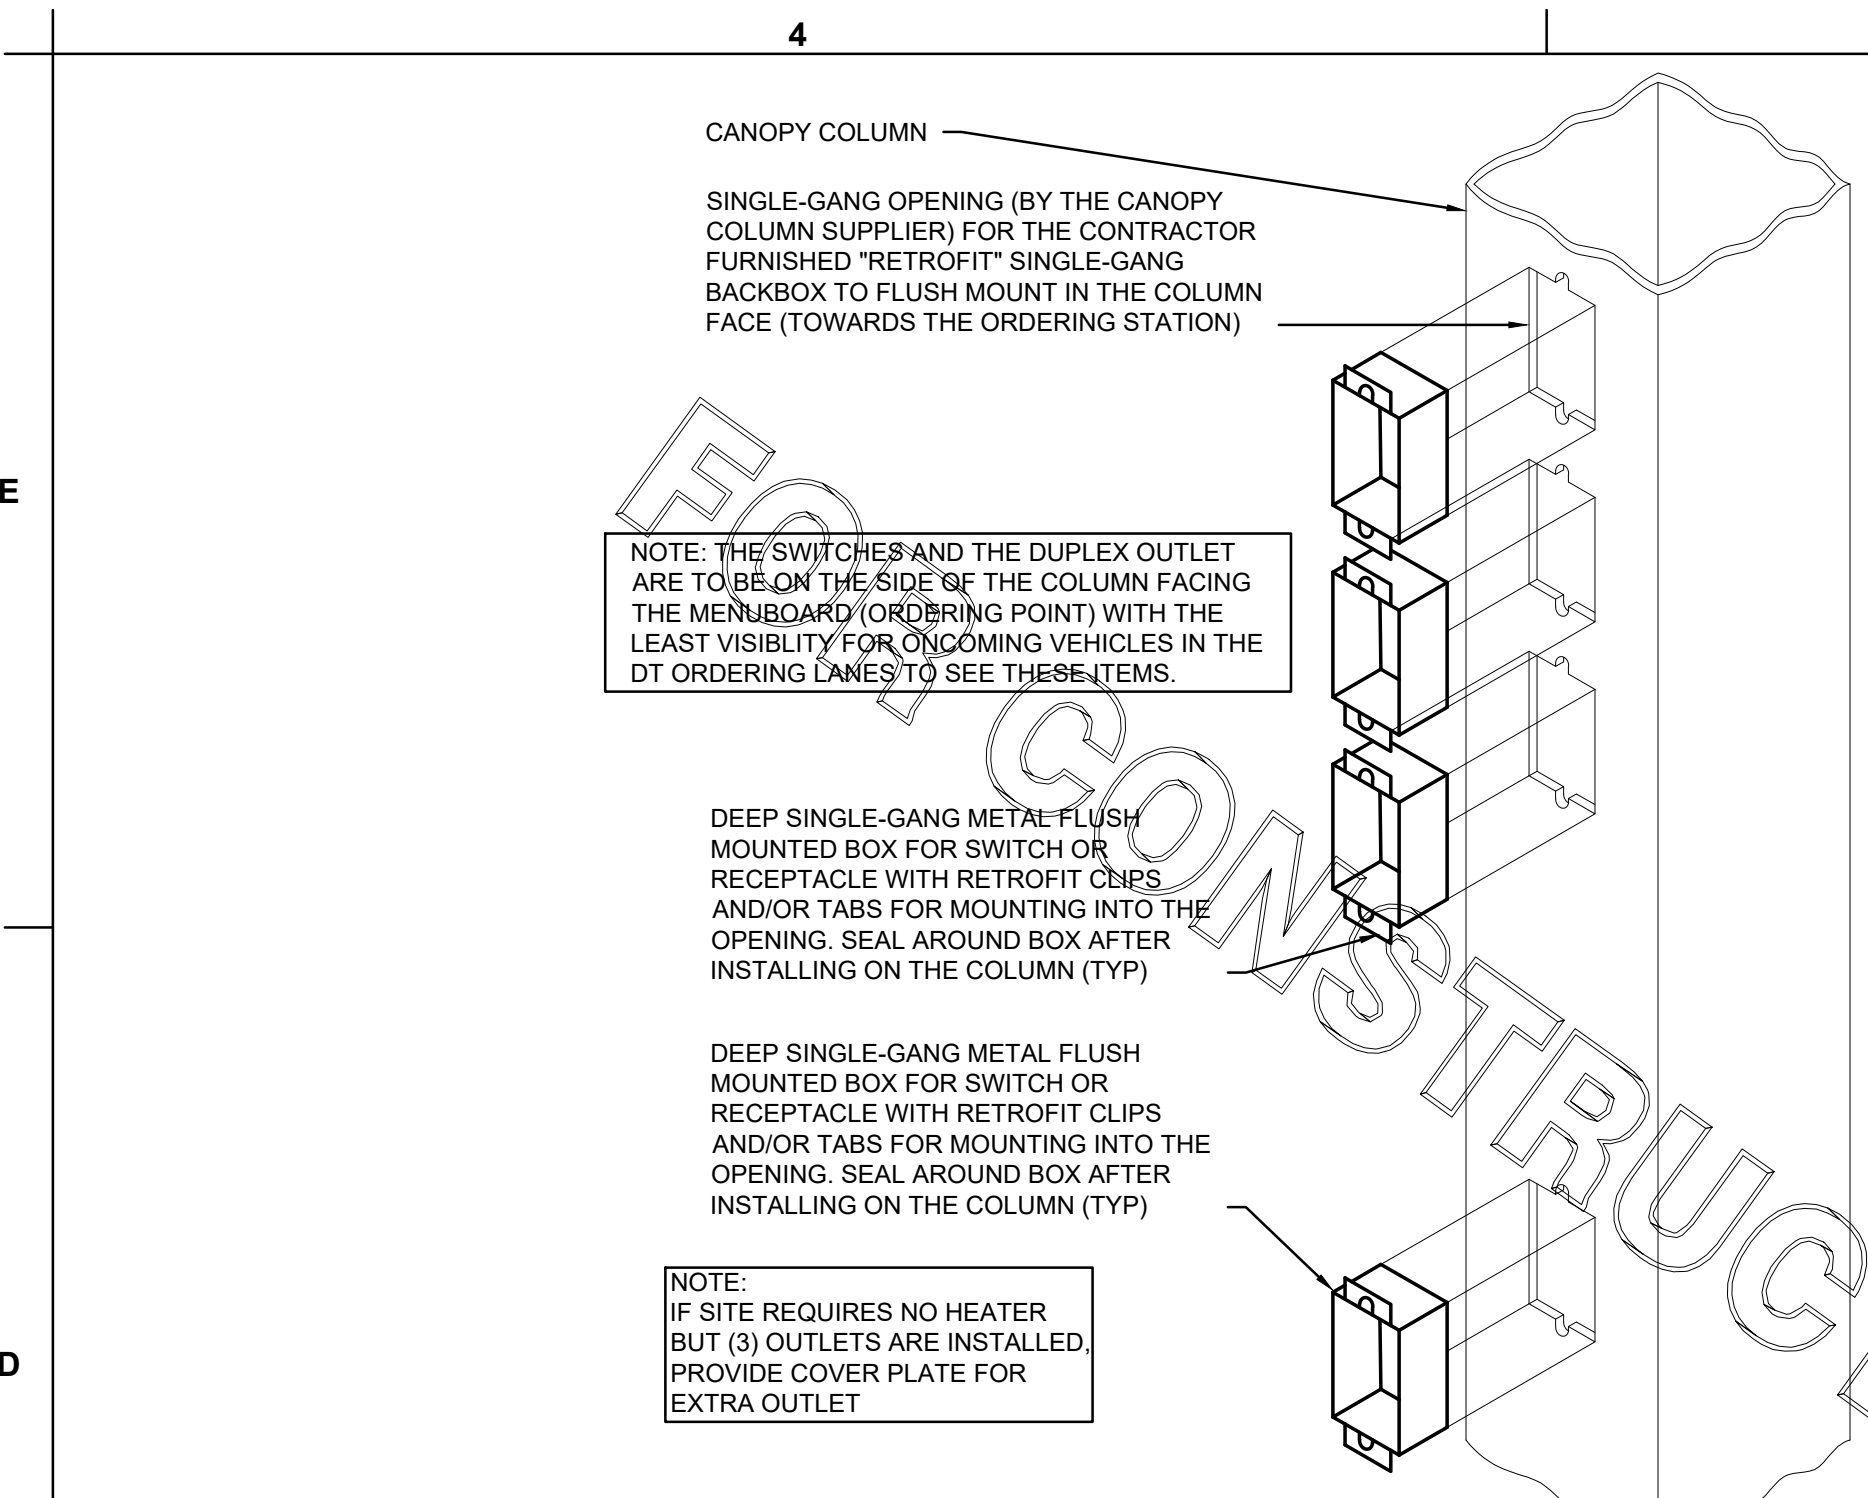


**CANOPY COLUMN ISOMETRIC**  
NOT TO SCALE

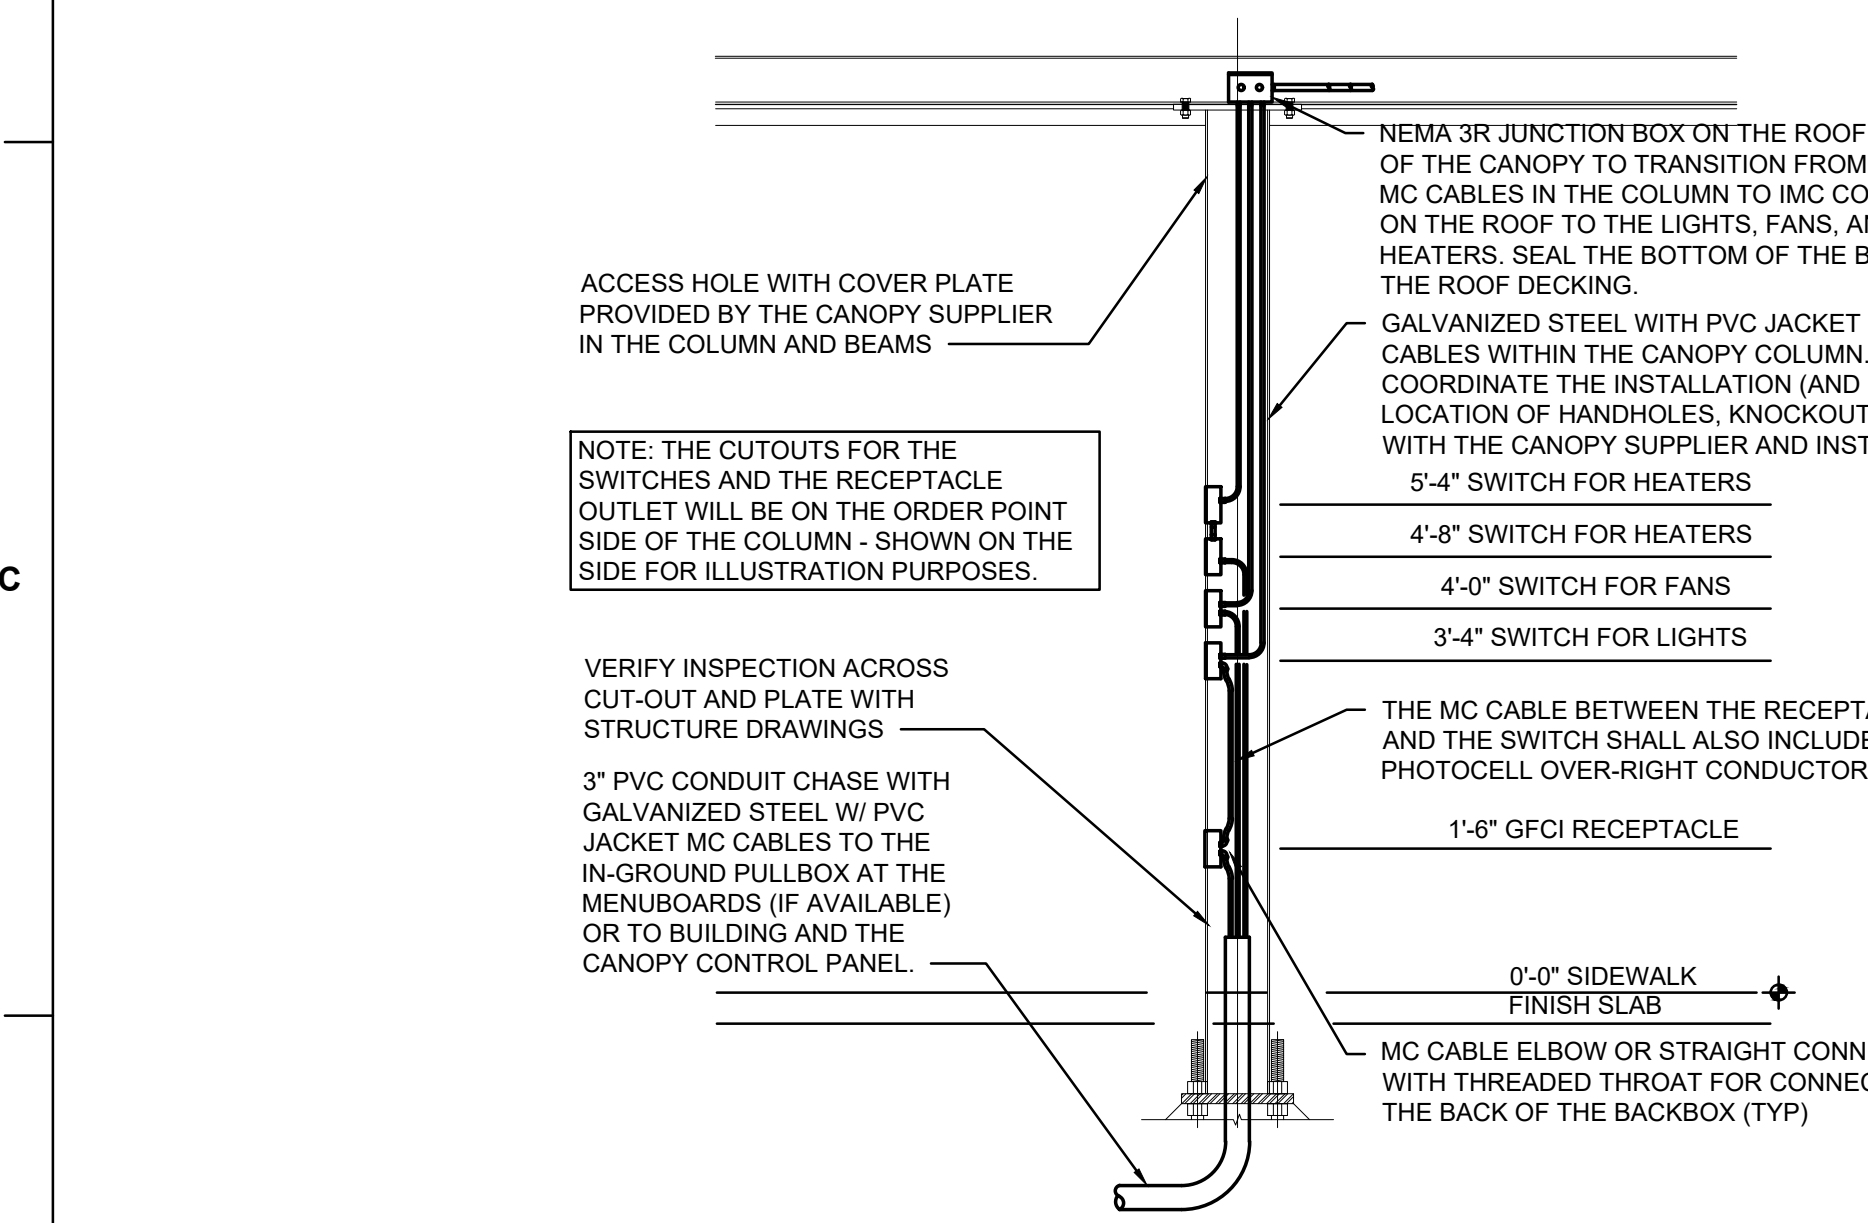


**ORDER CANOPY COLUMN SECTION**  
NOT TO SCALE

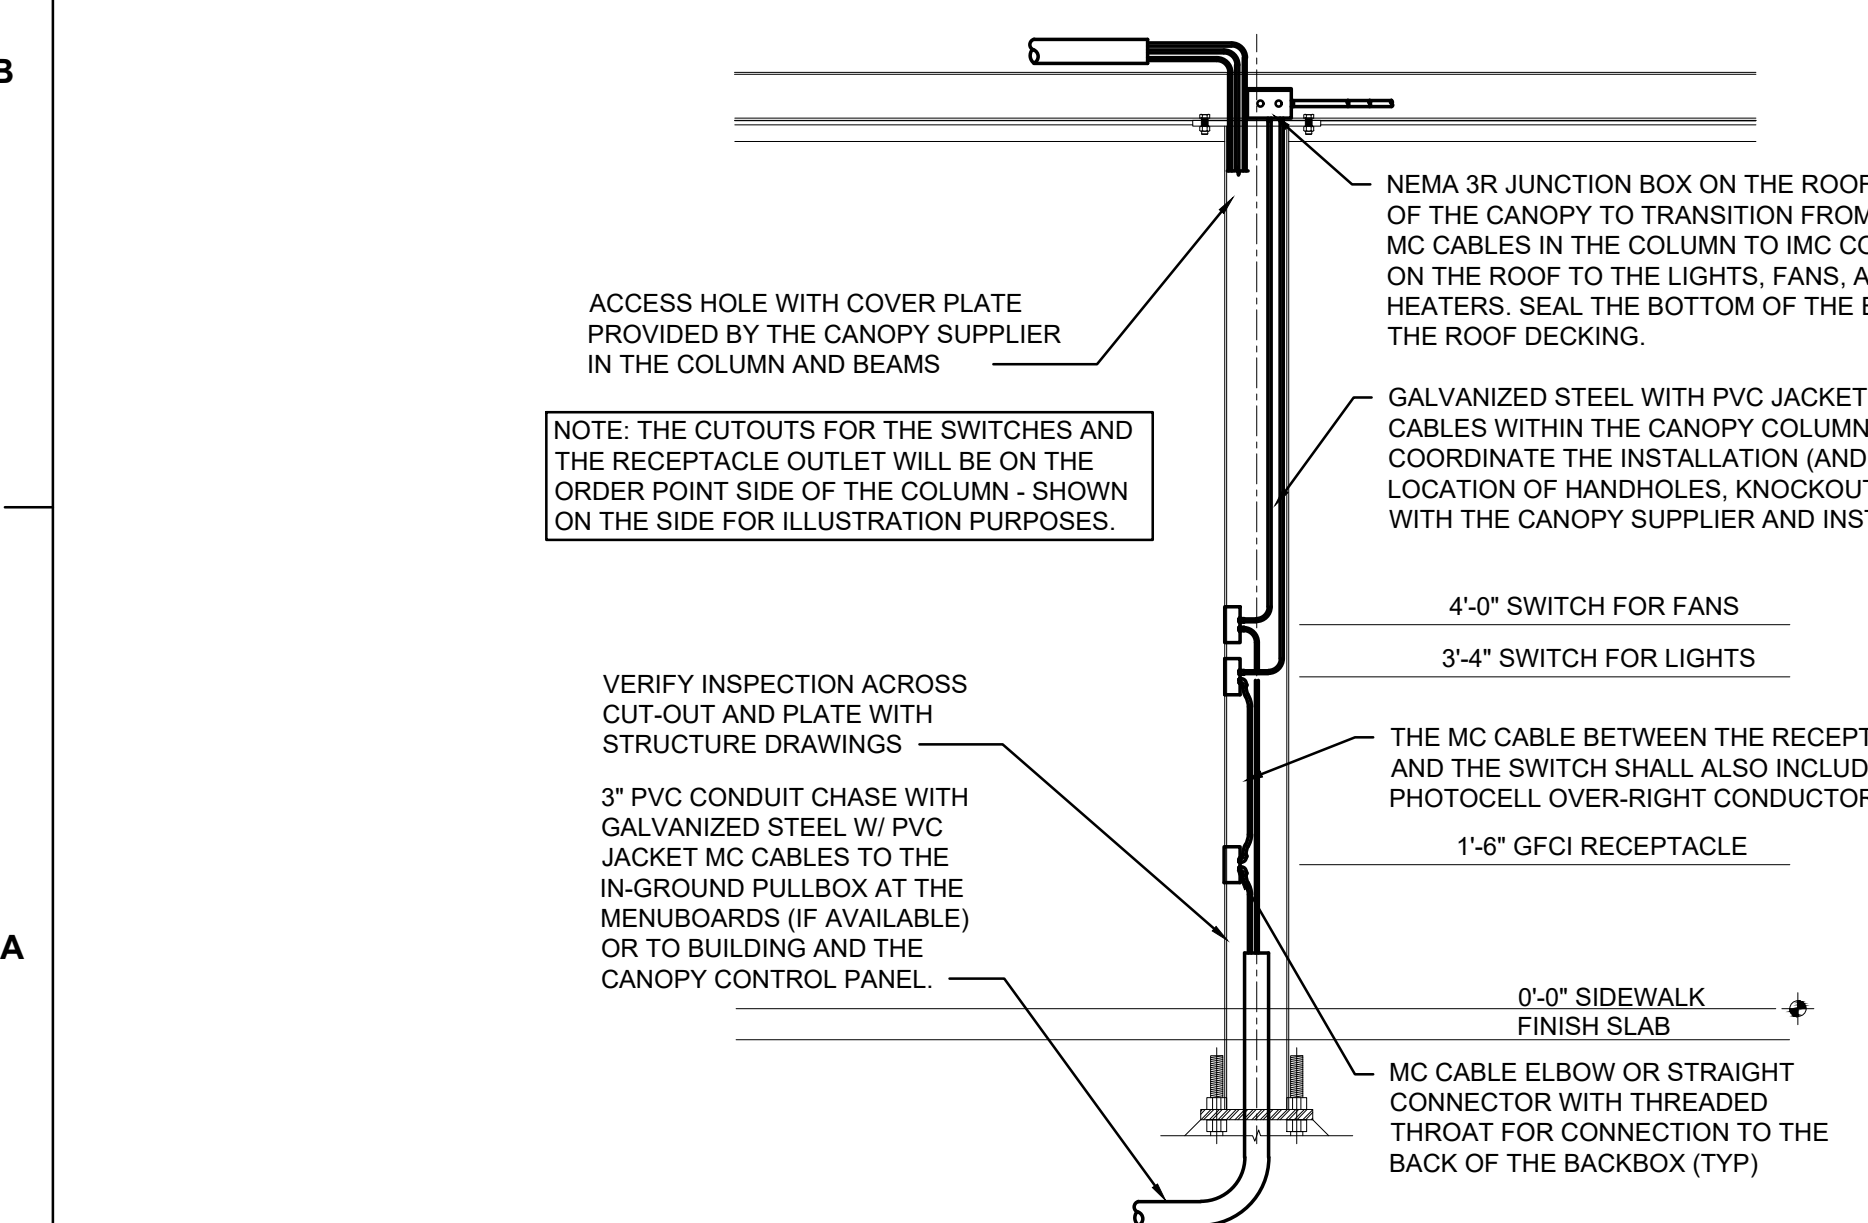


**OMD CANOPY COLUMN SECTION**  
NOT TO SCALE

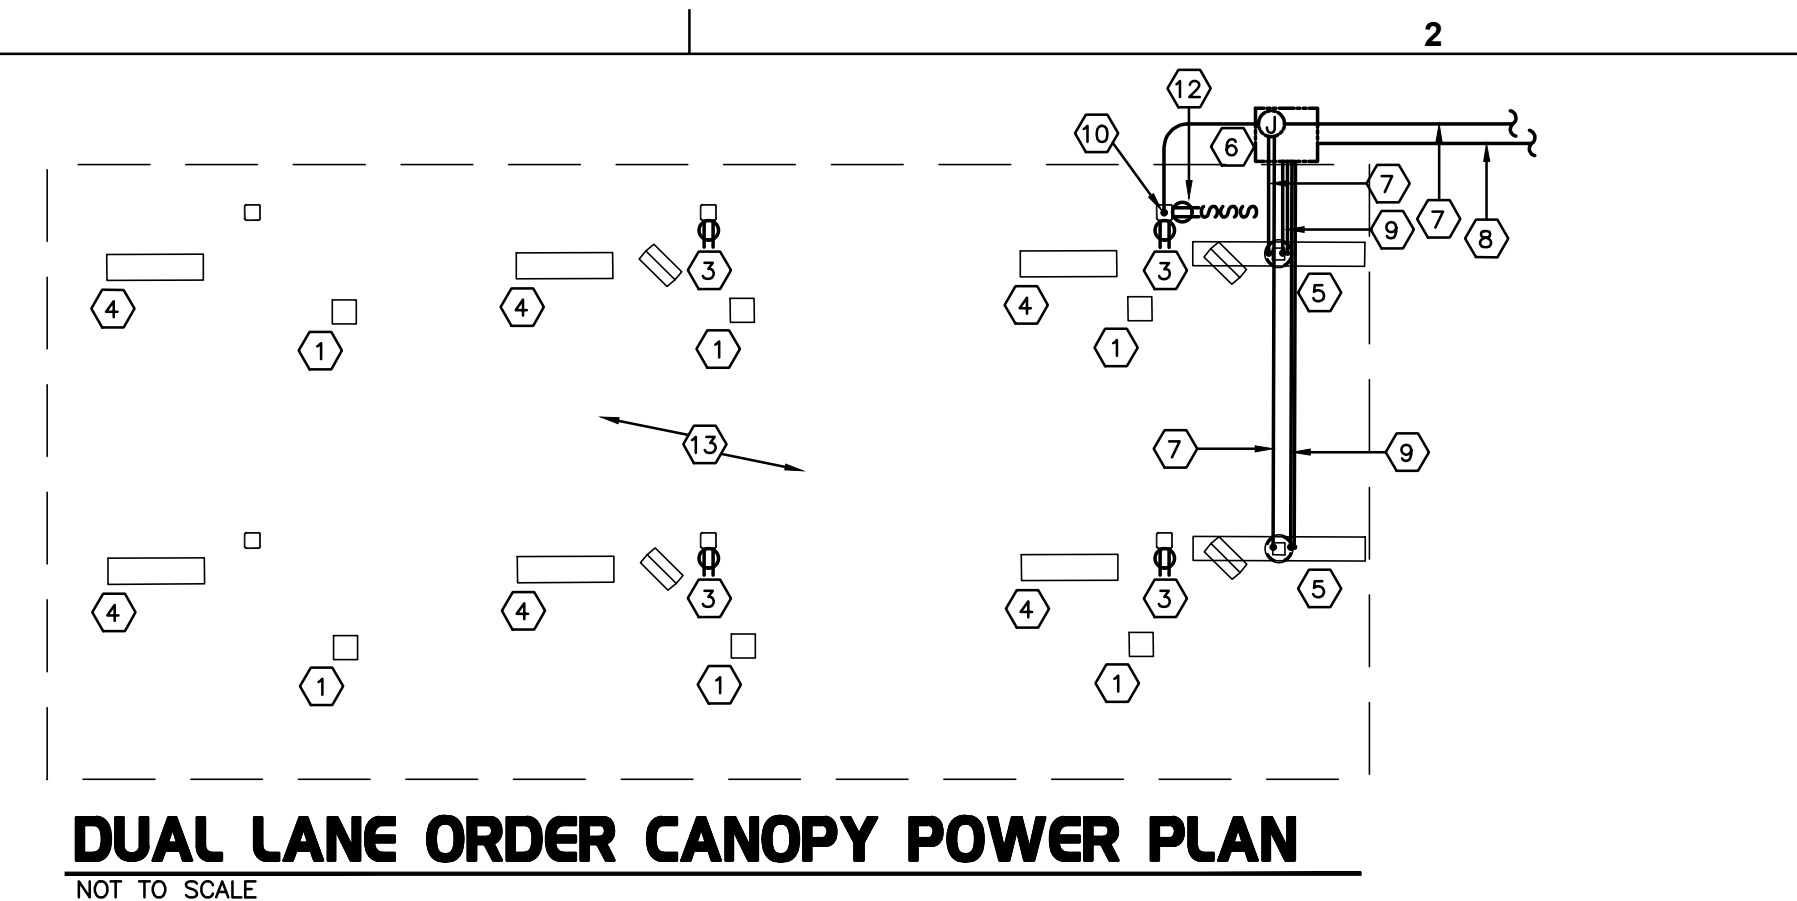


**DUAL LANE ORDER CANOPY POWER PLAN**  
NOT TO SCALE

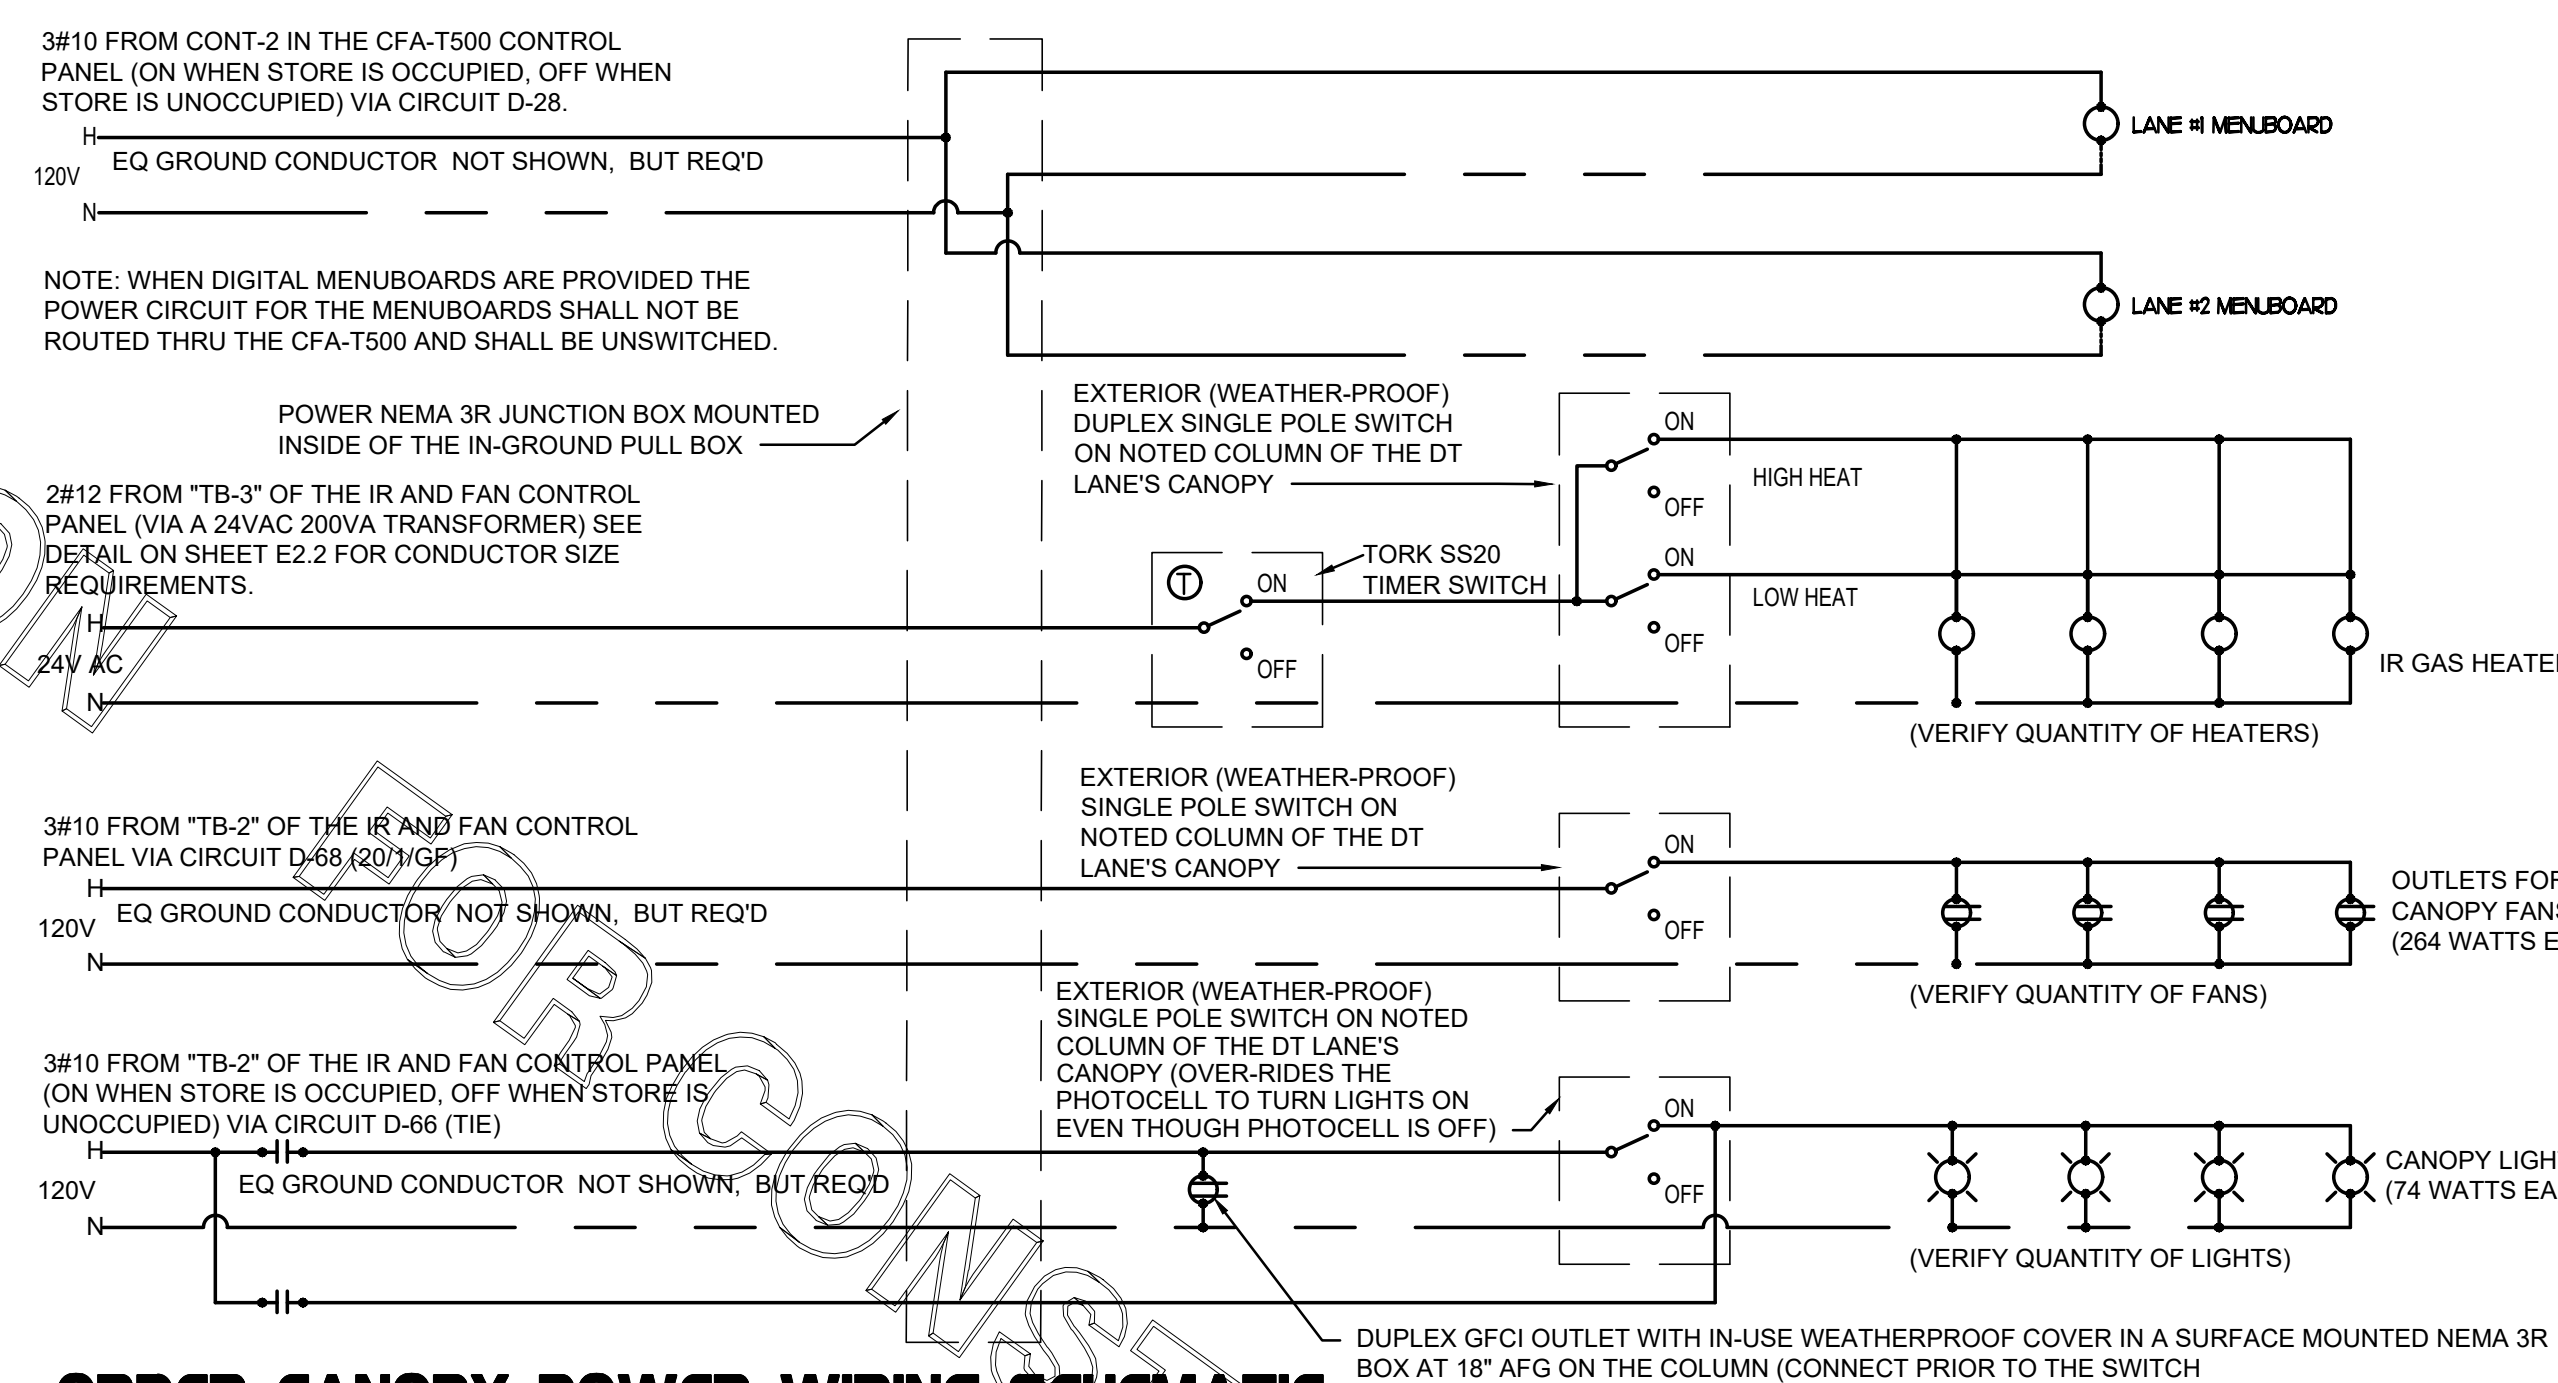

**ORDER CANOPY POWER WIRING SCHEMATIC**  
NOT TO SCALE

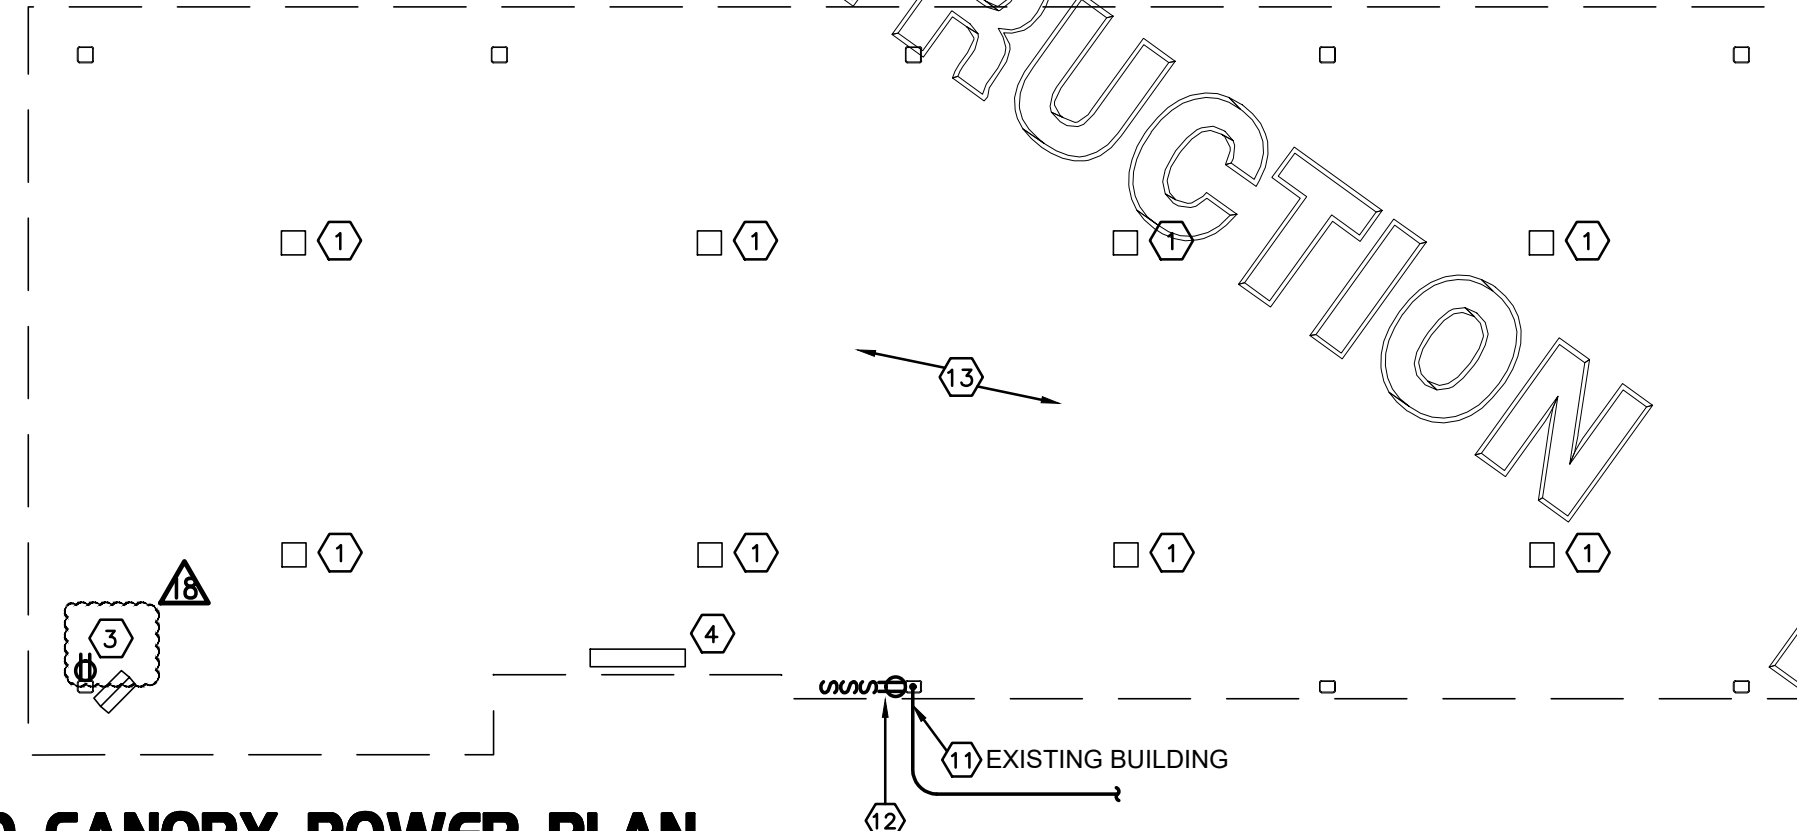

**OMD CANOPY POWER PLAN**  
NOT TO SCALE

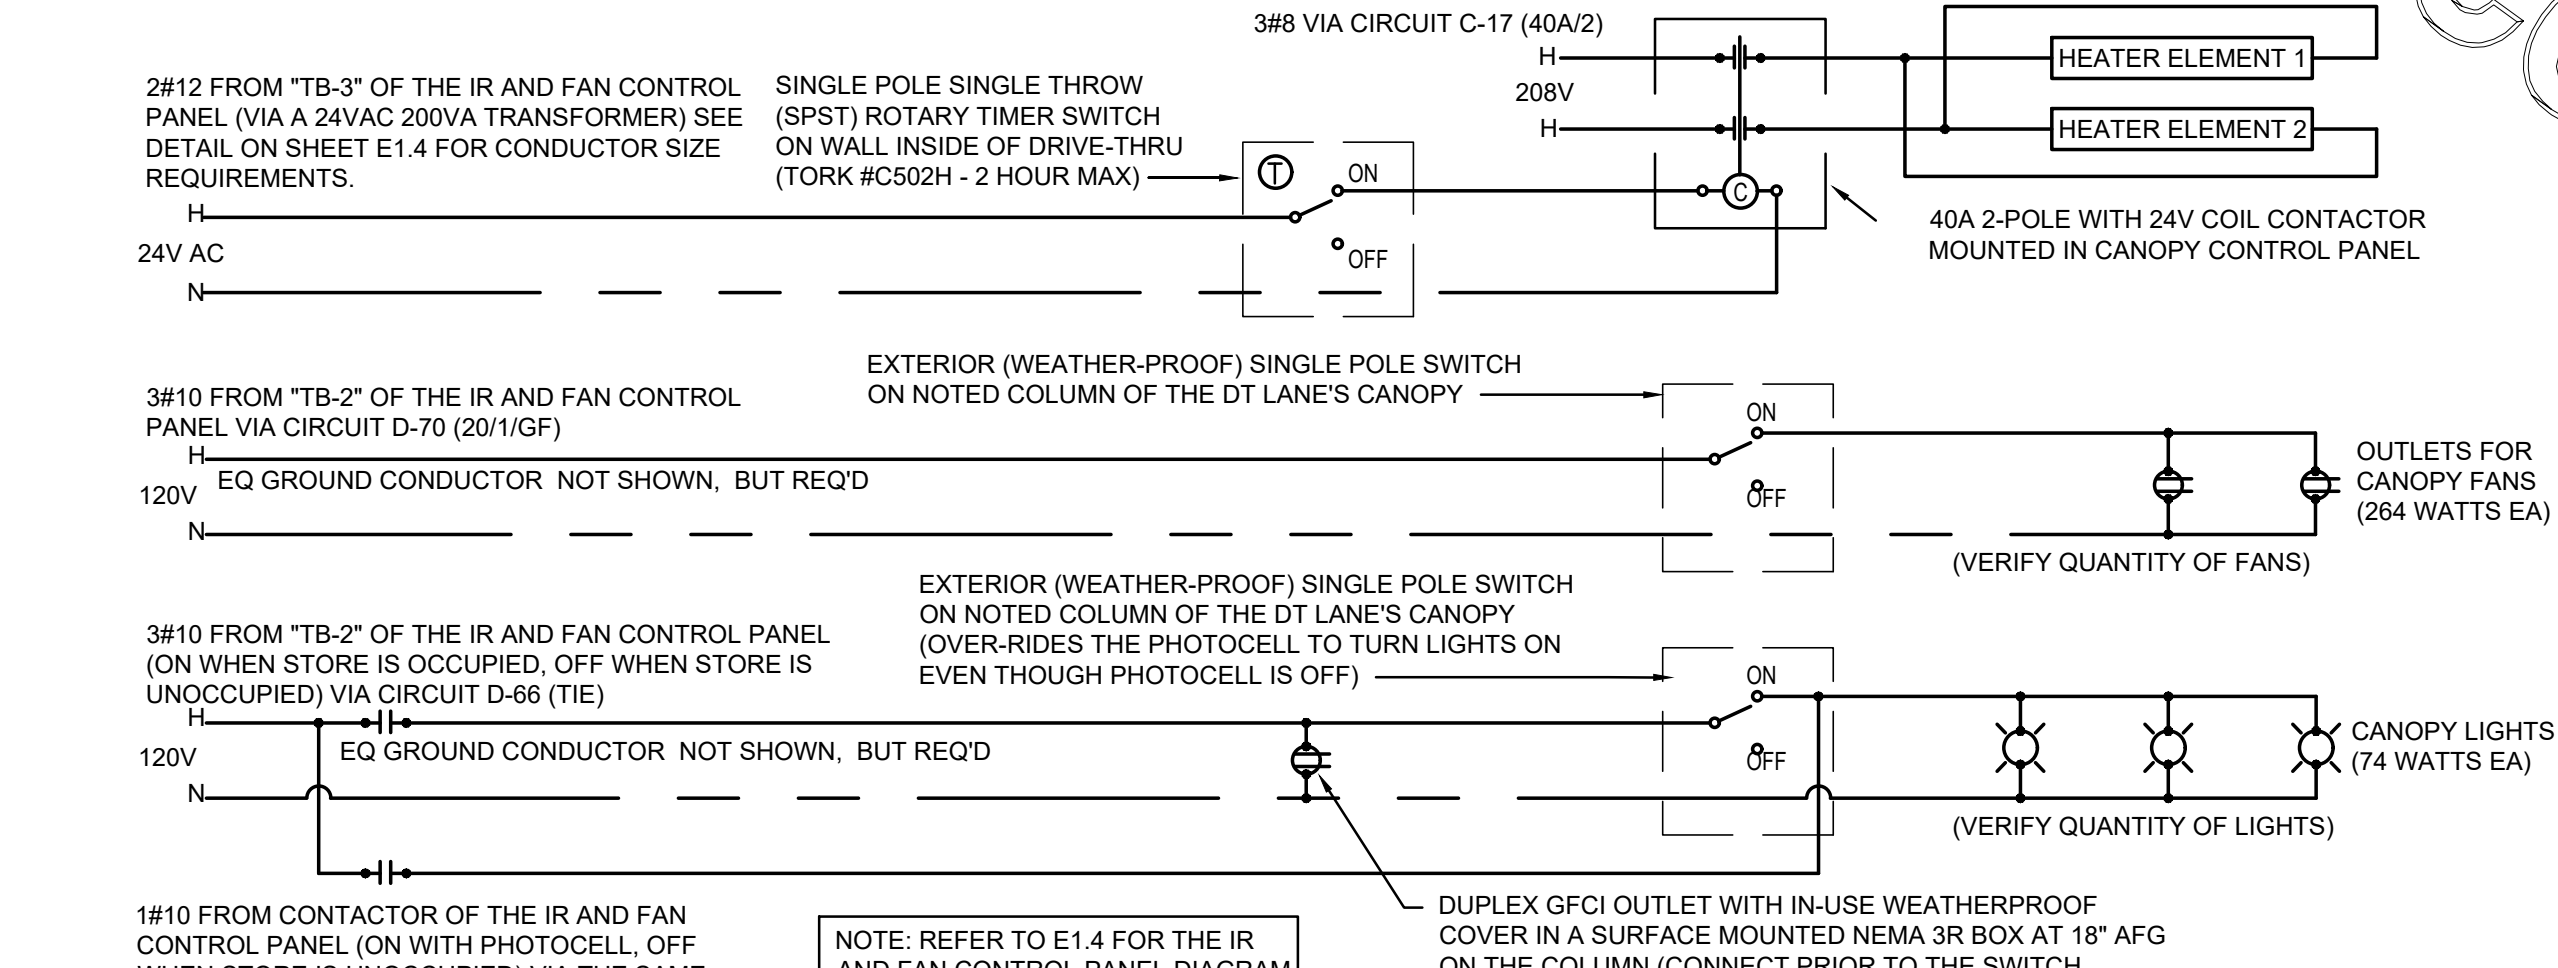


**OMD CANOPY POWER WIRING SCHEMATIC**  
NOT TO SCALE

NOTE: REFER TO SHEET E1.4 FOR THE ABOVE ROOF PIPING SUPPORT DETAIL AND ROUT THE CONDUIT FOR FANS, HEATERS, AND LIGHTS ABOVE THE ROOF WITH THE LOCATION OF THE ABOVE ROOF GAS PIPING.

NOTE: REFER TO SHEET E1.4 FOR THE ABOVE ROOF PIPING SUPPORT DETAIL AND ROUT THE CONDUIT FOR FANS, HEATERS, AND LIGHTS ABOVE THE ROOF WITH THE LOCATION OF THE ABOVE ROOF GAS PIPING.

- ELECTRICAL KEYNOTES (NEW ORDER POINTS):**
- CEILING LIGHT PROVIDED BY CANOPY SUPPLIER AND INSTALLED BY E.C.
  - NOT USED.
  - AIR CIRCULATING FAN (WITH INTEGRAL ON-OFF SWITCH) PROVIDED BY OTHERS. PROVIDE A DUPLEX OUTLET (WITH IN-USE WP COVER PLATE) FLUSH MTD. IN CUT-OUT FOR FAN'S PLUG & CORD. LOCATE CUT-OUT AT TOP OF COLUMN ON DOWNSTREAM SIDE.
  - INFRARED GAS HEATER WITH INTEGRAL ON-OFF SWITCH PROVIDED BY OTHERS.
  - MENUBOARD PROVIDED BY OTHERS.
  - PROVIDE IN-GROUND QUARTZITE PULLBOX FOR MLOP DATA CABLES WITH POWER NEMA 3R JUNCTION BOX MOUNTED INSIDE THE PULLBOX.
  - 2" UNDERGROUND SCH40 PVC CONDUIT WITH POWER CONDUCTORS, SEE WIRING SCHEMATIC.
  - TWO 2" EMPTY UNDERGROUND SCH40 PVC CONDUIT, ONE 2" FOR OWNER'S AUDIO SYSTEM/DETECTOR LOOP CABLES AND ONE 2" FOR OWNER'S DIGITAL MENUBOARD CABLES.
  - 1" EMPTY UNDERGROUND SCH40 PVC CONDUIT FOR OWNER'S AUDIO SYSTEM/DETECTOR LOOP CABLES AND 2" EMPTY UNDERGROUND SCH40 PVC CONDUIT FOR OWNER'S DIGITAL MENUBOARD CABLES.
  - INSTALL UNDERGROUND 3" SCH40 PVC CONDUIT UP INTO THE CANOPY COLUMN WITH TYPE MC CABLE (GALVANIZED STEEL WITH PVC JACKET) RUN WITHIN FOR THE 120V POWER FOR LIGHTS, 120 VOLT POWER FOR FANS, AND 24 VOLT POWER FOR THE INFRARED GAS HEATERS.
  - NOT USED.
  - PROVIDE ONE DUPLEX GFCI (WITH IN-USE WP COVER PLATE), TWO 120V SINGLE-POLE SWITCHES (EACH WITH HUBBELL #RW51550 WP COVER PLATE), AND ONE DUPLEX SINGLE-POLE SWITCH (WITH HUBBELL #RW51470 WP COVER PLATE) MOUNTED ON THE COLUMN IN FLUSH MOUNTED METAL SINGLE GANG BOXES FOR LOCAL ON-OFF CONTROL OF THE FAN, HEATERS, AND CANOPY LIGHTS. SEE WIRING SCHEMATIC AND CANOPY COLUMN DETAILS FOR FURTHER INFORMATION. ALL SURFACE MOUNTED ITEMS AND COVER PLATES TO BE FIELD PAINTED MATTE BLACK.
  - ALL CONDUIT AND BOXES SHALL BE CONCEALED FROM NORMAL VIEW: UNDERGROUND, IN COLUMNS, OR ABOVE THE CANOPY (ON THE ROOF). MC CABLE (GALVANIZED STEEL WITH PVC JACKET) TO BE USED INSIDE THE COLUMNS, BUT MUST CONVERT BACK TO IMC ABOVE THE ROOF. REFER TO THE MECHANICAL DRAWINGS FOR DETAILS OF MOUNTING CONDUIT ON THE ROOF OF THE CANOPY. ALL EXPOSED ELECTRICAL BOXES TO BE NEMA 3R CAST-METAL.

- ELECTRICAL KEYNOTES (OMD CANOPY):**
- CEILING LIGHT PROVIDED BY CANOPY SUPPLIER AND INSTALLED BY E.C.
  - NOT USED.
  - AIR CIRCULATING FAN (WITH INTEGRAL ON-OFF SWITCH) PROVIDED BY OTHERS. PROVIDE A DUPLEX OUTLET (WITH IN-USE WP COVER PLATE) FLUSH MTD. IN CUT-OUT FOR FAN'S PLUG & CORD. LOCATE CUT-OUT AT TOP OF COLUMN ON DOWNSTREAM SIDE.
  - SEE SHEET E2.2 FOR INFORMATION RELATED TO WALL MTD ELECTRIC HEATED ABOVE DT DOOR.
  - THRU (9) NOT USED.
  - NOT USED.
  - AT EXISTING BUILDINGS STUB A 3" CHASE THRU THE EXTERIOR WALL FROM THE CEILING SPACE ABOVE THE KITCHEN TO ABOVE THE CANOPY'S COLUMN FOR THE MC CABLE POWER CIRCUITS TO GO THRU THE COLUMN MOUNTED SWITCHES AND OUTLET.
  - PROVIDE ONE DUPLEX GFCI (WITH IN-USE WP COVER PLATE), TWO 120V SINGLE-POLE SWITCHES (EACH WITH HUBBELL #RW51550 WP COVER PLATE), AND ONE DUPLEX SINGLE-POLE SWITCH (WITH HUBBELL #RW51470 WP COVER PLATE) MOUNTED ON THE COLUMN IN FLUSH MOUNTED METAL SINGLE GANG BOXES FOR LOCAL ON-OFF CONTROL OF THE FAN, HEATERS, AND CANOPY LIGHTS. SEE WIRING SCHEMATIC AND CANOPY COLUMN DETAILS FOR FURTHER INFORMATION. ALL SURFACE MOUNTED ITEMS AND COVER PLATES TO BE FIELD PAINTED MATTE BLACK.
  - ALL CONDUIT AND BOXES SHALL BE CONCEALED FROM NORMAL VIEW: UNDERGROUND, IN COLUMNS, OR ABOVE THE CANOPY (ON THE ROOF). MC CABLE (GALVANIZED STEEL WITH PVC JACKET) TO BE USED INSIDE THE COLUMNS, BUT MUST CONVERT BACK TO IMC ABOVE THE ROOF. REFER TO THE MECHANICAL DRAWINGS FOR DETAILS OF MOUNTING CONDUIT ON THE ROOF OF THE CANOPY. ALL EXPOSED ELECTRICAL BOXES TO BE NEMA 3R CAST-METAL.

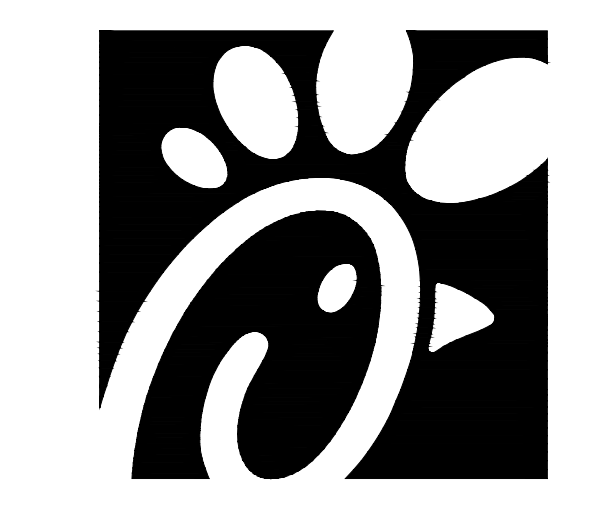

**Chick-fil-A**  
5200 Buffington Road  
Atlanta, Georgia 30349

**Kurzynske & Associates**  
CONSULTING ENGINEERS  
2705 Lebanon Pike - Suite One  
Nashville, Tennessee 37214  
Telephone: (615) 255-5203



**CHICK-FIL-A**  
DELTRAN FSU  
1301 FAIRVIEW BLVD  
DELTRAN, NJ 08075

**FSR#01385**  
BUILDING TYPE / SIZE: S97-110  
RELEASE: v05.22  
**REVISION SCHEDULE**


NO.	DATE	DESCRIPTION
18	01/09/24	Design Note

**CONSTRUCTION**

CONSULTANT PROJECT # 22146.HF.R  
PRINTED FOR CONSTRUCTION  
DATE 1/30/2023  
DRAWN BY ML  
SHEET CANOPY PLANS AND DETAILS  
SHEET NUMBER



**Chick-fil-A**  
5200 Buffington Road  
Atlanta, Georgia 30349

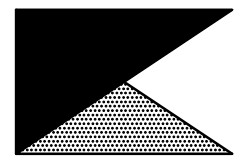

**Kurzynske & Associates**  
CONSULTING ENGINEERS  
2705 Lebanon Pike - Suite One  
Nashville, Tennessee 37214  
Telephone: (615) 255-5203



**CHICK-FIL-A**  
**DELTRAN FSU**  
1301 FAIRVIEW BLVD  
DELTRAN, NJ 08075

**FSR#01385**

BUILDING TYPE / SIZE: S97-110  
RELEASE: v05.22  
**REVISION SCHEDULE**

NO.	DATE	DESCRIPTION

**CONSTRUCTION**




CONSULTANT PROJECT # 22146.HF.R  
PRINTED FOR CONSTRUCTION  
DATE 1/30/2023  
DRAWN BY ML

Information contained on this drawing and in all digital files produced for above named project may not be reproduced in any manner without express written or verbal consent from authorized project representatives.

SHEET ORDER CANOPY CONTROL PANEL

SHEET NUMBER

**E1.4**

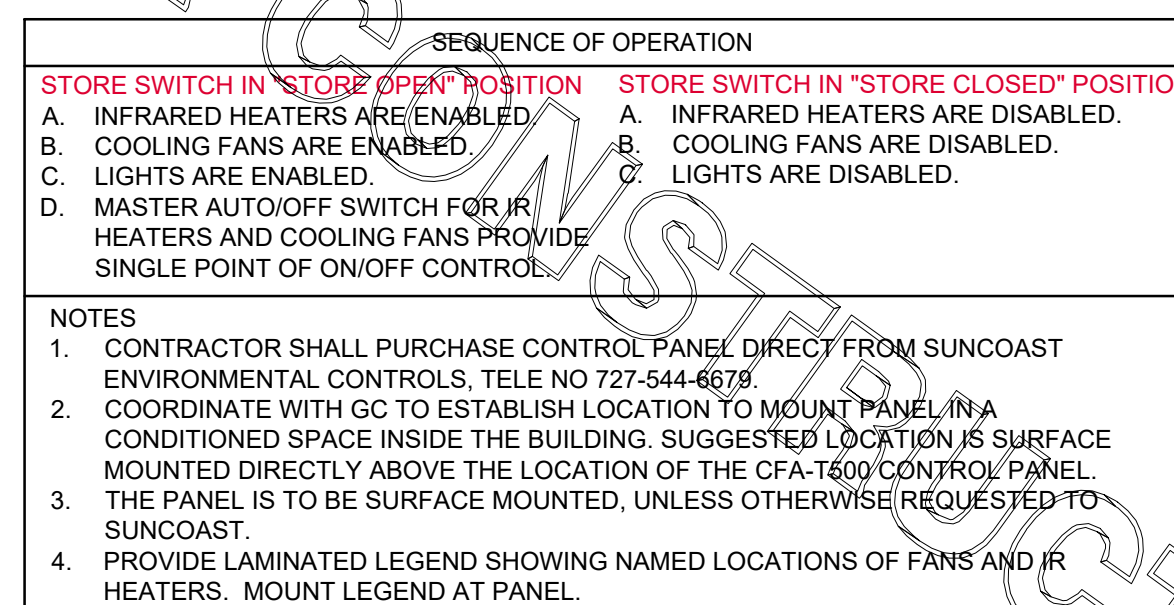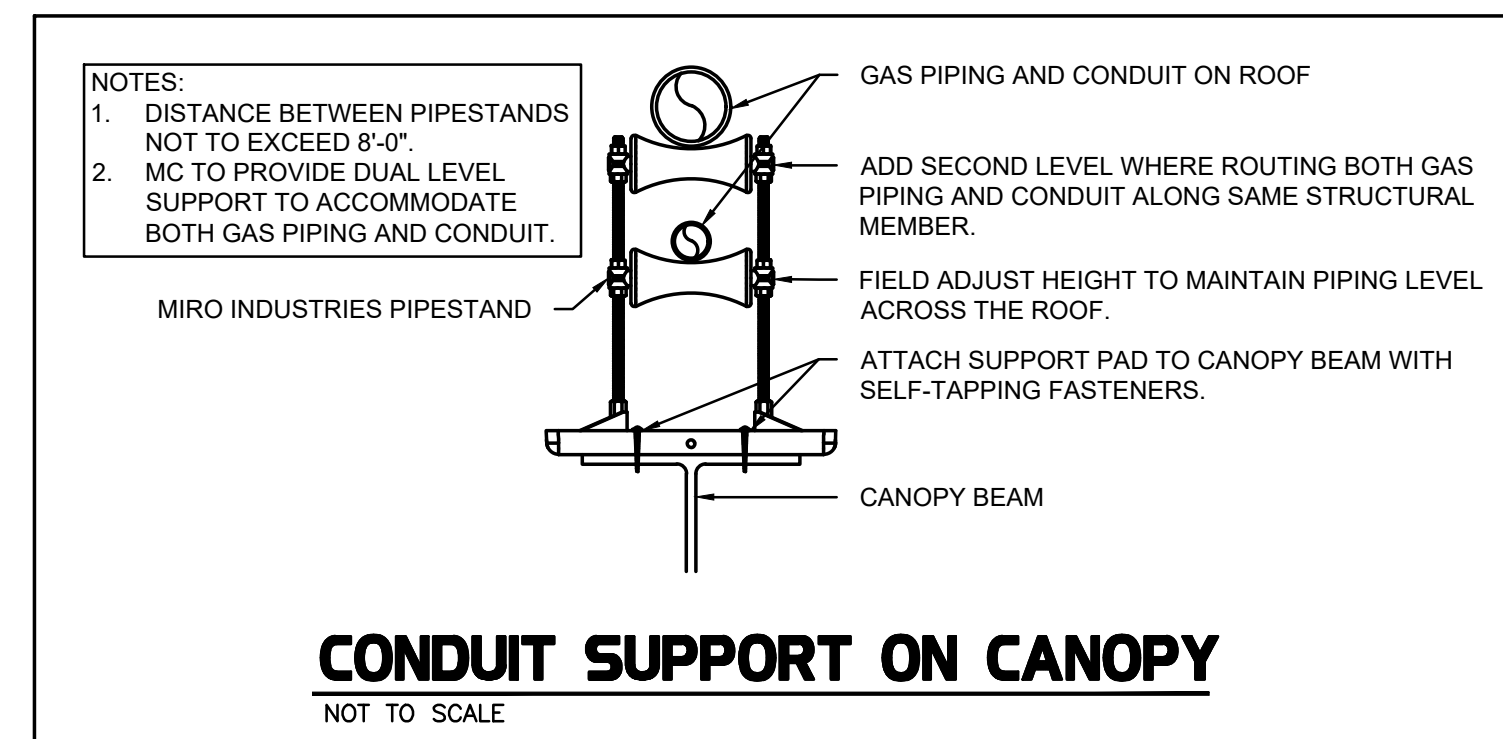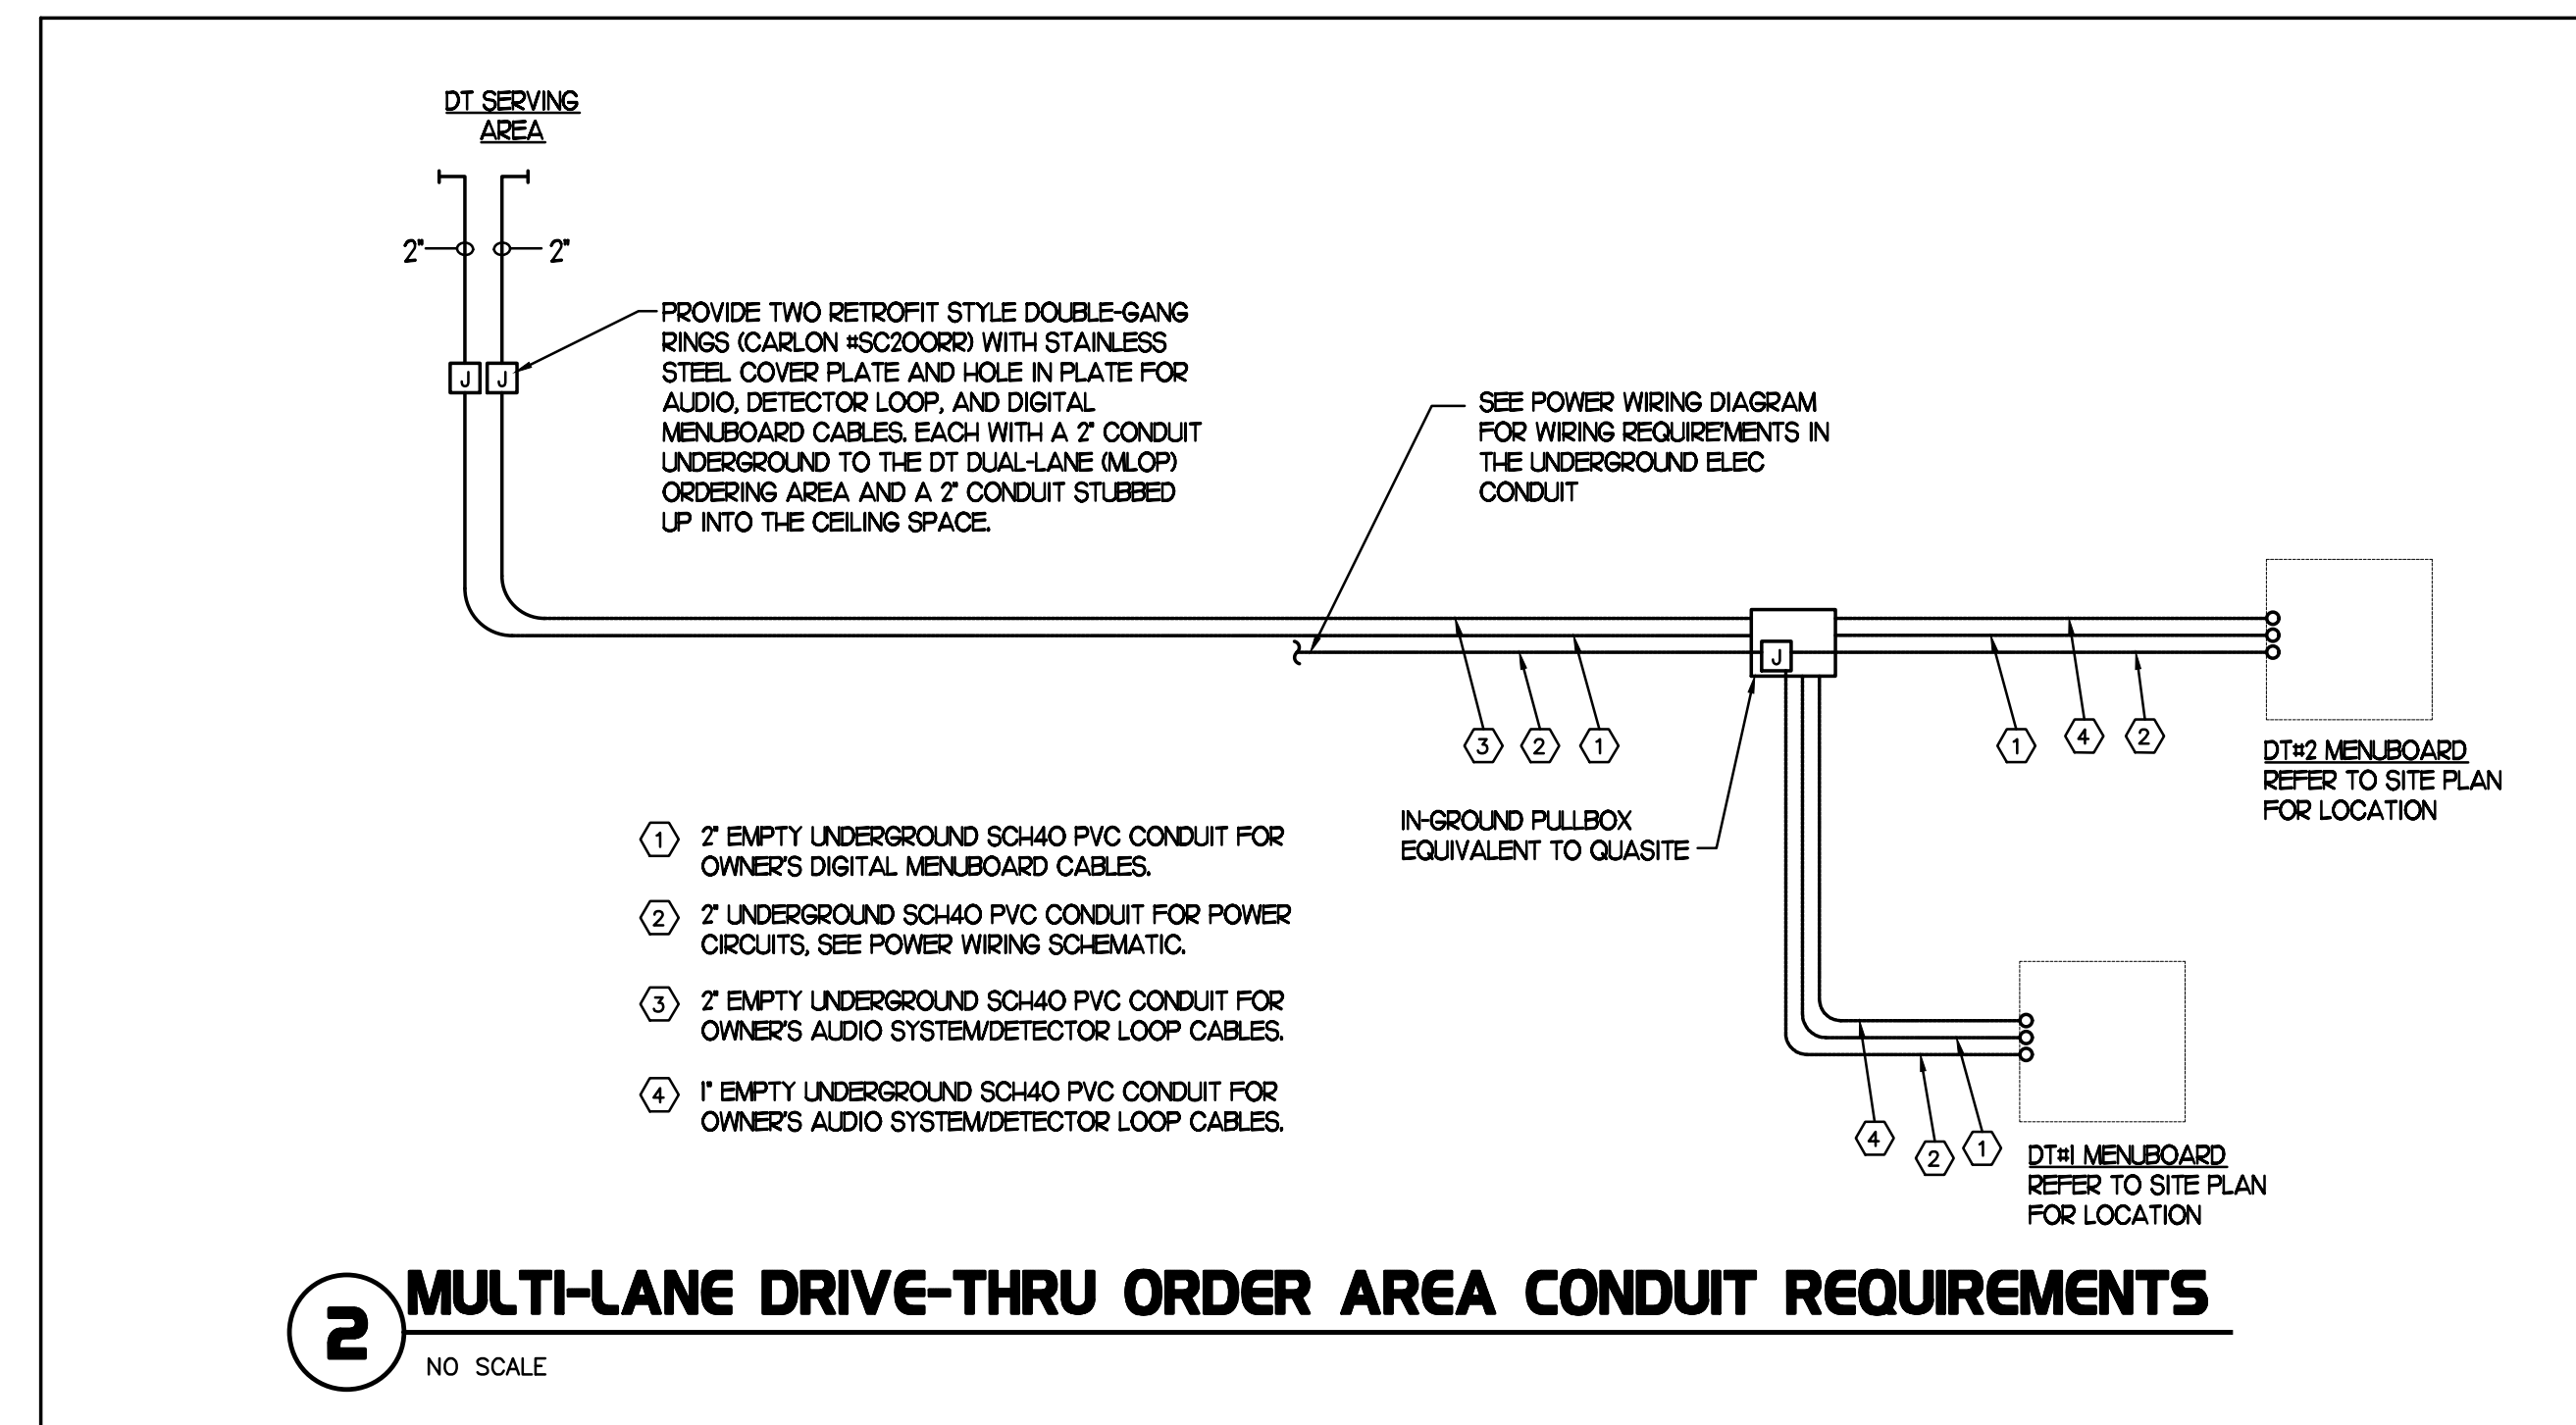

**LEGEND**

SEC	SUNCOAST ENVIRONMENTAL CONTROLS (SUPPLIER OF CONTROL PANELS)
MC	MECHANICAL CONTRACTOR
EC	ELECTRICAL CONTRACTOR
---	LOW VOLTAGE BY MECHANICAL CONTRACTOR
---	18 GA. MIN LOW VOLTAGE WIRING BY SUNCOAST
---	120 VOLT BY ELECTRICAL CONTRACTOR
---	120 VOLT BY SUNCOAST

**CIRCULATING FAN SCHEDULE**


MARK	CFM	RPM	HP	MODEL	MANUFACTURER
CF	5,750	1,625	1/8	U18TE-HD	TPI

REMARKS

- ALUMINUM PADDLE WITH STEEL HUB/SPIDER PROPELLER.
- 360° ROTATING HEAD HORIZONTALLY AND VERTICALLY.
- OSHA COMPLIANT DOUBLE LOCKING, COATED STEEL WIRE GUARD
- 3-SPEED, TOTALLY ENCLOSED, PERMANENTLY LUBRICATED BALL BEARING MOTOR.
- FACTORY PRE-WIPED POWER CORD.
- PROVIDE FACTORY WALL MOUNTING BRACKET. SEE FAN MOUNTING DETAIL ON CANOPY SHOP DRAWINGS FOR TYPICAL INSTALLATION INSTRUCTIONS.
- PROVIDE ENGRAVED PLASTIC LABEL AT EACH UNIT WITH UNIT DESIGNATION IN 1" HIGH WHITE LETTERS ON A BLACK BACKGROUND. MOUNT TO UNDERSIDE OF CANOPY OR EXISTING OVERHANG, FACING DOWNWARD, 12" LATERALLY FROM THE FAN LOCATION.
- REMOVE PULL CHAIN EXTENSION AT ON/OFF SWITCH IN FIELD.
- FACTORY CERTIFIED FOR OUTDOOR INSTALLATION.

**NATIONAL ACCOUNTS**

1. TPI FAN PACKAGE - THE MECHANICAL CONTRACTOR IS REQUIRED TO PURCHASE THE FAN PACKAGE DIRECTLY FROM TOM BARROW COMPANY. CONTACT MR. SCOTT GEORGE AT 404-351-1010 FOR PRICING AND AVAILABILITY. FANS NOT PURCHASED THRU TOM BARROW COMPANY WILL NOT BE ACCEPTED.

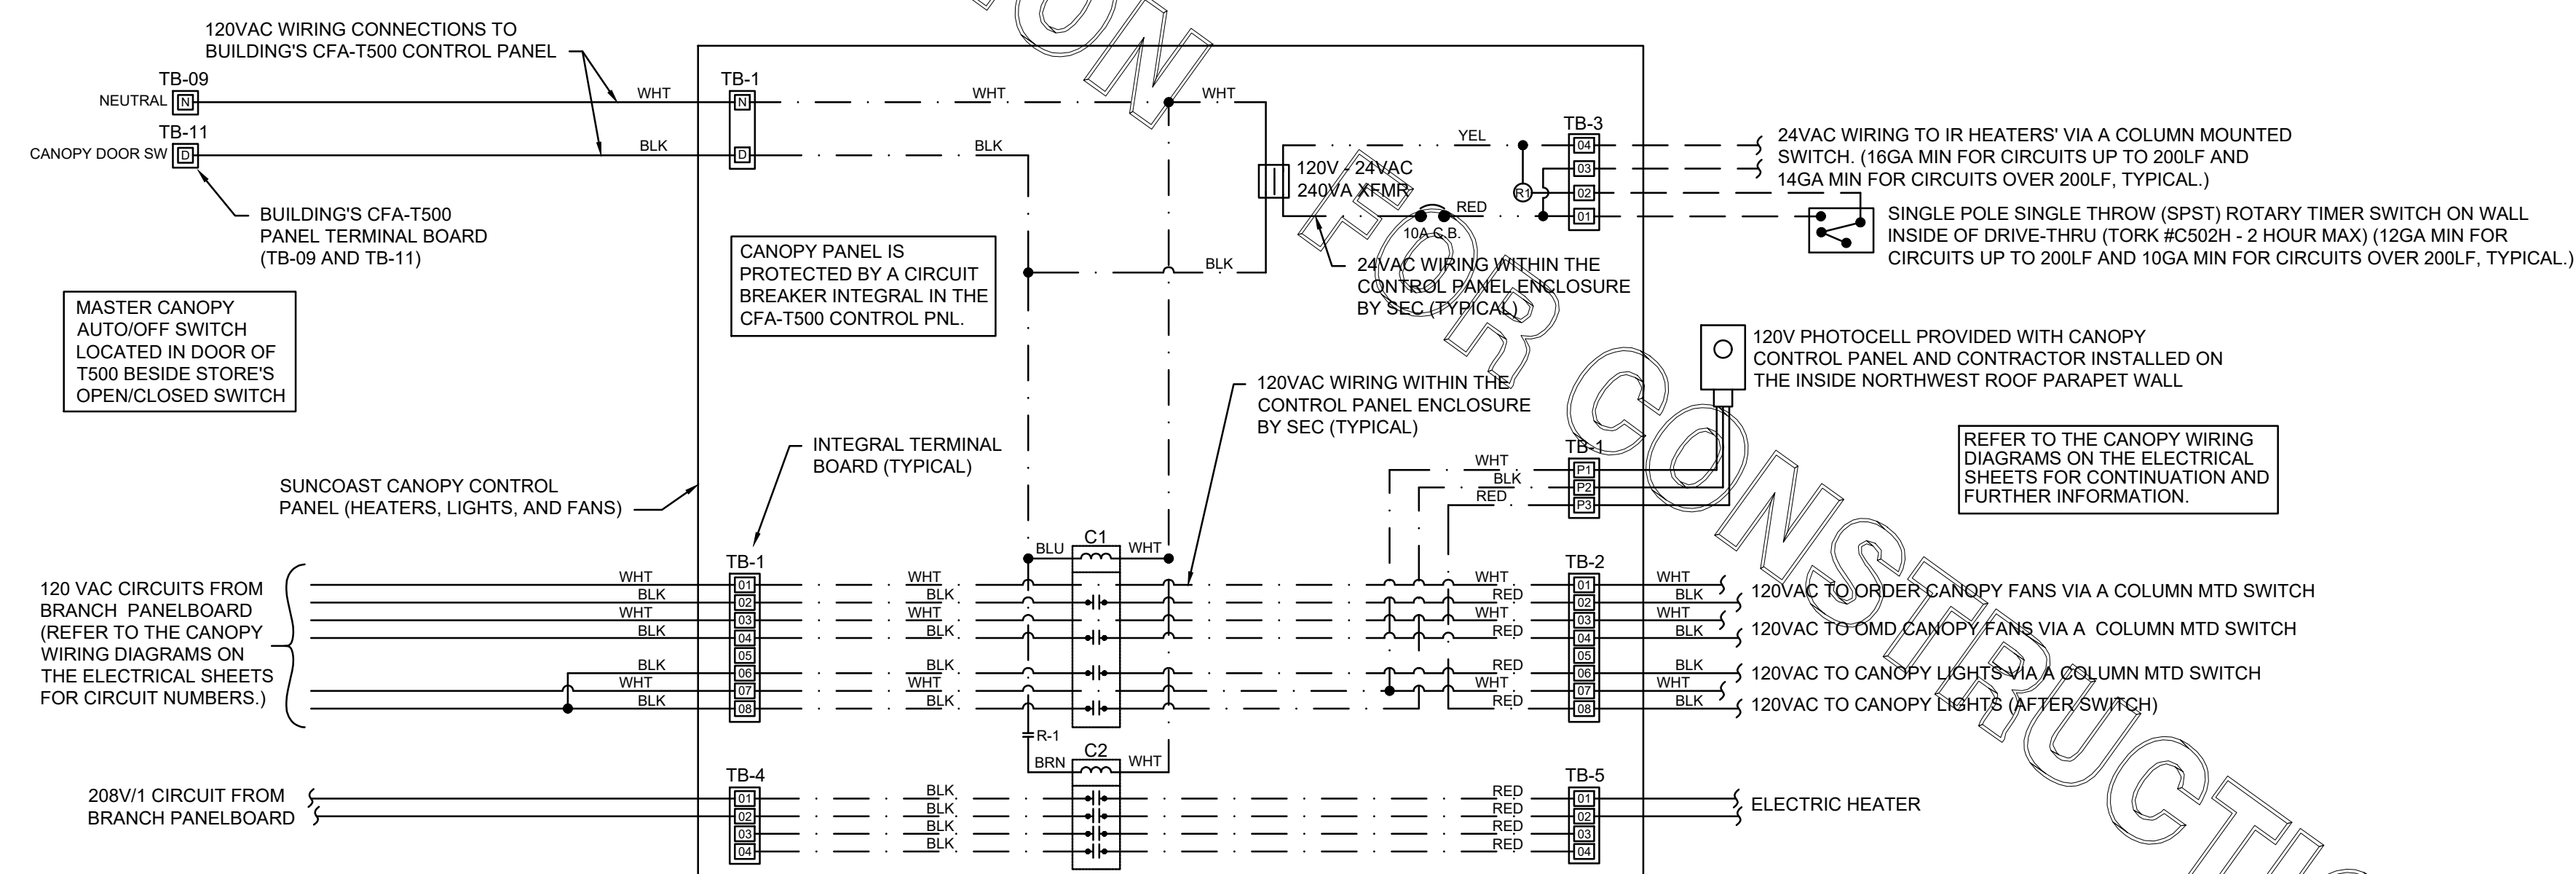

FOR CONSTRUCTION


FOR CONSTRUCTION

FOR CONSTRUCTION

E  
D  
C  
B  
A



**Chick-fil-A**  
5200 Buffington Road  
Atlanta, Georgia 30349

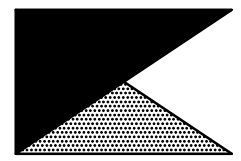

**Kurzynske & Associates**  
CONSULTING ENGINEERS  
2705 Lebanon Pike - Suite One  
Nashville, Tennessee 37214  
Telephone: (615) 255-5203



**CHICK-FIL-A**  
**DELTRAN FSU**  
1301 FAIRVIEW BLVD  
DELTRAN, NJ 08075

**FSR#01385**


BUILDING TYPE / SIZE: S97-110  
RELEASE: v05.22  
REVISION SCHEDULE  
NO. DATE DESCRIPTION

**CONSTRUCTION**

18 01/09/24 Design Note  
CONSULTANT PROJECT # 22146.HF.R  
PRINTED FOR CONSTRUCTION  
DATE 1/30/2023  
DRAWN BY ML

Information contained on this drawing and in all digital files produced for above named project may not be reproduced in any manner without express written or verbal consent from authorized project representatives.  
SHEET ELECTRICAL DEMOLITION PLAN  
SHEET NUMBER

**E2.0**

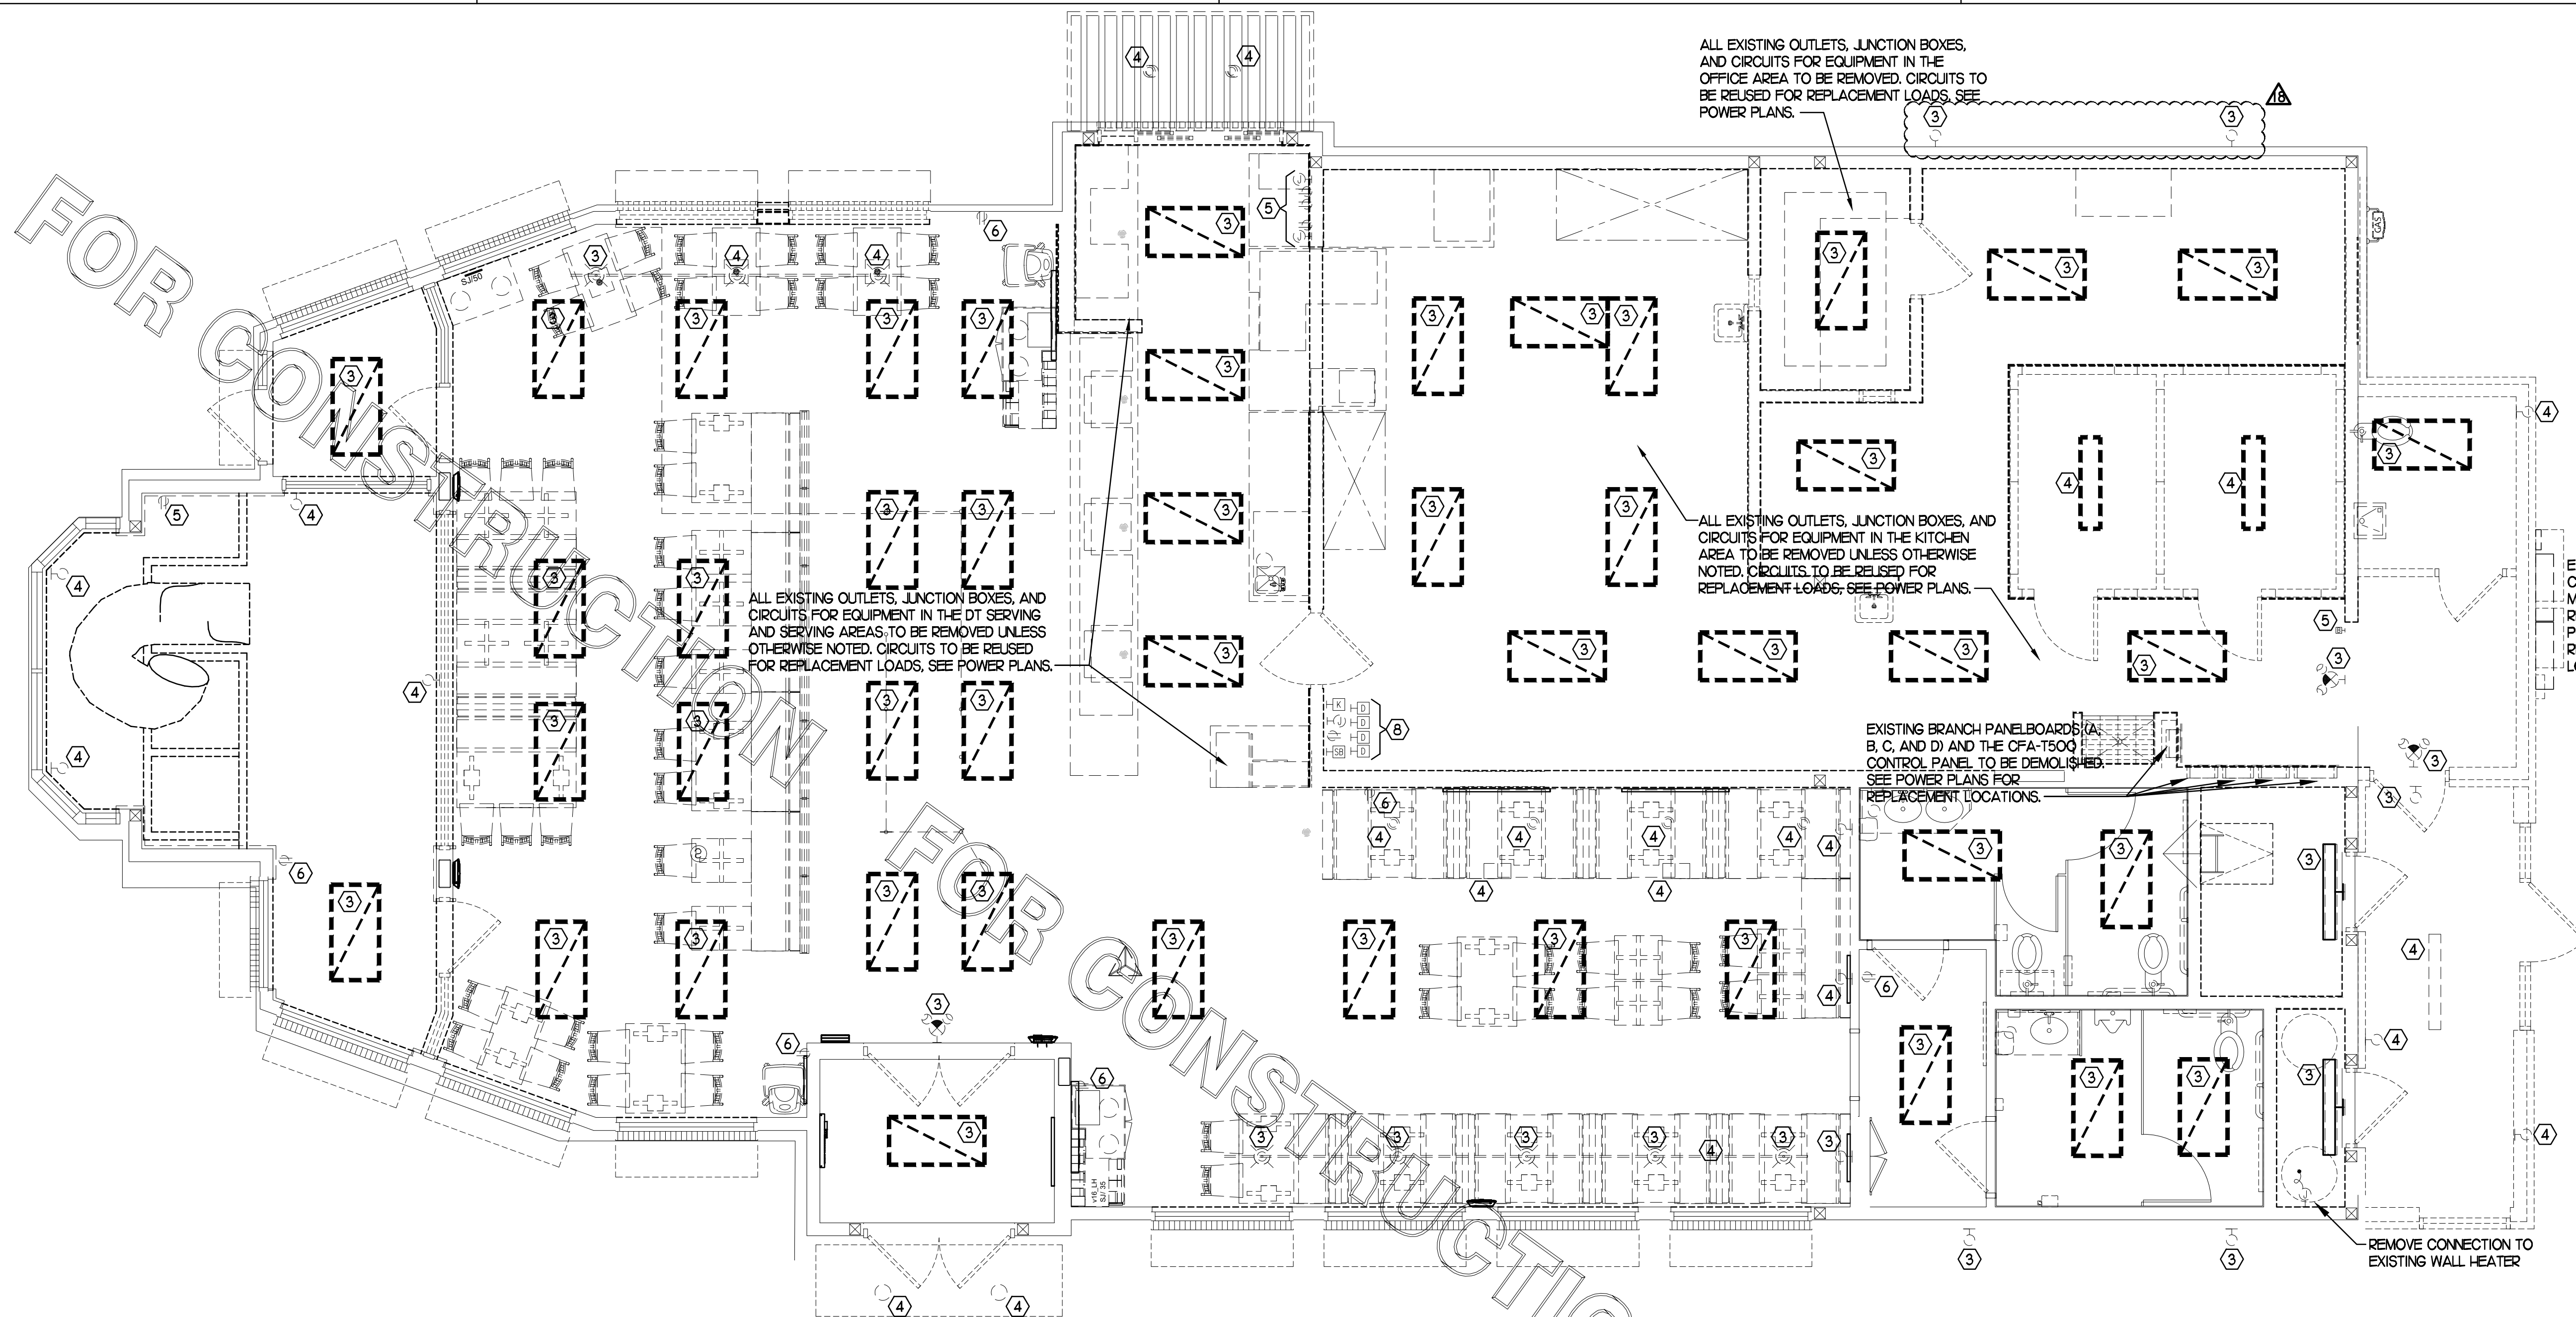

**1 ELECTRICAL DEMOLITION PLAN**  
SCALE: 1/4"=1'-0"

THE INFORMATION USED TO DEVELOP THE EXISTING CONDITIONS AS SHOWN ON THESE PLANS IS FROM PREVIOUS BUILDING DRAWINGS. WHAT WAS SHOWN ON PLAN AND WHAT WAS ACTUALLY INSTALLED MAY VARY. FIELD VERIFY ALL EXISTING CONDITIONS.


**2 KEYNOTES (APPLY TO THIS SHEET ONLY)**

- ① EXISTING LIGHTING FIXTURE TO REMAIN CLEAN AND RELAMP THE FIXTURE AND RECONNECT TO THE EXISTING BRANCH CIRCUIT.
- ② EXISTING LIGHTING FIXTURE TO BE REMOVED AND REINSTALLED IN THE REPLACEMENT CEILING. CLEAN AND RELAMP THE FIXTURE. VERIFY FIXTURE LOCATION WITH THE LIGHTING PLAN AND THE REFLECTED CEILING PLAN.
- ③ EXISTING LIGHTING FIXTURE TO BE REMOVED AND REPLACED. SEE THE LIGHTING FLOOR PLAN.
- ④ EXISTING LIGHTING FIXTURE TO BE REMOVED. EXISTING BRANCH CIRCUIT WIRING TO BE REUSED IF POSSIBLE AND FEASIBLE.
- ⑤ EXISTING WIRING DEVICE/JUNCTION BOX TO REMAIN.
- ⑥ EXISTING WIRING DEVICE TO BE REPLACED WITH TAMPER-RESISTANT USB CHARGING TYPE DEVICE.
- ⑦ EXISTING LIGHTING FIXTURE TO BE RELOCATED AND REINSTALLED IN THE REPLACEMENT CEILING. CLEAN AND RELAMP THE FIXTURE AS NEEDED. VERIFY FIXTURE LOCATION WITH THE LIGHTING PLAN AND THE REFLECTED CEILING PLAN.
- ⑧ EXISTING ELECTRICAL ITEMS TO BE REMOVED AND/OR RELOCATED. SEE THE POWER FLOOR PLAN FOR THE REUSE OF THE EXISTING CIRCUITS.

FOR CONSTRUCTION

FOR CONSTRUCTION

FOR CONSTRUCTION

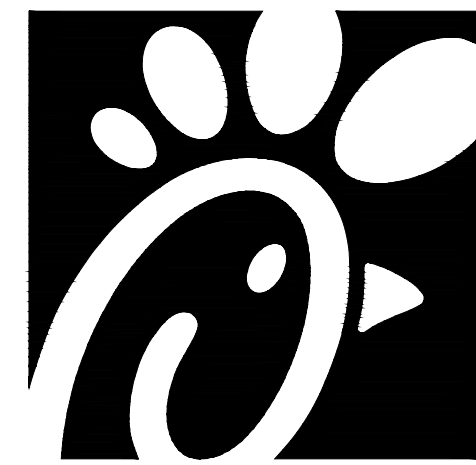

**Chick-fil-A**  
5200 Buffington Road  
Atlanta, Georgia 30349



**Kurzynske & Associates**  
CONSULTING ENGINEERS  
2705 Lebanon Pike - Suite One  
Nashville, Tennessee 37214  
Telephone: (615) 255-5203

MARK T. KURZYNSKIE  
NEW JERSEY LICENSE # GE44646



**CHICK-FIL-A**  
DELTRAN FSU  
1301 FAIRVIEW BLVD  
DELTRAN, NJ 08075

**FSR#01385**

BUILDING TYPE / SIZE: S97-110  
RELEASE: v05.22

**REVISION SCHEDULE**

NO.	DATE	DESCRIPTION
1	02/22/23	Owner Revision
3	05/16/23	Construction Set
7	07/31/23	Pre-bid Comments



18 01/09/24 Design Note  
CONSULTANT PROJECT # 22146.HF.R  
PRINTED FOR CONSTRUCTION  
DATE 1/30/2023  
DRAWN BY ML

Information contained on this drawing and in all digital files produced for above named project may not be reproduced in any manner without express written or verbal consent from authorized project representatives.  
SHEET LIGHTING PLAN


SHEET NUMBER

**E2.1**

SEE SHEET E1.3 FOR CANOPY REQUIREMENTS

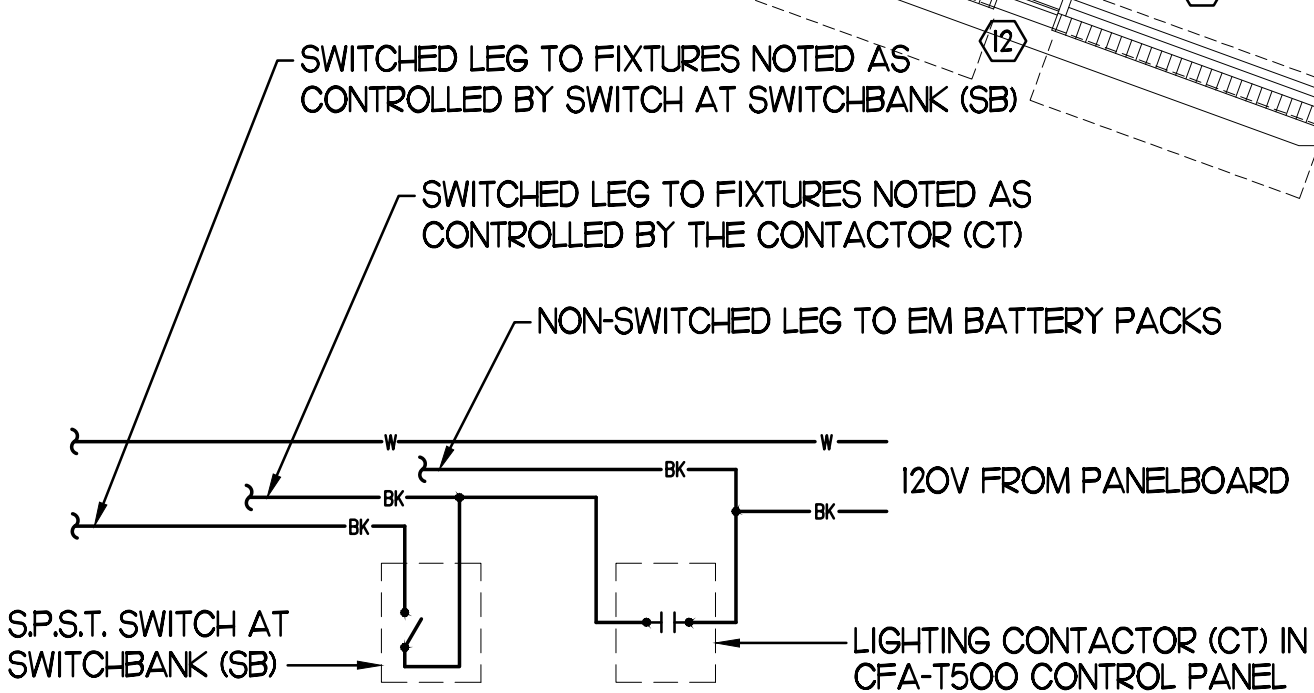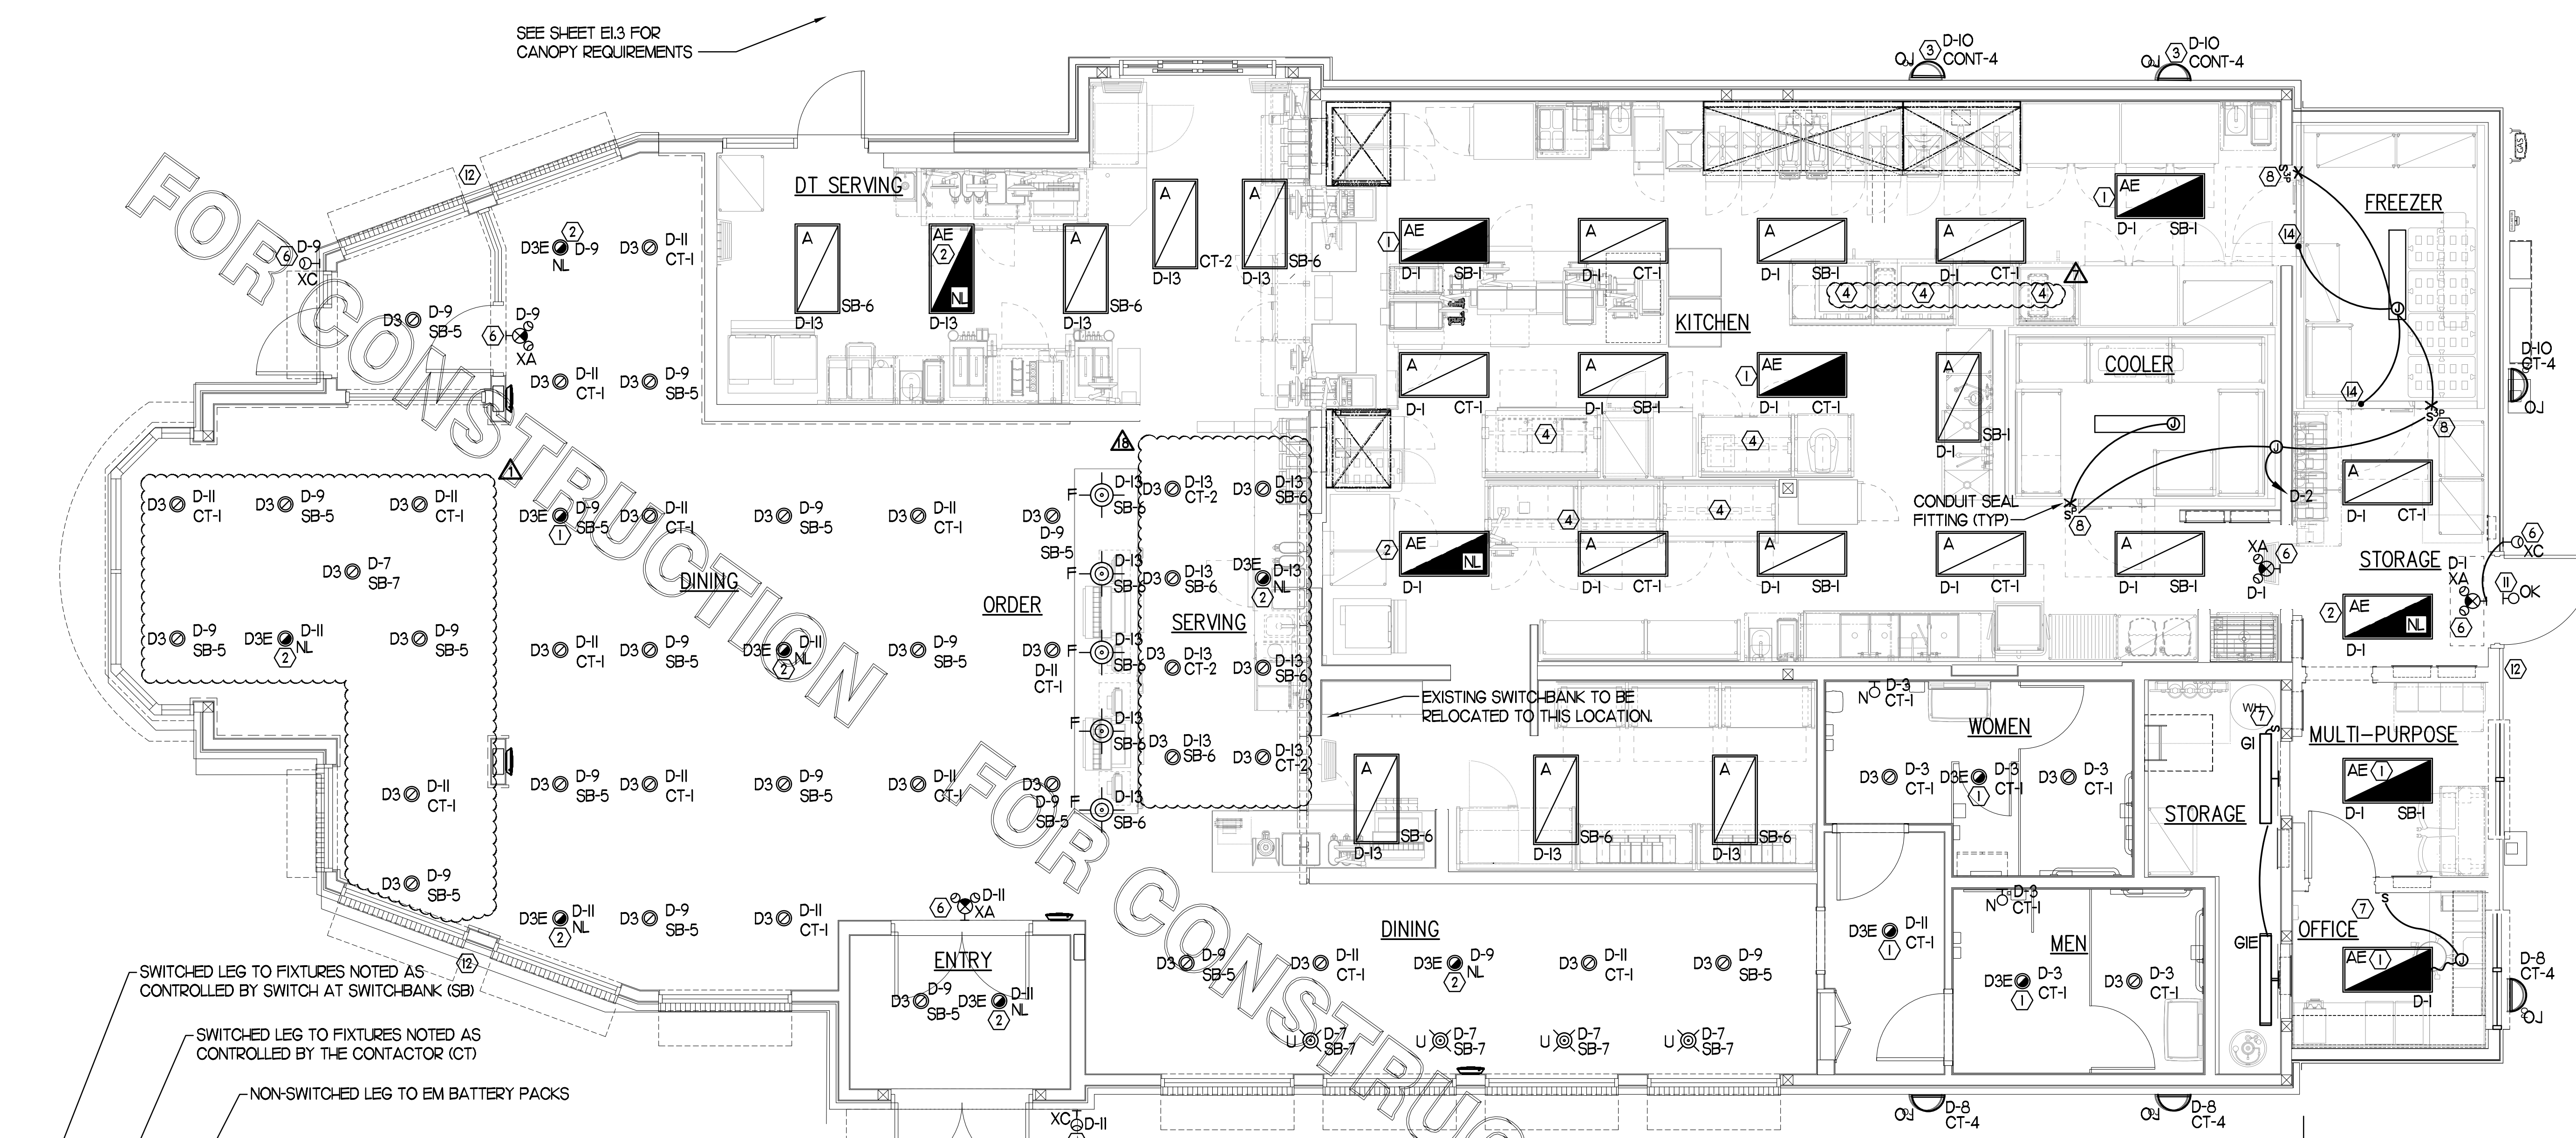

**5 TYPICAL LIGHTING CONTROL DETAIL**  
NO SCALE

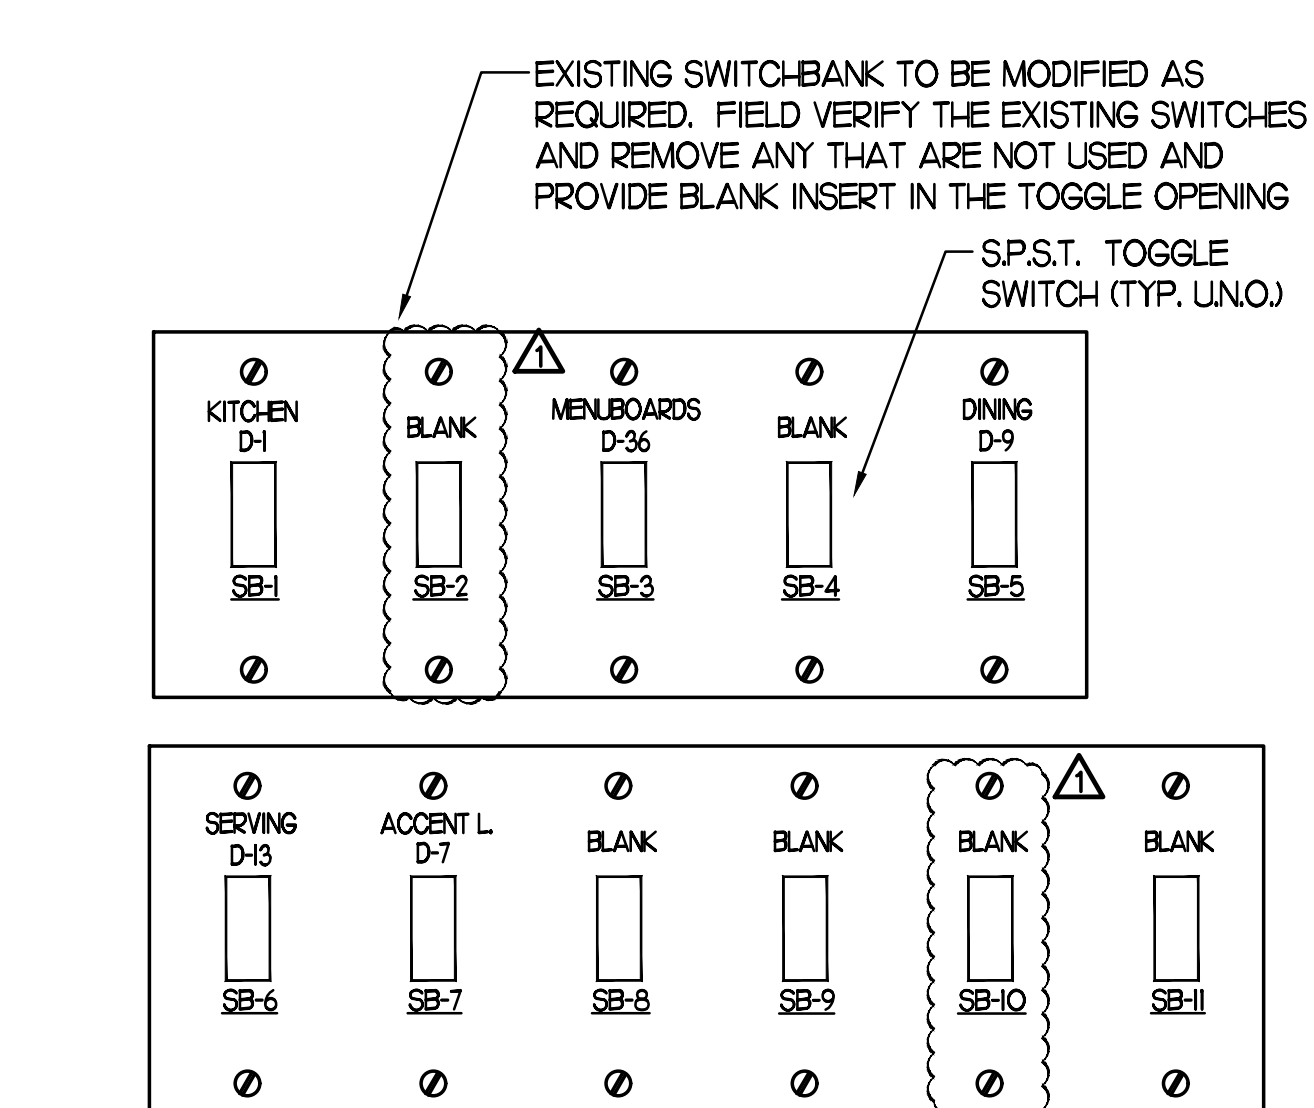


**6 RELOCATED SWITCH BANK "SB" DETAIL**  
NO SCALE

**4 KEYNOTES (APPLY TO THIS SHEET ONLY)**

- CONNECT FIXTURE SO THAT BATTERY PACK IS NOT SWITCHED WITH LIGHTS, BUT ALL LAMPS ARE SWITCHED.
- CONNECT FIXTURE SO THAT LAMP BALLAST AND EMERGENCY BALLAST ARE NOT SWITCHED. 'NL' ADJACENT TO FIXTURE INDICATES THAT FIXTURE SHALL BE ON 24 HOURS.
- NOT USED.
- PROVIDE A TYPE BI LIGHT FIXTURE. MOUNT TO THE UNDERSIDE OF THE WIRE SHELVING. PROVIDE FLEX CONDUIT AND CONNECT TO A SWITCH IN AN FS BOX MOUNTED TO THE SHELF. FROM FS BOX PROVIDE AN SO CORD WITH PLUG AND CONNECT TO THE GEN RECEPTACLE.
- NOT USED.
- CONNECT FIXTURE TO CIRCUIT AHEAD OF ALL SWITCHING AND CONTROLS. THIS FIXTURE SHALL NOT BE SWITCHED.
- PROVIDE A WALL SWITCH LINE VOLTAGE OCCUPANCY SENSOR EQUIVALENT TO SENSOR SWITCH #WSD-WH
- PILOT LIGHT SWITCH FOR CONTROL OF LED LIGHT FIXTURE INSIDE THE WIC OR WIF UNIT. PROVIDE CONDUIT SEAL-OFF FITTINGS FOR ALL CONDUIT PENETRATIONS THRU THE FREEZERS WALL. LED LIGHT FIXTURE FURNISHED WITH THE UNIT BY THE EQUIPMENT SUPPLIER.
- PROVIDE TAMPER-RESISTANT DUPLEX RECEPTACLE AT STANDARD HEIGHT FOR FUTURE COMPACTING TRASH CAN ON A DEDICATED 20 AMP CIRCUIT. USE CIRCUITS C-24, C-26, AND C-28.
- NOT USED.
- CONNECT THE 'OK' FIXTURE TO D-27 VIA THE EXISTING DUSK-TO-DAWN CIRCUIT IN THE CFA-T500.
- COORDINATE CONNECTION OF REPLACEMENT SIGNAGE TO EXISTING CKT.
- NOT USED.
- TO WALK-IN DOOR FRAME HEATER AND AIR RELIEF ASSEMBLY. J-BOX TO BE ABOVE THE UNIT AND EXTEND DOWN ALONG THE FRONT AT 9'-6" AFF TO HEATER, AIR RELIEF VALVE ASSEMBLY, AND LIGHT SWITCHES.

**1 LIGHTING PLAN**  
SCALE: 1/4"=1'-0"

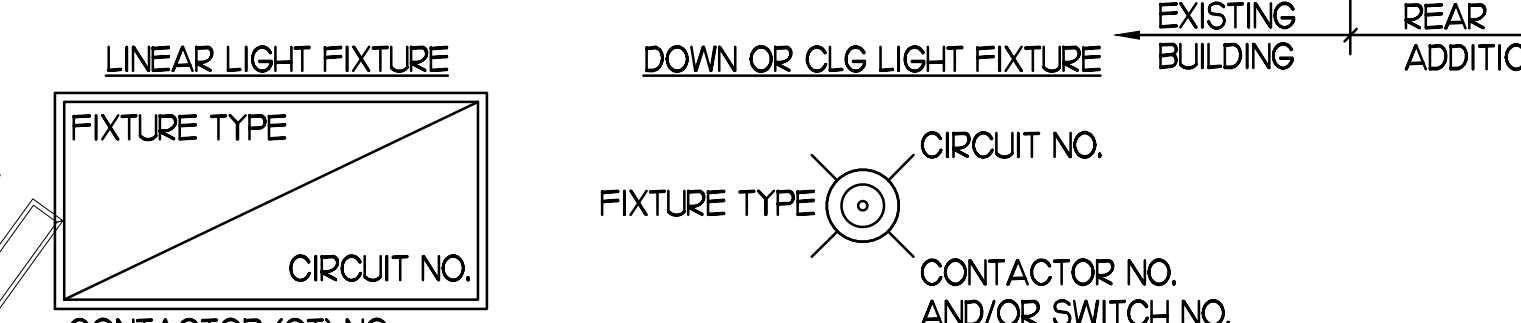


**2 LIGHT FIXTURE NOMENCLATURE DETAIL**  
NO SCALE

**3 LIGHTING FIXTURE (LUMINAIRE) SCHEDULE - CHICK-FIL-A REMODEL Store #1385**

MARK	MANUFACTURER	CATALOG NUMBER	NO. LAMPS/TYPE	WATTS	VOLTS	MOUNTING	REMARKS
A	COOPER/METALUX	24FP6440C	INTEGRAL WITH FIXTURE	59.4	120	RECESSED	KITCHEN AREA, 2'X4' LED PANEL TROFFER, 4000K COLOR TEMP
AE	COOPER/METALUX	24FP6440C-EL14W	INTEGRAL WITH FIXTURE	59.4	120	RECESSED	SAME AS 'A' WITH EMERGENCY BATTERY PACK. SEE PLAN NOTES ABOUT LAMP SWITCHING
B1	METALUX	2VT3-LD5-UNW-L840-CD1-SSL-U	INTEGRAL WITH FIXTURE	32	120	SURFACE	MOUNT LIGHT TO BTM OF OVERHEAD WIRE SHELVING WITH CORD & PLUG
D3	COOPER/HALO	HC6-20-D010-EM14-HM6-12-830-61-ND-C	INTEGRAL WITH FIXTURE	21.1	120	RECESSED	PUBLIC AREA, 6" DIAMETER LED DOWNLIGHT
D3E	COOPER/HALO	HC6-20-D010-EM14-HM6-12-830-61-ND-C	INTEGRAL WITH FIXTURE	21.1	120	RECESSED	SAME AS 'D3' WITH EMERGENCY BATTERY PACK
F	COOPER/HALO	SLDSL6069S1EMWR	INTEGRAL WITH FIXTURE	9	120	SURFACE	SURFACE-MOUNTED LED DOWNLIGHT, 600 LUMENS, 3000K COLOR TEMP
G1	COOPER/METALUX	4SLSTP40400D-UNW	INTEGRAL WITH FIXTURE	44	120	SURFACE	4760 LUMEN 4'FOOT LENSED LED STRIPLIGHT
G1E	COOPER/METALUX	4SLSTP40400D-UNW / EBPLED14W	INTEGRAL WITH FIXTURE	44	120	SURFACE	SAME AS G1 EXCEPT WITH A 14' WATT REMOTE EMERGENCY BATTERY PACK
N	MINKA	4531-2678	1-LED11A19/827/D	11	120	WALL	LAVATORY WALL SCONCE/SHADE POINTED DOWN W/ LED LAMP & CL ON LAVATORY
S	NOT USED						
SE	NOT USED						
U	BESA LIGHTING	BES00298-060	FURNISHED	7.5	120	PENDANT	MONO-POINT PENDANT, RED FRIT GLASS, BRONZE CABLE & CANOPY, 6'-6" AFF
XA	COOPER/SURE-LITES	APCH7R	INTEGRAL WITH FIXTURE	4.11	120	WALL	EXIT SIGN WITH BATTERY PACK AND TWO INTEGRAL ADJUSTABLE LAMPHEADS
XJ	MULE LITG	MAKO-LED-ACEM-NK-IH	INTEGRAL WITH FIXTURE	13	120	WALL	EXTERIOR WALL MOUNTED EMERGENCY LIGHTING UNIT, LOCATE NEAR EGRESS DOOR
QC	SECURITY LITG	RWS0-72L-3K-UD-U-DB	FURNISHED	25	120	WALL	UP/DOWN LED EXTERIOR WALL SCONCE, SEE ELEVATIONS FOR MOUNTING HEIGHT
OK	HUBBELL	LNC-5LU-3K-3-1	FURNISHED	12.9	120	WALL	LED WALLPACK W/ CENTERLINE OF FIXTURE AT 8'-0" ABV 0'-0" (FINISH FLOOR LINE)

NOTES:  
1. LUMINAIRES UTILIZING DOUBLE-ENDED LAMPS AND CONTAIN BALLASTS THAT CAN BE SERVICED IN PLACE SHALL HAVE A DISCONNECTING MEANS EITHER INTERNAL OR EXTERNAL TO EACH LUMINAIRE PER NEC 410.130(G).  
2. THE LIGHTING FIXTURE PACKAGE IS AVAILABLE THROUGH A NATIONAL ACCOUNT PROGRAM. REFER TO THE ELECTRICAL SPECIFICATIONS SHEET, SECTION C16500 FOR VENDOR INFORMATION.  
3. THE ASTERISK (\*) BESIDE THE FIXTURE MARK IN THE ABOVE SCHEDULE INDICATES THE FIXTURE IS A NON-PROTOTYPICAL LIGHT FIXTURE PER THE CFA NATIONAL P12 PROTOTYPE.

**CONSTRUCTION**

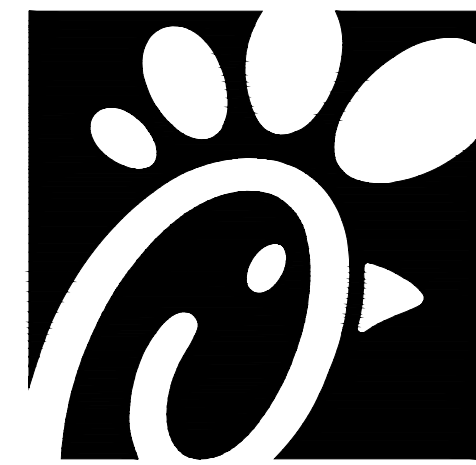

Chick-fil-A

Chick-fil-A  
5200 Buffington Road  
Atlanta, Georgia 30349



Kurzynske  
& Associates  
CONSULTING ENGINEERS  
2705 Lebanon Pike - Suite One  
Nashville, Tennessee 37214  
Telephone: (615) 255-5203

MARK T. KURZYNSKIE  
NEW JERSEY LICENSE # GE44646



**CHICK-FIL-A**  
DELTRAN FSU  
1301 FAIRVIEW BLVD  
DELTRAN, NJ 08075

**FSR#01385**

BUILDING TYPE / SIZE: S97-110

RELEASE: v05.22

REVISION SCHEDULE

NO.	DATE	DESCRIPTION
1	02/22/23	Owner Revision
3	05/16/23	Construction Set
7	07/31/23	Pre-bid Comments
15	11/17/23	Owner Revision
18	01/09/24	Design Note
20	02/20/24	GD Coordination

CONSULTANT PROJECT # 22146.HF.R

PRINTED FOR CONSTRUCTION

DATE 1/30/2023


DRAWN BY ML

Information contained on this drawing and in all digital files produced for above named project may not be reproduced in any manner without express written or verbal consent from authorized project representatives.

SHEET  
LARGE SCALE KITCHEN  
POWER

SHEET NUMBER

**E2.2**

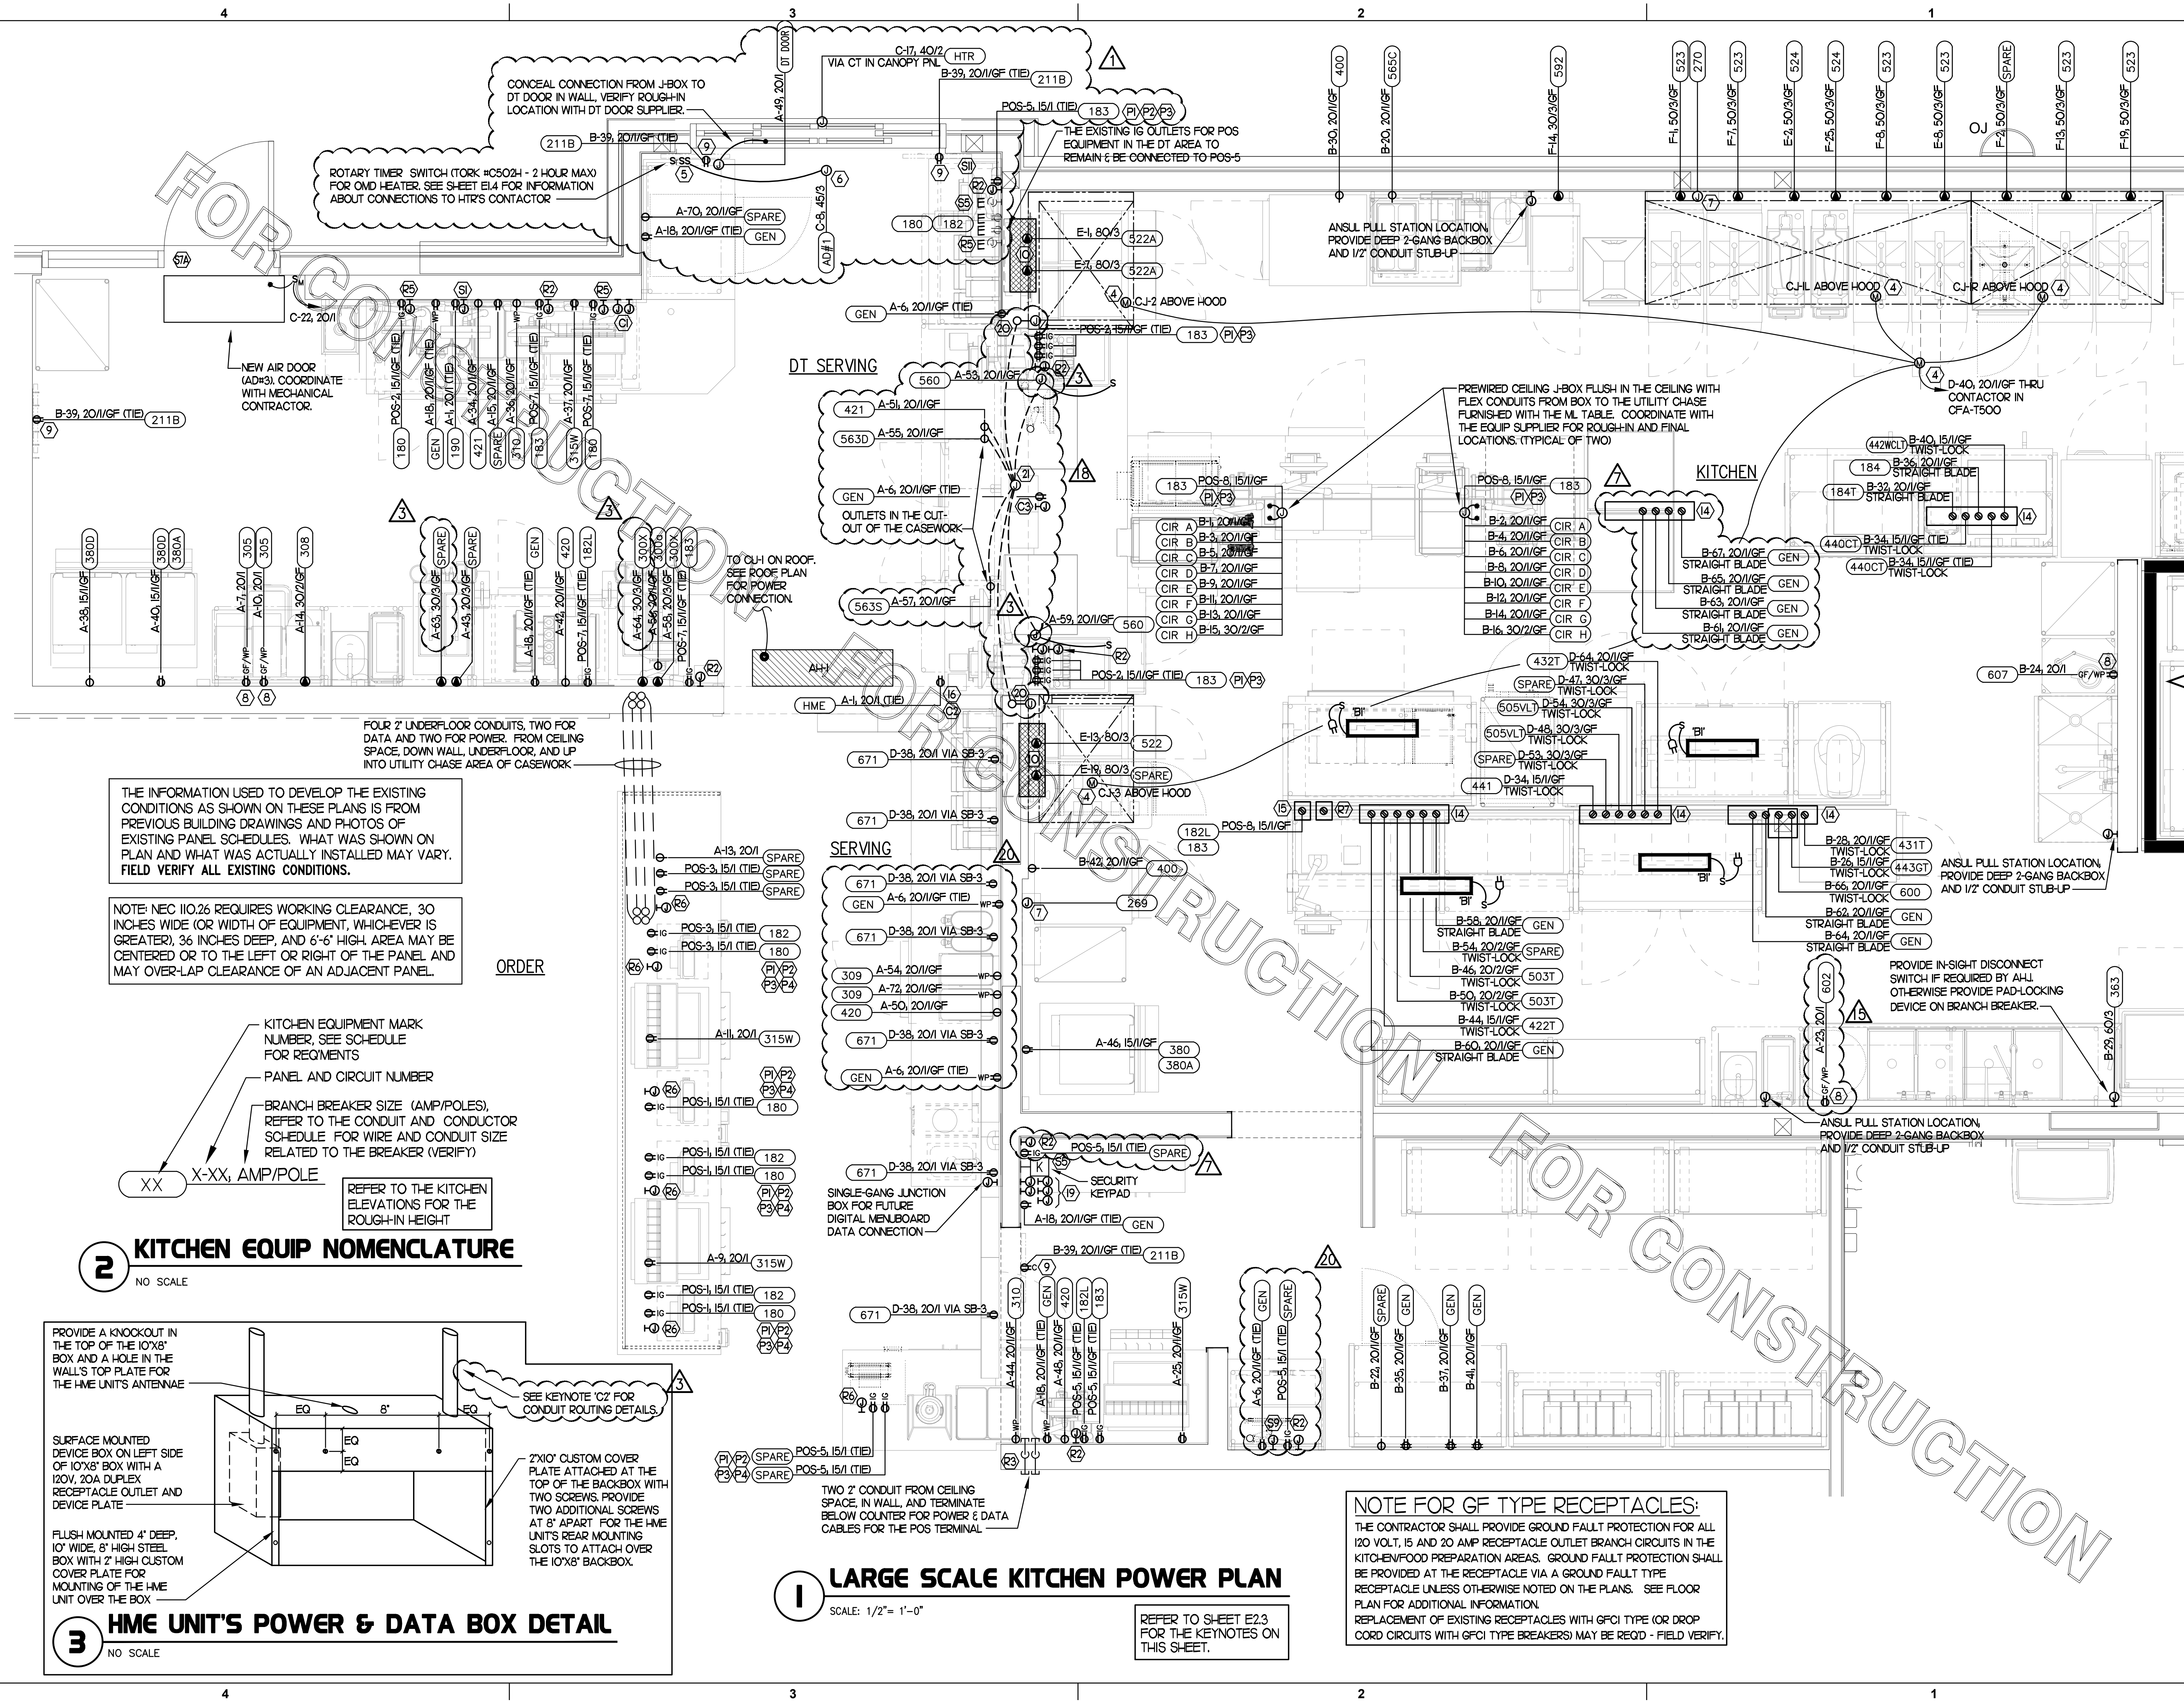

THE INFORMATION USED TO DEVELOP THE EXISTING CONDITIONS AS SHOWN ON THESE PLANS IS FROM PREVIOUS BUILDING DRAWINGS AND PHOTOS OF EXISTING PANEL SCHEDULES. WHAT WAS SHOWN ON PLAN AND WHAT WAS ACTUALLY INSTALLED MAY VARY. FIELD VERIFY ALL EXISTING CONDITIONS.

NOTE: NEC 110.26 REQUIRES WORKING CLEARANCE, 30 INCHES WIDE (OR WIDTH OF EQUIPMENT, WHICHEVER IS GREATER), 36 INCHES DEEP, AND 6'-6" HIGH. AREA MAY BE CENTERED OR TO THE LEFT OR RIGHT OF THE PANEL AND MAY OVER-LAP CLEARANCE OF AN ADJACENT PANEL.

**KITCHEN EQUIP NOMENCLATURE**

NO SCALE


XX X-XX, AMP/POLE

REFER TO THE KITCHEN ELEVATIONS FOR THE ROUGH-IN HEIGHT

KITCHEN EQUIPMENT MARK NUMBER, SEE SCHEDULE FOR REQMENTS

PANEL AND CIRCUIT NUMBER

BRANCH BREAKER SIZE (AMP/POLES), REFER TO THE CONDUIT AND CONDUCTOR SCHEDULE FOR WIRE AND CONDUIT SIZE RELATED TO THE BREAKER (VERIFY)

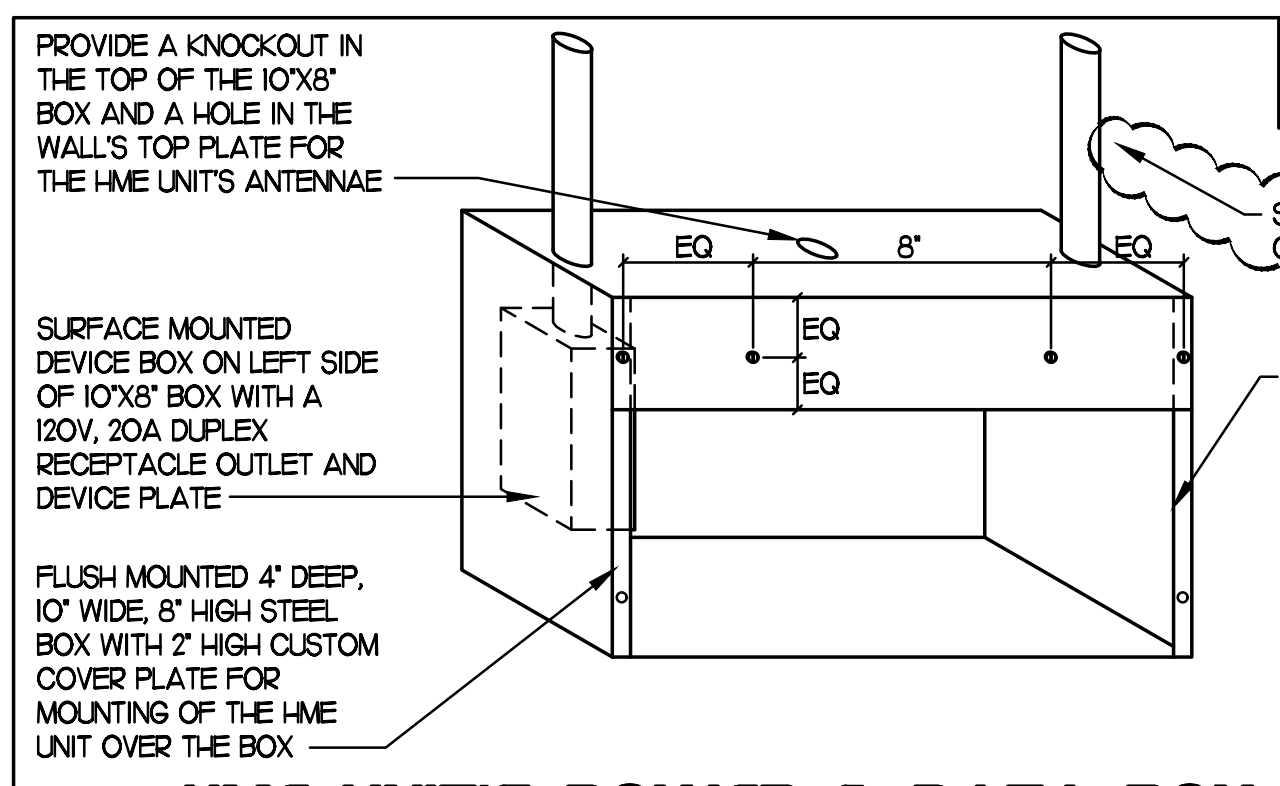

**1 LARGE SCALE KITCHEN POWER PLAN**  
SCALE: 1/2" = 1'-0"

REFER TO SHEET E2.3 FOR THE KEYNOTES ON THIS SHEET.

**NOTE FOR GF TYPE RECEPTACLES:**  
THE CONTRACTOR SHALL PROVIDE GROUND FAULT PROTECTION FOR ALL 120 VOLT, 15 AND 20 AMP RECEPTACLE OUTLET BRANCH CIRCUITS IN THE KITCHEN/FOOD PREPARATION AREAS. GROUND FAULT PROTECTION SHALL BE PROVIDED AT THE RECEPTACLE VIA A GROUND FAULT TYPE RECEPTACLE UNLESS OTHERWISE NOTED ON THE PLANS. SEE FLOOR PLAN FOR ADDITIONAL INFORMATION.  
REPLACEMENT OF EXISTING RECEPTACLES WITH GFCI TYPE (OR DROP CORD CIRCUITS WITH GFCI TYPE BREAKERS) MAY BE REQ'D - FIELD VERIFY.

ORDER


REFER TO THE KITCHEN ELEVATIONS FOR THE ROUGH-IN HEIGHT

SINGLE-GANG JUNCTION BOX FOR FUTURE DIGITAL MENUBOARD DATA CONNECTION


TWO 2" CONDUIT FROM CEILING SPACE, IN WALL, AND TERMINATE BELOW COUNTER FOR POWER & DATA CABLES FOR THE POS TERMINAL

NOTE FOR GF TYPE RECEPTACLES:  
THE CONTRACTOR SHALL PROVIDE GROUND FAULT PROTECTION FOR ALL 120 VOLT, 15 AND 20 AMP RECEPTACLE OUTLET BRANCH CIRCUITS IN THE KITCHEN/FOOD PREPARATION AREAS. GROUND FAULT PROTECTION SHALL BE PROVIDED AT THE RECEPTACLE VIA A GROUND FAULT TYPE RECEPTACLE UNLESS OTHERWISE NOTED ON THE PLANS. SEE FLOOR PLAN FOR ADDITIONAL INFORMATION.  
REPLACEMENT OF EXISTING RECEPTACLES WITH GFCI TYPE (OR DROP CORD CIRCUITS WITH GFCI TYPE BREAKERS) MAY BE REQ'D - FIELD VERIFY.

REFER TO SHEET E2.3 FOR THE KEYNOTES ON THIS SHEET.

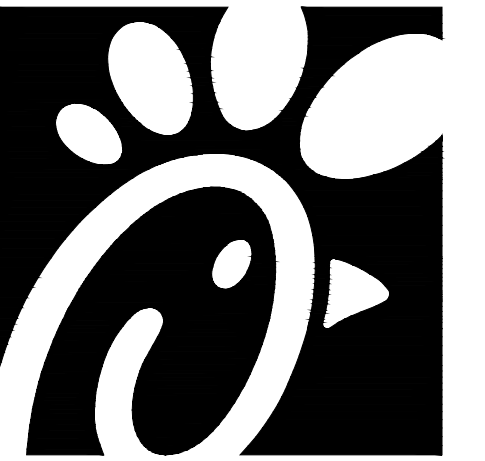

**Chick-fil-A**  
5200 Buffington Road  
Atlanta, Georgia 30349

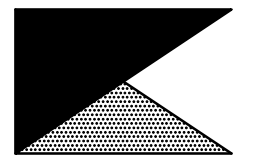

**Kurzynske & Associates**  
CONSULTING ENGINEERS  
2705 Lebanon Pike - Suite One  
Nashville, Tennessee 37214  
Telephone: (615) 255-5203



**CHICK-FIL-A**  
**DELTRAN FSU**  
1301 FAIRVIEW BLVD  
DELTRAN, NJ 08075

**FSR#01385**

BUILDING TYPE / SIZE: S97-110  
RELEASE: v05.22  
REVISION SCHEDULE  
NO. DATE DESCRIPTION

CONSULTANT PROJECT # 22146.HF.R  
PRINTED FOR CONSTRUCTION  
DATE 1/30/2023  
DRAWN BY ML

Information contained on this drawing and in all digital files produced for above named project may not be reproduced in any manner without express written or verbal consent from authorized project representatives.

SHEET LIGHTING COMCHECK

SHEET NUMBER

**E5.1**

A	B	C	D	E
Fixture ID : Description / Lamp / Wattage Per Lamp / Ballast	Lamps/ Fixture	# of Fixtures	Fixture Watt.	(C X D)
LED: A/AE: 2x4 Troffer: Other:	1	1	59	59
Total Proposed Watts =				2776

**Interior Lighting PASSES: Design 29% better than code**

**Interior Lighting Compliance Statement**  
Compliance Statement: The proposed interior lighting design represented in this document is consistent with the building plans, specifications, and other calculations submitted with this permit application. The proposed interior lighting systems have been designed to meet the 2015 IECC requirements in COMcheck Version 4.1.5.1 and to comply with any applicable mandatory requirements listed in the Inspection Checklist.

Mark Kurzynske - PE  
Name - Title \_\_\_\_\_ Signature \_\_\_\_\_ Date \_\_\_\_\_

Project Title: Chick-fil-A #1385  
Data filename: Z:\Shared\02 Prototypes\Chick-fil-A\2022\Remodels\22146.HF.R - Delran, NJ - 1385\ComCheck\CFA #1385 2015 IECC ComCheck.cck

Report date: 10/25/22  
Page 2 of 10

**COMcheck Software Version 4.1.5.1**  
**Interior Lighting Compliance Certificate**

**Project Information**  
Energy Code: 2015 IECC  
Project Title: Chick-fil-A #1385  
Project Type: Addition  
Construction Site: 1301 Fairview Blvd Delran, NJ 08075  
Owner/Agent: Chick-fil-A 5200 Buffington Road Atlanta, GA 30349  
Designer/Contractor: Kurzynske & Associates 2705 Lebanon Pike - Suite One Nashville, TN 37214 615-255-5203

**Allowed Interior Lighting Power**

A Area Category	B Floor Area (ft <sup>2</sup> )	C Allowed Watts / ft <sup>2</sup>	D Allowed Watts (B X C)
1-Kitchen (Common Space Types:Food Preparation)	1778	1.21	2151
2-Office (Common Space Types:Office - Enclosed)	61	1.11	68
3-Storage (Common Space Types:Storage)	177	0.63	112
4-Restrooms (Common Space Types:Restrooms)	211	0.98	207
5-Dining (Common Space Types:Dining Area - Family Restaurant)	1422	0.89	1266
6-Multipurpose (Common Space Types:Conference/Meeting/Multipurpose)	73	1.23	90
Total Allowed Watts =			3893

**Proposed Interior Lighting Power**

A Fixture ID : Description / Lamp / Wattage Per Lamp / Ballast	B Lamps/ Fixture	C # of Fixtures	D Fixture Watt.	E (C X D)
1-Kitchen (Common Space Types:Food Preparation)				
LED: A/AE: 2x4 Troffer: Other:	1	23	59	1366
LED: B/B: Task Light: Other:	1	4	35	140
LED: F: LED Egg Light: Other:	1	4	12	48
LED: D3/D3E: LED Downlight: Other:	1	4	21	84
2-Office (Common Space Types:Office - Enclosed)				
LED: A/AE: 2x4 Troffer: Other:	1	1	59	59
3-Storage (Common Space Types:Storage)				
LED: A/AE: 2x4 Troffer: Other:	1	2	59	119
LED: G1/G1E: LED Strip: Other:	1	2	44	88
4-Restrooms (Common Space Types:Restrooms)				
LED: D3/D3E: LED Downlight: Other:	1	5	21	106
LED: N: Vanity: Other:	1	2	11	22
5-Dining (Common Space Types:Dining Area - Family Restaurant)				
LED: D3: Downlight: Other:	1	31	21	654
LED: U: Pendant: Other:	1	4	8	30
6-Multipurpose (Common Space Types:Conference/Meeting/Multipurpose)				

Project Title: Chick-fil-A #1385  
Data filename: Z:\Shared\02 Prototypes\Chick-fil-A\2022\Remodels\22146.HF.R - Delran, NJ - 1385\ComCheck\CFA #1385 2015 IECC ComCheck.cck

Report date: 10/25/22  
Page 1 of 10

**COMcheck Software Version 4.1.5.1**  
**Exterior Lighting Compliance Certificate**

**Project Information**  
Energy Code: 2015 IECC  
Project Title: Chick-fil-A #1385  
Project Type: Addition  
Exterior Lighting Zone: 2 (Neighborhood business district)  
Construction Site: 1301 Fairview Blvd Delran, NJ 08075  
Owner/Agent: Chick-fil-A 5200 Buffington Road Atlanta, GA 30349  
Designer/Contractor: Kurzynske & Associates 2705 Lebanon Pike - Suite One Nashville, TN 37214 615-255-5203

**Allowed Exterior Lighting Power**

A Area/Surface Category	B Quantity	C Allowed Watts / Unit	D Tradable Wattage	E Allowed Watts (B X C)
Illuminated area of facade wall or surface	600 ft <sup>2</sup>	0.1	No	60
Free standing/attached sales canopy	3484 ft <sup>2</sup>	0.6	Yes	2090
Main entry	4 ft of door	20	Yes	80
Total Tradable Watts (a) =			2170	
Total Allowed Watts =			2230	
Total Allowed Supplemental Watts (b) =			600	

(a) Wattage tradeoffs are only allowed between tradable areas/surfaces.  
(b) A supplemental allowance equal to 600 watts may be applied toward compliance of both non-tradable and tradable areas/surfaces.

**Proposed Exterior Lighting Power**

A Fixture ID : Description / Lamp / Wattage Per Lamp / Ballast	B Lamps/ Fixture	C # of Fixtures	D Fixture Watt.	E (C X D)
Illuminated area of facade wall or surface (600 ft <sup>2</sup> ): Non-tradable Wattage				
LED: OJ: Wall Sconce: Other:	1	6	25	150
Free standing/attached sales canopy (3484 ft <sup>2</sup> ): Tradable Wattage				
LED: Canopy Lig: Integral Light: Other:	1	14	74	1036
Main entry (4 ft of door width): Tradable Wattage				
LED: OK: Wall Pack: Other:	1	1	13	13
Total Tradable Proposed Watts =			1049	

**Exterior Lighting PASSES: Design 61% better than code**


**Exterior Lighting Compliance Statement**  
Compliance Statement: The proposed exterior lighting design represented in this document is consistent with the building plans, specifications, and other calculations submitted with this permit application. The proposed exterior lighting systems have been designed to meet the 2015 IECC requirements in COMcheck Version 4.1.5.1 and to comply with any applicable mandatory requirements listed in the Inspection Checklist.

Project Title: Chick-fil-A #1385  
Data filename: Z:\Shared\02 Prototypes\Chick-fil-A\2022\Remodels\22146.HF.R - Delran, NJ - 1385\ComCheck\CFA #1385 2015 IECC ComCheck.cck

Report date: 10/25/22  
Page 3 of 10

FOR CONSTRUCTION



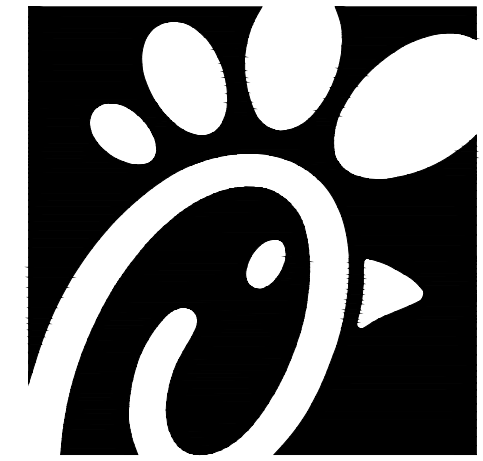

Chick-fil-A

Chick-fil-A  
5200 Buffington Road  
Atlanta, Georgia 30349



Kurzynske & Associates  
CONSULTING ENGINEERS  
2705 Lebanon Pike - Suite One  
Nashville, Tennessee 37214  
Telephone: (615) 255-5203

MARK T. KURZYNSKE  
NEW JERSEY LICENSE # GE44646  
Professional Engineer  
4-2-24

**CHICK-FIL-A**  
DELTRAN FSU  
1301 FAIRVIEW BLVD  
DELTRAN, NJ 08075

**FSR#01385**

BUILDING TYPE / SIZE: S97-110  
RELEASE: V05.22

REVISION SCHEDULE

NO.	DATE	DESCRIPTION
3	05/16/23	Construction Set
7	07/31/23	Pre-bid Comments


CONSTRUCTION

NO.	DATE	DESCRIPTION
24	04/02/24	CD Comments

CONSULTANT PROJECT # 22146.HF.R  
PRINTED FOR CONSTRUCTION  
DATE 1/30/2023  
DRAWN BY ML

Information contained on this drawing and in all digital files produced for above named project may not be reproduced in any manner without express written or verbal consent from authorized project representatives.  
SHEET ROOF POWER PLAN

SHEET NUMBER

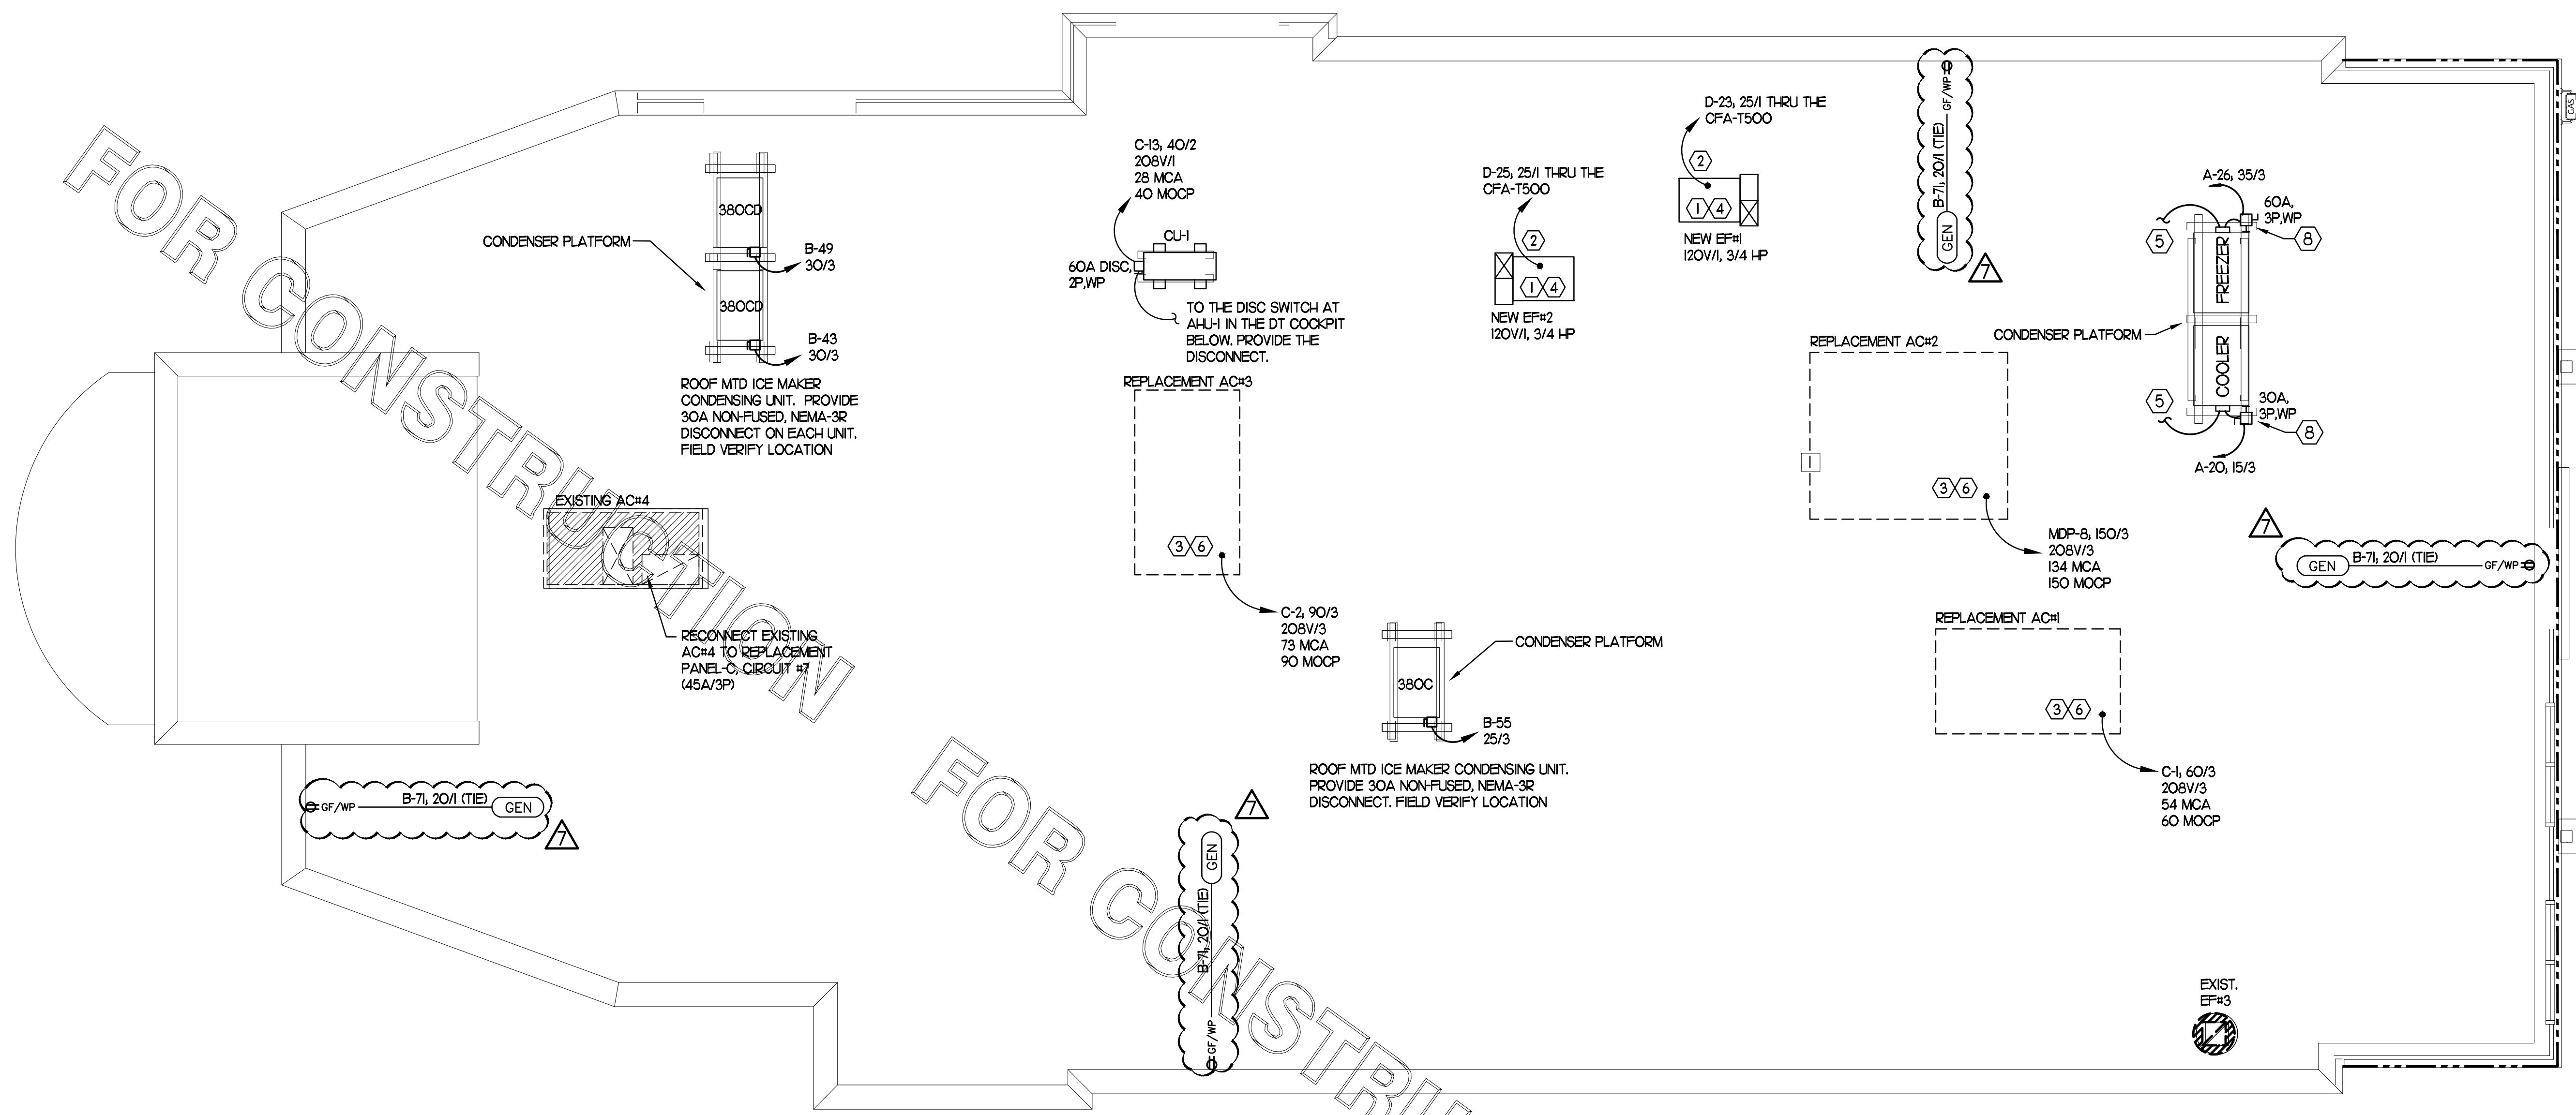


CIR D-1	CONTACTOR-1 30A 4-POLE 120 VOLT COIL (STORE SWITCH ON AND OFF)	KITCHEN LTG	SPARE	CONTACTOR-6 30A 4-POLE 120 VOLT COIL (P/CELL/TC ON & SWITCH OFF)	SPARE
CIR D-3		RESTROOM LTG	SPARE		SPARE
CIR D-5		PLAY LTG	SPARE		SPARE
CIR D-9		DINING LTG	SPARE		SPARE
CIR D-11	CONTACTOR-2 30A 4-POLE 120 VOLT COIL (STORE SWITCH ON AND OFF)	DINING LTG	SPARE	CONTACTOR-7 30A 4-POLE 120 VOLT COIL (P/CELL/TC ON & SWITCH OFF)	SPARE
CIR D-13		SERV AREA LTG	SPARE		SPARE
CIR A-76		HOT WATER RECIRC. PUMP	SPARE		SPARE
CIR D-25		DT MENUBOARDS	SPARE		SPARE
CIR D-29	CONTACTOR-3 30A 4-POLE 120 VOLT COIL (P/CELL ON AND SWITCH OFF)	BLDG. SIGNAGE	SPARE	CONTACTOR-8 30A 4-POLE 120 VOLT COIL (STORE SWITCH ON AND OFF)	SPARE
CIR D-31		BLDG. SIGNAGE	SPARE		SPARE
CIR D-33		BLDG. SIGNAGE	SPARE		SPARE
CIR D-35		BLDG. SIGNAGE	SPARE		SPARE
CIR D-8	CONTACTOR-4 30A 4-POLE 120 VOLT COIL (P/CELL ON AND SWITCH OFF)	BLDG LIGHTING	SPARE	CONTACTOR-9 30A 4-POLE 120 VOLT COIL (PHOTOCELL ON AND OFF)	SEC/FLAGPOLE LTG
CIR D-10		BLDG LIGHTING	SPARE		SPARE
CIR D-22		DIRECTIONAL SIGNS	SPARE		SPARE
SPARE		SPARE			SPARE
CIR D-16	CONTACTOR-5 30A 4-POLE 120 VOLT COIL (P/CELL ON AND SWITCH OFF)	MAIN ID SIGN	SPARE	CONTACTOR-10 30A 4-POLE 120 VOLT COIL (SWITCH ON & OFF, ANSUL ON)	EXHAUST FAN EF-1
CIR D-18		MAIN ID SIGN	SPARE		EXHAUST FAN EF-2
CIR D-20		MAIN ID SIGN	SPARE		SPARE
CIR D-6		LED BOLLARDS	SPARE		SPARE
SPARE		SPARE			SPARE
SPARE		SPARE			SPARE
SPARE		SPARE			SPARE
SPARE		SPARE			SPARE
CIR D-40	CONTACTOR-11 30A 4-POLE 120 VOLT COIL (SWITCH ON & OFF)	CAPTURE JET (CJ) FANS	SPARE		
SPARE		SPARE			
SPARE		SPARE			
SPARE		SPARE			

NOTES:  
(1) VERIFY WITH SUNCOAST ENVIRONMENTAL CONTROLS' SHOP DRAWINGS  
(2) ONLY THE 'HOT' CONDUCTOR OF EACH CIRCUIT SHALL BE RUN THRU THE CONTACTOR.  
(3) ANY TAPS OR WIRING CONNECTIONS OTHER THAN TO THE TERMINALS SHALL BE DONE IN A JUNCTION BOX OUTSIDE OF THIS CABINET.  
(4) THE STORE OPEN/CLOSED SWITCH SHALL BE IN THE DOOR OF THE CFA-T500 ALONG WITH THE CANOPY CONTROL PANEL'S MASTER ON/OFF SWITCH.

**4 CFA-T500 CONTROL PANEL CONNECTION DIAGRAM**  
NOT TO SCALE

**1 ROOF POWER PLAN**  
SCALE: 1/4" = 1'-0"

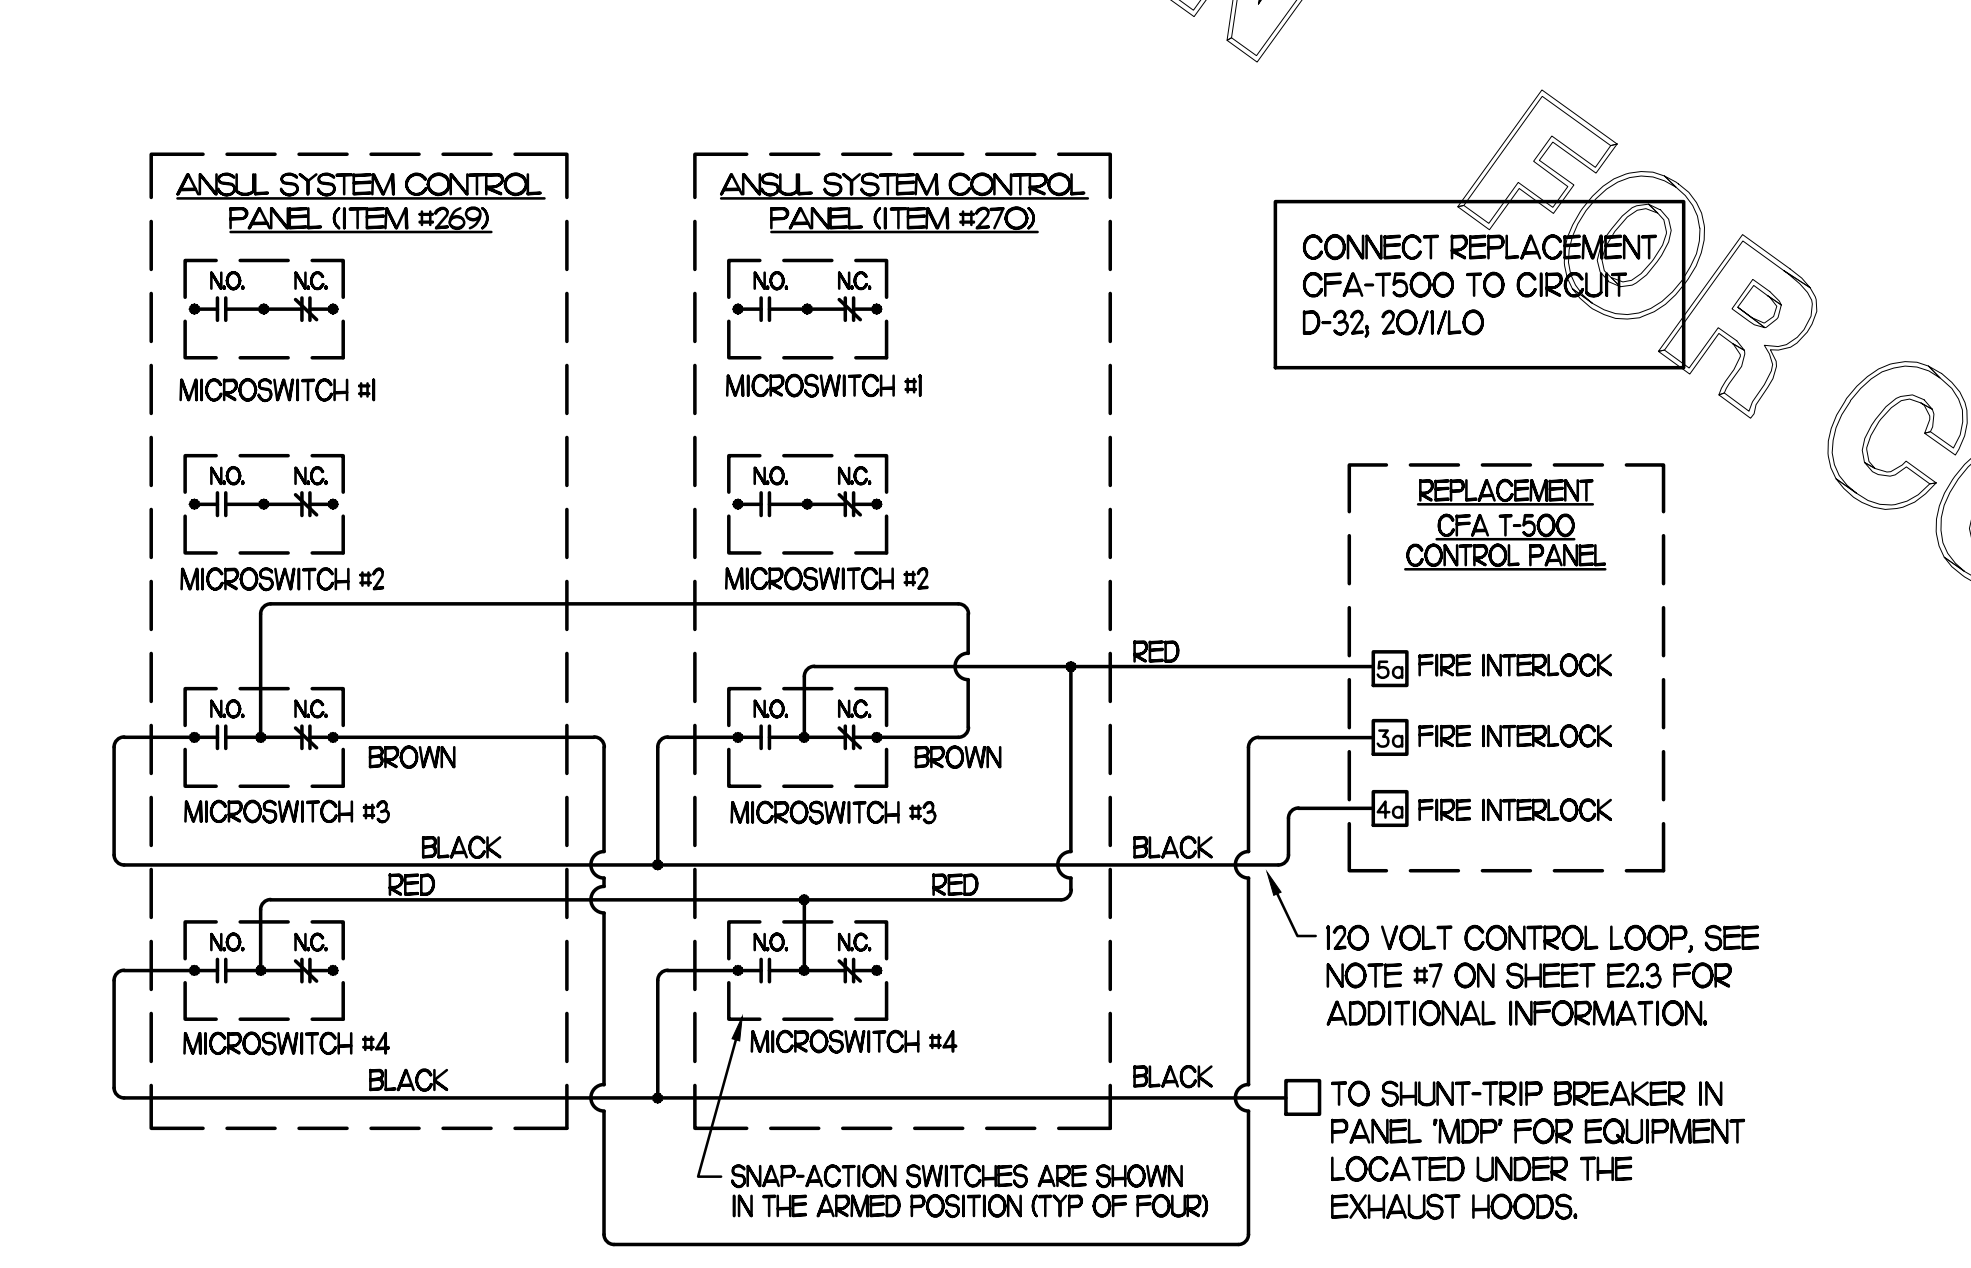


**3 ANSUL SYSTEM PANEL WIRING DIAGRAM**  
NOT TO SCALE

**2 KEYNOTES (APPLY TO THIS SHEET ONLY)**

- CONNECT EF#1, EF#2, AND EF#3 THRU THE CFA-500 CONTROL PANEL.
- COORDINATE EXACT LOCATION OF CONDUIT AND DISCONNECT AT EXHAUST FAN. CONDUIT SHALL BE INSTALLED THROUGH ROOF ON OUTSIDE OF FAN CURB. CONDUIT SHALL BE LOCATED AT FAN HINGE SUCH THAT THE FAN HOOD CAN BE FULLY HINGED OPEN AND NOT TOUCH THE CONDUIT. PROVIDE 14" DIAMETER LOOP IN THE FLEXIBLE CONDUIT BETWEEN THE ROOF AND THE FAN ELECTRICAL CONNECTION.
- A/C UNIT DISCONNECT IS FURNISHED WITH A/C UNIT AND SHALL BE CONNECTED BY THE CONTRACTOR.
- EXHAUST FAN DISCONNECT IS FURNISHED WITH THE FAN AND SHALL BE CONNECTED BY THE CONTRACTOR.
- CONNECT POWER FROM EACH CONDENSING UNITS COMPRESSOR CONTACTOR TO THE EVAPORATOR COIL UNITS JUNCTION BOX BELOW. REFER TO E23 FOR LOCATION.
- CONVENIENCE OUTLET SUPPLIED WITH UNIT. PROVIDE POWER THROUGH CIRCUIT D-38.
- CONVENIENCE OUTLET SUPPLIED WITH UNIT AND UNIT POWERED.
- MOUNT DISCONNECT SWITCHES FOR WIC AND WIF CONDENSERS ON UNISTRUT WITH CONDUIT DOWN INTO CEILING SPACE BELOW THRU ROOF PENETRATION DEVICE (NOT THRU ROOF). PROVIDE FUSE SIZE PER MANUFACTURER REQUIREMENTS.

THE INFORMATION USED TO DEVELOP THE EXISTING CONDITIONS AS SHOWN ON THESE PLANS IS FROM PREVIOUS BUILDING DRAWINGS. WHAT WAS SHOWN ON PLAN AND WHAT WAS ACTUALLY INSTALLED MAY VARY. FIELD VERIFY ALL EXISTING CONDITIONS.

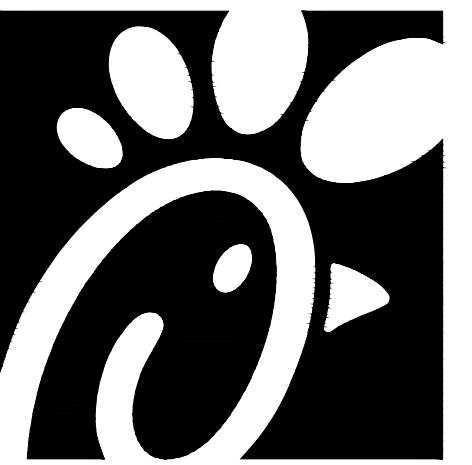

**Chick-fil-A**  
5200 Buffington Road  
Atlanta, Georgia 30349



**Kurzynske & Associates**  
CONSULTING ENGINEERS  
2705 Lebanon Pike - Suite One  
Nashville, Tennessee 37214  
Telephone: (615) 255-5203



**CHICK-FIL-A**  
**DELTRAN FSU**  
1301 FAIRVIEW BLVD  
DELTRAN, NJ 08075

**FSR#01385**

BUILDING TYPE / SIZE: S97-110  
RELEASE: v05.22

REVISION SCHEDULE		
NO.	DATE	DESCRIPTION
1	02/22/23	Owner Revision
3	05/16/23	Construction Set
11	08/20/23	Owner Changes
18	01/09/24	Design Note


CONSULTANT PROJECT # 22146.HF.R  
PRINTED FOR CONSTRUCTION  
DATE 1/30/2023  
DRAWN BY ML

Information contained on this drawing and in all digital files produced for above named project may not be reproduced in any manner without express written or verbal consent from authorized project representatives.


SHEET  
DINING POWER PLAN

SHEET NUMBER

**E2.5**

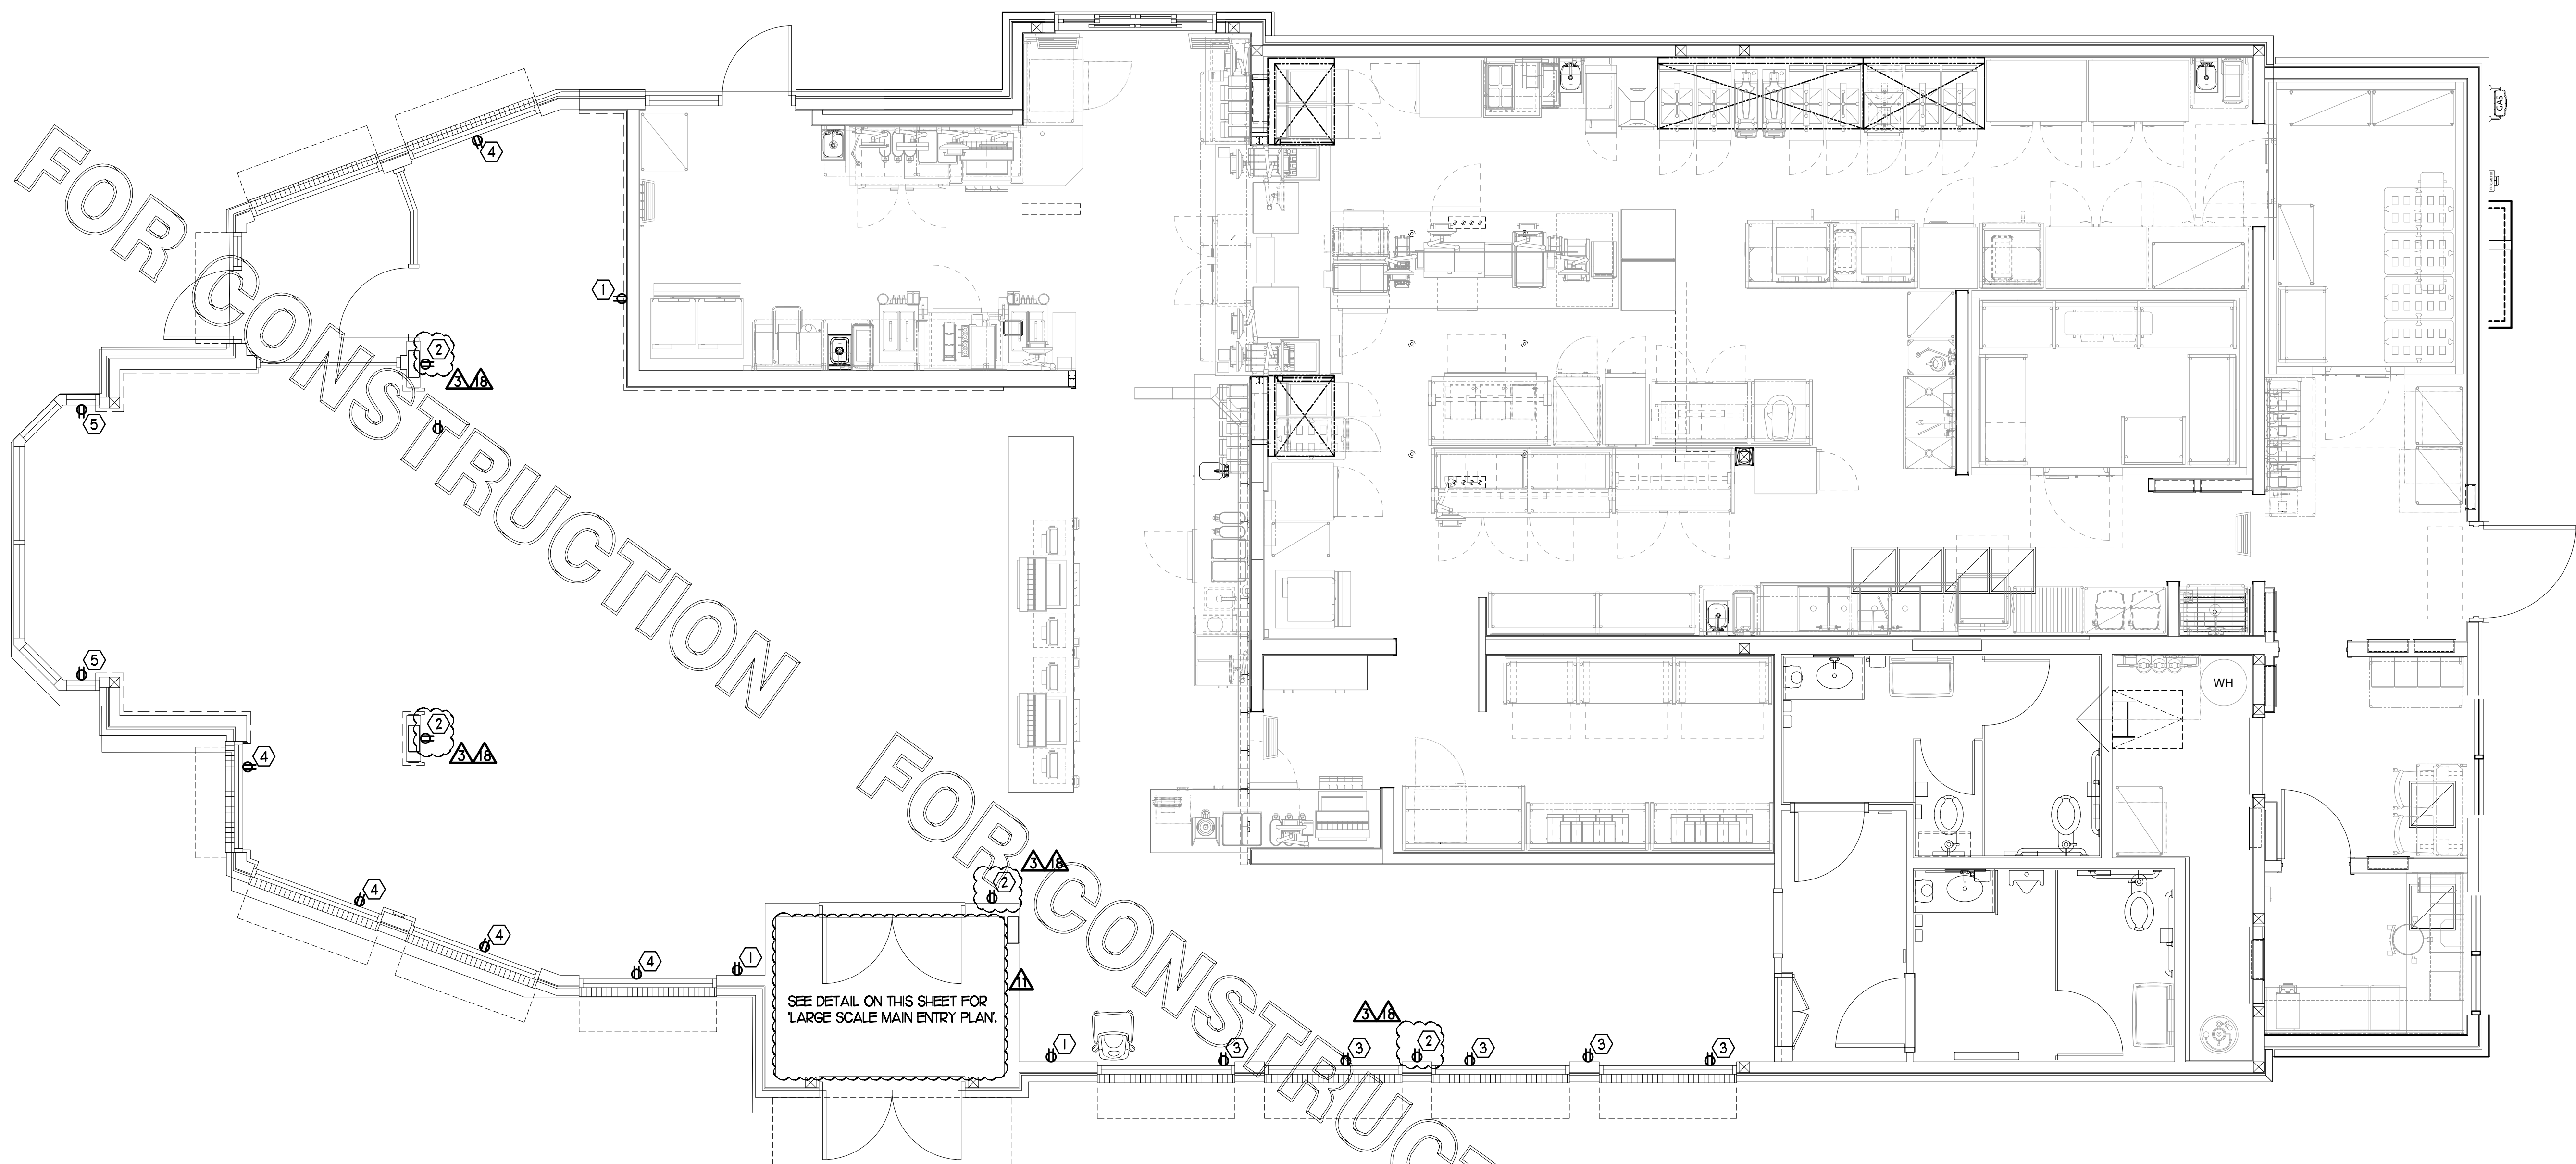

**1 DINING POWER PLAN**  
SCALE: 1/4" = 1'-0"

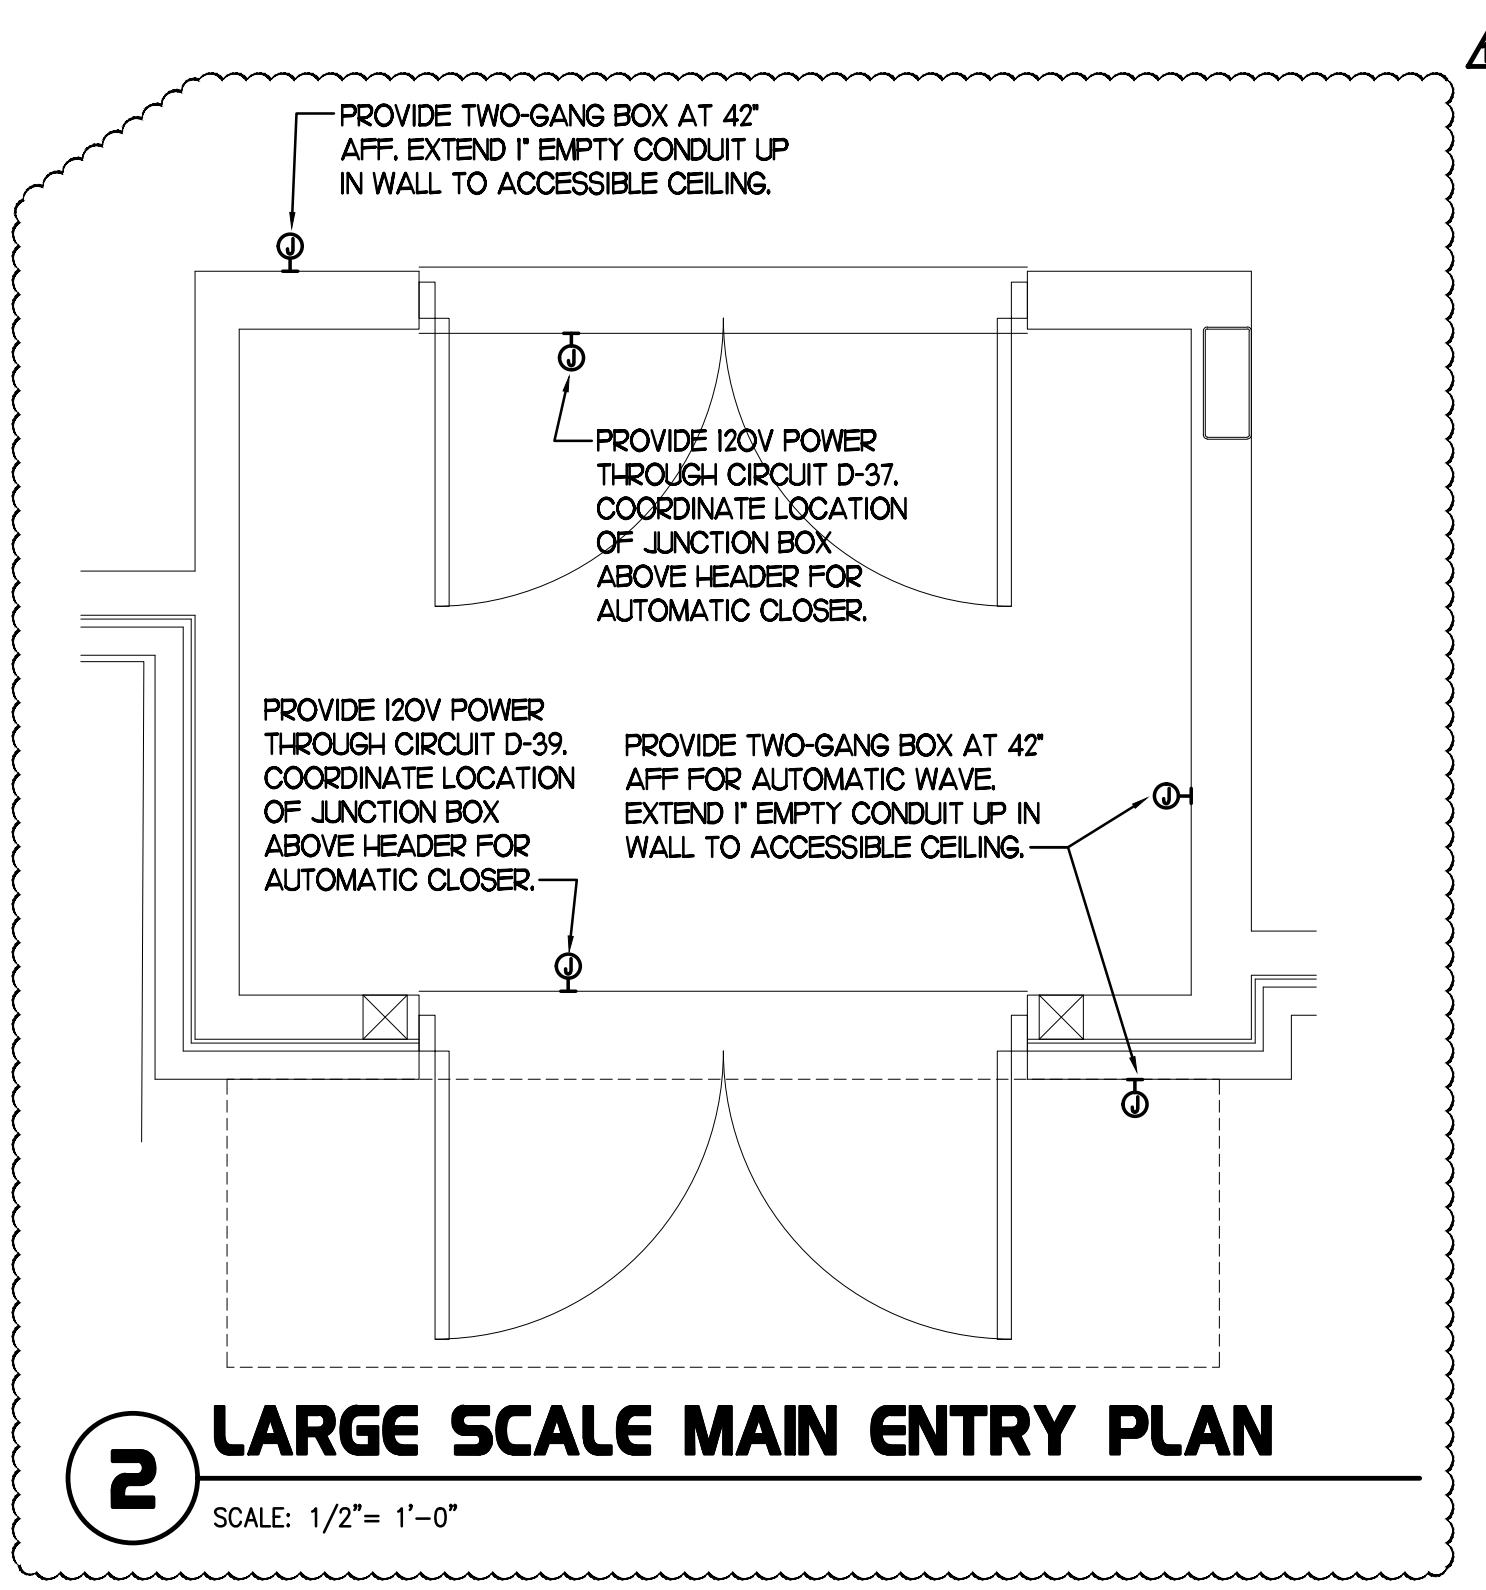

**2 LARGE SCALE MAIN ENTRY PLAN**  
SCALE: 1/2" = 1'-0"

- 3 KEYNOTES (APPLY TO THIS SHEET ONLY)**
- PROVIDE TAMPER-RESISTANT DUPLEX RECEPTACLE AT STANDARD HEIGHT FOR FUTURE COMPACTING TRASH CAN ON A DEDICATED 20 AMP CIRCUIT. USE CIRCUITS C-18, C-20, & C-22.
  - PROVIDE DUPLEX RECEPTACLE IN AN ARLINGTON #DVR23W DOUBLE-GANG RECESSED BOX FOR THE FLY SYSTEM #21C. FIELD VERIFY MOUNTING HEIGHT AND CONNECT TO CIRCUIT B-31.
  - PROVIDE 20A, 120V TAMPER-RESISTANT, USB CHARGING TYPE DUPLEX RECEPTACLE OUTLETS (ARROW-HART #TR7756-B) IN THE DINING AREA. CONNECT THE NEW DEVICES TO D-15 (20/1) UNLESS OTHERWISE NOTED. VERIFY RECEPTACLES ARE NOT CENTERED ON TABLE LEGS.
  - PROVIDE 20A, 120V TAMPER-RESISTANT, USB CHARGING TYPE DUPLEX RECEPTACLE OUTLETS (ARROW-HART #TR7756-B) IN THE DINING AREA. CONNECT THE NEW DEVICES TO D-17 (20/1) UNLESS OTHERWISE NOTED. VERIFY RECEPTACLES ARE NOT CENTERED ON TABLE LEGS.
  - PROVIDE 20A, 120V TAMPER-RESISTANT, USB CHARGING TYPE DUPLEX RECEPTACLE OUTLETS (ARROW-HART #TR7756-B) IN THE DINING AREA. CONNECT THE NEW DEVICES TO D-19 (20/1) UNLESS OTHERWISE NOTED. VERIFY RECEPTACLES ARE NOT CENTERED ON TABLE LEGS.

FOR CONSTRUCTION

FOR CONSTRUCTION

FOR CONSTRUCTION





SECTION C16100 ELECTRICAL GENERAL PROVISIONS

PART 1 - GENERAL

- 1.01 WORK INCLUDED
A. Provide all materials, labor and equipment required to furnish and install a complete electrical system as indicated on drawings and as specified herein.
1.02 REGULATORY REQUIREMENTS
A. Equipment furnished shall be UL listed where such label is available.
B. Electrical work shall be installed in accordance with drawings and specifications, NEC and NFPA codes in effect at project location, state and local electrical and building codes and special codes having jurisdiction over specific portions within complete installation.
1.03 SUBMITTALS
A. Submit list of materials and equipment prior to manufacture, order or installation and within twenty days after award of contract for approval.
B. Certified shop drawings and submittals shall bear stamp of approval of contractor as evidence that drawings have been checked.
C. If submittals show variances or substitutions from requirements of contract, contractor shall make specific mention of such variation in his letter of transmittal in order that, if acceptable, suitable action may be taken for proper adjustment.
1.04 SITE VISIT
A. Visit job site prior to bid date to determine actual conditions under which work shall be done, to familiarize oneself with project and to verify total scope of work required.

SECTION C16101 BASIC MATERIALS AND METHODS

PART 1 - GENERAL

- 1.01 COORDINATION
A. Obtain and review shop drawings, product data, and manufacturer's instructions for equipment furnished under other sections to determine connection locations and requirements.
B. Sequence rough-in of electrical connections to coordinate with installation and start-up of equipment furnished under other sections.

PART 2 - PRODUCTS

- 2.01 SUBSTITUTIONS
A. Where specifications list one or more manufacturers and do not include "or approved equal", furnish materials made by one of manufacturers listed. Where "or approved equal" is included, contractor may substitute equal products by another manufacturer subject to approval by engineer and owner.

PART 3 - EXECUTION

- 3.01 INSTALLATION
A. Make electrical connections to utilization equipment in accordance with equipment manufacturer's instructions.
B. Drawings are diagrammatic and shall not be scaled for exact sizes or locations, they are not intended to disclose absolute or unconditional knowledge of actual field conditions.
C. Protect work and materials from damage by weather, entrance of water and dirt. cap conduit during installation. Avoid damage to materials and equipment in place.
D. Satisfactorily repair or remove and replace damaged work with new materials. Deliver equipment and materials to job site in original, unopened, labeled containers. Store ferrous materials to prevent rusting. Store finished materials and equipment to prevent staining and discoloring.
E. Trenches shall be excavated 6" below elevation of bottom of conduit.
F. Failure to route conduit through building without interfering with other equipment and construction shall not constitute a reason for an extra charge. Equipment, conduit and fixtures shall fit into available spaces in building and shall not be introduced into building at such times and manner as to cause damage to structure. Equipment requiring service shall be readily accessible.

3.02 TESTING AND EQUIPMENT SERVICING

- A. Make test to ensure that entire system is in proper operating condition, and

that adjustments and apparatus setting of circuit breakers, fuses, control equipment and apparatus have been made. Correct defects discovered during tests.

3.03 REMOVAL OF DEBRIS

- A. Remove surplus materials and debris caused by, or incidental to, electrical work. Remove such debris at frequent intervals. Keep job clean during construction.

3.04 IDENTIFICATION OF EQUIPMENT

- A. Identify electrical distribution equipment, disconnects, and contactors with black laminated plastic name-plates, attached with two screws, engraved with 1/4" high, white letters.

3.05 TEMPORARY LIGHTING AND POWER IN AREAS OF CONSTRUCTION

- A. Provide, maintain and remove after construction is completed, temporary lighting adequate for workman safety and temporary power for all trades including any 3 phase power required.
B. Provide and maintain barricade lighting where required to adequately protect owner against liability for damage to public or personnel. All lamps used in barricade shall be 60 watt red, installed in weatherproof socket with wire guard. All wiring shall be approved for weatherproof installation.

3.06 GUARANTEE-WARRANTY

- A. Guarantee work to be free from defects of materials and workmanship for a period of one year from date of final acceptance of building. Repair and replace defective work and other work damaged thereby which becomes defective during term of guarantee-warranty. Furnish owner with three written copies of guarantee-warranty.

SECTION C16120 RACEWAYS AND CONDUIT SYSTEMS

PART 1 - PRODUCTS

1.01 ACCEPTABLE MANUFACTURERS

- A. Rigid IMC, and EMT conduit shall be hot-dipped, galvanized, or electro-galvanized steel by Allied, Republic, Triangle, Wheatland, or approved equal.
B. PVC conduit shall be Carlon, schedule 40, 90 degrees C. rated, unless otherwise noted.
C. MC cable shall be manufactured by AFC Cable Systems or approved equal. Type "AC-90" is not allowed. All MC Cables shall have a green equipment ground conductor and an additional isolated ground (green + yellow stripe) conductor for isolated ground circuits (POS System). Fittings used for connecting MC cable to boxes, cabinets, or other equipment shall be listed and identified for such use.
D. Associated couplings, connectors and fittings shall be steel as manufactured by Raco or equivalent. Catalog numbers used below are those of Raco.
E. Erickson Couplings, Series 1502, shall be used where neither length of conduit can be rotated.
F. Insulated bushings shall be series 1402.
G. EMT box connectors shall be compression or set-screw fittings.
H. Conduit, connectors, couplings and fittings shall be UL listed and labeled.

1.02 ELECTRICAL METALLIC TUBING (EMT)

- A. Use Electrical Metallic Tubing (EMT) where drawings call for conduit to be:
1. Concealed in walls.
2. Installed above suspended ceilings.
3. Installed exposed, above 6 feet.

1.03 INTERMEDIATE METAL CONDUIT (IMC)

- A. Use Intermediate Metal Conduit (IMC) where drawings call for conduit to be:
1. Installed for panelboard feeders.
2. Installed in wet locations (interior and exterior).
3. Installed exposed below 6 feet.

1.04 POLYVINYL CHLORIDE (PVC) RACEWAY

- A. Use PVC raceway for:
1. Underground service entrance conduits for telephone and power.
2. Exterior branch circuits installed underground.
3. Interior branch circuit conduits installed in or under concrete slab on ground floor.

1.05 RIGID STEEL CONDUIT (RSC)

- A. Use Rigid Steel Conduit for:
1. Install underground for power Service Entrance elbows penetrating floor slab.
2. Exposed to physical damage.

1.06 FLEXIBLE METAL CONDUIT

- A. Provide flexible metal conduit for termination subject to motion and vibration.
B. Length shall not exceed 6 feet in accessible ceiling areas.
C. Shall not be concealed in walls.
D. Where exposed to continuous or intermittent moisture, conduit shall be UL Type EF liquidtight or type as indicated.
E. For connection to ceiling mounted lighting fixtures from outlet boxes.

1.07 MC (METAL-CLAD) CABLE

- A. MC Cable shall be UL listed per standard 1569, color coded copper conductors (type THHN), the sheathing shall be constructed of interlocked

galvanized steel, and shall conform to the requirements of Article 330 of the National Electrical Code.

- B. MC Cable with an isolated grounding conductor shall be used, concealed above ceiling and in walls, for the connection of the Point Of Sales (POS) system equipment from the isolated ground receptacles to the panelboard serving the POS loads when allowed by local codes and Article 330 of the National Electrical Code.

- C. MC Cable may be used when allowed by local codes and Article 330 of the National Electrical Code for branch circuits (except the main homerun to the panelboard which shall be conduit with conductors) for the following:

- 1. Lighting
2. Dining area receptacles
3. Fly Lights
4. Building mounted signage
5. Office area receptacles

- D. MC Cable shall not be used for branch circuits serving Kitchen Equipment Items and similar circuits in the Kitchen, the Drive-Thru area, and the Serving area's back counter.

PART 2 - EXECUTION

2.01 INSTALLATION

- A. Minimum size of conduits shall be 1/2 inch.
B. Run concealed conduits in direct line with long sweep bends or offsets. Run exposed conduits parallel to and at right angles to building lines. Group multiple conduit runs in banks.
C. Cap ends of conduits to prevent entrance of water and other foreign material during construction.
D. Provide No. 12 AWG copper pull wires or nylon cord in all empty conduits. Steel wire not acceptable as pull wire.
E. Where IMC enters a cabinet, junction box, or pull box conductors shall be protected by an insulated bushing. Locknuts shall be installed on conduit outside and inside enclosure.
F. In areas where enclosed and gasketed fixtures and weatherproof devices are specified, where Rigid Conduit enters a sheet metal enclosure, junction box and outlet box, and not terminated in a threaded hub, a steel, or malleable iron nylon insulated hub, complete with recessed sealing "O" ring or sealing locknut shall be used.
G. Provide seal-off fitting in all conduits entering a cold temperature area such as freezers and dry refrigerators.
H. In concrete slabs, block up conduit from forms and securely fasten in place. all conduits in slabs shall have a minimum of 4" inches concrete coverage above.
I. Failure to route conduit through building without interfering with other equipment, and construction shall not constitute a reason for an extra charge. Equipment, conduit, and fixtures shall fit into available spaces in building and shall not be introduced into building at such times and manner as to cause damage to structure or equipment. Equipment requiring servicing shall be readily accessible.

SECTION C16122 OUTLET AND JUNCTION BOXES

PART 1 - GENERAL

- 1.01 PROJECT CONDITIONS
A. Verify field measurements are as shown on drawings.
B. Verify locations of floor boxes and outlets in work areas prior to rough-in.

PART 2 - PRODUCTS

- 2.01 OUTLET BOXES
A. Sheet metal outlet boxes: galvanized steel.
B. Cast boxes: type FS, cast fer alloy. Provide gasketed cover by box manufacturer.
C. Manufacturers: National, Appleton, General Electric, RACO, OR Steel City.
2.02 EMT (ELECTRICAL METALLIC TUBING) RACEWAY
A. Do not use Electrical Metallic Tubing in cinder concrete or cinder fill or where conduit system is in contact with dissimilar metals or in wet locations.
2.03 PVC RACEWAY
A. Use threaded fittings for all connectors and adapters.
E. Provide 1/4-inch nylon pull rope in all primary power and incoming telephone service entrance conduits.

2.04 FLEXIBLE METAL CONDUIT

- A. Where fittings for liquid tight flexible conduit are brought into an enclosure with a knock-out, a gasket assembly, consisting of one piece "O" ring, with Buna-N sealing material, series 3400, shall be installed on outside of box. Fittings shall be made of either steel or malleable iron only, and shall have insulated throats or insulated bushings.
B. In dry locations, where final connections to motors and other equipment may be made with Flexible Metal Conduit, fittings shall be of steel or malleable iron only with insulated throats or insulated bushings, and shall be of wedge and screw type having an angular wedge fitting between convolutions of conduit.

2.05 MC CABLE

- A. MC Cable may be used for branch circuits as noted in Part 1 above and where the local code allows use of MC Cable. The installation shall conform to Article 330 of the National Electrical Code and shall be concealed in walls and above ceilings. (Exposed MC Cable will not be acceptable.)
B. MC Cables shall be secured and supported by the building structure per the National Electrical Code and any local code requirements. MC Cable shall not lay on ceilings.

SECTION C16121 CONDUCTORS

PART 1 - PRODUCTS

- 1.01 CONDUCTORS
A. Provide 98% conductivity copper conductors with 600-volt insulation. For conductors No. 12 AWG and No. 10 AWG, provide solid type. For all conductors No. 8 AWG and larger, provide stranded type. All conductors shall have THHN/THWN insulation unless noted otherwise.

- B. Conductors shall be manufactured by Triangle, American, Rome, Southwire or approved equal.
C. Provide No. 14 AWG type THHN fixture conductors, for conductors entering lighting fixtures.
D. Branch circuit conductors shall be minimum #12 AWG, copper.

PART 2 - EXECUTION

- 2.01 INSTALLATION
A. Install pull boxes in circuits or feeders over 100 feet long.
B. Make all splices or connections only at outlet, pull or junction boxes.
C. All conductors and connections shall test free of grounds, shorts, and opens prior to energizing circuit.
D. Provide No. 10 wire in lieu of No. 12 wire for any branch circuit in excess of 100 feet linear length to prevent excessive voltage drop.
E. Use Ideal wing nuts, Scotchlok Type Y, R, G, or B, or approved equivalent connectors for fixture connections at outlet boxes.
F. Make feeder taps and joints with OZ Type T, PT, PM or PTS, or approved equivalent clamp connectors as manufactured by Kupler, or with approved compression sleeves. Wrap connectors with No. 10 Electro-Seal or approved equivalent plastic filler and vinyl tape.
G. Leave a minimum of 8" slack wire in every outlet box.
H. Provide color coded wire and with a different color for each phase and neutral and ground as follows: Phase A, B, C: Black, Red and Blue respectively; Neutral: White; Isolated Ground: Green with Yellow Stripes. Approved color tape is acceptable for feeders using larger than #6 conductors.
I. All conductors shall be continuous from origin to panel or equipment termination without splices where possible. Where splices and taps are necessary or are required, they shall be made in splice boxes with suitable connectors.
J. Tighten all electrical connectors and terminals, including screws and bolts, in accordance with manufacturer's published torque tightening values. Where manufacturer's torquing requirements are not indicated, tighten connectors and terminals to comply with tightening torques specified in UL486A and UL486B.

SECTION C16122 OUTLET AND JUNCTION BOXES

PART 1 - GENERAL

- 1.01 PROJECT CONDITIONS
A. Verify field measurements are as shown on drawings.
B. Verify locations of floor boxes and outlets in work areas prior to rough-in.

PART 2 - PRODUCTS

- 2.01 OUTLET BOXES
A. Sheet metal outlet boxes: galvanized steel.
B. Cast boxes: type FS, cast fer alloy. Provide gasketed cover by box manufacturer.
C. Manufacturers: National, Appleton, General Electric, RACO, OR Steel City.
D. Provide boxes for fixtures with fixture studs in center.

2.02 PULL AND JUNCTION BOXES

- A. Sheet metal boxes: galvanized steel.
B. Surface-mounted cast metal box: type 4; flat-flanged, surface-mounted junction box.
1. Material: galvanized cast iron.
2. Cover: furnish with ground flange, neoprene gasket, and stainless steel cover screws.
C. In-ground cast metal box: inside flanged, recessed cover box for flush mounting.
1. Material: galvanized cast iron.
2. Cover: nonskid cover with neoprene gasket and stainless steel cover screws.
3. Cover legend: electric.
D. Manufacturers: National, Appleton, General Electric, RACO, Oz-Gedney or Steel City.

PART 3 - EXECUTION

- 3.01 INSTALLATION
A. Install electrical boxes as shown on drawings, and as required for splices, taps, wire pulling, equipment connections and compliance with regulatory requirements.
B. Install pull boxes and junction boxes above accessible ceilings.
C. Inaccessible ceiling areas: Install outlet and junction boxes no more than 6

- inches from ceiling access panel or from removable recessed light fixture.
D. Use flush mounting outlet boxes in finished areas.
E. Use stamped steel bridges to fasten flush mounting outlet box between studs.
F. Install flush mounted box without damaging wall insulation or reducing its effectiveness.

PART 2 - EXECUTION

- 2.01 INSTALLATION
A. Install pull boxes in circuits or feeders over 100 feet long.
B. Make all splices or connections only at outlet, pull or junction boxes.
C. All conductors and connections shall test free of grounds, shorts, and opens prior to energizing circuit.
D. Provide No. 10 wire in lieu of No. 12 wire for any branch circuit in excess of 100 feet linear length to prevent excessive voltage drop.
E. Use Ideal wing nuts, Scotchlok Type Y, R, G, or B, or approved equivalent connectors for fixture connections at outlet boxes.
F. Make feeder taps and joints with OZ Type T, PT, PM or PTS, or approved equivalent clamp connectors as manufactured by Kupler, or with approved compression sleeves. Wrap connectors with No. 10 Electro-Seal or approved equivalent plastic filler and vinyl tape.
G. Leave a minimum of 8" slack wire in every outlet box.
H. Provide color coded wire and with a different color for each phase and neutral and ground as follows: Phase A, B, C: Black, Red and Blue respectively; Neutral: White; Isolated Ground: Green with Yellow Stripes. Approved color tape is acceptable for feeders using larger than #6 conductors.
I. All conductors shall be continuous from origin to panel or equipment termination without splices where possible. Where splices and taps are necessary or are required, they shall be made in splice boxes with suitable connectors.
J. Tighten all electrical connectors and terminals, including screws and bolts, in accordance with manufacturer's published torque tightening values. Where manufacturer's torquing requirements are not indicated, tighten connectors and terminals to comply with tightening torques specified in UL486A and UL486B.



SECTION C16123 GROUNDING AND BONDING

PART 1 - PRODUCTS

- 1.01 ROD ELECTRODES
A. Material: copper-clad steel.
B. Diameter: 3/4 inch.
C. Length: 10 feet.
1.02 MECHANICAL CONNECTORS
A. Material: bronze.
1.03 GROUNDING CONDUCTOR (WIRE)
A. Material: stranded copper, sized to meet NFPA 70, Article 250 requirements.

PART 2 - EXECUTION

- 2.01 INSTALLATION
A. Install rod electrodes at locations indicated. Install additional rod electrodes as required to achieve resistance to ground of less than 25 ohms.
B. Provide grounding electrode conductor and connect to reinforcing steel in foundation footing.
C. Provide bonding to meet regulatory requirements.
D. Bond together each metallic raceway, pipe, duct and other metal objects.
E. Provide isolated grounding conductor for circuits supplying all isolated ground outlets. Insulation shall be green with yellow stripe. Size per NEC Table 250.66. This isolated grounding conductor shall run in addition to equipment grounding conductor and along with the branch circuit conductors.
2.02 GROUNDING
A. Ground electrical system in accordance with NEC Article 250 and local authorities having jurisdiction.
B. Install a #3/0 bare copper wire bond across the water meter attached to ground clamps on water line on each side of meter. Arrangements shall be made to do this work at the time the water meter is installed.
C. From the point of entrance of the water main into the building and on the meter side of the main inside water valve and union install a stranded copper cable #3/0 in 1-1/4" conduit to the main distribution panel. Connect the cable to the equipment ground bus.
D. Install a green equipment grounding conductor in each raceway, sized per NEC Table 250-122. Terminate on equipment ground bus within panelboard serving load.
E. Install #6 awg copper grounding conductor from ground bar in main telephone box to grounded neutral bus in main distribution panel.
F. All separate grounding electrode conductors shall be bonded together to limit potential differences between them and between their associated wiring systems. This includes the power system, telephone system, etc.
2.03 FIELD QUALITY CONTROL
A. Inspect grounding and bonding system conductors and connections for tightness and proper installation.

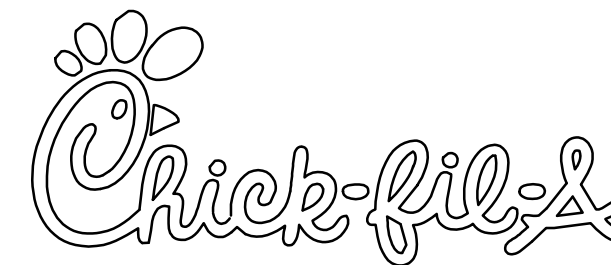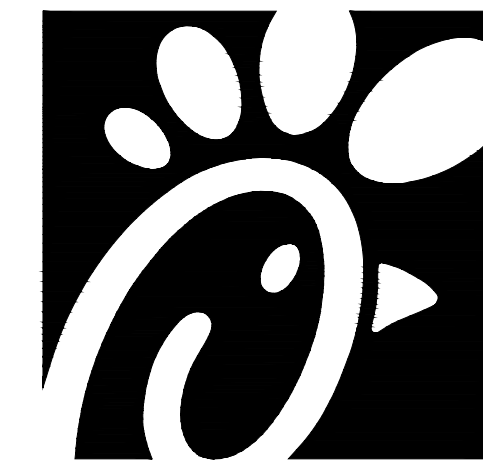

Chick-fil-A
5200 Buffington Road
Atlanta, Georgia 30349



Kurzynske & Associates
CONSULTING ENGINEERS
2705 Lebanon Pike - Suite One
Nashville, Tennessee 37214
Telephone: (615) 255-5203



CHICK-FIL-A
DELTRAN FSU
1301 FAIRVIEW BLVD
DELTRAN, NJ 08075

FSR#01385

BUILDING TYPE / SIZE: S97-110
RELEASE: V05.22
REVISION SCHEDULE
NO. DATE DESCRIPTION

CONSULTANT PROJECT # 22146.HF.R
PRINTED FOR CONSTRUCTION
DATE 1/30/2023
DRAWN BY ML

Information contained on this drawing and in all digital files produced for above named project may not be reproduced in any manner without express written or verbal consent from authorized project representatives.

SHEET ELECTRICAL SPECIFICATIONS

SHEET NUMBER

E4.1

CONSTRUCTION

SECTION C16124  
SUPPORTING DEVICES AND HANGERS

PART 1 - PRODUCTS

- 1.01 ACCEPTABLE MANUFACTURERS
- A. Supporting devices and hangers shall be manufactured by RACO Fasteners, or approved equivalent.

PART 2 - EXECUTION

- 2.01 INSTALLATION
- A. Secure conduits to within 3" of each outlet box, junction box, cabinet, fitting, etc., and at intervals not to exceed ten feet (10') and in accordance with the National Electric Code. In seismic zones, support conduits 1" and under at 6' intervals.
- B. Install clamps secured to structure for feeder and other conduits routed against the structure. Use drop rods and hangers or racks to support conduits run apart from the structure.
- C. Provide and install suitable angle iron, channel iron or steel metal framing with accessories to support or brace electrical equipment including safety switches, fixtures, panelboards, etc.
- D. Use of chains, perforated iron, baling wire, or tie wire for supporting conduit runs is not permitted.
- E. For support of low voltage wiring not required to be in conduit, bundle cables together in a neat manner using approved nylon tie wraps. Bundled cables shall be supported with "J" hooks on telephone type bridge rings, a minimum of 6 feet on centers. Clearly identify all differing types of cables being run and tag with tape tags regarding telephone, POS System, music/communication, security, etc. for various system utilizing said cable. Identification tape shall be provided at minimum intervals of 25 feet on center and within each building space.
- F. Provide a system of supporting devices and hangers to insure secure support or bracing for conduit, electrical equipment, including safety switches, fixtures, panelboards, outlet boxes, junction boxes, cabinets, etc.

SECTION C16140  
WIRING DEVICES AND PLATES

PART 1 - PRODUCTS

- 1.01 WALL SWITCHES
- a. Shall be purchased from the National Accounts Vendor indicated on the plans.
- B. Ratings: 20 amps, 120/277 volts a.c. or as identified on drawings.
- C. Devices: (Cooper/Arrow Hart catalog numbers are listed unless noted otherwise):  
1. Single pole toggle switches:  
20 AMP device - #AH1221-GY (Kitchen) or #AH1221-B (Dining)  
20 AMP Pilot lights illuminated with load on - #AH1221-PL  
2. Double pole toggle switches:  
20 AMP device - #AH1222-GY (Kitchen) or #AH1222-B (Dining)
- 1.02 RECEPTACLES
- A. Shall be purchased from the National Accounts Vendor indicated on the plans.
- B. Devices: (Cooper/Arrow Hart catalog numbers are listed unless otherwise noted):  
1. Specification grade devices (grey device color in Kitchen, brown device color in Dining, and orange for IG type) to be 20 amp, 125 volts, a.c. receptacles:  
Single (simplex) device: #1877-GY (Kitchen) or #1877-B (Dining)  
Duplex device: #CR20-GY (Kitchen) or #CR20-B (Dining)  
Tampor Resistant duplex: #TRCR20-B (Vestibules & Play Area)  
Tampor Resistant USB Charger duplex: #TR7756-B (Dining)  
GF (ground-fault circuit interrupter) duplex device: #VGF20-GY (Kitchen) or #VGF20-B (Dining)  
IG (isolated ground) duplex device: #IG5362-RN (orange face)

1.03 SPECIAL DEVICES

- A. Manual motor starter switch: SQ. D Class 2510, Type F, for use on motors up to 3/4 horsepower. Provide NEMA 1 enclosure in dry locations; provide NEMA 3R enclosure in wet or exterior locations.

1.04 WALL PLATES

- A. Provide Cooper/Arrow Hart, or approved equal, smooth satin stainless steel 302-SS series for switches and receptacles in the Kitchen areas. All other areas shall be brown Nylon plastic.
- B. Provide blank plates on all outlet boxes for future outlets, or outlets without devices. Plate style shall match device plates.
- C. Provide non-metallic weatherproof covers for duplex GF receptacles located outside or in wet locations that feature 'while-in-use' cover equivalent to Arrow Hart #WIU-1.
- D. Where devices installed in exposed boxes or conduit fittings; provide properly designed plates and covers equal to Arrow Hart RS-Series exposed work covers.
- E. Install galvanized steel plates on outlet boxes and junction boxes in unfinished areas, above accessible ceilings, and on surface mounted boxes.

PART 2 - EXECUTION

2.01 INSTALLATION

- A. Mounting
  1. Mount switches and receptacles at height above finished floor as indicated on plans, and legend.
  2. Mount switches on strike side of door maximum 8" from door frame. Outlet box for switch shall be located clear of door frame. Coordinate with architectural plans prior to rough-in.
  3. Install switches with off position down.
  4. Do not use the feed thru feature for the GF Type receptacle, unless required by the plans.
  5. Use jumbo sized plates for outlets installed in masonry walls.
  6. Each receptacle shall be provided with a #12 green grounding jumper between the ground terminal of the receptacle and the outlet box.
  7. The grounding conductor to each receptacle shall be installed such that the removal of the device will not interfere with the continuity of the ground.
- B. Testing
  1. Test each switch and verify proper operation with energized circuit.
  2. Test each receptacle for proper polarity on energized circuit.
  3. Test each GF receptacle with a GF receptacle tester and verify circuit is opened by GF device at milli-ampere ranges established by the manufacturer.

SECTION C16440  
PANELBOARDS

PART 1 - PRODUCTS

- 1.01 MANUFACTURER (via Chick-fil-A National Accounts Program) as indicated in Panelboard Schedules:
  - A. Square-D (Atlantic and Southeast Regions): from Accu-Serv, Bob Harpring (502)961-0096.
  - B. Square-D (West, Southwest, Midwest, and Northeast Regions): from Villa Lighting, Dave Christanell (800)325-0963.
  - C. Siemens: from Suncoast Environmental Controls (SEC), Scott Dyer (877)544-6679.
- 1.02 PANELBOARD FEATURES
- A. Panelboards shall have a minimum symmetrical interrupting rating to meet or exceed the available symmetrical interrupting fault current at the device intended to interrupt current.
- B. Bus bars shall be copper or tin plated aluminum.
- C. Provide factory-installed copper ground bus in each panelboard with lugs or connectors on bar.
- D. Provide electrically isolated, factory installed, neutral bus in each 3 phase, 4 wire or 1 phase 3 wire panelboard.
- E. In addition to the ground bus required by paragraph 1.02D (above), provide factory installed, electrically isolated, copper ground bus in each panelboard serving isolated ground receptacles.
- F. Main lugs and main circuit breaker lugs shall be UL Listed for use with both aluminum and copper conductors.
- G. Provide panelboard doors with chrome-plated locks and catches. All locks shall be keyed alike. Provide two keys for each lock.
- H. Provide thermal-magnetic circuit breakers which are rated for 40 degrees C ambient temperature. Breakers shall be quick-make, quick-break type trip with trip indication shown by handle position other than on or off. Multi-pole breakers shall have a common trip handle. Tandem type circuit breakers shall not be permitted.
- I. Provide typed directory card with clear holder for each panelboard.

PART 2 - EXECUTION

- 2.01 INSTALLATION
- A. Panelboards shall be mounted at height above finished floor such that the height of the top-most breaker in the panel is not more than 6-1/2 feet above finished floor in its highest position per the NEC.
- B. Where multiple panelboards are installed on walls in common areas of buildings, the panelboards shall be installed with the top of all panelboards at the same height.
- C. Provide blank filler plates over all unused spaces in panelboards.
- D. A typed directory card shall indicate devices being served and the space name where the device is located.
- E. Provide minimum of one (1) 3/4" empty spare conduit for every 3 poles of spare breaker or space in the panelboard. Stub conduit to nearest accessible ceiling space. Label conduit as spare at panelboard and termination point.
- F. Non-isolated ground bars shall be grounded to panelboard can and main service entrance ground bus with a code sized grounding conductor installed in the same conduit as the phase and neutral conductors.
- G. Circuits using a common neutral shall be installed in accordance with the National Electrical Code.
- H. Inspect each panelboard for proper installation, physical damage, tightness and installation of overcurrent devices. Verify proper color coding of conductors. Correct or repair all items found in inspection.
- I. Neutral wires, ground wires, and isolated ground wires shall be connected to the appropriate panel bus bar. Do not mix bus wire connections.

SECTION C16441  
ENCLOSED SWITCHES

PART 1 - PRODUCTS

- 1.01 MANUFACTURERS
- A. Square D.
- B. General Electric.
- C. Siemens
- 1.02 ENCLOSED SWITCHES
- A. Nonfusable switch assemblies: NEMA KS 1, General Duty Type for 208 volt load interrupter enclosed knife switch with externally operable handle interlocked to prevent opening front cover with switch in on position. Handle lockable in off position. Provide equipment ground lug in each switch.
- B. Enclosures: NEMA KS 1.
  1. Interior dry locations: Type 1.
  2. Exterior locations: Type 3R.

SECTION C16442  
UTILITY SERVICE ENTRANCE AND DISTRIBUTION SYSTEM

PART 1 - GENERAL

- 1.01 SYSTEM DESCRIPTION
- A. The underground electrical system service characteristics shall be 208Y/120 volts, Three Phase, Four Wire service and shall extend from utility company transformer secondary.
- B. Metering of electrical usage shall be located as required by local electrical utility company. Coordinate requirements with local utility company.
- C. Distribution system originates at secondary of utility transformer and includes service entrance conduit and conductors, distribution equipment, lighting panelboards, utilization equipment, overcurrent devices, disconnecting means, controls, branch and feeder circuits, etc.

PART 2 - PRODUCTS

- 2.01 MATERIALS
- A. Furnish service entrance conduit, cable, and miscellaneous hardware as required by plans and specifications for electrical service entrance and system grounding at main electrical service.
- 3.01 EXAMINATION AND PREPARATION
- A. Coordinate exact locations of electrical service utility transformer, metering equipment, service lateral, etc. prior to commencement of installation. Contact engineer with conflicts prior to bid.
- B. Ensure pad mounted transformer is not located within roadway or sidewalk.
- C. Coordinate with local electrical utility for all utility company requirements and provide for the following items and any others required by the utility:
  1. Concrete pad for utility transformer with required dimensions and details.
  2. Primary underground conduit, excavation, and backfill requirements.
  3. Pay for all fees associated with establishment of electrical service.
  4. Furnish list of loads to the electrical utility company serving the facility.
  5. Verify that utility company clearances are provided on all sides of utility equipment.
- D. Ensure proper access to utility equipment is maintained.
- E. Provide pull rope, excavation in accordance with electrical utility company requirements, backfill and concrete envelope for primary in accordance with electrical utility company requirements. Turn conduits up riser pole as required, cap spare conduits 12 inches above grade with plumbers pipe cap.
- F. Provide secondary lugs on utility transformer and perform drilling and installation of lugs in accordance with utility requirements. Type of lugs shall be in accordance with electrical utility company requirements. Connect service conductor to transformer secondary lugs as directed by electrical utility.

SECTION C16500  
LIGHTING FIXTURES (LUMINAIRES)

PART 1 - GENERAL

- 1.01 ACCEPTABLE MANUFACTURERS AND VENDORS
- A. Lighting fixtures indicated on lighting fixture schedule are to be purchased from the National Account Vendor for the region of the project (verify region designation with Owner's Representative):
  1. Accu-Serv Lighting - Atlantic region and Southeast region. Contact at Accu-Serv: Bob Harpring at 877-707-7378, fax - 502-961-0357, email - bharpring@accu-serv.com
  2. Villa Lighting - Midwest region, Northeast region, Southwest region, and West region. Contact at Villa Lighting: Dave Christanell at 800-325-0963, fax - 314-531-8720, email - dave.christanell@villalighting.com
- B. Ballasts to be electronic ballast provided with lighting fixture by the manufacturer.
- C. Lamps to be Osram-Sylvania and will typically be provided with the luminaire by the lighting manufacturer.
- 1.02 FIXTURE REQUIREMENTS

- A. Provide regulating, HPF ballasts in all HID lighting fixtures. HID lamp types shall be as indicated on the drawings.
- B. Recessed fluorescent lighting fixture ballasts shall be provided with integral thermal protection. C. Provide energy-saving Instant or Rapid Start lamps for all fluorescent fixtures.
- D. All lamps and ballasts shall meet or exceed the requirements of the National Energy Policy Act of 1992 and any other applicable Codes or Criteria.
- E. All components of recessed fixtures shall be accessible without disturbing fixture in or on ceiling.
- F. Energy saving ballasts and energy saving lamps provided shall be compatible for operation together.
- G. Exterior fixtures and poles shall be suitable for exterior use, shall be UL Listed, and shall be a standard design for exterior application.
- H. Exterior poles for fixtures with luminaires installed shall be designed for maximum constant velocity wind load with luminaires installed, applicable to the geographic area.
- 1.03 CONTROLS
- A. Lighting contactors shall be Square-D, General Electric, Cutler-Hammer or Siemens of types and quantity shown on drawings, except those furnished with the switchgear as part of the National Account Program by Suncoast Environmental Controls (SEC).
- 1.04 EMERGENCY LIGHTING UNITS
- A. BATTERIES shall supply emergency power for lighting with minimum operating time of 1-1/2 hours.
- B. Emergency lighting shall be automatically operational upon normal utility power failure.

PART 3 - EXECUTION

- 3.01 INSTALLATION
- A. Lighting fixtures shall be structurally supported. Fluorescent fixtures mounted in suspended ceilings shall be supported by and attached to ceiling system as required by NEC Article 410. In addition, fluorescent troffers shall be supported at two opposite corners to building structure.
- B. Recessed fixtures in dropped ceiling areas shall be connected to power source using flexible conduit. Flexible conduit shall contain a separate insulated green No. 12 copper ground wire. Flexible conduit shall be connected to junction box and fixture. Green ground wire shall provide ground continuity between conduit system and fixture. Grounding conductors shall be permanently and mechanically connected between fixture and conduit system so as to be electrically continuous.
- C. Fixtures surface mounted on exposed tee bar ceilings shall use grip clamps on tee bars to support fixtures.
- D. Wire shall be continuous from splice in outlet box of building wiring system to lamp socket or ballast terminals.
- E. Maintain the integrity of enclosures on enclosed and gasketed fixtures. Minimize the number of enclosure penetrations and make such penetrations water and dust tight with appropriate gaskets and fittings.
- F. Concrete bases shall be provided for all exterior ground mounted or pole mounted fixtures.
- G. Install accessories furnished with each fixture.
- H. Wiring from pole bases to pole mounted luminaire shall be No. 12 with fuse protection provided by a 30 amp, 600 volt waterproof fuseholder with Bussman "Limiter" fuse of ampere rating 3 times the load current.
- I. Surface and recessed fixtures on or in plastered or drywall ceilings shall be supported by support channels. Support channels shall span across main support channels and shall not depend upon ceilings for support.
- 3.02 FIELD QUALITY CONTROL
- A. Relamp fixtures that have failed lamps at substantial completion.

SECTION C16596  
SPECIAL SYSTEMS

PART 1 - GENERAL

- 1.01 WORK INCLUDED
- A. Furnish and install raceway system for music/communications security, CCTV, POS, and other owner-furnished systems, consisting of empty conduits, junction boxes, outlet boxes, and device plates, etc., as specified and shown on owner selected vendor wiring schematics. Cable, equipment, and installation of the interior system will be provided by the owner's system vendor.
- B. Interior system equipment will be furnished by Owner's Vendor.
- C. Install special backboxes furnished by Owner's Vendor. Coordinate with the Vendor for the installation. Coordinate with the Vendor if backboxes are to be contractor provided in order to provide and install the appropriate item for the Vendor.

PART 2 - PRODUCTS

- 2.01 MATERIALS
- A. Provide 4-11/16" square boxes, with plaster rings. Provide device plates for system outlets as specified in Section 16141. Provide separate conduit to nearest accessible ceiling space from each outlet.

- B. Cable shall be in conduit where installed in walls or inaccessible ceilings.
- C. Minimum conduit size shall be 3/4" .
- PART 3 - EXECUTION
- 3.01 INSTALLATION
- A. Furnish and install conduits, junction boxes, outlet boxes, and plates.
- B. Provide one #10 equivalent nylon pull wire in each system empty conduit.
- C. Provide a complete raceway system in accordance with interior system vendor requirements. Interior system vendor shall review the drawings. Contractor shall provide for any additional or varying requirements.
- D. Final connections and testing of systems will be provided by the system vendor. Contractor shall contact the owner's vendor and schedule the work so as to complete system installation and testing prior to occupancy of the facility.
- E. Terminate each conduit stub-up or termination with nylon insulated bushing.

SECTION C16597  
TELEPHONE SERVICE

PART 1 - GENERAL

- 1.01 WORK INCLUDED
- A. Furnish and install telephone system consisting of empty conduits, junction boxes, outlet boxes, device plates, etc., as specified and shown on owner selected vendor wiring schematics. Cable, equipment, and installation of the interior system will be provided by the owner's system vendor.
- B. Provide underground PVC, Schedule 40, service conduit as required by plans.
- C. Telephone Utility Company will provide service entrance cable.
- D. Interior telephone system will be furnished by owner's vendor.
- E. Special backboxes (unless otherwise noted) and faceplates will be furnished by the owner's vendor.

PART 2 - PRODUCTS

- 2.01 MATERIALS
- A. Provide 4-11/16" square boxes, with plaster rings. Provide device plates for telephone outlets to match those specified in wiring device section. Provide separate conduit to nearest accessible ceiling space from each outlet.
- B. Minimum conduit size shall be 3/4" .
- C. Provide lightning arrester for telephone service entrance at main telephone backboard in accordance with UL96A paragraph 11.2 and NFPA 780.
- D. Cable shall be in conduit where installed in walls or above inaccessible ceiling spaces.

PART 3 - EXECUTION


- 3.01 INSTALLATION
- A. Provide one #10 equivalent nylon pull wire in each empty telephone conduit.
- B. Provide trenching, backfilling, etc., for installation of service entrance conduit in accordance with other divisions, plans, and telephone utility requirements. Provide pull wire in empty conduit.
- C. Coordinate with the local utility for point of service and type of service required. Pay for any utility company charges and fees for establishment of service.
- D. Provide a complete raceway system in accordance with telephone utility company and interior system vendor/utility requirements. Telephone utility company and interior system vendor shall review the drawings. Contractor shall provide for any additional or varying requirements.
- E. Terminate each conduit stub-up or termination with nylon insulated bushings.
- F. Final connections and testing of system will be provided by the system vendor. Contractor shall contact the owner and vendor and schedule the work.

CLOSE OUT DOCUMENT REQUIREMENTS

- Provide the following to the building owner upon completion of construction:
  1. Submittal data stating equipment rating and selected options for each piece of equipment requiring maintenance.
  2. Operation manuals and maintenance manuals for each piece of equipment requiring maintenance. Required routine maintenance actions shall be clearly identified.
  3. Names and addresses of at least one qualified service agency.
  4. A complete narrative of how each system is intended to operate.



Chick-fil-A  
5200 Buffington Road  
Atlanta, Georgia 30349

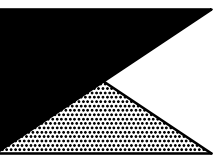

Kurzynske & Associates  
CONSULTING ENGINEERS  
2705 Lebanon Pike - Suite One  
Nashville, Tennessee 37214  
Telephone: (615) 255-5203



CHICK-FIL-A  
DELTRAN FSU  
1301 FAIRVIEW BLVD  
DELTRAN, NJ 08075

FSR#01385

BUILDING TYPE / SIZE: S97-110  
RELEASE: V05.22  
REVISION SCHEDULE  
NO. DATE DESCRIPTION

CONSULTANT PROJECT # 22146.HF.R  
PRINTED FOR CONSTRUCTION  
DATE 1/30/2023  
DRAWN BY ML

Information contained on this drawing and in all digital files produced for above named project may not be reproduced in any manner without express written or verbal consent from authorized project representatives.

SHEET ELECTRICAL SPECIFICATIONS

SHEET NUMBER

E4.2

CONSTRUCTION