

GENERAL NOTES:

1. ALL DUCT ELEVATIONS ARE CONSIDERED FROM SHEET METAL.
2. ALL DUCT ELEVATIONS ARE INDICATED FROM GROUND FLOOR.
3. SOME OF THE LOW WALL RETURN DUCTWORK FABRICATED AS S&D TO FIT WITHIN WALL CAVITY.

CODED NOTES:

1. EXISTING FIRE PROTECTION PIPING IN THIS LOCATION INTENDED TO BE REWORKED.
2. EXISTING PLUMBING IN THIS LOCATION INTENDED TO BE REWORKED.
3. SMALL RECTANGULAR DUCT NEEDED AT THIS LOCATION DUE TO LIMITED SPACE.

BY	DATE	DESCRIPTION OF REVISION

PROJECT: **UCMC PHASE 2 PHARMACY RELOCATION**
3188 BELLEVUE AVENUE
CINCINNATI, OH 45219-2316







SHEET TITLE: **PARTIAL GROUND FLOOR PLAN - NEW WORK SHOP DRAWING**

DRAWN BY: **TB**

CINFAB JOB #: **24123947**



FULL SHEET SIZE: **34X45.5**

SM-F-G.2

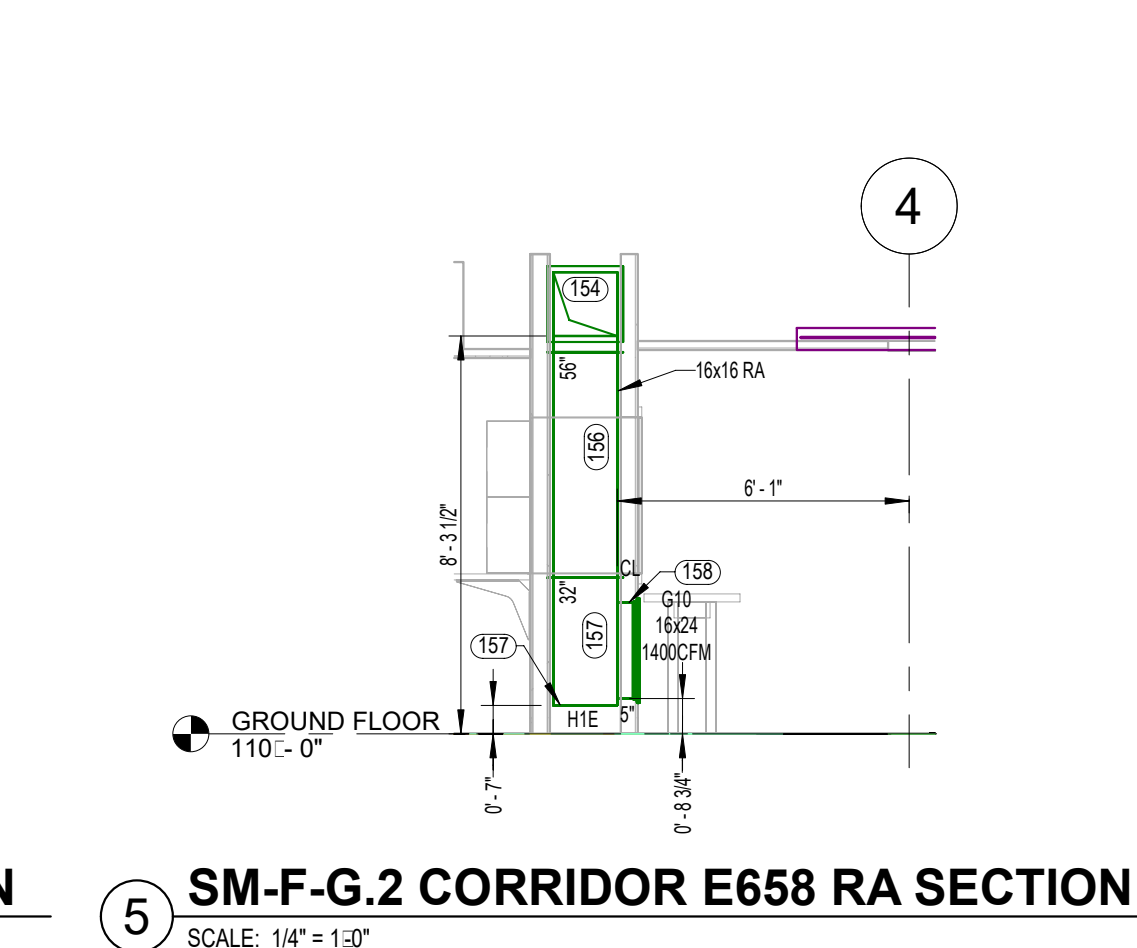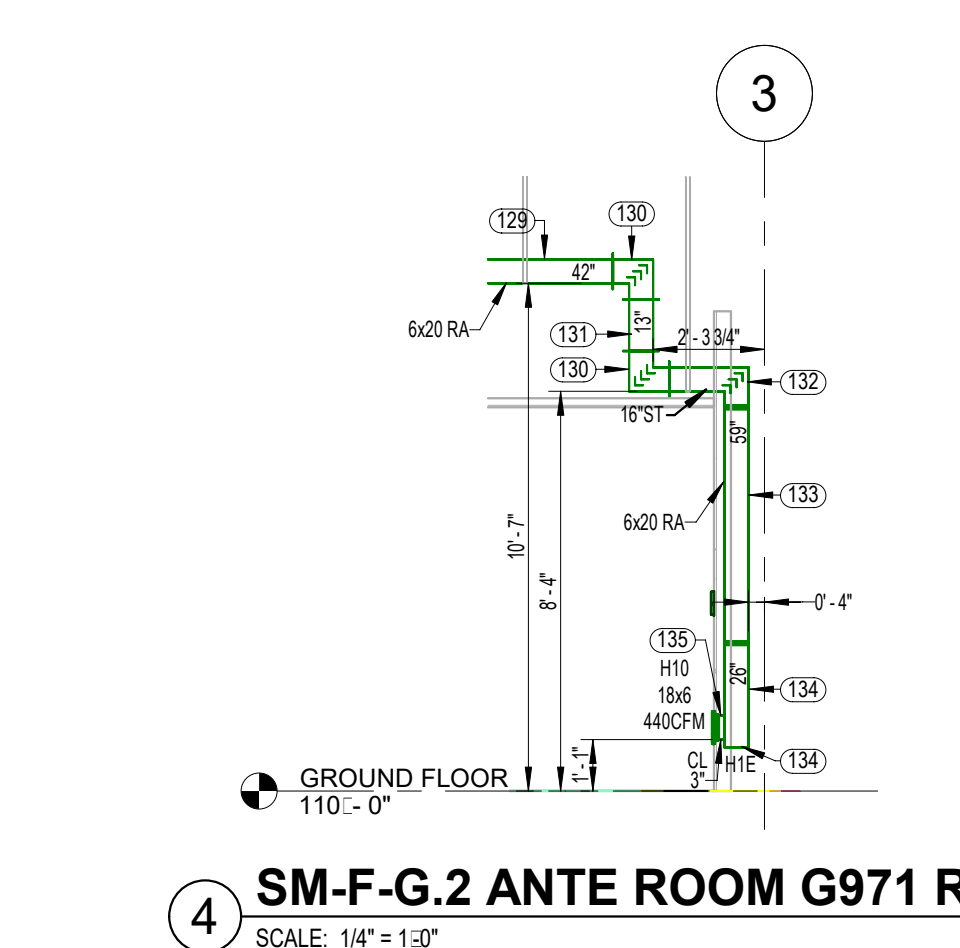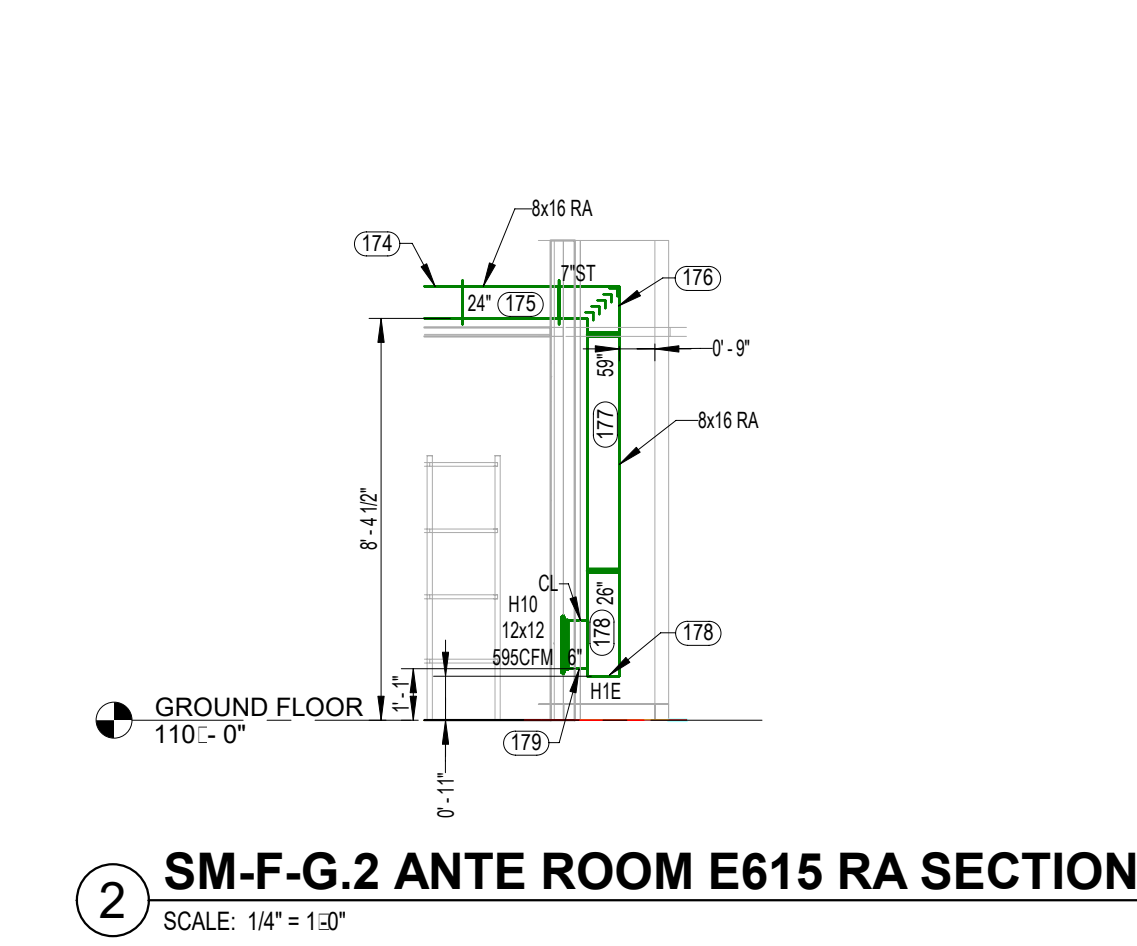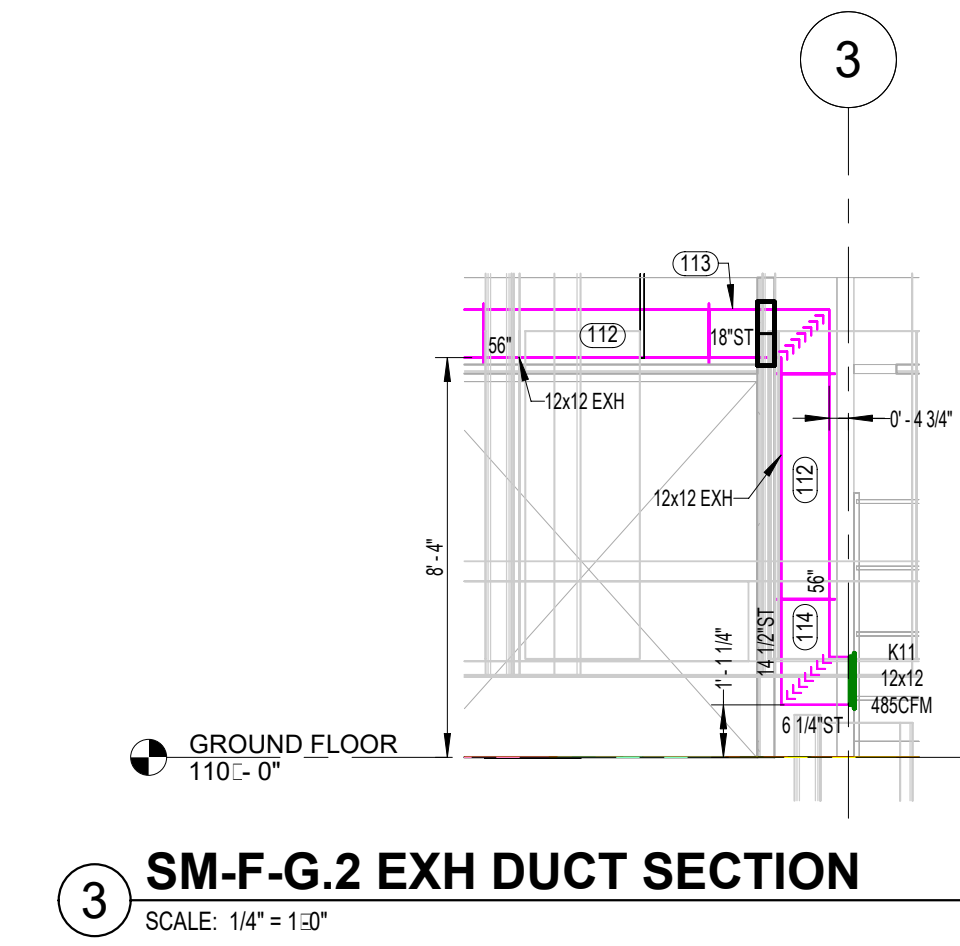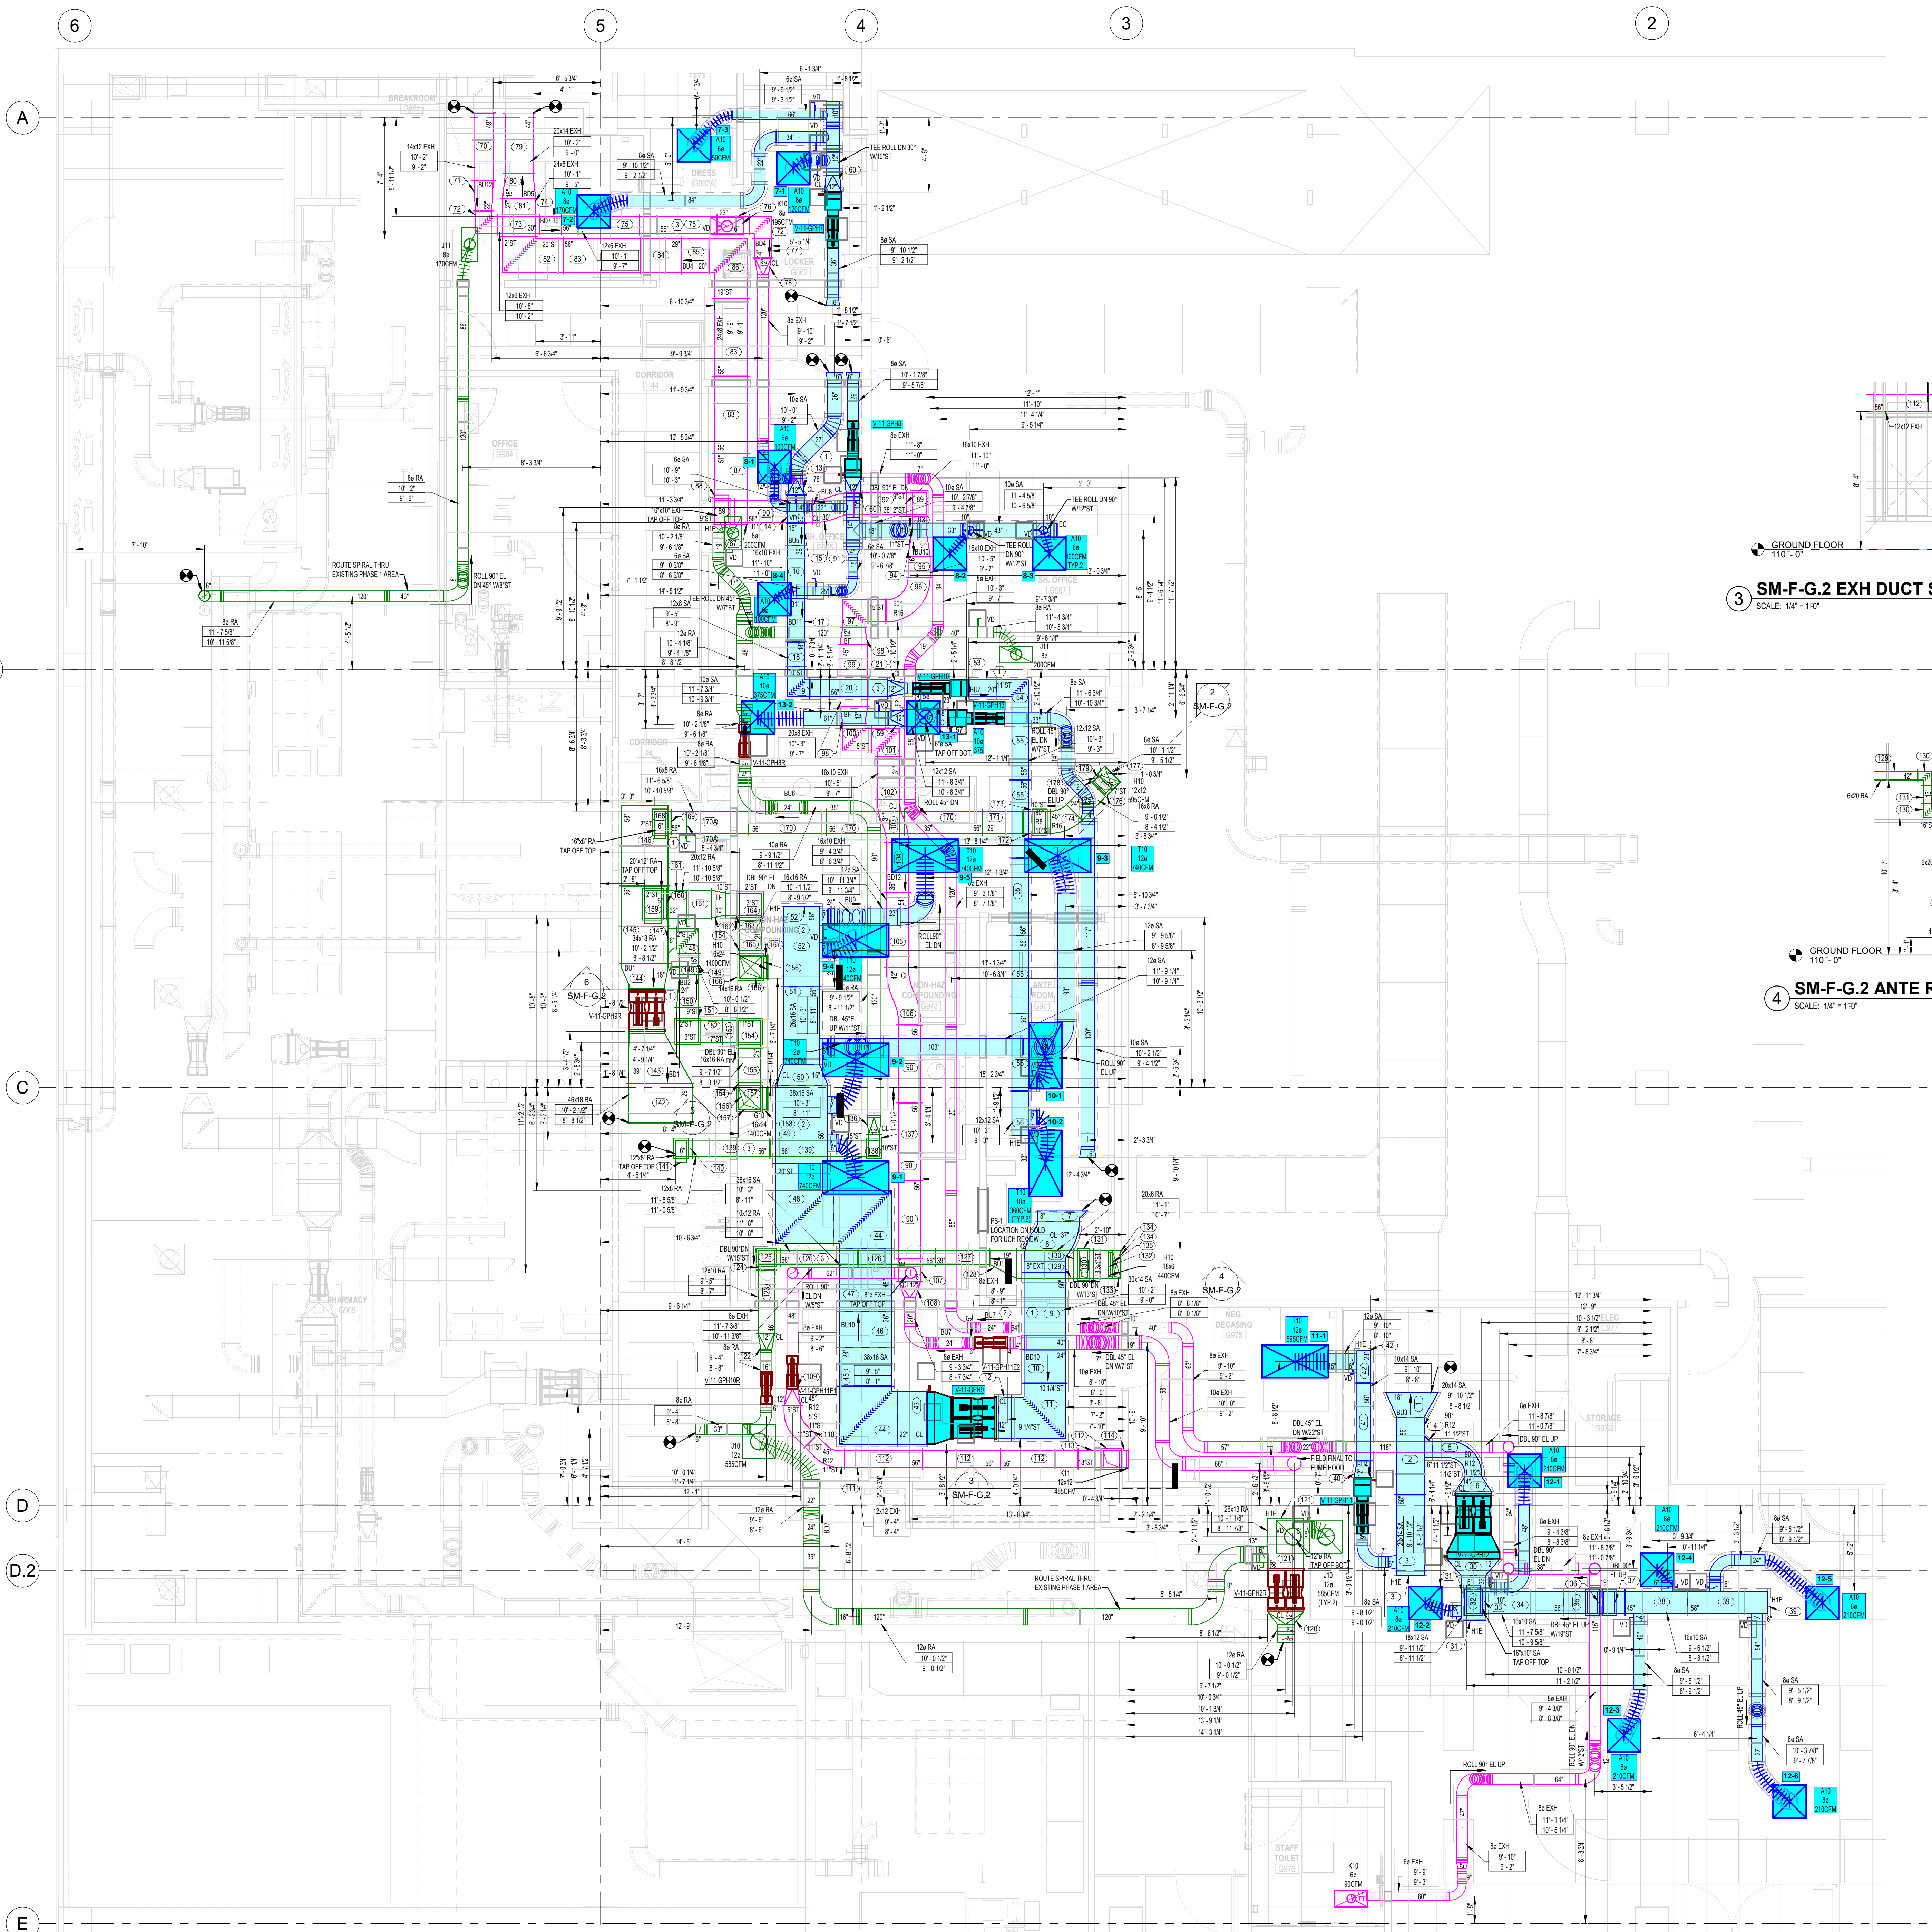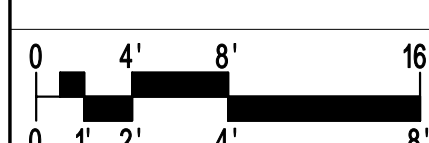

Air Valve Schedule

Valve Tag	Inlet - Outlet	Top/Bottom Mount	Coil Orientation For Supply Valve	Max CFM	Room#
V-11-GPH10	8\"/>				
V-11-GPH9	8\"/>				
V-11-GPH11	8\"/>				
V-11-GPH12	26.25\"/>				
V-11-GPH9	30.25\"/>				
V-11-GPH13	8\"/>				
V-11-GPH7	8\"/>				
V-11-GPH10R	8\"/>				
V-11-GPH12R	26.25\"/>				
V-11-GPH12	26.25\"/>				
V-11-GPH12R	26.25\"/>				
V-11-GPH11E	8\"/>				

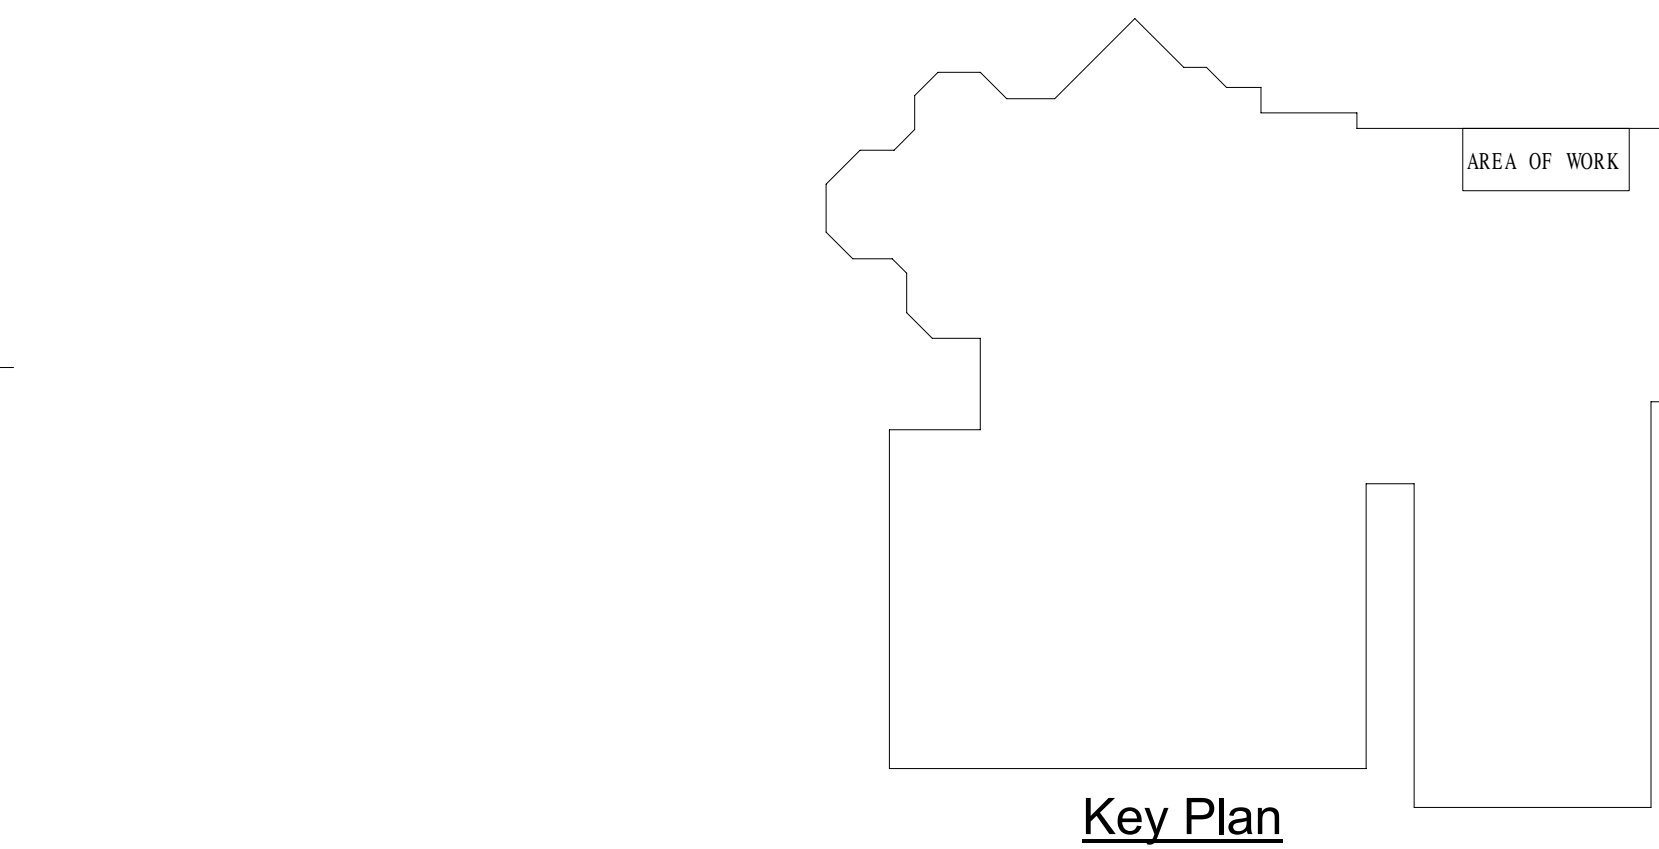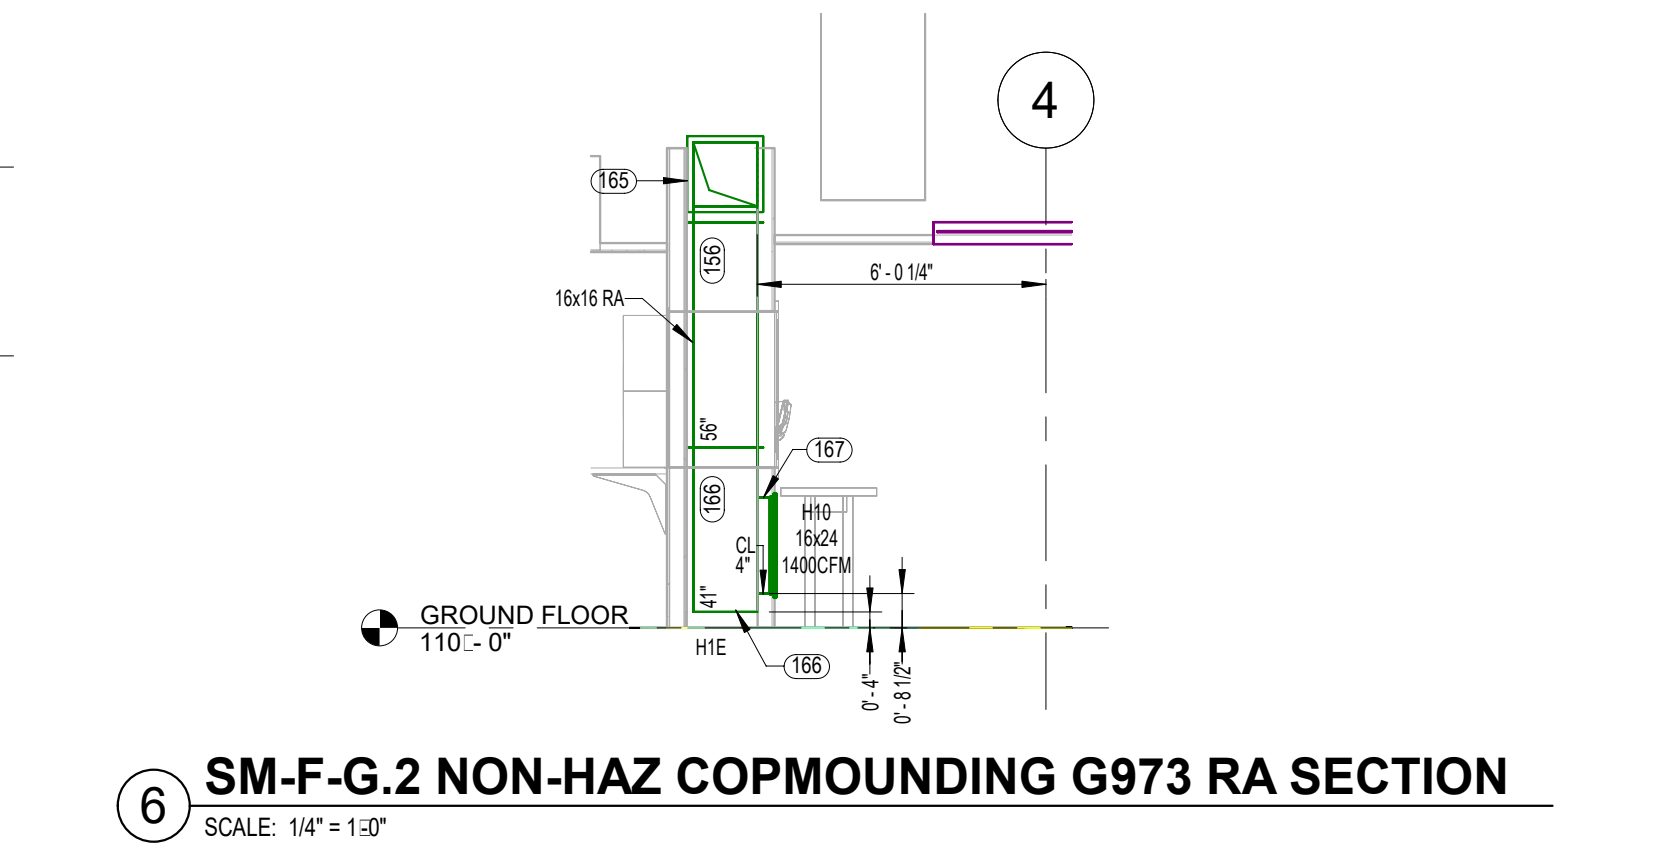

1 PARTIAL GROUND FLOOR PLAN - NEW WORK SHOP DRAWING
SCALE: 1/4\"/>