

...NSER, IF REFRIGERANT PIPING TO
...LESS STEEL SHROUD AS SHOWN

...TION INSTRUCTIONS AND AS

...D IN THE ARCHITECTURAL AND
...URNISHED BY CHIPOTLE ON


...R DETAIL 1/M700. TYPICAL.
...OR WITH REMOTE KEY OPERATED
...UNIT 60" AFF. TYPICAL.

...R DETAIL 6/M700. SEE ELECTRICAL
...V WARNING STICKERS ON FACE OF
...UGH WHICH THE REME HALO

...INATION AND OUTSIDE AIR
...OMBUSTION AIR INTAKE AND
...MORE INFORMATION ON WATER

...POSITE SIDE OF ROOM AT
...OM.

...R INTAKE

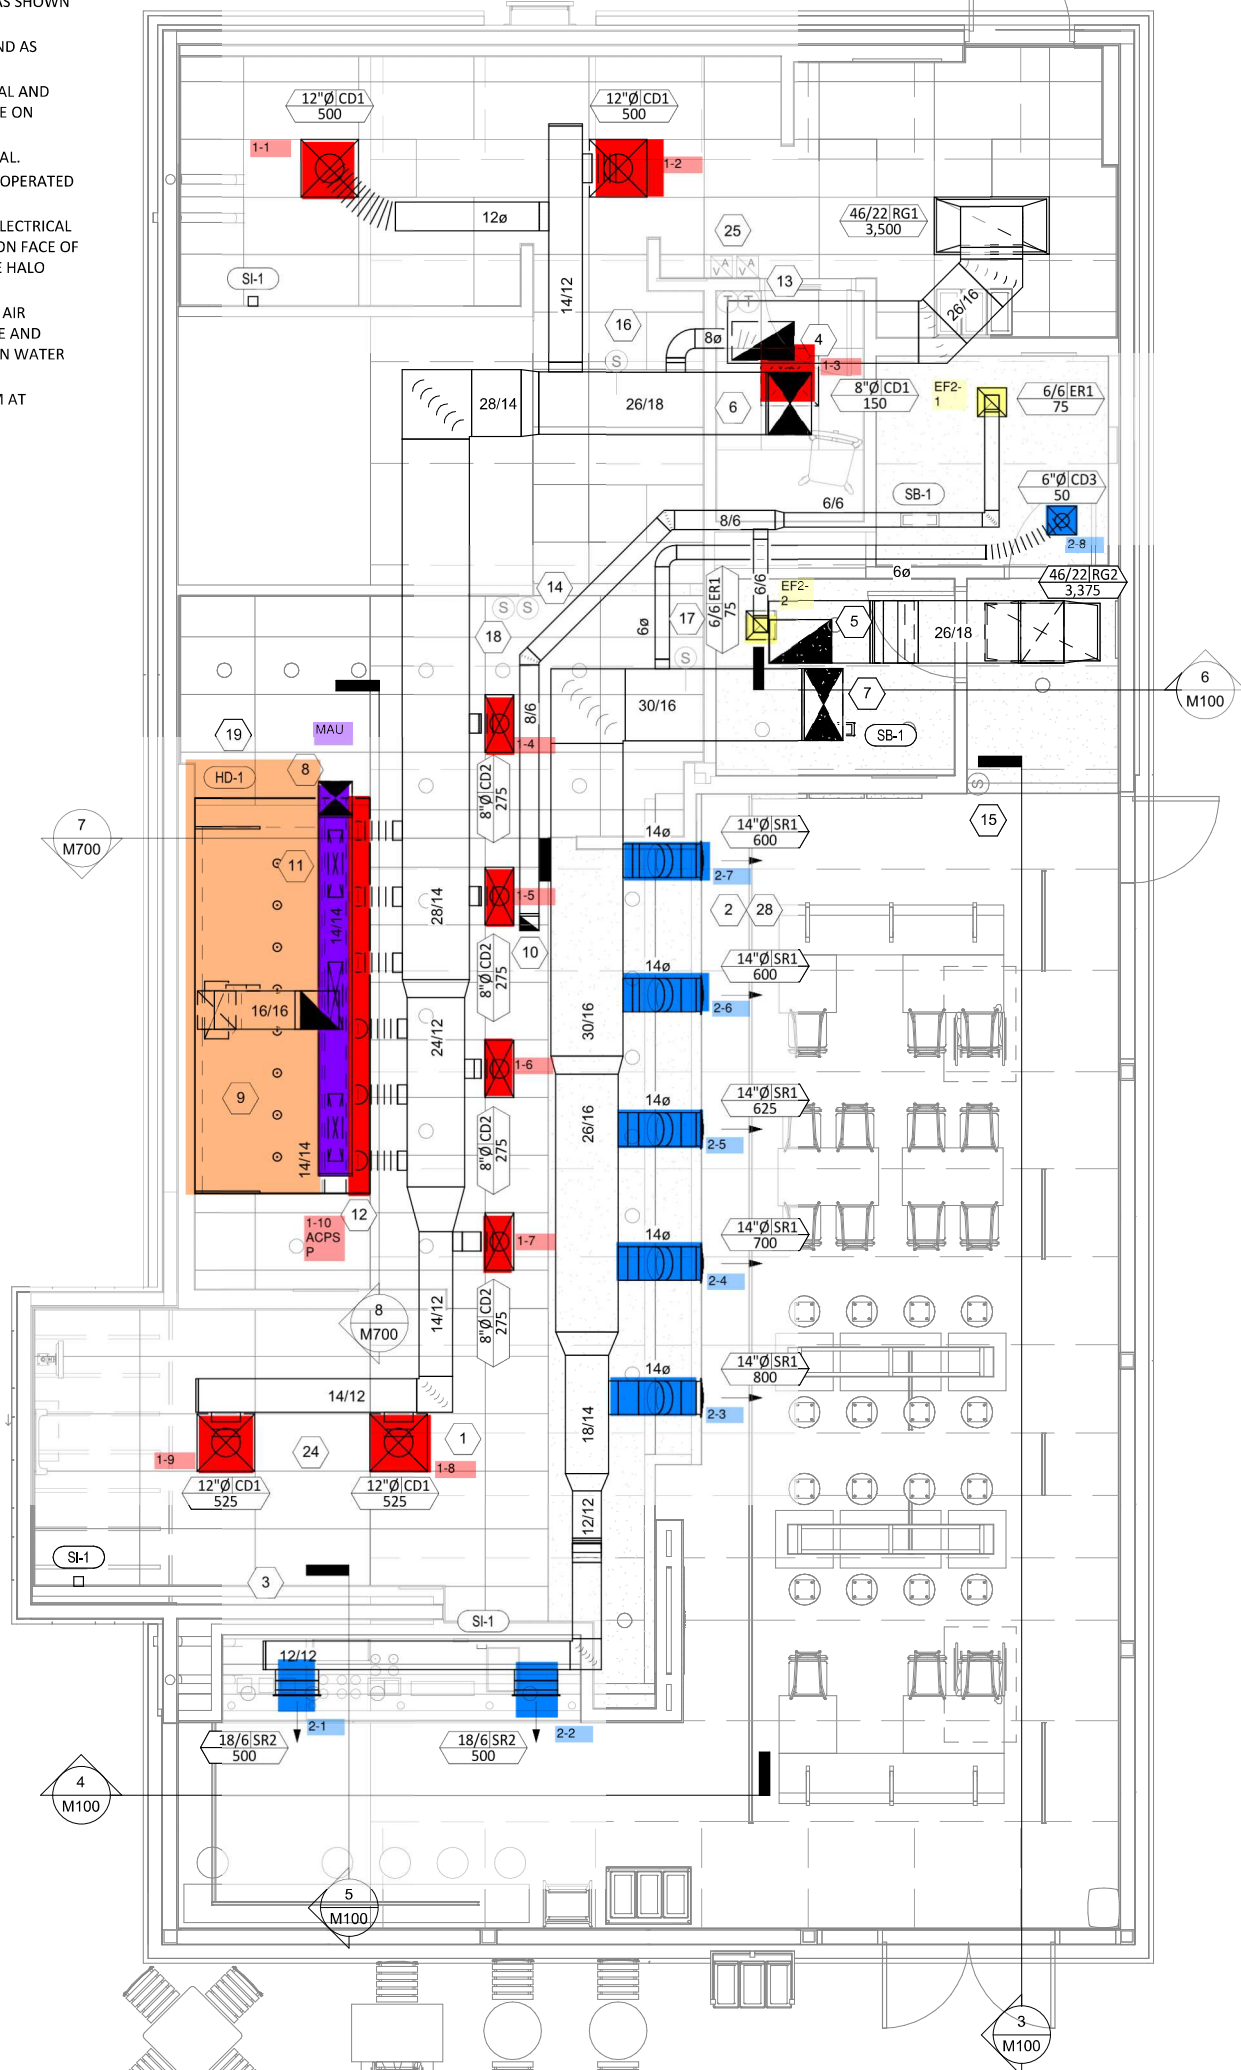

COPYRIGHT 2022
THIS DRAWING IS AN INSTRUMENT OF SERVICE AND AS SUCH REMAINS THE PROPERTY OF CHIPOTLE MEXICAN GRILL. ANY REUSE OR REPRODUCTION OF THIS DOCUMENT WITHOUT THE WRITTEN PERMISSION OF CHIPOTLE MEXICAN GRILL IS PROHIBITED.



CHIPOTLE MEXICAN GRILL
PO BOX 1000
COLUMBUS, OH 43216
TELEPHONE: (614) 425-1100
INTERNET: WWW.CHIPOTLE.COM

STORE NO.: 5204

41ST & GARNETT

Issue Record:

04/02/2024	PERMITS
05/15/2024	BID SET
06/26/2024	CONSTRUCTION

Revisions:

Rev	Date	Description

Drawn: MPC

GPD Project No. 2023201.45

Contents:
HVAC PLAN