

H.E.S. SYSTEM
 MECHANICAL CONTRACTOR TO PROVIDE
 ALL INSTALL, S/MOUNT, H.E.S. SYSTEM FOR
 ALL NEW HOODS. SEE HOOD FAN/EQUIPMENT
 INTERLOCK WIRING DIAGRAM ON SHEET MA1
 FOR MORE INFORMATION.

REBALANCE TO 450
 CFM SUPPLY AIR EACH

REBALANCE TO 450
 CFM SUPPLY AIR EACH
 COLLAR AND DUCTWORK AS SHOWN

REBALANCE TO 450
 CFM SUPPLY AIR EACH
 COLLAR AND DUCTWORK AS SHOWN

REBALANCE TO 450
 CFM SUPPLY AIR EACH

NEW AIR CURTAIN DOWN MOUNTED IN CEILING GRID
 CENTERED ON THE DOOR AT 1' OFF THE EXTERIOR
 WALL. MECHANICAL CONTRACTOR SHALL ADJUST
 AIR DEFLECTORS TOWARD AIR DIVERGENT BOX

HOLD DUCT AT ACH AS HIGH AS
 POSSIBLE DUE TO LIMITED
 CLEARANCE ABOVE CEILING.

EXISTING CONDITIONS SHOWN ARE FROM PREVIOUS DRAWINGS.
 MECHANICAL CONTRACTOR SHALL VERIFY EXACT
 LOCATIONS OF ALL DUCT AND DIFFUSERS. IF MAJOR DIFFERENCES
 OCCUR IN FIELD, CONTACT CHECK-FL-A CONSTRUCTION MANAGER.

LEGEND

A-12-400	TYPE - NECK, SIZE - CFM
	SPIN-IN FITTING, W/O, NO SCOOP
	REMOTE TEMPERATURE SENSOR

CONTRACTOR SHALL CLEAN
 EXISTING RETURN AIR DUCTWORK
 TO LIKE NEW CONDITION

MECHANICAL FLOOR PLAN
 SCALE: 1/4"=1'-0"

EXISTING CONDITIONS SHOWN ARE FROM PREVIOUS DRAWINGS.
 MECHANICAL CONTRACTOR SHALL VERIFY EXACT
 LOCATIONS OF ALL DUCT AND DIFFUSERS. IF MAJOR DIFFERENCES
 OCCUR IN FIELD, CONTACT CHECK-FL-A CONSTRUCTION MANAGER.


REBALANCE TO 450
 CFM SUPPLY AIR EACH

REBALANCE TO 450
 CFM SUPPLY AIR EACH

REBALANCE TO 450
 CFM SUPPLY AIR EACH

REBALANCE TO 450
 CFM SUPPLY AIR EACH

REBALANCE TO 450
 CFM SUPPLY AIR EACH

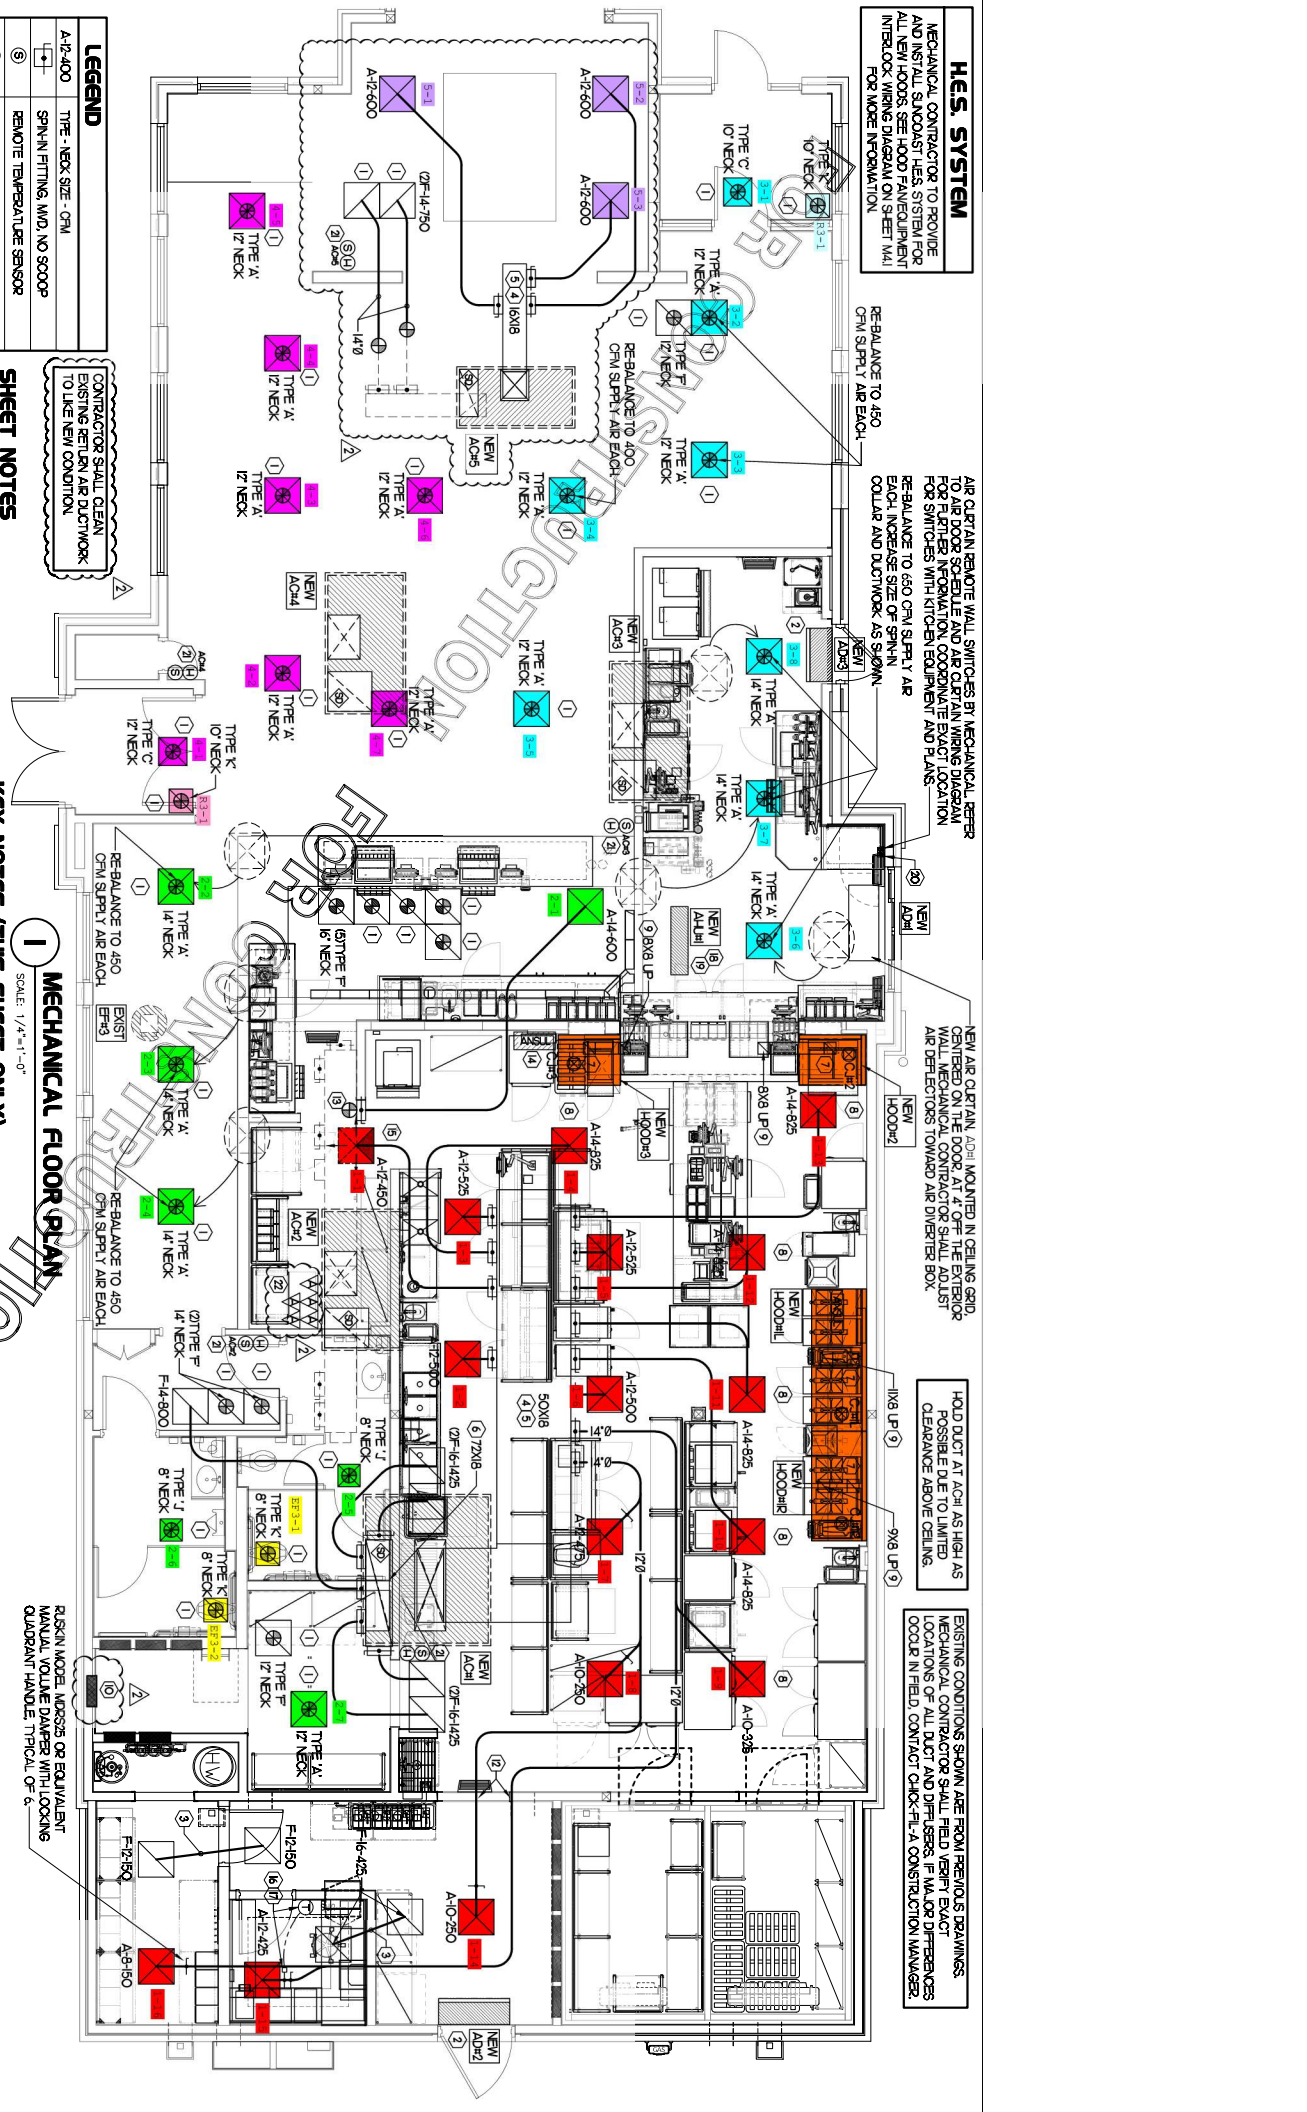

RISER UNITS, ACCESS OR EQUIPMENT
 MANUAL VOLUME DAMPER WITH LOCKING
 QUADRANT HANDLE, TYPICAL OF C