


GREASE DUCT CLEANOUTS SHALL BE UL-LISTED DUCTATE PREINSULATED CLEANOUT DOORS MODEL D12ULV/SBI FOR DUCTS AT LEAST 17" TALL AND DW128ULV/SBI FOR DUCTS LESS THAN 17" TALL. CLEANOUTS SHALL BE FURNISHED BY TENANT. COORDINATE NUMBER AND SIZE REQUIRED WITH ENVIRONMENT. INSTALL AS SHOWN IN THE HVAC FLOOR PLAN.

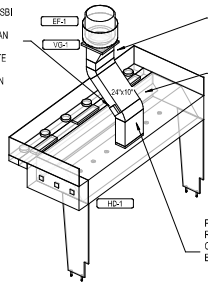


PROVIDE FIRE RESISTANT INSULATION ON TYPE I HOOD EXHAUST DUCT FROM CONNECTION TO HOOD TO CONNECTION TO EXHAUST FAN PER DETAIL 3M700.

SLOPE HORIZONTAL GREASE DUCT A MINIMUM OF 1/4" PER FOOT DOWN TOWARD THE CONNECTION TO THE HOOD.


PROVIDE RADIUS ELBOWS WITH AN INSIDE RADIUS OF 0.5 X THE DUCT DIMENSION AT ALL CHANGES OF DIRECTION IN THE TYPE I HOOD EXHAUST DUCT.

9 HOOD EXHAUST ISOMETRIC
M700 NOT TO SCALE

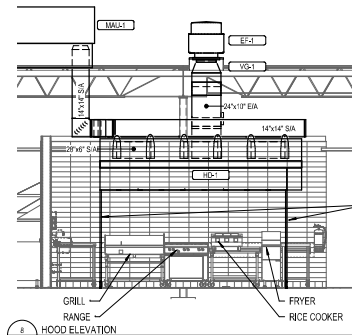


INSTALL VERTICAL END PANELS AT EACH END OF HOOD AS SHOWN. HOOD IS UL-LISTED FOR 0' OVERHANG WHEN USED WITH VERTICAL END PANELS.

8 HOOD ELEVATION
M700 NOT TO SCALE

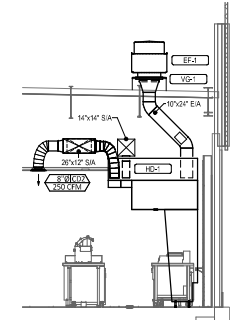


7 DUCT SECTION AT HOOD
M700 NOT TO SCALE

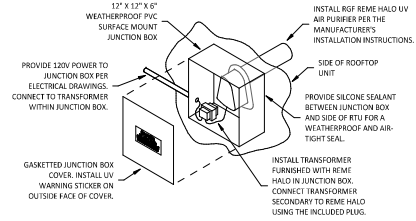

INSTALL AIR PURIFIER WITH JUNCTION BOX ON OUTSIDE FACE OF ROOFTOP UNIT AND WITH UV LAMP TUBE EXTENDING INTO THE INTERIOR OF THE ROOFTOP UNIT. FIELD VERIFY EXACT LOCATION TO AVOID DAMAGING, TOUCHING, OR INTERFERING WITH ANY KIU IN/OUT COMPONENTS. INSTALLATION LOCATION SHALL BE AS FOLLOWS:


TRANE: INSTALL INTO THE SUPPLY AIR STREAM THROUGH THE REMOVABLE PANEL COVERING THE HORIZONTAL DISCHARGE SUPPLY AIR OPENING.
YORK: INSTALL INTO THE SUPPLY AIR PLENUM FROM THE BACK SIDE OF THE UNIT JUST ABOVE THE HEAT EXCHANGER.

6 UV AIR PURIFIER INSTALLATION
M700 NOT TO SCALE

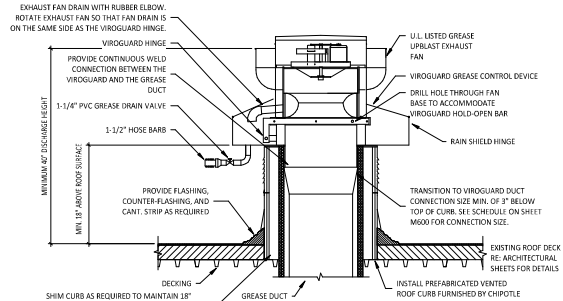


1. INSTALLATION SHALL BE IN ACCORDANCE WITH NFPA 96 REQUIREMENTS.
2. HINGE FAN SO IT TIPS BACK TOWARD FAN DRAIN AND TOWARD VIROGUARD DRAIN.


5 GREASE EXHAUST FAN
M700 NOT TO SCALE

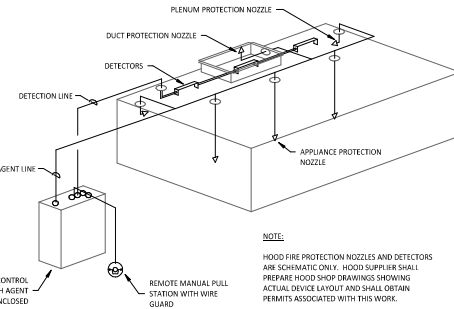


4 FIRE SUPPRESSION SYSTEM SCHEMATIC
M700 NOT TO SCALE

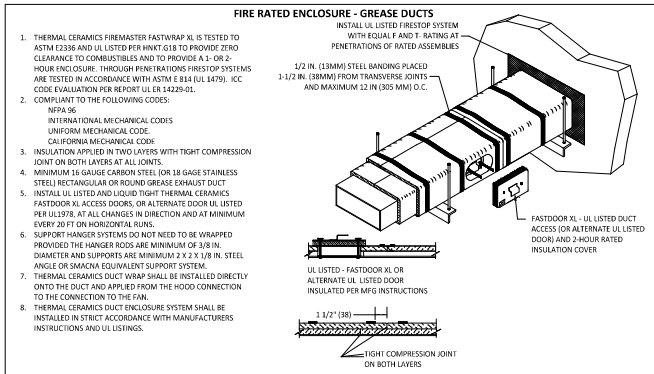

3 FIREMASTER DUCT WRAP - UL-HNK-G16
M700 NOT TO SCALE

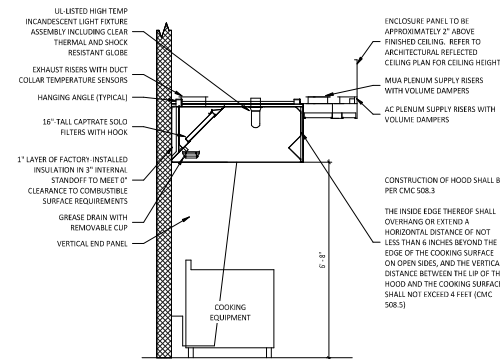

2 HOOD SECTION VIEW
M700 NOT TO SCALE

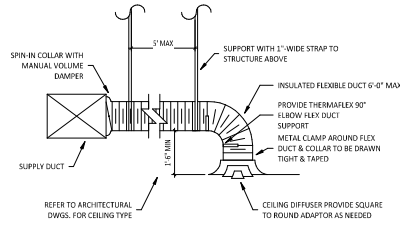

1 DIFFUSER CONNECTION
M700 NOT TO SCALE

Consultant:

AVRES
MECHANICAL ELECTRICAL
PLUMBING (MEP)
1700 West Highway 36 - Suite 700
Rosemead, Illinois 60510
(615) 636-5606 Fax (615) 636-5618
Project No.



CONTRACT NO. 2023
THIS DRAWING IS AN INSTRUMENT OF SERVICE AND AS SUCH REMAINS THE PROPERTY OF AVRES. NO REPRODUCTION OR TRANSMISSION FOR USE OF THIS DOCUMENT IS PERMITTED AND SHALL BE CONSIDERED A VIOLATION OF THE PROFESSIONAL ENGINEER'S ETHICS AGREEMENT WITH CHIPOTLE MEXICAN GRILL, INC.



CHIPOTLE MEXICAN GRILL, INC.
PO BOX 28256
COLUMBUS, OH 43228-2566
WEB: 318.2826
www.chipotle.com

STORE NO. 4796
"GRAFTON"
NORTH PORT WASHINGTON ROAD
GRAFTON, WI 53024

Date Plotted:	04/18/2023	PERMIT SET
Drawn:		Checked:
RLD		LAO
Project No.:		
Contract:		

HVAC DETAILS



M700

NO.	REV.	DATE	BY	DESCRIPTION
1	0			ISSUED FOR PERMIT

NO.	REV.	DATE	BY	DESCRIPTION
1	0			ISSUED FOR PERMIT

NO.	REV.	DATE	BY	DESCRIPTION
1	0			ISSUED FOR PERMIT

NO.	REV.	DATE	BY	DESCRIPTION
1	0			ISSUED FOR PERMIT

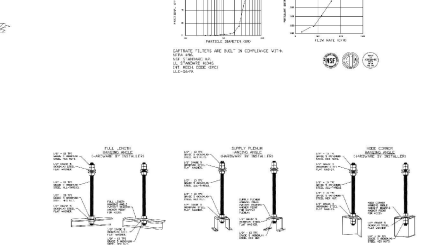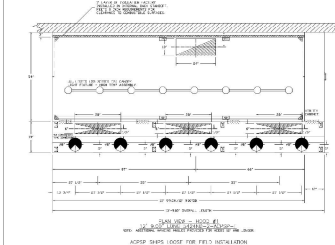

SECTION 11-0000 - HOODS
 11-0010 - HOODS
 11-0010 - HOODS

REVISIONS

CAPTIVE LIFE

CHICOPILLE #1796 GRANTON
 GRANTON, WI 53024

DATE: 4/17/2023
 DRAWN BY: LAO
 CHECKED BY: LAO
 SCALE: 1/4" = 1'-0"
 WATER MARKING

SHEET NO. 1

NO.	REV.	DATE	BY	DESCRIPTION
1	0			ISSUED FOR PERMIT

NO.	REV.	DATE	BY	DESCRIPTION
1	0			ISSUED FOR PERMIT

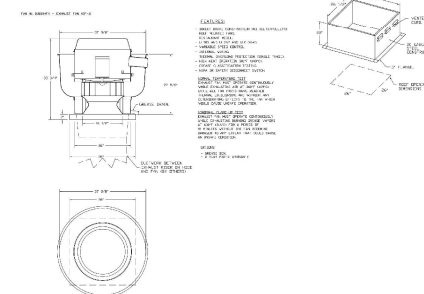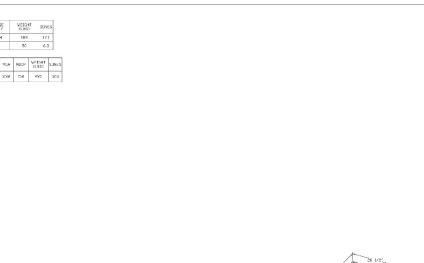

SECTION 11-0000 - HOODS
 11-0010 - HOODS
 11-0010 - HOODS


REVISIONS

CAPTIVE LIFE

CHICOPILLE #1796 GRANTON
 GRANTON, WI 53024

DATE: 4/17/2023
 DRAWN BY: LAO
 CHECKED BY: LAO
 SCALE: 1/4" = 1'-0"
 WATER MARKING

SHEET NO. 2

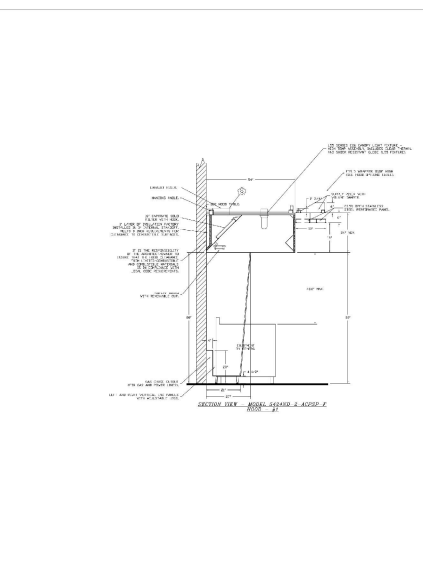



REVISIONS

CAPTIVE LIFE

CHICOPILLE #1796 GRANTON
 GRANTON, WI 53024

DATE: 4/17/2023
 DRAWN BY: LAO
 CHECKED BY: LAO
 SCALE: 1/4" = 1'-0"
 WATER MARKING

SHEET NO. 3

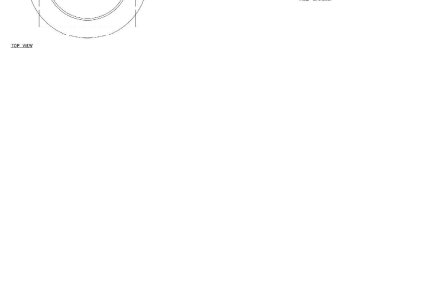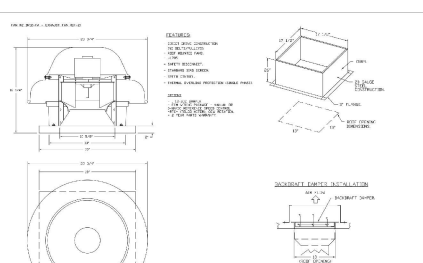

SECTION 11-0000 - HOODS
 11-0010 - HOODS
 11-0010 - HOODS

REVISIONS

CAPTIVE LIFE

CHICOPILLE #1796 GRANTON
 GRANTON, WI 53024

DATE: 4/17/2023
 DRAWN BY: LAO
 CHECKED BY: LAO
 SCALE: 1/4" = 1'-0"
 WATER MARKING

SHEET NO. 4

AVRES
 MECHANICAL ELECTRICAL PLUMBING (MEP)
 1700 West Highway 36 - Suite 700
 Roseville, Minnesota 55113
 (651) 638-6606 Fax (651) 638-6618
 Project No.

CHIPOTLE MEXICAN GRILL

CHICOPILLE #1796 GRANTON
 GRANTON, WI 53024

DATE: 4/17/2023
 DRAWN BY: LAO
 CHECKED BY: LAO
 SCALE: 1/4" = 1'-0"
 WATER MARKING

SHEET NO. 5

STORE NO. 4796
 "GRANTON"
 NORTH PORT WASHINGTON ROAD
 GRANTON, WI 53024

Issue Record:

NO.	REV.	DATE	BY	DESCRIPTION
1	0			ISSUED FOR PERMIT

Drawn: _____
 Checked: _____
 RD: LAO
 Project No. _____

HOOD DRAWINGS

M701

