


E5 HVAC PLAN

SCALE: 1/4" = 1'-0"

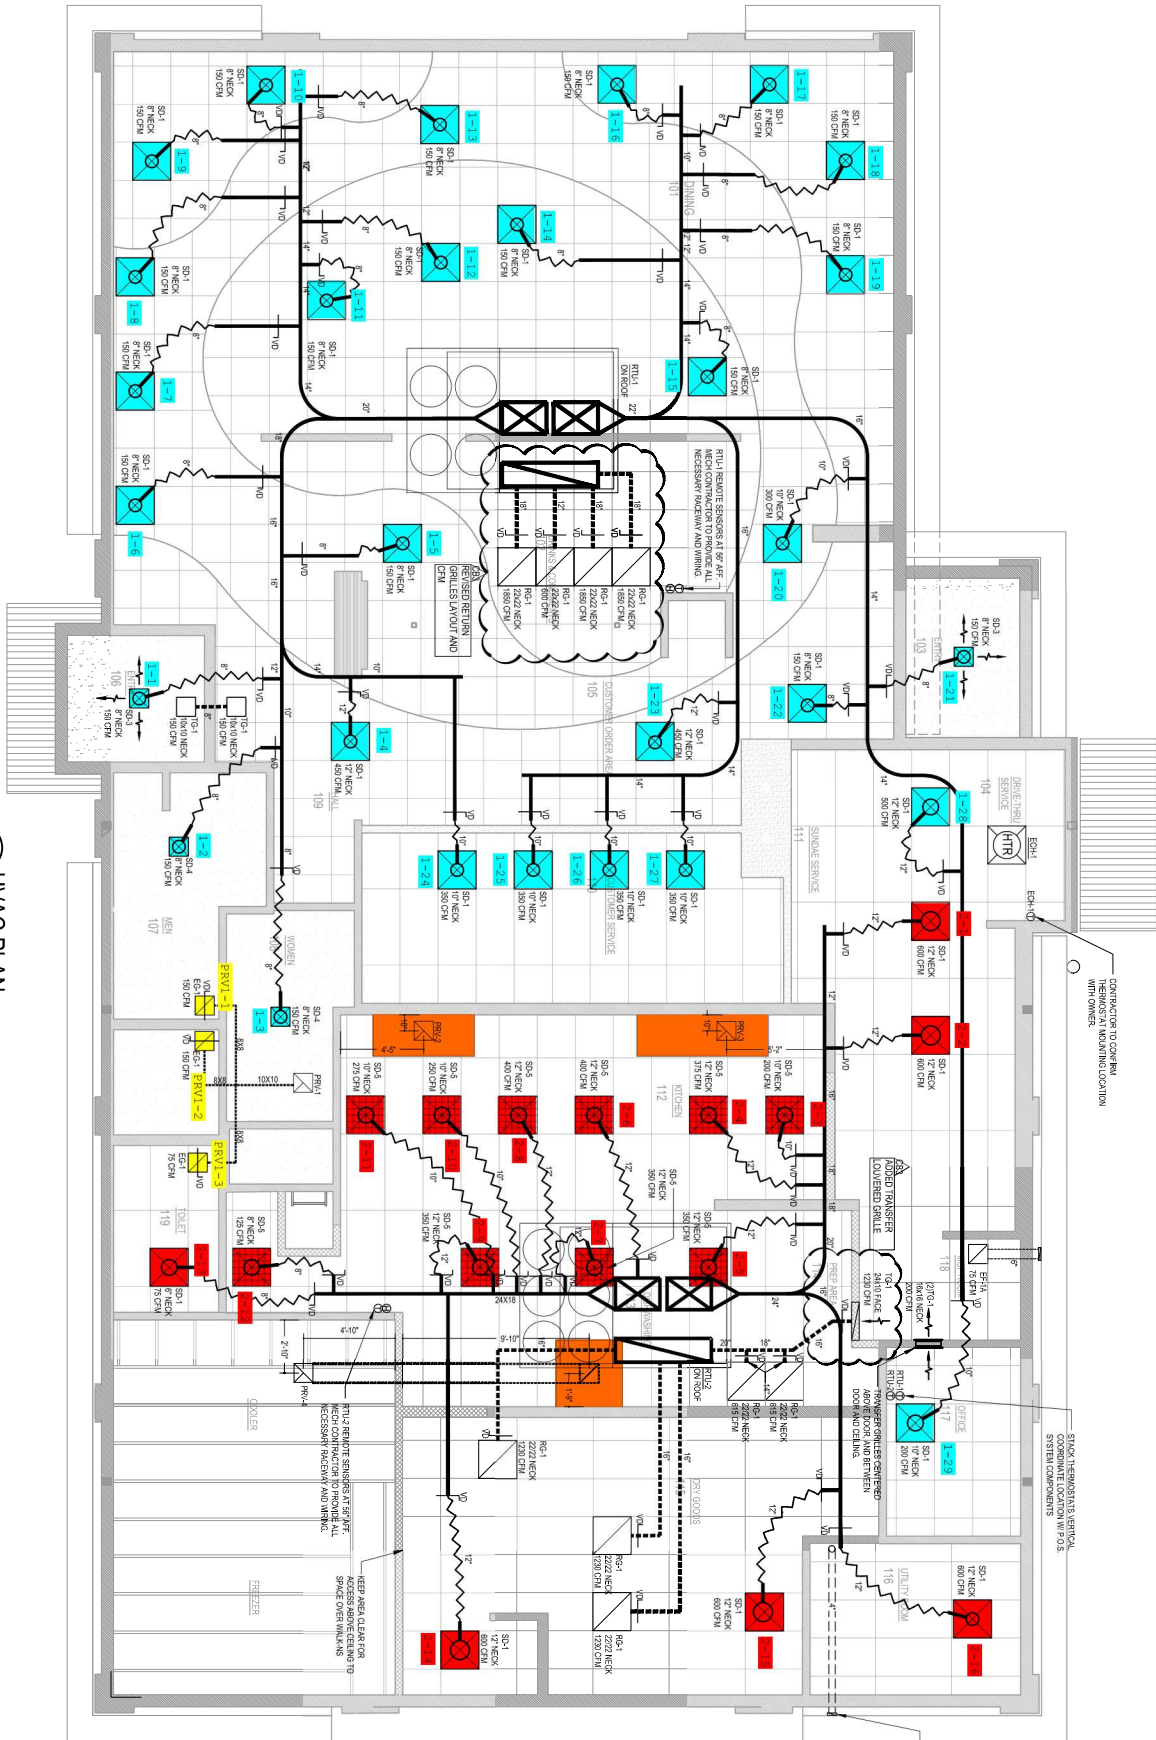

NOTE: ALL EQUIPMENT TO BE LOCATED IN MOST SPACE WHERE POSSIBLE.
 SEE MECHANICAL PLAN FOR EQUIPMENT SCHEDULES.
 1. KITCHEN HEATING TO BE PROVIDED BY SEPARATE OPERATIONAL QUELINES.
 2. KITCHEN HEATING TO BE PROVIDED BY SEPARATE OPERATIONAL QUELINES.

CONTRACTOR TO COORDINATE WITH OWNER REGARDING MECHANICAL EQUIPMENT LOCATION.
 CONTRACTOR TO COORDINATE WITH OWNER REGARDING MECHANICAL EQUIPMENT LOCATION.
 CONTRACTOR TO COORDINATE WITH OWNER REGARDING MECHANICAL EQUIPMENT LOCATION.

4. FOR THE EXHAUST TO BE MOVED OUTSIDE, CONTRACTOR TO PROVIDE EXHAUST SYSTEM TO MATCH EXTERIOR.