

PROPOSAL REQUEST

- Owner
- Architect
- Contractor
- Field
- Other

PROJECT: Sycamore CSD-HS Seger Natatorium

PROPOSAL REQUEST NO: 10

PROJECT NO: 2019147.09

DATE OF ISSUANCE: 5/21/2024

OWNER: Sycamore Comm. SD
5959 Hagewa Drive
Cincinnati, OH 45242

ARCHITECT: SHP
312 Plum Street, Suite 700
Cincinnati, OH 45202

CONTRACTOR: HGC Constructions Co.
2814 Stanton Avenue
Cincinnati, OH 45206

CONTRACT FOR: General Trades

Please submit an itemized proposal for changes in the Contract Sum and Contract Time for proposed modifications to the Contract Documents described herein. Submit proposal within days, or notify the Architect in writing of the date on which you anticipate submitting your proposal.

THIS IS NOT A CHANGE ORDER, A CONSTRUCTION CHANGE DIRECTIVE, OR A DIRECTION TO PROCEED WITH THE WORK DESCRIBED IN THE PROPOSED MODIFICATIONS

DESCRIPTION:

M100.0 has been revised to add exhaust in the pit in 1201A Pump Room.

Justification:

This was requested by the owner to exhaust any chlorine that may get into that area.

Cost Basis:

Owner Request

ATTACHMENTS:

(1) Dwg: M100.0


REQUESTED BY:




Jerry Dirr
Principal, Director of Construction Services

C:\Users\ehleinbach\Documents\1_Files\2020\1914704_MEP_SycamoreHS_Natatorium_ehleinbach.nt


5/21/2024 10:56:19 AM

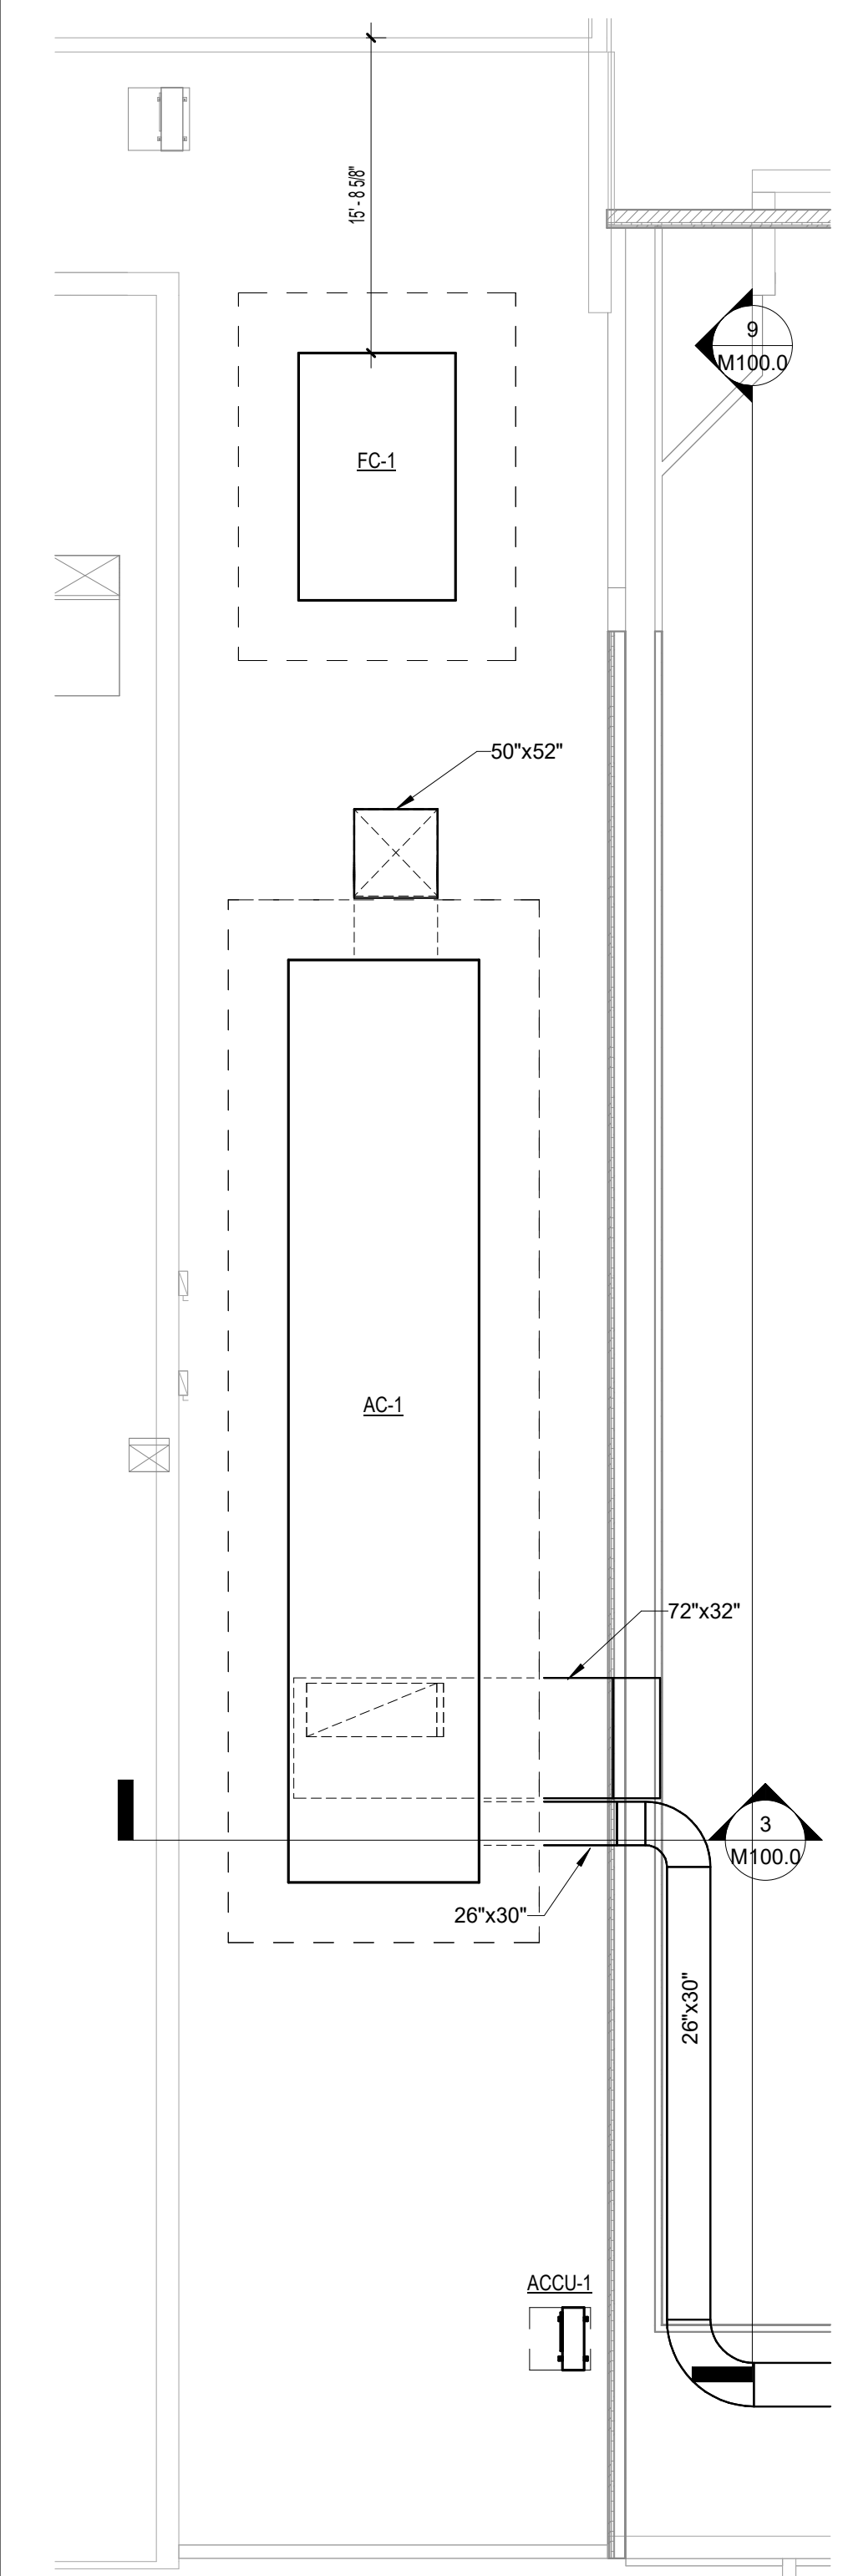


4 ROOF DUCTWORK PLAN AREA C
M100.0 1/8" = 1'-0"

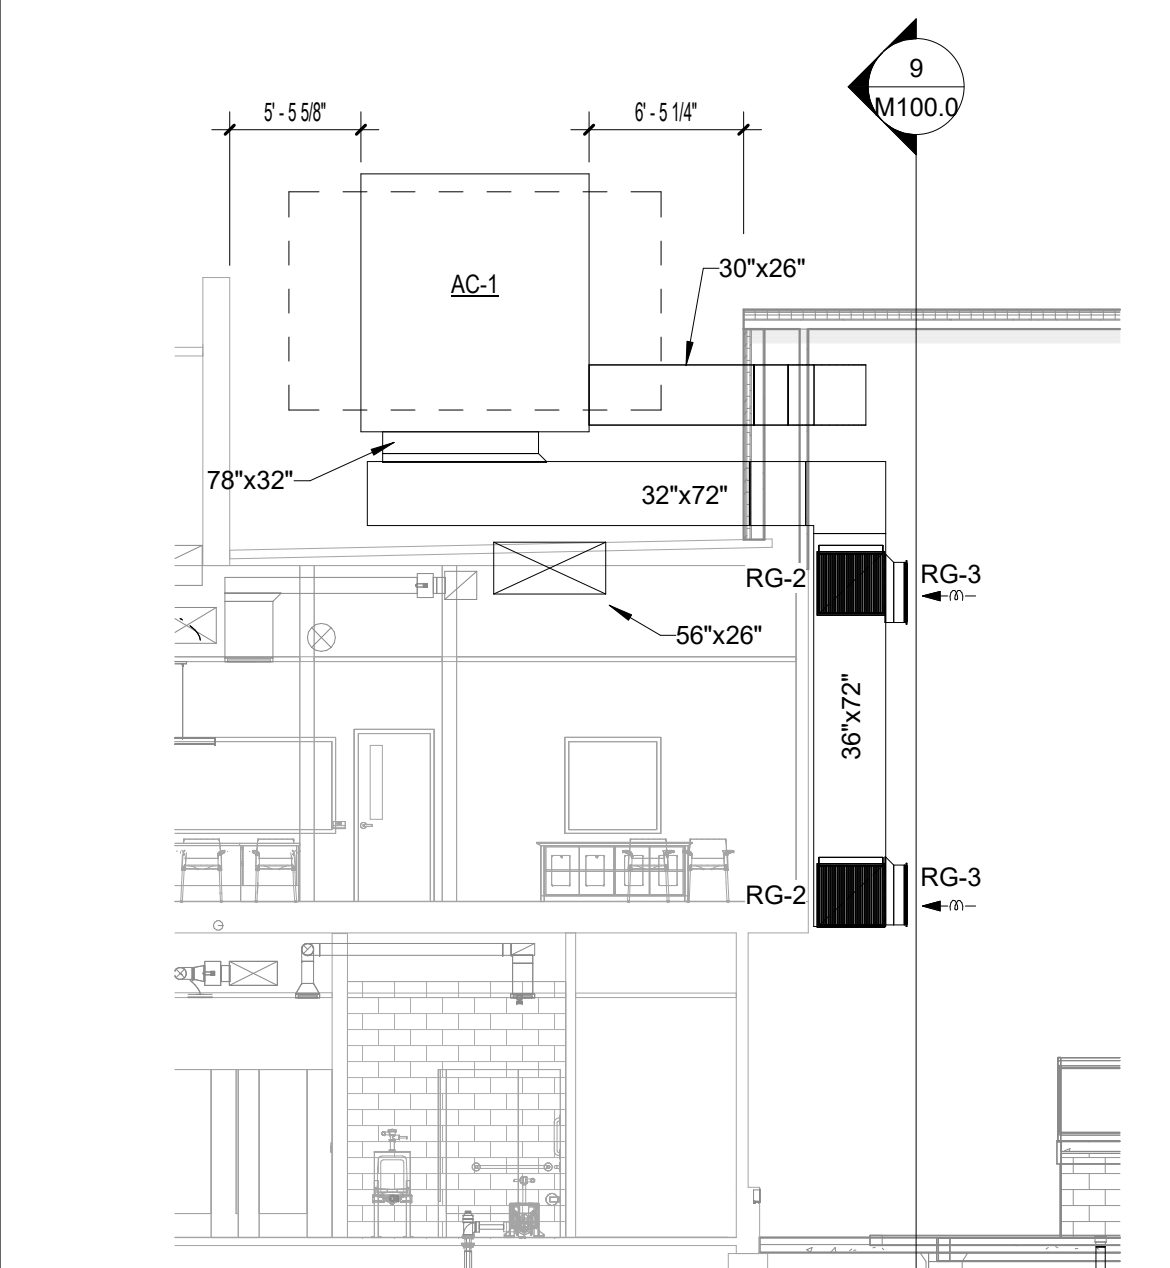


3 POOL RETURN DUCT SECTION VIEW
M100.0 1/8" = 1'-0"

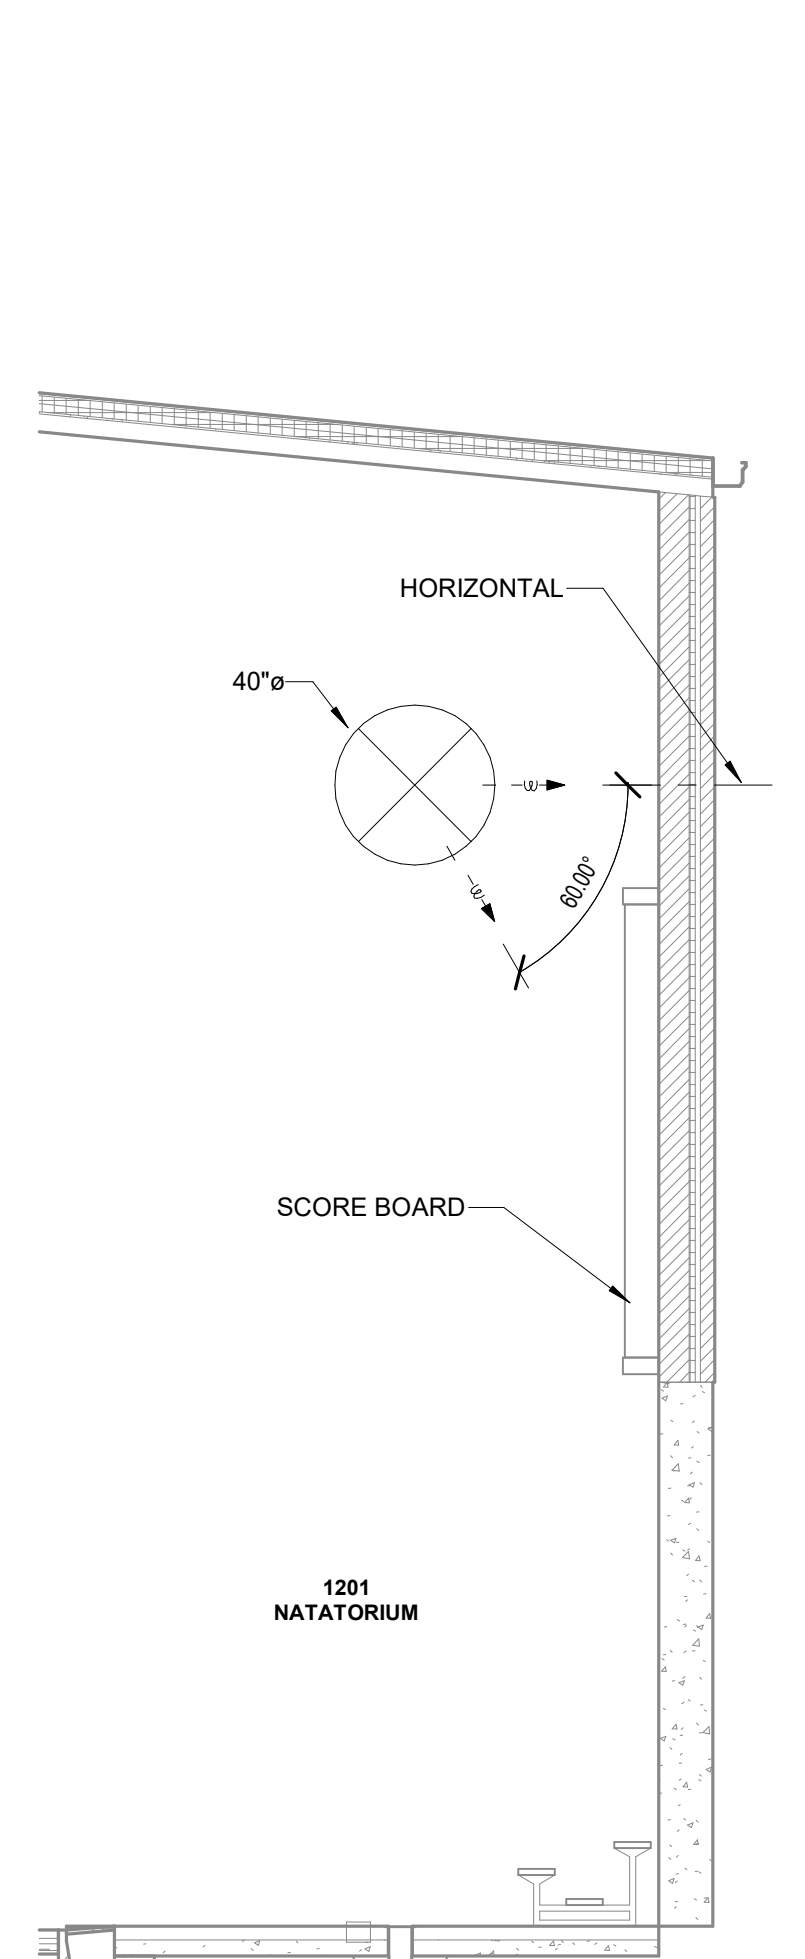


6 NORTH WALL SECTION VIEW
M100.0 1/4" = 1'-0"

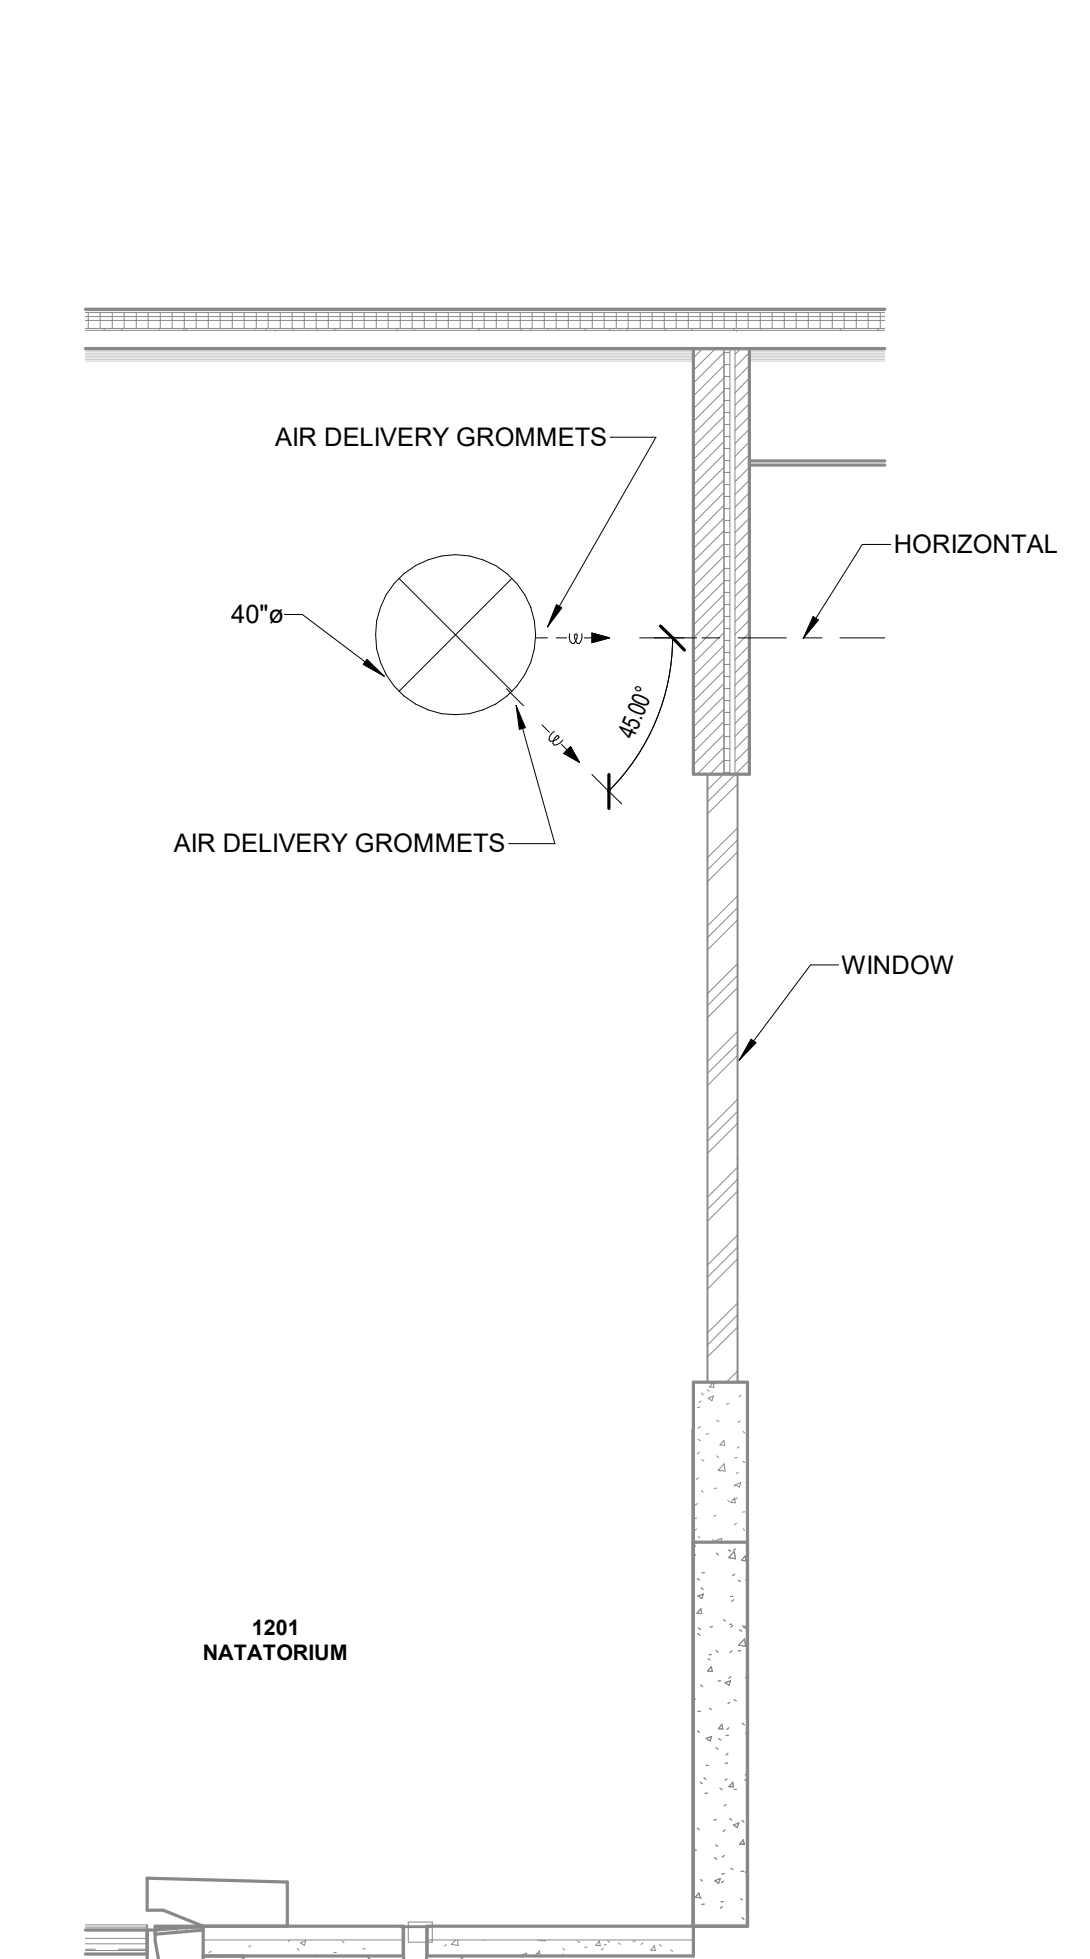


7 EAST WALL SECTION VIEW
M100.0 1/4" = 1'-0"

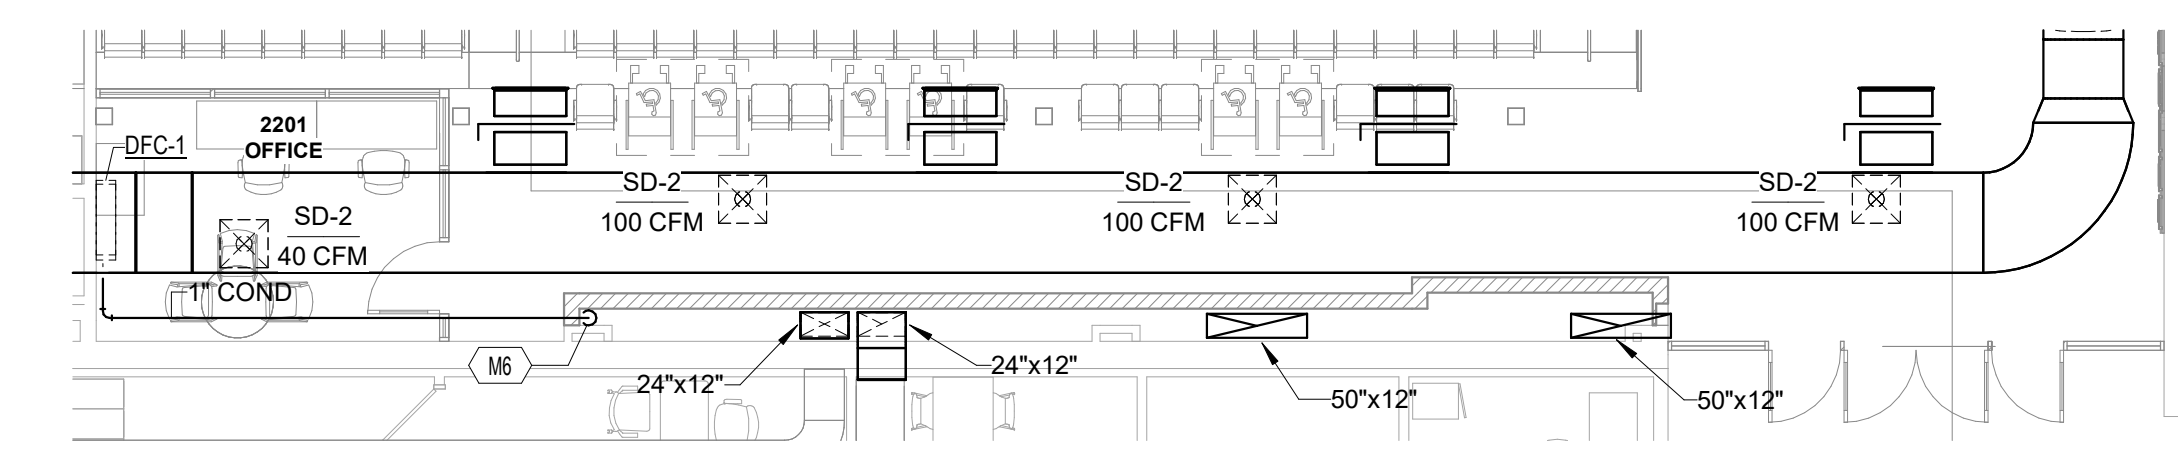


5 UPPER LEVEL DUCTWORK PLAN AREA C (NATATORIUM)
M100.0 1/8" = 1'-0"

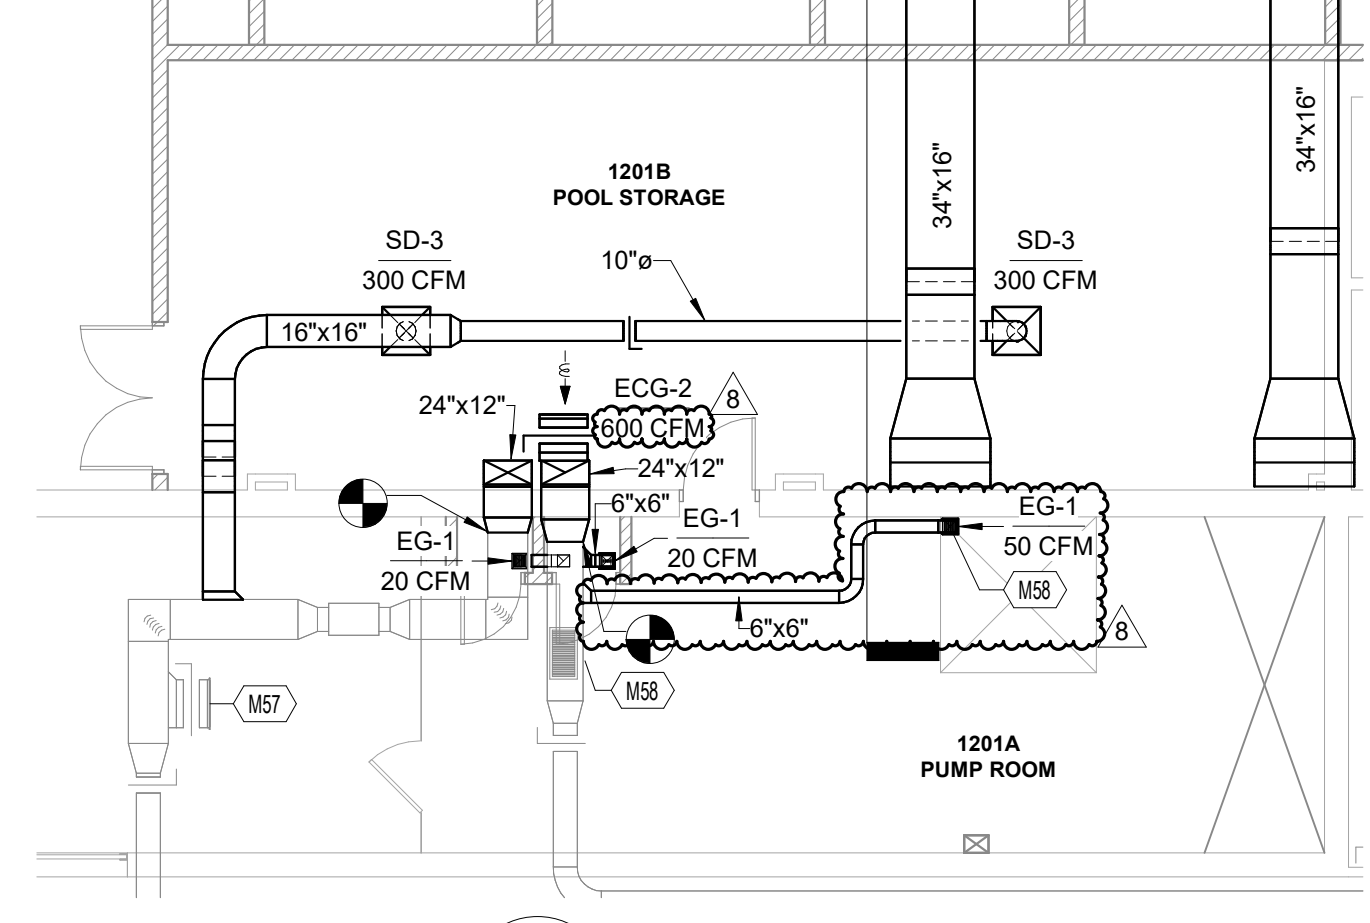


2 POOL STORAGE PLAN
M100.0 1/8" = 1'-0"

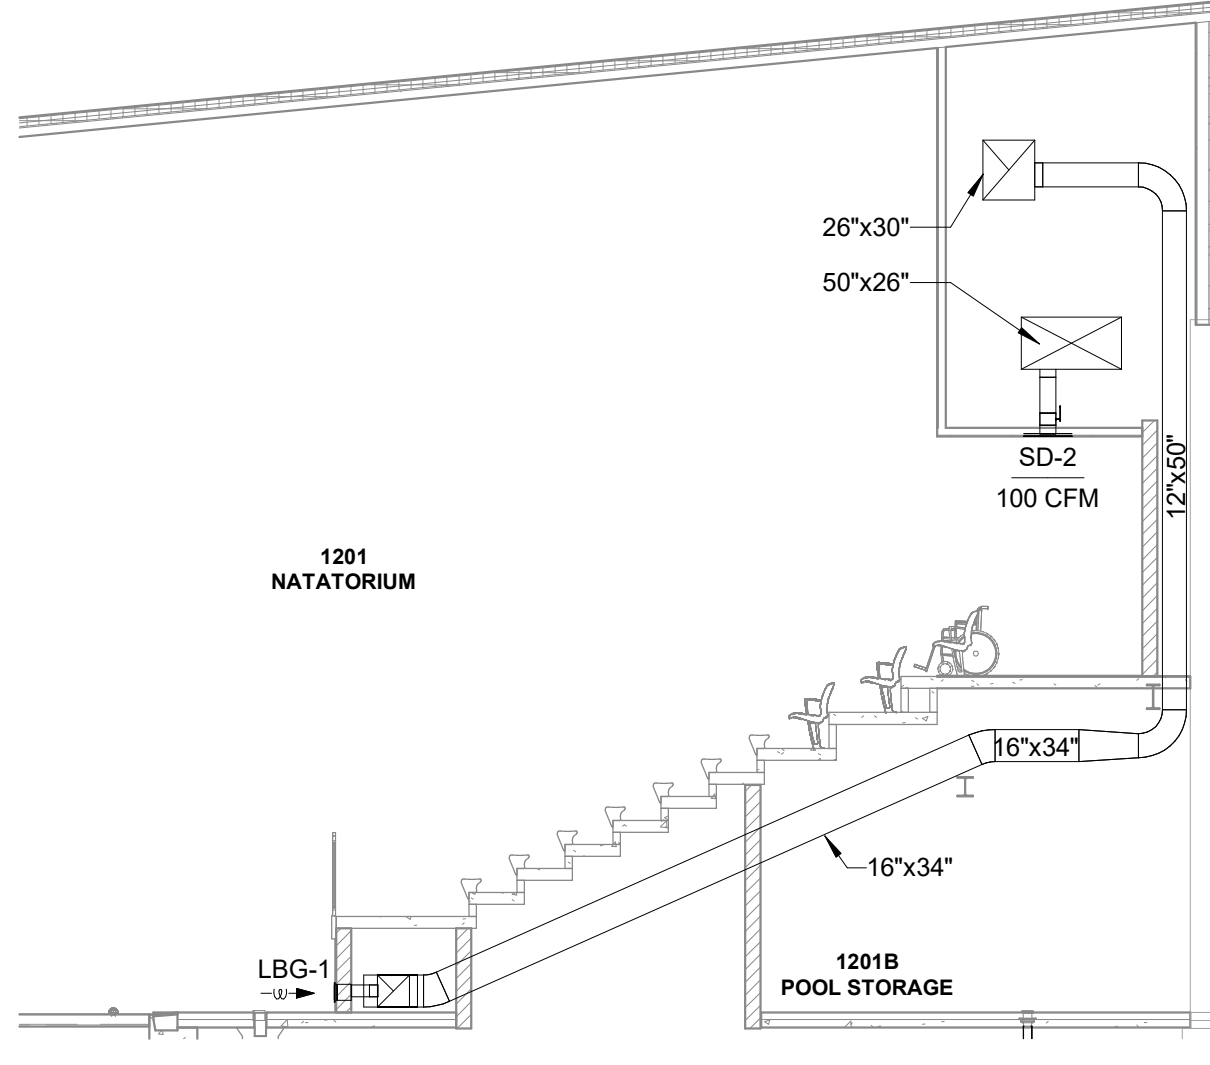

8 LOW EXHAUST DUCT SECTION VIEW
M100.0 1/8" = 1'-0"

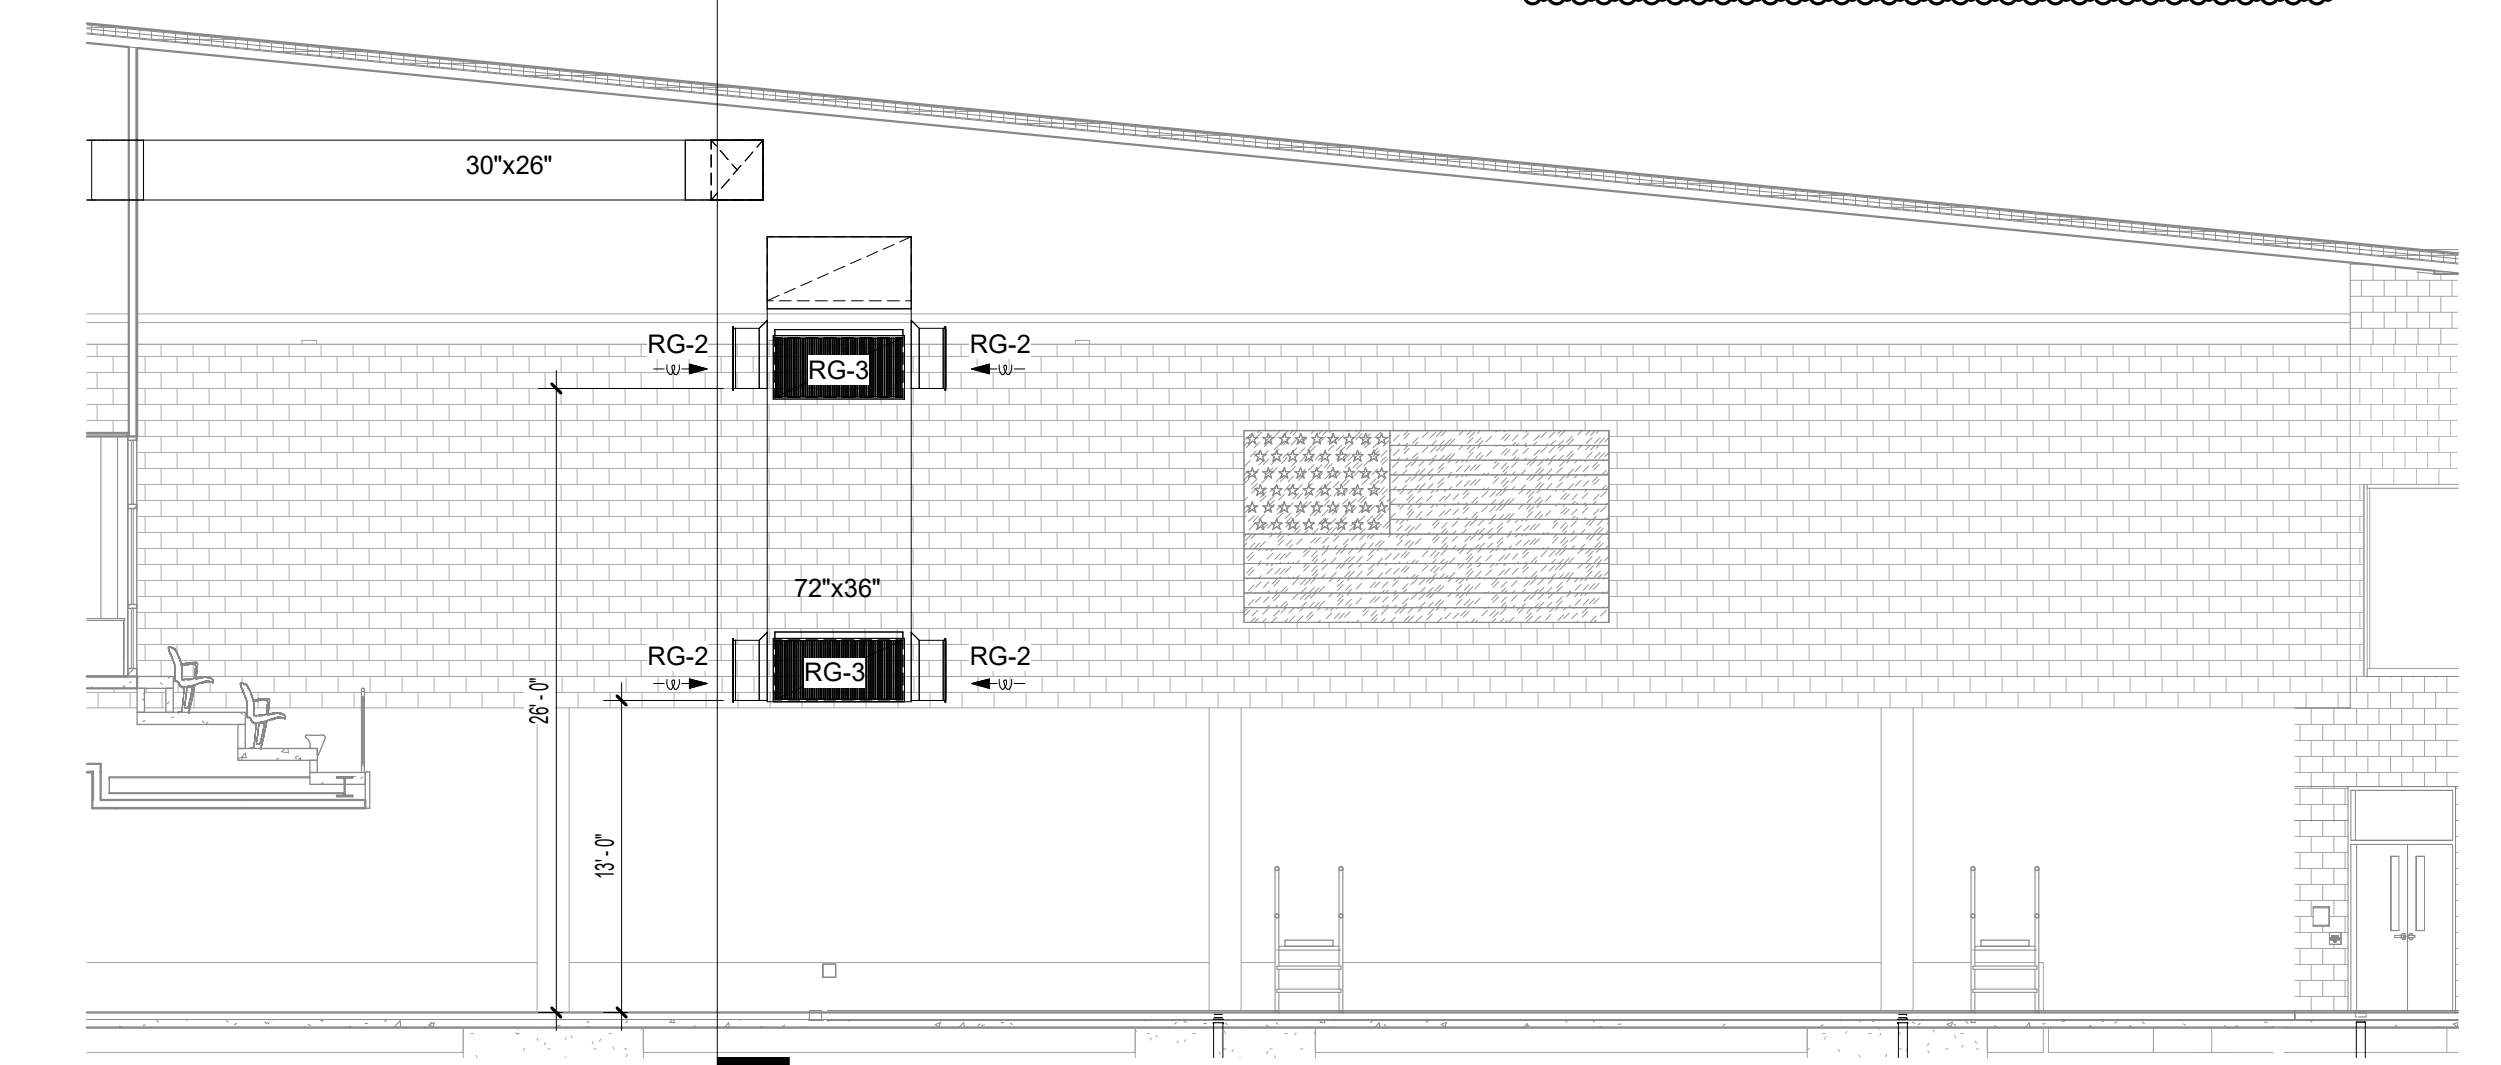


9 POOL RETURN & EXHAUST DUCT SECTION VIEW
M100.0 1/8" = 1'-0"

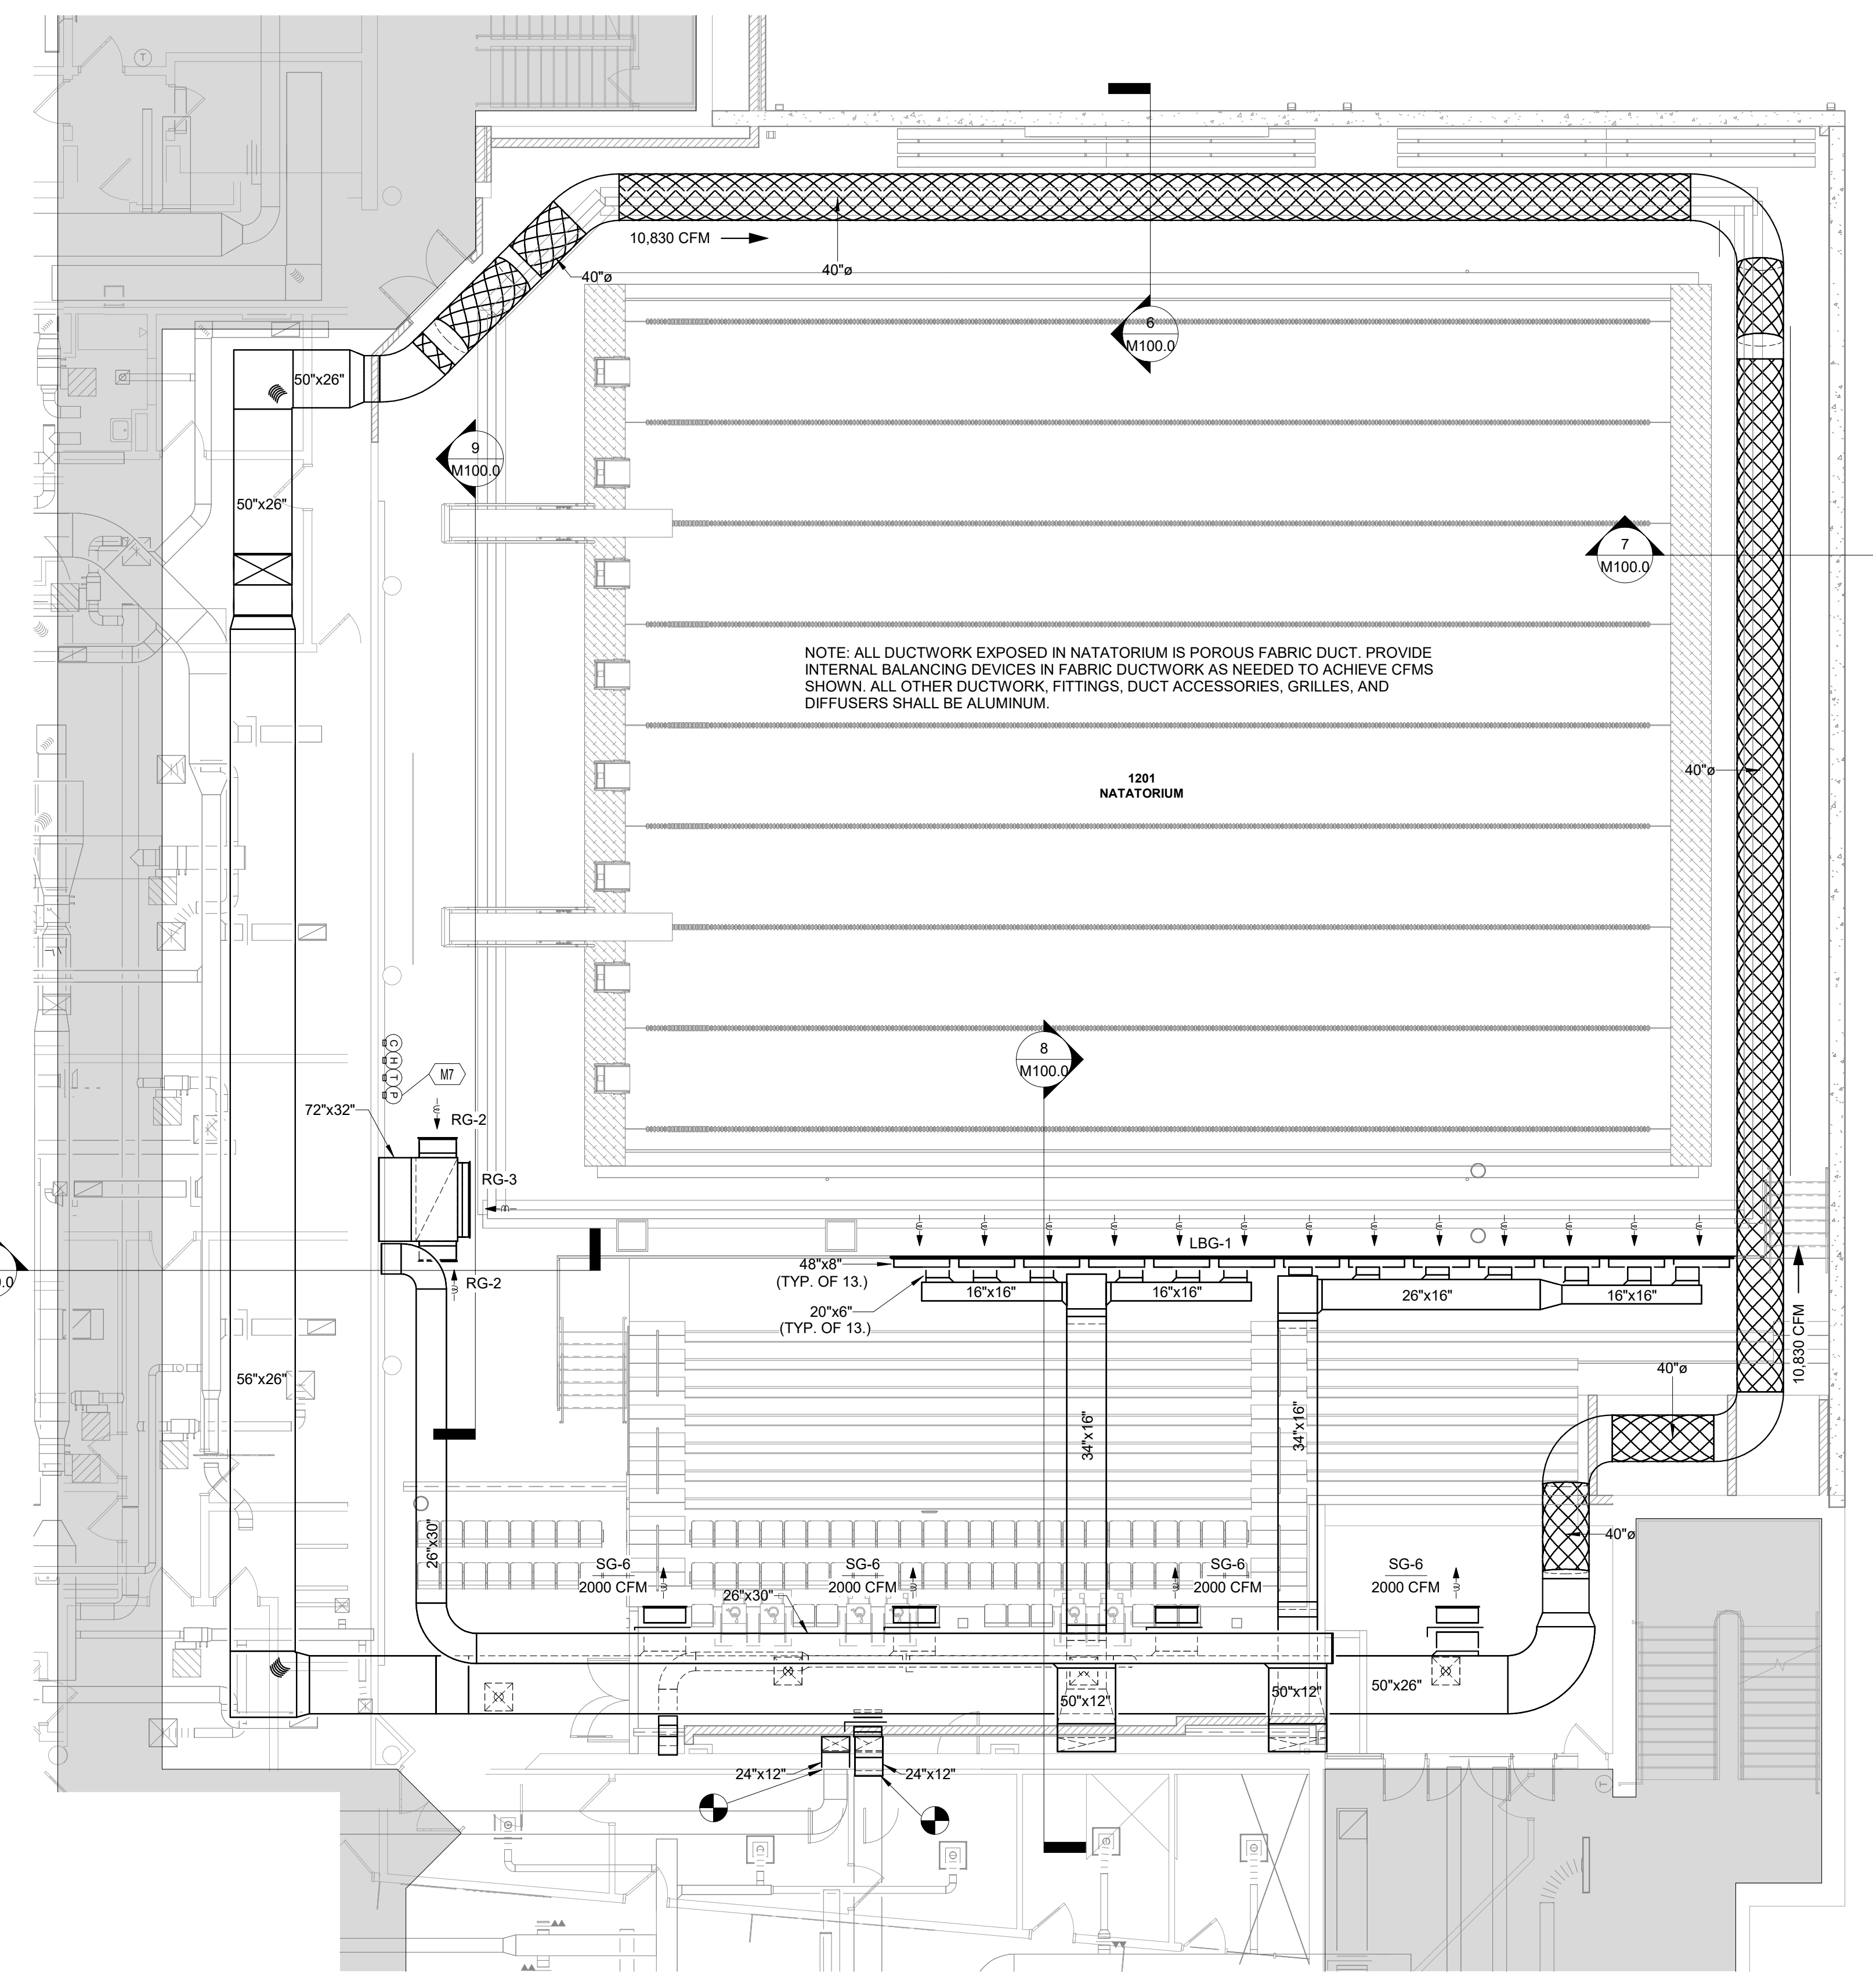

1 NATATORIUM DUCTWORK PLAN
M100.0 1/8" = 1'-0"

KEYNOTE LEGEND
M6 CONDENSATE PIPE DOWN TO UTILITY SINK IN PUMP ROOM.
M7 PROVIDE TWO PRESSURE SENSORS, ONE IN BREATHING ZONE (APPROX. 4' ABOVE FLOOR) AND ONE AS CLOSE TO ROOF AS POSSIBLE.
M57 BALANCE EXISTING GRILLE TO 650 CFM.
M58 EXTEND DUCT DOWN AND PLACE GRILLE 6' ABOVE THE FLOOR OF THE PIT.

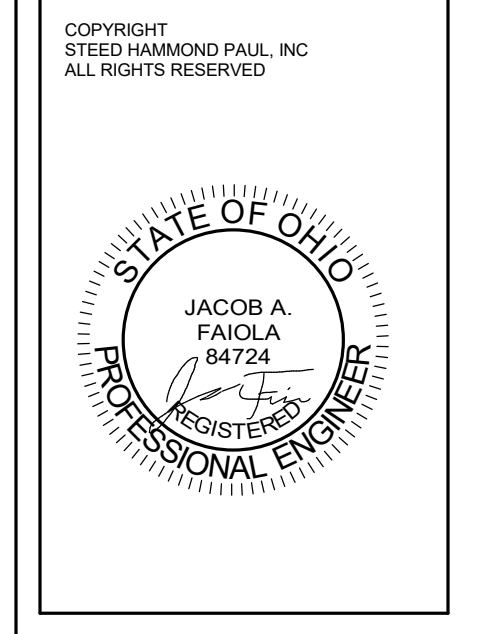

SHP
312 Plum St., Ste 700
Cincinnati, OH 45202
513.391.1112
1066 North 4th St., Ste 111
Bellevue, KY 41073
223 Fairfield Ave., Ste 100
Cincinnati, OH 43201
513.391.1124
857.300.1234

RENOVATION OF
SYCAMORE H.S. - SEGER NATATORIUM
7400 Cornell Road, Montgomery, OH 45242
SYCAMORE COMMUNITY SCHOOLS
5959 Hegeweg Drive, Cincinnati, OH 45242

ISSUANCES

1	09-02-22	DESIGN DEVELOPMENT
2	10-11-23	FOR CONSTRUCTION SET
3	11-02-23	PR-08
4	11-02-23	PR-08
5	11-02-23	PR-08
6	12-21-23	RFP-44
7	12-21-23	RFP-44
8	05-21-24	PR-10

NATATORIUM
MECHANICAL
PLANS

DATE 02-17-23
COMM NO. 2019147.09

M100.0

1'-0" REFERENCE LINE