




ISSUE INFORMATION


1 ISSUE FOR PERMIT & CONSTRUCTION 12.15.23

REVISIONS

1 PERMIT REVISION 02.19.24
2 PERMIT REVISION 02 07.22.24
3 PERMIT REVISION 03 11.06.24
8 PERMIT REVISION 08 08.08.25
9 PERMIT REVISION 08 05.09.25

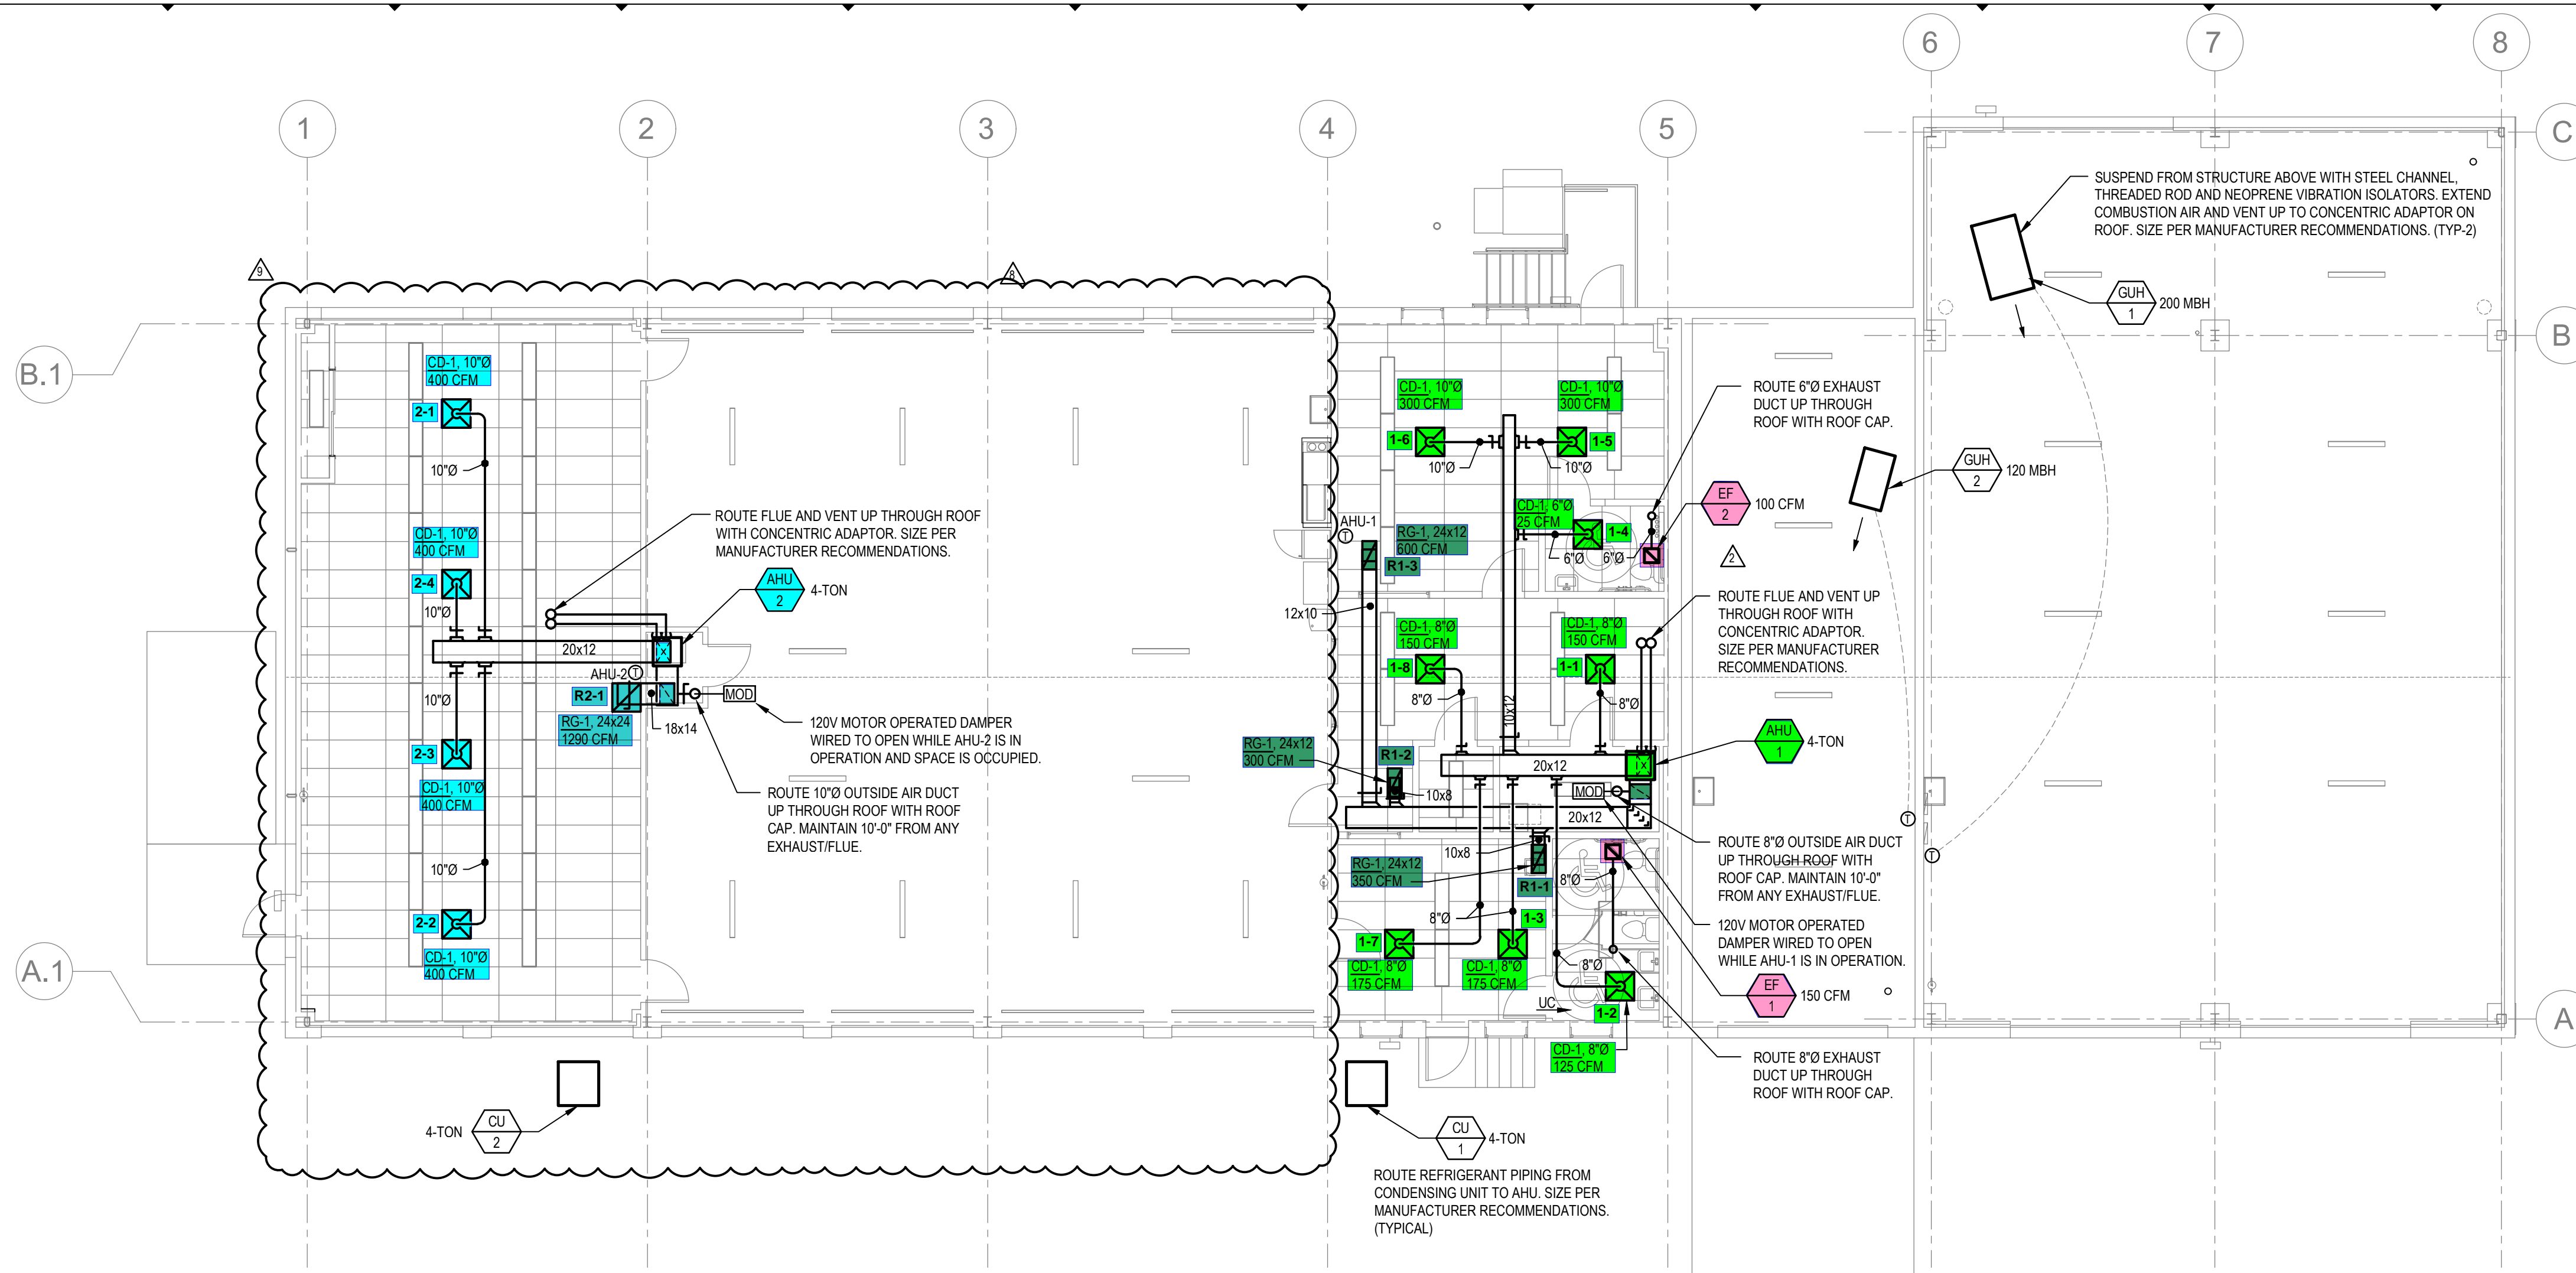

MECHANICAL PLAN
SCALE: 1/8" = 1' - 0"

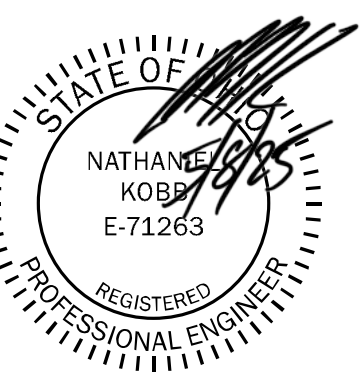

PROJECT INFORMATION

WAREHOUSE RENOVATION

LRC DAYTON, LLC
61 COMMERCE DRIVE
DAYTON, OH 45404

PROJECT #:
2373

SHEET INFORMATION

MECHANICAL PLAN

SCALE:
AS NOTED
AUTHORIZED FOR:
PERMIT

M-02