


H.E.S. SYSTEM

MECHANICAL CONTRACTOR TO PROVIDE AND INSTALL SUCTION/ST-LES SYSTEM FOR ALL NEW HOODS. SEE HOOD FAN/EQUIPMENT INTERLOCK WIRING DIAGRAM ON SHEET MAF-FOR MORE INFORMATION.

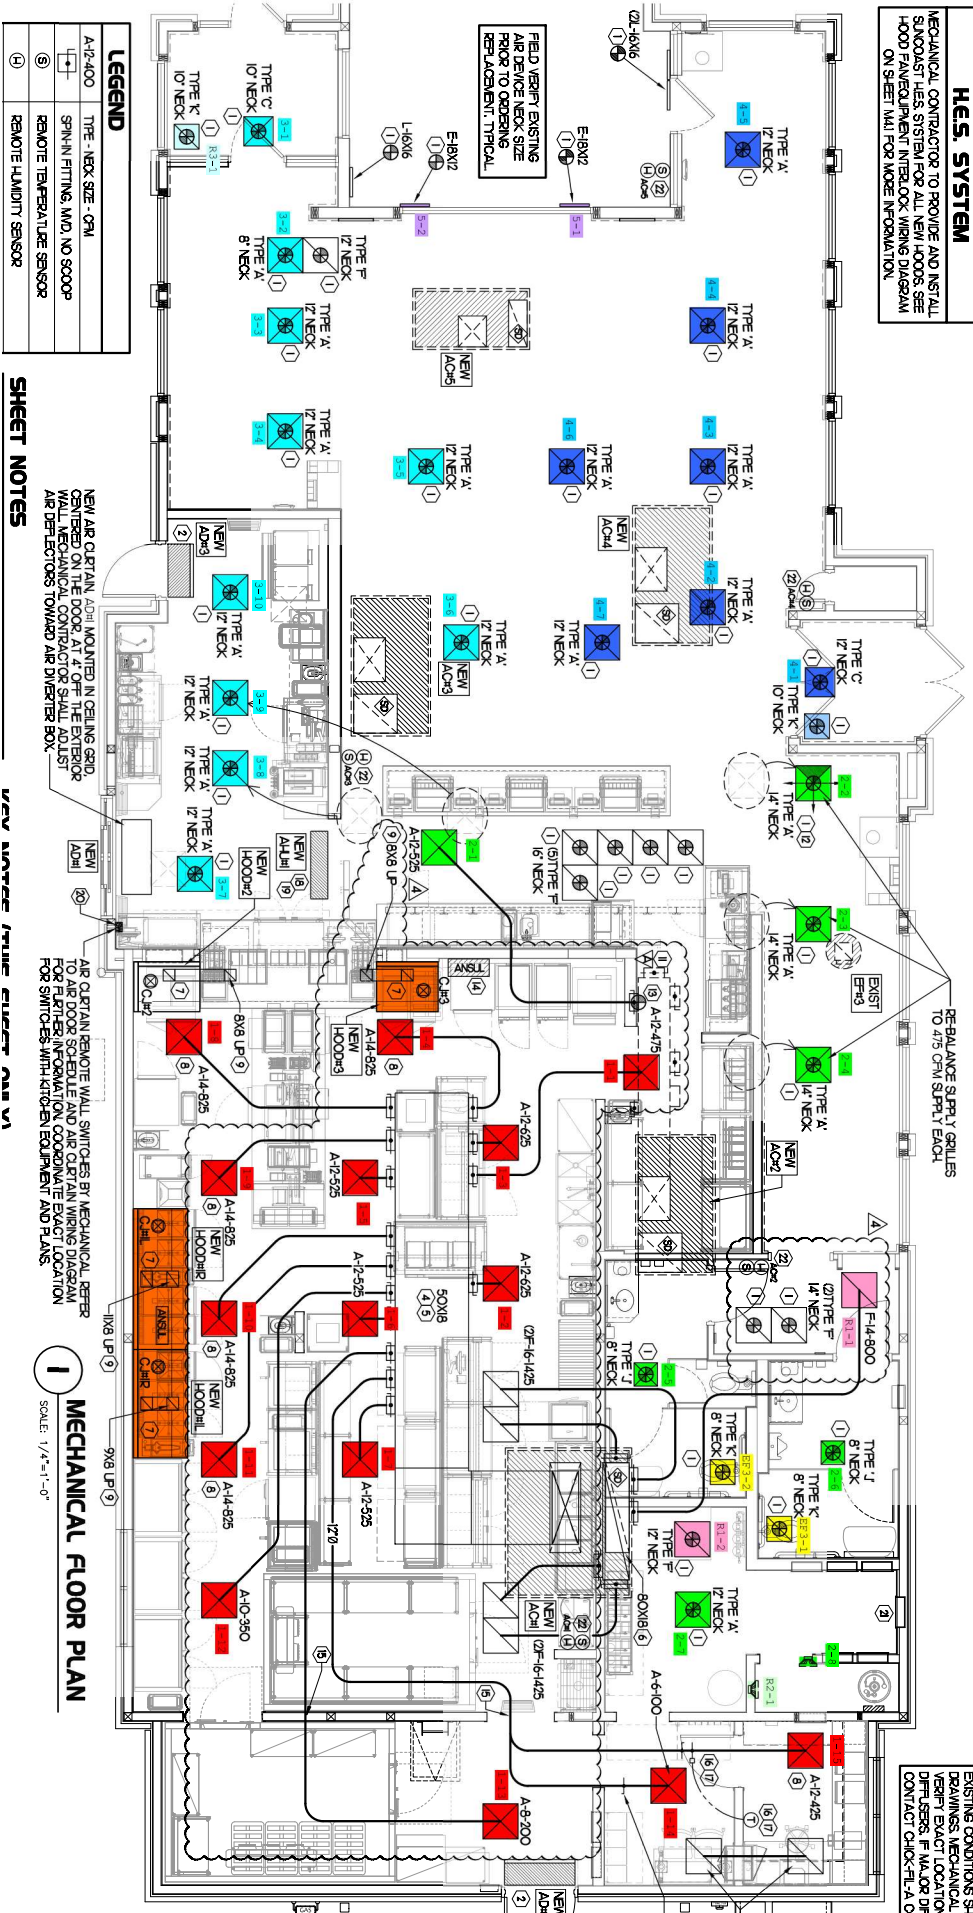

LEGEND

A-1/4-000	SPIN-IN FITTING, 1/4" O.D. NO SCOOP
③	RELOCATE TEMPERATURE SENSOR
④	RELOCATE HUMIDITY SENSOR

MECHANICAL FLOOR PLAN

NEW AIR CURTAIN, 12" HIGH, NO NETS IN CEILING GRID. SEE MAF FOR CEILING GRID AND AIR CURTAIN WALL MECHANICAL CONTRACTOR SHALL ADJUST AIR DEFLECTORS TOWARD AIR SWIRLER BOX.

AIR CURTAIN REMOVE WALL SWITCHES BY MECHANICAL REFER TO AIR DOOR SCHEDULE AND AIR CURTAIN WIRING DIAGRAM FOR SWITCH INFORMATION. COORDINATE EXIST LOCATION FOR SWITCHES WITH KITCHEN EQUIPMENT AND PLANS.

FIELD VERIFY EXISTING AIR DEVICE NECK SIZE PRIOR TO ORDERING REPLACEMENT. TYPICAL.

RE-BALANCE SUPPLY GRILLES TO 475 CFM SUPPLY EACH.

EXISTING CONDITIONS SHOWN ARE FROM PREVIOUS DRAWINGS. MECHANICAL CONTRACTOR SHALL FIELD VERIFY ALL CONDITIONS. DISCREPANCIES OCCUR IN FIELD, CONTACT CHECK-FILE A CONSTRUCTION MANAGER.

RE-SKIN MOTOR, MOUNTS ON EQUIPMENT MANUALLY LOCKING OUBERAIN HANDLE. TYPICAL OF 2.

F-12-423 TRANSFER GRILLES NO BALANCING DAMPER.

HOLD BACK AT 42" AS DISCREPANCY TO LIMITED CLEARANCE ABOVE CEILING.

NEW WIRING / TYPICAL AIR V

SCALE: 1/4"=1'-0"