




9 HVAC DINING ROOM SECTION  
1/4" = 1'-0"

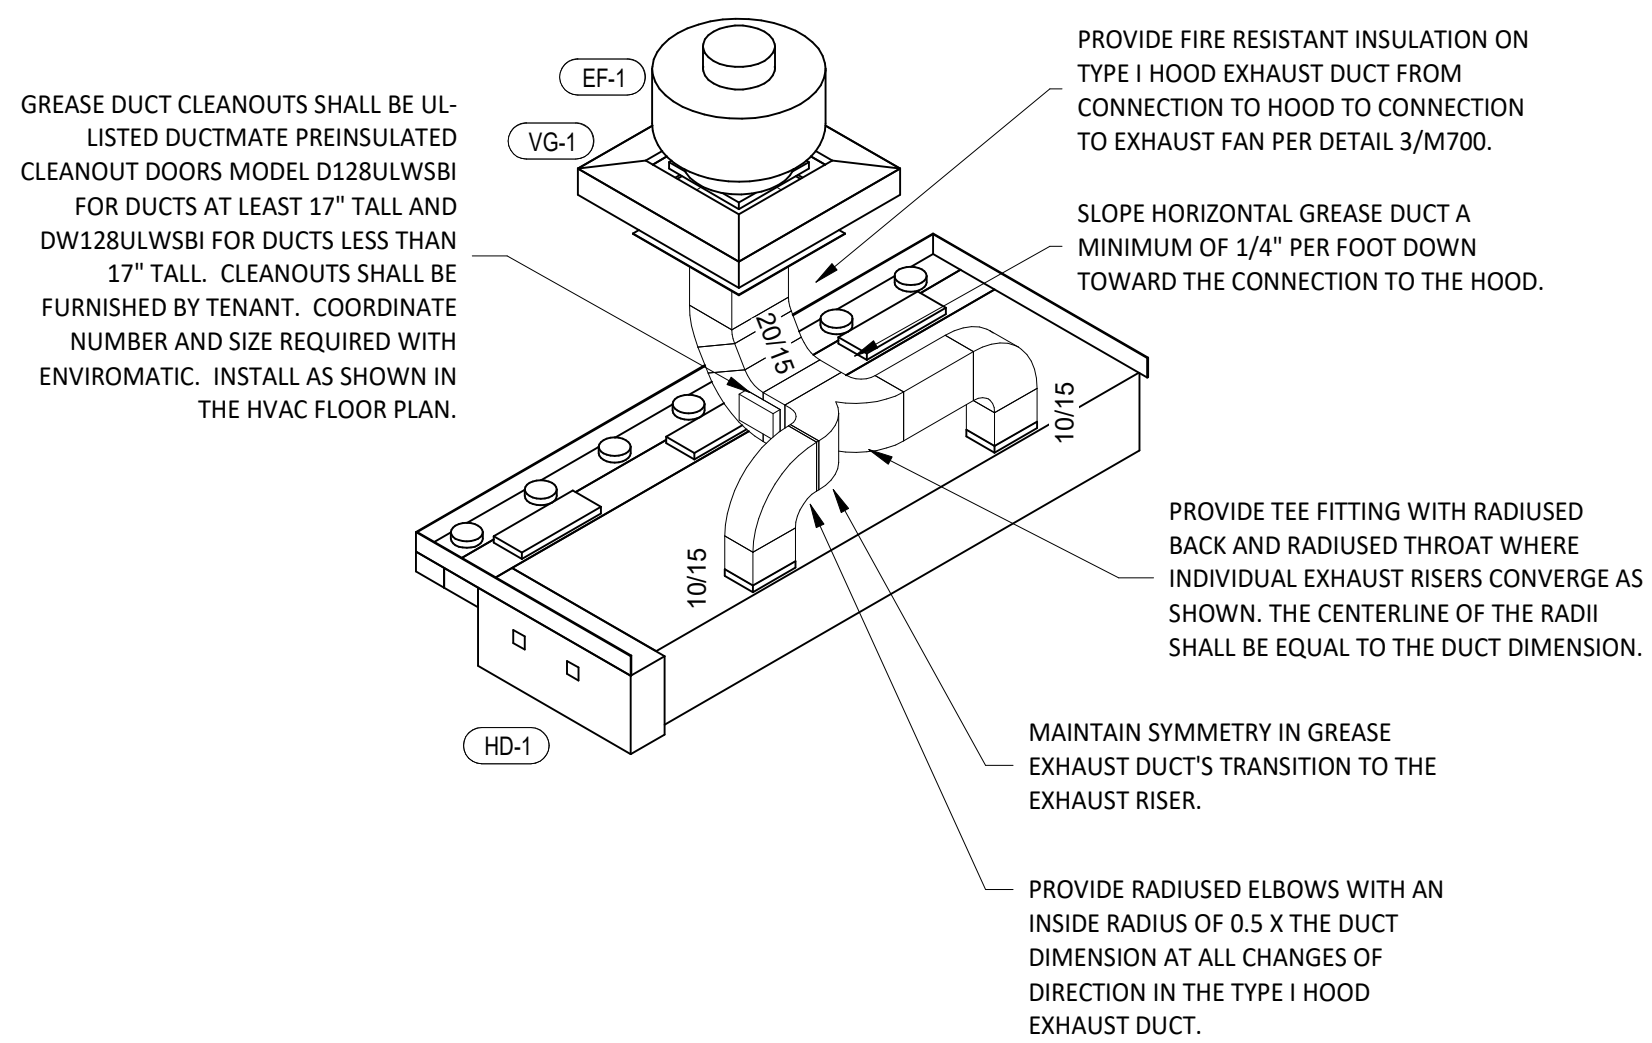


8 HOOD EXHAUST ISOMETRIC  
N.T.S.

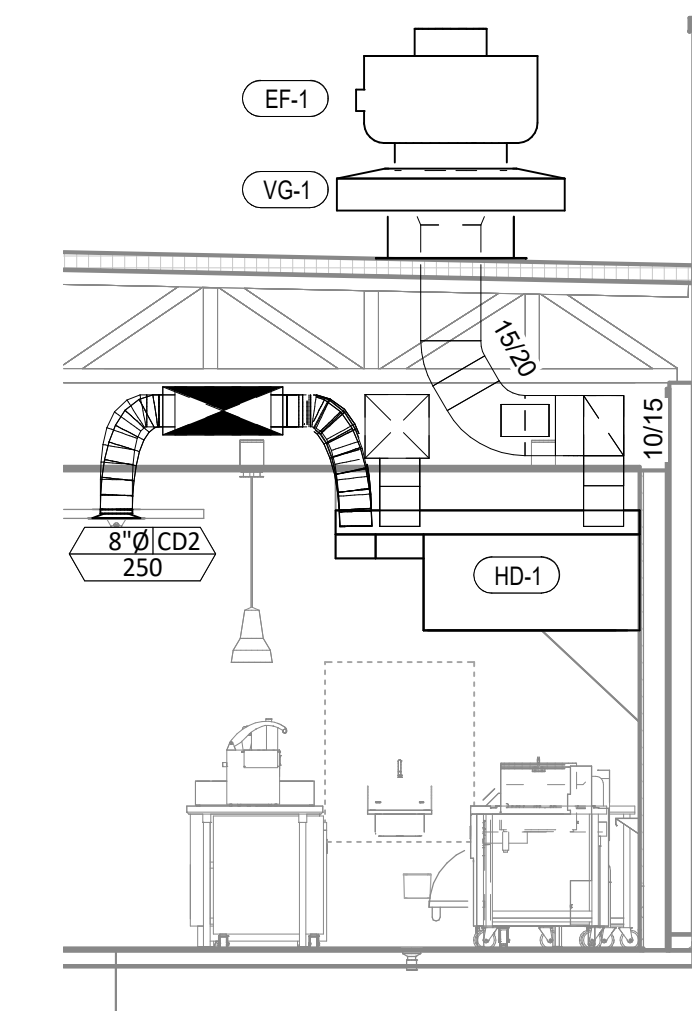


7 DUCT SECTION AT HOOD  
1/4" = 1'-0"

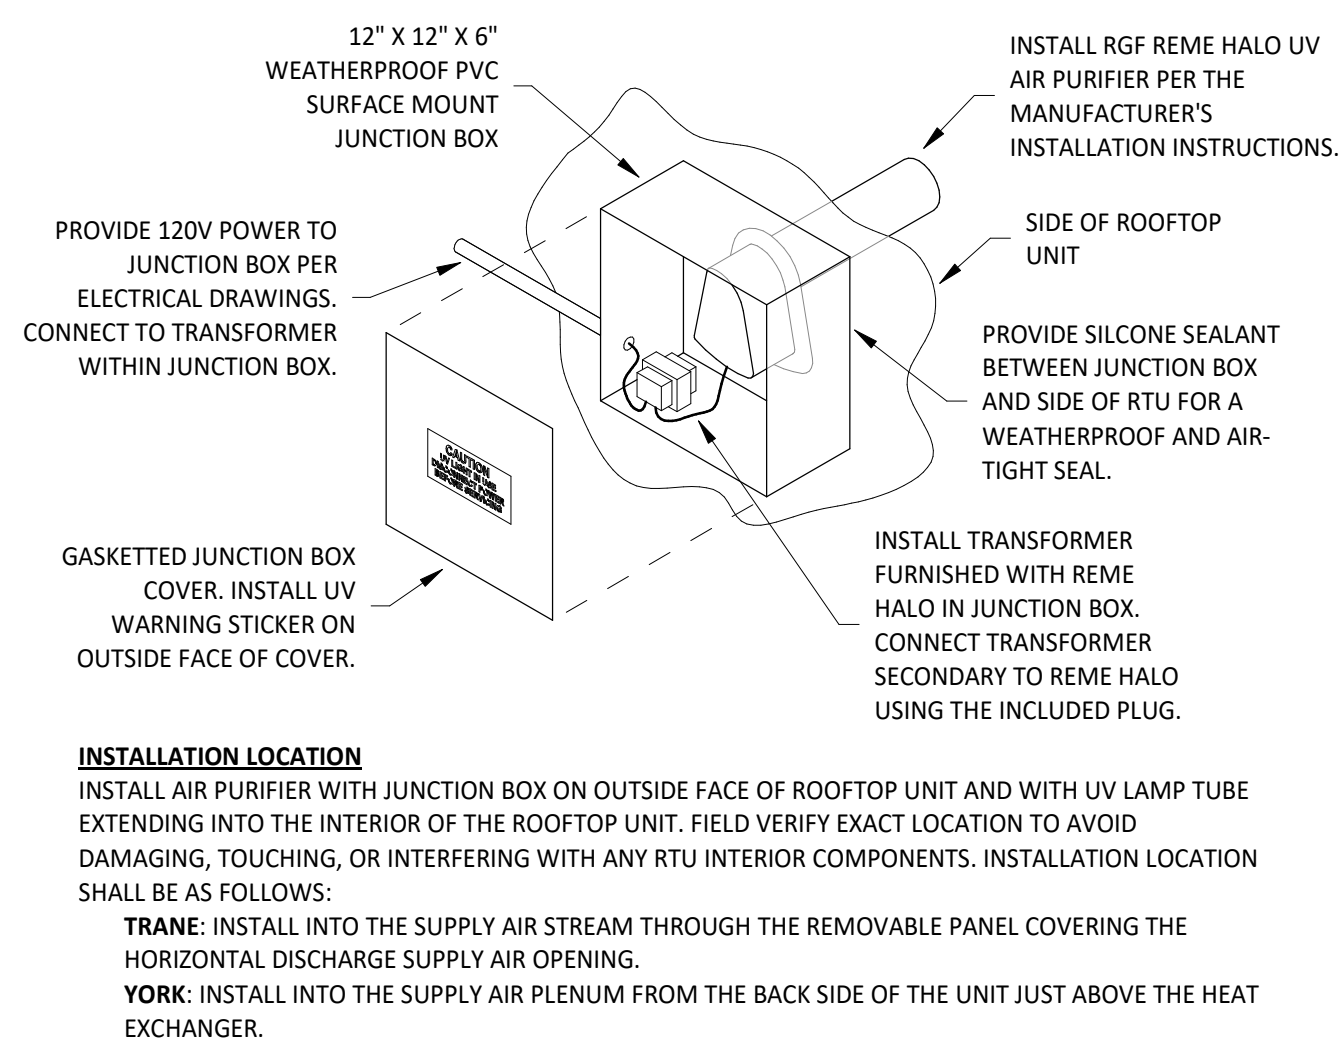


6 UV AIR PURIFIER INSTALLATION  
N.T.S.

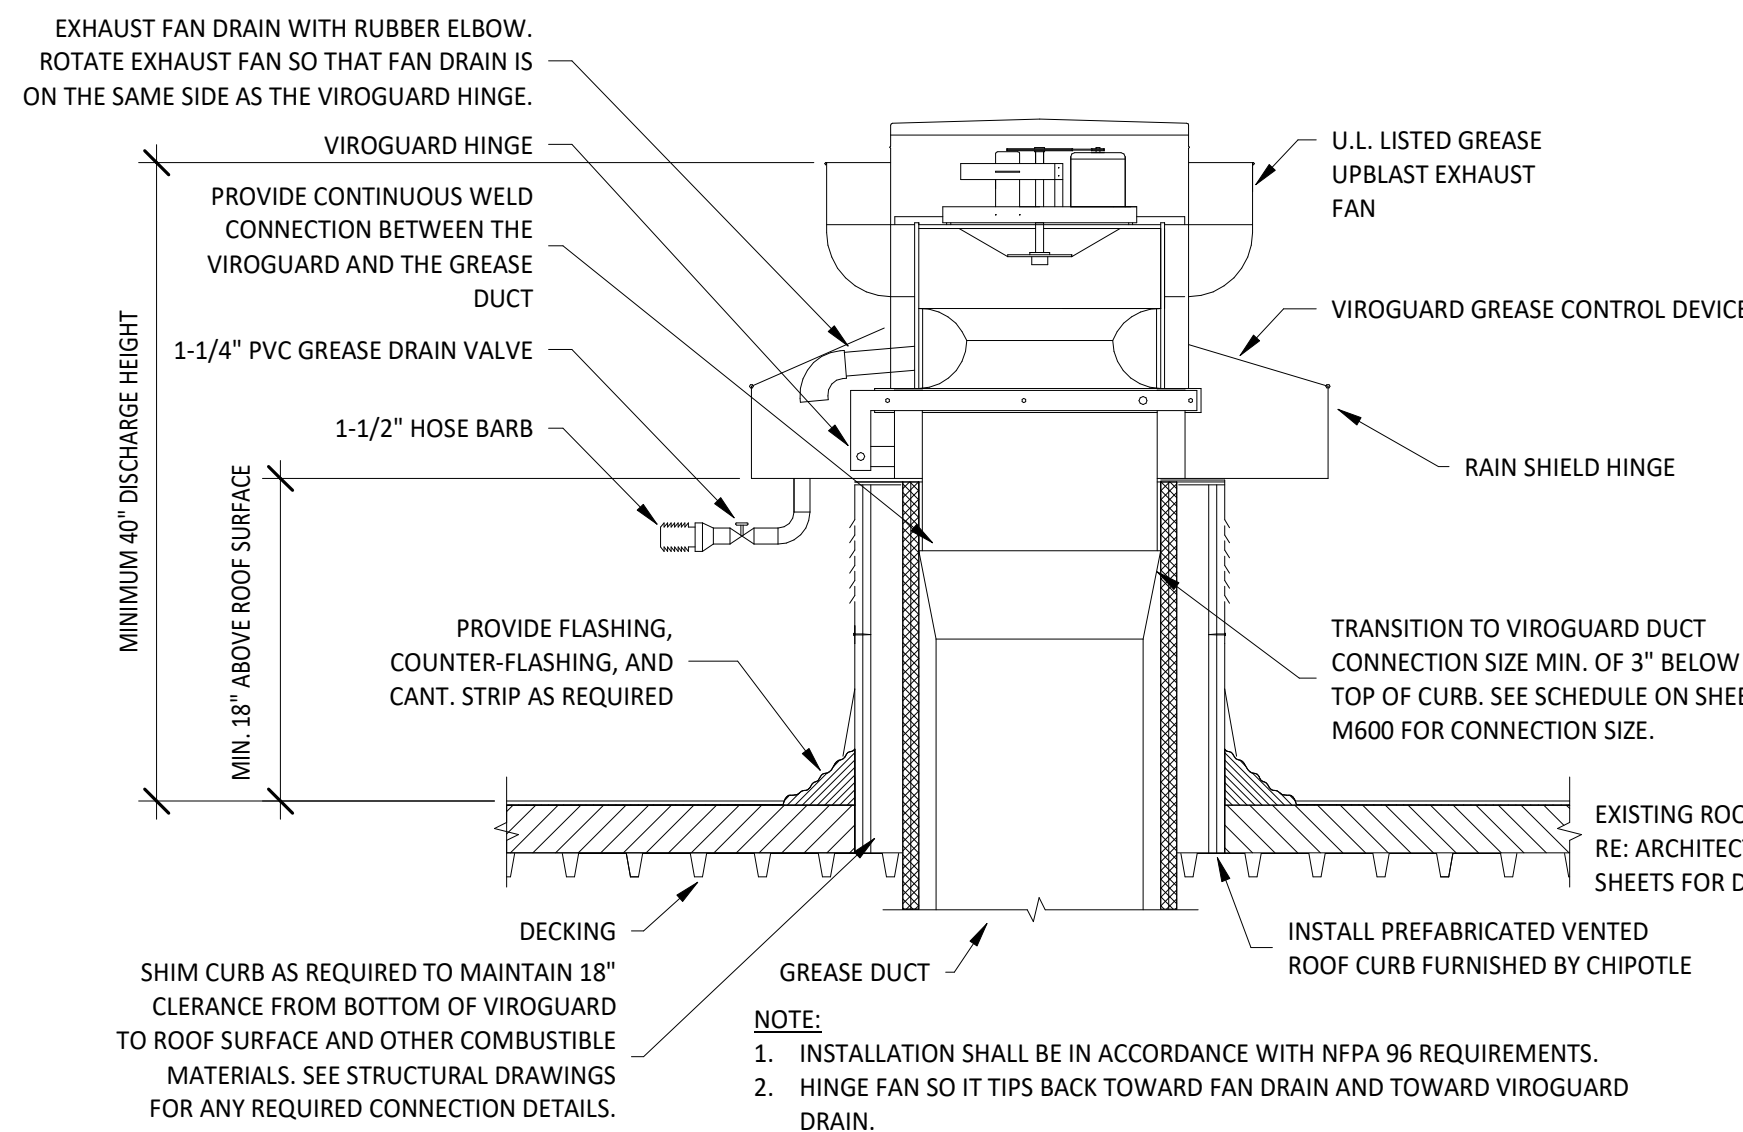


5 GREASE EXHAUST FAN  
N.T.S.

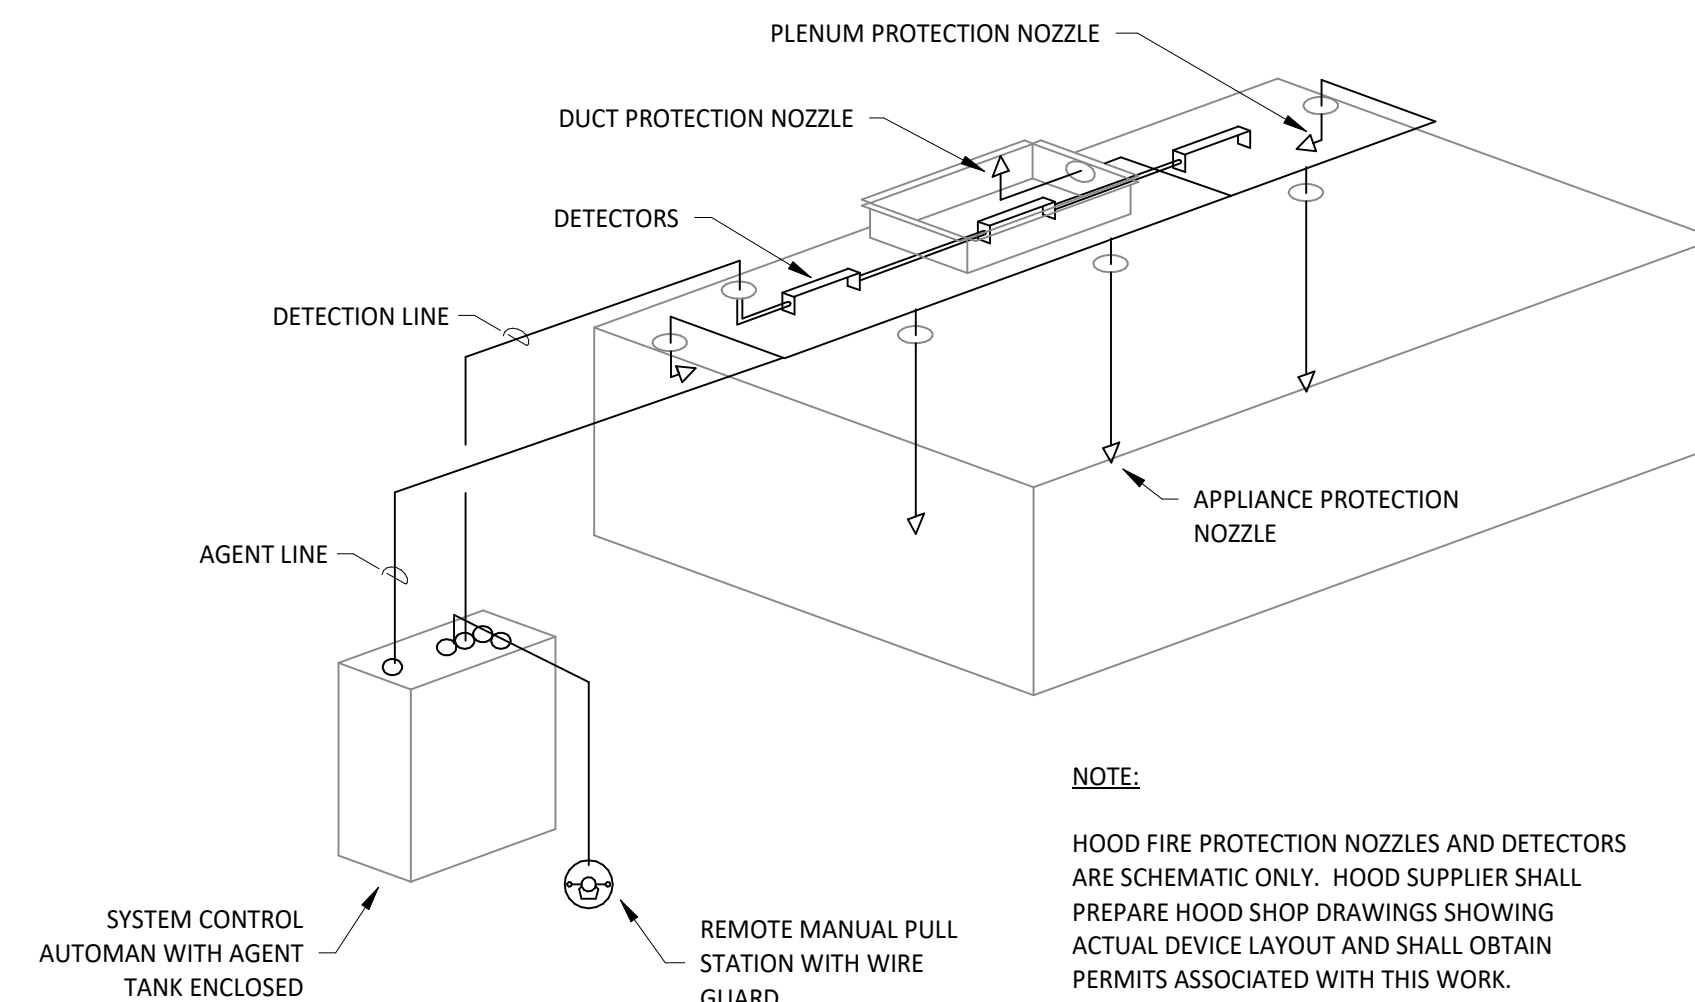


4 FIRE SUPPRESSION SYSTEM SCHEMATIC  
N.T.S.

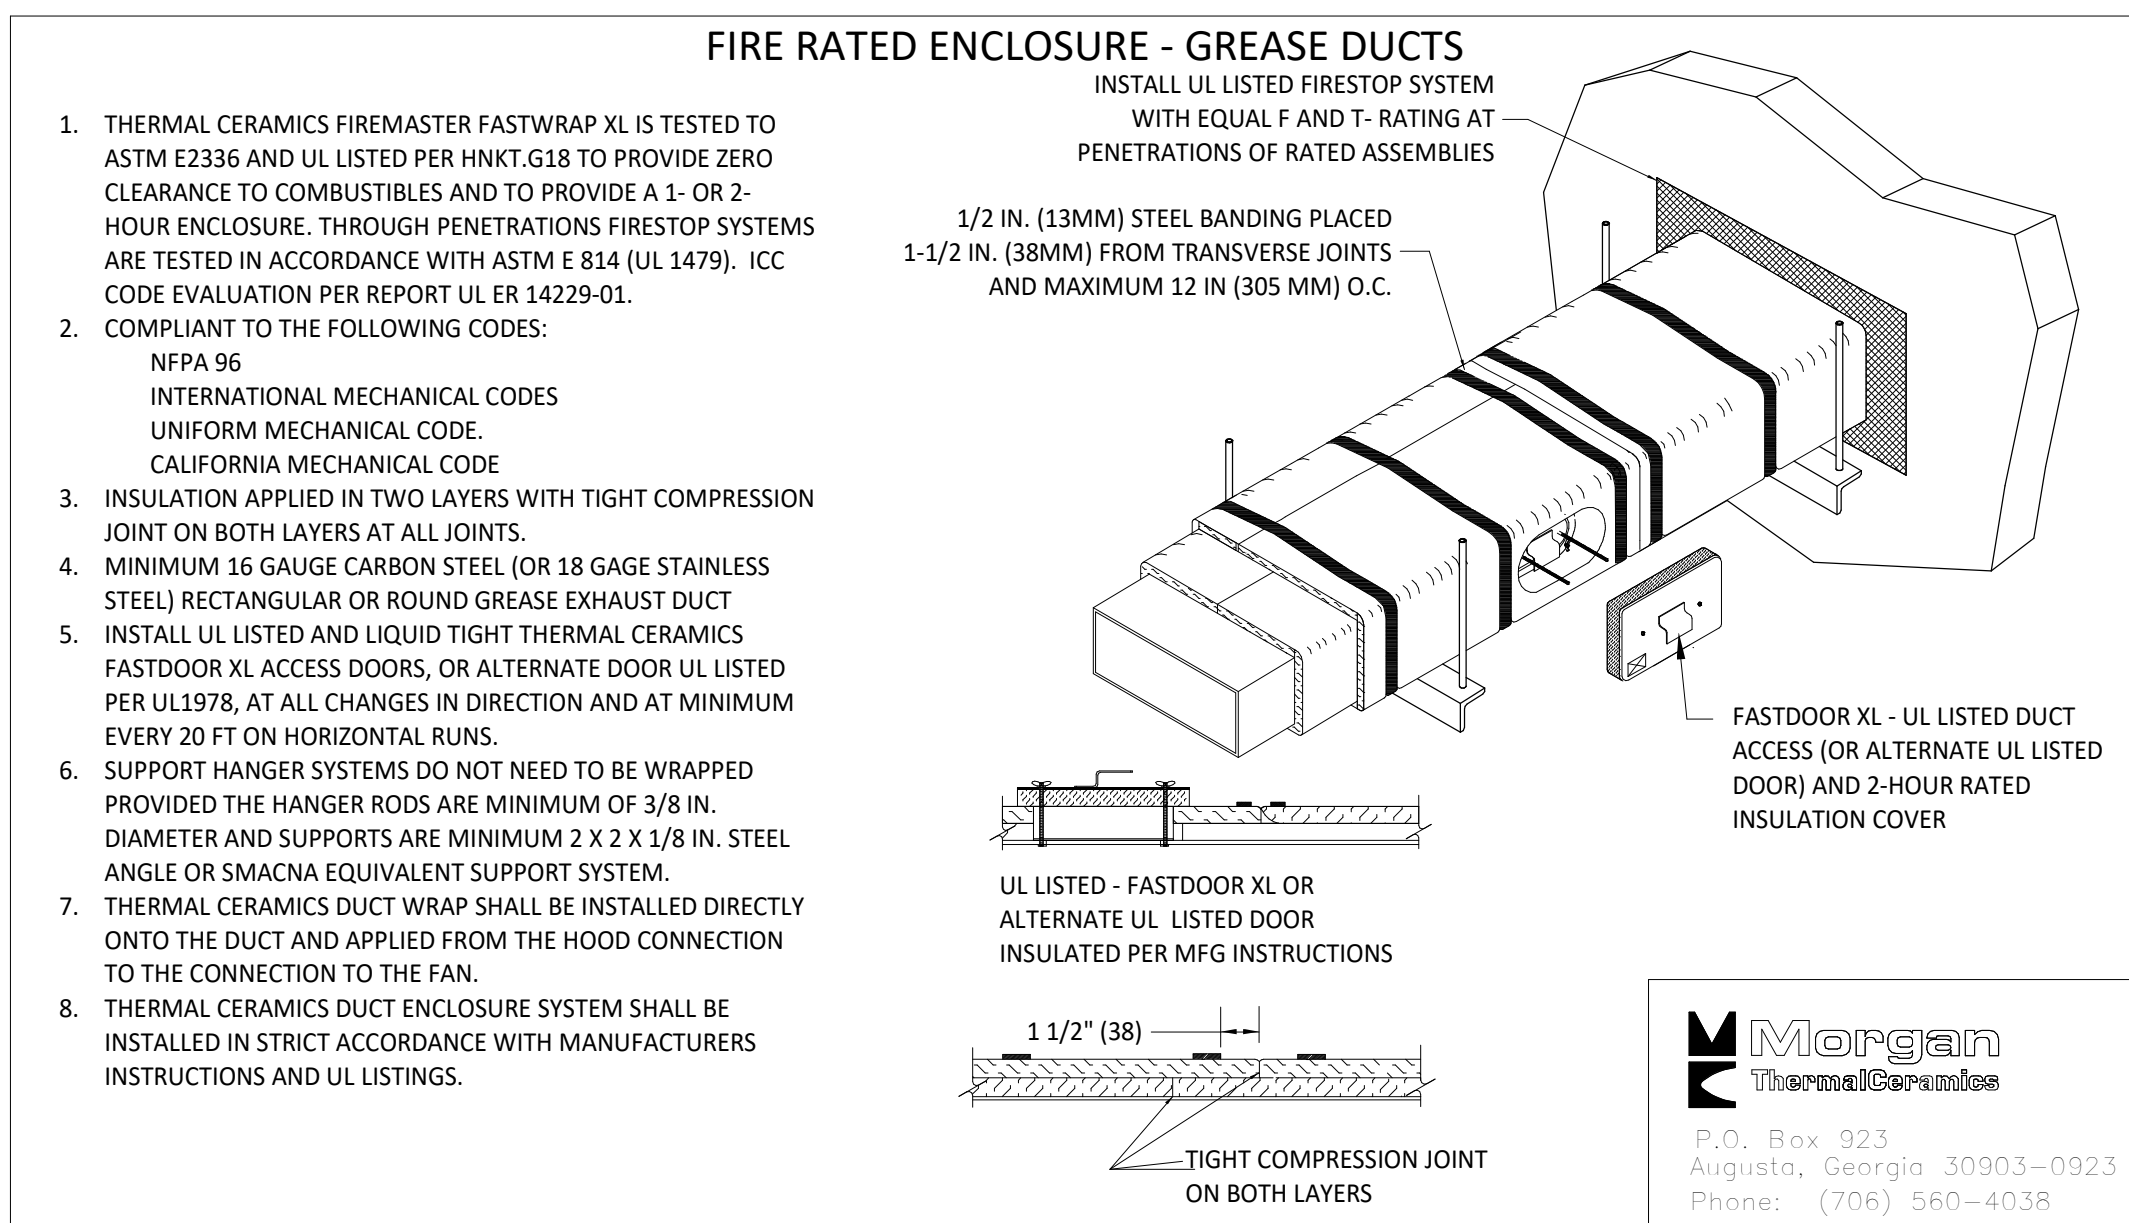

3 FIREMASTER DUCT WRAP - UL HNKT-G18  
N.T.S.

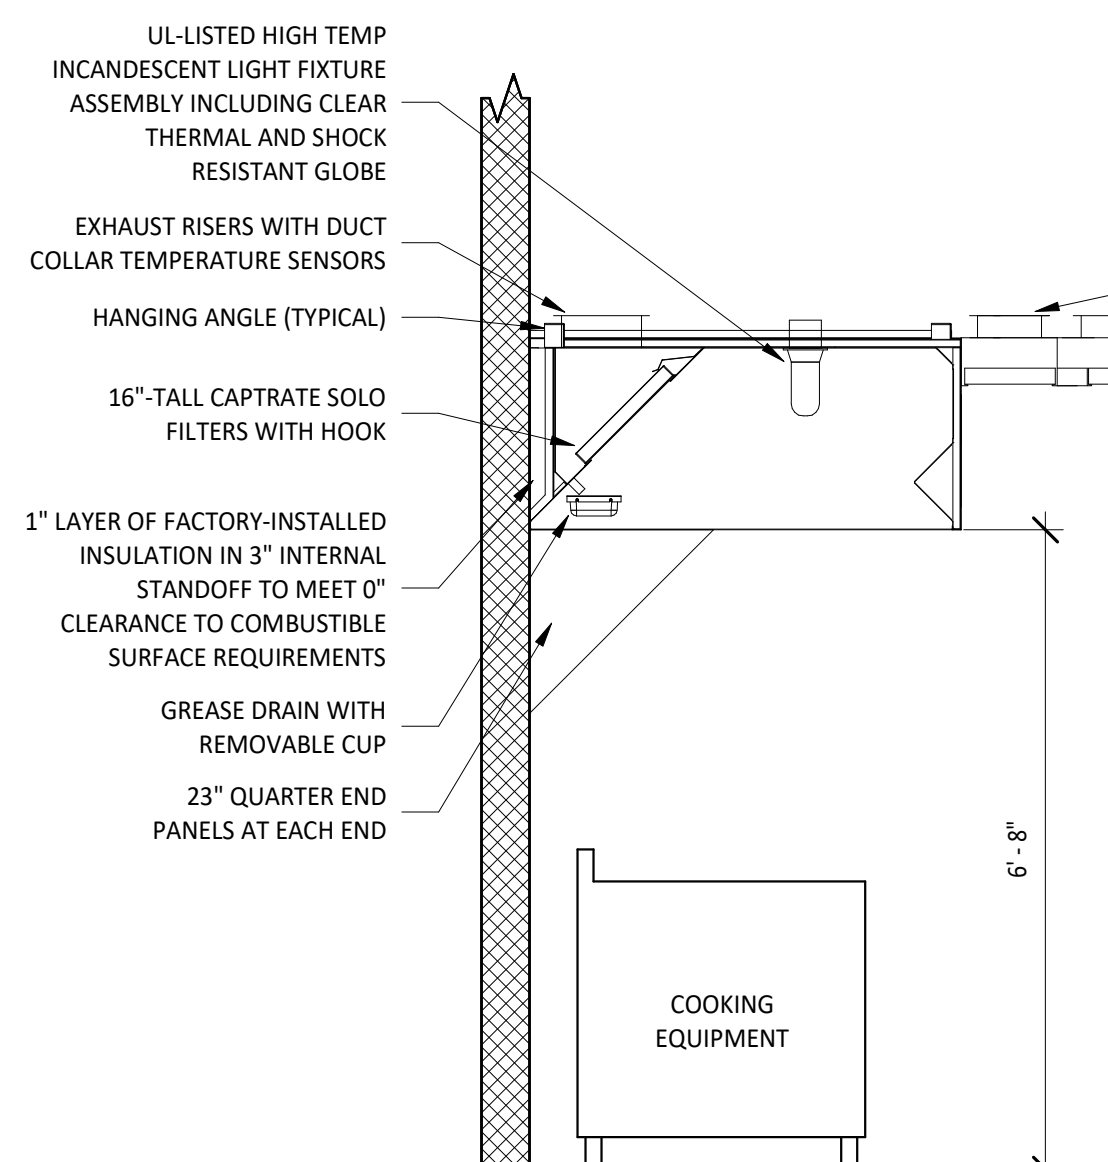


2 HOOD SECTION VIEW  
N.T.S.

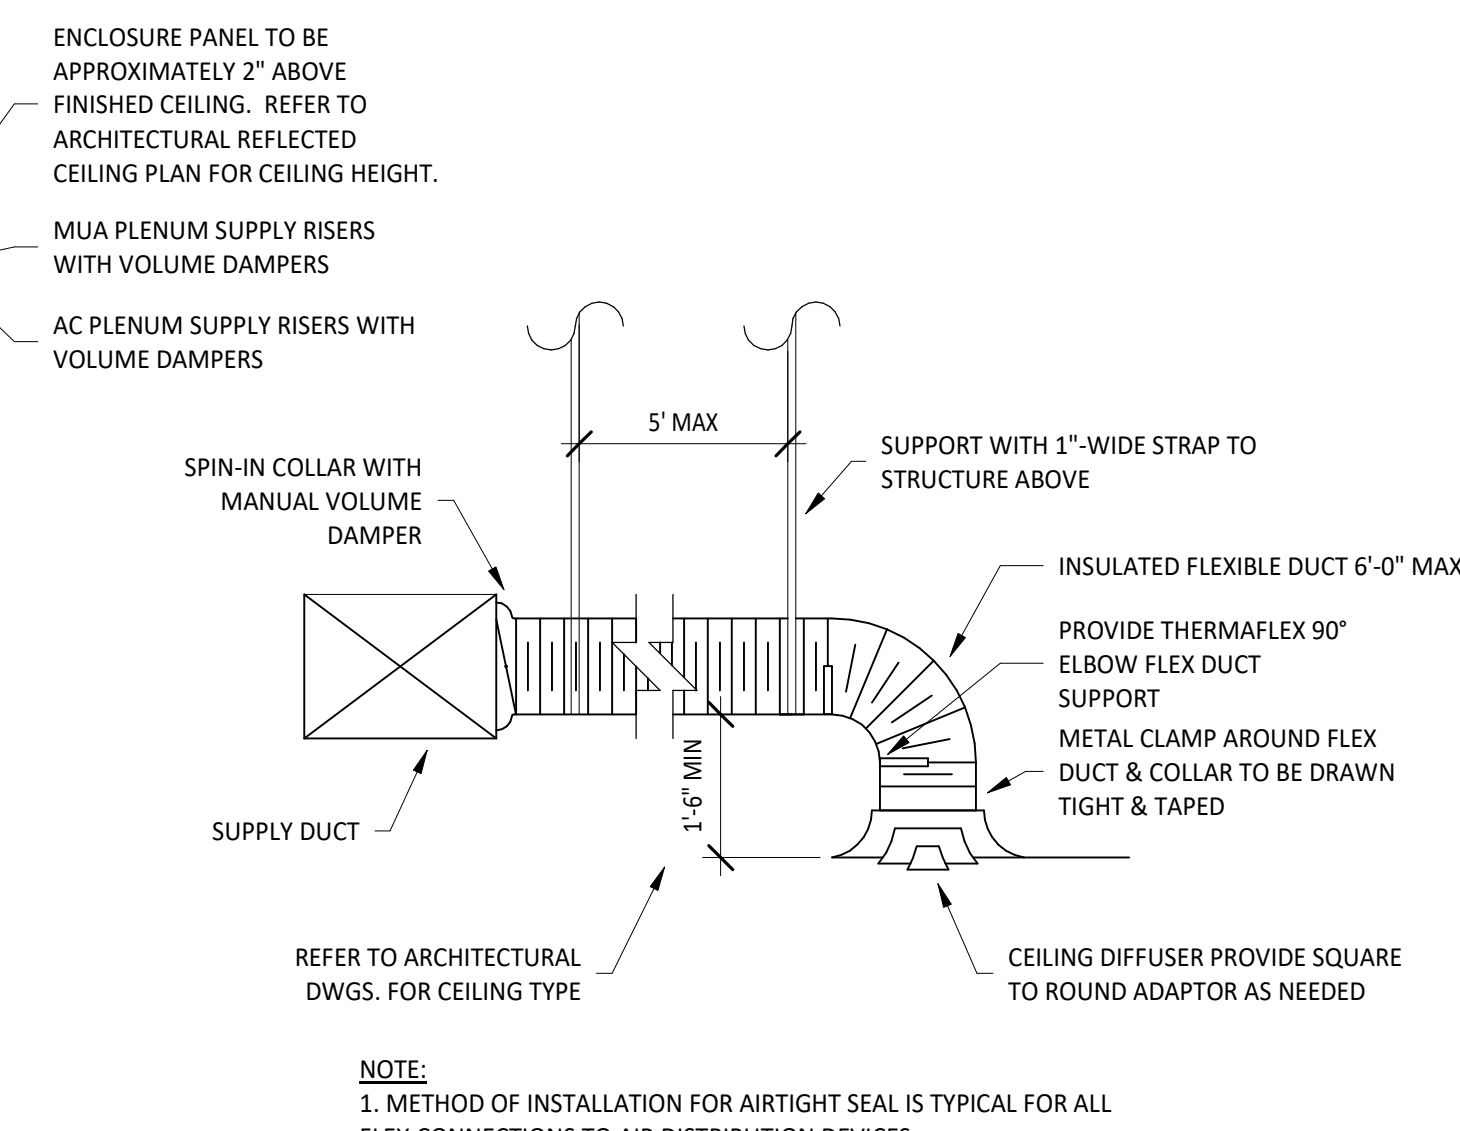

1 DIFFUSER CONNECTION  
N.T.S.

Consultant:  
**NE NATIONAL ENGINEERING**  
4635 Trueman Blvd, Suite 250  
Hilliard, Ohio 43026  
Phone: (614) 751-9610  
Fax: (614) 552-5240  
Contact: Allison Griswold  
(614) 328-2025  
Agriswold@nationalengineering.com

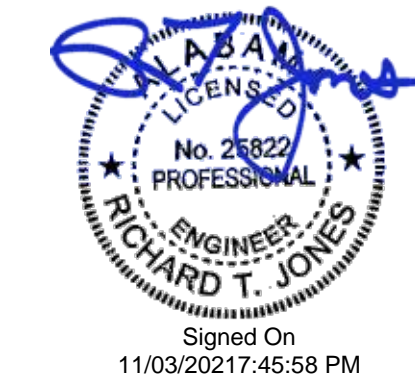

COPYRIGHT 2021  
THIS DRAWING IS AN INSTRUMENT OF SERVICE AND AS SUCH REMAINS THE PROPERTY OF CHIPOTLE MEXICAN GRILL, INC. PERMISSION FOR USE OF THIS DOCUMENT IS LIMITED AND CAN BE EXTENDED ONLY BY WRITTEN AGREEMENT WITH CHIPOTLE MEXICAN GRILL, INC.



CHIPOTLE MEXICAN GRILL, INC.  
PO BOX 182566  
COLUMBUS, OH 43218-2566  
TELEPHONE: (614) 318-2400  
INTERNET: WWW.CHIPOTLE.COM

STORE NO.: 4267  
FOLEY, AL  
TBD MCKENZIE STREET  
FOLEY, AL 36535

Issue Record:  
11/01/21 PERMIT ISSUE

Revisions:

Drawn: AMG Checked: MPC

Project No:  
2101146

Contents:  
HVAC DETAILS

M700