


MECHANICAL FLOOR PLAN-DUCT
SCALE: 1/4" = 1'-0"

Palisades Episcopal High School
13120 Grand Palisades Parkway
Charlotte, NC

GENERAL CONTRACTOR:
Metrolina
○ PRELIMINARY - NOT FOR CONSTRUCTION
○ FOR CONSTRUCTION
● SHOP DRAWINGS
○ AS-BUILT DRAWINGS

REVISIONS DATE

DRAWN BY: RJM
CHECKED BY: RJM
PROJECT: 24-777
DATE: xx/xx/xxxx
SHEET: 1 OF: 4

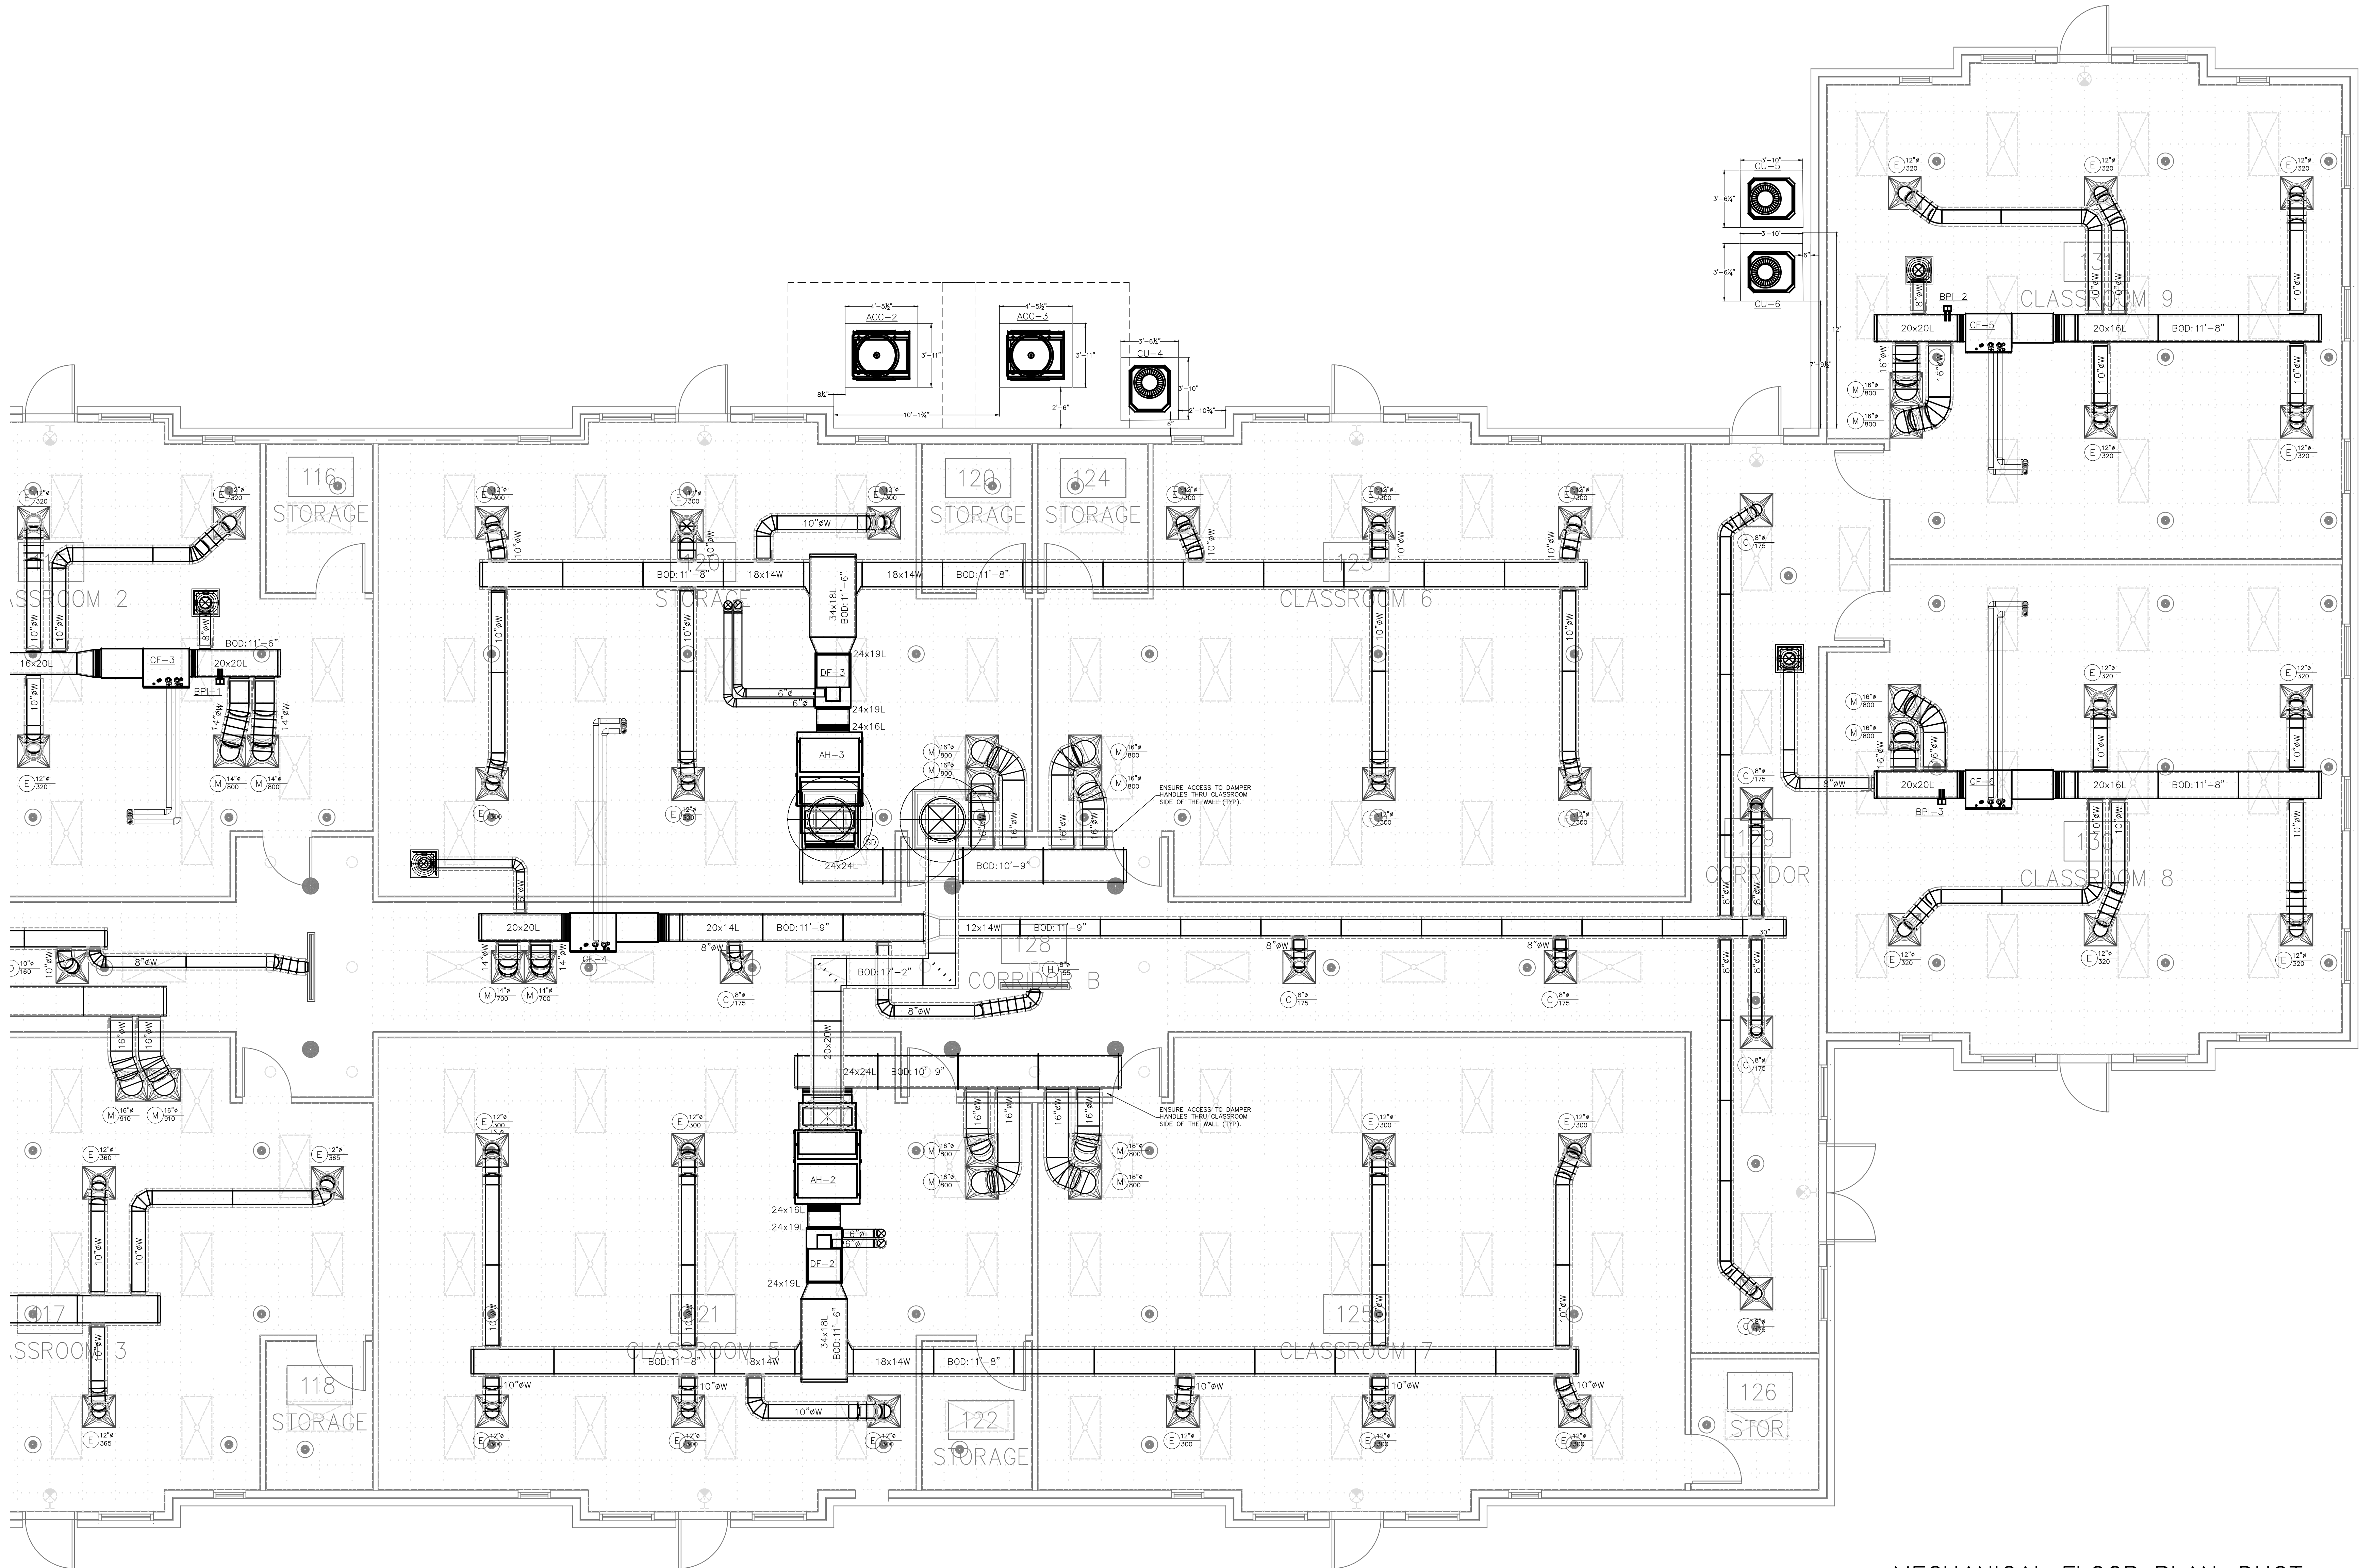

Palisades Episcopal High School
 13120 Grand Palisades Parkway
 Charlotte, NC


GENERAL CONTRACTOR:
 Metrolina

- PRELIMINARY - NOT FOR CONSTRUCTION
- FOR CONSTRUCTION
- SHOP DRAWINGS
- AS-BUILT DRAWINGS

REVISIONS	DATE

DRAWN BY: RJM
 CHECKED BY: RJM
 PROJECT: 24-777
 DATE: xx/xx/xxxx
 SHEET: 2 OF 4

MECHANICAL FLOOR PLAN-DUCT
 SCALE: 1/4"=1'-0"

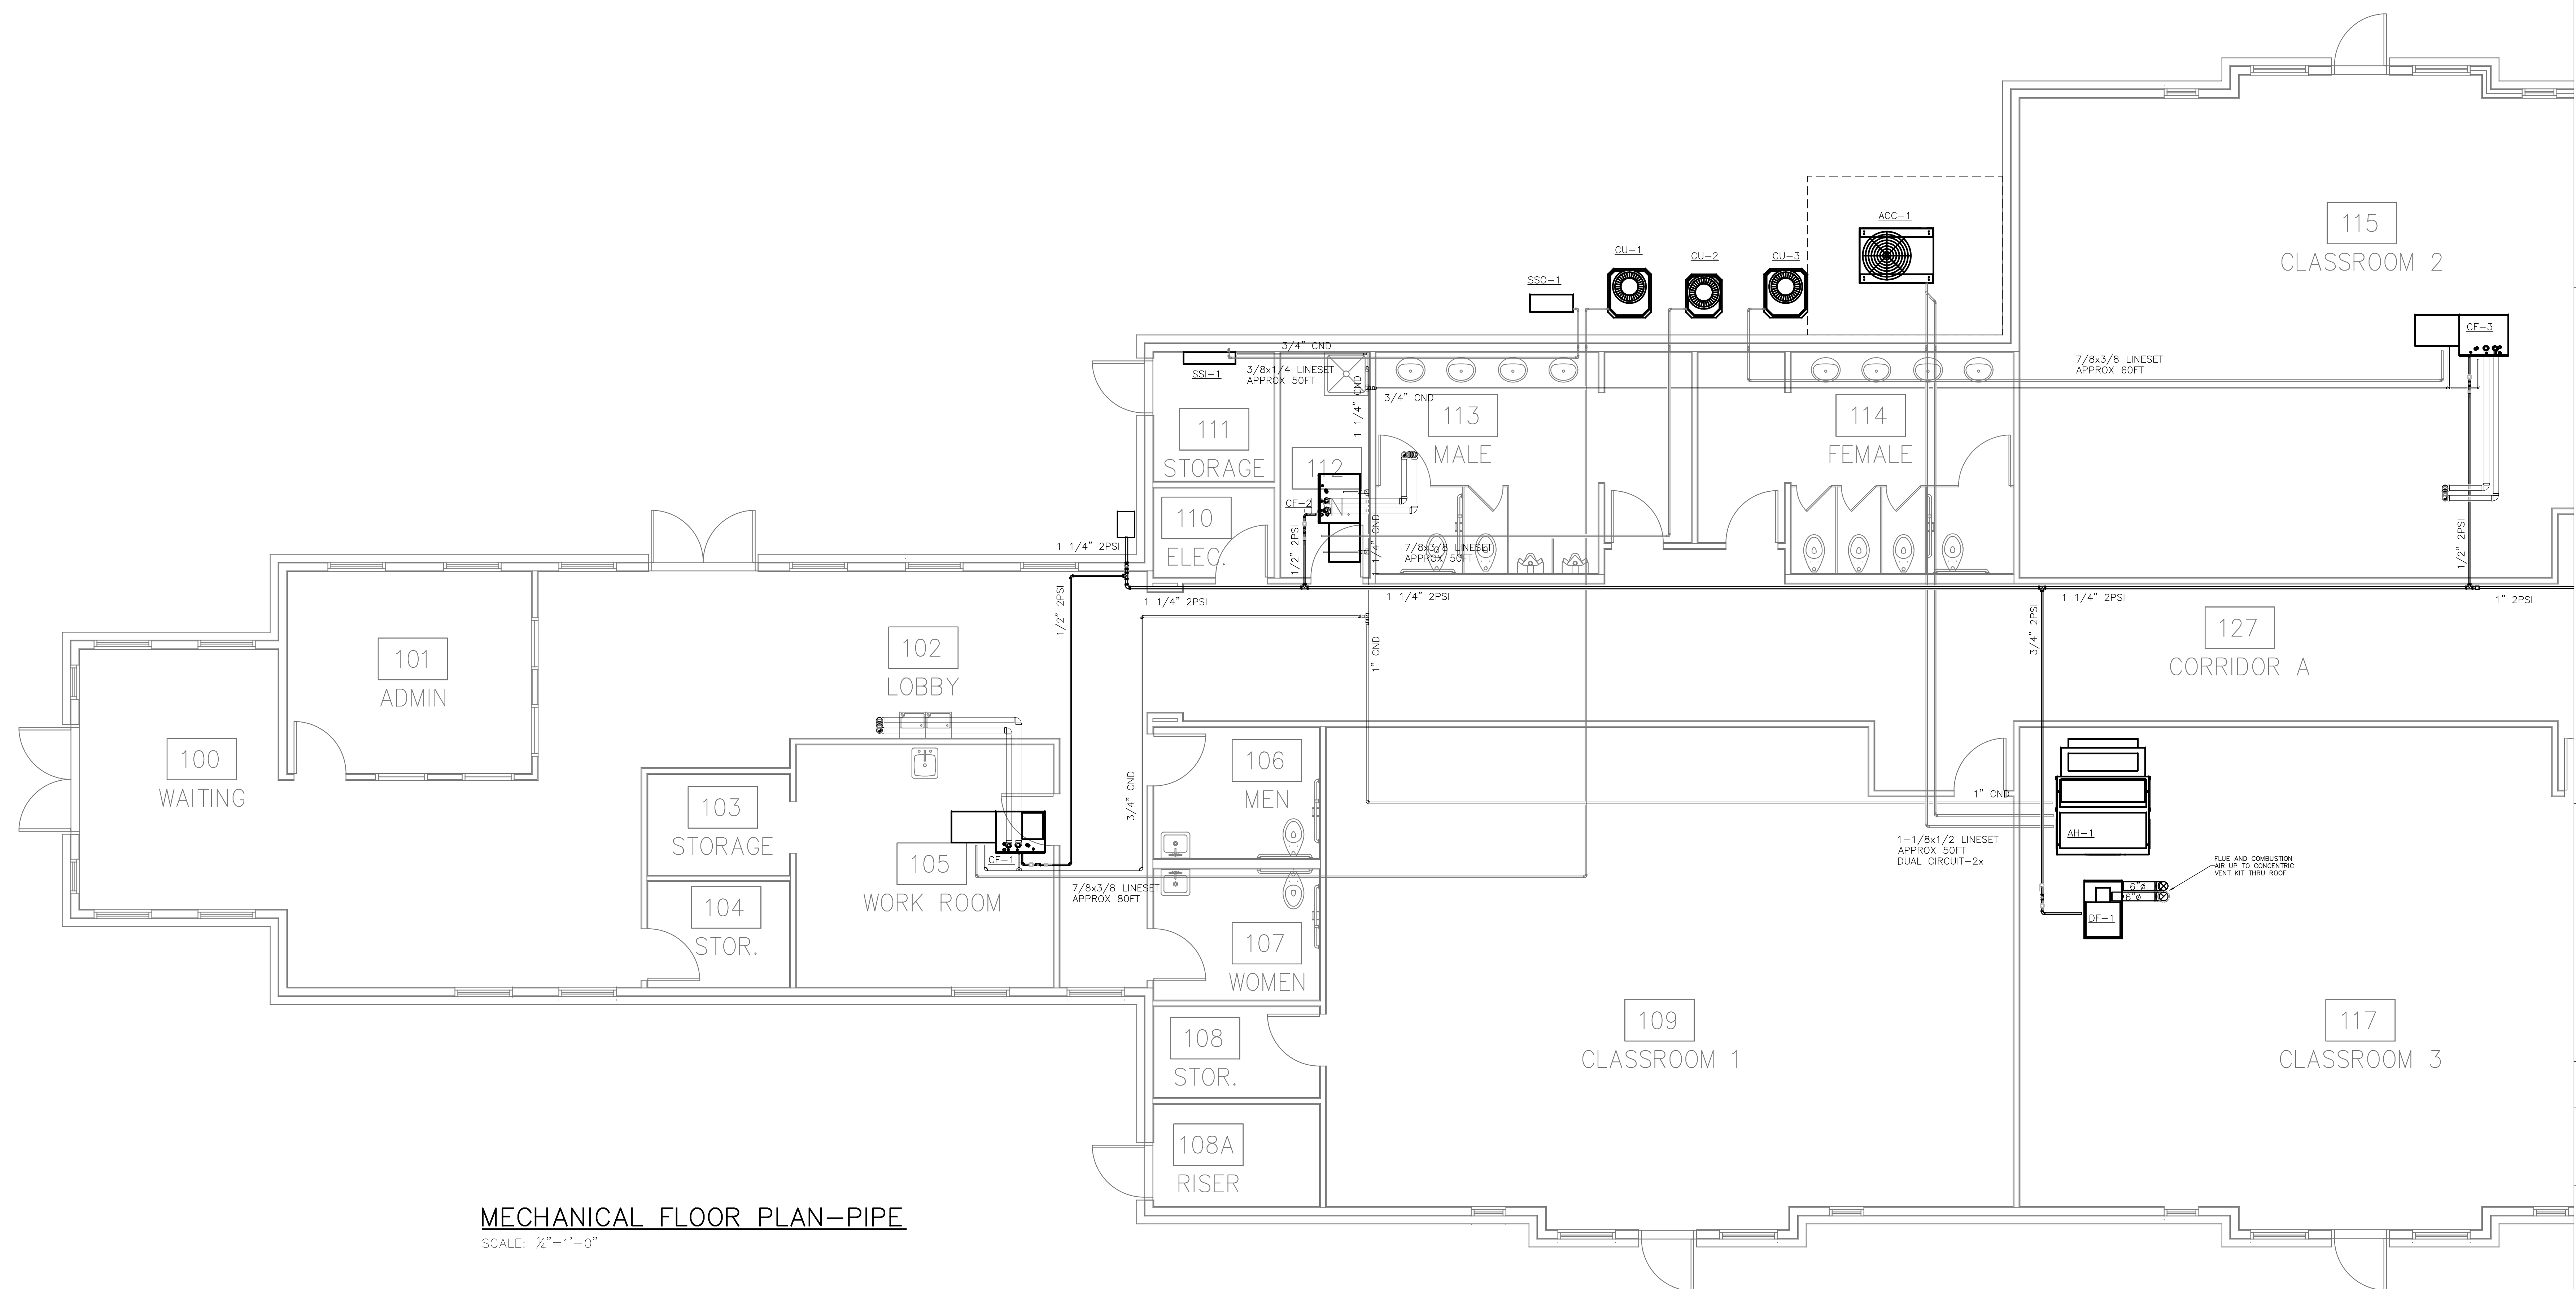

MECHANICAL FLOOR PLAN-PIPE
 SCALE: 1/4"=1'-0"


Palisades Episcopal High School
 13120 Grand Palisades Parkway
 Charlotte, NC

GENERAL CONTRACTOR:
 Metrolina

○ PRELIMINARY - NOT FOR CONSTRUCTION
 ○ FOR CONSTRUCTION
 ● SHOP DRAWINGS
 ○ AS-BUILT DRAWINGS

REVISIONS	DATE

DRAWN BY: RJM
 CHECKED BY: RJM
 PROJECT: 24-777
 DATE: xx/xx/xxxx
 SHEET: 3 OF 4

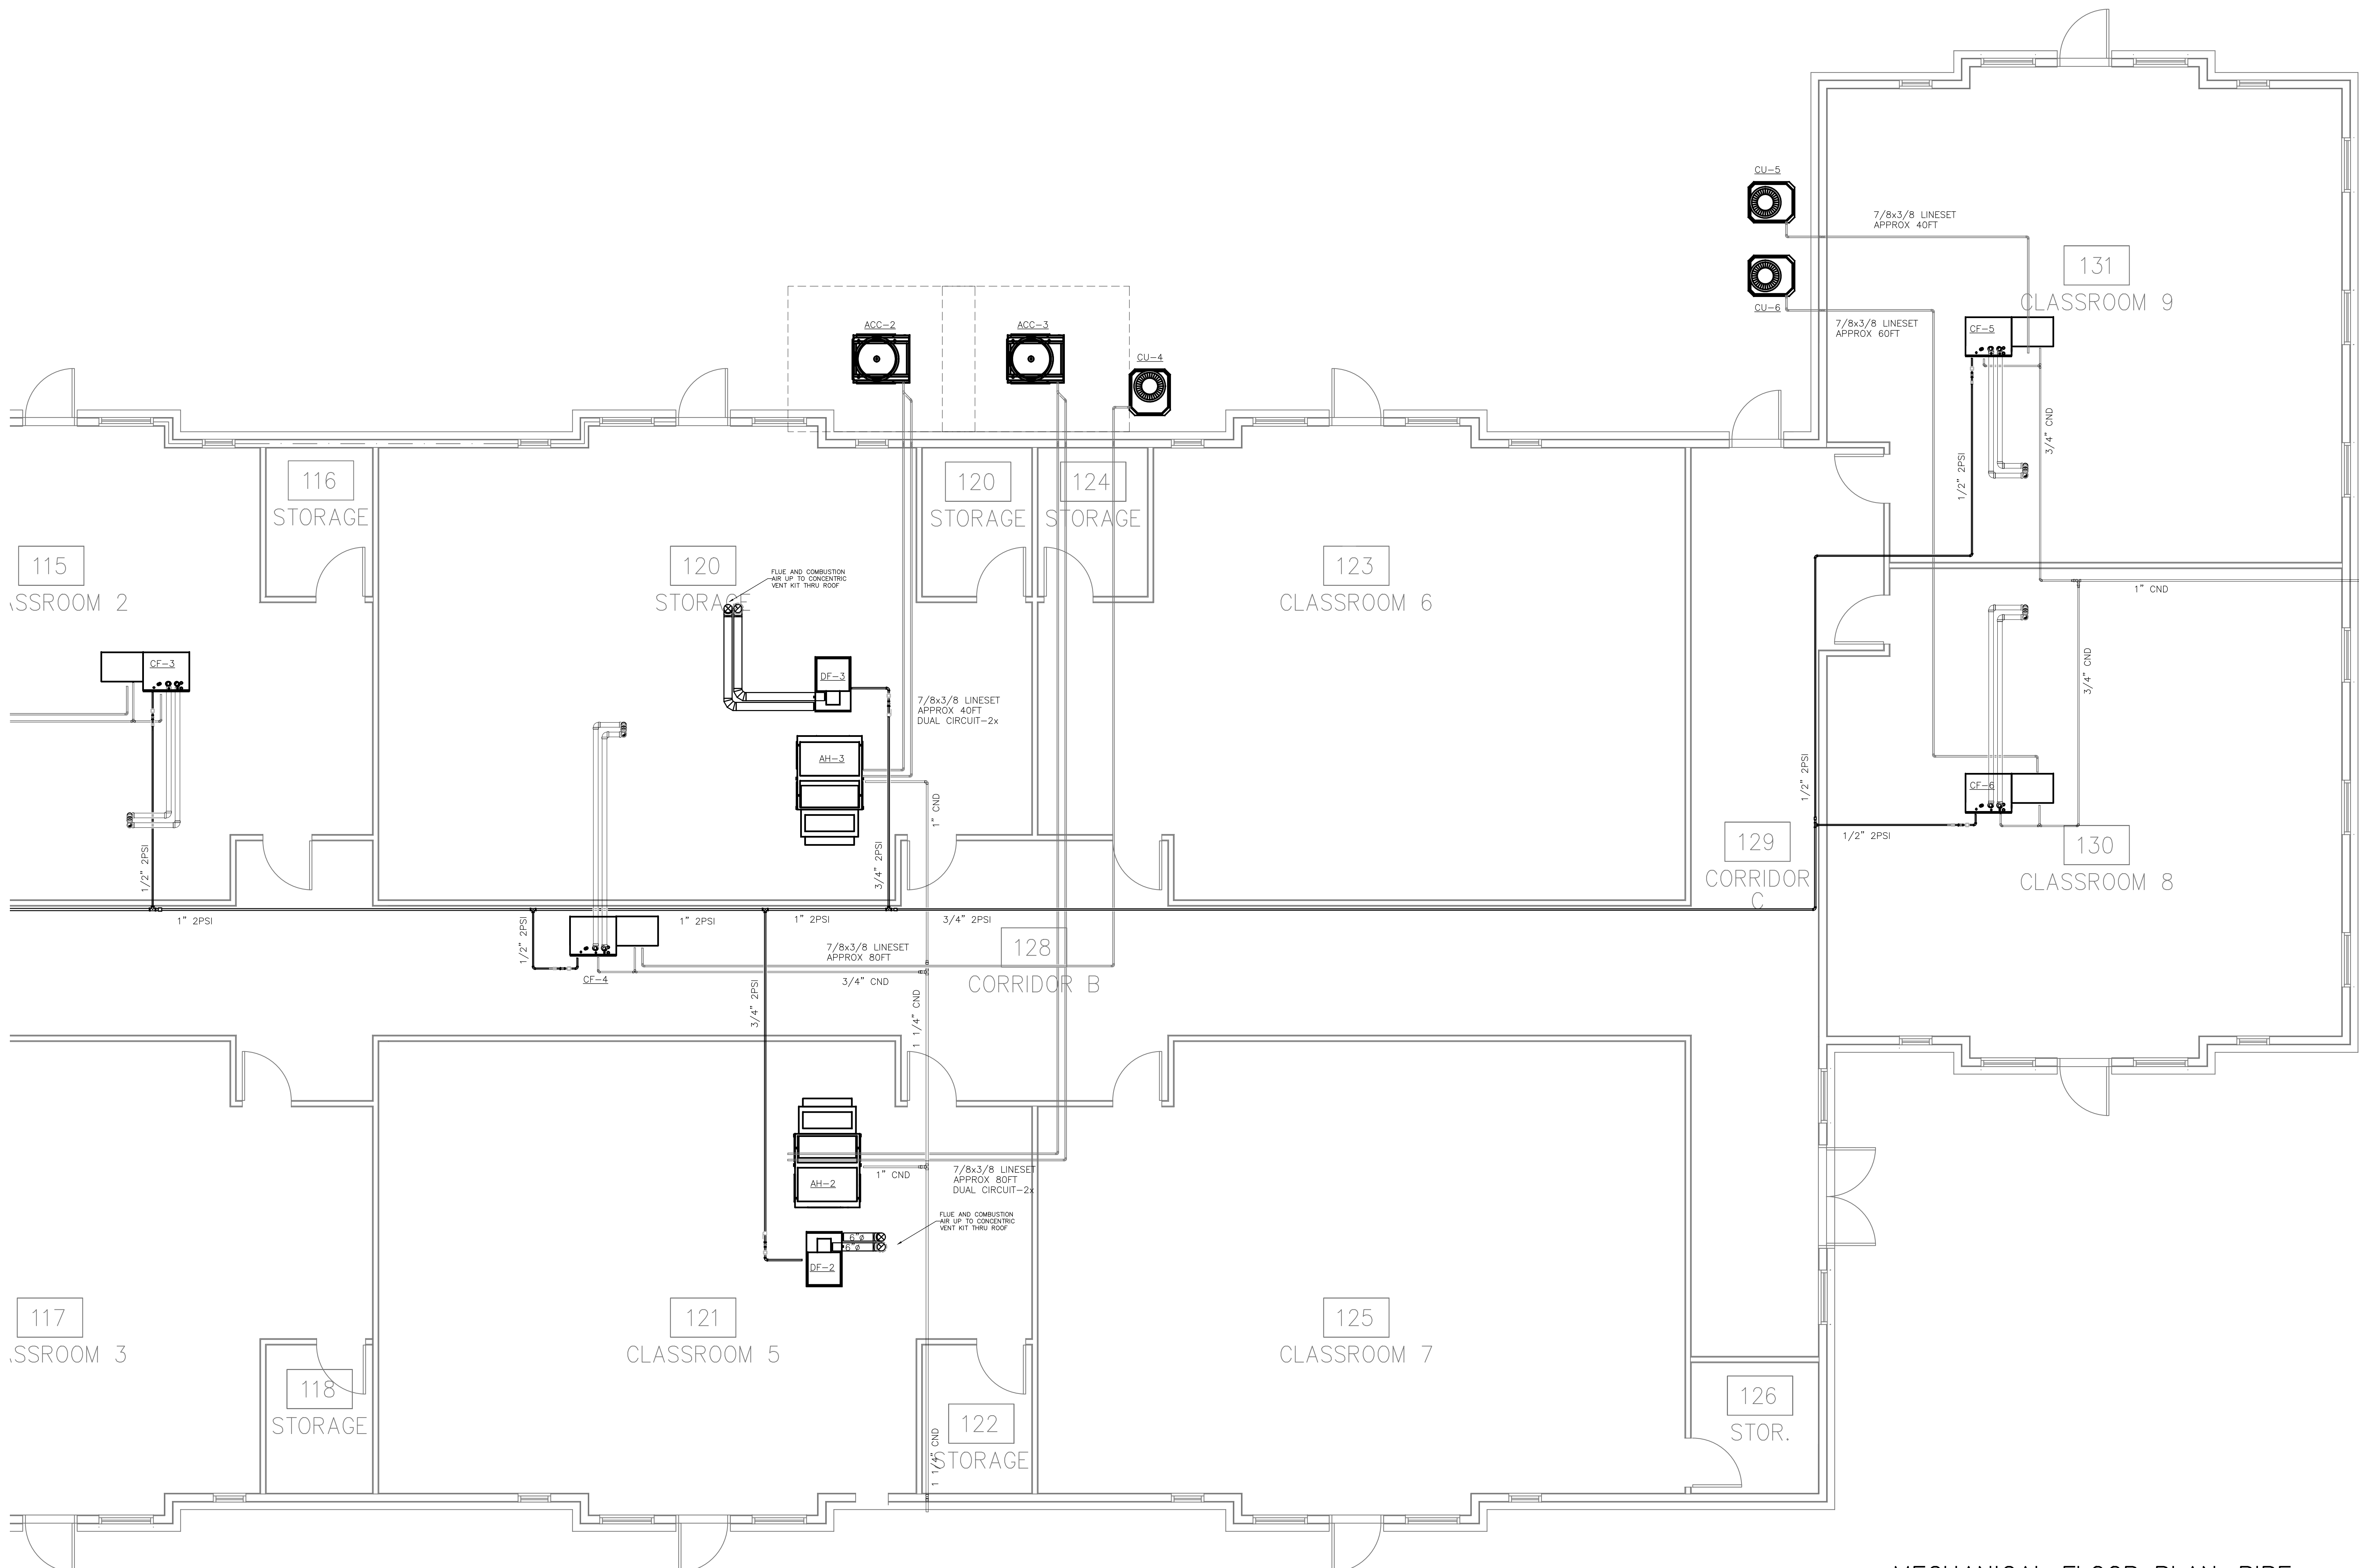

MECHANICAL FLOOR PLAN-PIPE
 SCALE: 1/4"=1'-0"

Palisades Episcopal High School
 13120 Grand Palisades Parkway
 Charlotte, NC

GENERAL CONTRACTOR:
 Metrolina

○ PRELIMINARY - NOT FOR CONSTRUCTION
 ○ FOR CONSTRUCTION
 ● SHOP DRAWINGS
 ○ AS-BUILT DRAWINGS

REVISIONS	DATE

DRAWN BY: RJM
 CHECKED BY: RJM
 PROJECT: 24-777
 DATE: xx/xx/xxxx
 SHEET: 2 OF: 4