


H.E.S. SYSTEM
 MECHANICAL CONTRACTOR TO PROVIDE AND INSTALL SUDCAST H.E.S. SYSTEM FOR ALL NEW HOODS. SEE HOOD PAW/EQUIPMENT INTERLOCK WIRING DIAGRAM ON SHEET M41 FOR MORE INFORMATION.

AP CURTAIN REMOTE WALL SWITCHES BY MECHANICAL REFER TO AIR DOOR SCHEDULE AND AIR CURTAIN WIRING DIAGRAM FOR FURTHER INFORMATION. COORDINATE EXACT LOCATION FOR SWITCHES WITH KITCHEN EQUIPMENT AND PLANS.

NEW AIR CURTAIN (2) MOUNTED IN CEILING GRID CENTERED ON THE DOOR. THE EXISTING WALL MECHANICAL CONTRACTOR SHALL ADJUST AIR DEFLECTORS TOWARD AIR DIVERTER BOX.

LIQUID DUCT AT AC20 AS HIGH AS POSSIBLE IN E TO LIMITED CLEARANCE ABOVE CEILING.

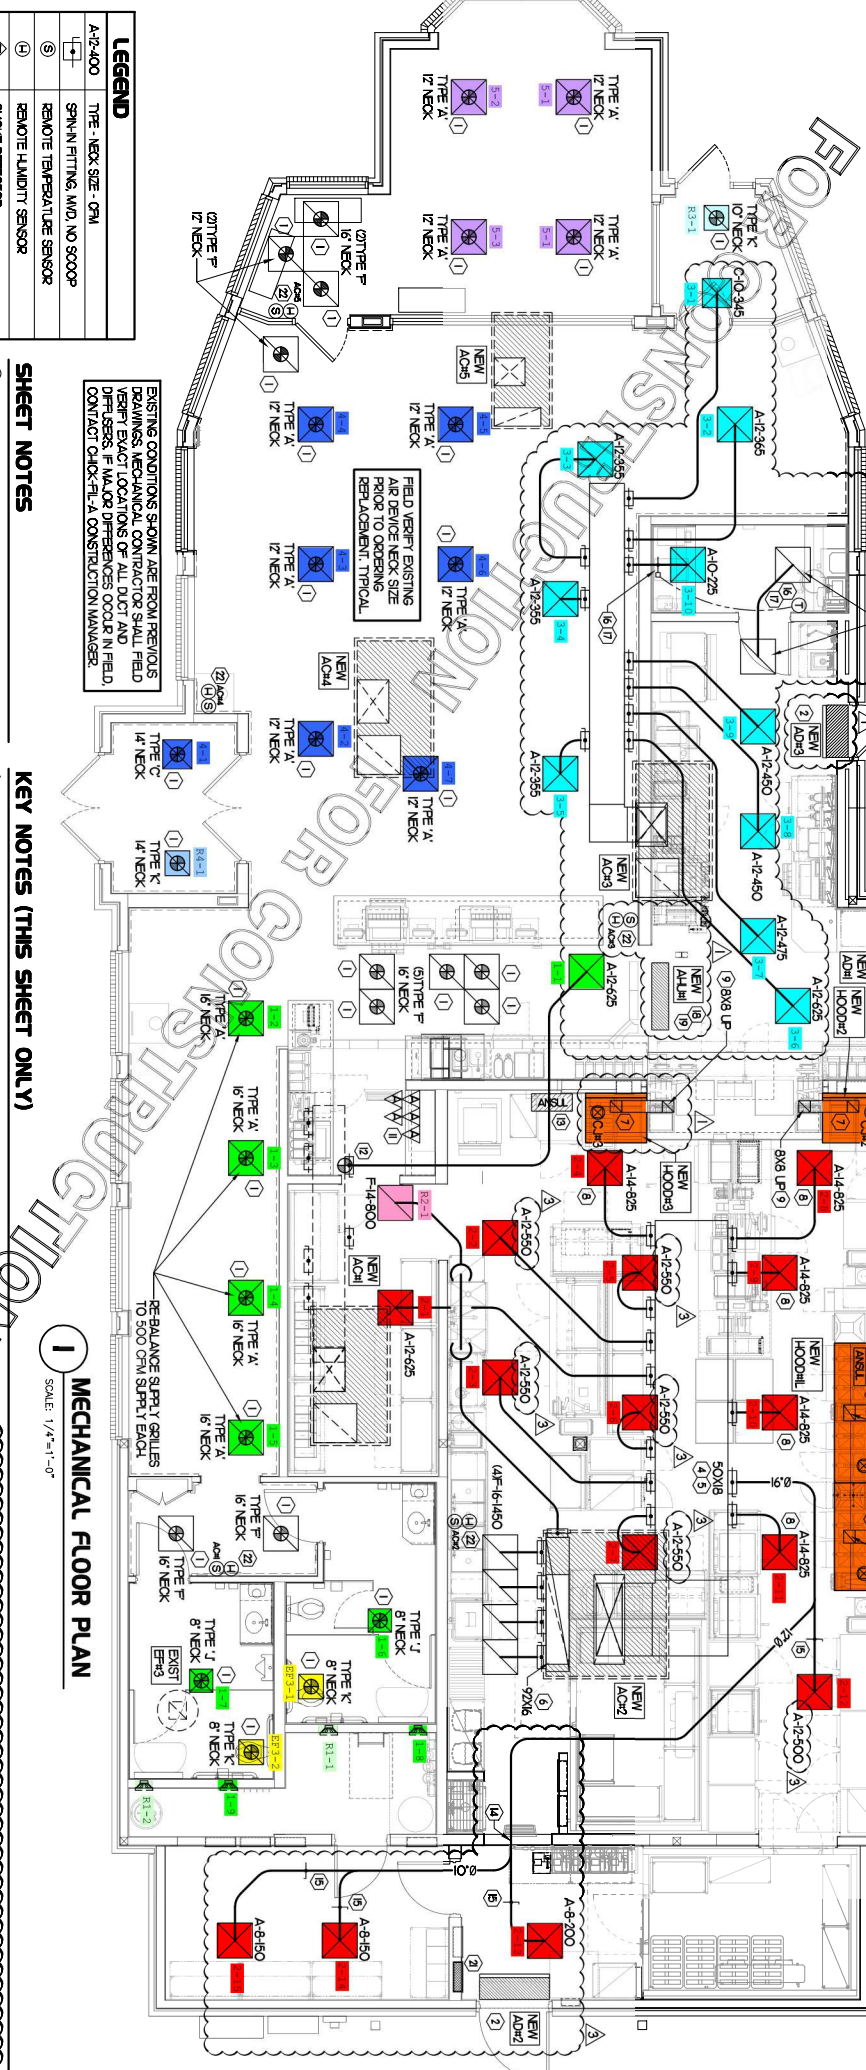

LEGEND

A-12-400	TYPE - MAX SIZE - 6" M
+	SPRINK FITTING, MVD, NO SCOOP
⊖	REMOTE TEMPERATURE SENSOR
⊕	REMOTE HUMIDITY SENSOR

EXISTING CONDITIONS SHOWN ARE FROM PREVIOUS DRAWINGS. MECHANICAL CONTRACTOR SHALL FIELD PERMITS AND LOCATIONS OF ALL EXISTING FIELD. CONTACT CHECK-FIELD A CONSTRUCTION MANAGER.

SHEET NOTES

KEY NOTES (THIS SHEET ONLY)

1 MECHANICAL FLOOR PLAN
 SCALE: 1/4"=1'-0"