

TAGS & LABELS

ROOM NAME	AREA/ROOM IDENTIFIERS	DOOR OPENING TAG
CLG HT 9'-0"	CEILING HEIGHT INDICATOR	WINDOW SILL & OPENING TAG

DOORS

STANDARD DOOR	TOILET PARTITION DOOR
DOUBLE SWING DOOR	SLIDING & POCKET DOOR
OVERHEAD DOOR	SLIDING DOOR
SINGLE FOLD DOOR	BI-FOLD DOOR
ELEVATOR DOUBLE DOOR	ELEVATOR SINGLE DOOR

ELECTRICAL

SINGLE OUTLET	DUPLEX OUTLET
QUAD OUTLET	COVER PLATE
SPEAKER	SECURITY CAMERA
WIFI ROUTER	MOTION SENSOR
RFID ANTENNA	JUNCTION BOX
DATA	TELEPHONE
DATA/PHONE COMBO	
EXHAUST FAN w/o LIGHT	EXHAUST FAN w/ LIGHT
EXHAUST FAN w/o LIGHT	EXHAUST FAN w/ LIGHT

FIRE PROTECTION

ALARM BELL/STROBE	SMOKE DETECTOR
GENERAL ALARM	HEAT DETECTOR
CARBON MONOXIDE	SPRINKLER HEAD

HVAC


SUPPLY DIFFUSER	ROUND SUPPLY DIFFUSER
RETURN DIFFUSER	WALL DIFFUSER
EQUALIZER DIFFUSER	

LIGHTING

SURFACE FLUORESCENT LIGHT	EXIT LIGHT
RECESSED FLUORESCENT LIGHT	EMERGENCY LIGHT WITH EXIT
LIGHT TRACK	EMERGENCY LIGHT
SURFACE MOUNTED CEILING LIGHT	RECESSED CEILING LIGHT
PENDANT CEILING LIGHT	

OTHER

WALL ACCESS PANEL	BREAKLINE
CEILING ACCESS PANEL	

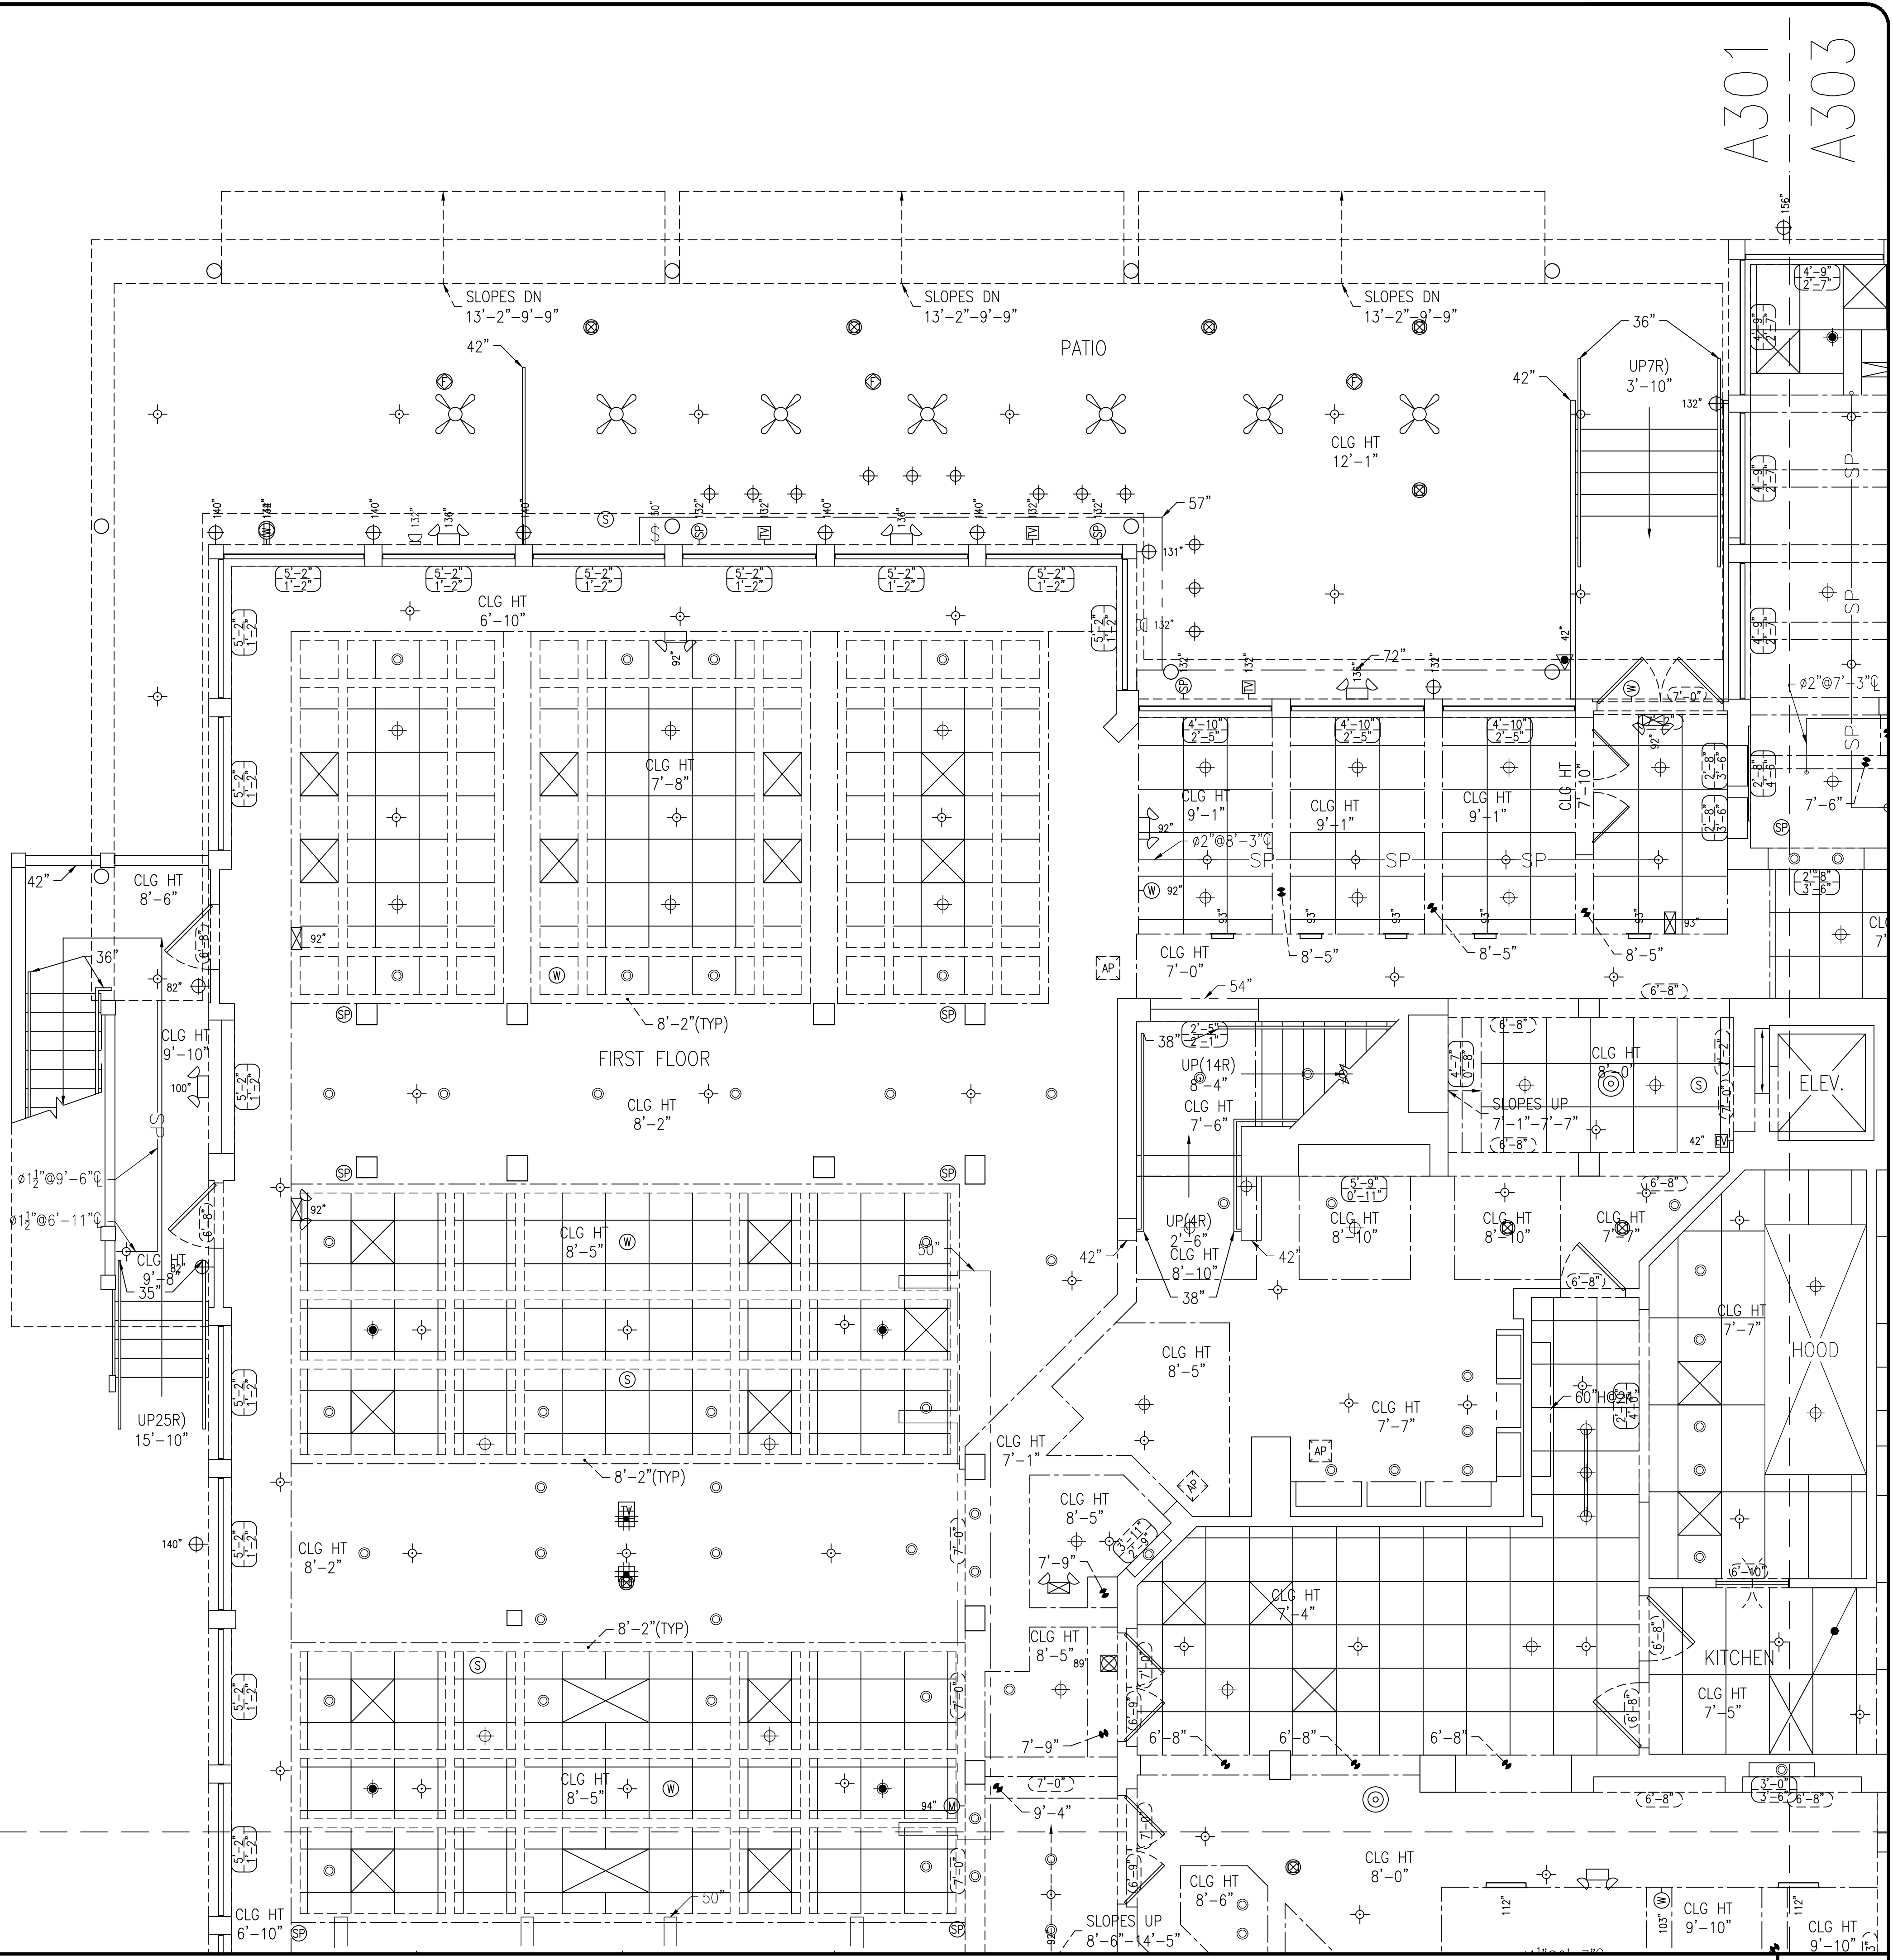

A301
A302

1ST LEVEL REFLECTED CEILING PLAN-1

SCALE: 1/4" = 1'-0"



STYS HOSPITALITY INITIATIVE
462 BOSTON ST
TOPSFIELD, MA 01983

Drawn By: A. HURT
Checked By: J. CLOOS
Project Number: 190721

SMITH-WOLLENSKY
1 WASHINGTON AVENUE
MIAMI BEACH, FL 33139

COAST 2 COAST
7704 BASSWOOD DR.
CHATTANOOGA, TN 37416
PH. 423.296.9000
www.coast2coast.net

Date: 09/22/2019

A301

TAGS & LABELS

ROOM NAME	AREA/ROOM IDENTIFIERS	DOOR OPENING TAG
CLG HT 9'-0"	CEILING HEIGHT INDICATOR	WINDOW SILL & OPENING TAG

DOORS

STANDARD DOOR	TOILET PARTITION DOOR
DOUBLE SWING DOOR	SLIDING & POCKET DOOR
OVERHEAD DOOR	SLIDING DOOR
SINGLE FOLD DOOR	BI-FOLD DOOR
ELEVATOR DOUBLE DOOR	ELEVATOR SINGLE DOOR

ELECTRICAL

SINGLE OUTLET	DUPLEX OUTLET
QUAD OUTLET	COVER PLATE
SPEAKER	SECURITY CAMERA
WIFI ROUTER	MOTION SENSOR
RFID ANTENNA	JUNCTION BOX
DATA	TELEPHONE
DATA/PHONE COMBO	
EXHAUST FAN w/o LIGHT	EXHAUST FAN w/ LIGHT
EXHAUST FAN w/o LIGHT	EXHAUST FAN w/ LIGHT

FIRE PROTECTION

ALARM BELL/STROBE	SMOKE DETECTOR
GENERAL ALARM	HEAT DETECTOR
CARBON MONOXIDE	SPRINKLER HEAD

HVAC


SUPPLY DIFFUSER	ROUND SUPPLY DIFFUSER
RETURN DIFFUSER	WALL DIFFUSER
EQUALIZER DIFFUSER	

LIGHTING

SURFACE FLUORESCENT LIGHT	EXIT LIGHT
RECESSED FLUORESCENT LIGHT	EMERGENCY LIGHT WITH EXIT
LIGHT TRACK	EMERGENCY LIGHT
SURFACE MOUNTED CEILING LIGHT	RECESSED CEILING LIGHT
PENDANT CEILING LIGHT	

OTHER

WALL ACCESS PANEL	BREAKLINE
CEILING ACCESS PANEL	

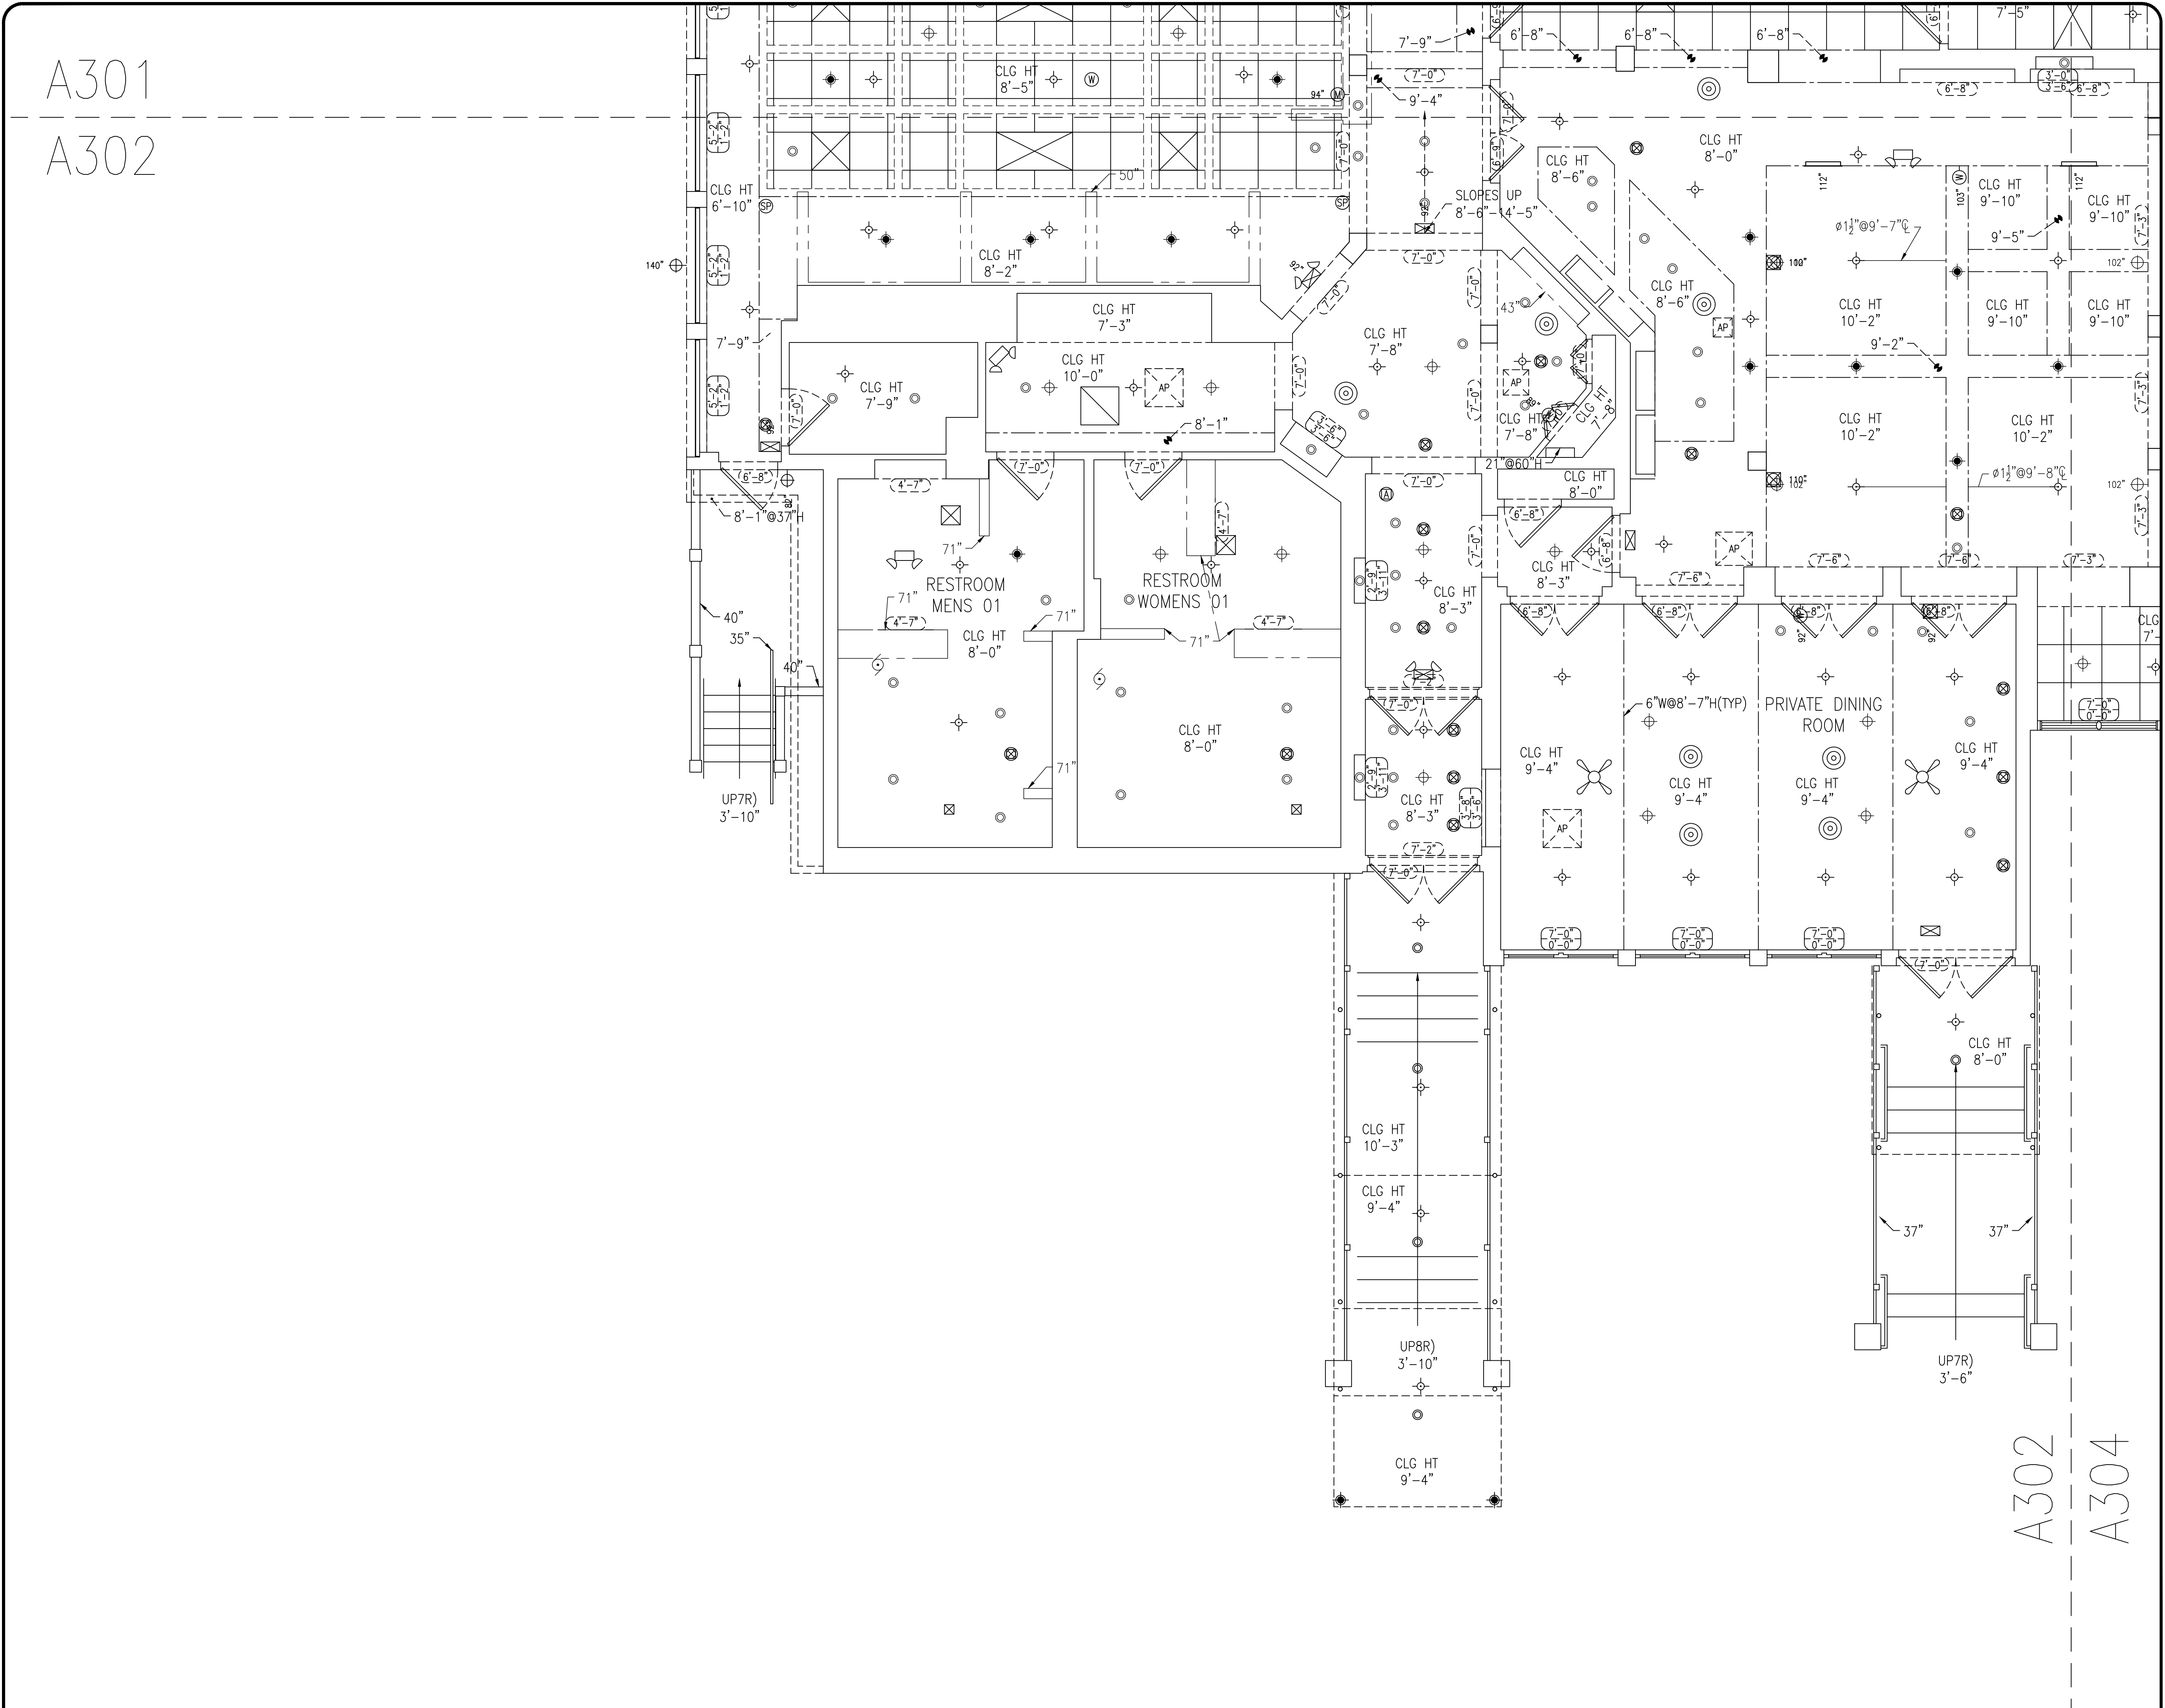

1ST LEVEL REFLECTED CEILING PLAN-2

SCALE: 1/4" = 1'-0"



SHI STYS HOSPITALITY INITIATIVE

STYS HOSPITALITY INITIATIVE
462 BOSTON ST
TOPSFIELD, MA 01983

Drawn By: A. HURT
Checked By: J. CLOOS
Project Number: 190721


SMITH-WOLLENSKY
1 WASHINGTON AVENUE
MIAMI BEACH, FL 33139

COAST 2 COAST
7704 BASSWOOD DR.
CHATTANOOGA, TN 37416
PH. 423.296.9000
www.coast2coast.net

Date: 09/22/2019

A302


TAGS & LABELS			
ROOM NAME	AREA/ROOM IDENTIFIERS	DOOR OPENING TAG	WINDOW SILL & OPENING TAG
CLG HT 9'-0"	CLG HT INDICATOR		
DOORS			
STANDARD DOOR	TOILET PARTITION DOOR		
DOUBLE SWING DOOR	SLIDING & POCKET DOOR		
OVERHEAD DOOR	SLIDING DOOR		
SINGLE FOLD DOOR	BI-FOLD DOOR		
ELEVATOR DOUBLE DOOR	ELEVATOR SINGLE DOOR		
ELECTRICAL			
SINGLE OUTLET	DUPLEX OUTLET		
QUAD OUTLET	COVER PLATE		
SPEAKER	SECURITY CAMERA		
WIFI ROUTER	MOTION SENSOR		
RFID ANTENNA	JUNCTION BOX		
DATA	TELEPHONE		
DATA/PHONE COMBO			
EXHAUST FAN w/o LIGHT	EXHAUST FAN w/ LIGHT		
EXHAUST FAN w/o LIGHT	EXHAUST FAN w/ LIGHT		
FIRE PROTECTION			
ALARM BELL/STROBE	SMOKE DETECTOR		
GENERAL ALARM	HEAT DETECTOR		
CARBON MONOXIDE	SPRINKLER HEAD		
HVAC			
SUPPLY DIFFUSER	ROUND SUPPLY DIFFUSER		
RETURN DIFFUSER	WALL DIFFUSER		
EQUALIZER DIFFUSER			
LIGHTING			
SURFACE FLUORESCENT LIGHT	EXIT LIGHT		
RECESSED FLUORESCENT LIGHT	EMERGENCY LIGHT WITH EXIT		
LIGHT TRACK	EMERGENCY LIGHT		
SURFACE MOUNTED CEILING LIGHT	RECESSED CEILING LIGHT		
PENDANT CEILING LIGHT			
OTHER			
WALL ACCESS PANEL	BREAKLINE		
CEILING ACCESS PANEL			

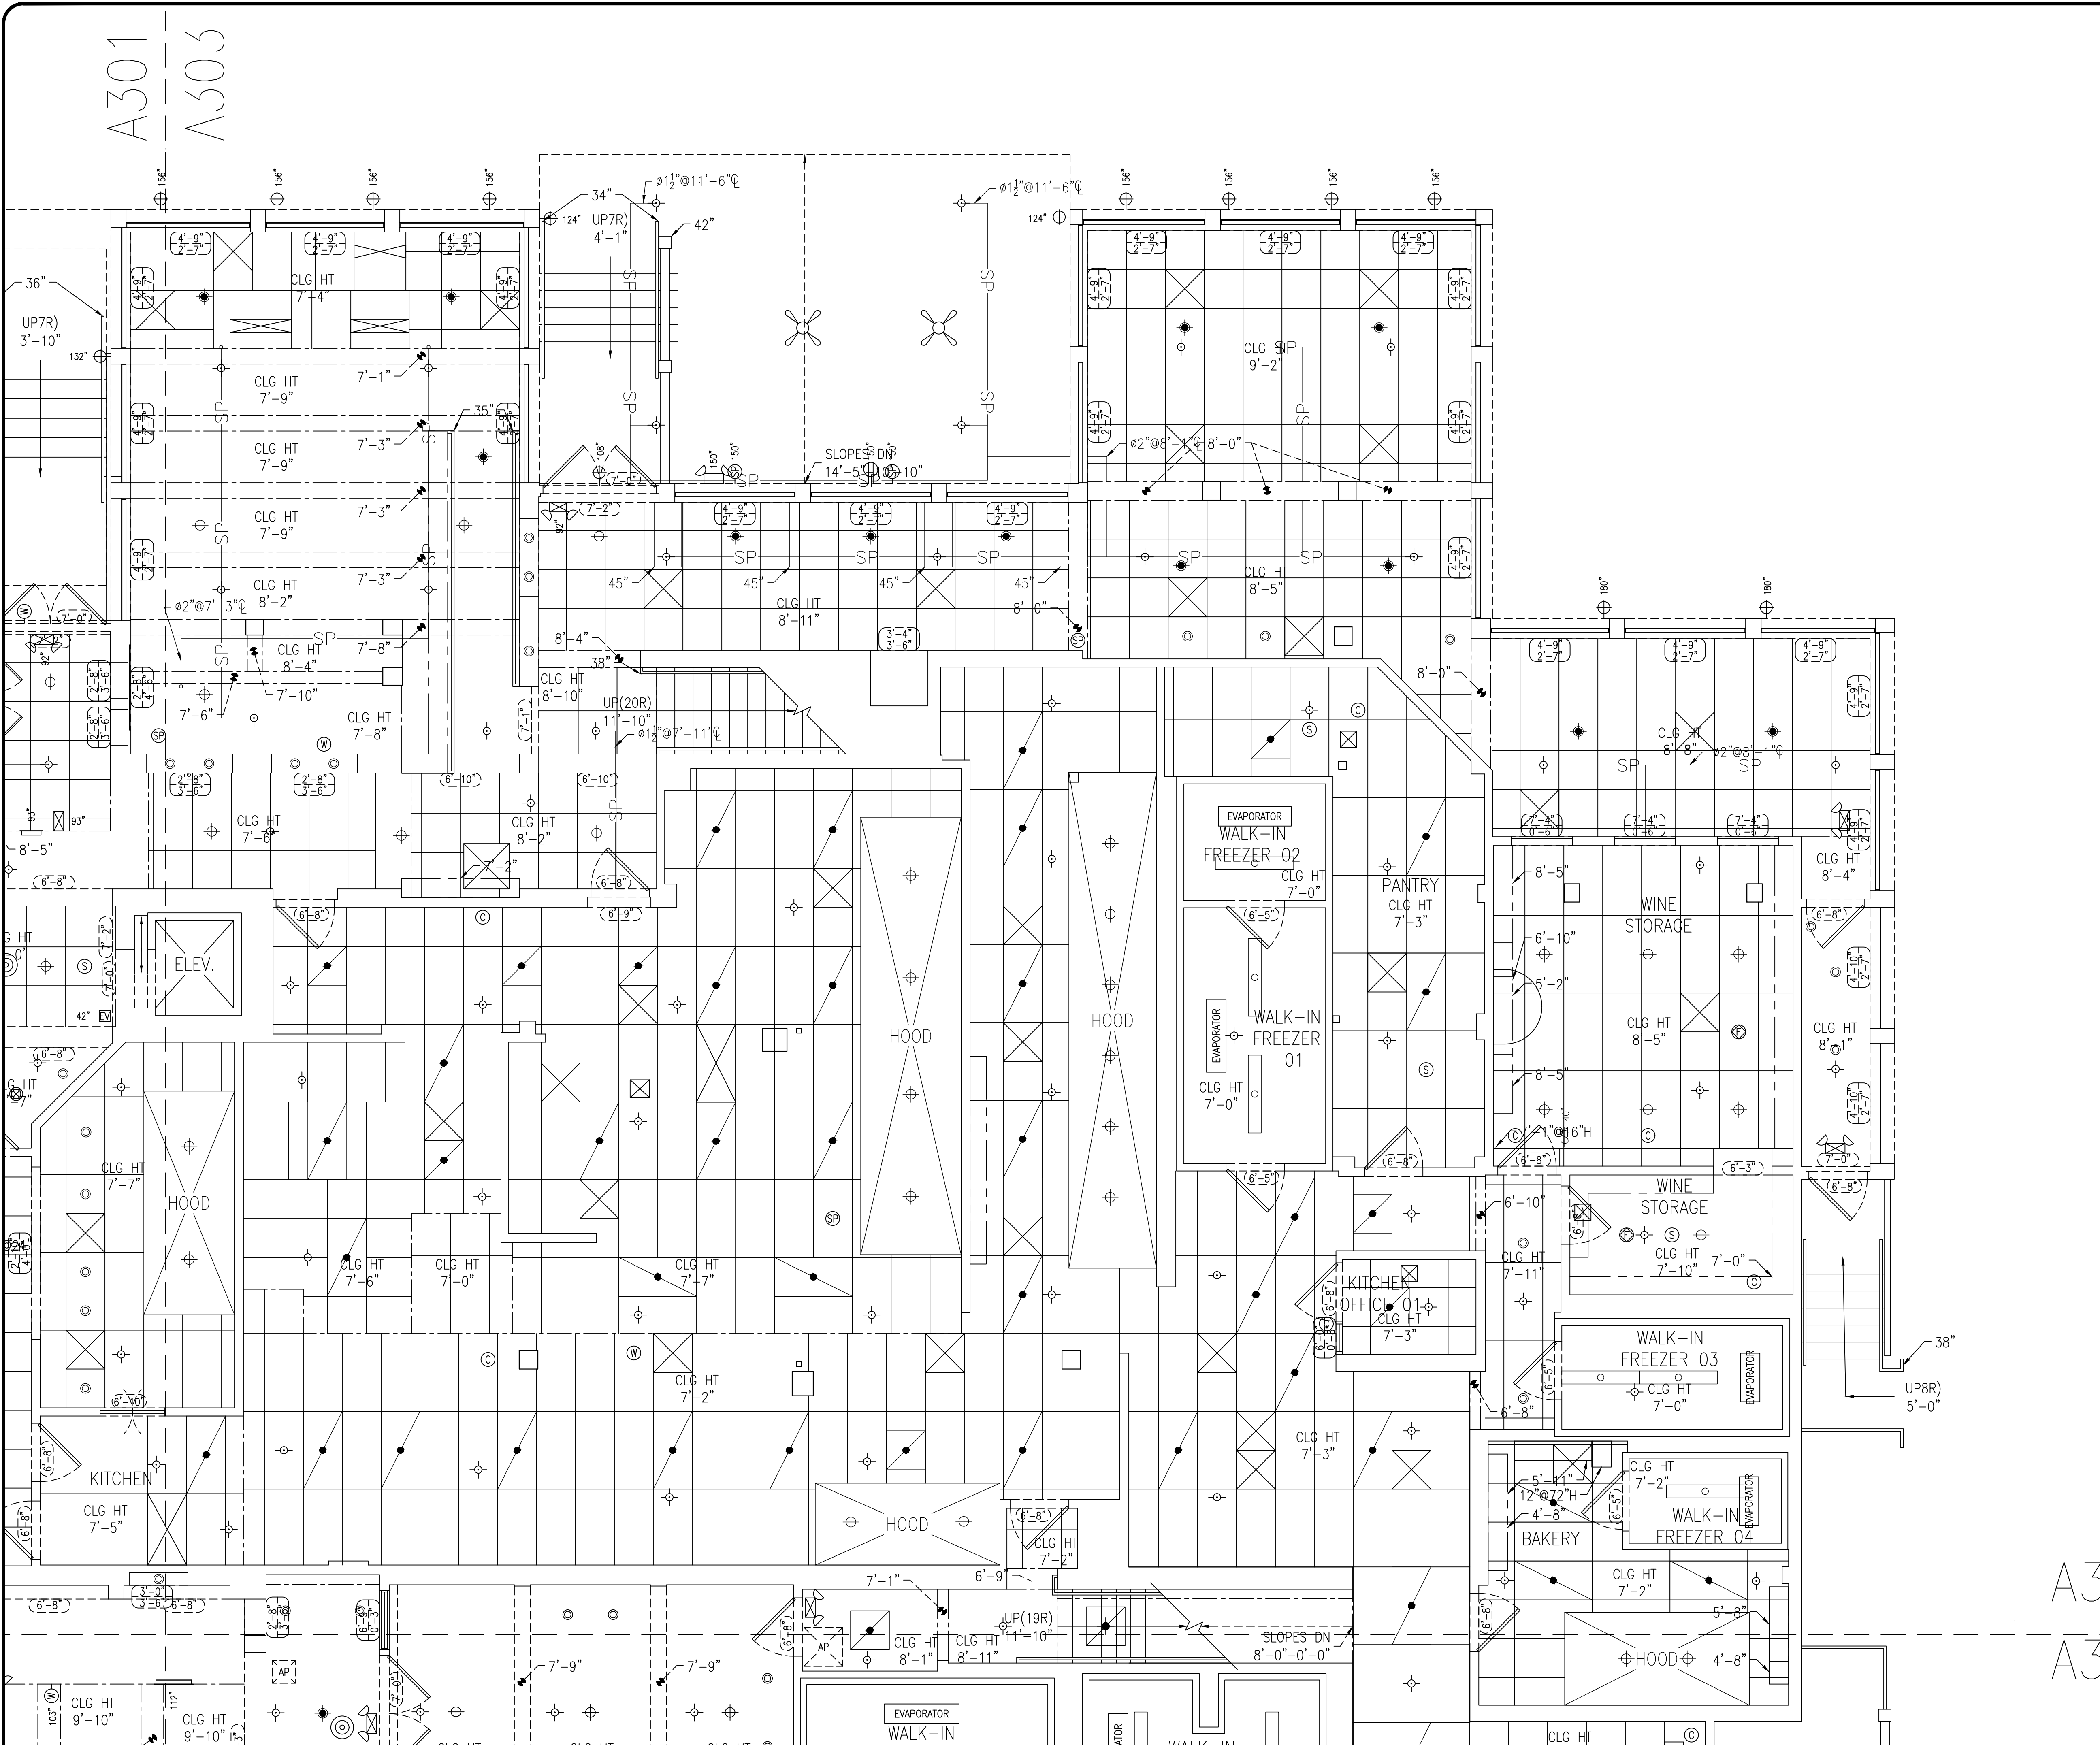

1ST LEVEL REFLECTED CEILING PLAN-3

SCALE: 1/4" = 1'-0"





STYS HOSPITALITY INITIATIVE
462 BOSTON ST
TOPSFIELD, MA 01983

Drawn By: A. HURT
Checked By: J. CLOOS
Project Number: 190721

SMITH-WOLLENSKY
1 WASHINGTON AVENUE
MIAMI BEACH, FL 33139

COAST 2 COAST
7704 BASSWOOD DR.
CHATTANOOGA, TN 37416
PH. 423.296.9000
www.coast2coast.net

Date: 09/22/2019

A303

TAGS & LABELS

ROOM NAME	AREA/ROOM IDENTIFIERS	DOOR OPENING TAG
CLG HT 9'-0"	CEILING HEIGHT INDICATOR	WINDOW SILL & OPENING TAG

DOORS

STANDARD DOOR	TOILET PARTITION DOOR
DOUBLE SWING DOOR	SLIDING & POCKET DOOR
OVERHEAD DOOR	SLIDING DOOR
SINGLE FOLD DOOR	BI-FOLD DOOR
ELEVATOR DOUBLE DOOR	ELEVATOR SINGLE DOOR

ELECTRICAL

SINGLE OUTLET	DUPLEX OUTLET
QUAD OUTLET	COVER PLATE
SPEAKER	SECURITY CAMERA
WIFI ROUTER	MOTION SENSOR
RFID ANTENNA	JUNCTION BOX
DATA	TELEPHONE
DATA/PHONE COMBO	
EXHAUST FAN w/o LIGHT	EXHAUST FAN w/ LIGHT
EXHAUST FAN w/o LIGHT	EXHAUST FAN w/ LIGHT

FIRE PROTECTION

ALARM BELL/STROBE	SMOKE DETECTOR
GENERAL ALARM	HEAT DETECTOR
CARBON MONOXIDE	SPRINKLER HEAD

HVAC


SUPPLY DIFFUSER	ROUND SUPPLY DIFFUSER
RETURN DIFFUSER	WALL DIFFUSER
EQUALIZER DIFFUSER	

LIGHTING

SURFACE FLUORESCENT LIGHT	EXIT LIGHT
RECESSED FLUORESCENT LIGHT	EMERGENCY LIGHT WITH EXIT
LIGHT TRACK	EMERGENCY LIGHT
SURFACE MOUNTED CEILING LIGHT	RECESSED CEILING LIGHT
PENDANT CEILING LIGHT	

OTHER

WALL ACCESS PANEL	BREAKLINE
CEILING ACCESS PANEL	

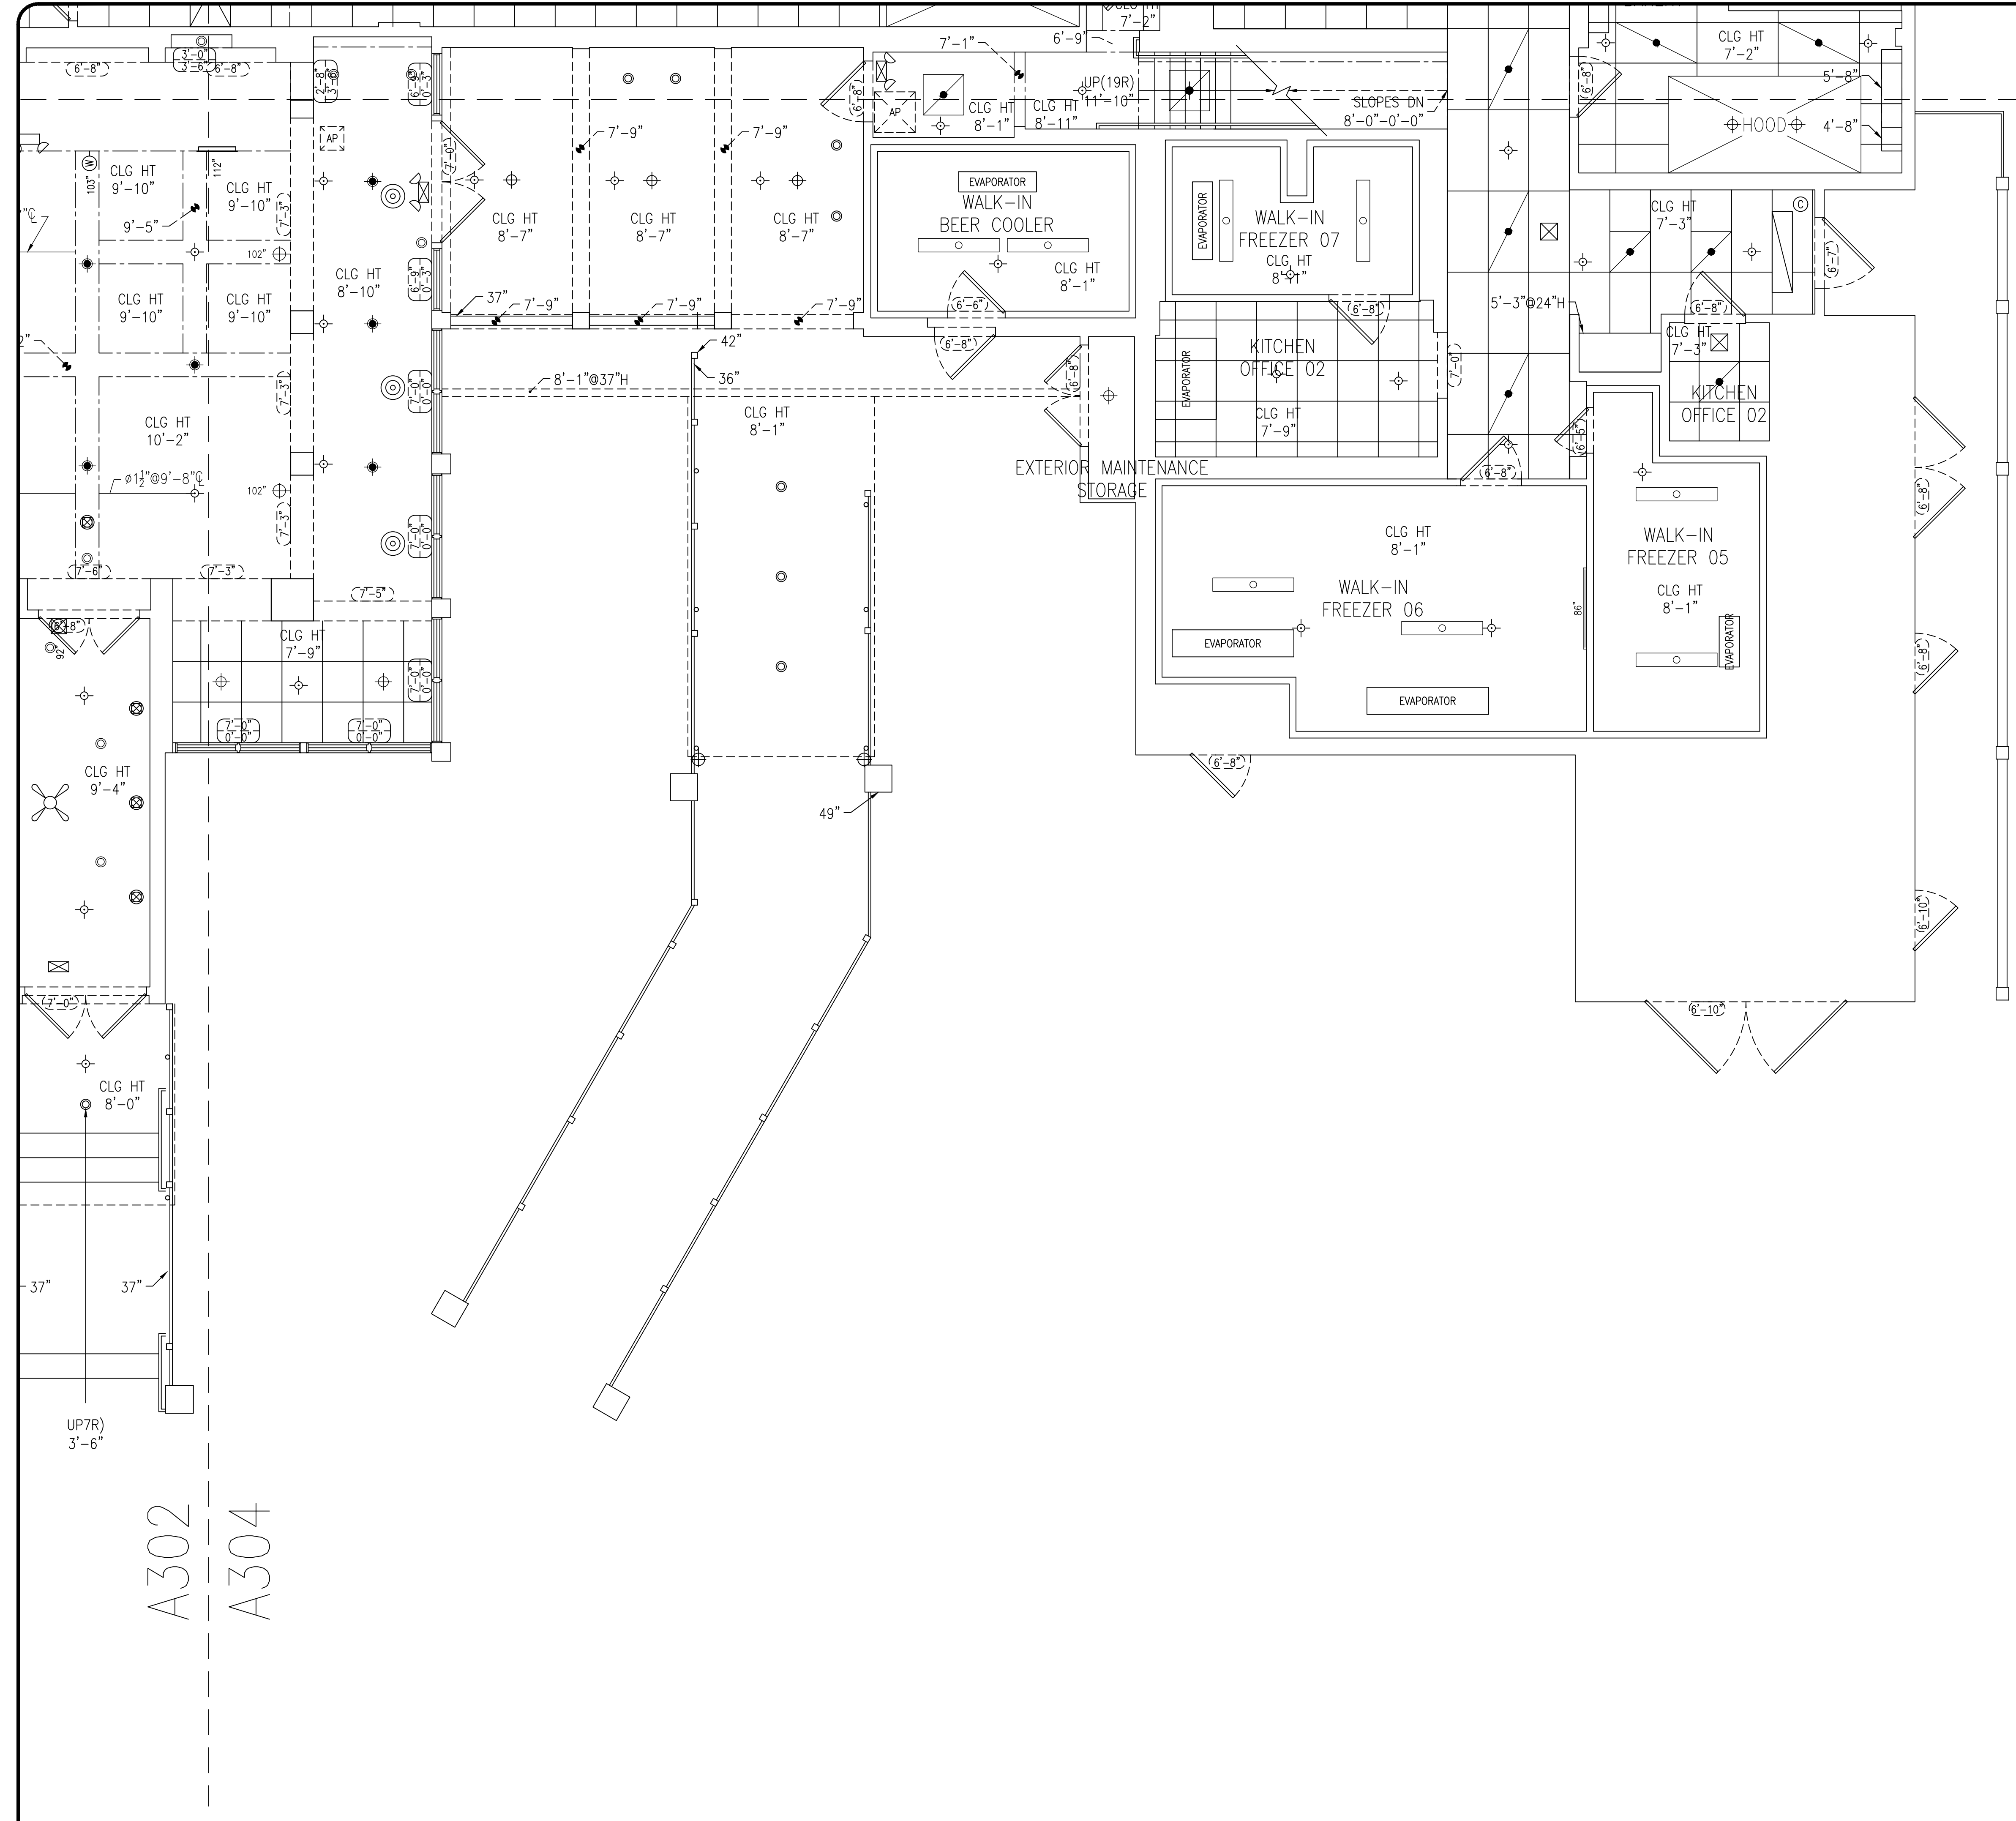

A303
A304

A302
A304



STYS HOSPITALITY INITIATIVE
462 BOSTON ST
TOPSFIELD, MA 01983

Drawn By: A. HURT
Checked By: J. CLOOS
Project Number: 190721

SMITH-WOLLENSKY
1 WASHINGTON AVENUE
MIAMI BEACH, FL 33139

COAST 2 COAST
7704 BASSWOOD DR.
CHATTANOOGA, TN 37416
PH. 423.296.9000
www.coast2coast.net

Date: 09/22/2019

1ST LEVEL REFLECTED CEILING PLAN-4

SCALE: 1/4" = 1'-0"



A304

TAGS & LABELS

ROOM NAME	AREA/ROOM IDENTIFIERS	DOOR OPENING TAG
CLG HT 9'-0"	CEILING HEIGHT INDICATOR	WINDOW SILL & OPENING TAG

DOORS

STANDARD DOOR	TOILET PARTITION DOOR
DOUBLE SWING DOOR	SLIDING & POCKET DOOR
OVERHEAD DOOR	SLIDING DOOR
SINGLE FOLD DOOR	BI-FOLD DOOR
ELEVATOR DOUBLE DOOR	ELEVATOR SINGLE DOOR

ELECTRICAL

SINGLE OUTLET	DUPLEX OUTLET
QUAD OUTLET	COVER PLATE
SPEAKER	SECURITY CAMERA
WIFI ROUTER	MOTION SENSOR
RFID ANTENNA	JUNCTION BOX
DATA	TELEPHONE
DATA/PHONE COMBO	
EXHAUST FAN w/o LIGHT	EXHAUST FAN w/ LIGHT
EXHAUST FAN w/o LIGHT	EXHAUST FAN w/ LIGHT

FIRE PROTECTION

ALARM BELL/STROBE	SMOKE DETECTOR
GENERAL ALARM	HEAT DETECTOR
CARBON MONOXIDE	SPRINKLER HEAD

HVAC


SUPPLY DIFFUSER	ROUND SUPPLY DIFFUSER
RETURN DIFFUSER	WALL DIFFUSER
EQUALIZER DIFFUSER	

LIGHTING

SURFACE FLUORESCENT LIGHT	EXIT LIGHT
RECESSED FLUORESCENT LIGHT	EMERGENCY LIGHT WITH EXIT
LIGHT TRACK	EMERGENCY LIGHT
SURFACE MOUNTED CEILING LIGHT	RECESSED CEILING LIGHT
PENDANT CEILING LIGHT	

OTHER

WALL ACCESS PANEL	BREAKLINE
CEILING ACCESS PANEL	

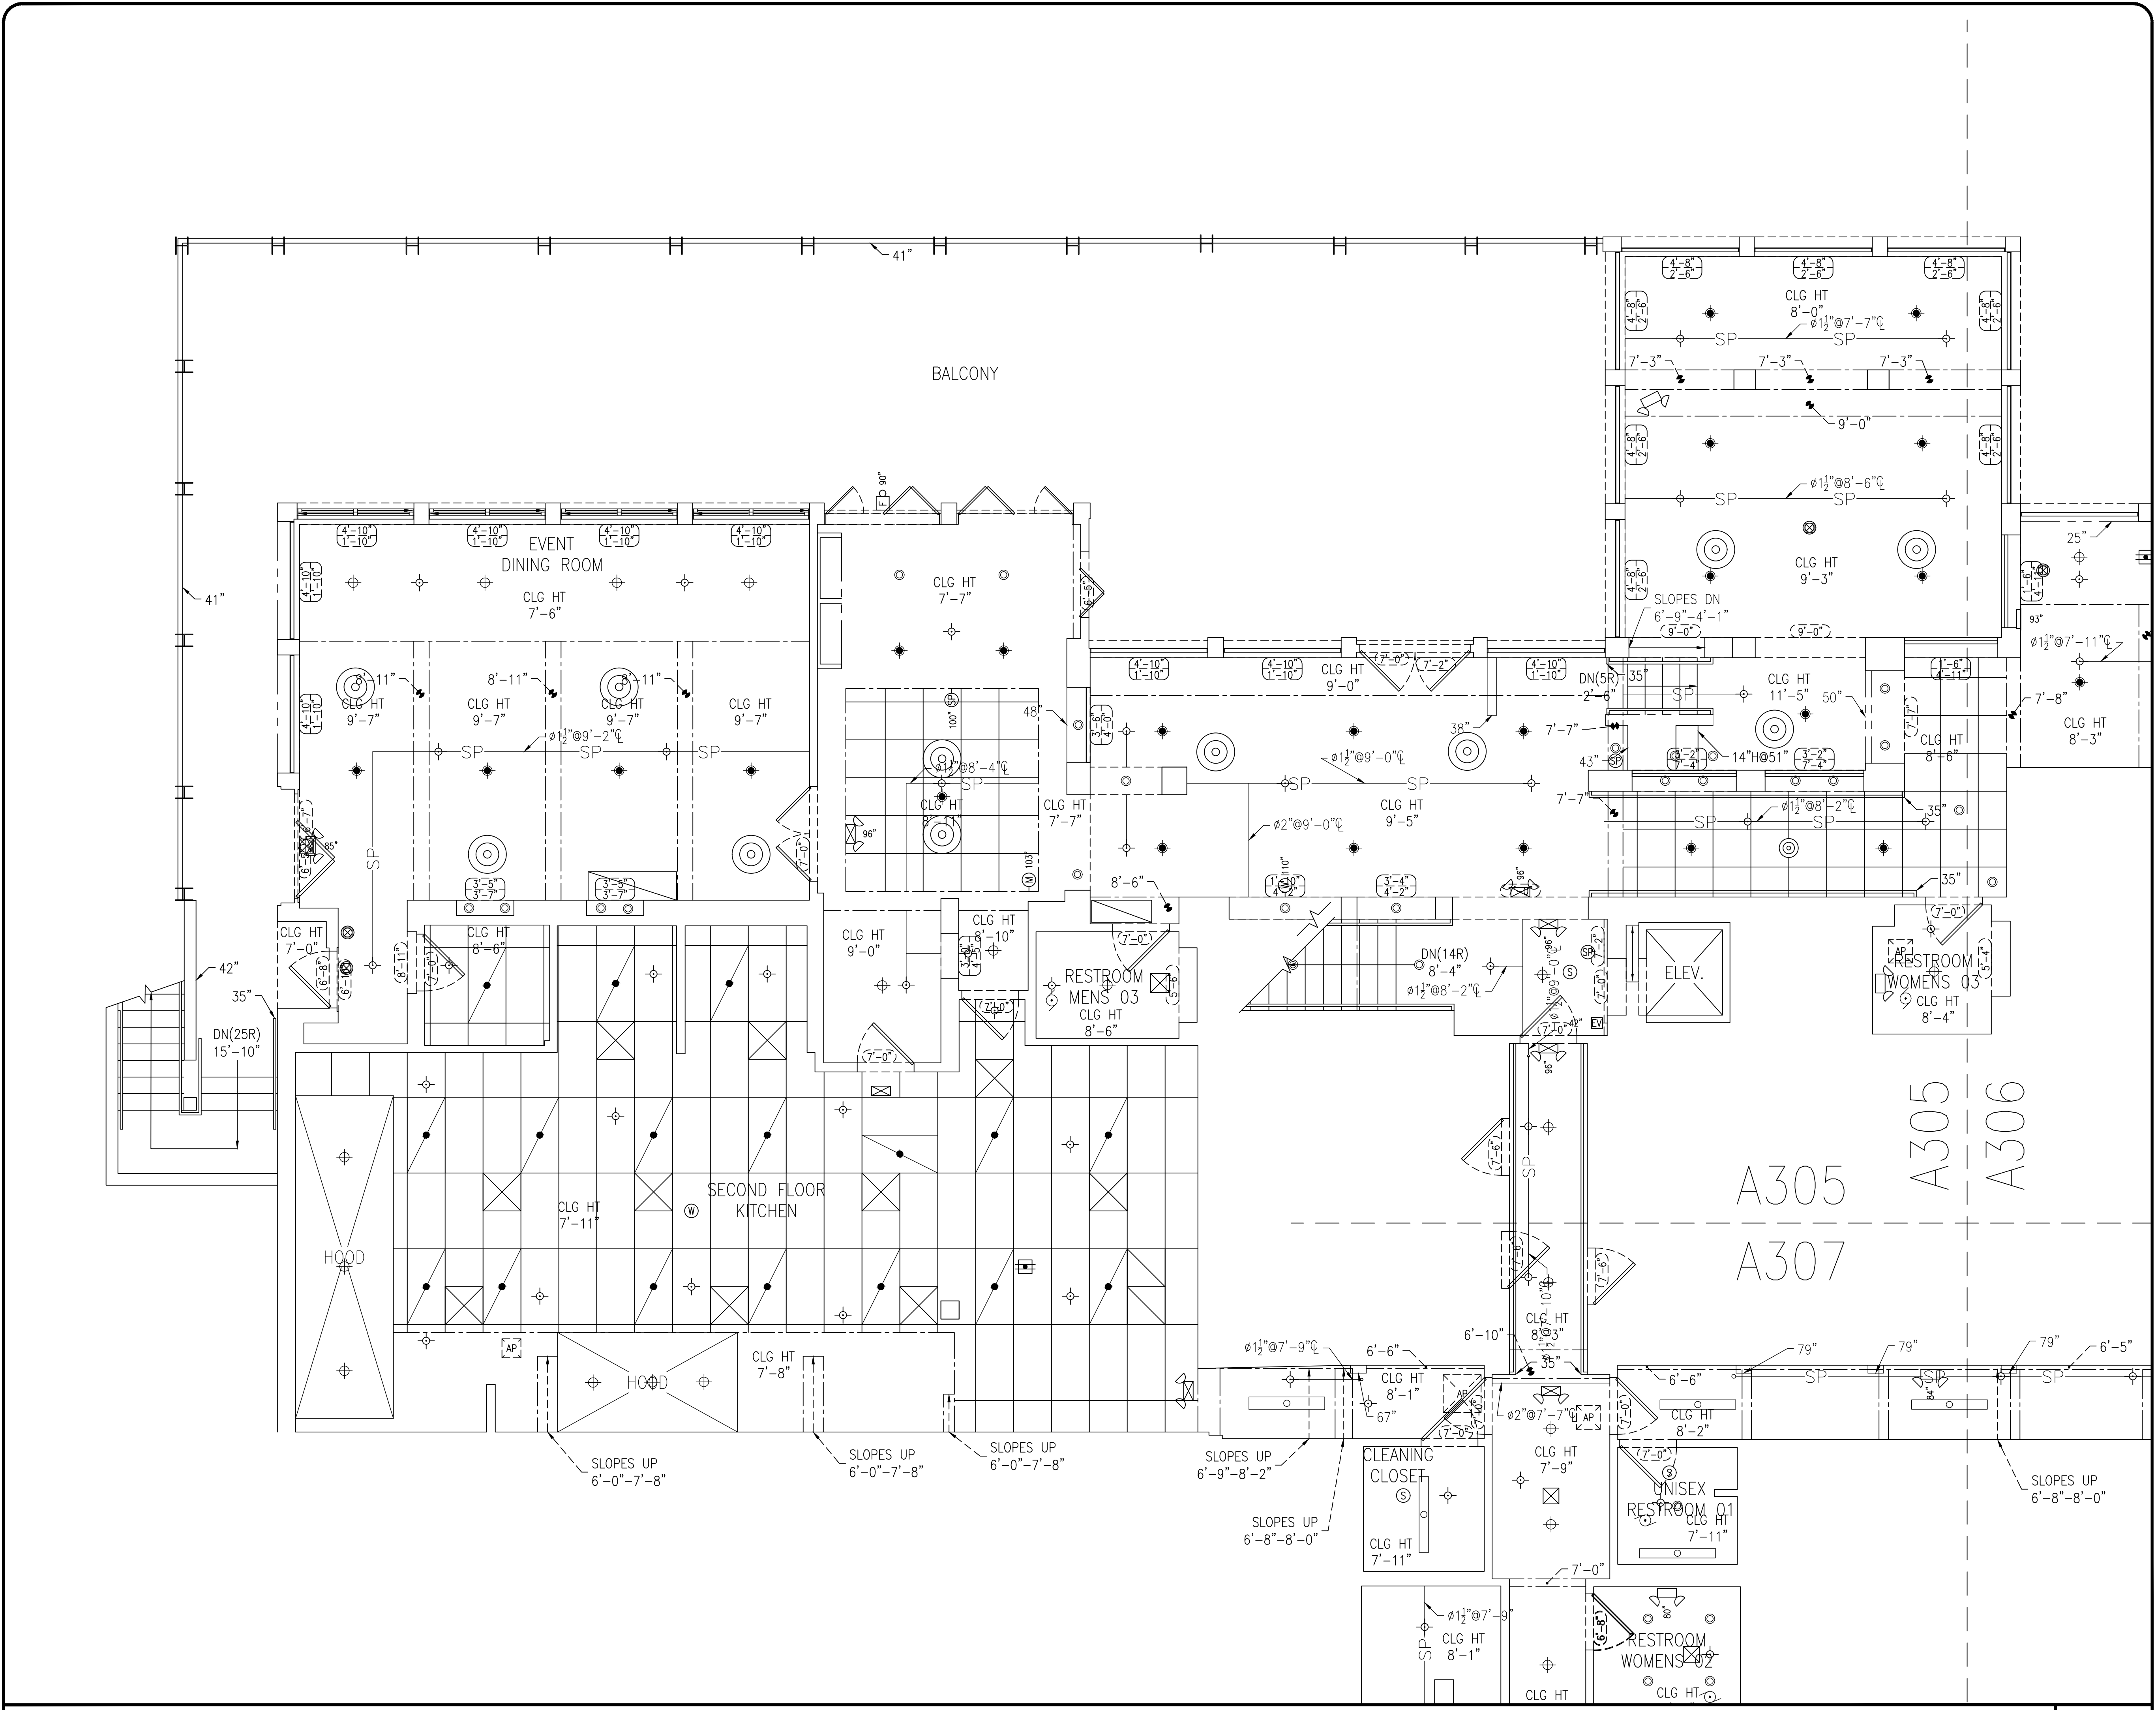

2ND LEVEL REFLECTED CEILING PLAN-1

SCALE: 1/4" = 1'-0"



STYS HOSPITALITY INITIATIVE
462 BOSTON ST
TOPSFIELD, MA 01983

Drawn By: A. HURT
Checked By: J. CLOOS
Project Number: 190721

SMITH-WOLLENSKY
1 WASHINGTON AVENUE
MIAMI BEACH, FL 33139

COAST 2 COAST
7704 BASSWOOD DR.
CHATTANOOGA, TN 37416
PH. 423.296.9000
www.coast2coast.net

Date: 09/22/2019

A305

TAGS & LABELS

ROOM NAME	AREA/ROOM IDENTIFIERS	DOOR OPENING TAG
CLG HT 9'-0"	CEILING HEIGHT INDICATOR	WINDOW SILL & OPENING TAG

DOORS

STANDARD DOOR	TOILET PARTITION DOOR
DOUBLE SWING DOOR	SLIDING & POCKET DOOR
OVERHEAD DOOR	SLIDING DOOR
SINGLE FOLD DOOR	BI-FOLD DOOR
ELEVATOR DOUBLE DOOR	ELEVATOR SINGLE DOOR

ELECTRICAL

SINGLE OUTLET	DUPLEX OUTLET
QUAD OUTLET	COVER PLATE
SPEAKER	SECURITY CAMERA
WIFI ROUTER	MOTION SENSOR
RFID ANTENNA	JUNCTION BOX
DATA	TELEPHONE
DATA/PHONE COMBO	
EXHAUST FAN w/o LIGHT	EXHAUST FAN w/ LIGHT
EXHAUST FAN w/o LIGHT	EXHAUST FAN w/ LIGHT

FIRE PROTECTION

ALARM BELL/STROBE	SMOKE DETECTOR
GENERAL ALARM	HEAT DETECTOR
CARBON MONOXIDE	SPRINKLER HEAD

HVAC


SUPPLY DIFFUSER	ROUND SUPPLY DIFFUSER
RETURN DIFFUSER	WALL DIFFUSER
EQUALIZER DIFFUSER	

LIGHTING

SURFACE FLUORESCENT LIGHT	EXIT LIGHT
RECESSED FLUORESCENT LIGHT	EMERGENCY LIGHT WITH EXIT
LIGHT TRACK	EMERGENCY LIGHT
SURFACE MOUNTED CEILING LIGHT	RECESSED CEILING LIGHT
PENDANT CEILING LIGHT	

OTHER

WALL ACCESS PANEL	BREAKLINE
CEILING ACCESS PANEL	

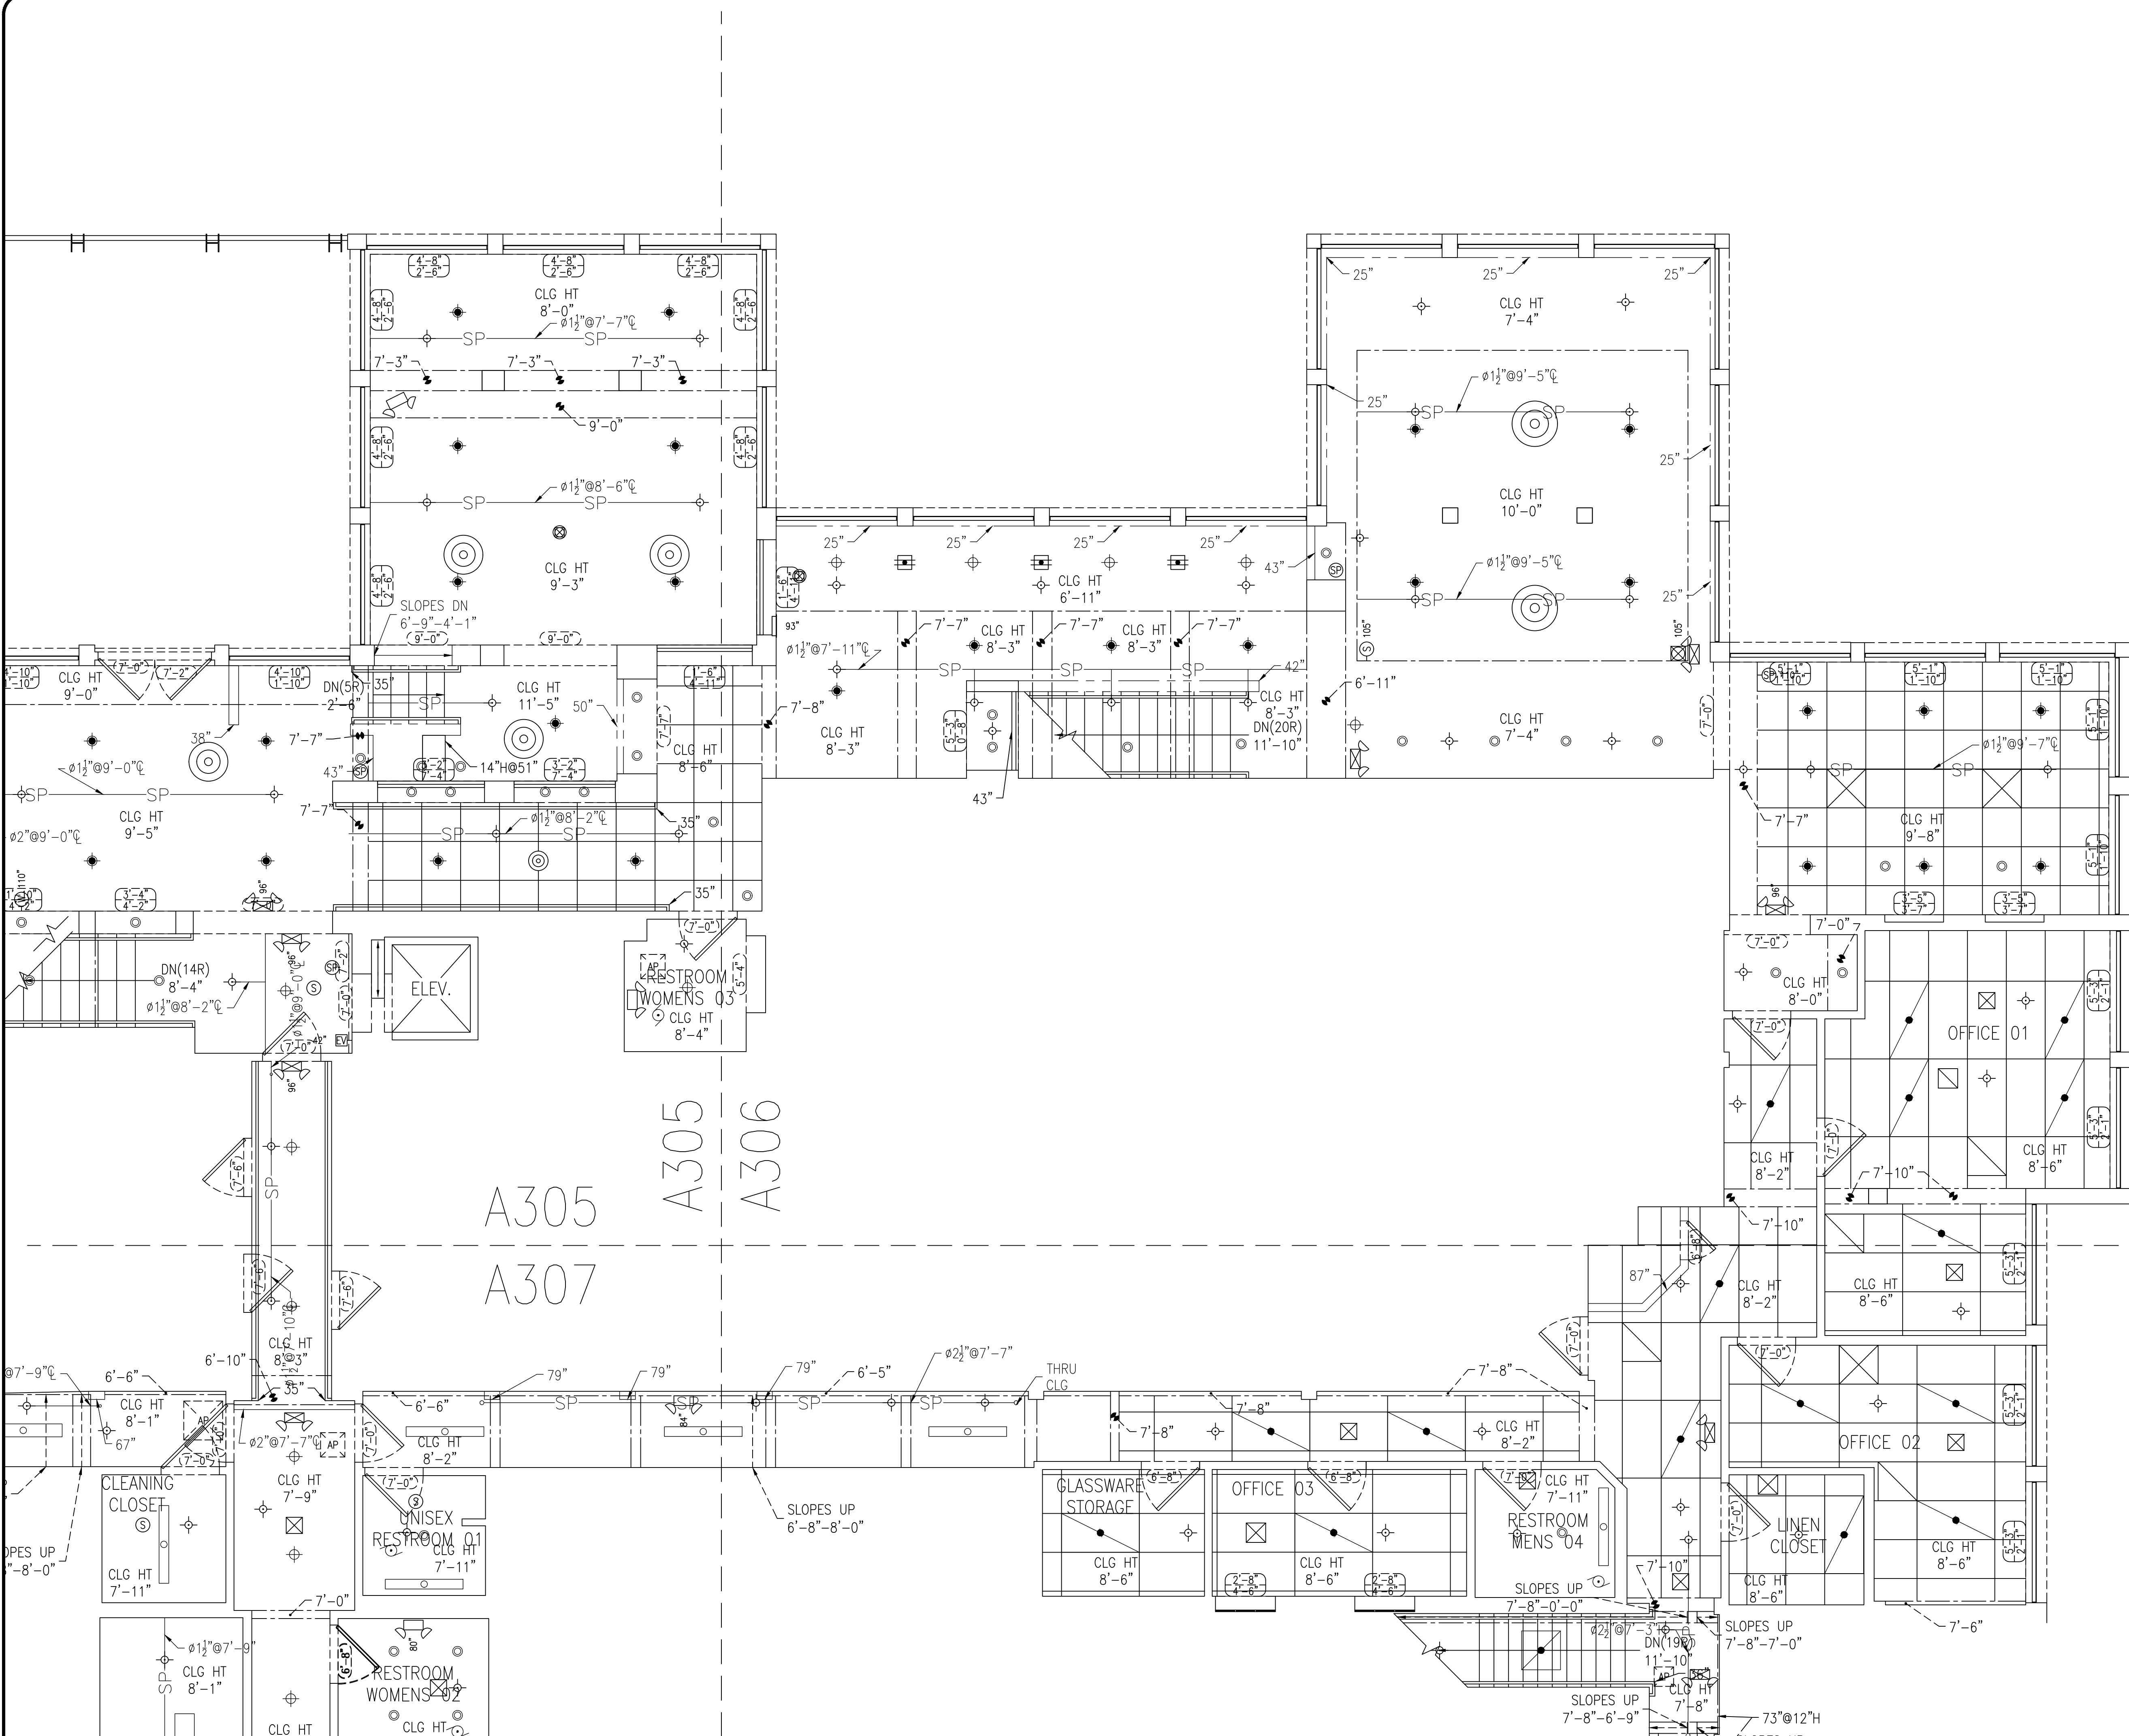

2ND LEVEL REFLECTED CEILING PLAN-2

SCALE: 1/4" = 1'-0"



STYS HOSPITALITY INITIATIVE
 462 BOSTON ST
 TOPSFIELD, MA 01983

Drawn By: A. HURT
 Checked By: J. CLOOS
 Project Number: 190721

SMITH-WOLLENSKY
 1 WASHINGTON AVENUE
 MIAMI BEACH, FL 33139

COAST 2 COAST
 7704 BASSWOOD DR.
 CHATTANOOGA, TN 37416
 PH. 423.296.9000
 www.coast2coast.net

Date: 09/22/2019

A306

TAGS & LABELS		
ROOM NAME	AREA/ROOM IDENTIFIERS	DOOR OPENING TAG
CLG HT 9'-0"	CEILING HEIGHT INDICATOR	WINDOW SILL & OPENING TAG

DOORS	
STANDARD DOOR	TOILET PARTITION DOOR
DOUBLE SWING DOOR	SLIDING & POCKET DOOR
OVERHEAD DOOR	SLIDING DOOR
SINGLE FOLD DOOR	BI-FOLD DOOR
ELEVATOR DOUBLE DOOR	ELEVATOR SINGLE DOOR


ELECTRICAL	
SINGLE OUTLET	DUPLEX OUTLET
QUAD OUTLET	COVER PLATE
SPEAKER	SECURITY CAMERA
WIFI ROUTER	MOTION SENSOR
RFID ANTENNA	JUNCTION BOX
DATA	TELEPHONE
DATA/PHONE COMBO	
EXHAUST FAN w/o LIGHT	EXHAUST FAN w/ LIGHT
EXHAUST FAN w/o LIGHT	EXHAUST FAN w/ LIGHT

FIRE PROTECTION	
ALARM BELL/STROBE	SMOKE DETECTOR
GENERAL ALARM	HEAT DETECTOR
CARBON MONOXIDE	SPRINKLER HEAD

HVAC	
SUPPLY DIFFUSER	ROUND SUPPLY DIFFUSER
RETURN DIFFUSER	WALL DIFFUSER
EQUALIZER DIFFUSER	

LIGHTING	
SURFACE FLUORESCENT LIGHT	EXIT LIGHT
RECESSED FLUORESCENT LIGHT	EMERGENCY LIGHT WITH EXIT
LIGHT TRACK	EMERGENCY LIGHT
SURFACE MOUNTED CEILING LIGHT	RECESSED CEILING LIGHT
PENDANT CEILING LIGHT	

OTHER	
WALL ACCESS PANEL	BREAKLINE
CEILING ACCESS PANEL	

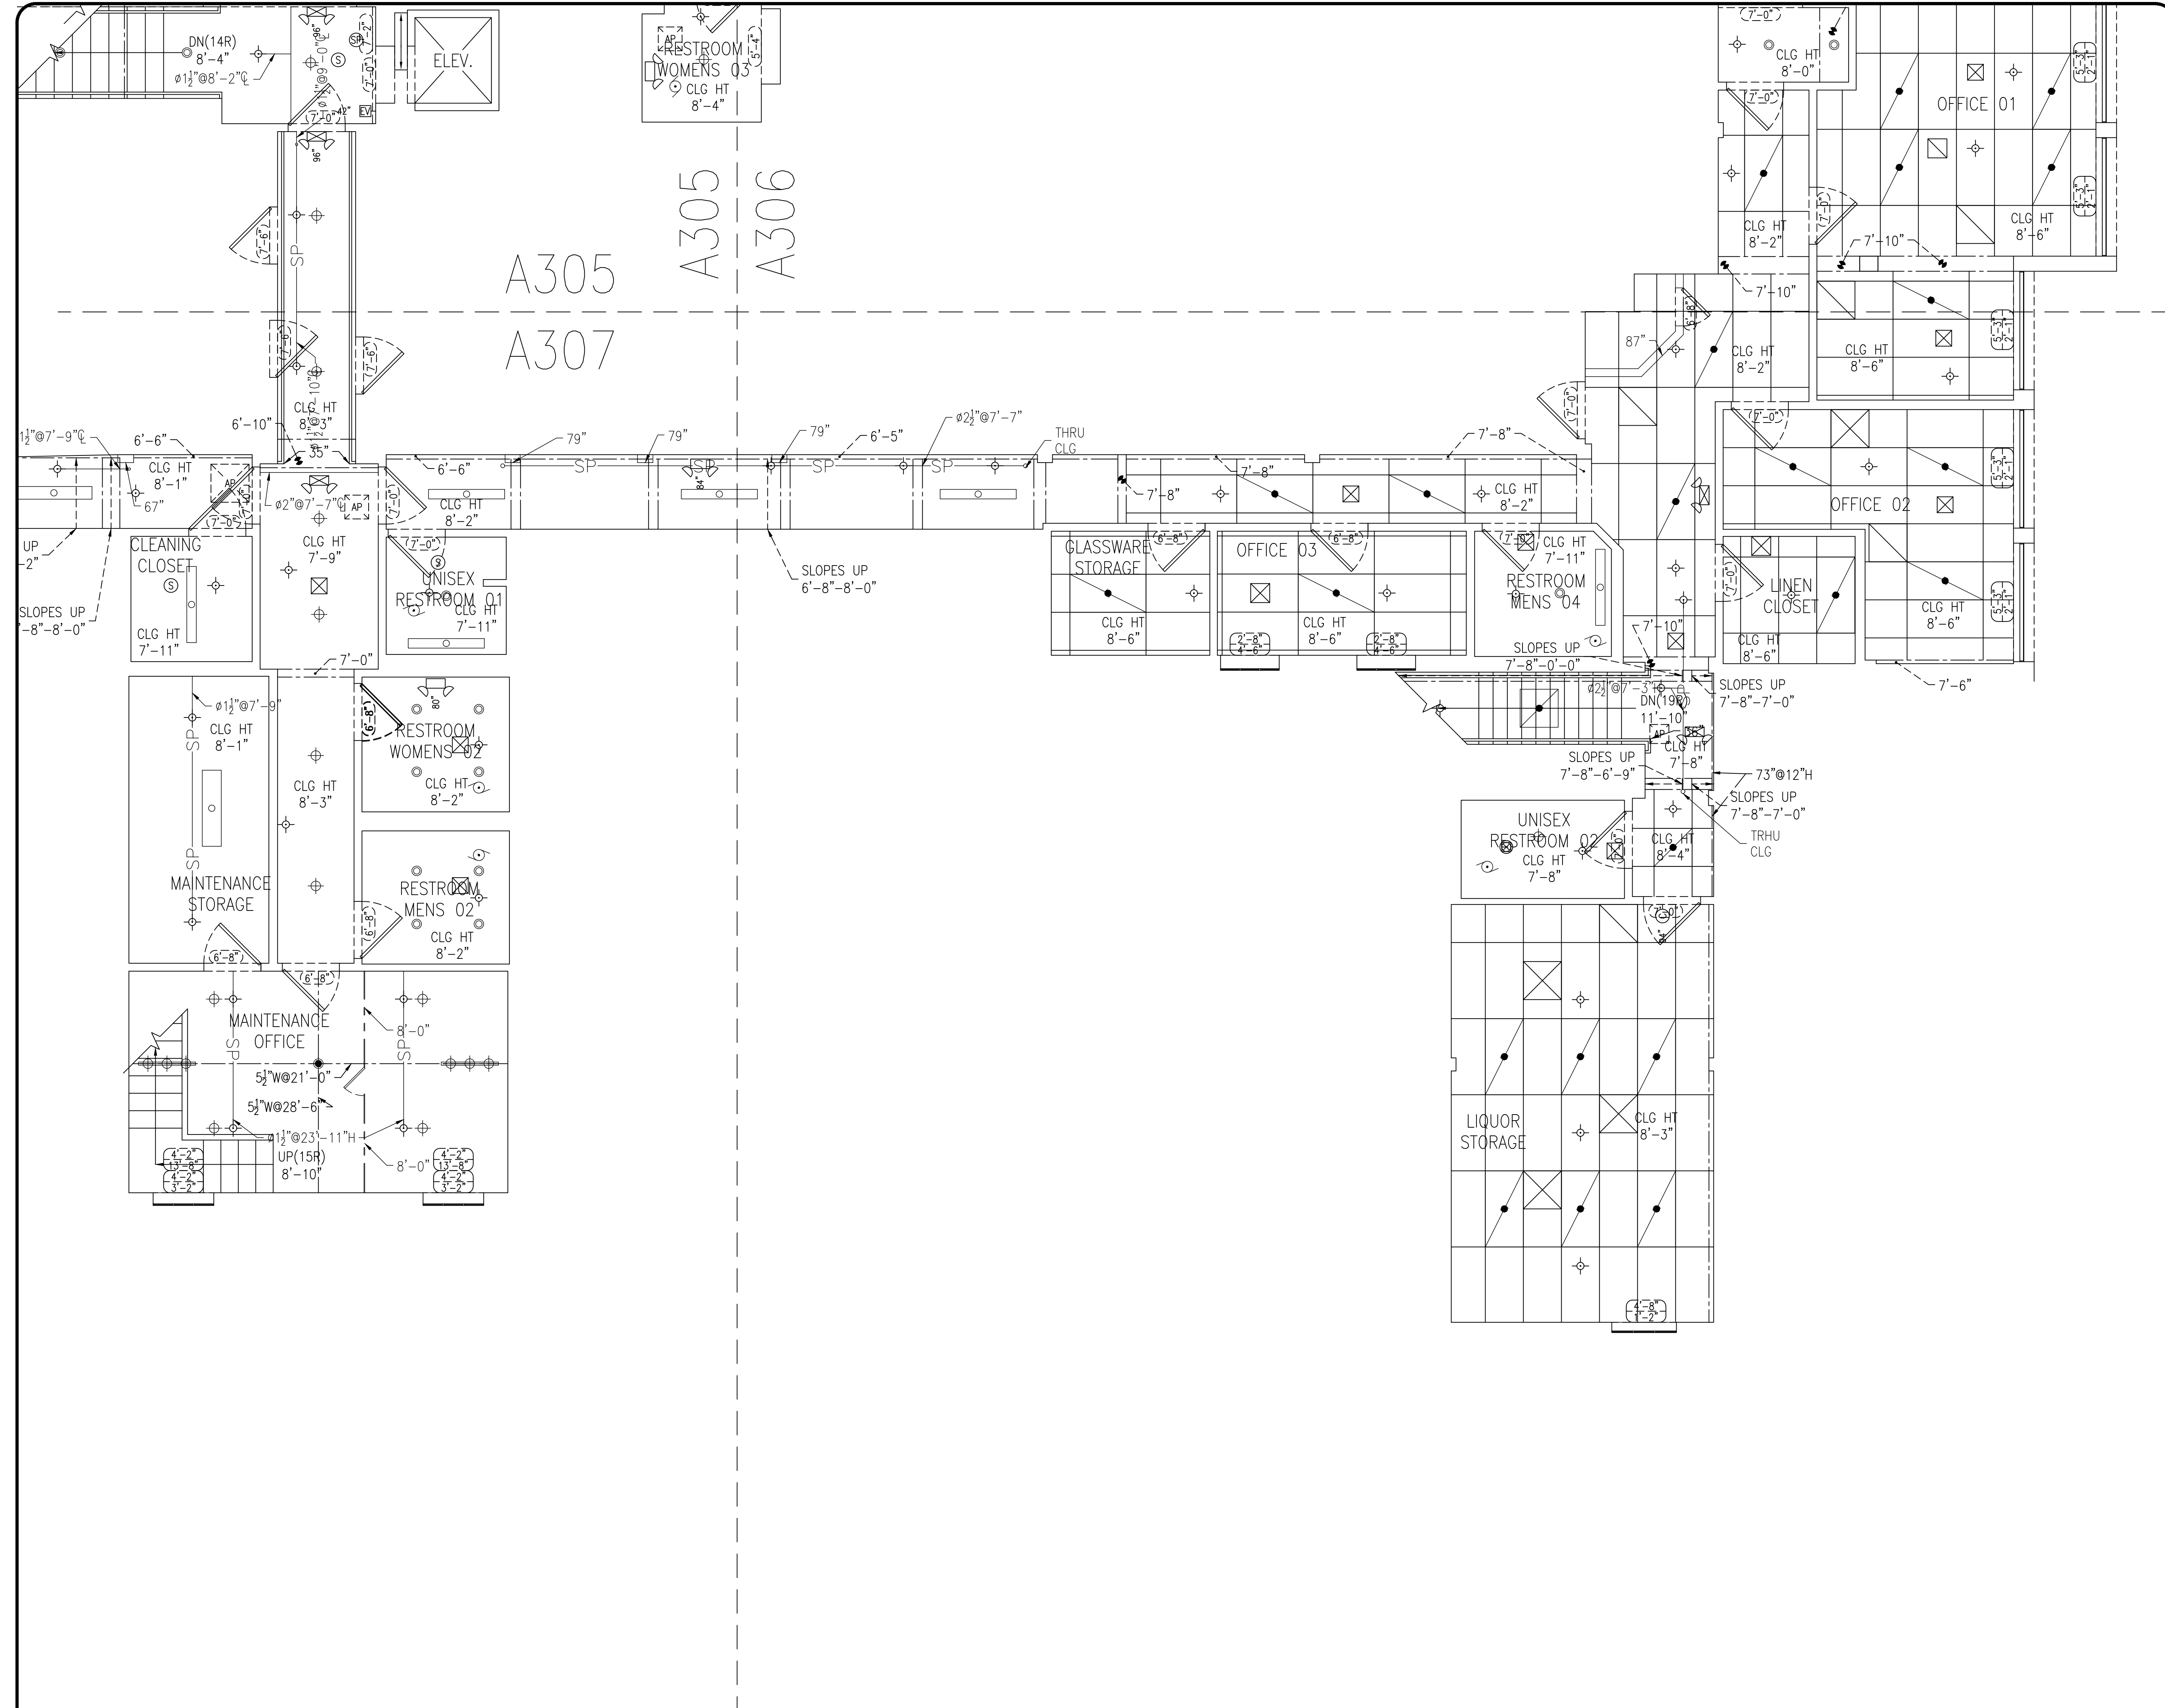

2ND LEVEL REFLECTED CEILING PLAN-3

SCALE: 1/4" = 1'-0"



STYS HOSPITALITY INITIATIVE
 462 BOSTON ST
 TOPSFIELD, MA 01983

Drawn By: A. HURT
 Checked By: J. CLOOS
 Project Number: 190721

SMITH-WOLLENSKY
 1 WASHINGTON AVENUE
 MIAMI BEACH, FL 33139

COAST 2 COAST
 7704 BASSWOOD DR.
 CHATTANOOGA, TN 37416
 PH. 423.296.9000
 www.coast2coast.net

Date: 09/22/2019

A307

TAGS & LABELS

ROOM NAME	AREA/ROOM IDENTIFIERS		DOOR OPENING TAG
CLG HT 9'-0"	CEILING HEIGHT INDICATOR		WINDOW SILL & OPENING TAG

DOORS

	STANDARD DOOR		TOILET PARTITION DOOR
	DOUBLE SWING DOOR		SLIDING & POCKET DOOR
	OVERHEAD DOOR		SLIDING DOOR
	SINGLE FOLD DOOR		BI-FOLD DOOR
	ELEVATOR DOUBLE DOOR		ELEVATOR SINGLE DOOR

ELECTRICAL

	SINGLE OUTLET		DUPLEX OUTLET
	QUAD OUTLET		COVER PLATE
	SPEAKER		SECURITY CAMERA
	WIFI ROUTER		MOTION SENSOR
	RFID ANTENNA		JUNCTION BOX
	DATA		TELEPHONE
	DATA/PHONE COMBO		
	EXHAUST FAN w/o LIGHT		EXHAUST FAN w/ LIGHT
	EXHAUST FAN w/o LIGHT		EXHAUST FAN w/ LIGHT

FIRE PROTECTION

	ALARM BELL/STROBE		SMOKE DETECTOR
	GENERAL ALARM		HEAT DETECTOR
	CARBON MONOXIDE		SPRINKLER HEAD

HVAC


	SUPPLY DIFFUSER		ROUND SUPPLY DIFFUSER
	RETURN DIFFUSER		WALL DIFFUSER
	EQUALIZER DIFFUSER		

LIGHTING

	SURFACE FLUORESCENT LIGHT		EXIT LIGHT
	RECESSED FLUORESCENT LIGHT		EMERGENCY LIGHT WITH EXIT
	LIGHT TRACK		EMERGENCY LIGHT
	SURFACE MOUNTED CEILING LIGHT		RECESSED CEILING LIGHT
	PENDANT CEILING LIGHT		

OTHER

	WALL ACCESS PANEL		BREAKLINE
	CEILING ACCESS PANEL		

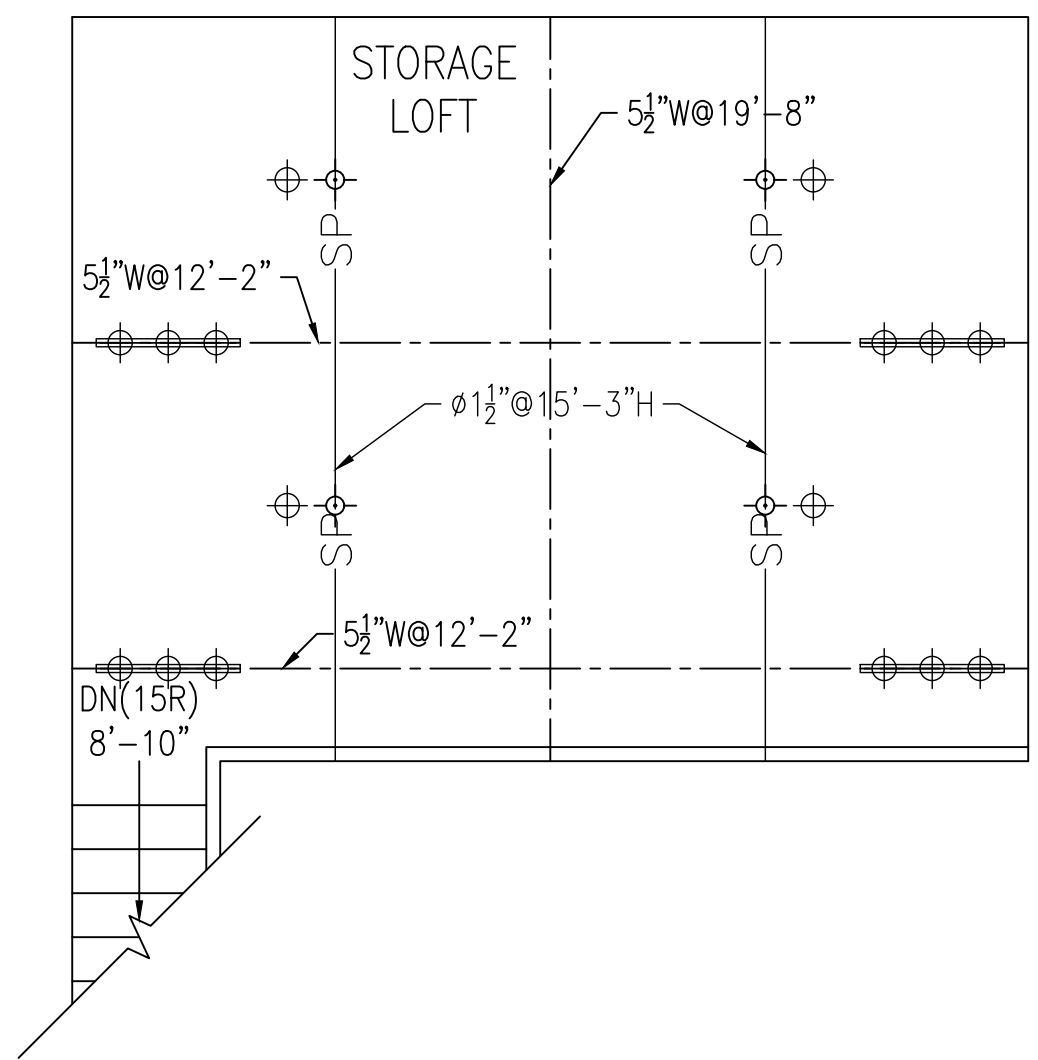

STORAGE LOFT REFLECTED CEILING

SCALE: 1/4" = 1'-0"



STYS HOSPITALITY INITIATIVE
 462 BOSTON ST
 TOPSFIELD, MA 01983

Drawn By: A. HURT
 Checked By: J. CLOOS
 Project Number: 190721

SMITH-WOLLENSKY
 1 WASHINGTON AVENUE
 MIAMI BEACH, FL 33139

COAST 2 COAST
 7704 BASSWOOD DR.
 CHATTANOOGA, TN 37416
 PH. 423.296.9000
 www.coast2coast.net

Date: 09/22/2019

A308