

TAGS & LABELS

ROOM NAME IDENTIFIERS	DOOR OPENING TAG
CLG HT 9'-0"	WINDOW SILL & OPENING TAG
CEILING HEIGHT INDICATOR	

DOORS

STANDARD DOOR	TOILET PARTITION DOOR
DOUBLE SWING DOOR	SLIDING & POCKET DOOR
OVERHEAD DOOR	SLIDING DOOR
SINGLE FOLD DOOR	BI-FOLD DOOR
ELEVATOR DOUBLE DOOR	ELEVATOR SINGLE DOOR

ELECTRICAL

SINGLE OUTLET	DUPLEX OUTLET
QUAD OUTLET	COVER PLATE
SPEAKER	SECURITY CAMERA
WIFI ROUTER	MOTION SENSOR
RFD ANTENNA	JUNCTION BOX
DATA	TELEPHONE
DATA/PHONE COMBO	
EXHAUST FAN w/o LIGHT	EXHAUST FAN w/ LIGHT
EXHAUST FAN w/o LIGHT	EXHAUST FAN w/ LIGHT

FIRE PROTECTION

ALARM BELL/STROBE	SMOKE DETECTOR
GENERAL ALARM	HEAT DETECTOR
CARBON MONOXIDE	SPRINKLER HEAD

HVAC


SUPPLY DIFFUSER	ROUND SUPPLY DIFFUSER
RETURN DIFFUSER	WALL DIFFUSER
EQUALIZER DIFFUSER	

LIGHTING

SURFACE FLUORESCENT LIGHT	EXIT LIGHT
RECESSED FLUORESCENT LIGHT	EMERGENCY LIGHT WITH EXIT
LIGHT TRACK	EMERGENCY LIGHT
SURFACE MOUNTED CEILING LIGHT	RECESSED CEILING LIGHT
PENDANT CEILING LIGHT	

OTHER

WALL ACCESS PANEL	BREAKLINE
CEILING ACCESS PANEL	

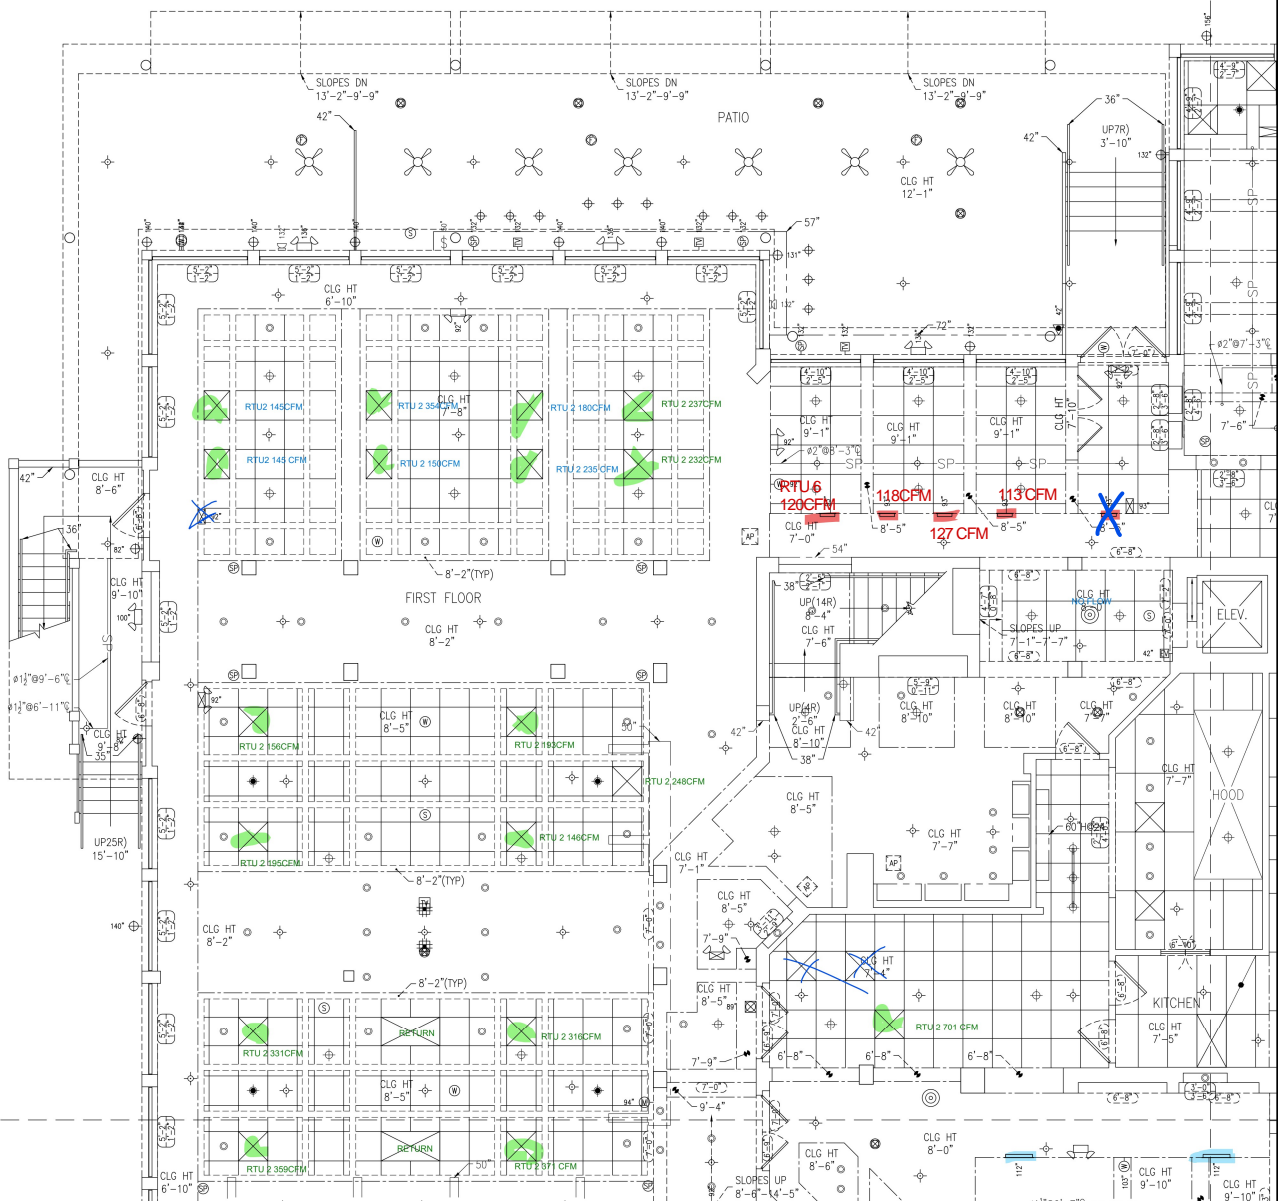


A301
A302


1ST LEVEL REFLECTED CEILING PLAN-1

SCALE: 1/4" = 1'-0"



TAGS & LABELS	
ROOM NAME IDENTIFIERS	DOOR OPENING TAG
CLG HT 9'-0"	WINDOW SILL & OPENING TAG
CEILING HEIGHT INDICATOR	
DOORS	
STANDARD DOOR	TOILET PARTITION DOOR
DOUBLE SWING DOOR	SLIDING & POCKET DOOR
OVERHEAD DOOR	SLIDING DOOR
SINGLE FOLD DOOR	BI-FOLD DOOR
ELEVATOR DOUBLE DOOR	ELEVATOR SINGLE DOOR
ELECTRICAL	
SINGLE OUTLET	DUPLEX OUTLET
QUAD OUTLET	COVER PLATE
SPEAKER	SECURITY CAMERA
WIFI ROUTER	MOTION SENSOR
RFID ANTENNA	JUNCTION BOX
DATA	TELEPHONE
DATA/PHONE COMBO	
EXHAUST FAN w/ LIGHT	EXHAUST FAN w/ LIGHT
EXHAUST FAN w/ LIGHT	EXHAUST FAN w/ LIGHT
FIRE PROTECTION	
ALARM BELL/STROBE	SMOKE DETECTOR
GENERAL ALARM	HEAT DETECTOR
CARBON MONOXIDE	SPRINKLER HEAD
HVAC	
SUPPLY DIFFUSER	ROUND SUPPLY DIFFUSER
RETURN DIFFUSER	WALL DIFFUSER
EQUALIZER DIFFUSER	
LIGHTING	
SURFACE FLUORESCENT LIGHT	EXIT LIGHT
RECESSED FLUORESCENT LIGHT	EMERGENCY LIGHT WITH EXIT
LIGHT TRACK	EMERGENCY LIGHT
SURFACE MOUNTED CEILING LIGHT	RECESSED CEILING LIGHT
PENDANT CEILING LIGHT	
OTHER	
WALL ACCESS PANEL	BREAKLINE
CEILING ACCESS PANEL	

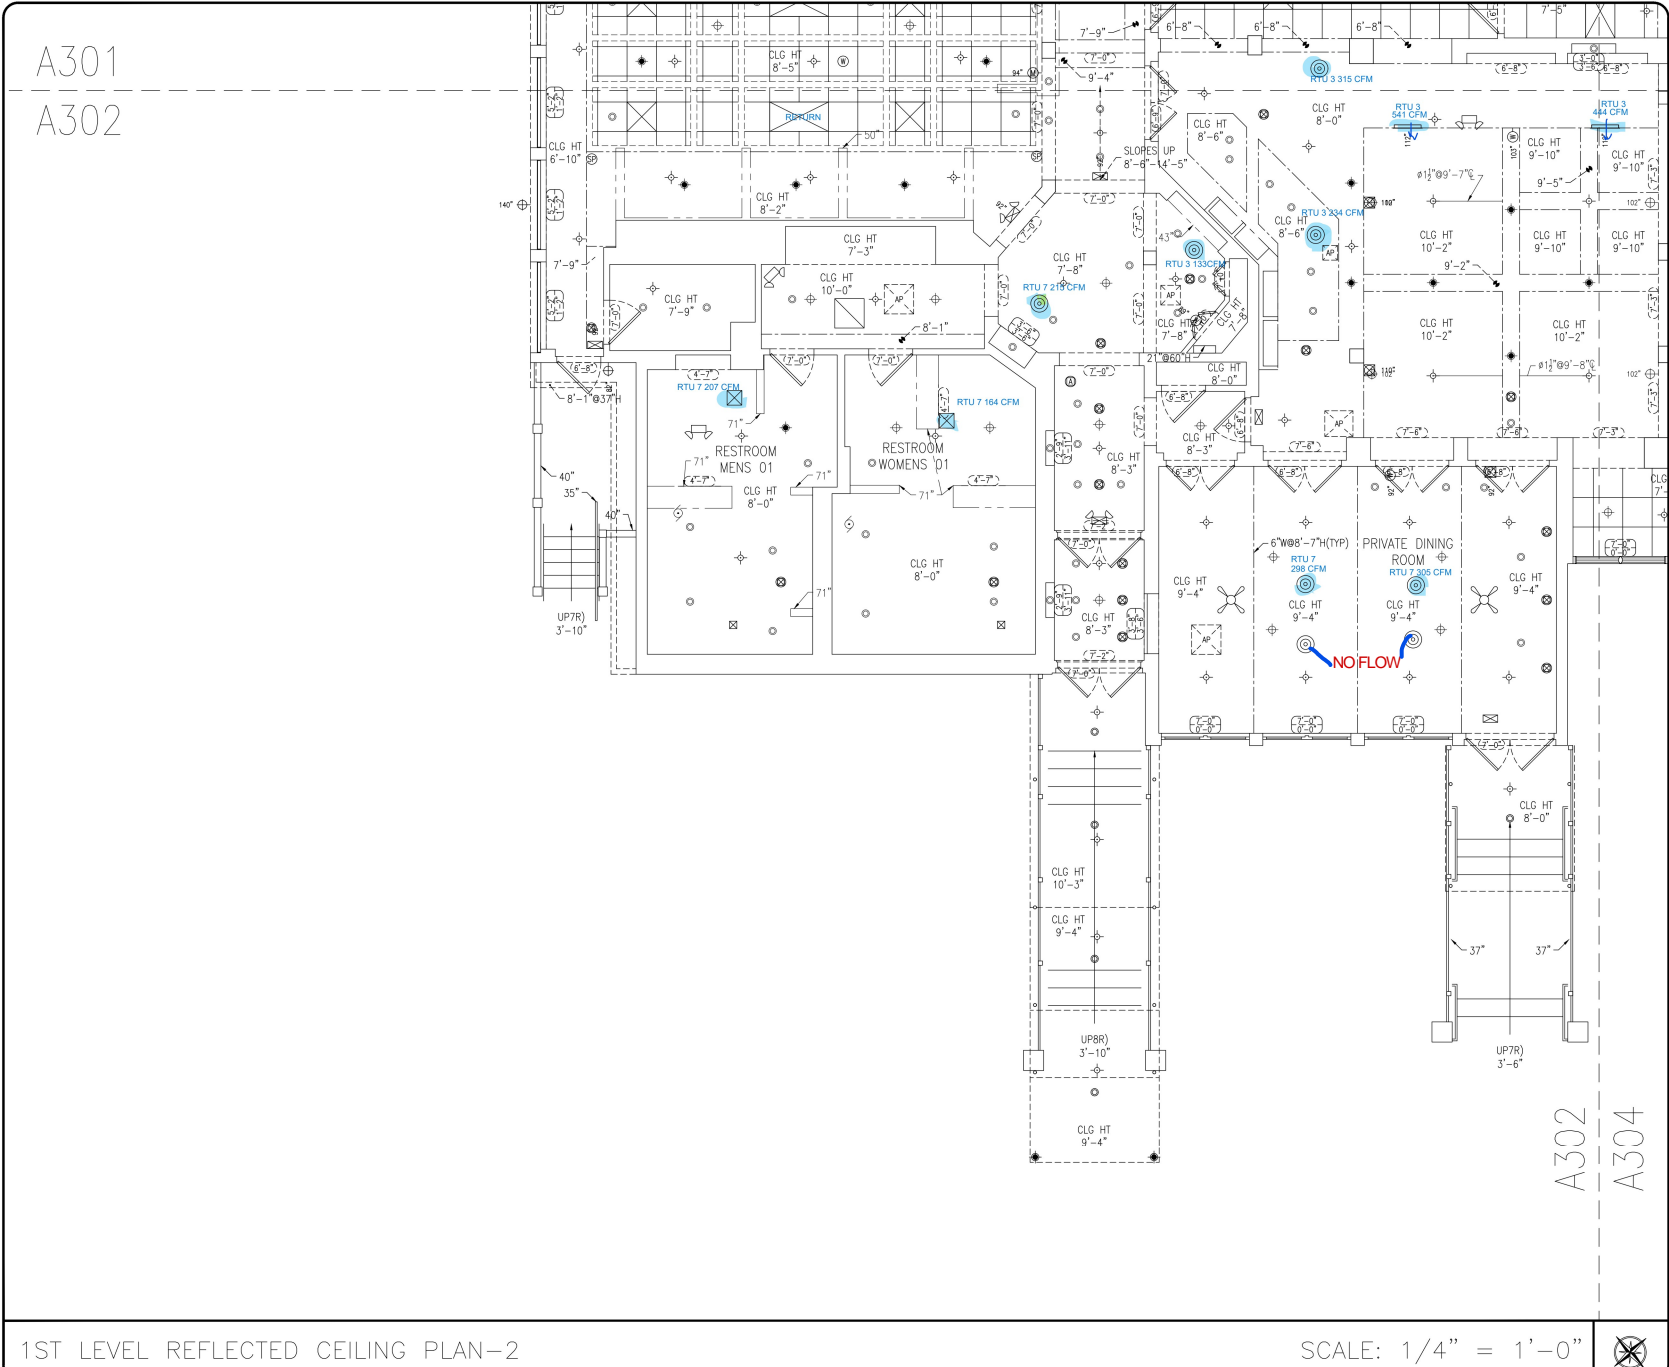



STYS HOSPITALITY INITIATIVE
462 BOSTON ST
TOPSFIELD, MA 01983

Drawn By: A. HURT
Checked By: J. CLOOS
Project Number: 190721

SMITH-WOLLENSKY
1 WASHINGTON AVENUE
MIAMI BEACH, FL 33139

COAST 2 COAST
7704 BASSWOOD DR.
CHATTANOOGA, TN 37416
PH: 423.296.9000
www.coast2coast.net

Date: 09/22/2019

A302

1ST LEVEL REFLECTED CEILING PLAN-2

SCALE: 1/4" = 1'-0"



TAGS & LABELS

ROW NAME IDENTIFIERS	DOOR OPENING TAG
CLG HT 9'-0"	WINDOW SILL & OPENING TAG
CEILING HEIGHT INDICATOR	

DOORS

STANDARD DOOR	TOILET PARTITION DOOR
DOUBLE SWING DOOR	SLIDING & POCKET DOOR
OVERHEAD DOOR	SLIDING DOOR
SINGLE FOLD DOOR	BI-FOLD DOOR
ELEVATOR DOUBLE DOOR	ELEVATOR SINGLE DOOR

ELECTRICAL

SINGLE OUTLET	DUPLEX OUTLET
QUAD OUTLET	COVER PLATE
SPEAKER	SECURITY CAMERA
WIFI ROUTER	MOTION SENSOR
RFD ANTENNA	JUNCTION BOX
DATA	TELEPHONE
DATA/PHONE COMBO	
EXHAUST FAN w/o LIGHT	EXHAUST FAN w/ LIGHT
EXHAUST FAN w/o LIGHT	EXHAUST FAN w/ LIGHT

FIRE PROTECTION

ALARM BELL/STROBE	SMOKE DETECTOR
GENERAL ALARM	HEAT DETECTOR
CARBON MONOXIDE	SPRINKLER HEAD

HVAC

SUPPLY DIFFUSER	ROUND SUPPLY DIFFUSER
RETURN DIFFUSER	WALL DIFFUSER
EQUALIZER DIFFUSER	


LIGHTING

SURFACE FLUORESCENT LIGHT	EXIT LIGHT
RECESSED FLUORESCENT LIGHT	EMERGENCY LIGHT WITH EXIT
LIGHT TRACK	EMERGENCY LIGHT
SURFACE MOUNTED CEILING LIGHT	RECESSED CEILING LIGHT
PENDANT CEILING LIGHT	

OTHER

WALL ACCESS PANEL	BREAKLINE
CEILING ACCESS PANEL	

NOTICEABLE DRAFT (YELLOW LINE)

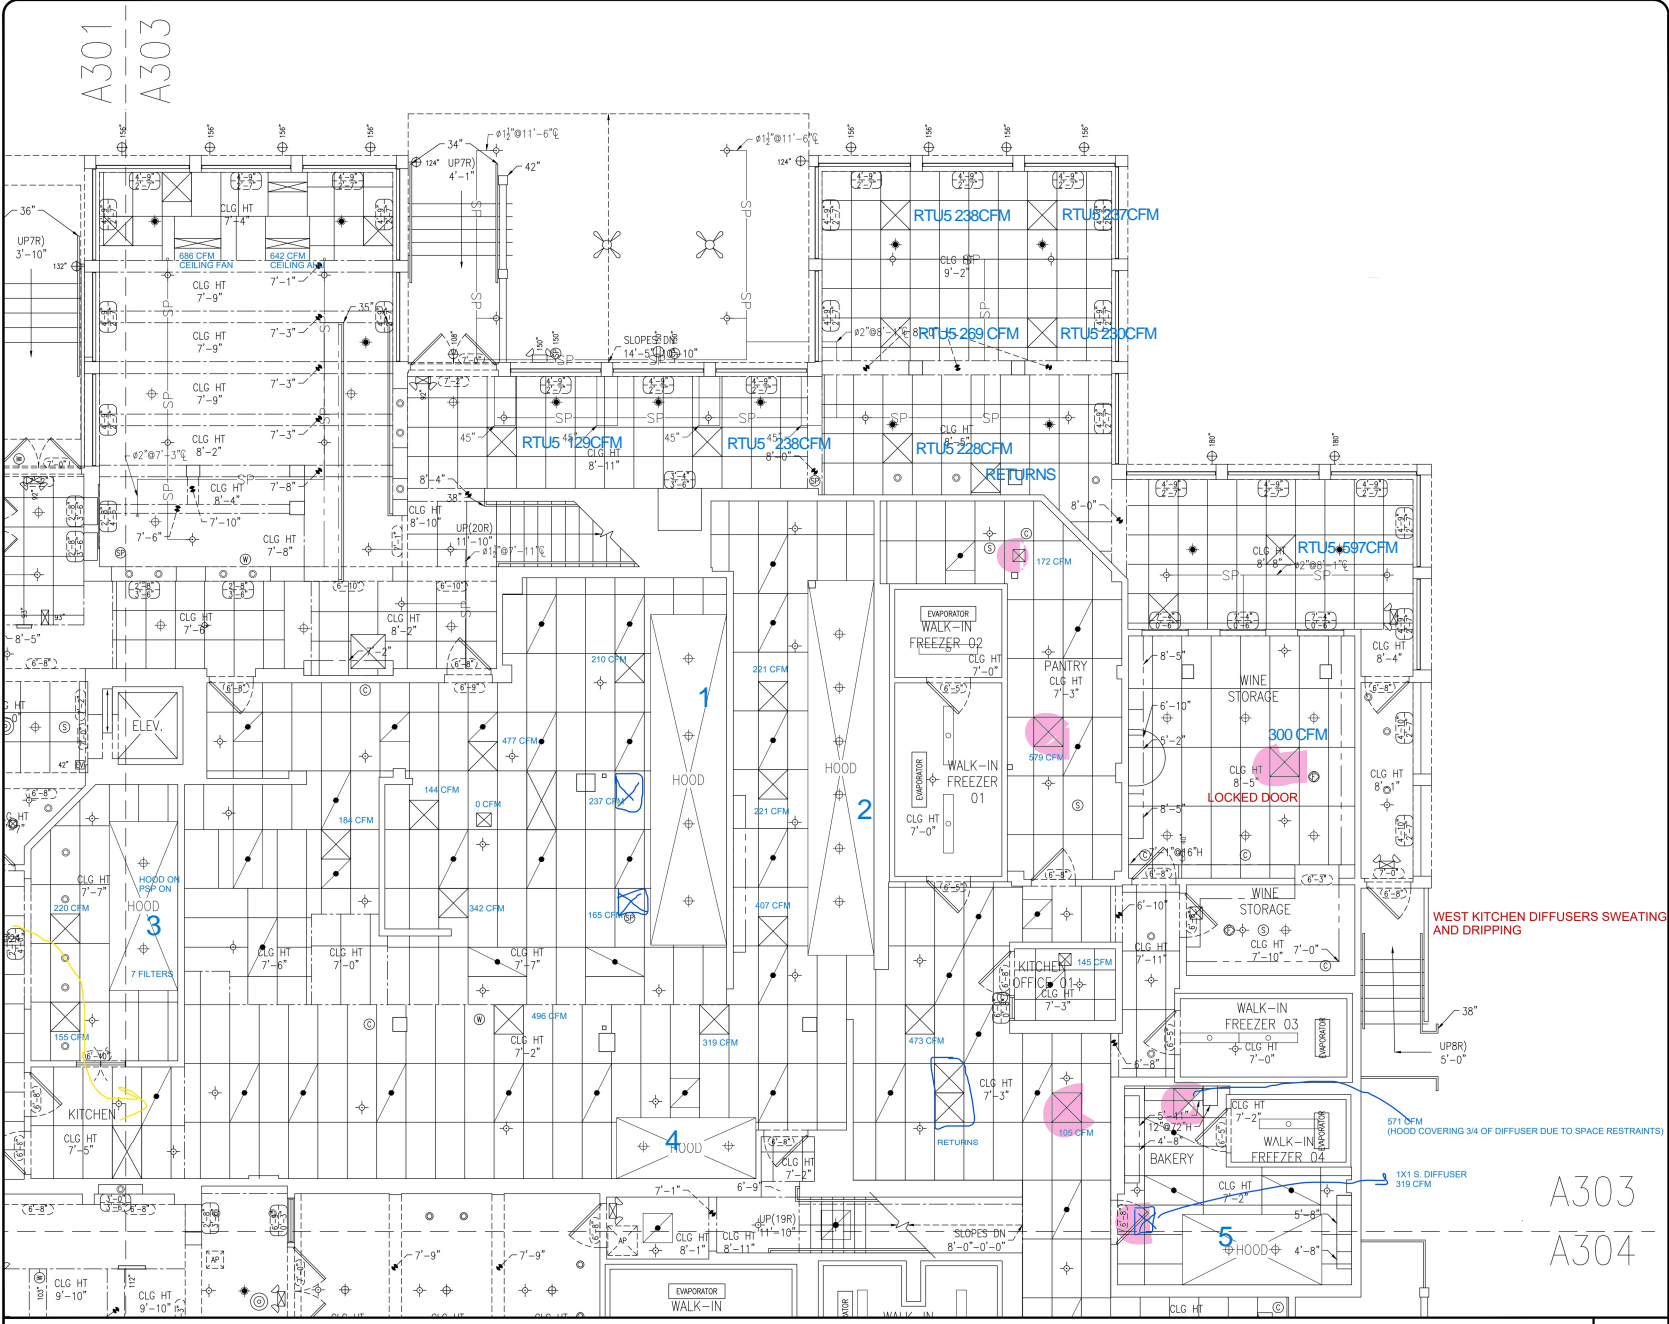

1ST LEVEL REFLECTED CEILING PLAN-3

SCALE: 1/4" = 1'-0"



A303
A304



STYS HOSPITALITY INITIATIVE
462 BOSTON ST
TOPSFIELD, MA 01983

Drawn By: A. HURT
Checked By: J. CLOOS
Project Number: 190721


SMITH-WOLLENSKY
1 WASHINGTON AVENUE
MIAMI BEACH, FL 33139

COAST 2 COAST
7704 BASSWOOD DR.
CHATTANOOGA, TN 37416
PH: 423.296.9000
www.coast2coast.net

Date: 09/22/2019

A304

TAGS & LABELS	
ROOM NAME IDENTIFIERS	DOOR OPENING TAG
CLG HT 9'-0"	WINDOW SILL & OPENING TAG
CEILING HEIGHT INDICATOR	
DOORS	
STANDARD DOOR	TOILET PARTITION DOOR
DOUBLE SWING DOOR	SLIDING & POCKET DOOR
OVERHEAD DOOR	SLIDING DOOR
SINGLE FOLD DOOR	BI-FOLD DOOR
ELEVATOR DOUBLE DOOR	ELEVATOR SINGLE DOOR
ELECTRICAL	
SINGLE OUTLET	DUPLEX OUTLET
QUAD OUTLET	COVER PLATE
SPEAKER	SECURITY CAMERA
WIFI ROUTER	MOTION SENSOR
RFID ANTENNA	JUNCTION BOX
DATA	TELEPHONE
DATA/PHONE COMBO	
EXHAUST FAN w/ LIGHT	EXHAUST FAN w/ LIGHT
EXHAUST FAN w/o LIGHT	EXHAUST FAN w/ LIGHT
FIRE PROTECTION	
ALARM BELL/STROBE	SMOKE DETECTOR
GENERAL ALARM	HEAT DETECTOR
CARBON MONOXIDE	SPRINKLER HEAD
HVAC	
SUPPLY DIFFUSER	ROUND SUPPLY DIFFUSER
RETURN DIFFUSER	WALL DIFFUSER
EQUALIZER DIFFUSER	
LIGHTING	
SURFACE FLUORESCENT LIGHT	EXIT LIGHT
RECESSED FLUORESCENT LIGHT	EMERGENCY LIGHT WITH EXIT
LIGHT TRACK	EMERGENCY LIGHT
SURFACE MOUNTED CEILING LIGHT	RECESSED CEILING LIGHT
PENDANT CEILING LIGHT	
OTHER	
WALL ACCESS PANEL	BREAKLINE
CEILING ACCESS PANEL	

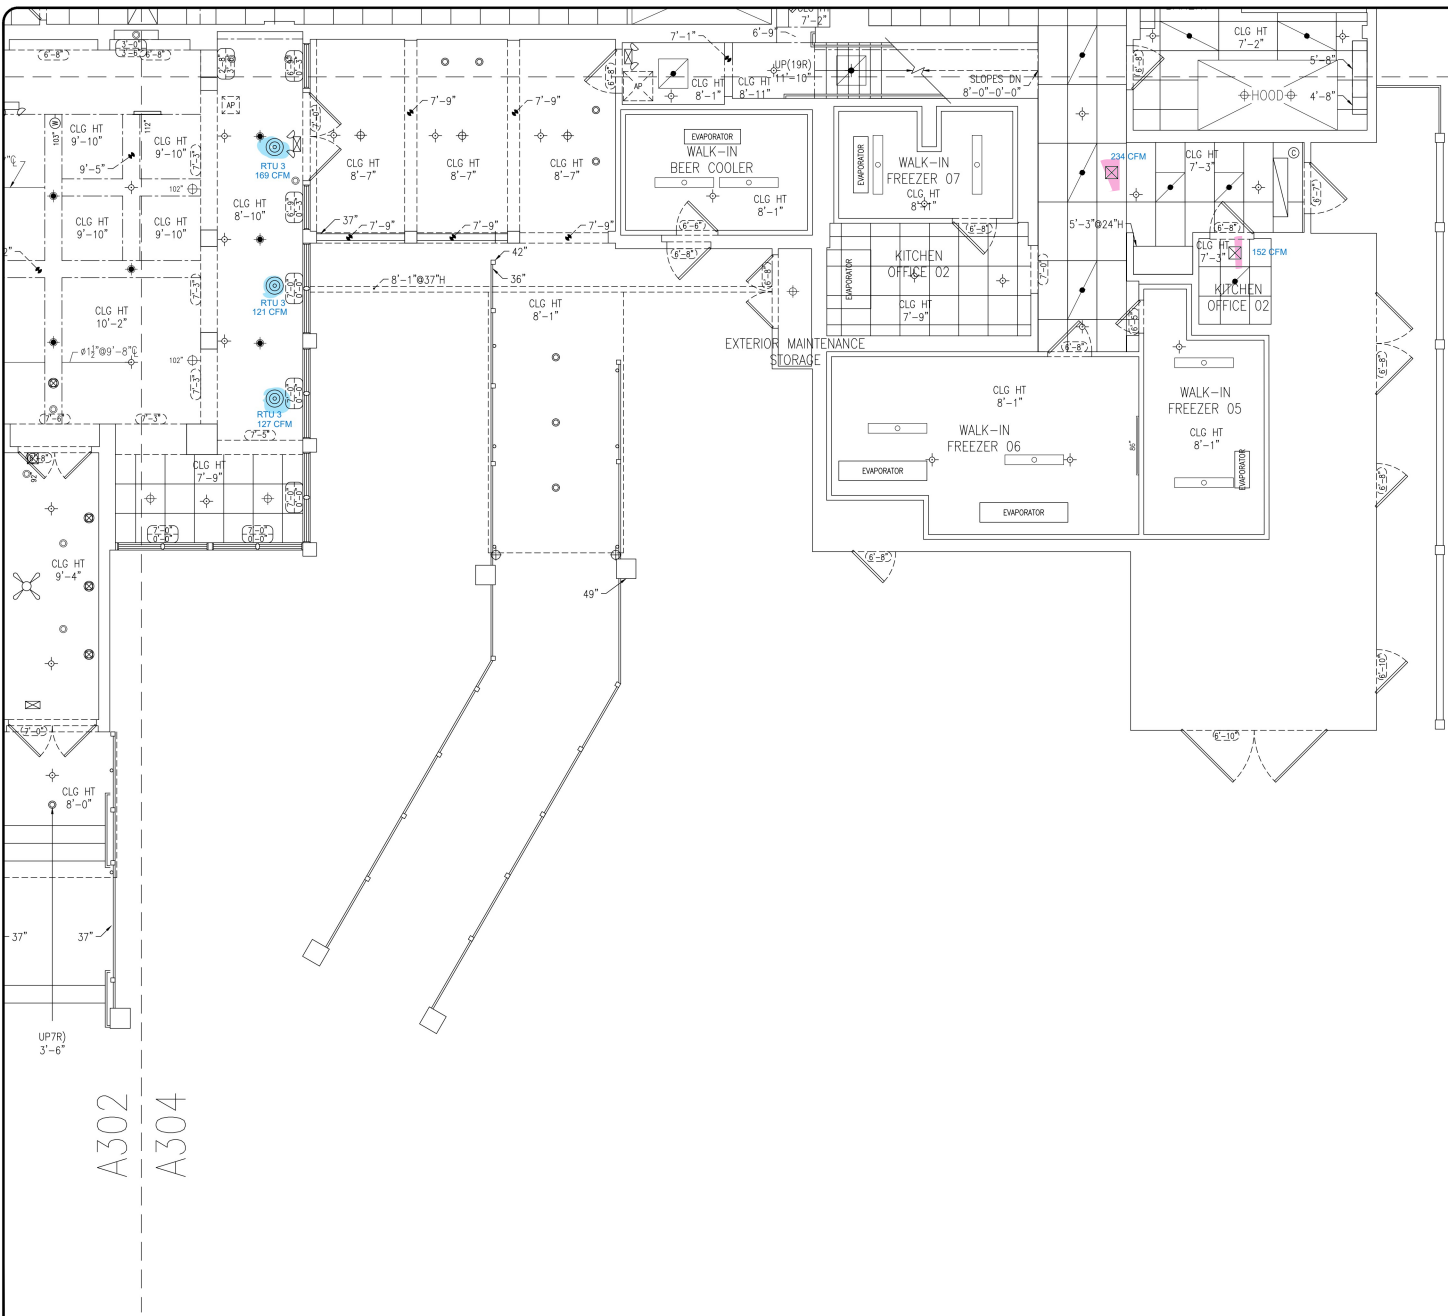


A302
A304

1ST LEVEL REFLECTED CEILING PLAN-4

SCALE: 1/4" = 1'-0"




TAGS & LABELS	
AREA/ROOM IDENTIFIERS	DOOR OPENING TAG
CLG HT 9'-0"	WINDOW SILL & OPENING TAG
DOORS	
STANDARD DOOR	TOILET PARTITION DOOR
DOUBLE SWING DOOR	SLIDING & POCKET DOOR
OVERHEAD DOOR	SLIDING DOOR
SINGLE FOLD DOOR	B-FOLD DOOR
ELEVATOR DOUBLE DOOR	ELEVATOR SINGLE DOOR
ELECTRICAL	
SINGLE OUTLET	DUPLEX OUTLET
QUAD OUTLET	COVER PLATE
SPEAKER	SECURITY CAMERA
WIFI ROUTER	MOTION SENSOR
RFID ANTENNA	JUNCTION BOX
DATA	TELEPHONE
DATA/PHONE COMBO	
EXHAUST FAN w/o LIGHT	EXHAUST FAN w/ LIGHT
EXHAUST FAN w/o LIGHT	EXHAUST FAN w/ LIGHT
FIRE PROTECTION	
ALARM BELL/STROBE	SMOKE DETECTOR
GENERAL ALARM	HEAT DETECTOR
CARBON MONOXIDE	SPRINKLER HEAD
HVAC	
SUPPLY DIFFUSER	ROUND SUPPLY DIFFUSER
RETURN DIFFUSER	WALL DIFFUSER
EQUALIZER DIFFUSER	
LIGHTING	
SURFACE FLUORESCENT LIGHT	EXIT LIGHT
RECESSED FLUORESCENT LIGHT	EMERGENCY LIGHT WITH EXIT
LIGHT TRACK	EMERGENCY LIGHT
SURFACE MOUNTED CEILING LIGHT	RECESSED CEILING LIGHT
PENDANT CEILING LIGHT	
OTHER	
WALL ACCESS PANEL	BREAKLINE
CEILING ACCESS PANEL	

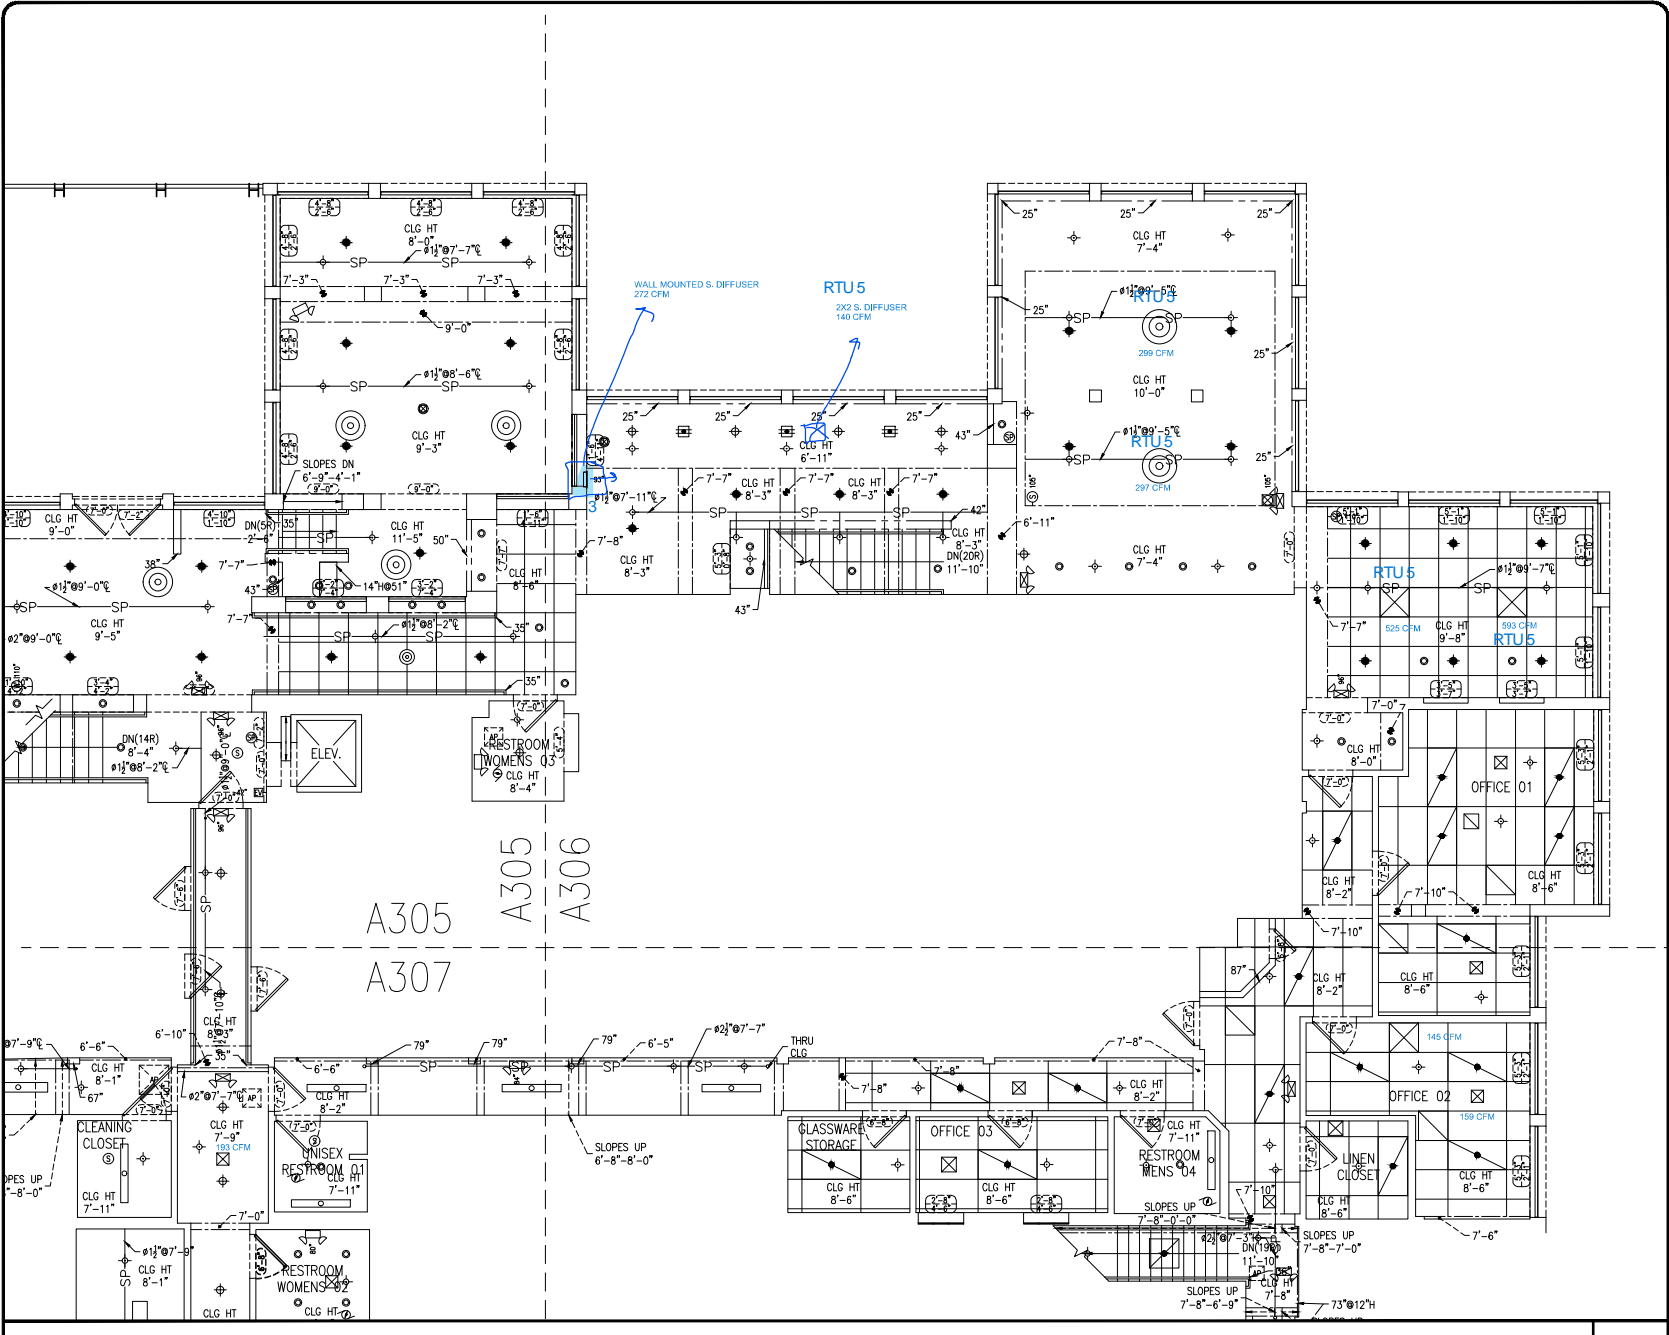

2ND LEVEL REFLECTED CEILING PLAN-2

SCALE: 1/4" = 1'-0"



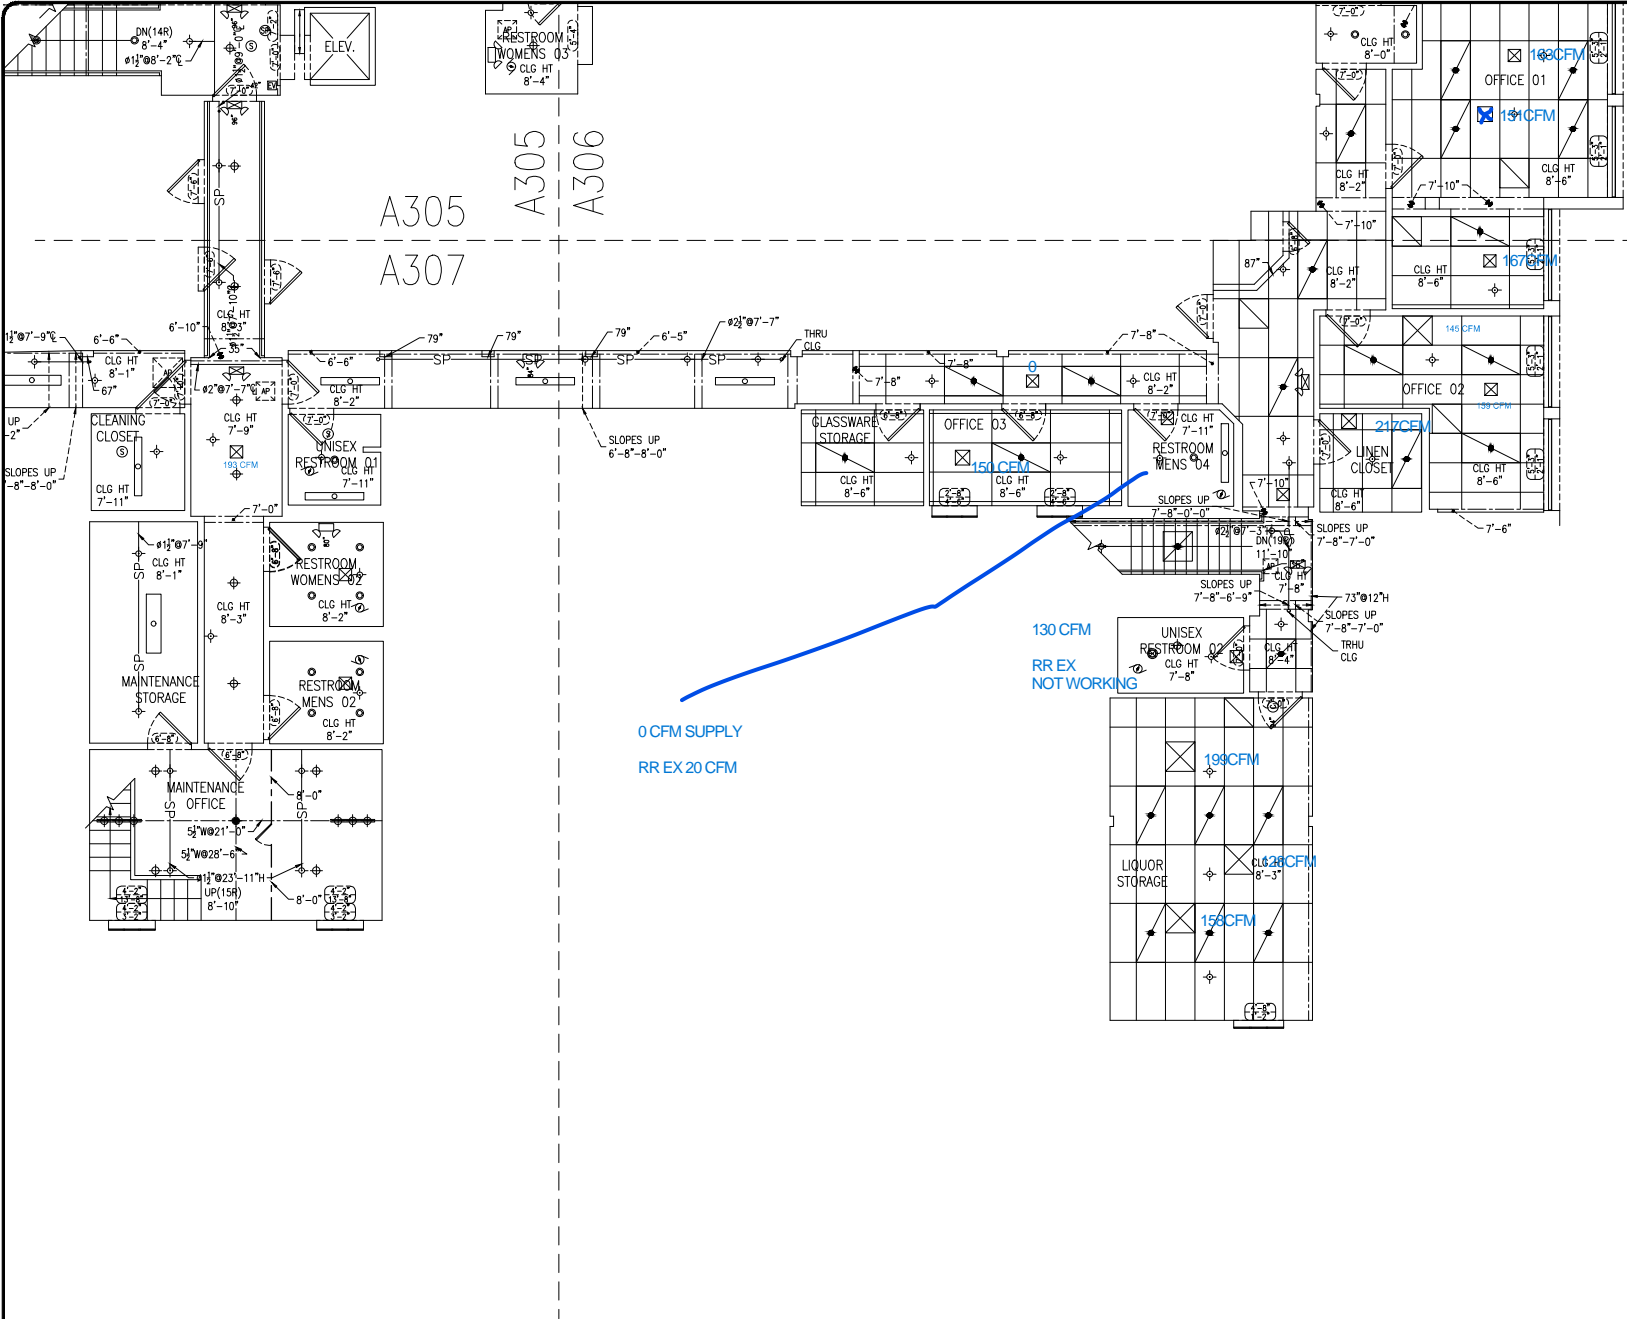

TAGS & LABELS	
ROOM NAME	DOOR OPENING TAG
CEILING HEIGHT INDICATOR	WINDOW SILL & OPENING TAG
DOORS	
STANDARD DOOR	TOILET PARTITION DOOR
DOUBLE SWING DOOR	SLIDING & POCKET DOOR
OVERHEAD DOOR	SLIDING DOOR
SINGLE FOLD DOOR	B-FOLD DOOR
ELEVATOR DOUBLE DOOR	ELEVATOR SINGLE DOOR
ELECTRICAL	
SINGLE OUTLET	DUPLEX OUTLET
QUAD OUTLET	COVER PLATE
SPEAKER	SECURITY CAMERA
WIFI ROUTER	MOTION SENSOR
RFD ANTENNA	JUNCTION BOX
DATA	TELEPHONE
DATA/PHONE COMBO	
EXHAUST FAN w/o LIGHT	EXHAUST FAN w/ LIGHT
EXHAUST FAN w/o LIGHT	EXHAUST FAN w/ LIGHT
FIRE PROTECTION	
ALARM BELL/STROBE	SMOKE DETECTOR
GENERAL ALARM	HEAT DETECTOR
CARBON MONOXIDE	SPRINKLER HEAD
HVAC	
SUPPLY DIFFUSER	ROUND SUPPLY DIFFUSER
RETURN DIFFUSER	WALL DIFFUSER
EQUALIZER DIFFUSER	
LIGHTING	
SURFACE FLUORESCENT LIGHT	EXIT LIGHT
RECESSED FLUORESCENT LIGHT	EMERGENCY LIGHT WITH EXIT
LIGHT TRACK	EMERGENCY LIGHT
SURFACE MOUNTED CEILING LIGHT	RECESSED CEILING LIGHT
PENDANT CEILING LIGHT	
OTHER	
WALL ACCESS PANEL	BREAKLINE
CEILING ACCESS PANEL	

2ND LEVEL REFLECTED CEILING PLAN-3

SCALE: 1/4" = 1'-0"



TAGS & LABELS

ROOM NAME IDENTIFIERS		DOOR OPENING TAG	
CLG HT 9'-0" INDICATOR		WINDOW SILL & OPENING TAG	

DOORS

STANDARD DOOR		TOILET PARTITION DOOR	
DOUBLE SWING DOOR		SLIDING & POCKET DOOR	
OVERHEAD DOOR		SLIDING DOOR	
SINGLE FOLD DOOR		B-FOLD DOOR	
ELEVATOR DOUBLE DOOR		ELEVATOR SINGLE DOOR	

ELECTRICAL

SINGLE OUTLET		DUPLEX OUTLET	
QUAD OUTLET		COVER PLATE	
SPEAKER		SECURITY CAMERA	
WIFI ROUTER		MOTION SENSOR	
RFID ANTENNA		JUNCTION BOX	
DATA		TELEPHONE	
DATA/PHONE COMBO			
EXHAUST FAN w/o LIGHT		EXHAUST FAN w/ LIGHT	
EXHAUST FAN w/o LIGHT		EXHAUST FAN w/ LIGHT	

FIRE PROTECTION

ALARM BELL/STROBE		SMOKE DETECTOR	
GENERAL ALARM		HEAT DETECTOR	
CARBON MONOXIDE		SPRINKLER HEAD	

HVAC


SUPPLY DIFFUSER		ROUND SUPPLY DIFFUSER	
RETURN DIFFUSER		WALL DIFFUSER	
EQUALIZER DIFFUSER			

LIGHTING

SURFACE FLUORESCENT LIGHT		EXIT LIGHT	
RECESSED FLUORESCENT LIGHT		EMERGENCY LIGHT WITH EXIT	
LIGHT TRACK		EMERGENCY LIGHT	
SURFACE MOUNTED CEILING LIGHT		RECESSED CEILING LIGHT	
PENDANT CEILING LIGHT			

OTHER

WALL ACCESS PANEL		BREAKLINE	
CEILING ACCESS PANEL			

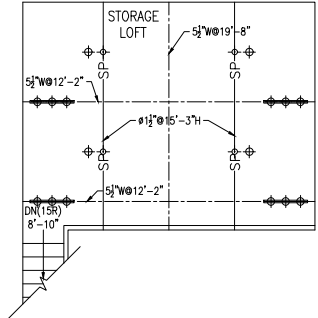

STORAGE LOFT REFLECTED CEILING

SCALE: 1/4" = 1'-0"

