


DUCTWORK FLOOR PLAN—OVERALL 1ST FLOOR
 SCALE: 1/8"=1'-0"



**SELMA BURKE
 MIDDLE SCHOOL**
 235 RINEHARDT ROAD
 MOORESVILLE, NC 28115

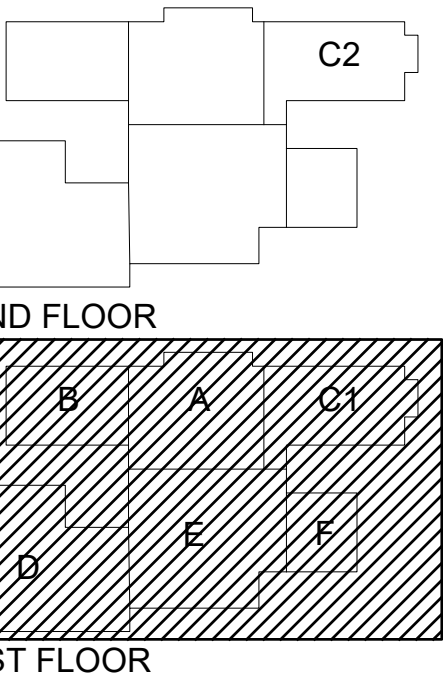


- GENERAL CONTRACTOR:
 BARNHILL CONTRACTING
- PRELIMINARY - NOT FOR CONSTRUCTION
 - FOR CONSTRUCTION
 - SHOP DRAWINGS
 - AS-BUILT DRAWINGS

REVISIONS	DATE

DRAWN BY: RJM
 CHECKED BY: RJM
 PROJECT: 22-693
 DATE: 05/06/2022
 SHEET: 0 OF: 17

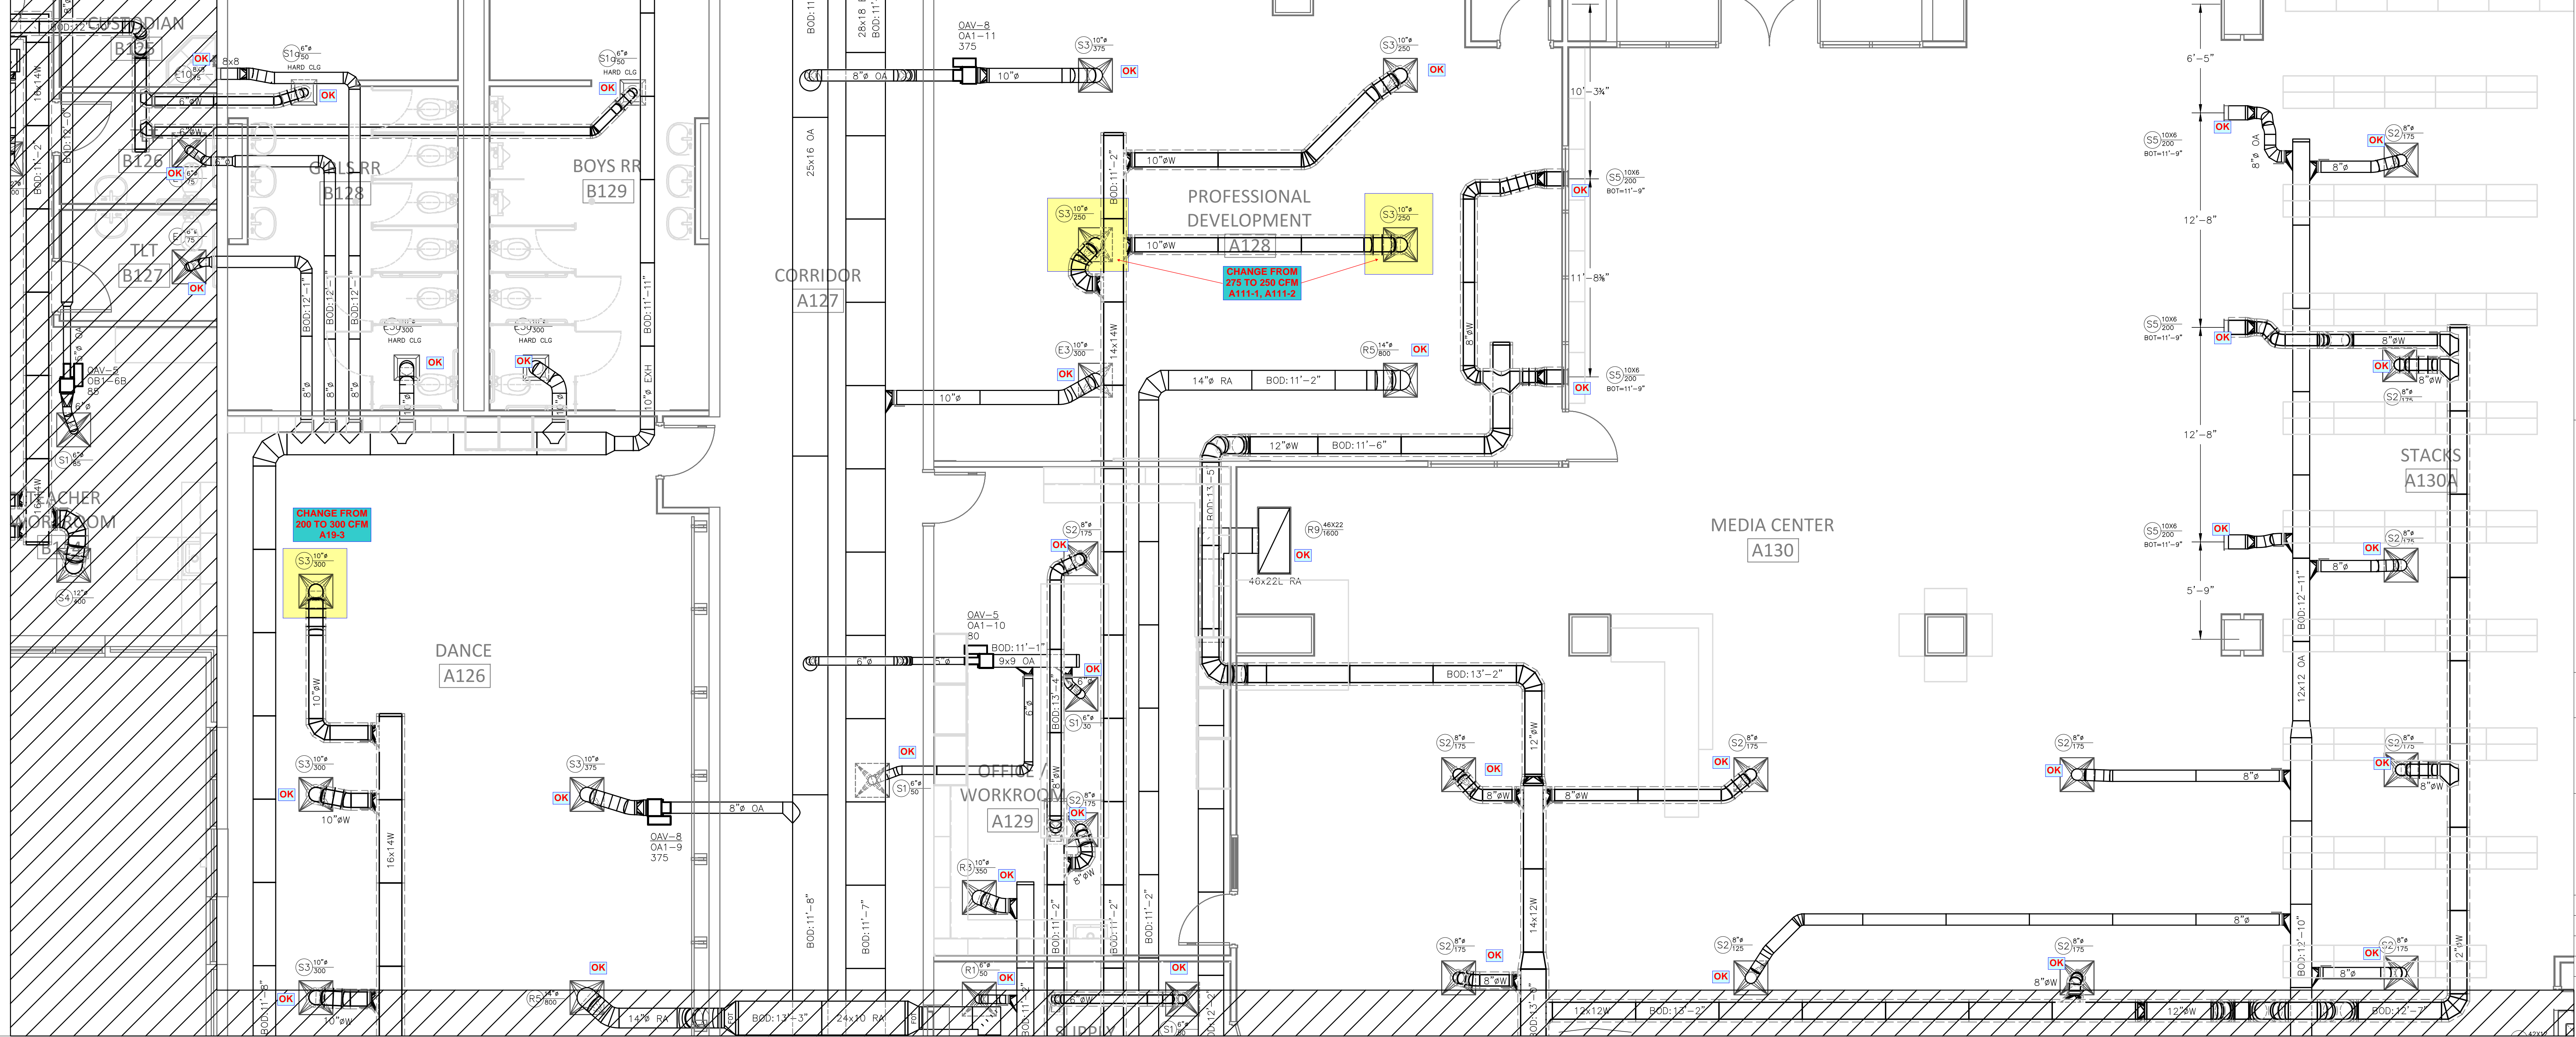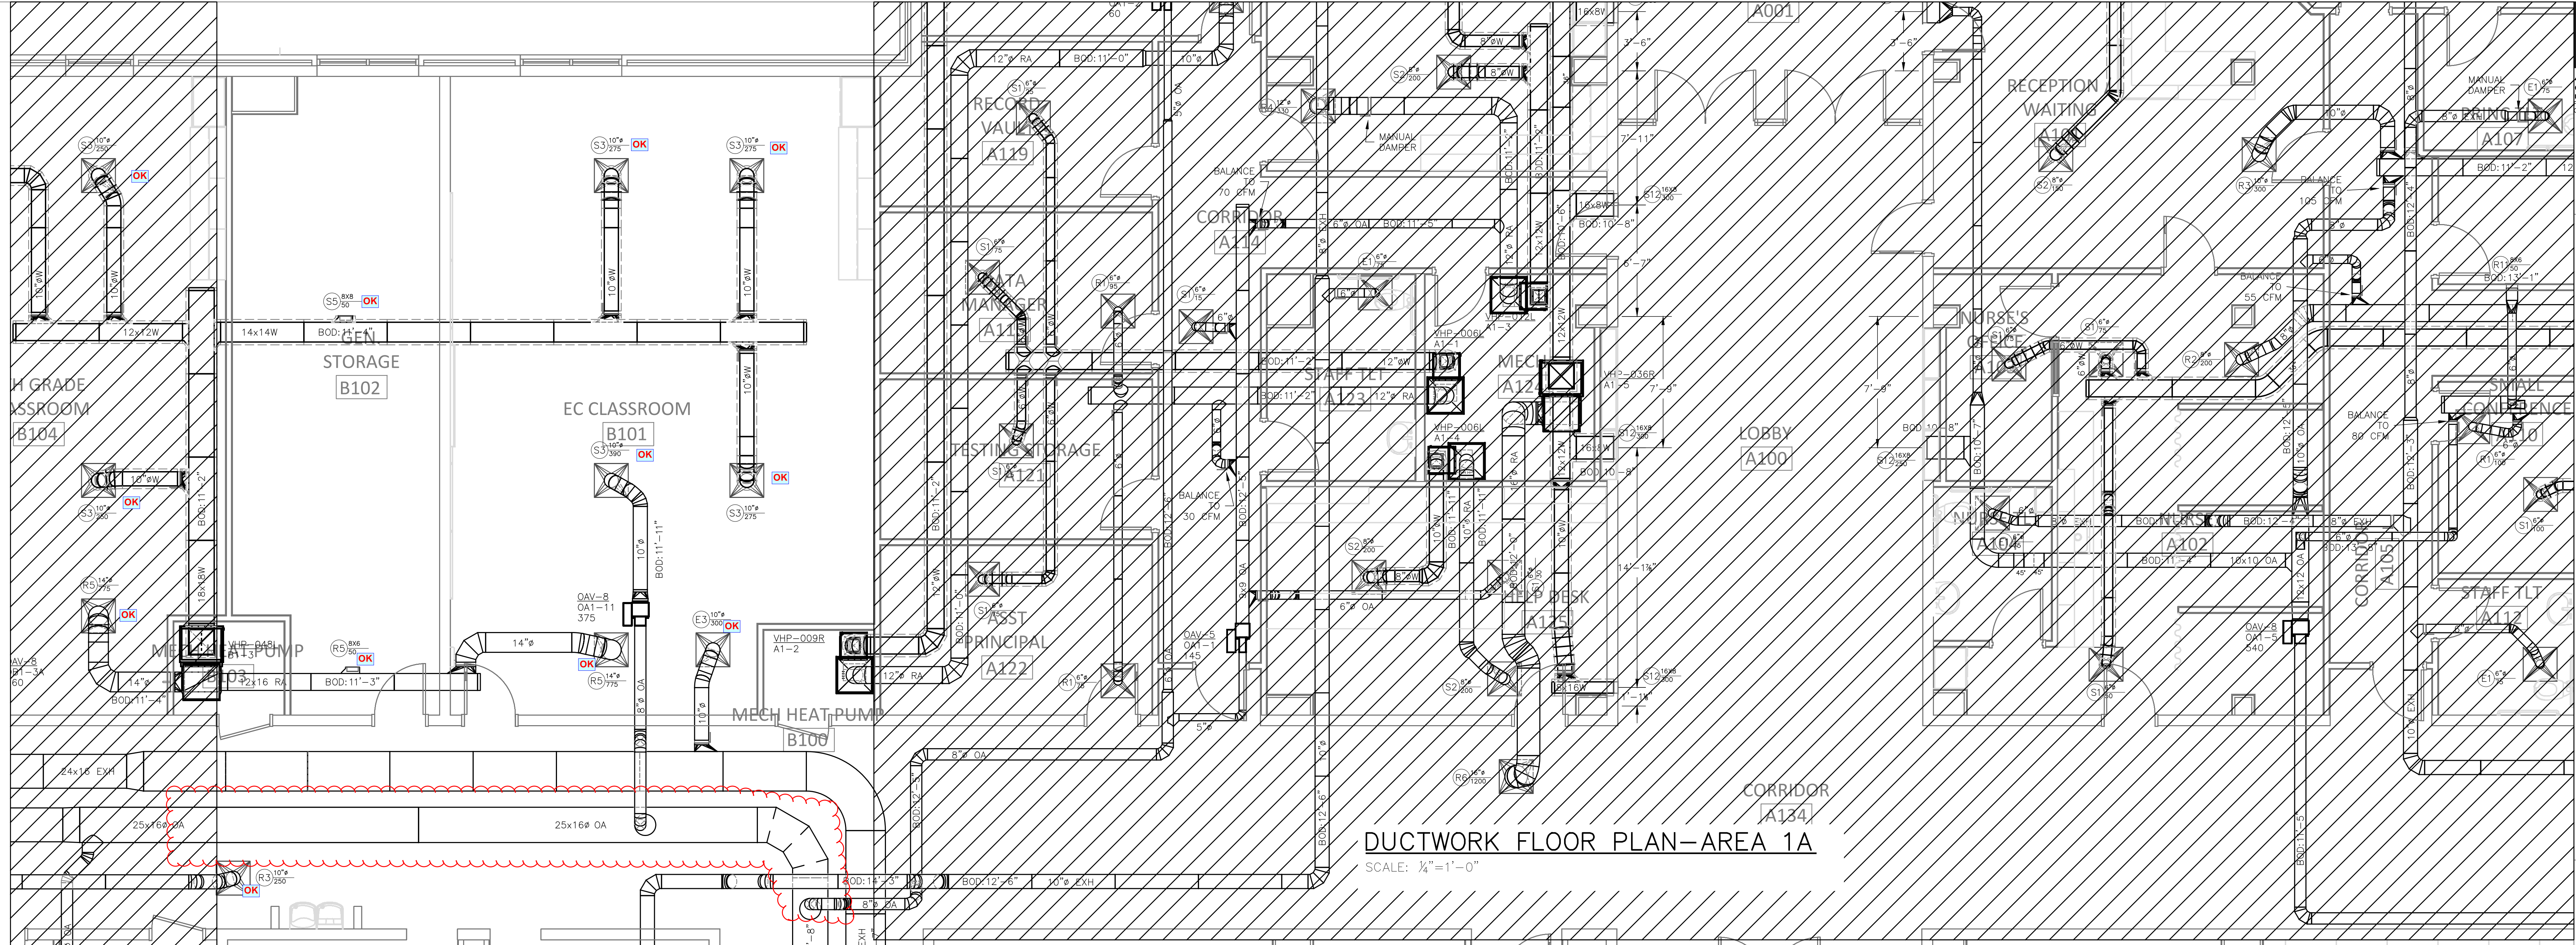

SELMA BURKE MIDDLE SCHOOL 235 RINEHARDT ROAD MOORESVILLE, NC 28115

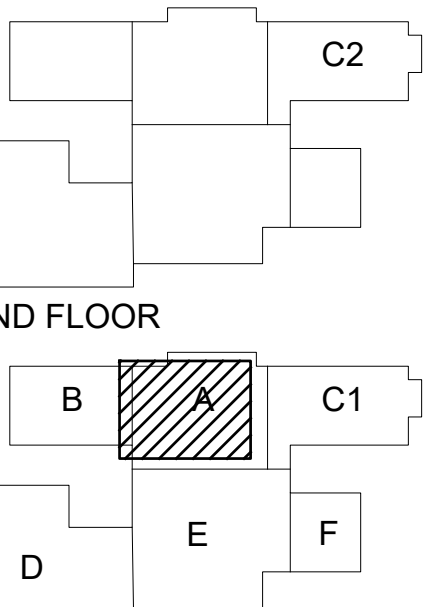


GENERAL CONTRACTOR: BARNHILL CONTRACTING
PRELIMINARY - NOT FOR CONSTRUCTION
SHOP DRAWINGS
AS-BUILT DRAWINGS


REVISIONS DATE

NO.	DESCRIPTION	DATE


DRAWN BY: RJM
CHECKED BY: RJM
PROJECT: 22-693
DATE: 05/06/2022
SHEET: 2 OF: 17

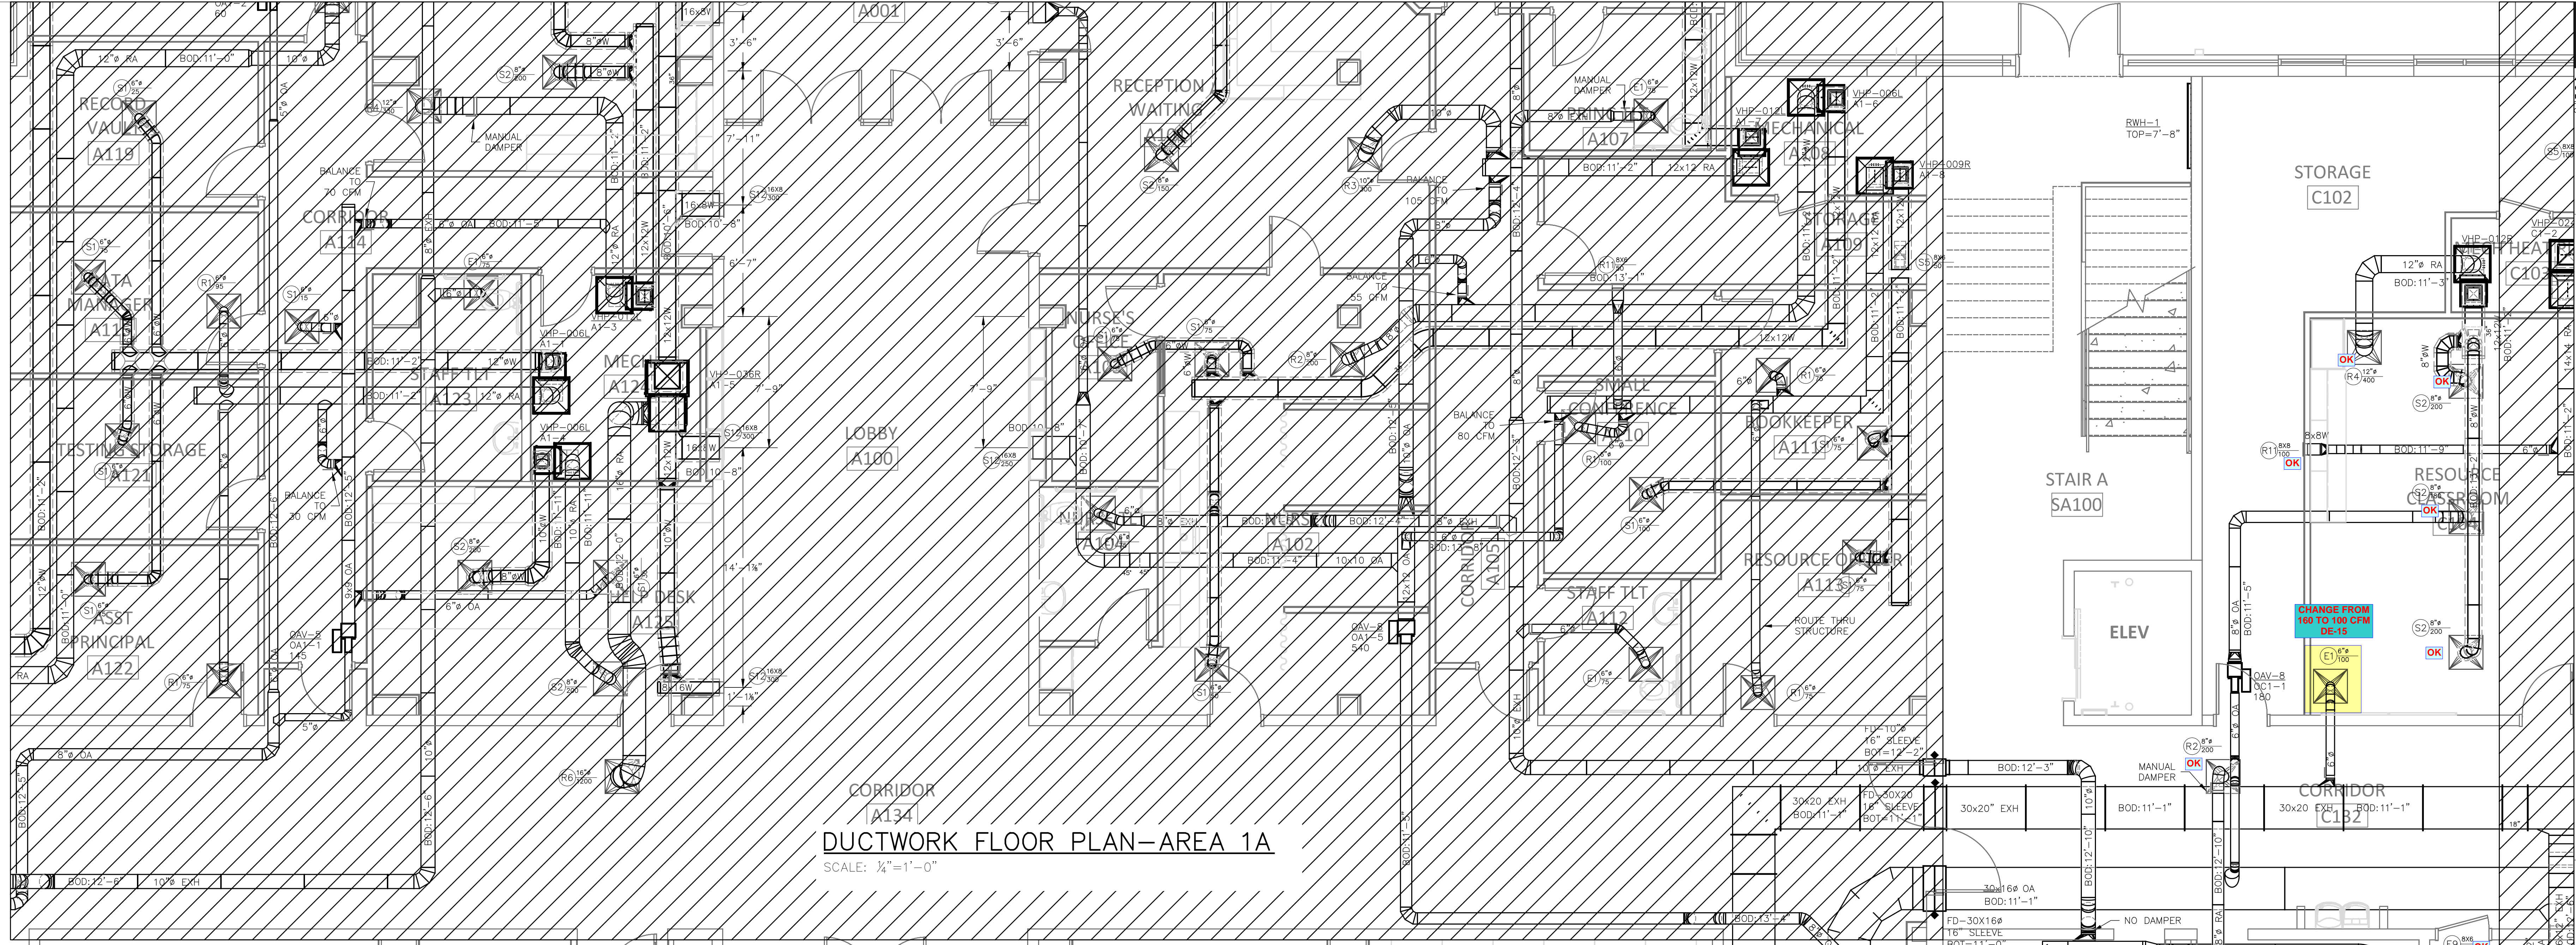

DUCTWORK FLOOR PLAN-AREA 1A
SCALE: 1/4"=1'-0"

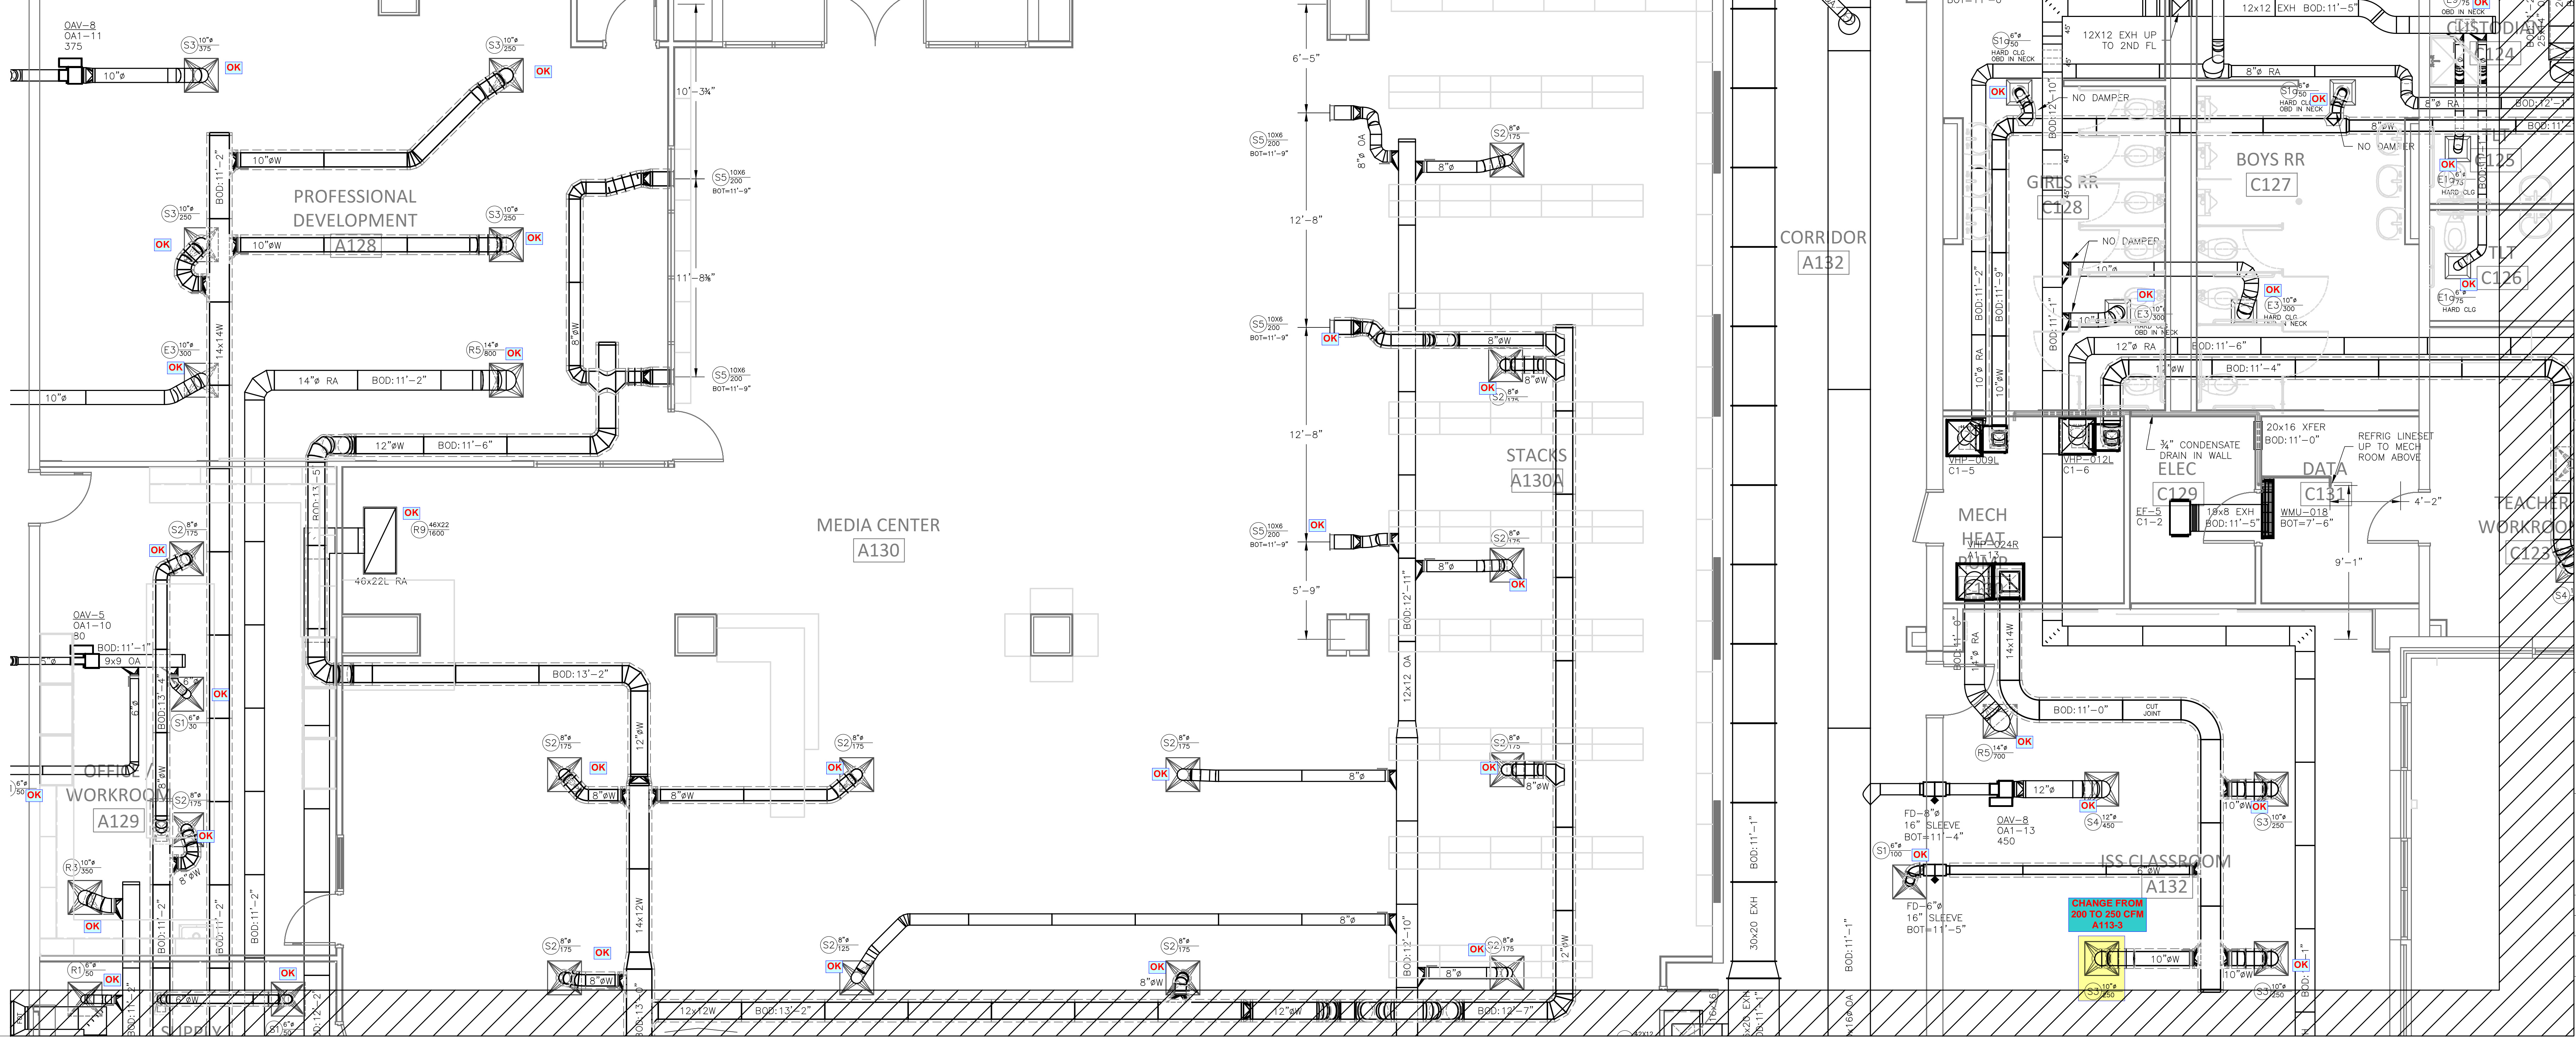


**SELMA BURKE
MIDDLE SCHOOL**
235 RINEHARDT ROAD
MOORESVILLE, NC 28115

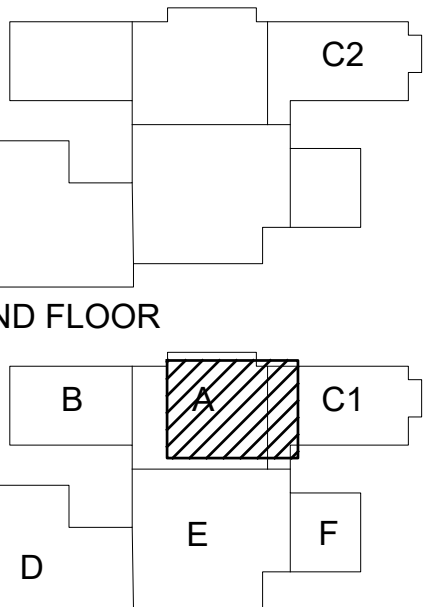


- 1ST FLOOR
GENERAL CONTRACTOR:
BARNHILL
CONTRACTING
○ PRELIMINARY - NOT
FOR CONSTRUCTION
○ FOR CONSTRUCTION
● SHOP DRAWINGS
● AS-BUILT DRAWINGS
REVISIONS DATE

DRAWN BY: RJM
CHECKED BY: RJM
PROJECT: 22-693
DATE: 05/06/2022
SHEET: 3 OF: 17

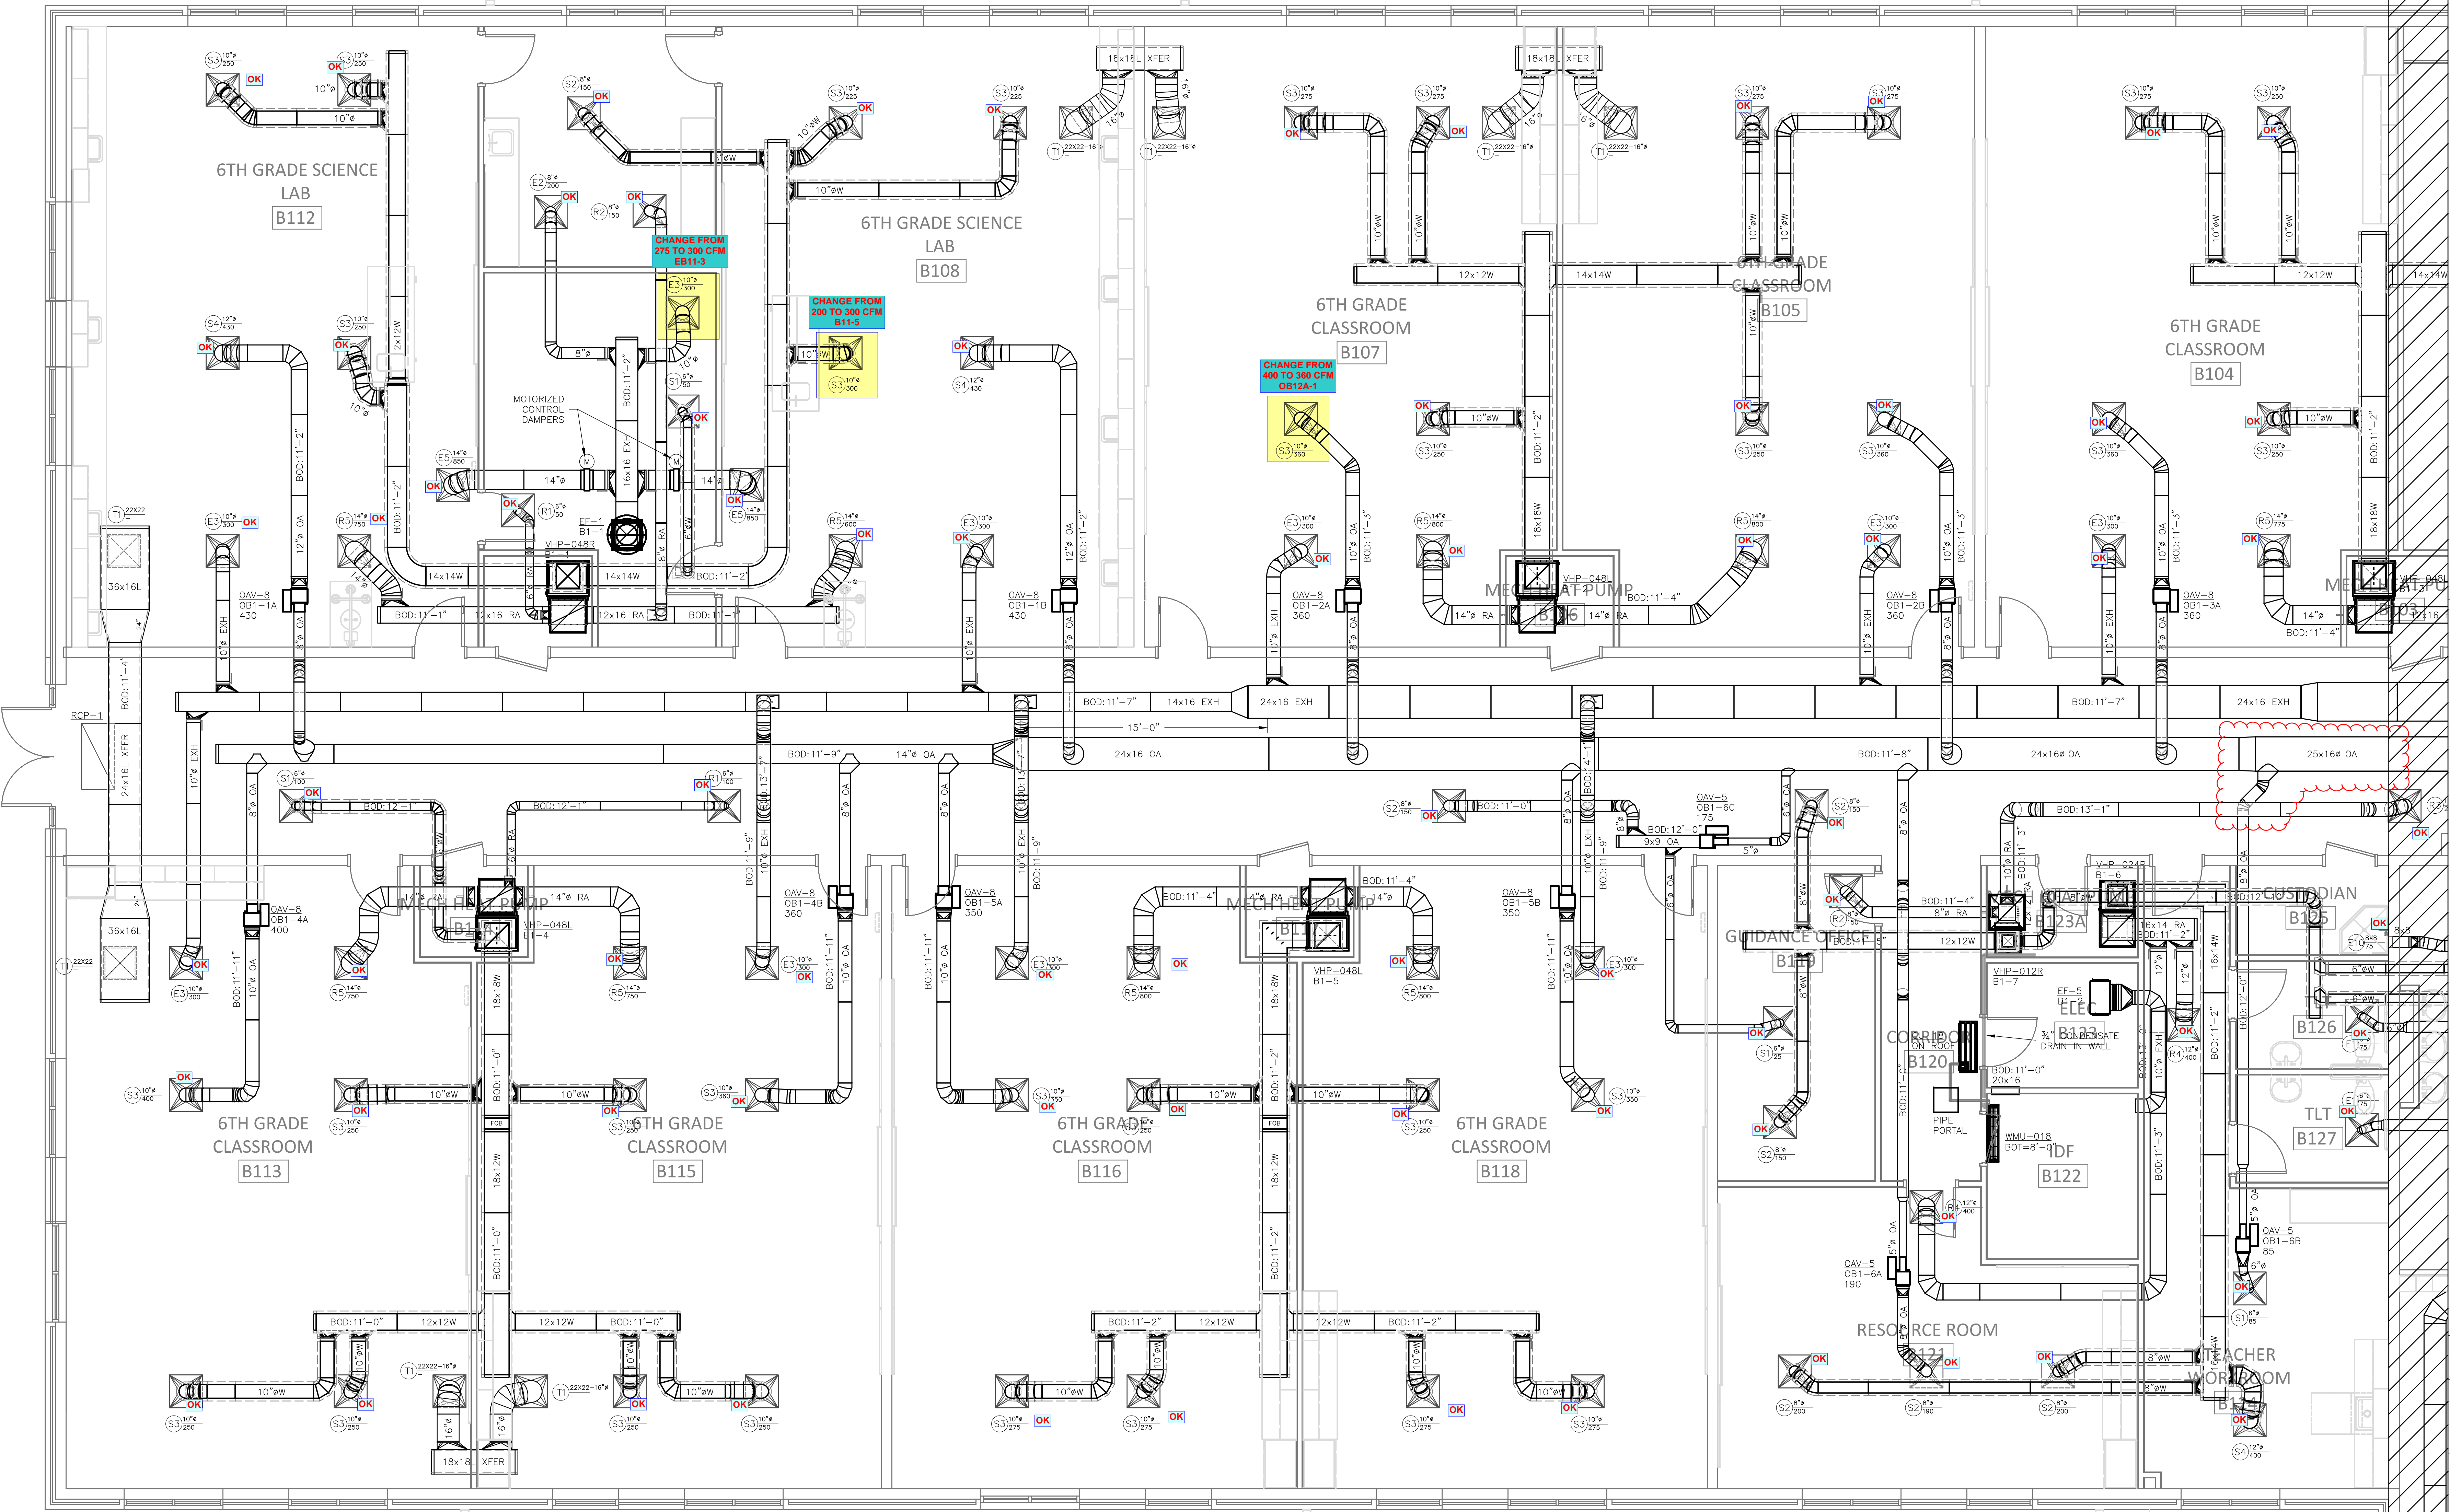


DUCTWORK FLOOR PLAN—AREA 1B
 SCALE: 1/4"=1'-0"

SELMA BURKE MIDDLE SCHOOL
 235 RINEHARDT ROAD
 MOORESVILLE, NC 28115

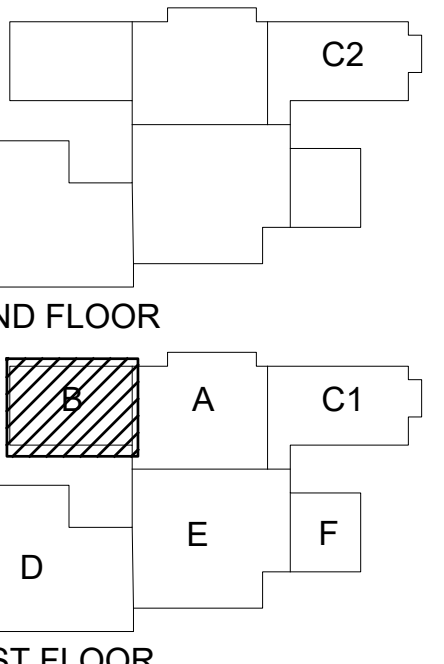


- GENERAL CONTRACTOR:**
 BARNHILL CONTRACTING
- PRELIMINARY - NOT FOR CONSTRUCTION
 - FOR CONSTRUCTION
 - SHOP DRAWINGS
 - AS-BUILT DRAWINGS
- REVISIONS** **DATE**

DRAWN BY: RJM
CHECKED BY: RJM
PROJECT: 22-693
DATE: 05/06/2022
SHEET: 4 **OF:** 17

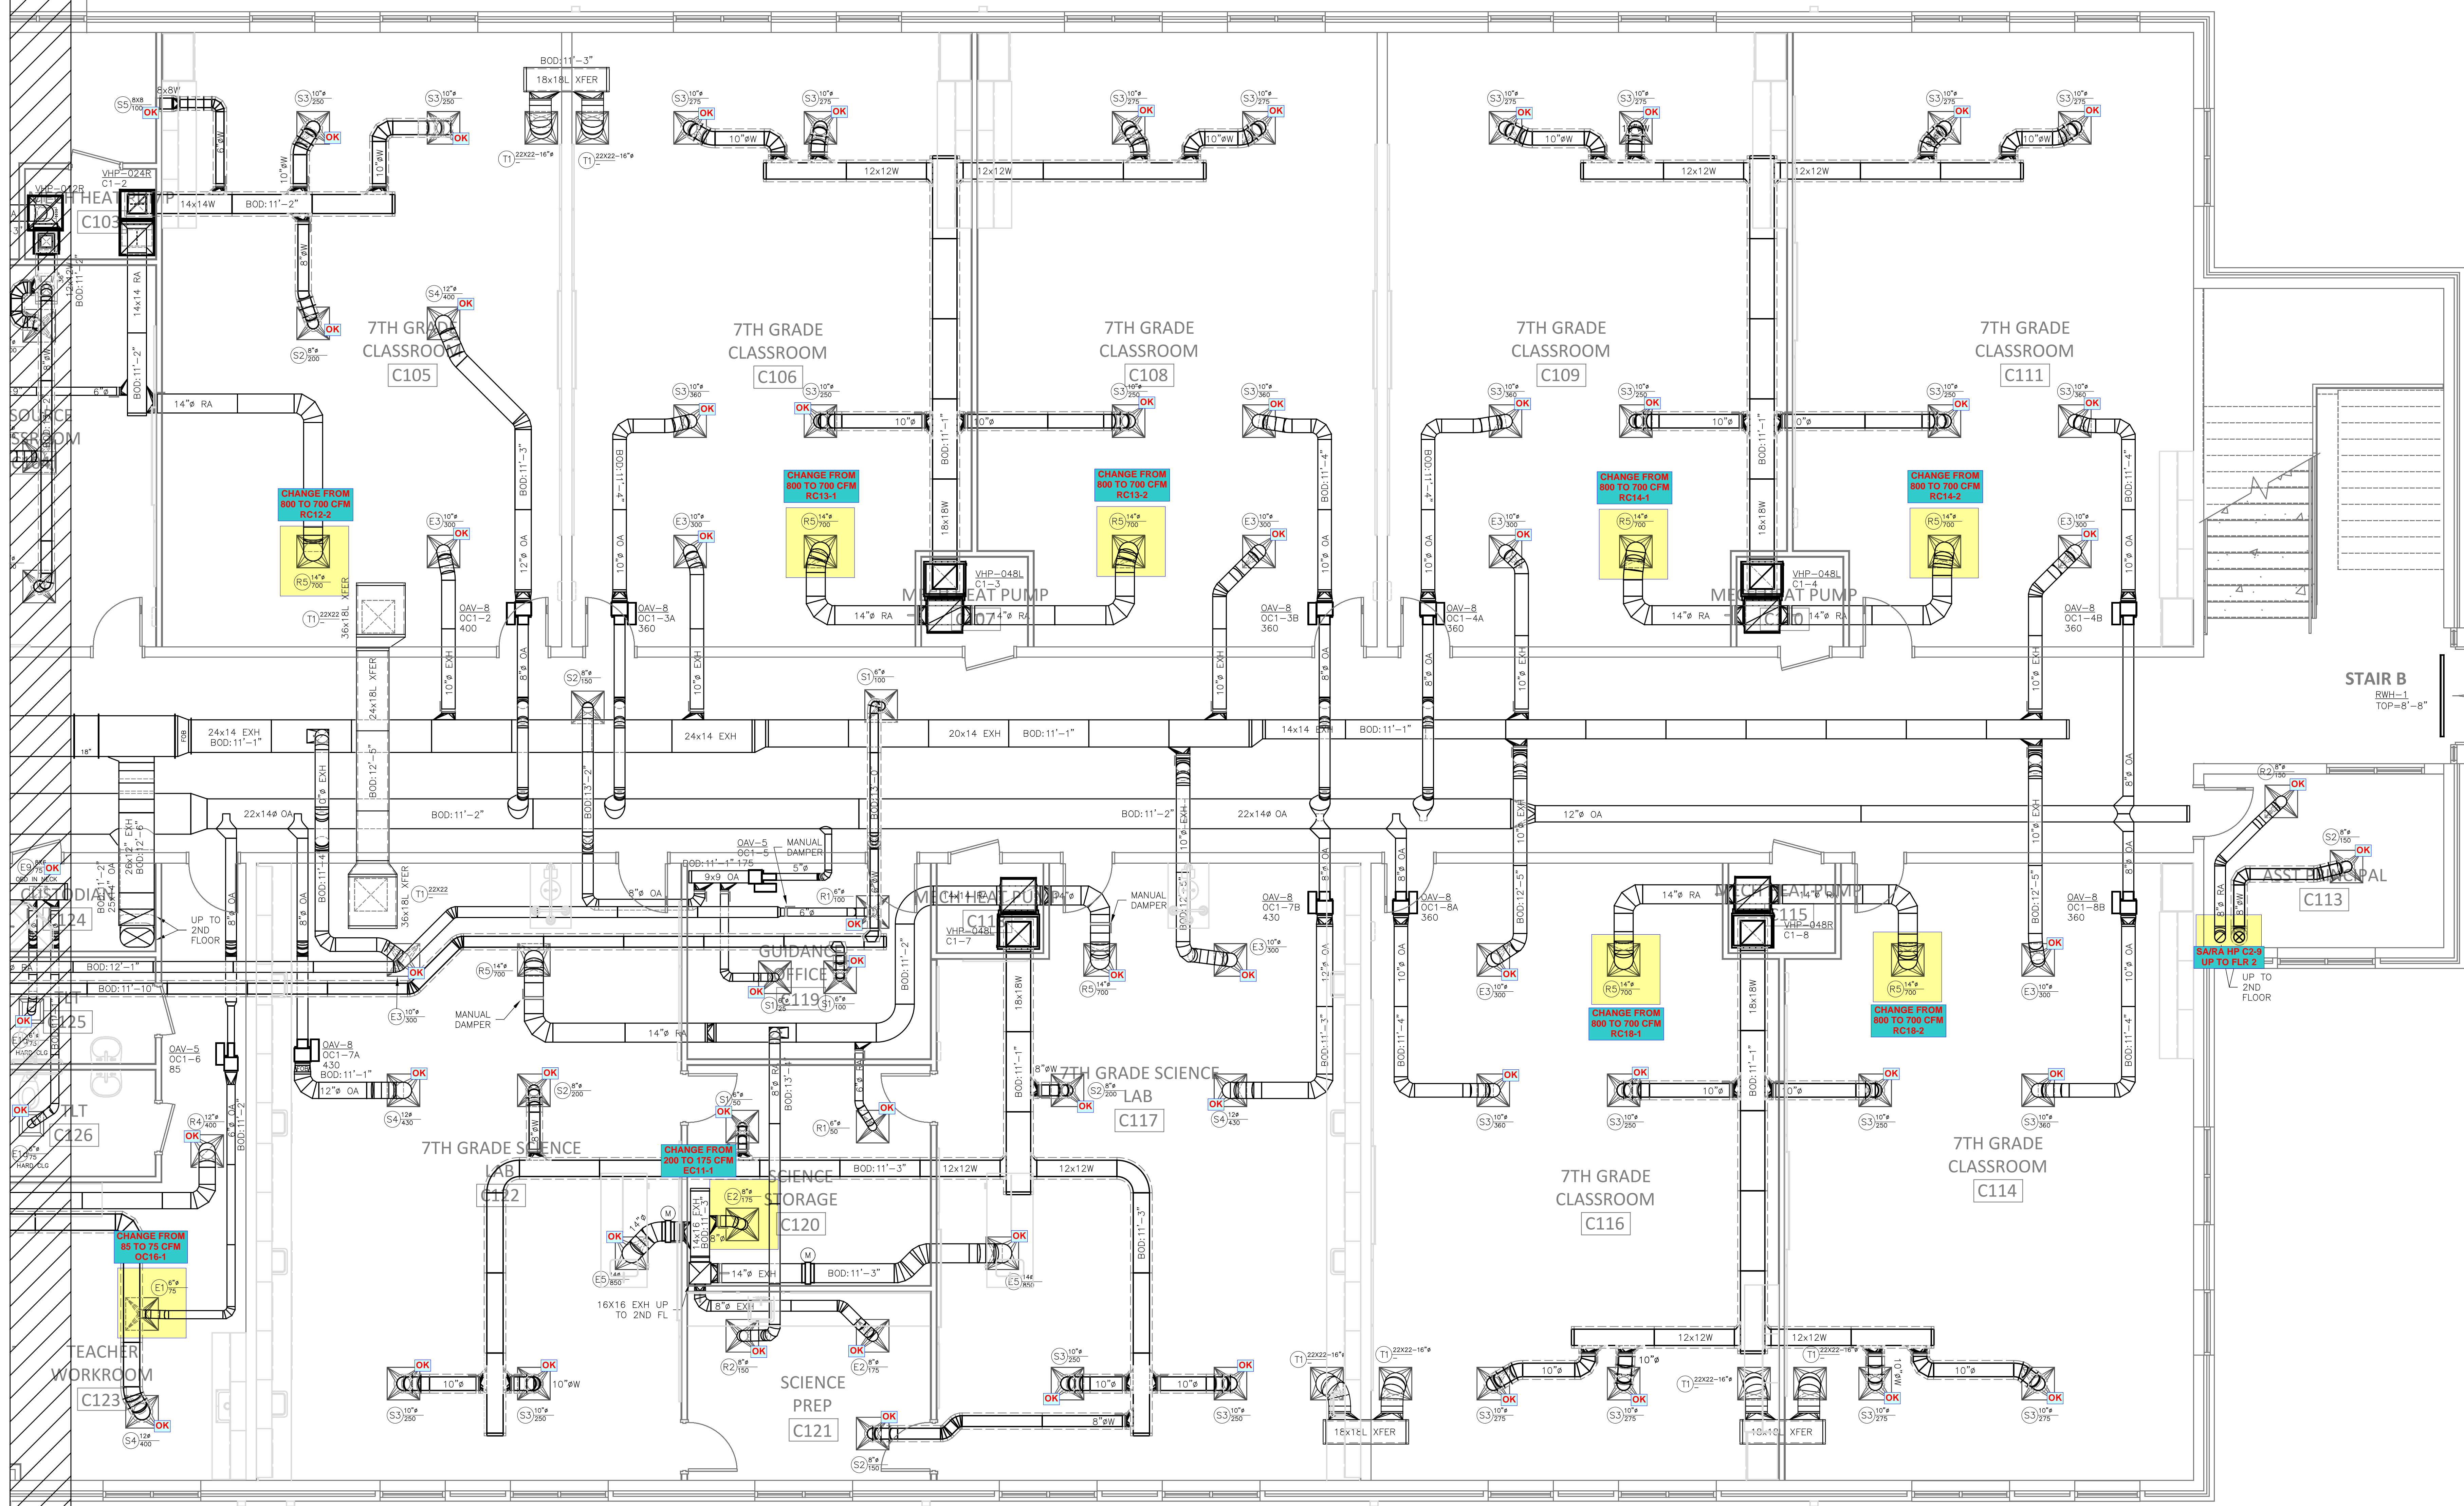


DUCTWORK FLOOR PLAN-AREA 1C
SCALE: 1/4"=1'-0"

**SELMA BURKE
MIDDLE SCHOOL**
235 RINEHARDT ROAD
MOORESVILLE, NC 28115

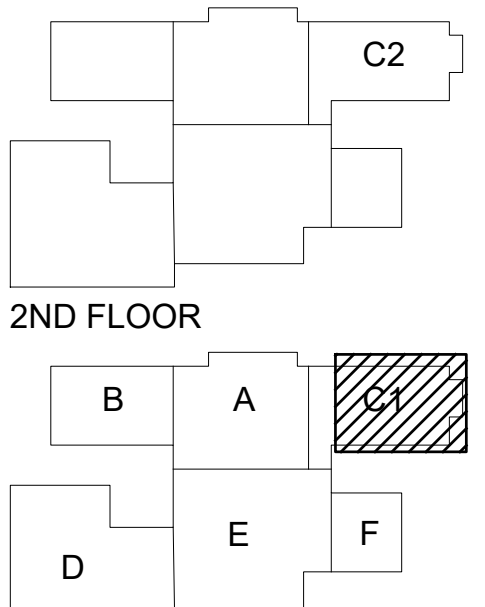


- 2ND FLOOR
- 1ST FLOOR
- GENERAL CONTRACTOR:
BARNHILL CONTRACTING
- PRELIMINARY - NOT FOR CONSTRUCTION
 - FOR CONSTRUCTION
 - SHOP DRAWINGS
 - AS-BUILT DRAWINGS
- REVISIONS DATE

DRAWN BY: RJM
CHECKED BY: RJM
PROJECT: 22-693
DATE: 05/06/2022
SHEET: 5 OF: 17

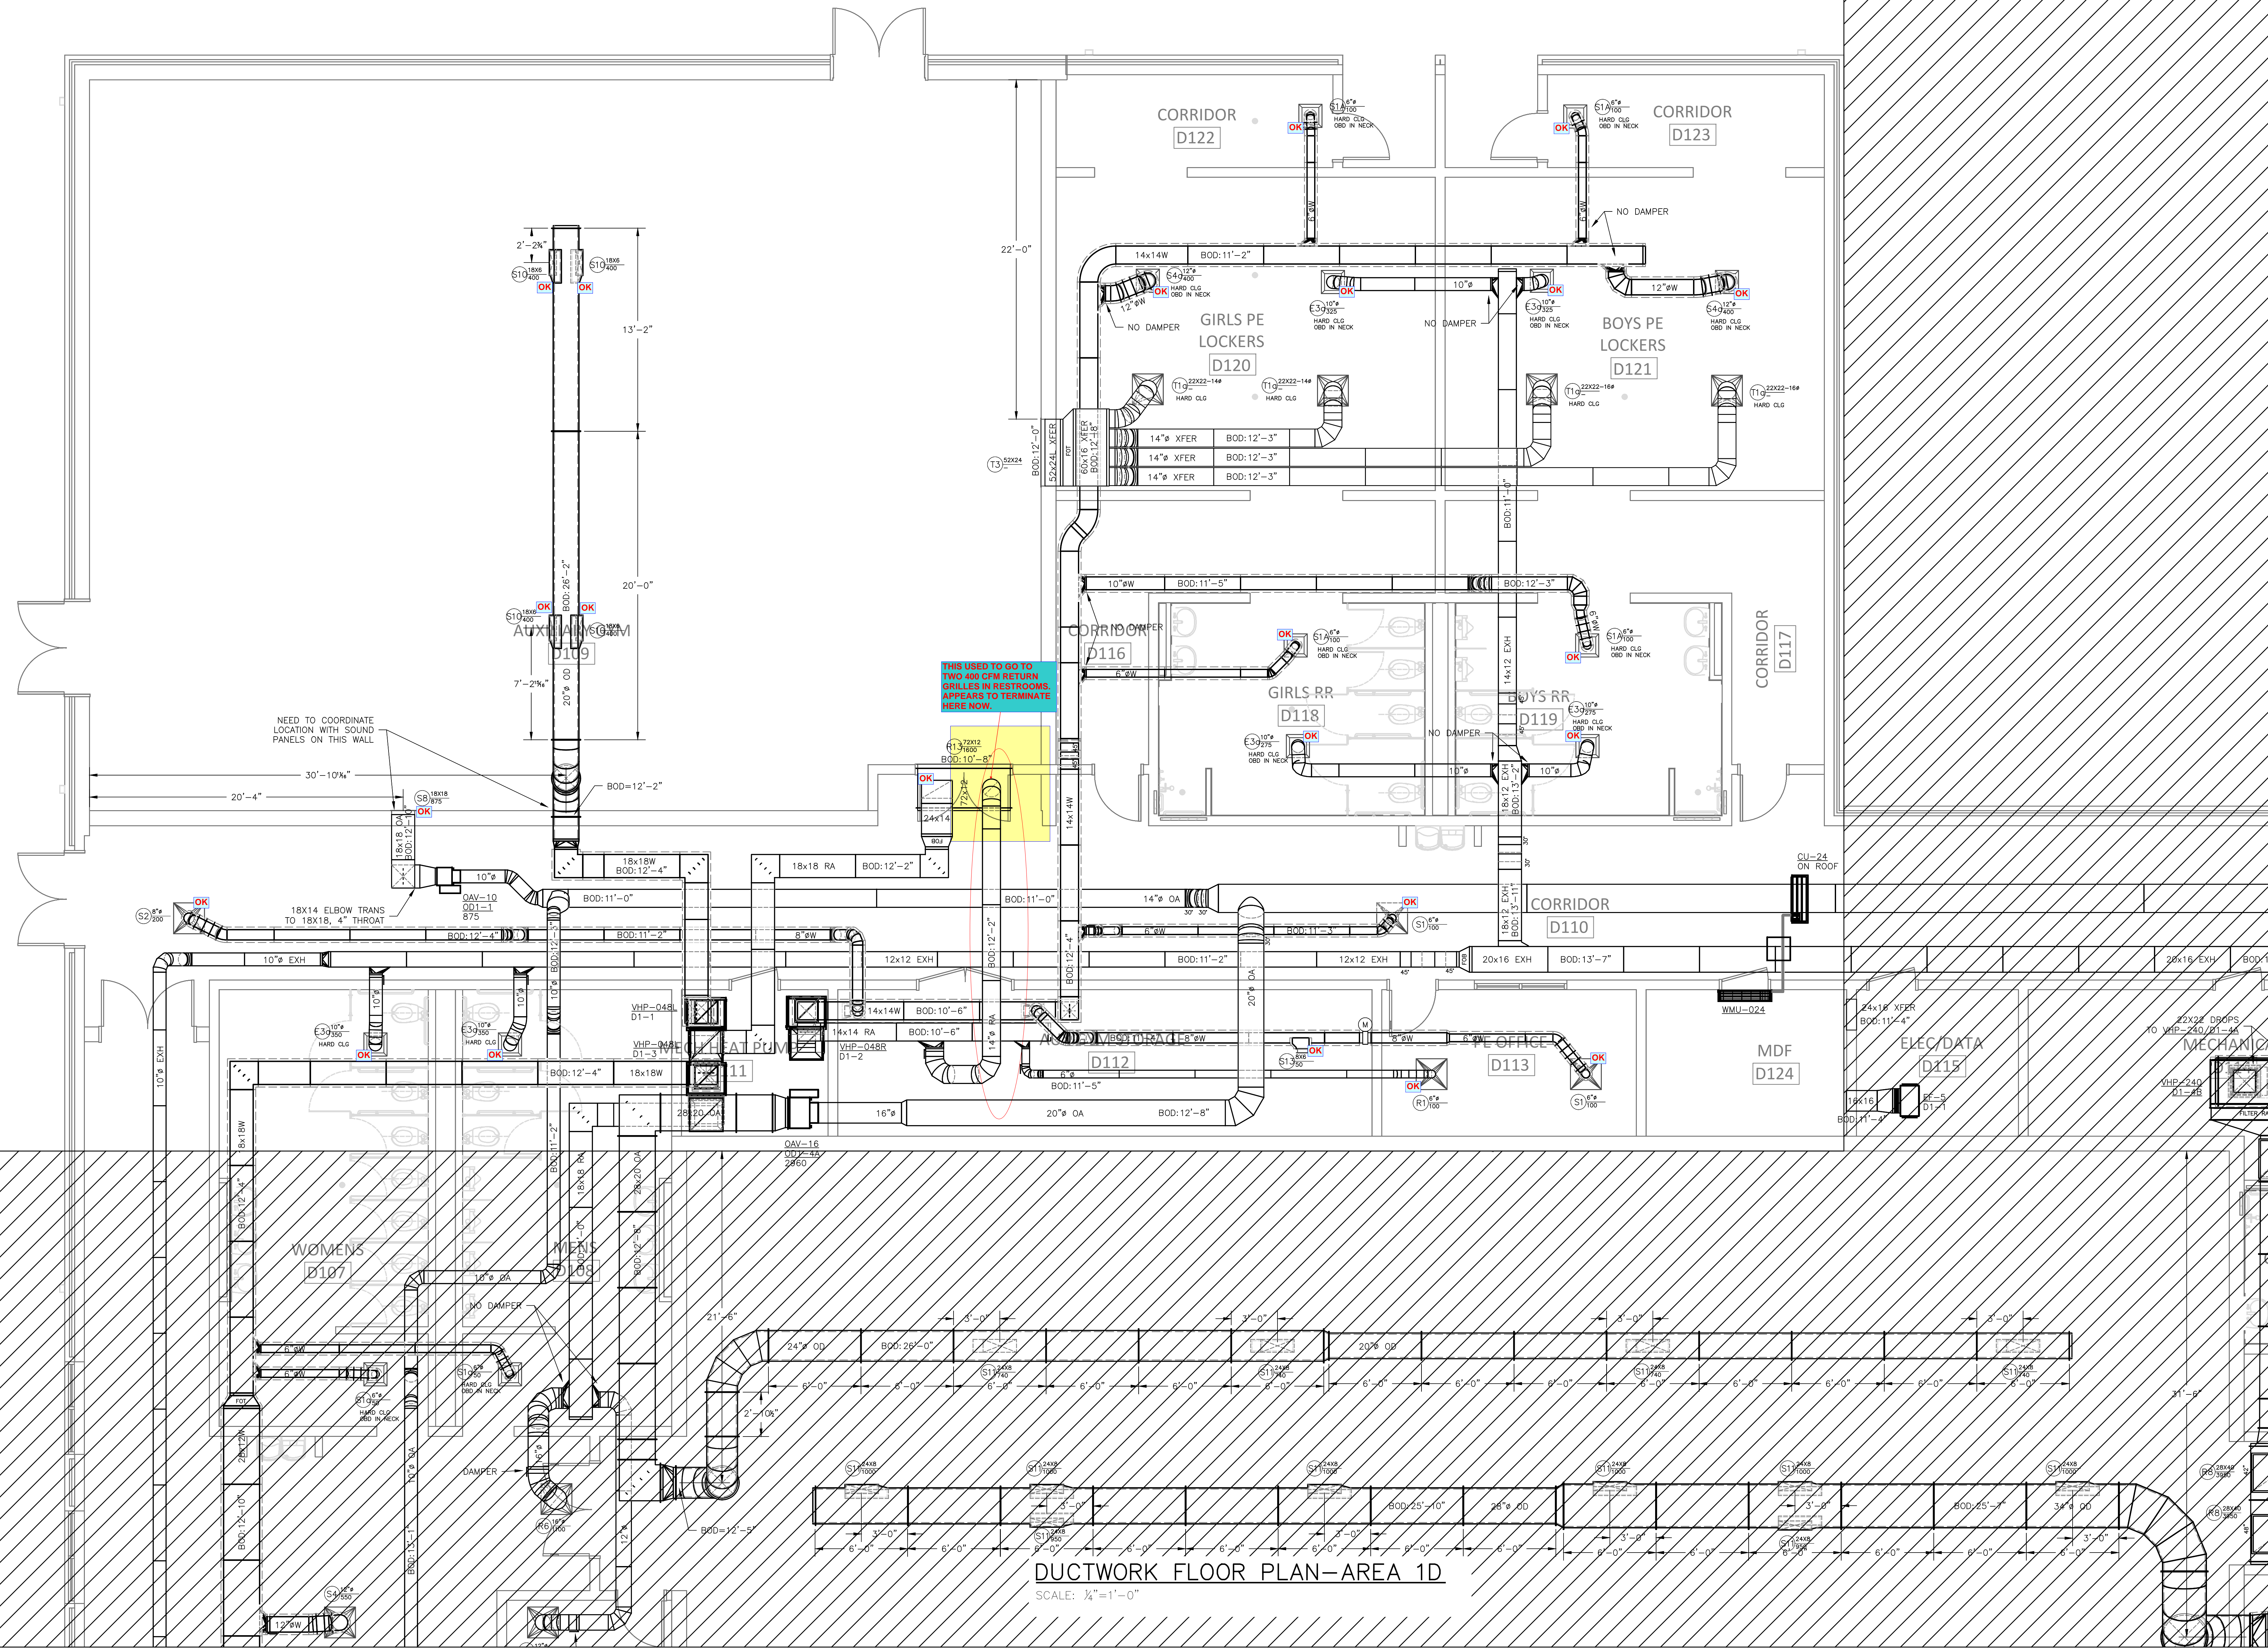


DUCTWORK FLOOR PLAN—AREA 1D
 SCALE: 1/4" = 1'-0"

SELMA BURKE MIDDLE SCHOOL
 235 RINEHARDT ROAD
 MOORESVILLE, NC 28115

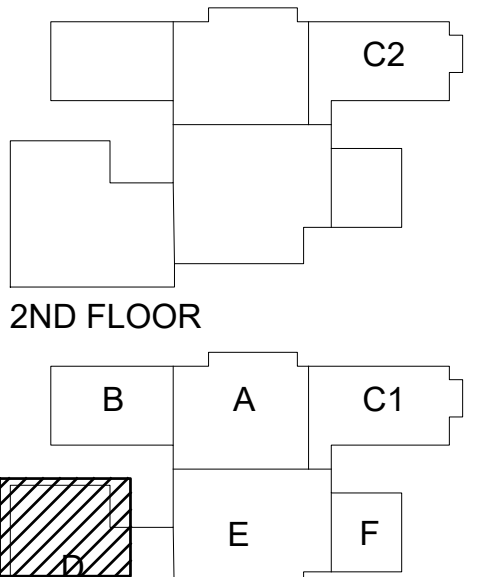


- GENERAL CONTRACTOR:**
 BARNHILL CONTRACTING
- PRELIMINARY - NOT FOR CONSTRUCTION
 - FOR CONSTRUCTION
 - SHOP DRAWINGS
 - AS-BUILT DRAWINGS
- REVISIONS** **DATE**

DRAWN BY: RJM
CHECKED BY: RJM
PROJECT: 22-693
DATE: 05/06/2022
SHEET: 6 **OF:** 17

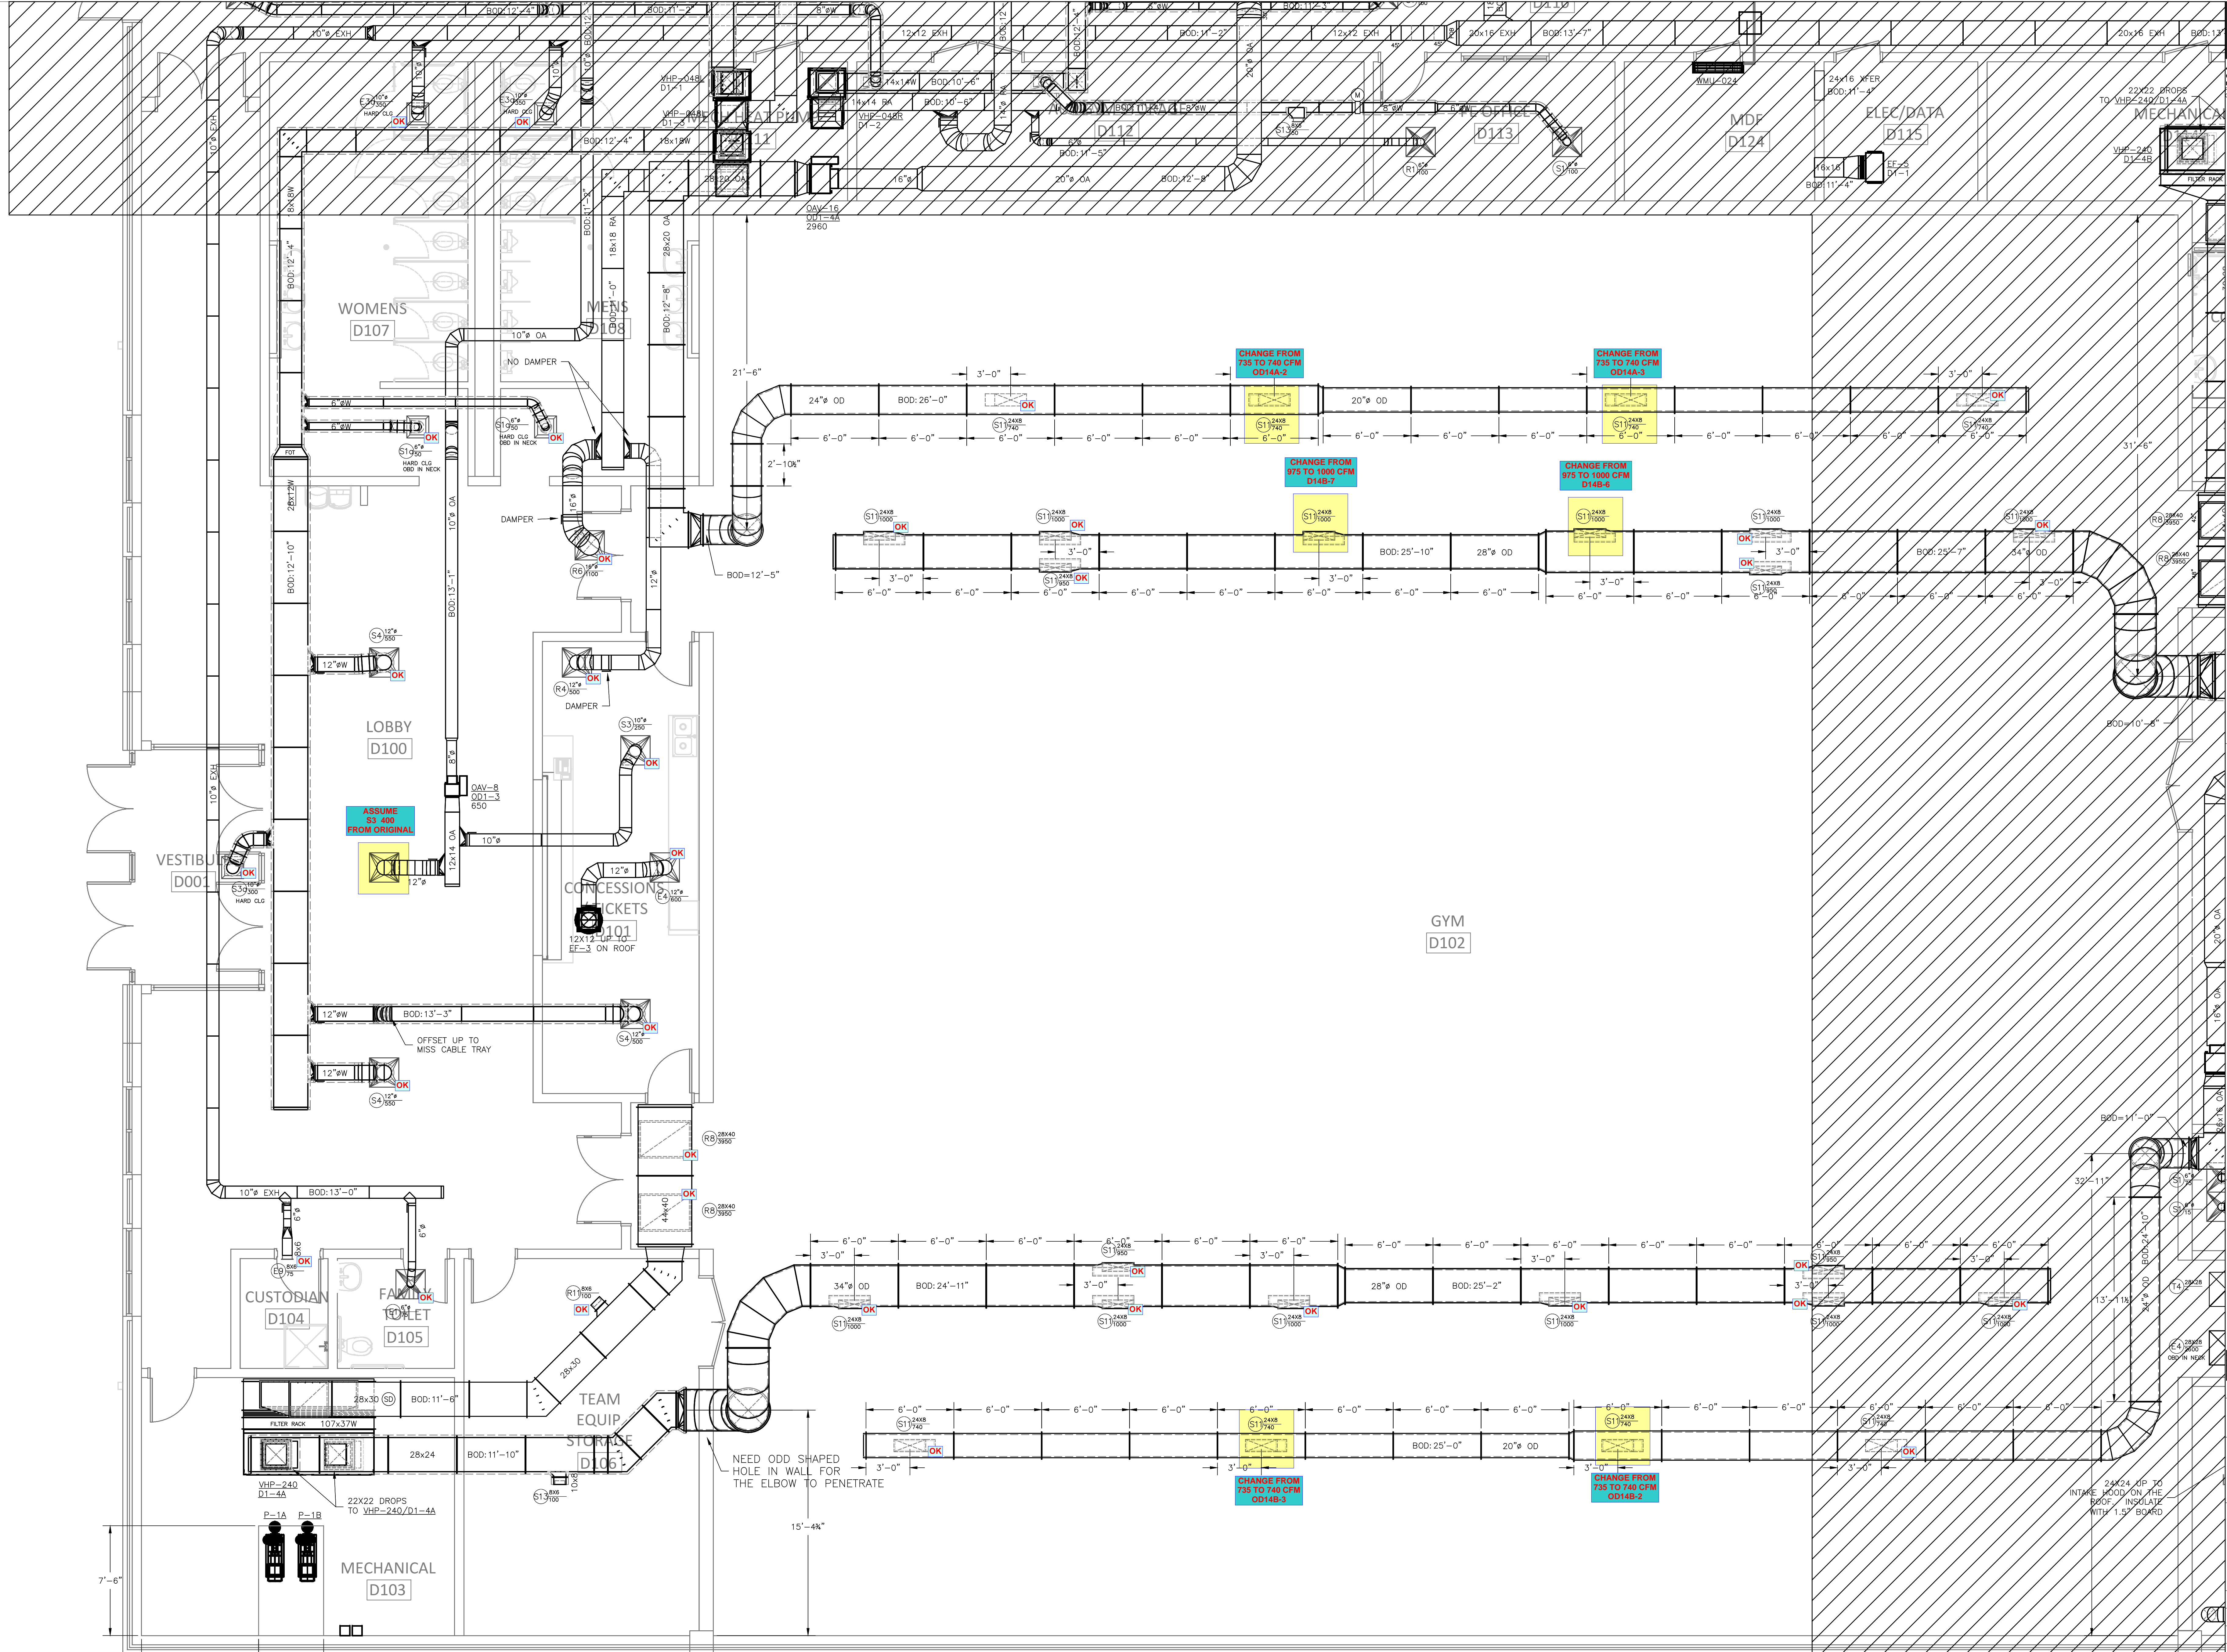


**SELMA BURKE
MIDDLE SCHOOL**
235 RINEHARDT ROAD
MOORESVILLE, NC 28115

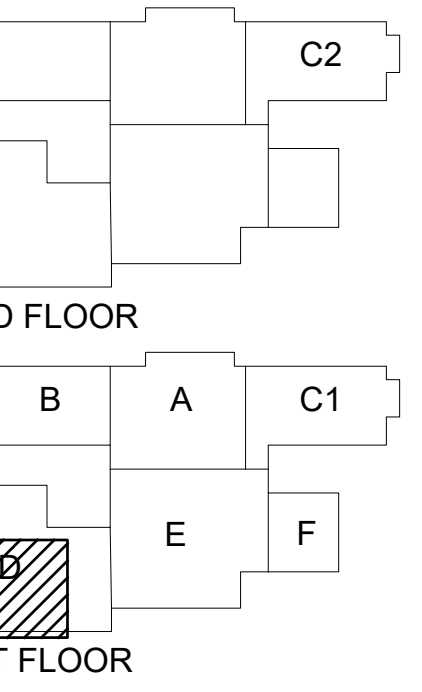

GENERAL CONTRACTOR:
BARNHILL CONTRACTING
○ PRELIMINARY - NOT FOR CONSTRUCTION
○ FOR CONSTRUCTION
● SHOP DRAWINGS
● AS-BUILT DRAWINGS
REVISIONS DATE


DRAWN BY: RJM
CHECKED BY: RJM
PROJECT: 22-693
DATE: 05/06/2022
SHEET: 8 OF: 17

DUCTWORK FLOOR PLAN-AREA 1D
SCALE: 1/4"=1'-0"

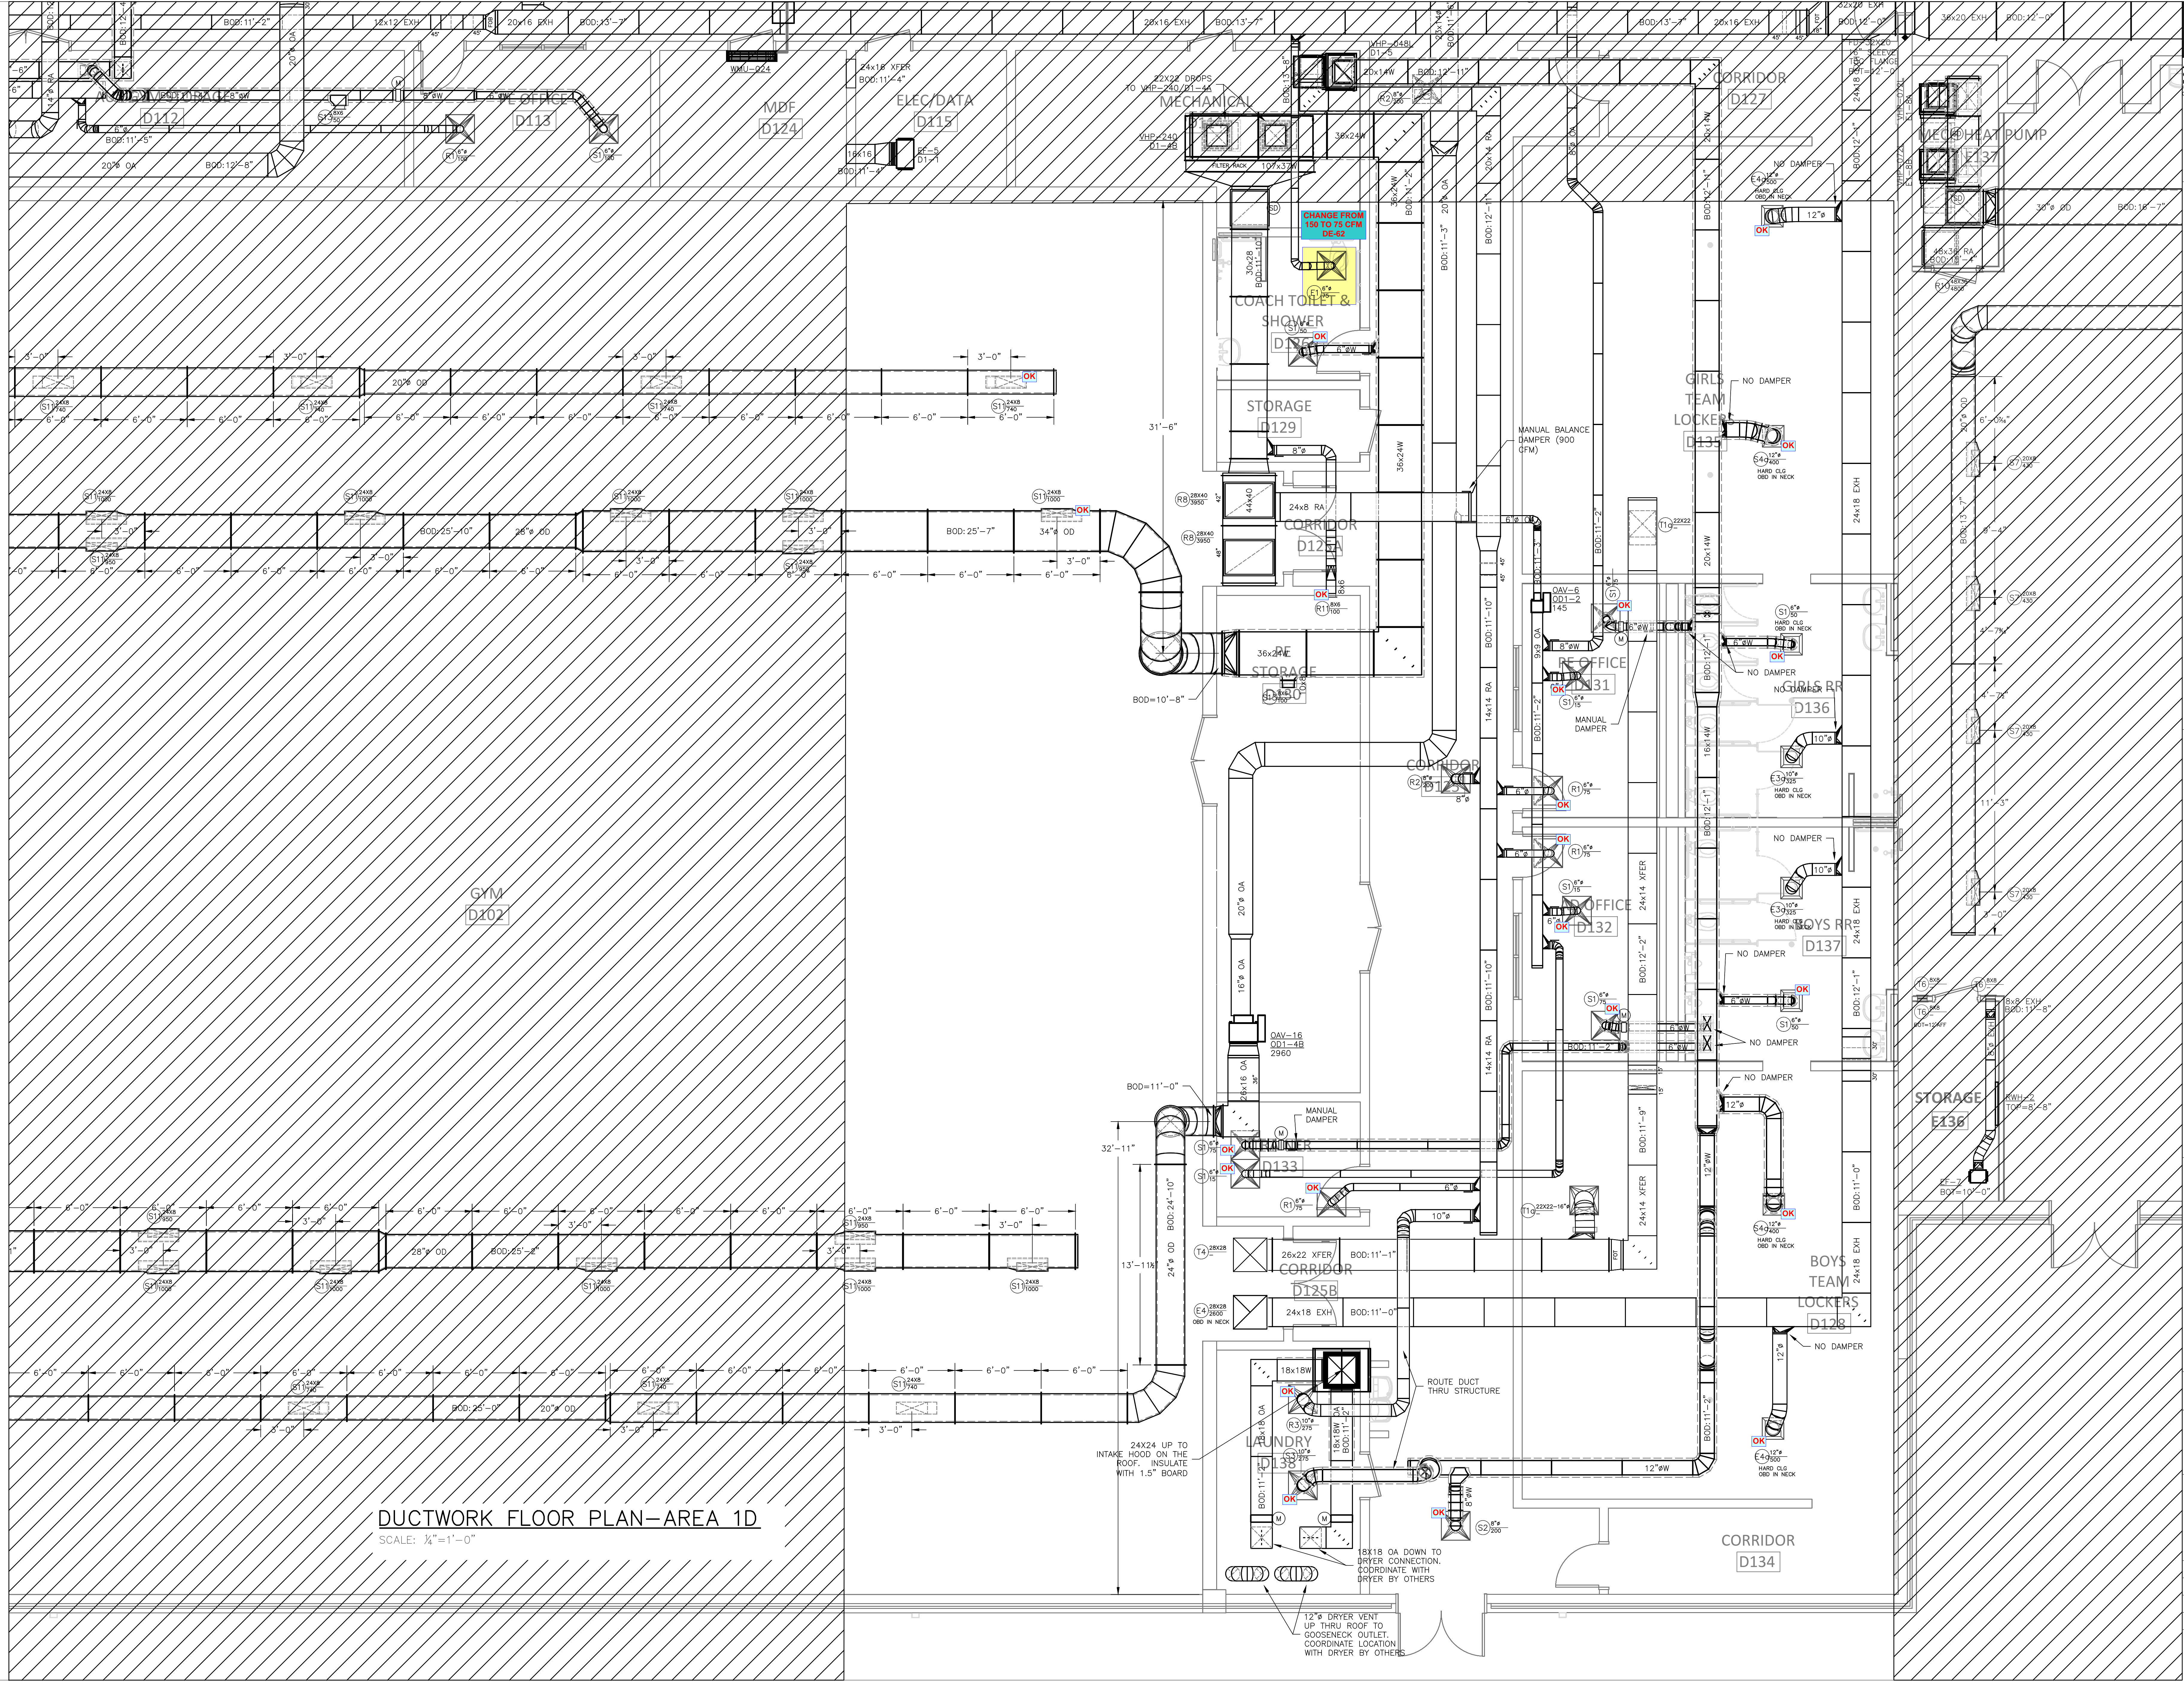


DUCTWORK FLOOR PLAN-AREA 1D
SCALE: 1/4"=1'-0"

**SELMA BURKE
MIDDLE SCHOOL**
235 RINEHARDT ROAD
MOORESVILLE, NC 28115

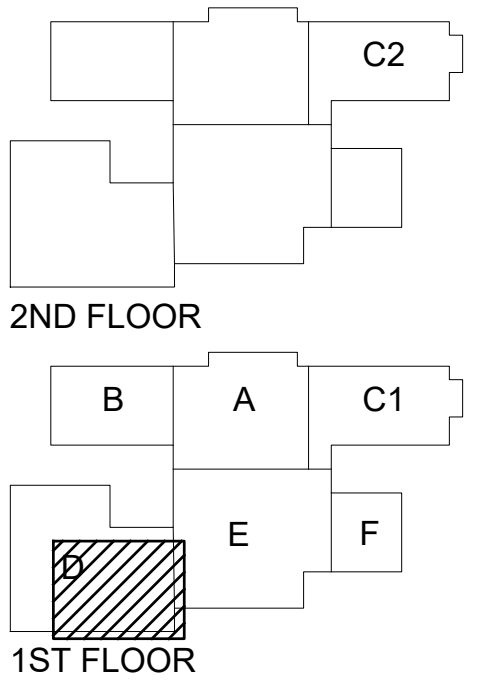


- GENERAL CONTRACTOR: BARNHILL CONTRACTING
○ PRELIMINARY - NOT FOR CONSTRUCTION
○ FOR CONSTRUCTION
● SHOP DRAWINGS
○ AS-BUILT DRAWINGS
- | REVISIONS | DATE |
|-----------|------|
| | |

DRAWN BY: RJM
CHECKED BY: RJM
PROJECT: 22-693
DATE: 05/06/2022
SHEET: 9 OF: 17

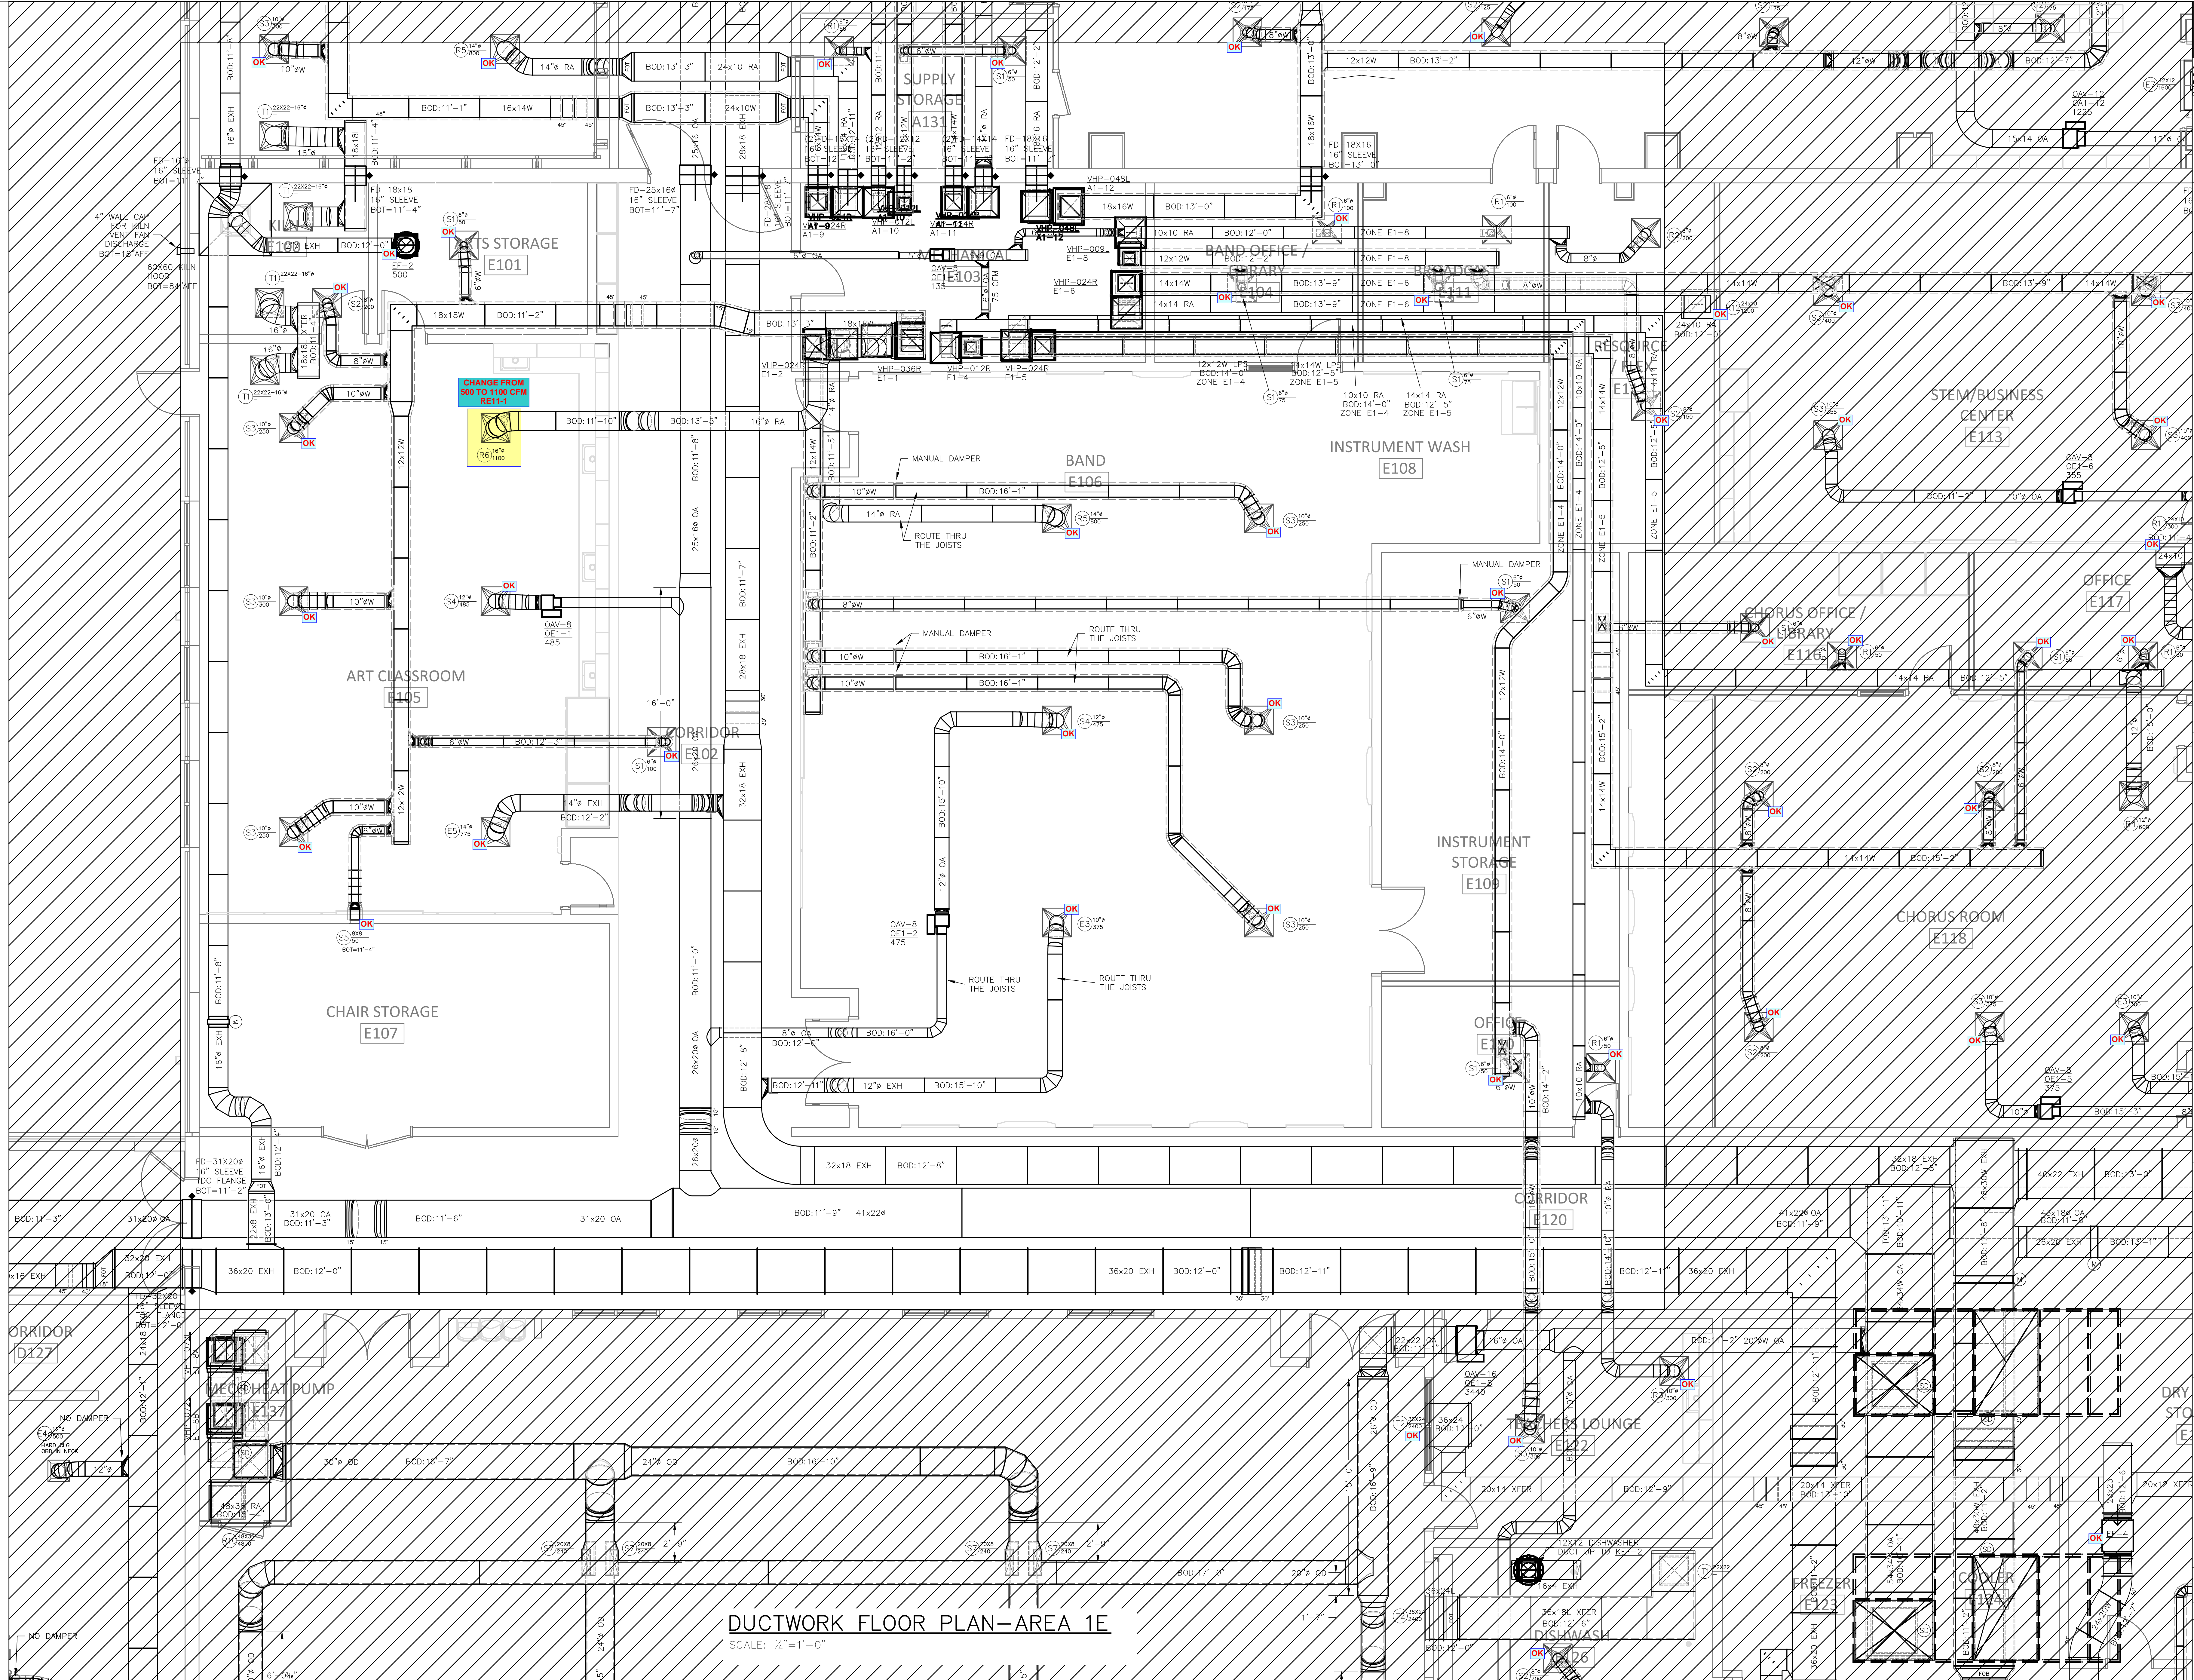


DUCTWORK FLOOR PLAN-AREA 1E
SCALE: 1/4" = 1'-0"

SELMA BURKE MIDDLE SCHOOL
235 RINEHARDT ROAD
MOORESVILLE, NC 28115

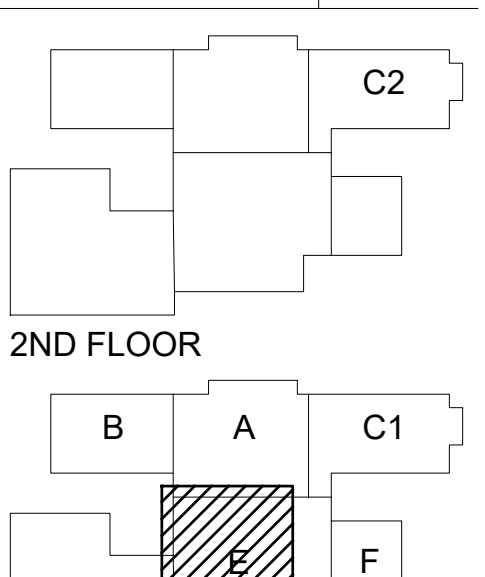


- 1ST FLOOR
2ND FLOOR
- GENERAL CONTRACTOR: BARNHILL CONTRACTING
- PRELIMINARY - NOT FOR CONSTRUCTION
 - ◐ FOR CONSTRUCTION
 - SHOP DRAWINGS
 - ◑ AS-BUILT DRAWINGS
- REVISIONS DATE

DRAWN BY: RJM
 CHECKED BY: RJM
 PROJECT: 22-693
 DATE: 05/06/2022
 SHEET: 10 OF: 17

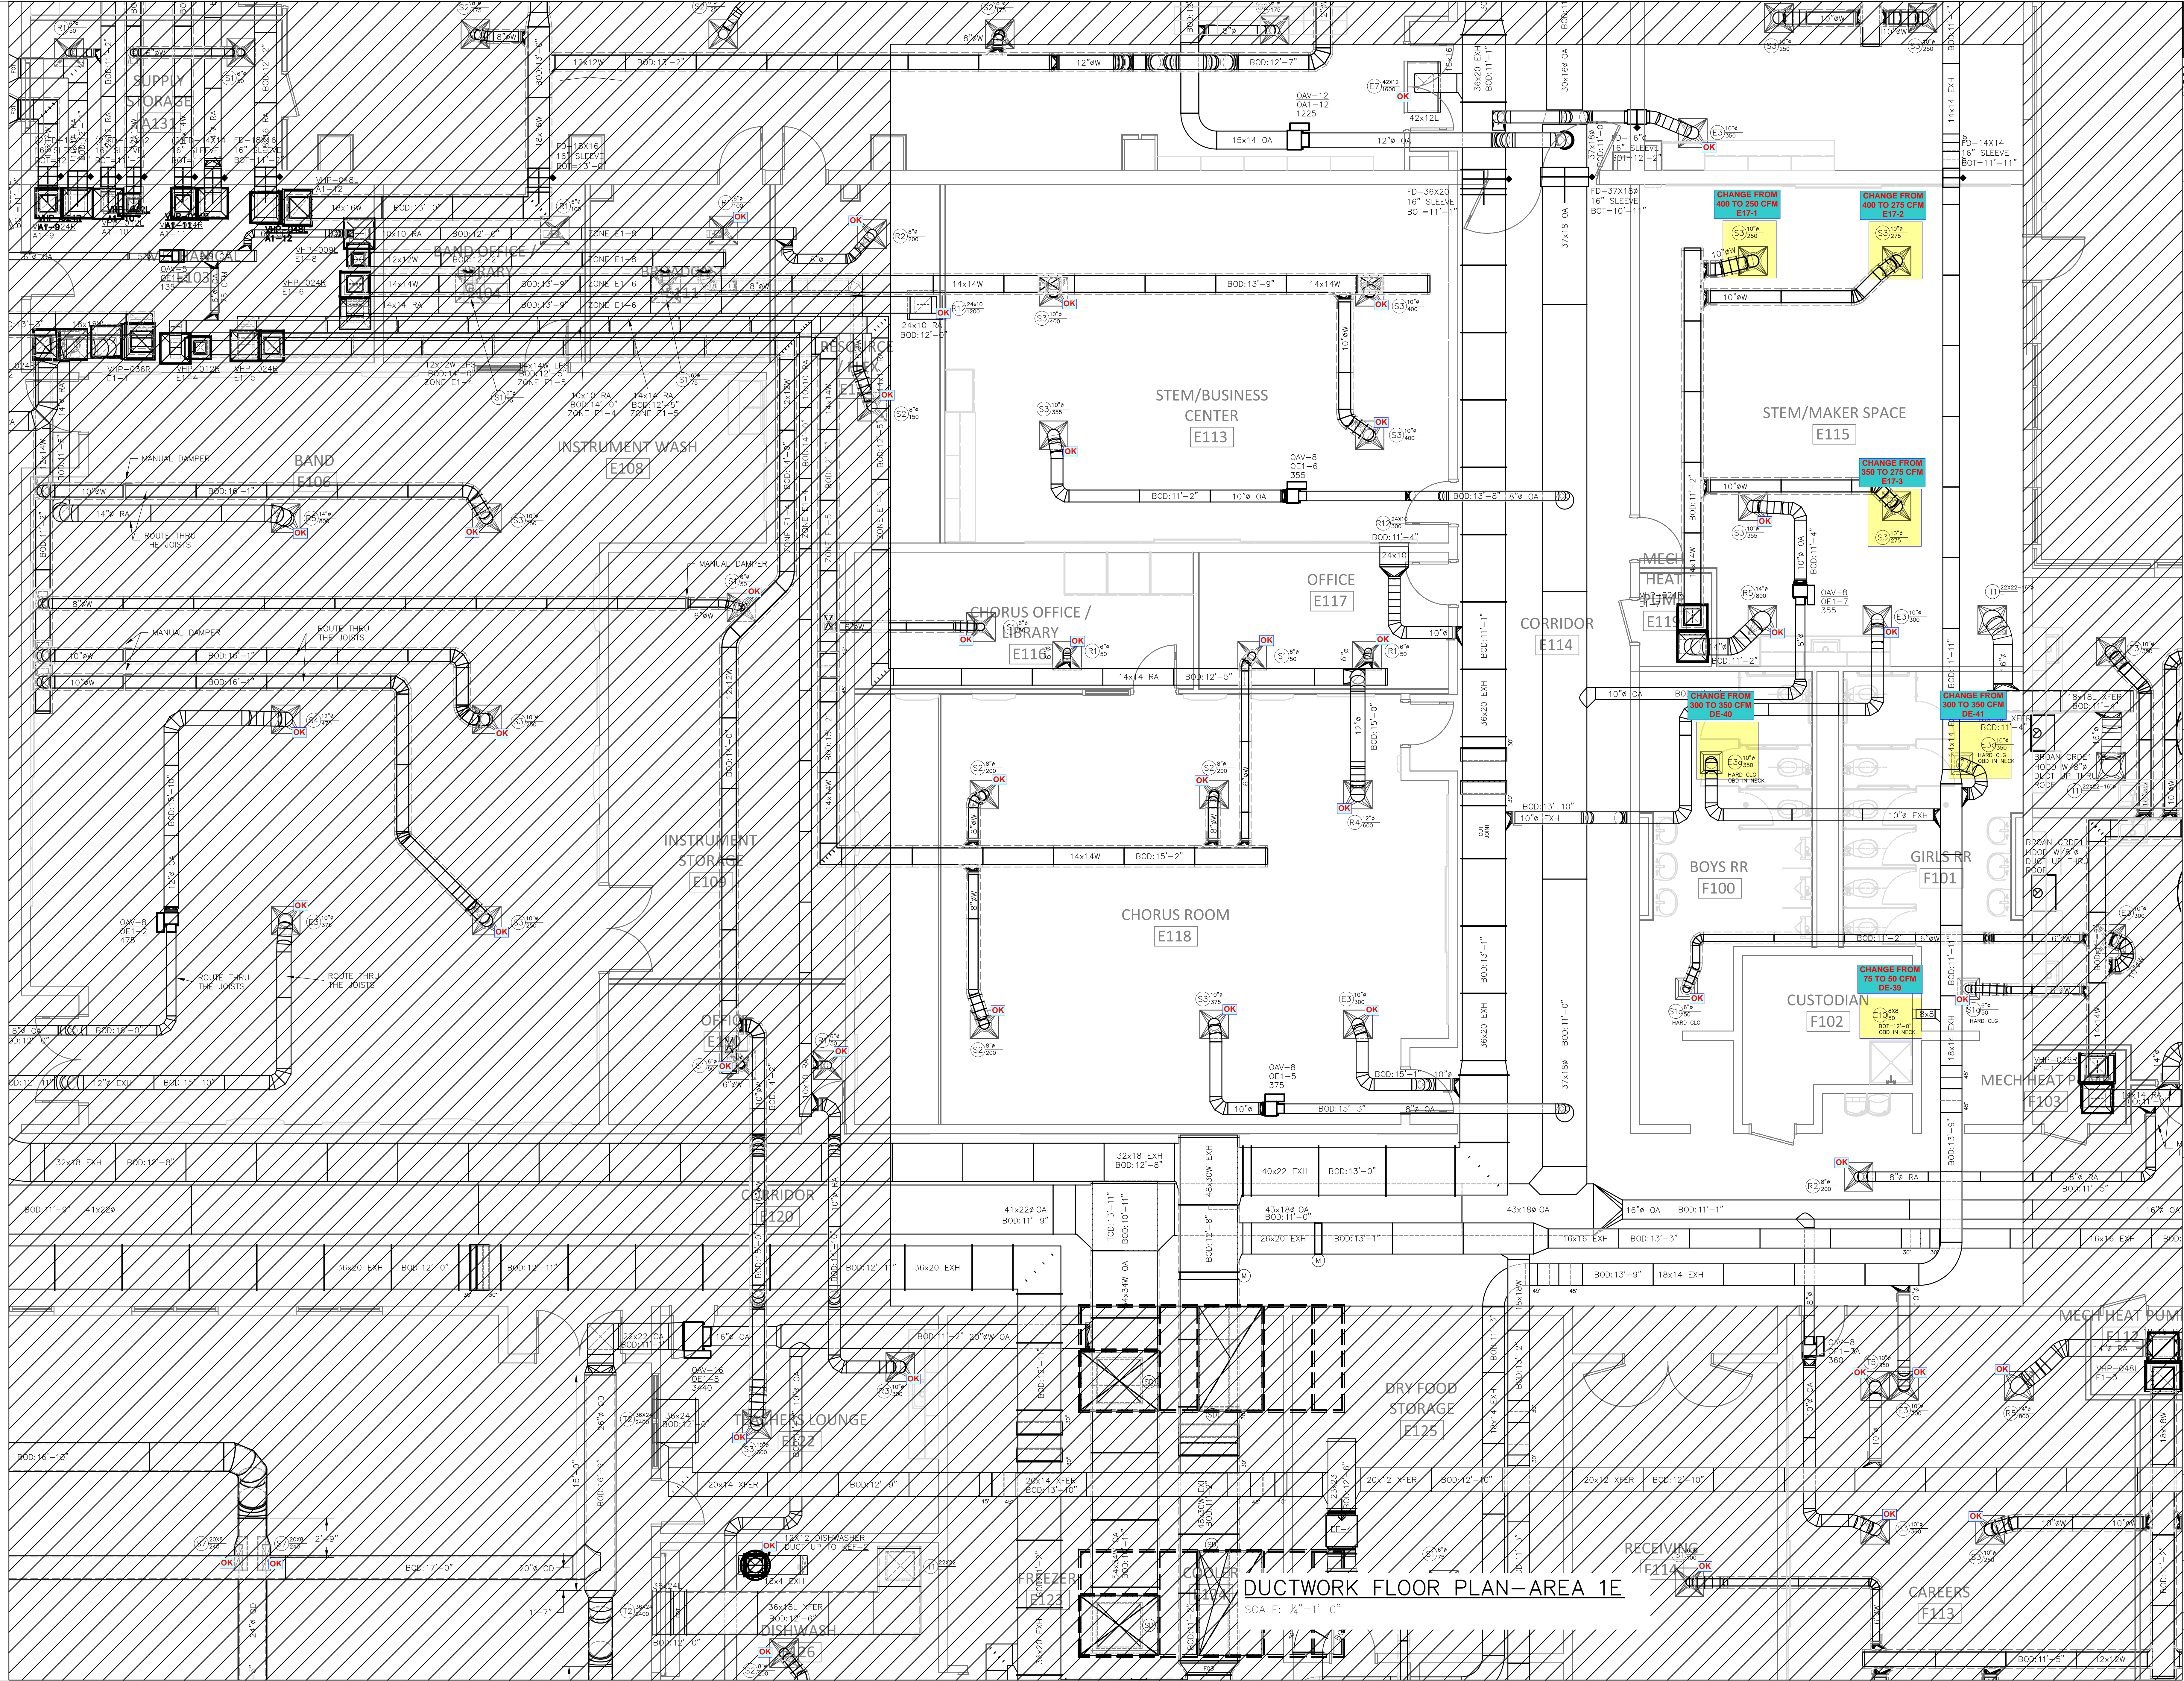


SELMA BURKE MIDDLE SCHOOL 235 RINEHARDT ROAD MOORESVILLE, NC 28115

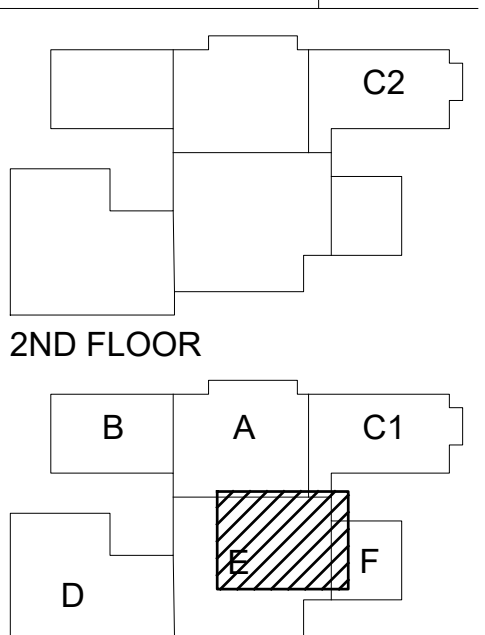

- GENERAL CONTRACTOR: BARNHILL CONTRACTING
PRELIMINARY - NOT FOR CONSTRUCTION
FOR CONSTRUCTION
SHOP DRAWINGS
AS-BUILT DRAWINGS


REVISIONS DATE
DRAWN BY: RJM
CHECKED BY: RJM
PROJECT: 22-693
DATE: 05/06/2022
SHEET: 11 OF: 17

DUCTWORK FLOOR PLAN-AREA 1E
SCALE: 1/4"=1'-0"

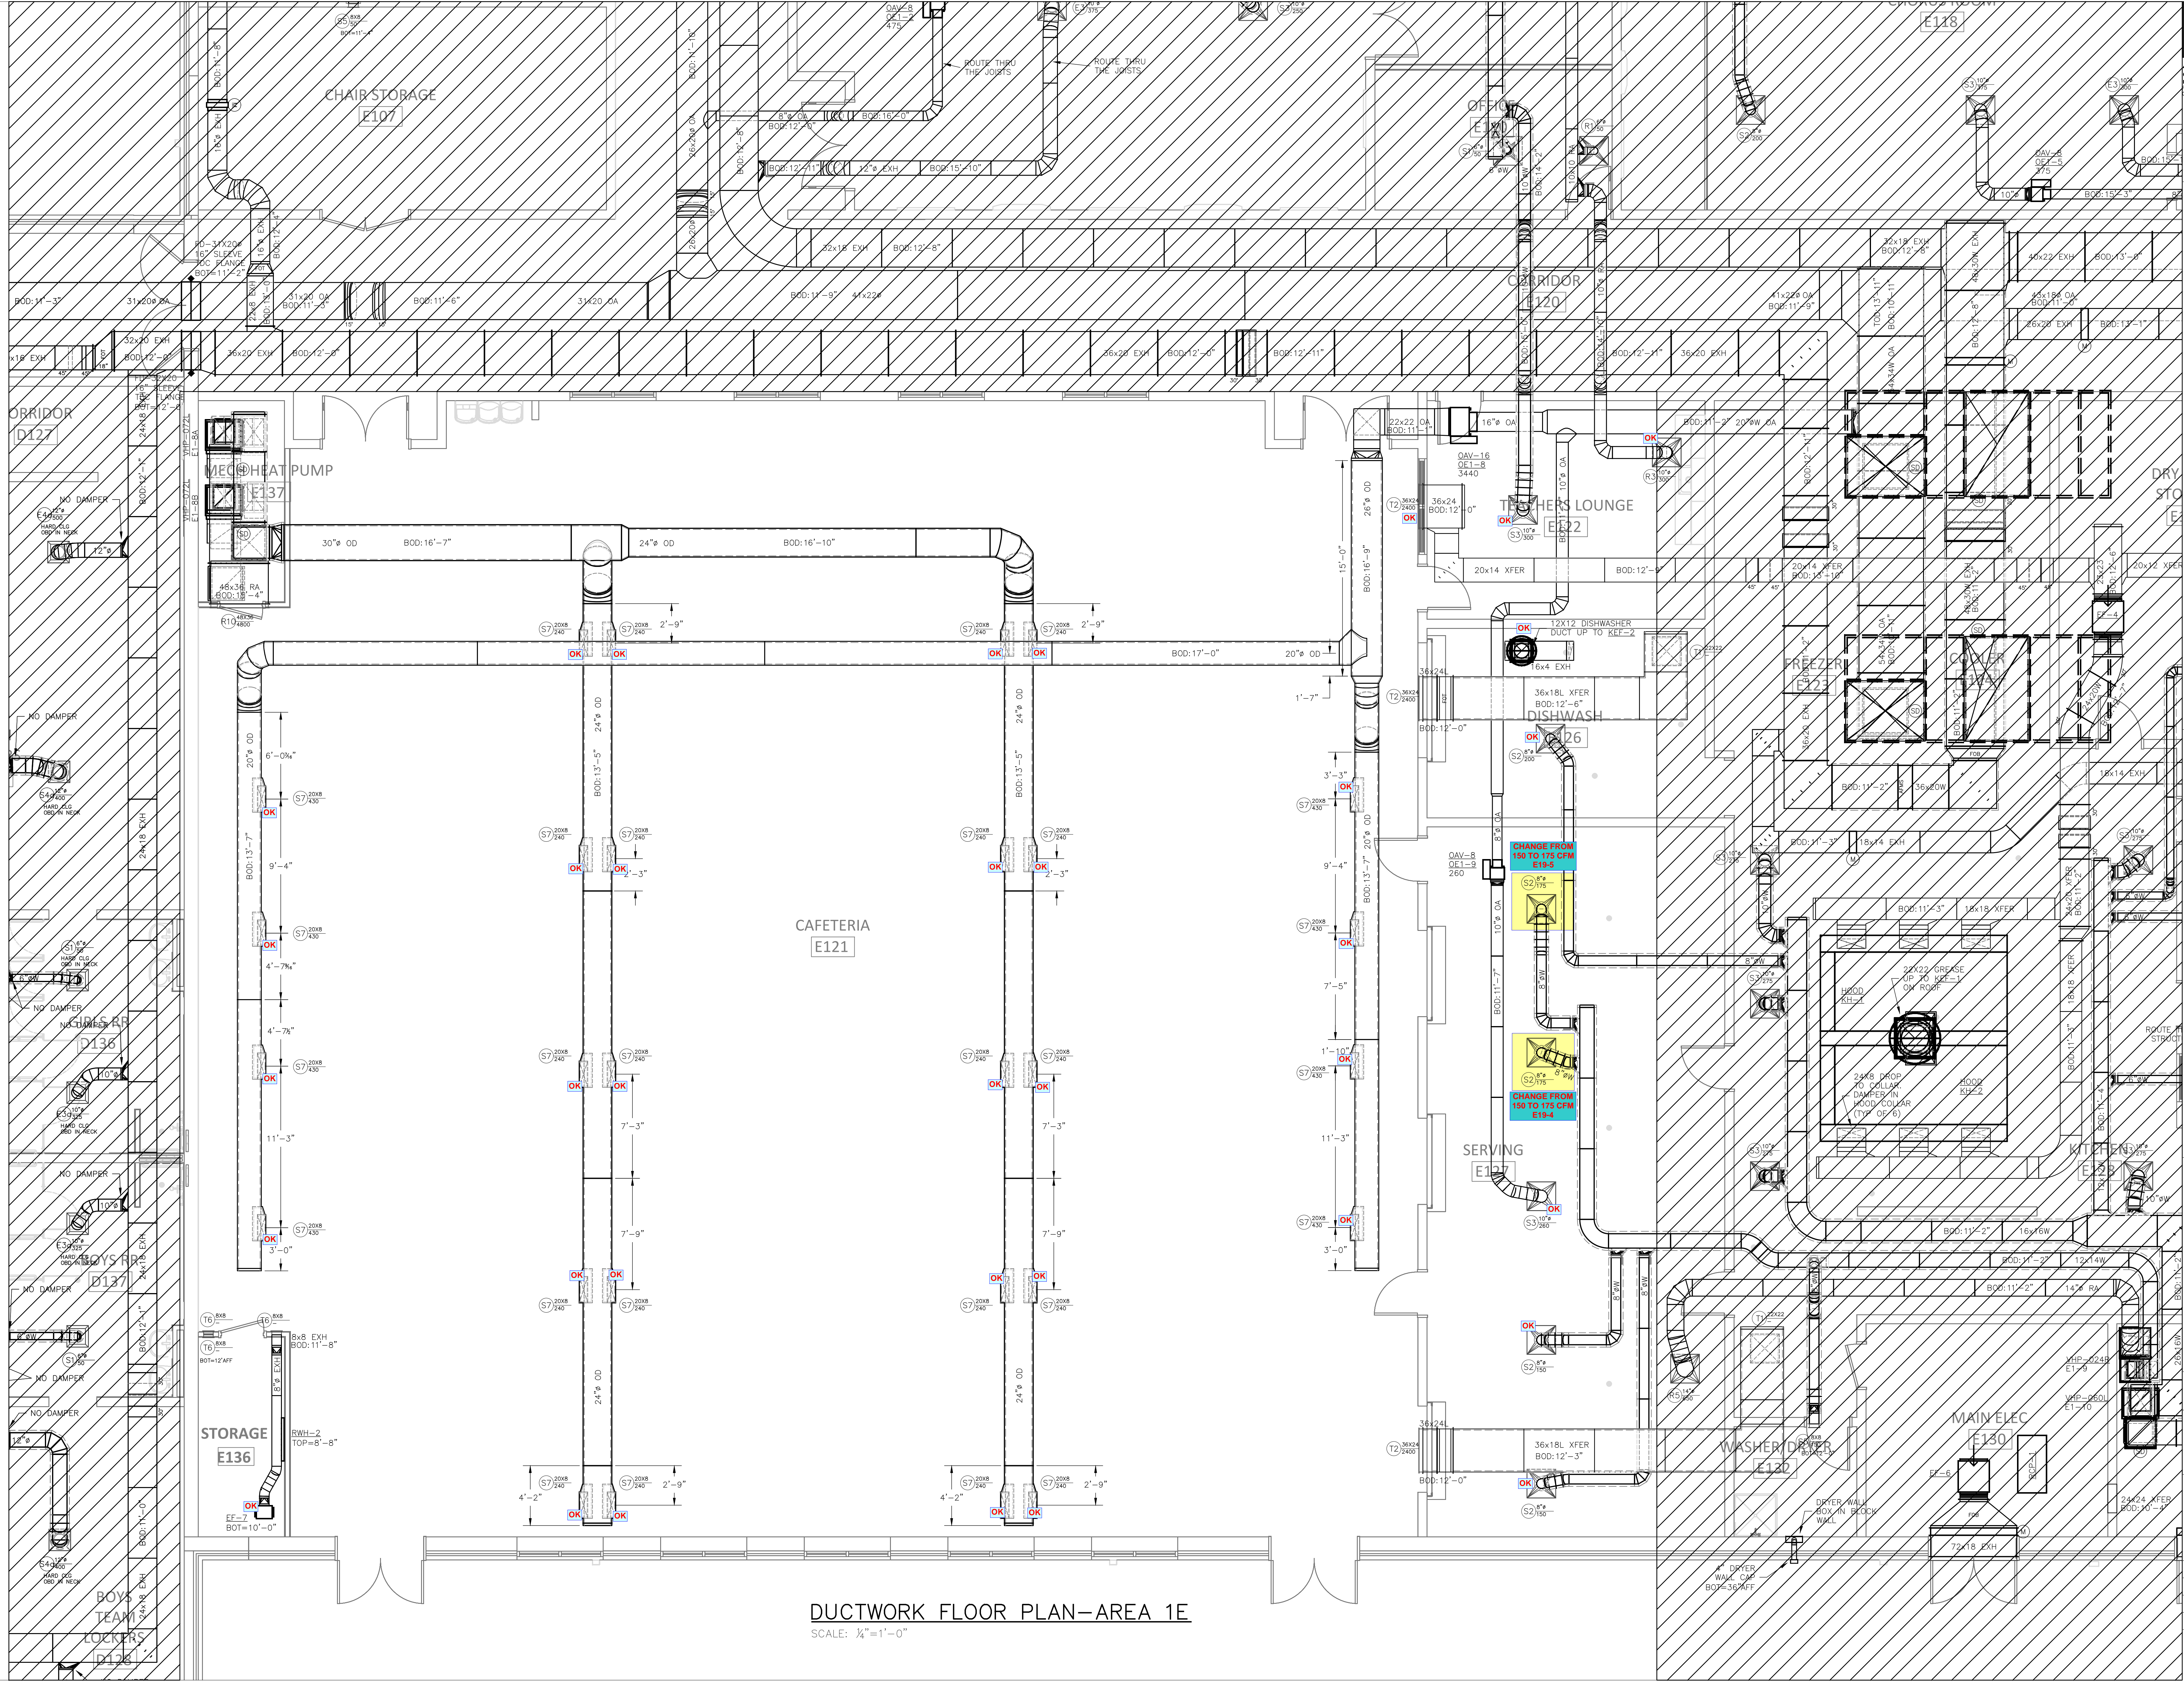


DUCTWORK FLOOR PLAN-AREA 1E
SCALE: 1/4"=1'-0"

SELMA BURKE
MIDDLE SCHOOL
235 RINEHARDT ROAD
MOORESVILLE, NC 28115

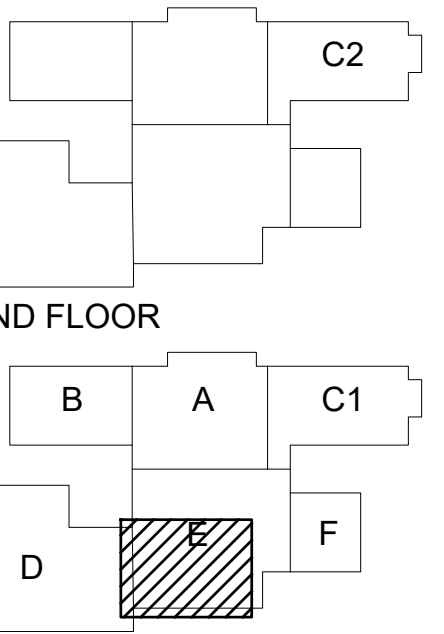


GENERAL CONTRACTOR: BARNHILL CONTRACTING
PRELIMINARY - NOT FOR CONSTRUCTION
SHOP DRAWINGS
AS-BUILT DRAWINGS

REVISIONS DATE
DRAWN BY: RJM
CHECKED BY: RJM
PROJECT: 22-693
DATE: 05/06/2022
SHEET: 12 OF: 17

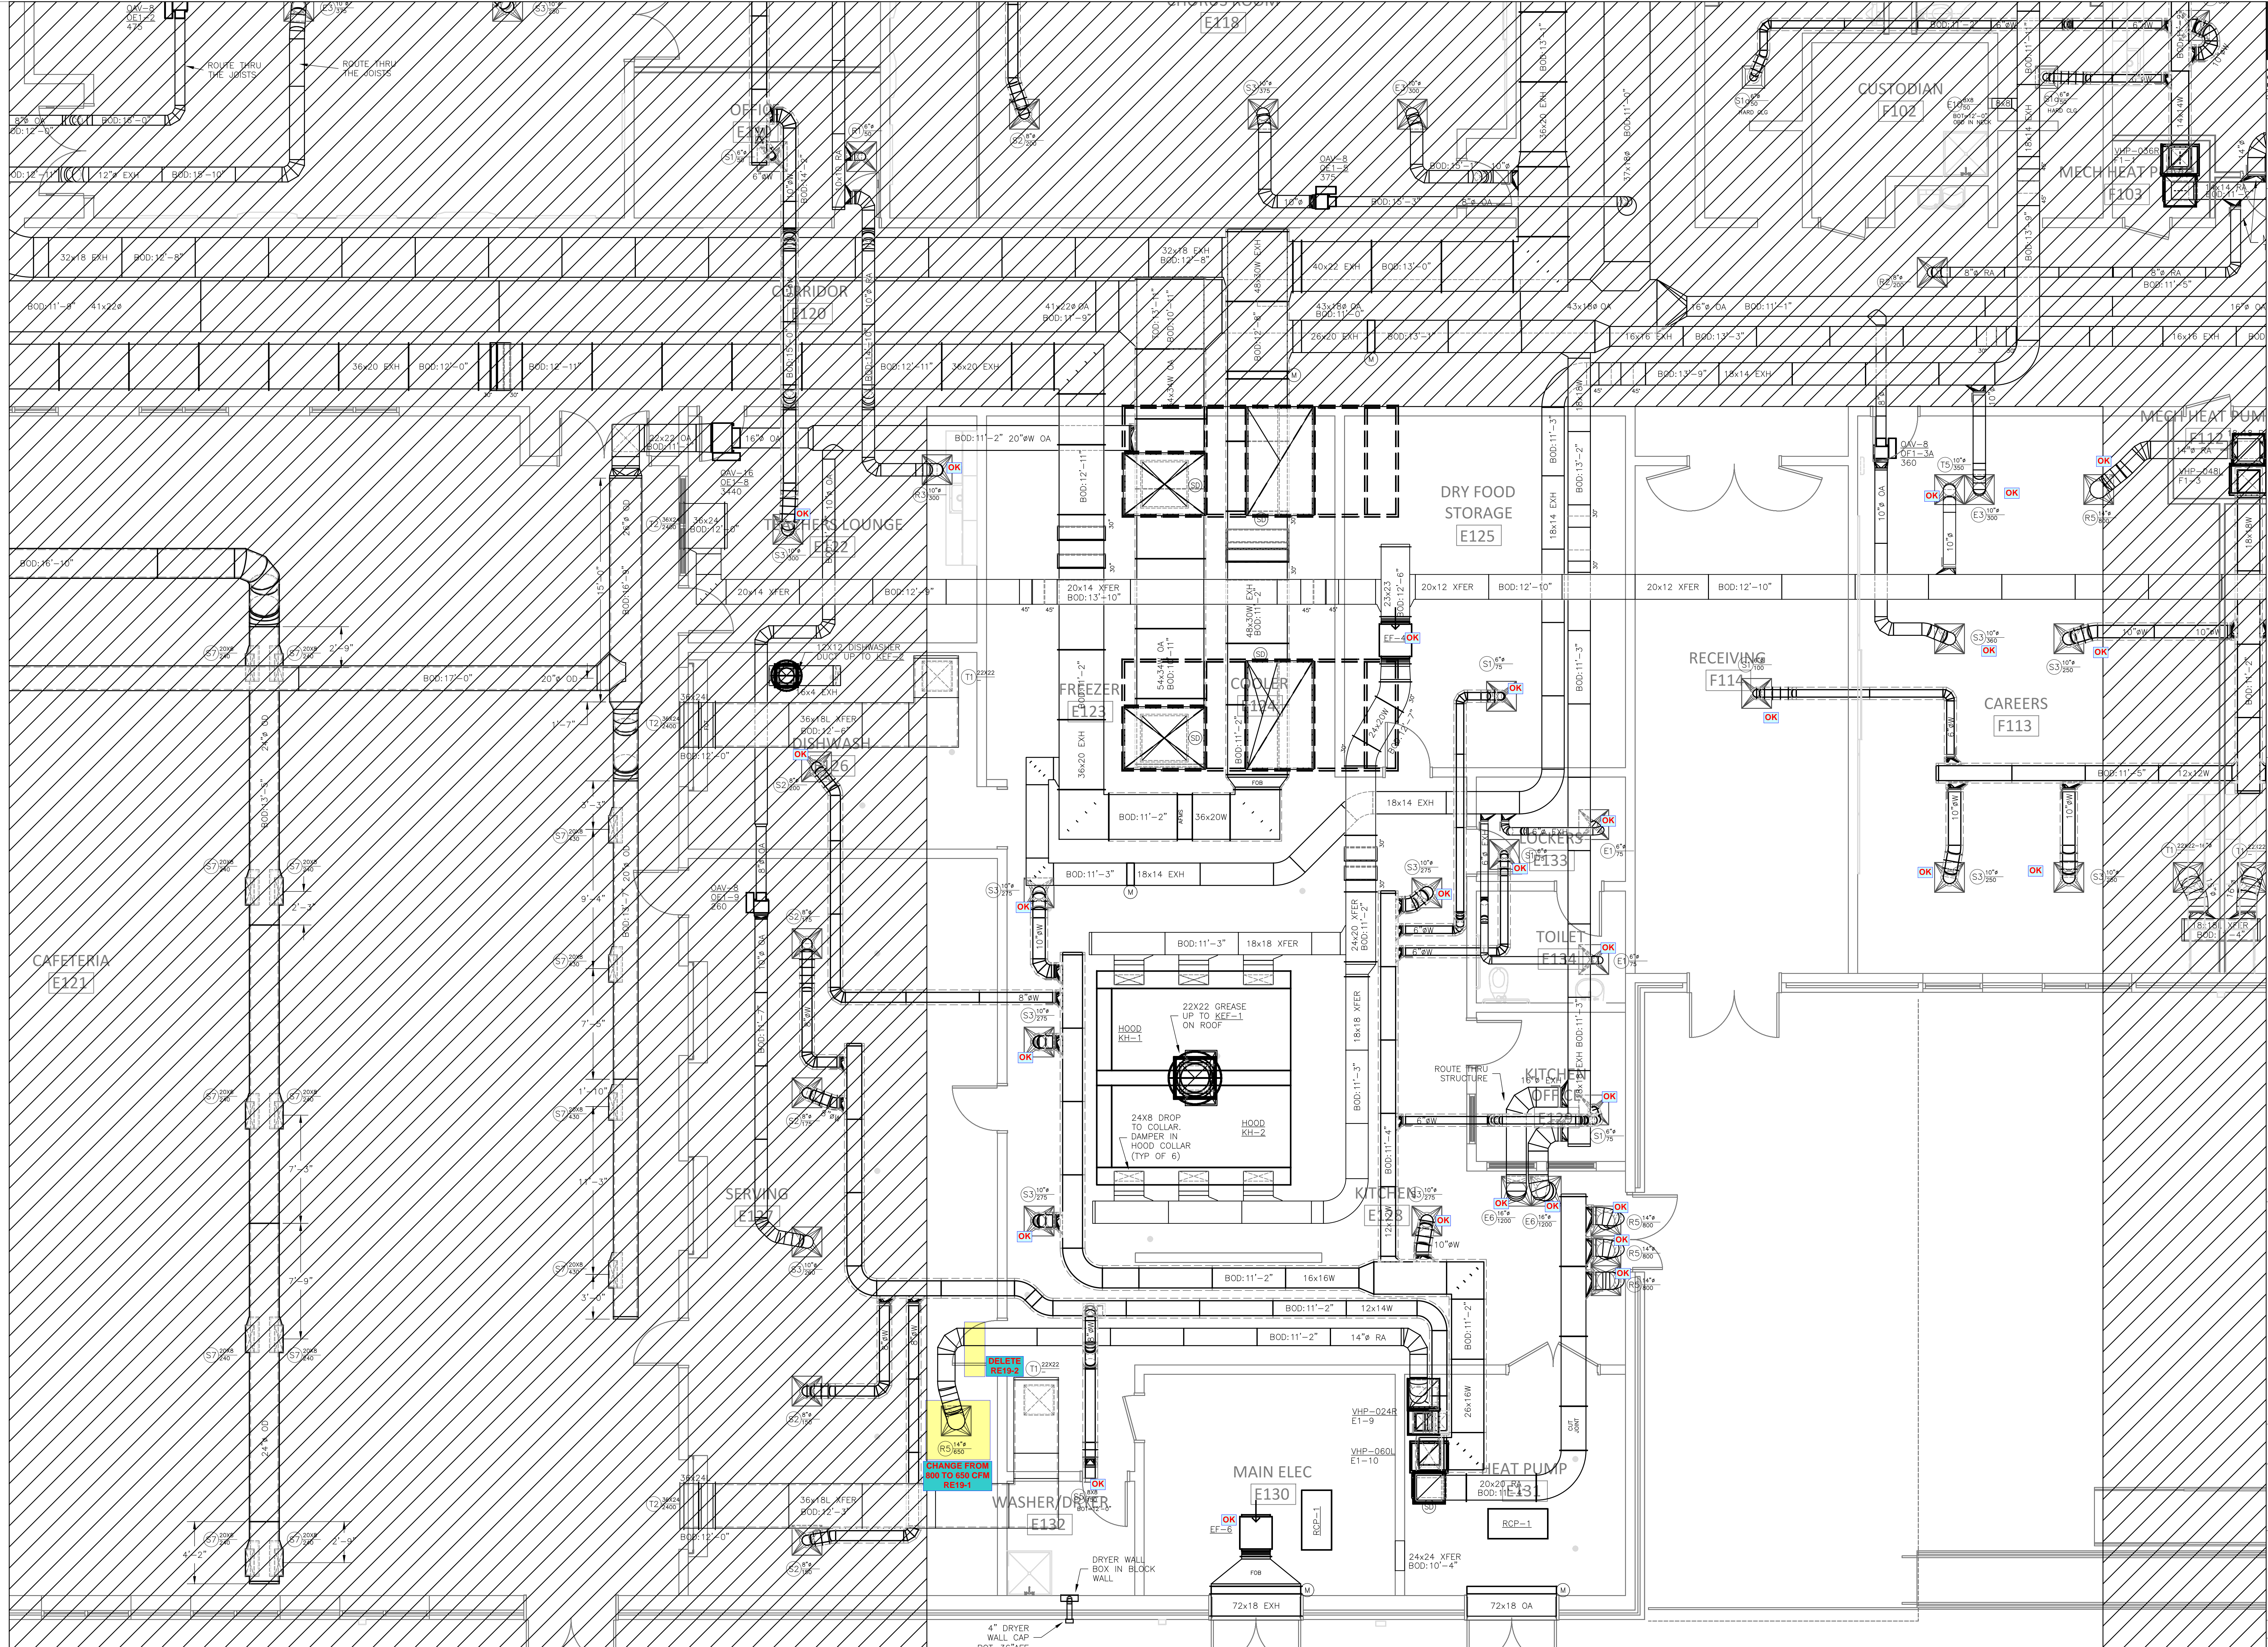



DUCTWORK FLOOR PLAN-AREA 1E
SCALE: 1/4"=1'-0"

**SELMA BURKE
MIDDLE SCHOOL**
235 RINEHARDT ROAD
MOORESVILLE, NC 28115

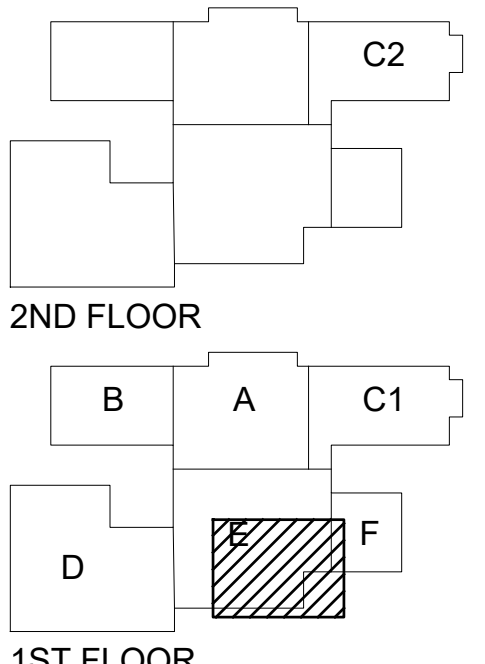


GENERAL CONTRACTOR:
BARNHILL CONTRACTING
○ PRELIMINARY - NOT FOR CONSTRUCTION
○ FOR CONSTRUCTION
● SHOP DRAWINGS
○ AS-BUILT DRAWINGS
REVISIONS DATE

DRAWN BY: RJM
CHECKED BY: RJM
PROJECT: 22-693
DATE: 05/06/2022
SHEET: 13 OF: 17

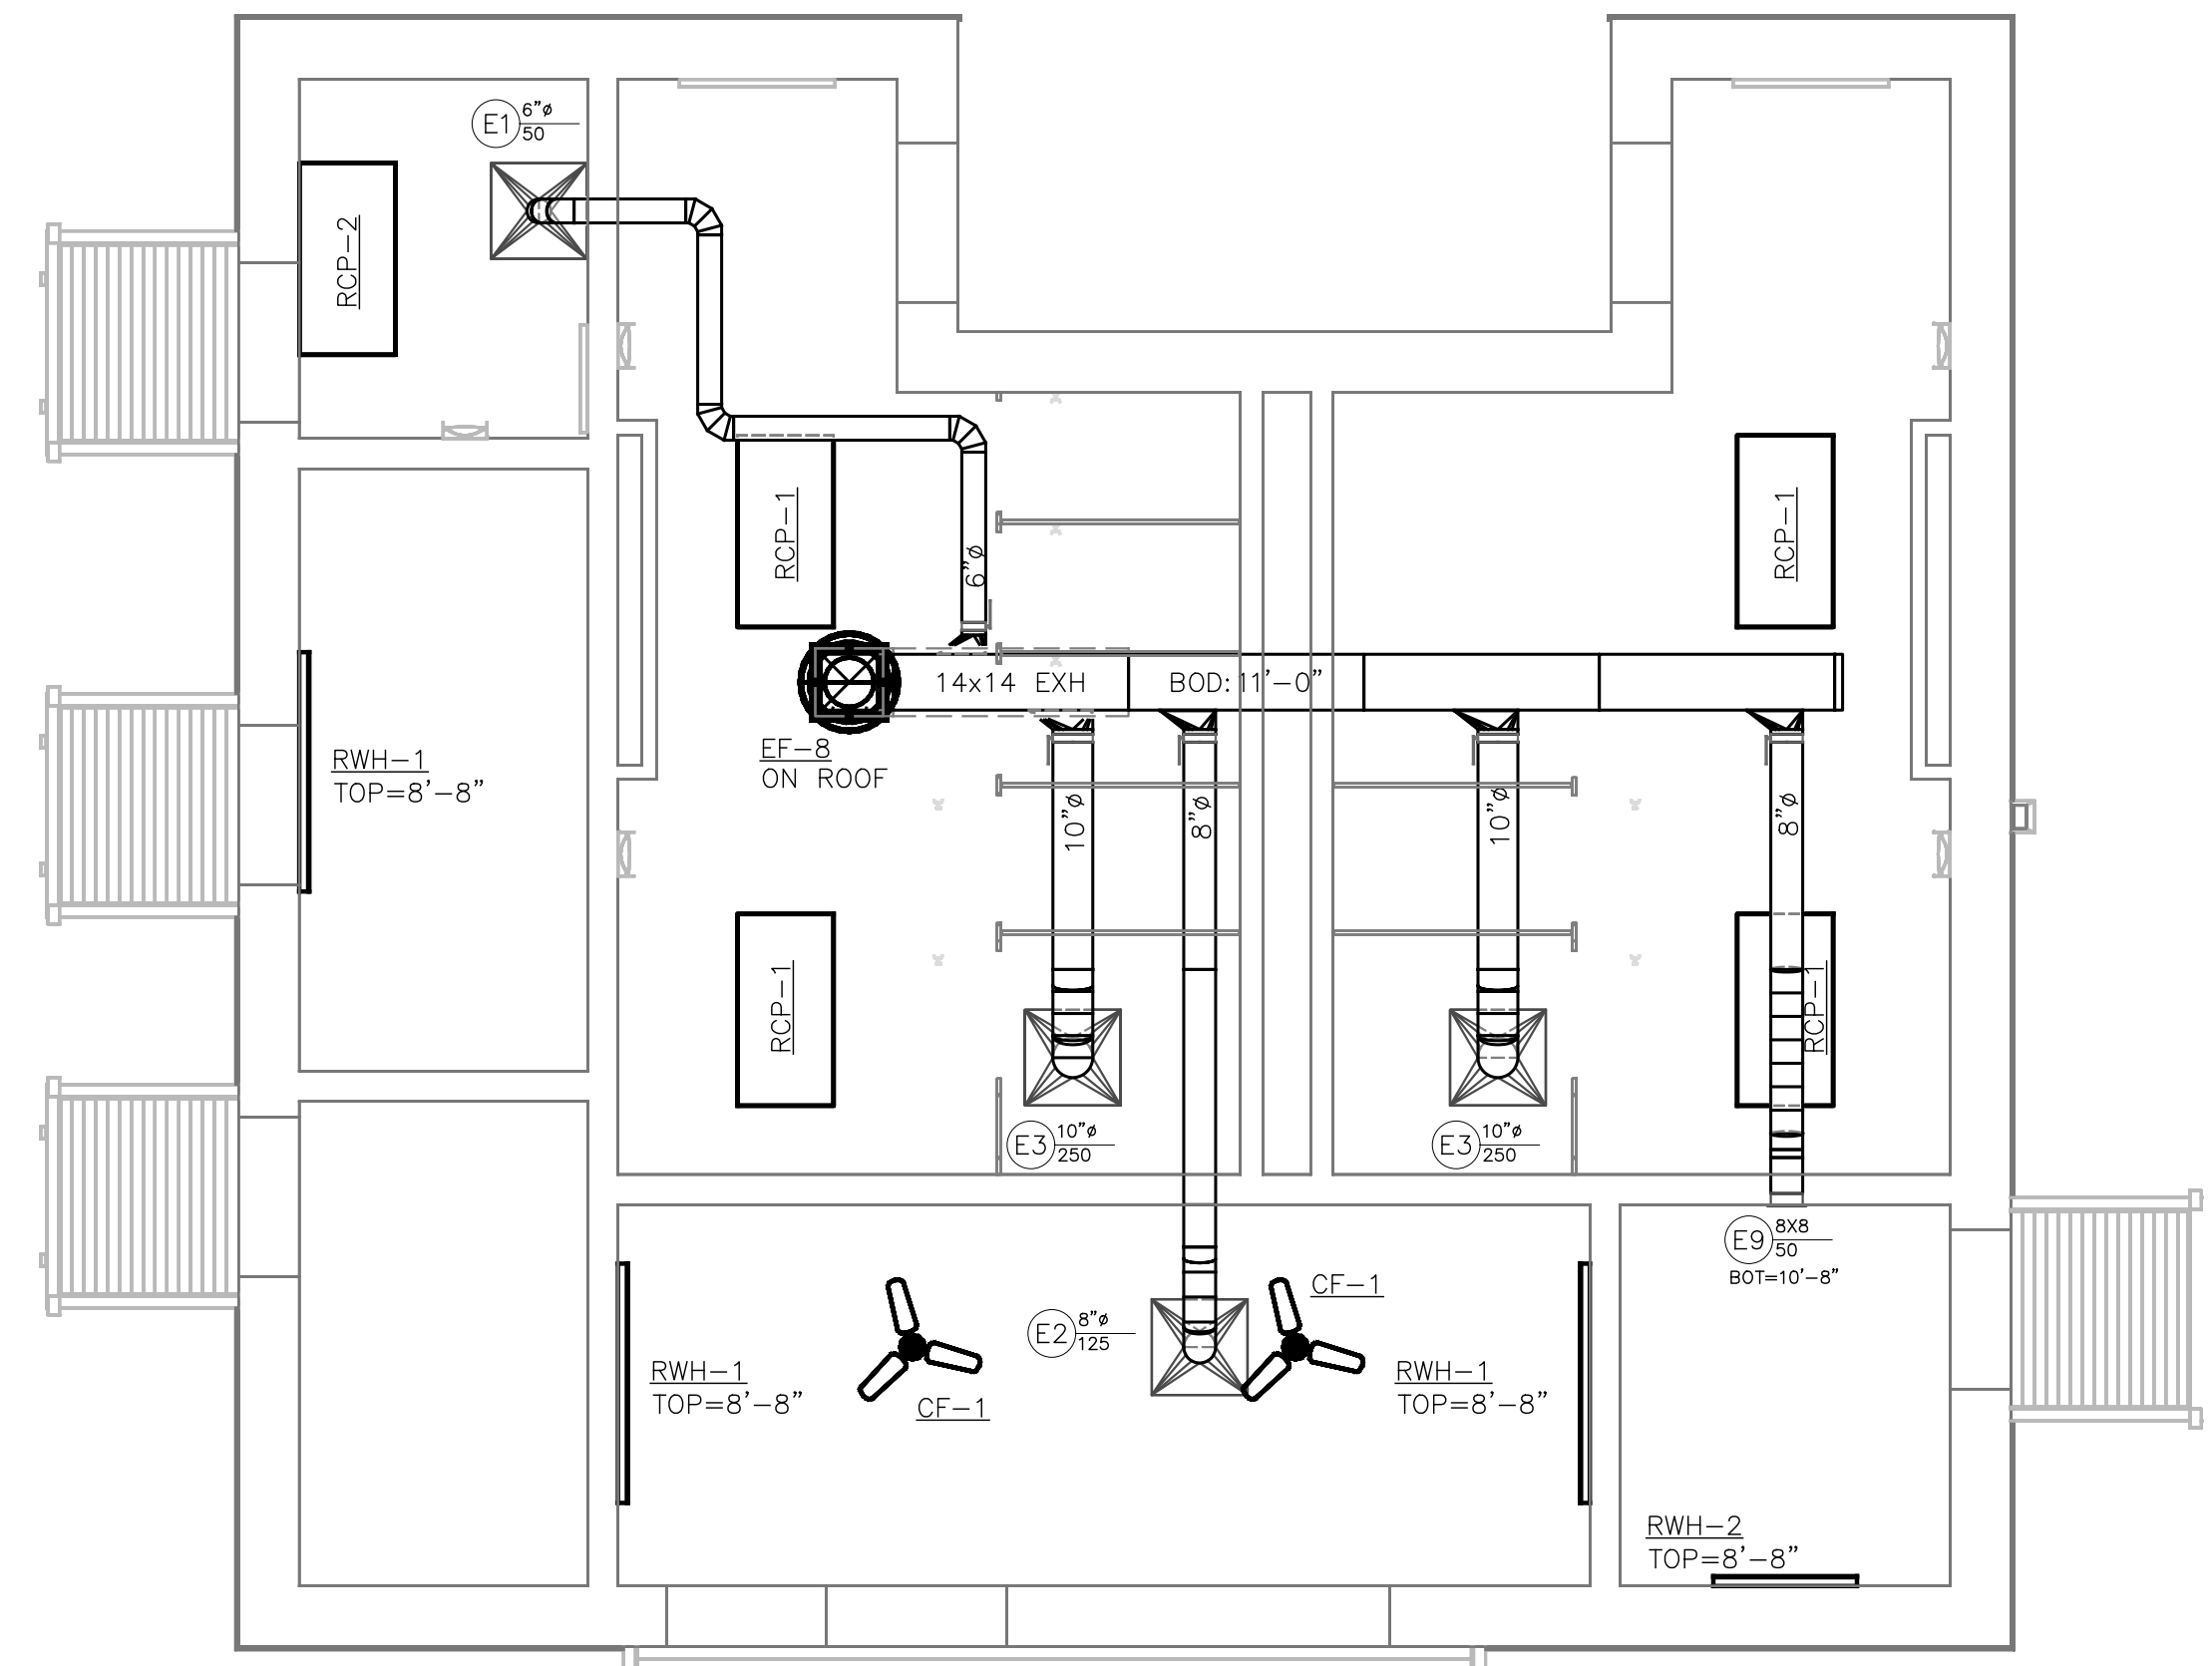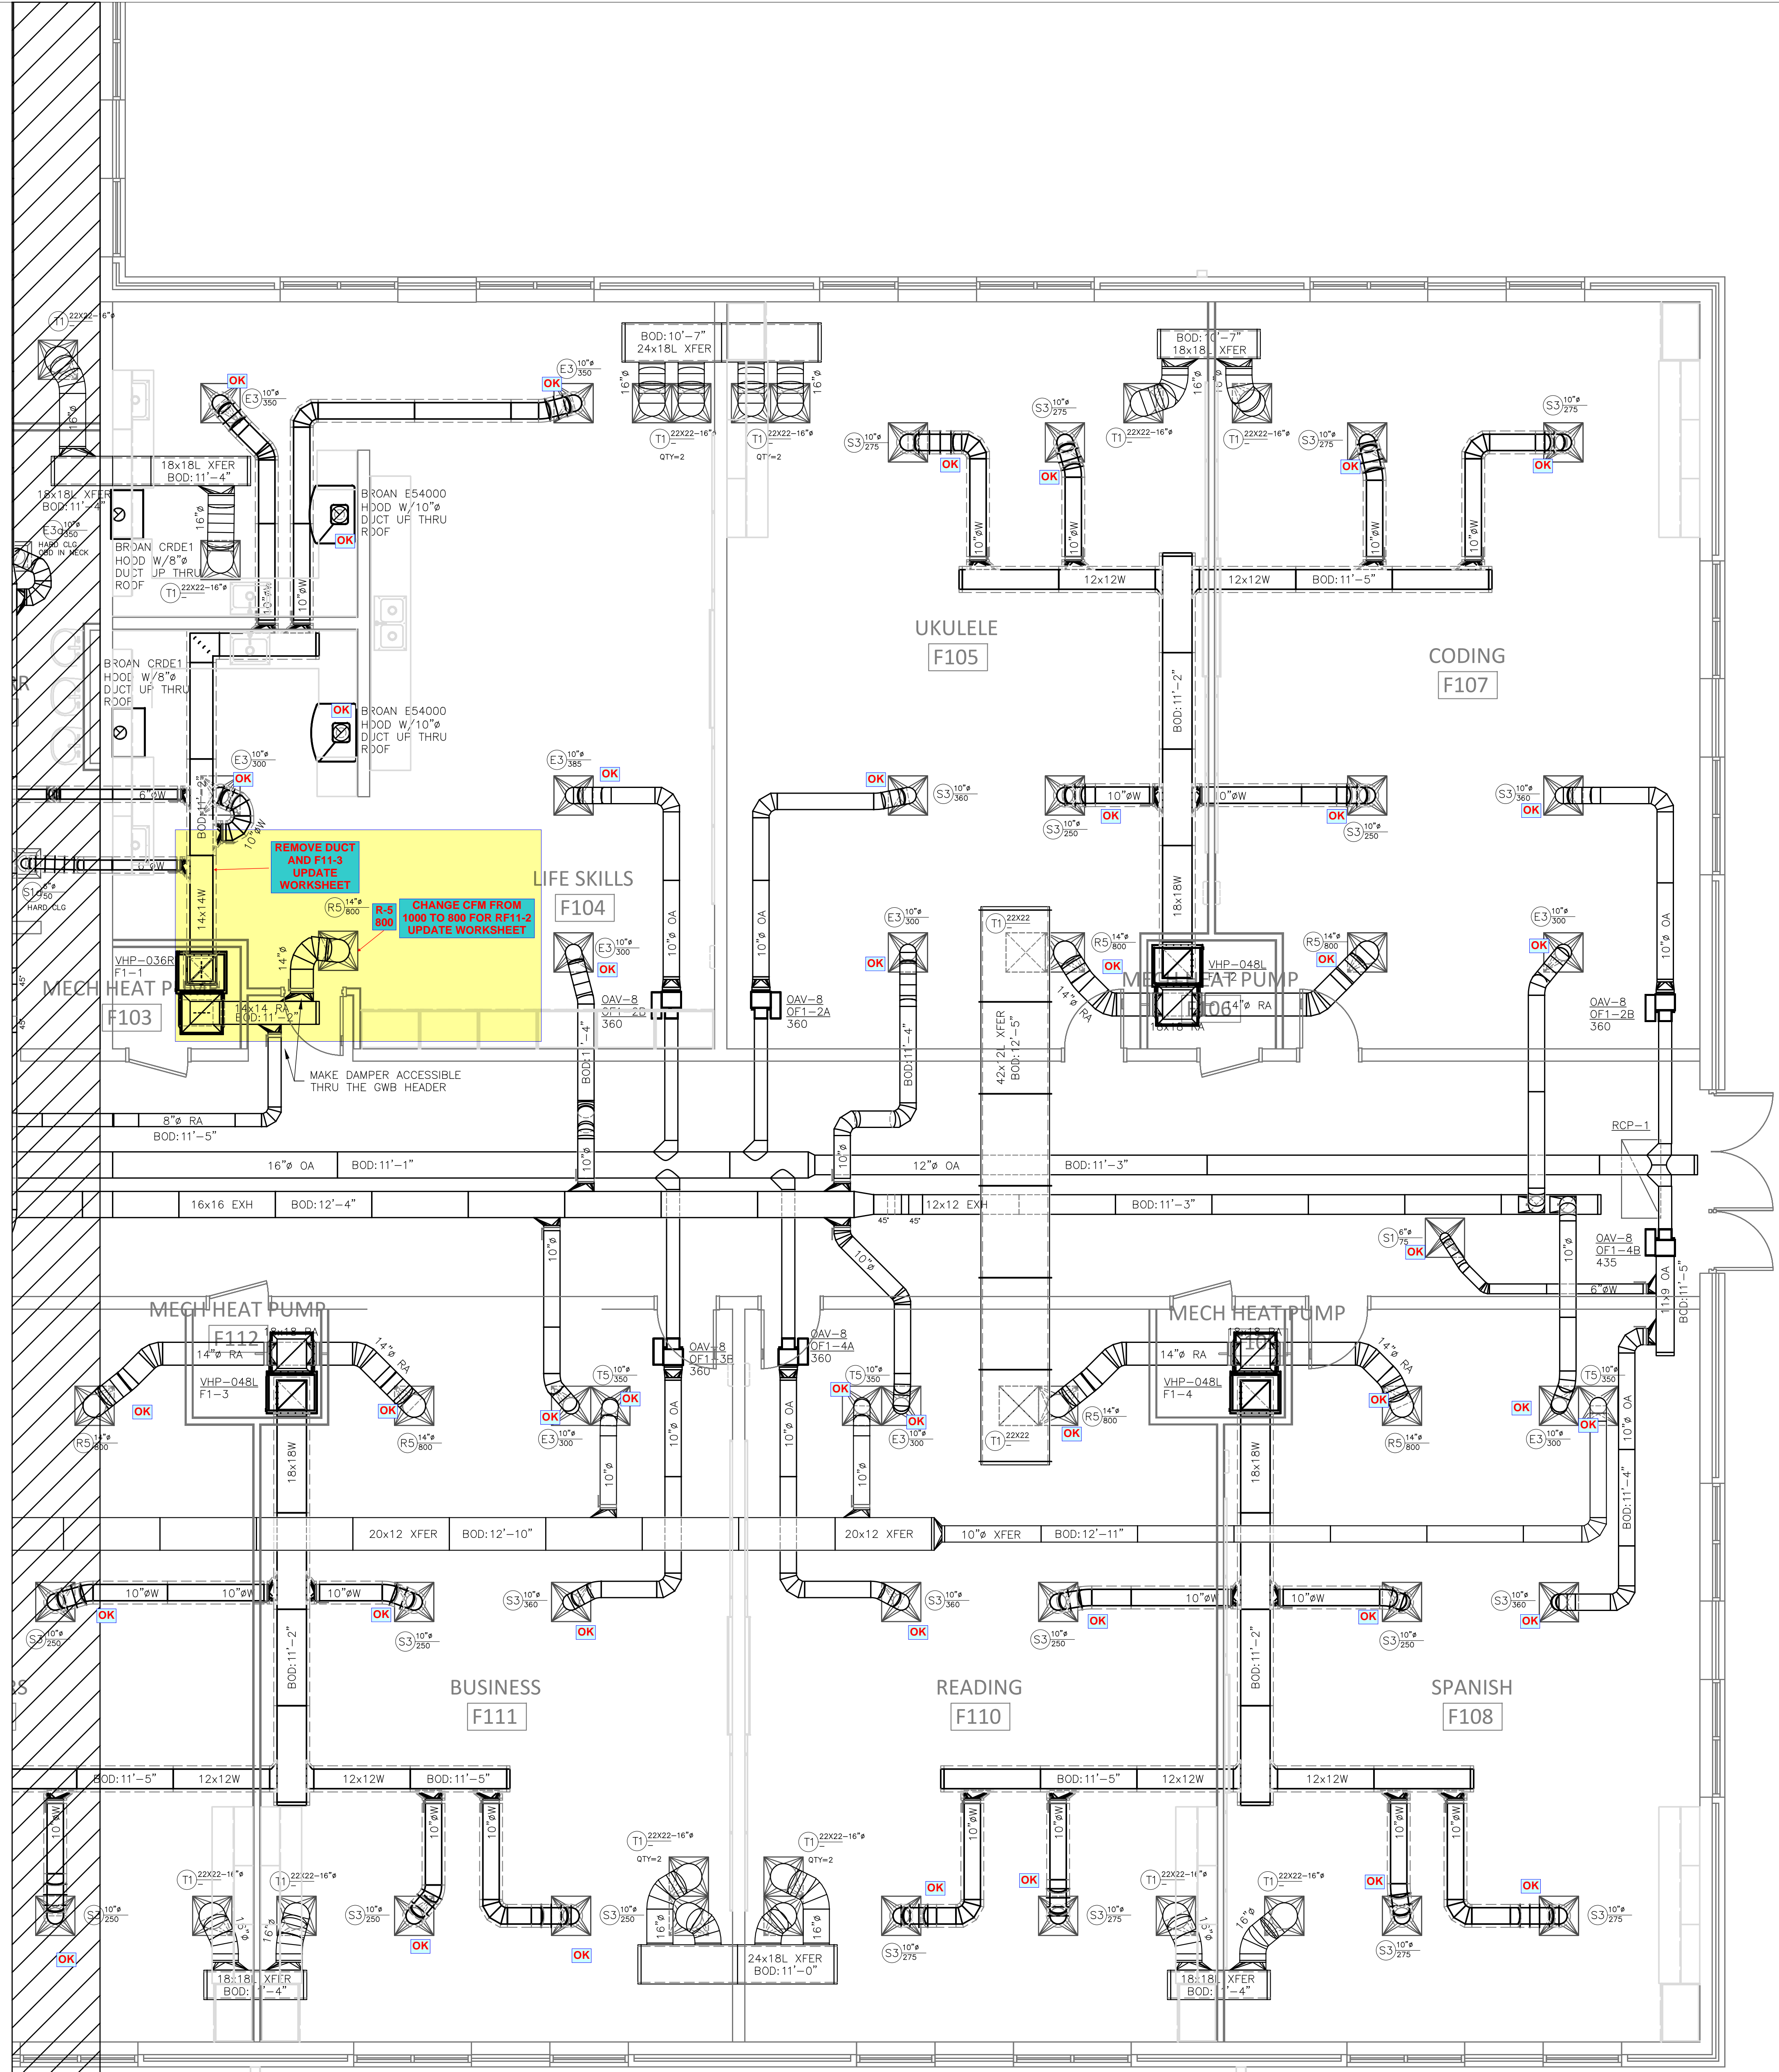

SELMA BURKE MIDDLE SCHOOL
 235 RINEHARDT ROAD
 MOORESVILLE, NC 28115

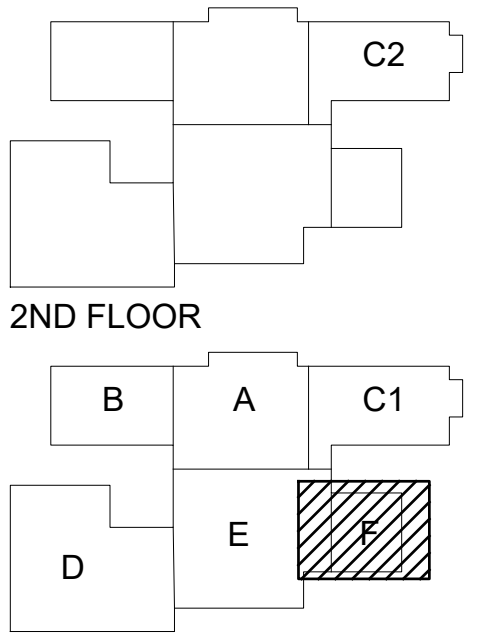


GENERAL CONTRACTOR:
 BARNHILL CONTRACTING



○ PRELIMINARY - NOT FOR CONSTRUCTION
 ○ FOR CONSTRUCTION
 ● SHOP DRAWINGS
 ○ AS-BUILT DRAWINGS

REVISIONS	DATE

DRAWN BY: RJM
CHECKED BY: RJM
PROJECT: 22-693
DATE: 05/06/2022
SHEET: 14 **OF:** 17

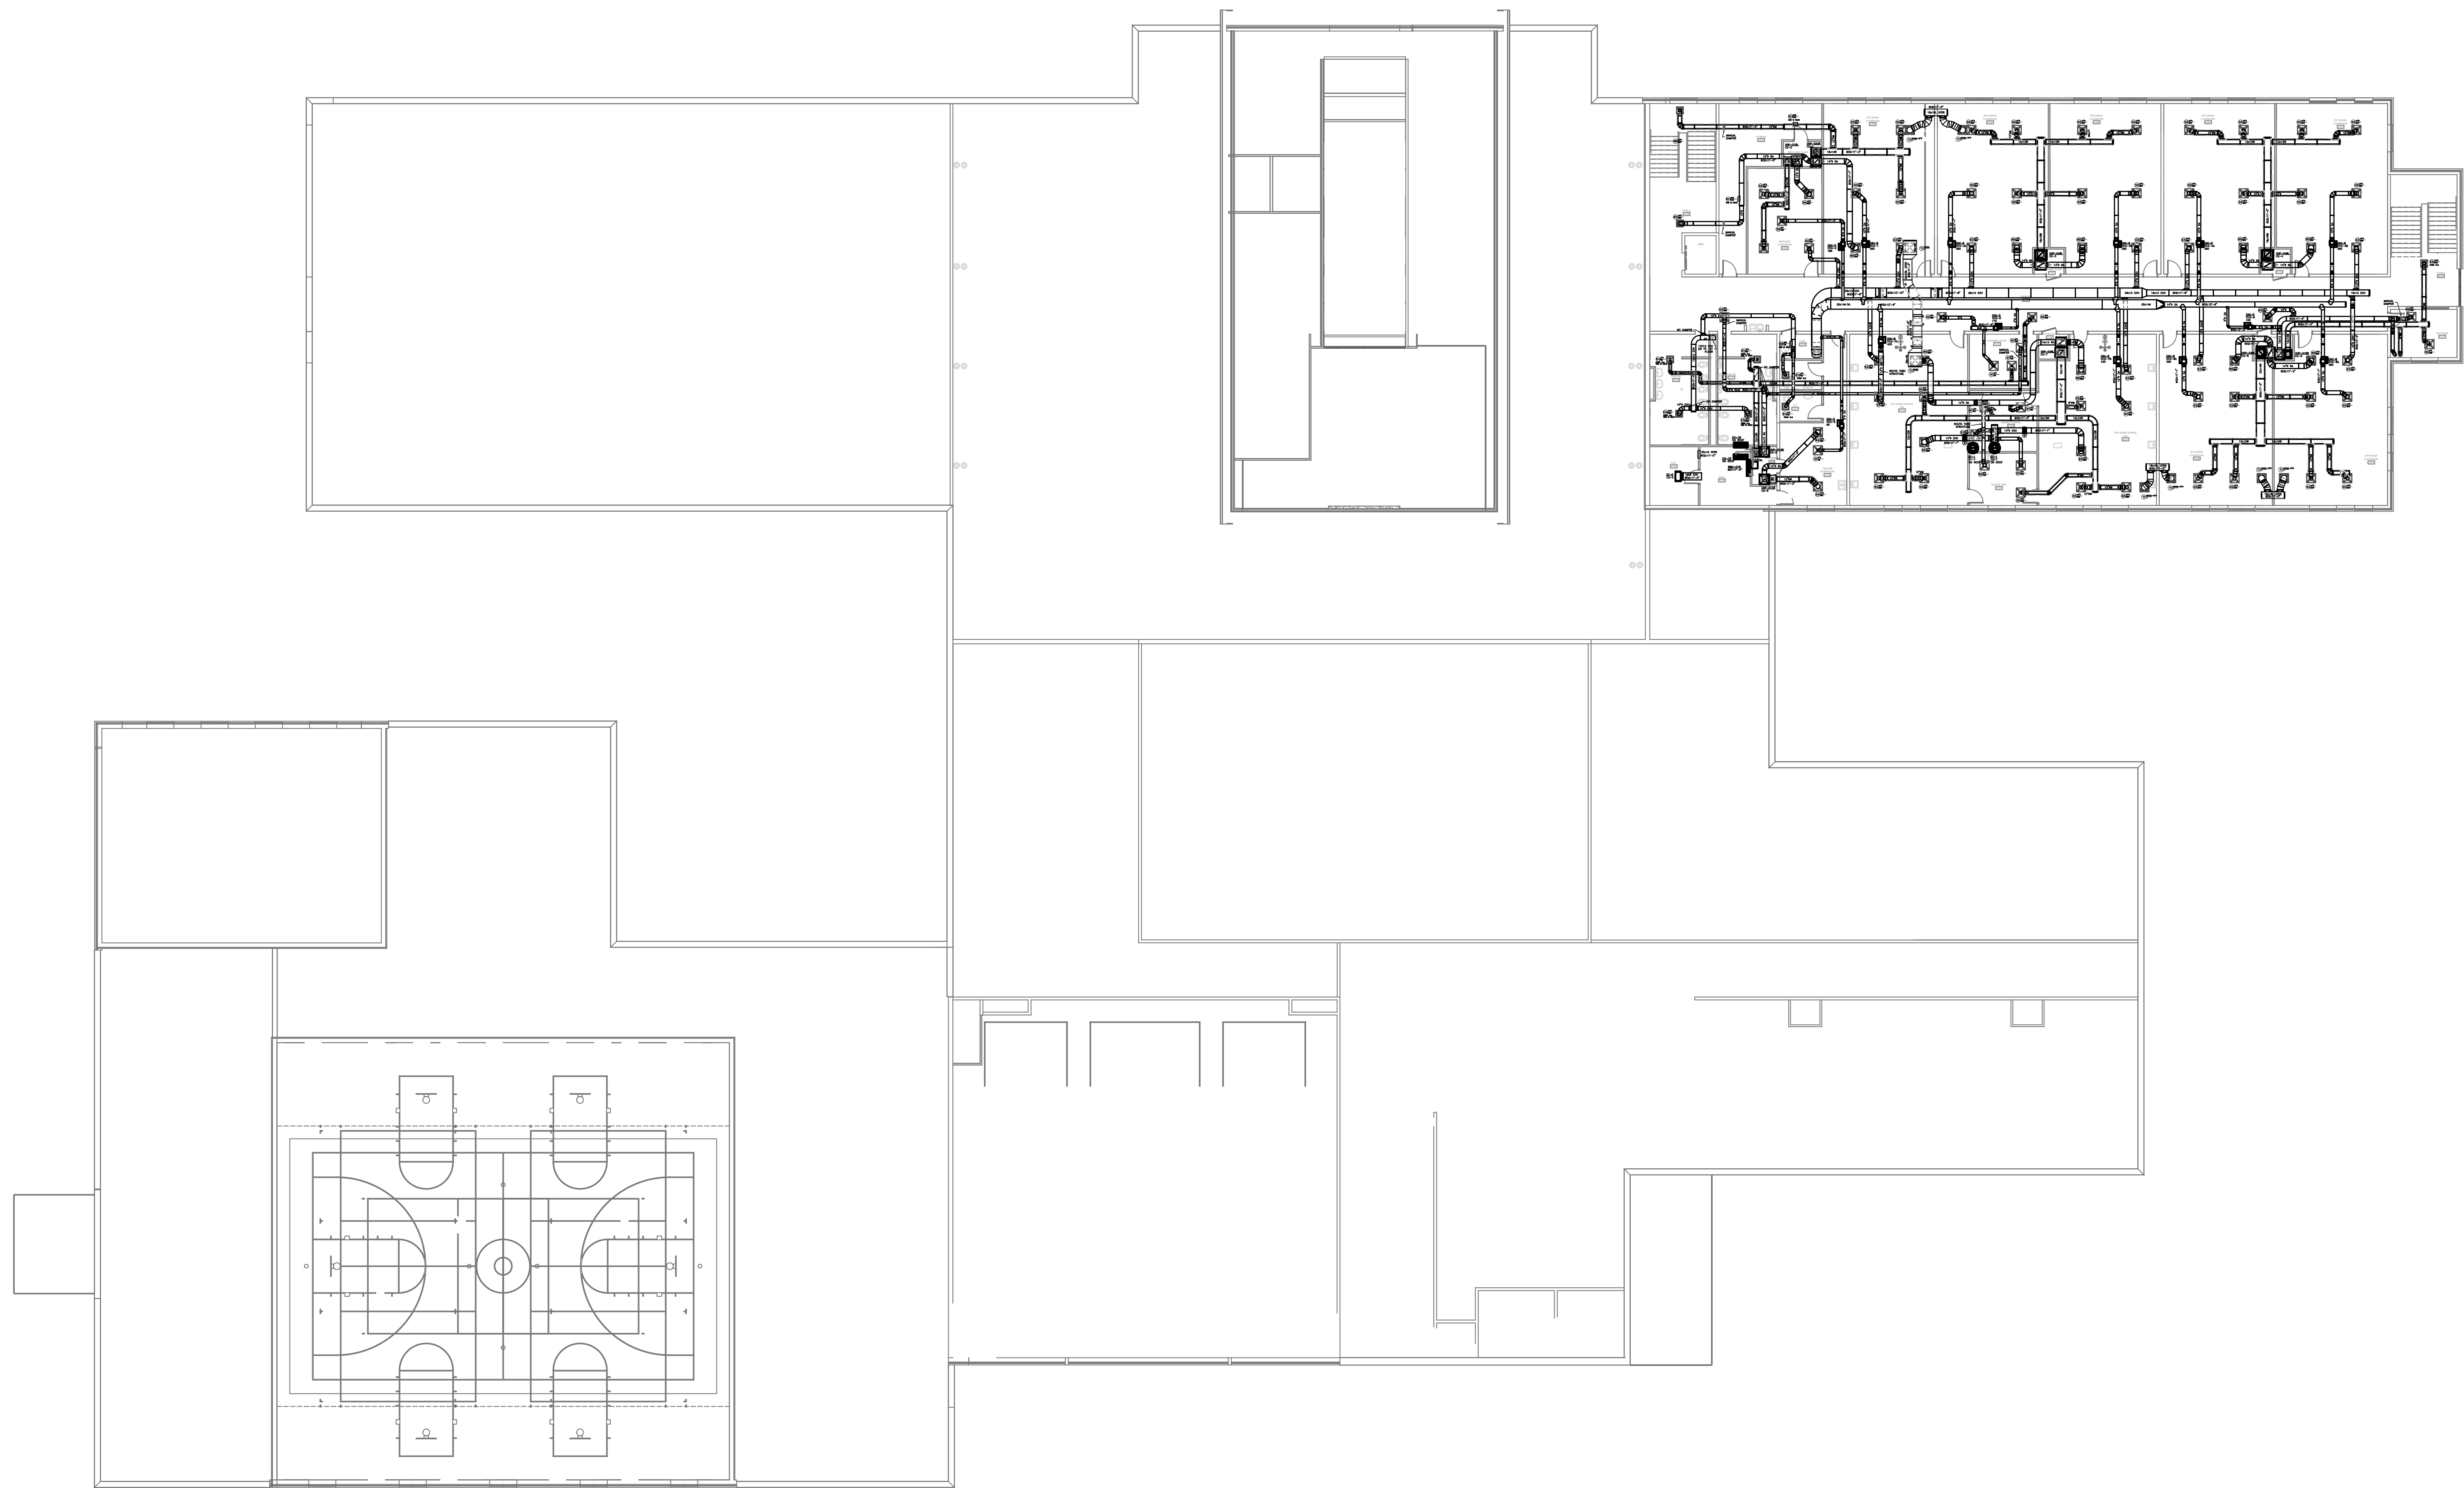

**SELMA BURKE
 MIDDLE SCHOOL**
 235 RINEHARDT ROAD
 MOORESVILLE, NC 28115

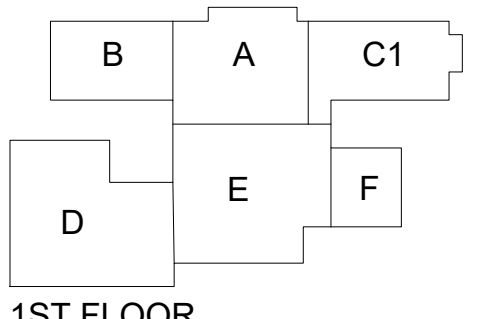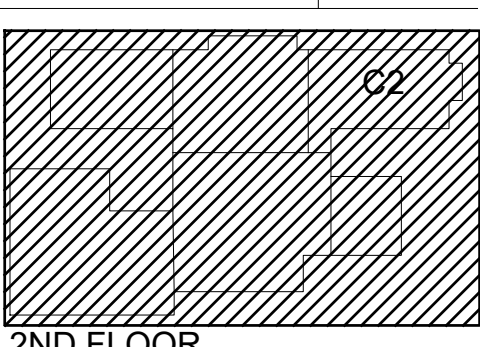



- GENERAL CONTRACTOR:**
 BARNHILL CONTRACTING
- PRELIMINARY - NOT FOR CONSTRUCTION
 - FOR CONSTRUCTION
 - SHOP DRAWINGS
 - AS-BUILT DRAWINGS

REVISIONS	DATE

DRAWN BY: RJM
 CHECKED BY: RJM
 PROJECT: 22-693
 DATE: 05/06/2022
 SHEET: 15 OF: 17

DUCTWORK FLOOR PLAN—OVERALL 2ND FLOOR
 SCALE: 3/8"=1'-0"

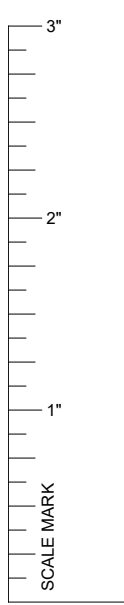

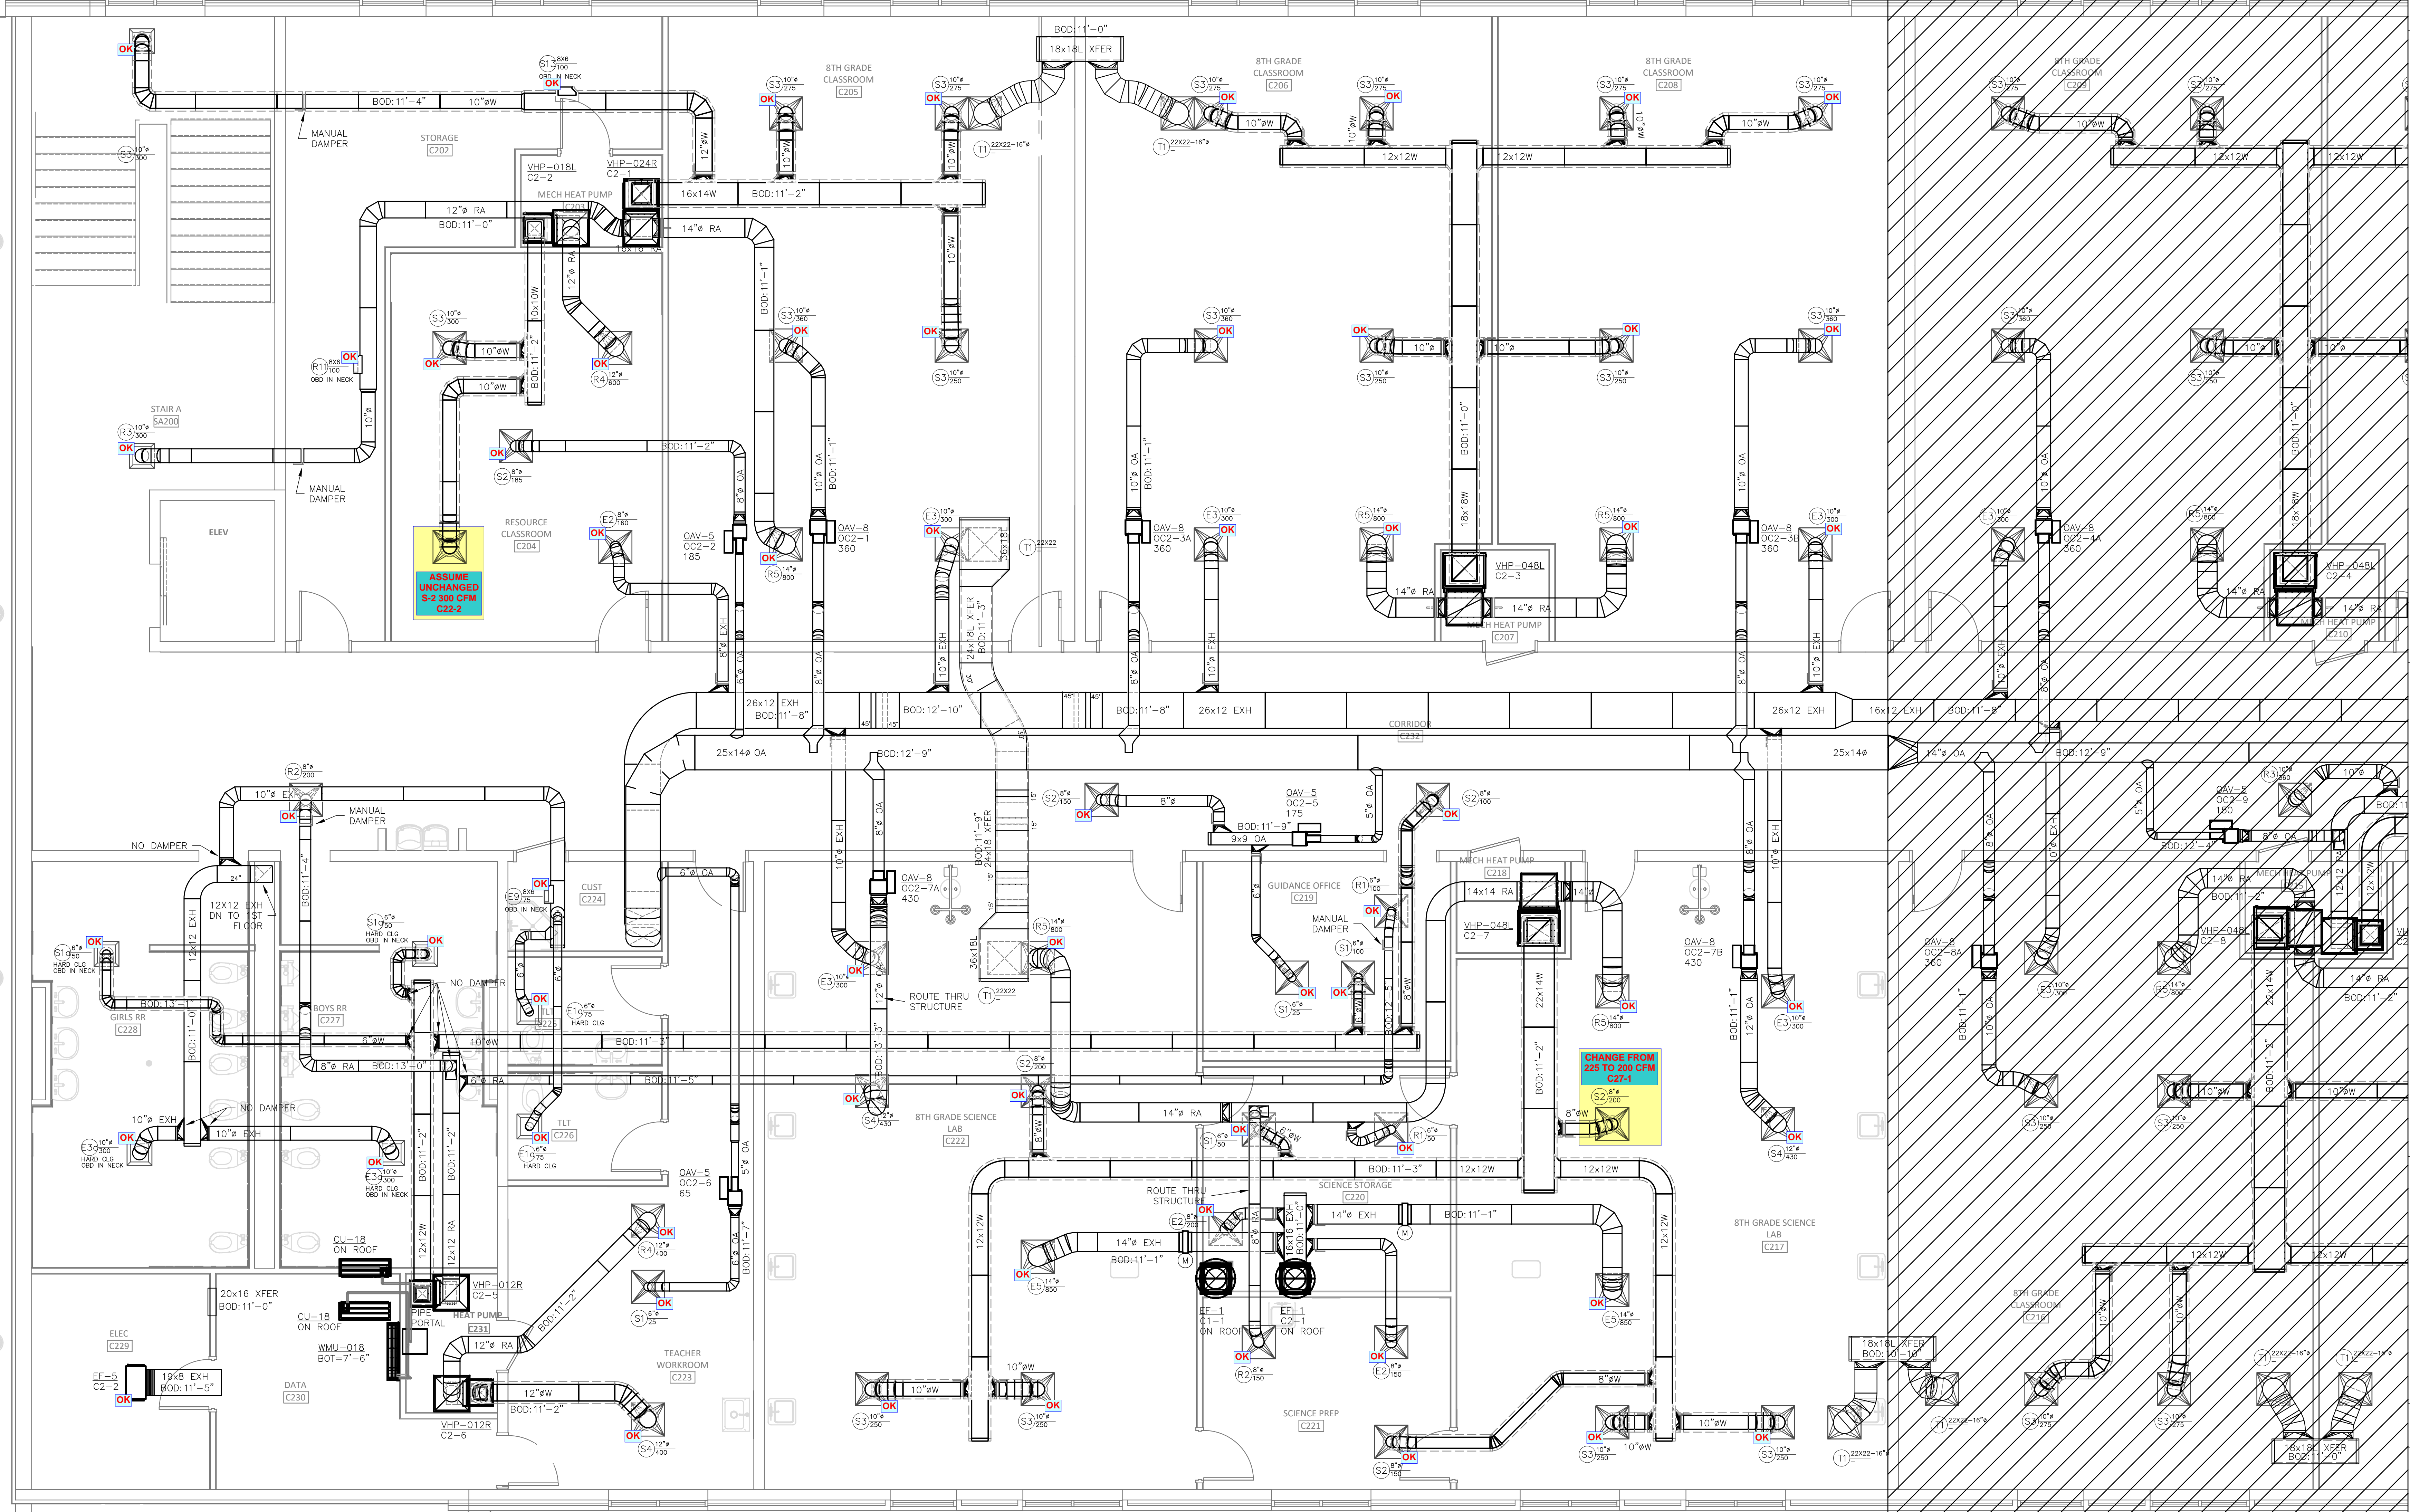


ASSUME UNCHANGED S-3 300 CFM C22-2

CHANGE FROM 225 TO 300 CFM C27-1



DUCTWORK FLOOR PLAN-AREA 2C
SCALE: 1/4"=1'-0"

SELMA BURKE MIDDLE SCHOOL
235 RINEHARDT ROAD
MOORESVILLE, NC 28115

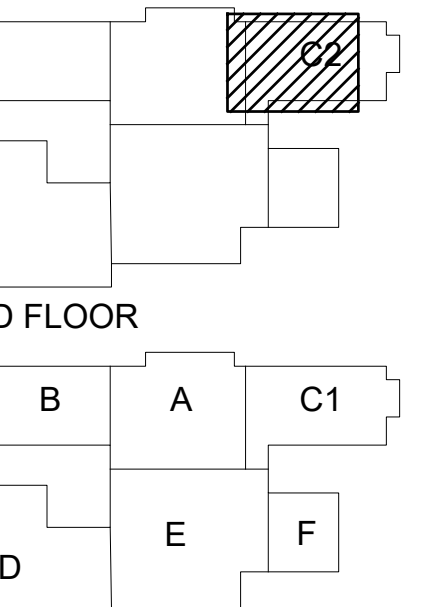


GENERAL CONTRACTOR: BARNHILL CONTRACTING
○ PRELIMINARY - NOT FOR CONSTRUCTION
○ FOR CONSTRUCTION
● SHOP DRAWINGS
○ AS-BUILT DRAWINGS

REVISIONS DATE
DRAWN BY: RJM
CHECKED BY: RJM
PROJECT: 22-693
DATE: 05/06/2022
SHEET: 16 OF: 17

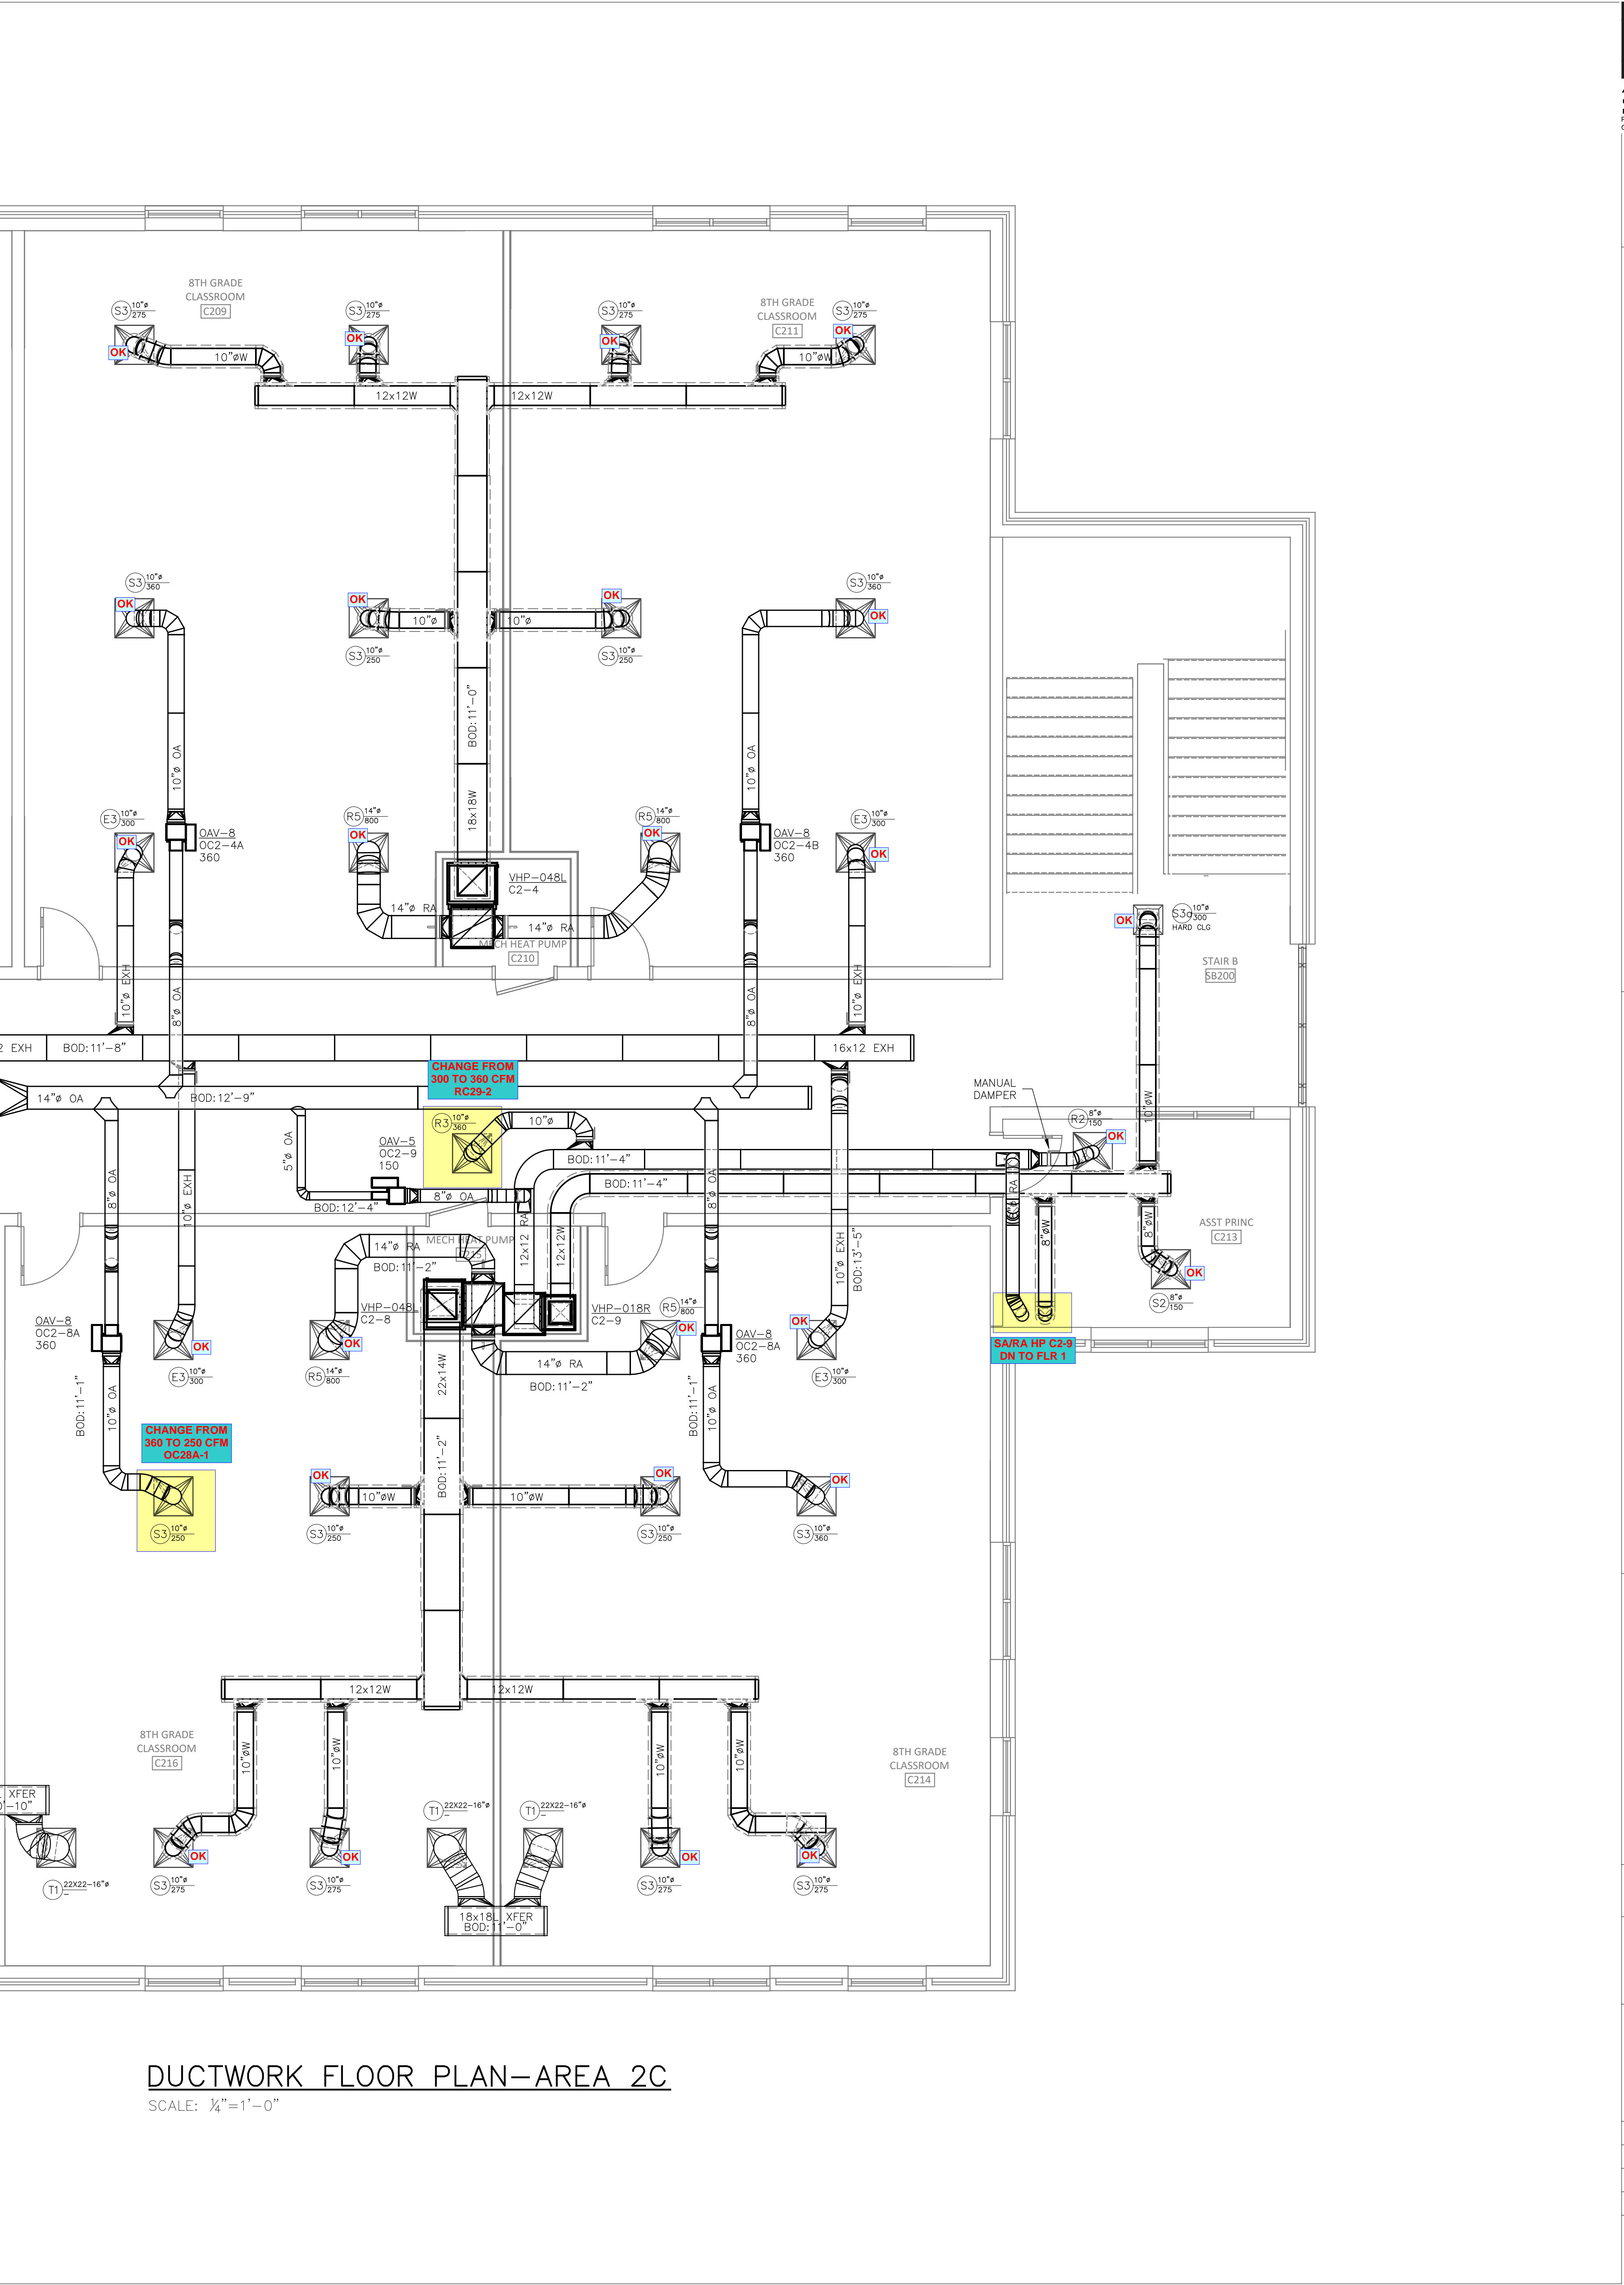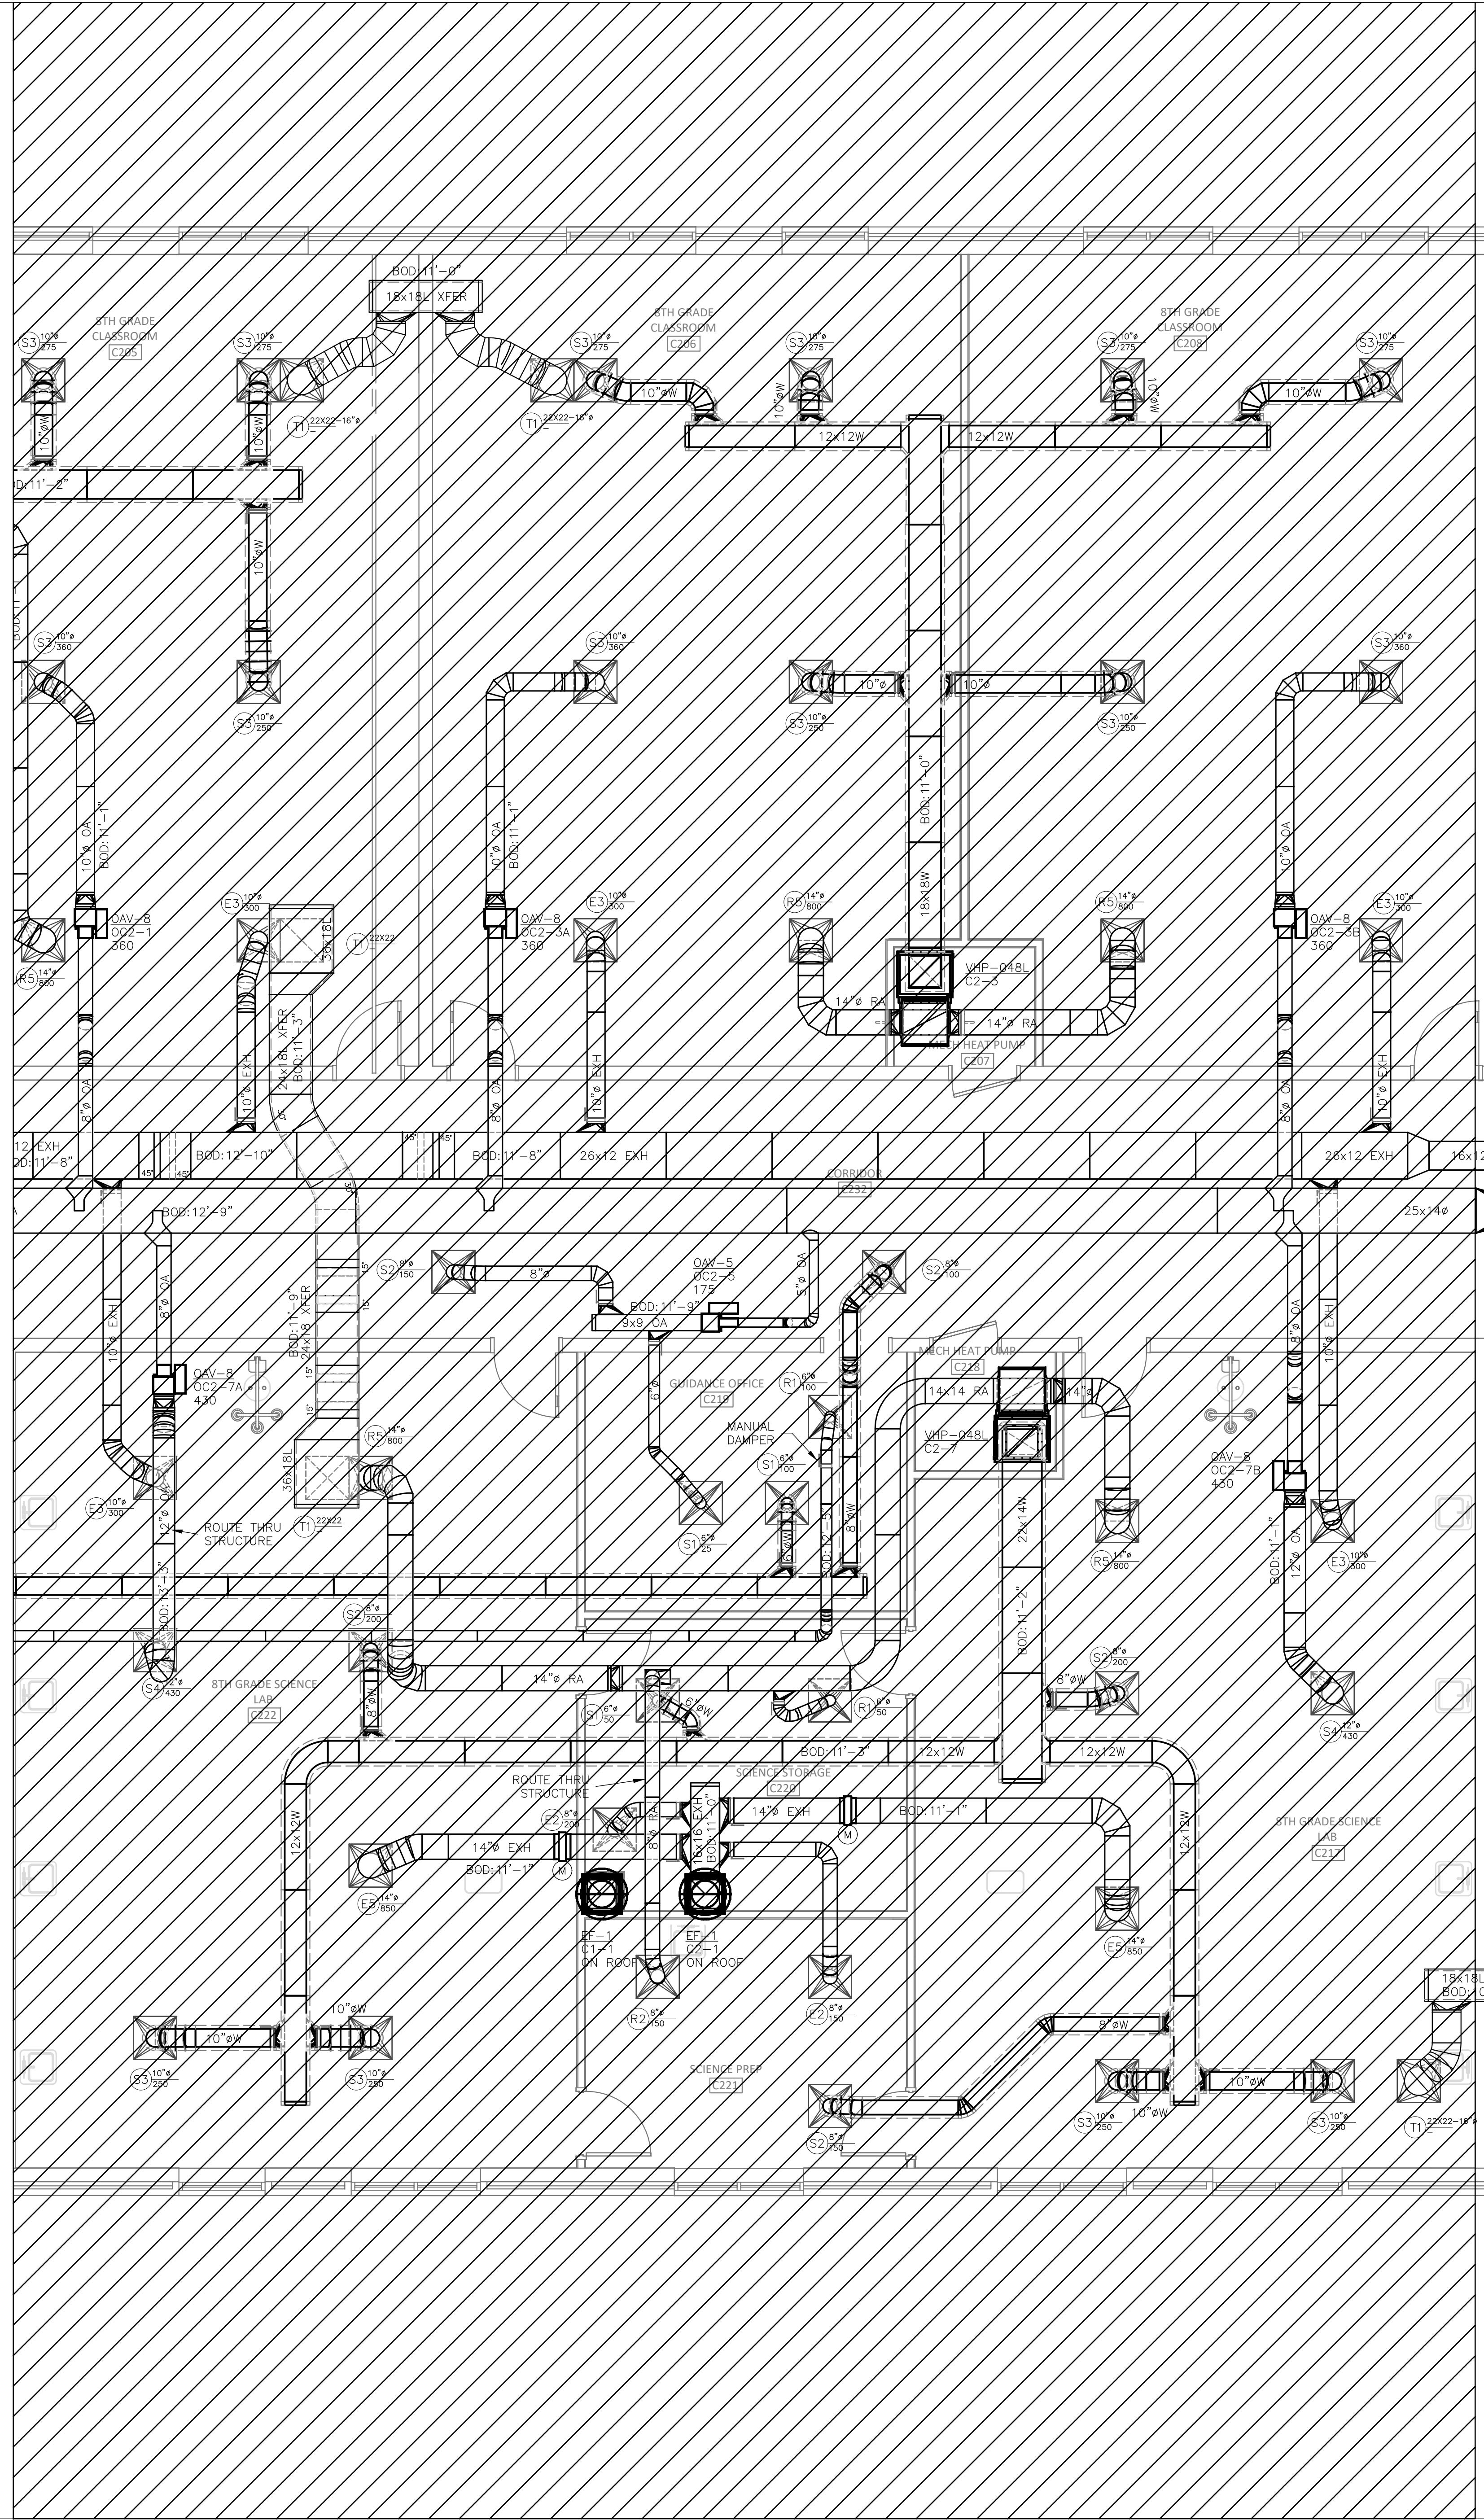

DUCTWORK FLOOR PLAN-AREA 2C
 SCALE: 1/4" = 1'-0"

**SELMA BURKE
 MIDDLE SCHOOL**
 235 RINEHARDT ROAD
 MOORESVILLE, NC 28115

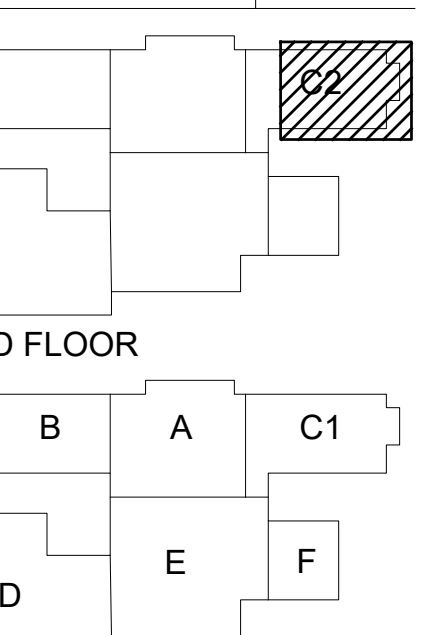

- 2ND FLOOR**
- 1ST FLOOR**
- GENERAL CONTRACTOR:
 BARNHILL CONTRACTING
- PRELIMINARY - NOT FOR CONSTRUCTION
 - FOR CONSTRUCTION
 - SHOP DRAWINGS
 - AS-BUILT DRAWINGS

REVISIONS	DATE

DRAWN BY: RJM
 CHECKED BY: RJM
 PROJECT: 22-693
 DATE: 05/06/2022
 SHEET: 17 OF: 17