


DUCTWORK FLOOR PLAN—OVERALL 1ST FLOOR
 SCALE: 1/8"=1'-0"

**SELMA BURKE
 MIDDLE SCHOOL**
 235 RINEHARDT ROAD
 MOORESVILLE, NC 28115

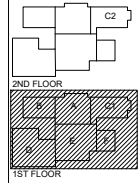


GENERAL CONTRACTOR: **BAWRELL CONTRACTING**

- PRELIMINARY - NOT FOR CONSTRUCTION
- ◐ FOR CONSTRUCTION
- SHOP DRAWINGS
- AS-BUILT DRAWINGS


REVISIONS	DATE

DRAWN BY: **RJM**
 CHECKED BY: **RJM**
 PROJECT: **22-693**
 DATE: **05/06/2022**
 SHEET: **0** OF: **17**

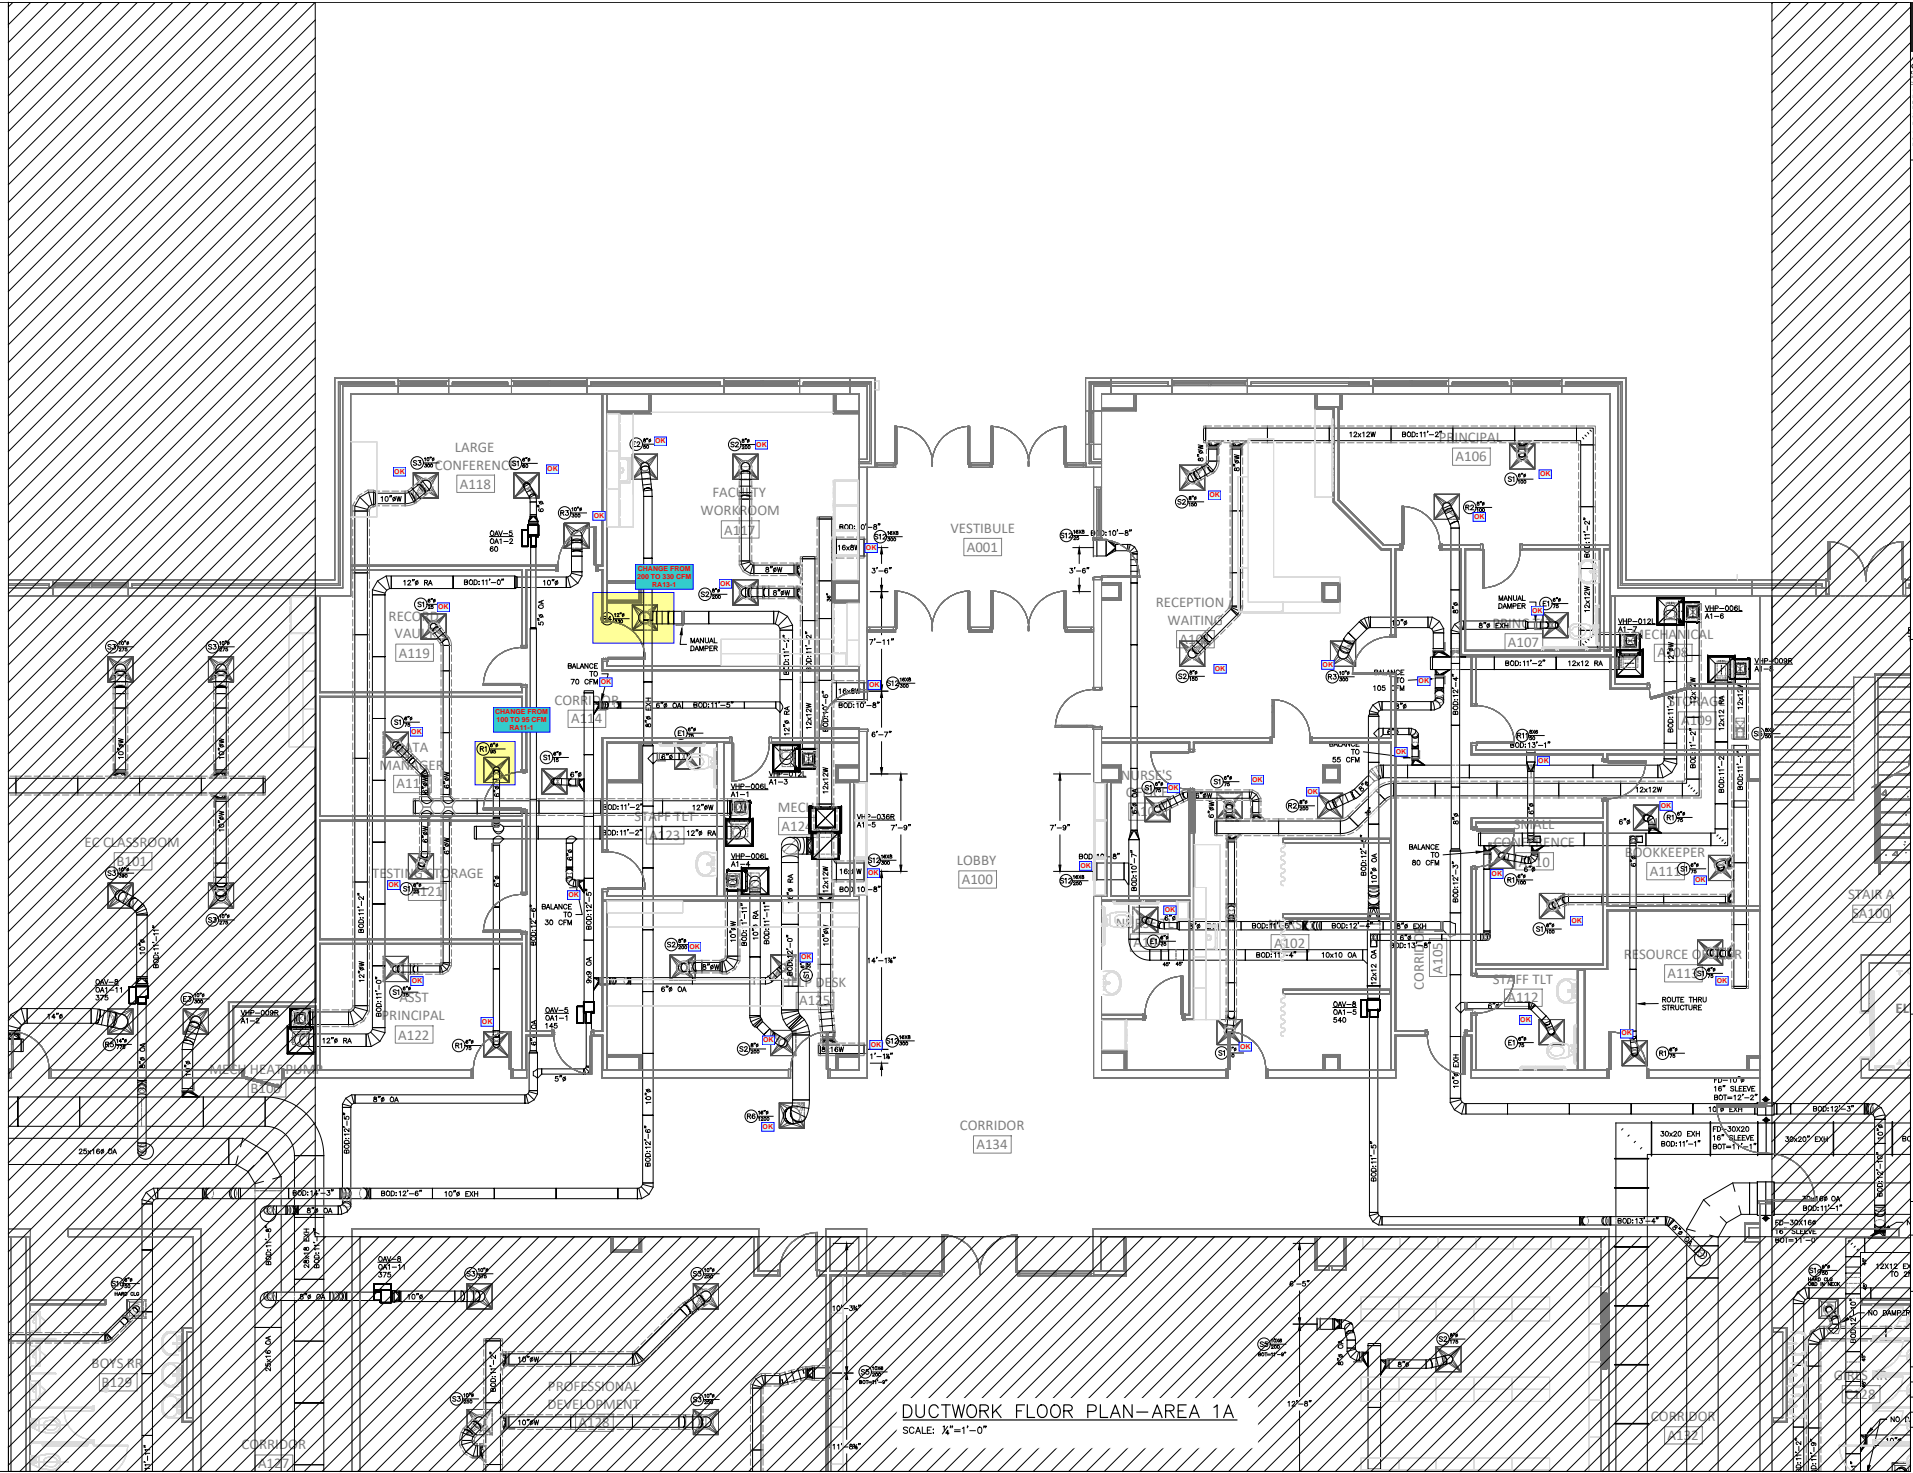

DUCTWORK FLOOR PLAN-AREA 1A
SCALE: 1/4"=1'-0"

 
**SELMA BURKE
MIDDLE SCHOOL**
235 RINEHARDT ROAD
MOORESVILLE, NC 28115




GENERAL CONTRACTOR: BARNHILL CONTRACTING
PRELIMINARY - NOT FOR CONSTRUCTION
FOR CONSTRUCTION
SHOP DRAWINGS
AS-BUILT DRAWINGS

REVISIONS: DATE


DRAWN BY: RJM
CHECKED BY: RJM
PROJECT: 22-693
DATE: 05/06/2022
SHEET: 1 OF 17

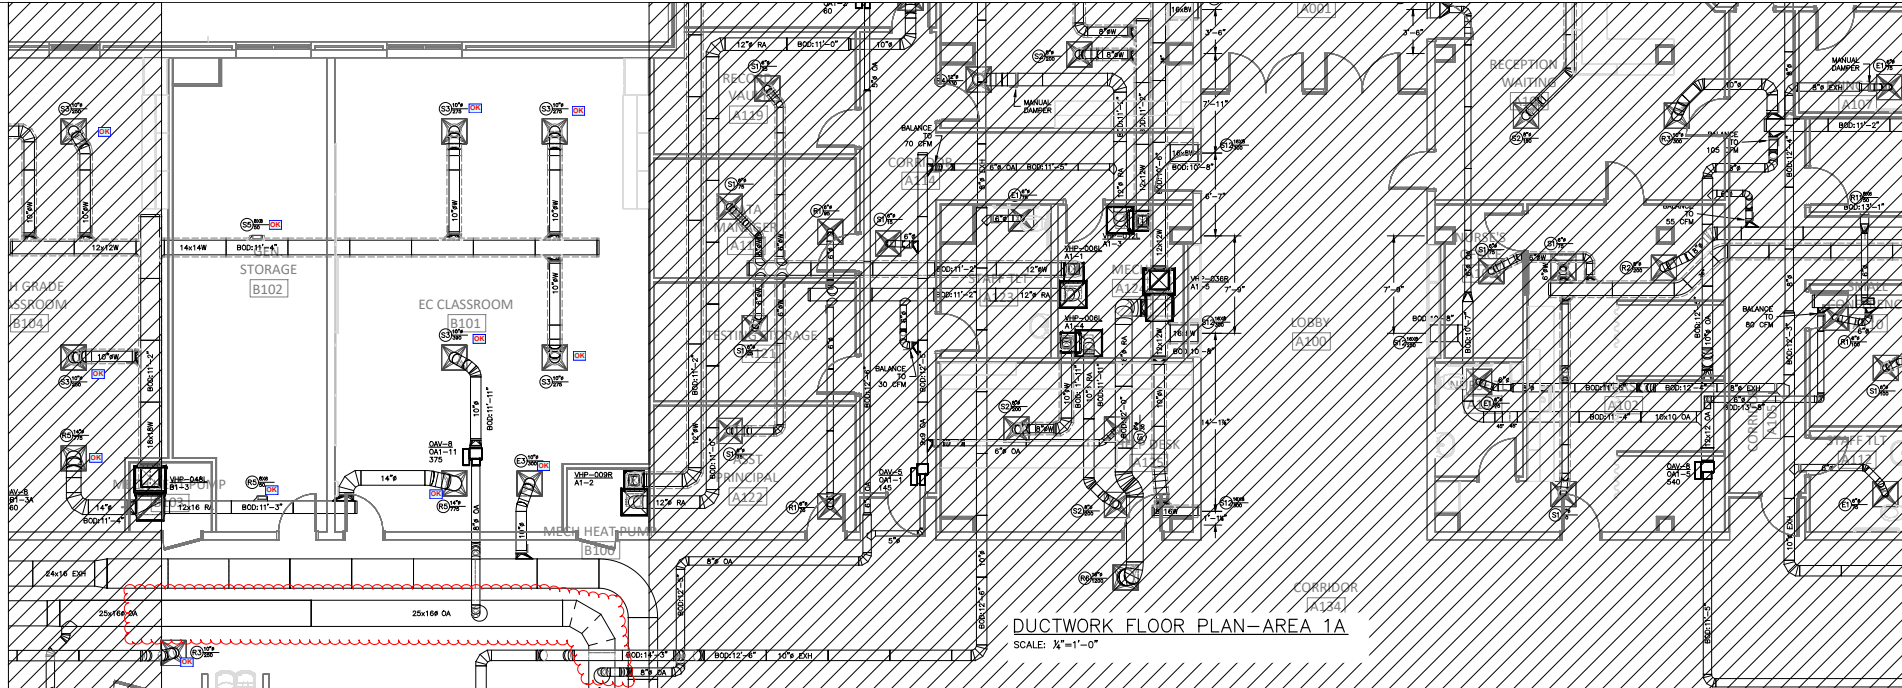

DUCTWORK FLOOR PLAN-AREA 1A
SCALE: 1/4"=1'-0"

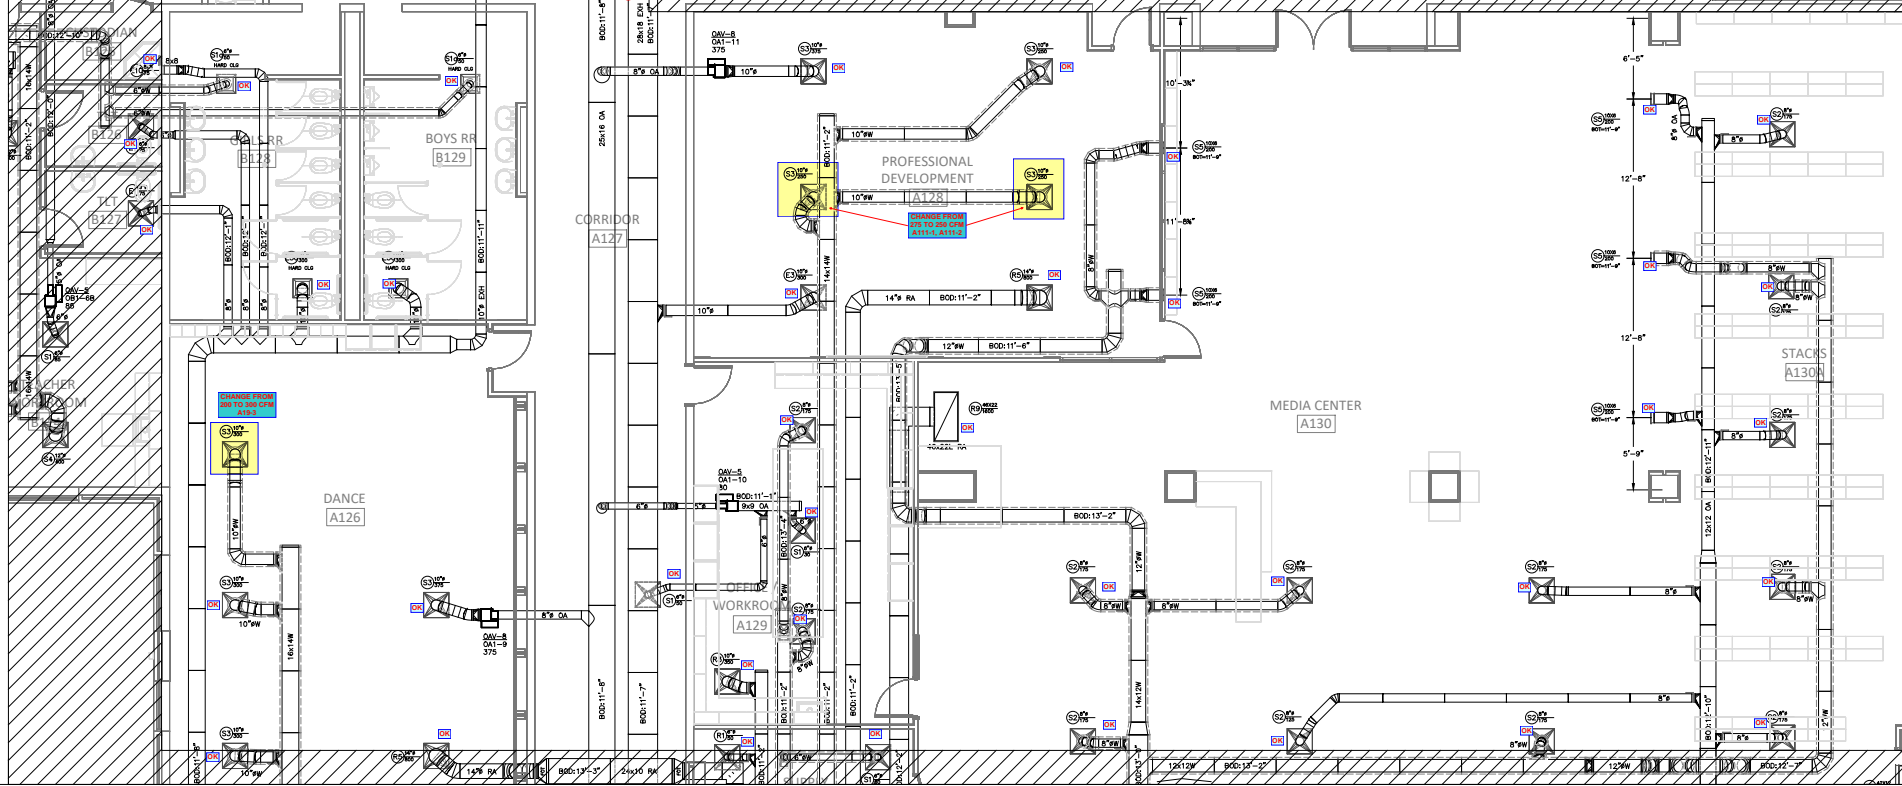

SELMA BURKE
MIDDLE SCHOOL
235 RINEHARDT ROAD
MOORESVILLE, NC 28115

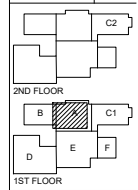


GENERAL CONTRACTOR: BARNHILL CONTRACTING
PRELIMINARY - NOT FOR CONSTRUCTION
FOR CONSTRUCTION
SHOP DRAWINGS
AS-BUILT DRAWINGS


REVISIONS DATE

NO.	DATE	DESCRIPTION


DRAWN BY: RJM
CHECKED BY: RJM
PROJECT: 22-693
DATE: 05/06/2022
SHEET: 2 OF: 17

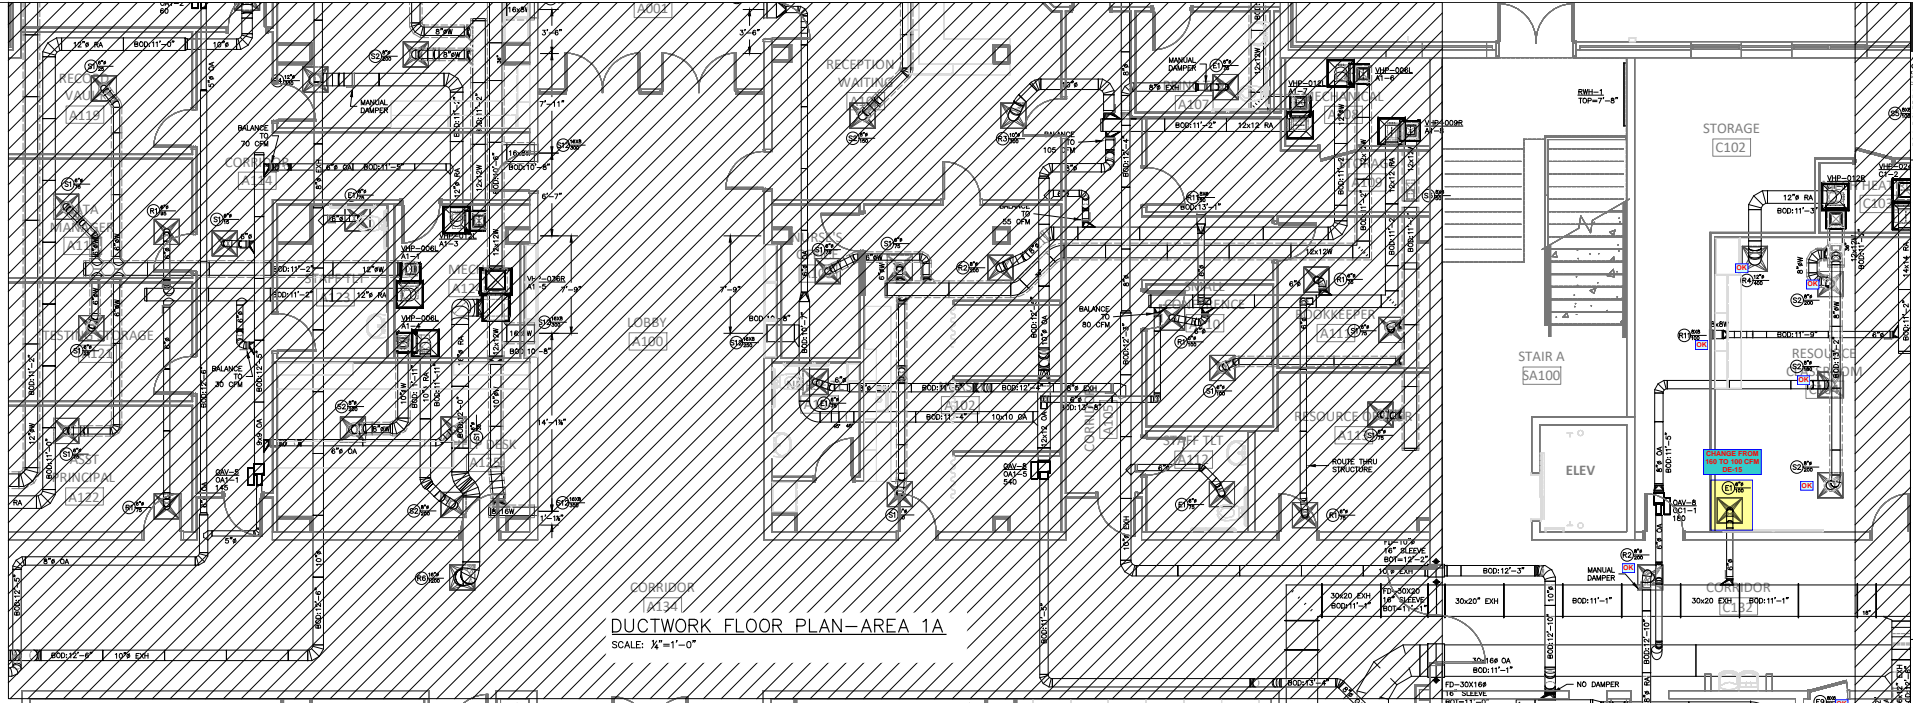

DUCTWORK FLOOR PLAN-AREA 1A
SCALE: 1/4"=1'-0"

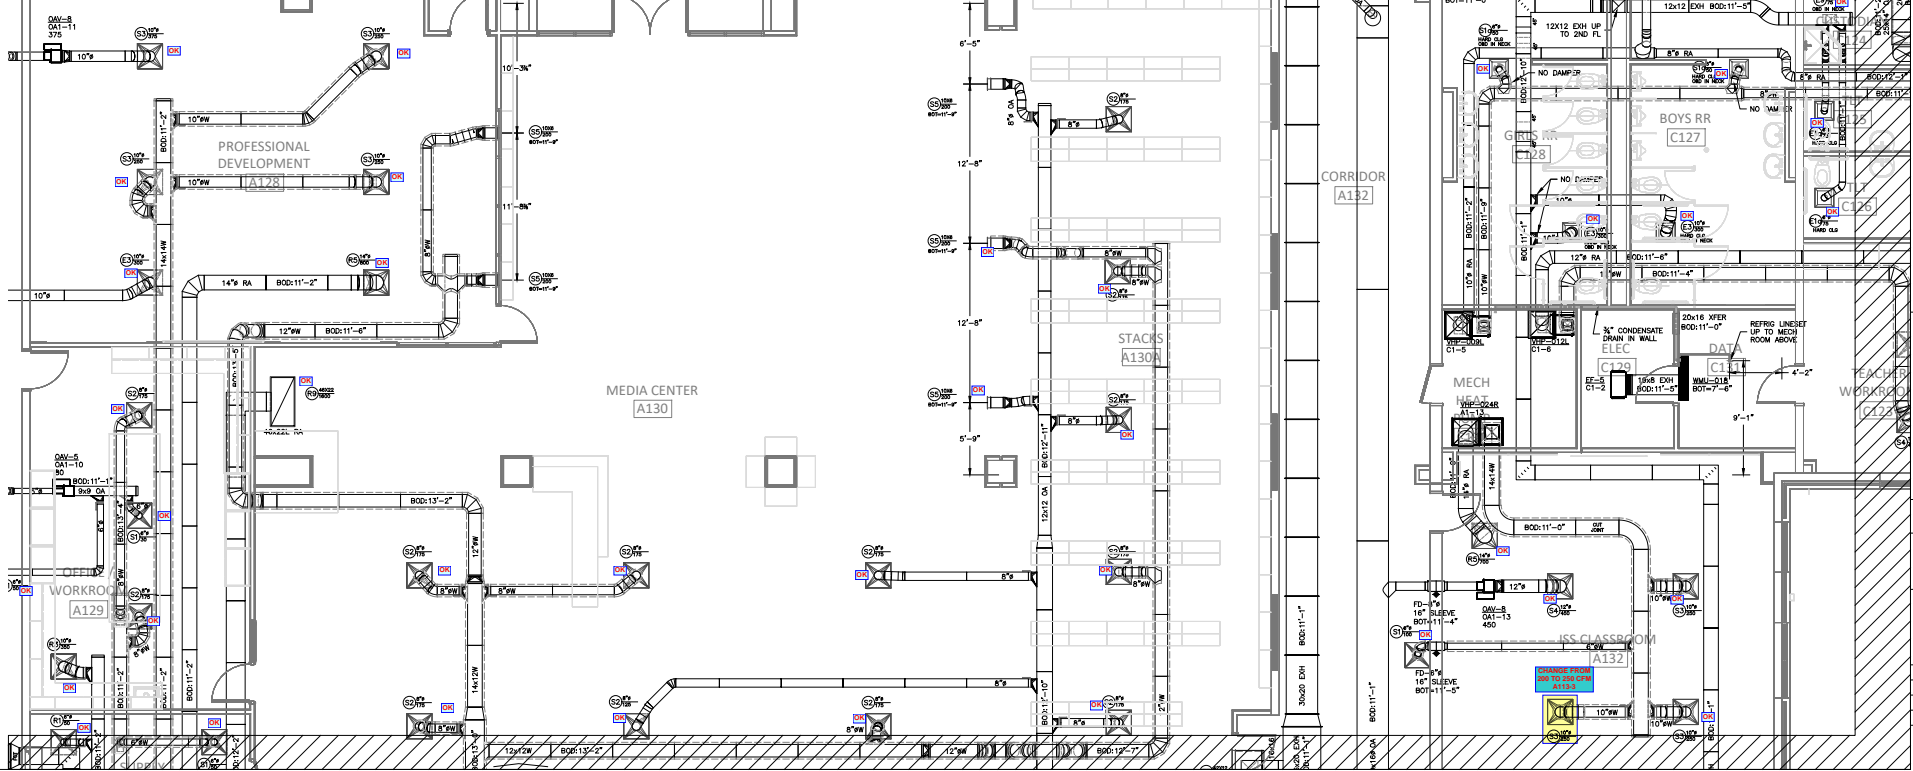

 **SELMA BURKE
MIDDLE SCHOOL**
235 RINEHARDT ROAD
MOORESVILLE, NC 28115




GENERAL CONTRACTOR: BARNHILL CONTRACTING
PRELIMINARY - NOT FOR CONSTRUCTION
FOR CONSTRUCTION
SHOP DRAWINGS
AS-BUILT DRAWINGS

REVISIONS


NO.	DATE	DESCRIPTION

DRAWN BY: RJM
CHECKED BY: RJM
PROJECT: 22-693
DATE: 05/06/2022
SHEET: 3 OF: 17

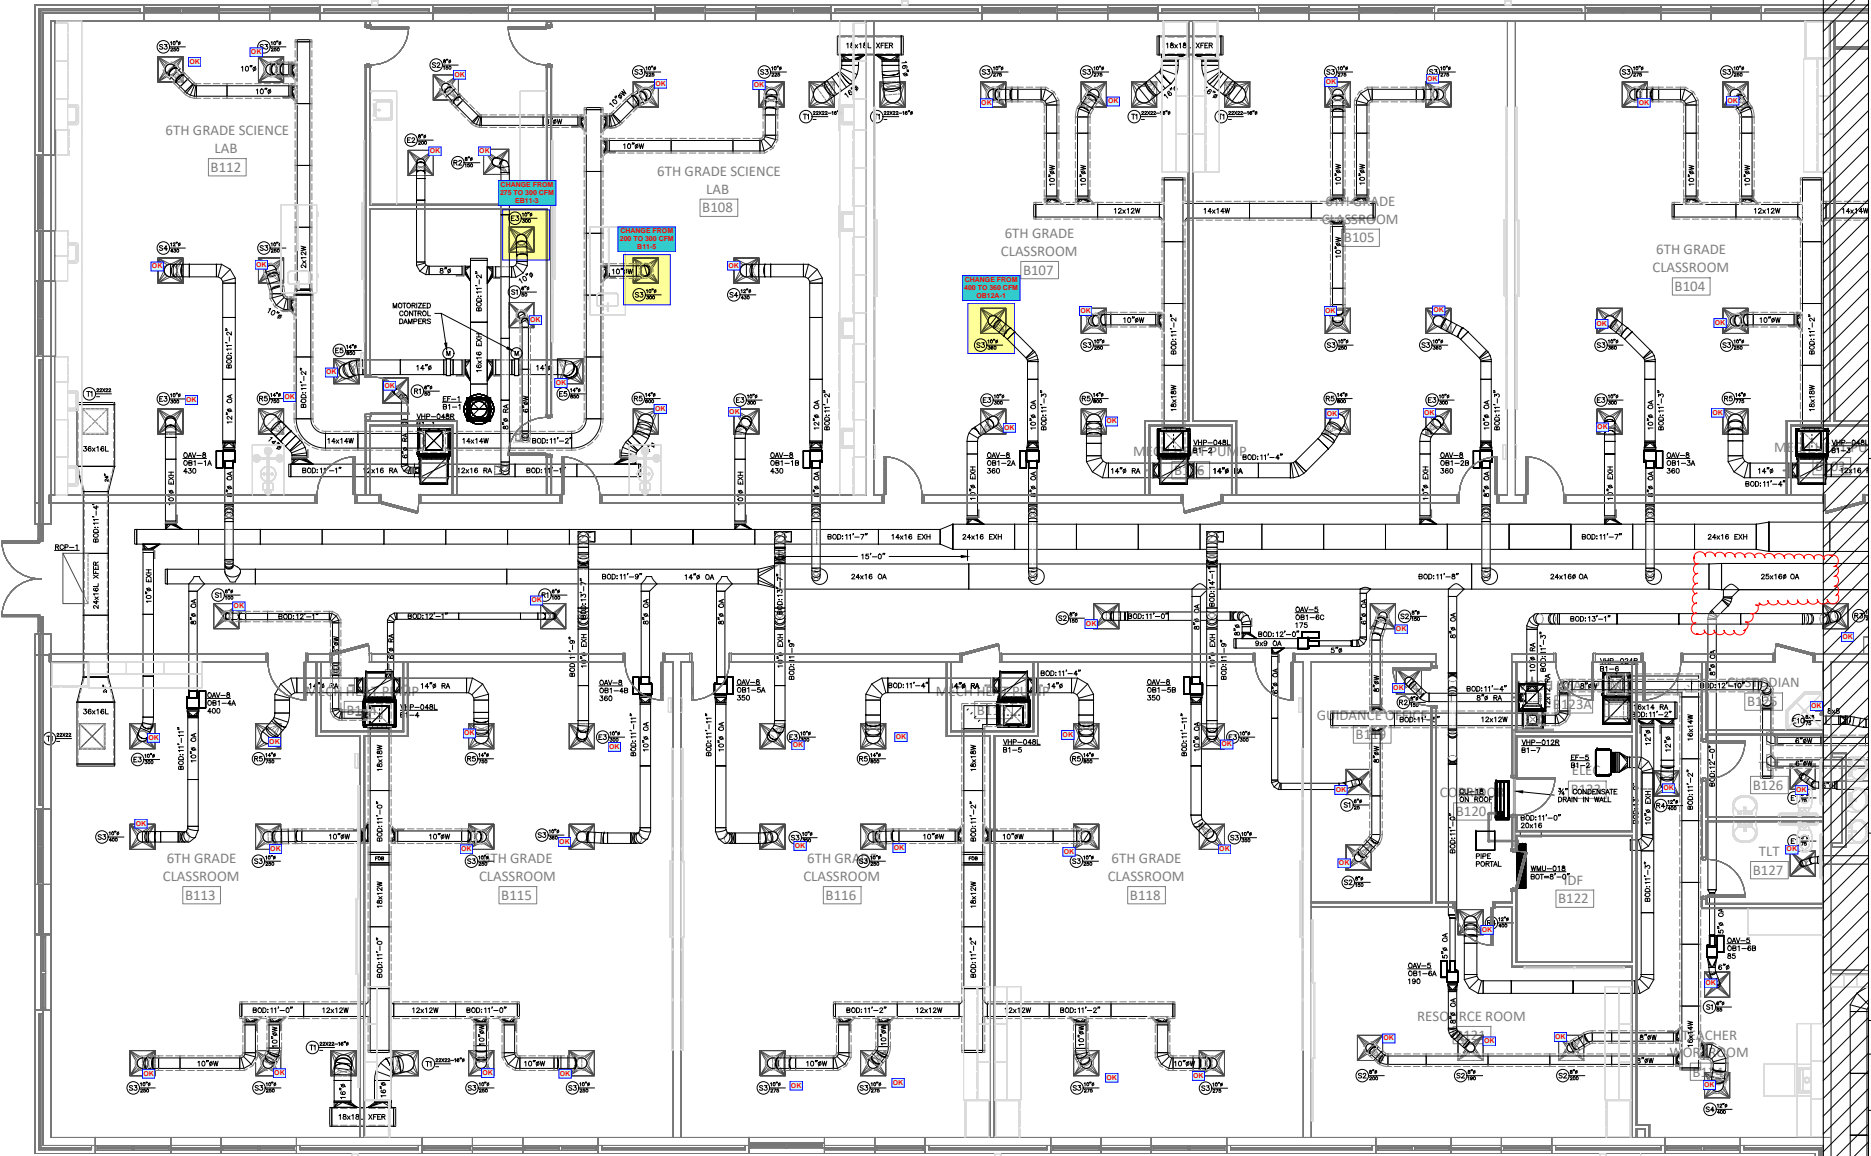


DUCTWORK FLOOR PLAN—AREA 1B
 SCALE: 1/4"=1'-0"

 **SELMA BURKE
 MIDDLE SCHOOL**
 235 RINEHARDT ROAD
 MOORESVILLE, NC 28115




GENERAL CONTRACTOR: BARNETT CONTRACTING
 PRELIMINARY - NOT FOR CONSTRUCTION
 FOR CONSTRUCTION: SHOP DRAWINGS
 AS-BUILT DRAWINGS

REVISIONS: DATE
 DRAWN BY: RJM
 CHECKED BY: RJM
 PROJECT: 22-693
 DATE: 05/06/2022
 SHEET: 4 OF 17

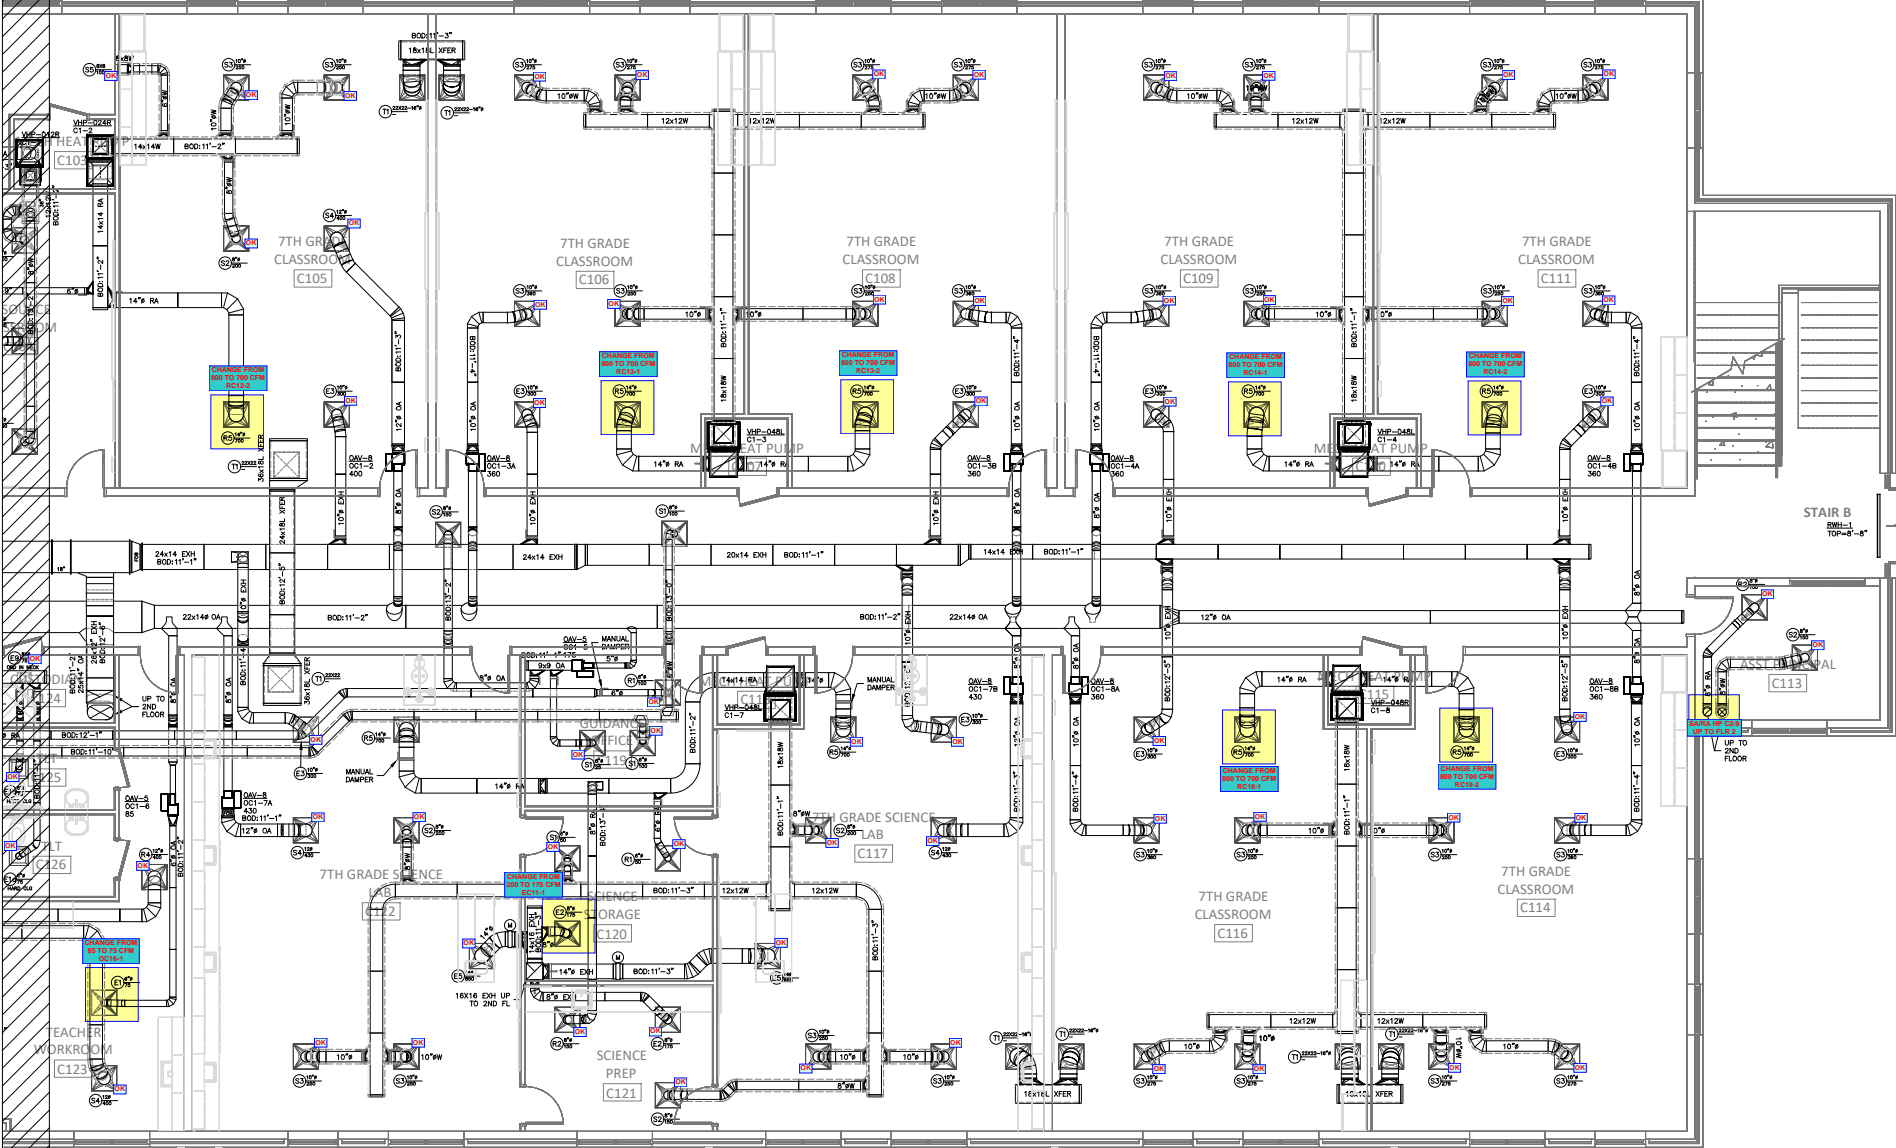

DUCTWORK FLOOR PLAN-AREA 1C
 SCALE: 1/8"=1'-0"

 **SELMA BURKE
 MIDDLE SCHOOL**
 235 RINEHART ROAD
 MOORESVILLE, NC 28115




GENERAL CONTRACTOR:
 BARNHILL CONTRACTING

PRELIMINARY - NOT FOR CONSTRUCTION
 FOR CONSTRUCTION
 SHOP DRAWINGS
 AS-BUILT DRAWINGS


REVISIONS DATE

DRAWN BY: RJM
 CHECKED BY: RJM
 PROJECT: 22-693
 DATE: 05/06/2022
 SHEET: 5 OF: 17

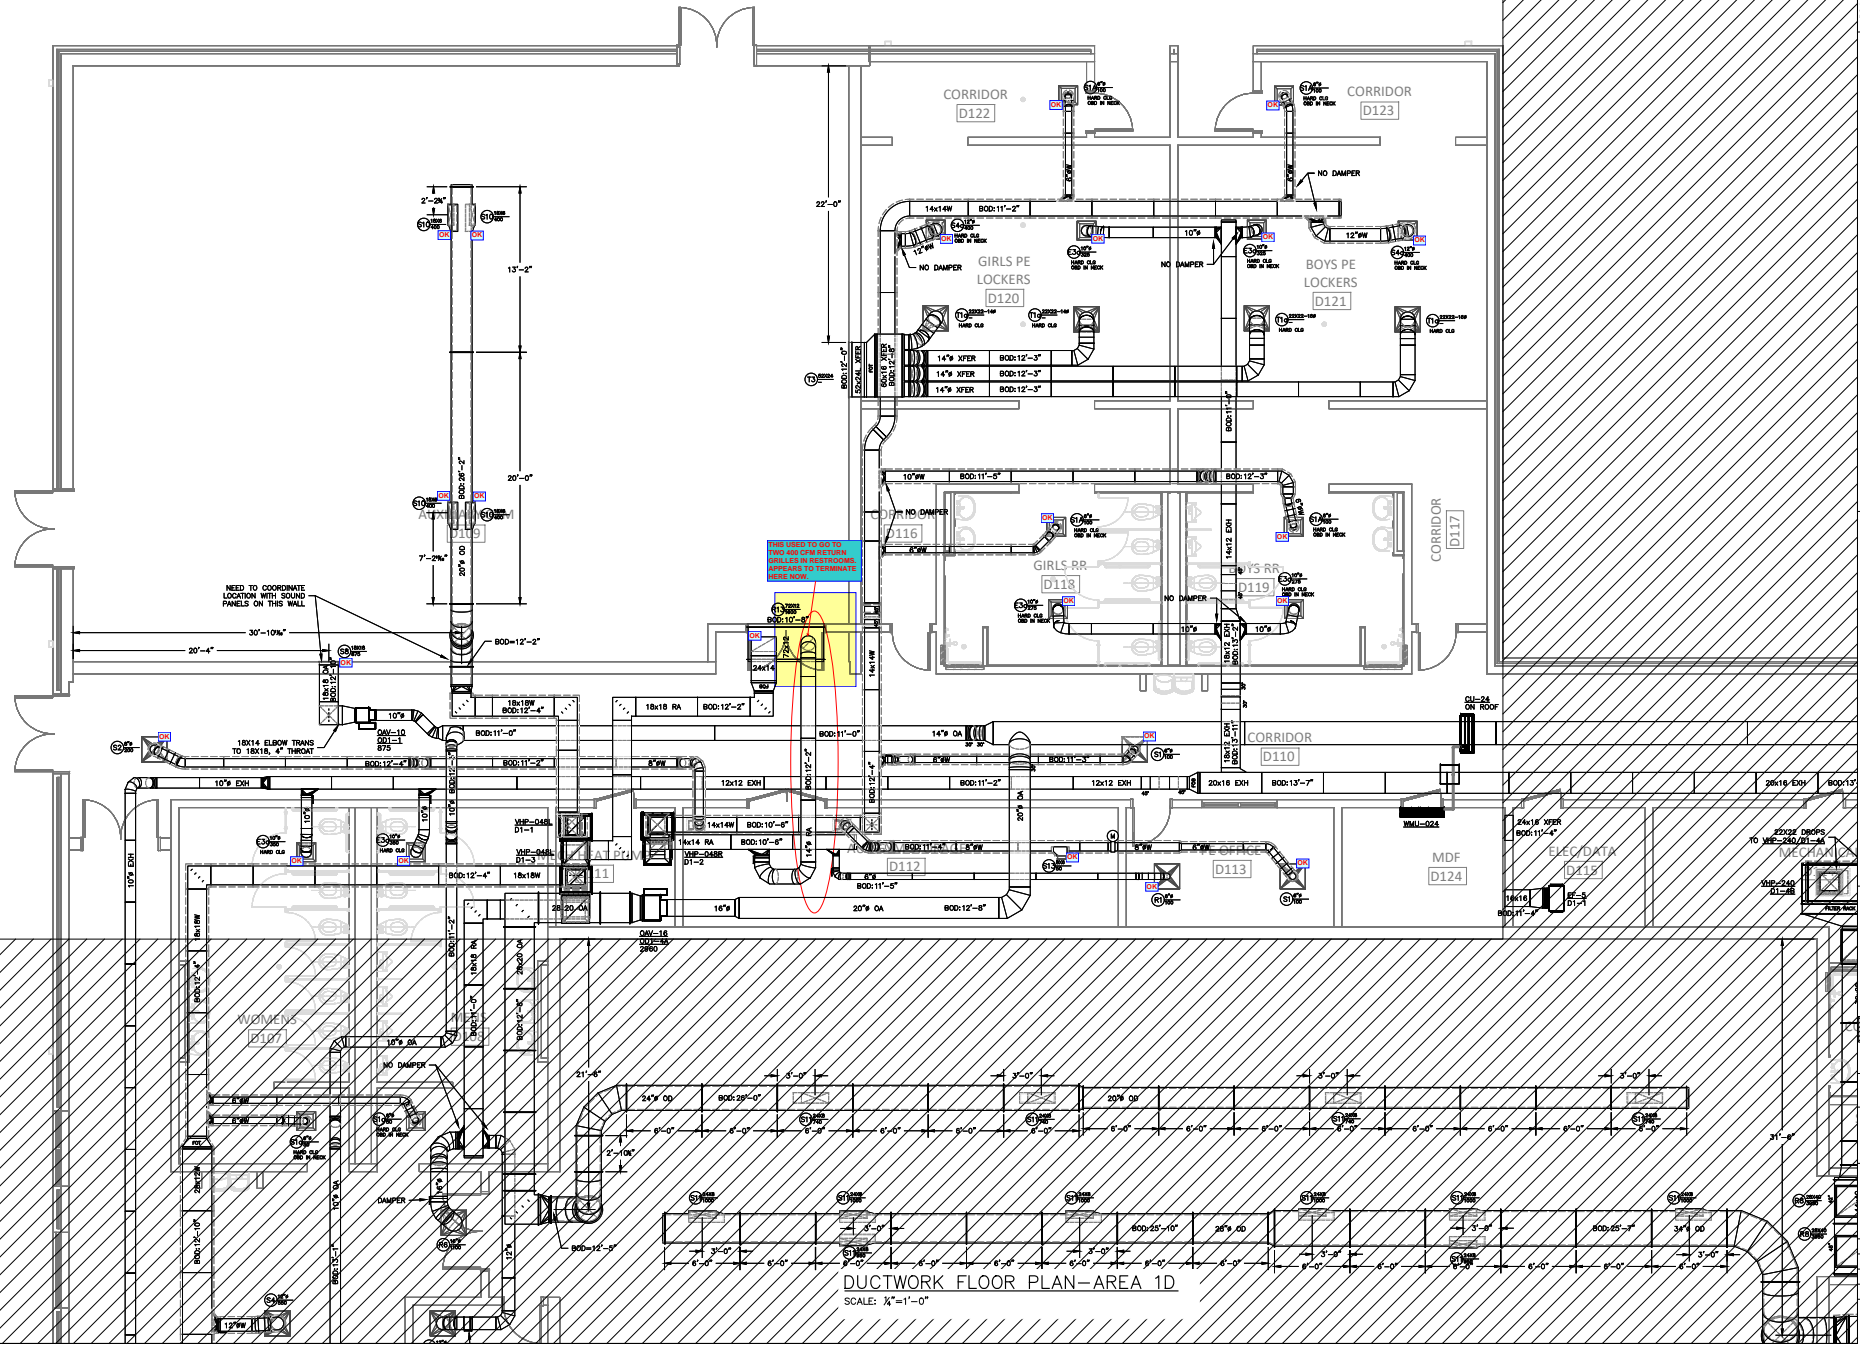

DUCTWORK FLOOR PLAN-AREA 1D
SCALE: 1/4"=1'-0"

 SELMA BURKE
MIDDLE SCHOOL
235 RINEHARDT ROAD
MOORESVILLE, NC 28115




- 2ND FLOOR
- 1ST FLOOR
- GENERAL CONTRACTOR: BARNETT CONTRACTING
- PRELIMINARY - NOT FOR CONSTRUCTION
- FOR CONSTRUCTION
- SHOP DRAWINGS
- AS-BUILT DRAWINGS


REVISIONS DATE

DRAWN BY:	RJM
CHECKED BY:	RJM
PROJECT:	22-693
DATE:	05/06/2022
SHEET:	6 OF 17

ACTION MECHANICAL CONTRACTORS, INC.
 1000 W. HARRIS STREET, SUITE 100
 RALEIGH, NC 27601
 (919) 871-1111
 www.actionmechanical.com

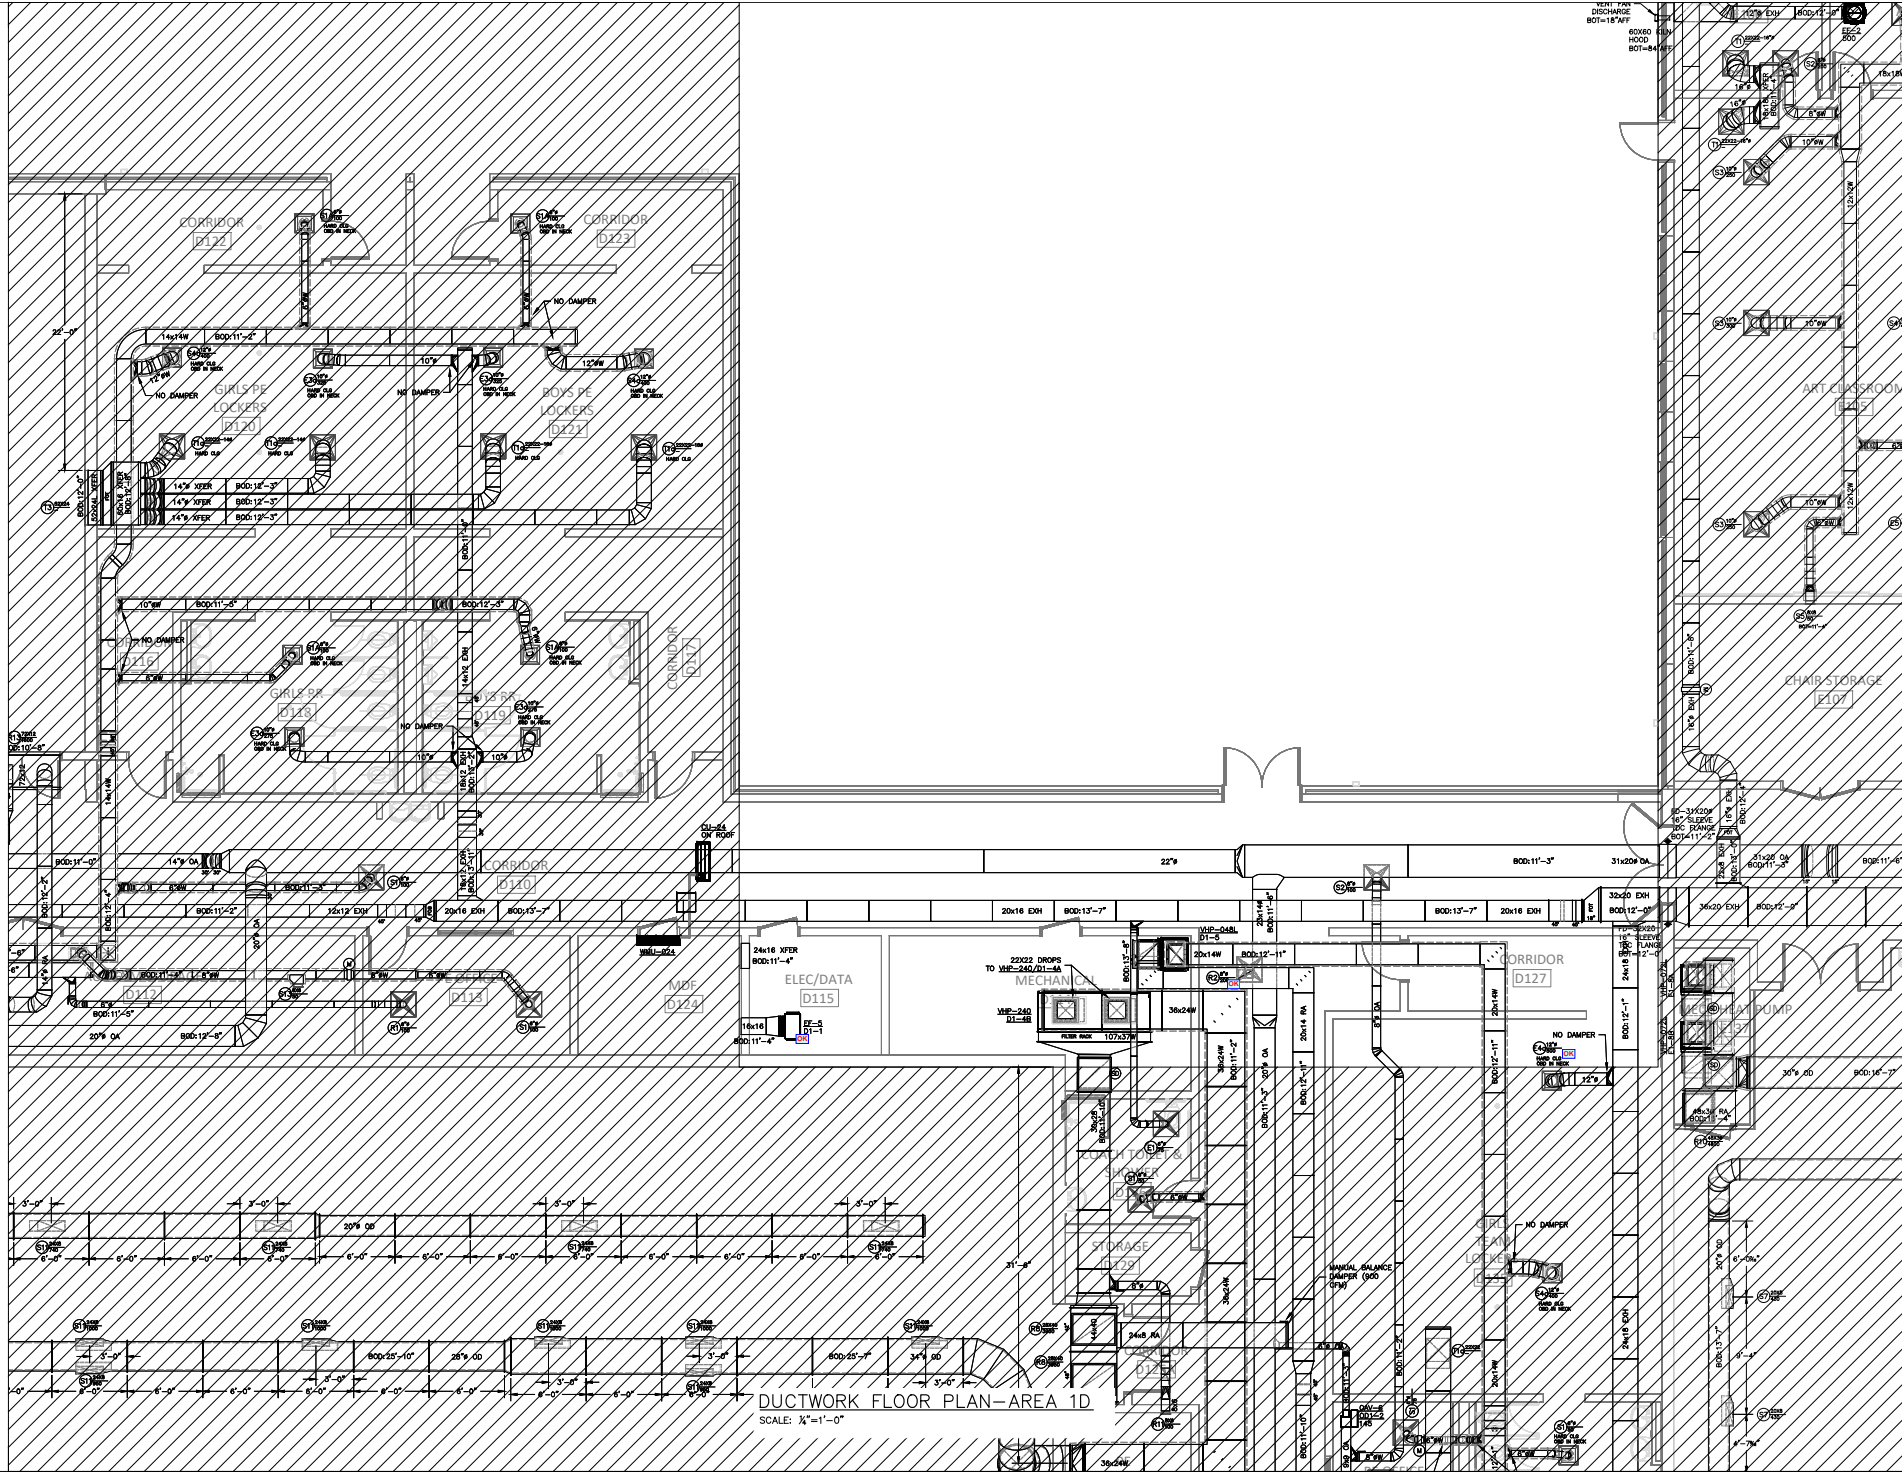

**SELMA BURKE
 MIDDLE SCHOOL**
 235 RINEHARDT ROAD
 MOORESVILLE, NC 28115

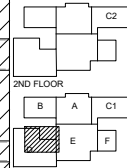


2ND FLOOR
 GENERAL CONTRACTOR: BARNELL CONTRACTING
 ○ PRELIMINARY - NOT FOR CONSTRUCTION
 ● FOR CONSTRUCTION
 ● SHOP DRAWINGS
 ○ AS-BUILT DRAWINGS


REVISIONS DATE

DRAWN BY: RJM
 CHECKED BY: RJM
 PROJECT: 22-693
 DATE: 05/06/2022
 SHEET: 7 OF: 17

DUCTWORK FLOOR PLAN-AREA 1D
 SCALE: 1/4"=1'-0"

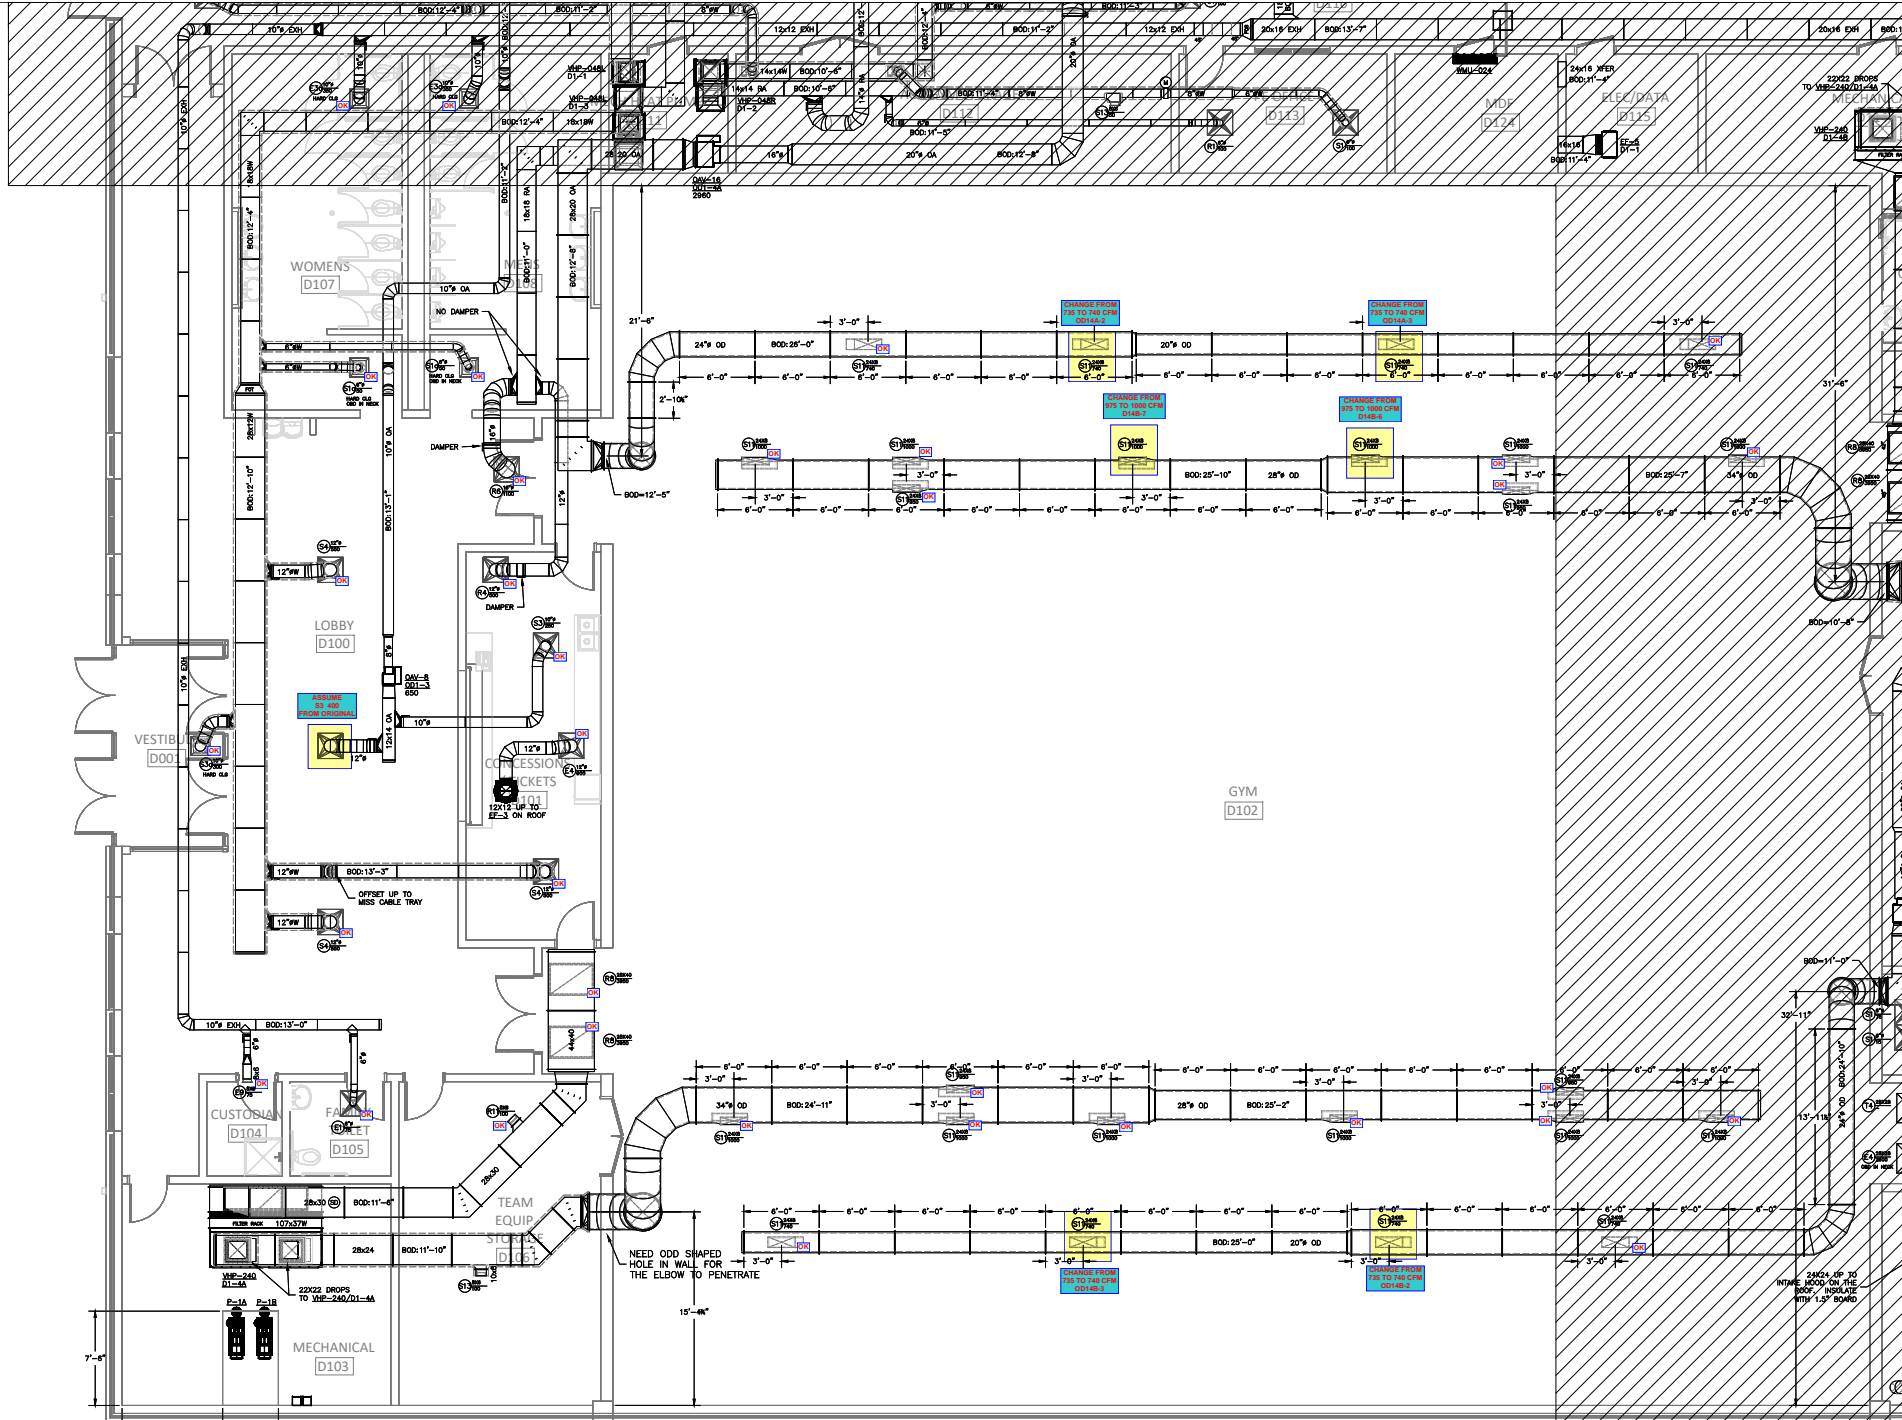

**SELMA BURKE
MIDDLE SCHOOL**
235 RINEHARDT ROAD
MOORESVILLE, NC 28115

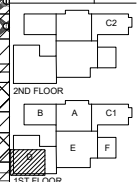


GENERAL CONTRACTOR: BARNELL CONTRACTING
PRELIMINARY - NOT FOR CONSTRUCTION
FOR CONSTRUCTION
SHOP DRAWINGS
AS-BUILT DRAWINGS

REVISIONS	DATE


DRAWN BY: RJM
CHECKED BY: RJM
PROJECT: 22-693
DATE: 05/06/2022
SHEET: 8 OF: 17

DUCTWORK FLOOR PLAN-AREA 1D
SCALE: 1/4"=1'-0"

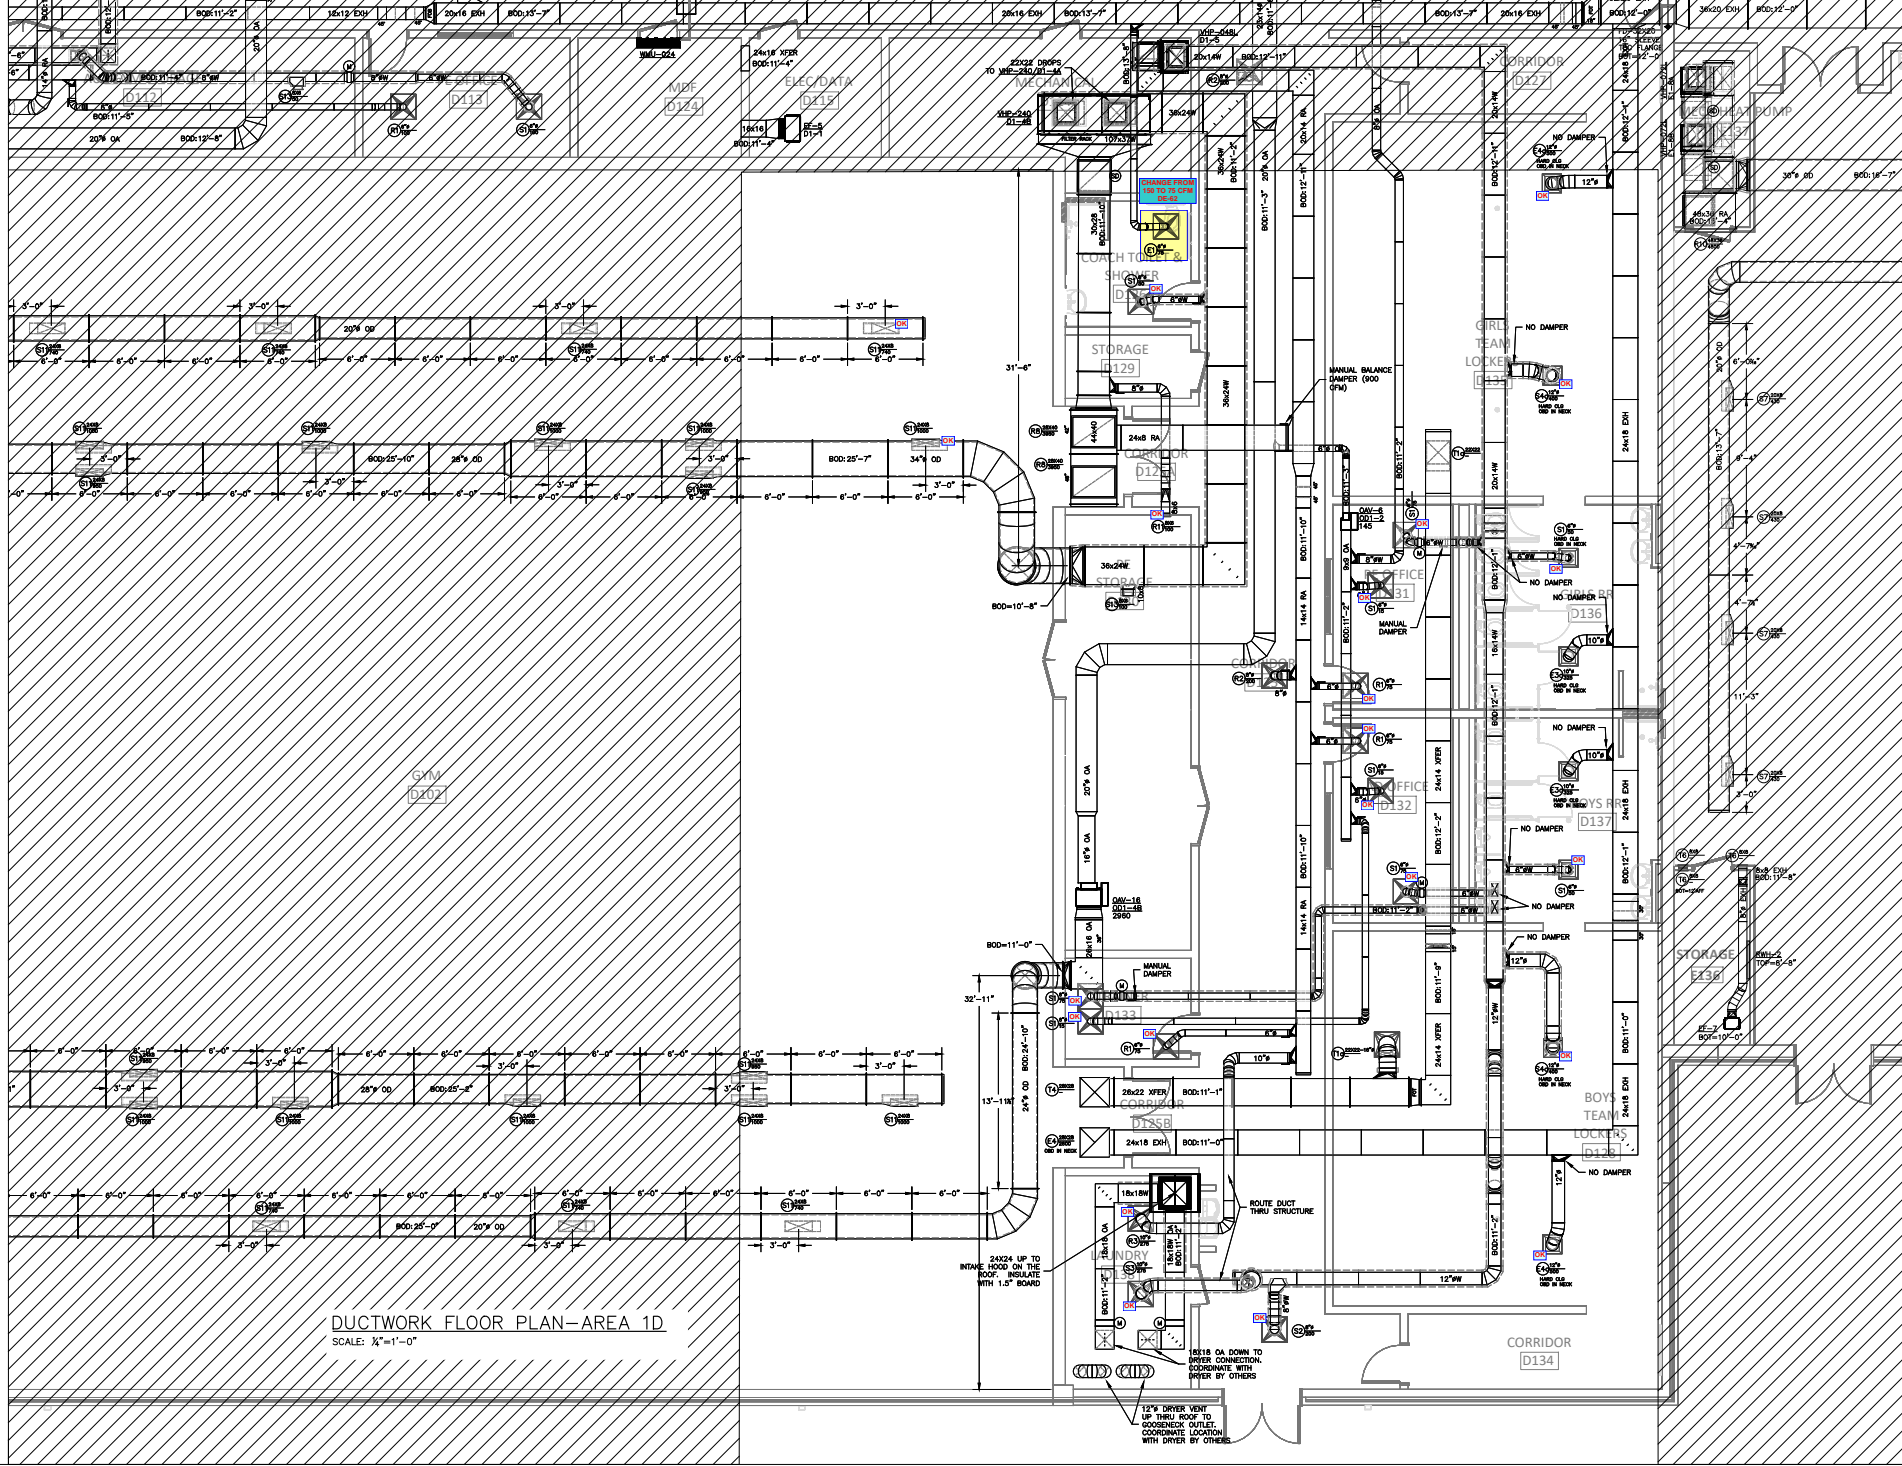

DUCTWORK FLOOR PLAN-AREA 1D
SCALE: 1/2"=1'-0"

**SELMA BURKE
MIDDLE SCHOOL**
235 RINEHARDT ROAD
MOORESVILLE, NC 28115

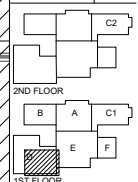


GENERAL CONTRACTOR: BARNELL CONTRACTING
PRELIMINARY - NOT FOR CONSTRUCTION
FOR CONSTRUCTION
SHOP DRAWINGS
AS-BUILT DRAWINGS

REVISIONS

NO.	DATE	DESCRIPTION


DRAWN BY: RJM
CHECKED BY: RJM
PROJECT: 22-693
DATE: 05/06/2022
SHEET: 9 OF: 17

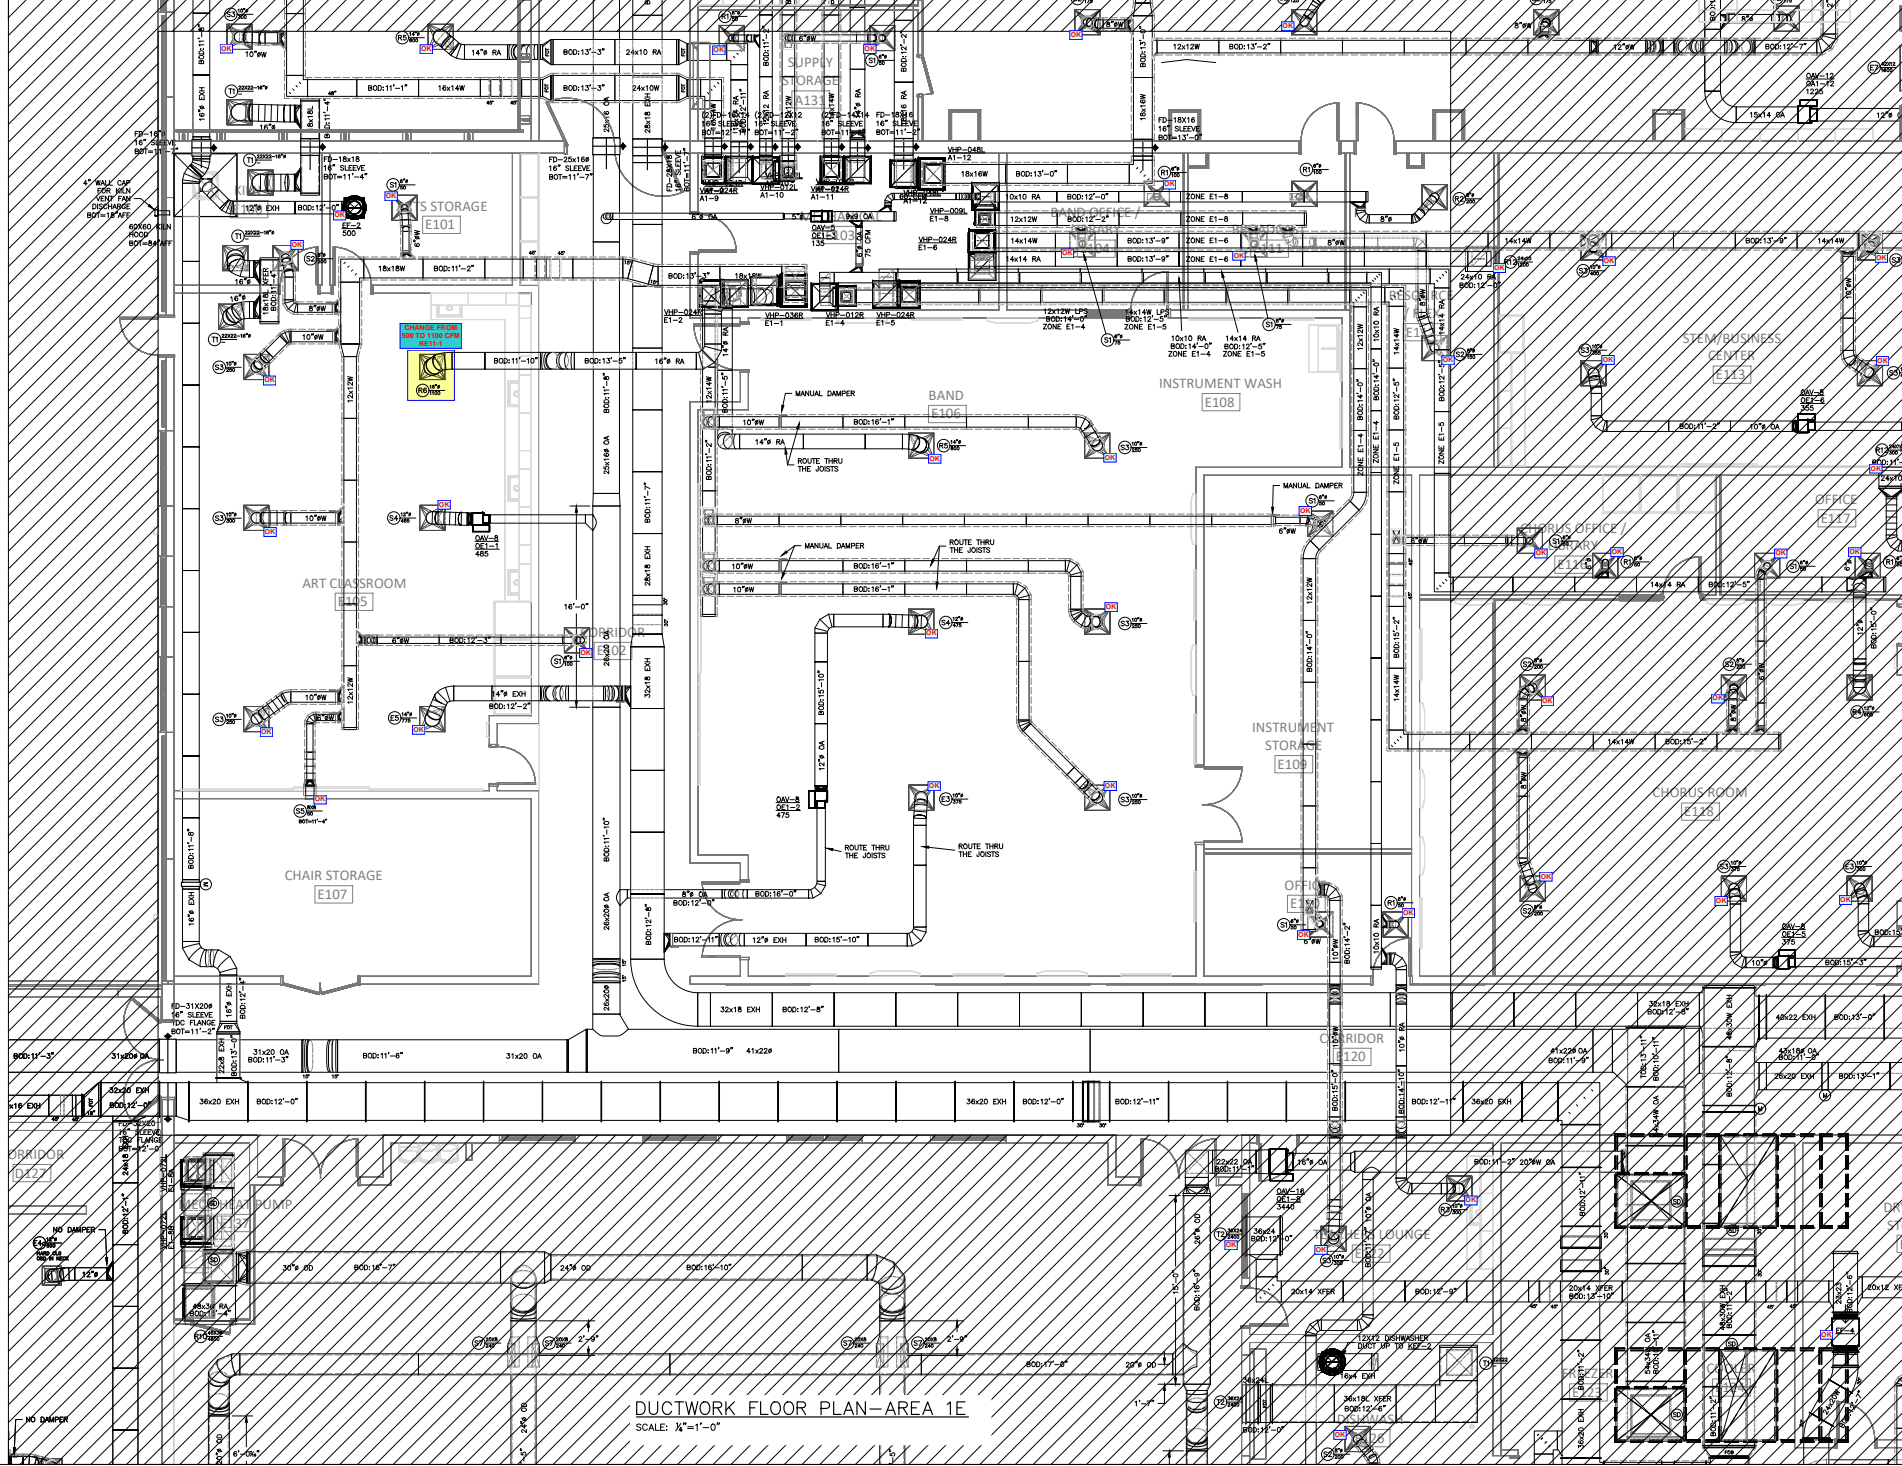

DUCTWORK FLOOR PLAN-AREA 1E
SCALE: 1/4"=1'-0"


STEM/BUSINESS CENTER (E103)
OFFICE (E104)
OFFICE (E107)
OFFICE (E108)
OFFICE (E109)
OFFICE (E200)

SELMA BURKE
MIDDLE SCHOOL
235 RINEHARDT ROAD
MOORESVILLE, NC 28115

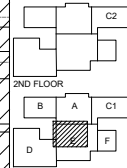


1ST FLOOR
GENERAL CONTRACTOR: BARNHILL CONTRACTING
PRELIMINARY - NOT FOR CONSTRUCTION
FOR CONSTRUCTION
SHOP DRAWINGS
AS-BUILT DRAWINGS

REVISIONS DATE
DRAWN BY: RJM
CHECKED BY: RJM
PROJECT: 22-693
DATE: 05/06/2022
SHEET: 10 OF: 17

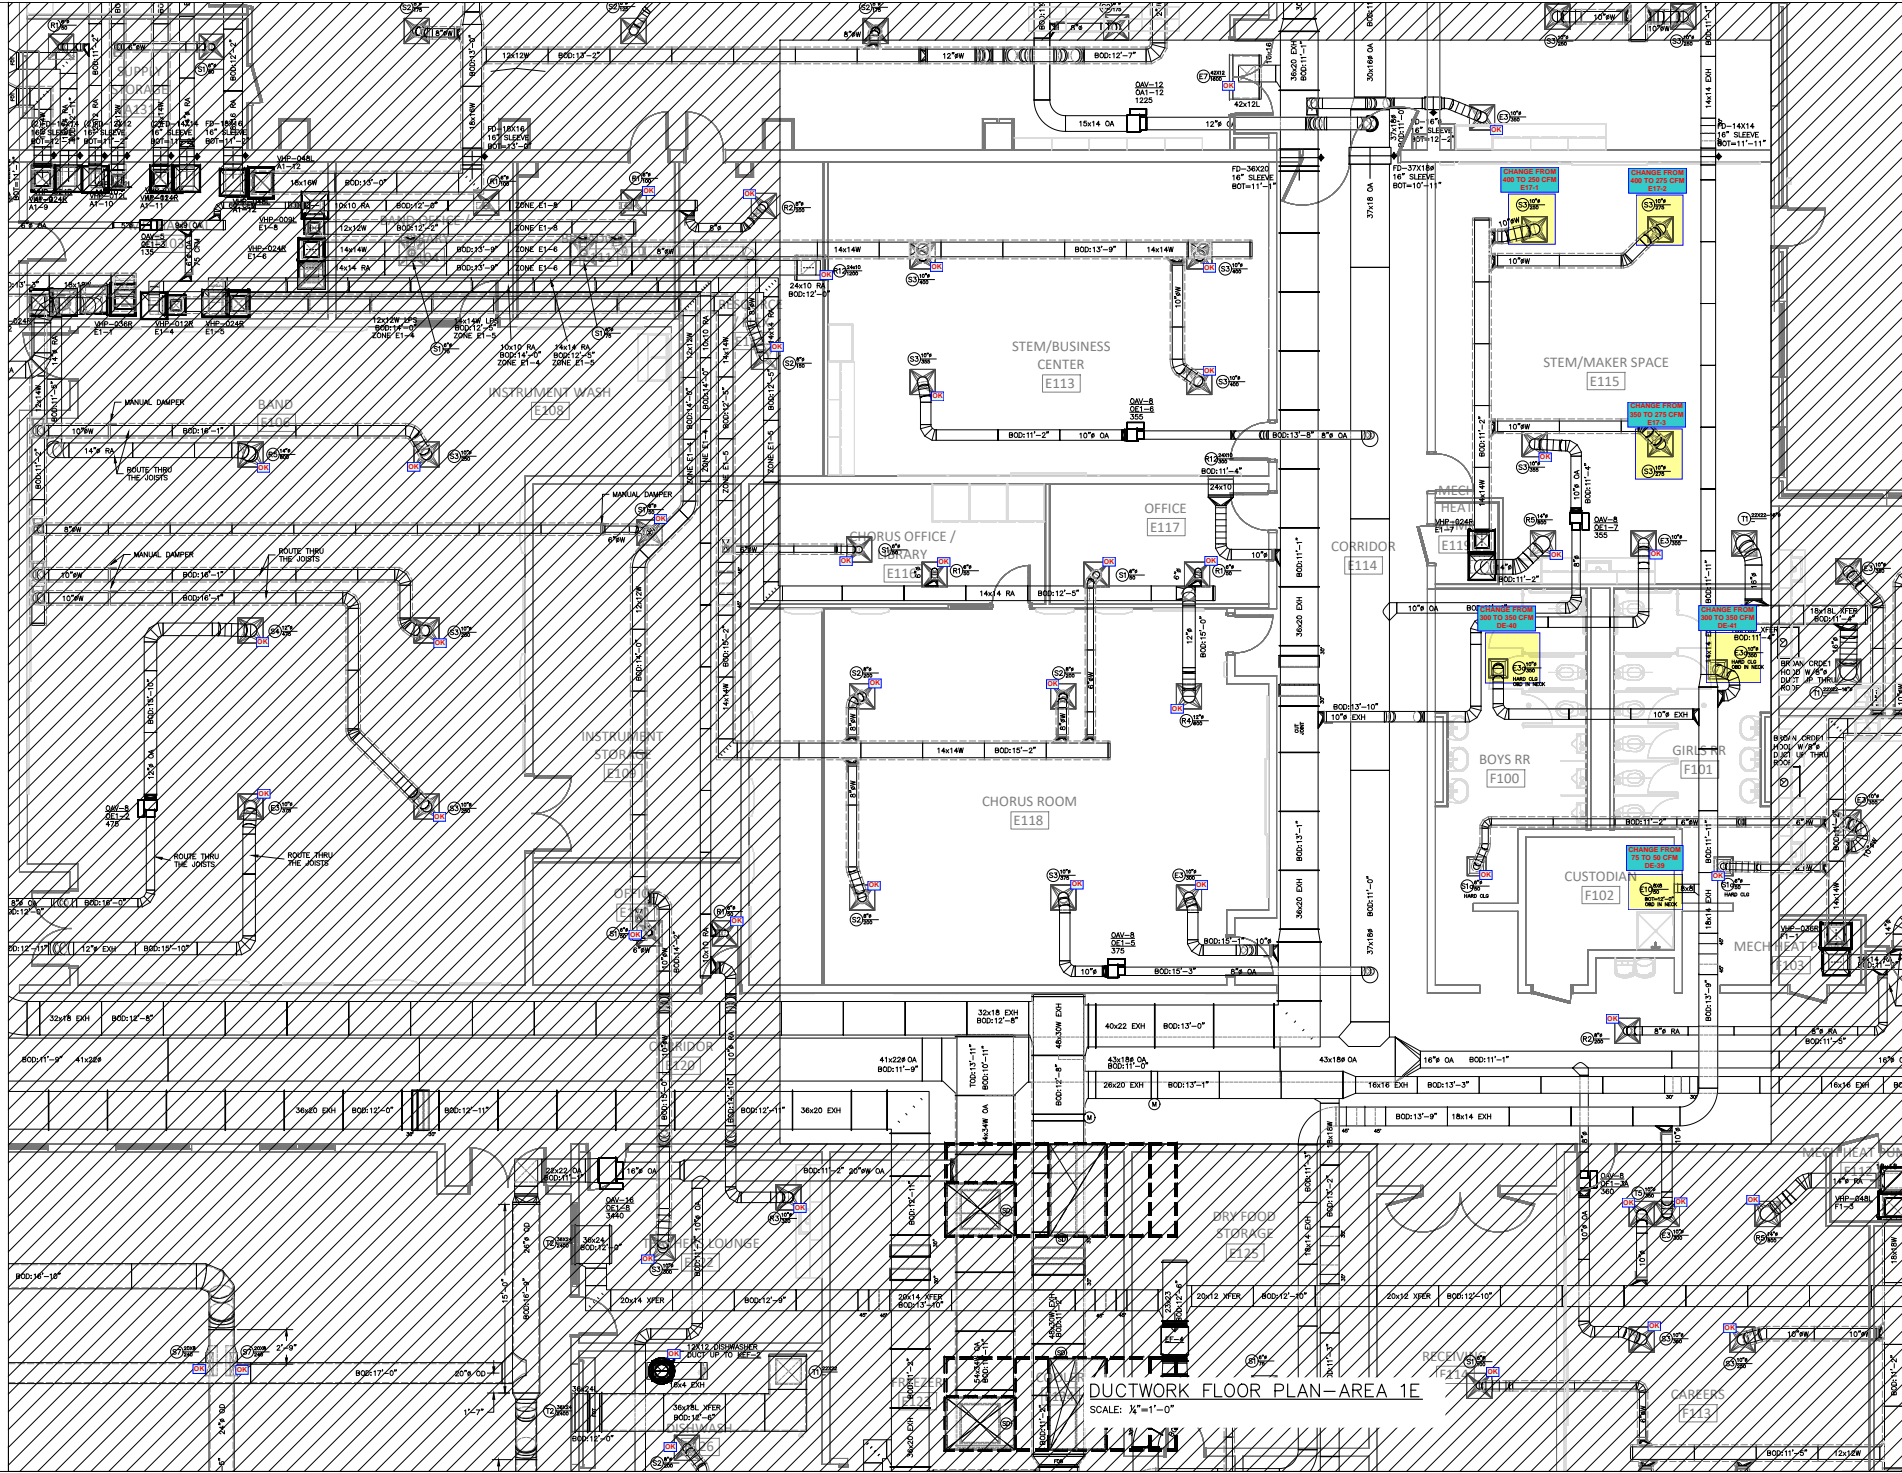

**SELMA BURKE
MIDDLE SCHOOL**
235 RINEHARDT ROAD
MOORESVILLE, NC 28115

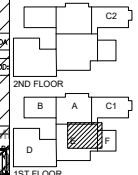


GENERAL CONTRACTOR: BARNETT CONTRACTING
○ PRELIMINARY - NOT FOR CONSTRUCTION
● FOR CONSTRUCTION
● SHOP DRAWINGS
○ AS-BUILT DRAWINGS

REVISIONS: DATE


DRAWN BY: RJM
CHECKED BY: RJM
PROJECT: 22-693
DATE: 05/06/2022
SHEET: 11 OF: 17

DUCTWORK FLOOR PLAN-AREA 1E
SCALE: 1/4"=1'-0"

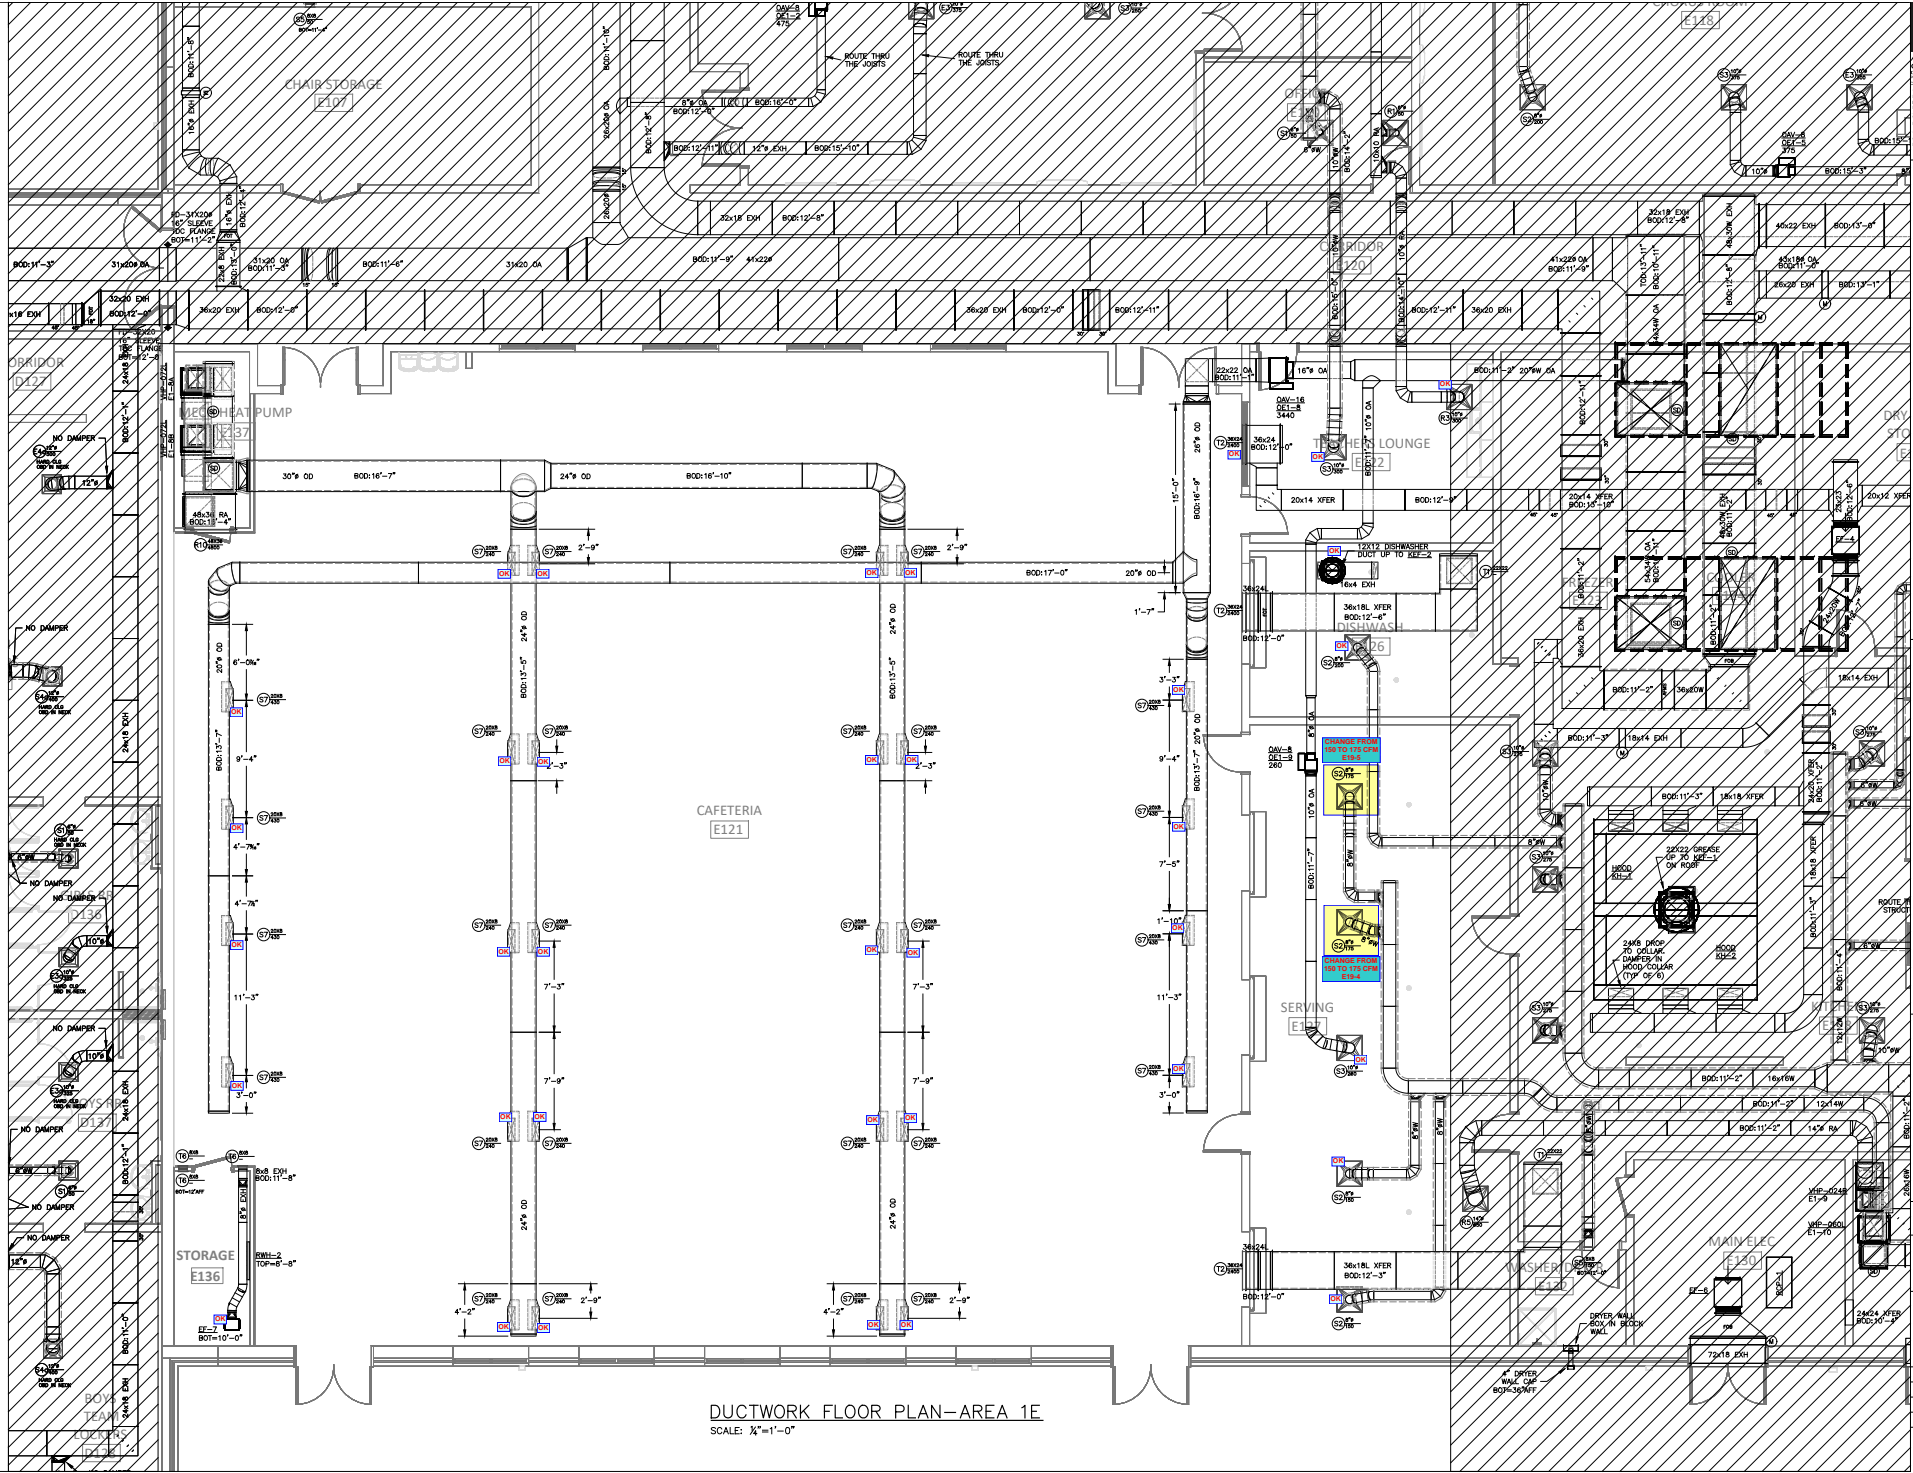

DUCTWORK FLOOR PLAN—AREA 1E
SCALE: 1/4"=1'-0"

 SELMA BURKE
MIDDLE SCHOOL
235 RINEHARDT ROAD
MOORESVILLE, NC 28115




GENERAL CONTRACTOR:
BARNELL CONTRACTING
○ PRELIMINARY - NOT FOR CONSTRUCTION
○ FOR CONSTRUCTION
● SHOP DRAWINGS
○ AS-BUILT DRAWINGS

REVISIONS


NO.	DATE	DESCRIPTION

DRAWN BY: RJM
CHECKED BY: RJM
PROJECT: 22-693
DATE: 05/06/2022
SHEET: 12 OF 17

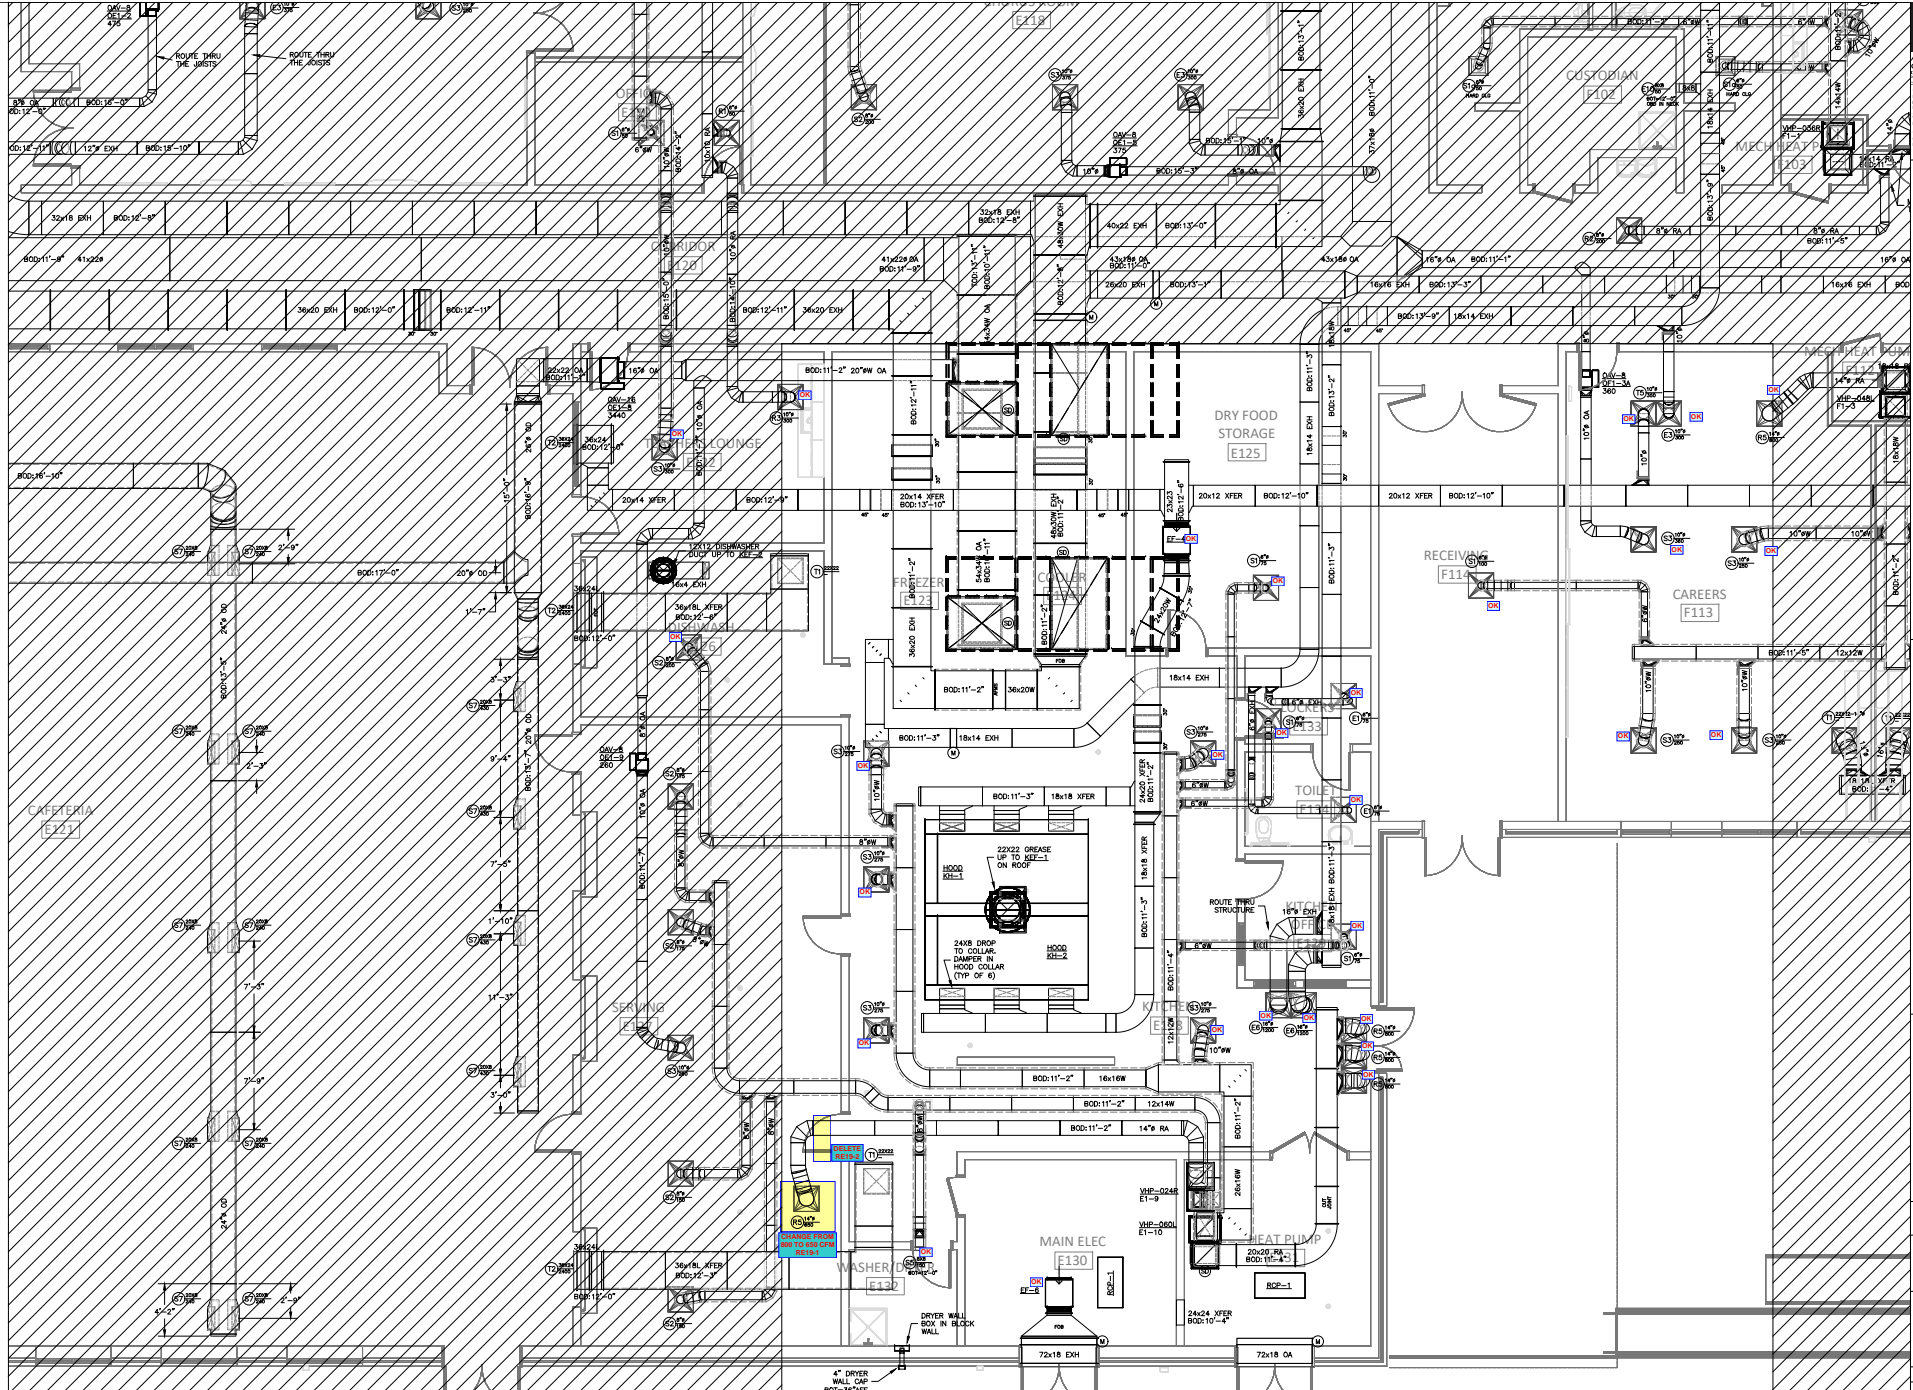

DUCTWORK FLOOR PLAN-AREA 1E
SCALE: 1/8"=1'-0"

 **SELMA BURKE
MIDDLE SCHOOL**
235 RINEHARDT ROAD
MOORESVILLE, NC 28115




GENERAL CONTRACTOR:
BARNHILL CONTRACTING
○ PRELIMINARY - NOT FOR CONSTRUCTION
○ FOR CONSTRUCTION
● SHOP DRAWINGS
○ AS-BUILT DRAWINGS


REVISIONS DATE

NO.	DESCRIPTION	DATE

DRAWN BY: RJM
CHECKED BY: RJM
PROJECT: 22-693
DATE: 05/06/2022
SHEET: 13 OF: 17

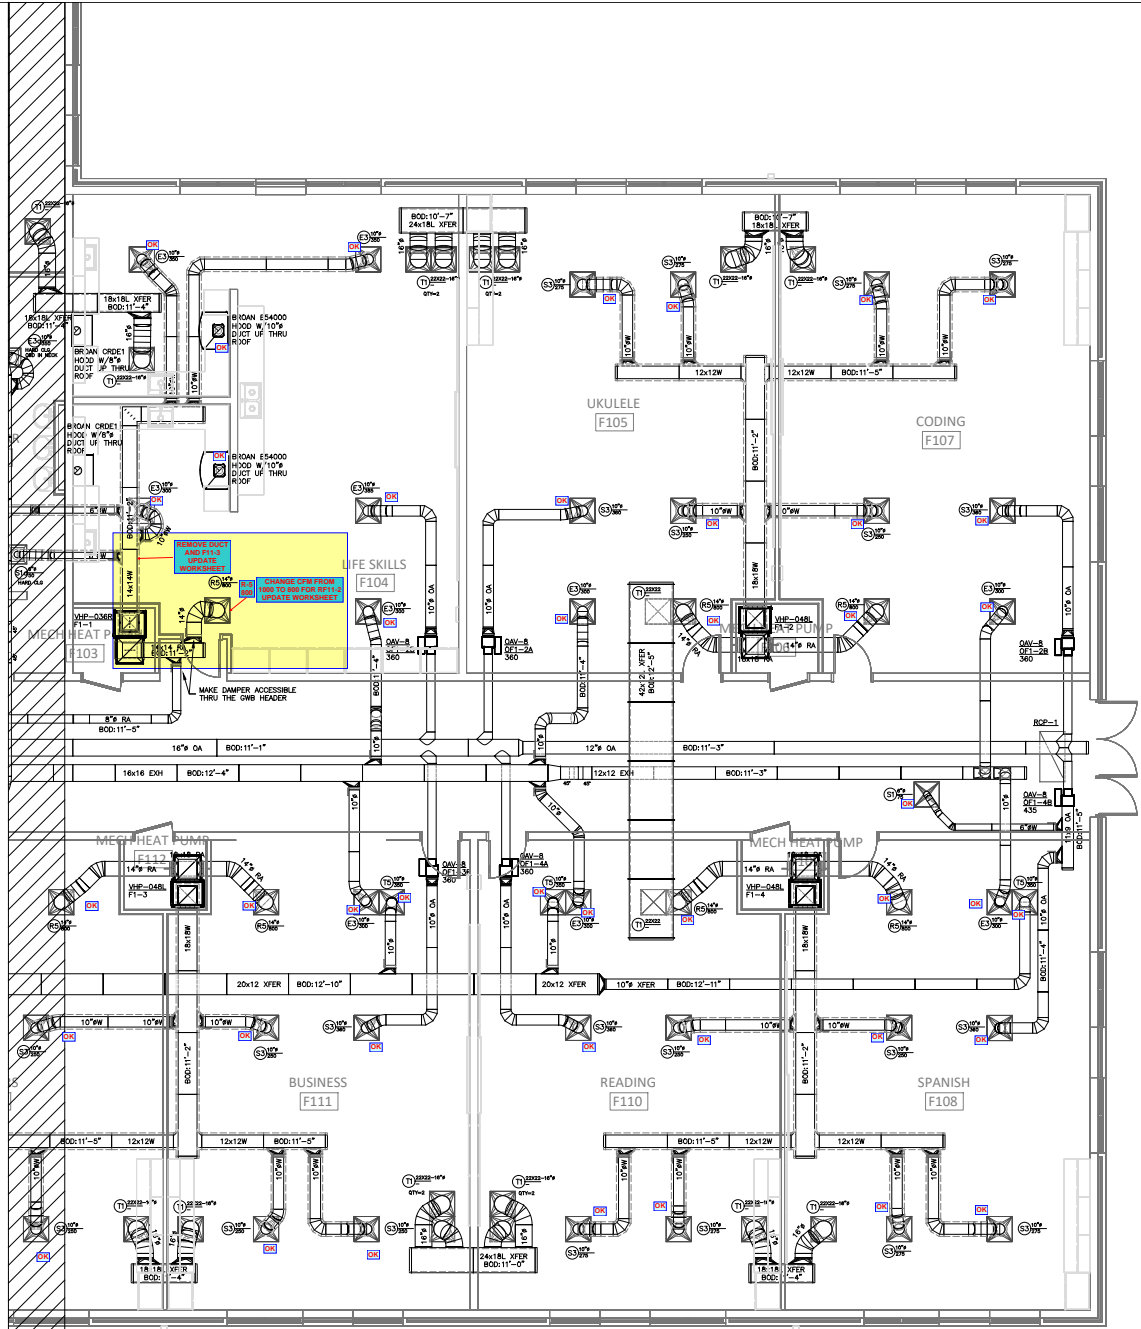


DUCTWORK FLOOR PLAN-AREA 1F
 SCALE: 1/8"=1'-0"

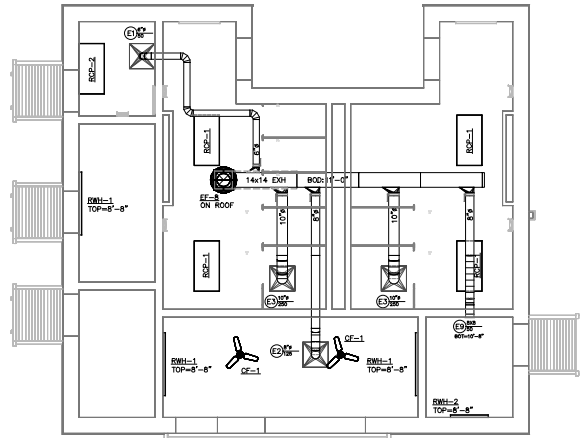

DUCTWORK FLOOR PLAN-CONCESSION
 SCALE: 1/4"=1'-0"

 
SELMA BURKE MIDDLE SCHOOL
 235 RINEHARDT ROAD
 MOORESVILLE, NC 28115





GENERAL CONTRACTOR: BARNHILL CONTRACTING
 ○ PRELIMINARY - NOT FOR CONSTRUCTION
 ○ FOR CONSTRUCTION
 ● SHOP DRAWINGS
 ○ AS-BUILT DRAWINGS

REVISIONS	DATE

DRAWN BY: RJM
CHECKED BY: RJM
PROJECT: 22-693
DATE: 05/06/2022

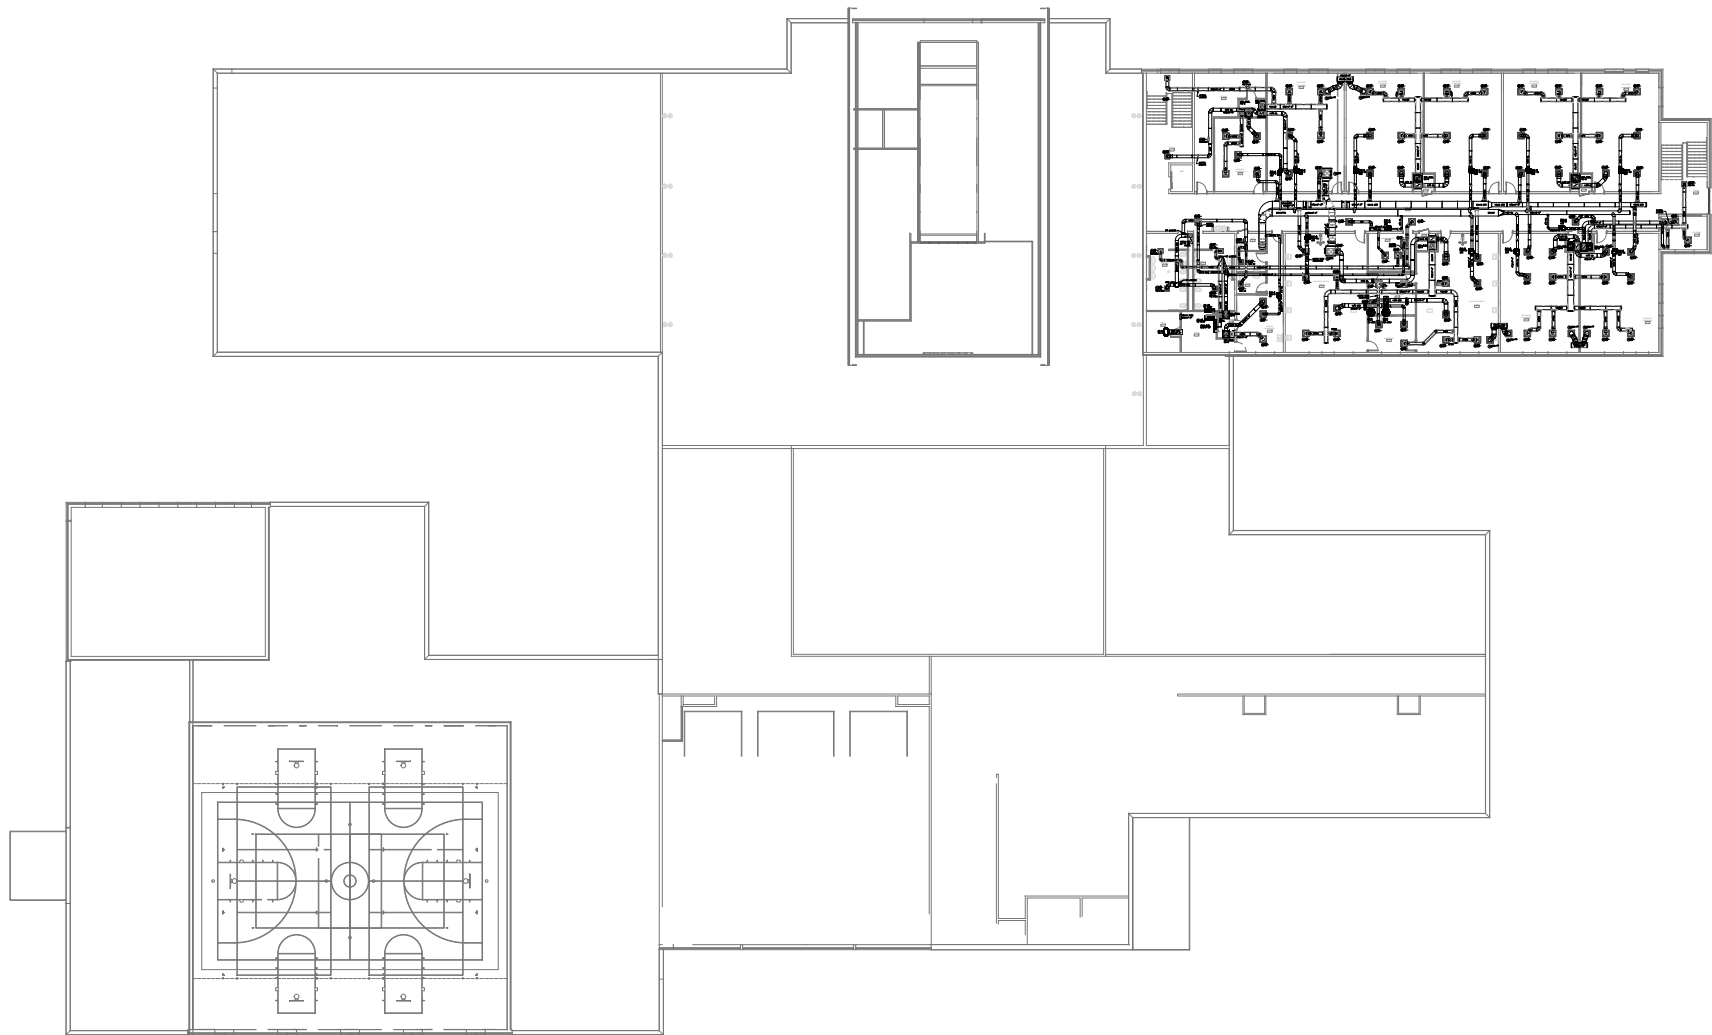

  **SELMA BURKE
MIDDLE SCHOOL**
235 RINEHARDT ROAD
MOORESVILLE, NC 28115




GENERAL CONTRACTOR:
BARNHILL
CONTRACTING

- PRELIMINARY - NOT FOR CONSTRUCTION
- FOR CONSTRUCTION
- SHOP DRAWINGS
- AS-BUILT DRAWINGS

REVISIONS	DATE

DRAWN BY: RJM
 CHECKED BY: RJM
 PROJECT: 22-693
 DATE: 05/06/2022
 SHEET: 15 OF: 17

DUCTWORK FLOOR PLAN—OVERALL 2ND FLOOR
SCALE: 1/8"=1'-0"

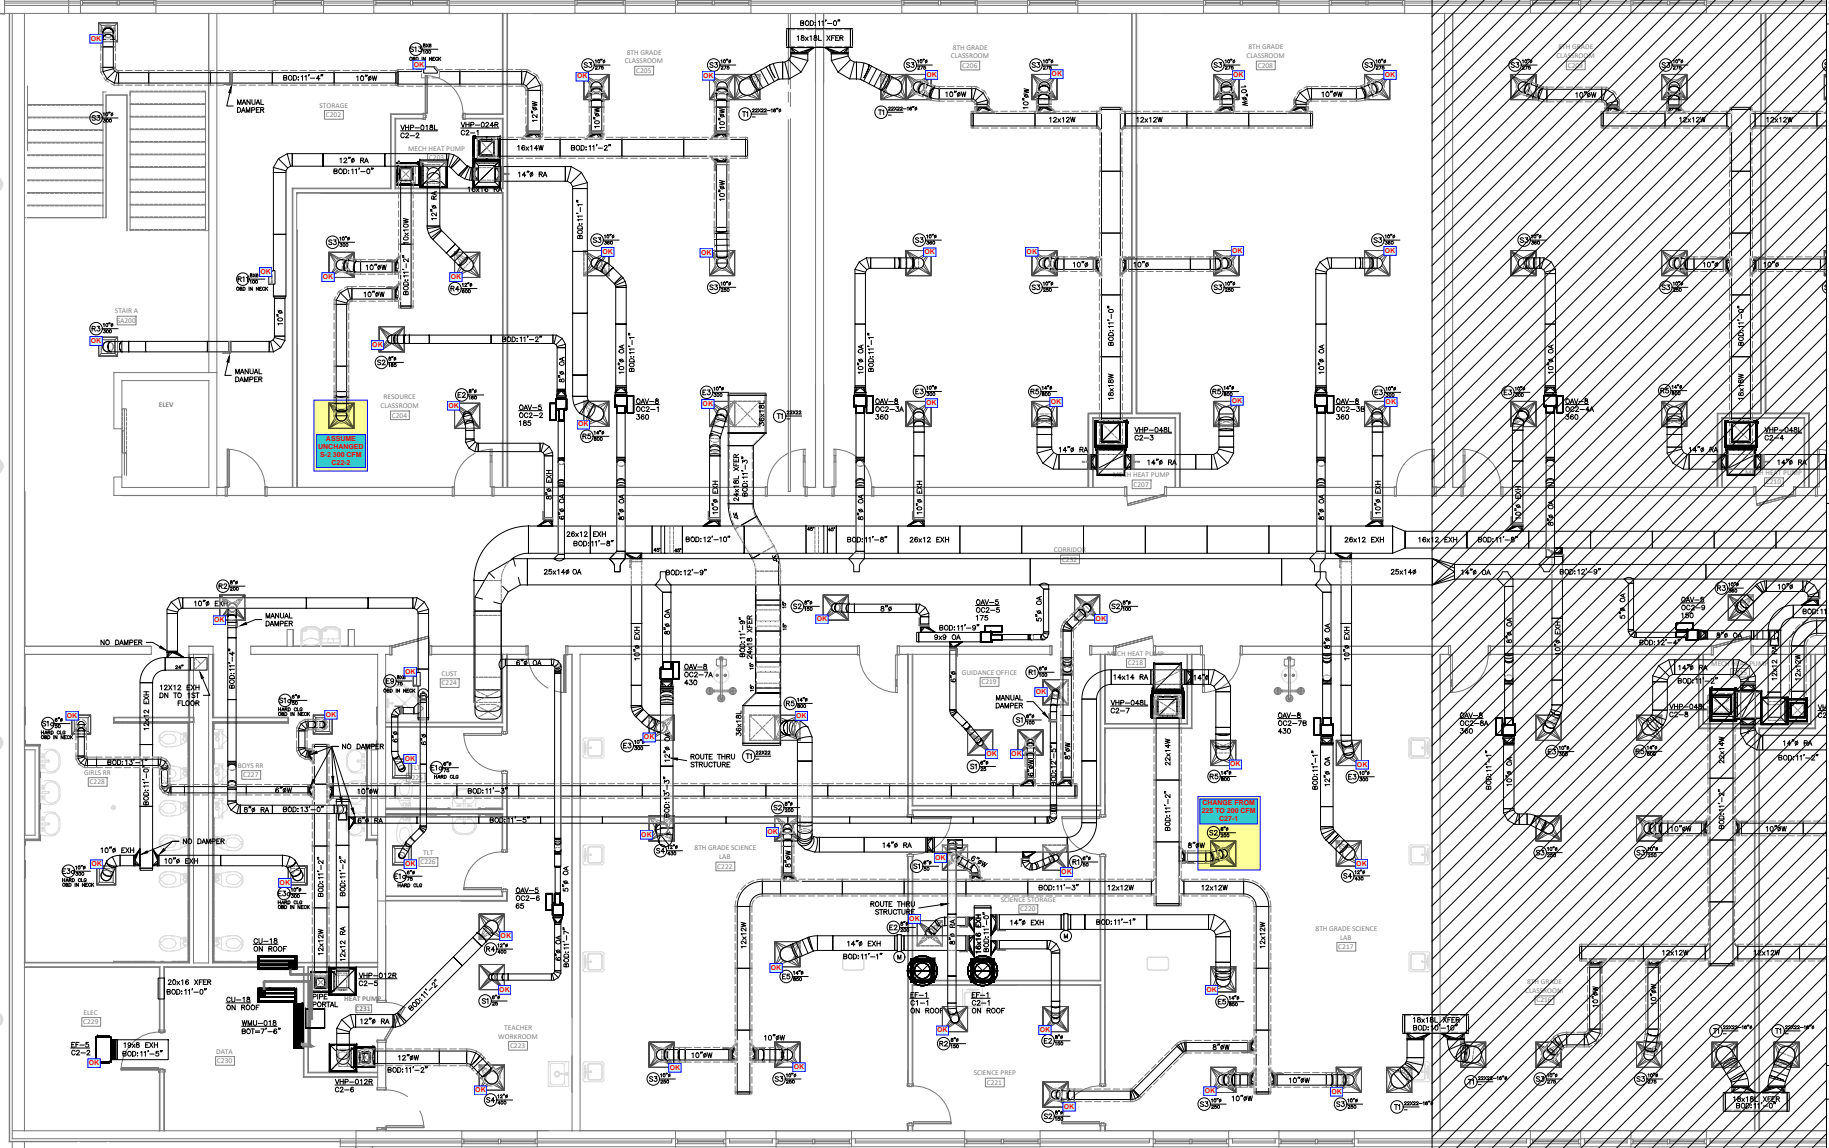

DUCTWORK FLOOR PLAN-AREA 2C
SCALE: 1/4"=1'-0"

**SELMA BURKE
MIDDLE SCHOOL**
235 RINEHARDT ROAD
MOORESVILLE, NC 28115





GENERAL CONTRACTOR: BARNETT CONTRACTING
PRELIMINARY - NOT FOR CONSTRUCTION
FOR CONSTRUCTION
SHOP DRAWINGS
AS-BUILT DRAWINGS

REVISIONS DATE


DRAWN BY: RJM
CHECKED BY: RJM
PROJECT: 22-693
DATE: 05/06/2022

SHEET: 16 OF: 17

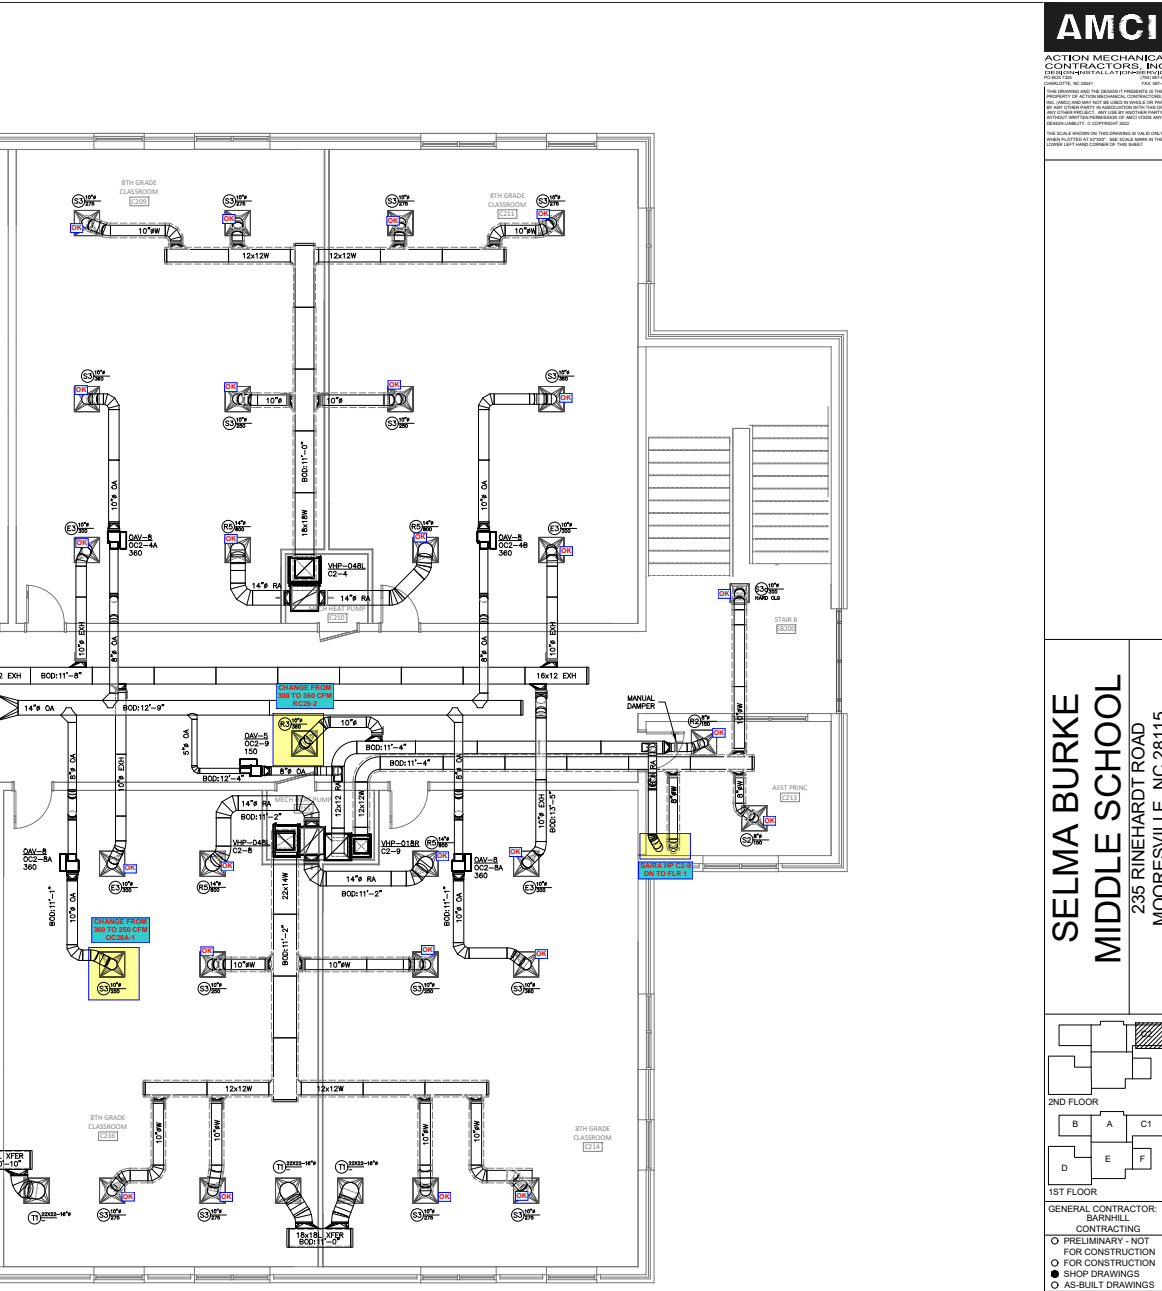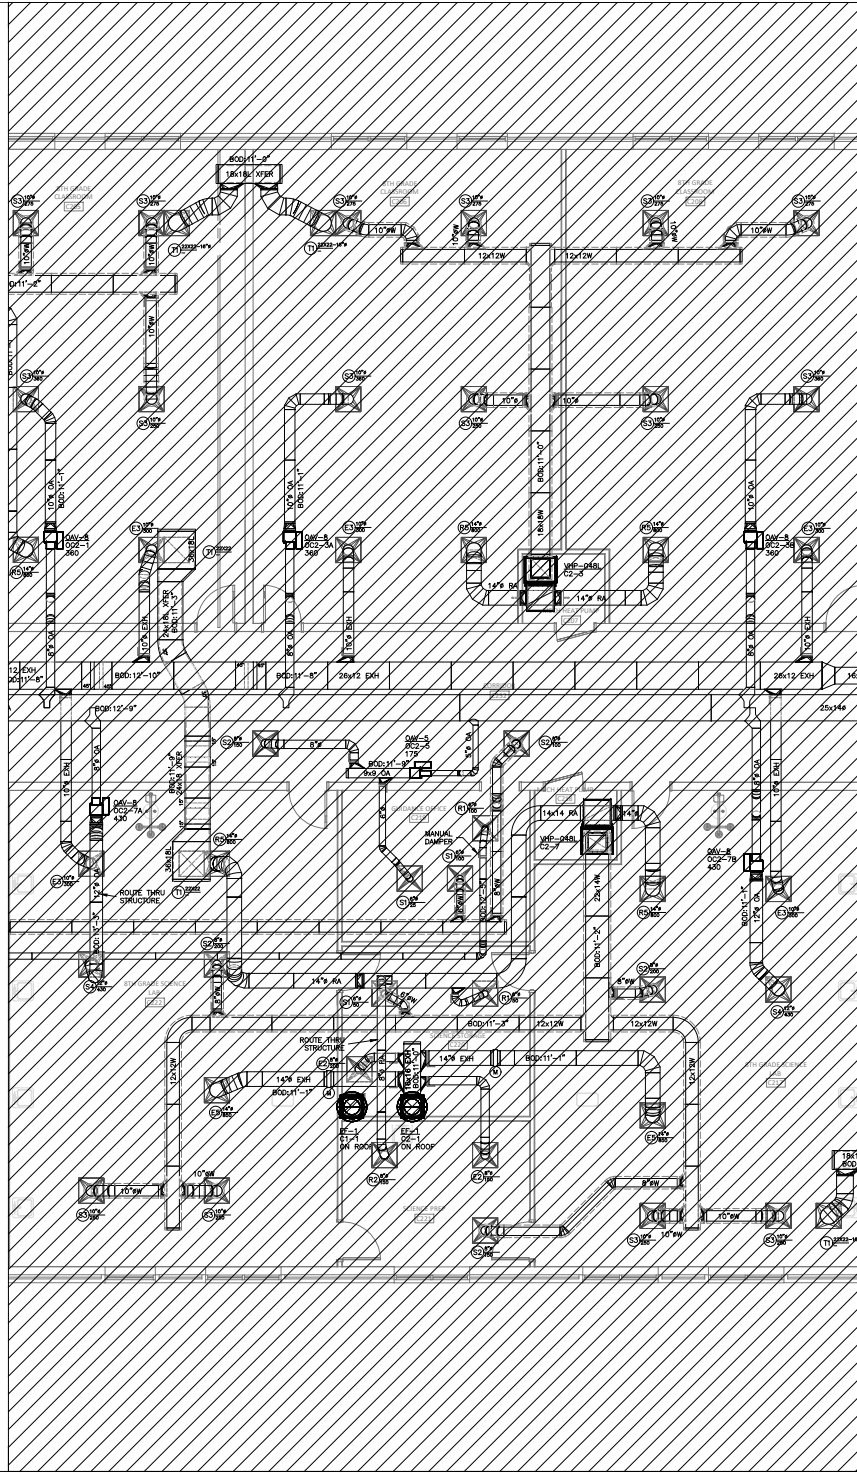

DUCTWORK FLOOR PLAN—AREA 2C
 SCALE: 1/4"=1'-0"

 SELMA BURKE MIDDLE SCHOOL
 235 RINEHARDT ROAD
 MOORESVILLE, NC 28115



GENERAL CONTRACTOR: **BARNELL CONTRACTING**
 ○ PRELIMINARY - NOT FOR CONSTRUCTION
 ○ FOR CONSTRUCTION
 ● SHOP DRAWINGS
 ○ AS-BUILT DRAWINGS

REVISIONS: _____ DATE: _____

DRAWN BY: RJM
 CHECKED BY: RJM
 PROJECT: 22-693
 DATE: 05/06/2022