



DHL CVG AMC
CINCINNATI/NORTHERN KENTUCKY
INTERNATIONAL AIRPORT
410 WENDELL H. FORD BLVD
ERLANGER, KY 41018

CONTRACTOR INFORMATION

ESTD 1951
PERFECTION GROUP
2649 COMMERCE BLVD.
CINCINNATI, OHIO 45241
TEL +1.513.772.7545

ARCHITECT/ENGINEER INFORMATION

GHAFFARI
122 SOUTH MICHIGAN AVENUE
SUITE 1600
CHICAGO, IL 60603-8152 USA
TEL +1.312.984.2300
www.ghaffari.com

SHOP DRAWING


1 01/02/25 ISSUED FOR CONSTRUCTION

REV DATE DOC REL ## - DESCRIPTION


PROJECT # 241054
PROJECT MANAGER E. RICE
DESIGNED BY T. JANZEN
DRAWN BY T. JANZEN
QUALITY CHECK C. LONG
SHEET TITLE

MECHANICAL HVAC PLAN FIRST FLOOR AREA A

MH1-01-01
SHEET NUMBER

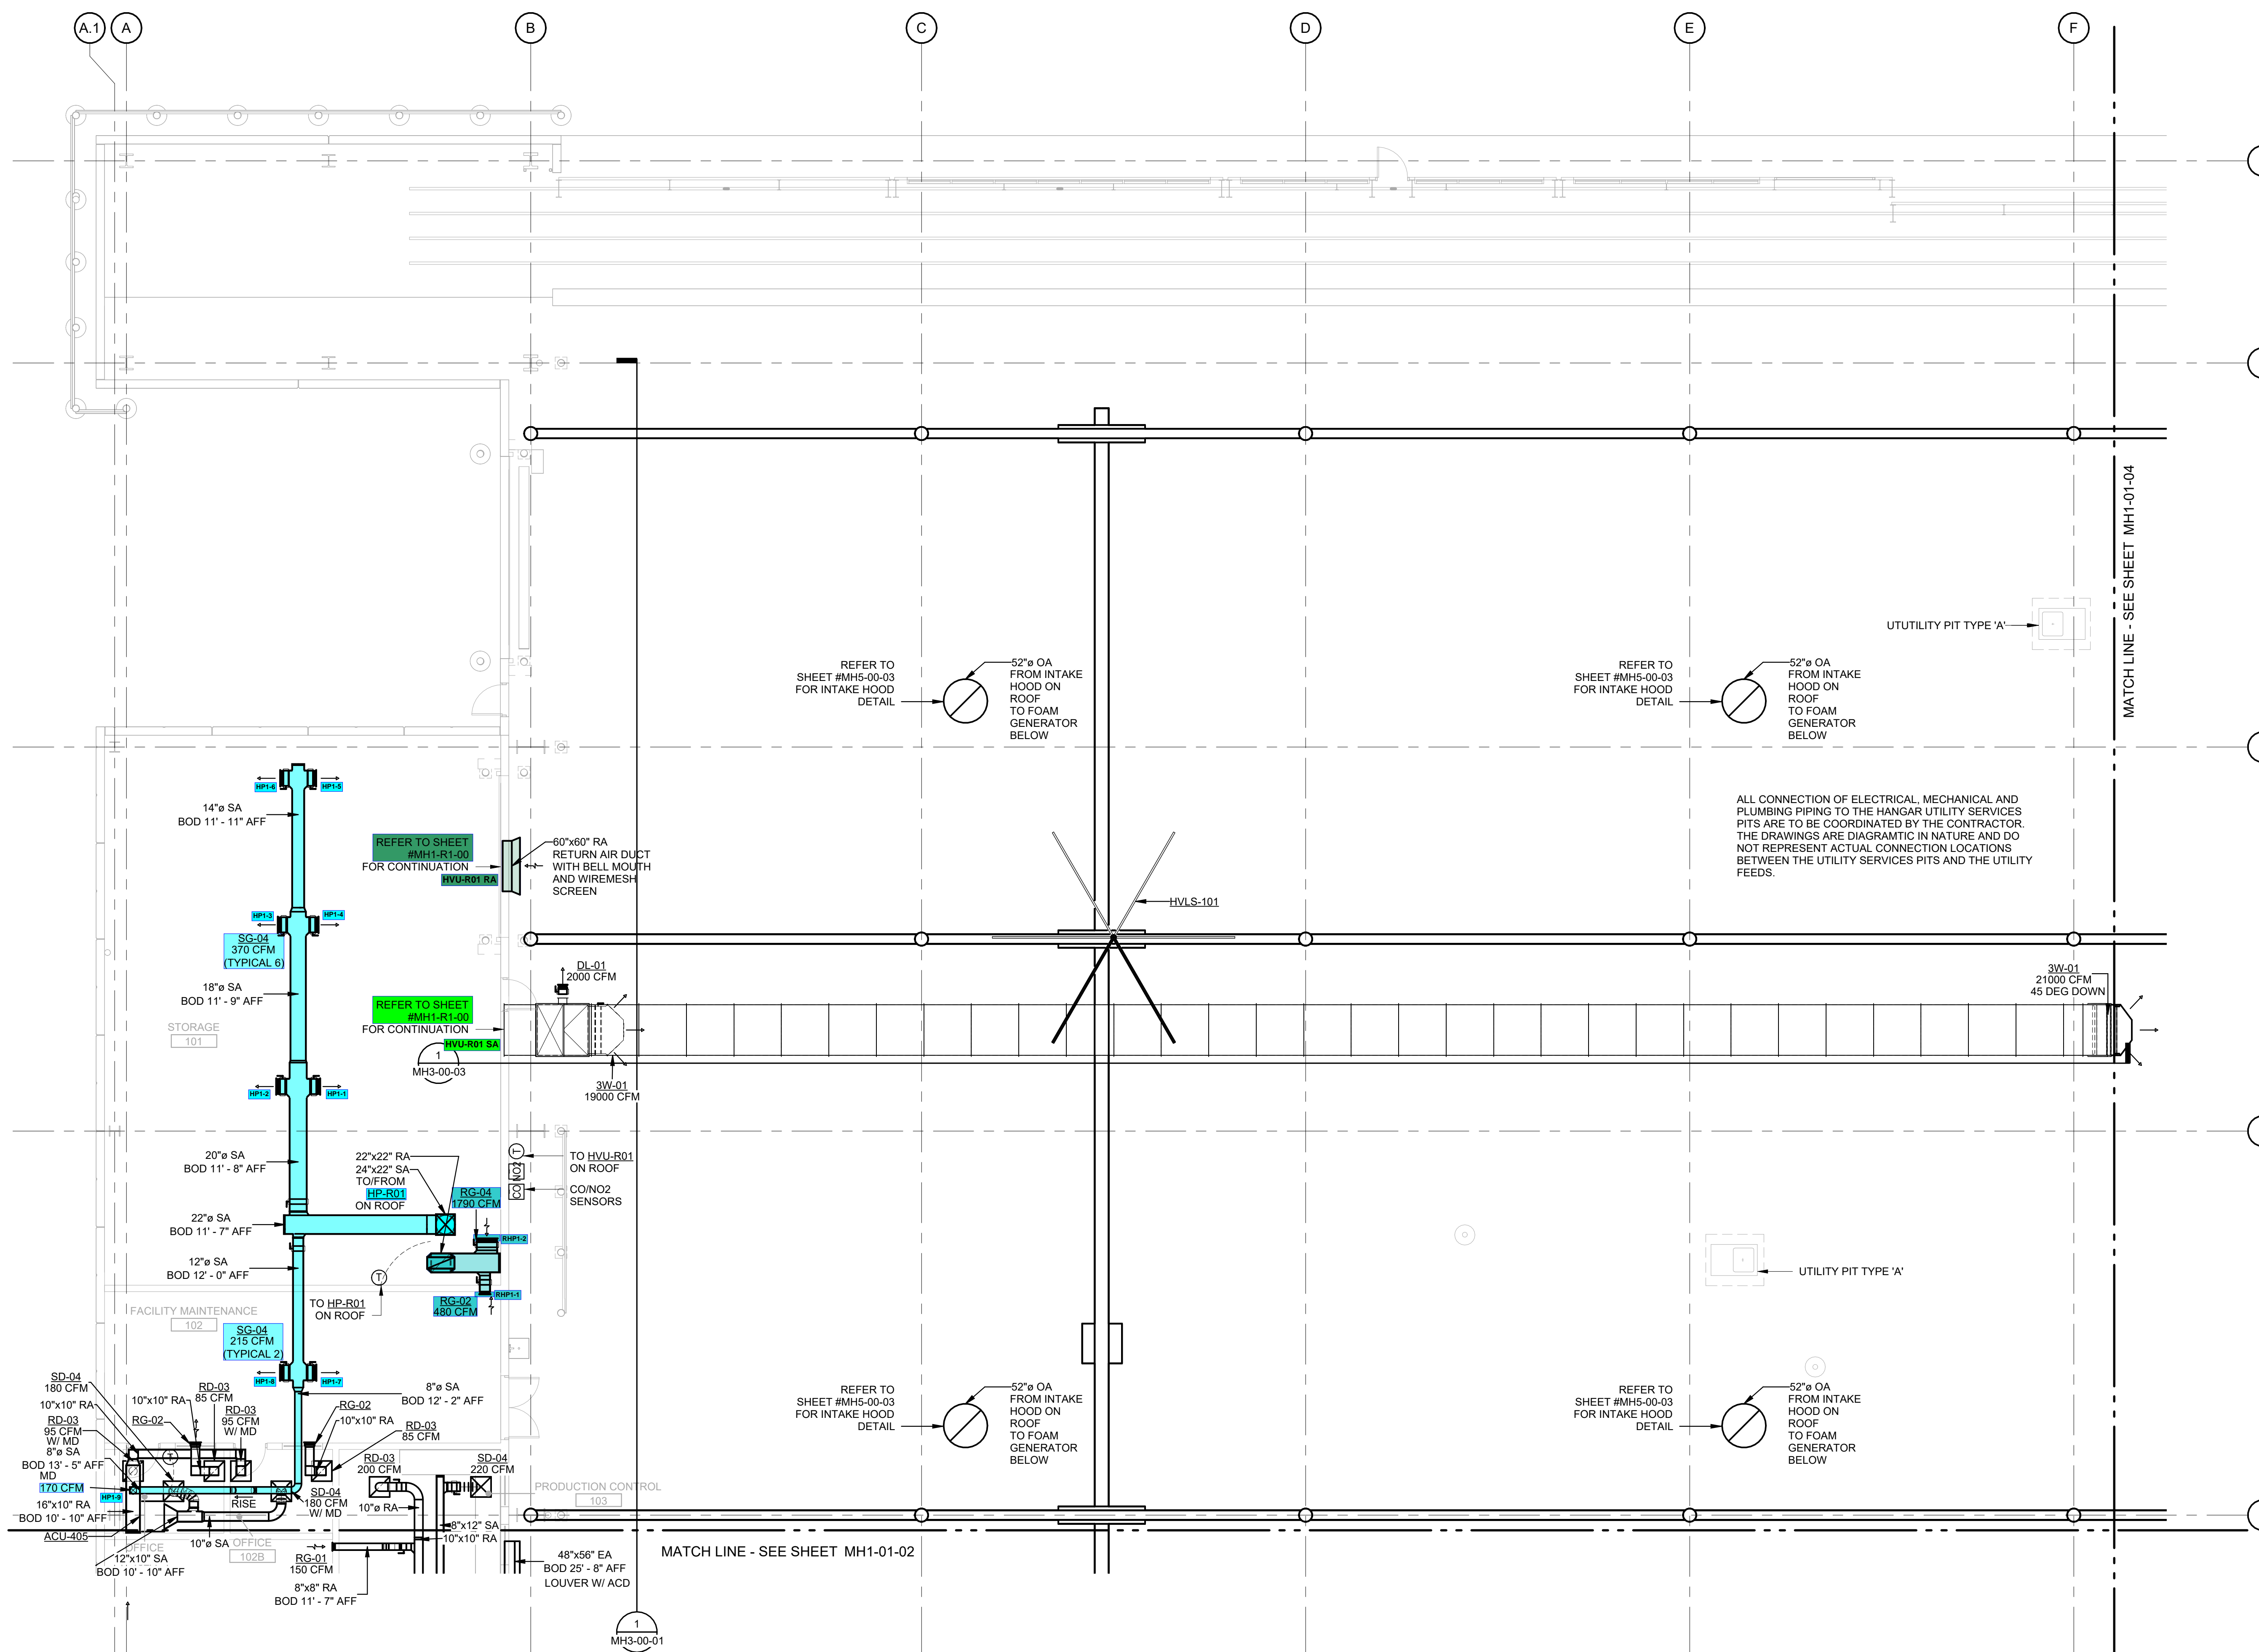

MECHANICAL HVAC PLAN FIRST FLOOR AREA A
SCALE: 1/8" = 1'-0"

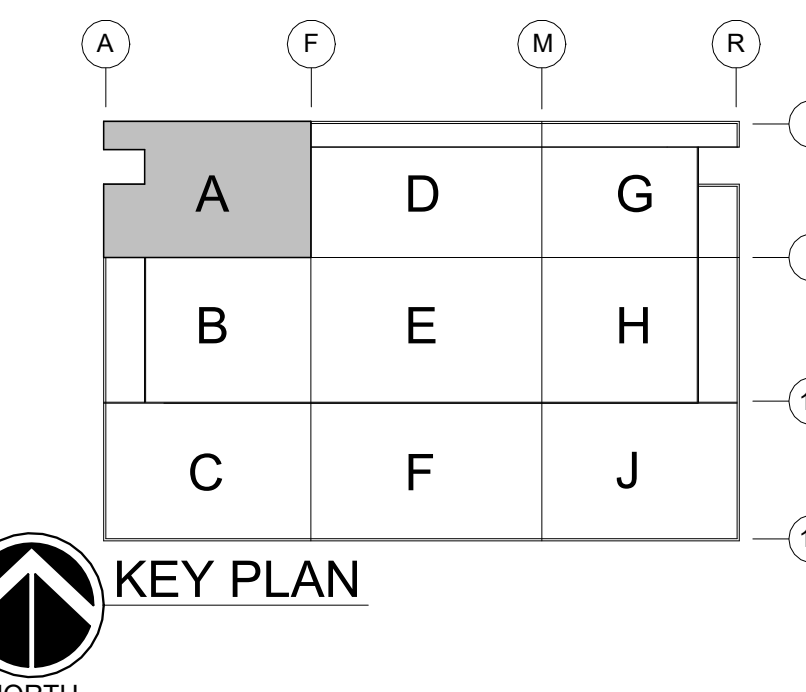

GHAFARI ASSOCIATES © 2023 1/15/2025 8:27:35 AM



DHL CVG AMC
CINCINNATI/NORTHERN KENTUCKY
INTERNATIONAL AIRPORT
410 WENDELL H. FORD BLVD
ERLANGER, KY 41018

CONTRACTOR INFORMATION

ESTD 1951
PERFECTION GROUP

2649 COMMERCE BLVD.
CINCINNATI, OHIO 45241
TEL +1.513.772.7545



ARCHITECT/ENGINEER INFORMATION

GHAFARI

122 SOUTH MICHIGAN AVENUE
SUITE 1600
CHICAGO, IL 60603-8152 USA
TEL +1.312.984.2300
www.ghafari.com

SHOP DRAWING

NOTES THIS DRAWING
1. LINEAR DEVICE PLENUM BOX TO BE PROVIDED WITH FIELD CUT INLET.

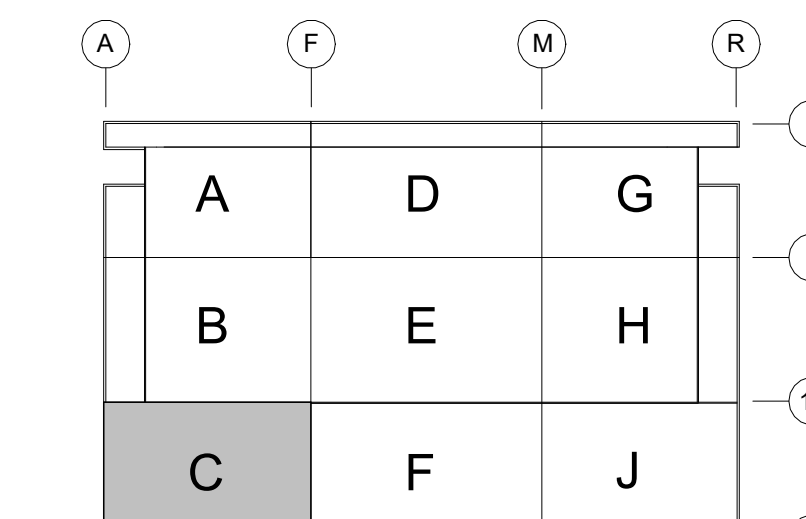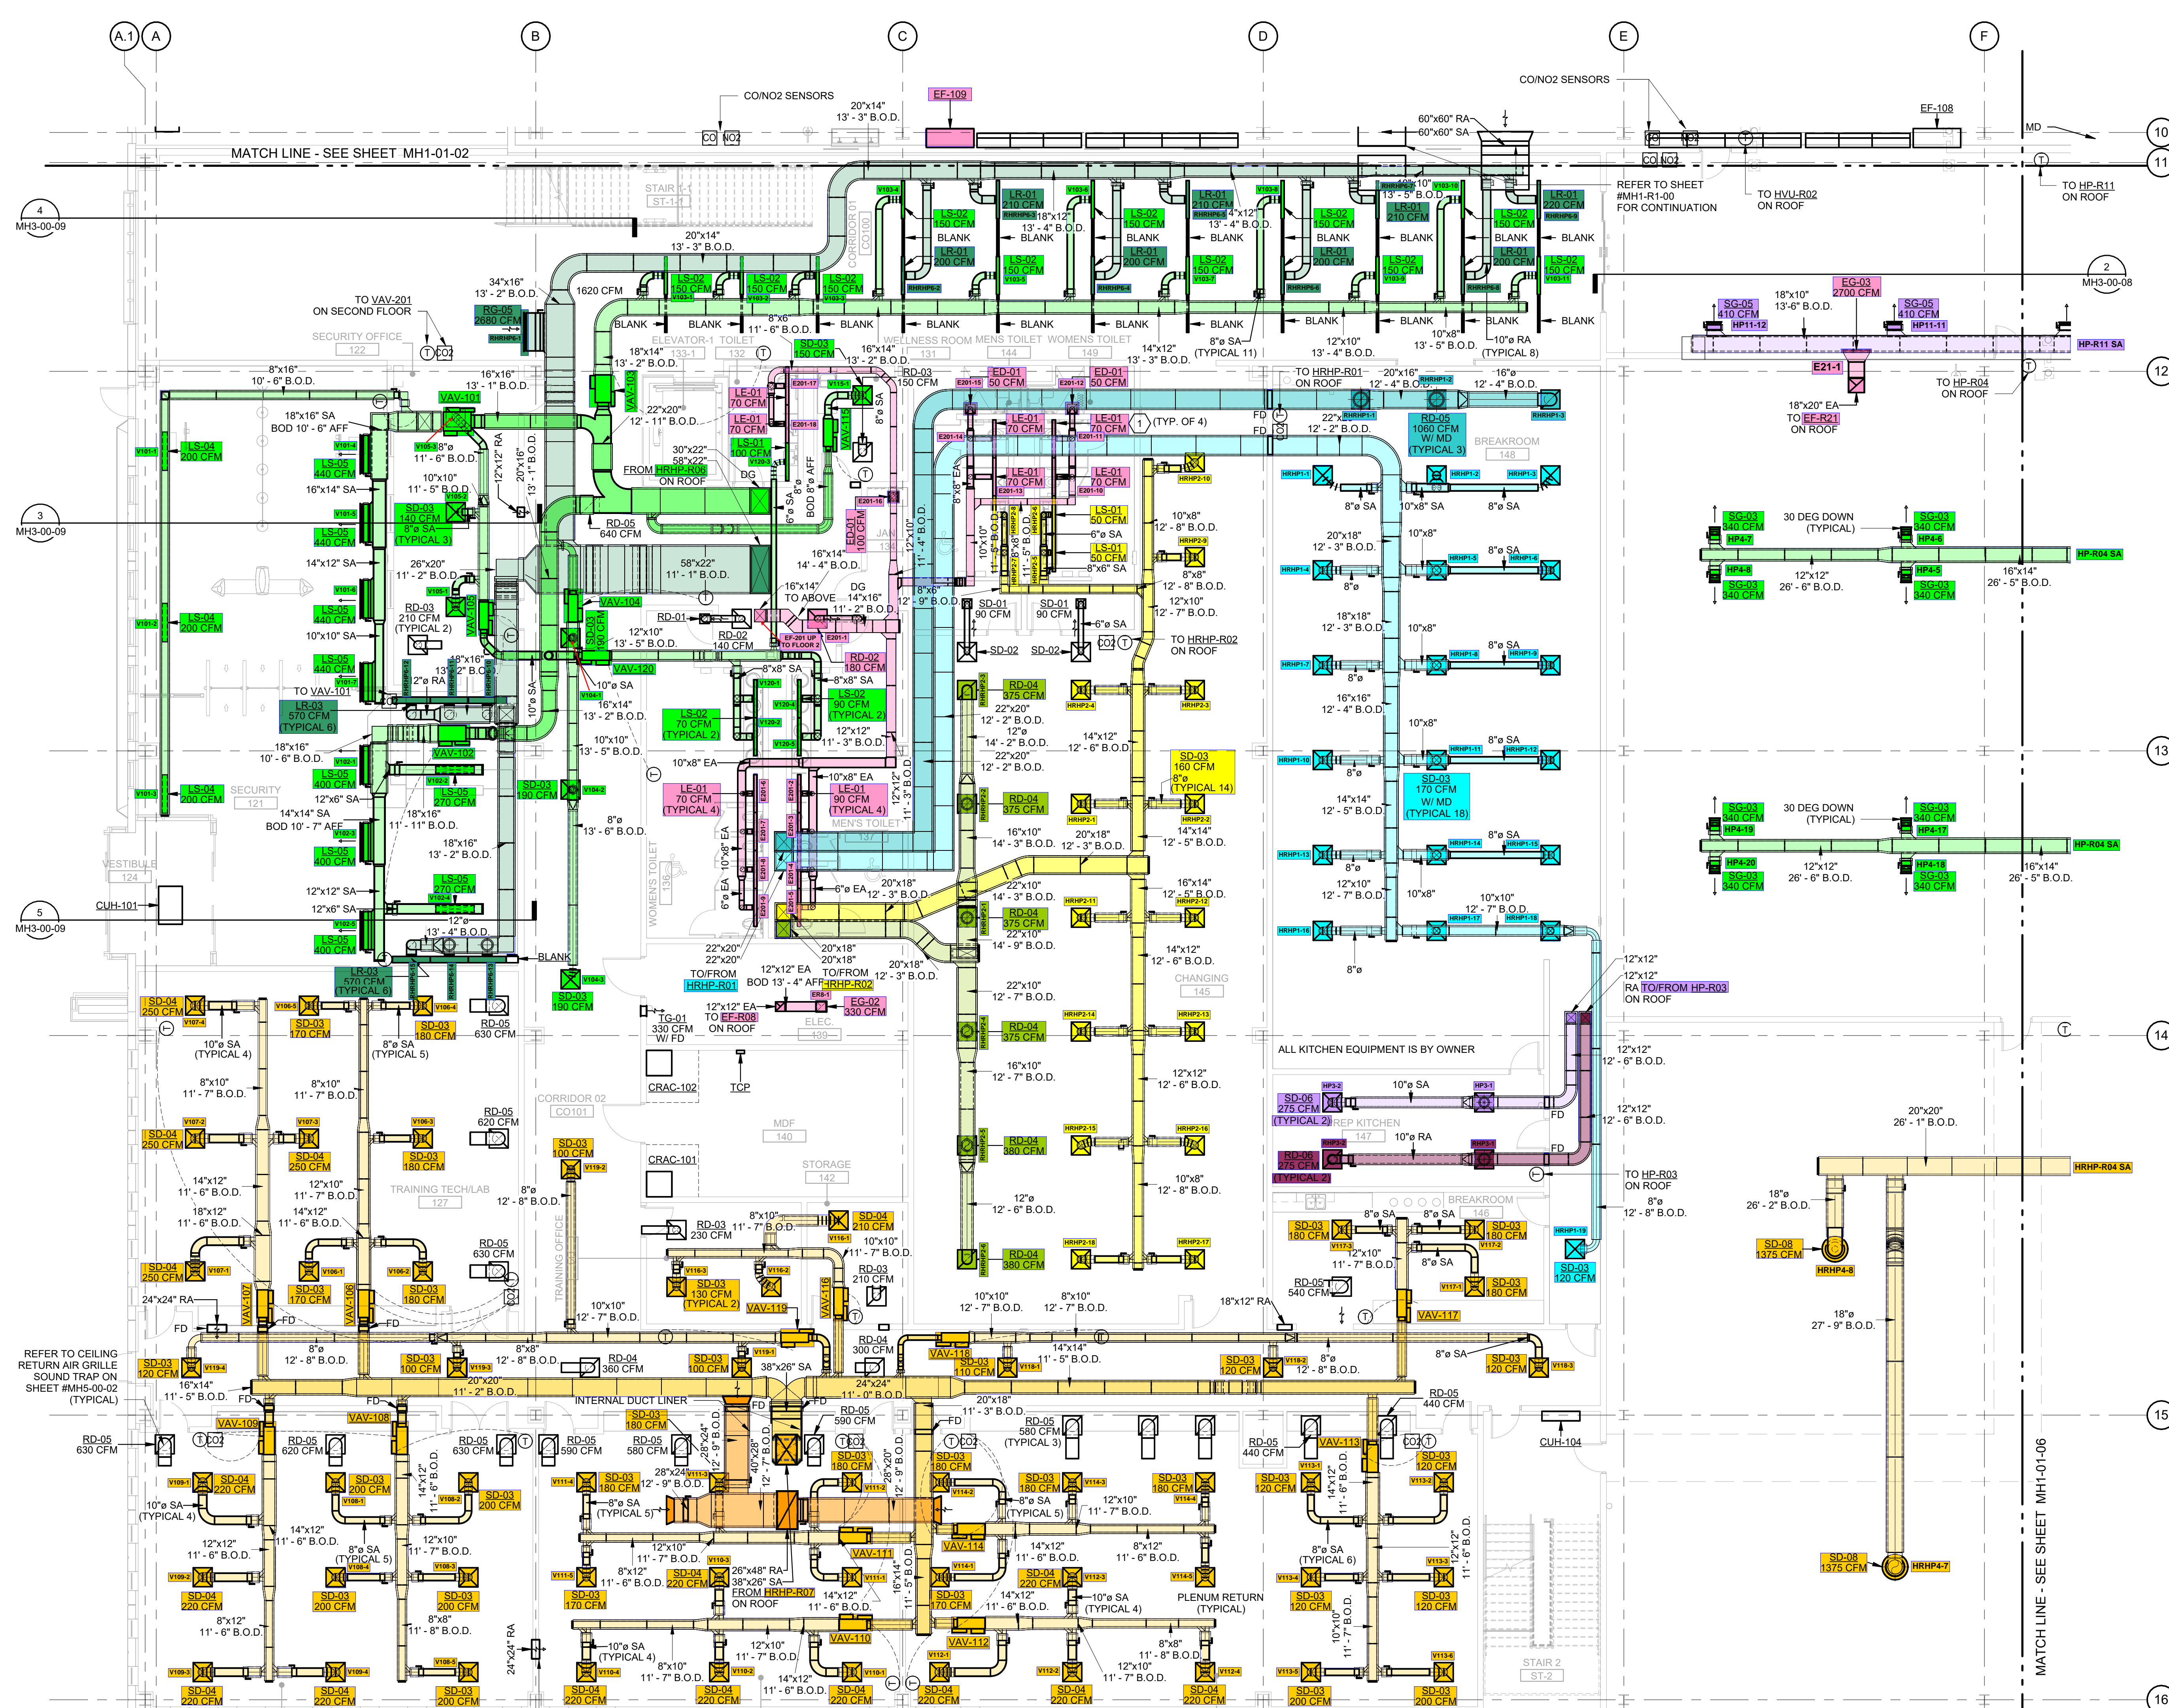

MECHANICAL HVAC PLAN FIRST FLOOR AREA C
SCALE: 1/8" = 1'-0"



PROJECT #	241054
PROJECT MANAGER	E. RICE
DESIGNED BY	T. JANZEN
DRAWN BY	T. JANZEN
QUALITY CHECK	C. LONG
SHEET TITLE	

MECHANICAL HVAC PLAN FIRST FLOOR AREA C

MH1-01-03
SHEET NUMBER

GHAFARI ASSOCIATES © 2023 1/15/2023 8:27:51 AM



DHL CVG AMC
CINCINNATI/NORTHERN KENTUCKY
INTERNATIONAL AIRPORT
410 WENDELL H. FORD BLVD
ERLANGER, KY 41018

CONTRACTOR INFORMATION

ESTD 1951
PERFECTION GROUP
2649 COMMERCE BLVD.
CINCINNATI, OHIO 45241
TEL +1.513.772.7545

ARCHITECT/ENGINEER INFORMATION

GHAFFARI
122 SOUTH MICHIGAN AVENUE
SUITE 1600
CHICAGO, IL 60603-8152 USA
TEL +1.312.984.2300
www.ghaffari.com


SHOP DRAWING

REV	DATE	DOC REL ## - DESCRIPTION
1	01/02/25	ISSUED FOR CONSTRUCTION


PROJECT #	241054
PROJECT MANAGER	E. RICE
DESIGNED BY	T. JANZEN
DRAWN BY	T. JANZEN
QUALCHECK	C. LONG
SHEET TITLE	

MECHANICAL HVAC PLAN FIRST FLOOR AREA D


MH1-01-04
SHEET NUMBER

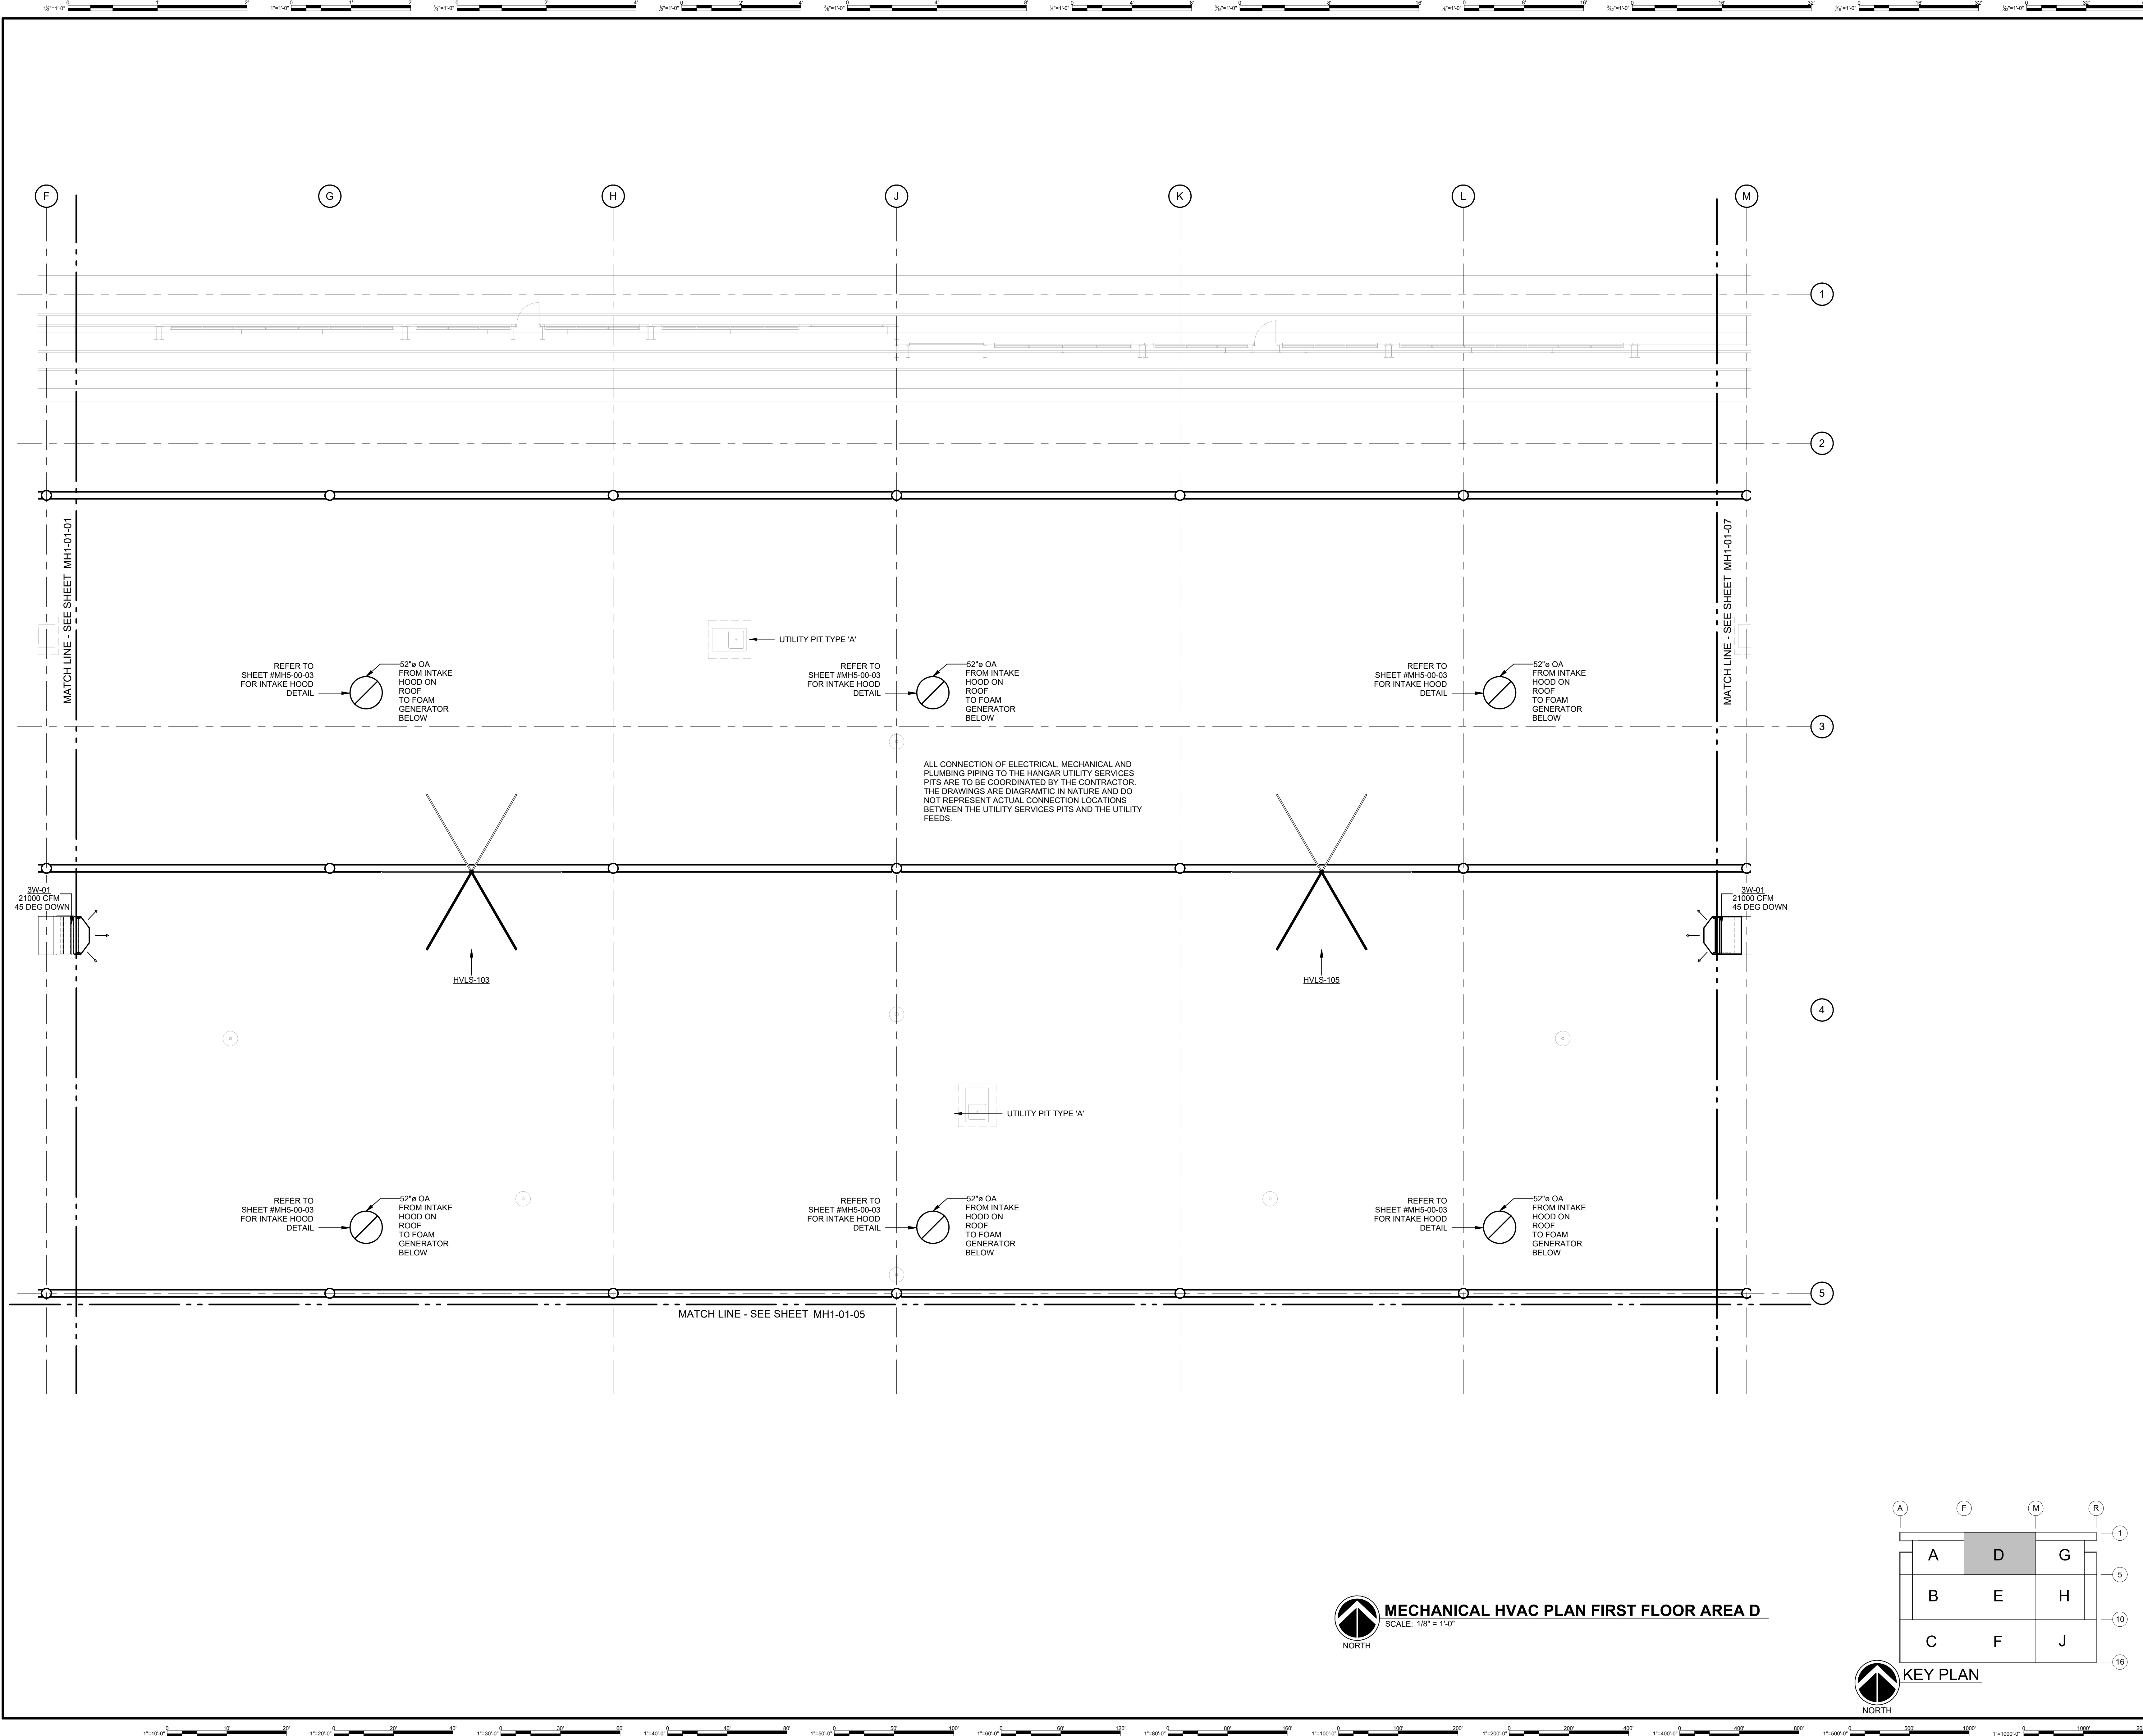

MECHANICAL HVAC PLAN FIRST FLOOR AREA D
SCALE: 1/8" = 1'-0"
NORTH

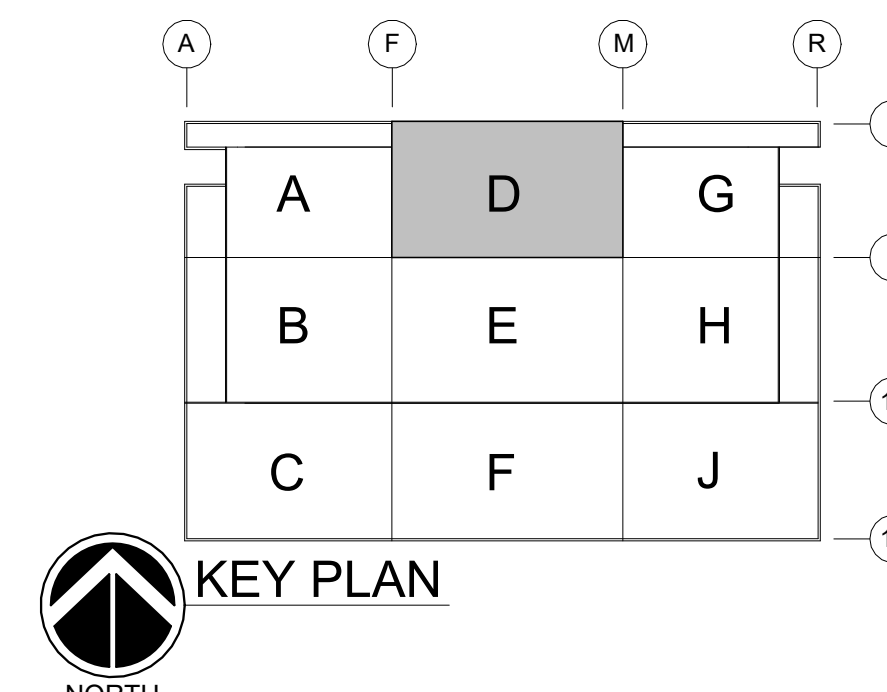

GHAFFARI ASSOCIATES © 2023 1/15/2025 8:27:55 AM

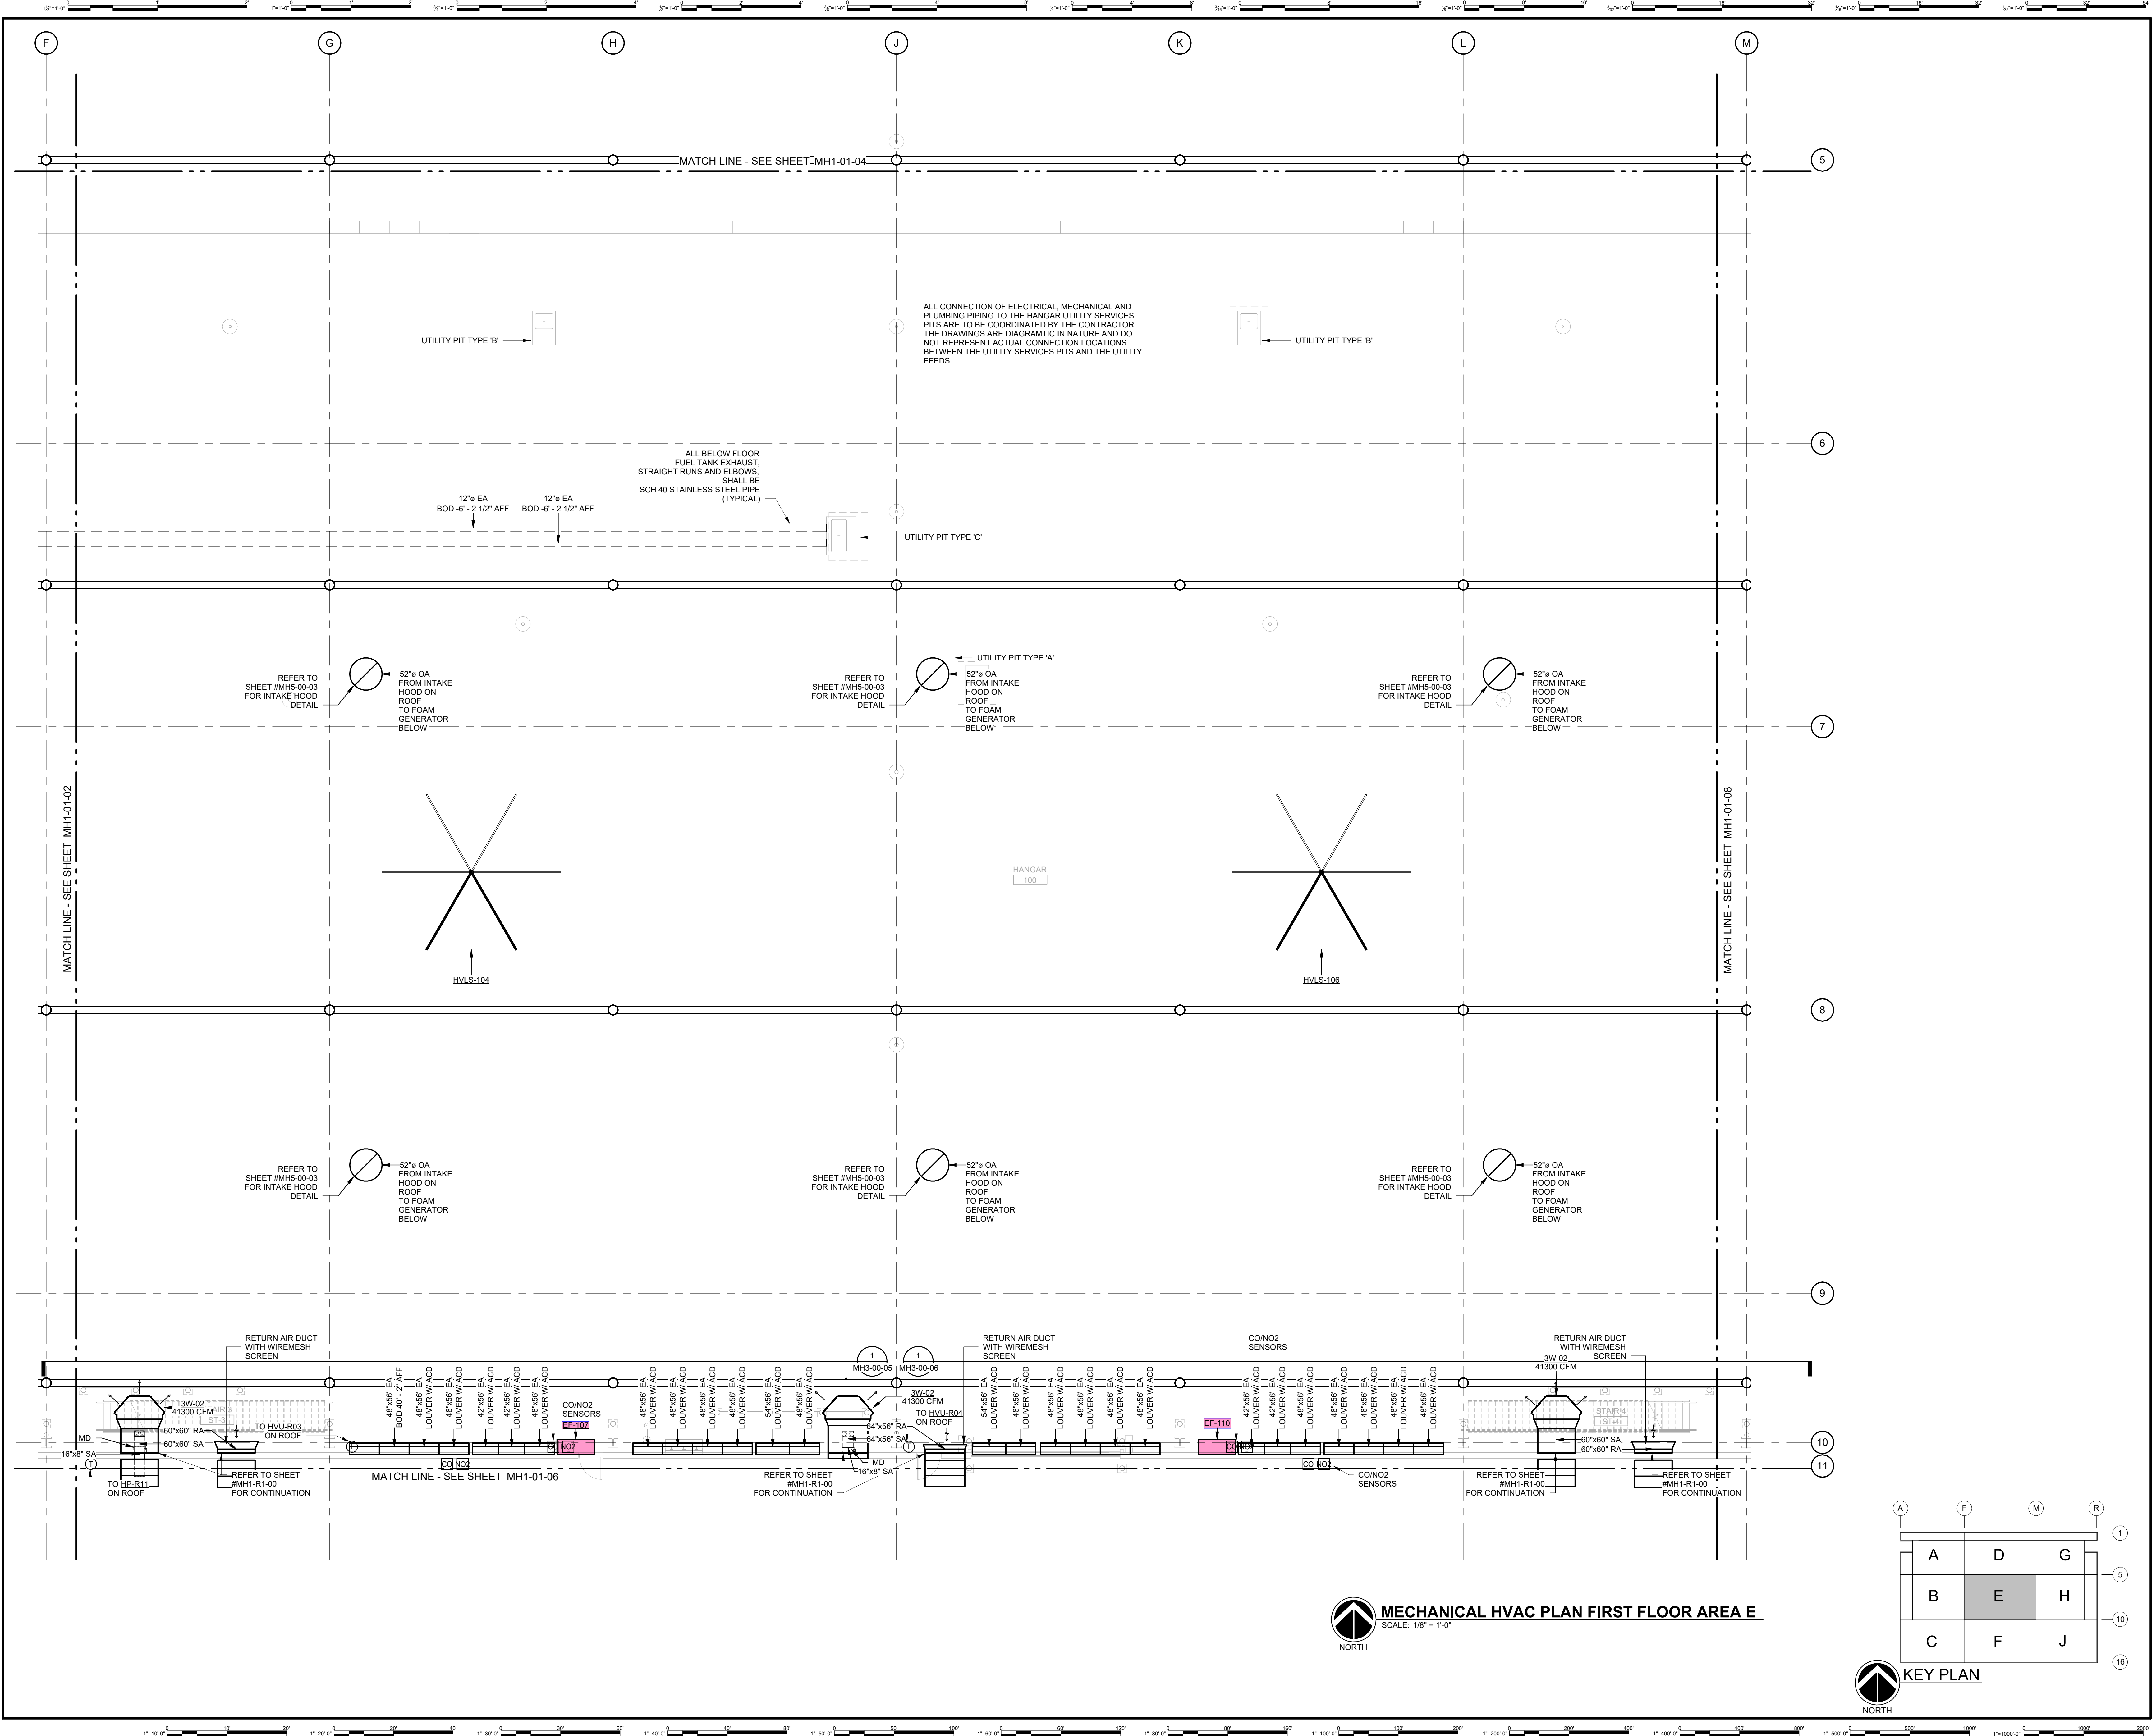

DHL CVG AMC
 CINCINNATI/NORTHERN KENTUCKY
 INTERNATIONAL AIRPORT
 410 WENDELL H. FORD BLVD
 ERLANGER, KY 41018

CONTRACTOR INFORMATION
 ESTD 1951
PERFECTION GROUP
 2649 COMMERCE BLVD.
 CINCINNATI, OHIO 45241
 TEL +1.513.772.7545

ARCHITECT/ENGINEER INFORMATION
GHAFFARI
 122 SOUTH MICHIGAN AVENUE
 SUITE 1600
 CHICAGO, IL 60603-8152 USA
 TEL +1.312.884.2300
 www.ghaffari.com


SHOP DRAWING

REV	DATE	ISSUED FOR CONSTRUCTION	DOC REL ## - DESCRIPTION
1	01/02/25	ISSUED FOR CONSTRUCTION	

PROJECT # 241054
 PROJECT MANAGER E. RICE
 DESIGNED BY T. JANZEN
 DRAWN BY T. JANZEN
 QUALITY CHECK C. LONG
 SHEET TITLE

MECHANICAL HVAC PLAN FIRST FLOOR AREA E
MH1-01-05
 SHEET NUMBER

MECHANICAL HVAC PLAN FIRST FLOOR AREA E
 SCALE: 1/8" = 1'-0"

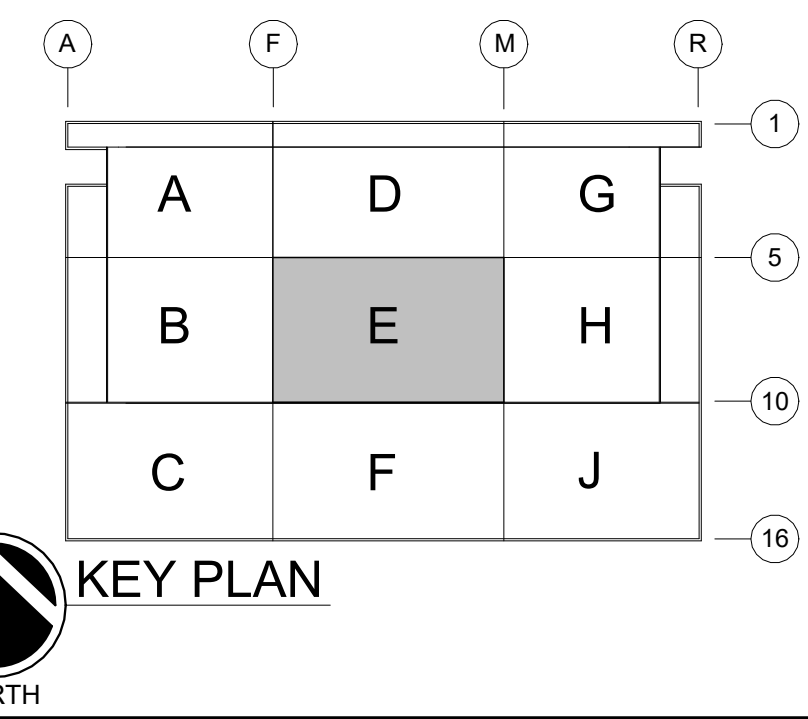

GHAFFARI ASSOCIATES © 2023 1/15/2025 8:27:56 AM



DHL CVG AMC
CINCINNATI/NORTHERN KENTUCKY
INTERNATIONAL AIRPORT
410 WENDELL H. FORD BLVD
ERLANGER, KY 41018

CONTRACTOR INFORMATION

ESTD 1951
PERFECTION GROUP
2649 COMMERCE BLVD.
CINCINNATI, OHIO 45241
TEL +1.513.772.7545

ARCHITECT/ENGINEER INFORMATION

GHAFFARI
122 SOUTH MICHIGAN AVENUE SUITE 1600
CHICAGO, IL 60603-8152 USA
TEL +1.312.984.2300
www.ghaffari.com

SHOP DRAWING


1 01/02/25 ISSUED FOR CONSTRUCTION

REV DATE DOC REL ## - DESCRIPTION


PROJECT # 241054
PROJECT MANAGER E. RICE
DESIGNED BY T. JANZEN
DRAWN BY T. JANZEN
QUALITY CHECK C. LONG
SHEET TITLE

MECHANICAL HVAC PLAN FIRST FLOOR AREA F

MH1-01-06
SHEET NUMBER

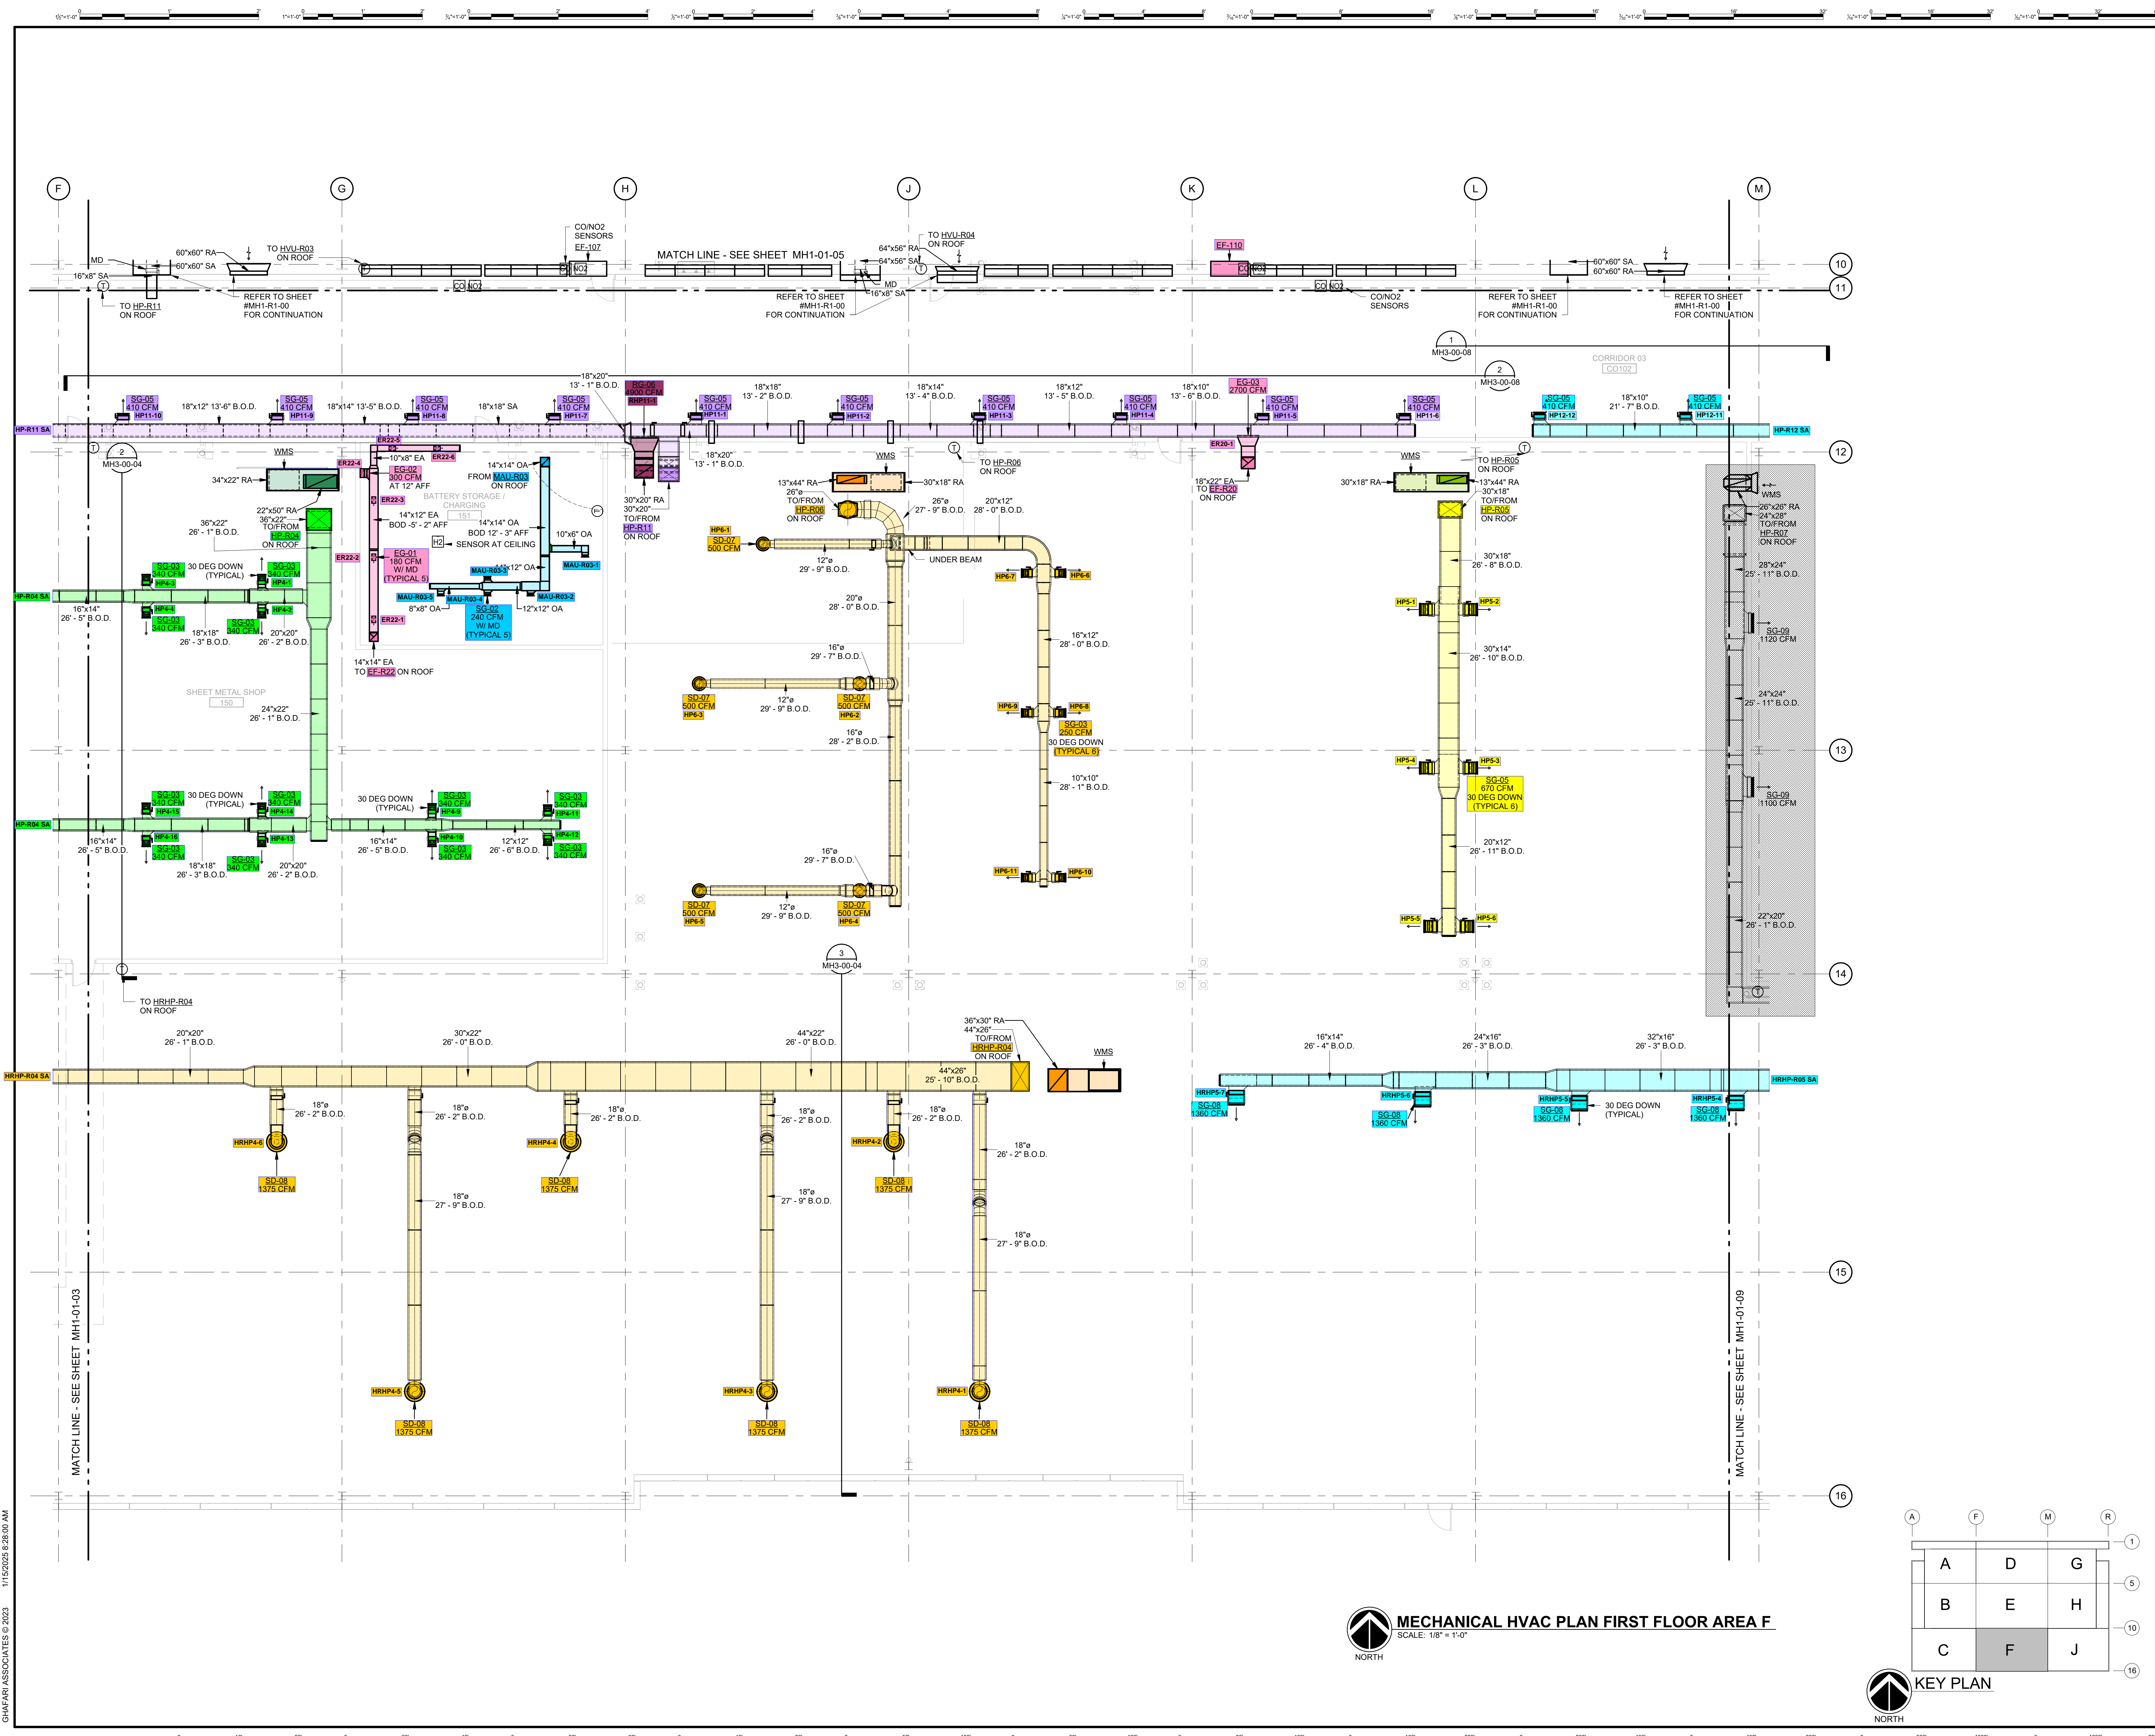

MECHANICAL HVAC PLAN FIRST FLOOR AREA F
SCALE: 1/8" = 1'-0"

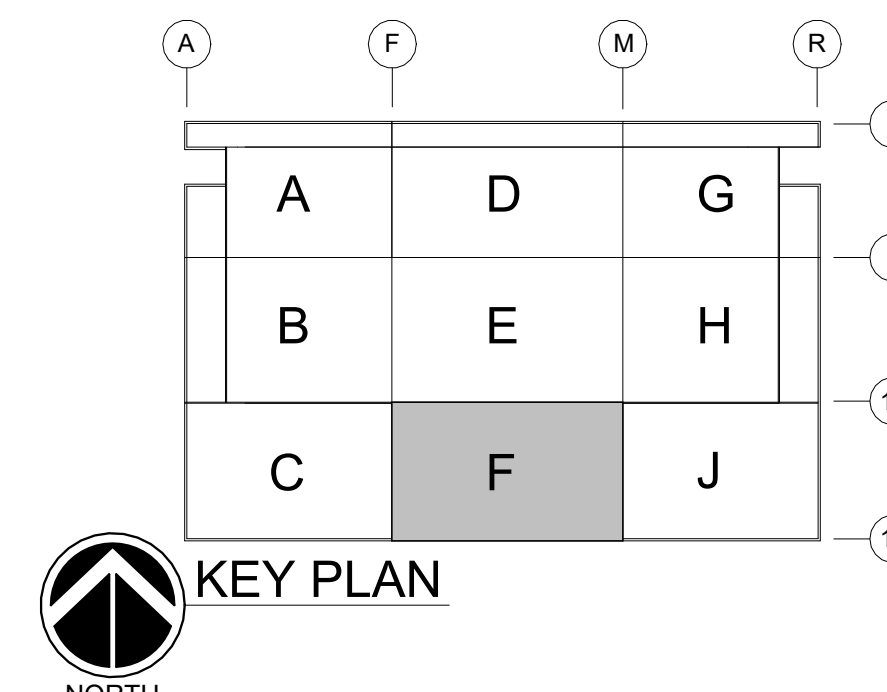

GHAFFARI ASSOCIATES © 2023 1/15/2025 8:28:00 AM



DHL CVG AMC
CINCINNATI/NORTHERN KENTUCKY
INTERNATIONAL AIRPORT
410 WENDELL H. FORD BLVD
ERLANGER, KY 41018

CONTRACTOR INFORMATION

ESTD 1951
PERFECTION GROUP
2649 COMMERCE BLVD.
CINCINNATI, OHIO 45241
TEL +1.513.772.7545

ARCHITECT/ENGINEER INFORMATION

GHAFARI
122 SOUTH MICHIGAN AVENUE
SUITE 1600
CHICAGO, IL 60603-8152 USA
TEL +1.312.984.2300
www.ghafari.com


SHOP DRAWING

1 01/02/25 ISSUED FOR CONSTRUCTION
REV DATE DOC REL ## - DESCRIPTION


PROJECT # 241054
PROJECT MANAGER E. RICE
DESIGNED BY T. JANZEN
DRAWN BY T. JANZEN
QUALITY CHECK C. LONG
SHEET TITLE

MECHANICAL HVAC PLAN FIRST FLOOR AREA G

MH1-01-07
SHEET NUMBER

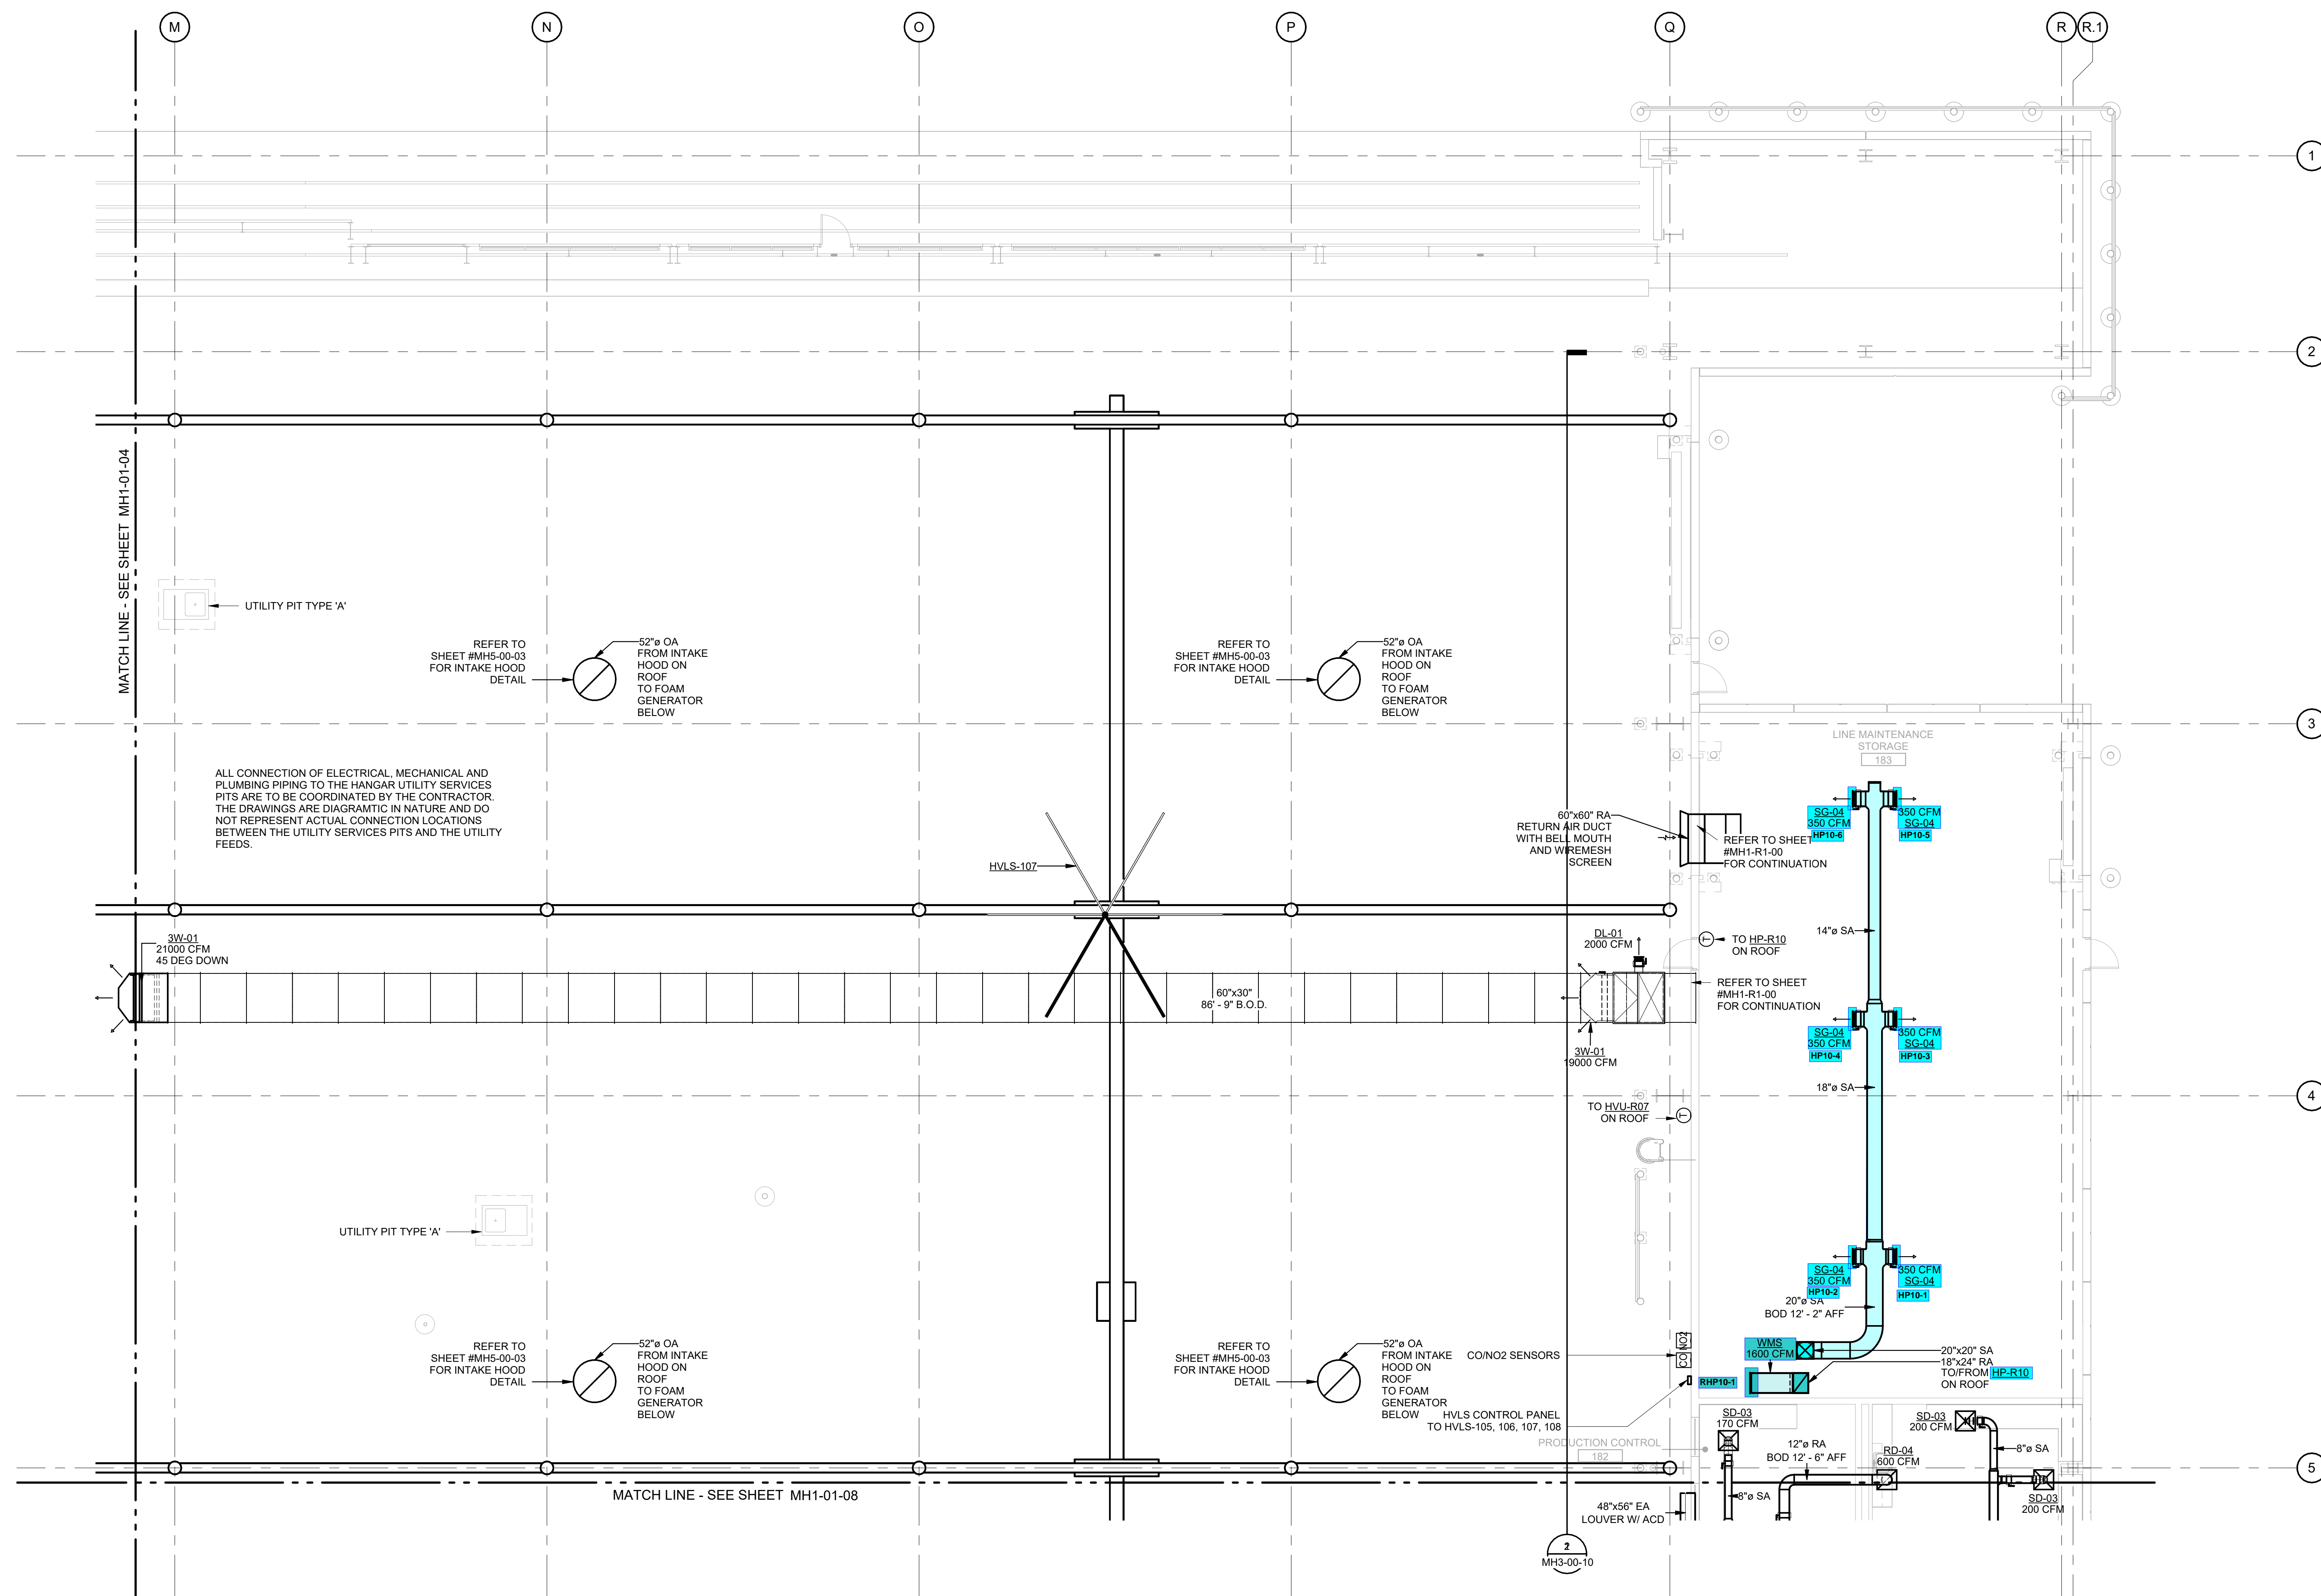

MECHANICAL HVAC PLAN FIRST FLOOR AREA G
SCALE: 1/8" = 1'-0"

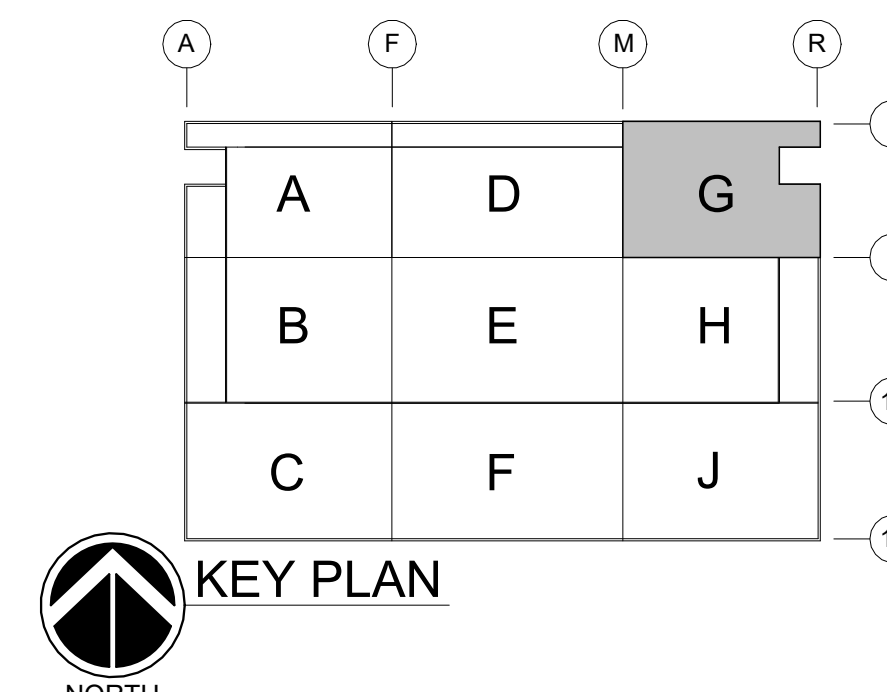

GHAFARI ASSOCIATES © 2023 1/15/2025 8:28:02 AM

CONTRACTOR INFORMATION

ESTD 1951
PERFECTION GROUP
2649 COMMERCE BLVD.
CINCINNATI, OHIO 45241
TEL +1.513.772.7545

ARCHITECT/ENGINEER INFORMATION

GHAFFARI
122 SOUTH MICHIGAN AVENUE
SUITE 1600
CHICAGO, IL 60603-8152 USA
TEL +1.312.984.2300
www.ghaffari.com


SHOP DRAWING

1	01/02/25	ISSUED FOR CONSTRUCTION
REV	DATE	DOC REL ## - DESCRIPTION


PROJECT #	241054
PROJECT MANAGER	E. RICE
DESIGNED BY	T. JANZEN
DRAWN BY	T. JANZEN
QUALITY CHECK	C. LONG
SHEET TITLE	

MECHANICAL HVAC PLAN FIRST FLOOR AREA H

MH1-01-08
SHEET NUMBER

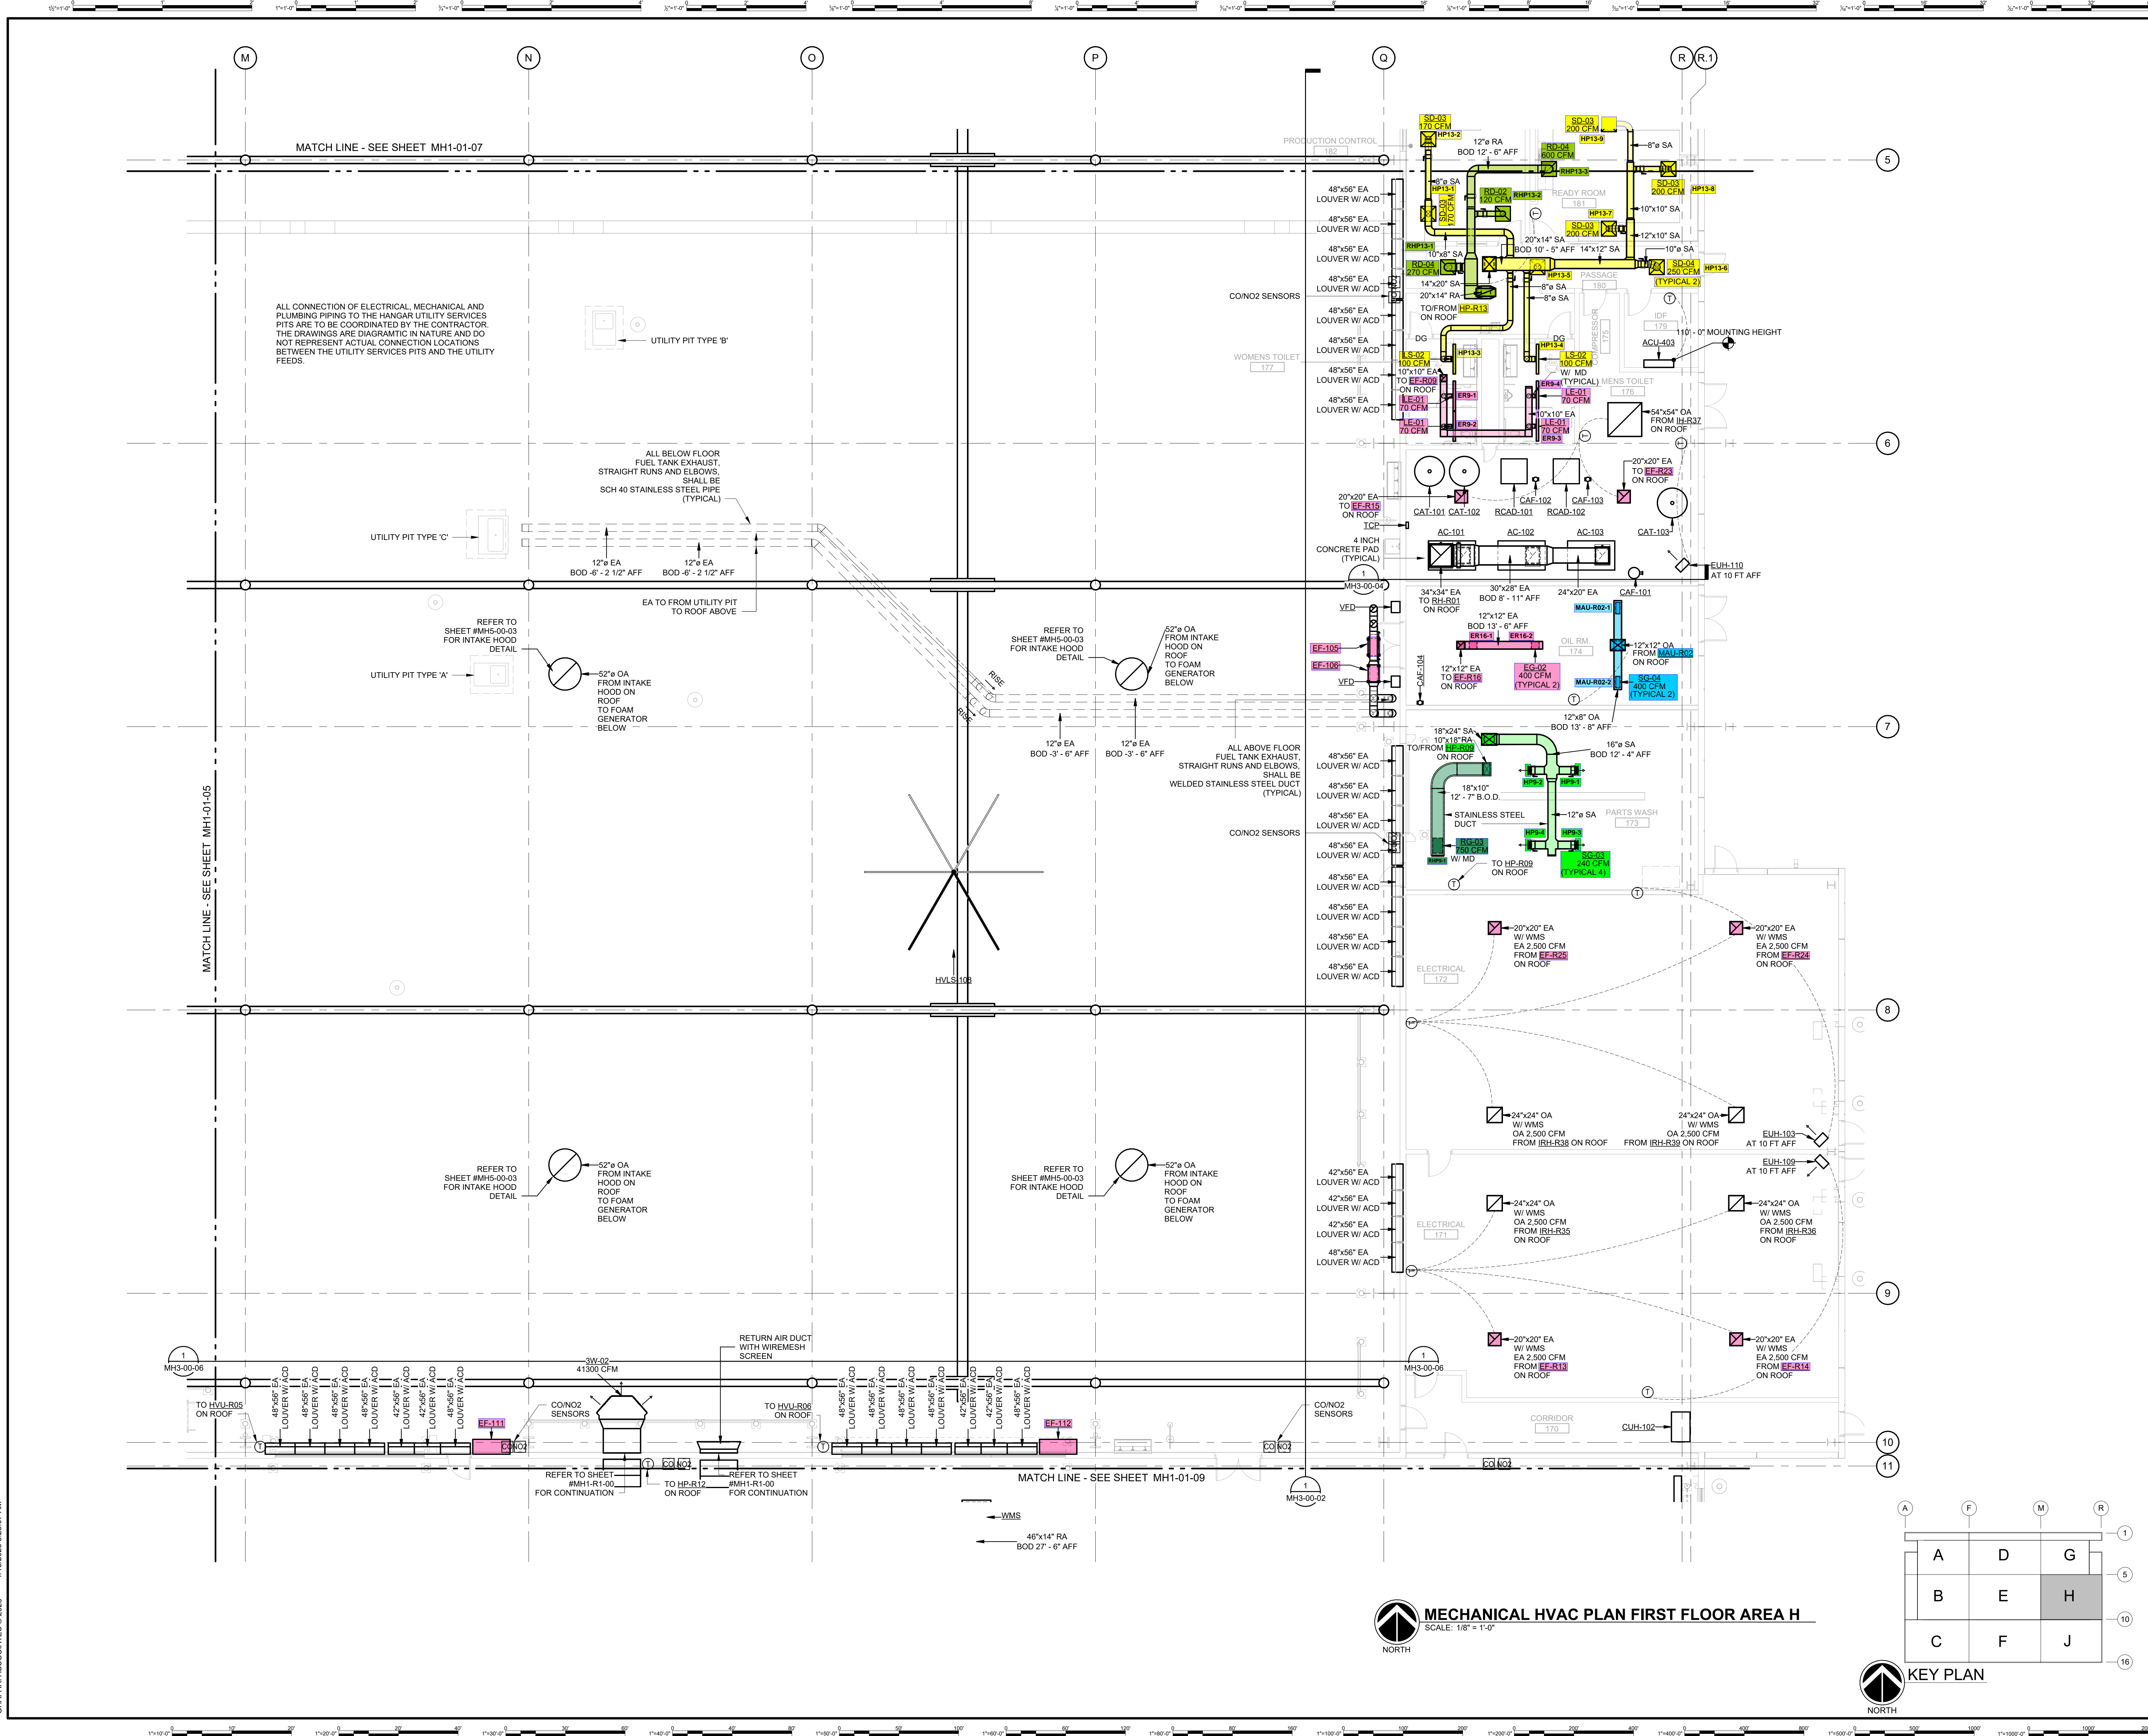

MECHANICAL HVAC PLAN FIRST FLOOR AREA H
SCALE: 1/8" = 1'-0"

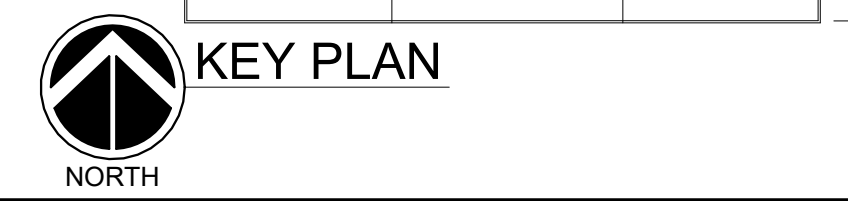



DHL CVG AMC
CINCINNATI/NORTHERN KENTUCKY
INTERNATIONAL AIRPORT
410 WENDELL H. FORD BLVD
ERLANGER, KY 41018

CONTRACTOR INFORMATION

ESTD 1951
PERFECTION GROUP
2649 COMMERCE BLVD.
CINCINNATI, OHIO 45241
TEL +1.513.772.7545

ARCHITECT/ENGINEER INFORMATION

GHAFFARI

122 SOUTH MICHIGAN AVENUE
SUITE 1600
CHICAGO, IL 60603-8152 USA
TEL +1.312.984.2300
www.ghaffari.com


SHOP DRAWING

1	01/02/25	ISSUED FOR CONSTRUCTION
REV	DATE	DOC REL ## - DESCRIPTION


PROJECT #	241054
PROJECT MANAGER	E. RICE
DESIGNED BY	T. JANZEN
DRAWN BY	T. JANZEN
QUALCHECK	C. LONG
SHEET TITLE	

**MECHANICAL HVAC PLAN
FIRST FLOOR
AREA J**

MH1-01-09
SHEET NUMBER

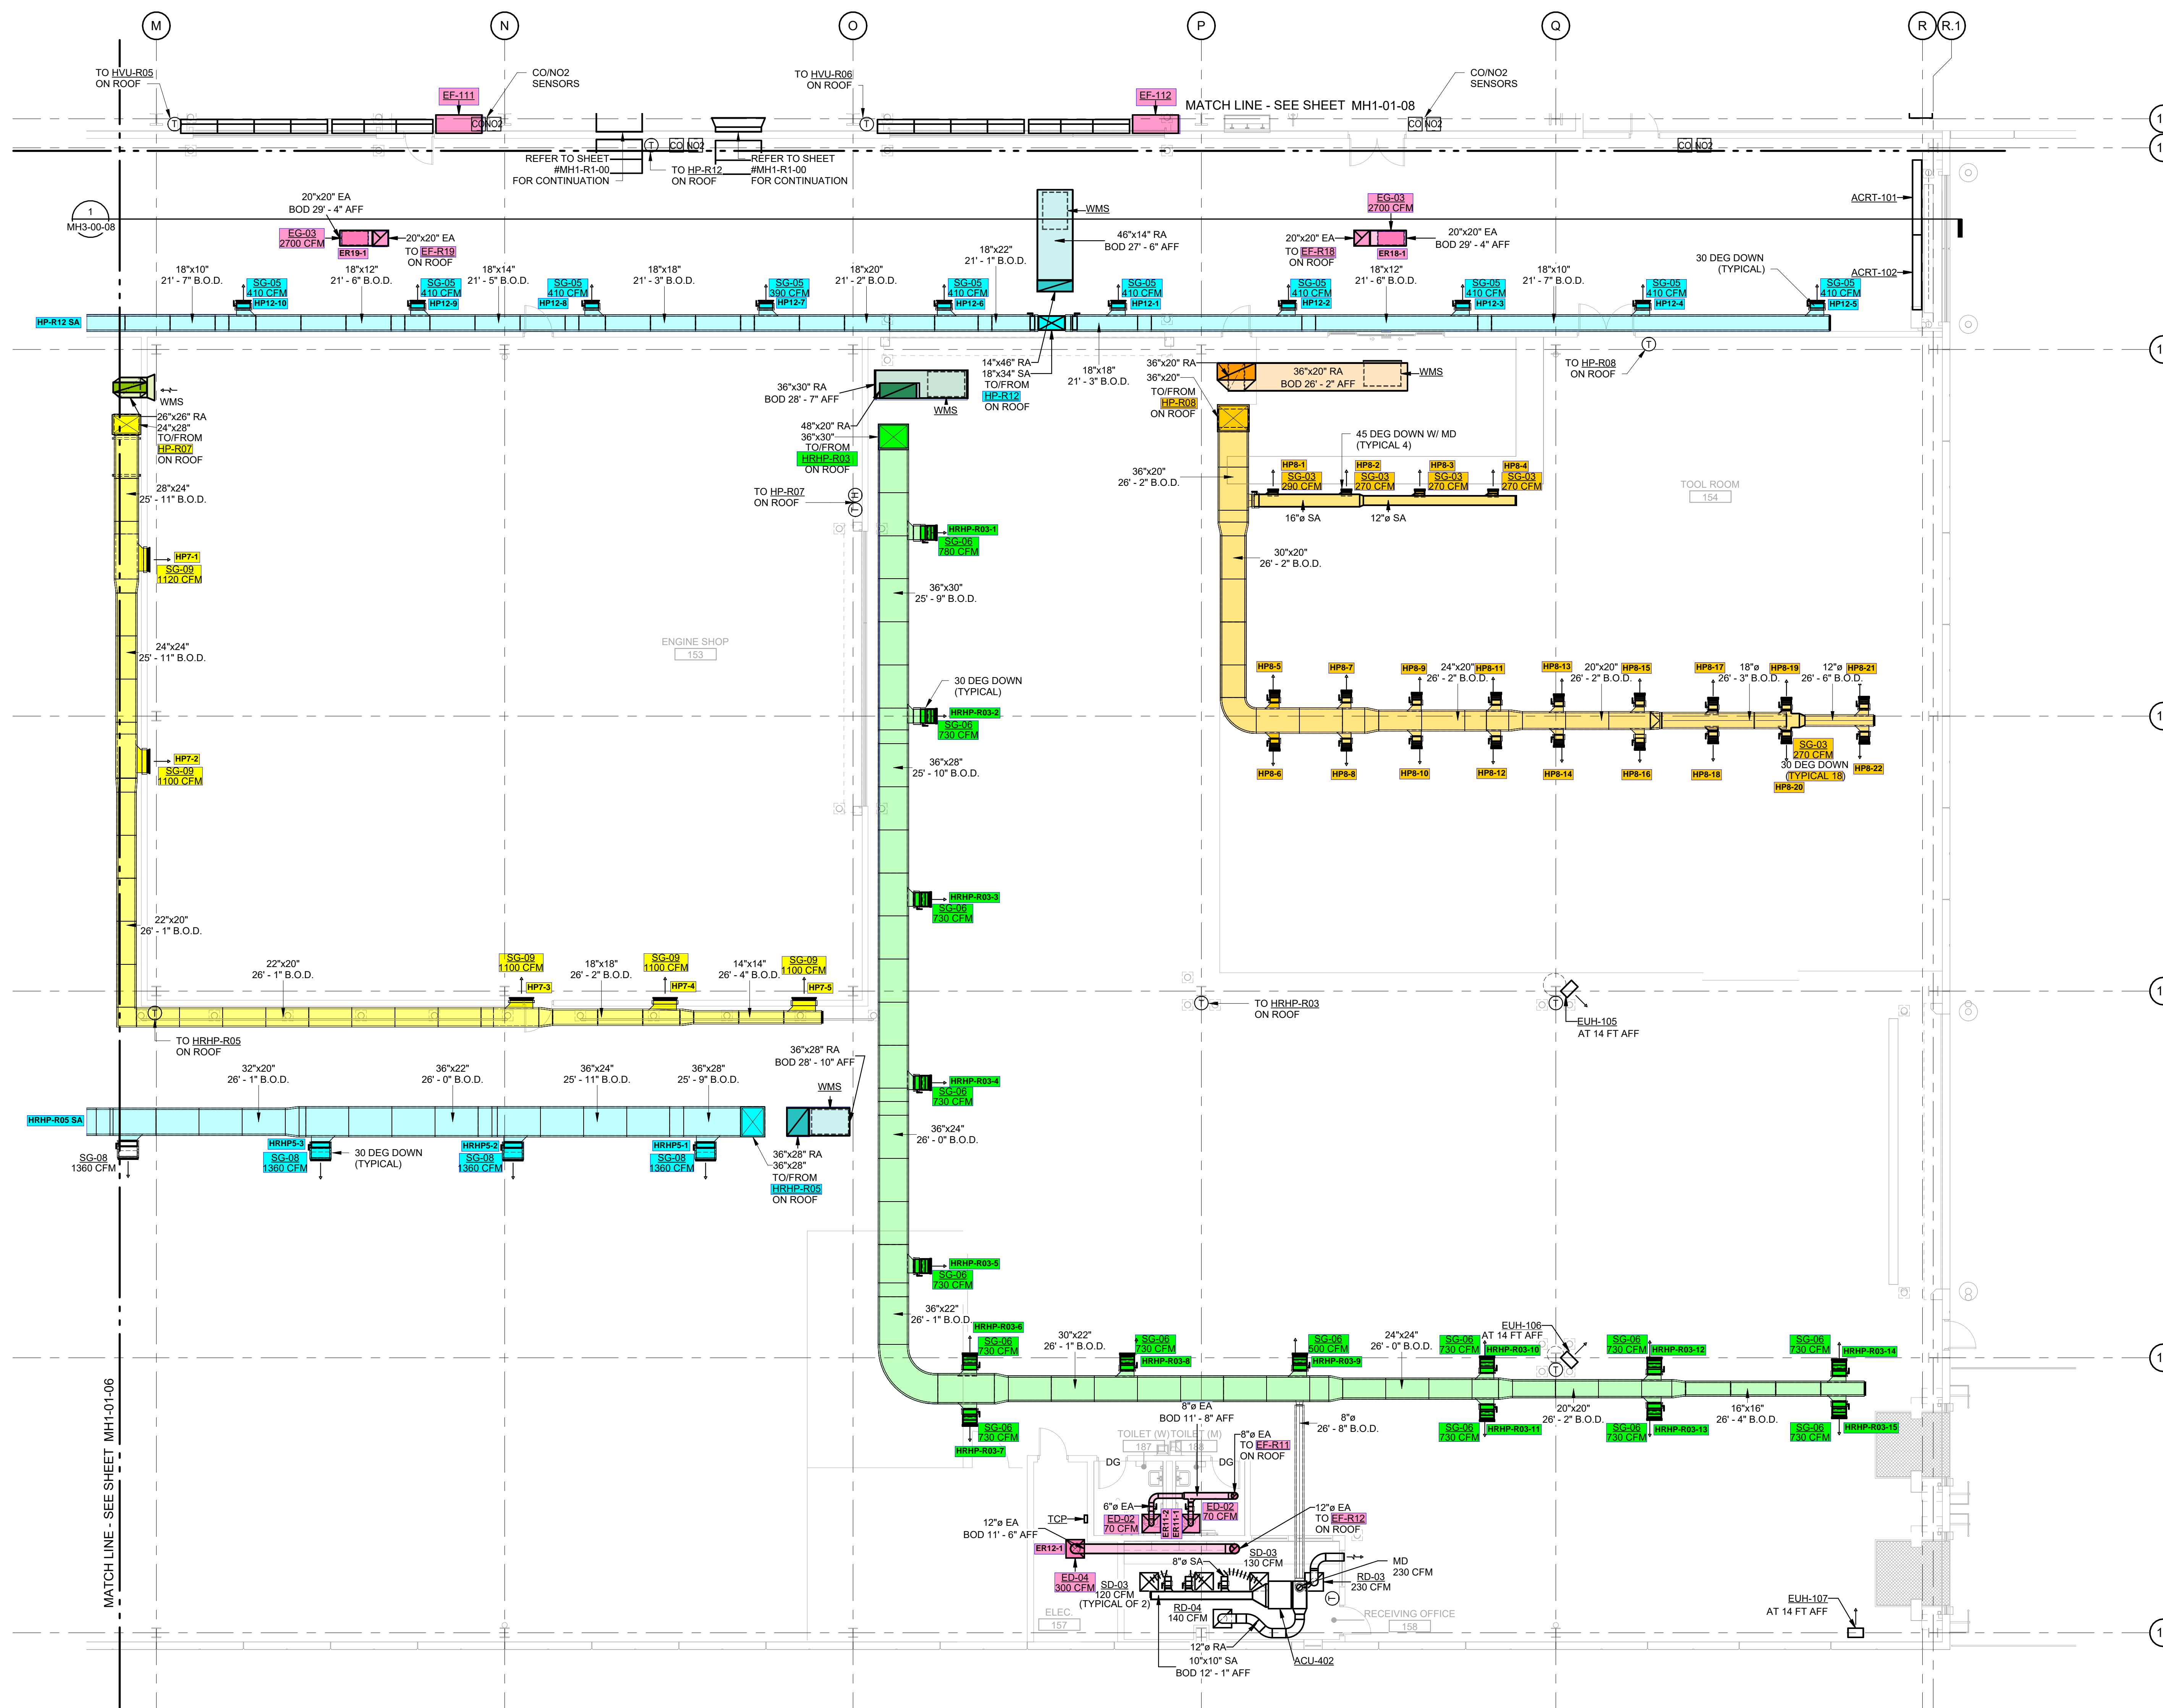

MECHANICAL HVAC PLAN FIRST FLOOR AREA J
SCALE: 1/8" = 1'-0"

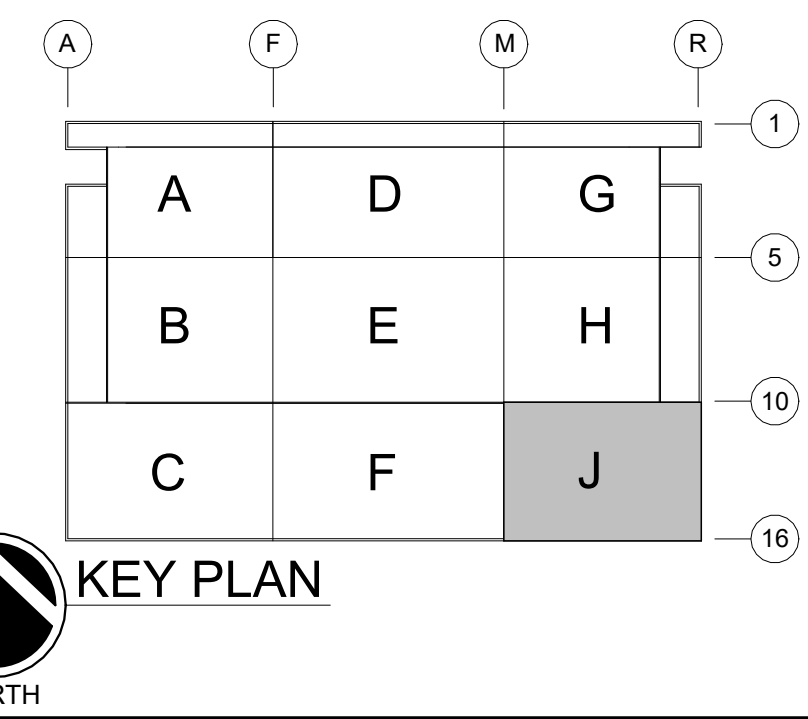

GHAFFARI ASSOCIATES © 2023 1/15/2025 8:28:11 AM



DHL CVG AMC
CINCINNATI/NORTHERN KENTUCKY
INTERNATIONAL AIRPORT
410 WENDELL H. FORD BLVD
ERLANGER, KY 41018

CONTRACTOR INFORMATION

ESTD 1951
PERFECTION GROUP
2649 COMMERCE BLVD.
CINCINNATI, OHIO 45241
TEL +1.513.772.7545

ARCHITECT/ENGINEER INFORMATION

GHAFFARI

122 SOUTH MICHIGAN AVENUE
SUITE 1600
CHICAGO, IL 60603-8152 USA
TEL +1.312.984.2300
www.ghaffari.com



**SHOP
DRAWING**

1	01/02/25	ISSUED FOR CONSTRUCTION
REV	DATE	DOC REL # - DESCRIPTION

PROJECT #	241054
PROJECT MANAGER	E. RICE
DESIGNED BY	T. JANZEN
DRAWN BY	T. JANZEN
QUALITY CHECK	C. LONG
SHEET TITLE	

**MECHANICAL
HVAC PLAN
SECOND FLOOR
AREA C**

MH1-02-03
SHEET NUMBER

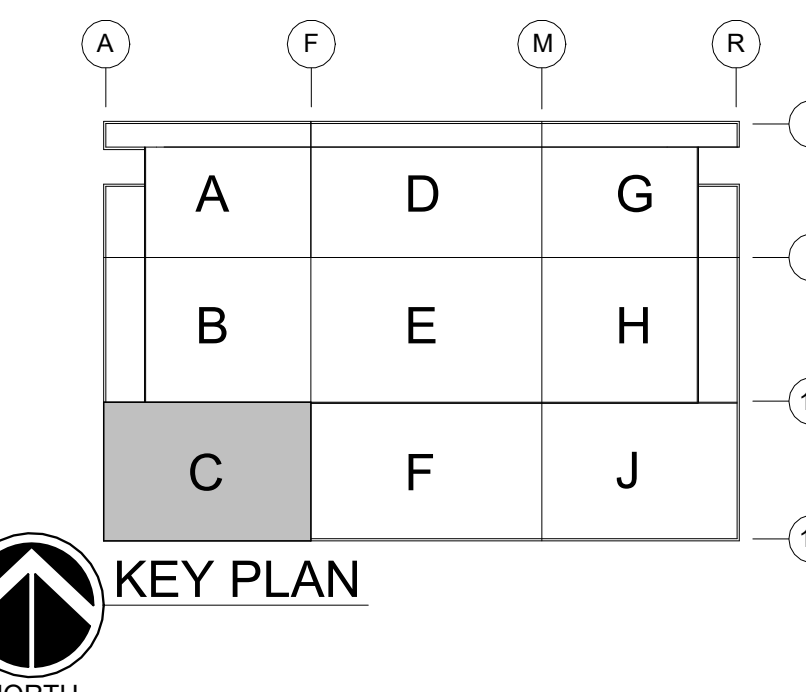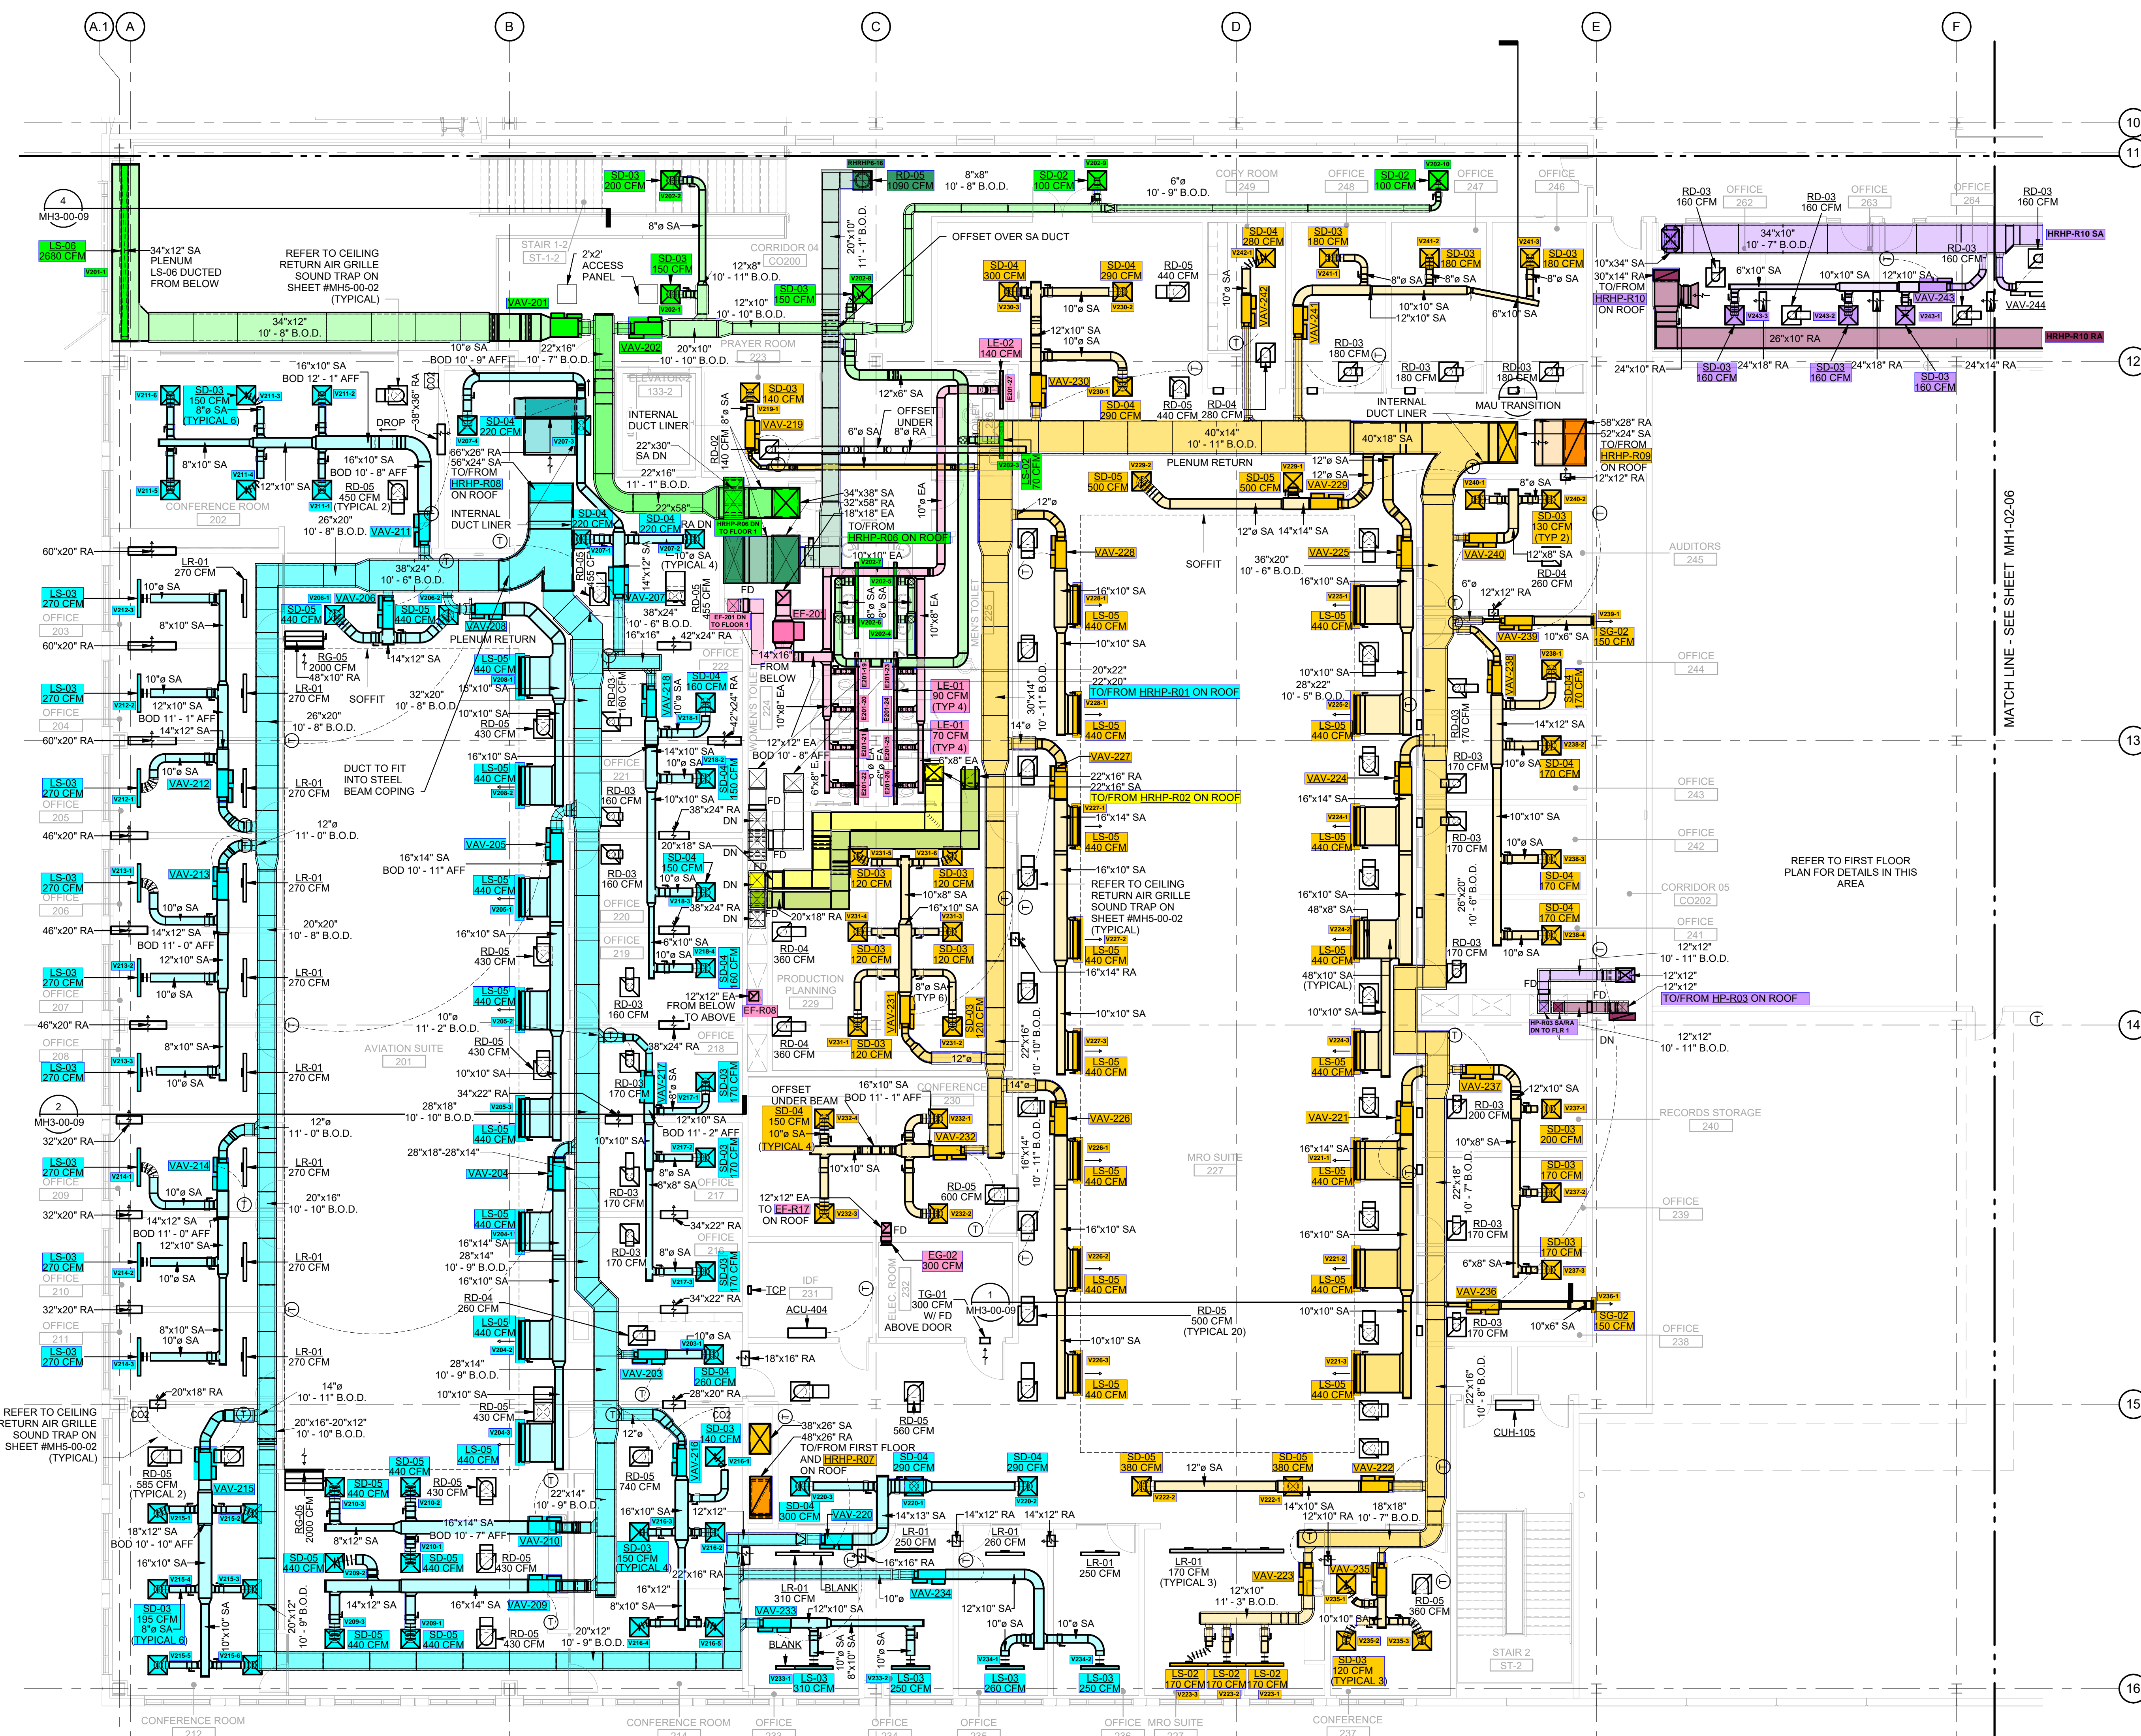

MECHANICAL HVAC PLAN SECOND FLOOR AREA C
SCALE: 1/8" = 1'-0"
NORTH

GHAFFARI ASSOCIATES © 2023 11/5/2025 8:28:21 AM



DHL CVG AMC
 CINCINNATI/NORTHERN KENTUCKY
 INTERNATIONAL AIRPORT
 410 WENDELL H. FORD BLVD
 ERLANGER, KY 41018

CONTRACTOR INFORMATION

ESTD 1951
PERFECTION GROUP
 2649 COMMERCE BLVD.
 CINCINNATI, OHIO 45241
 TEL +1.513.772.7545

ARCHITECT/ENGINEER INFORMATION

GHAFFARI

122 SOUTH MICHIGAN AVENUE
 SUITE 1600
 CHICAGO, IL 60603-8152 USA
 TEL +1.312.984.2300
 www.ghaffari.com


**SHOP
DRAWING**

1	01/02/25	ISSUED FOR CONSTRUCTION
REV	DATE	DOC REL ## - DESCRIPTION

PROJECT #	241054
PROJECT MANAGER	E. RICE
DESIGNED BY	T. JANZEN
DRAWN BY	T. JANZEN
QUALCHECK	C. LONG
SHEET TITLE	

**MECHANICAL
HVAC PLAN
ROOF
COMPOSITE**

MH1-R1-00
SHEET NUMBER

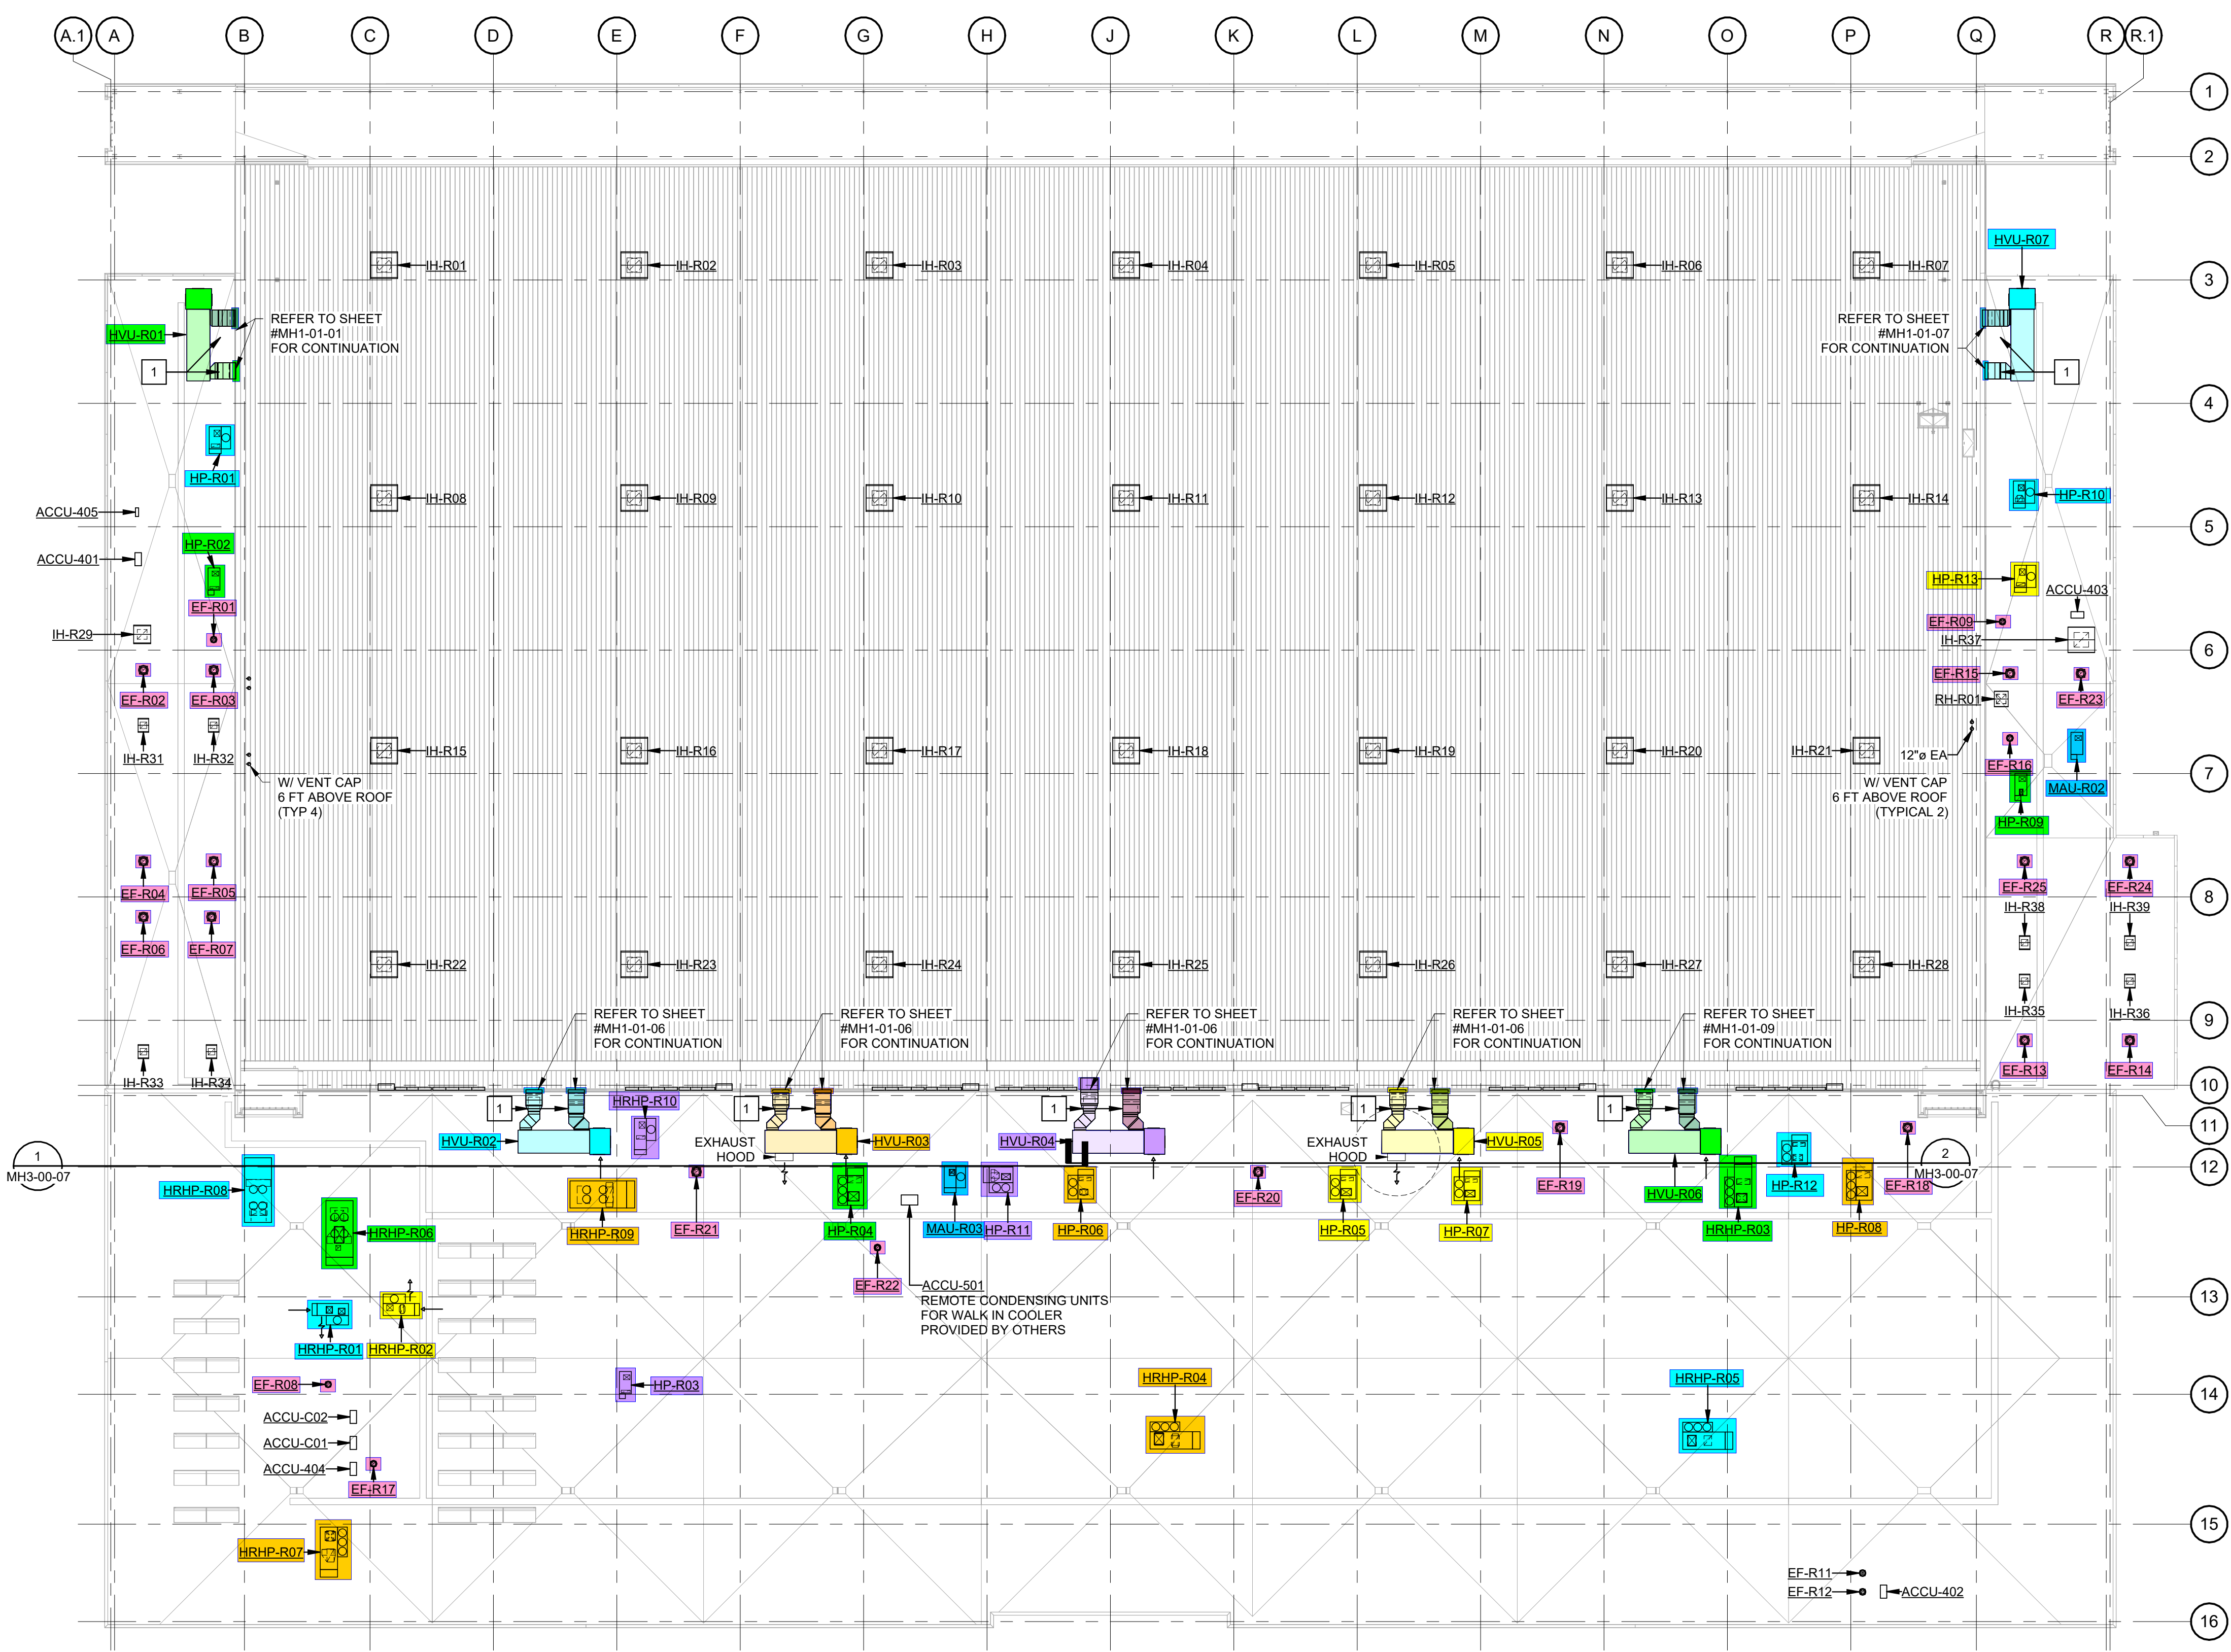

NEW KEY NOTES:

- 1 EXTERIOR SUPPLY AND RETURN DUCT SHALL BE INSULATED WITH DUCT BOARD AND JACKETED WITH STAINLESS STEEL JACKET.

MECHANICAL HVAC PLAN ROOF COMPOSITE
 SCALE: 1" = 30'-0"



GHAFFARI ASSOCIATES © 2023 1/15/2025 8:28:25 AM



DHL CVG AMC
 CINCINNATI/NORTHERN KENTUCKY
 INTERNATIONAL AIRPORT
 410 WENDELL H. FORD BLVD
 ERLANGER, KY 41018

CONTRACTOR INFORMATION

ESTD 1951
PERFECTION GROUP
 2649 COMMERCE BLVD.
 CINCINNATI, OHIO 45241
 TEL +1.513.772.7545

ARCHITECT/ENGINEER INFORMATION

GHAFARI

122 SOUTH MICHIGAN AVENUE
 SUITE 1600
 CHICAGO, IL 60603-8152 USA
 TEL +1.312.984.2300
 www.ghafari.com


**SHOP
 DRAWING**

REV	DATE	ISSUED FOR CONSTRUCTION	DOC REL ## - DESCRIPTION
1	01/02/25	ISSUED FOR CONSTRUCTION	

PROJECT #	241054
PROJECT MANAGER	E. RICE
DESIGNED BY	T. JANZEN
DRAWN BY	T. JANZEN
QUALCHECK	C. LONG
SHEET TITLE	

**MECHANICAL
 HVAC SECTIONS**

MH3-00-01
 SHEET NUMBER

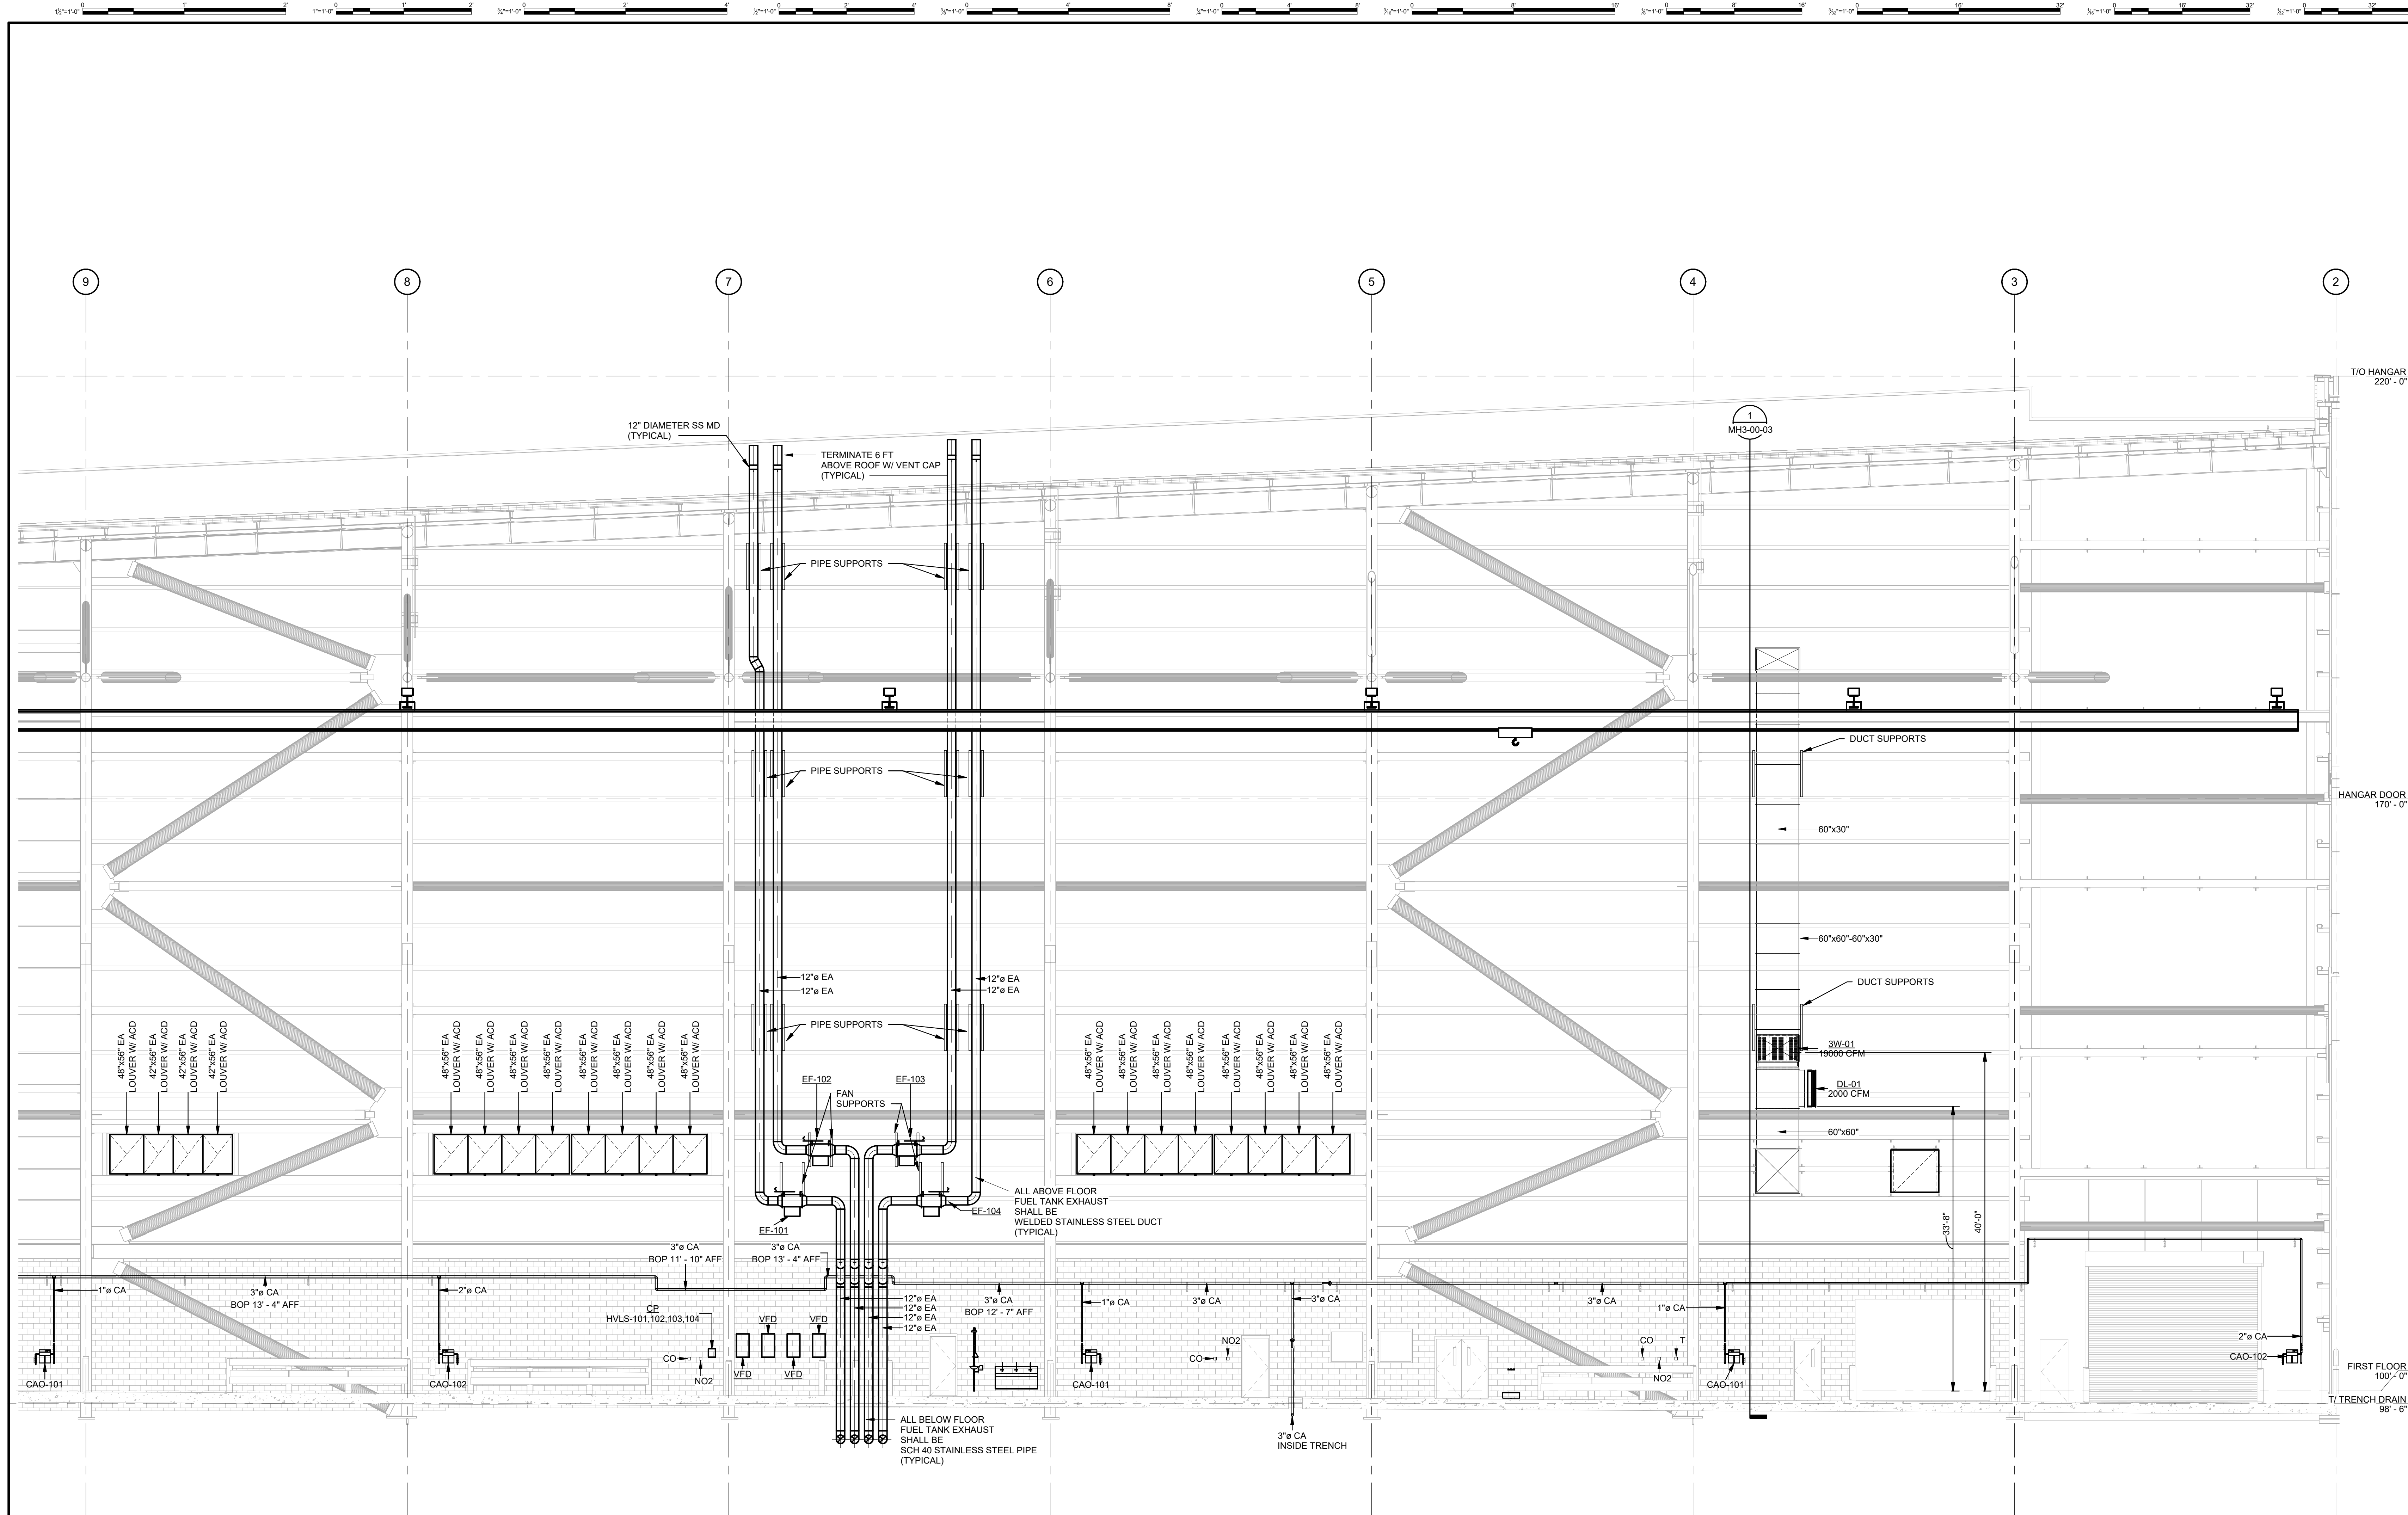

MECHANICAL HVAC SECTION 01 (100 HANGAR - WEST WALL)
 SCALE: 1/8" = 1'-0"

GHAFARI ASSOCIATES © 2023 1/15/2025 8:28:27 AM



DHL CVG AMC
 CINCINNATI/NORTHERN KENTUCKY
 INTERNATIONAL AIRPORT
 410 WENDELL H. FORD BLVD
 ERLANGER, KY 41018

CONTRACTOR INFORMATION


ESTD 1951
PERFECTION GROUP
 2649 COMMERCE BLVD.
 CINCINNATI, OHIO 45241
 TEL +1.513.772.7545

ARCHITECT/ENGINEER INFORMATION

GHAFFARI

122 SOUTH MICHIGAN AVENUE
 SUITE 1600
 CHICAGO, IL 60603-8152 USA
 TEL +1.312.884.2300
 www.ghaffari.com

**SHOP
 DRAWING**

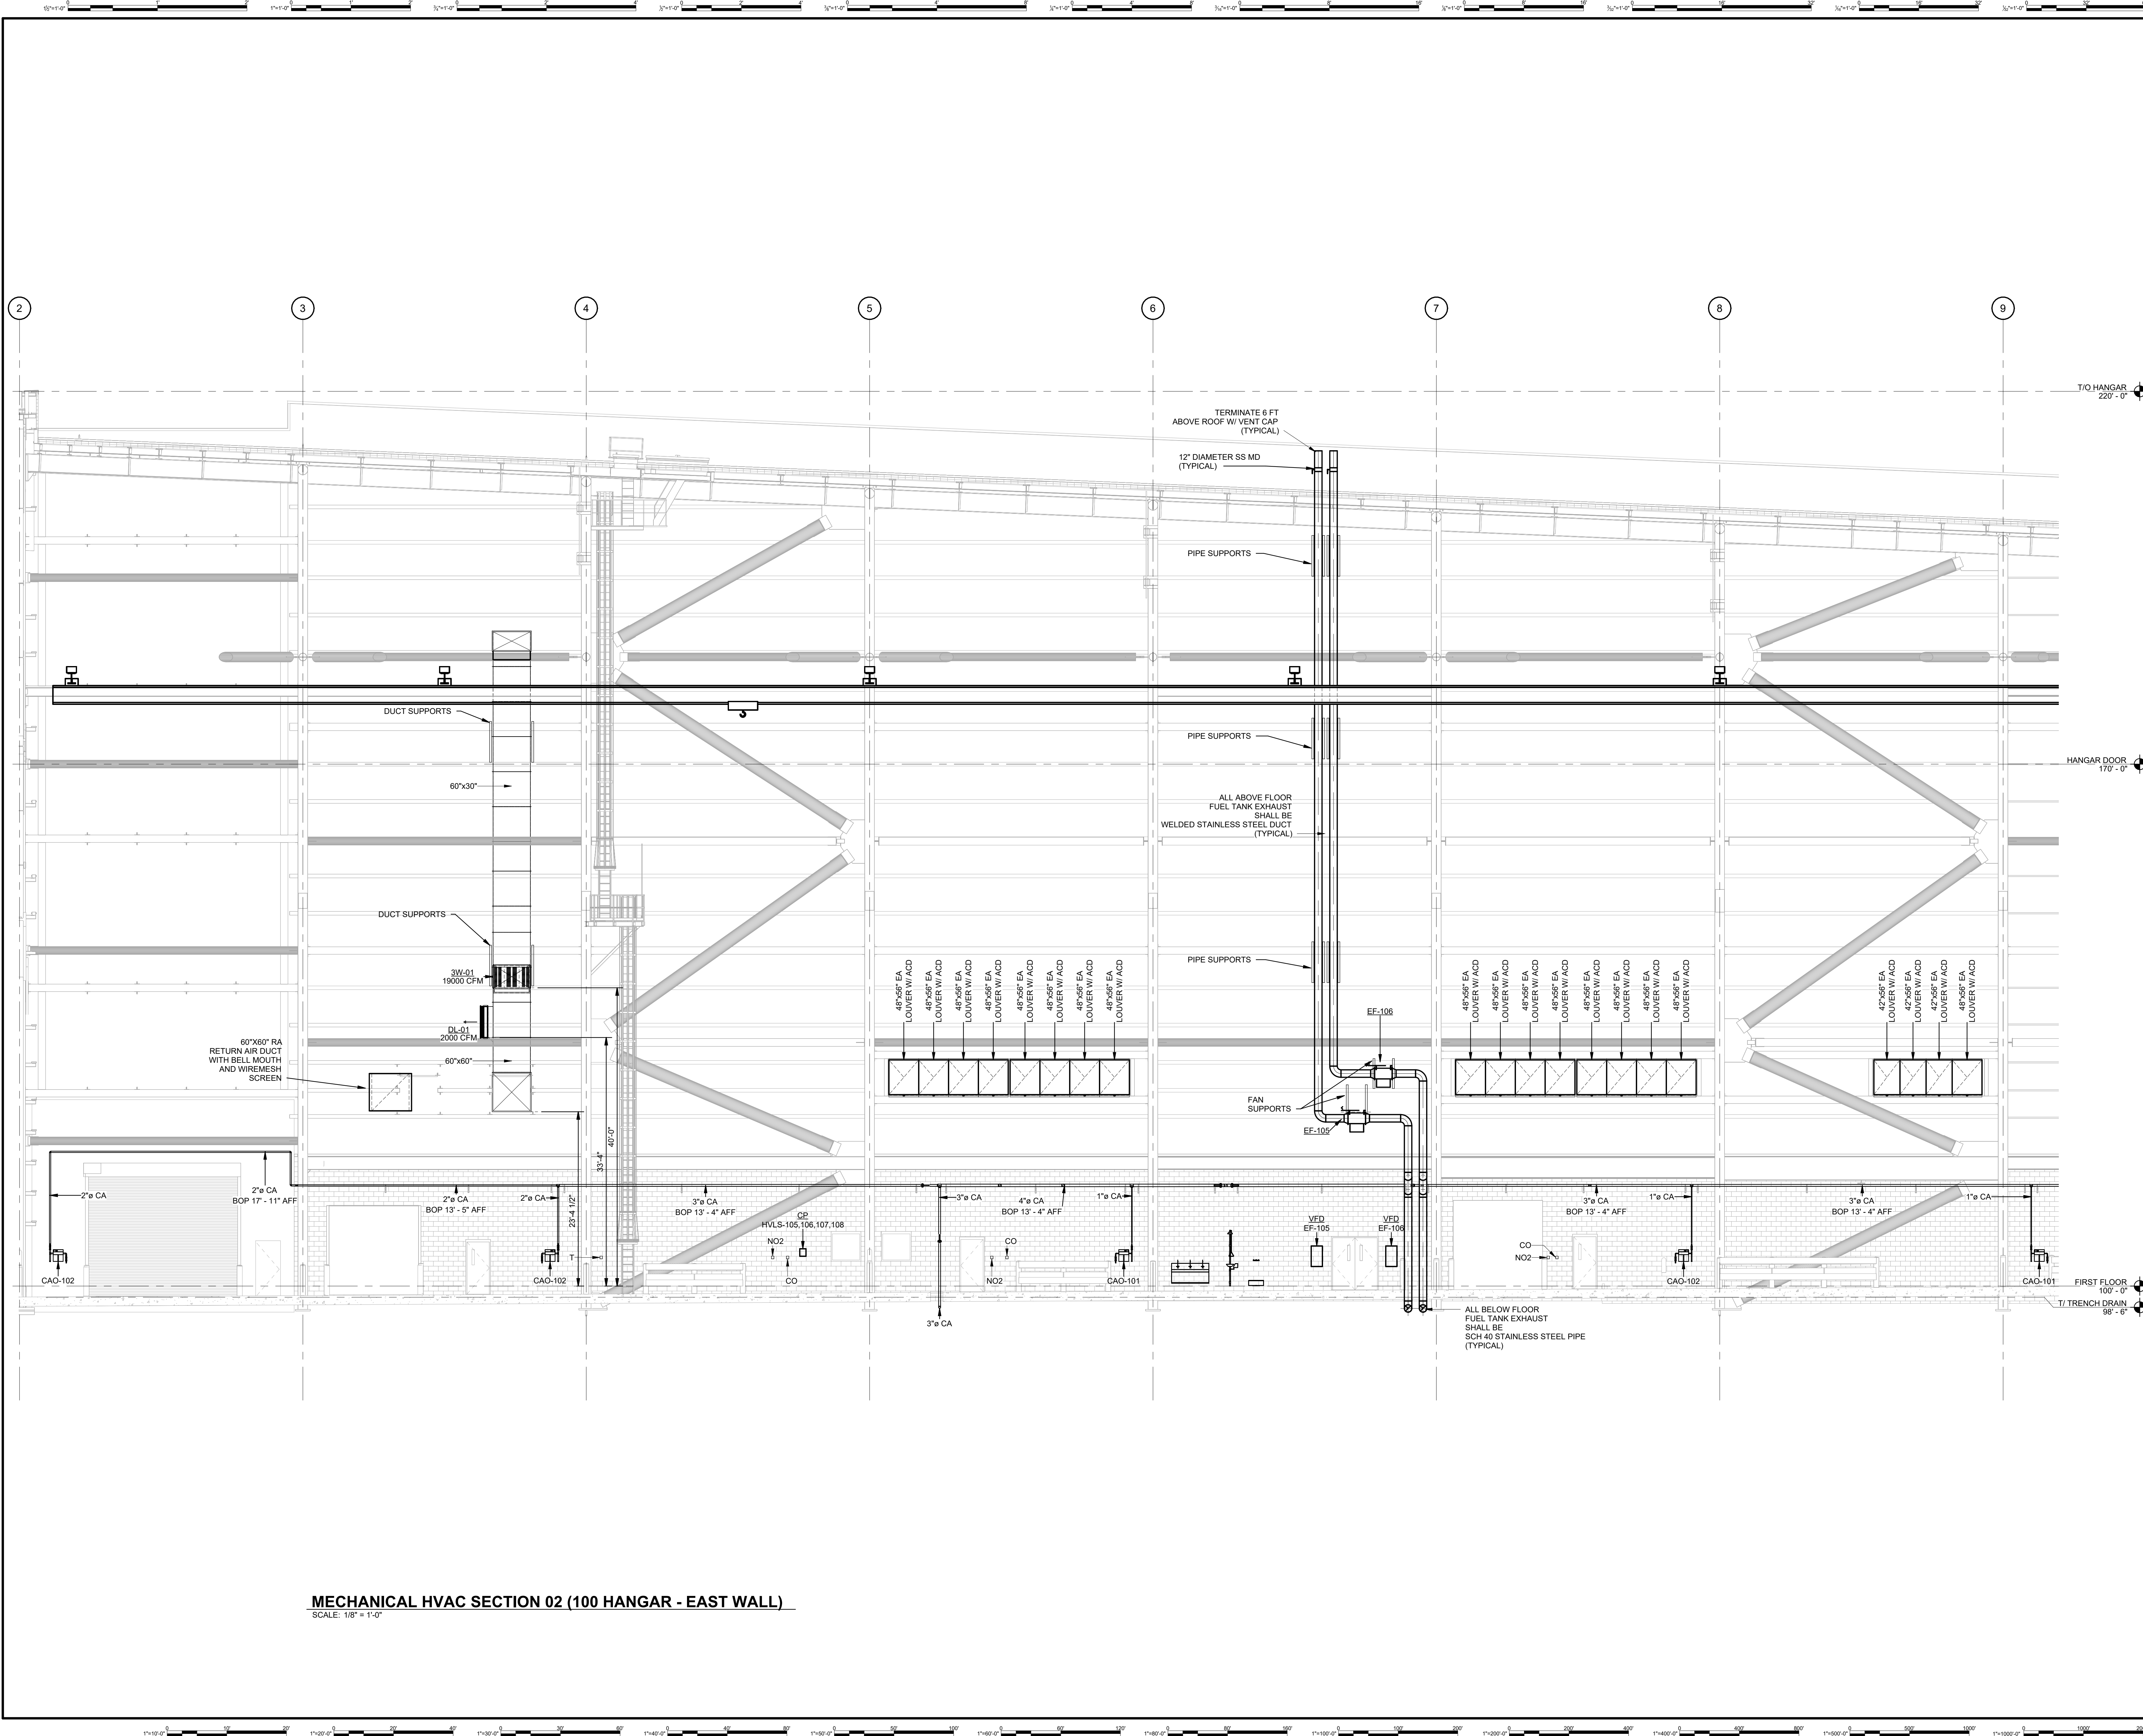

MECHANICAL HVAC SECTION 02 (100 HANGAR - EAST WALL)
 SCALE: 1/8" = 1'-0"

REV	DATE	ISSUED FOR CONSTRUCTION	DOC REL ## - DESCRIPTION
1	01/02/25	ISSUED FOR CONSTRUCTION	

PROJECT #	241054
PROJECT MANAGER	E. RICE
DESIGNED BY	T. JANZEN
DRAWN BY	T. JANZEN
QUALCHECK	C. LONG
SHEET TITLE	

**MECHANICAL
 HVAC SECTIONS**

MH3-00-02
 SHEET NUMBER

GHAFFARI ASSOCIATES © 2023 1/15/2025 8:28:30 AM



DHL CVG AMC
 CINCINNATI/NORTHERN KENTUCKY
 INTERNATIONAL AIRPORT
 410 WENDELL H. FORD BLVD
 ERLANGER, KY 41018

CONTRACTOR INFORMATION


ESTD 1951
PERFECTION GROUP
 2649 COMMERCE BLVD.
 CINCINNATI, OHIO 45241
 TEL +1.513.772.7545

ARCHITECT/ENGINEER INFORMATION

GHAFFARI

122 SOUTH MICHIGAN AVENUE
 SUITE 1600
 CHICAGO, IL 60603-8152 USA
 TEL +1.312.984.2300
 www.ghaffari.com

**SHOP
 DRAWING**

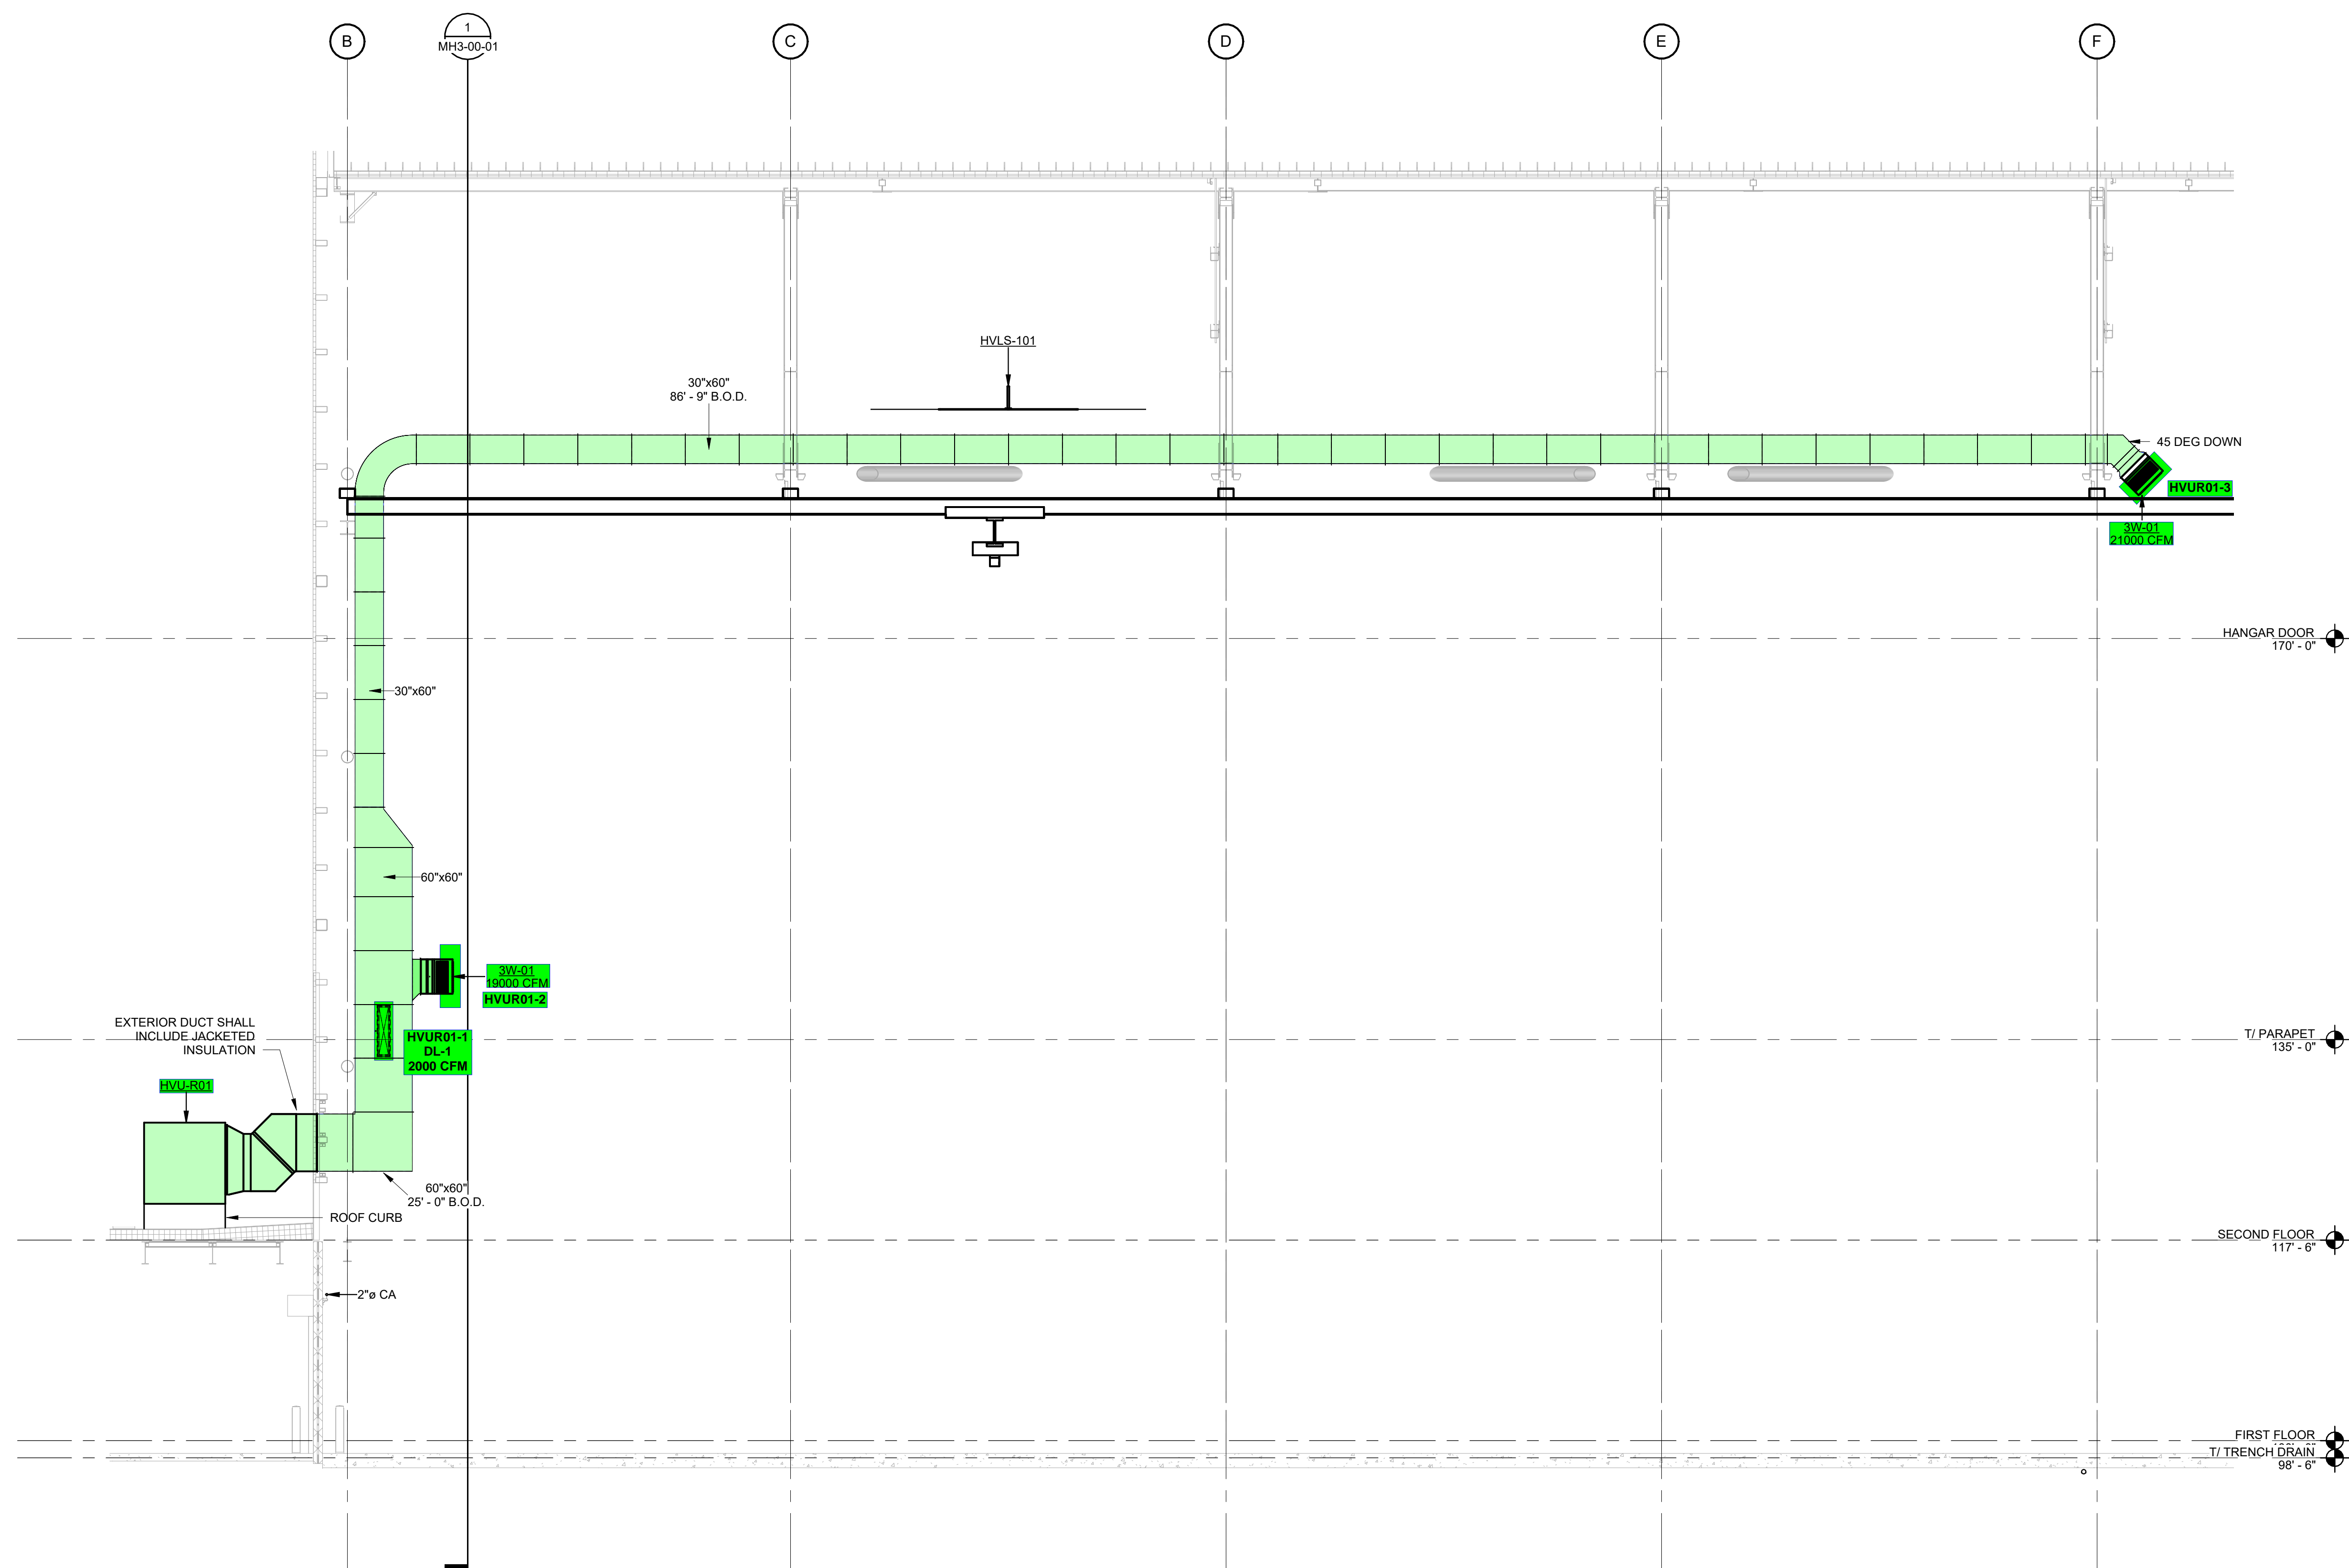

MECHANICAL HVAC SECTION 03 (100 HANGAR)


SCALE: 1/8" = 1'-0"

REV	DATE	DOC REL ## - DESCRIPTION
1	01/02/25	ISSUED FOR CONSTRUCTION

PROJECT #	241054
PROJECT MANAGER	E. RICE
DESIGNED BY	T. JANZEN
DRAWN BY	T. JANZEN
QUALCHECK	C. LONG
SHEET TITLE	

**MECHANICAL
 HVAC SECTIONS**

MH3-00-03
 SHEET NUMBER

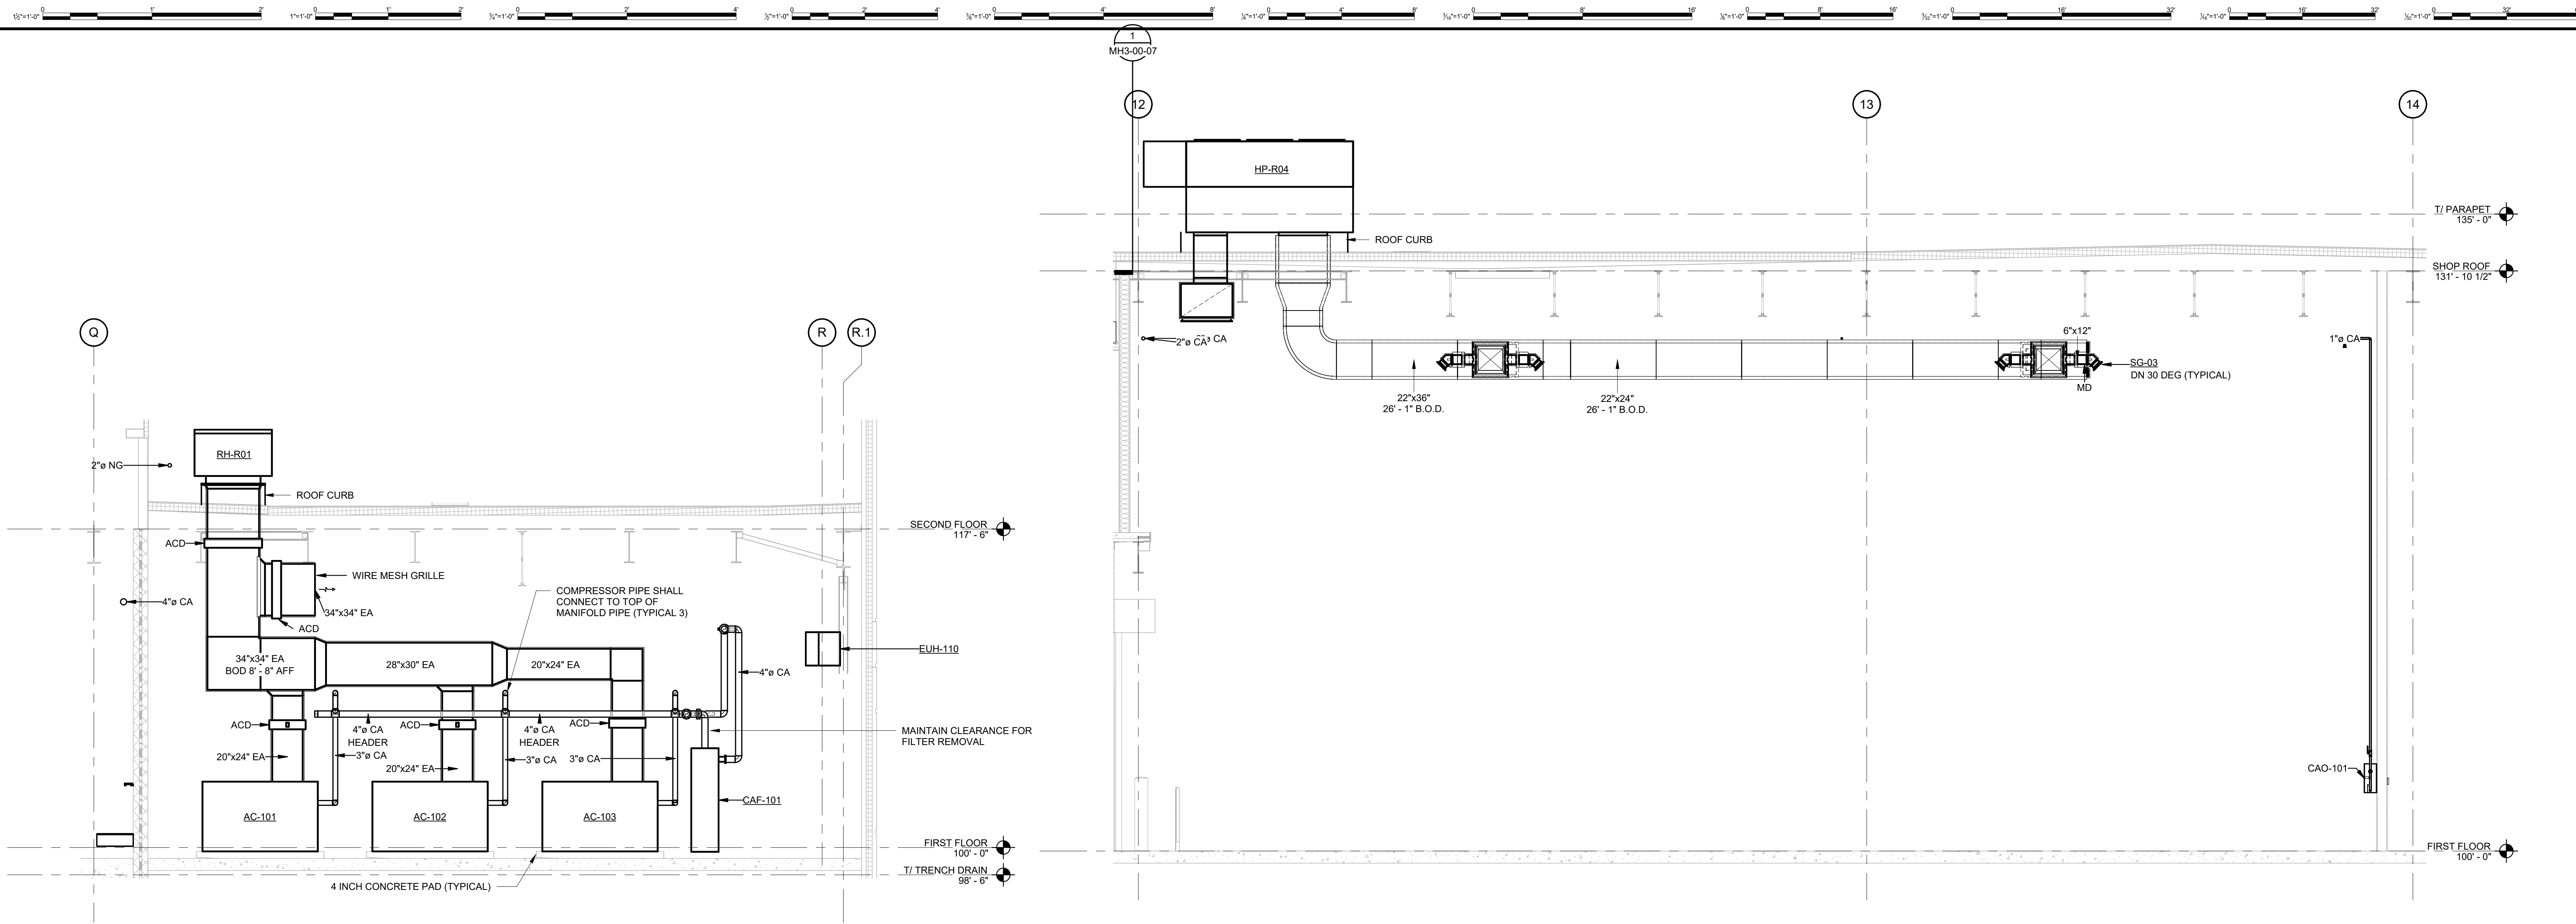

DHL CVG AMC
 CINCINNATI/NORTHERN KENTUCKY
 INTERNATIONAL AIRPORT
 410 WENDELL H. FORD BLVD
 ERLANGER, KY 41018

CONTRACTOR INFORMATION

ESTD 1951

PERFECTION GROUP

2649 COMMERCE BLVD.
 CINCINNATI, OHIO 45241
 TEL +1.513.772.7545

ARCHITECT/ENGINEER INFORMATION

GHAFFARI

122 SOUTH MICHIGAN AVENUE
 SUITE 1600
 CHICAGO, IL 60603-8152 USA
 TEL +1.312.984.2300
 www.ghaffari.com

SHOP DRAWING

REV	DATE	DOC REL ## - DESCRIPTION
1	01/02/25	ISSUED FOR CONSTRUCTION

PROJECT #	241054
PROJECT MANAGER	E. RICE
DESIGNED BY	T. JANZEN
DRAWN BY	T. JANZEN
QUALCHECK	C. LONG
SHEET TITLE	

MECHANICAL HVAC SECTIONS

MH3-00-04
 SHEET NUMBER

MECHANICAL HVAC SECTION 04 (175 COMPRESSOR)
 SCALE: 1/4" = 1'-0"

MECHANICAL HVAC SECTION 05 (150 SHEET METAL SHOP)
 SCALE: 1/4" = 1'-0"

MECHANICAL HVAC SECTION 06 (152 STORES)
 SCALE: 1/4" = 1'-0"

GHAFFARI ASSOCIATES © 2023 1/15/2025 8:28:37 AM



DHL CVG AMC
CINCINNATI/NORTHERN KENTUCKY
INTERNATIONAL AIRPORT
410 WENDELL H. FORD BLVD
ERLANGER, KY 41018

CONTRACTOR INFORMATION


ESTD 1951
PERFECTION GROUP
2649 COMMERCE BLVD.
CINCINNATI, OHIO 45241
TEL +1.513.772.7545

ARCHITECT/ENGINEER INFORMATION

GHAFFARI

122 SOUTH MICHIGAN AVENUE
SUITE 1600
CHICAGO, IL 60603-8152 USA
TEL +1.312.984.2300
www.ghaffari.com

**SHOP
DRAWING**

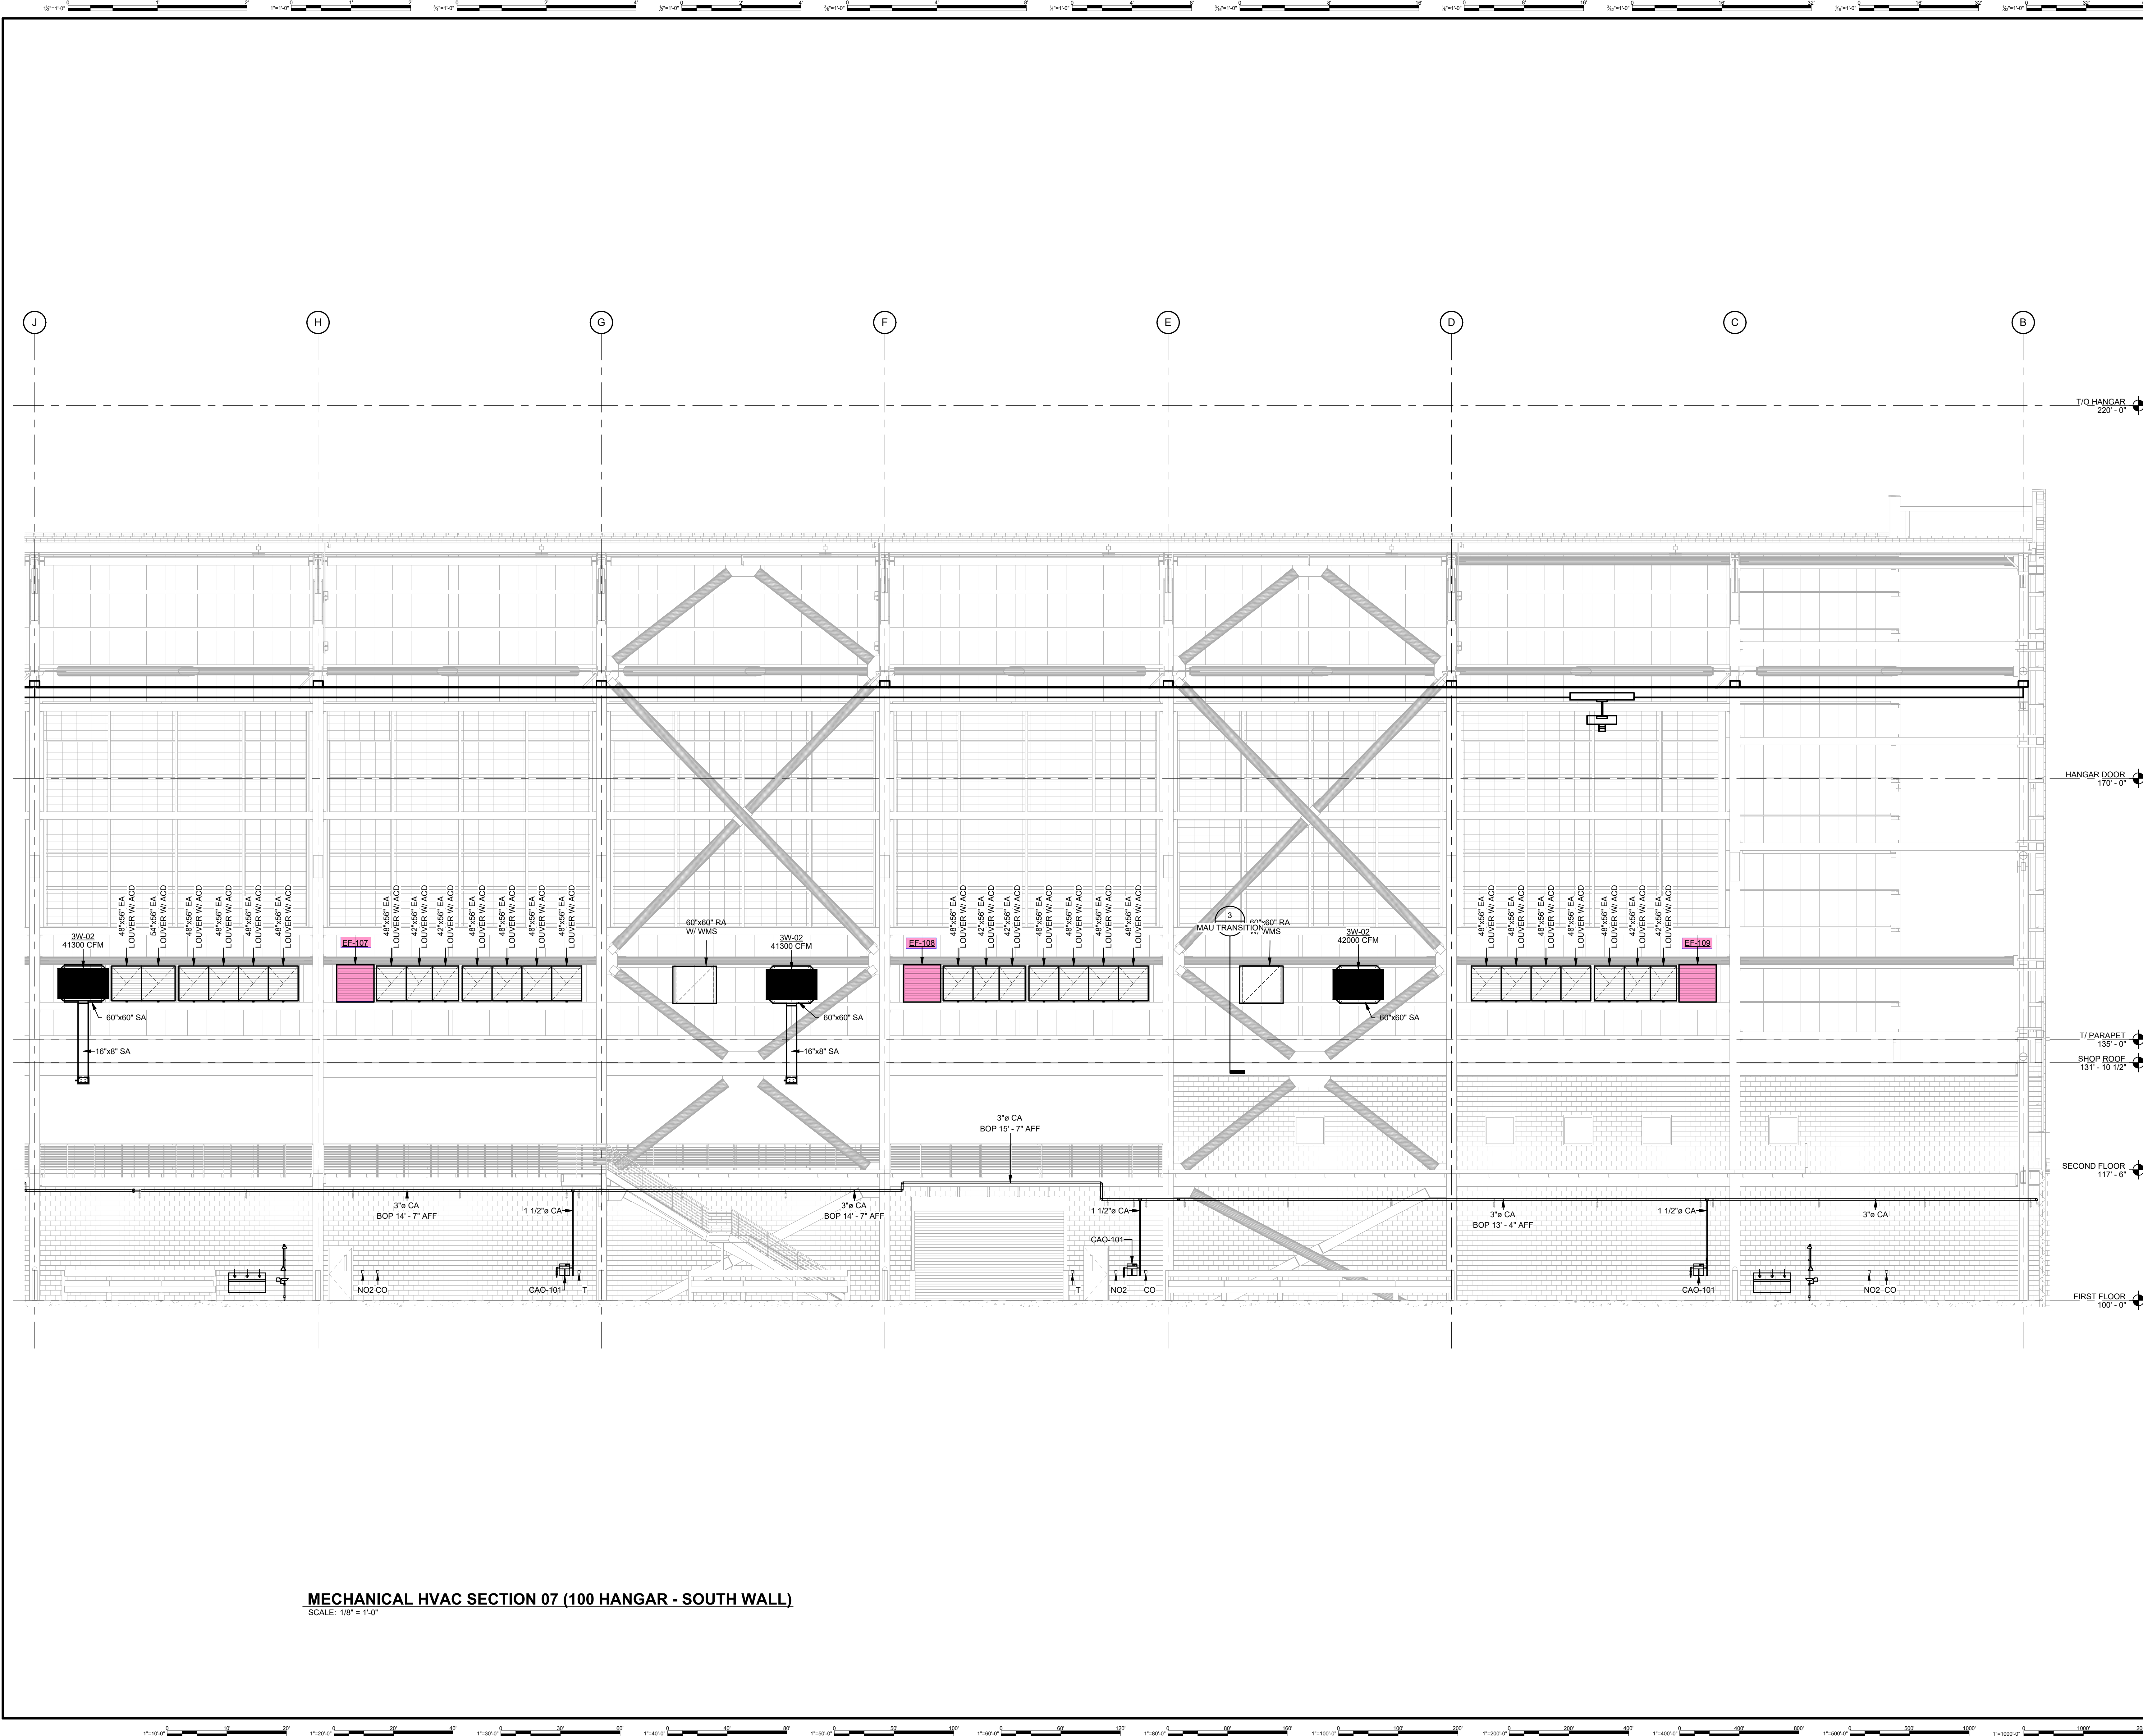

MECHANICAL HVAC SECTION 07 (100 HANGAR - SOUTH WALL)
SCALE: 1/8" = 1'-0"

REV	DATE	ISSUED FOR CONSTRUCTION	DOC REL ## - DESCRIPTION
1	01/02/25	ISSUED FOR CONSTRUCTION	

PROJECT #	241054
PROJECT MANAGER	E. RICE
DESIGNED BY	T. JANZEN
DRAWN BY	T. JANZEN
QUALCHECK	C. LONG
SHEET TITLE	

**MECHANICAL
HVAC SECTIONS**

MH3-00-05
SHEET NUMBER

GHAFFARI ASSOCIATES © 2023 1/15/2025 8:28:35 AM



DHL CVG AMC
 CINCINNATI/NORTHERN KENTUCKY
 INTERNATIONAL AIRPORT
 410 WENDELL H. FORD BLVD
 ERLANGER, KY 41018

CONTRACTOR INFORMATION


ESTD 1951
PERFECTION GROUP
 2649 COMMERCE BLVD.
 CINCINNATI, OHIO 45241
 TEL +1.513.772.7545

ARCHITECT/ENGINEER INFORMATION

GHAFFARI

122 SOUTH MICHIGAN AVENUE
 SUITE 1600
 CHICAGO, IL 60603-8152 USA
 TEL +1.312.884.2300
 www.ghaffari.com

SHOP DRAWING

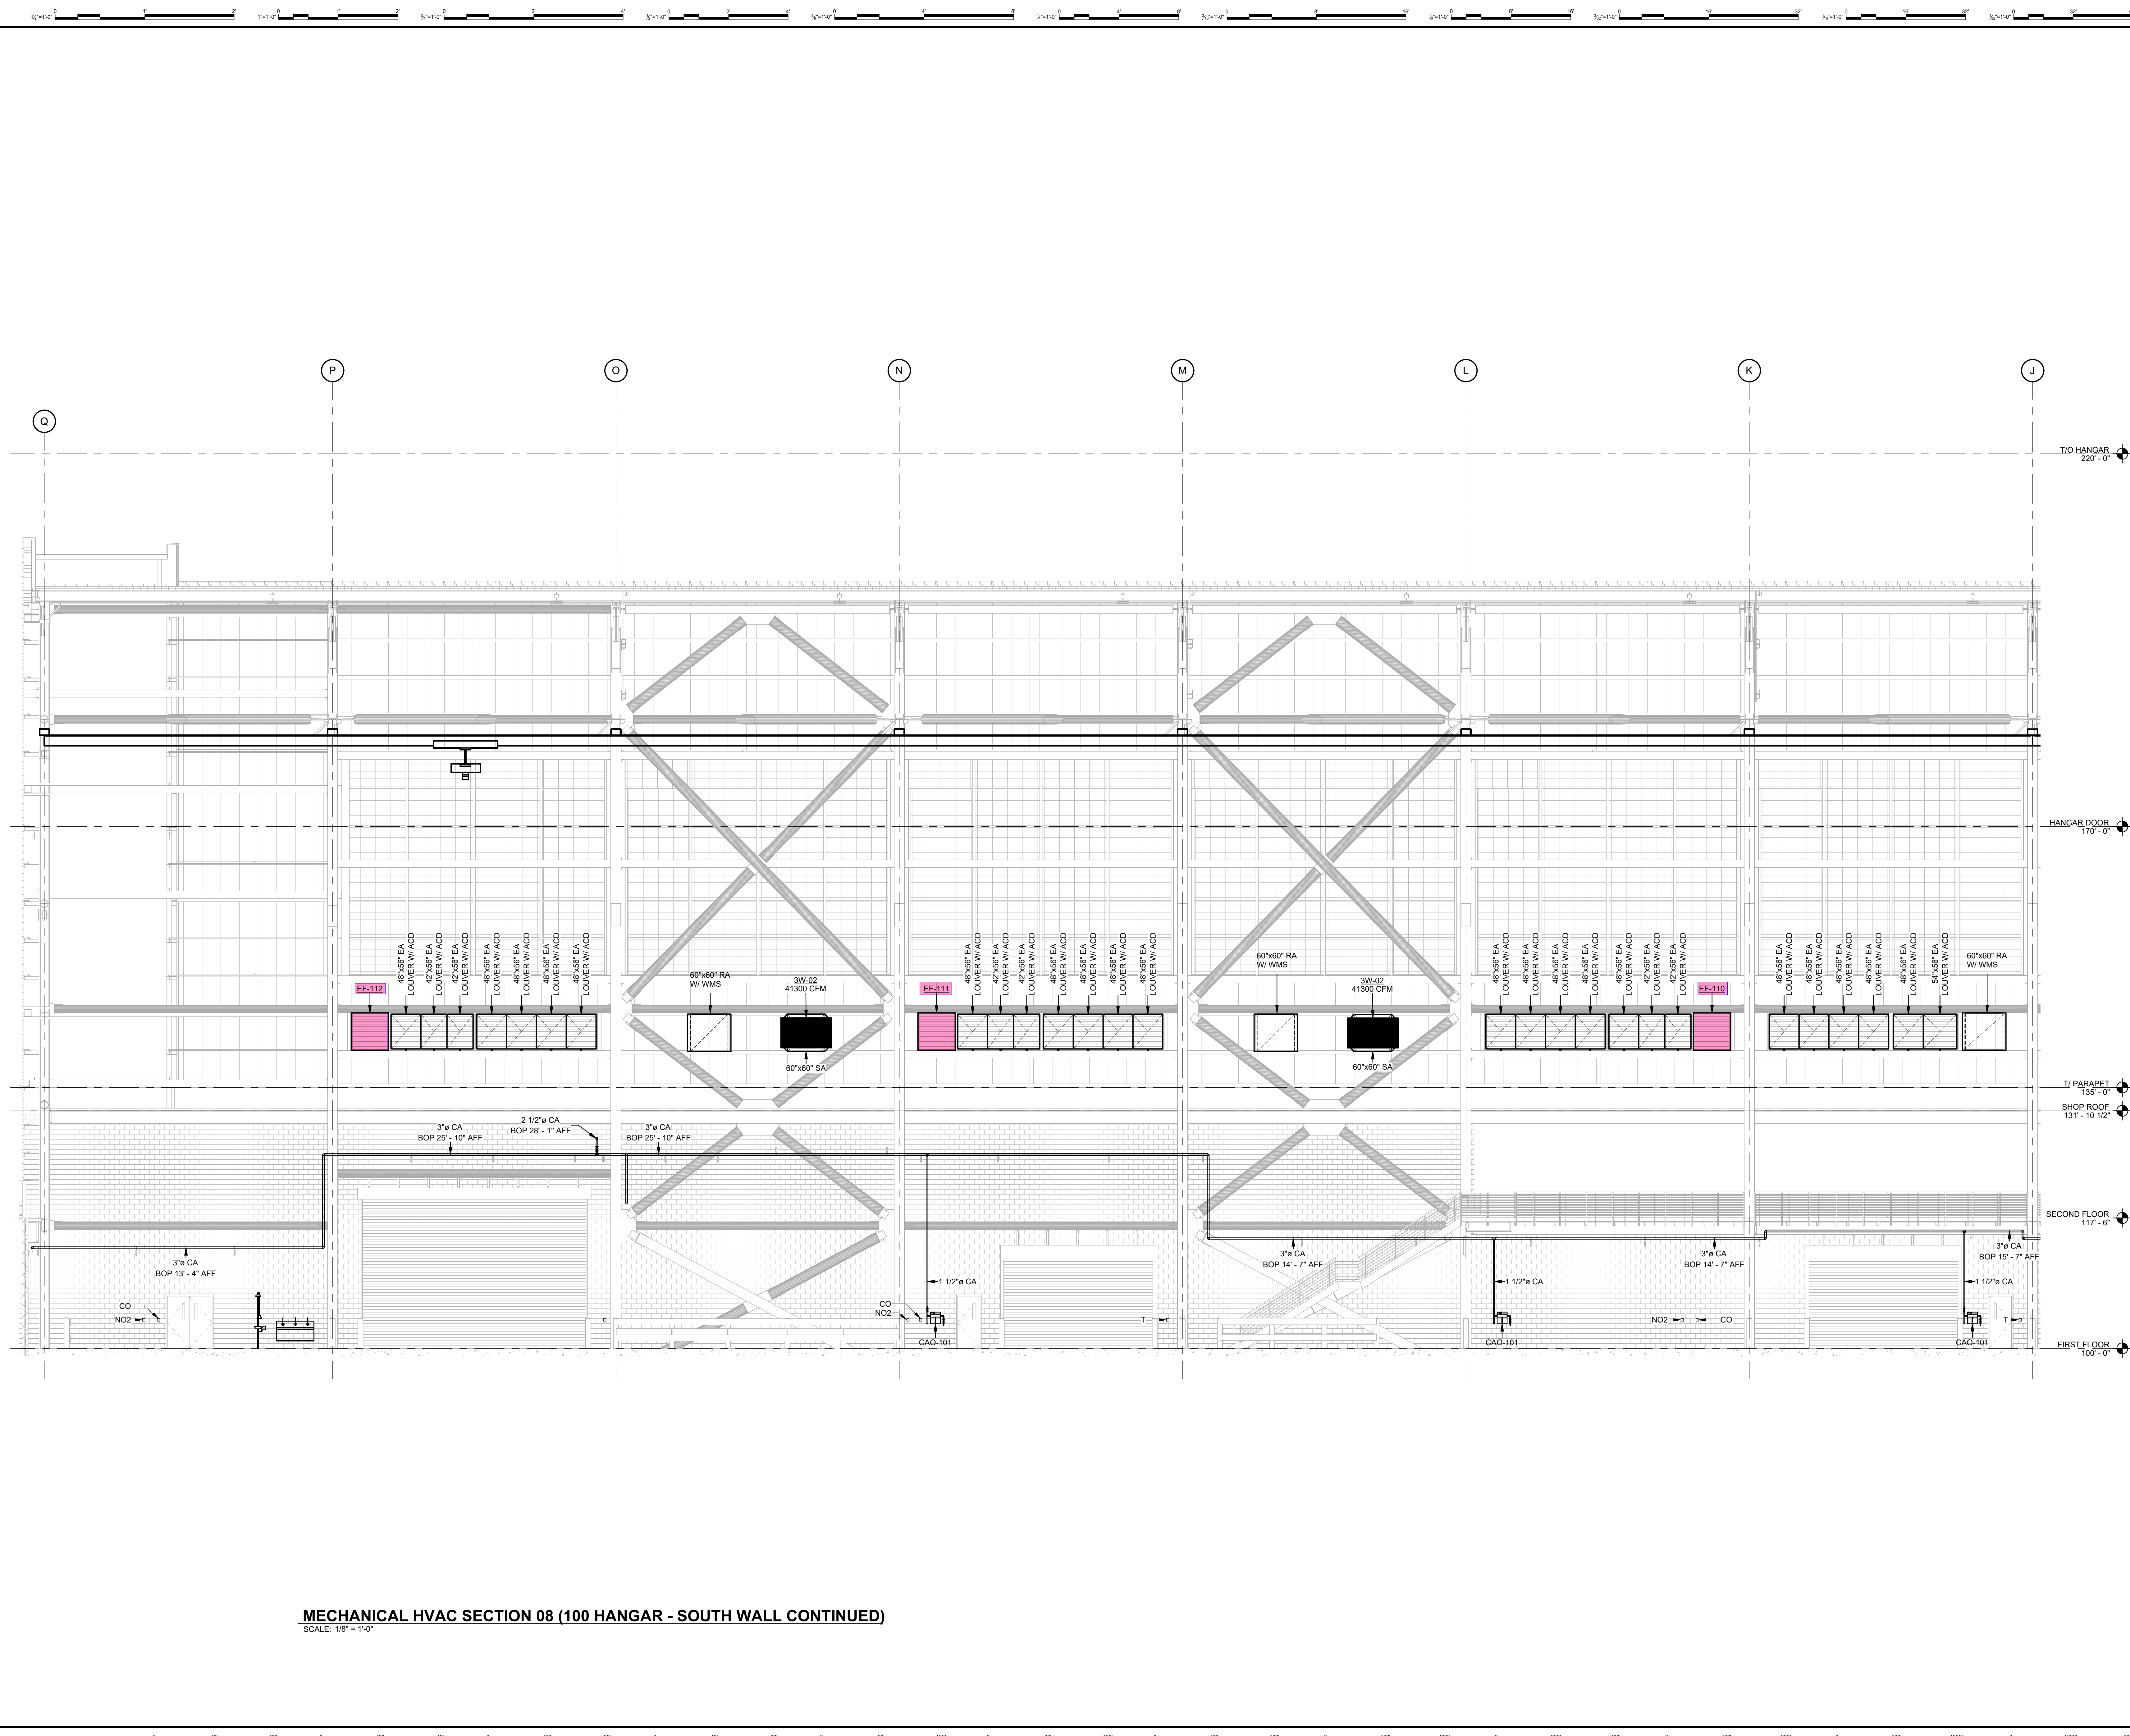

REV	DATE	ISSUED FOR CONSTRUCTION	DOC REL ## - DESCRIPTION
1	01/02/25	ISSUED FOR CONSTRUCTION	


PROJECT # 241054
 PROJECT MANAGER E. RICE
 DESIGNED BY T. JANZEN
 DRAWN BY T. JANZEN
 QUALCHECK C. LONG
 SHEET TITLE

MECHANICAL HVAC SECTIONS


MH3-00-06
 SHEET NUMBER

MECHANICAL HVAC SECTION 08 (100 HANGAR - SOUTH WALL CONTINUED)
 SCALE: 1/8" = 1'-0"

GHAFFARI ASSOCIATES © 2023 1/15/2025 8:28:39 AM

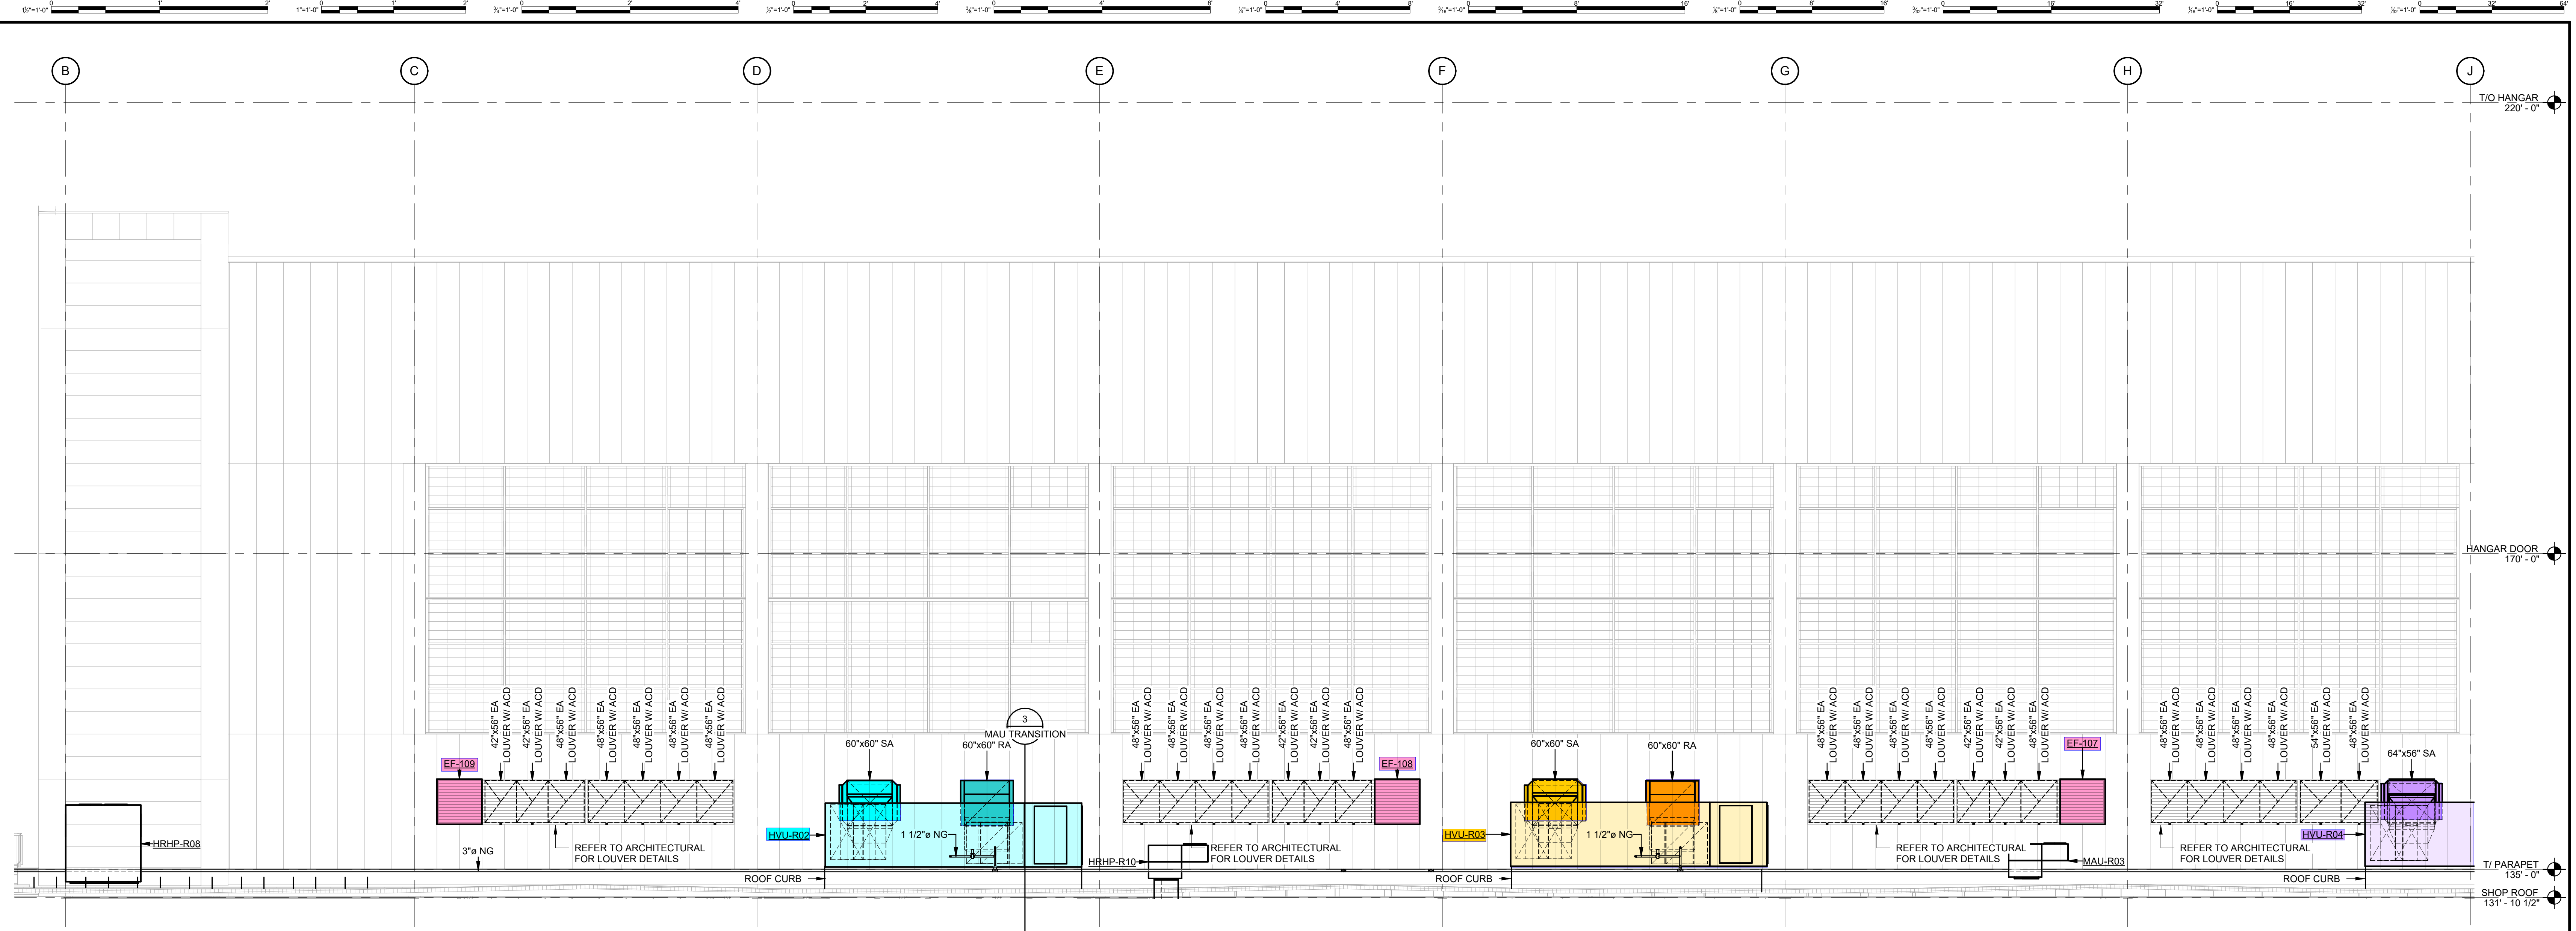

MECHANICAL HVAC SECTION 09 (100 HANGAR - BACK)
SCALE: 1/8" = 1'-0"

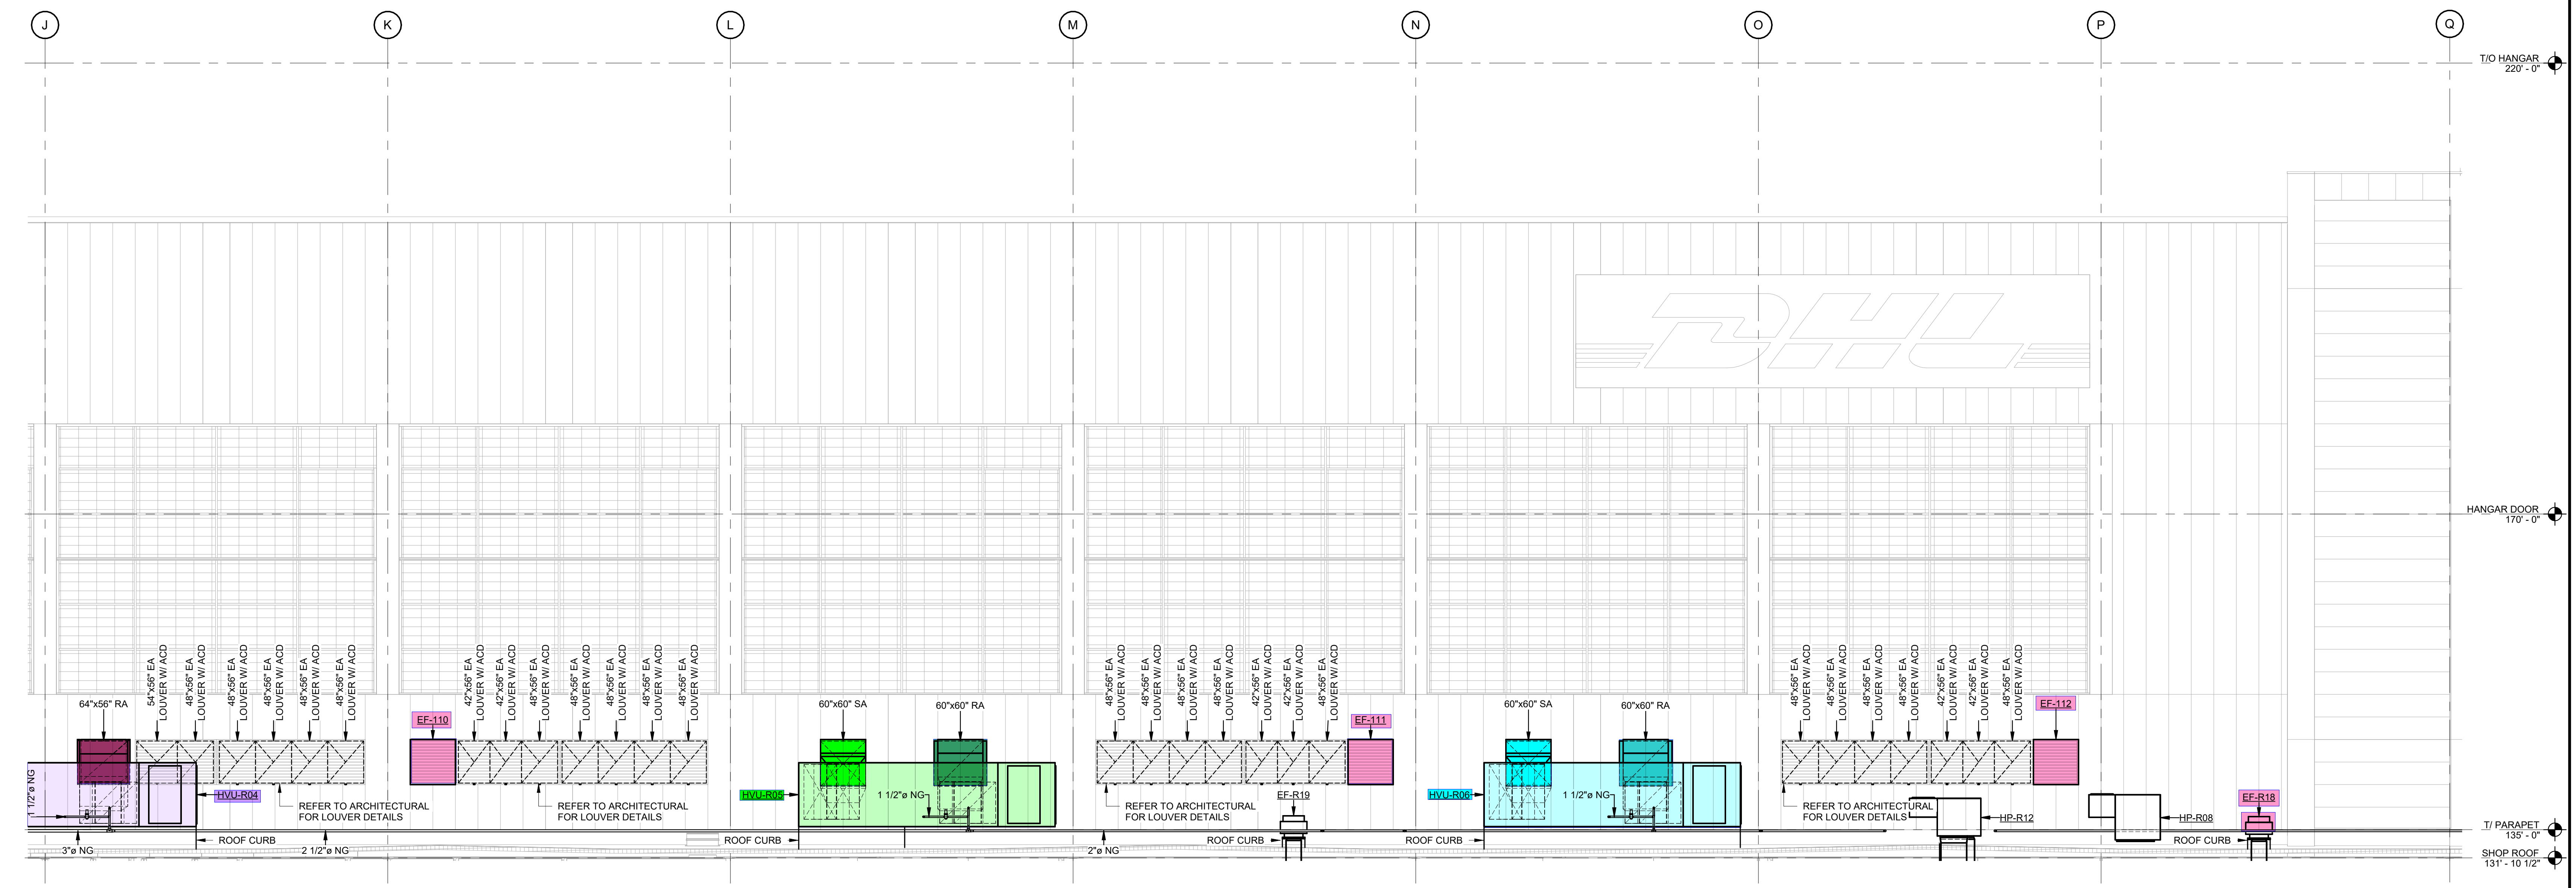

MECHANICAL HVAC SECTION 10 (100 HANGAR - BACK CONTINUED)
SCALE: 1/8" = 1'-0"

DHL CVG AMC
CINCINNATI/NORTHERN KENTUCKY
INTERNATIONAL AIRPORT
410 WENDELL H. FORD BLVD
ERLANGER, KY 41018

CONTRACTOR INFORMATION

ESTD 1951

PERFECTION GROUP

2649 COMMERCE BLVD.
CINCINNATI, OHIO 45241
TEL +1.513.772.7545

ARCHITECT/ENGINEER INFORMATION

GHAFARI

122 SOUTH MICHIGAN AVENUE SUITE 1600
CHICAGO, IL 60603-8152 USA
TEL +1.312.884.2300
www.ghafari.com

SHOP DRAWING

REV	DATE	DOC REL ## - DESCRIPTION
1	01/02/25	ISSUED FOR CONSTRUCTION

PROJECT # 241054
PROJECT MANAGER E. RICE
DESIGNED BY T. JANZEN
DRAWN BY T. JANZEN
QUALITY CHECK C. LONG
SHEET TITLE

MECHANICAL HVAC SECTIONS

MH3-00-07
SHEET NUMBER

GHAFARI ASSOCIATES © 2023 1/15/2025 8:28:45 AM



DHL CVG AMC
 CINCINNATI/NORTHERN KENTUCKY
 INTERNATIONAL AIRPORT
 410 WENDELL H. FORD BLVD
 ERLANGER, KY 41018

CONTRACTOR INFORMATION

ESTD 1951

PERFECTION GROUP

2649 COMMERCE BLVD.
 CINCINNATI, OHIO 45241
 TEL +1.513.772.7545

ARCHITECT/ENGINEER INFORMATION

GHAFFARI

122 SOUTH MICHIGAN AVENUE
 SUITE 1600
 CHICAGO, IL 60603-8152 USA
 TEL +1.312.984.2300
 www.ghaffari.com


**SHOP
 DRAWING**

REV	DATE	ISSUED FOR CONSTRUCTION	DOC REL ## - DESCRIPTION
1	01/02/25	ISSUED FOR CONSTRUCTION	

PROJECT #	241054
PROJECT MANAGER	E. RICE
DESIGNED BY	T. JANZEN
DRAWN BY	T. JANZEN
QUALCHECK	C. LONG
SHEET TITLE	


**MECHANICAL
 HVAC SECTIONS**

MH3-00-08
 SHEET NUMBER

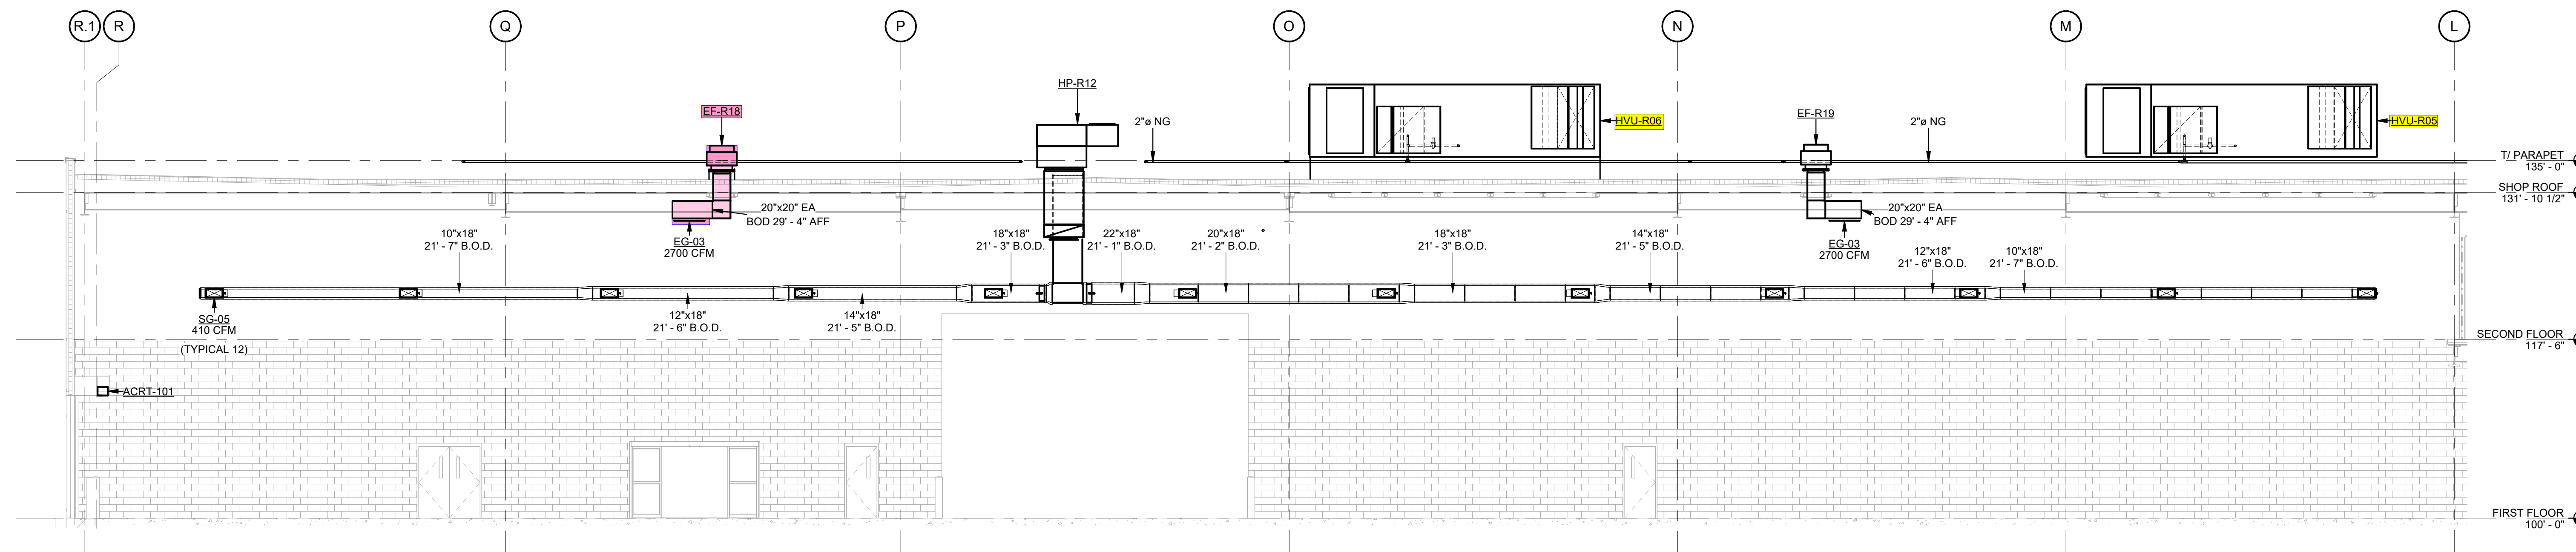


MECHANICAL HVAC SECTION 11 (CO102 CORRIDOR 03)

SCALE: 1/8" = 1'-0"

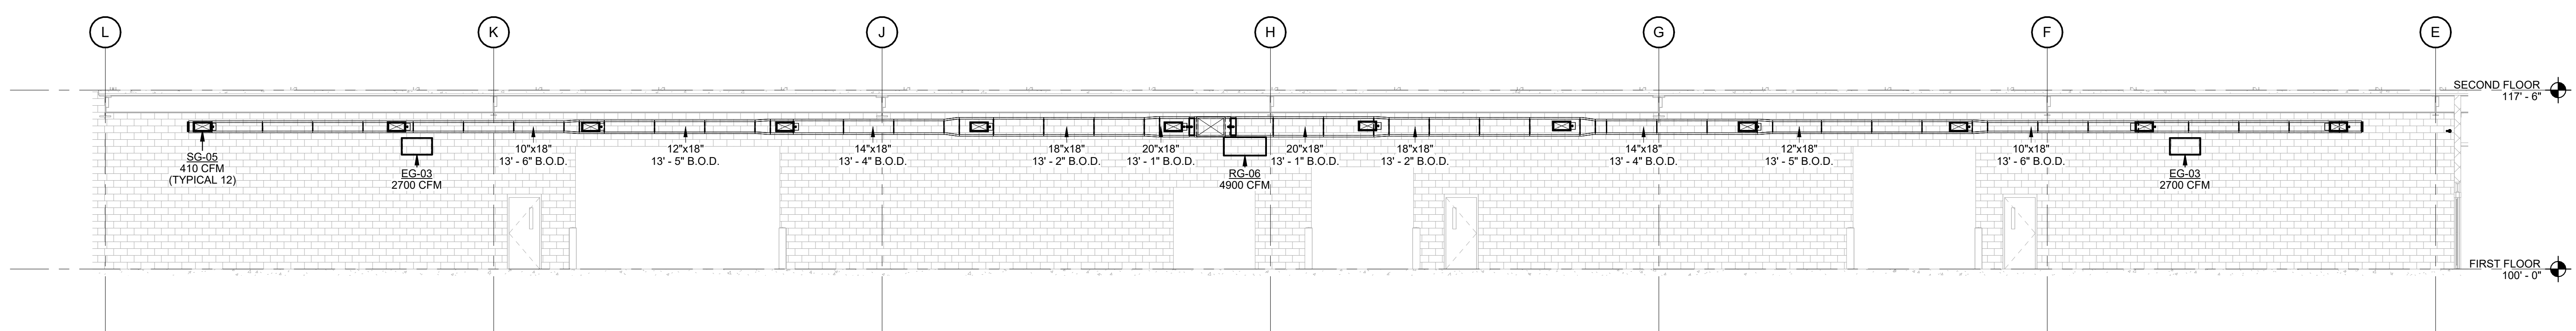


MECHANICAL HVAC SECTION 12 (CO102 CORRIDOR 03 CONTINUED)

SCALE: 1/8" = 1'-0"

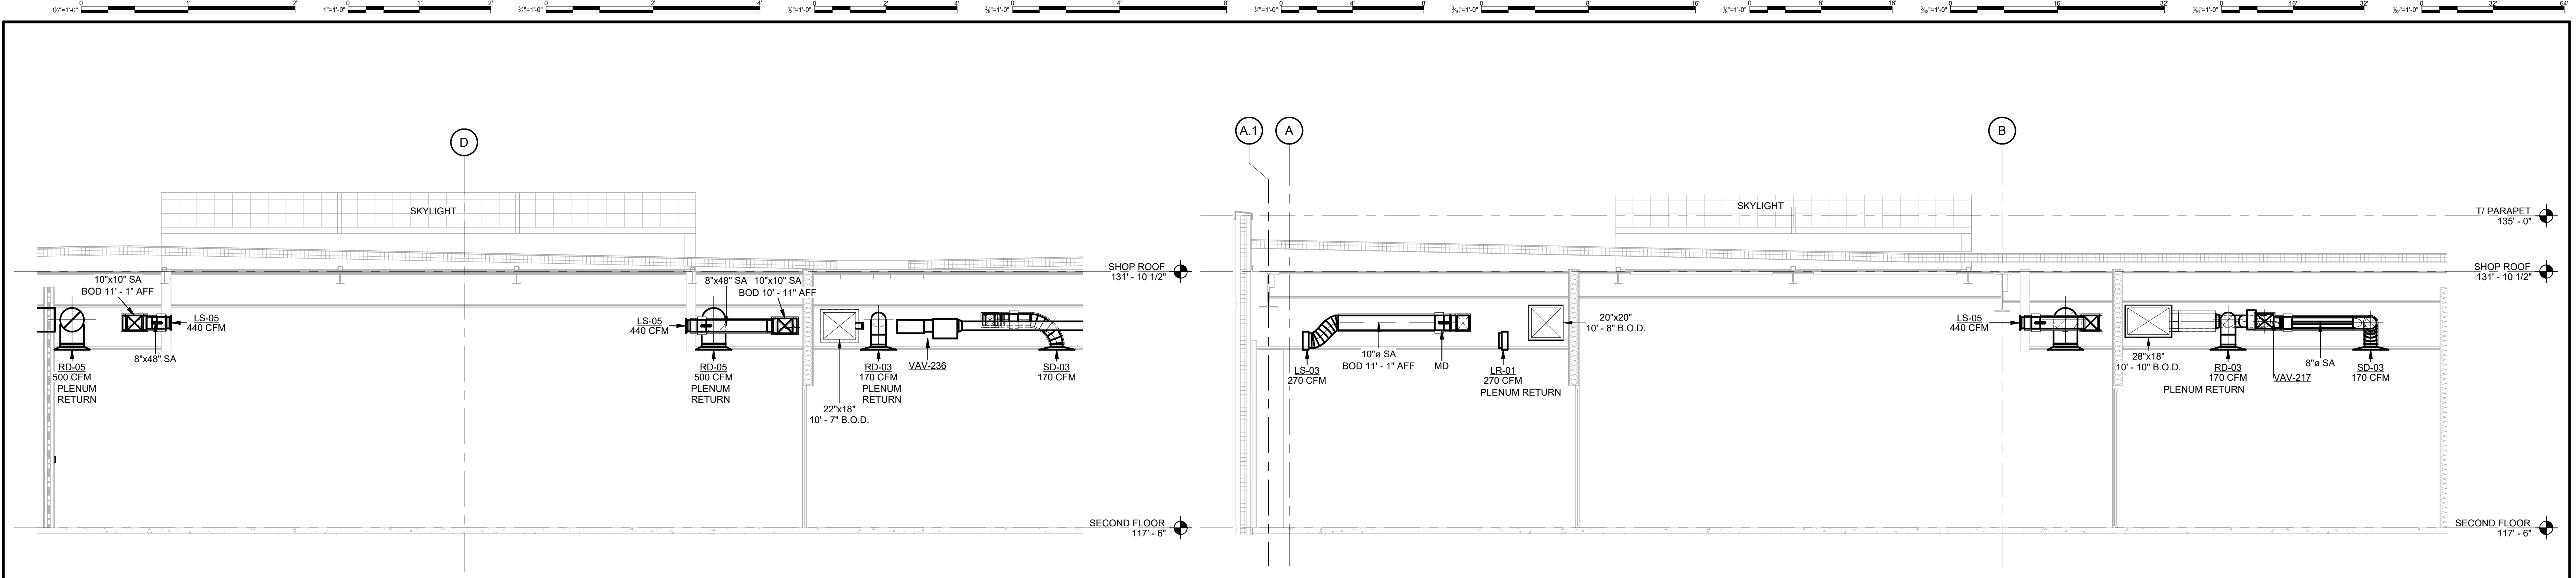


MECHANICAL HVAC SECTION 13 (227 MRO SUITE)
SCALE: 1/4" = 1'-0"


MECHANICAL HVAC SECTION 14 (201 AVIATION SUITE)
SCALE: 1/4" = 1'-0"

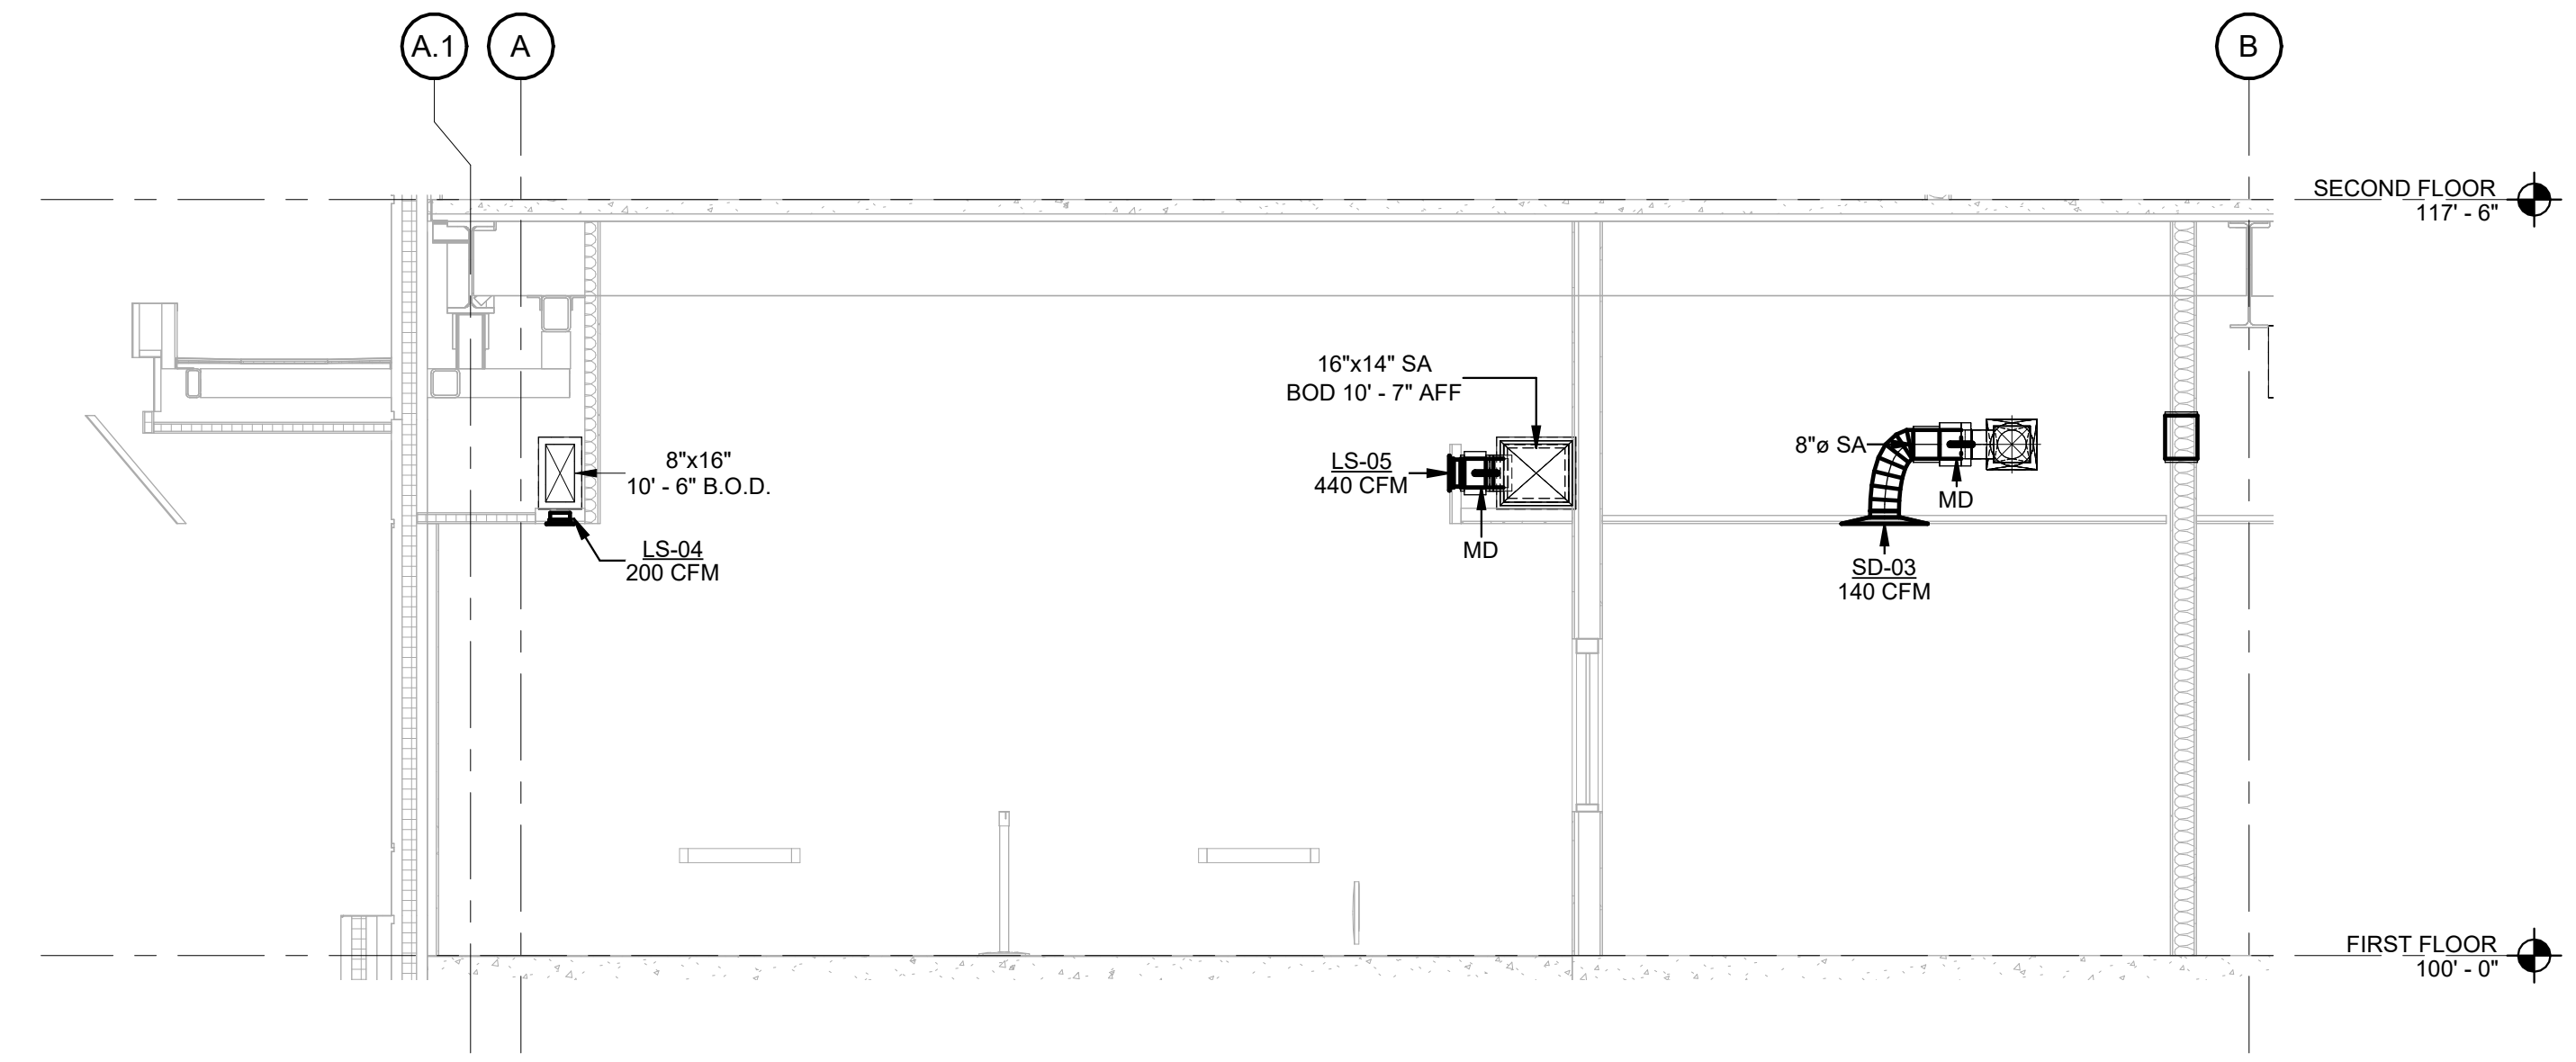

MECHANICAL HVAC SECTION 15 (121 SECURITY)
SCALE: 1/4" = 1'-0"

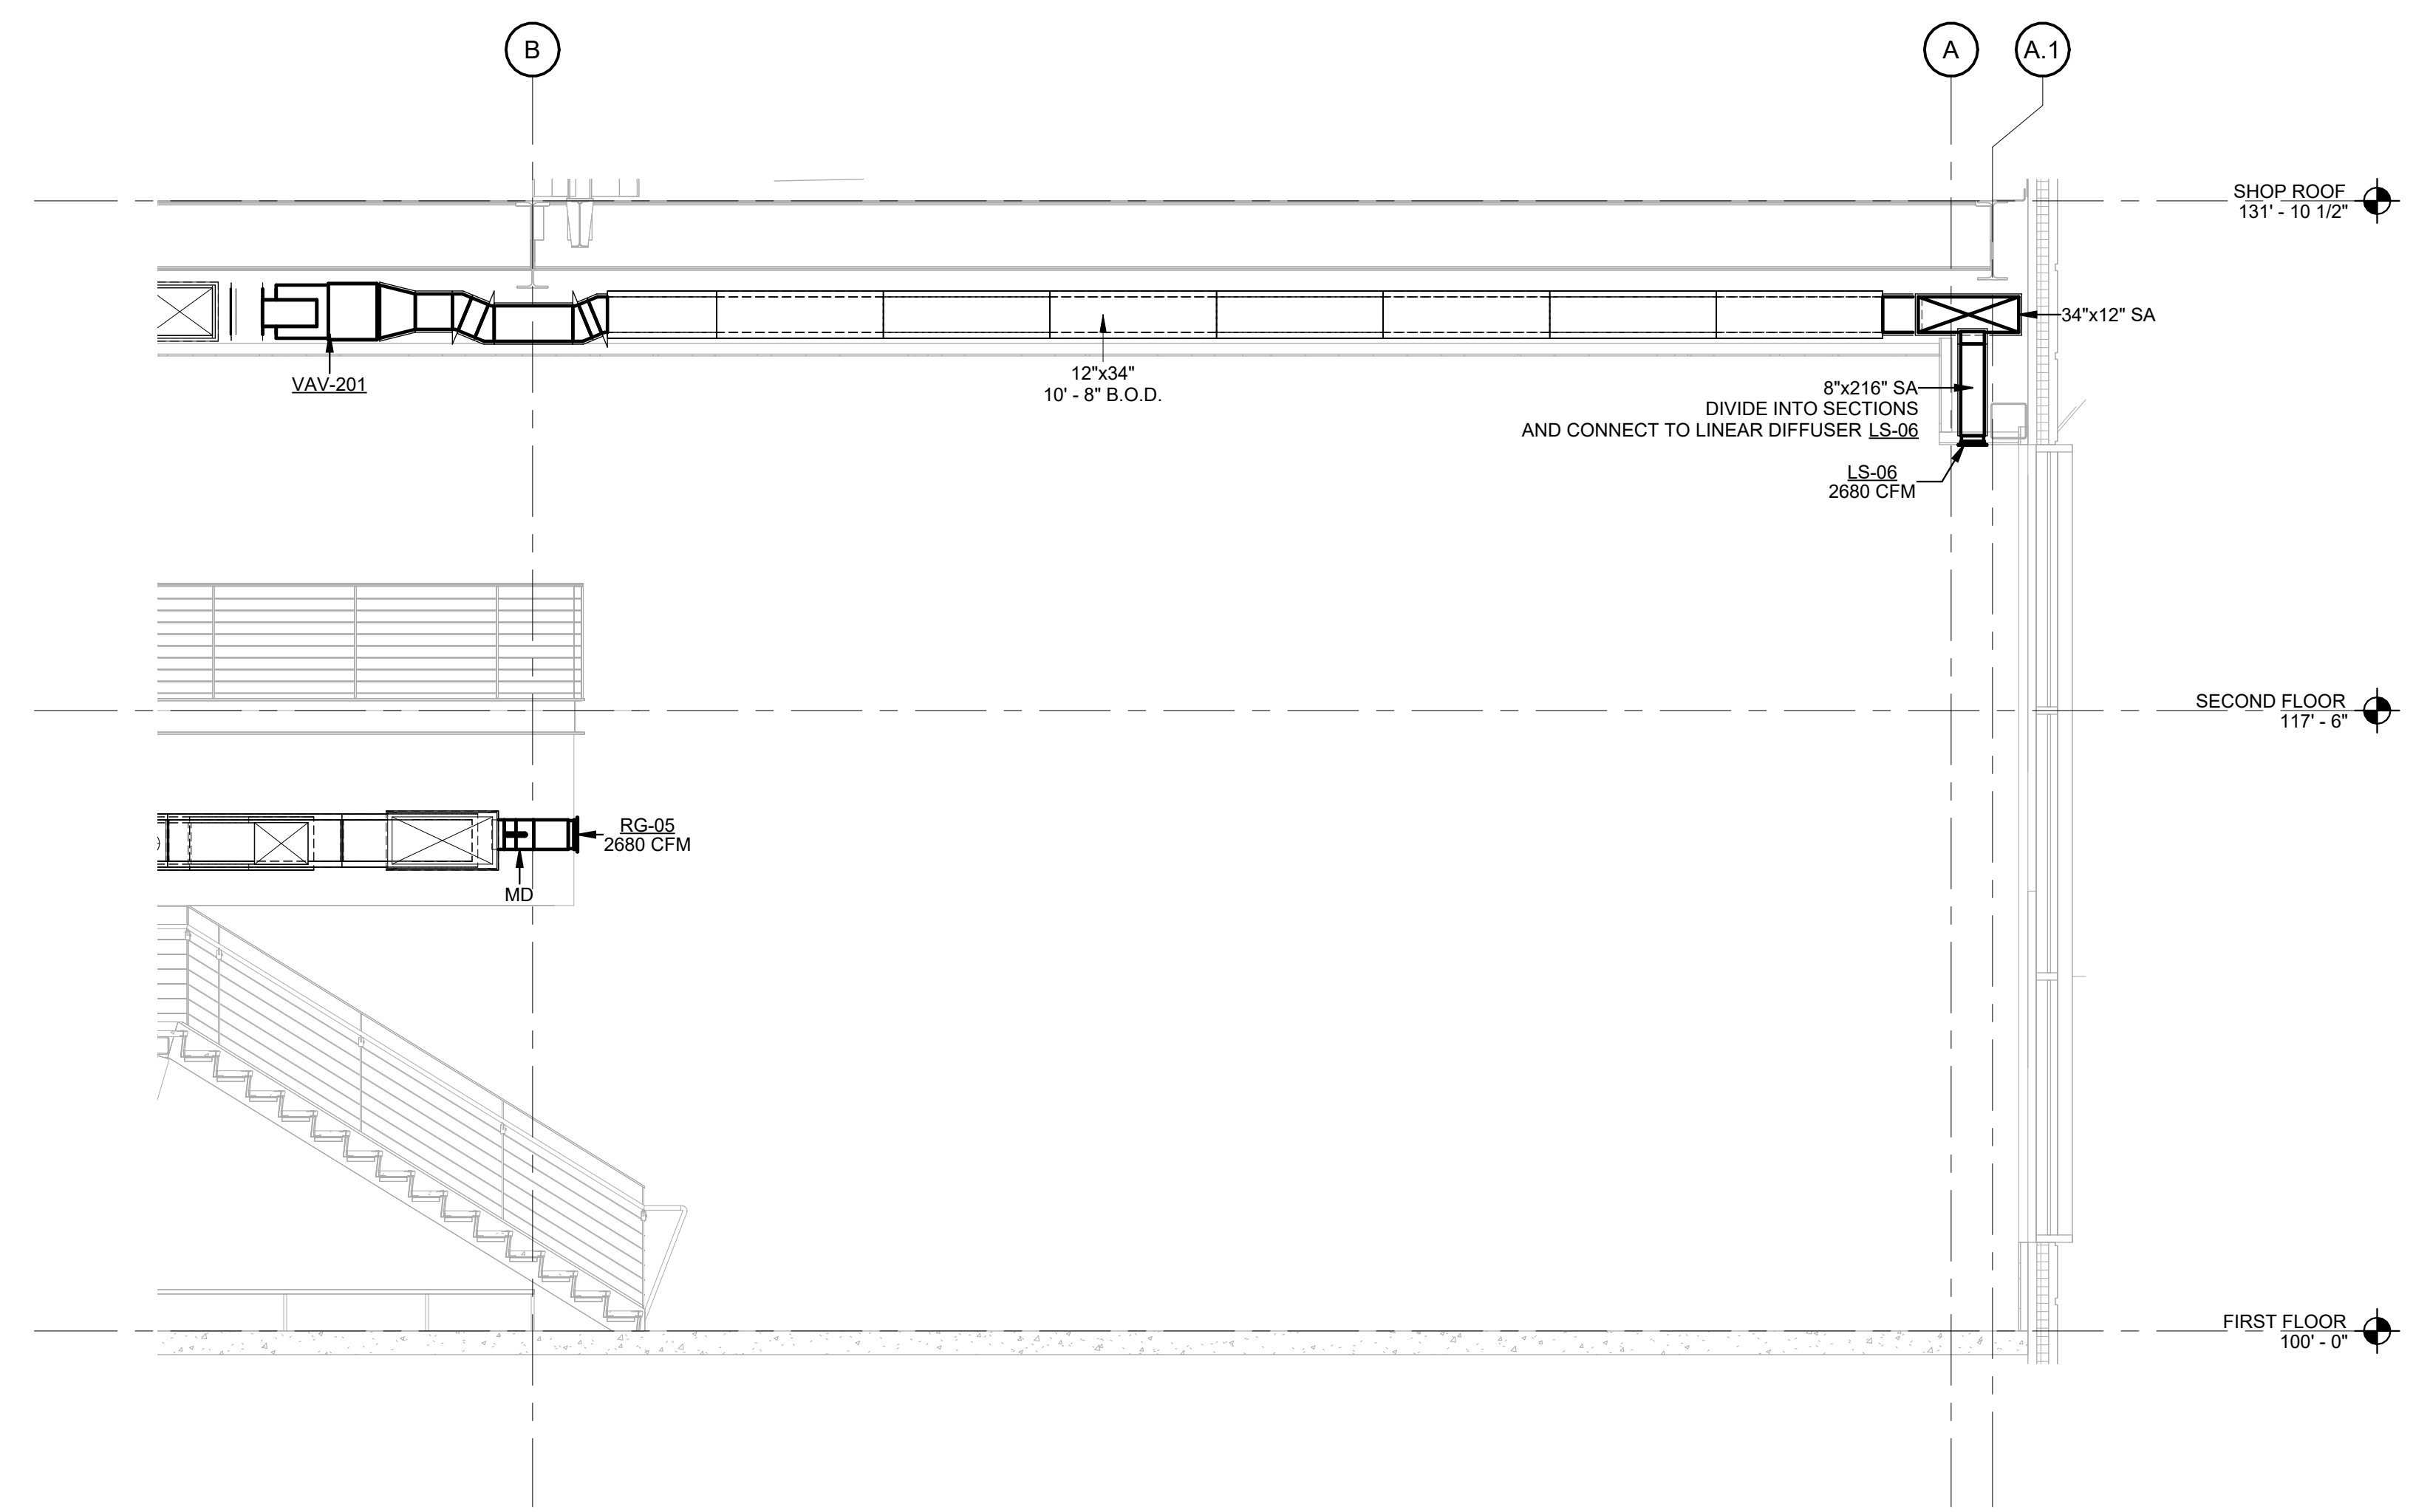

MECHANICAL HVAC SECTION 16 (CO100 CORRIDOR 01)
SCALE: 1/4" = 1'-0"

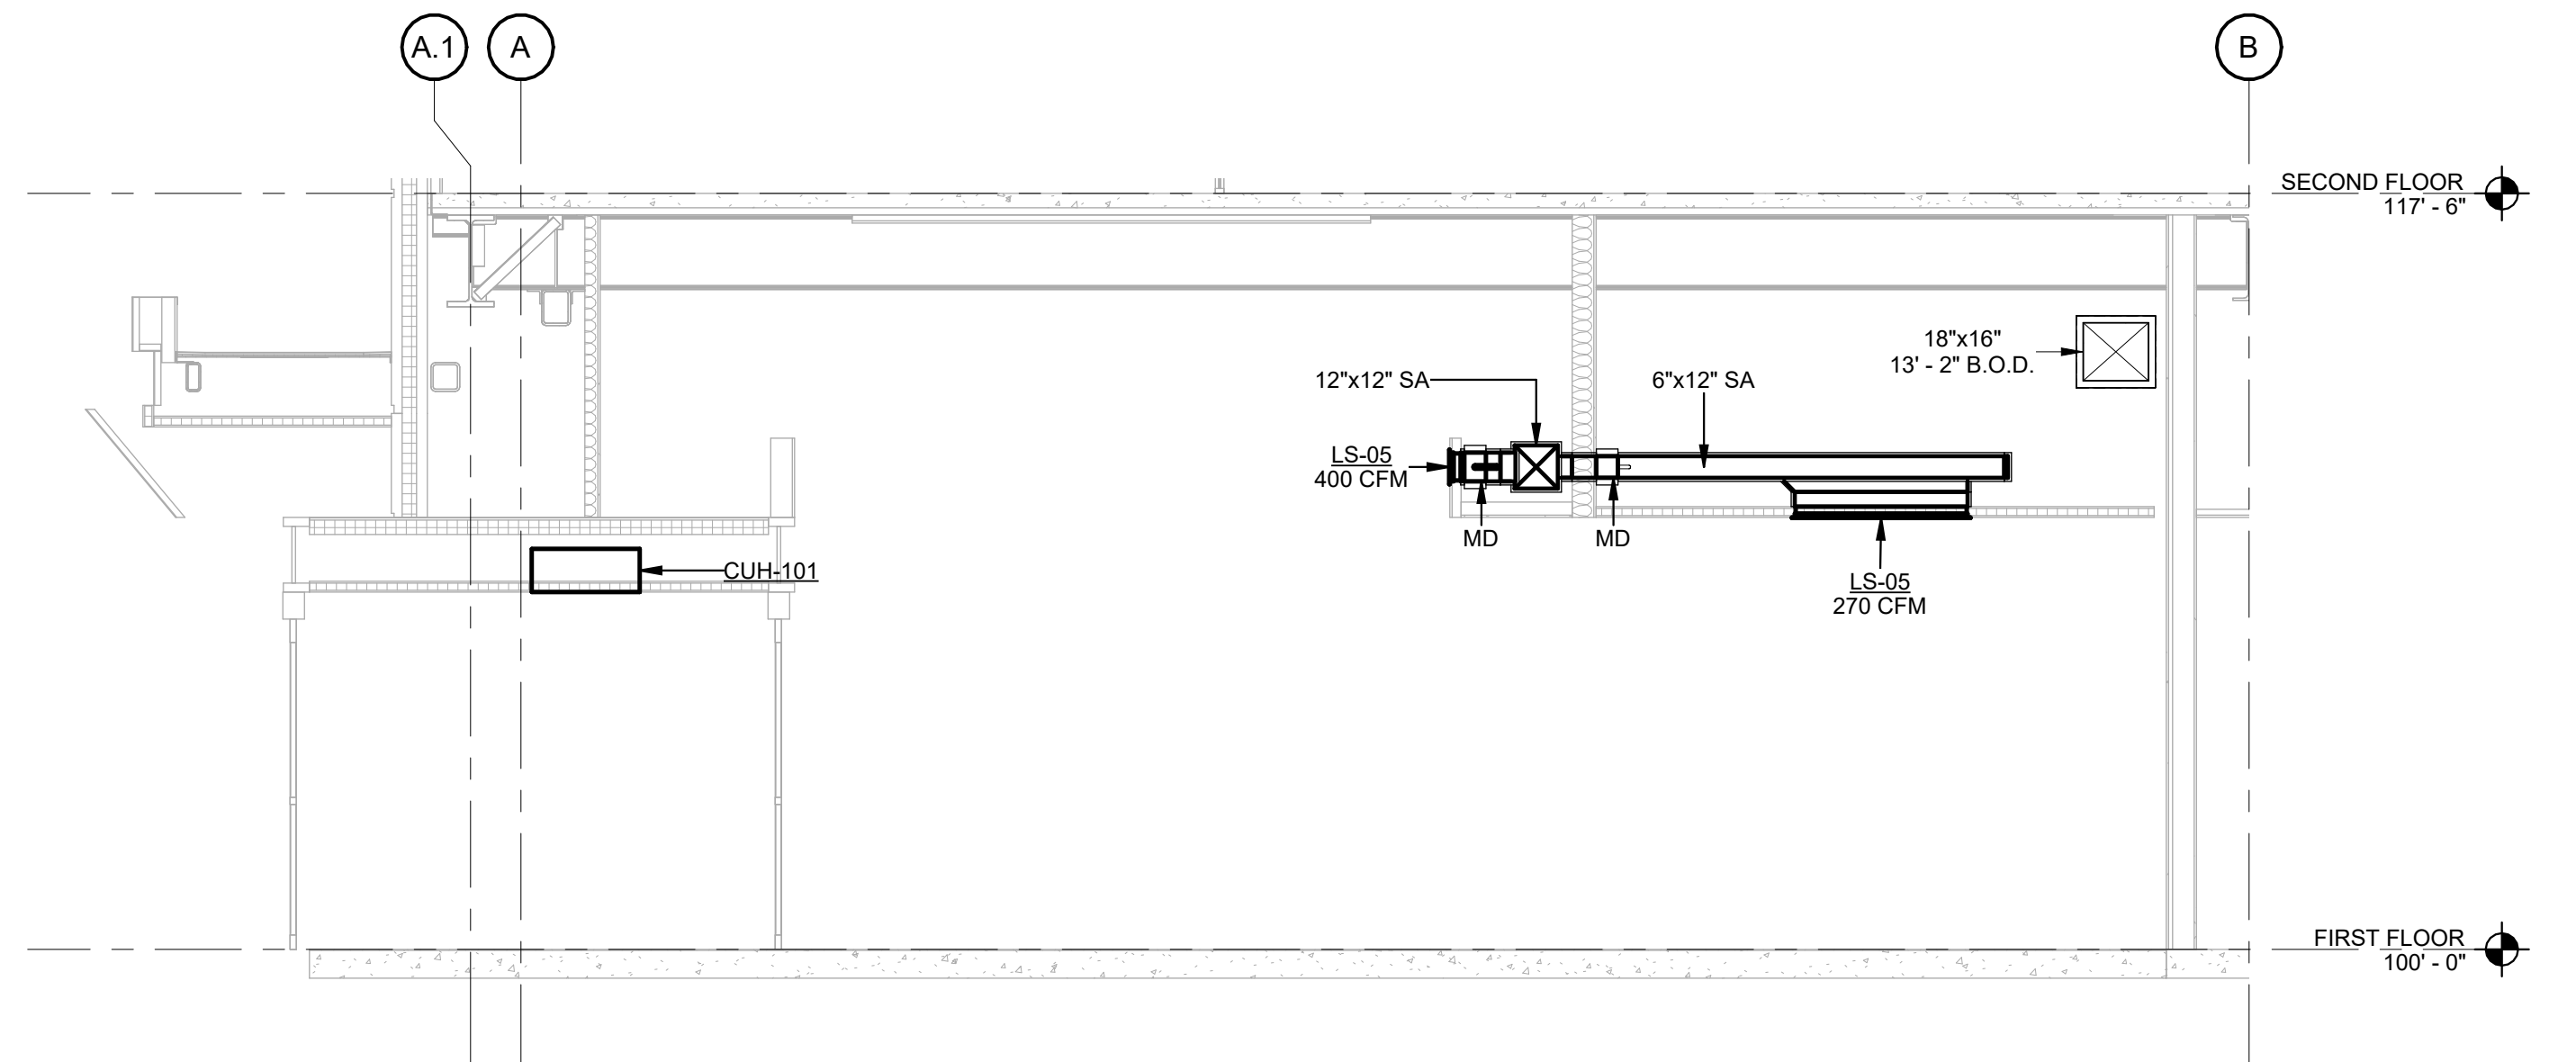

MECHANICAL HVAC SECTION 17 (121 SECURITY)
SCALE: 1/4" = 1'-0"



DHL CVG AMC
CINCINNATI/NORTHERN KENTUCKY
INTERNATIONAL AIRPORT
410 WENDELL H. FORD BLVD
ERLANGER, KY 41018

CONTRACTOR INFORMATION

ESTD 1951
PERFECTION GROUP
2649 COMMERCE BLVD.
CINCINNATI, OHIO 45241
TEL +1.513.772.7545

ARCHITECT/ENGINEER INFORMATION

GHAFFARI
122 SOUTH MICHIGAN AVENUE
SUITE 1600
CHICAGO, IL 60603-8152 USA
TEL +1.312.984.2300
www.ghaffari.com

SHOP DRAWING

REV	DATE	DOC REL ## - DESCRIPTION
1	01/02/25	ISSUED FOR CONSTRUCTION

PROJECT # 241054
PROJECT MANAGER E. RICE
DESIGNED BY T. JANZEN
DRAWN BY T. JANZEN
QUALITY CHECK C. LONG
SHEET TITLE

MECHANICAL HVAC SECTIONS

MH3-00-09
SHEET NUMBER

GHAFFARI ASSOCIATES © 2023 1/15/2025 8:28:46 AM