


MANUFACTURER'S WARRANTY ON ALL HVAC EQUIPMENT PROVIDED INSTALLED. THE WARRANTY SHALL INCLUDE ALL LABOR, MATERIALS AND SUPPLIES. (3) ROUTINE SERVICES INCLUDING FILTER CHANGES DURING A PERIOD.

X. AT THE COMPLETION OF CONSTRUCTION AN NEBB, AABC OR TAB BALANCE REPORT SHALL BE SUBMITTED TO THE ENGINEER AND LIAISON TO SCHEDULING BALANCING, COORDINATE WITH LANDLORD'S FIELD REPRESENTATIVE FOR THE VENDOR LISTED BELOW. IF APPROVED SHALL BE COMPLETED BY NATION TAB. CONTACT WILL TURNBOUR WILL@NATIONTAB.COM OR 314-954-6244.

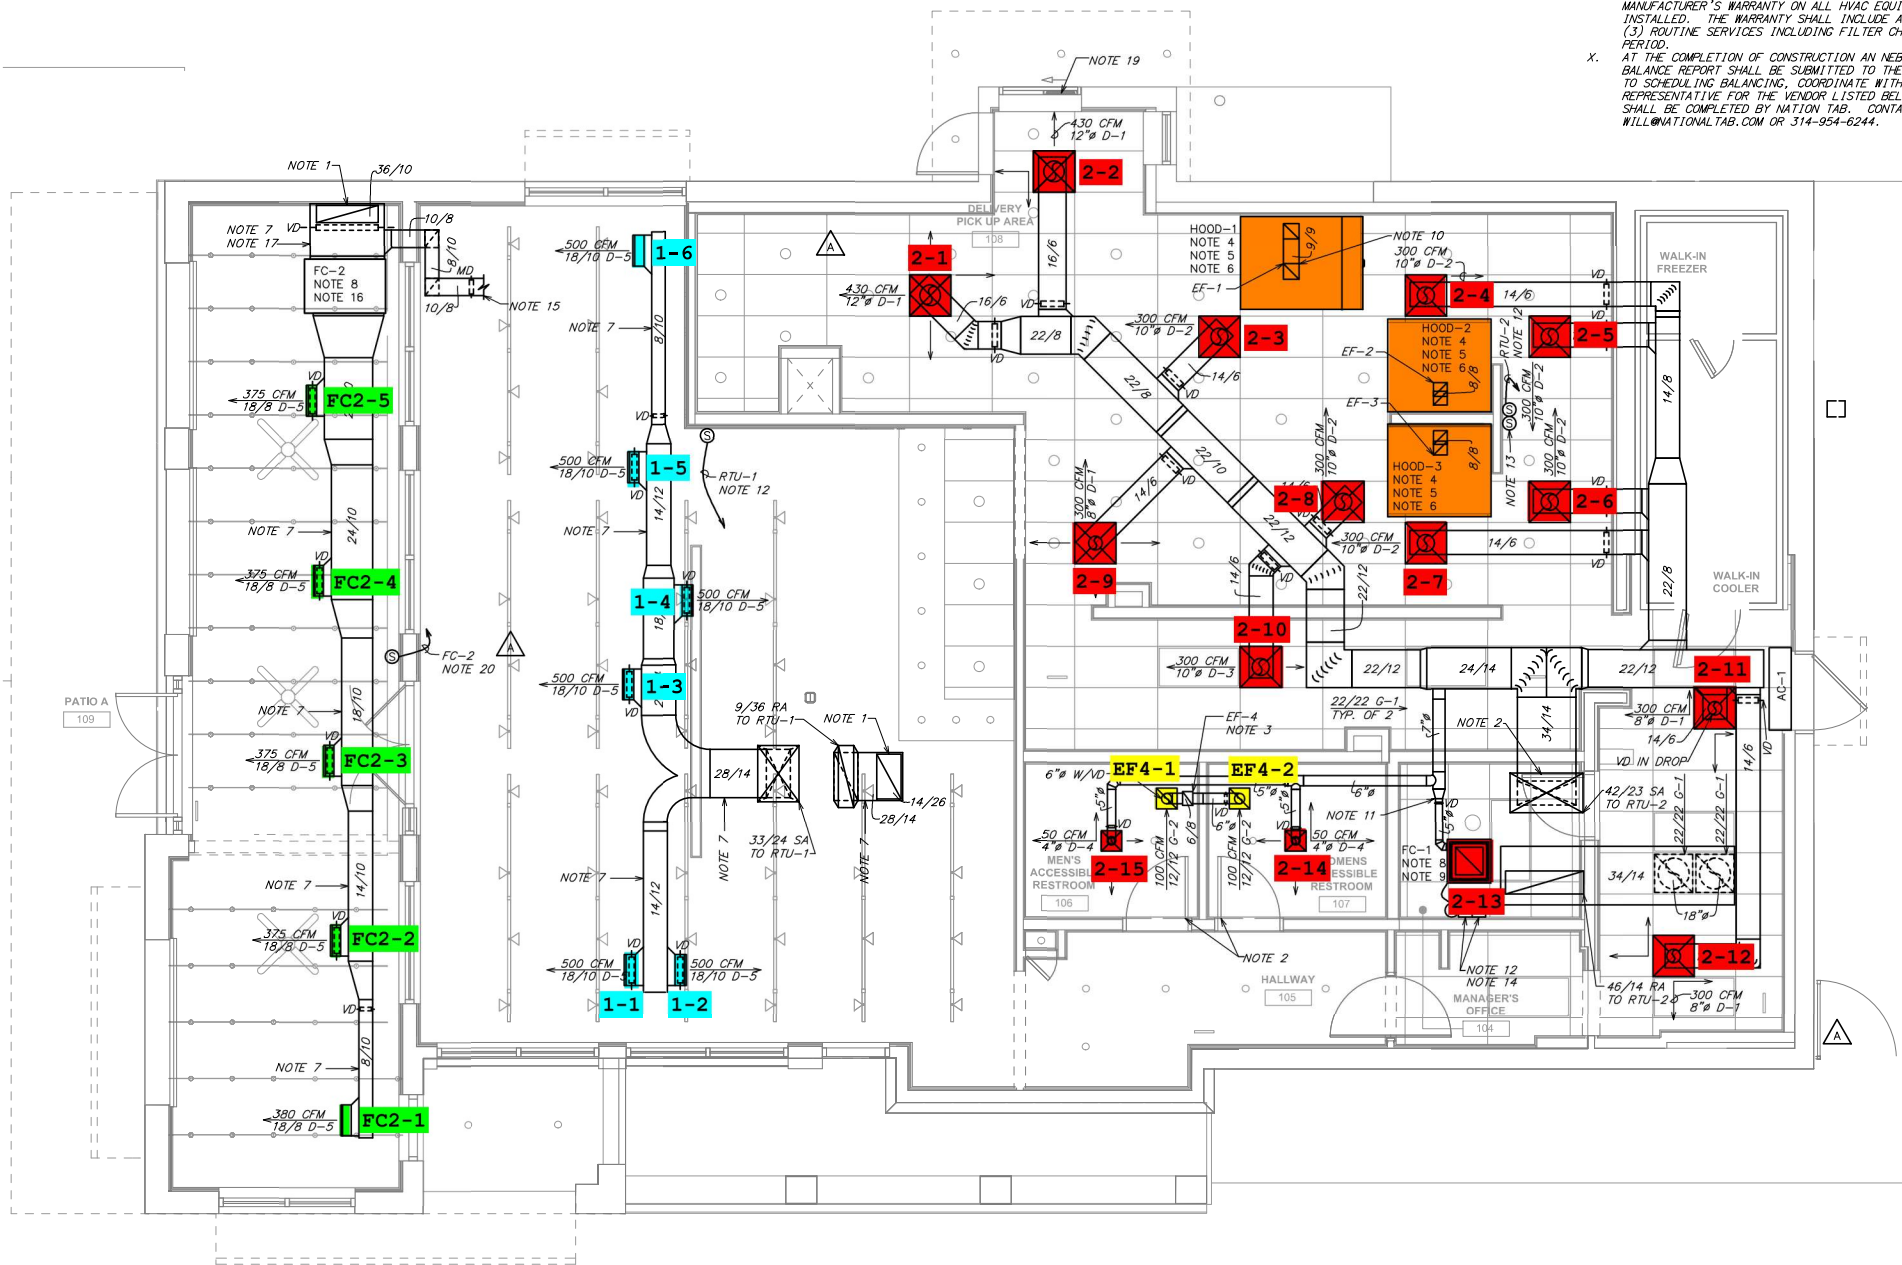

1 MECHANICAL FLOOR PLAN
SCALE: 1/4" = 1'-0"

