


HES. SYSTEM
 MECHANICAL CONTRACTOR TO PROVIDE AND INSTALL SCOPED HES SYSTEM FOR ALL NEW COOKS. SEE HOOD FLOOR PLAN FOR COOKING EQUIPMENT LAYOUT ON SHEET 1141 FOR MORE INFORMATION.

EXISTING CONDITIONS SHOWN ARE FROM 444000000 DRAWINGS. MECHANICAL CONTRACTOR SHALL VERIFY EXACT LOCATIONS OF ALL DUCTWORK, AIR DIFFUSERS, IF MAJOR DIFFERENCES OCCUR IN FIELD, CONTACT CHECK-FL-A CONSTRUCTION MANAGER.

HOLD DUCT AT ACH1 & ACH6 AS HIGH AS POSSIBLE DUE TO LIMITED CLEARANCE ABOVE CEILING.

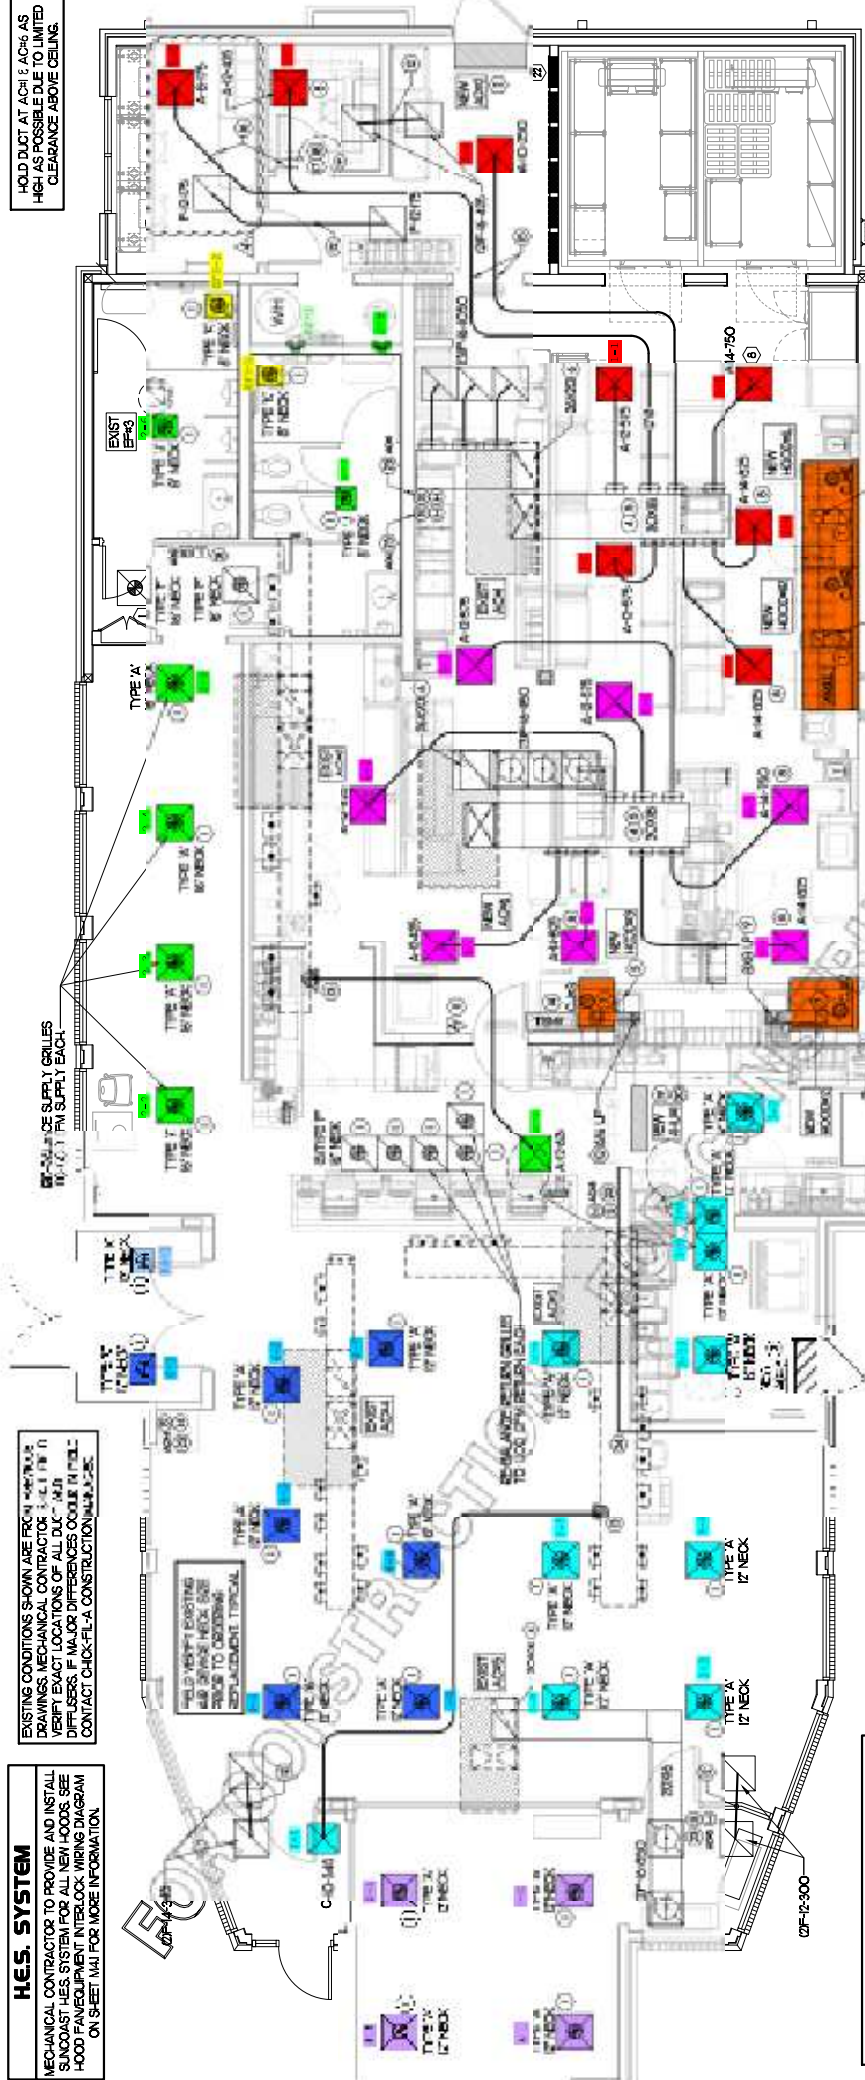

LEGEND

AH-400	TYPE - NEX SIZE - CFM
+	SPINN FITTING, MTD, NO SCOOP
Ⓢ	REMOTE TEMPERATURE SENSOR

AIR CURTAIN REMOTE WALL SWITCHES TO BE INSTALLED TO AIR DOOR SCOPES AND OCCUPANT SWAIT LOCATION FOR SWITCHES WITH KITCHEN EQUIPMENT AND PLANS.

NEW AIR CURTAIN AS CALICATED IN CORRIDOR. CENTERED ON THE DOOR AT 4' OFF THE EXTERIOR WALL. REMOVAL OF SWAIT FROM WALL SHALL ADJUST AIR DEFLECTORS TOWARD AIR FILTER BOX.

KEY NOTES (THIS SHEET ONLY)

MECHANICAL FLOOR PLAN

SCALE: 1/4"=1'-0"

1