


ROOM SCHEDULE	
NUMBER	NAME
101	MULTI-PURPOSE ROOM
102	CORRIDOR
103	WOMEN
104	MEN
105	STORAGE
106	HOSPITALITY STATION

NO. DATE DESCRIPTION  
1 08/04/2021 ISSUE FOR BID & PERMIT


- DRAWING NOTES**
- M01 PROVIDE SHEET METAL PLENUM BOX.
  - M02 SEAL DUCT PENETRATION AIR AND WATER TIGHT.
  - M03 PROVIDE BRACKET SUPPORT FOR VERTICAL DUCTWORK.
  - M04 PROVIDE KNEE BRACE SUPPORT.
  - M05 SUPPORT WITH WALL BRACKET.

- LINEWORK LEGEND**
- EXISTING
  - NEW WORK

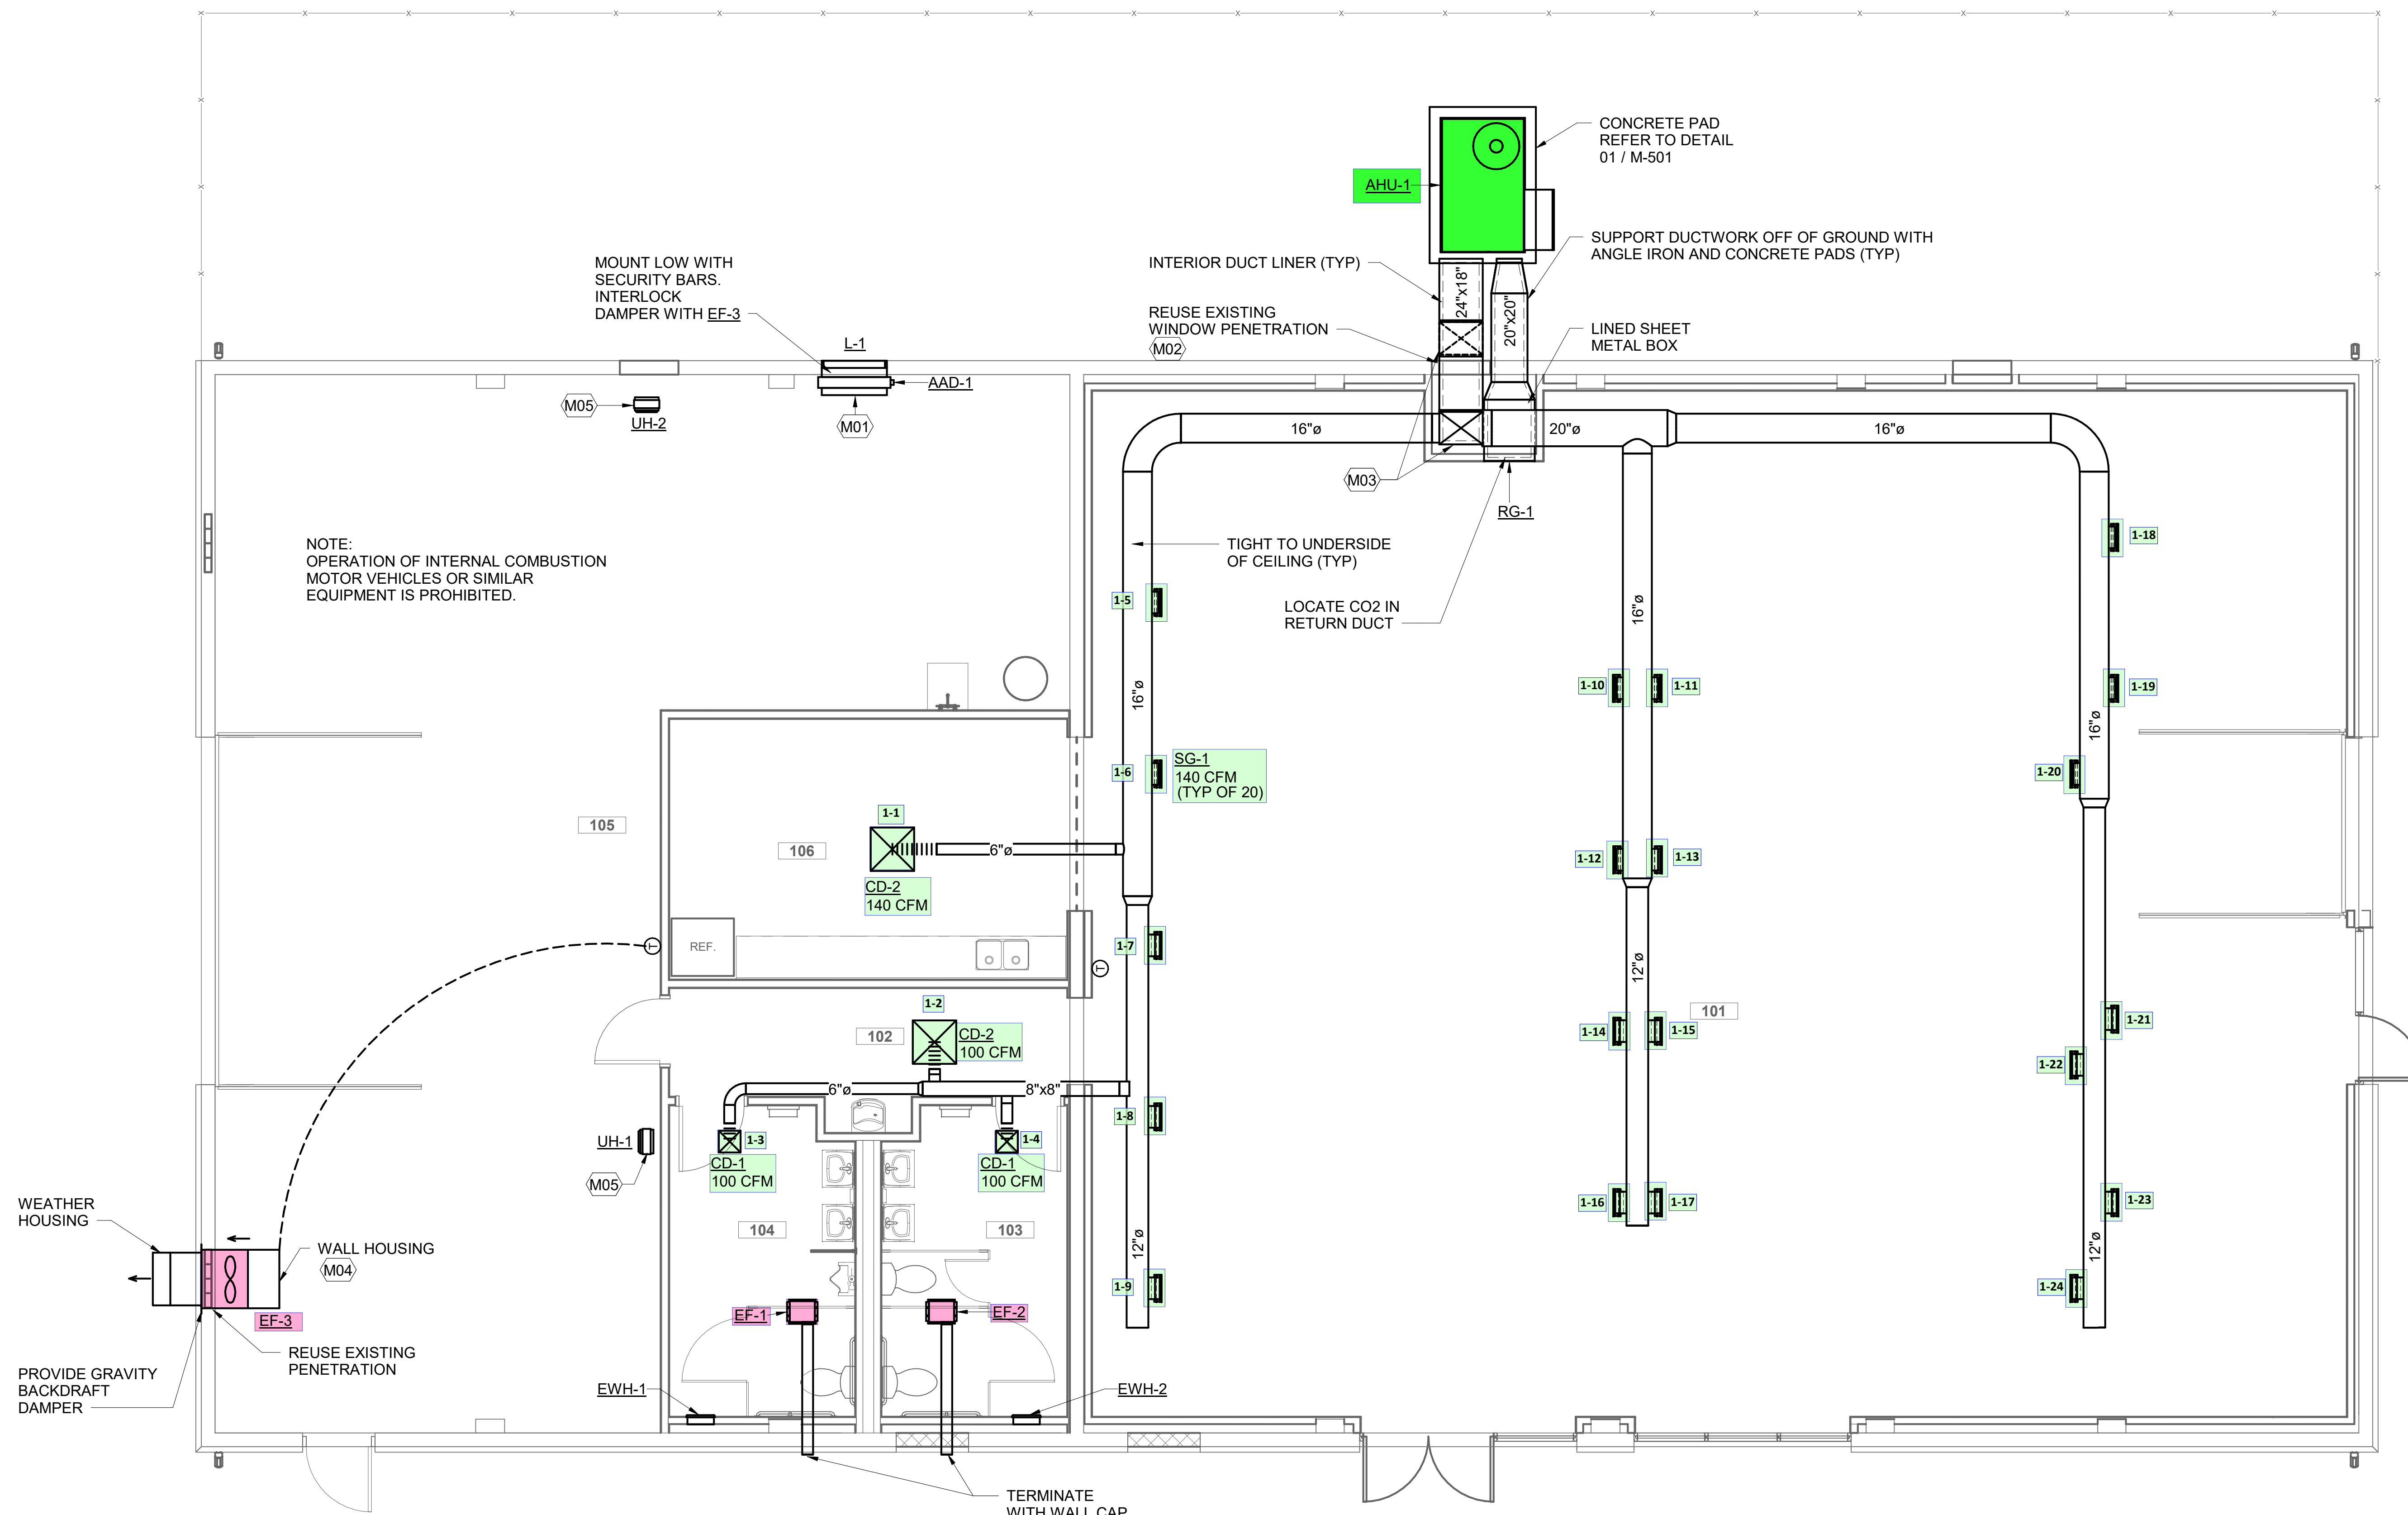

NOTE:  
OPERATION OF INTERNAL COMBUSTION  
MOTOR VEHICLES OR SIMILAR  
EQUIPMENT IS PROHIBITED.

01 MECHANICAL FLOOR PLAN  
M-101 1/4" = 1'-0"

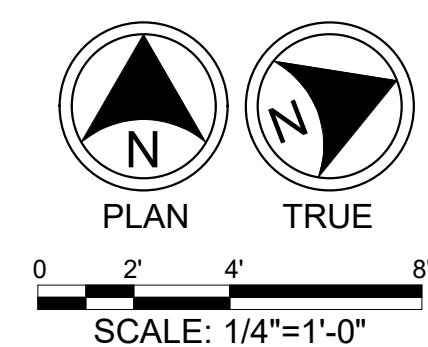

# KINGSWOOD PARK BARN RENOVATION

Irwin Simpson Rd, Mason, OH 45040

**KZF DESIGN**  
Designing Better Futures

**KZF DESIGN INC.**  
700 Broadway Street  
Cincinnati, OH 45202

main 513.621.6211  
kzf.com

**MSP DESIGN**  
McGill Smith Punshon  
3700 Park 42 Drive  
Suite 190B  
Cincinnati OH 45241  
Phone 513.759.0004  
www.mspsdesign.com

DESIGNED CARROLL	COMM. NO. 6669.31
DRAWN CARROLL	DATE 08-04-2021
CHECKED NADEER	PROJ. MGR. S. CSENDES

## MECHANICAL FLOOR PLAN

DRAWING NUMBER ISSUE  
**M-101 1**