


FOR SP  
FUNDAM  
COOLING  
WET BUI  
HEATING

RTU-5 (T1)  
RTU-3 (T1)  
RTU-2 (T1)  
RTU-1 (T1)  
EH-1 (T3)

NOTE: RTU-3 T-STAT IN OFFICE TO BE CONTROLLER, BUT LEAVE SENSOR WIRING WITHIN T-STAT. PROVIDE 6" SPACE BETWEEN T-STATS FOR SERVICE.

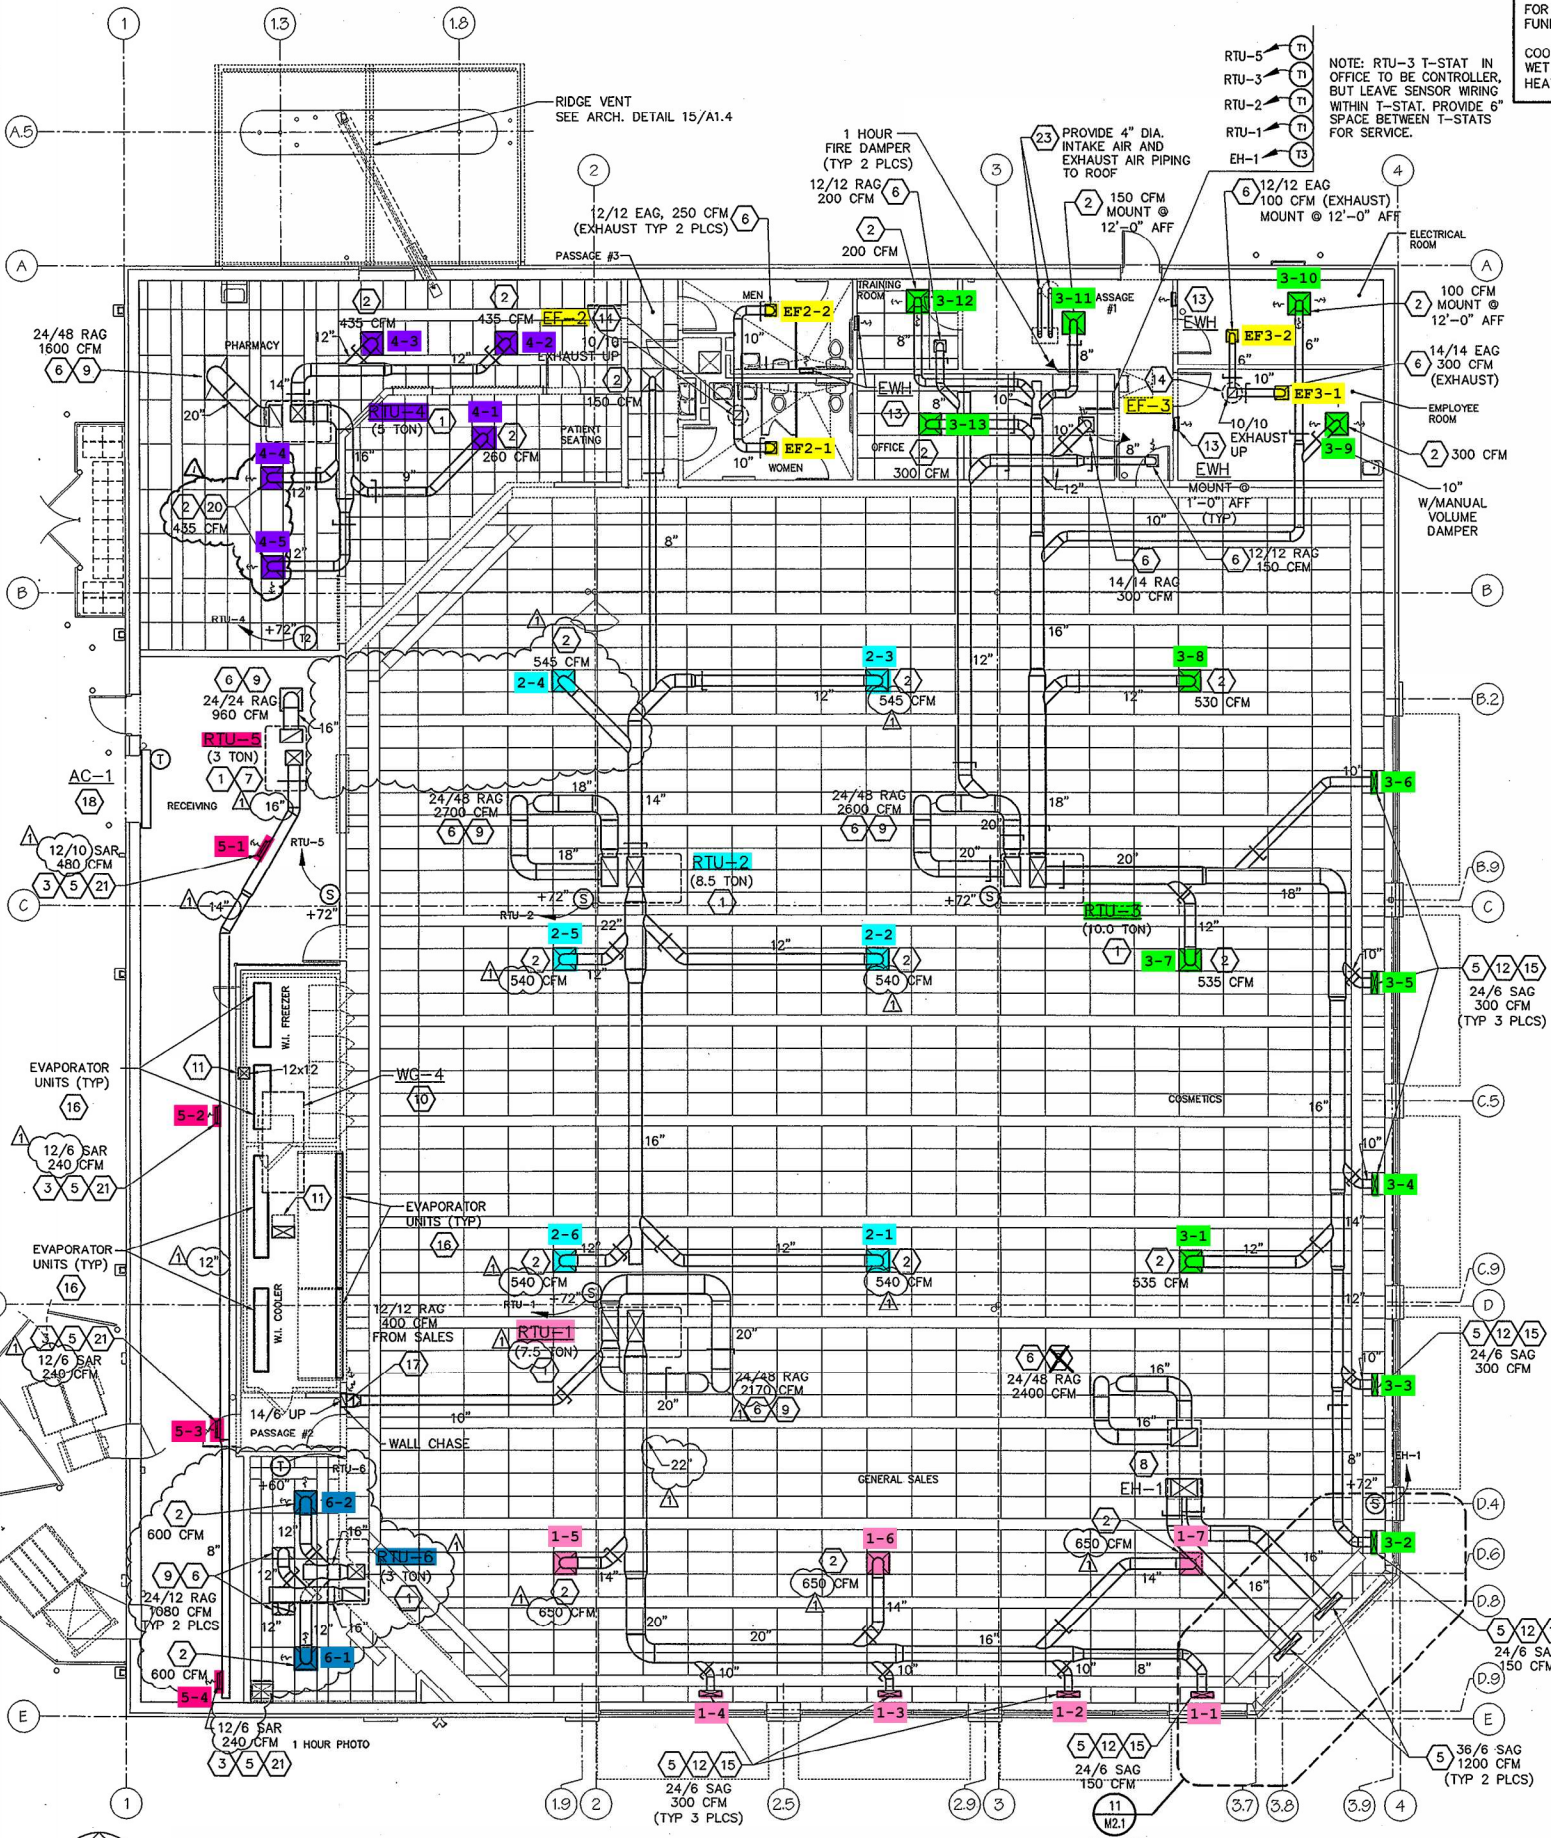

**FLOOR PLAN - MECHANICAL**  
SCALE: 1/8"=1'-0"



(TOWER)