


1 MECHANICAL PLAN
 M001 SCALE: 1/4"=1'-0"

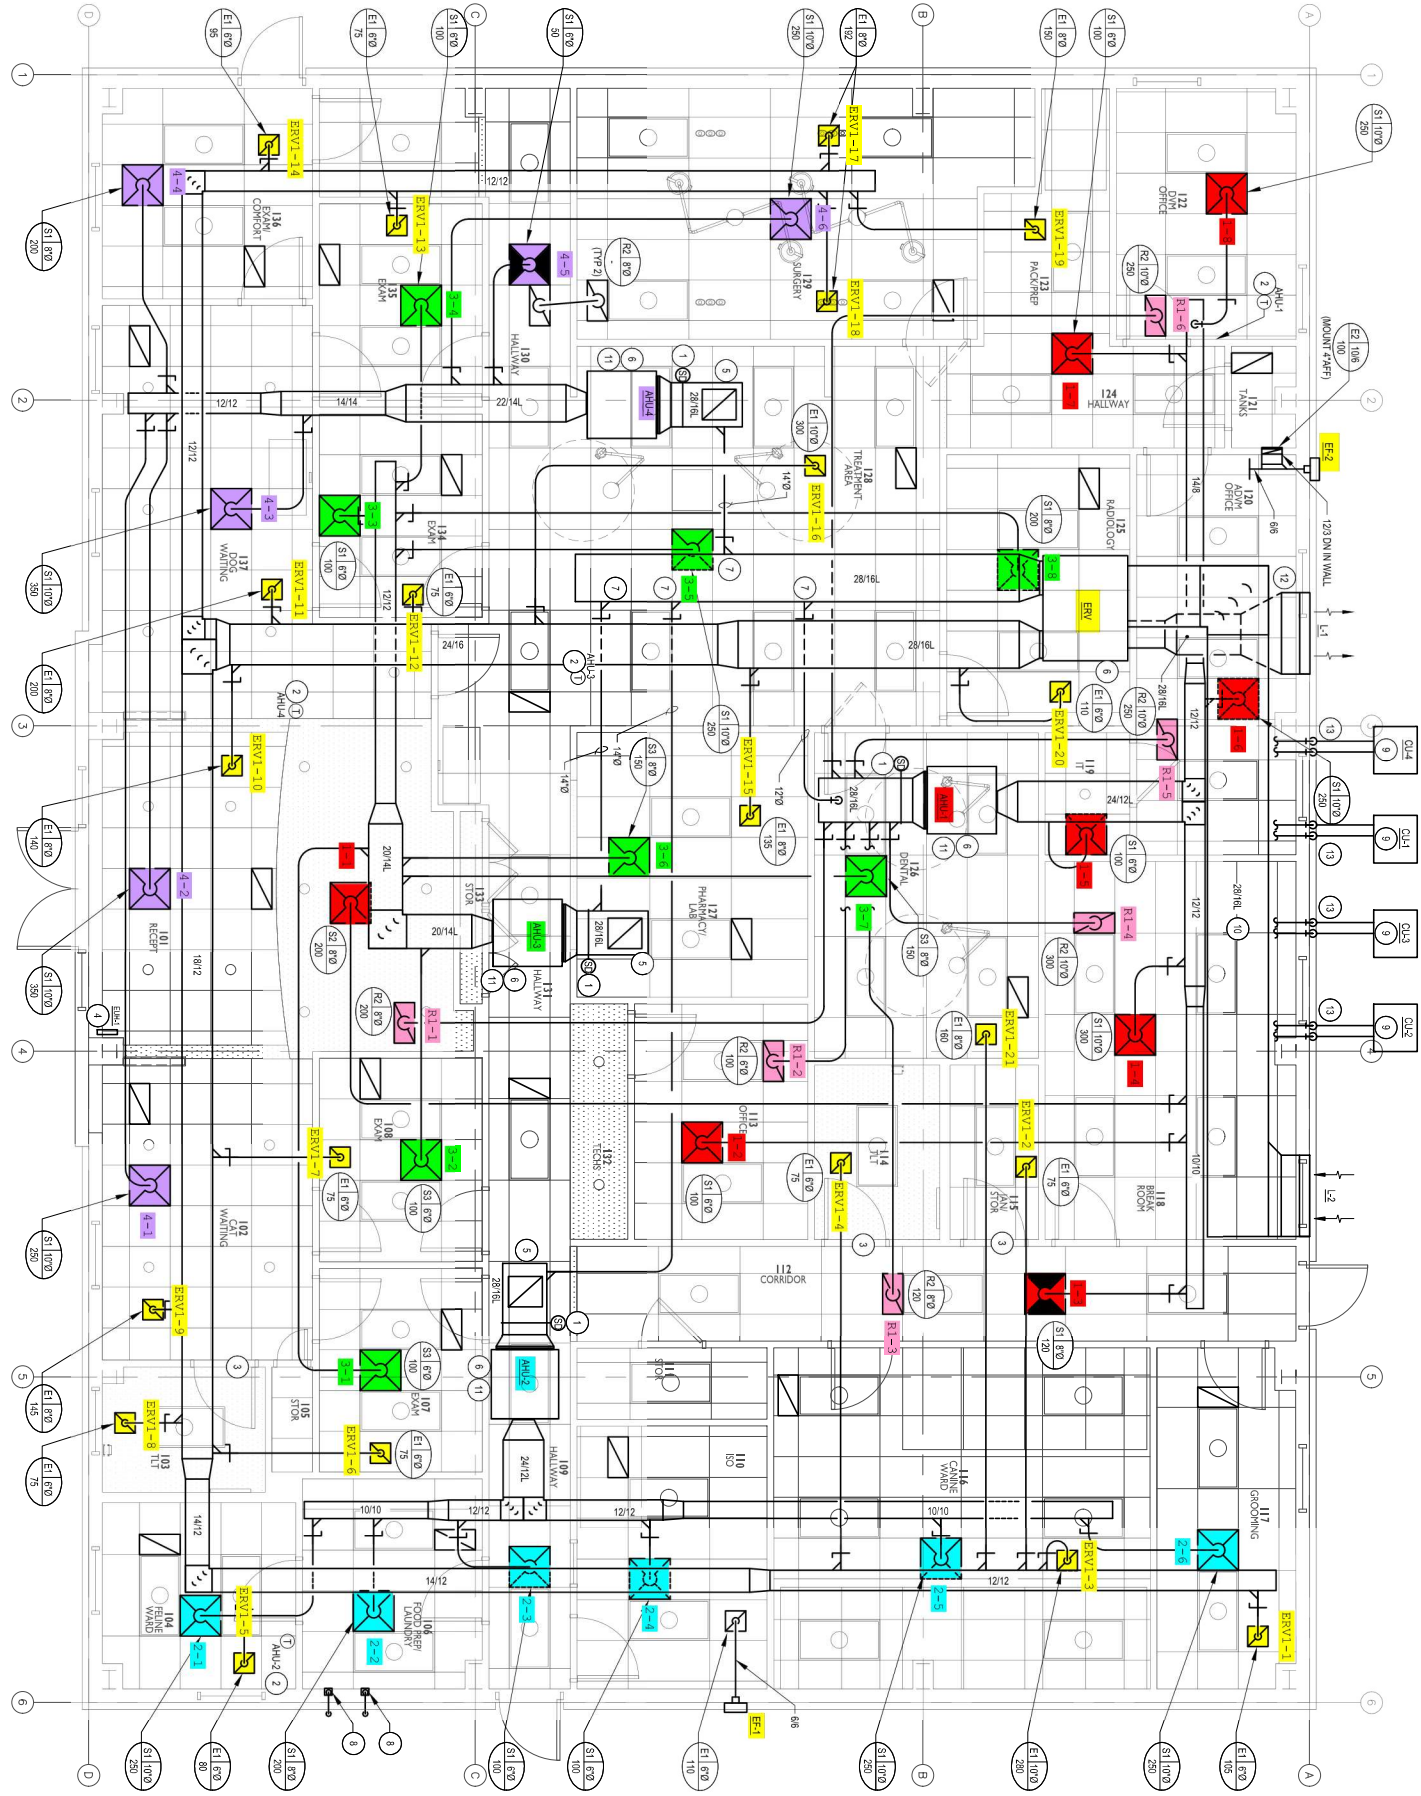

- 4. MEC
- 3. FLO
- 2. PEN
- 1. WAI
- 0. ALL
- 15. CON
- 14. TRN
- 13. THR
- 12. UNL
- 11. BSA
- 10. ALL
- 9. CHA
- 8. ANG
- 7. DUC
- 6. DUC
- 5. ANC
- 4. ANC
- 3. ANC
- 2. ANC
- 1. SMC
- 0. SMC

- 13. SIZE
- 12. DIA
- 11. DIA
- 10. DIA
- 9. DIA
- 8. DIA
- 7. DIA
- 6. DIA
- 5. DIA
- 4. DIA
- 3. DIA
- 2. DIA
- 1. DIA
- 0. DIA