



A1 HVAC PIPING PLAN - LEVEL 1 - AREA B - T.I.
3/16" = 1'-0"

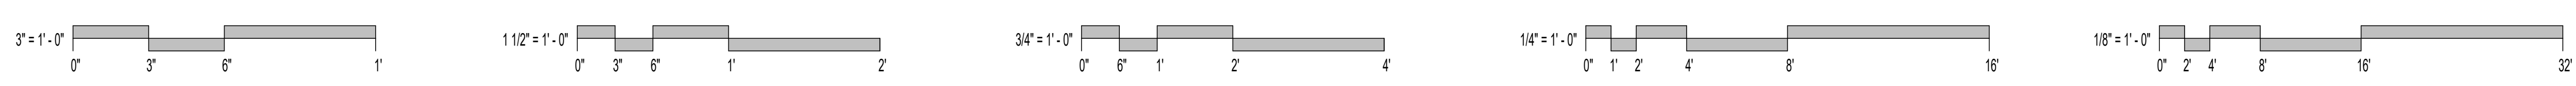

* REFERENCE 'G' SERIES FOR GENERAL NOTES AND ADDITIONAL INFORMATION.

- GENERAL NOTES:
- REFER TO SHEET 2M1-110 FOR ADDITIONAL GENERAL NOTES.
- PLAN NOTES:
- REFRIGERANT PIPING UP THRU ROOF AND ROUTE TO INDOOR UNIT. SIZE AND ROUTE PER MANUFACTURERS INSTRUCTIONS.
 - TERMINATE 1" CONDENSATE DRAIN OVER FLOOR DRAIN.

KEY PLAN

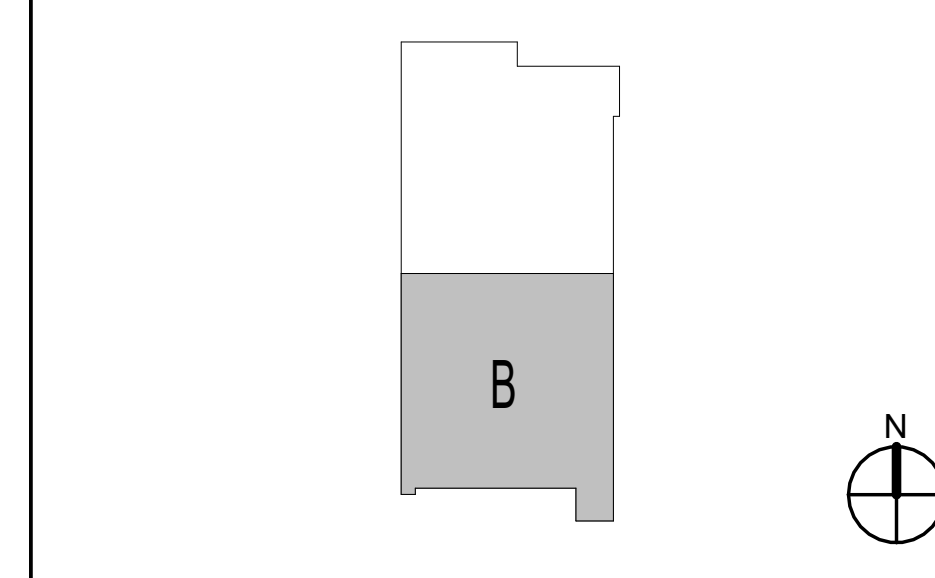

PULSE+ DESIGN GROUP
 422 Pennsylvania Ave., Suite 1050
 Kansas City, MO 64112
 pulse+designgroup.com
 PR: (913) 438-9095
 FX: (913) 438-2680

STATE OF MISSOURI
 RYAN JEROD DIEDERIK
 NUMBER 2015000020
 EXPIRES 03/31/25
 PROFESSIONAL ENGINEER
 3/20/25


smith & boucher engineers
 25618 west 103rd St. olathe, ks 66061
 phone 913.345.2127 fax 913.345.0617
 project number 2424300 P2

PLATE CITY ASC
 NUEHEALTH
 PACKAGE 2 TI CONSTRUCTION DOCUMENTS


nueHealth
 A ValueHealth Company

1101 KENTUCKY AVENUE
 PLATE CITY, MO 64079
 STATE NO. 4637860
 KDSIF 12345


ISSUE DATE:	03/20/2025
PROJECT #:	24158
REVISION	DATE
4 ADDENDUM #4	04/04/25

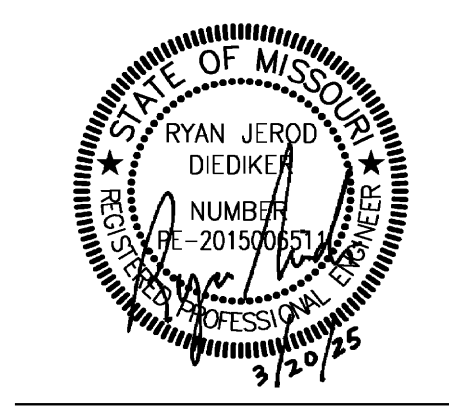

ISSUE DATE:	03/20/2025
PROJECT #:	24158
REVISION	DATE

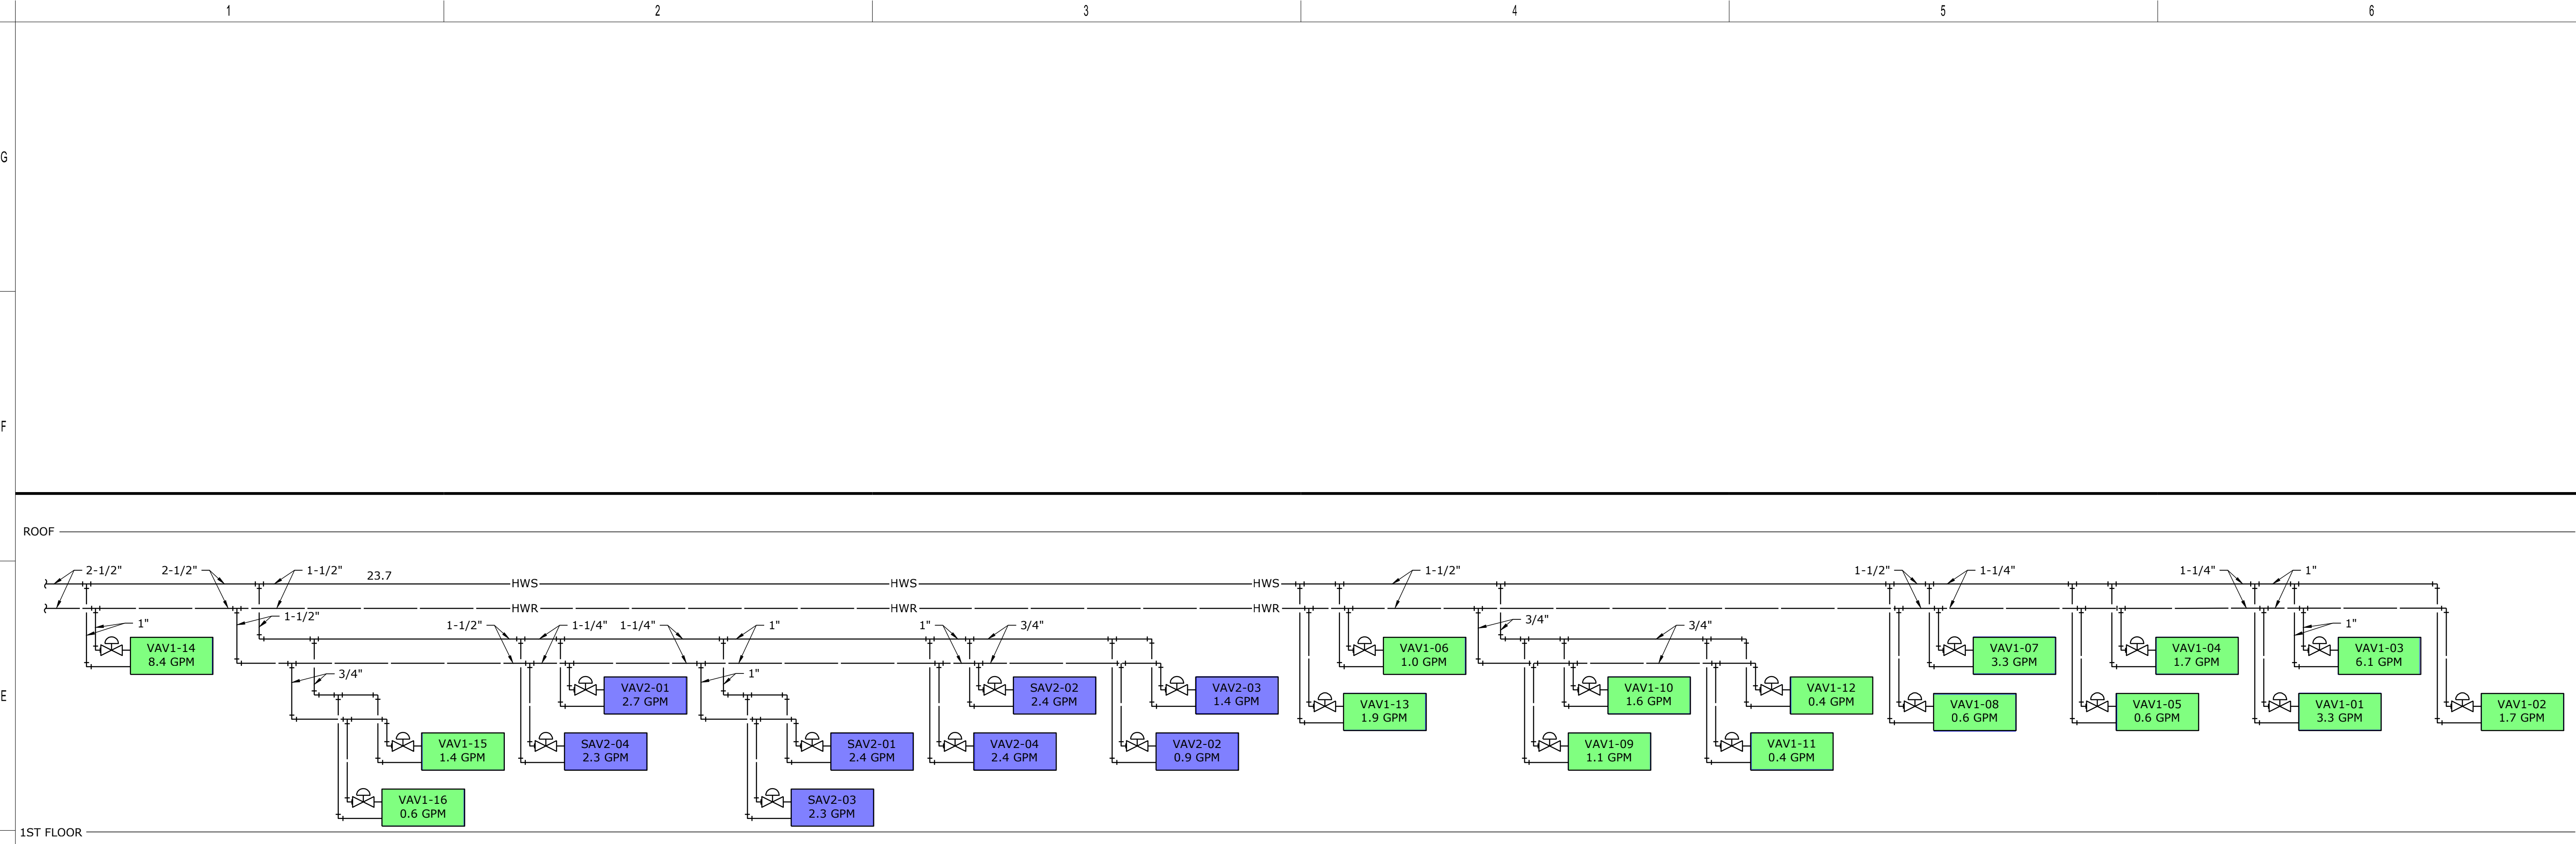


HEATING HOT WATER PIPING SCHEMATIC
NO SCALE

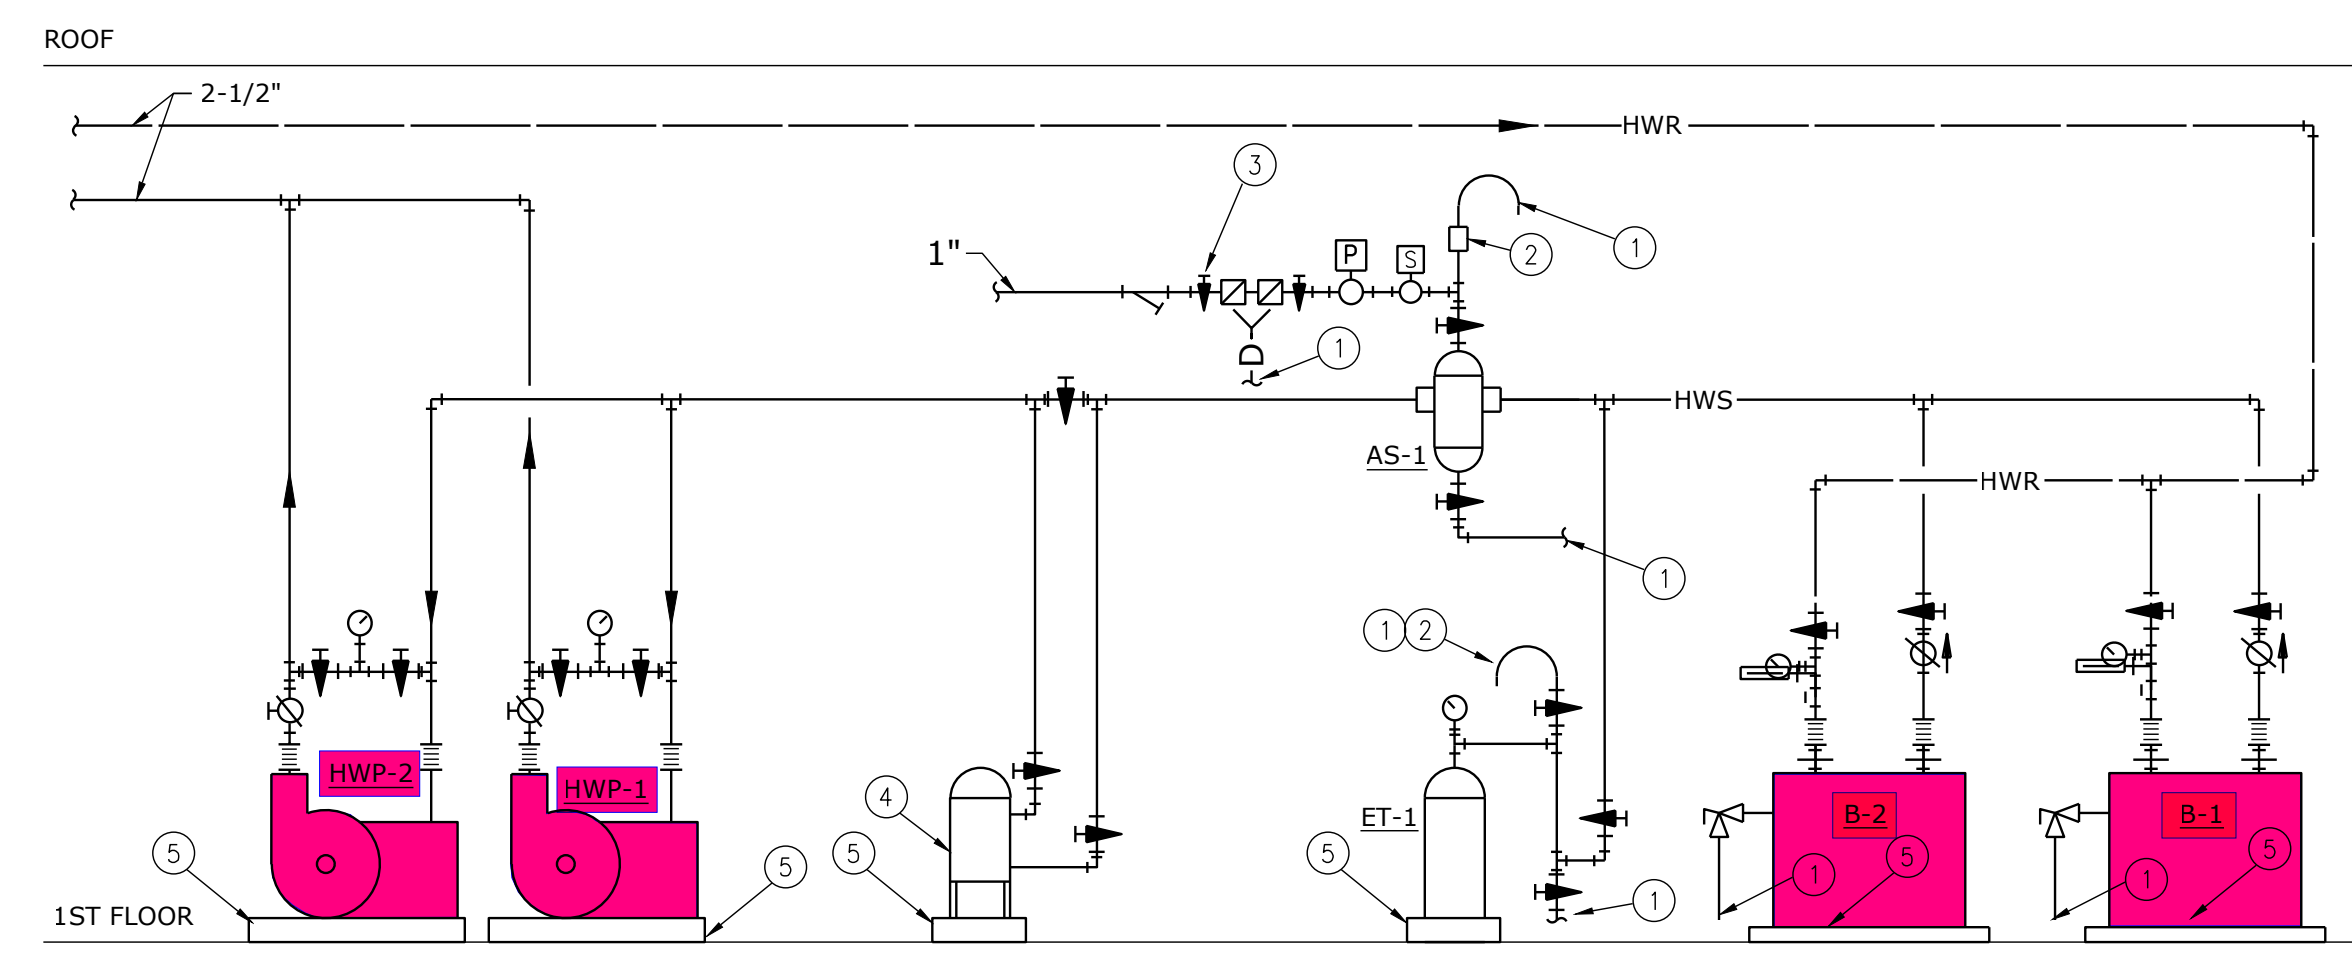

- PLAN NOTES:**
- 1 RELIEF VALVE SET TO XX PSI END. TERMINATE DRAIN LINE OVER FLOOR DRAIN.
 - 2 AUTOMATIC AIR VENT.
 - 3 MAKE UP/FILL WATER SYSTEM.
 - 4 CHEMICAL TREATMENT FILTER/FEEDER.
 - 5 PROVIDE HOUSEKEEPING PAD, COORDINATE EXACT SIZE AND LOCATION WITH EQUIPMENT PROVIDED.

MECHANICAL ROOM HOT WATER PIPING SCHEMATIC
NO SCALE

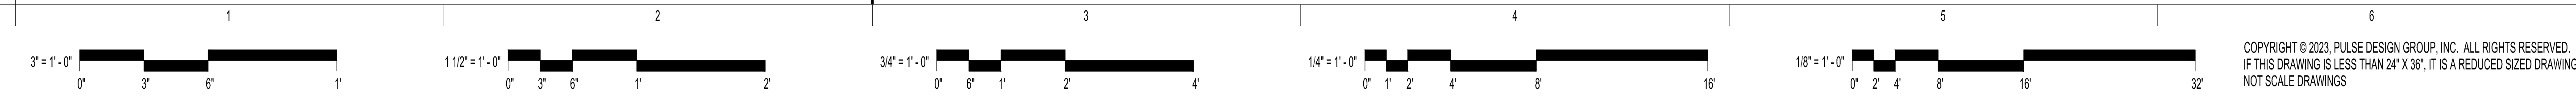

COPYRIGHT © 2023, PULSE DESIGN GROUP, INC. ALL RIGHTS RESERVED. NOTE: IF THIS DRAWING IS LESS THAN 24" X 36", IT IS A REDUCED SIZED DRAWING. DO NOT SCALE DRAWINGS

PROJECT NAME: 2314708 Liberty SD 2023 Heritage MS Renovations
AUTOCAD FILE LOCATION: \NAME:
LAST CORRECTION BY: DATE: TIME:
PLOTTED BY: DATE: TIME:
Jiangenfeld Thursday, March 20, 2025 1:05:42 PM
Booby Charles Thursday, March 20, 2025 4:25:54 PM