
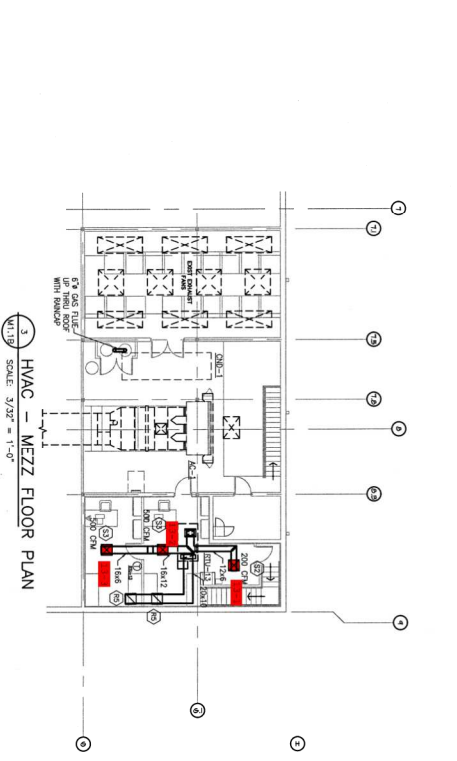


HVAC - FLOOR PLAN LEFT

MATCHLINE - SEE SHEET M.11 FOR CONTINUATION.

NOTE	SEE SHEET M.11 FOR CONTINUATION.
DATE	12/12/20
BY	JAN
CHKD	JAN
APP	JAN
CON	JAN

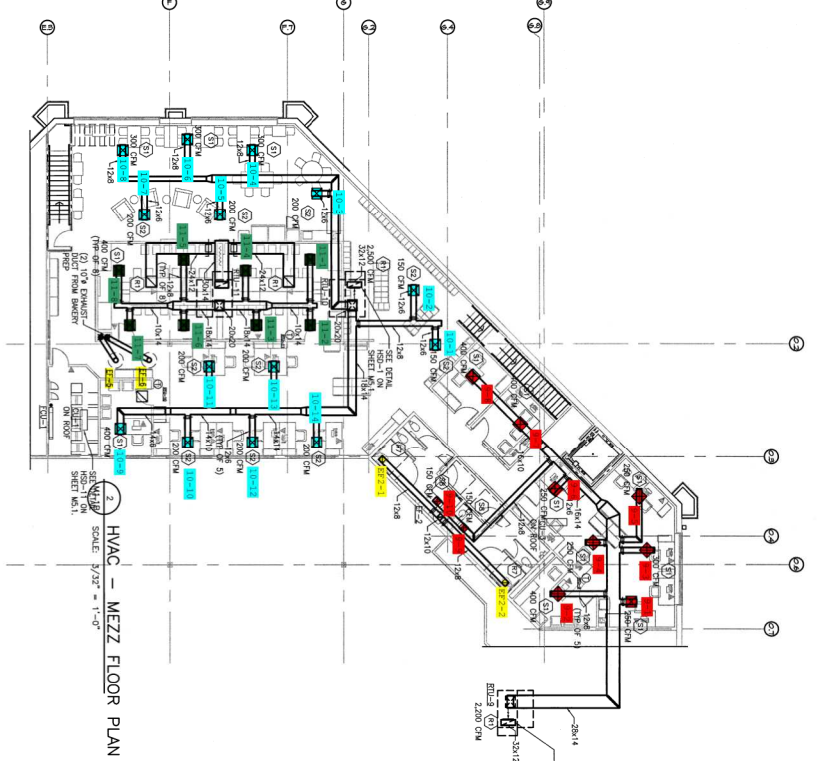


HVAC LEGEND & ABBREVIATIONS

<input checked="" type="checkbox"/>	SIMPLY LETTERS
<input checked="" type="checkbox"/>	RETURN GRADE
<input checked="" type="checkbox"/>	AIR DISTRIBUTION TUG
<input checked="" type="checkbox"/>	TEMPERATURE SENSORS
<input checked="" type="checkbox"/>	HUMIDITY SENSORS
<input checked="" type="checkbox"/>	MANUAL VOLUME DAMPERS
<input checked="" type="checkbox"/>	SPRING DAMPERS
<input checked="" type="checkbox"/>	FIRE DAMPERS
<input checked="" type="checkbox"/>	DOOR DAMPERS
<input checked="" type="checkbox"/>	DOOR DAMPERS

DEMOLITION LEGEND

	EXISTING DUCT WORK, REMOVE AND REPAIR
	EXISTING DUCT WORK TO REMAIN AND BE REUSED
	NEW, INSTALLED DUCTWORK

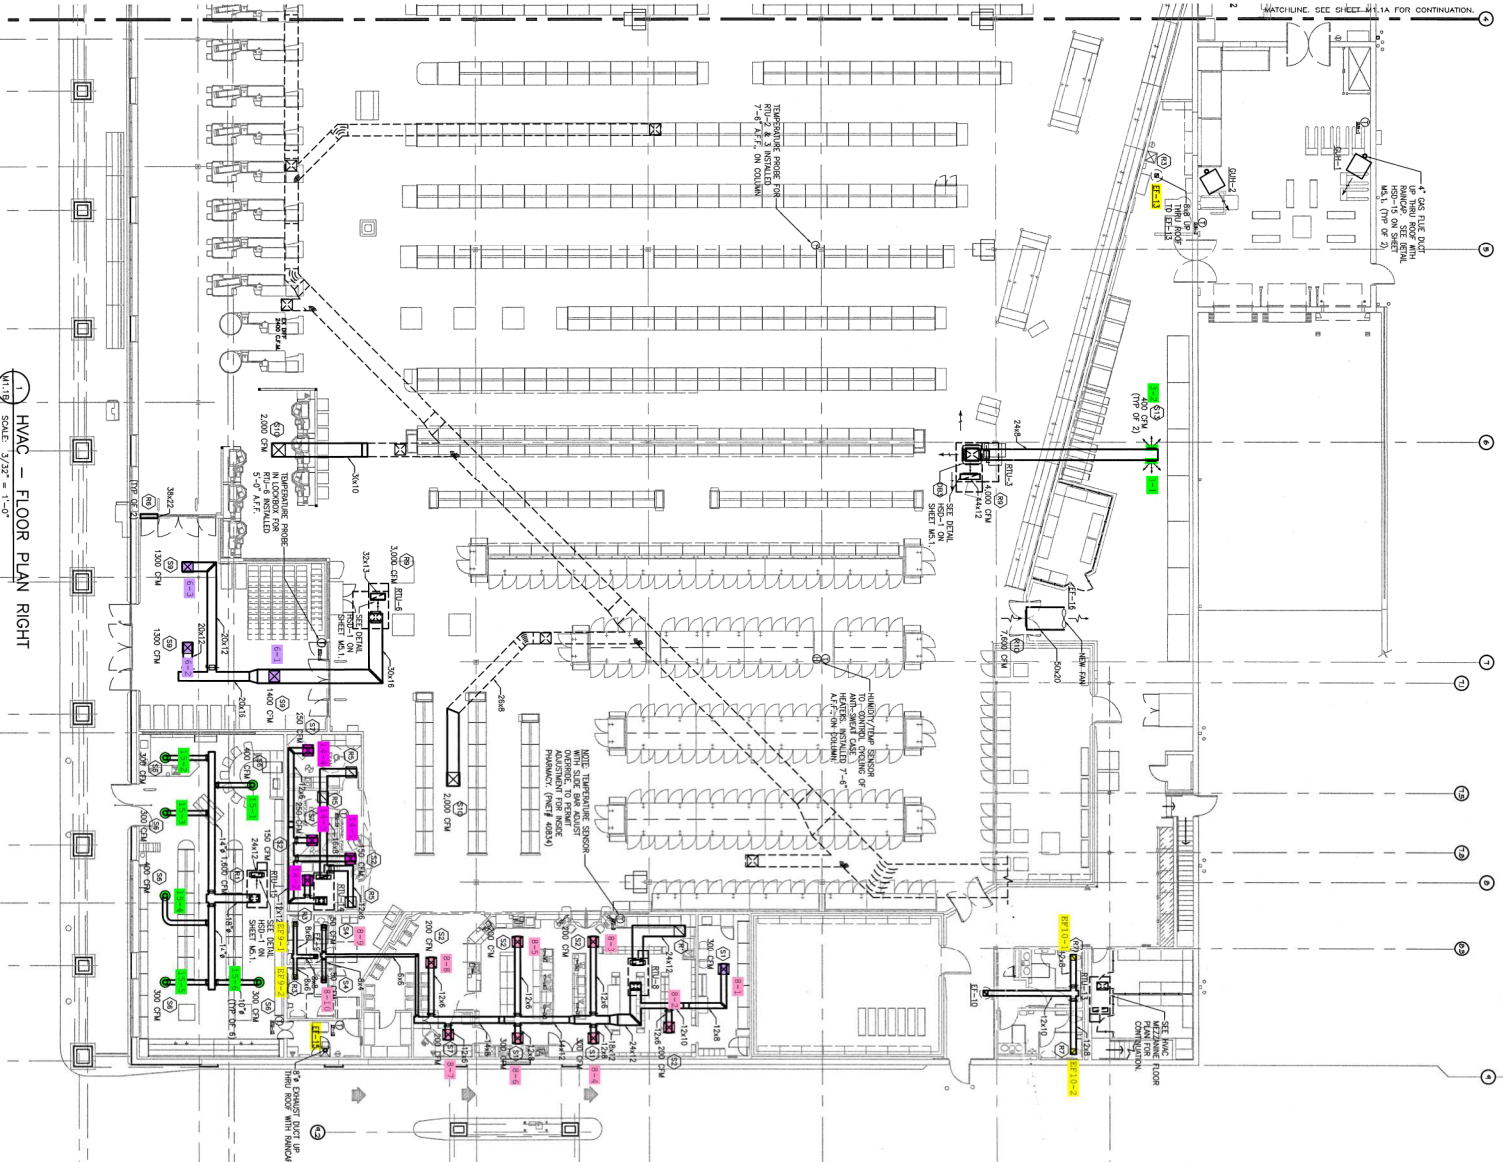

1 HVAC - FLOOR PLAN RIGHT
SCALE: 3/32" = 1'-0"

2 HVAC - MEZZ FLOOR PLAN
SCALE: 3/32" = 1'-0"

3 HVAC - MEZZ FLOOR PLAN
SCALE: 3/32" = 1'-0"