

**PLAN NOTES**

- 1 EXISTING RTU TO BE REMOVED.
- 2 EXISTING RETURN AIR DUCT TO BE REMOVED.
- 3 EXISTING SUPPLY AIR DUCT TO BE REMOVED BACK TO THIS POINT.
- 4 EXISTING SUPPLY AIR DUCT AND DIFFUSERS SHALL REMAIN.

**1 HVAC LEVEL 1**  
SCALE: 1/8" = 1'-0"

222 LINWOOD STREET  
DAYTON, OHIO 45405  
TEL: 937-461-5300  
FAX: 937-461-8829  
RUETSCHLE.COM



Issued:  
10.11.2024  
Permit / Construction REBID


Revisions:

Northeastern Local School District - Northeastern High School Athletic Complex  
**FIELDHOUSE LOCKERROOM ADDITION**  
144 Swanton Rd.  
Springfield, Ohio 45502

Comm. No.  
32204

HVAC DEMO PLAN

Sheet No.

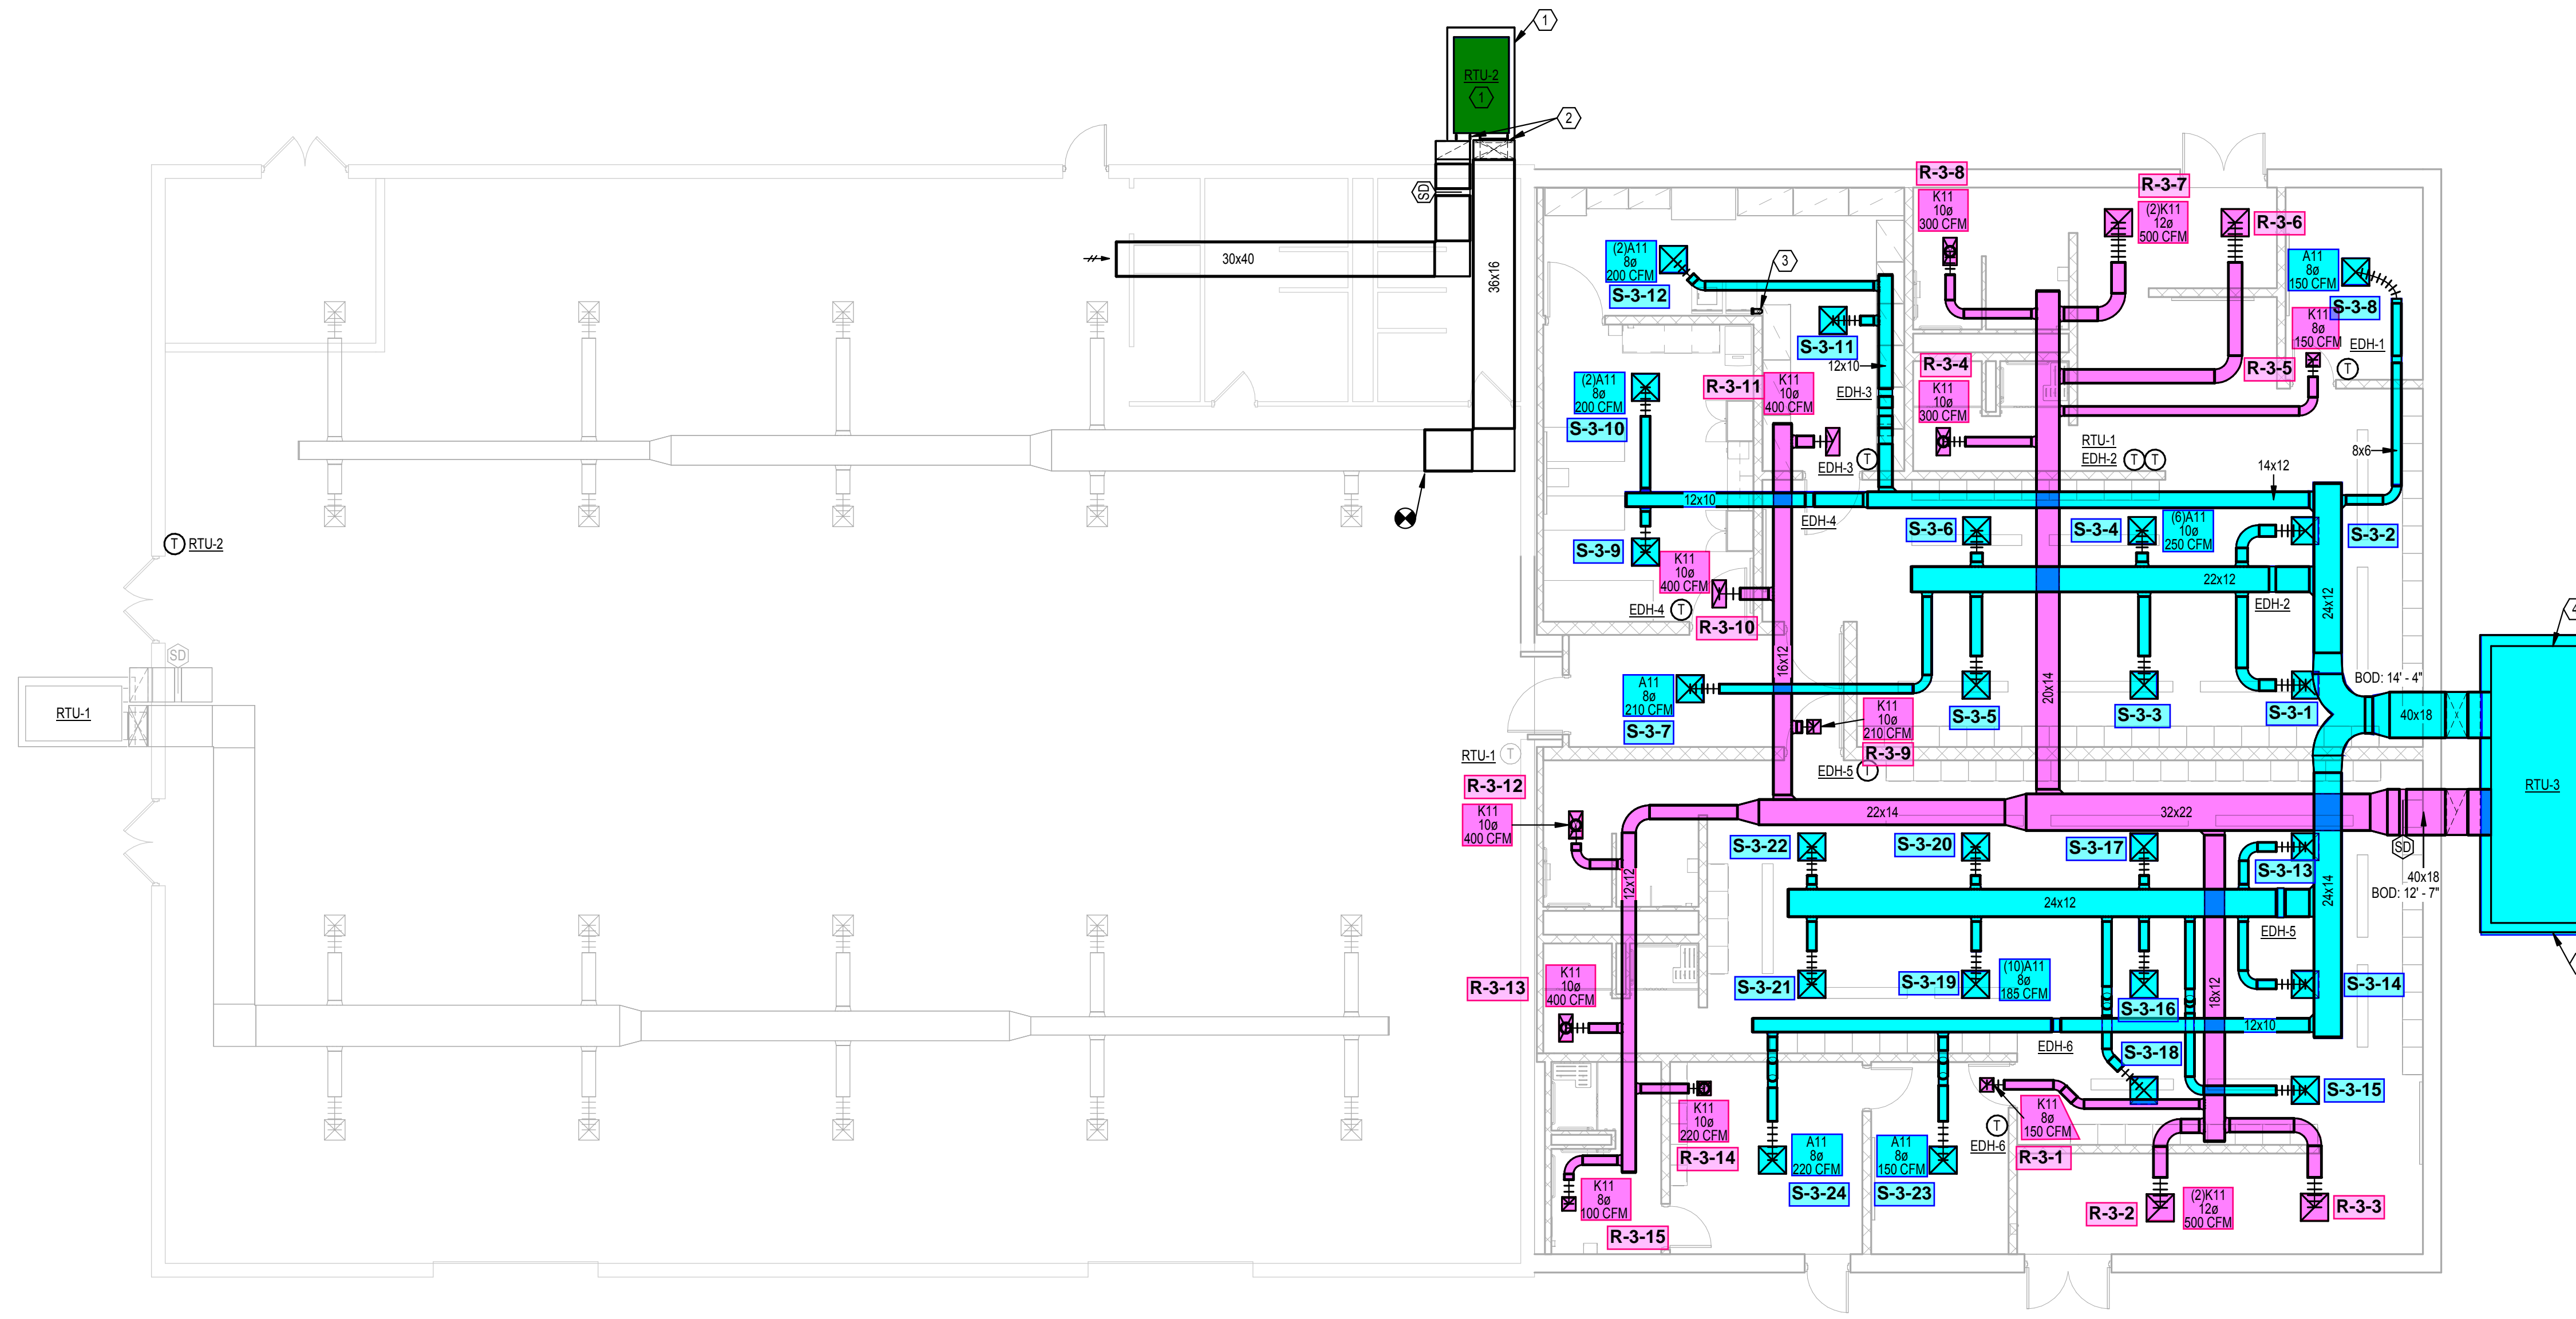


1 HVAC LEVEL 1  
SCALE: 1/8" = 1'-0"



NOTES

- 1 PROVIDE NEW 4" CONCRETE HOUSEKEEPING PAD.
- 2 SUPPLY AND RETURN AIR DUCTS TO TRANSITION AS NEEDED TO CONNECT TO RTU OPENINGS.
- 3 ROUTE 4" DIA. DRYER VENT UP THRU ROOF. SEE DETAIL "B" ON SHEET H303.
- 4 MAINTAIN MANUFACTURER'S RECOMMENDED CLEARANCES ON ALL SIDES OF UNIT.

222 LINWOOD STREET  
DAYTON, OHIO 45405  
TEL: 937-461-5390  
FAX: 937-461-8829  
RUETSCHLE.COM

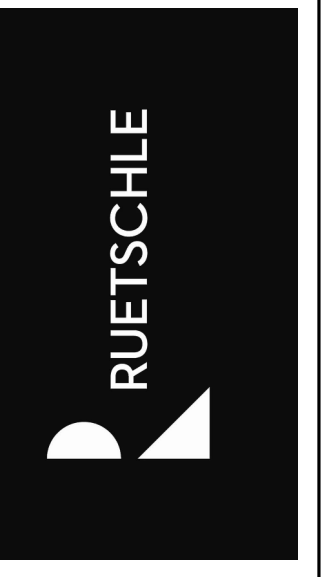

Issued:  
10.11.2024  
Permit / Construction REBID

Revisions:

Northeastern Local School District - Northeastern High School Athletic Complex  
**FIELDHOUSE LOCKERROOM ADDITION**  
141 Sawyers Rd.  
Springfield, Ohio 45502

Comm. No.  
32204  
FIRST FLOOR HVAC PLAN

Sheet No.