


1 MECHANICAL FLOOR PLAN  
SCALE: 1/4" = 1'-0"

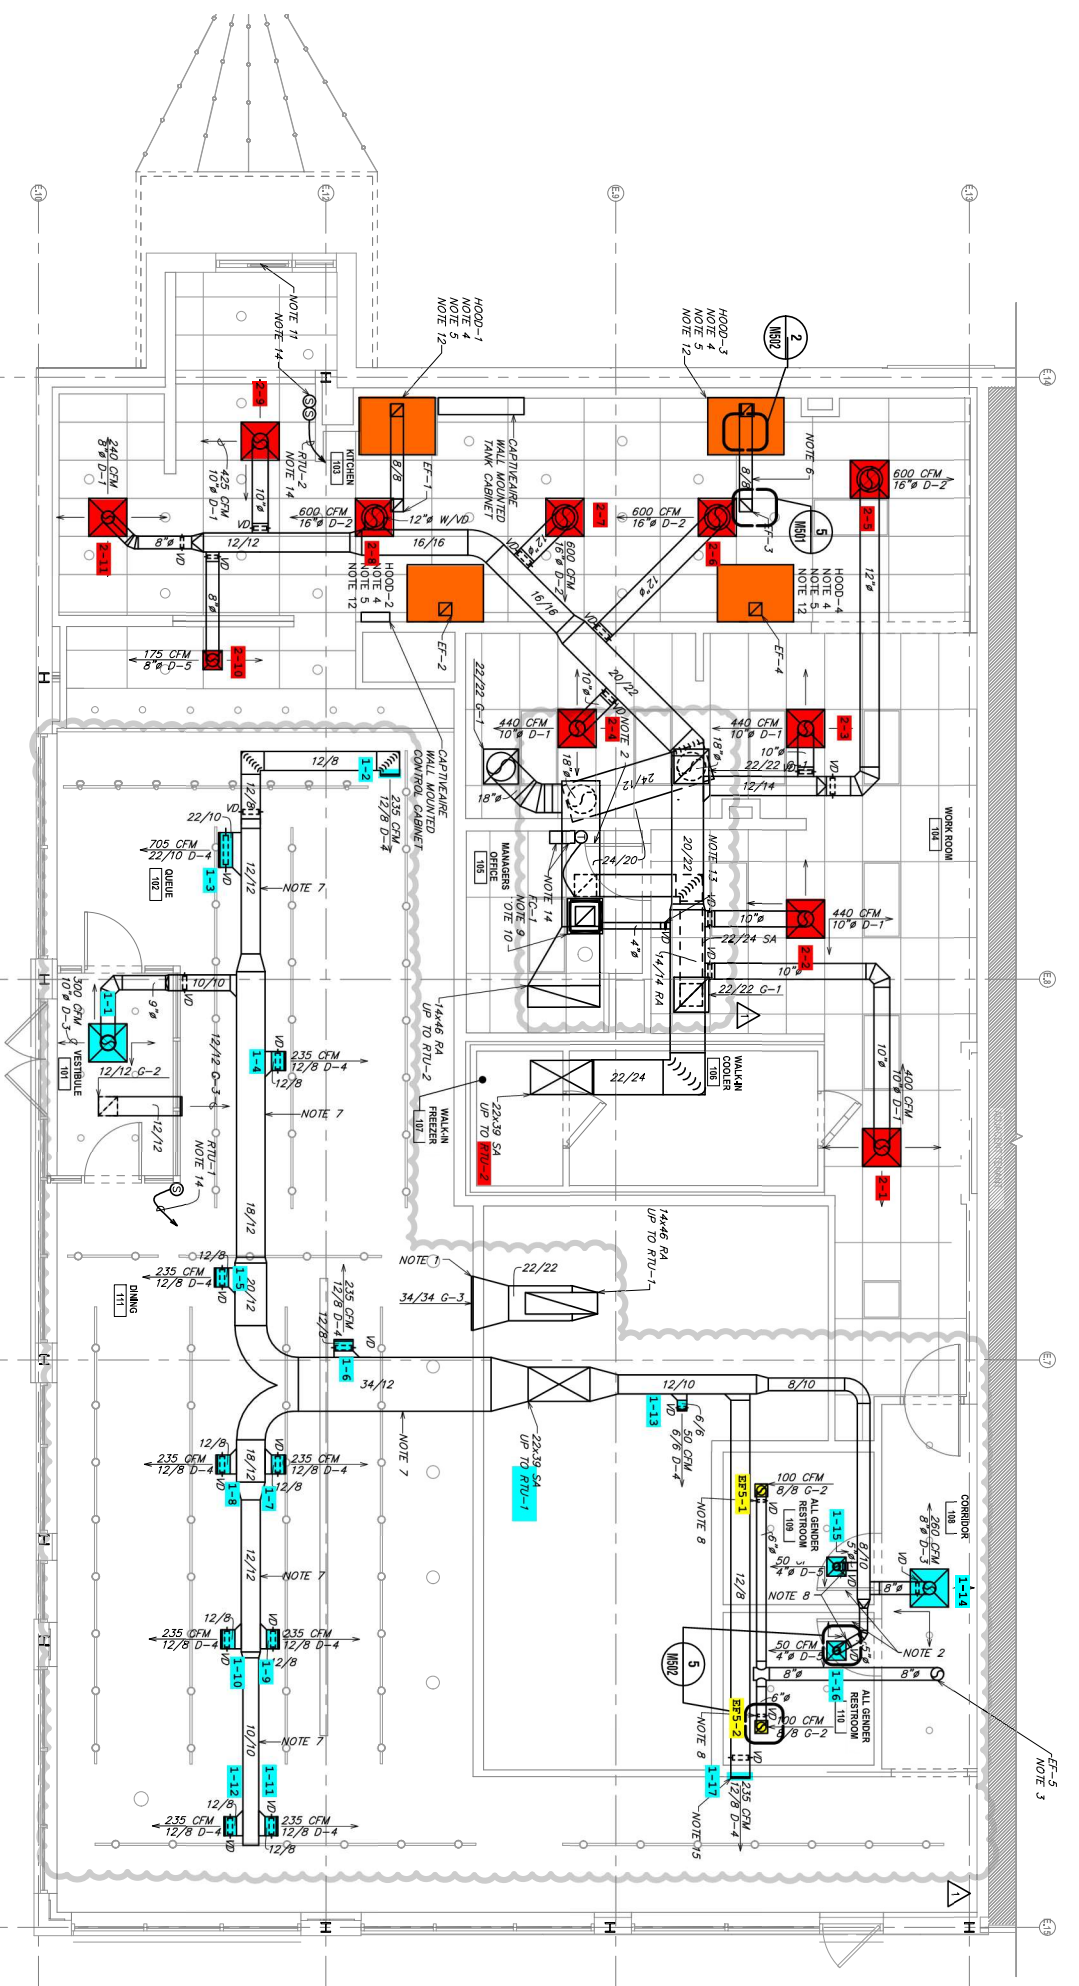

PLATO  
112



FF-5  
NOTE 3