


PROJECT TEAM

ARCHITECTURAL
Wellner Architects, Inc.
802 Broadway, 4th Floor
Kansas City, MO 64105
816.221.0017


STRUCTURAL, MECHANICAL, ELECTRICAL,
PLUMBING, FIRE ALARM, AUDIO/VISUAL
Closson Associates
1301 Burlington St
North Kansas City, MO 64116
816.361.1177

CIVIL & AVIATION PLANNING
Crowford, Murphy, & Tilly, Inc.
1627 Main St, Suite 600
Kansas City, MO 64108
816.800.7447

UNIVERSITY OF CENTRAL
MISSOURI
SKYHAVEN AVIATION CENTER
NW 251 Road, Warrensburg, MO 64093

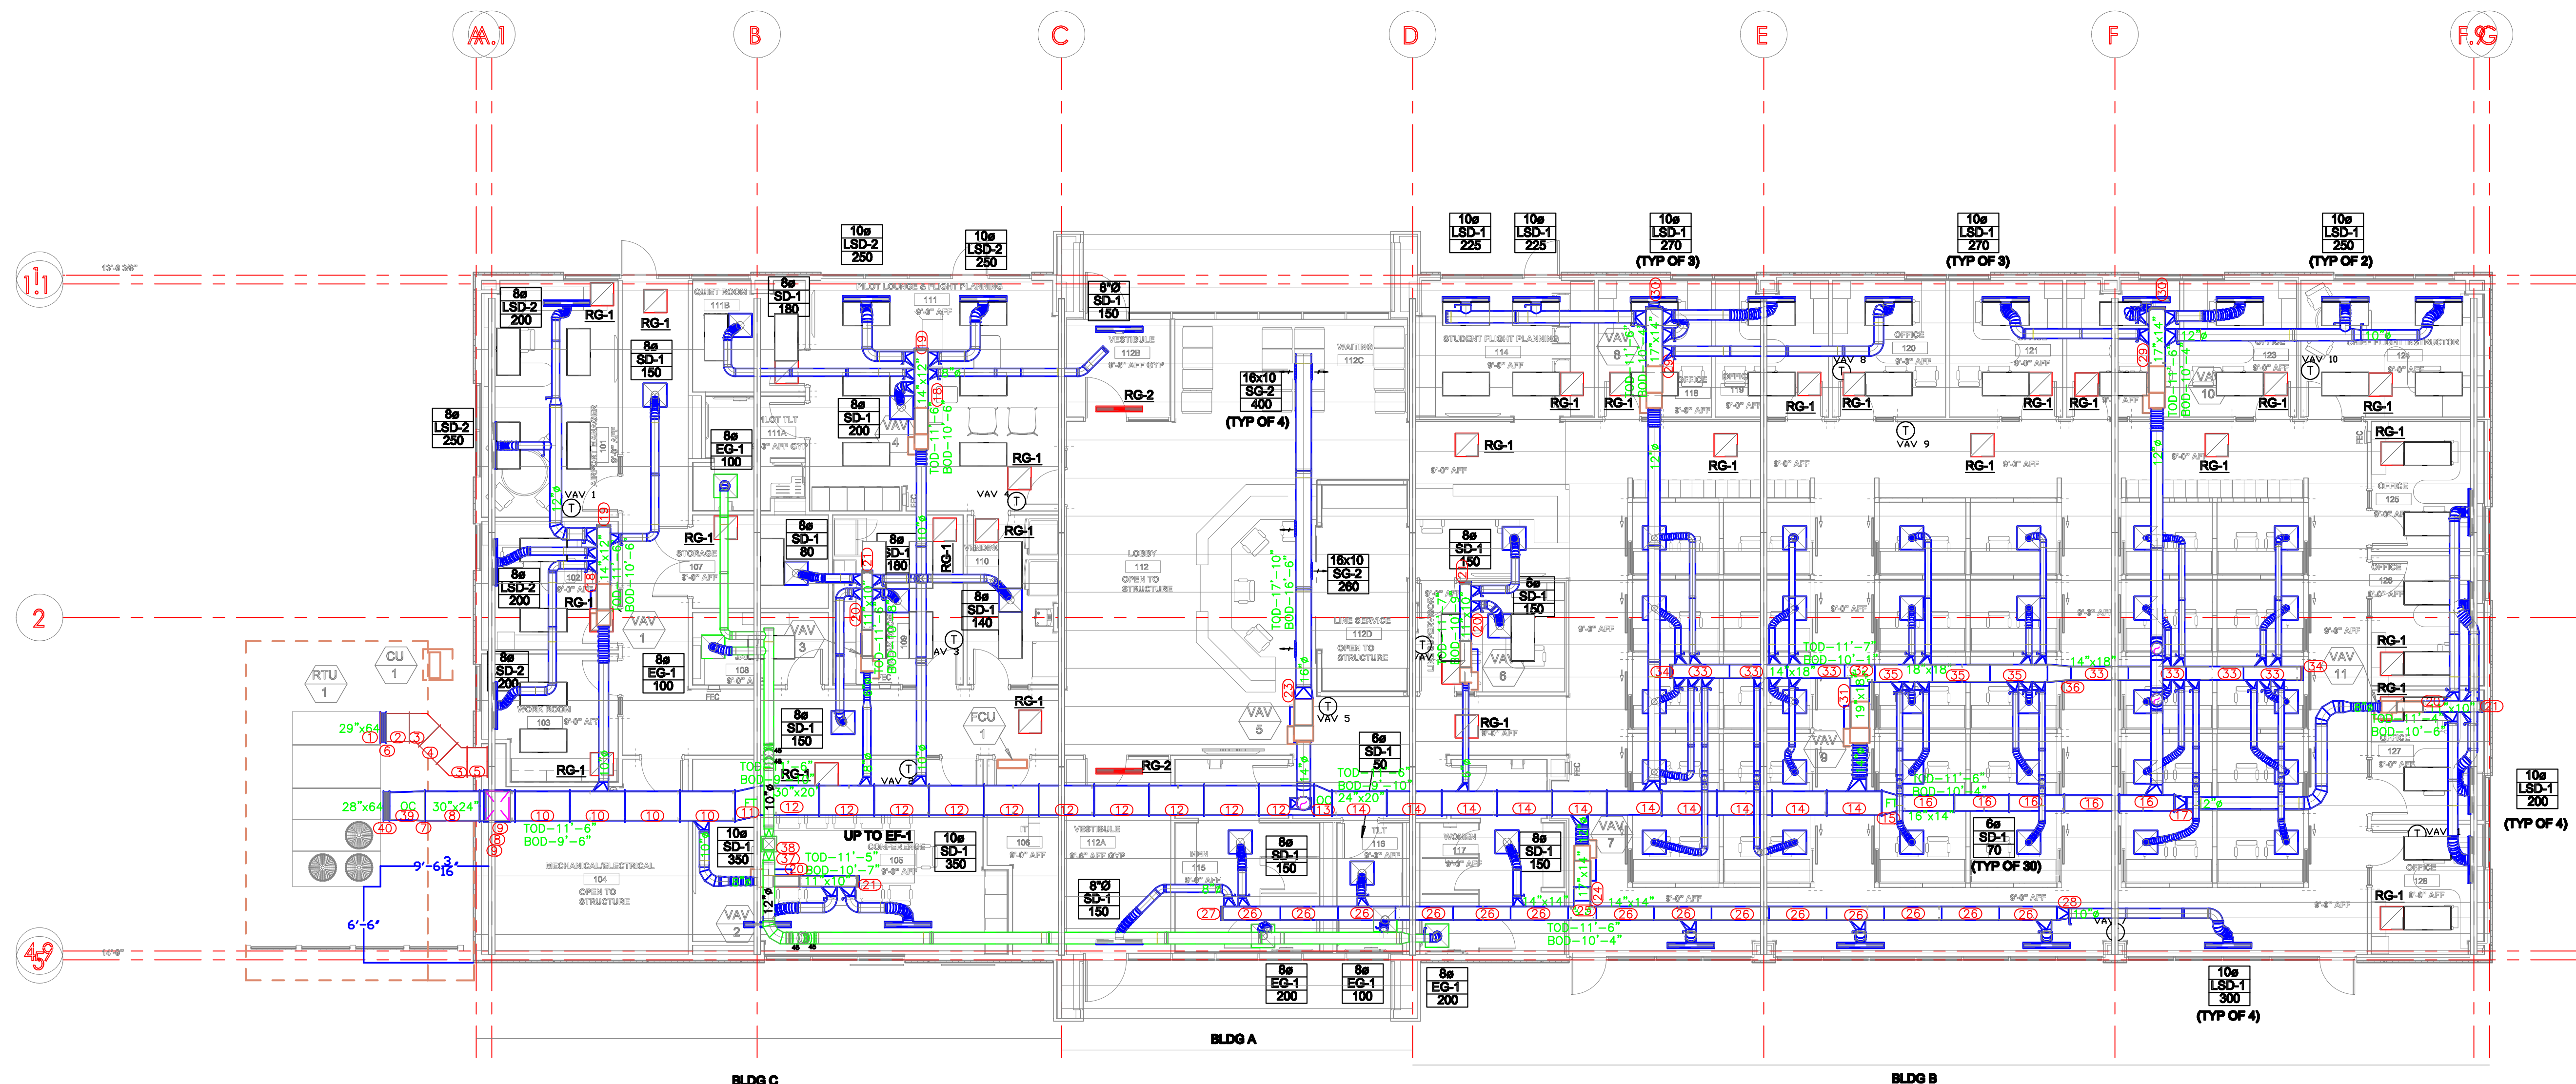


LEVEL 1 - HVAC PLAN

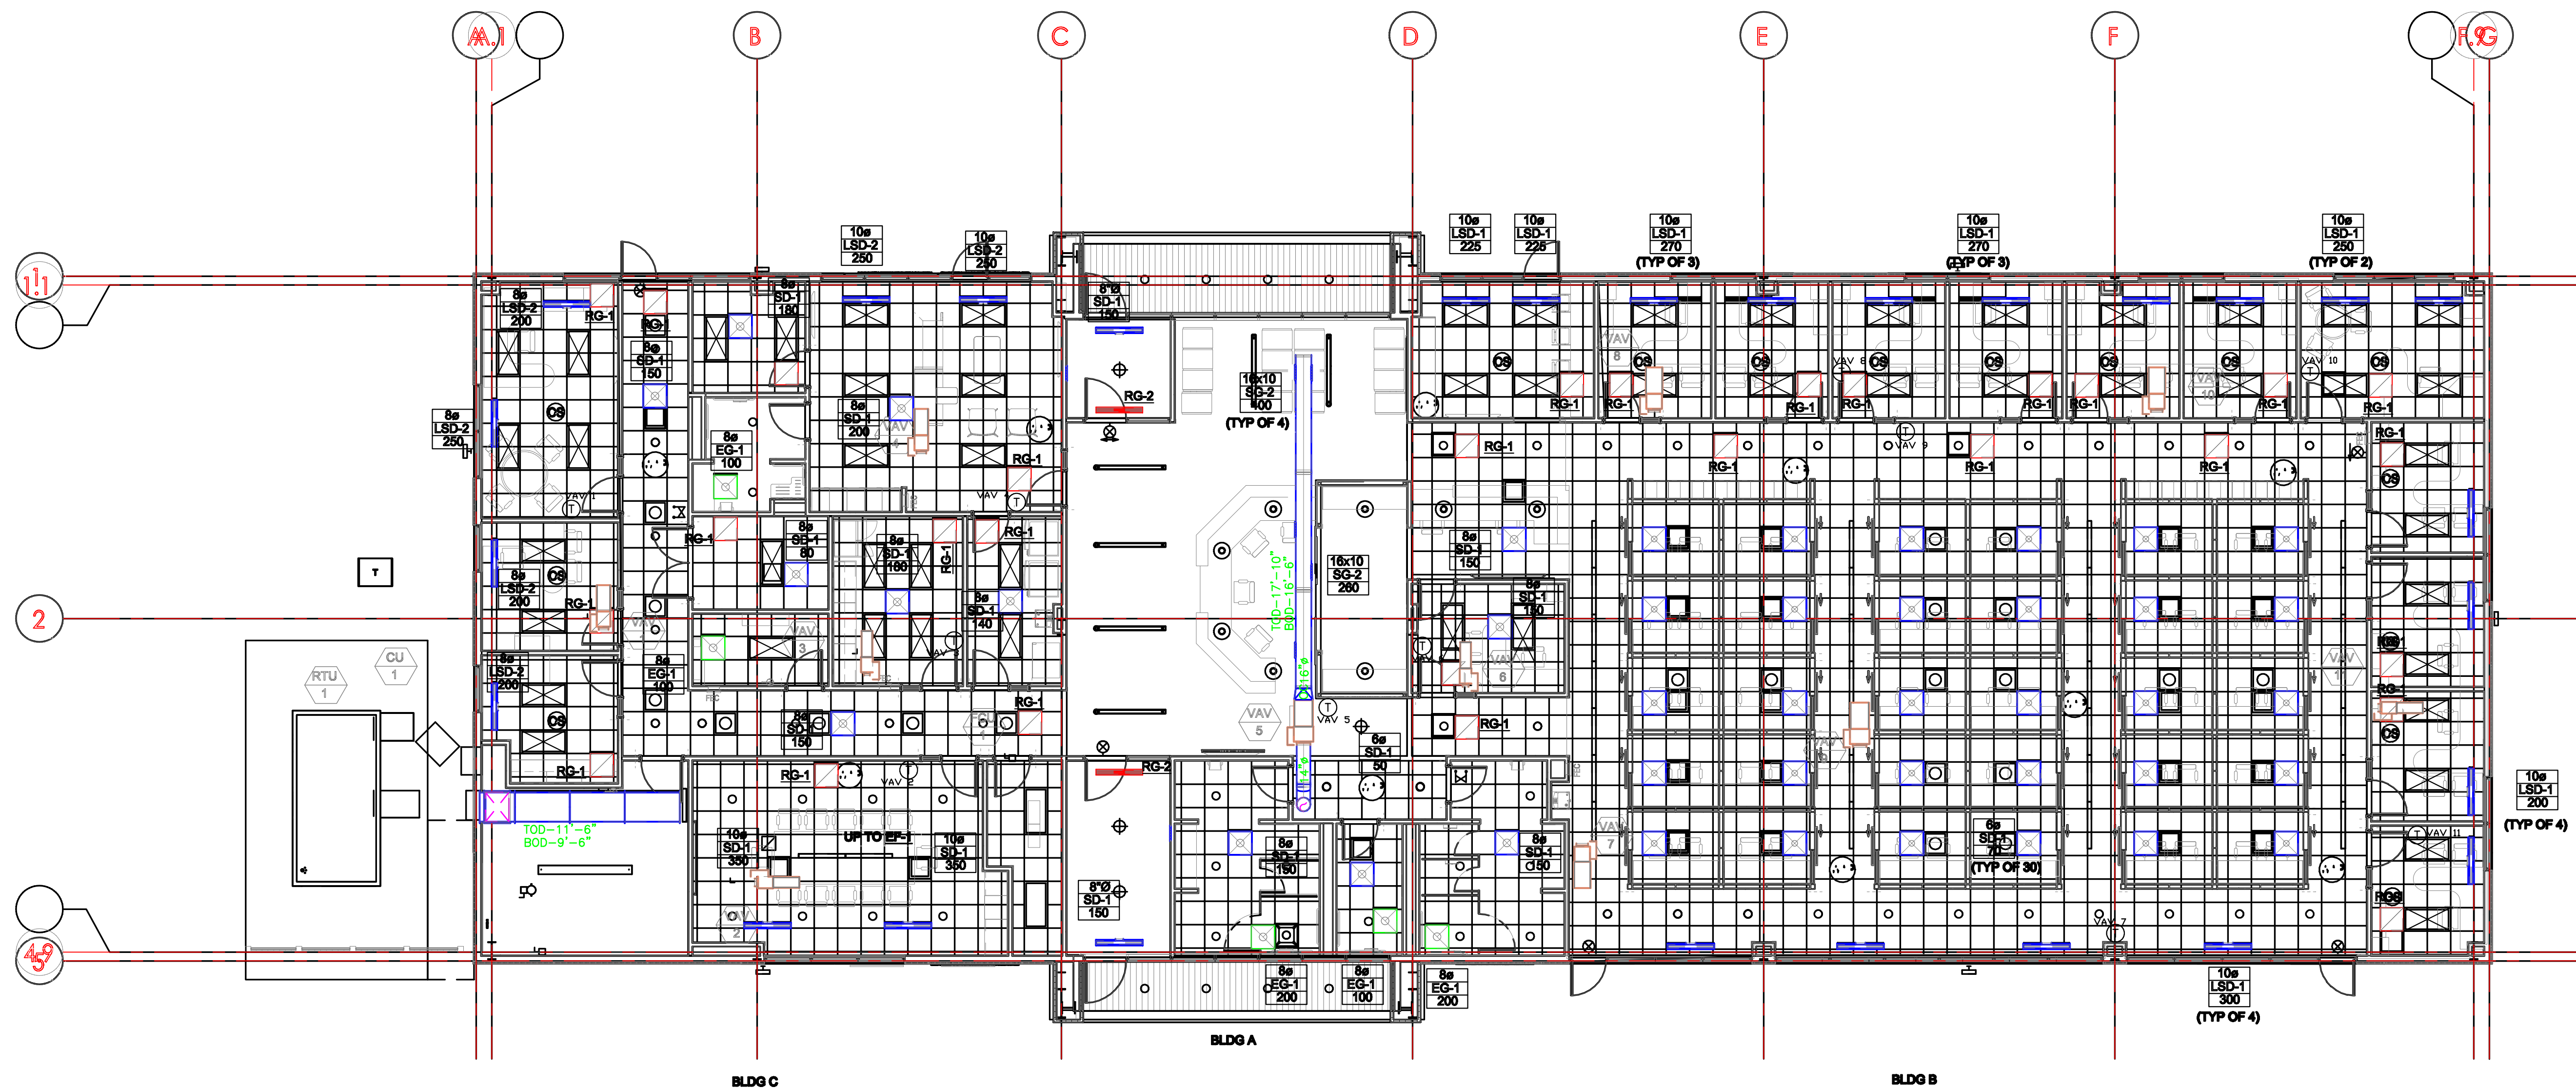

LEVEL 1 - REFLECTIVE CEILING PLAN

No. Date Description
Issue: FOR CONSTRUCTION
Date: AUGUST, 2022
Drawn By: EH Checked By: JG

KEY PLAN
NORTH

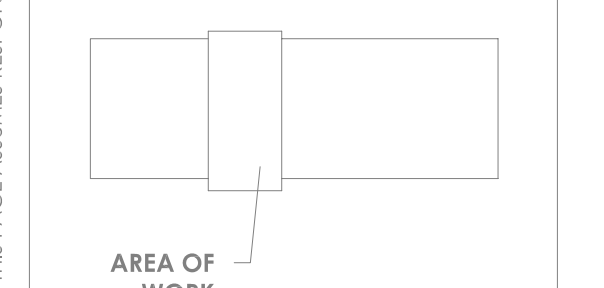

SHEET NAME
LEVEL 1 - HVAC
PLAN

SHEET NUMBER
M-101

WAI Project Num: 2013

