


ADJACENT  
TENANT  
(IN.I.C.)

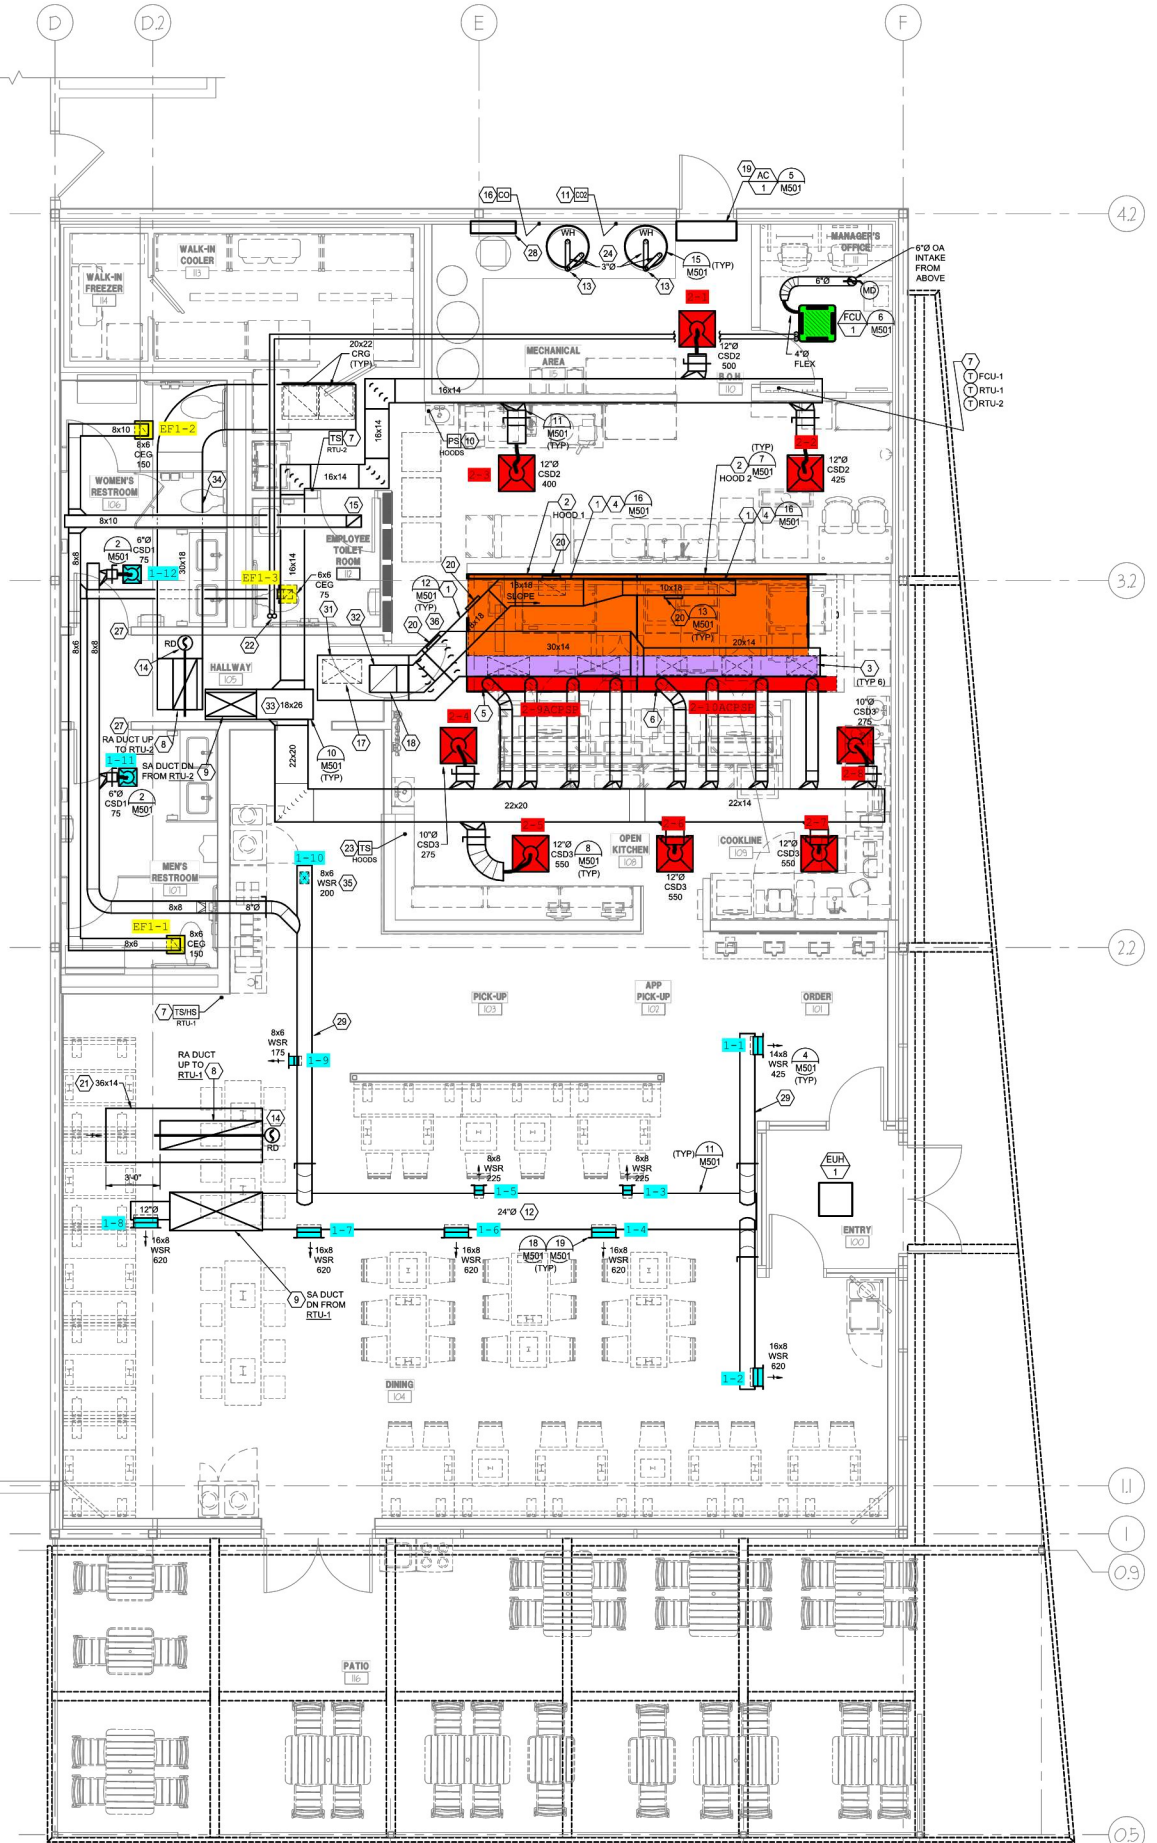

1 MECHANICAL PLAN  
SCALE: 1/4"=1'-0"