

29 ORINDA WAY, #1267  
 ORINDA, CA 94563  
 925-818-4132

WING STOP RESTAURANT

CYPRESS POINT SHOPPING CENTER  
 1020 E. CYPRESS AVE., Suite A  
 REDDING, CA 96002  
 STORE GL#AB078




DWG DATE:

DRAWN BY:

MSD


HVAC FLOOR PLAN

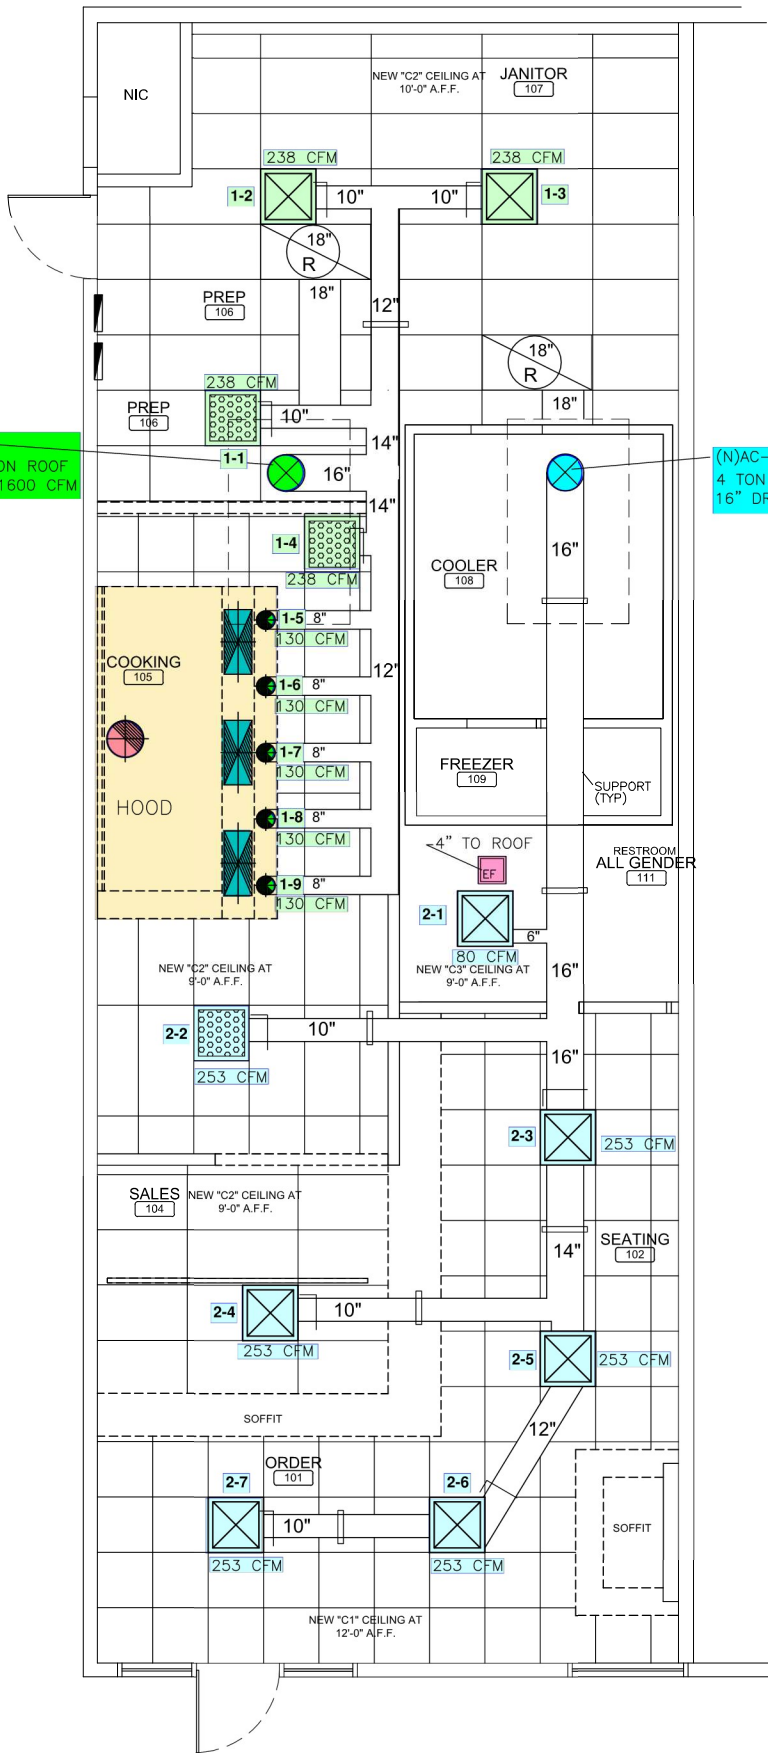

Hz, 4.8 KW  
 RIC UNIT  
 Hz, 4.8 KW  
 3.42"H  
 PROTECTION DEVICE AND DC

(E)AC-1  
4 TON HVAC ON ROOF  
16" DROP - 1600 CFM

 (N)AC-2  
4 TON HVAC ON ROOF  
16" DROP - 1600 CFM



**HVAC PLAN**  
 SCALE: 1/4" = 1'-0"

M.2