

HVAC PLAN - WEST
SCALE: 3/8" = 1'-0"

M1.1a
HVAC PLAN - WEST

THIS DRAWING IS THE PROPERTY OF COLLETT-BUSSELL ARCHITECTS, INC. NO PART OF THIS DOCUMENT MAY BE REPRODUCED OR TRANSMITTED IN ANY FORM OR BY ANY MEANS, ELECTRONIC OR MECHANICAL, WITHOUT THE EXPRESS WRITTEN PERMISSION OF COLLETT-BUSSELL ARCHITECTS, INC.

PROJECT: KING SCOPERS KSI #7
MECHANICAL WORK
FALCON CO

DATE: 08/20/2014
DESIGNER: COLLETT-BUSSELL ARCHITECTS, INC.
DRAWN BY: COLLETT-BUSSELL ARCHITECTS, INC.

DATE: 08/20/2014
DESIGNER: COLLETT-BUSSELL ARCHITECTS, INC.
DRAWN BY: COLLETT-BUSSELL ARCHITECTS, INC.

NUMBER	DESCRIPTION
101	MEAT & SEAFOOD COOLER
102	PRODUCE COOLER
103	MEAT SERVICE
104	STANDING COOKER
105	SEAFOOD
106	SALES
107	VEGETABLE
108	CART CORRAL
109	FEDERAL SALES
110	STARBUCKS
111	SEATING

KEYNOTE LEGEND

101 MEAT & SEAFOOD COOLER
102 PRODUCE COOLER
103 MEAT SERVICE
104 STANDING COOKER
105 SEAFOOD
106 SALES
107 VEGETABLE
108 CART CORRAL
109 FEDERAL SALES
110 STARBUCKS
111 SEATING

Produced by: **CR architecture + design**
 600 West 4th Street, Suite 2100, Seattle, WA 98104 | P: 206.467.4941
 1075 Broadway, Suite 2400, Denver, CO 80202 | P: 303.469.4949
 335 South South Street, Suite 300, Minneapolis, MN 55402 | P: 612.467.4941
 300 West 10th Street, Suite 200, Seattle, WA 98104 | P: 206.467.4941



KEYNOTE LEGEND

NUMBER	DESCRIPTION
101	100% DESIGN
102	90% DESIGN
103	80% DESIGN
104	70% DESIGN
105	60% DESIGN
106	50% DESIGN
107	40% DESIGN
108	30% DESIGN
109	20% DESIGN
110	10% DESIGN
111	CONCEPT DESIGN
112	PRELIMINARY DESIGN
113	SCHEMATIC DESIGN
114	PRELIMINARY ENGINEERING
115	FINAL ENGINEERING
116	CONSTRUCTION DOCUMENTS
117	AS-BUILT

GENERAL NOTES:

1. ALL WORK SHALL BE IN ACCORDANCE WITH THE LATEST EDITIONS OF THE INTERNATIONAL MECHANICAL AND ELECTRICAL CODES (IMC) AND THE NATIONAL ELECTRICAL CODE (NEC).
2. ALL WORK SHALL BE IN ACCORDANCE WITH THE LATEST EDITIONS OF THE INTERNATIONAL MECHANICAL AND ELECTRICAL CODES (IMC) AND THE NATIONAL ELECTRICAL CODE (NEC).
3. ALL WORK SHALL BE IN ACCORDANCE WITH THE LATEST EDITIONS OF THE INTERNATIONAL MECHANICAL AND ELECTRICAL CODES (IMC) AND THE NATIONAL ELECTRICAL CODE (NEC).

PROJECT: KING SCOPERS KSI#7

DATE: 08/20/2024

DESIGNER: KING SCOPERS

SCALE: 1/8" = 1'-0"

PROJECT NO.: 241000001

DATE: 08/20/2024

PROJECT: KING SCOPERS KSI#7

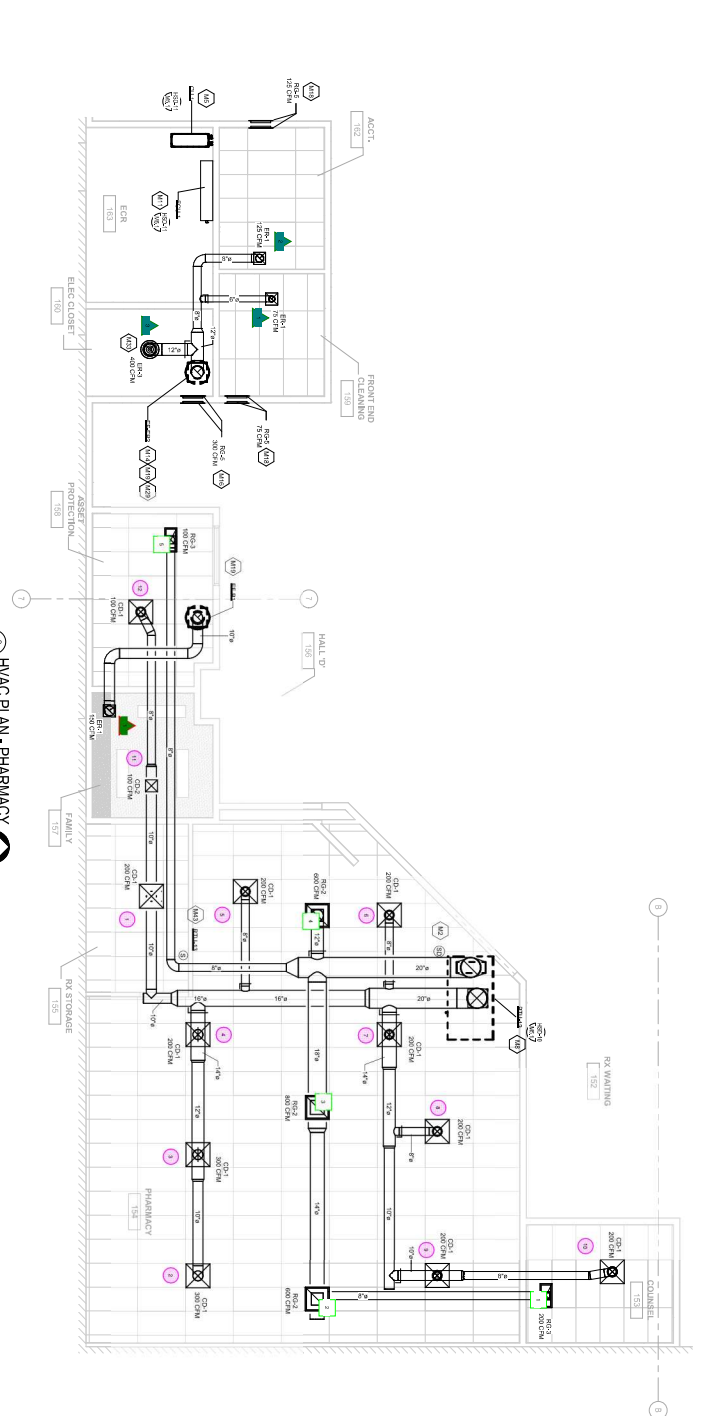
DATE: 08/20/2024

DESIGNER: KING SCOPERS

SCALE: 1/8" = 1'-0"

PROJECT NO.: 241000001


DATE: 08/20/2024



HVAC PLAN - PHARMACY
SCALE: 1/4" = 1'-0"

THESE PLANS AND SPECIFICATIONS ARE INTENDED TO BE USED AS A GUIDE ONLY. THE CONTRACTOR SHALL BE RESPONSIBLE FOR VERIFYING ALL DIMENSIONS AND CONDITIONS ON THE JOB. THE CONTRACTOR SHALL BE RESPONSIBLE FOR OBTAINING ALL NECESSARY PERMITS AND APPROVALS. THE CONTRACTOR SHALL BE RESPONSIBLE FOR PROTECTING ALL EXISTING UTILITIES AND STRUCTURES. THE CONTRACTOR SHALL BE RESPONSIBLE FOR MAINTAINING ACCESS TO ALL AREAS AT ALL TIMES. THE CONTRACTOR SHALL BE RESPONSIBLE FOR CLEANING UP ALL DEBRIS AND WASTE. THE CONTRACTOR SHALL BE RESPONSIBLE FOR PROTECTING ALL ADJACENT AREAS. THE CONTRACTOR SHALL BE RESPONSIBLE FOR OBTAINING ALL NECESSARY PERMITS AND APPROVALS. THE CONTRACTOR SHALL BE RESPONSIBLE FOR MAINTAINING ACCESS TO ALL AREAS AT ALL TIMES. THE CONTRACTOR SHALL BE RESPONSIBLE FOR CLEANING UP ALL DEBRIS AND WASTE. THE CONTRACTOR SHALL BE RESPONSIBLE FOR PROTECTING ALL ADJACENT AREAS.

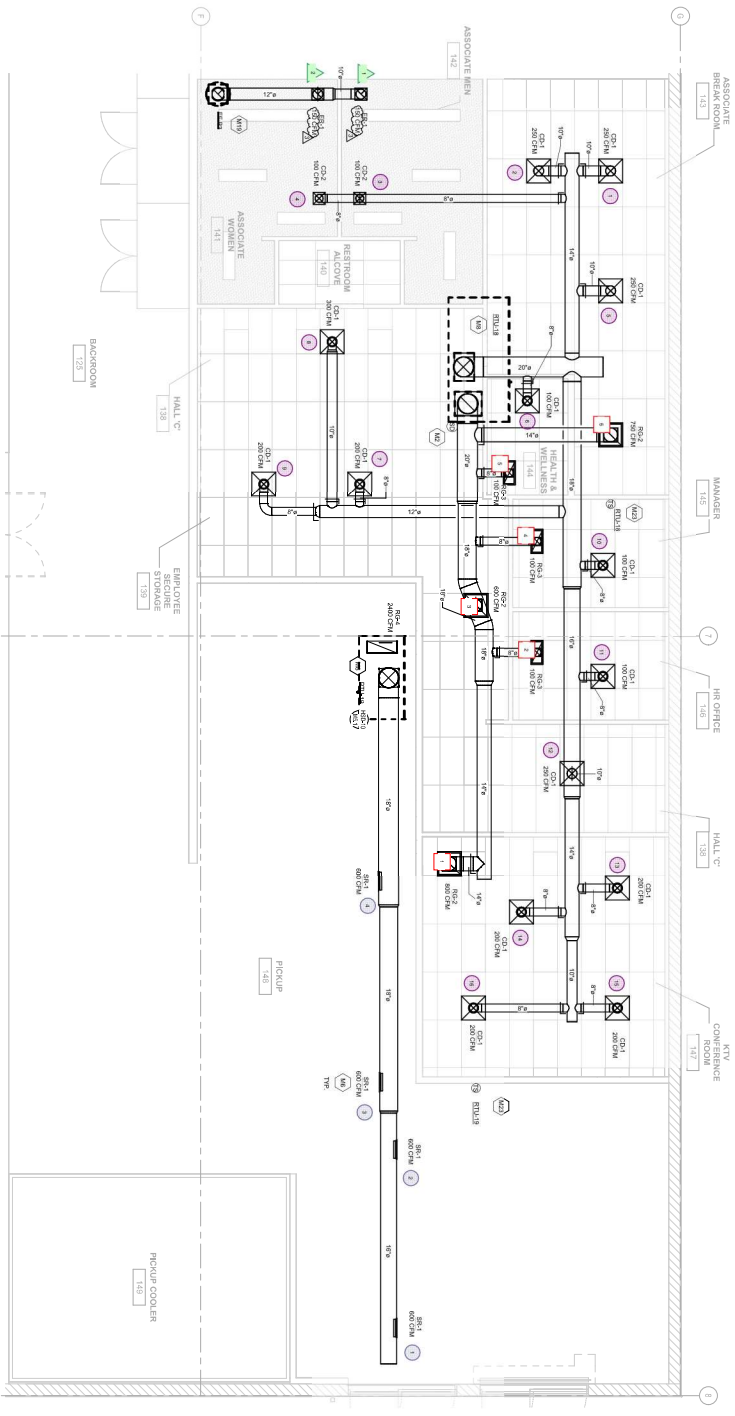HVAC PLAN - BACK OFFICE AND PICKUP
SCALE: 1/4" = 1'-0"



HVAC PLAN - BACK OFFICE AND PICKUP
SCALE: 1/4" = 1'-0"


KEYNOTE LEGEND

1	MECHANICAL ROOMS
2	MECHANICAL ROOMS
3	MECHANICAL ROOMS
100	MECHANICAL ROOMS

1 HVAC PLAN - DELI M.T.O



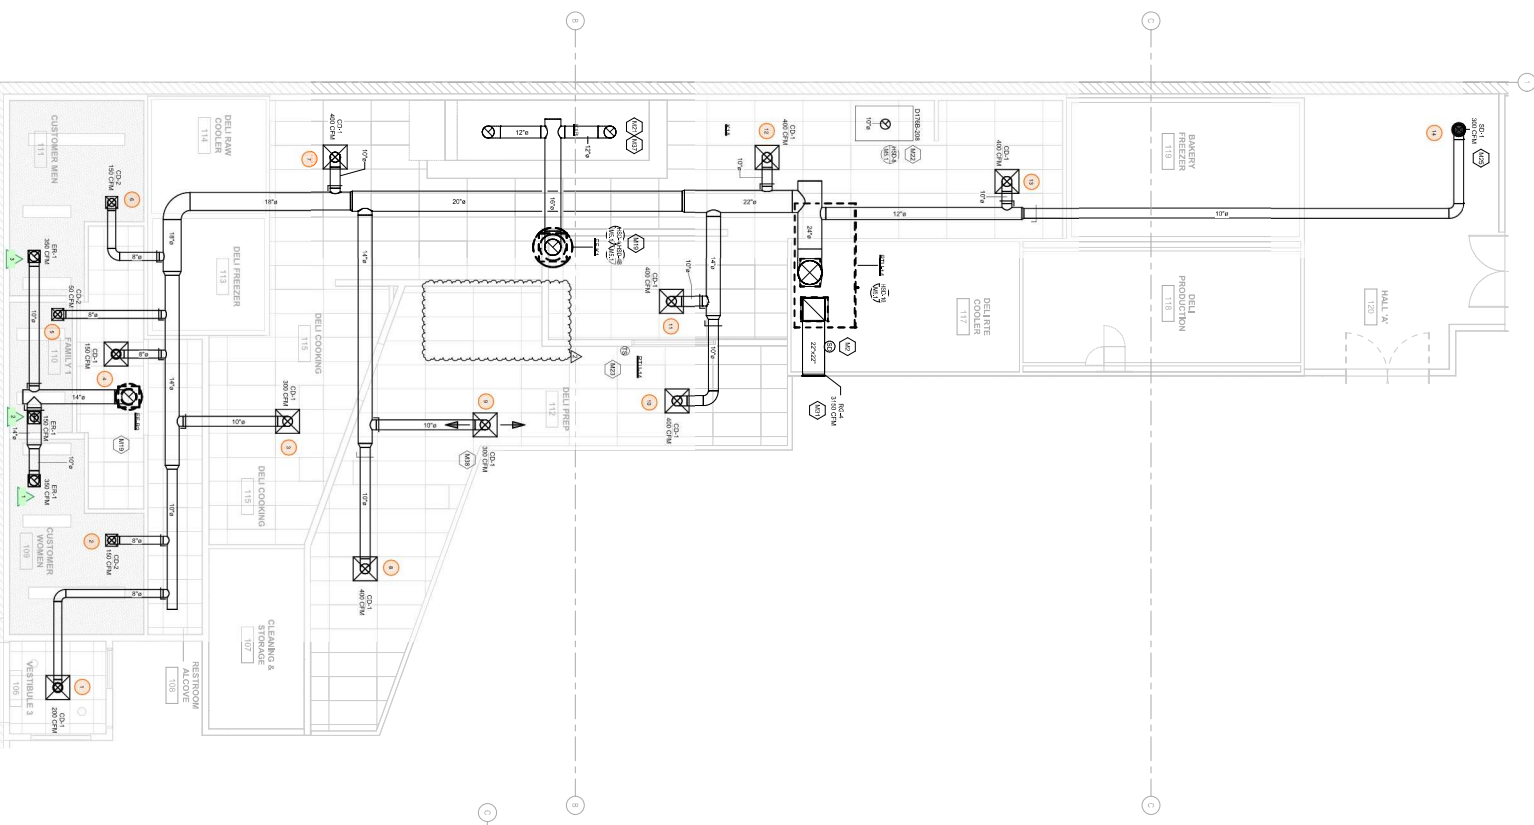
SCALE: 1/4" = 1'-0"



2 HVAC PLAN - DELI BAKERY



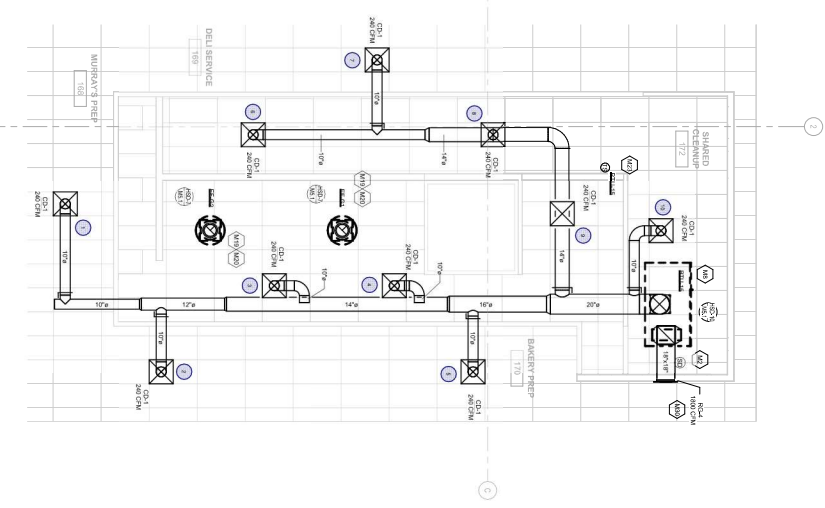SCALE: 1/4" = 1'-0"



PLEASE NOTE: CONTRACTOR SHALL VERIFY ALL EQUIPMENT IS INSTALLED AND OPERATING AS SHOWN ON THESE PLANS. THE CONTRACTOR SHALL BE RESPONSIBLE FOR OBTAINING ALL NECESSARY PERMITS AND APPROVALS FROM THE LOCAL HEALTH DEPARTMENT AND ALL APPLICABLE LOCAL, STATE AND FEDERAL REGULATIONS. THE CONTRACTOR SHALL BE RESPONSIBLE FOR OBTAINING ALL NECESSARY PERMITS AND APPROVALS FROM THE LOCAL HEALTH DEPARTMENT AND ALL APPLICABLE LOCAL, STATE AND FEDERAL REGULATIONS. THE CONTRACTOR SHALL BE RESPONSIBLE FOR OBTAINING ALL NECESSARY PERMITS AND APPROVALS FROM THE LOCAL HEALTH DEPARTMENT AND ALL APPLICABLE LOCAL, STATE AND FEDERAL REGULATIONS.

KEYNOTE LEGEND

NUMBER	DESCRIPTION
101	ROOF CURB
102	ROOF CURB
103	ROOF CURB
200	ROOF CURB

M4.1

PROJECT: KING SCOPERS KSI #7

DATE: 3/22/2018

SCALE: 1/4" = 1'-0"

PROJECT LOCATION: FALCON, CO

DESIGNER: COLC-HUBBELL ARCHITECTS INC.

PROJECT NO: 130102021

DATE: 3/22/2018

SCALE: 1/4" = 1'-0"

PROJECT LOCATION: FALCON, CO

DESIGNER: COLC-HUBBELL ARCHITECTS INC.

PROJECT NO: 130102021

king

COLC-HUBBELL ARCHITECTS INC.

130102021

3/22/2018

1/4" = 1'-0"

FALCON, CO

DESIGNER: COLC-HUBBELL ARCHITECTS INC.

PROJECT NO: 130102021

CR

architecture + design

130102021

3/22/2018

1/4" = 1'-0"

FALCON, CO

DESIGNER: COLC-HUBBELL ARCHITECTS INC.

PROJECT NO: 130102021

CR

architecture + design

130102021

3/22/2018

1/4" = 1'-0"

FALCON, CO

DESIGNER: COLC-HUBBELL ARCHITECTS INC.

PROJECT NO: 130102021

CR

architecture + design

130102021

3/22/2018

1/4" = 1'-0"

FALCON, CO

DESIGNER: COLC-HUBBELL ARCHITECTS INC.

PROJECT NO: 130102021