



COORDINATION DRAWING
MECHANICAL ENLARGED OFFICE PLAN

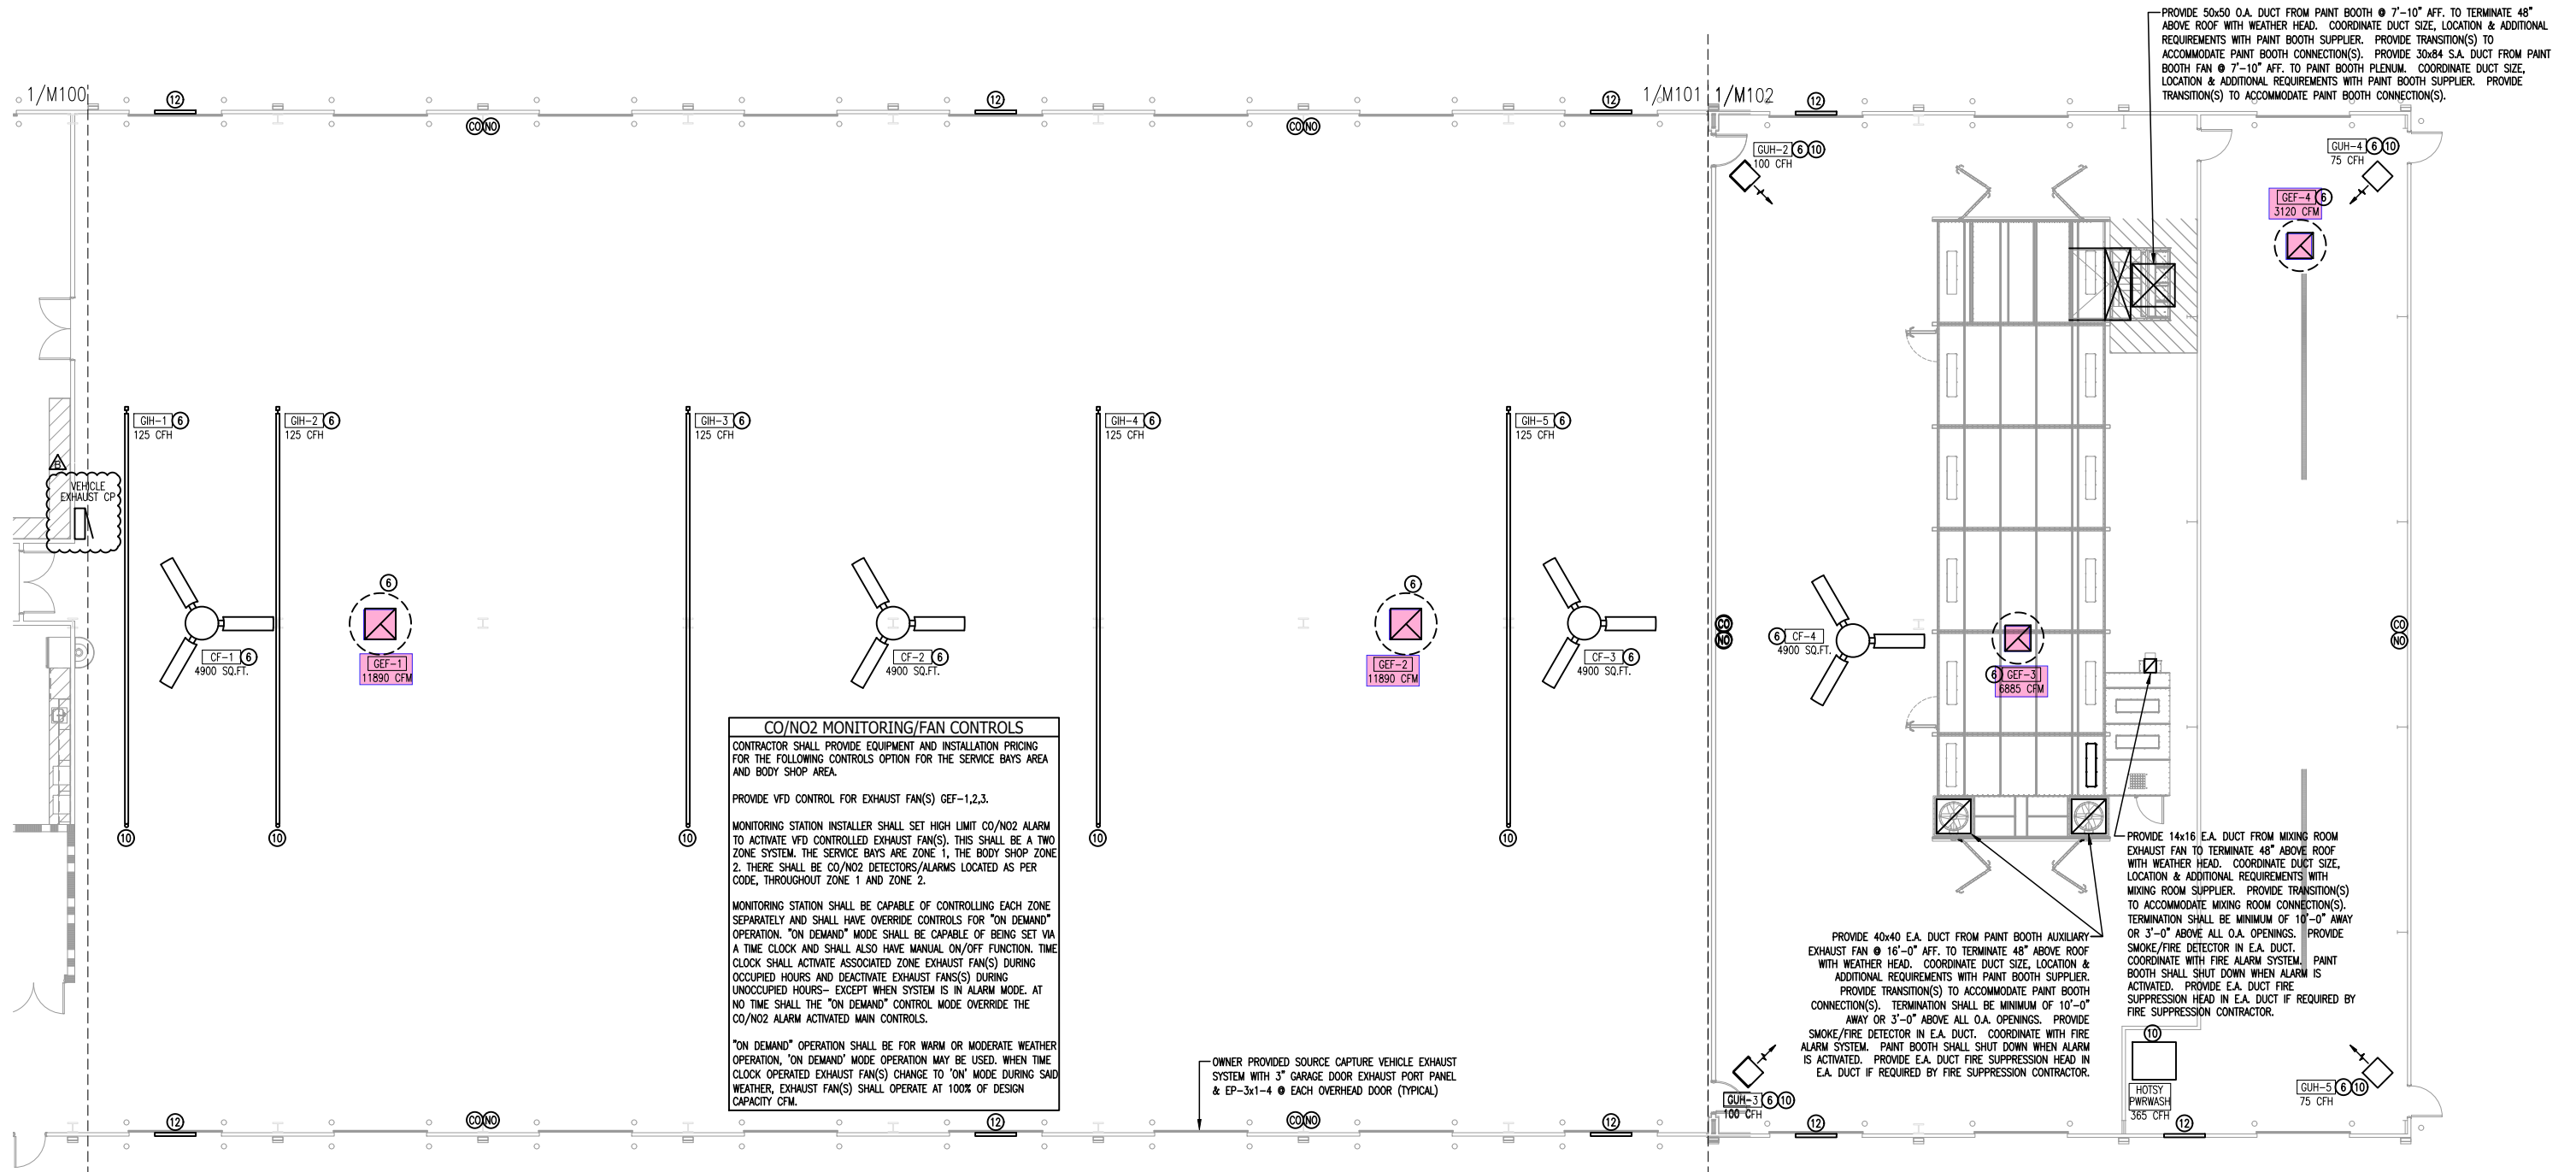

1
M101 MECHANICAL SERVICE BAY PLAN

1
M102 MECHANICAL BODY SHOP/WASH BAY PLAN

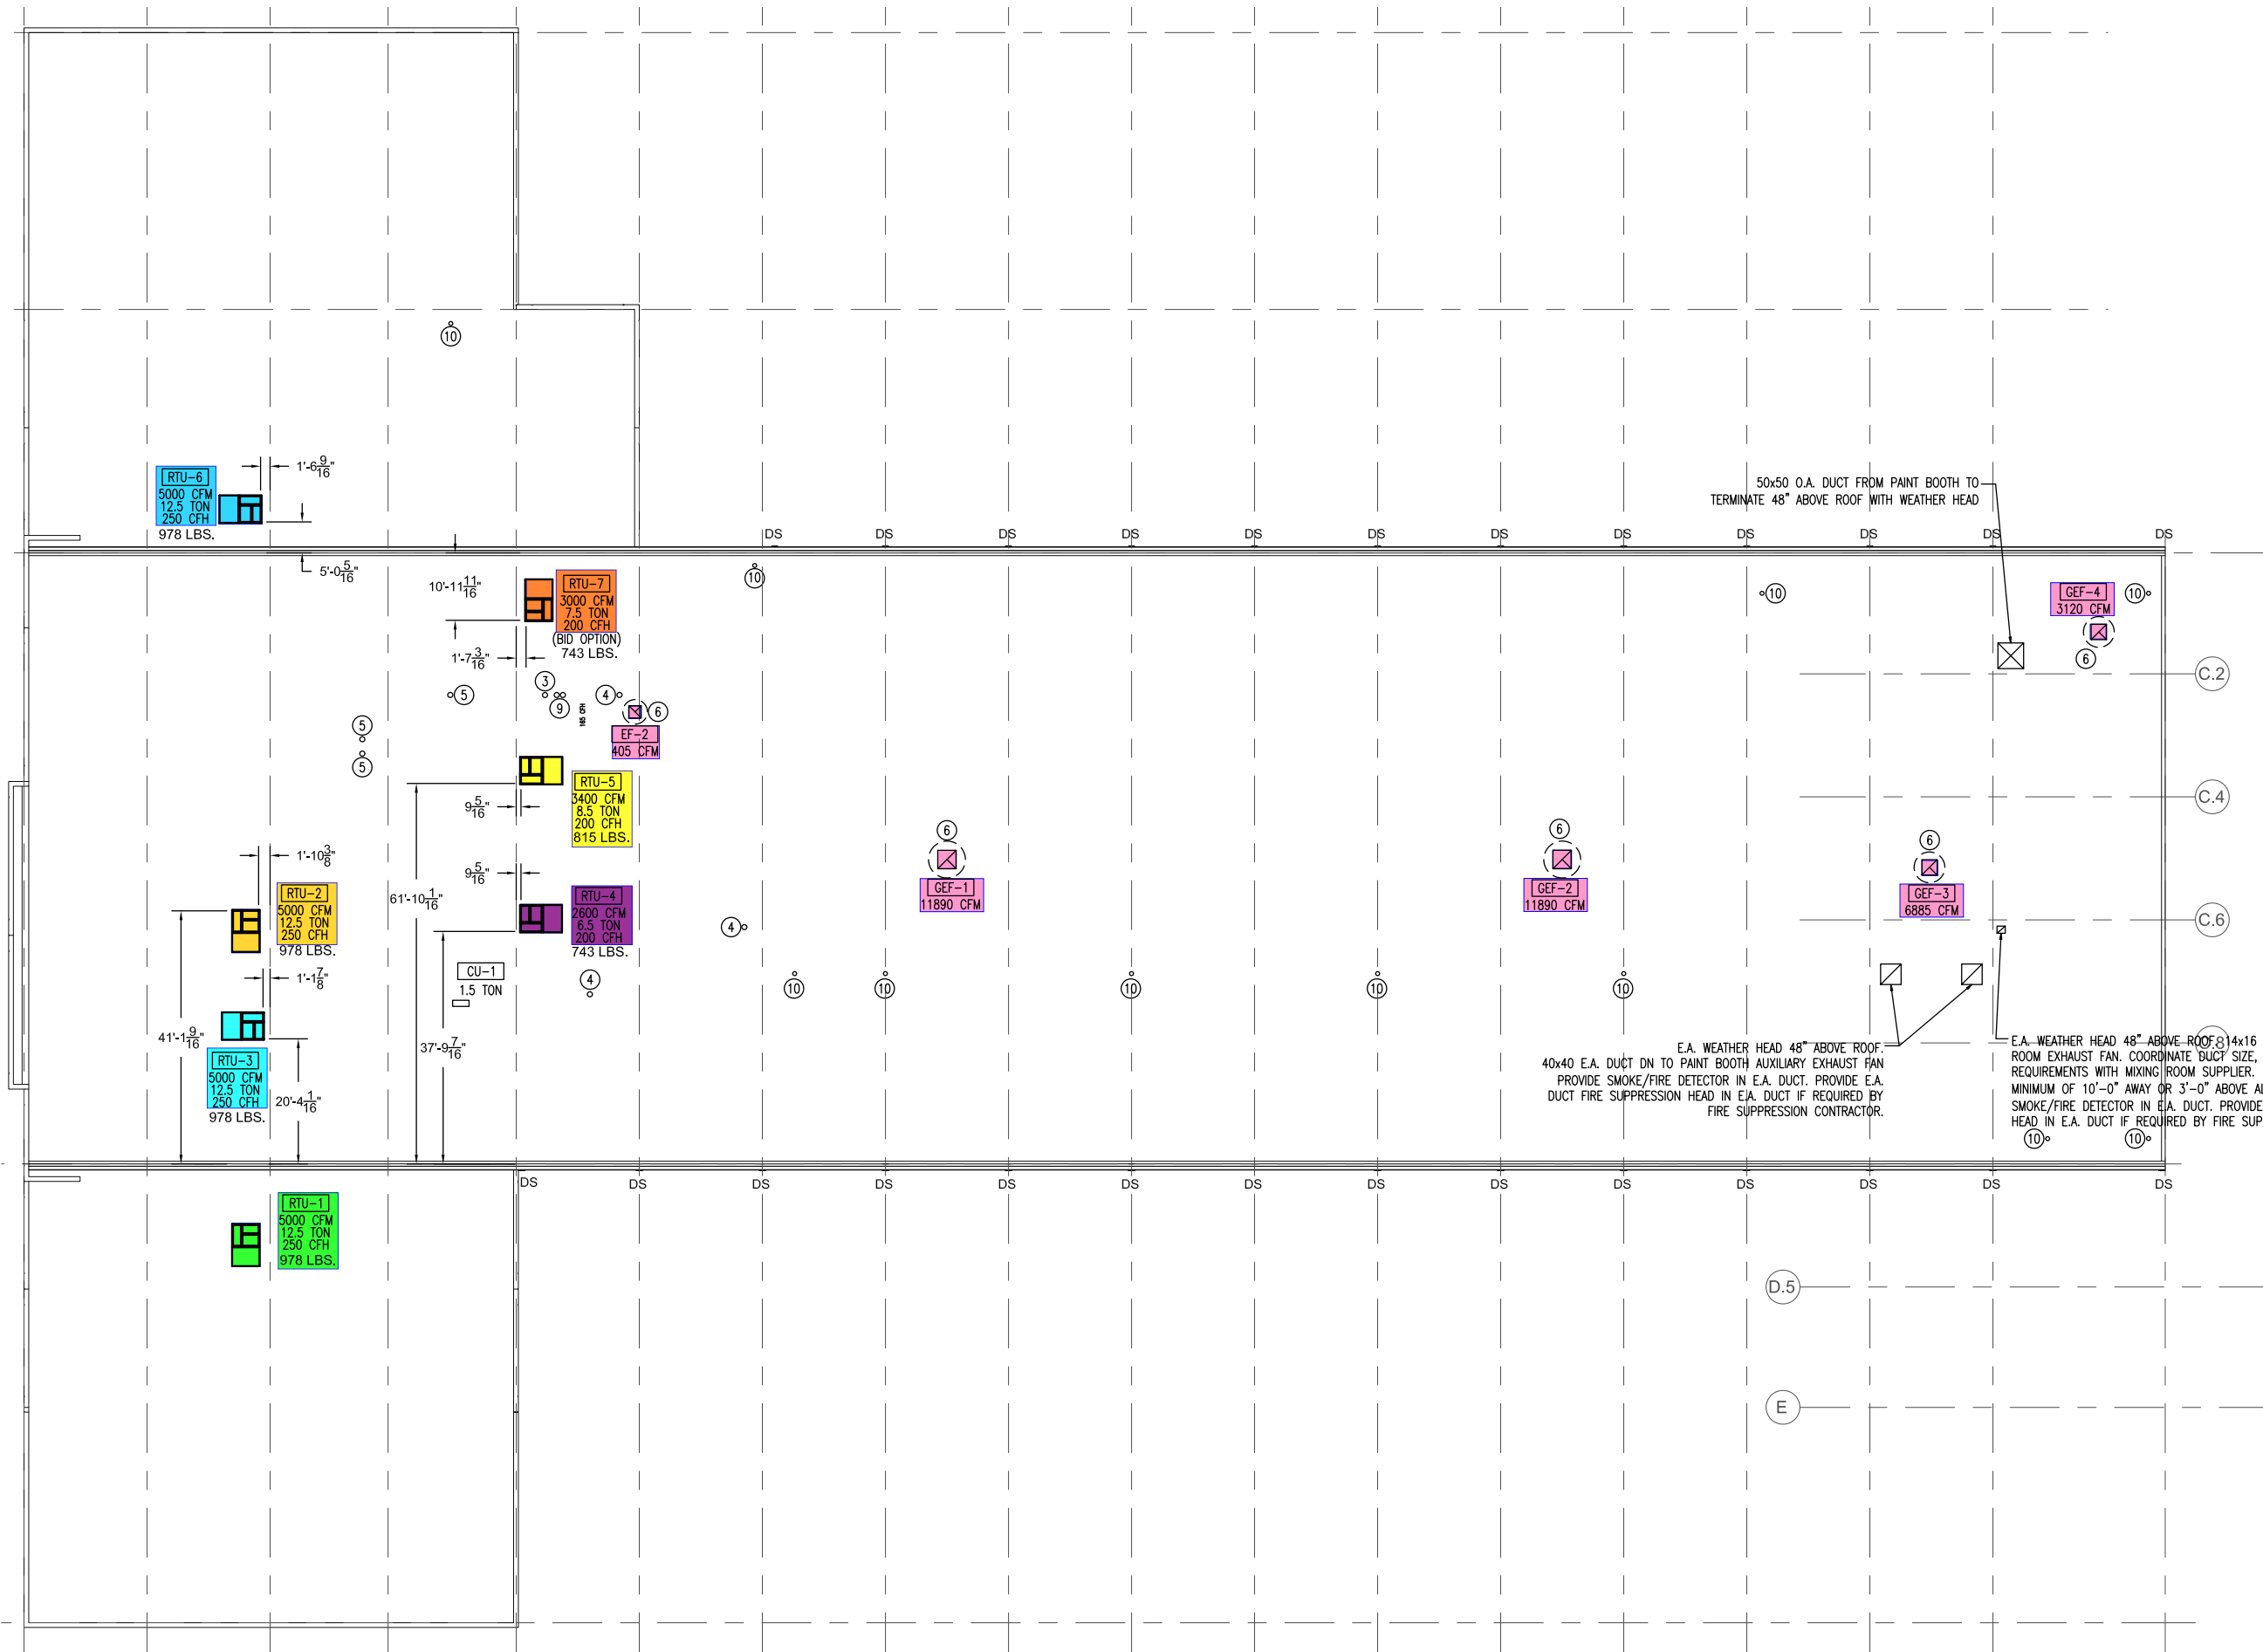

1 MECHANICAL ROOF PLAN
M103 Scale: 1/16" = 1'-0"