

NO.	REVISIONS	DATE
1	ADDENDUM #1	12/21/22


LANDLORD REVIEW ISSUE DATE: 12/21/2022
TENANT REVIEW ISSUE DATE: 12/21/2022
BD ISSUE DATE: 12/21/2022
PERMIT ISSUE DATE: 12/21/2022

DRAWING TITLE:
MECHANICAL FLOOR PLAN


DRAWING NUMBER:

1M-1.1

© 2022 idGROUP, LLC

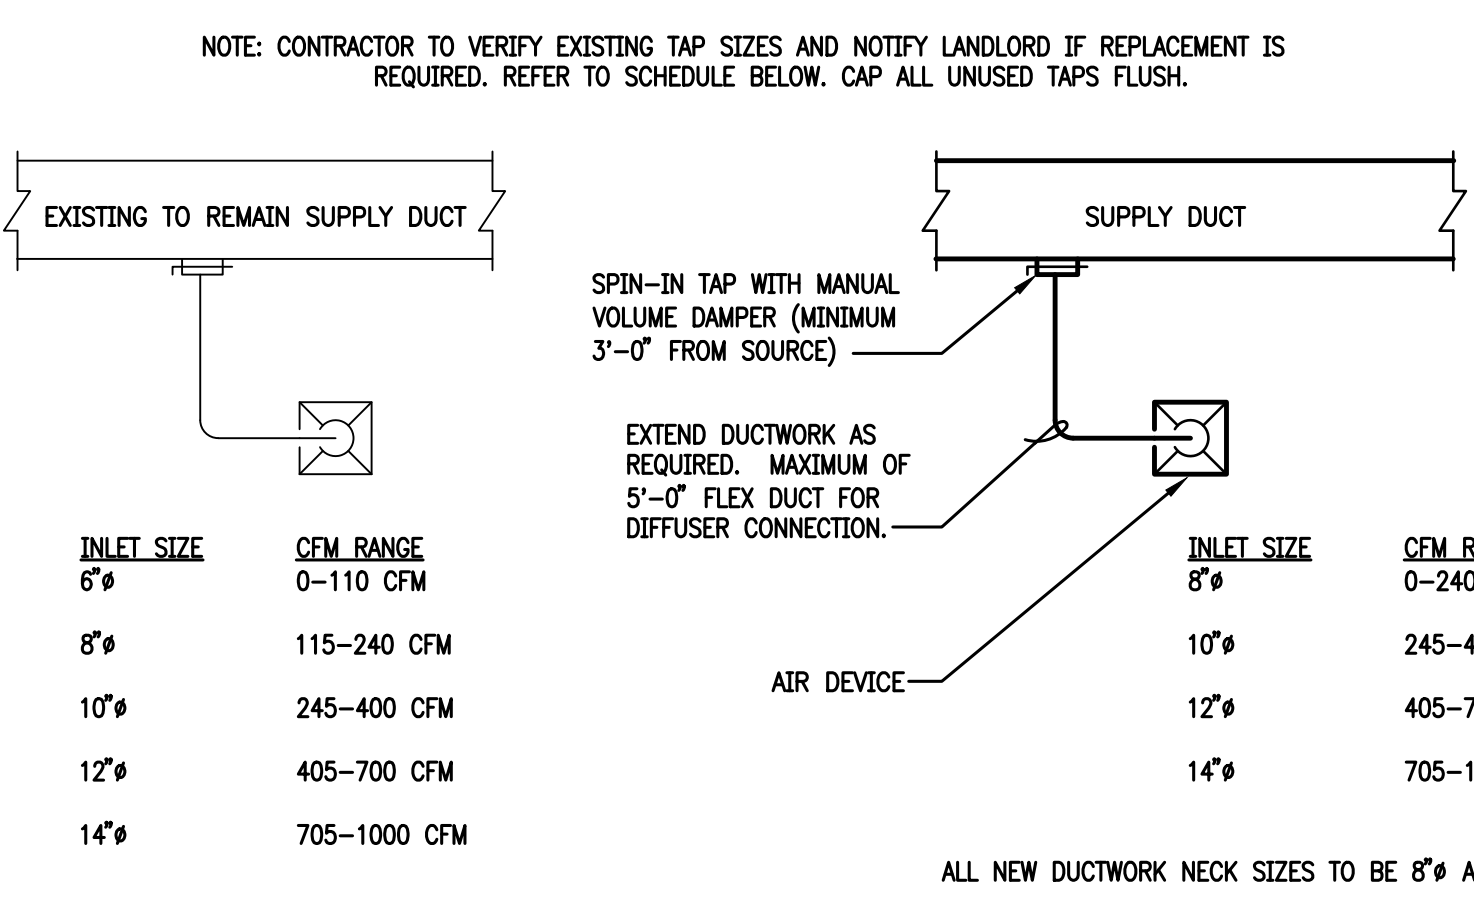

2 SUPPLY DIFFUSER CONNECTION DETAIL
SCALE: NOT TO SCALE

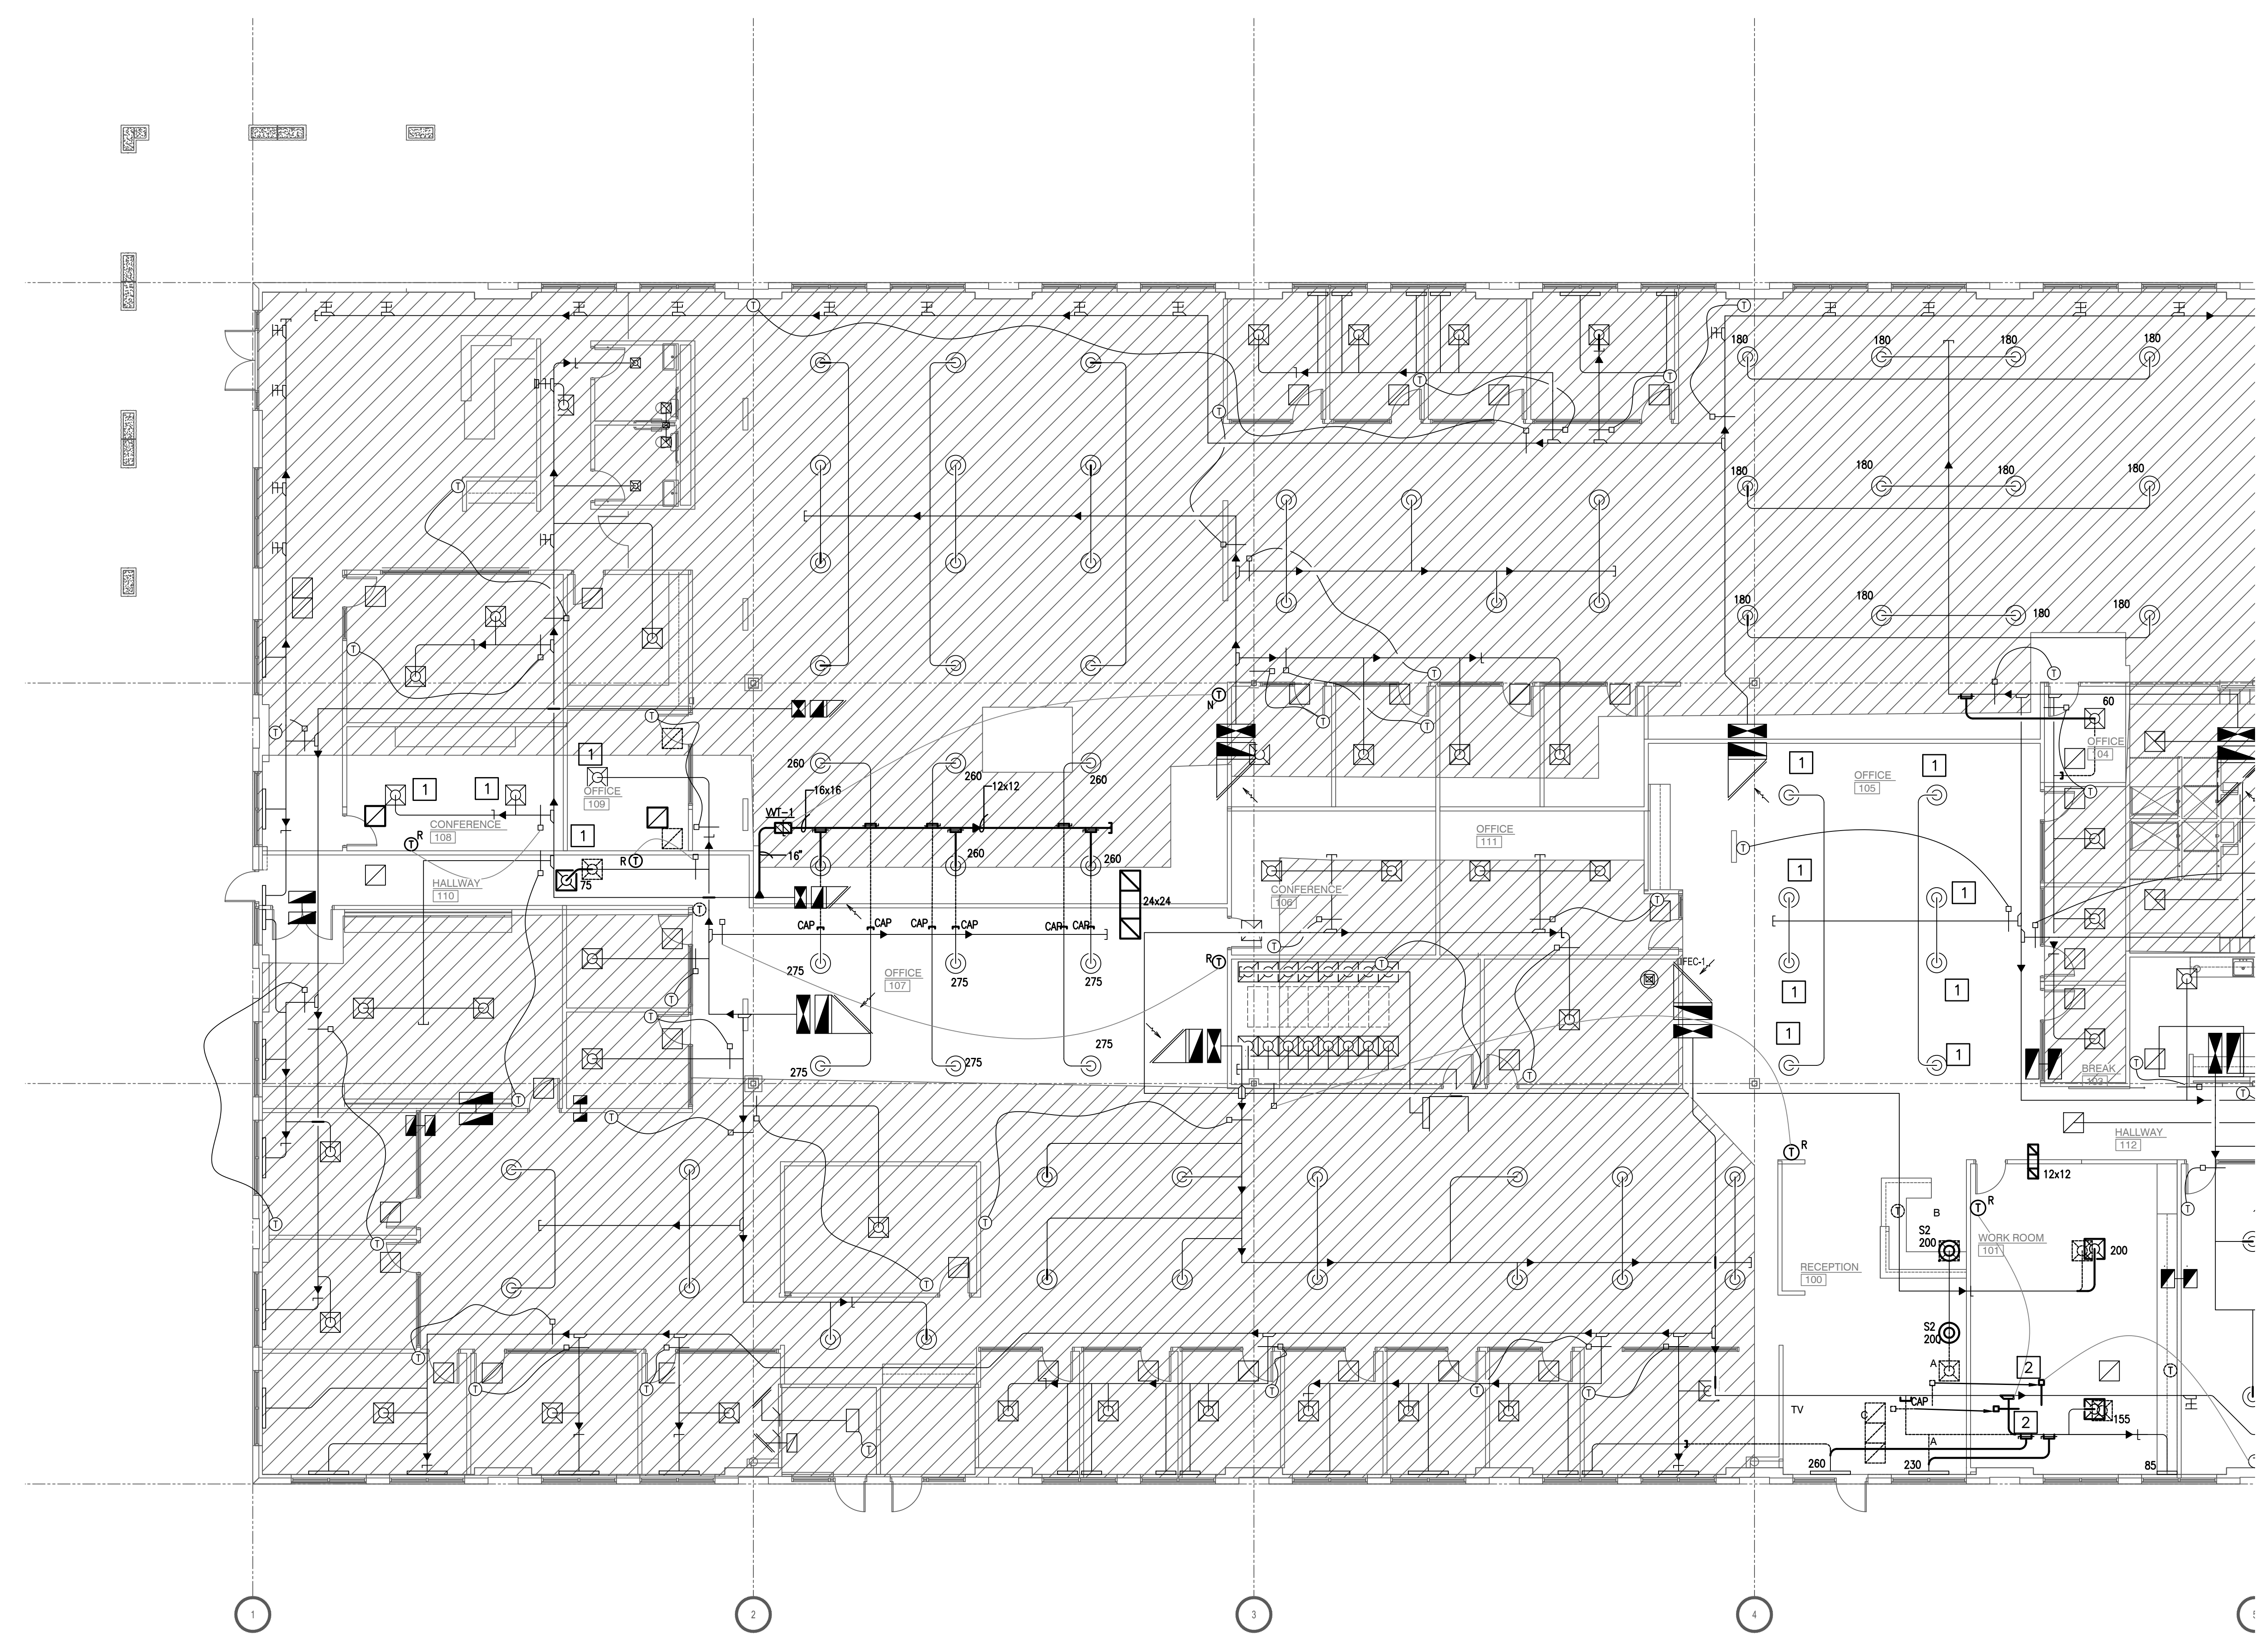

GENERAL NOTES:
A. NO FIRE DAMPERS ADDED TO ANY NEW RETURN AIR TRANSFERS. NEW WALLS TO DECK ARE NOT FIRE RATED.

KEY NOTES:
1 EXISTING CFM ON ASSOCIATED GRILLES TO REMAIN.
2 RELOCATED WT.

VARIABLE VOLUME AND TEMPERATURE BOX SCHEDULE

DESIG.	GENERAL			MECHANICAL		REMARKS
	SERVES	MFR.	MODEL #	INLET SIZE (IN.)	DESIGN CFM	
VVT-1	OFFICE	REMARK 4	REMARK 4	16	1000	1.4


NOTES:
A. EQUIPMENT TO BE CLEARLY LABELED.
B. ACCEPTABLE MANUFACTURERS ARE: ENVIRO-TEC, PRICE, TRUZE, WORKAL, TRANE.
C. REFER TO SCHEDULE FOR MINIMUM SETPOINTS.
D. 100V TO 24V CONTROL TRANSFORMER AS REQUIRED.
E. SWITCH BUILDING STANDARD MANUFACTURER AND MODEL.

AIR DEVICE SCHEDULE

DESIG.	MFR.	MODEL #	TYPE	FACE TYPE/SIZE (IN.)	MATERIAL	FINISH	REMARKS
S1	PRICE	300	CEILING SUPPLY	24X8	STEEL	PER ARCH	-
S2	PRICE	ROCE	DUCT MOUNTED SUPPLY	18" SQ	STEEL	PER ARCH	-
R1	PRICE	POOR	CEILING RETURN	24X8	STEEL	PER ARCH	-

NOTES:
A. MAX INLET LEVEL OF DIFFUSERS TO BE 3".
B. ACCEPTABLE MANUFACTURERS ARE: PRICE, TRUZE, WALKO, METALURE.
C. FRAME AND BORDER TYPES TO MATCH CEILING AND/OR WALL.
D. REFERENCE ARCHITECTURAL REFLECTIVE CEILING PLAN.

CONTRACTOR SHALL COORDINATE MEP DRAWINGS WITH ALL OTHER DISCIPLINES

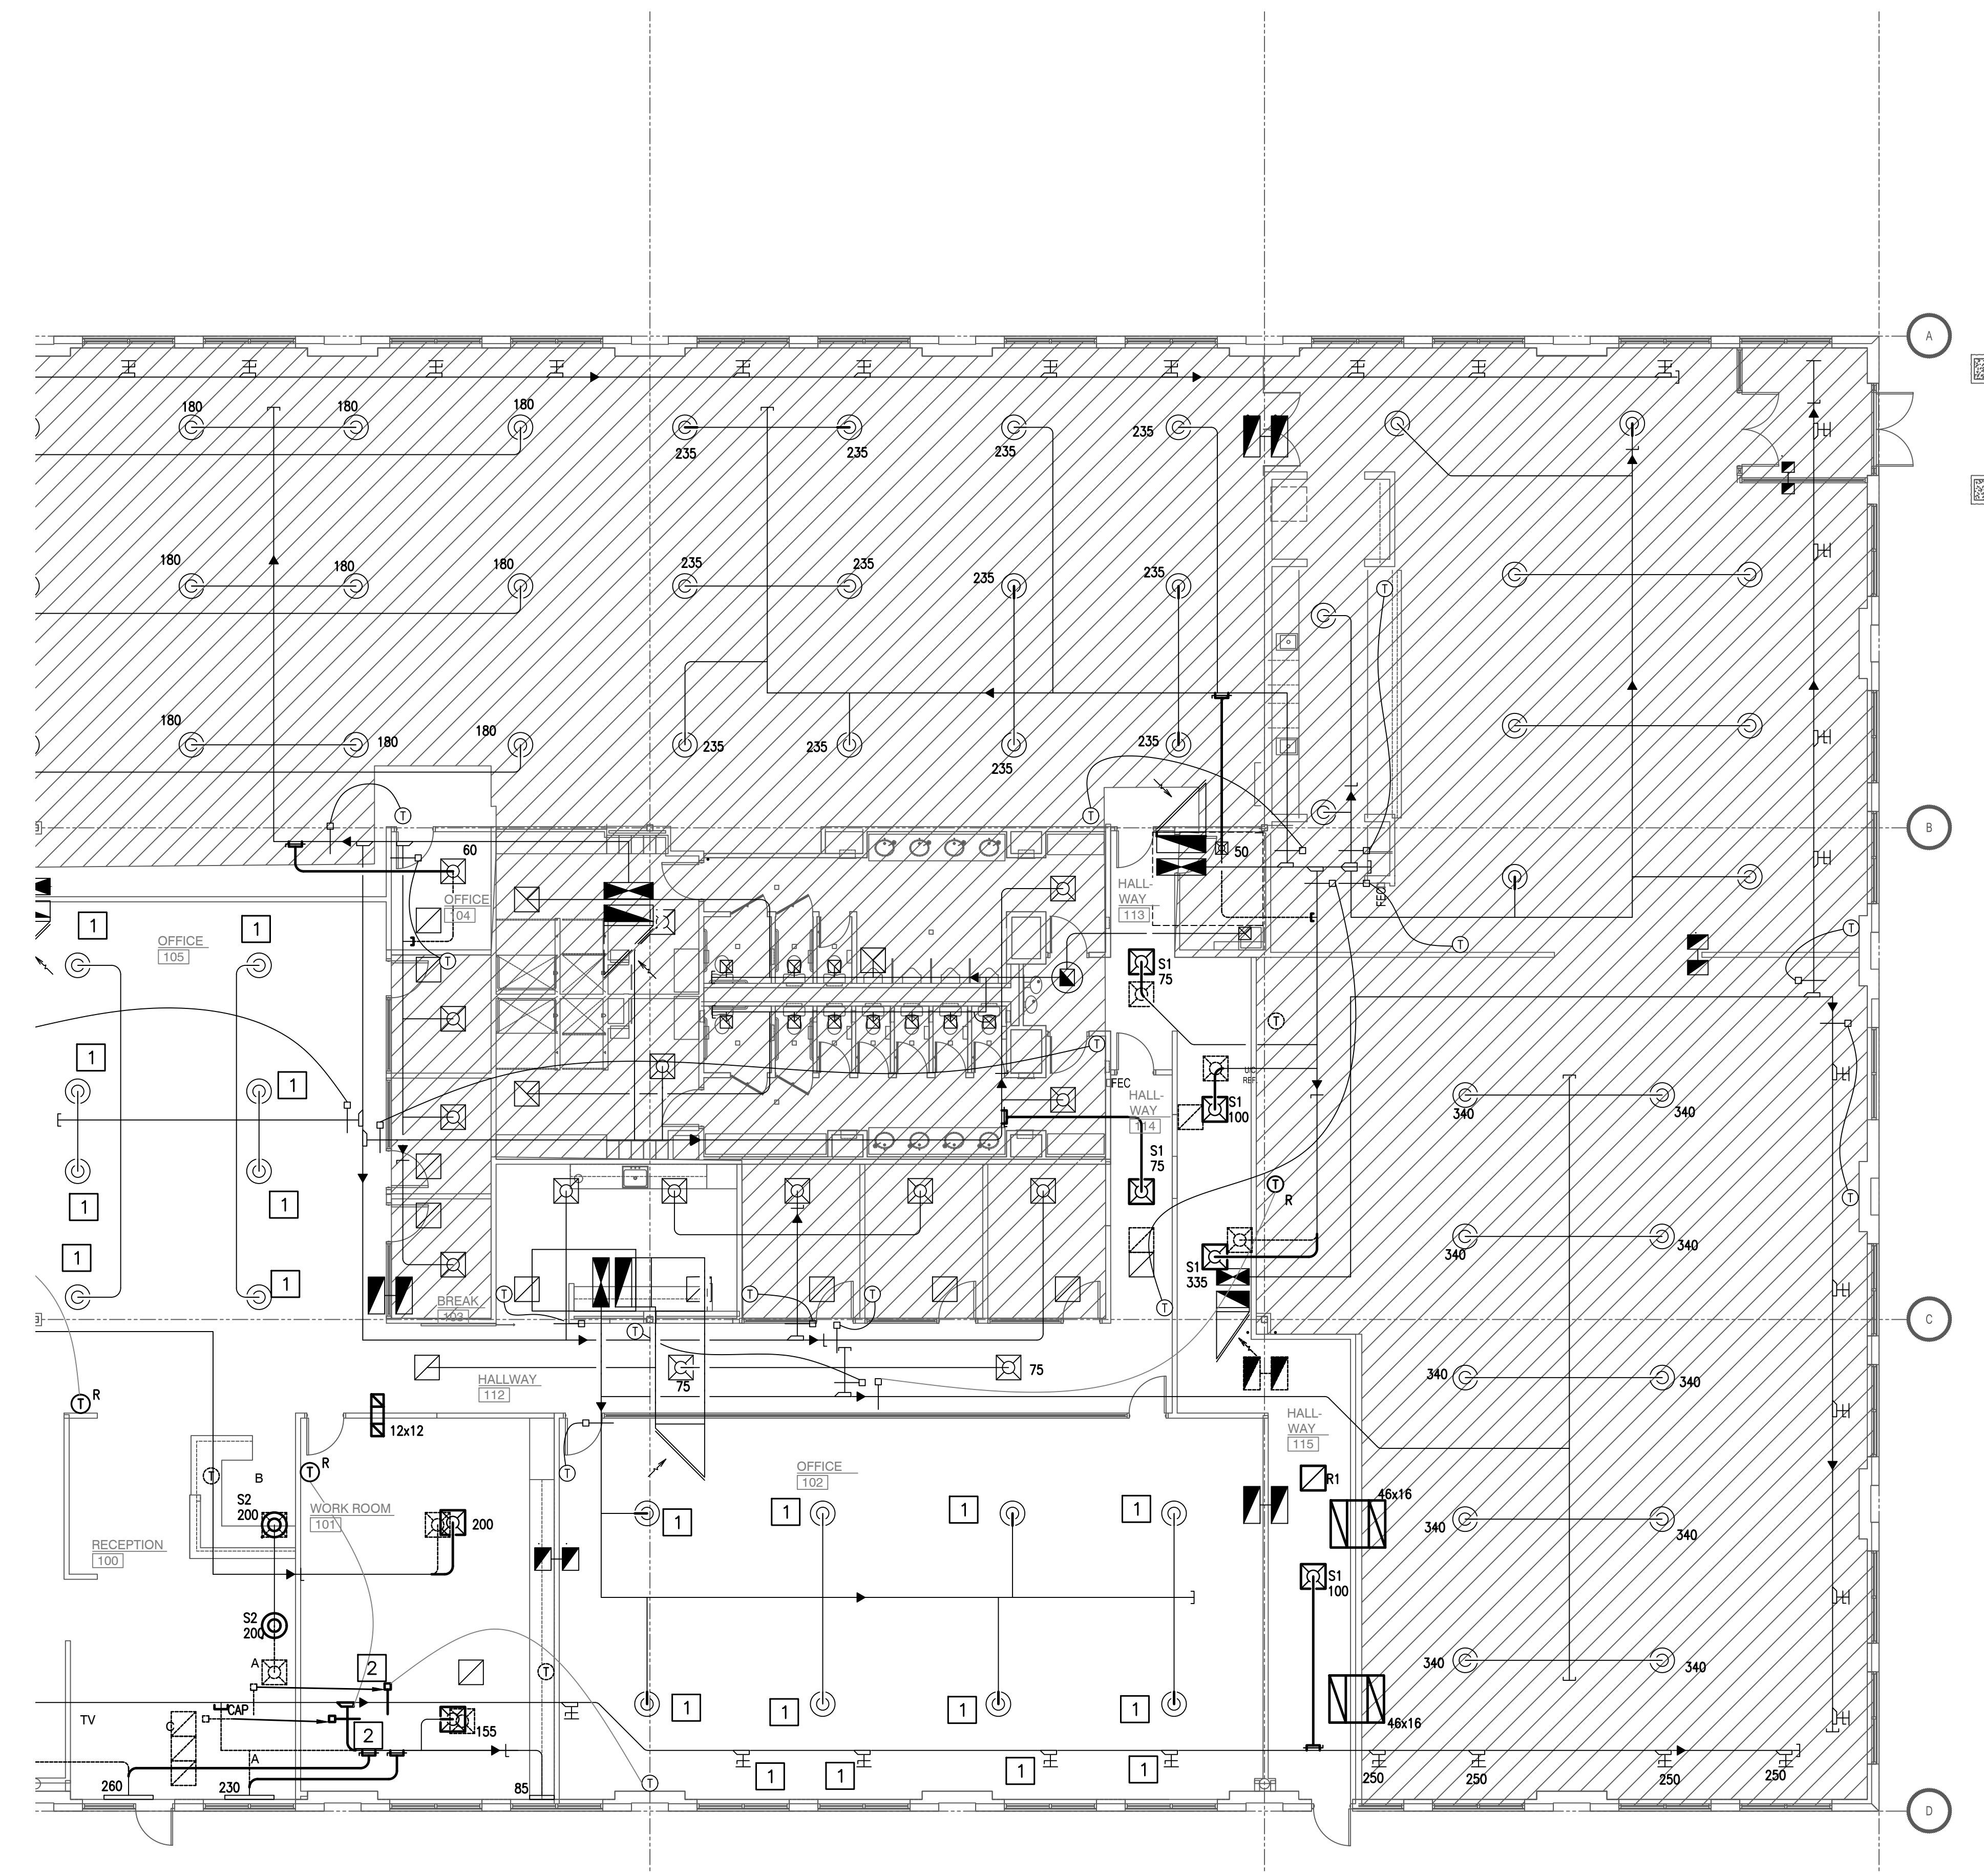

GENERAL NOTES:
A. NO FIRE DAMPERS ADDED TO ANY NEW RETURN AIR TRANSFERS. NEW WALLS TO DECK ARE NOT FIRE RATED.

- KEY NOTES:**
- 1 EXISTING CFM ON ASSOCIATED GRILLES TO REMAIN.
 - 2 RELOCATED WT.

3481 PLANO PKWY
SUITE 100
THE COLONY, TX 75056

NO.	REVISIONS	DATE
1	ADDENDUM #1	12/21/22

LANDLORD REVIEW ISSUE DATE: 12/21/2022
TENANT REVIEW ISSUE DATE: 12/21/2022
BD ISSUE DATE: 12/21/2022
PERMIT ISSUE DATE: 12/21/2022

DRAWING TITLE:
**OPTION 1
MECHANICAL
FLOOR PLAN**
DRAWING NUMBER:

1M-1.2
© 2022 idGROUP, LLC

CONTRACTOR SHALL COORDINATE
MEP DRAWINGS WITH ALL OTHER
DISCIPLINES