


**HVAC ROOF PLAN**

SCALE: 1/4" = 1'-0"

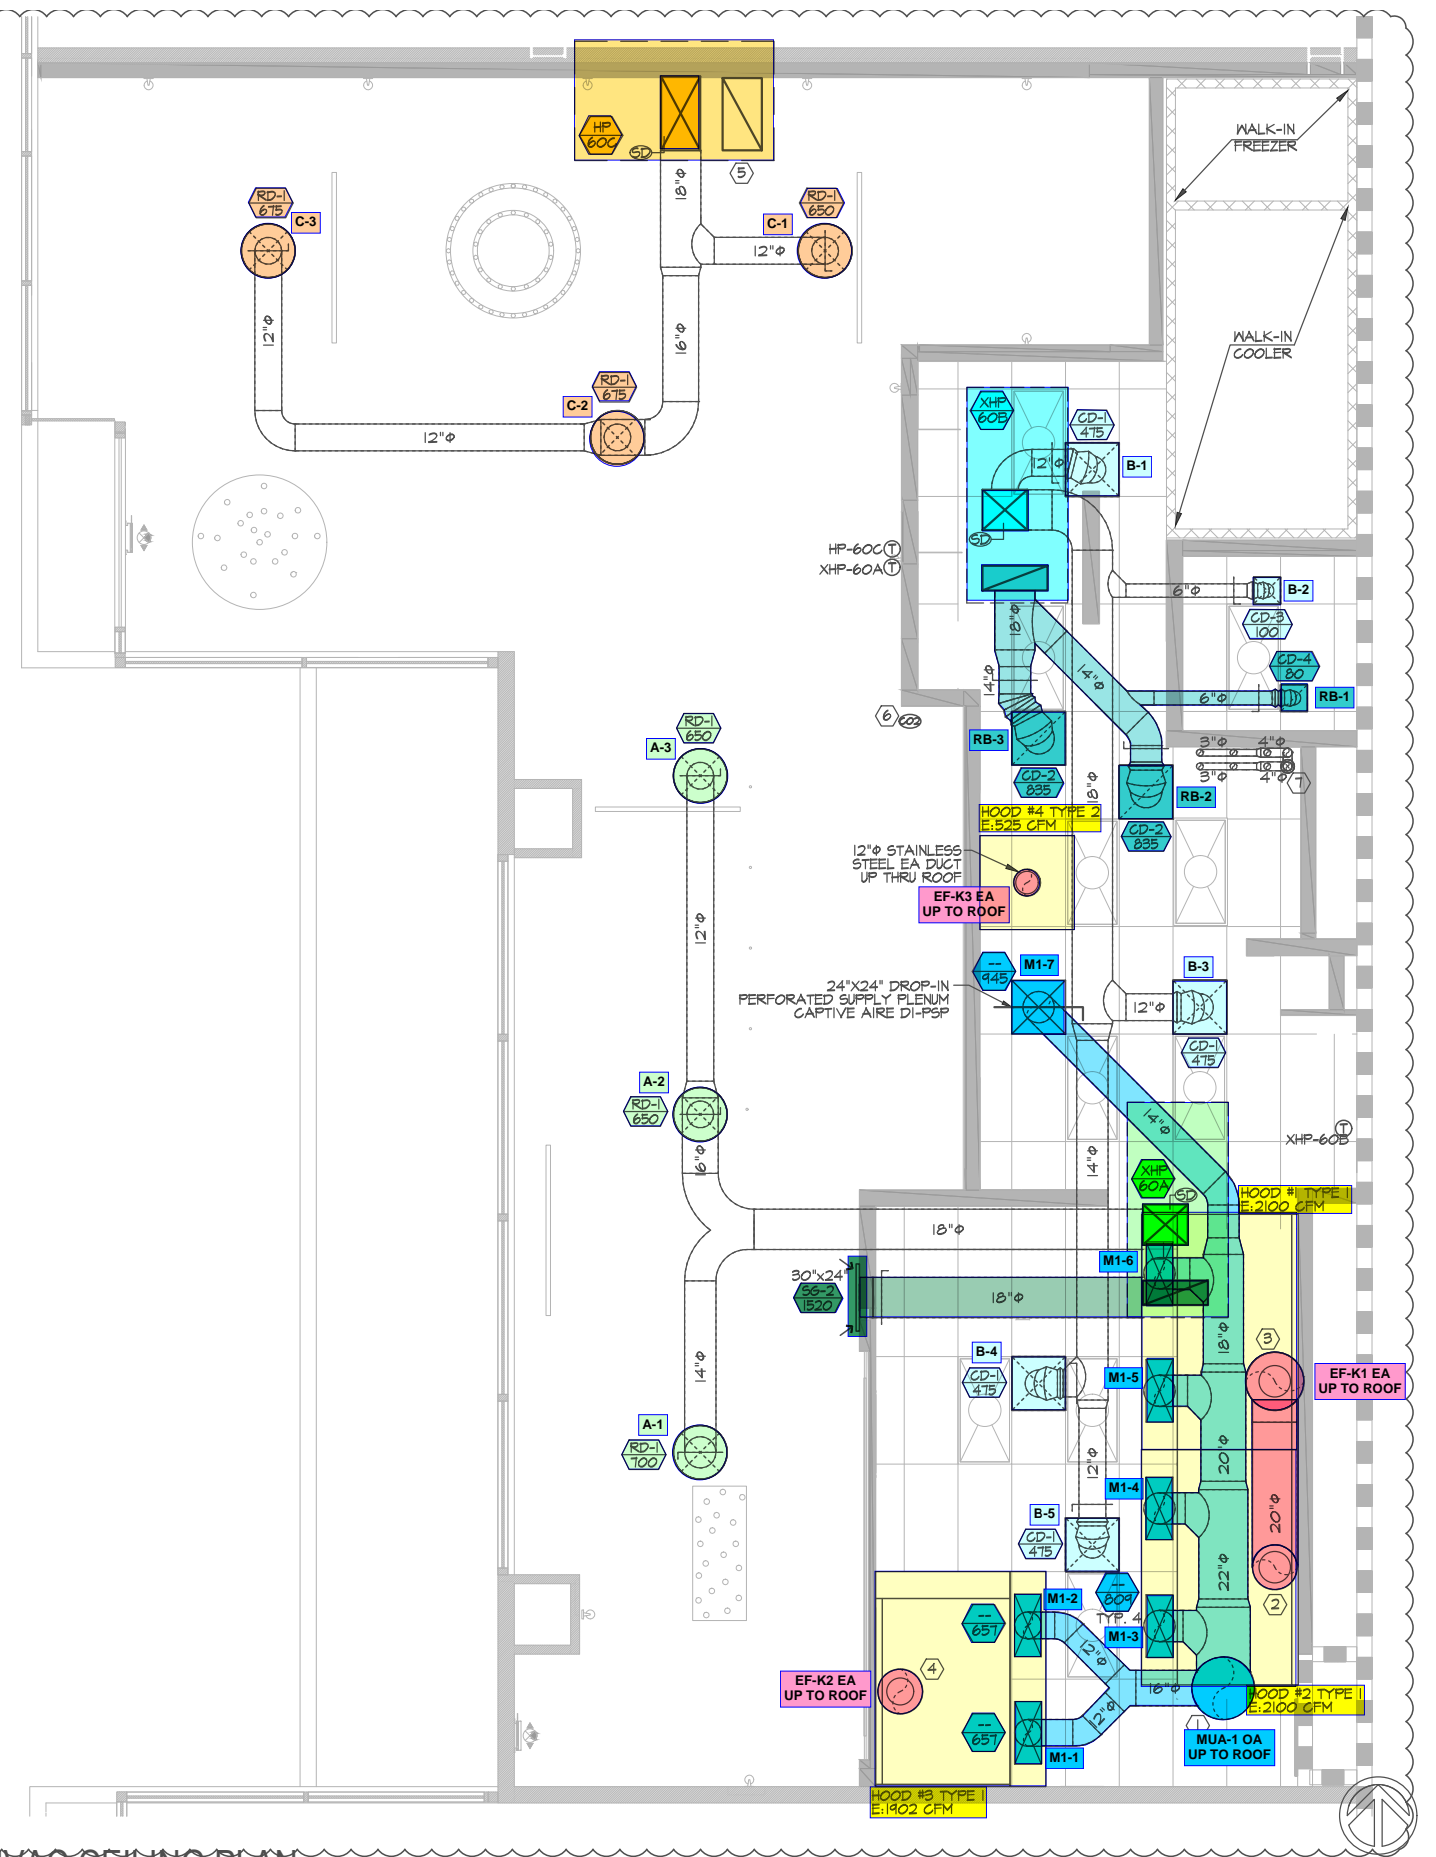

**HVAC CEILING PLAN**

SCALE: 1/4" = 1'-0"