


HIGH AS TRUSS
LOOK WILL ALLOW

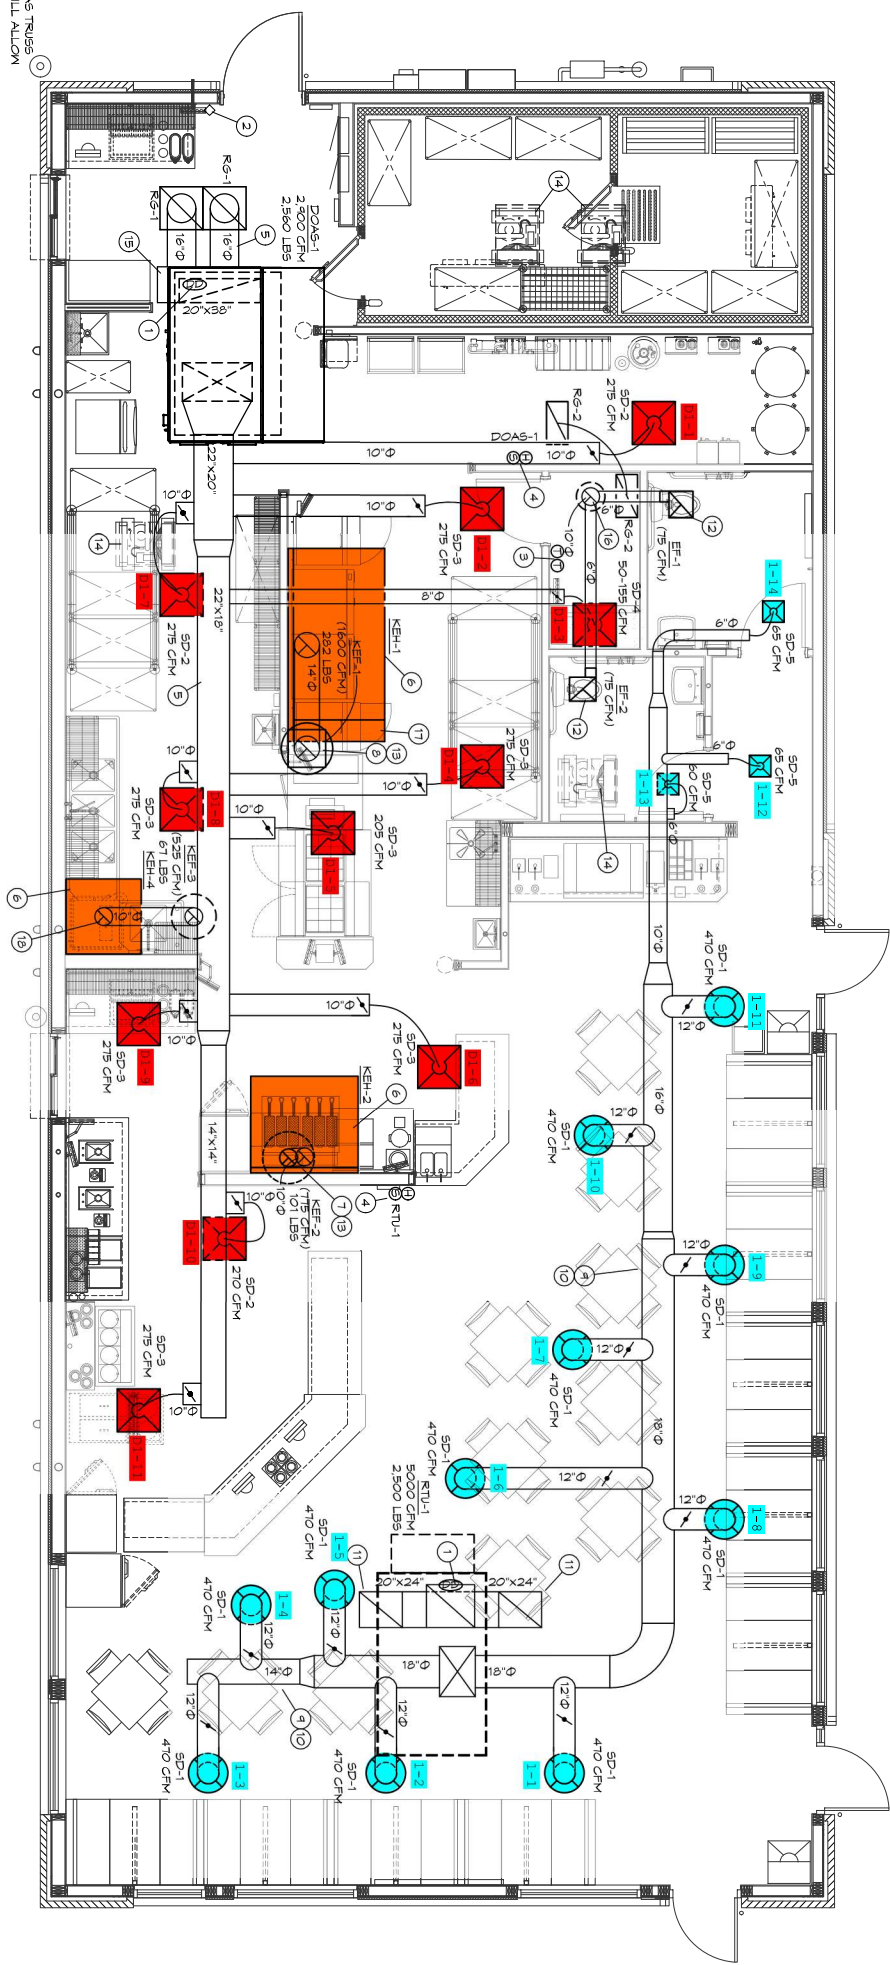

MET
MECHANICAL FLOOR PLAN
SCALE: 1/4" = 1'-0"