


ALL ROOFING WORK SHALL BE PERFORMED BY LANDLORD'S APPROVED ROOFING CONTRACTOR. IF REVISIONS ARE REQUIRED, IT SHALL BE IN LETTER OR EMAIL ON 10/18/14

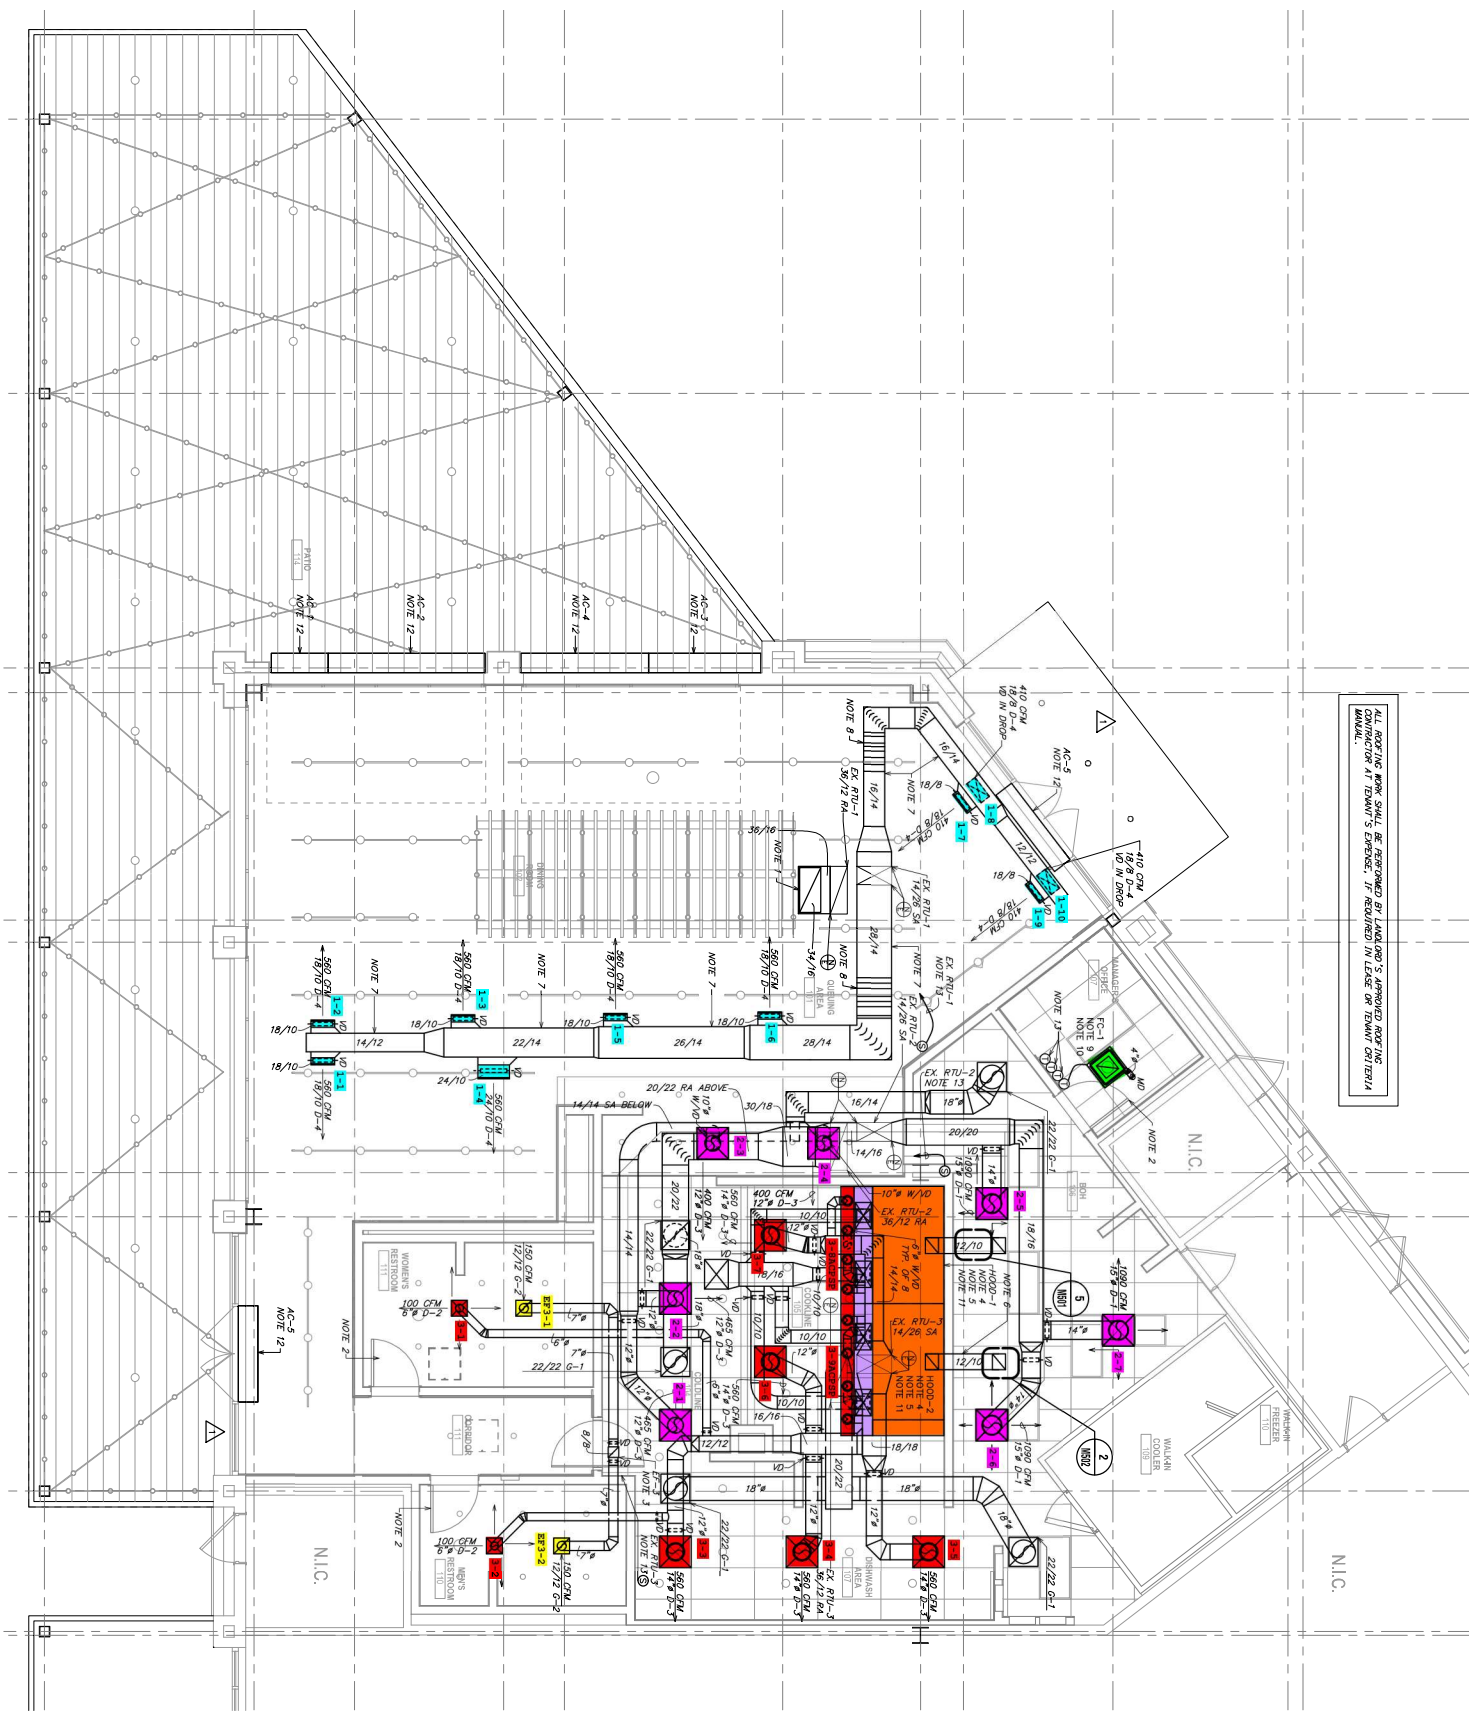

1 MECHANICAL FLOOR PLAN  
SCALE: 1/4" = 1'-0"