


AC-1
5 TON HVAC ON ROOF
16" DROP - 2000 CFM

AC-2
5 TON HVAC ON ROOF
16" DROP - 2000 CFM

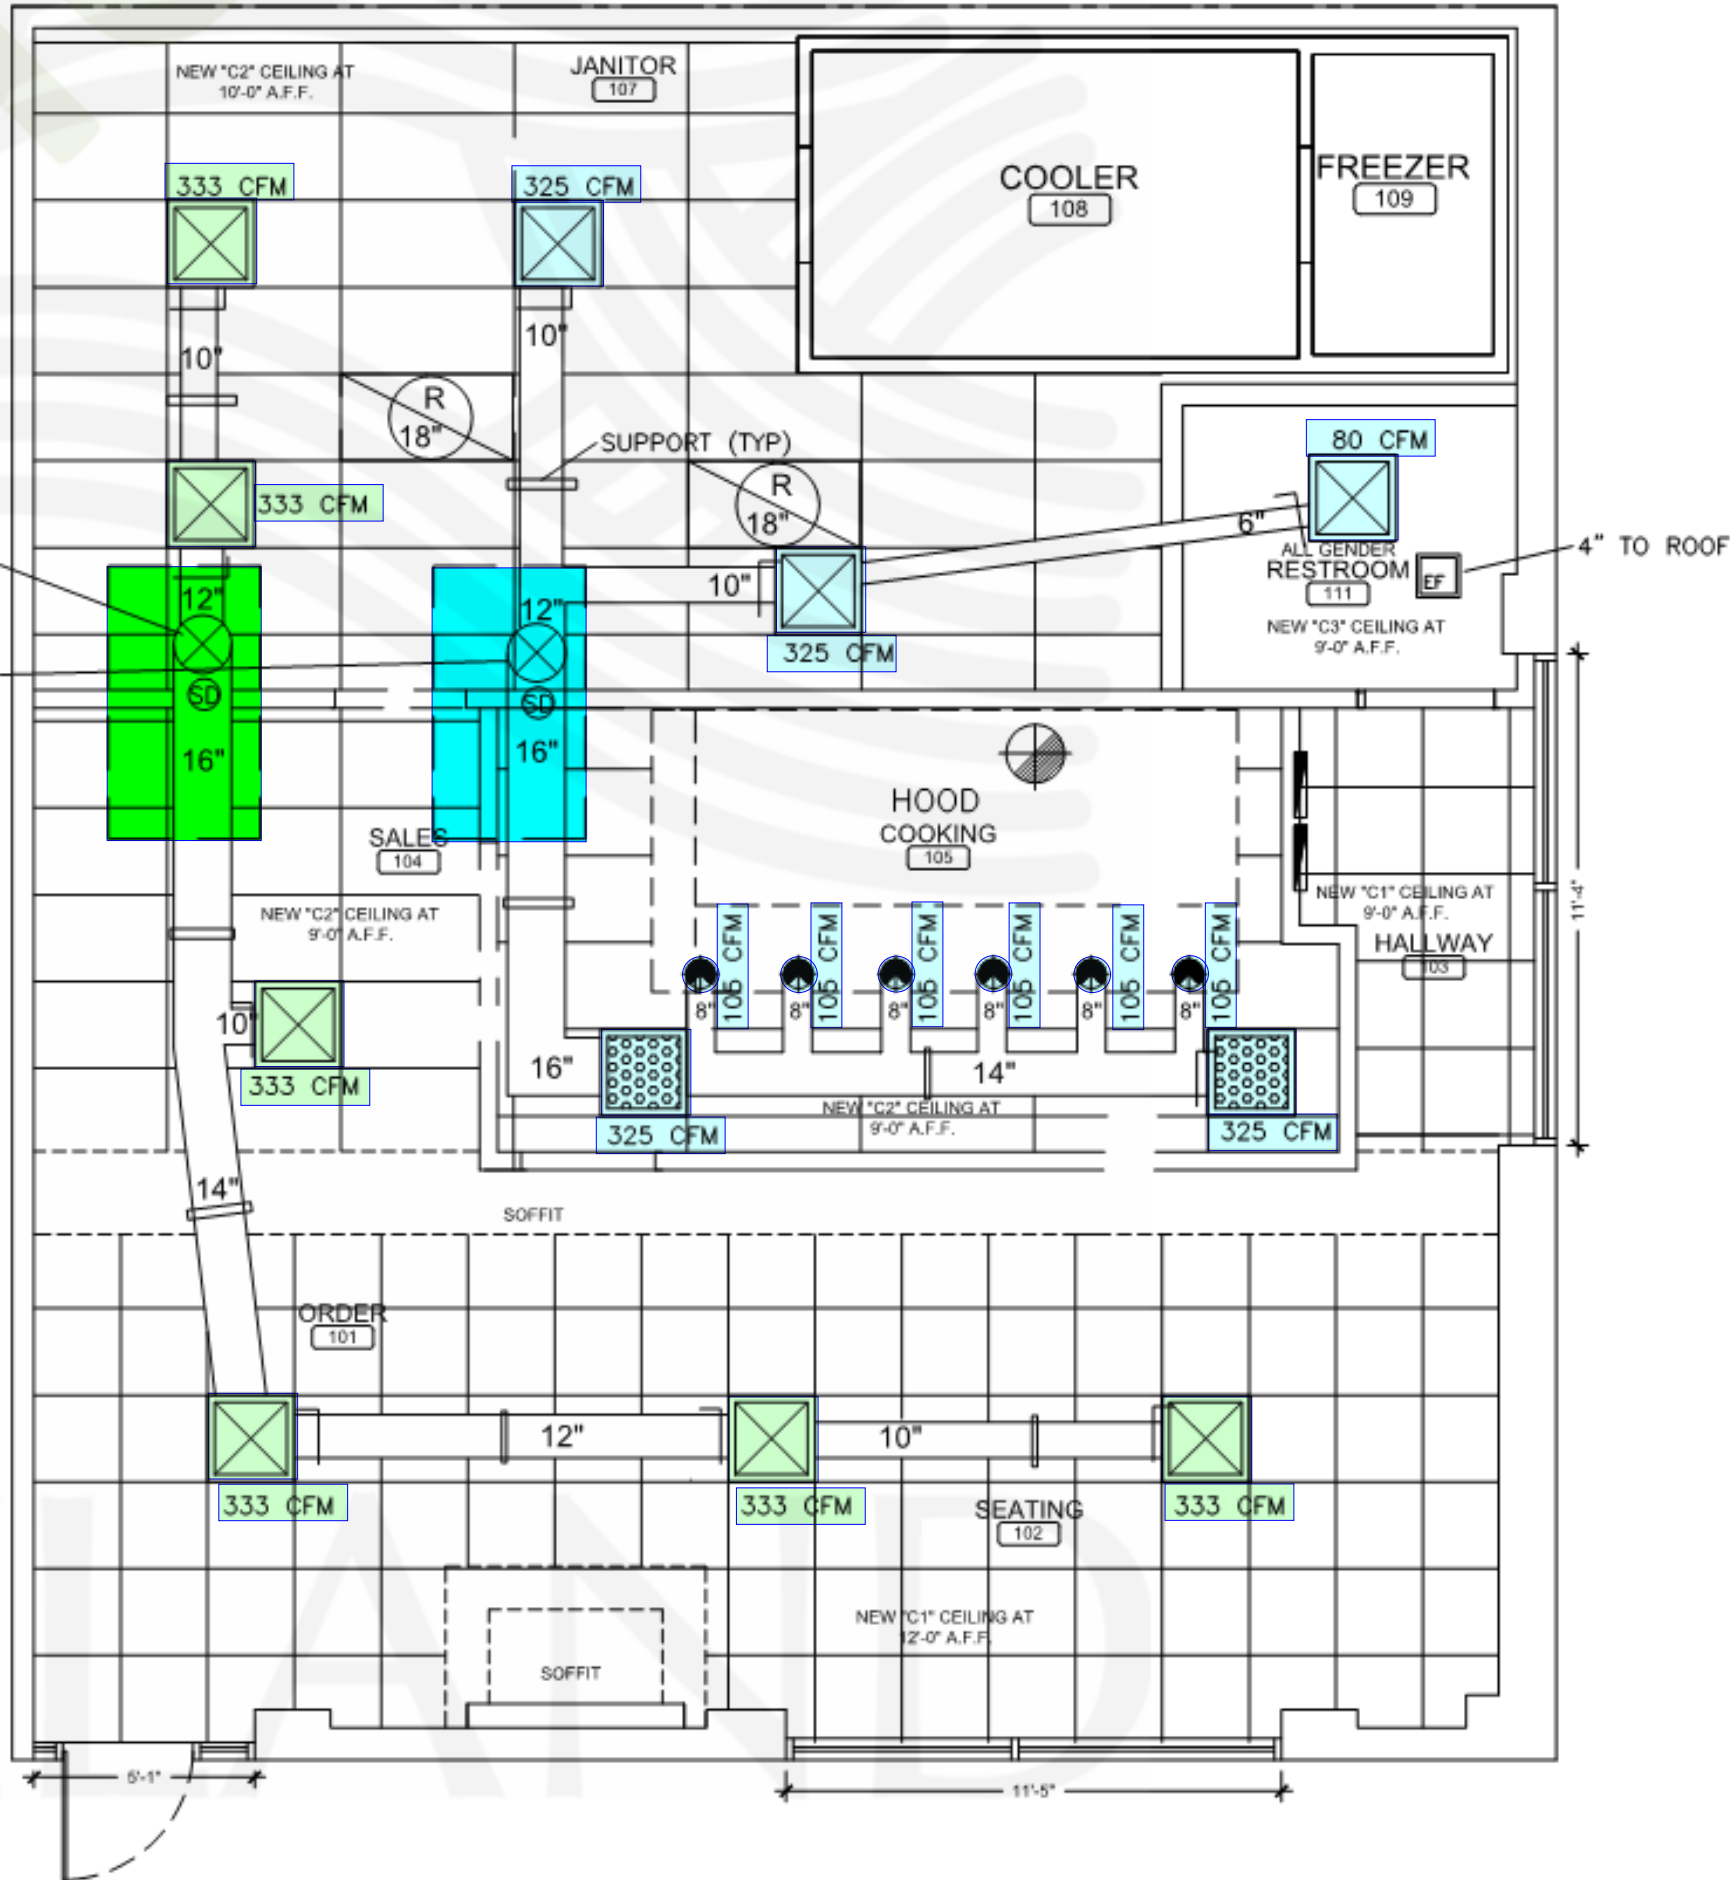

HVAC FLOOR PLAN

SCALE: 1/4" = 1'-0"