


AC-1  
5 TON HVAC ON ROOF  
16" DROP - 2000 CFM

AC-2  
5 TON HVAC ON ROOF  
16" DROP - 2000 CFM

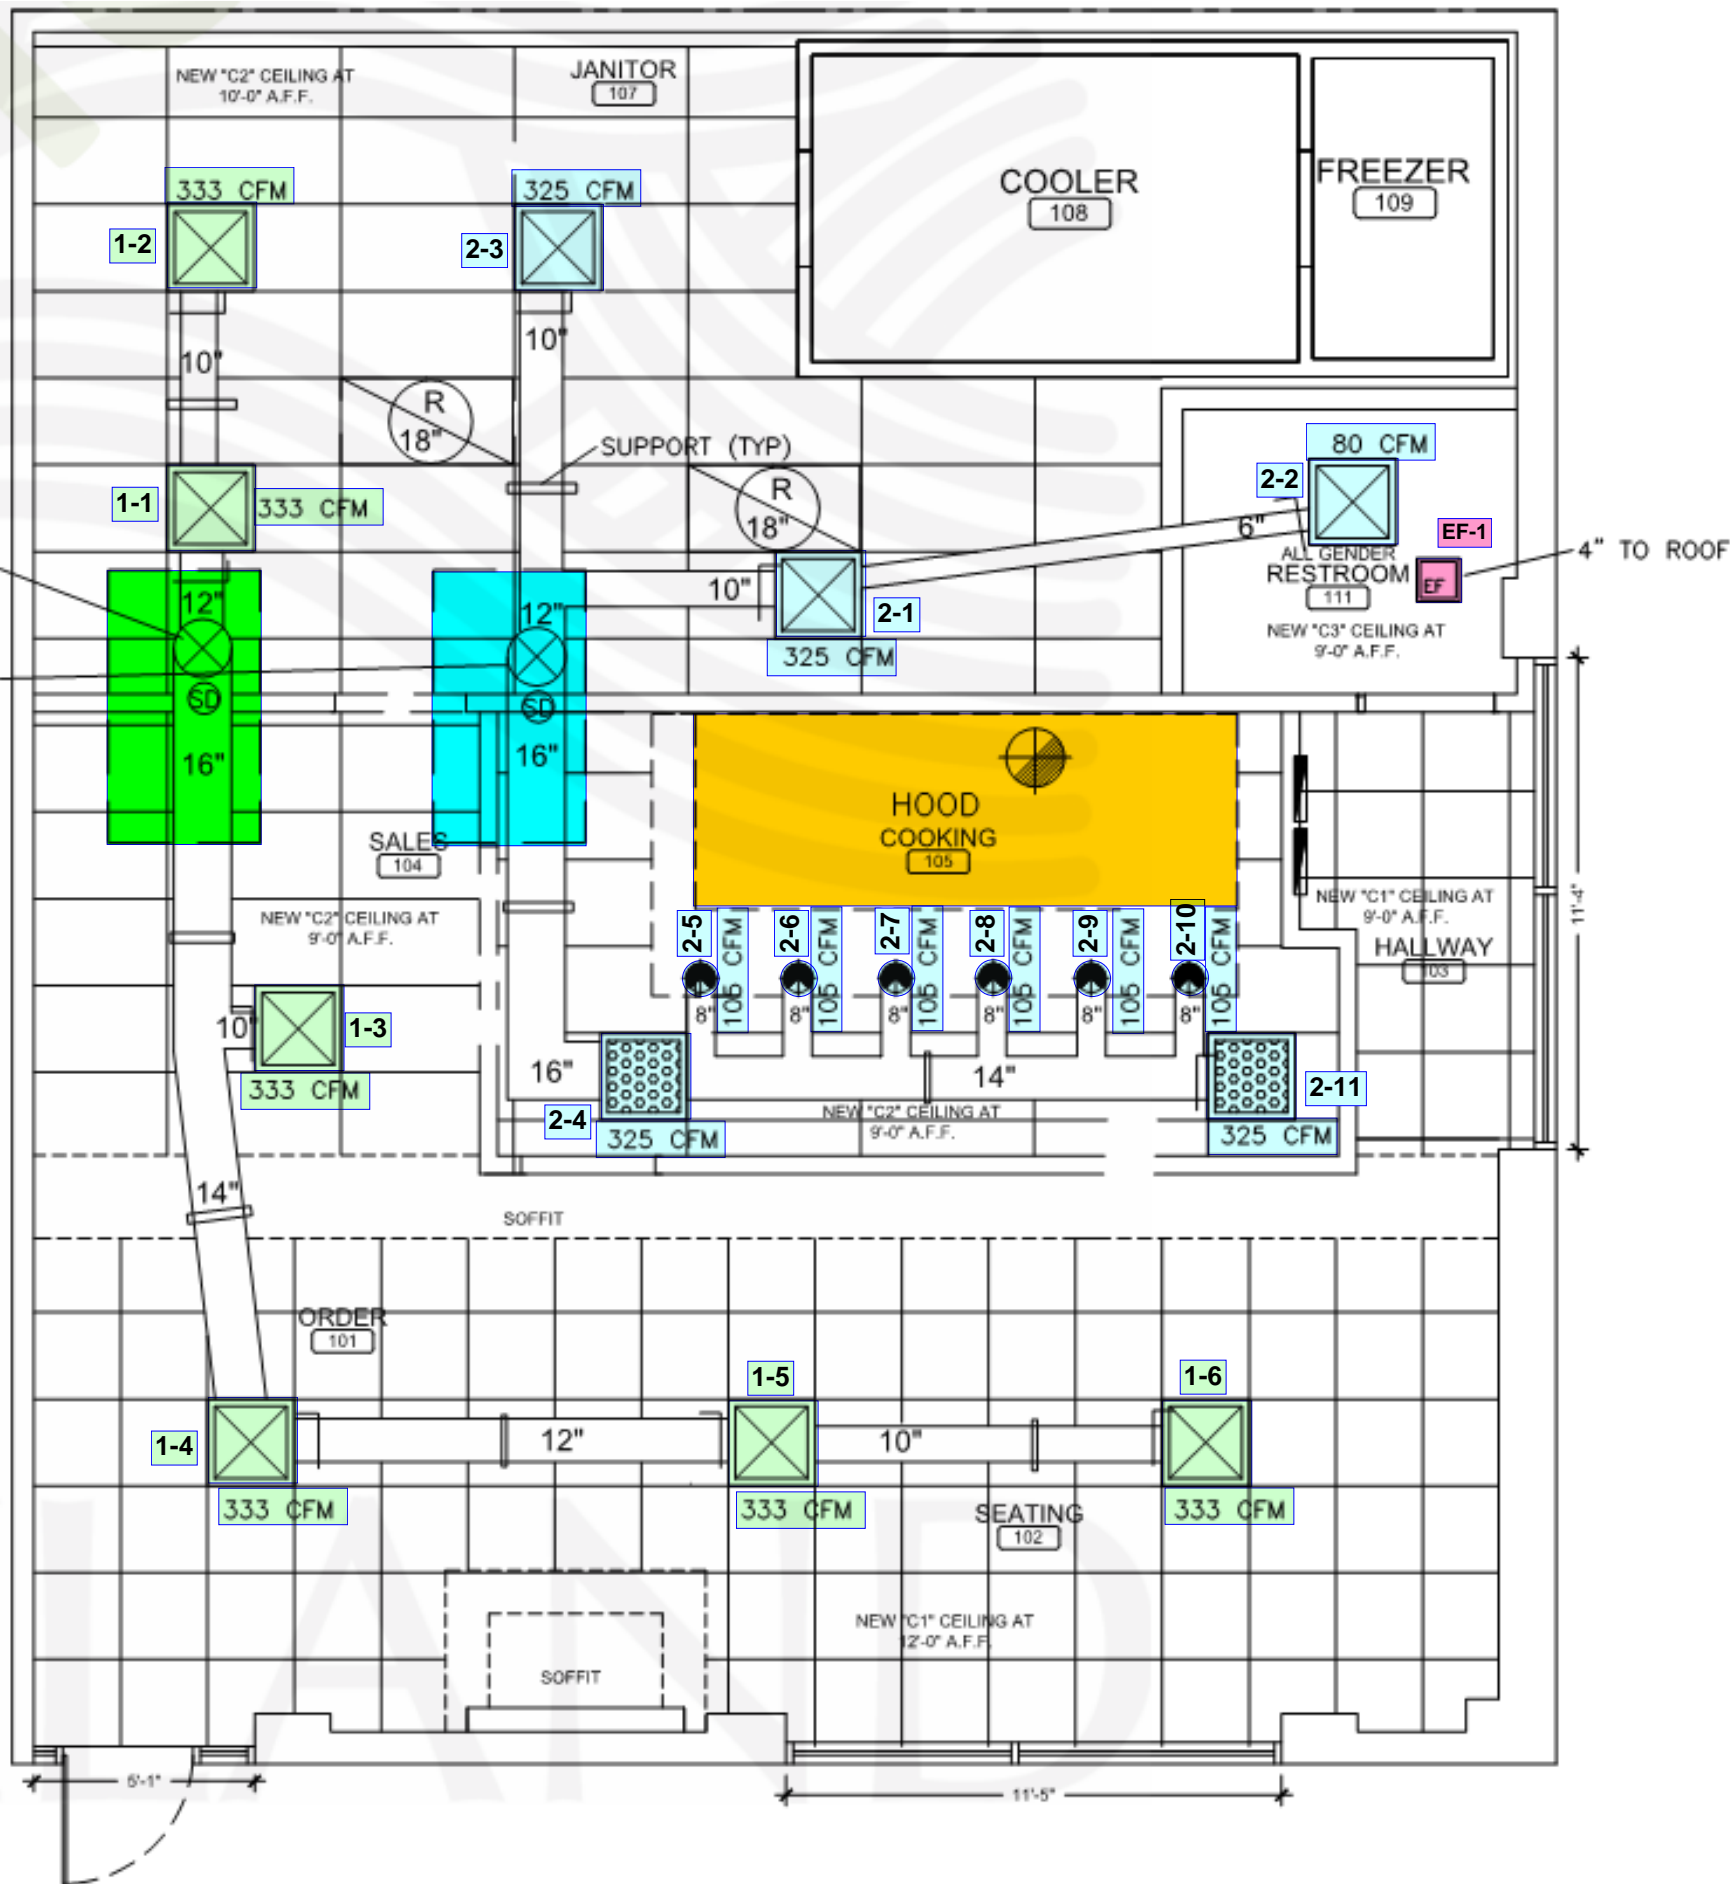

**HVAC FLOOR PLAN**  
SCALE: 1/4" = 1'-0"