


GENERAL NOTES:



1. CONTRACTOR TO COORDINATE ALL THERMOSTAT LOCATIONS WITH ARCHITECT PRIOR TO INSTALLATION WITH FINAL APPROVAL BY MECHANICAL ENGINEER.
2. CONTRACTOR SHALL COMPLY WITH THE LATEST VERSION OF THE BUILDING RULES AND REGULATIONS GUIDELINES.
3. CONTRACTOR TO CONFIRM ALL TERMINAL UNITS ARE LOCATED TO ENSURE MAINTENANCE ACCESS IS MAINTAINED. PROVIDE ACCESS PANELS IN HARD CEILING AS NEEDED. COORDINATE WITH ARCHITECT AND ENGINEER IF REQUIRED.
4. SHADED AREA IS NOT IN SCOPE.

MECHANICAL KEY NOTES:

1. REBALANCE EXISTING VAV BOX TO CFM ON PLAN.
2. REBALANCE EXISTING AC UNIT TO CFM ON PLAN.
3. PROVIDE 1-1/2 HR RATE FIRE DAMPER IN SUPPLY AND RETURN DUCT.

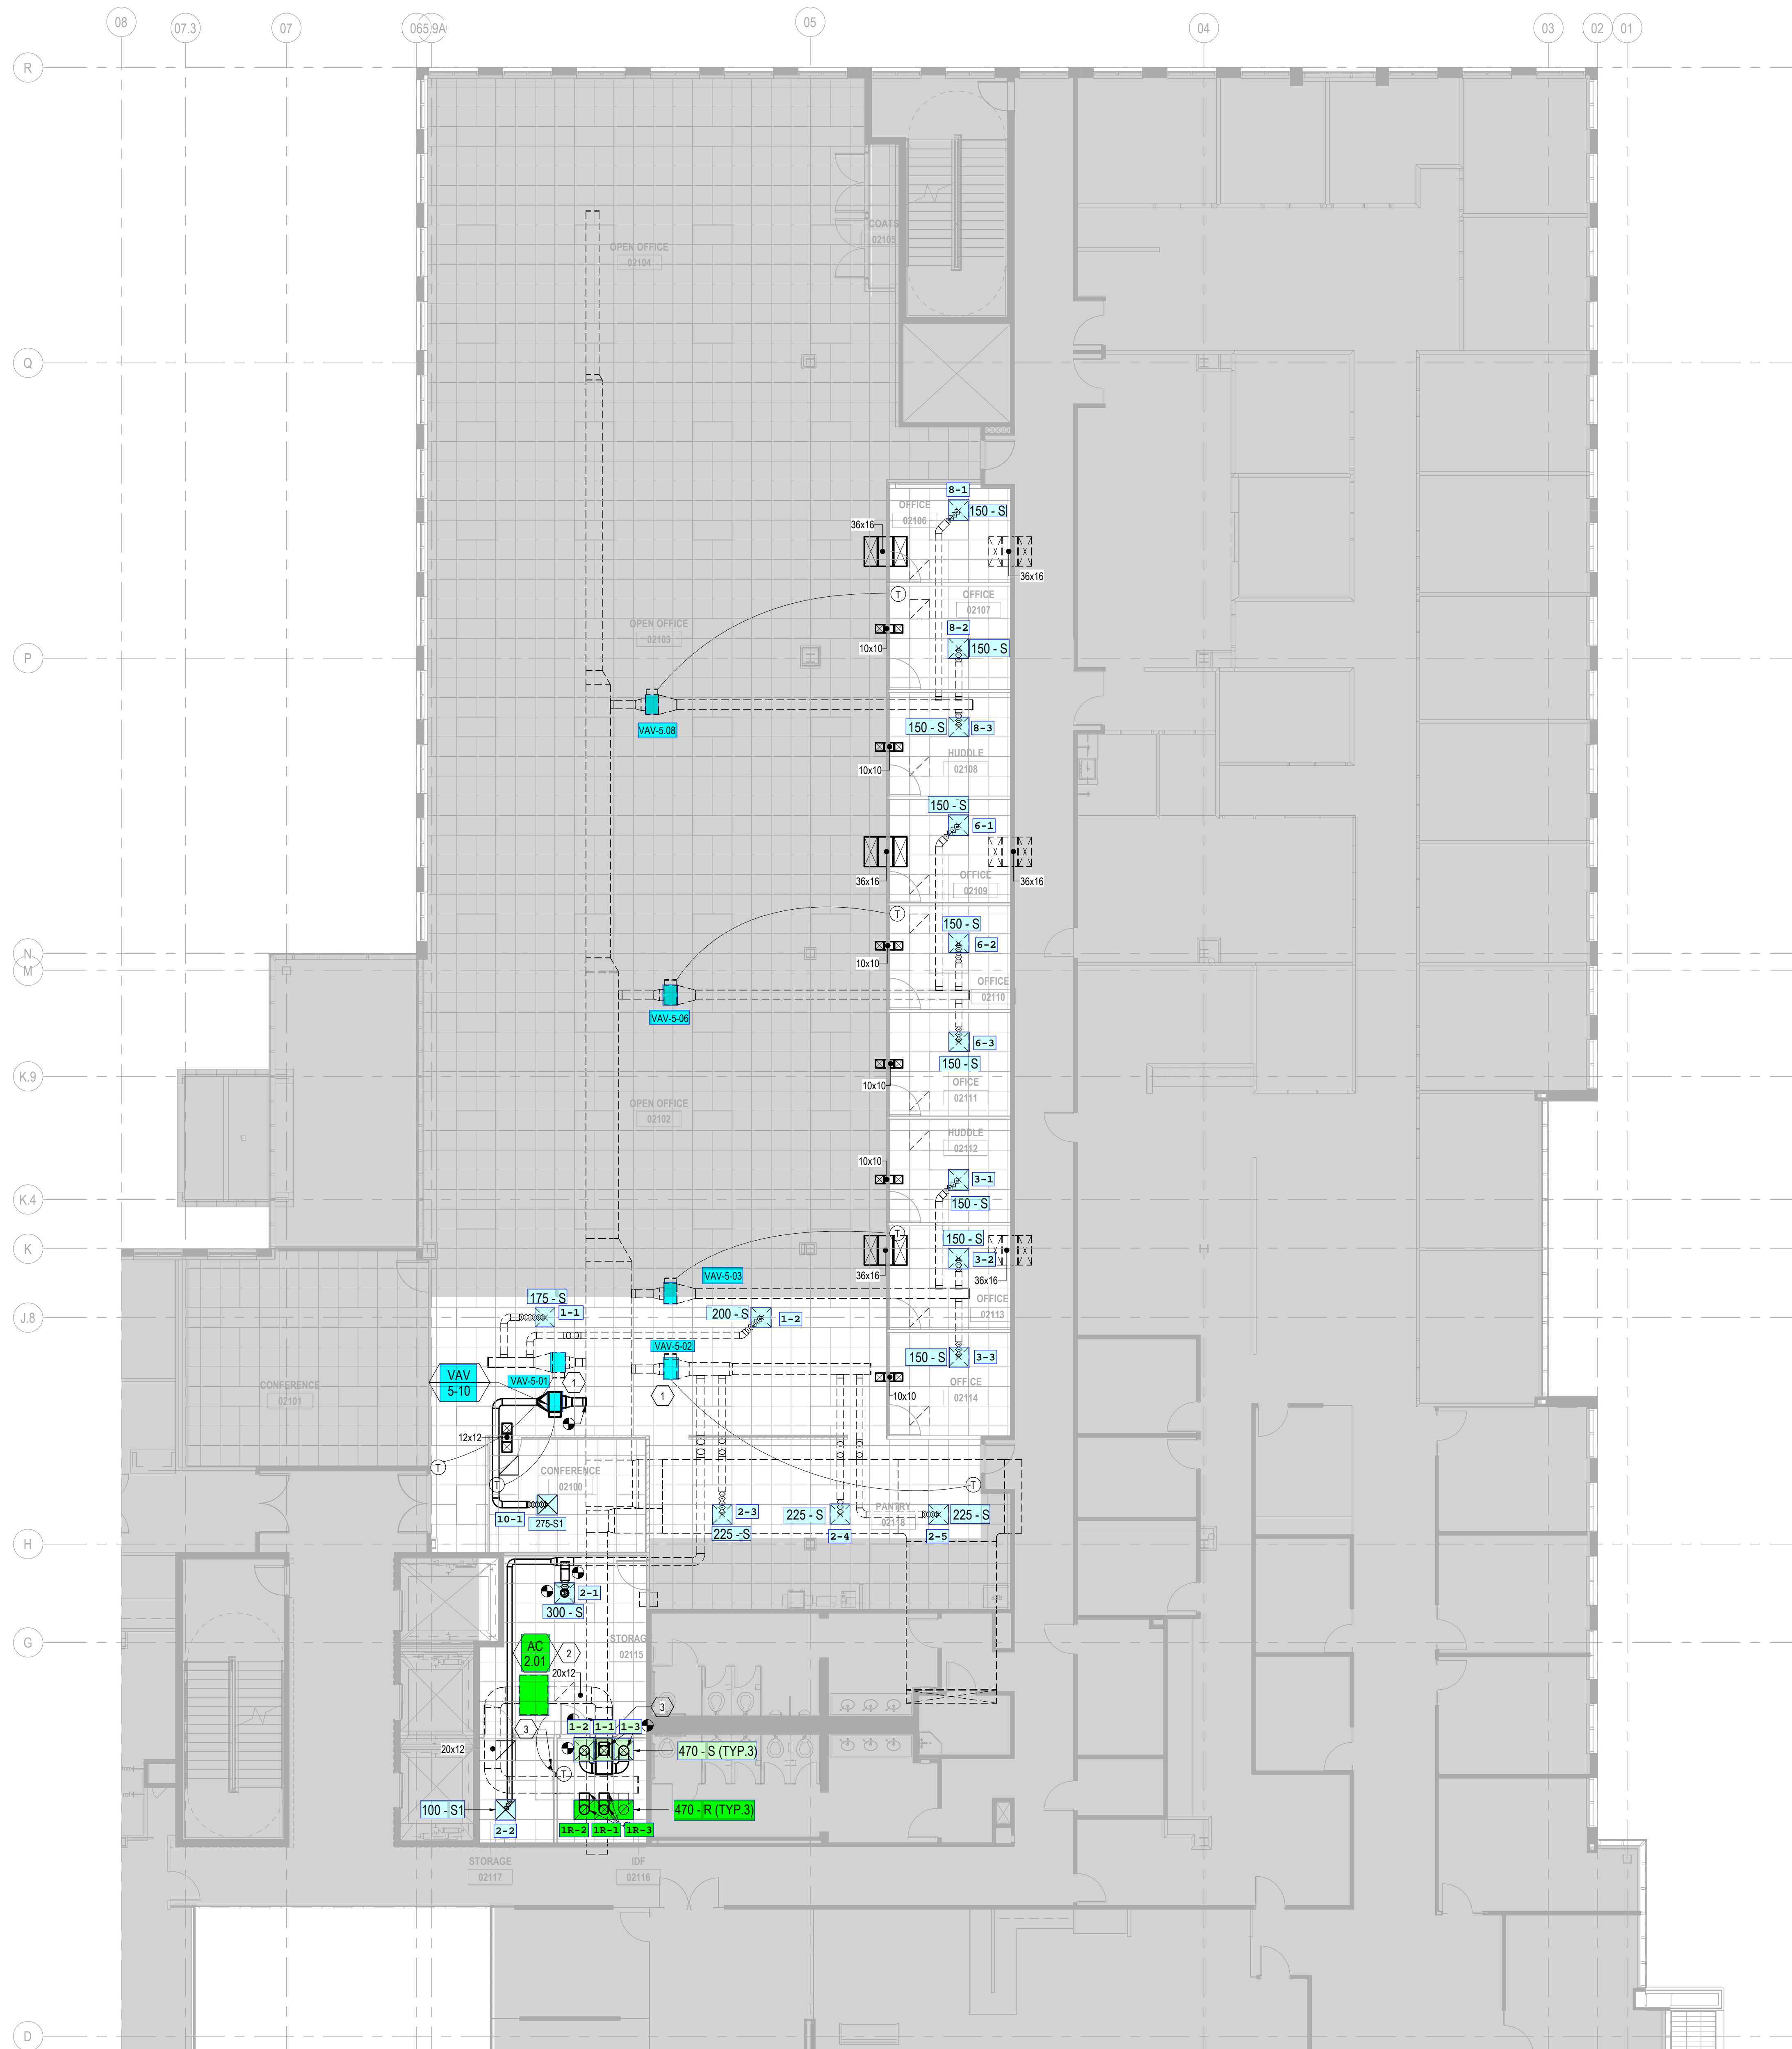

1 LEVEL 02 - MECHANICAL HVAC PLAN
1/8" = 1'-0"

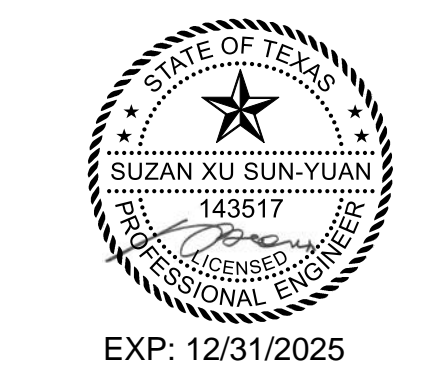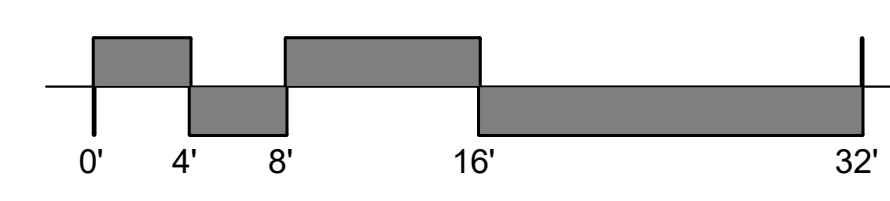

EXP: 12/31/2025

PROJECT


OCC DALLAS

2ND FLOOR EXPANSION



OPTIONS CLEARING CORPORATION

KEY PLAN

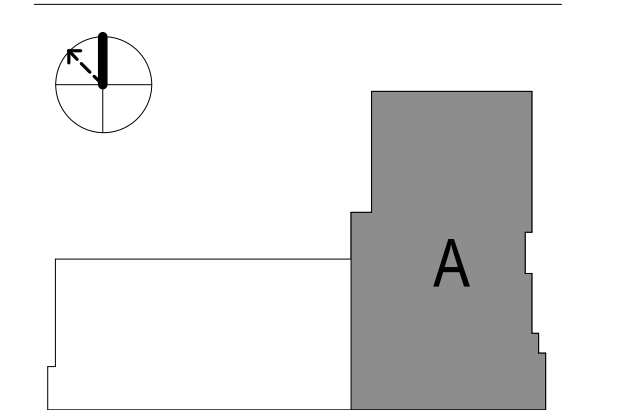

ISSUE CHART

NO.	ISSUE FOR BID/PERMIT	DATE
1	ISSUE FOR BID/PERMIT	09/05/2025
2	ISSUE	DATE

Job Number 240100992
TITLE

LEVEL 02 - MECHANICAL HVAC PLAN

SHEET NUMBER

MH1.02