




1
M-2.33 1/8" = 1'-0"
MECHANICAL PIPING SECOND LEVEL PLAN - 3



2
M-2.33 1/4" = 1'-0"
MECHANICAL PIPING PLAN - ENLARGED MECHANICAL COOLING PLANT

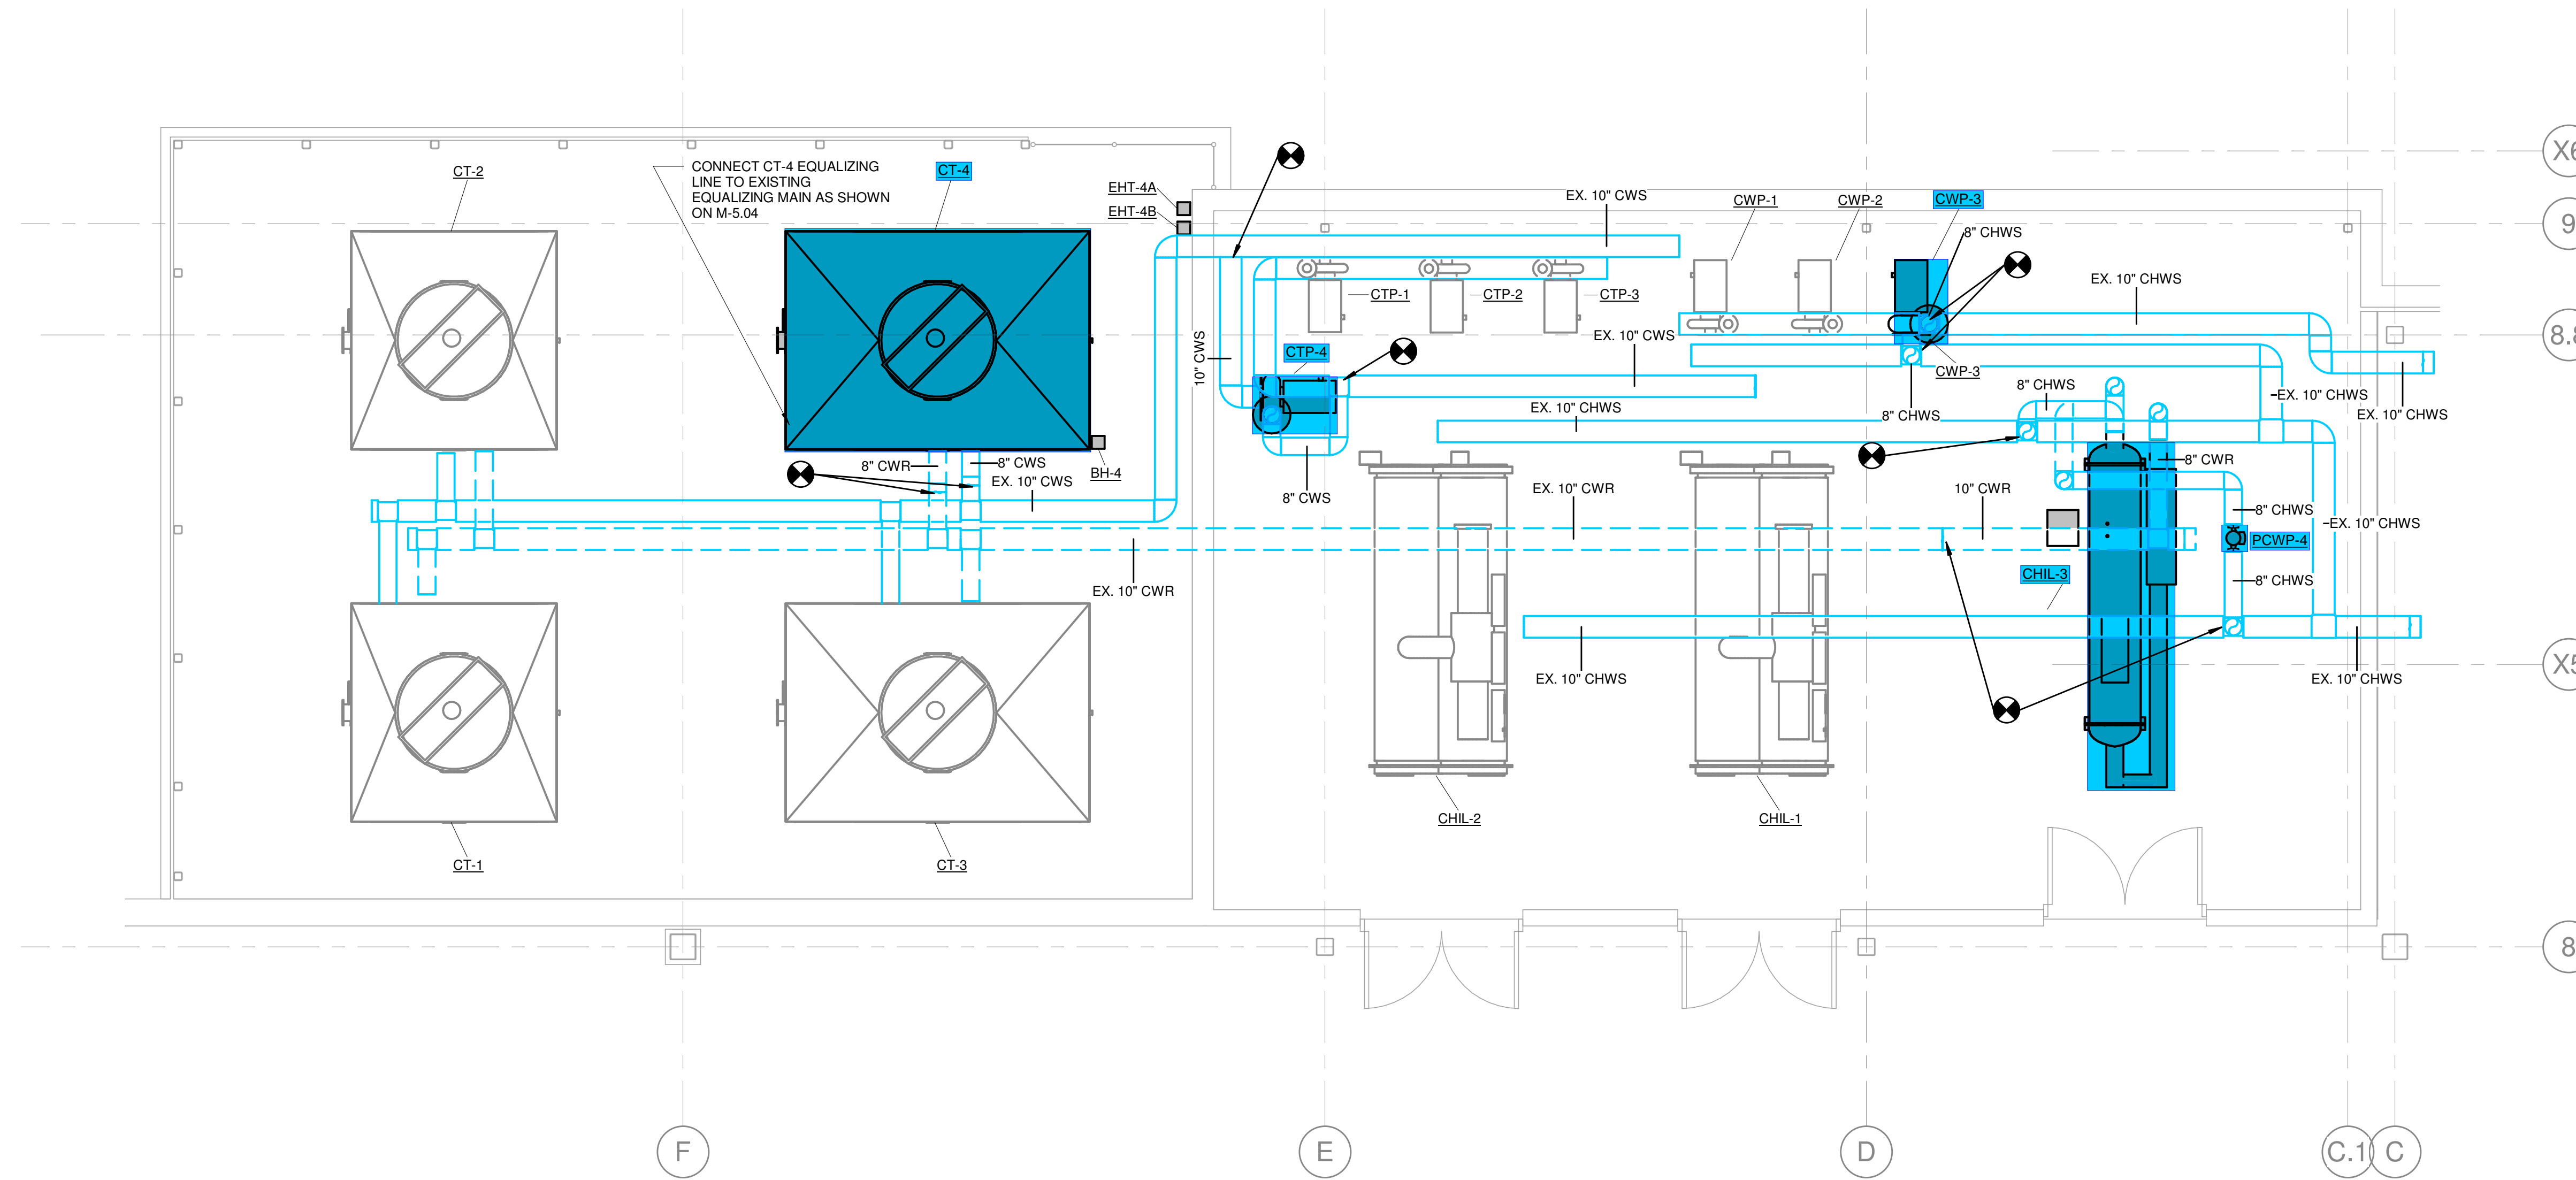

KEYPLAN

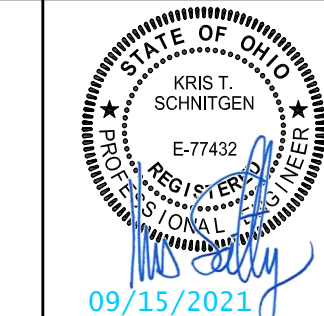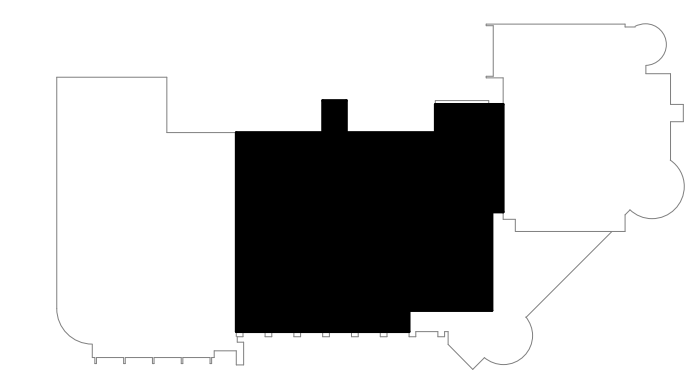

SEKLH
ENGINEERS
MECHANICAL/ELECTRICAL ENGINEERS
WWW.KLEHNS.COM

your trusted advisor
consultants
engineers
architects
planners


BY: CAM
DATE: 04-24-2021
09-18-2021

REV	DATE	DESCRIPTION
1	09/13/2021	ISSUED FOR FINAL ESTIMATE AND PERMIT (REMOVED FOR BIDDING AND PERMIT)


DATE: 09/13/2021
DRAWN BY: []
CHECKED BY: []
APPROVED BY: []
P.E. NO. []

SHARONVILLE CONVENTION CENTER EXPANSION
CITY OF SHARONVILLE
11355 CHESTER RD, CINCINNATI OH 45246
MECHANICAL PIPING SECOND LEVEL PLAN - 3

SCALE: AS NOTED
HORIZ:
VERT:
CONTRACT NO:
180634
SHEET
M-2.33
KLH JOB #: 21108.00

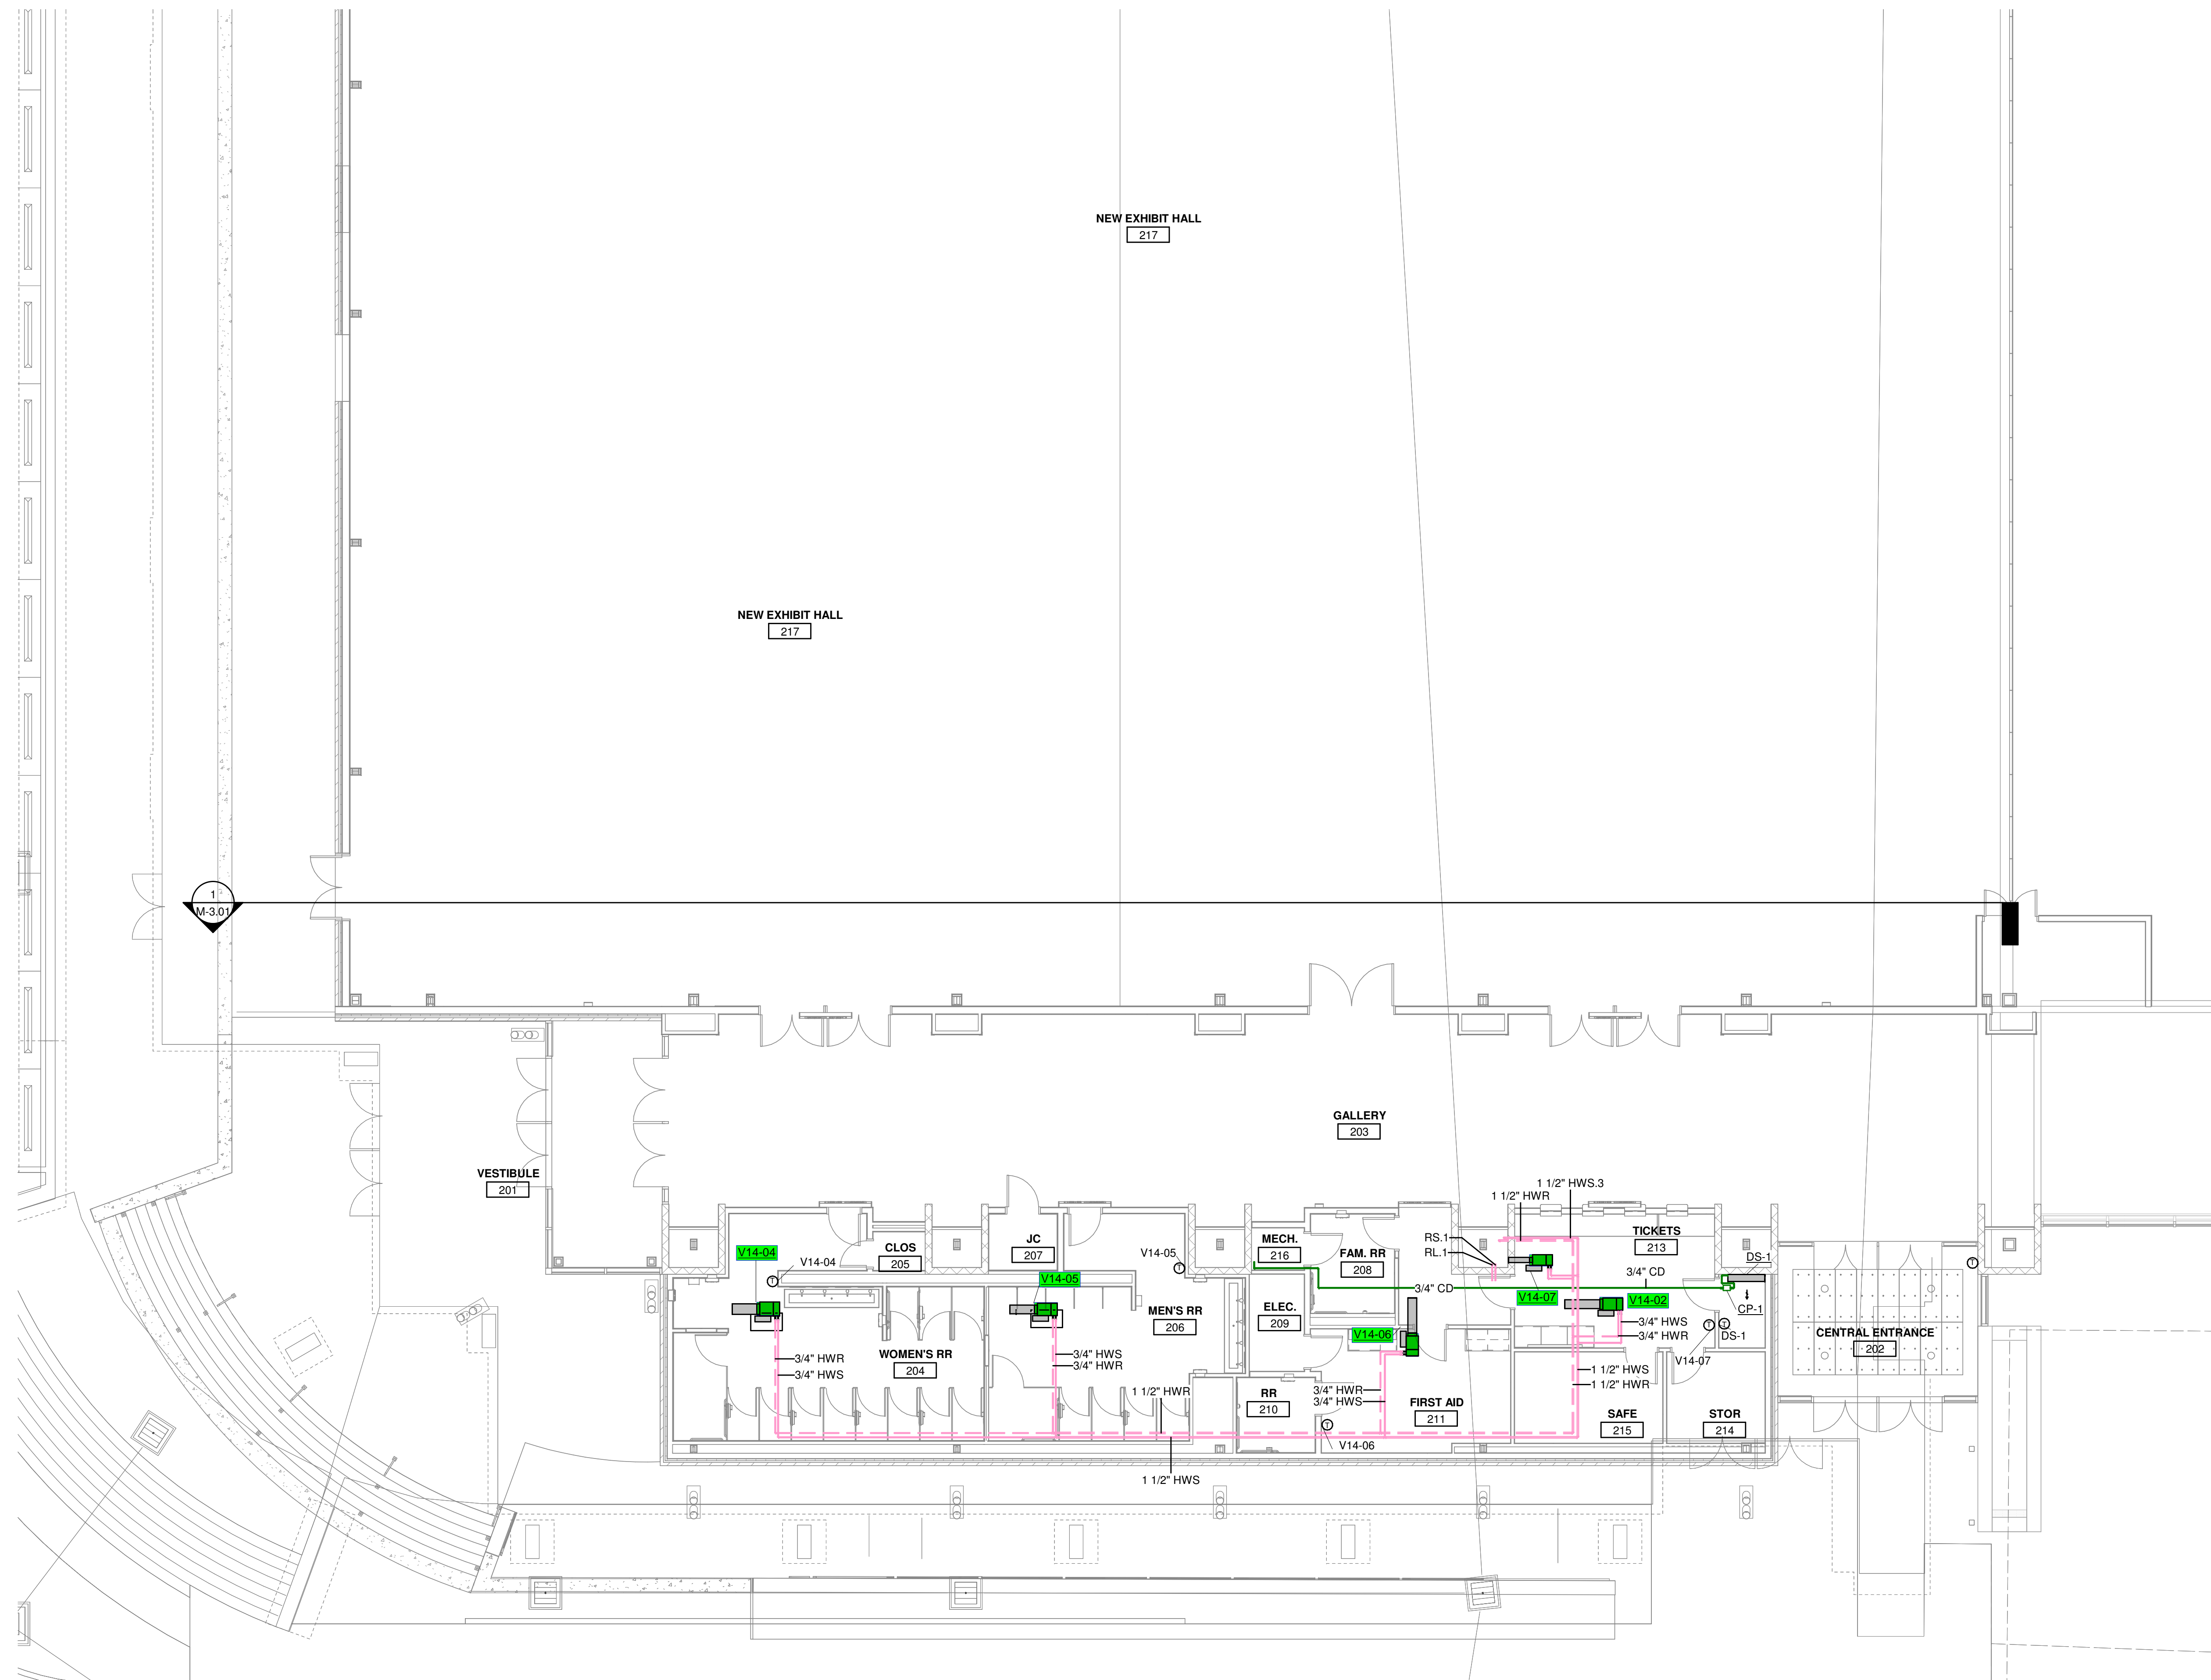


1 **MECHANICAL PIPING SECOND LEVEL PLAN - 4A**
 M-2.34A 1/8" = 1'-0"

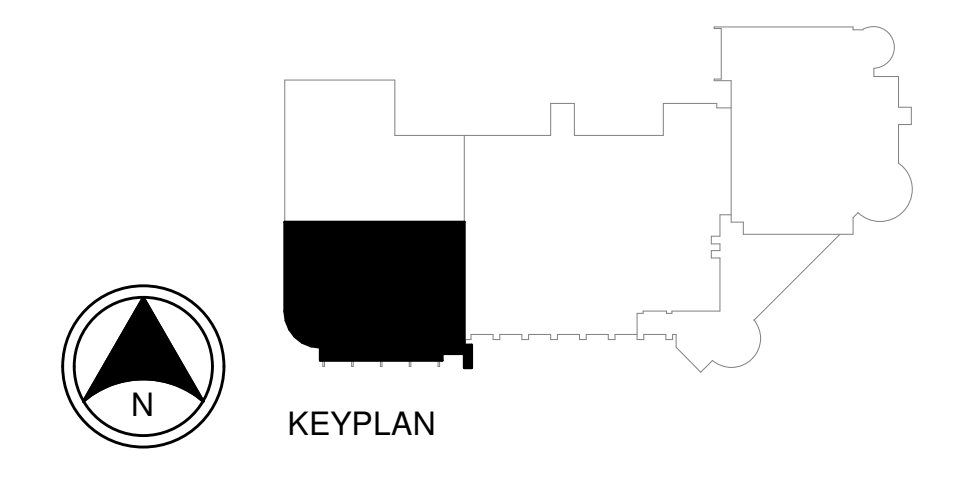

9/15/2021 1:25:11 PM



185 N. EVANSVILLE PKW. SUITE 100
 111 FT. THOMAS, KENTUCKY 40375
 41075 800-354-9799
 859-442-8688 FAX
 LEWISTON, KENTUCKY
 NEW YORK, NEW YORK
 LOUISVILLE, KENTUCKY

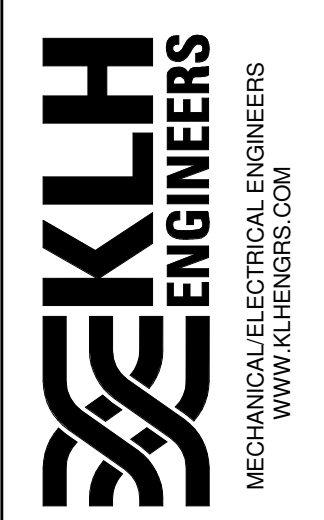


your trusted advisor
consultants
 engineers
 architects
 planners

REV	DATE	BY	REVISIONS
1	09-15-2021	CSL	ISSUED FOR FINAL ESTIMATE AND PERMIT
2	04-24-2021	CSL	ISSUED FOR BIDDING AND PERMIT
3	09-15-2021	CSL	


SHARONVILLE CONVENTION CENTER EXPANSION
 CITY OF SHARONVILLE
 11355 CHESTER RD., CINCINNATI OH 45246
MECHANICAL PIPING SECOND LEVEL PLAN - 4A

SCALE: AS NOTED
 HORIZ:
 VERT:
 CONTRACT NO:
180634
 SHEET
M-2.34A

KLH JOB #: 21108.00

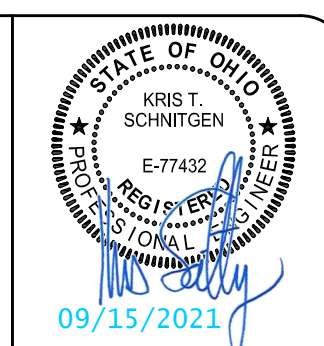

1539 ALEXANDRIA PIKE SUITE 111
 41075 800-354-9793
 89-442-8685 FAX
 LEWINGTON, KENTUCKY
 NEW YORK, NEW YORK
 LOUISVILLE, KENTUCKY

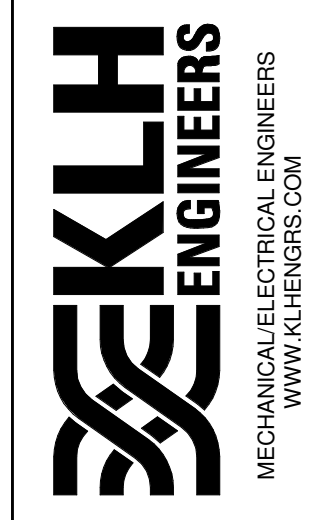


your trusted advisor
consultants
 engineers
 architects
 planners

REV	DATE	BY	REVISIONS
1	09/15/2021	CSM	ISSUED FOR BIDDING AND PERMIT


SHARONVILLE CONVENTION CENTER EXPANSION
 CITY OF SHARONVILLE
 11355 CHESTER RD., CINCINNATI, OH 45246
 MECHANICAL PIPING SECOND LEVEL PLAN - 4B

SCALE: AS NOTED
HORIZ:
VERT:
CONTRACT NO:
180634
SHEET
M-2.34B

Mark	Color	System Name	Pipe Material
CD.1	Green	CD - (HVAC) Condensate	1 - Copper - Type L - ASTM B88
CHWS.3	Blue	CHWS - (HVAC) Chilled Water Supply	3 - Black Steel - Schedule 40 - ASTM A-53
CHWR.3	Blue	CHWR - (HVAC) Chilled Water Return	3 - Black Steel - Schedule 40 - ASTM A-53
HWS.3	Red	HWS - (HVAC) Hot Water Supply	3 - Black Steel - Schedule 40 - ASTM A-53
HWR.3	Red	HWR - (HVAC) Hot Water Return	3 - Black Steel - Schedule 40 - ASTM A-53

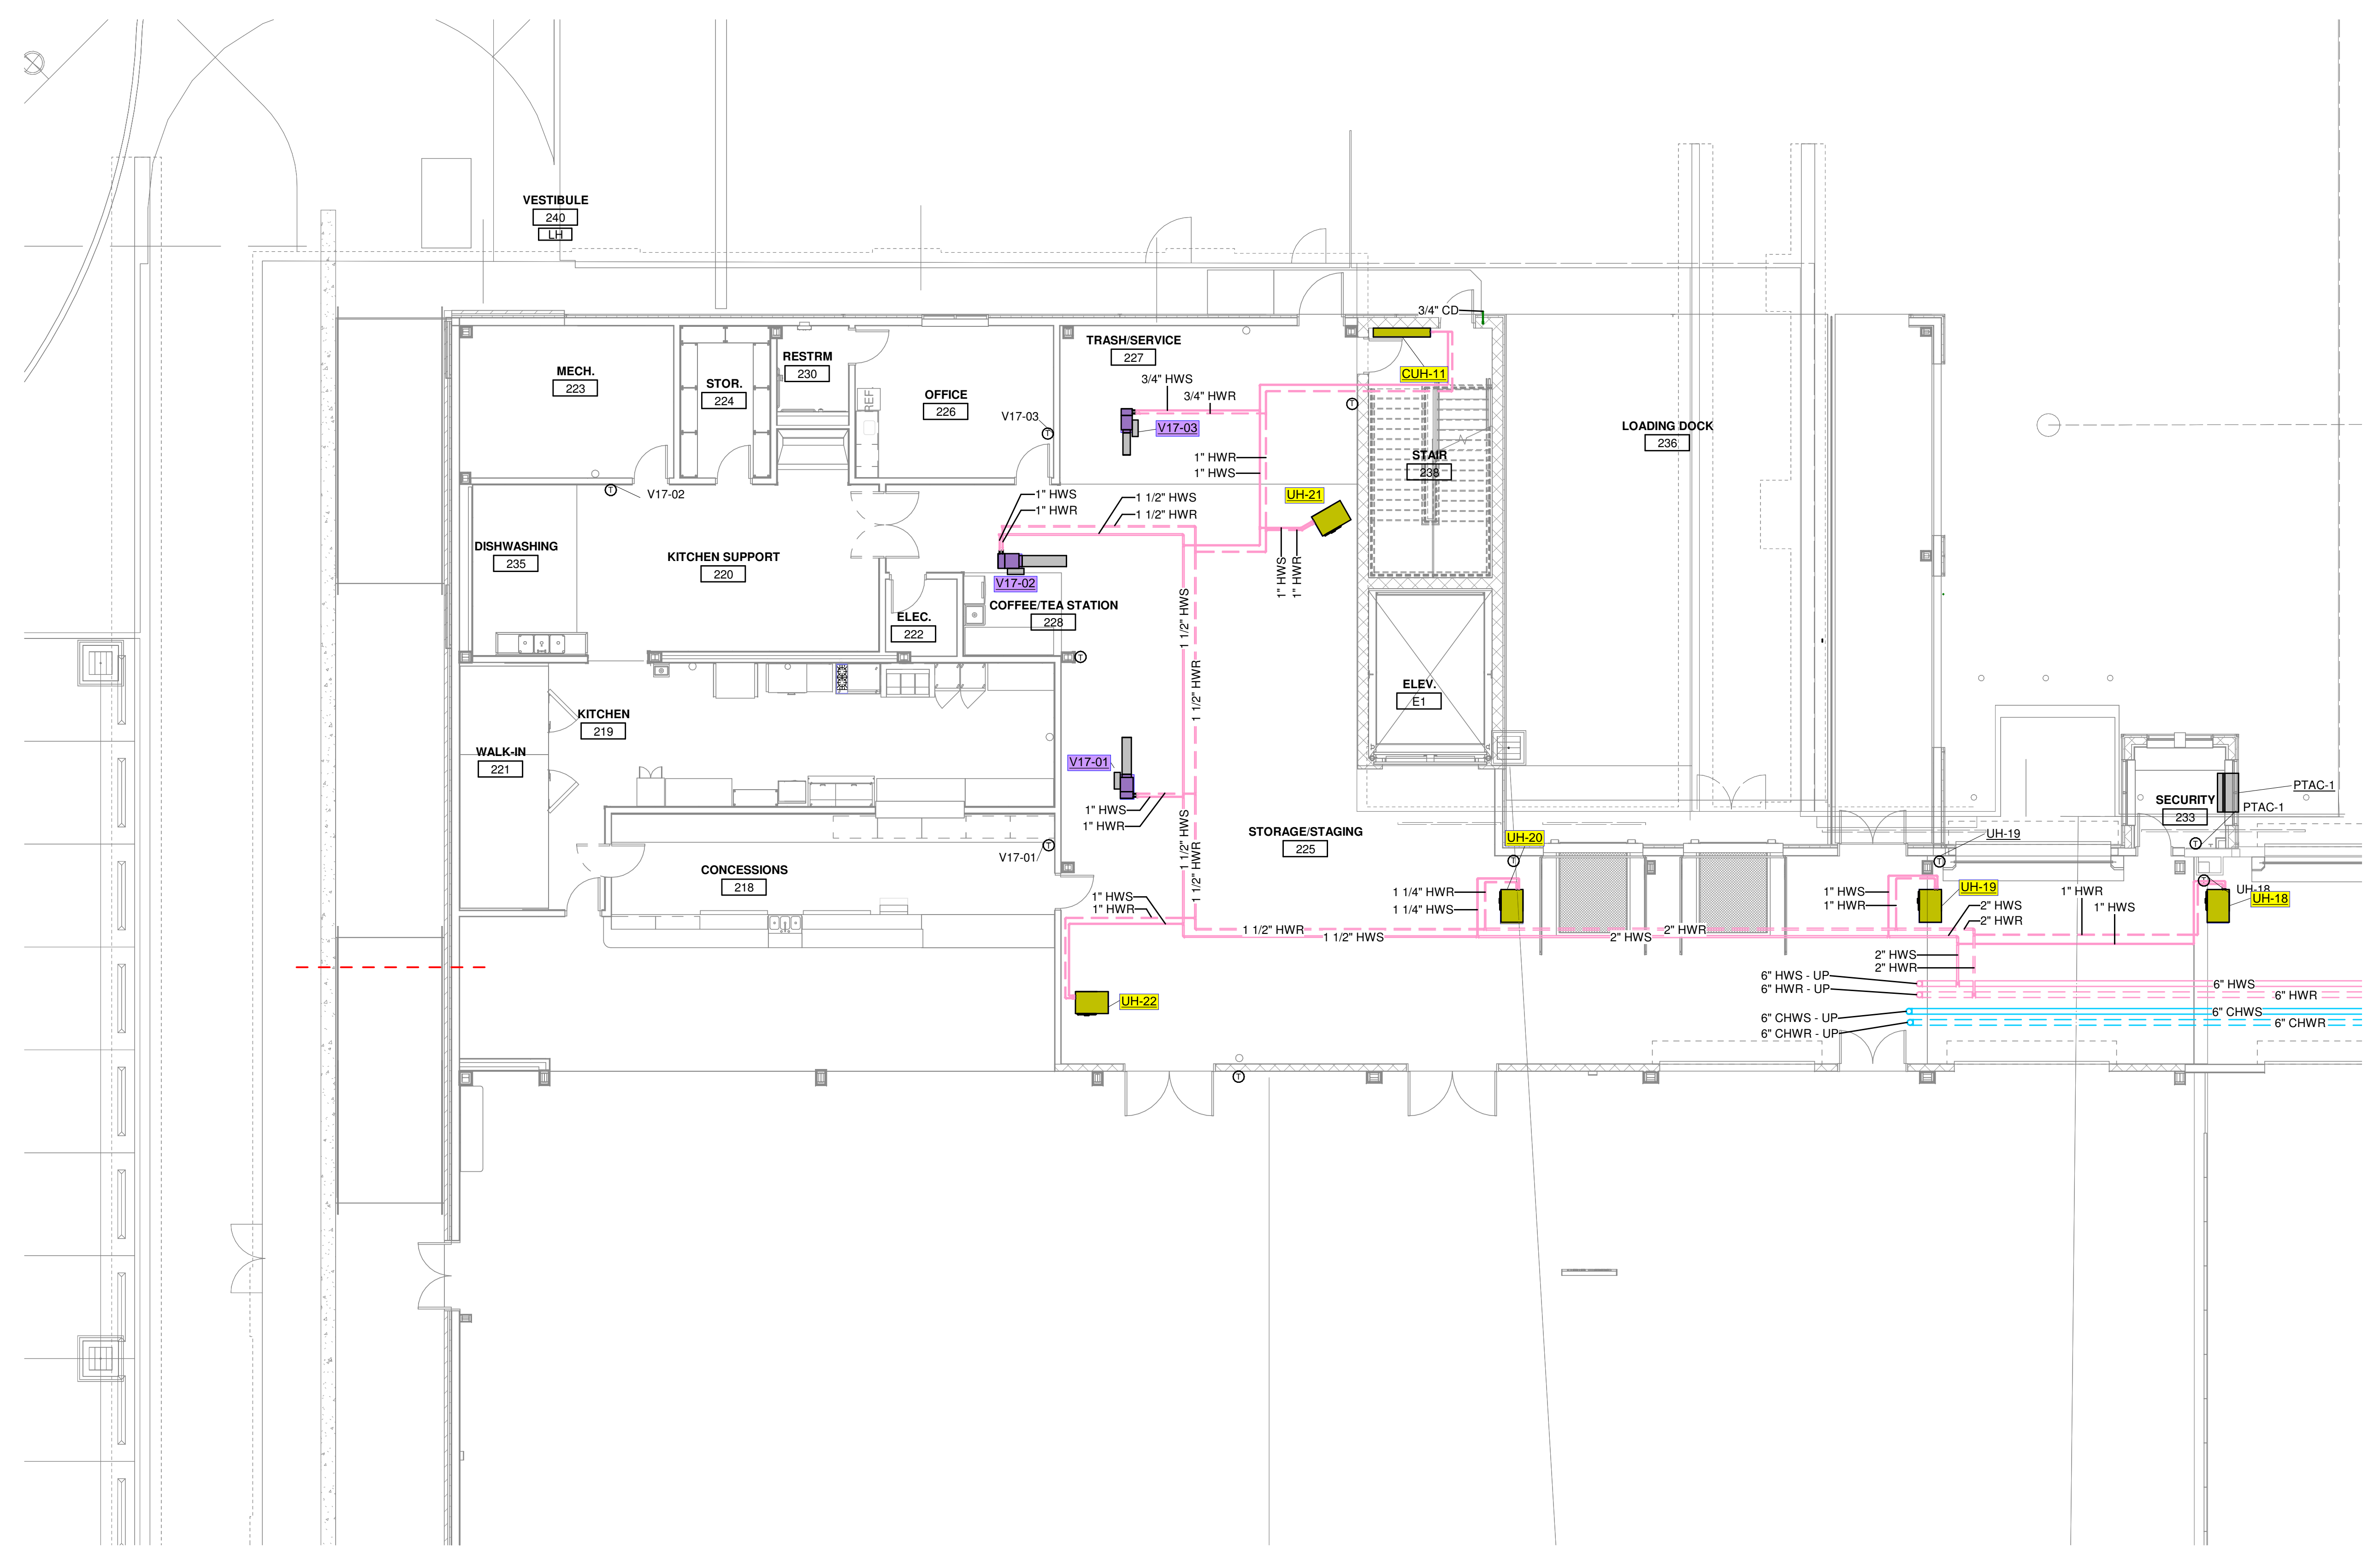

1
 M-2.34B 1/8" = 1'-0"

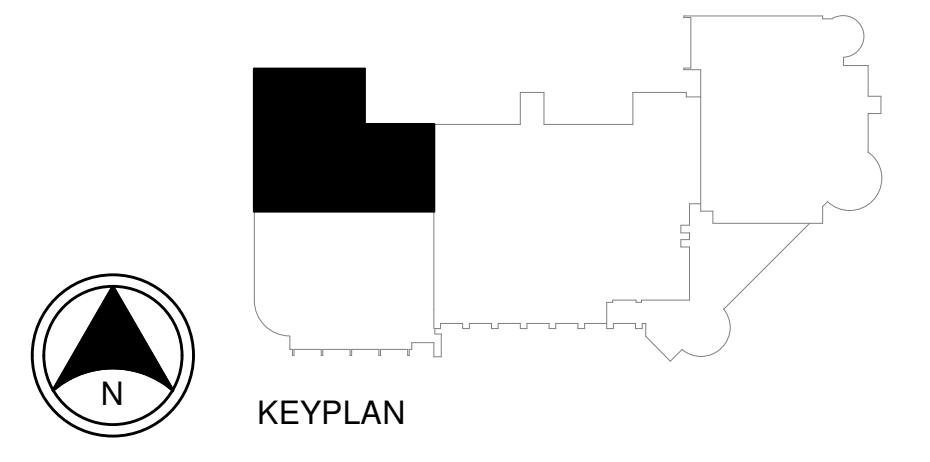


9/15/2021 1:25:14 PM


RLH JOB #: 21109.00

9/15/2021 1:25:17 PM

1 MECHANICAL PIPING THIRD LEVEL PLAN - 4
M-2.44 1/8" = 1'-0"

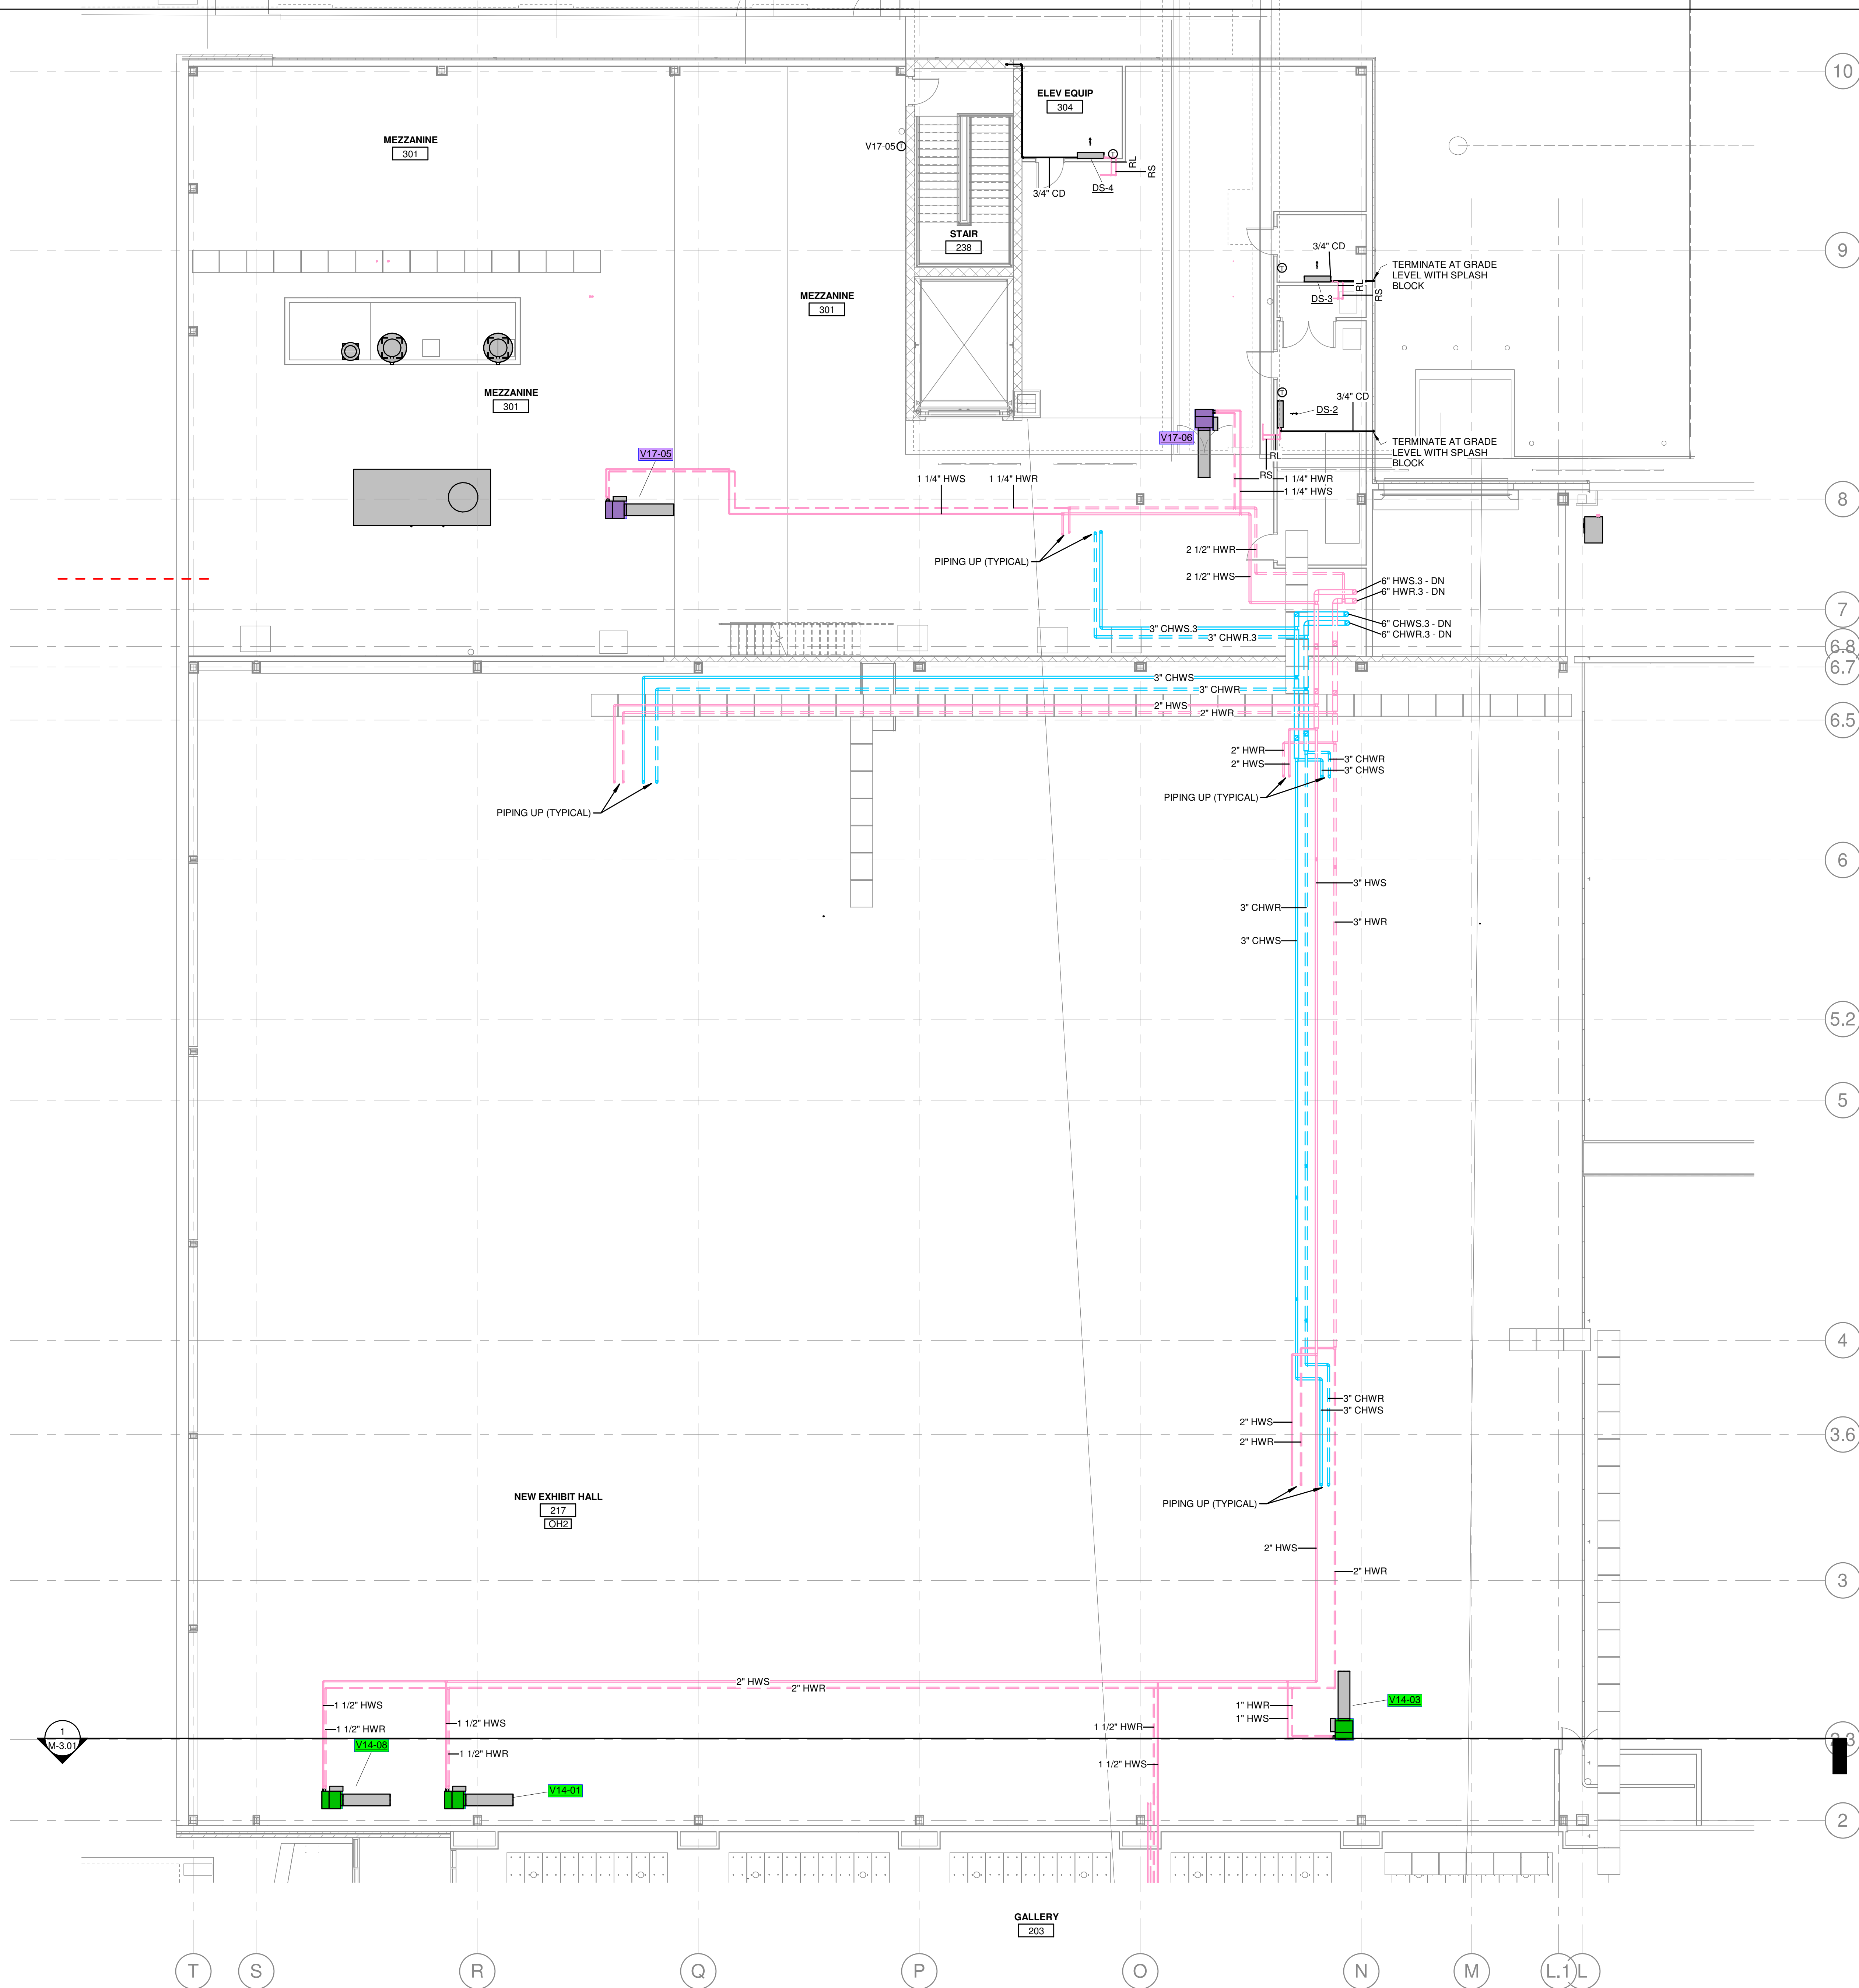

KEYPLAN

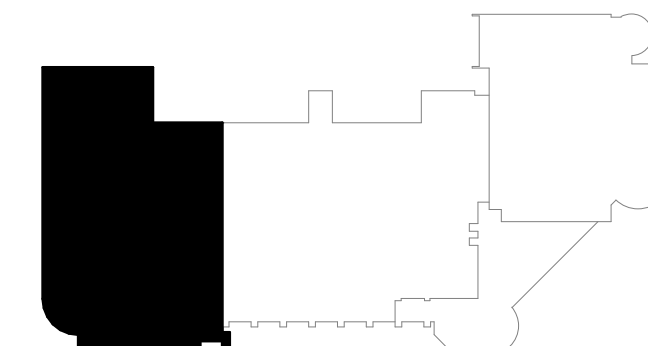

11355 CHESTER RD., CINCINNATI OH 45246
TEL: 513.963.8800 FAX: 513.963.8801
WWW.KELHLH.COM



your trusted advisor
consultants
engineers
architects
planners



REV	DATE	BY	REVISIONS
1	09-15-2021	CAM	ISSUED FOR FINAL ESTIMATE
2	09-15-2021	CAM	ISSUED FOR BIDDING AND PERMIT

SHARONVILLE CONVENTION CENTER EXPANSION
CITY OF SHARONVILLE
11355 CHESTER RD., CINCINNATI OH 45246
MECHANICAL PIPING THIRD LEVEL PLAN - 4

SCALE: AS NOTED
HORIZ: _____
VERT: _____
CONTRACT NO. 180634
SHEET M-2.44

KLH JOB # 21108.00

MECHANICAL PIPING ROOF PLAN - 4A
 M-2-54A 1/8" = 1'-0"

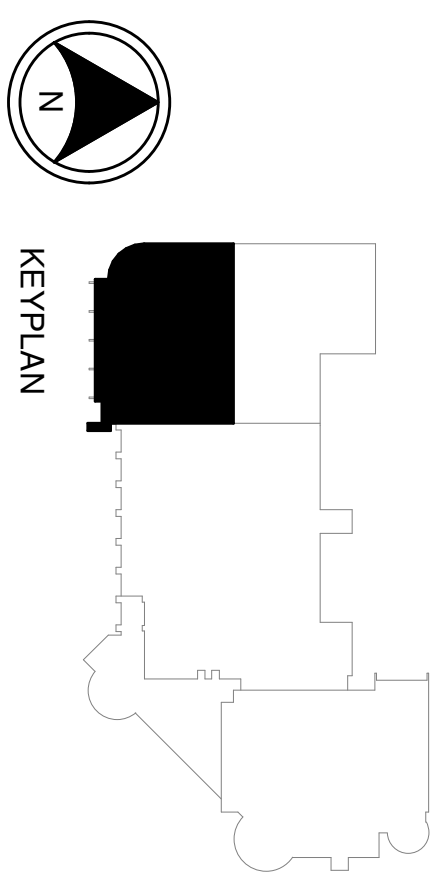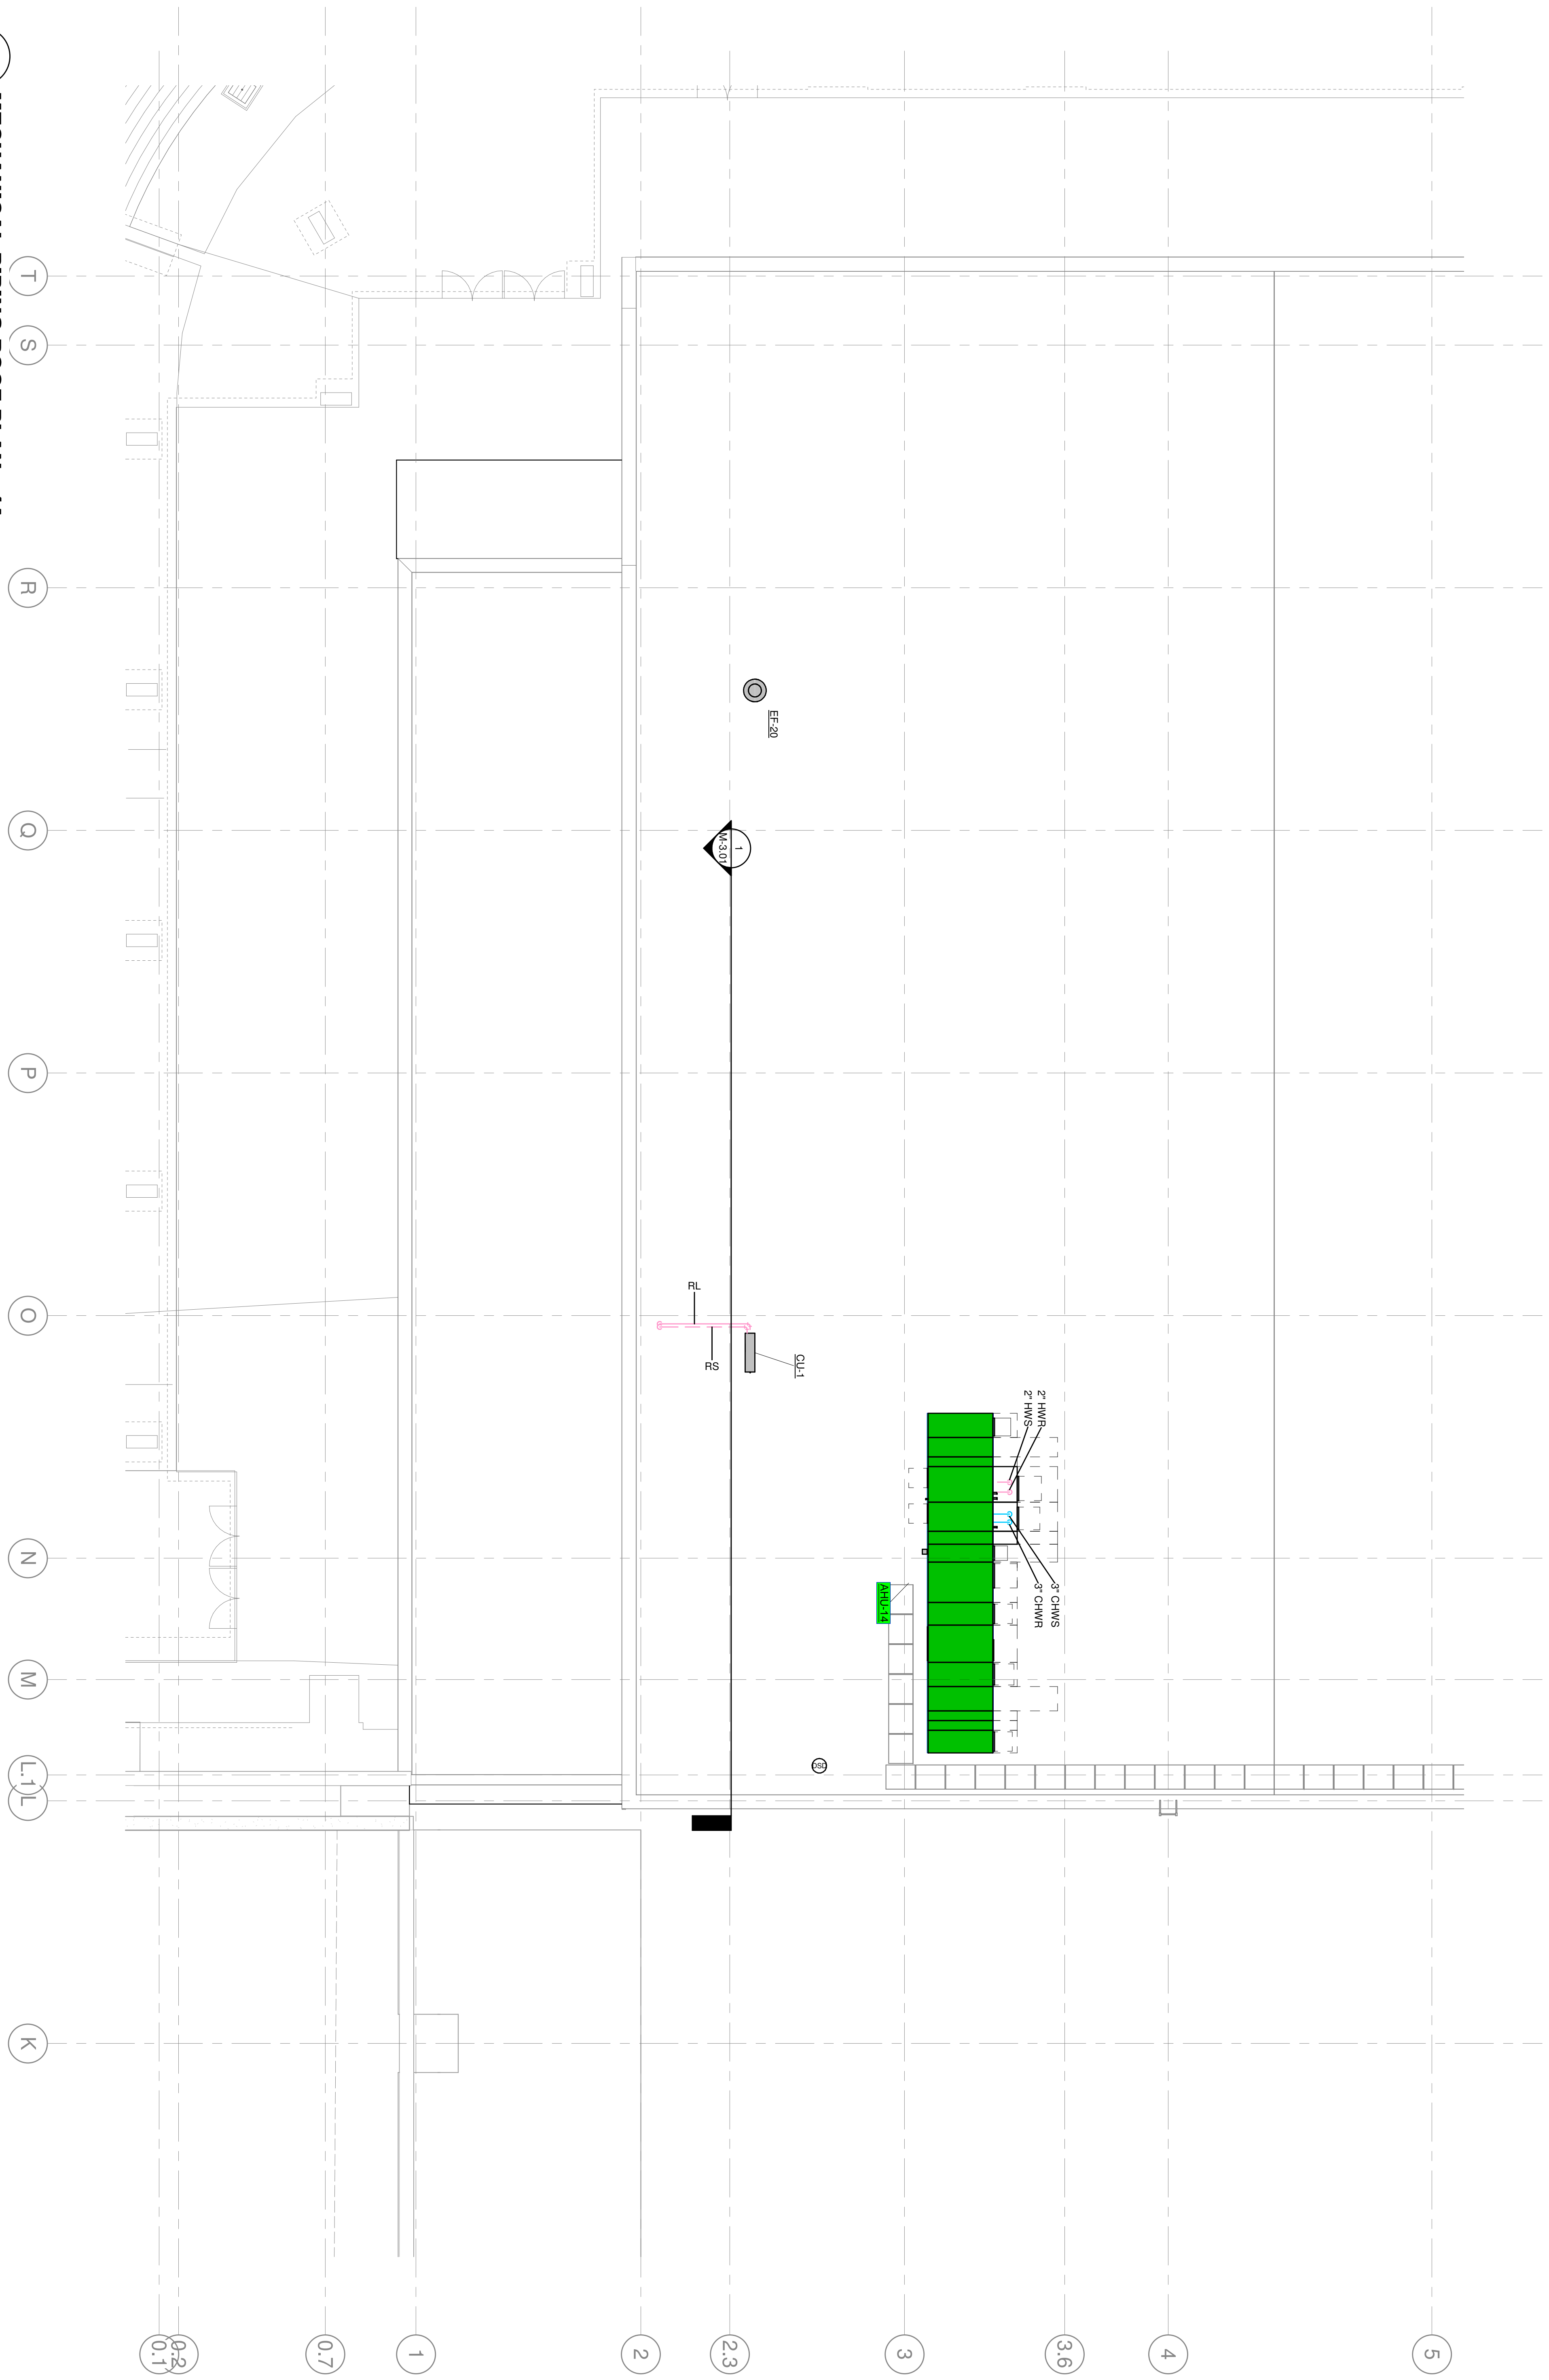

M-2-54A SHEET

SHARONVILLE CONVENTION CENTER EXPANSION
 CITY OF SHARONVILLE
 11355 CHESTER RD, CINCINNATI OH 45246
MECHANICAL PIPING ROOF PLAN - 4A


REV	REVISIONS	DATE	BY
0	ISSUED FOR FINAL ESTIMATE	04-24-2020	CAM
1	ISSUED FOR BIDDING AND PERMIT	09-15-2021	CAM

DATE: 09/15/2021
 DRAWN BY: CDS
 CHECKED BY: KTS
 APPROVED BY: _____
 F.B. NO. PG. _____





EKLH ENGINEERS
 MECHANICAL/ELECTRICAL ENGINEERS
 WWW.KLHENGRS.COM

1538 ALEXANDRIA PIKE, SUITE 111
 FT. THOMAS, KENTUCKY 41075
 800-354-9783
 859-442-9050
 859-442-8058 FAX
 LEXINGTON, KENTUCKY
 COLUMBUS, OHIO
 NEW YORK, NEW YORK
 LOUISVILLE, KENTUCKY

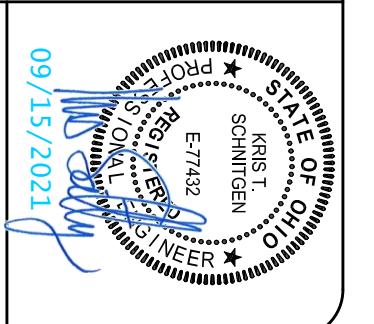

MECHANICAL PIPING ROOF PLAN - 4B

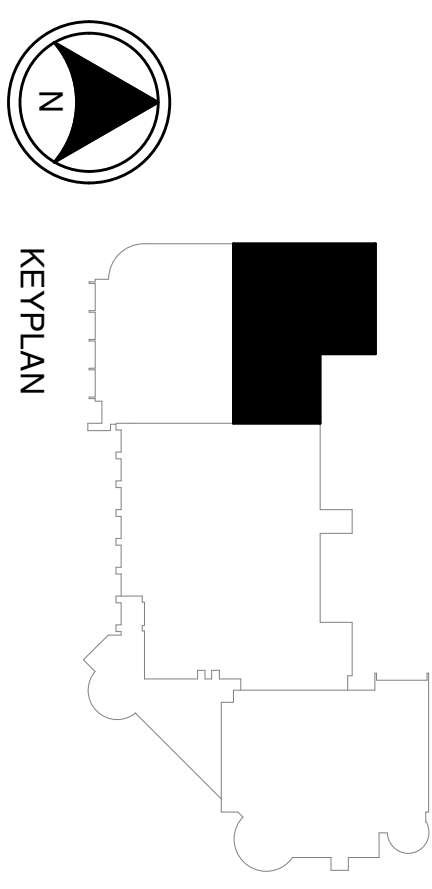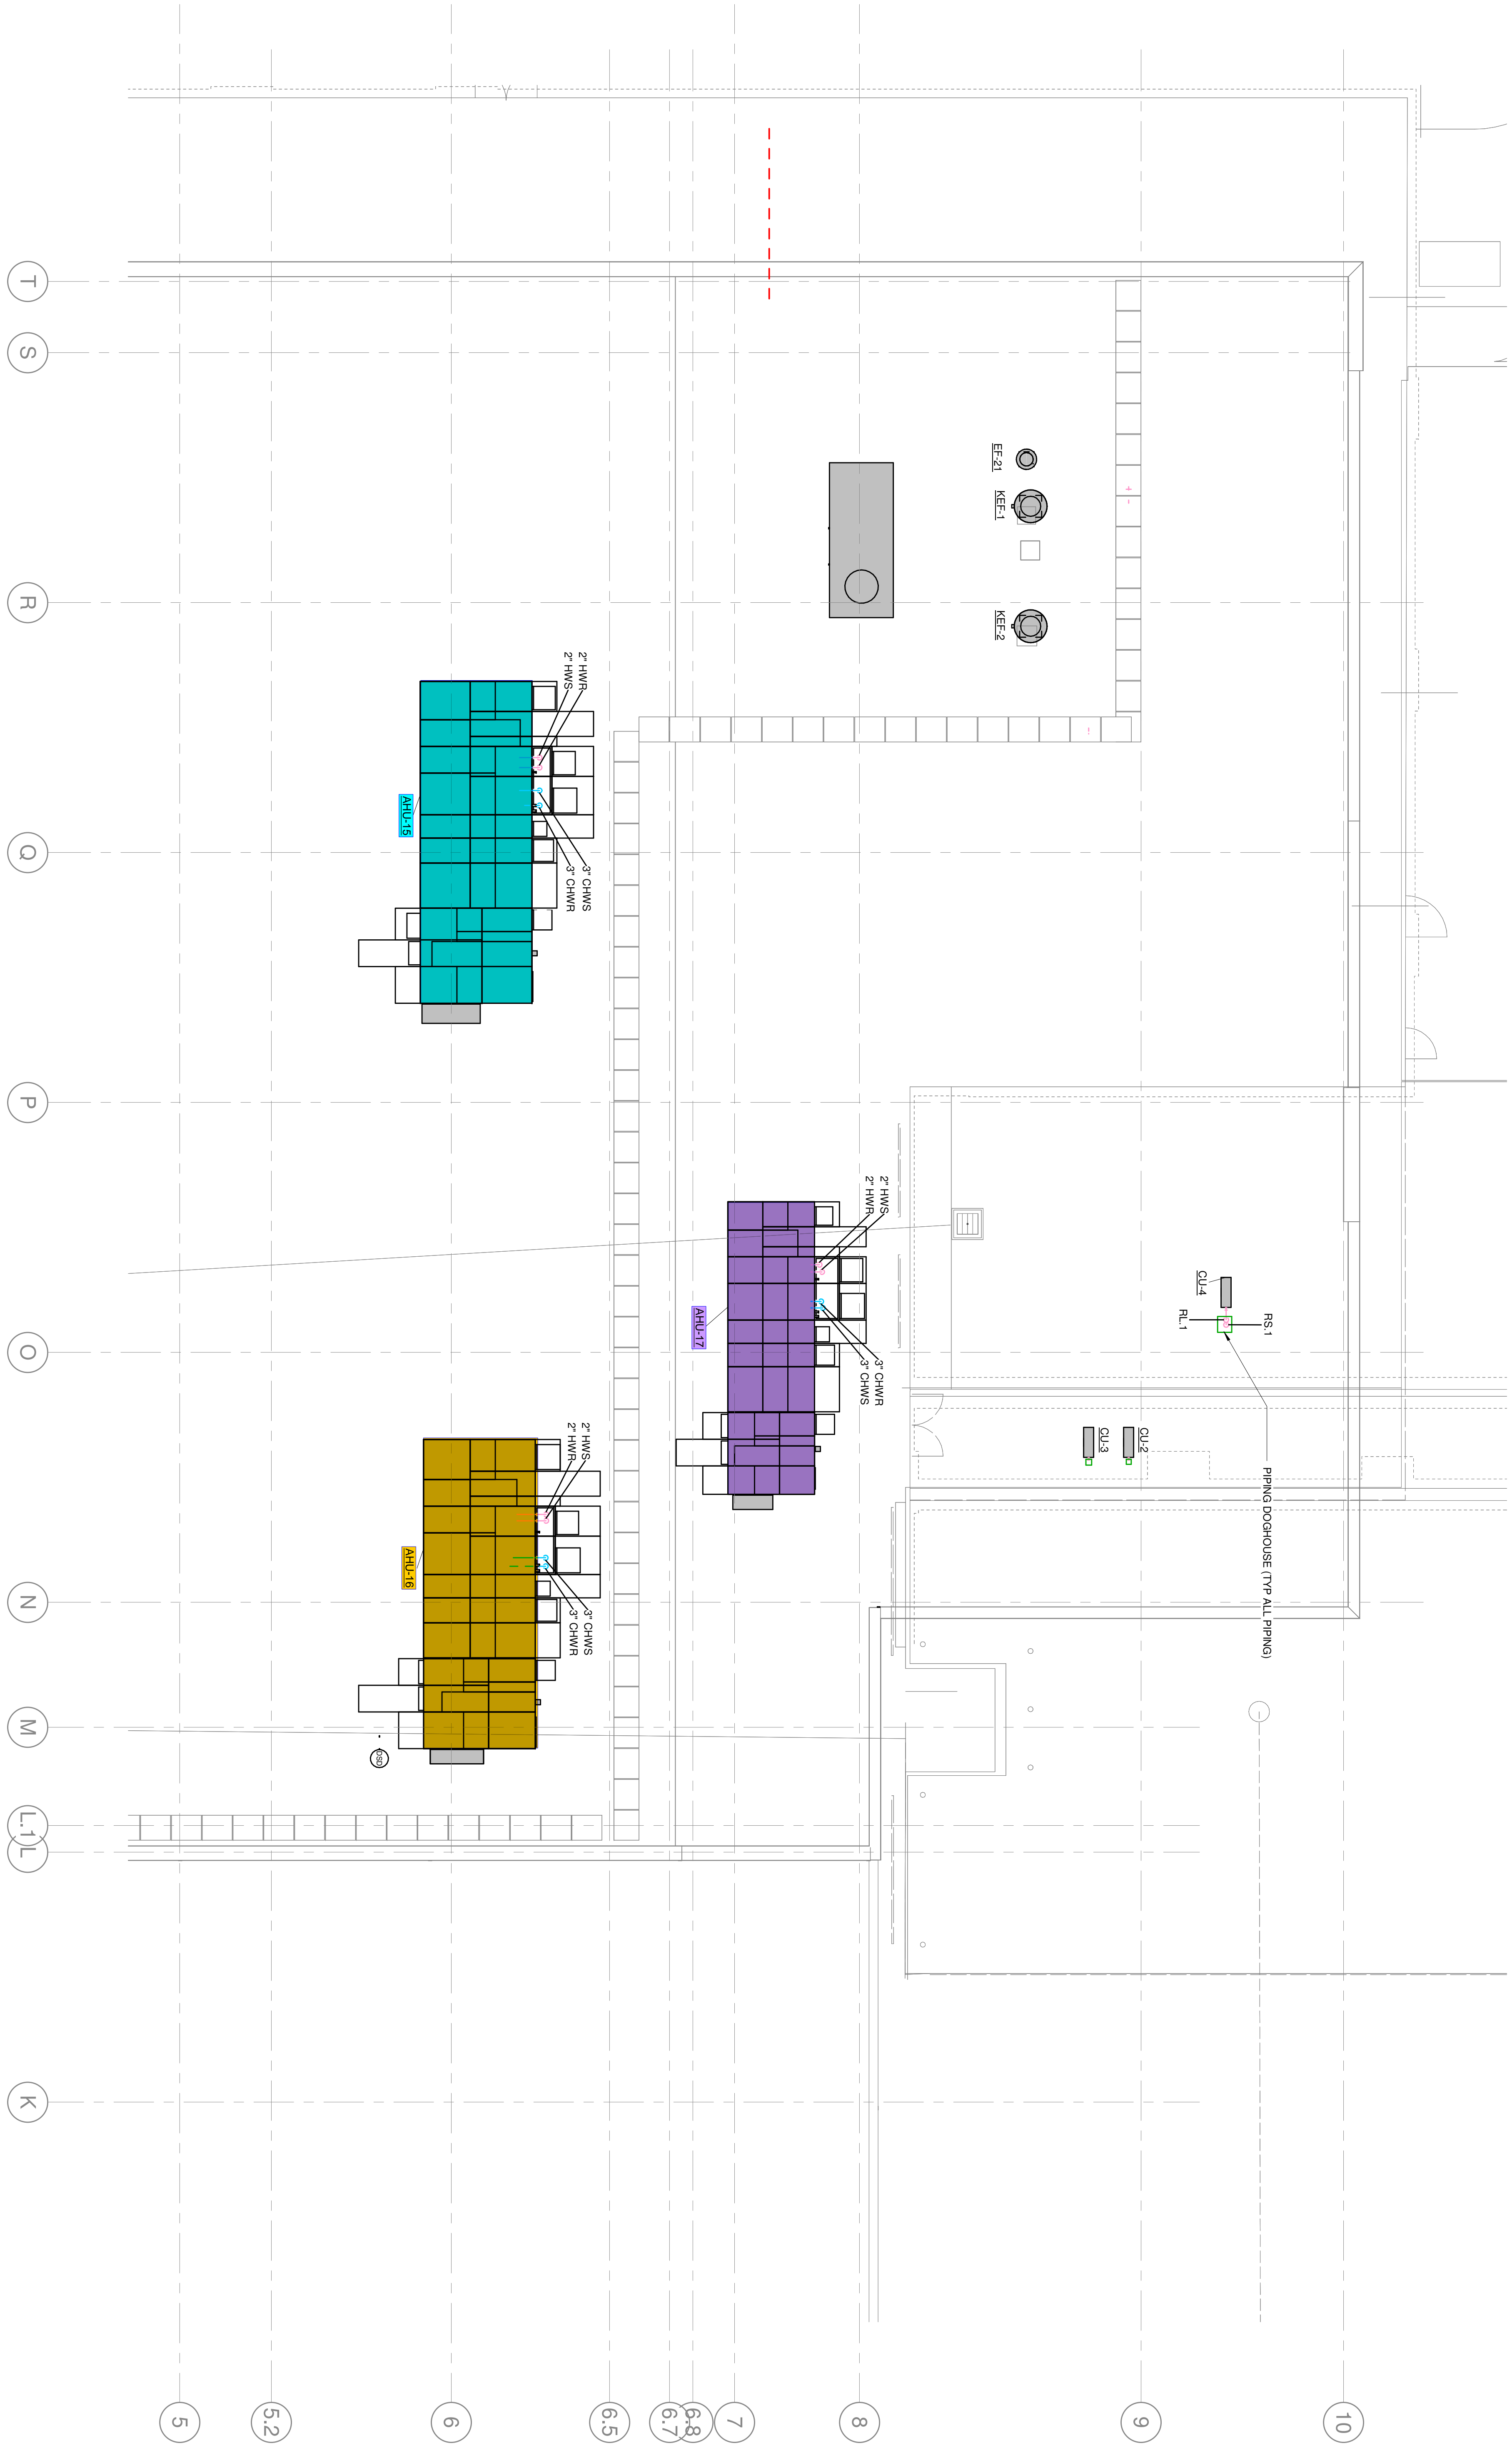

SHARONVILLE CONVENTION CENTER EXPANSION
 CITY OF SHARONVILLE
 11355 CHESTER RD, CINCINNATI OH 45246
 MECHANICAL PIPING ROOF PLAN - 4B

REV	REVISIONS	DATE	BY
0	ISSUED FOR FINAL ESTIMATE	04-24-2020	CAM
1	ISSUED FOR BIDDING AND PERMIT	09-15-2021	CAM

DATE: 09/15/2021
 DRAWN BY: DRS
 CHECKED BY: KTS
 APPROVED BY: PG
 F.B. NO.:



EKLH ENGINEERS
 MECHANICAL/ELECTRICAL ENGINEERS
 WWW.KLHENGRS.COM

1538 ALEXANDRIA PIKE, SUITE 111
 FT. THOMAS, KENTUCKY
 41075 800-354-9783
 859-442-9050
 859-442-8058 FAX
 LEXINGTON, KENTUCKY
 COLUMBUS, OHIO
 NEW YORK, NEW YORK
 LOUISVILLE, KENTUCKY

