

2 MECHANICAL DUCTWORK SECOND LEVEL PLAN - 4A
M-1.34A 3/16" = 1'-0"



1 MECHANICAL DUCTWORK SECOND LEVEL PLAN - 4A
M-1.34A 1/8" = 1'-0"




1535 BERNARD DRIVE SUITE 111
11 FT. THOMAS, KENTON, OH 41076
938-366-9793
899-442-8668 FAX
LEXINGTON, KENTUCKY
NEW YORK, NEW YORK
LOUISVILLE, KENTUCKY
SEKHL ENGINEERS
MECHANICAL/ELECTRICAL ENGINEERS
WWW.KLHEENRGS.COM

your trusted advisor
consultants
engineers
architects
planners



REV	DATE	BY	REVISIONS
1	04-24-2021	CLM	ISSUED FOR FINAL ESTIMATE AND PERMIT
2	09-15-2021	CLM	ISSUED FOR BIDDING AND PERMIT

SHARONVILLE CONVENTION CENTER EXPANSION
CITY OF SHARONVILLE
11355 CHESTER RD., CINCINNATI OH 45246
MECHANICAL DUCTWORK SECOND LEVEL PLAN - 4A
SCALE: AS NOTED
HORIZ: _____
VERT: _____
CONTRACT NO: 180634
SHEET M-1.34A
KLH JOB #: 21108.00

9/15/2021 1:24:43 PM

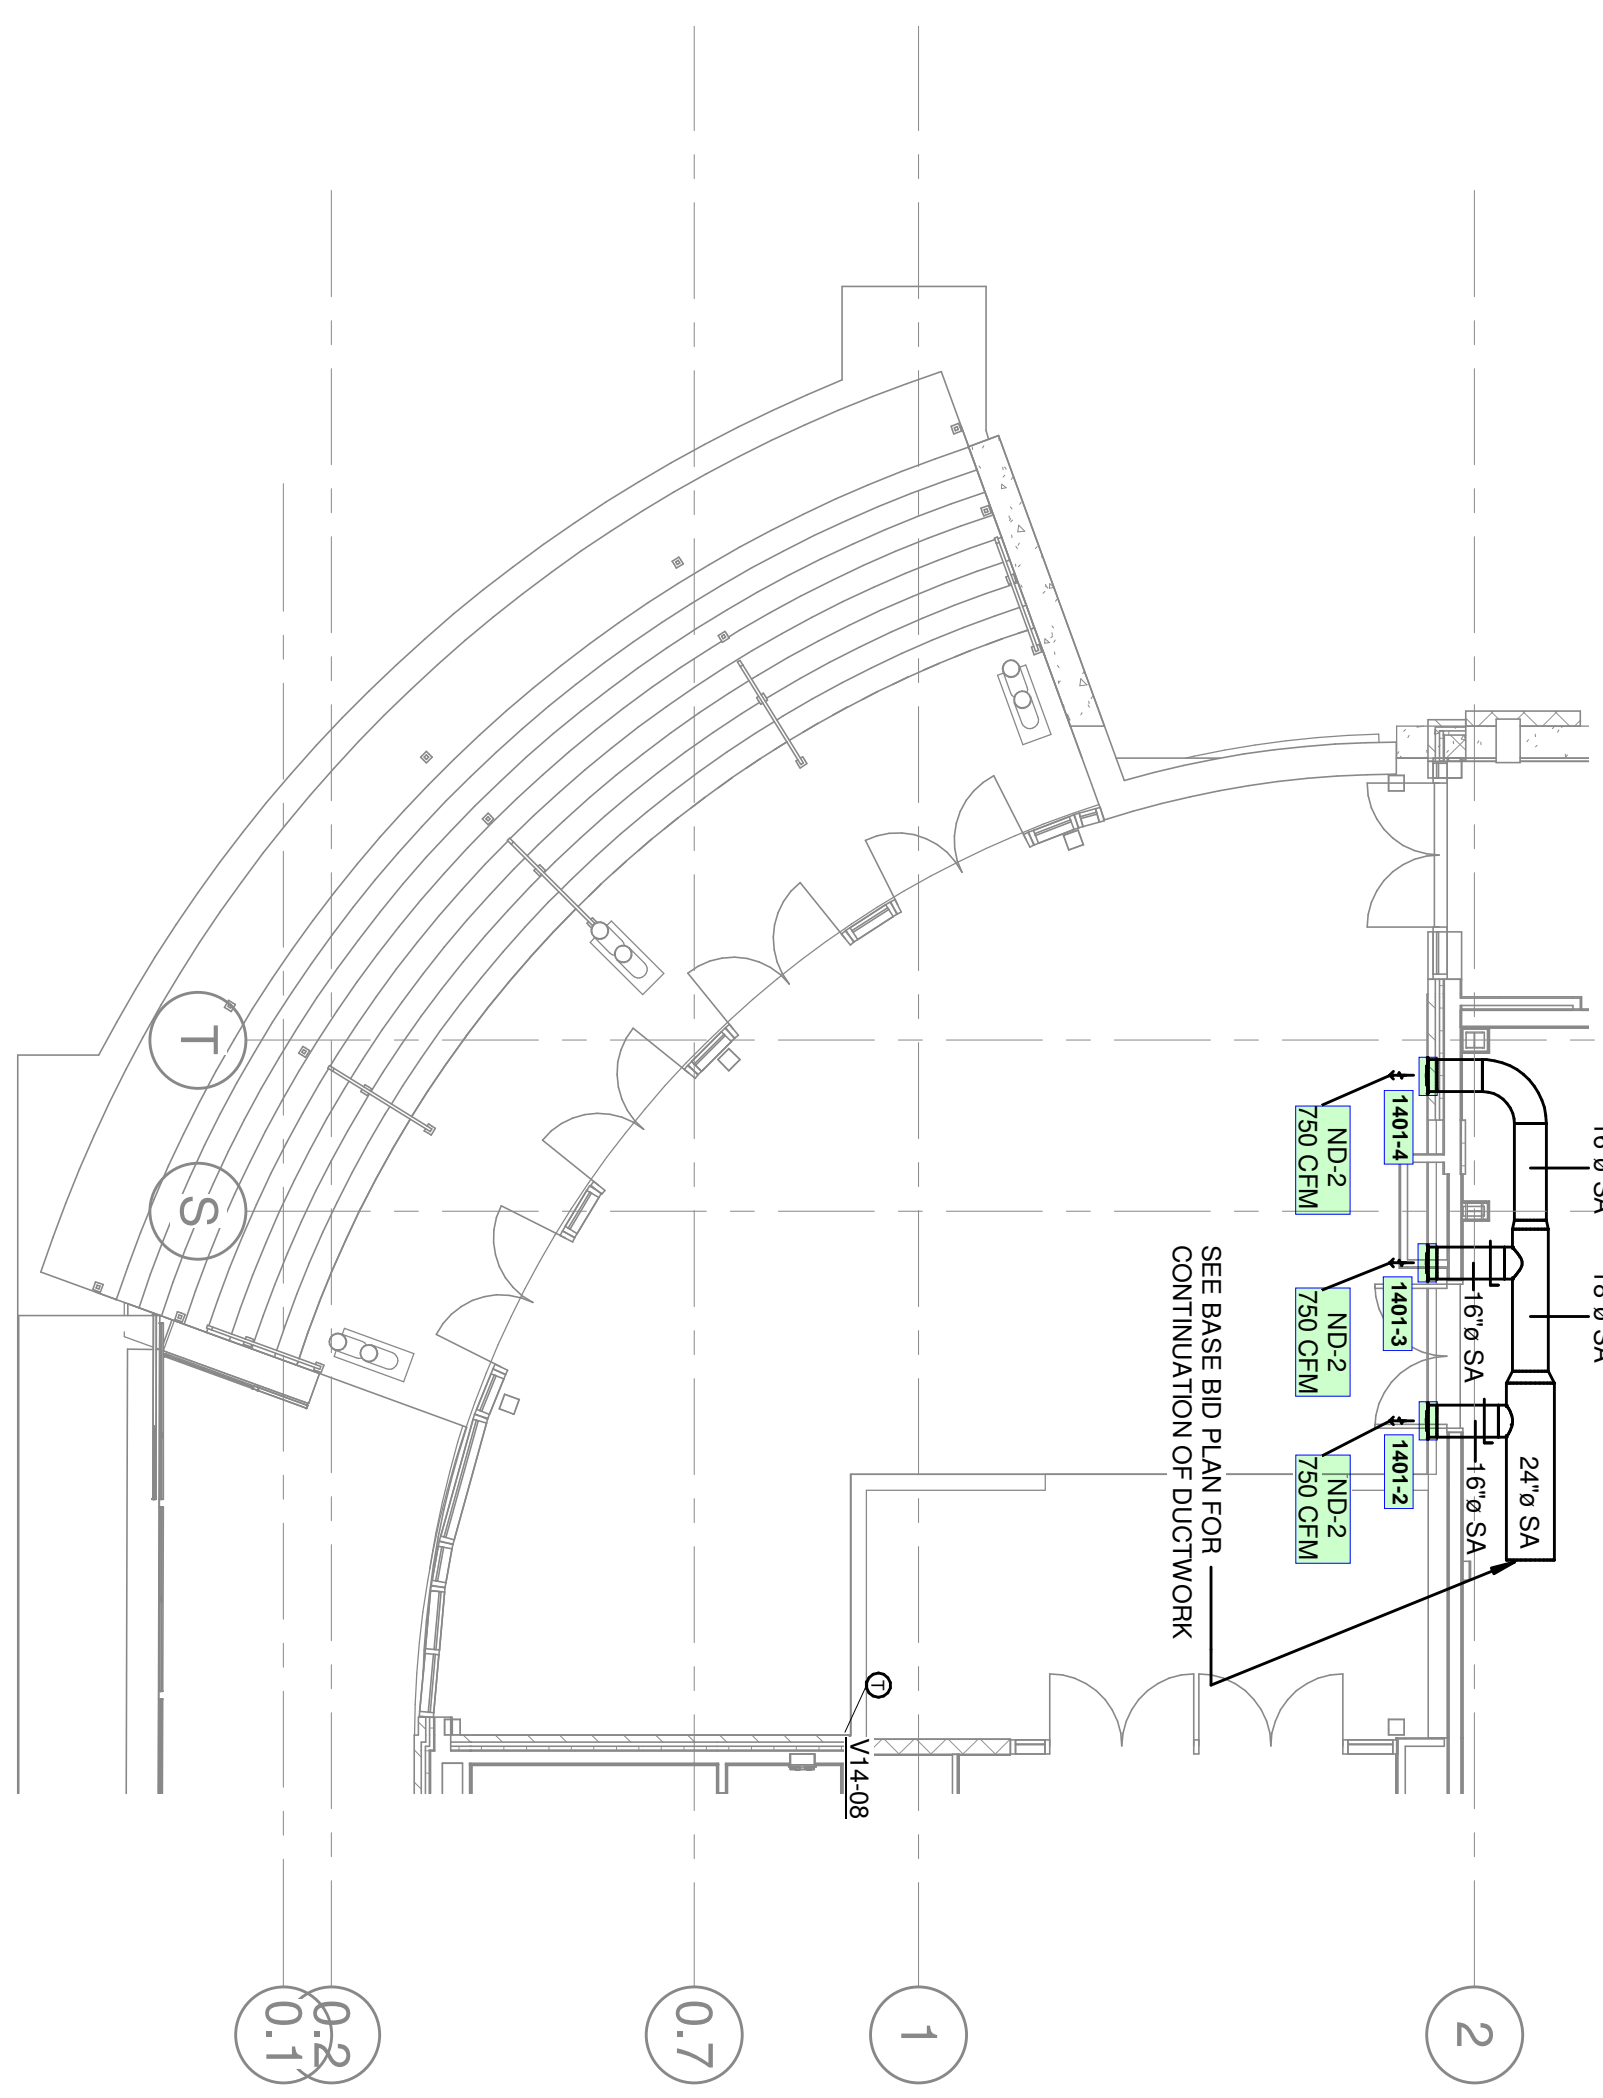

1
M-10.08 1/8" = 1'-0"
MECHANICAL DUCTWORK SECOND LEVEL PLAN - ALT 8

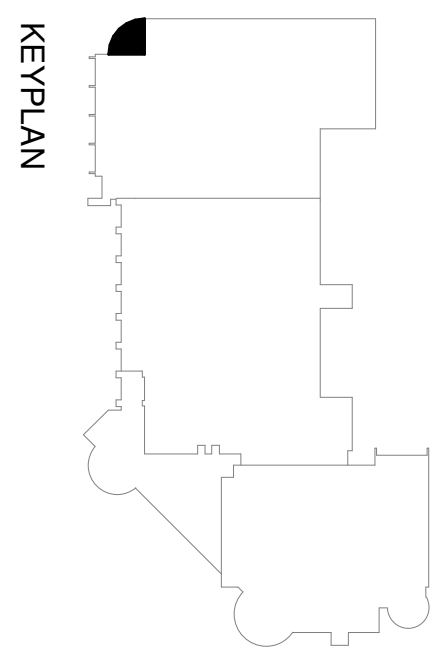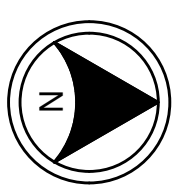



SHARONVILLE CONVENTION CENTER EXPANSION
 CITY OF SHARONVILLE
 11355 CHESTER RD, CINCINNATI OH 45246
MECHANICAL DUCTWORK PLAN - ALTERNATE 8

DATE:	09-15-2021	REV	REVISIONS	DATE	BY
DRAWN BY:	ERS	0	ISSUED FOR FINAL ESTIMATE	04-24-2020	CAM
CHECKED BY:	KTS	1	ISSUED FOR BIDDING AND PERMIT	09-15-2021	CAM
APPROVED BY:					
F.B. NO.	PG				





1538 ALEXANDRIA PIKE, SUITE 111
 FT. THOMAS, KENTUCKY 41075
 859-442-8050
 859-442-8058 FAX
 LEXINGTON, KENTUCKY
 COLUMBUS, OHIO
 NEW YORK, NEW YORK
 LOUISVILLE, KENTUCKY

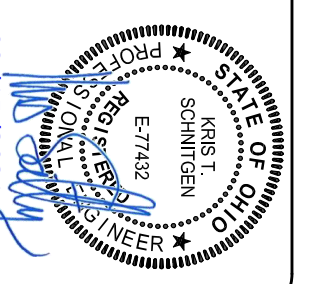


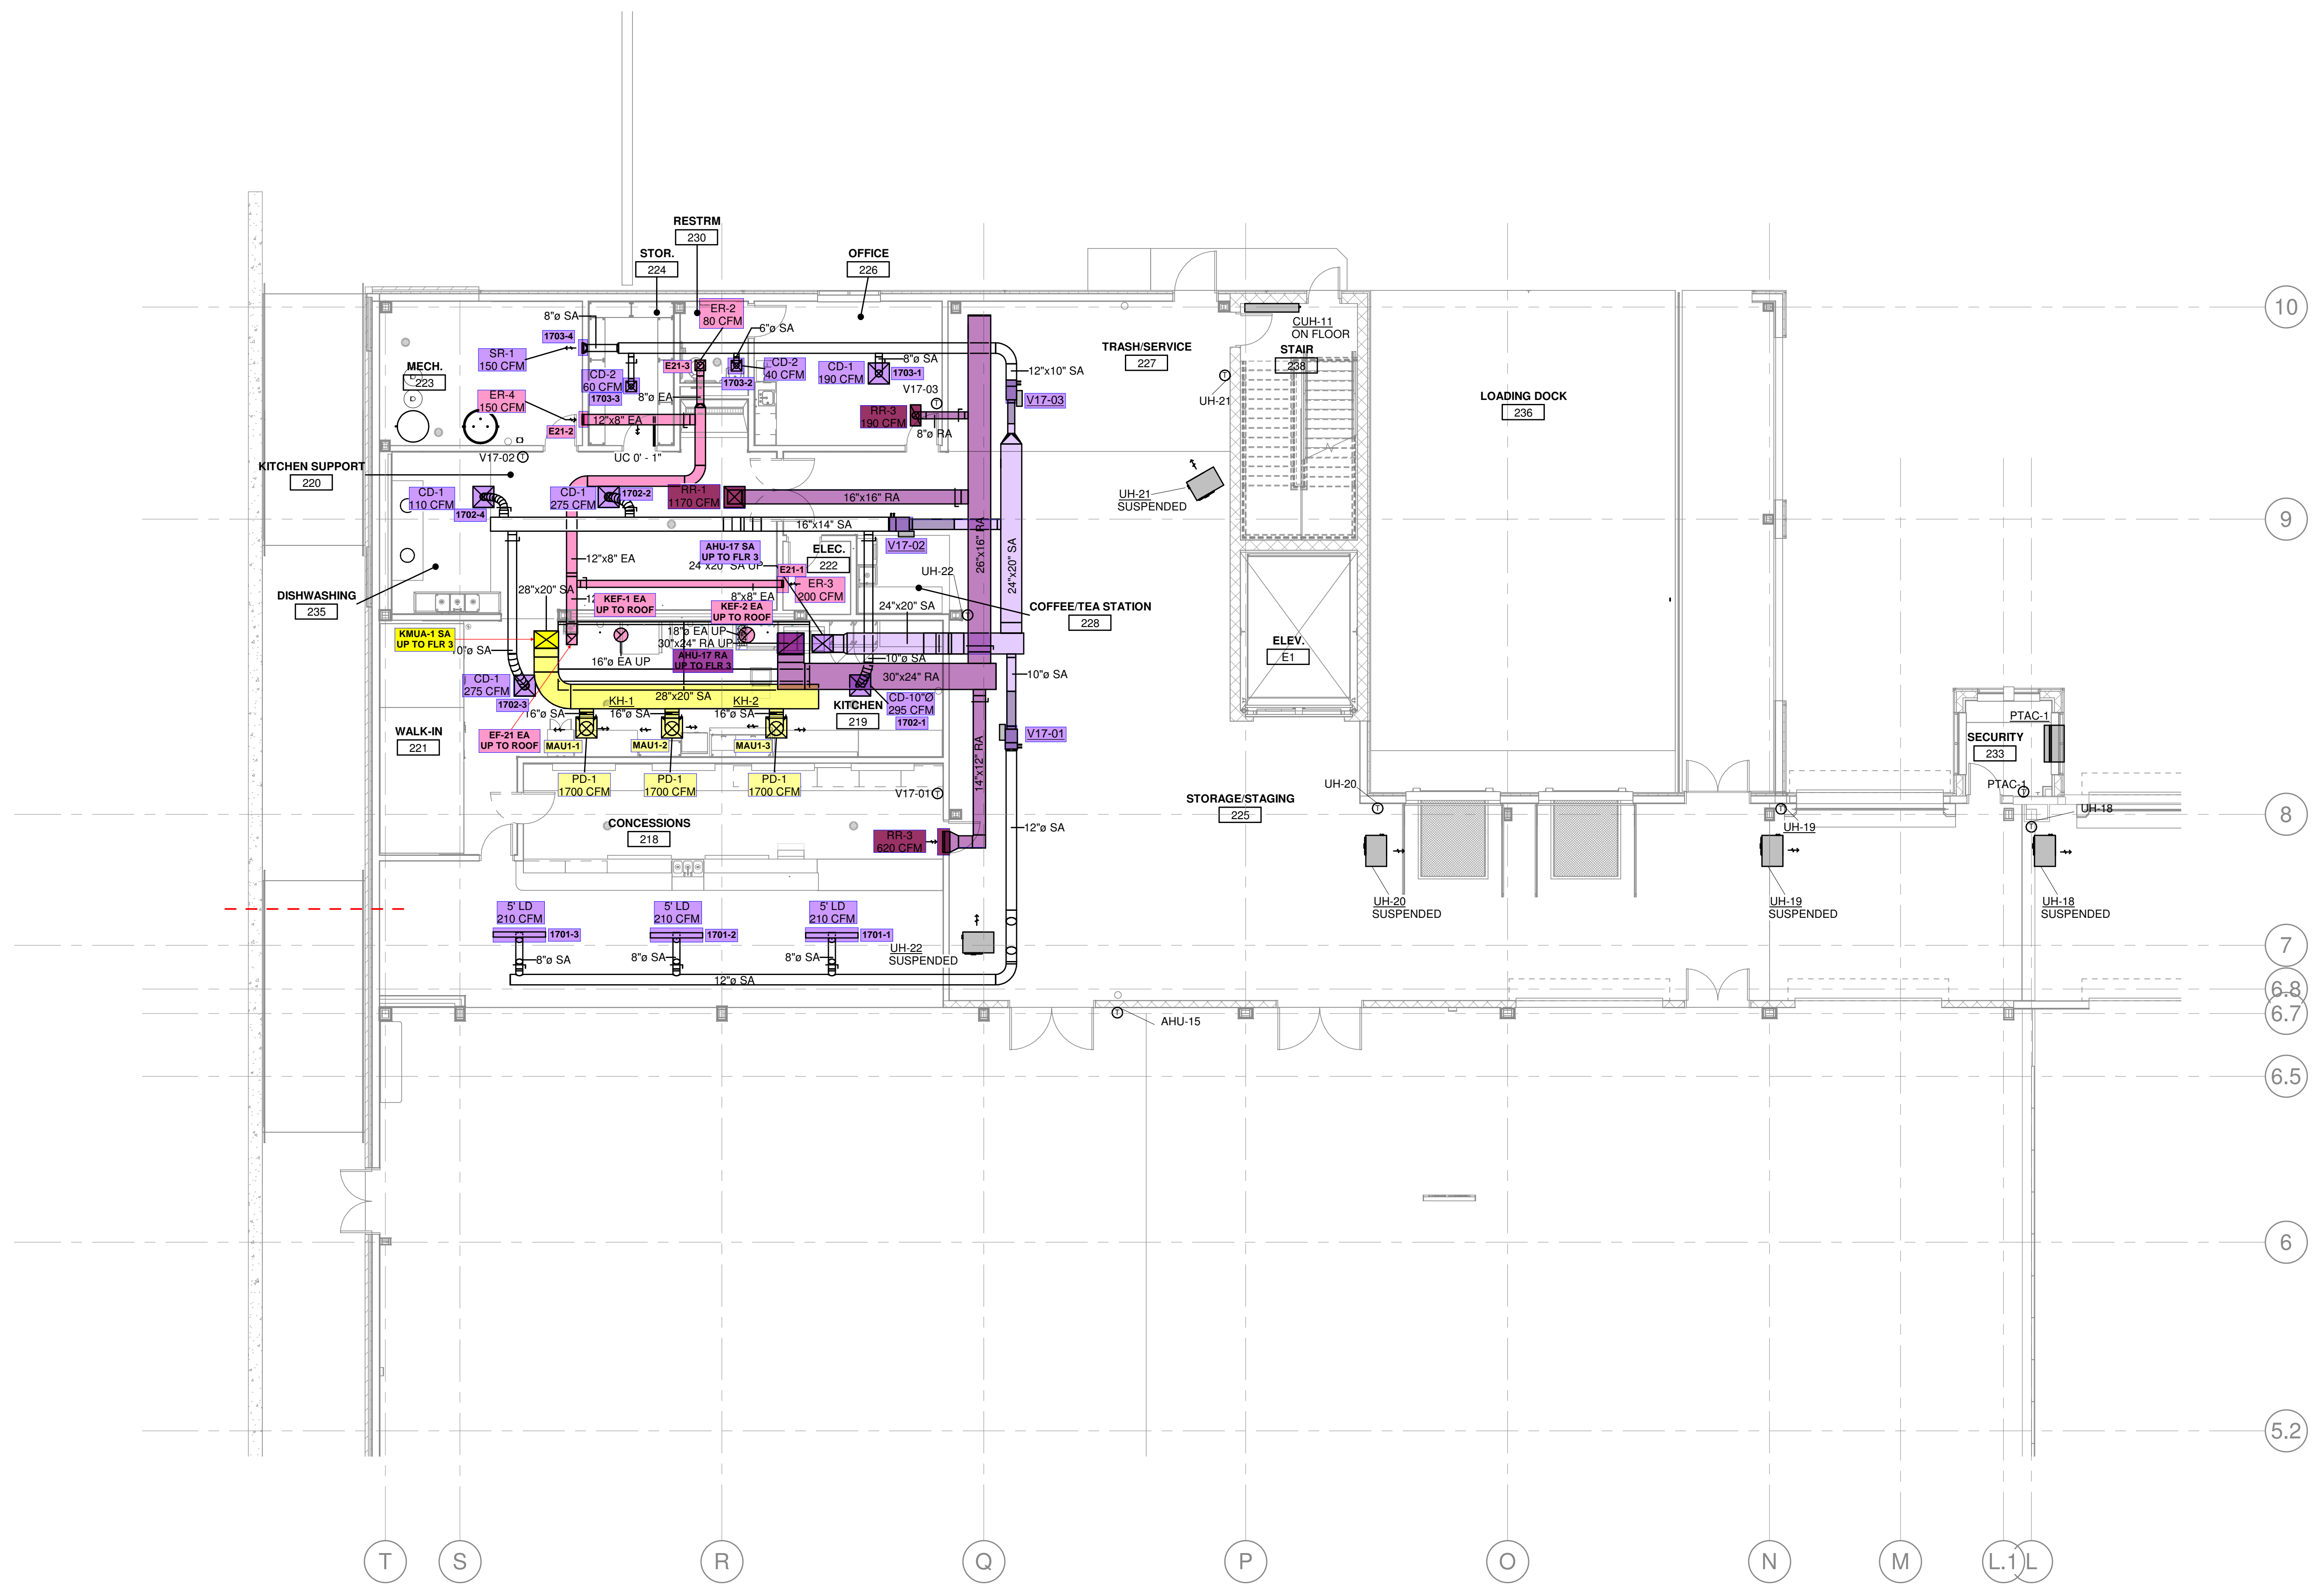

1
M-1.34B 1/8" = 1'-0"

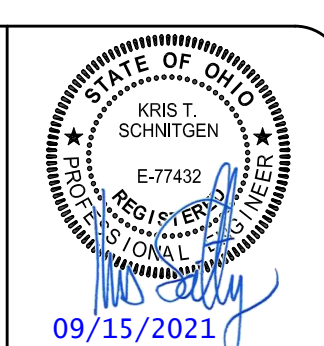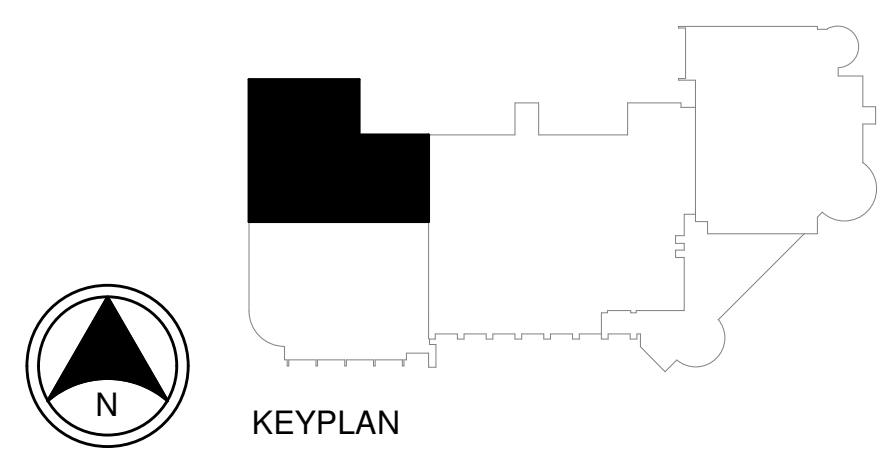

1539 ALEXANDRIA PIKE SUITE 111
LEWINGTON, KY 40346
859-442-8608 FAX
LEWINGTON, KENTUCKY
NEW YORK, NEW YORK
LOUISVILLE, KENTUCKY

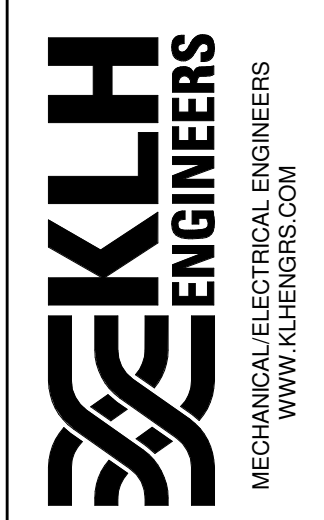

your trusted advisor
consultants
engineers
architects
planners

REV	DATE	BY	REVISIONS
1	09-15-2021	CAW	ISSUED FOR FINAL ESTIMATE
2	09-15-2021	CAW	REVISED FOR BIDDING AND PERMIT


SHARONVILLE CONVENTION CENTER EXPANSION
CITY OF SHARONVILLE
11365 CHESTER RD, CINCINNATI OH 45246
MECHANICAL DUCTWORK SECOND LEVEL PLAN -
4B

SCALE: AS NOTED
HORIZ: _____
VERT: _____
CONTRACT NO: 180634
SHEET
M-1.34B


9/15/2021 1:24:46 PM

RLH JOB #: 21108.00

9/15/2021 1:26:09 PM

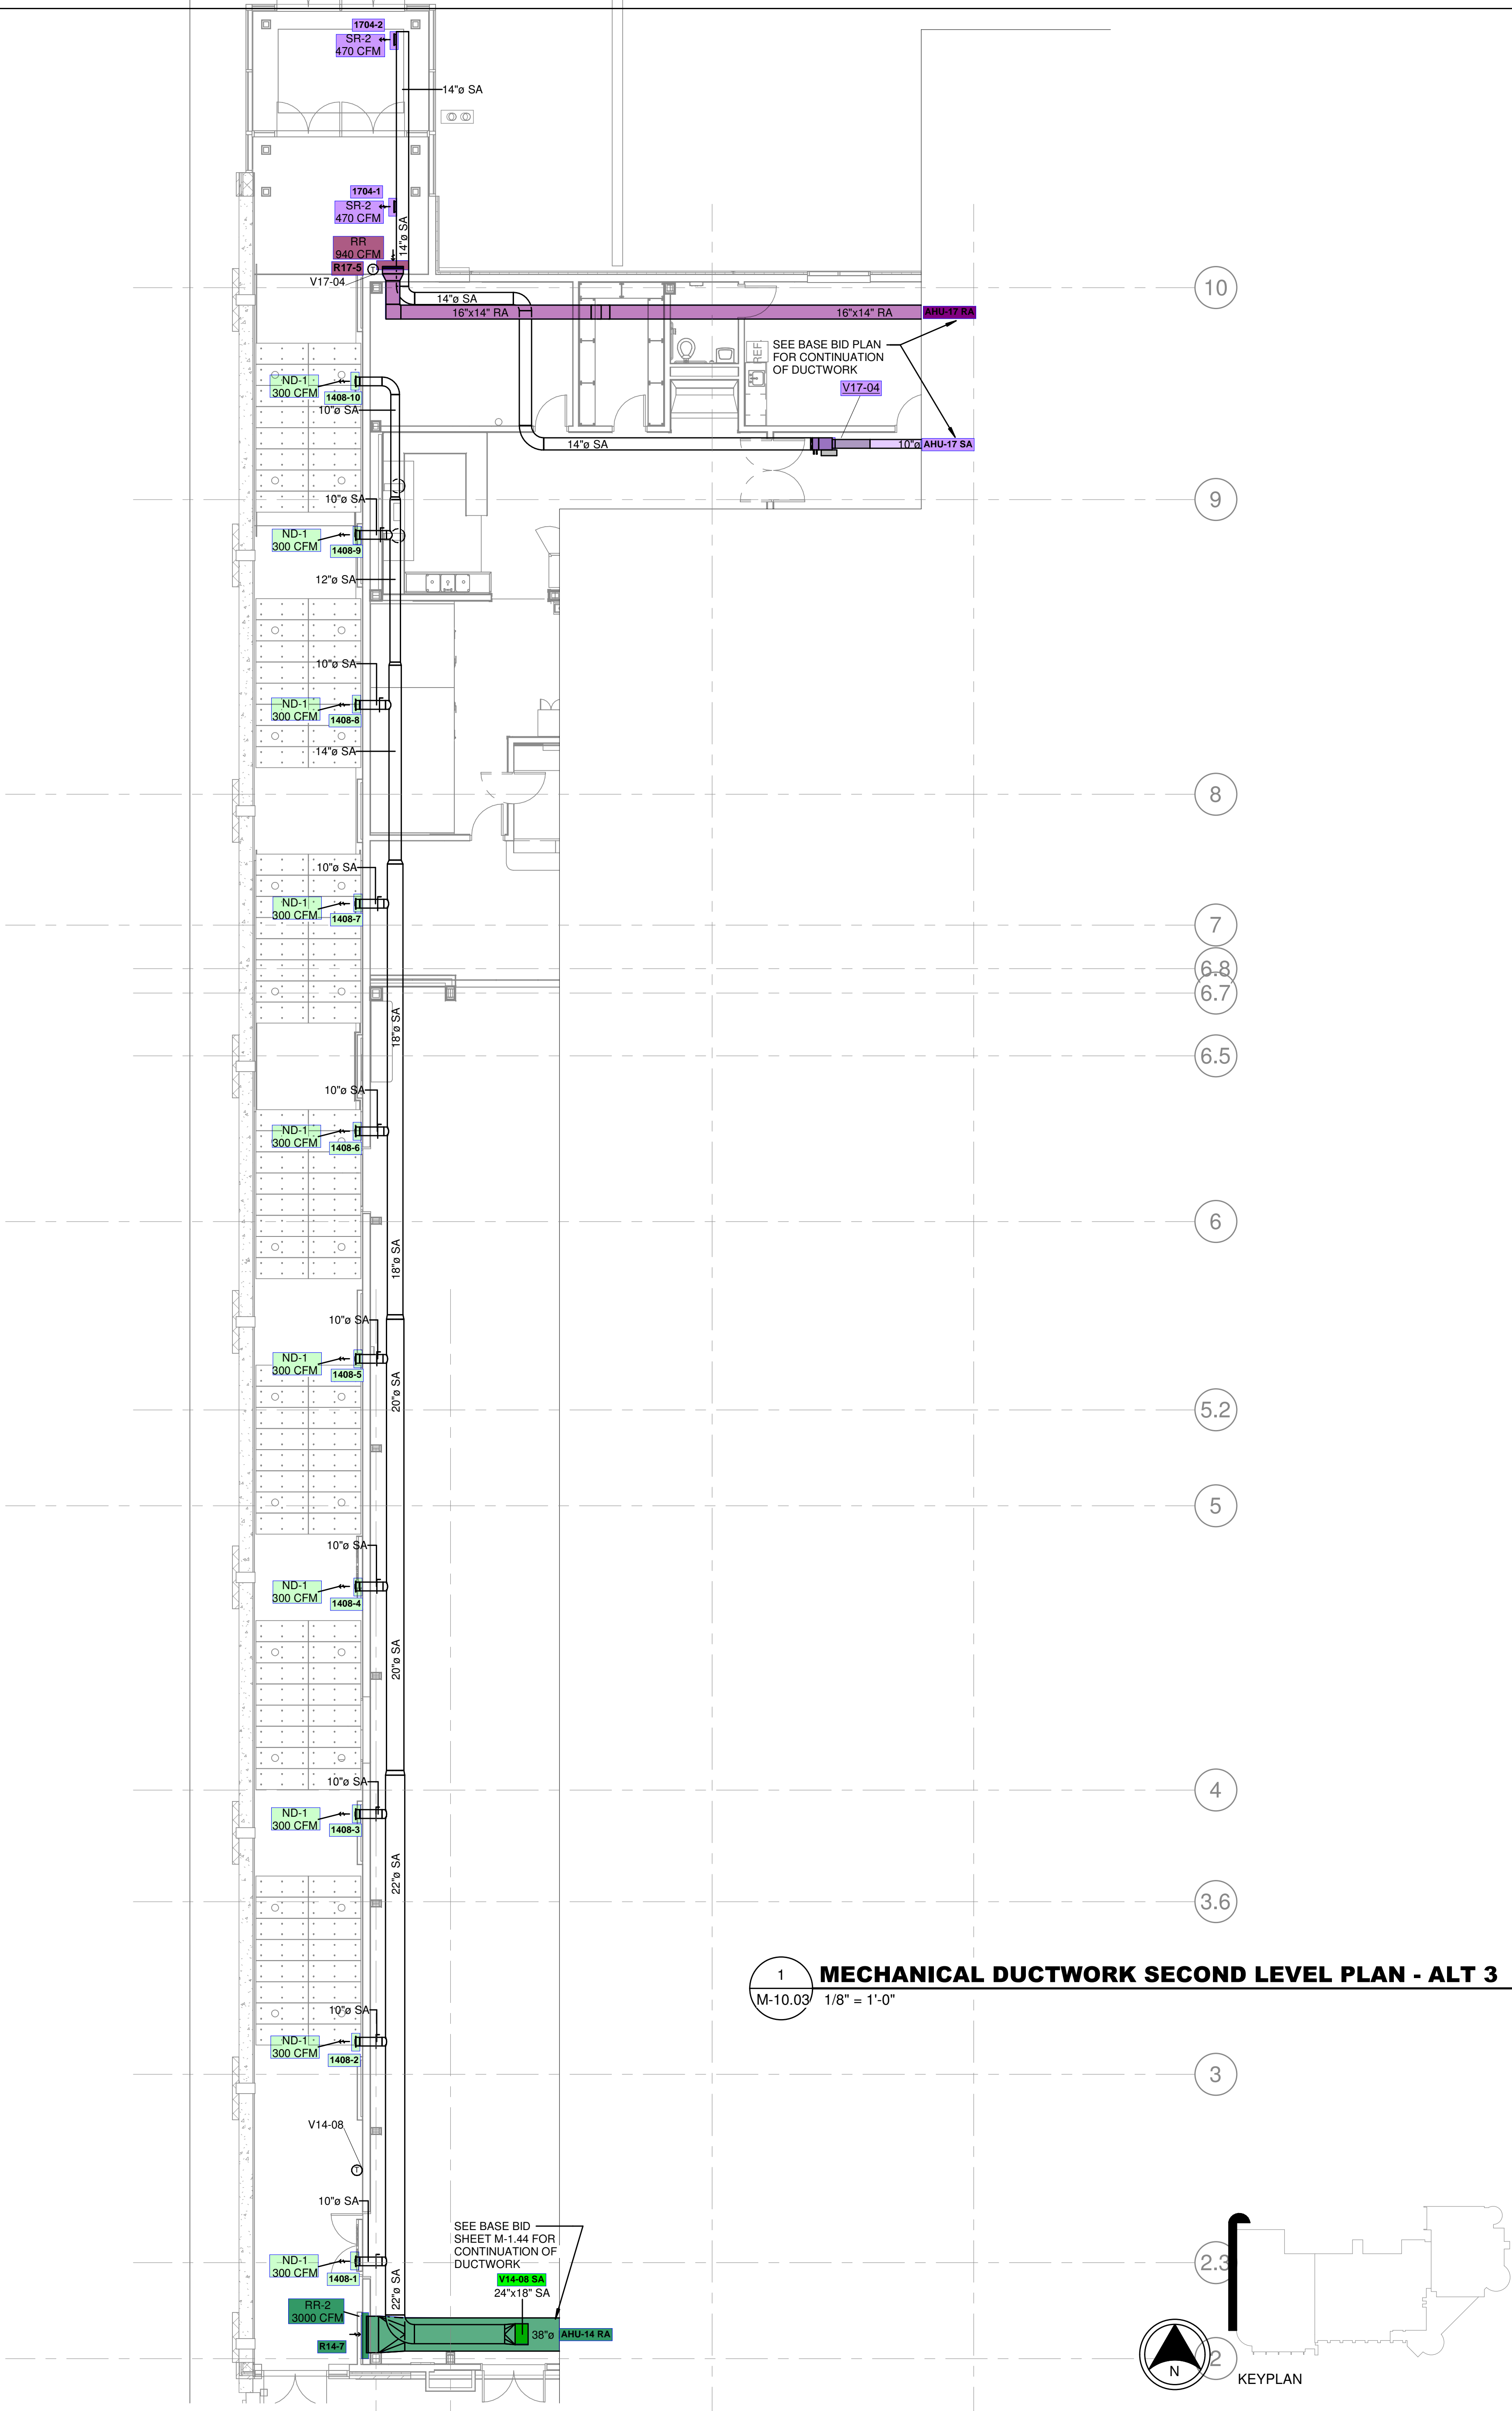

1 MECHANICAL DUCTWORK SECOND LEVEL PLAN - ALT 3
 M-10.03 1/8" = 1'-0"

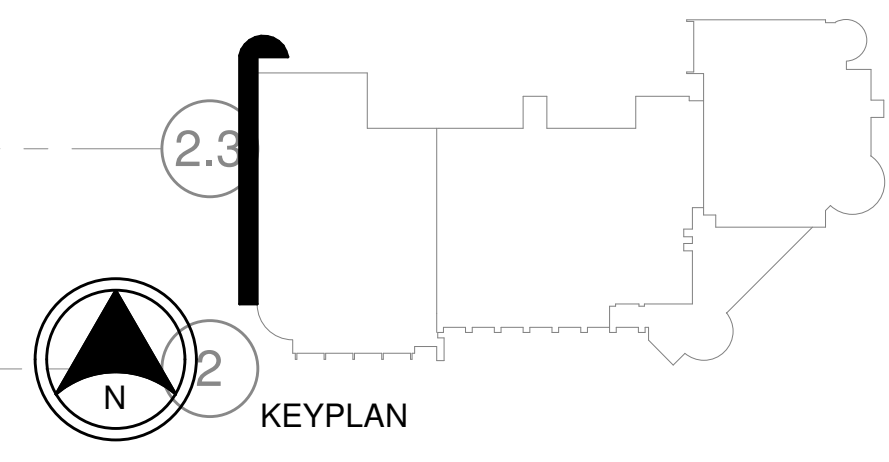

09/15/2021

1539 ALEXANDRIA PIKE SUITE 111
 LEXINGTON, KENTUCKY 40505-5427
 606-442-8900 FAX 606-442-8909
 WWW.VALENGERS.COM

MECHANICAL ELECTRICAL ENGINEERS
 WWW.VALENGERS.COM

your trusted advisor
consultants
 engineers
 architects
 planners

REV	DATE	BY	REVISIONS
0	09/15/2021	CSM	ISSUED FOR PERIODIC AND PERMIT


DATE: 09/15/2021
 DRAWN BY: CFS
 CHECKED BY: JTB
 APPROVED BY: [Signature]

F.B. NO. PD

SHARONVILLE CONVENTION CENTER EXPANSION
 CITY OF SHARONVILLE
 11355 CHESTER RD., CINCINNATI, OH 45246
 MECHANICAL DUCTWORK PLAN - ALTERNATE 3

SCALE: AS NOTED
 HORIZ: _____
 VERT: _____
 CONTRACT NO.: _____
 180634
 SHEET
 M-10.03


KLH JOB #: 21108.00

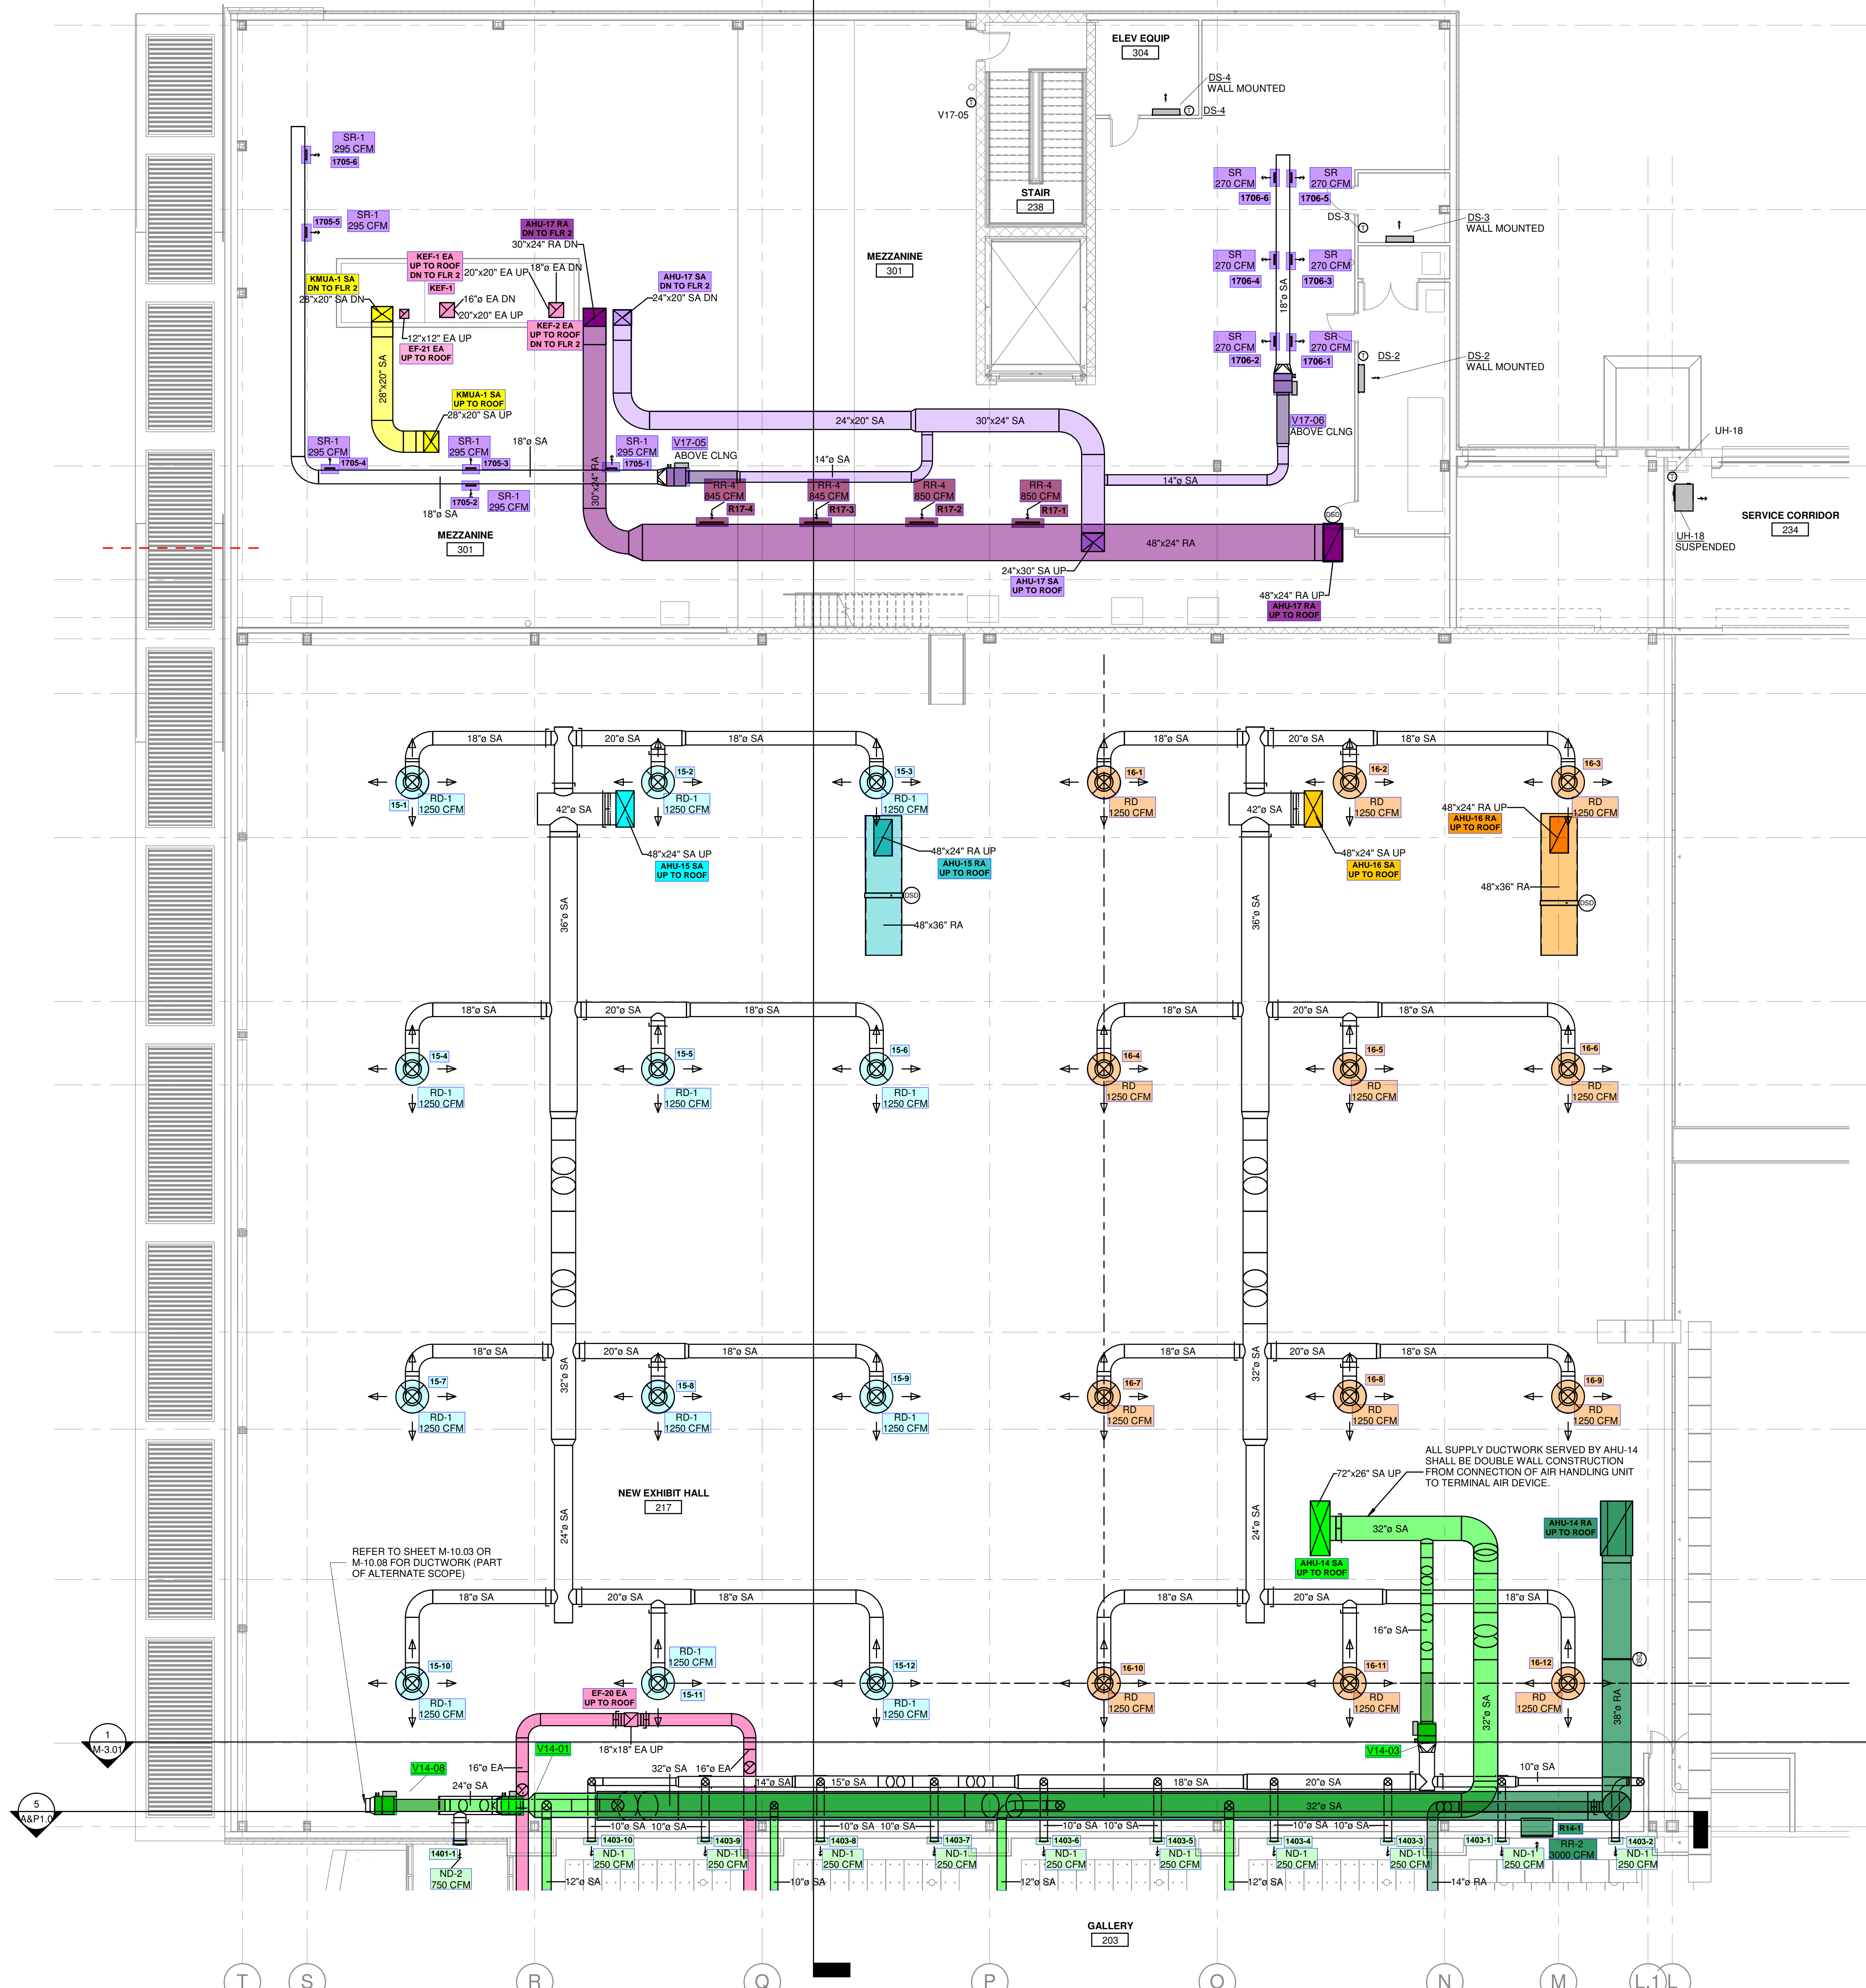

1 MECHANICAL DUCTWORK THIRD LEVEL PLAN - 4
M-1.44 1/8" = 1'-0"



USA EXPANSION, INC. 8110
117 THOMAS VENTURA
LEWISTON, KENTUCKY 40351
NEW YORK, NEW YORK
LOUISVILLE, KENTUCKY

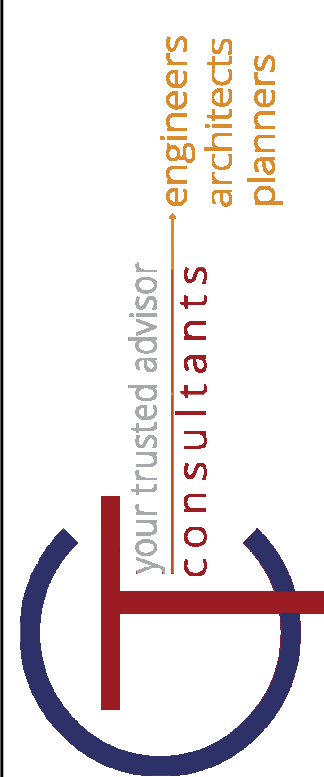

REV	DATE	BY	DATE	BY
1	04-24-2021	GAN	04-24-2021	GAN
2	05-18-2021	GAN	05-18-2021	GAN




SHARONVILLE CONVENTION CENTER EXPANSION
CITY OF SHARONVILLE
11355 CHESTER RD., CINCINNATI OH 45246
MECHANICAL DUCTWORK THIRD LEVEL PLAN - 4

SCALE: AS NOTED
HORIZ: _____
VERT: _____
CONTRACT NO: 180634
SHEET: M-1.44

9/15/2021 1:24:59 PM

KLH JOB #: 21108.00

M-1.54A / 1/8" = 1'-0"
MECHANICAL DUCTWORK ROOF PLAN - 4A

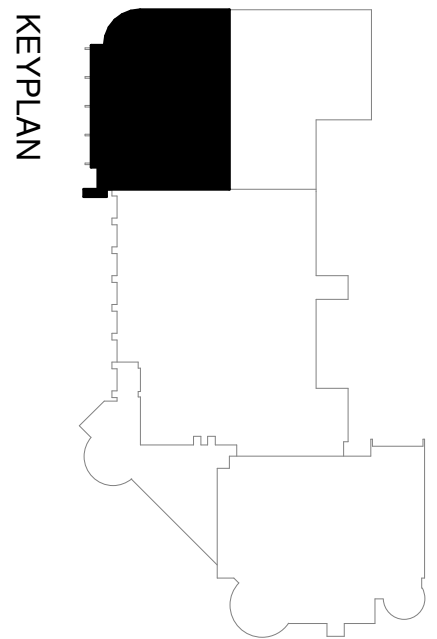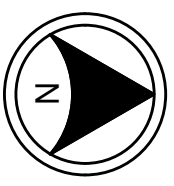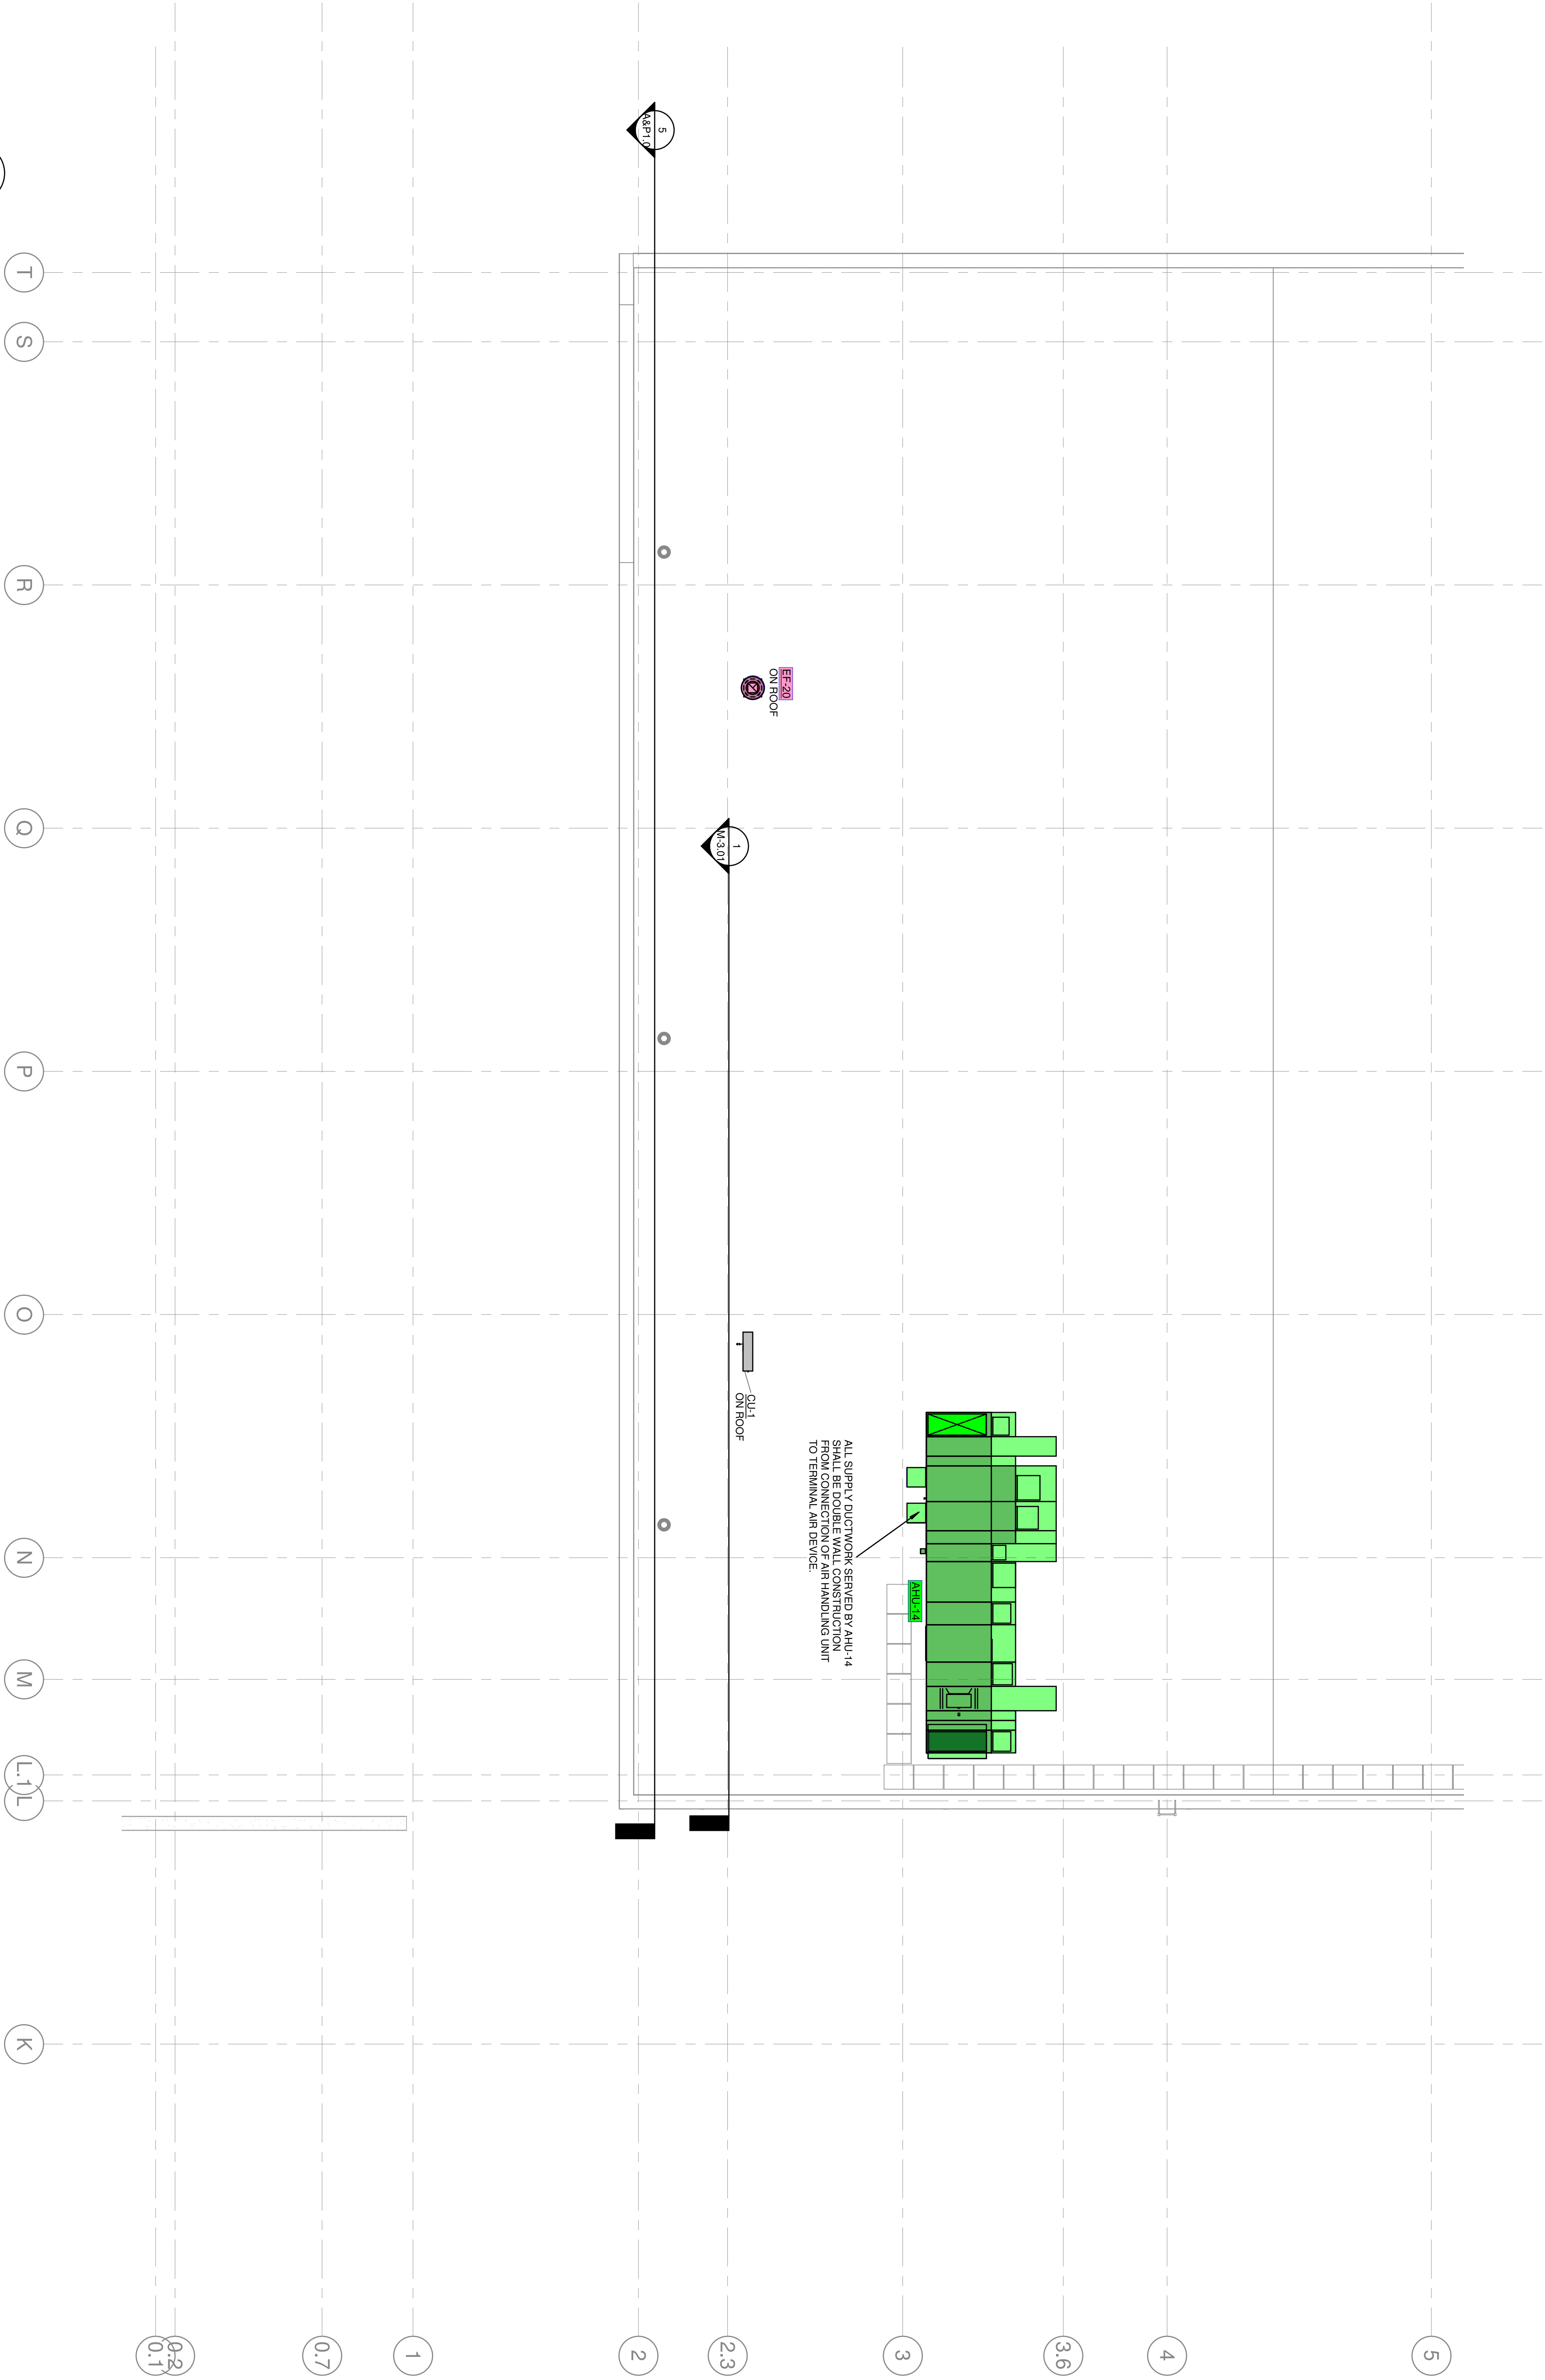


SHARONVILLE CONVENTION CENTER EXPANSION
 CITY OF SHARONVILLE
 11355 CHESTER RD, CINCINNATI OH 45246
MECHANICAL DUCTWORK ROOF PLAN - 4A

DATE	REV	REVISIONS	DATE	BY
09-15-2021	0	ISSUED FOR FINAL ESTIMATE	04-24-2020	CAM
	1	ISSUED FOR BIDDING AND PERMIT	09-15-2021	CAM




DRAWN BY: ERS
 CHECKED BY: KTS
 APPROVED BY: _____
 F.B. NO. PG. NO.



1538 ALEXANDRIA PIKE, SUITE 11
 11 FT. THOMAS, KENTUCKY
 41075 800-354-9783
 859-442-8050
 859-442-8058 FAX
 LEXINGTON, KENTUCKY
 COLUMBUS, OHIO
 NEW YORK, NEW YORK
 LOUISVILLE, KENTUCKY

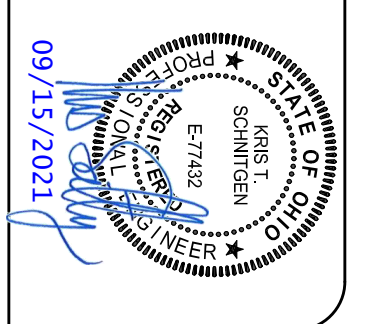

1
M-1.54B 1/8" = 1'-0"
MECHANICAL DUCTWORK ROOF PLAN - 4B

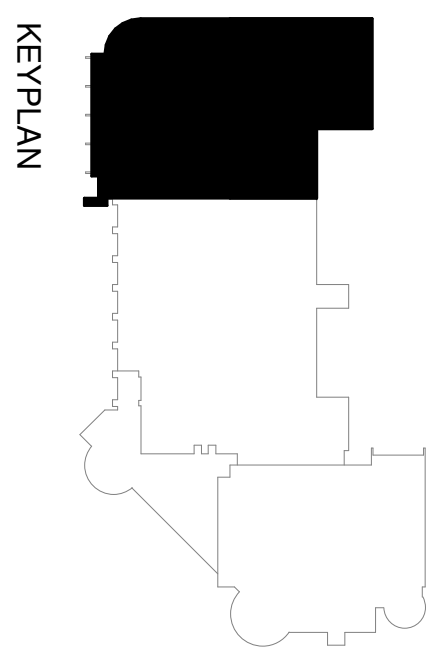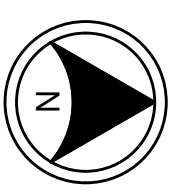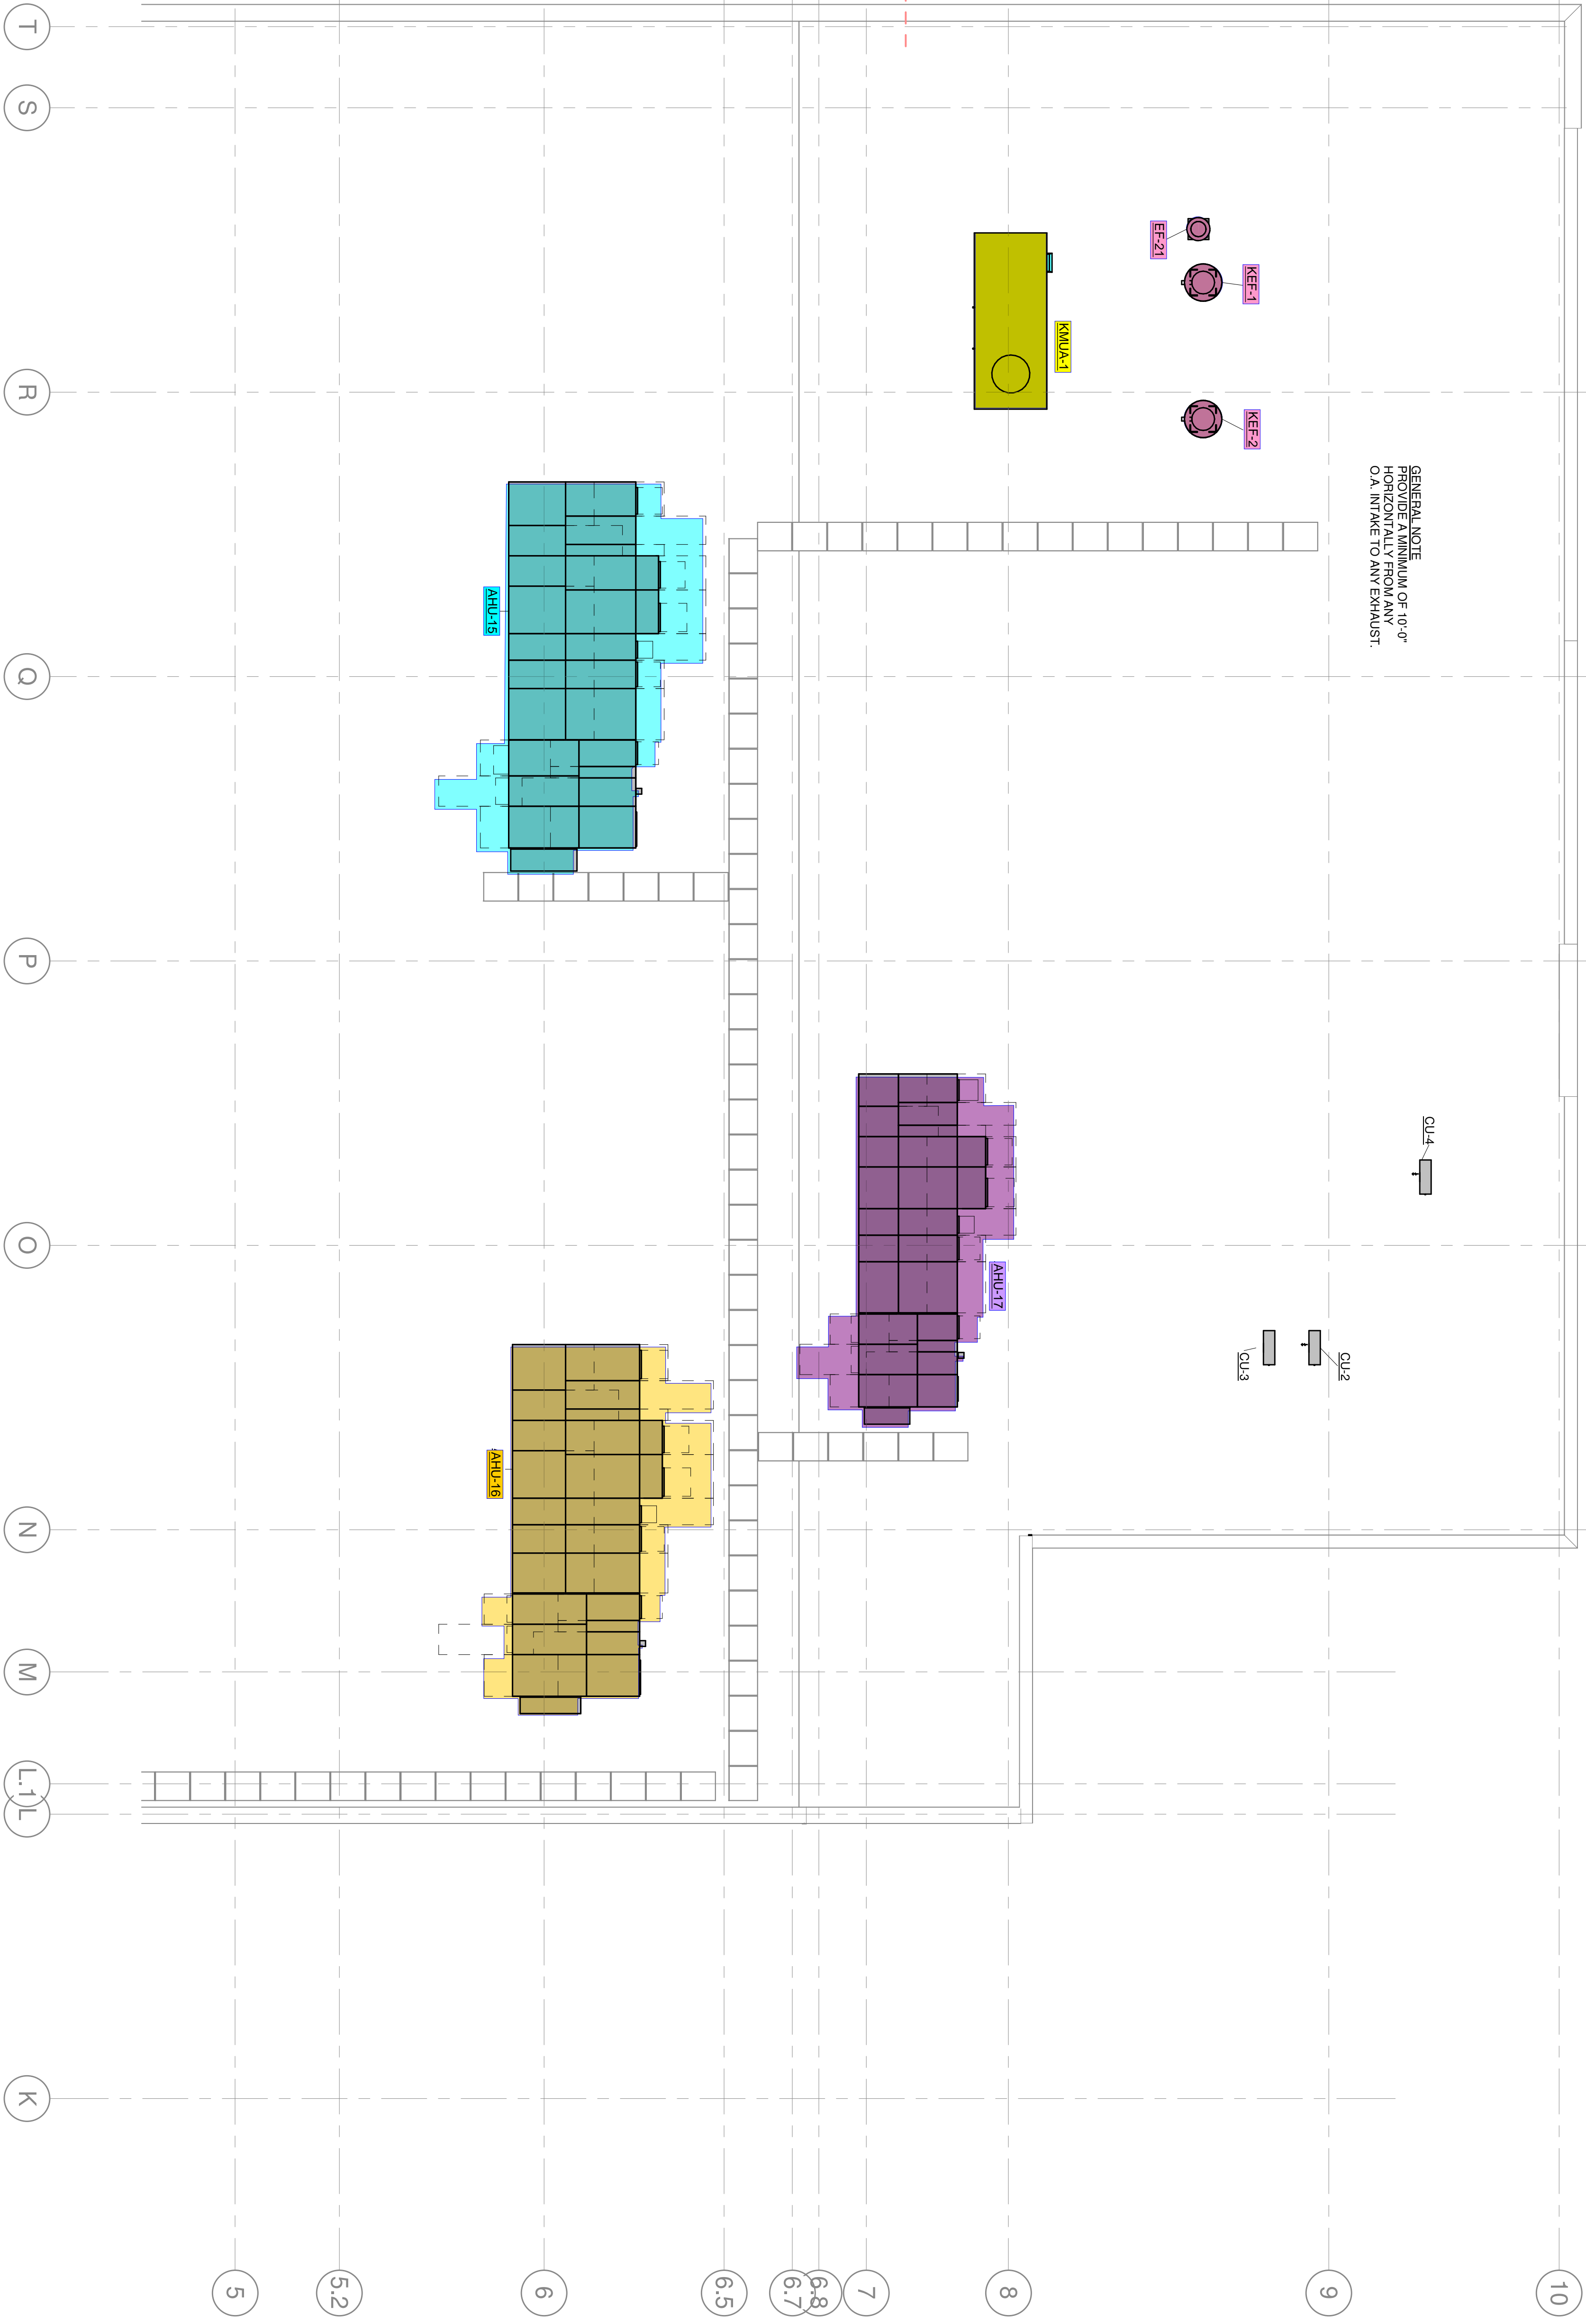

SHARONVILLE CONVENTION CENTER EXPANSION
CITY OF SHARONVILLE
11355 CHESTER RD, CINCINNATI OH 45246
MECHANICAL DUCTWORK ROOF PLAN - 4B

DATE:	REV	REVISIONS	DATE	BY
09/15/2021	0	ISSUED FOR FINAL ESTIMATE	04-24-2021	CAM
	1	ISSUED FOR BIDDING AND PERMIT	09-15-2021	CAM

DRAWN BY: DRS
CHECKED BY: KTS
APPROVED BY: _____
F.B. NO. PG. NO.



1539 ALEXANDRIA PIKE, SUITE 11
11 FT. THOMAS, KENTUCKY
41075 800-354-9783
859-442-8050
859-442-8058 FAX
LEXINGTON, KENTUCKY
COLUMBUS, OHIO
NEW YORK, NEW YORK
LOUISVILLE, KENTUCKY
WWW.KLENGRS.COM

