


1 HVAC DEMOLITION PLAN
 M011 SCALE: 1/8" = 1'-0"

HVAC DEMOLITION KEYED NOTES:

- 1 REMOVE EXISTING CEILING MOUNTED EXHAUST FAN AND ASSOCIATED EXHAUST DUCT BACK TO MAIN EXHAUST DUCT RISER.
- 2 REMOVE EXISTING SUPPLY DIFFUSER AND FLEX DUCT BACK TO MAIN SUPPLY DUCT.
- 3 REMOVE EXISTING EXHAUST GRILLE AND ASSOCIATED EXHAUST DUCT BACK TO MAIN EXHAUST DUCT RISER.
- 4 REMOVE AND REPLACE EXISTING ROOF MOUNTED EXHAUST FAN. EXISTING ROOF CURB TO REMAIN.
- 5 REMOVE EXISTING RETURN AIR GRILLE.

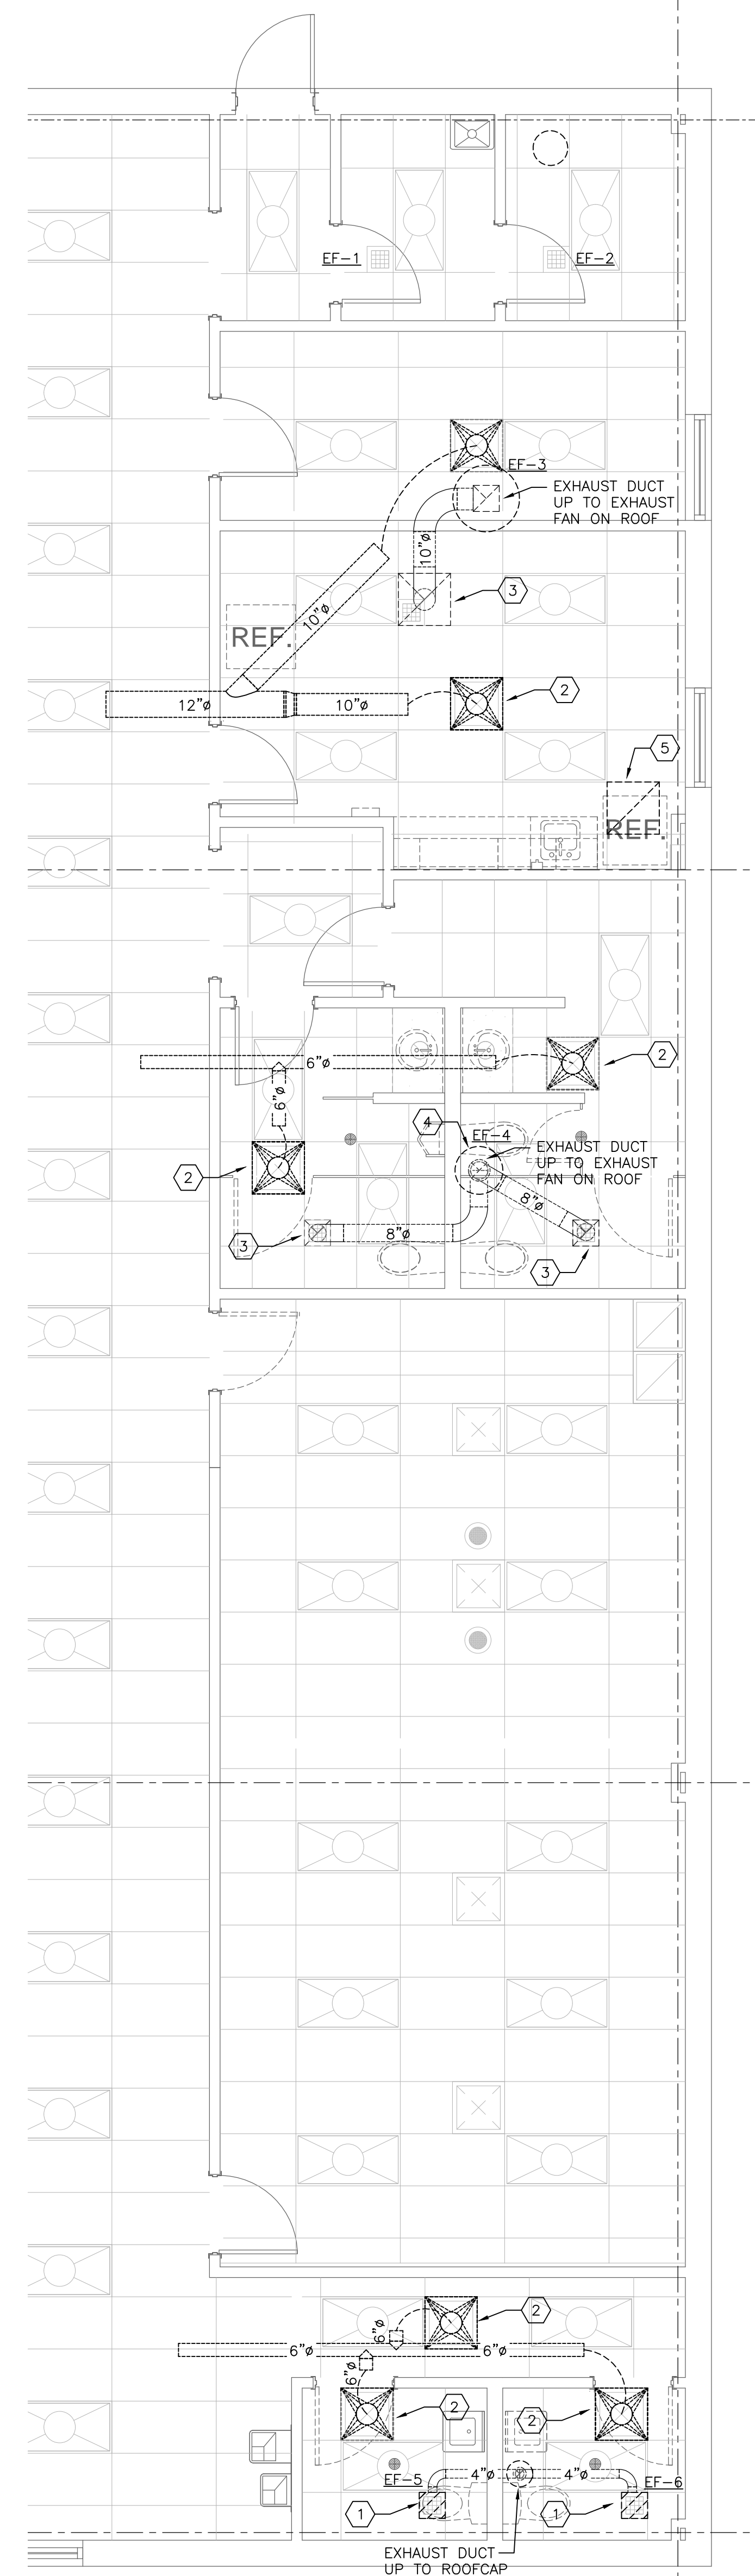


2 ENLARGED HVAC DEMOLITION PLAN
 M011 SCALE: 1/4" = 1'-0"

MARK	DESCRIPTION	DATE
REVISIONS		

TEXAS WORKFORCE COMMISSION
 CB5003-002 TWC MOPAC RESTROOM RENO PROJECT
 12312 N. MOPAC EXPRESSWAY
 AUSTIN, TX 78756
 HVAC DEMOLITION PLAN

JOB NO.	202265
ISSUE DATE:	05/09/2023
DRN. BY:	D. LARA
CRD. BY:	D. LARA


SHEET NUMBER
M011

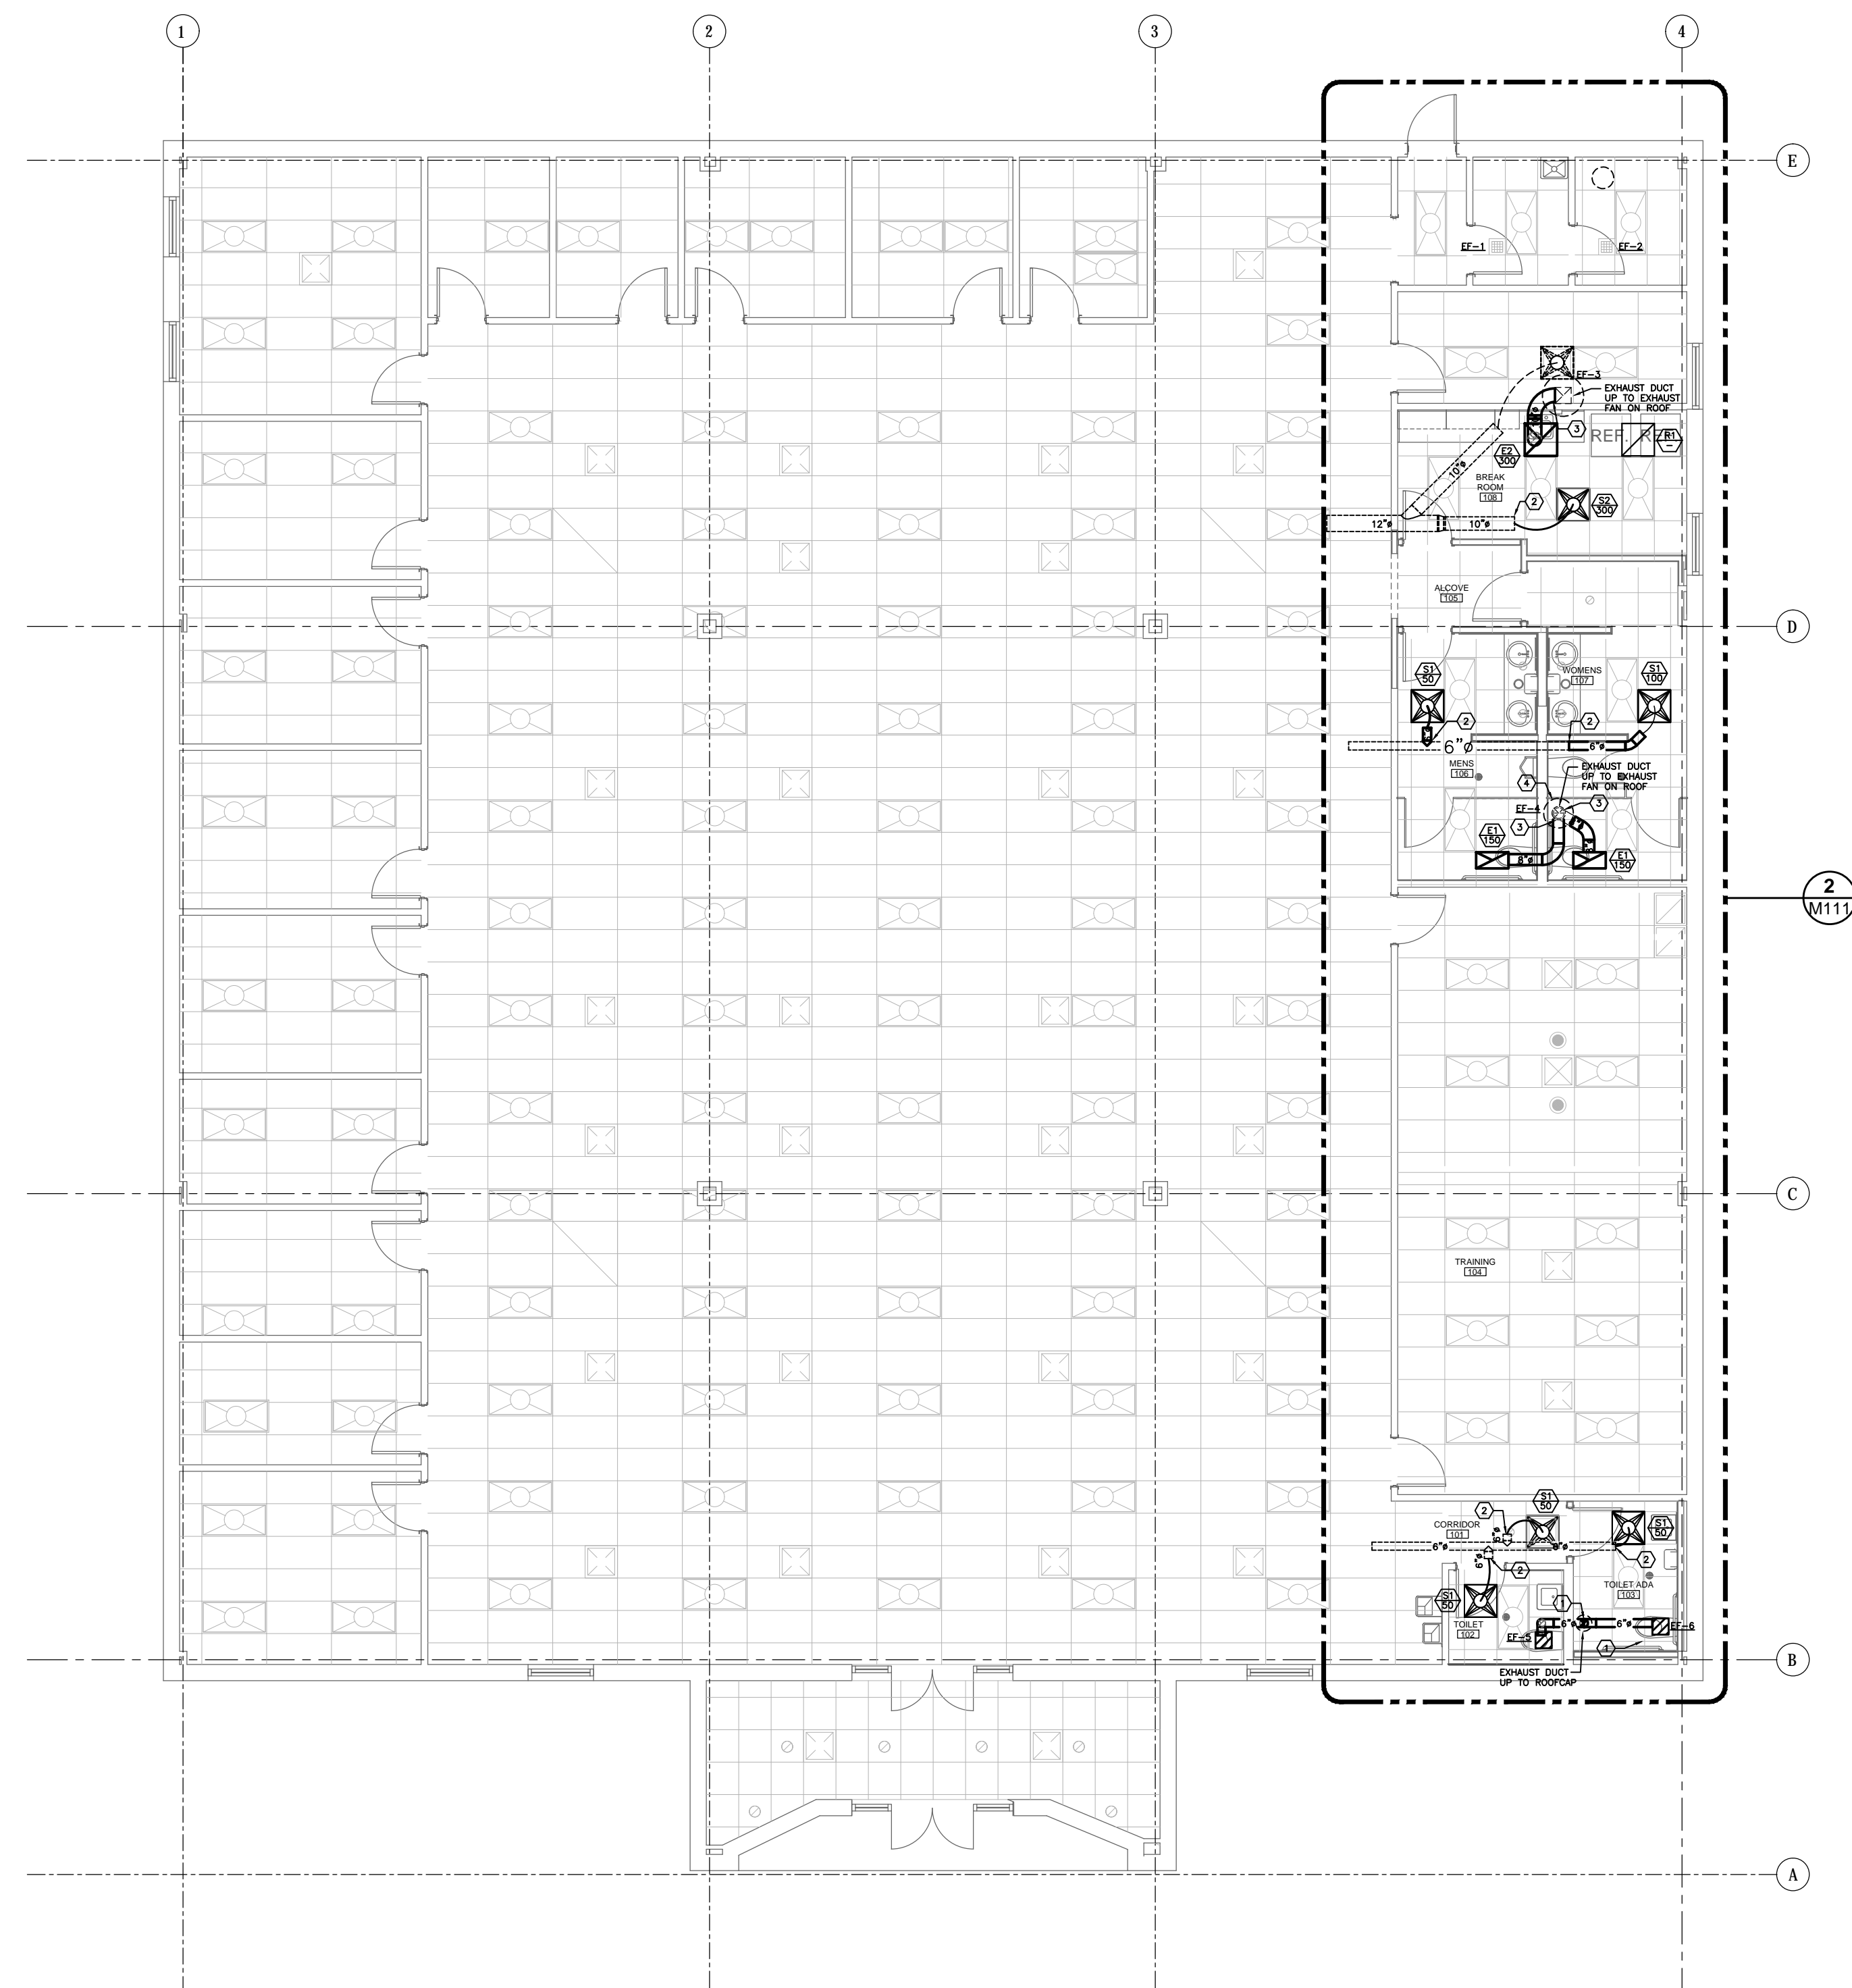

1 HVAC PLAN
 M111 SCALE: 1/8" = 1'-0"

HVAC KEYED NOTES:

- 1 CONNECT TO EXISTING EXHAUST DUCT RISER. PROVIDE 6X6X6 DOUBLE WYE FITTING TO CONNECT BRANCH EXHAUST DUCTS.
- 2 CONNECT TO EXISTING SUPPLY DUCT.
- 3 CONNECT TO EXISTING EXHAUST DUCT RISER.
- 4 PROVIDE NEW ROOF MOUNTED EXHAUST FAN, PROVIDE ROOFCURB ADAPTER TO INSTALL ON EXISTING ROOF CURB.

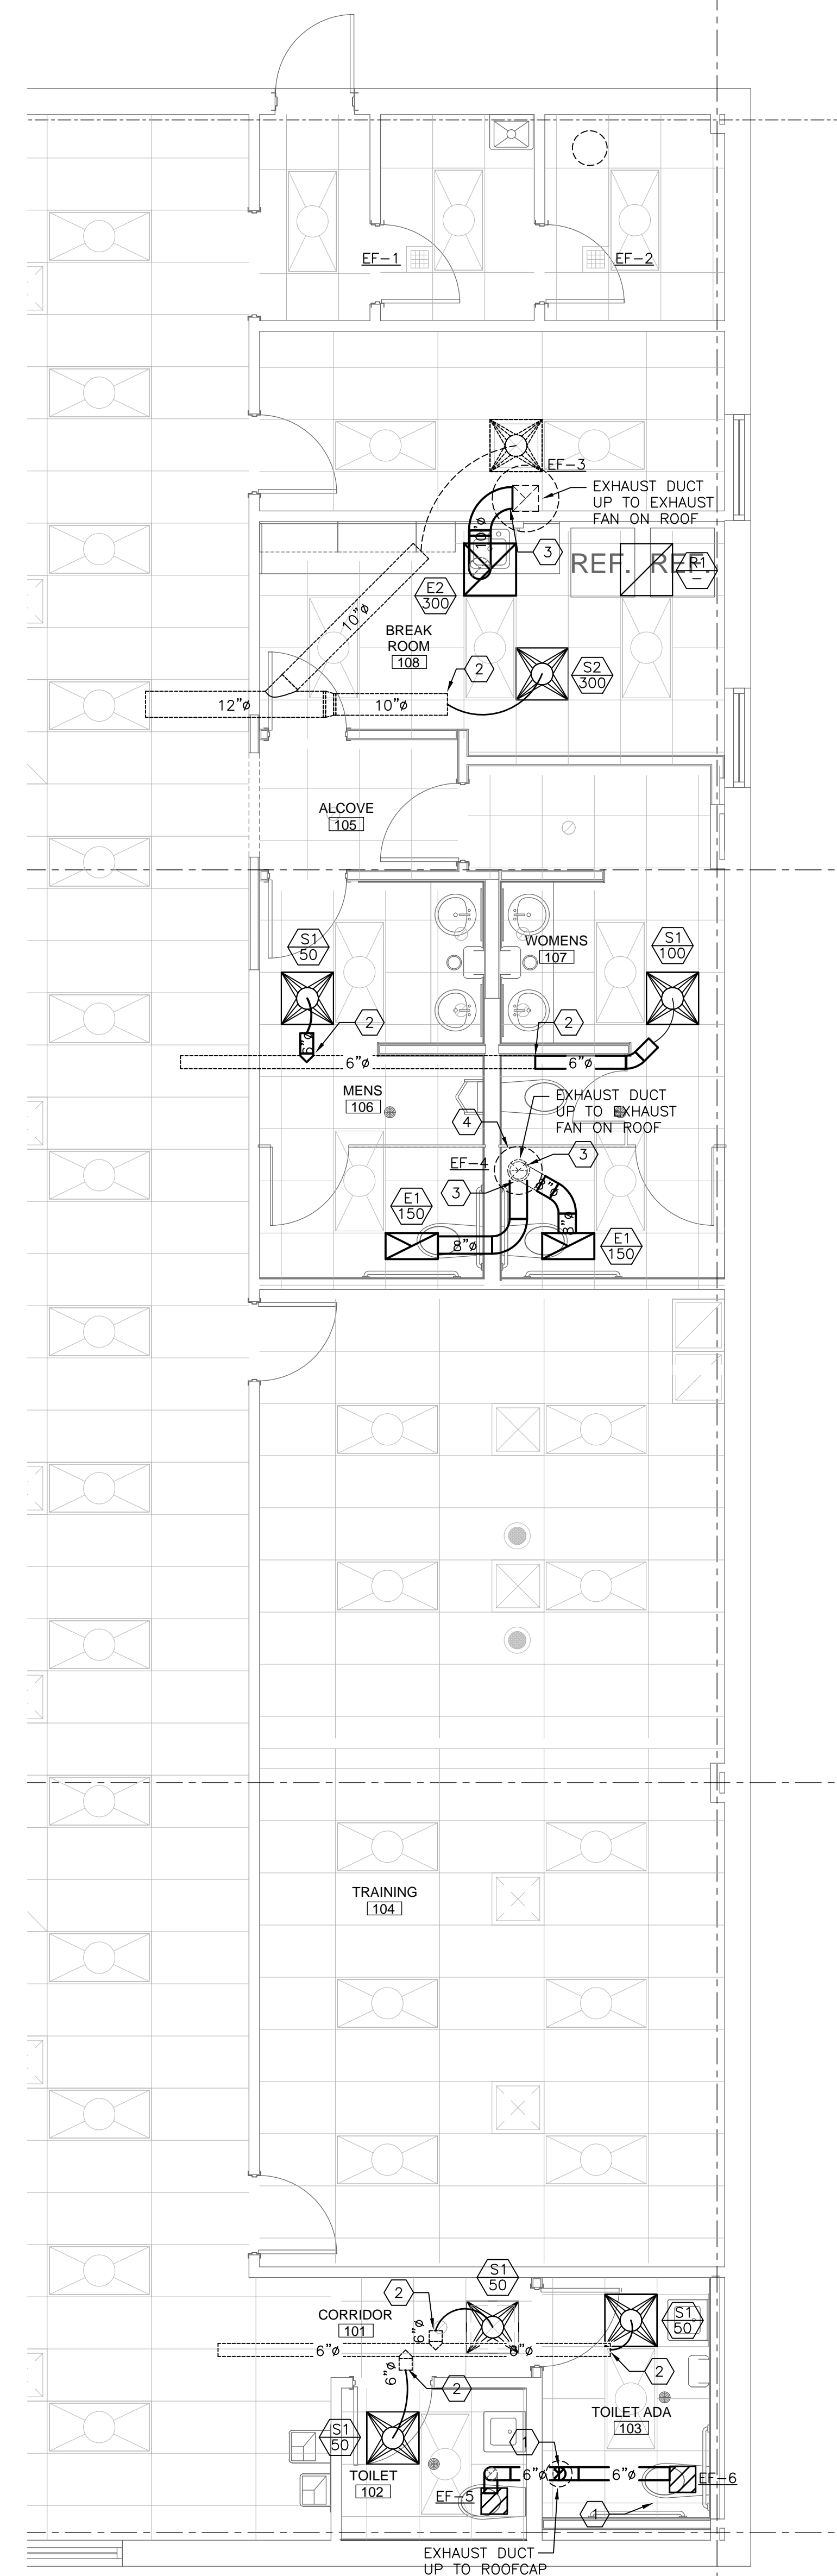

2 ENLARGED HVAC PLAN
 M111 SCALE: 1/4" = 1'-0"

MARK	DESCRIPTION	DATE
REVISIONS		

TEXAS WORKFORCE COMMISSION
 CB5003-002 TWC MOPAC RESTROOM RENO PROJECT
 12312 N. MOPAC EXPRESSWAY
 AUSTIN, TX 78756
HVAC PLAN

JOB NO.	202265
ISSUE DATE:	05/09/2023
DRN. BY:	D. LARA
CRD. BY:	D. LARA

SHEET NUMBER
M111

