


MECHANICAL FLOOR PLAN
1/4" = 1'-0"

SHEET NOTES

CANOPY GENERAL NOTES

KEY NOTES

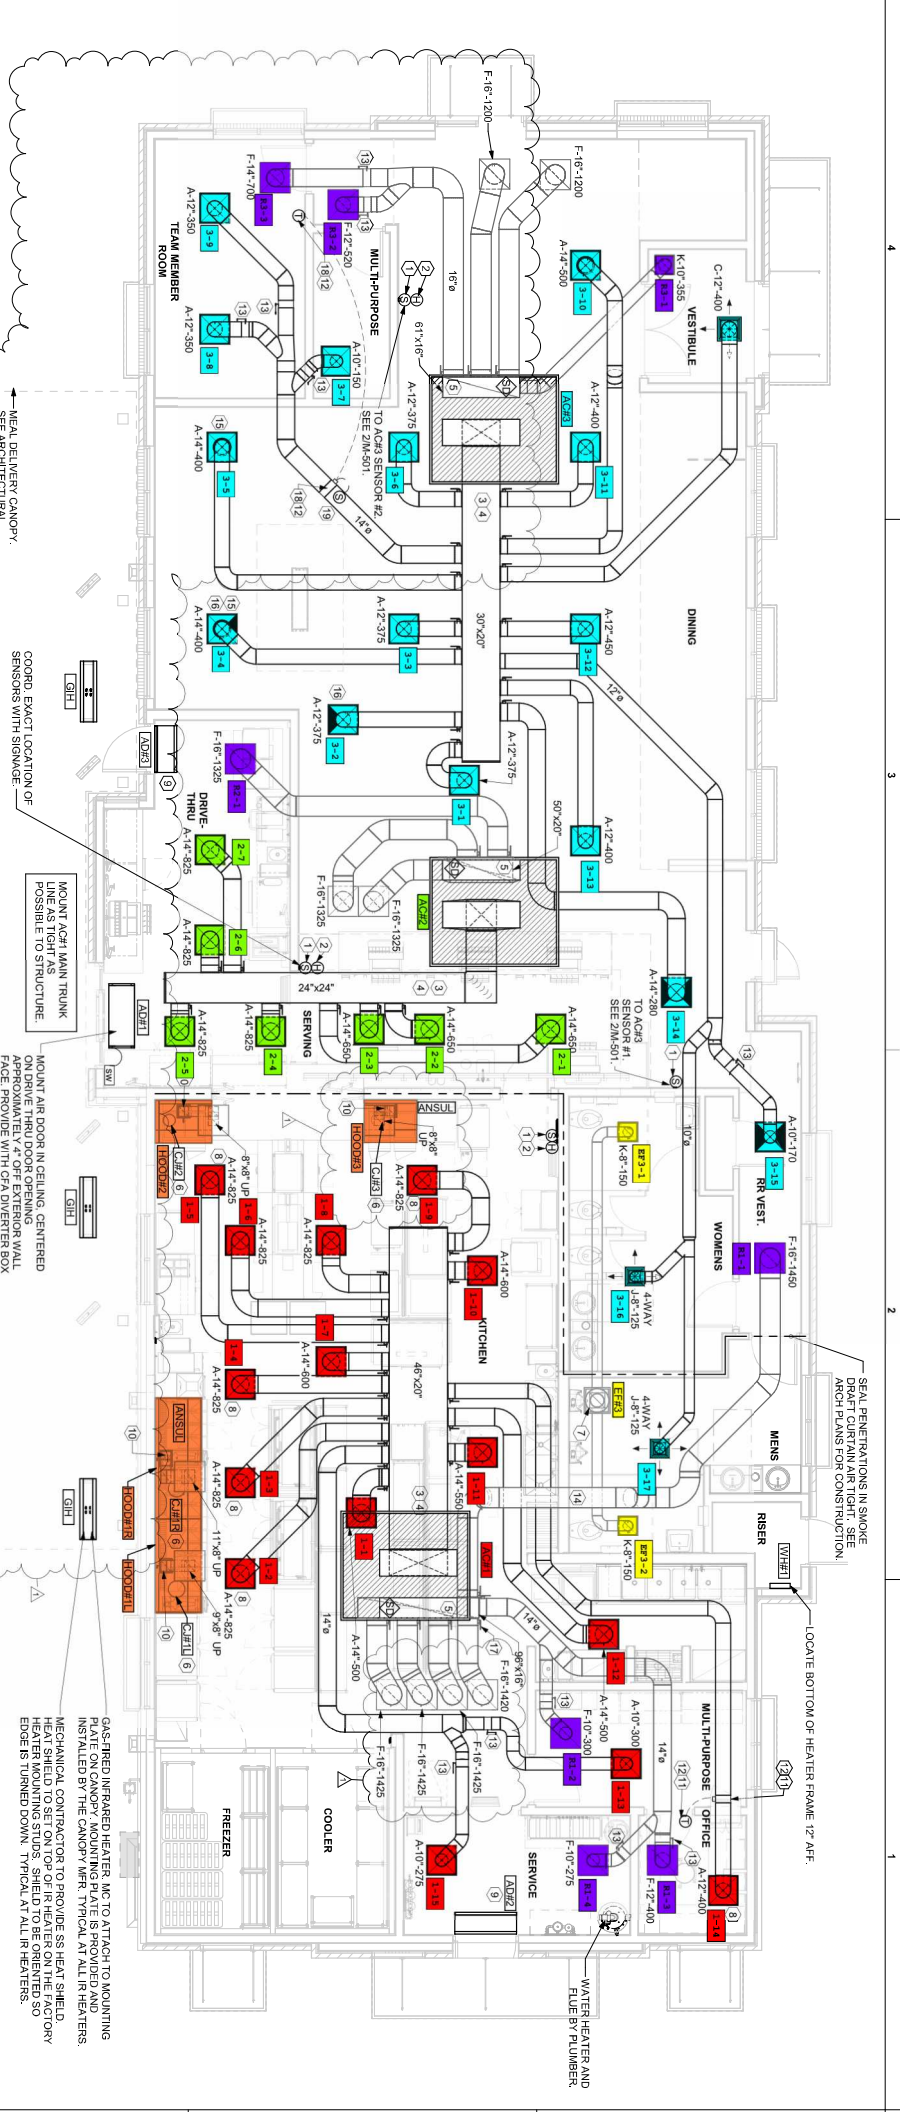

4

3

2

1