







COPYRIGHT RESERVED BY WSA STUDIO. THE DRAWING AND THE IDEAS EXPRESSED HEREIN ARE AND SHALL REMAIN THE SOLE PROPERTY OF WSA STUDIO, AND ARE NOT TO BE USED IN WHOLE OR IN PART, FOR ANY OTHER PURPOSES, OR BY ANY OTHER PARTIES, WITHOUT THE SPECIFIC WRITTEN AUTHORIZATION BY WSA STUDIO.

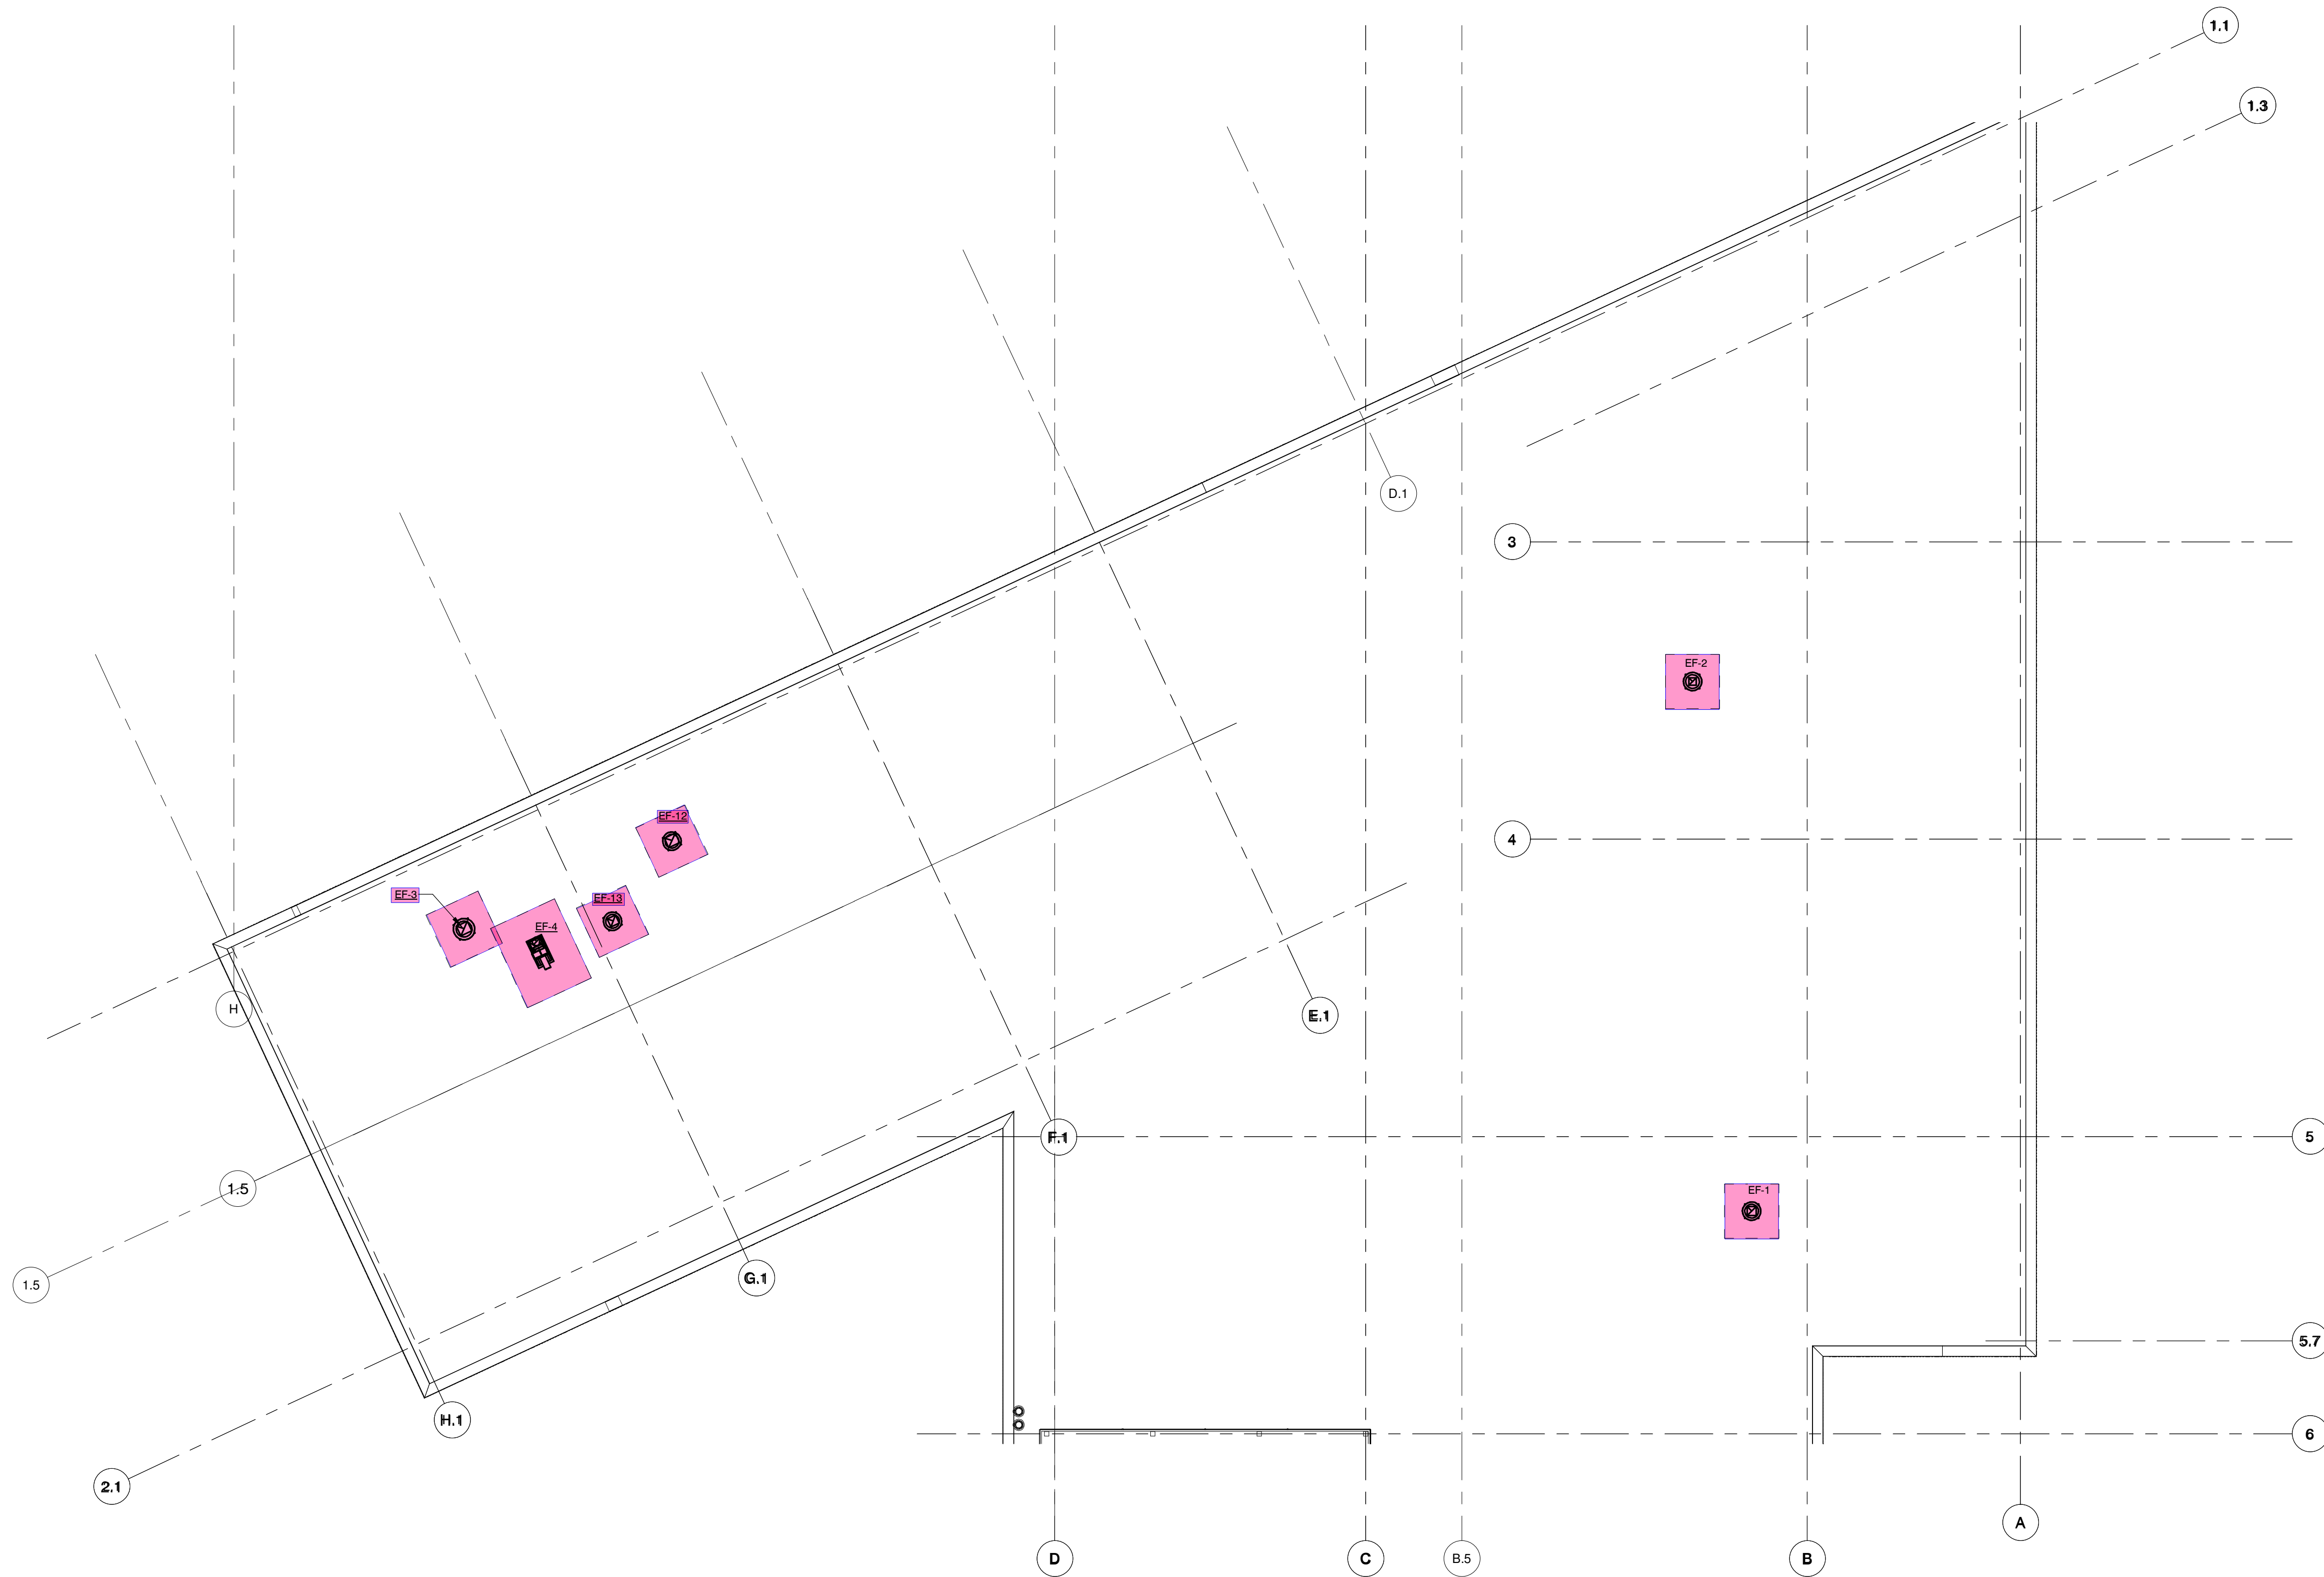

**1 ROOF PLAN AREA A**  
 SCALE: 3/32" = 1'-0"

|  |                                |  |                                  |
|--|--------------------------------|--|----------------------------------|
| <b>HAWA</b><br><small>engineers</small>  |                                | <small>HAWA Incorporated</small><br><small>880 OLD HENDERSON ROAD</small><br><small>COLUMBUS, OHIO 43229 614-451-1711</small><br><small>4055 EXECUTIVE PARK DRIVE, SUITE 400</small><br><small>CINCINNATI, OH 45241 513-771-6640</small> |                                  |
| <small>HAWA PROJECT No.</small><br>22124 | <small>DRAWN BY</small><br>TSK | <small>DESIGNED BY</small><br>J.J. PORTER, P.E.  | <small>CHECKED BY</small><br>NBH |

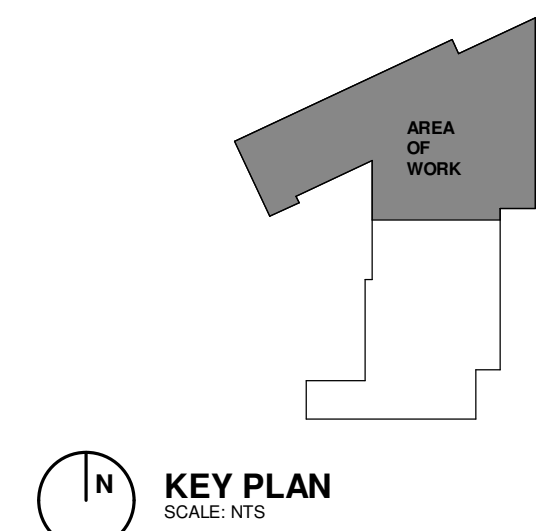

**KEY PLAN**  
 SCALE: NTS

**WSA**  
882 S. FRONT STREET  
COLUMBUS, OH 43206  
614.824.1633

**HAWA**  
engineers

**EDGE** PLANNING  
LANDSCAPE ARCHITECTURE  
URBAN DESIGN

**Jezerinac Geers**  
Structural Engineering

**MARKER**

**GLOBAL IMPACT STEM**  
**ACADEMY**  
 GISA - UPPER CAMPUS

**PROJECT ADDRESS**  
 570 E. Leffel Ln,  
 Springfield, OH  
 45505



**PERMIT SET**  
DATE PRINTED  
 23 JUNE 2023  
PROJECT NUMBER  
 202291.00

DRAWN BY: HAWA CHECKED BY: HAWA

ROOF MECHANICAL PLAN -  
AREA A

**M200**

