

Consultant:



214 W. Main Street, Suite 100
Moore, CO 80102
(8)

COPYRIGHT 2020
THIS DRAWING IS AN INSTRUMENT OF SERVICE. ALL RIGHTS RESERVED. SUCH REMAINS THE PROPERTY OF CHIPOTLE MEXICAN GRILL, INC. PERMISSION FOR USE OF THIS DRAWING IS LIMITED AND CAN BE EXTENDED ONLY BY AGREEMENT WITH CHIPOTLE MEXICAN GRILL, INC.



CHIPOTLE MEXICAN GRILL, INC.
1401 WYNKOOP STREET, SUITE 100
DENVER, COLORADO 80202
TELEPHONE: (303) 595-4000
FAX: (303) 595-4014
INTERNET: WWW.CHIPOTLE.COM

STORE NO.: 3477

REV. DATE	DESCRIPTION
2022.06.	
2022.06.	
1 2022.07.	
2 2022.08.	
3 2022.10.	

PROFESSIONAL SEA

M
N
PROFESSIONAL IN C
DRAWN BY: PCE
CHECKED BY: AIS


PROJECT NUMBER:
21078

SHEET TITLE:
HVAC PL

SHEET NUMBER:
M-

M-

DOB NOW

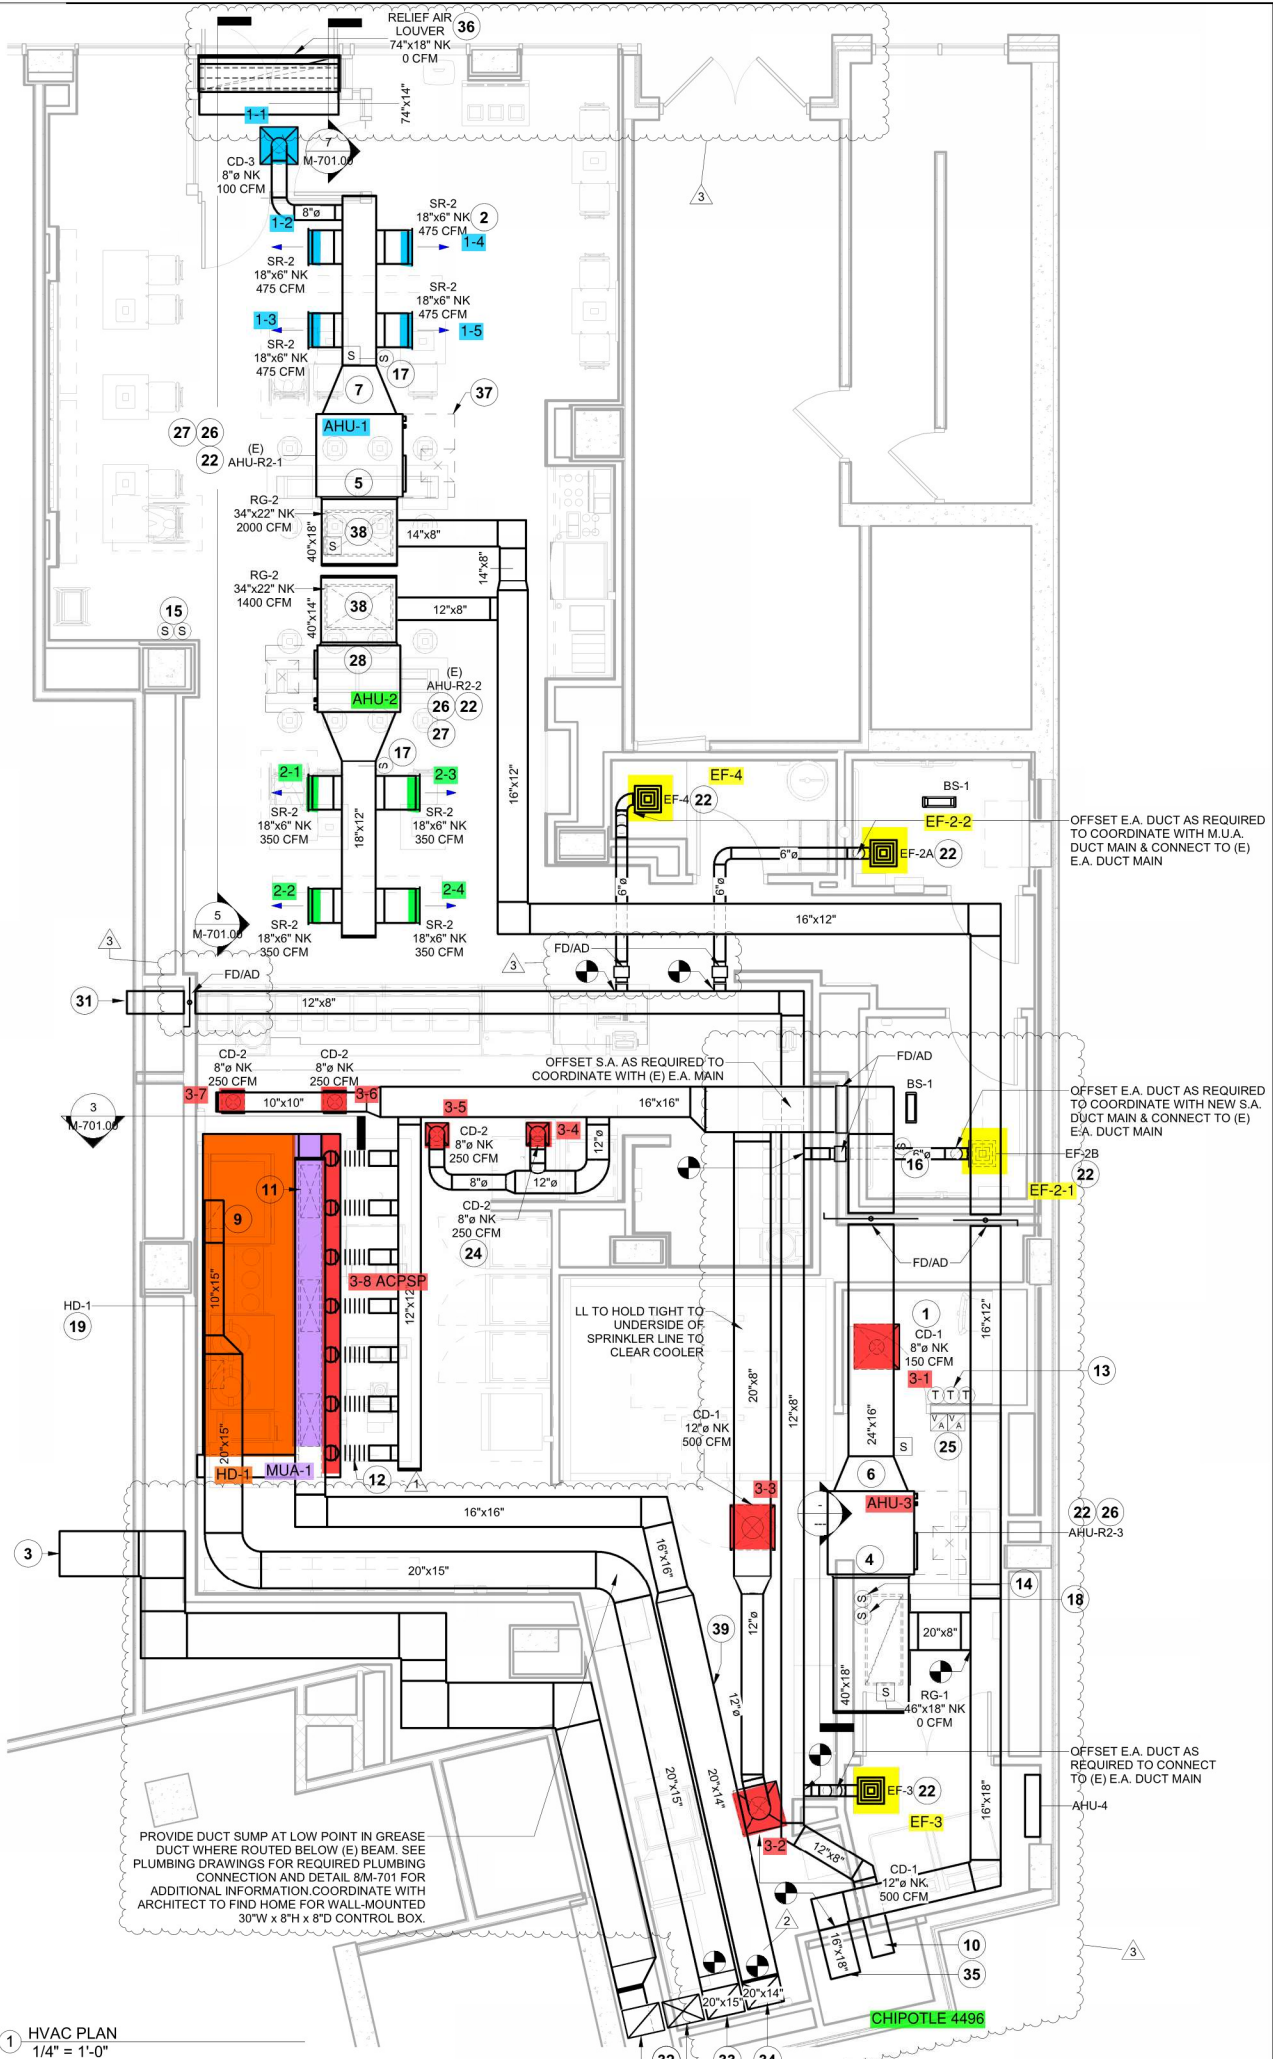

PROVIDE DUCT SUMP AT LOW POINT IN GREASE DUCT WHERE ROUTED BELOW (E) BEAM. SEE PLUMBING DRAWINGS FOR REQUIRED PLUMBING CONNECTION AND DETAIL 3M-701 FOR ADDITIONAL INFORMATION COORDINATE WITH ARCHITECT TO FIND HOME FOR WALL-MOUNTED 30"W x 8"H x 8"D CONTROL BOX.

1 HVAC PLAN
1/4" = 1'-0"