


ALL CODES AND NOTES ACCORDING TO APPROX
 ALL DRAWINGS ONLY. CLASS I FLUENT NR
 PROVIDE SUPPORT AT 4'-0" O.C.

RENDERED WITH EFFECT OF ROOM TOP FINISH. VERIFY
 REFINISH SPACE. COORDINATE WITH RISER SUPPLIER
 TO BE BLACK. ALL OTHERS TO BE WHITE.

- RECOMMENDED HVAC SET POINTS:
1. CHILLING/HEATING CO. COOLING 72°
 2. RECHILLING/HEATING 68° COOLING 74°

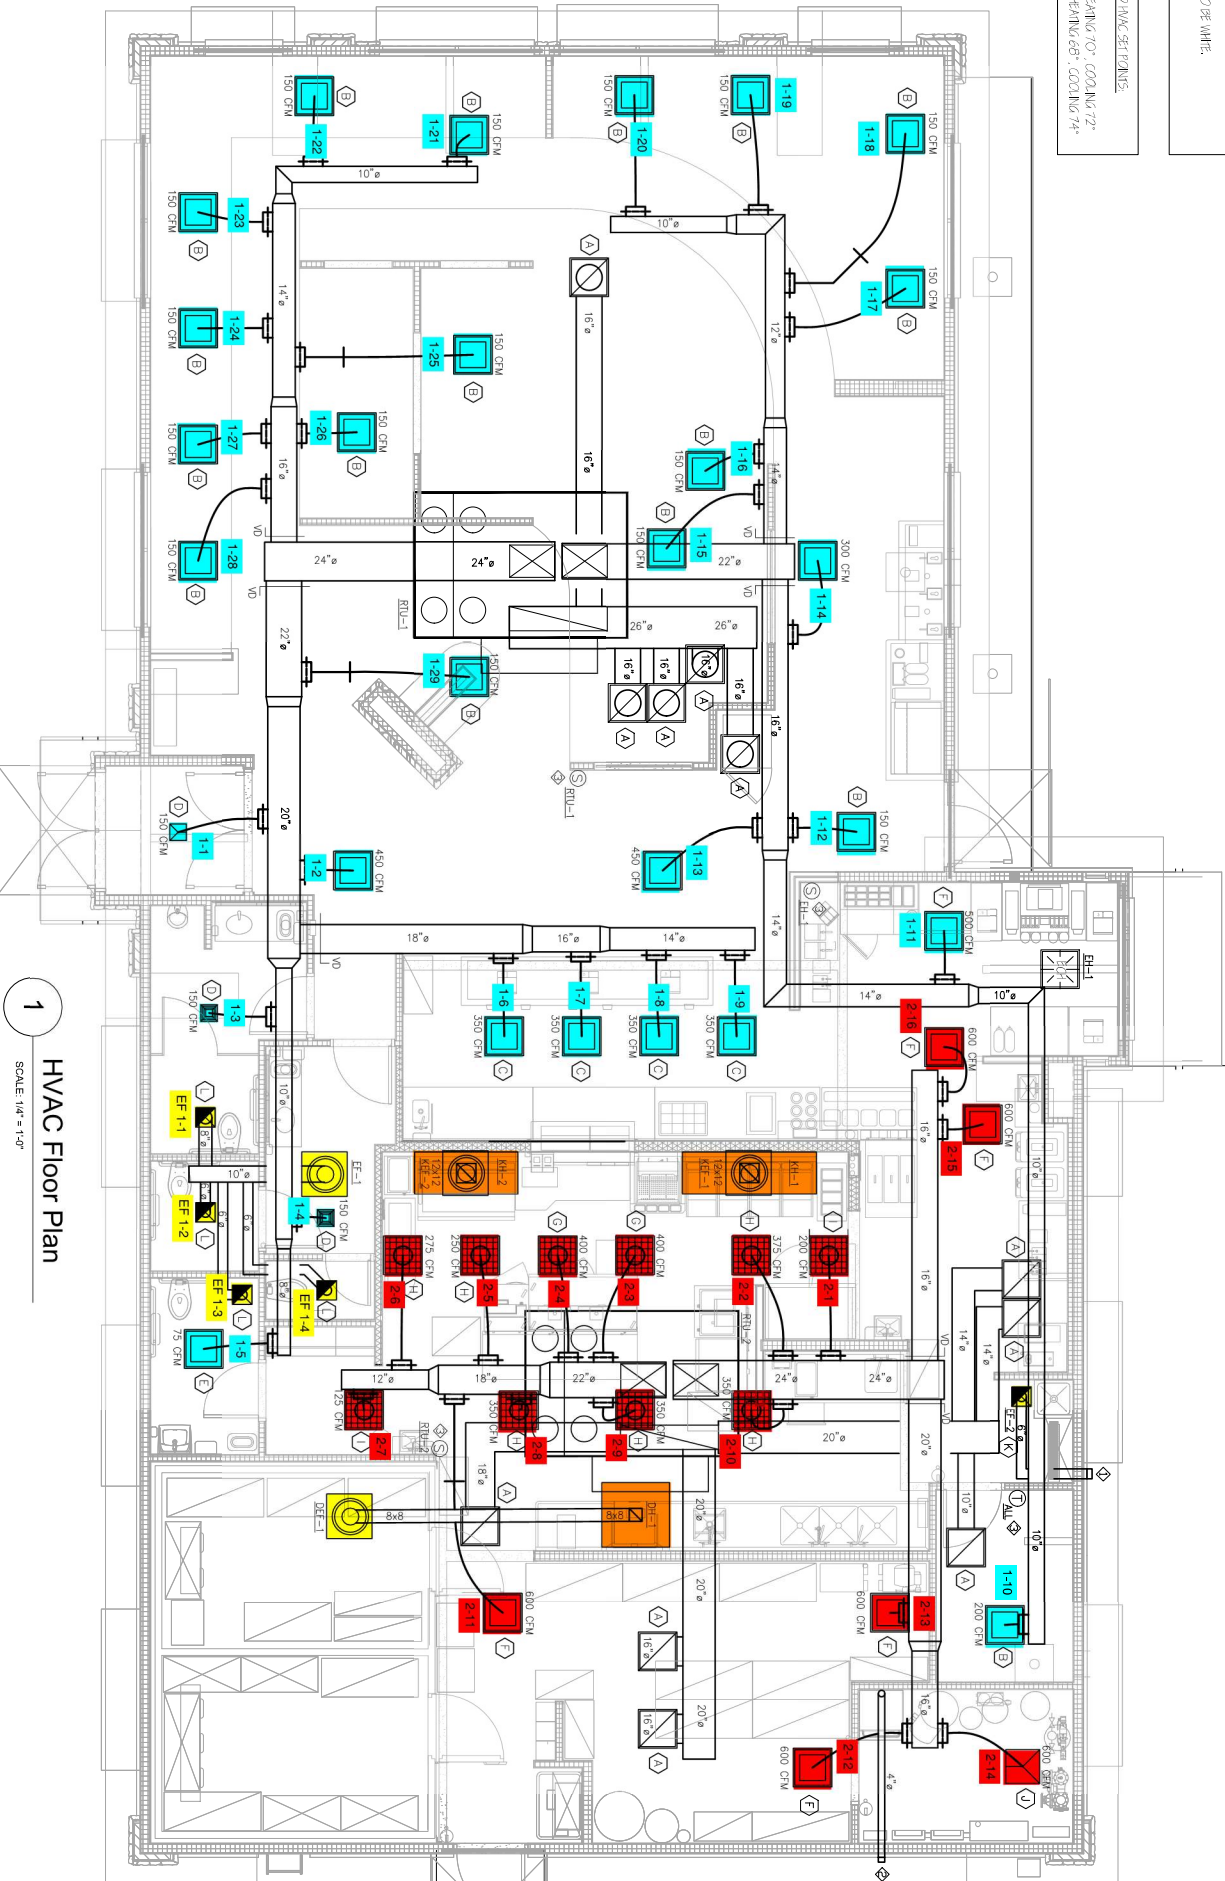

1 HVAC Floor Plan
 SCALE: 1/4" = 1'-0"