


E5 HVAC PLAN
SCALE: 1/4" = 1'-0"

PATIO

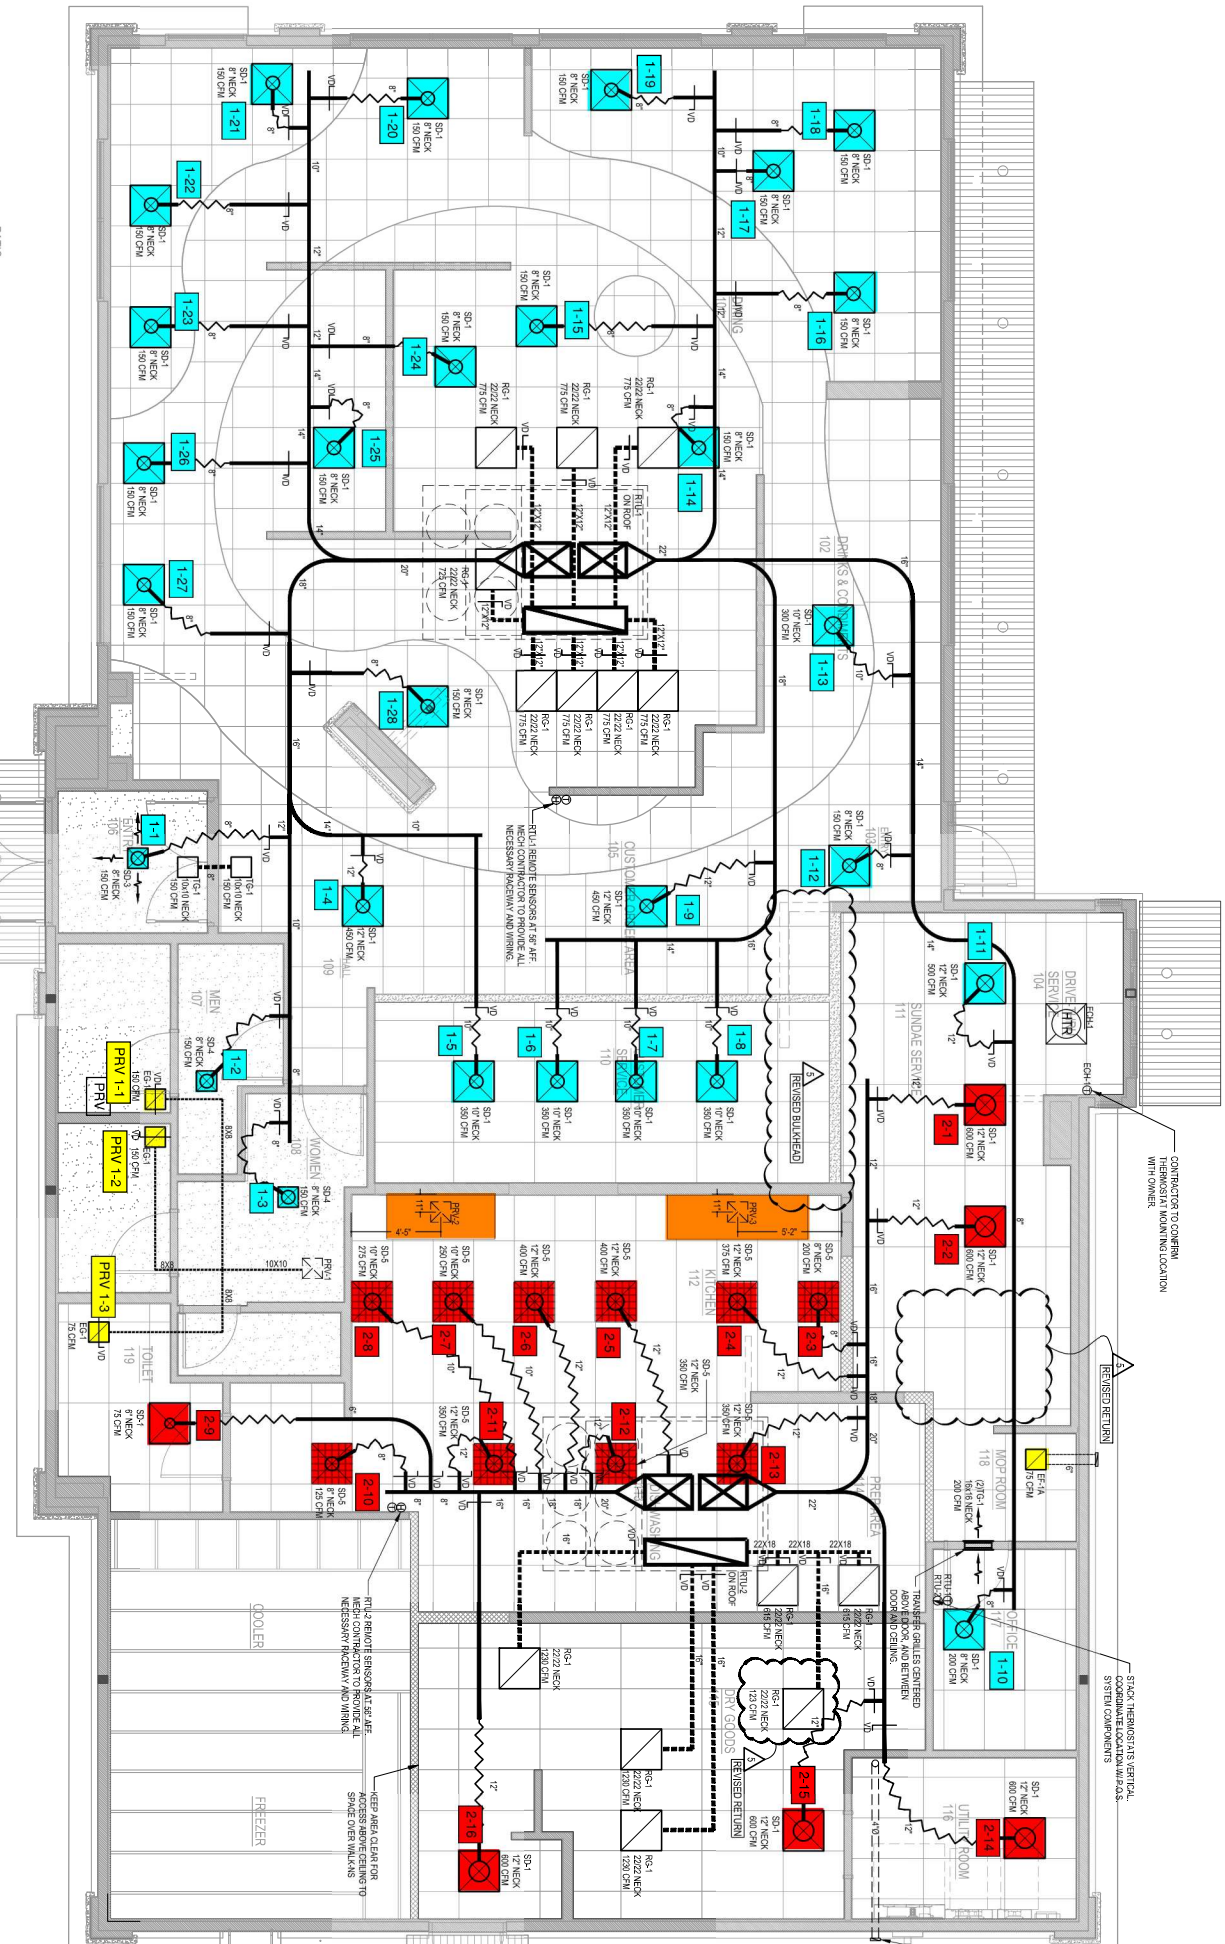

NOTE: ALL DUCTWORK TO BE LOCATED IN ROSS SPACE WHERE POSSIBLE. SEE DRAWING T-5-01.

CONTRACTOR TO CONFIRM WITH OWNER

RTU-REMOTE SENSORS AT 5' AFF. MECH. CONTRACTOR TO PROVIDE ALL NECESSARY PIPING AND WIRING

KEEP AREA CLEAR FOR MECH. CONTRACTOR TO PROVIDE ALL SPACE OVER HANGERS