


2 LOWER LEVEL MECHANICAL PLAN
M-1.1 Scale: 1/4" = 1'-0"

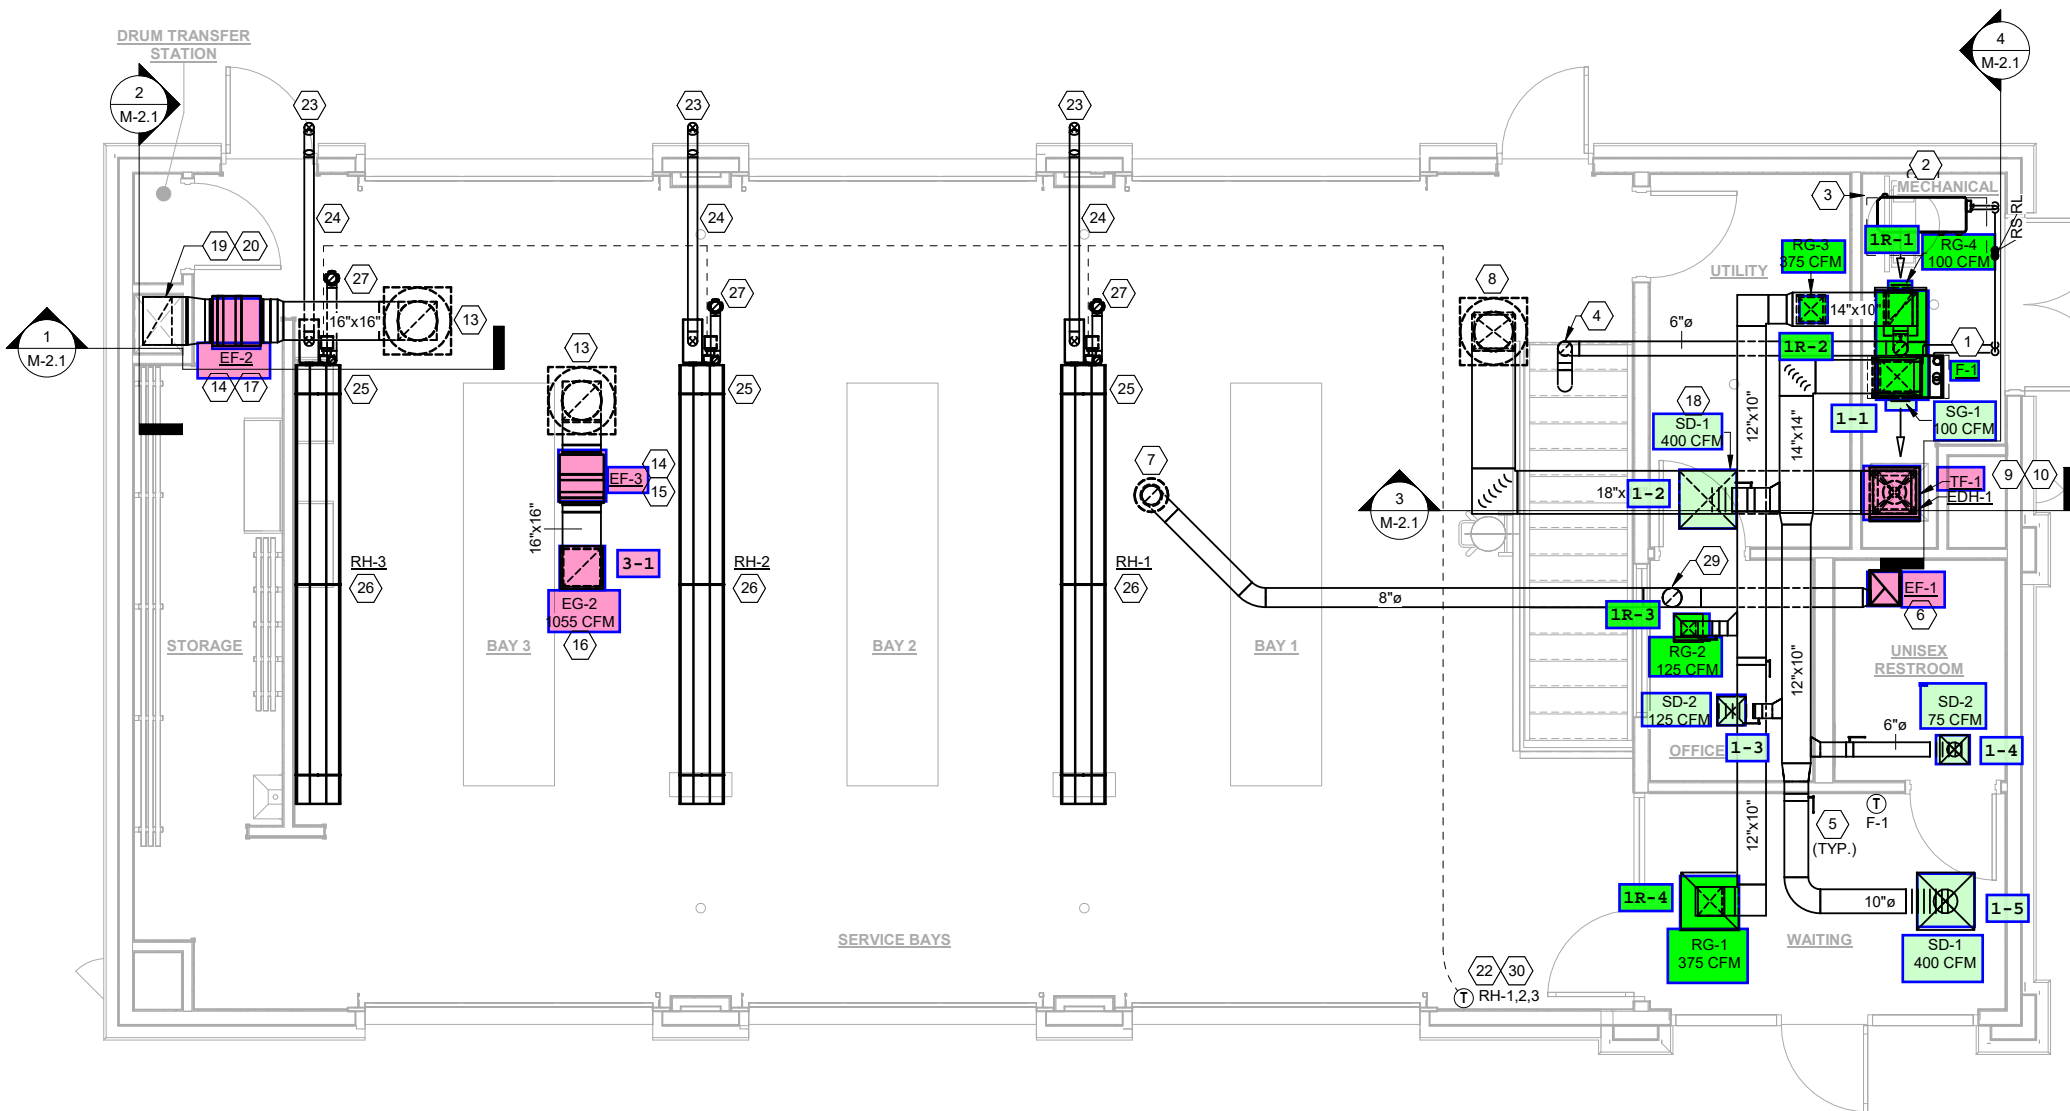

1 UPPER LEVEL MECHANICAL PLAN
M-1.1 Scale: 1/4" = 1'-0"