


**2 LOWER LEVEL MECHANICAL PLAN**  
 M-1.1 Scale: 1/4" = 1'-0"

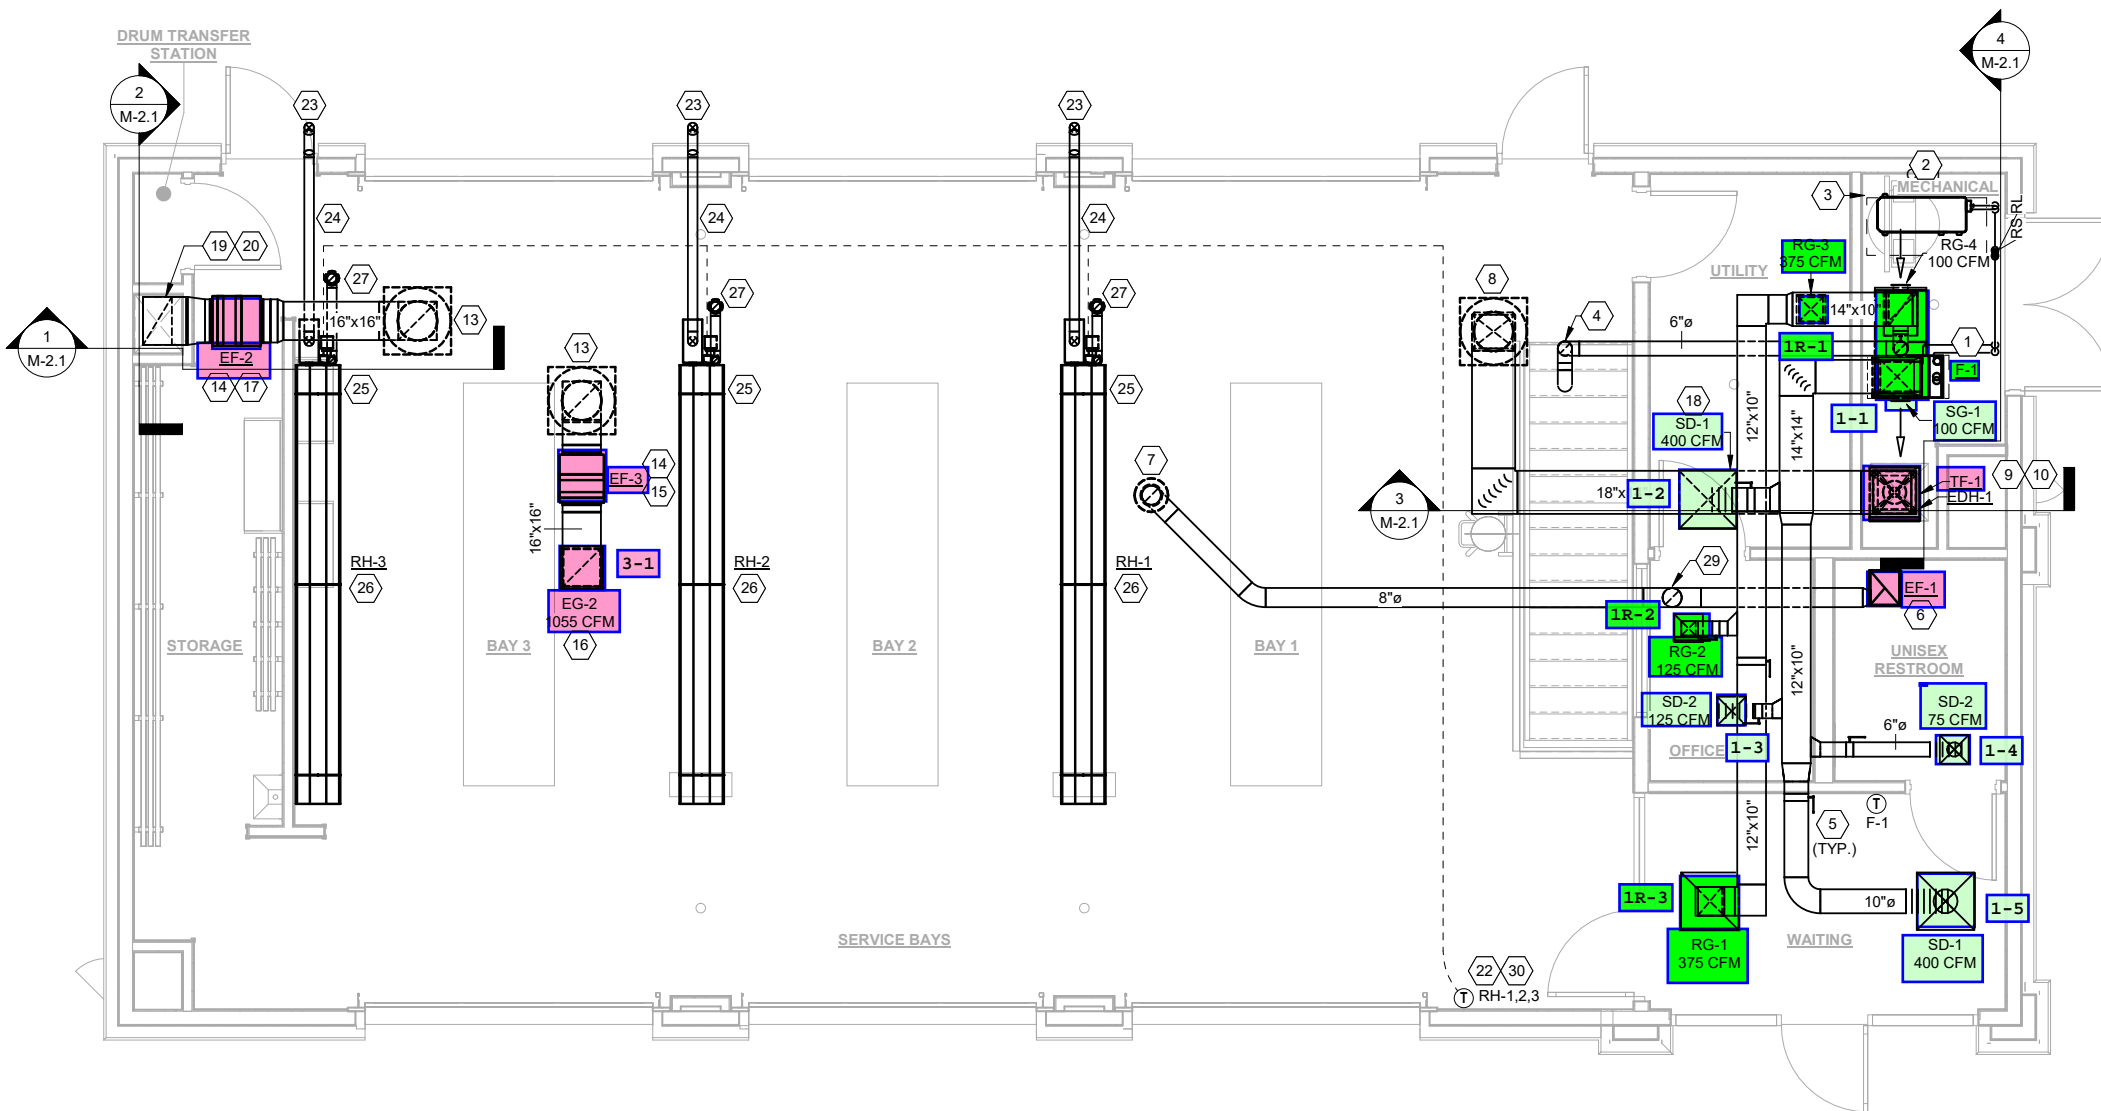

**1 UPPER LEVEL MECHANICAL PLAN**  
 M-1.1 Scale: 1/4" = 1'-0"