







PRELIMINARY -  
 NOT FOR CONSTRUCTION

COPYRIGHT 2021  
 THIS DRAWING IS AN INSTRUMENT OF SERVICE  
 AND AS SUCH REMAINS THE PROPERTY OF  
 CHIPOTLE MEXICAN GRILL, INC. PERMISSION FOR  
 USE OF THIS DOCUMENT IS LIMITED AND CAN BE  
 EXTENDED ONLY BY WRITTEN AGREEMENT WITH  
 CHIPOTLE MEXICAN GRILL, INC.



CHIPOTLE MEXICAN GRILL, INC.  
 PO BOX 182566  
 COLUMBUS, OH 43218-2566  
 TELEPHONE: (614) 318-2400  
 INTERNET: WWW.CHIPOTLE.COM

STORE NO.: 3593  
 PORTSMOUTH FREDERICK BLVD  
 FREDERICK BLVD  
 PORTSMOUTH, VA

Issue Record:	04/09/2021	ISSUE TO LANDLORD
	04/20/2021	ISSUE FOR PERMIT

Revisions:


Drawn: CJK  
 Checked: AMD

Project No:  
 1901159


Contents:

HVAC DETAILS


M700

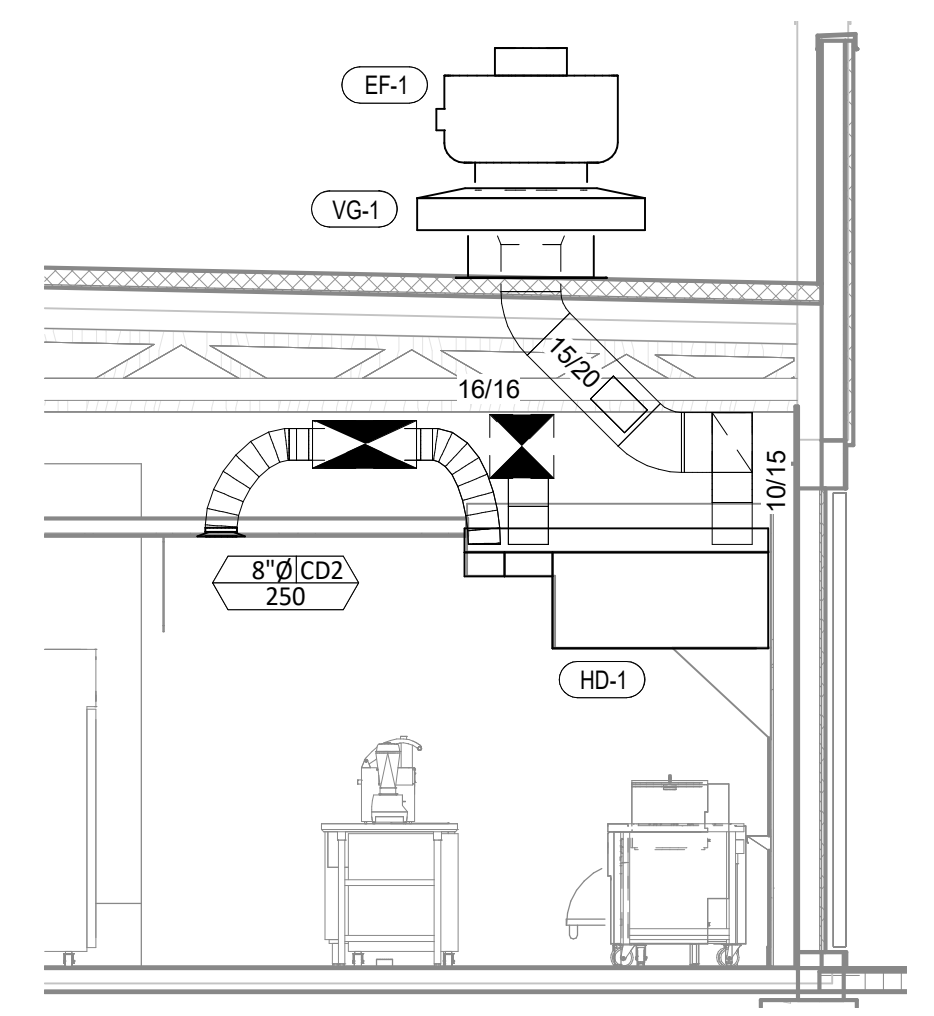


7 DUCT SECTION AT HOOD  
 1/4" = 1'-0"

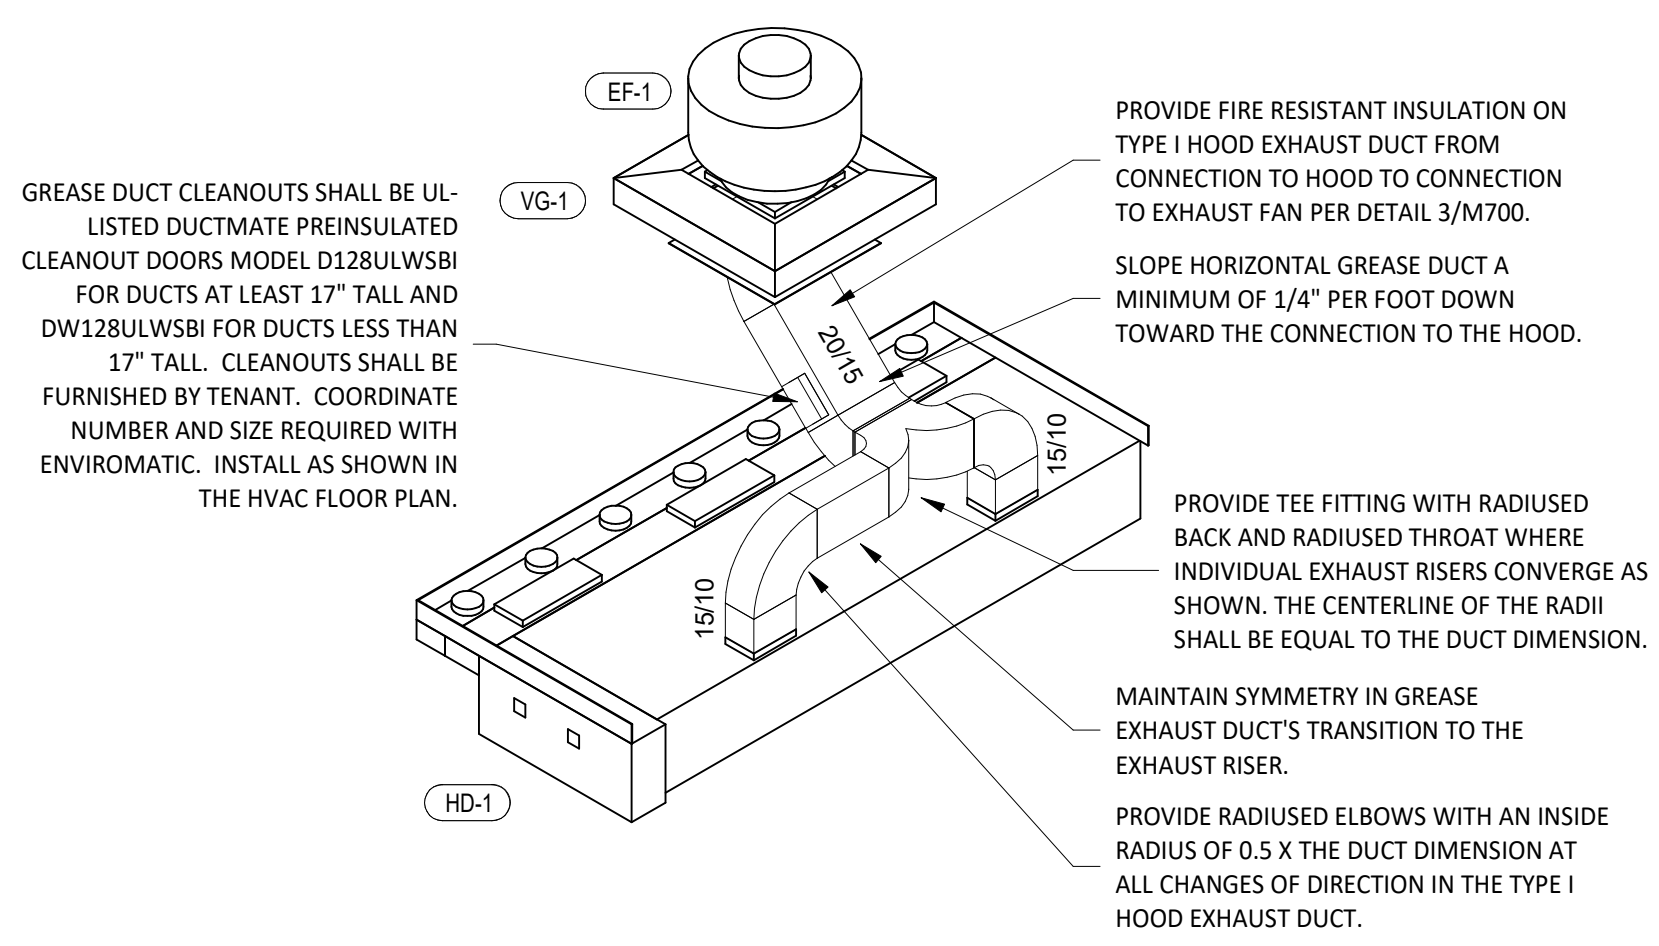


8 HOOD EXHAUST ISOMETRIC  
 N.T.S.

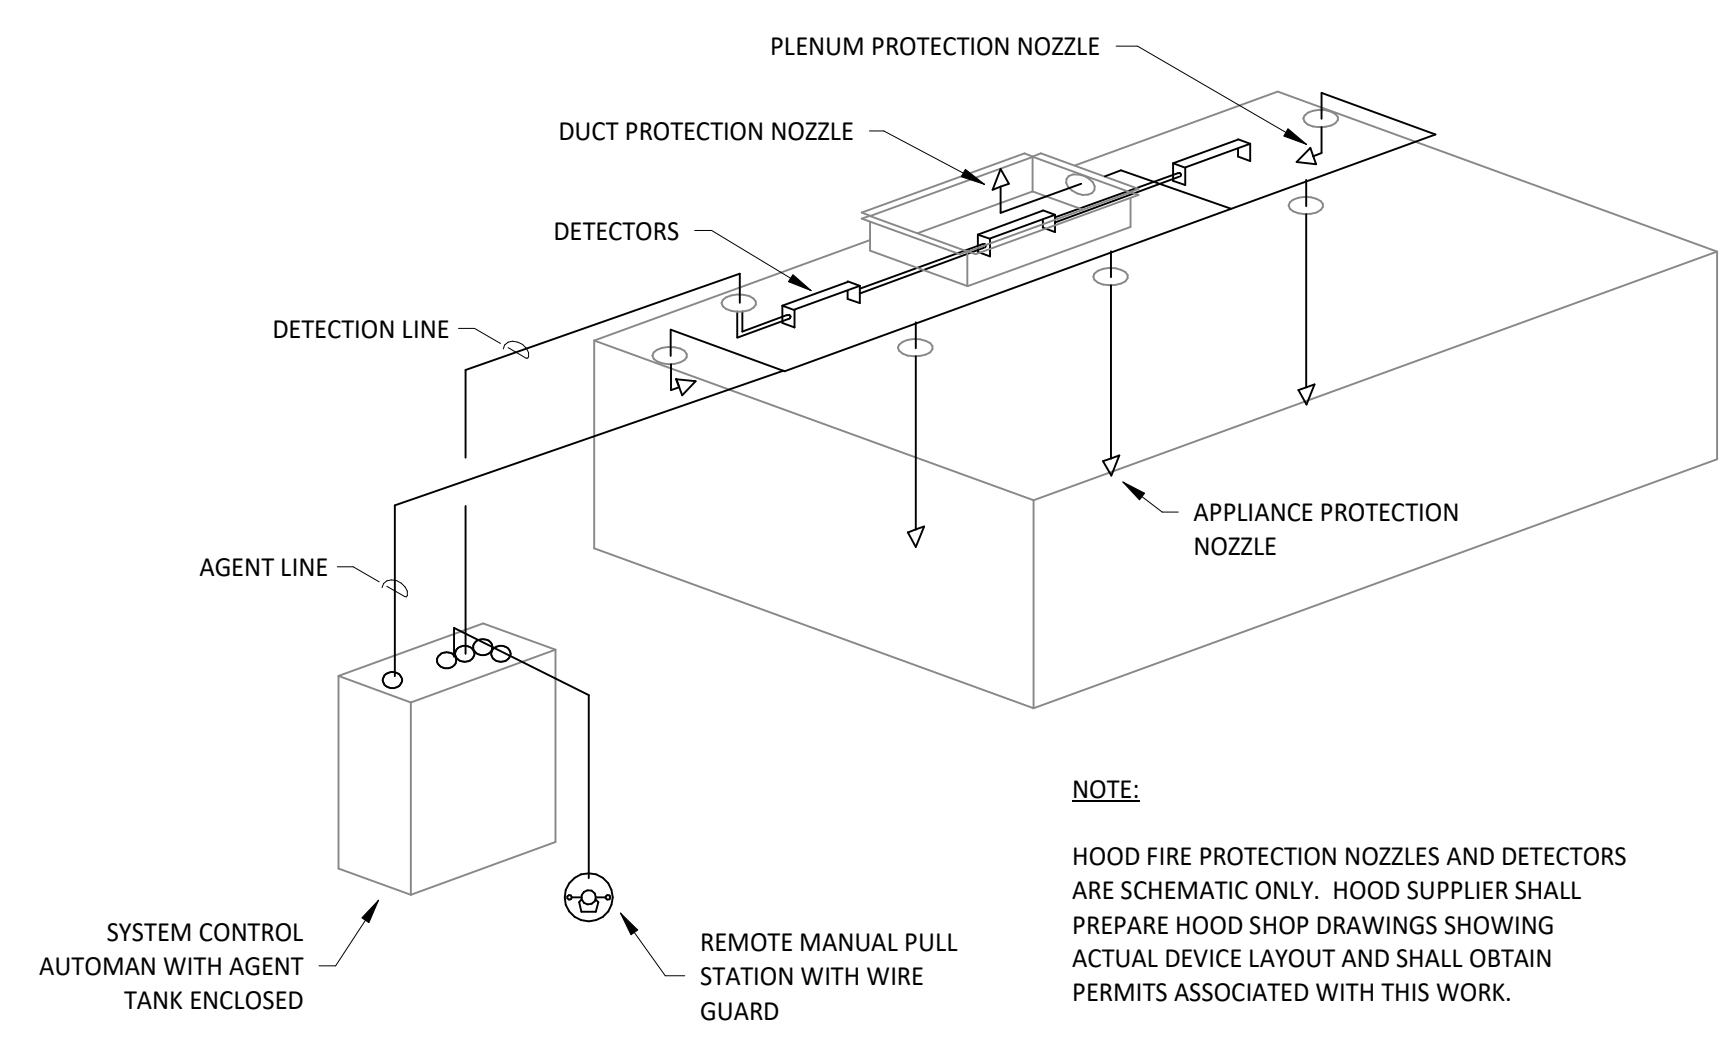


4 FIRE SUPPRESSION SYSTEM SCHEMATIC  
 N.T.S.

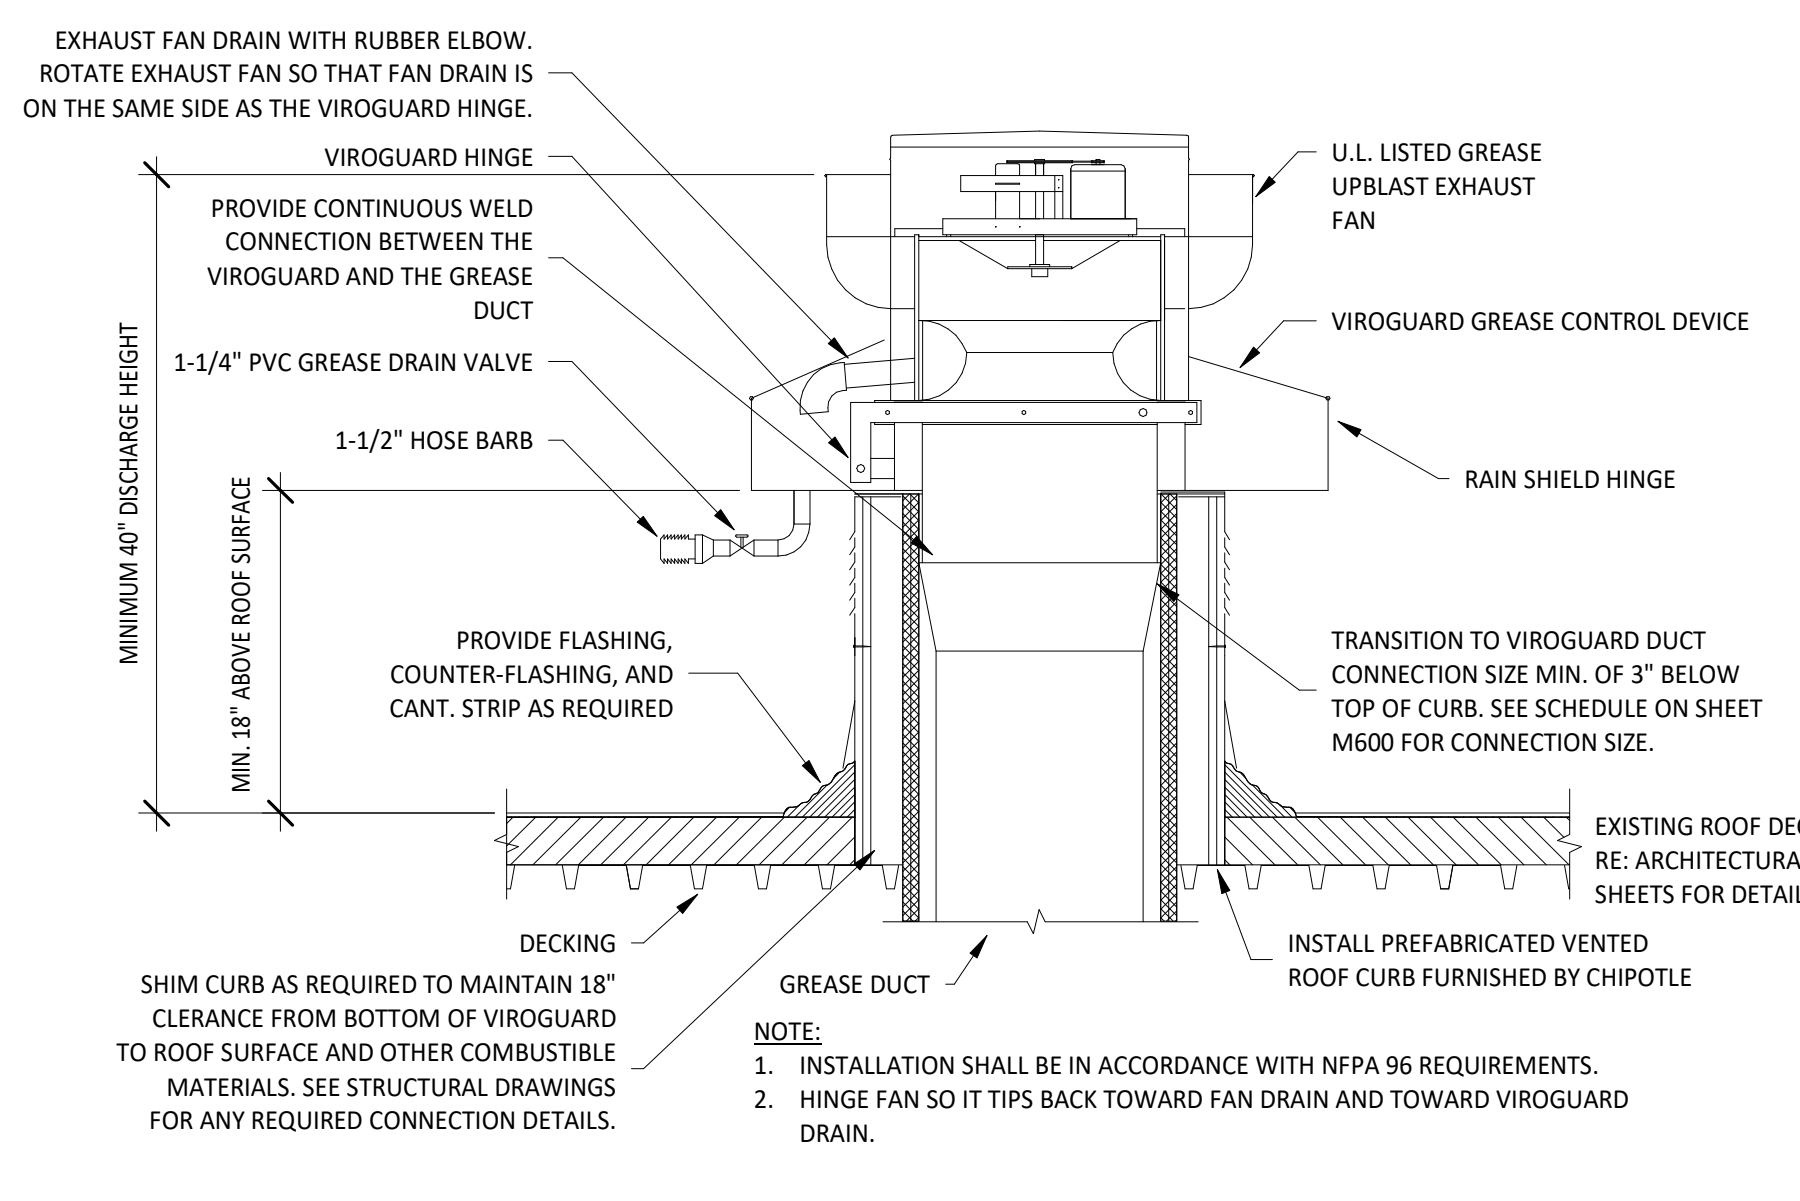


5 GREASE EXHAUST FAN  
 N.T.S.

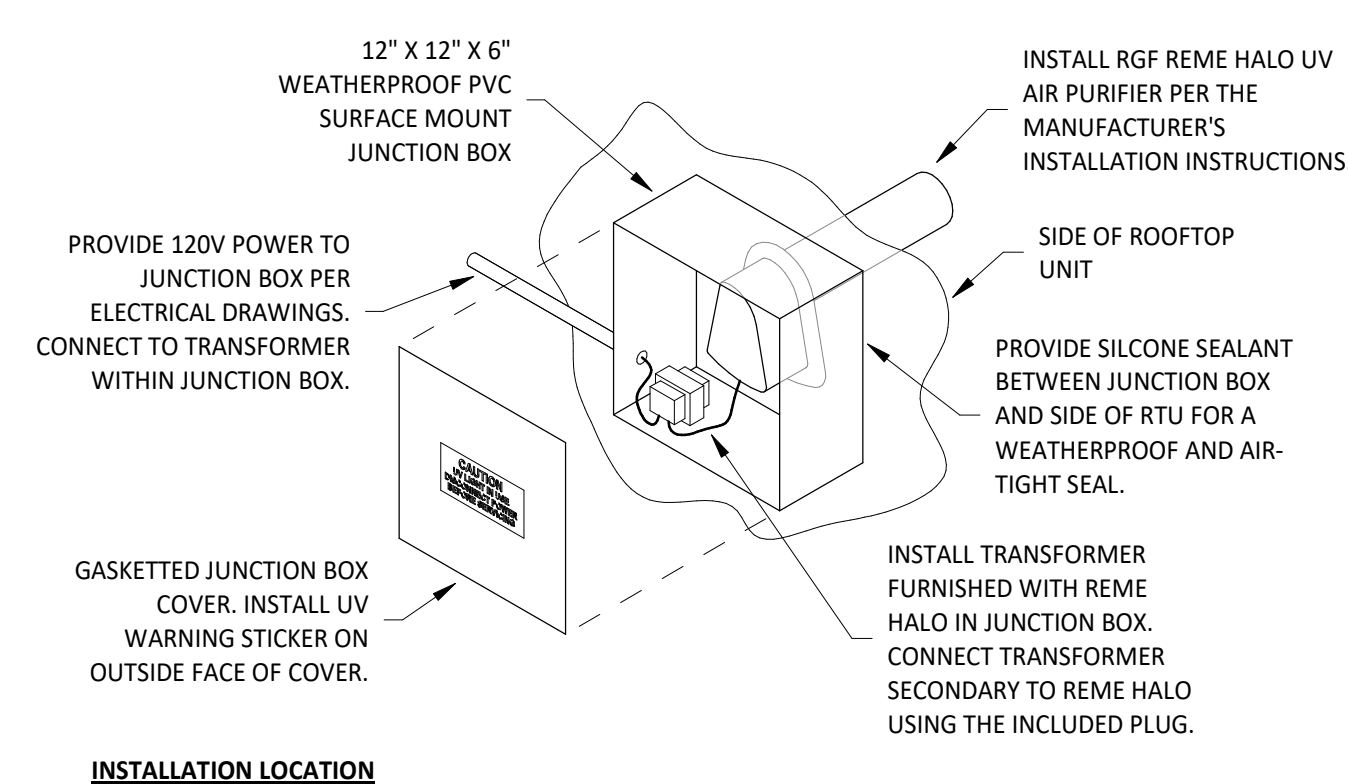


6 UV AIR PURIFIER INSTALLATION  
 N.T.S.

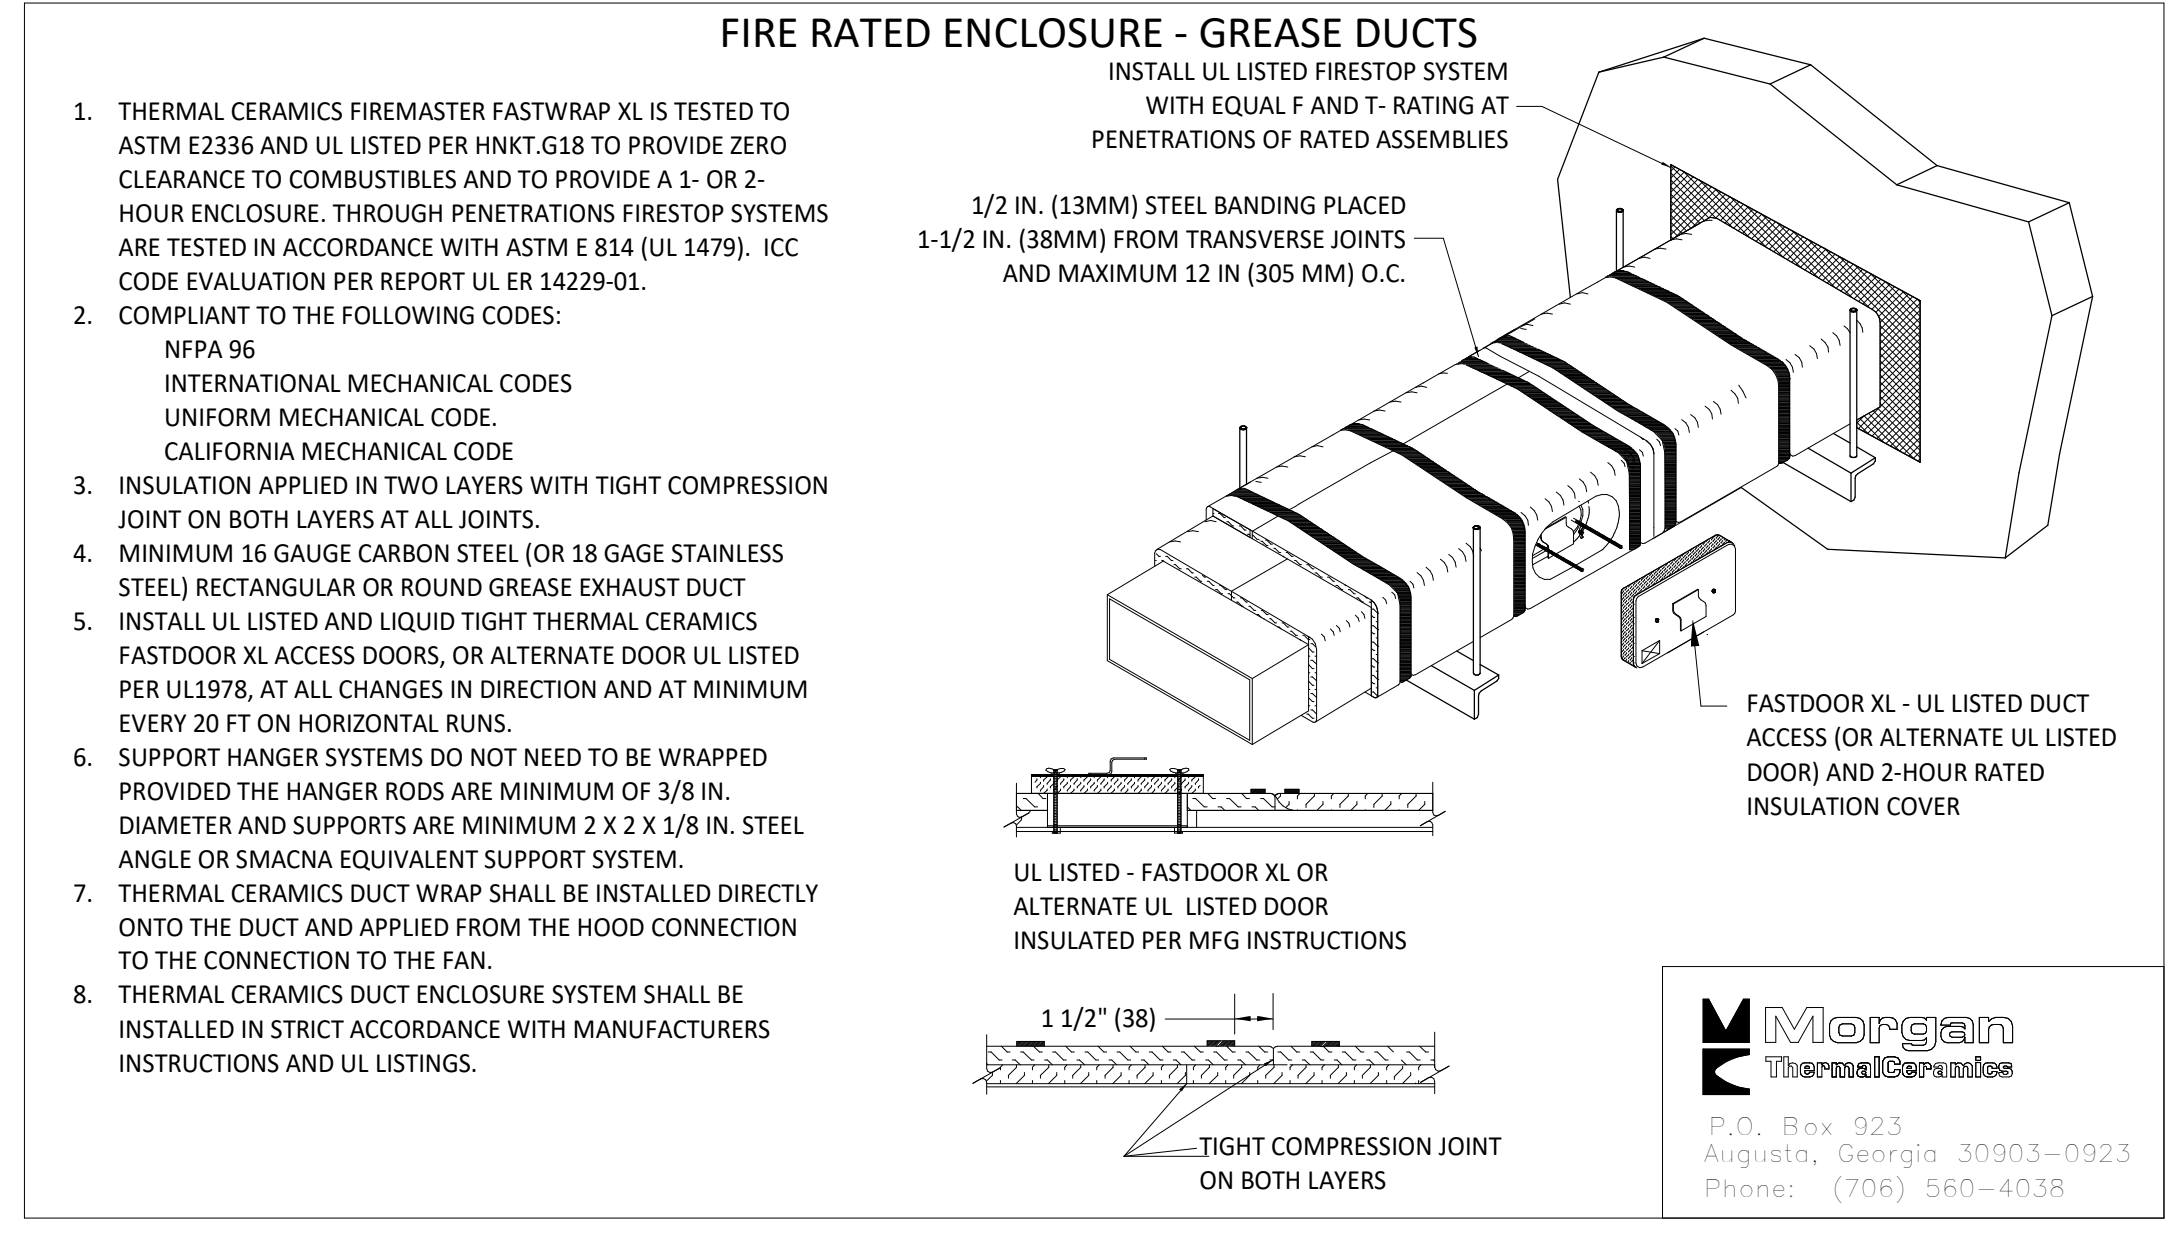

3 FIREMASTER DUCT WRAP - UL HNKT-G18  
 N.T.S.

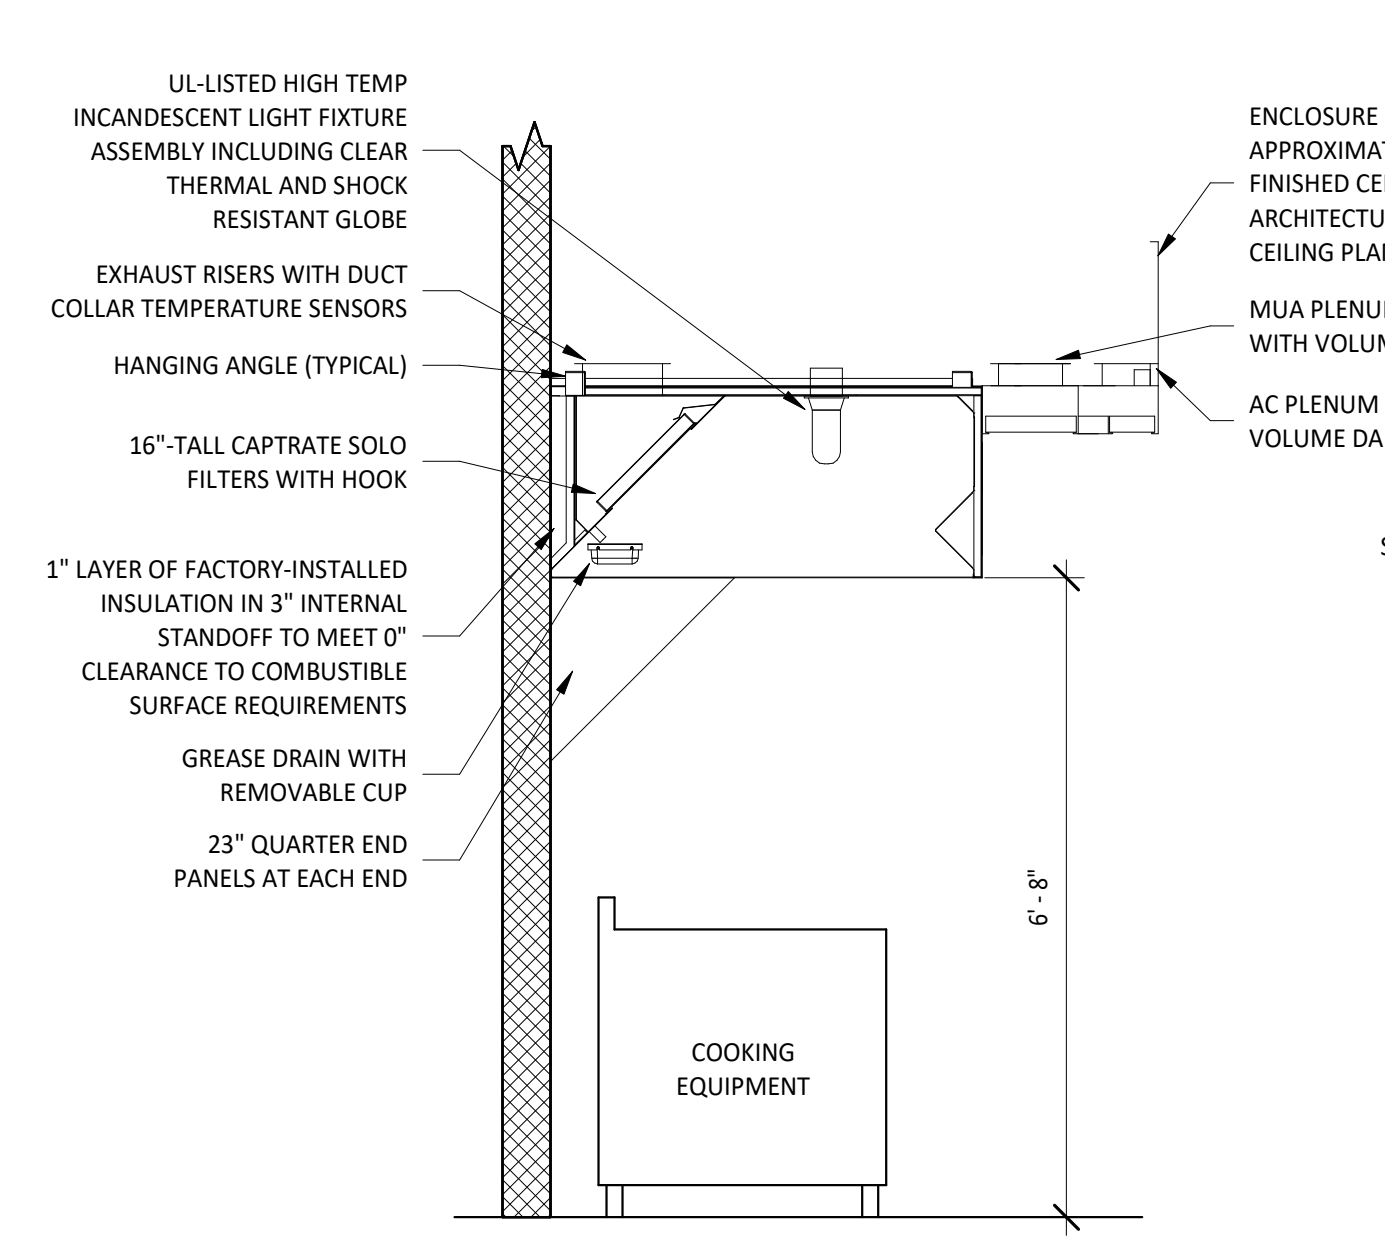

2 HOOD SECTION VIEW  
 N.T.S.

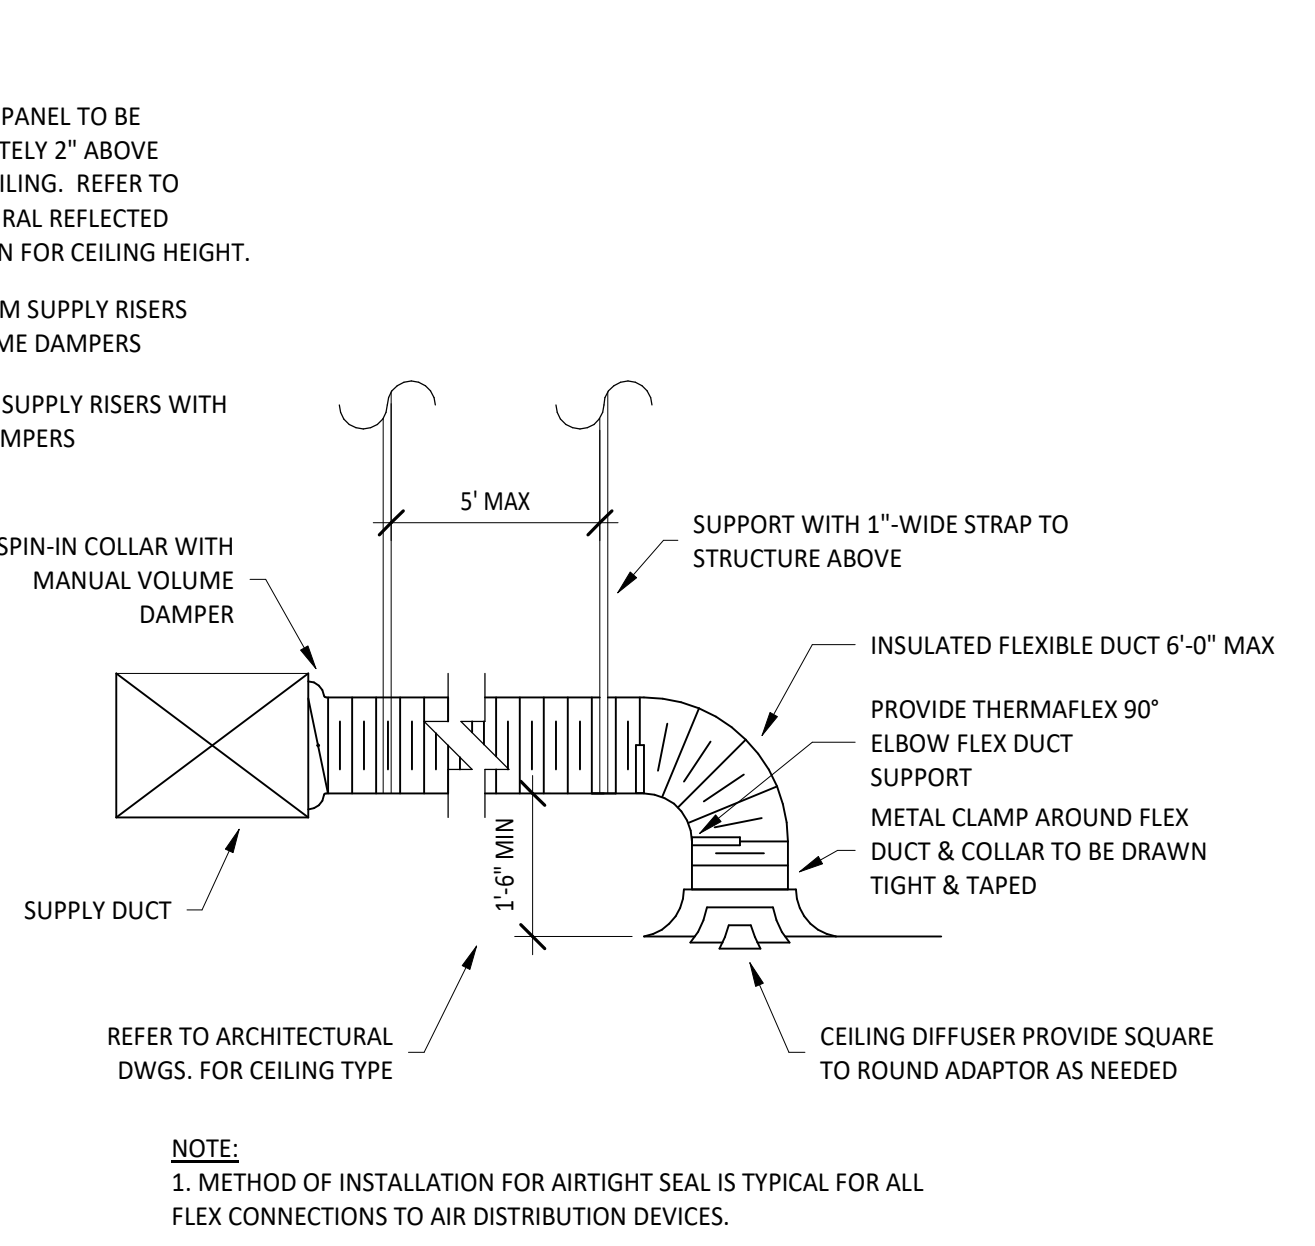

1 DIFFUSER CONNECTION  
 N.T.S.